
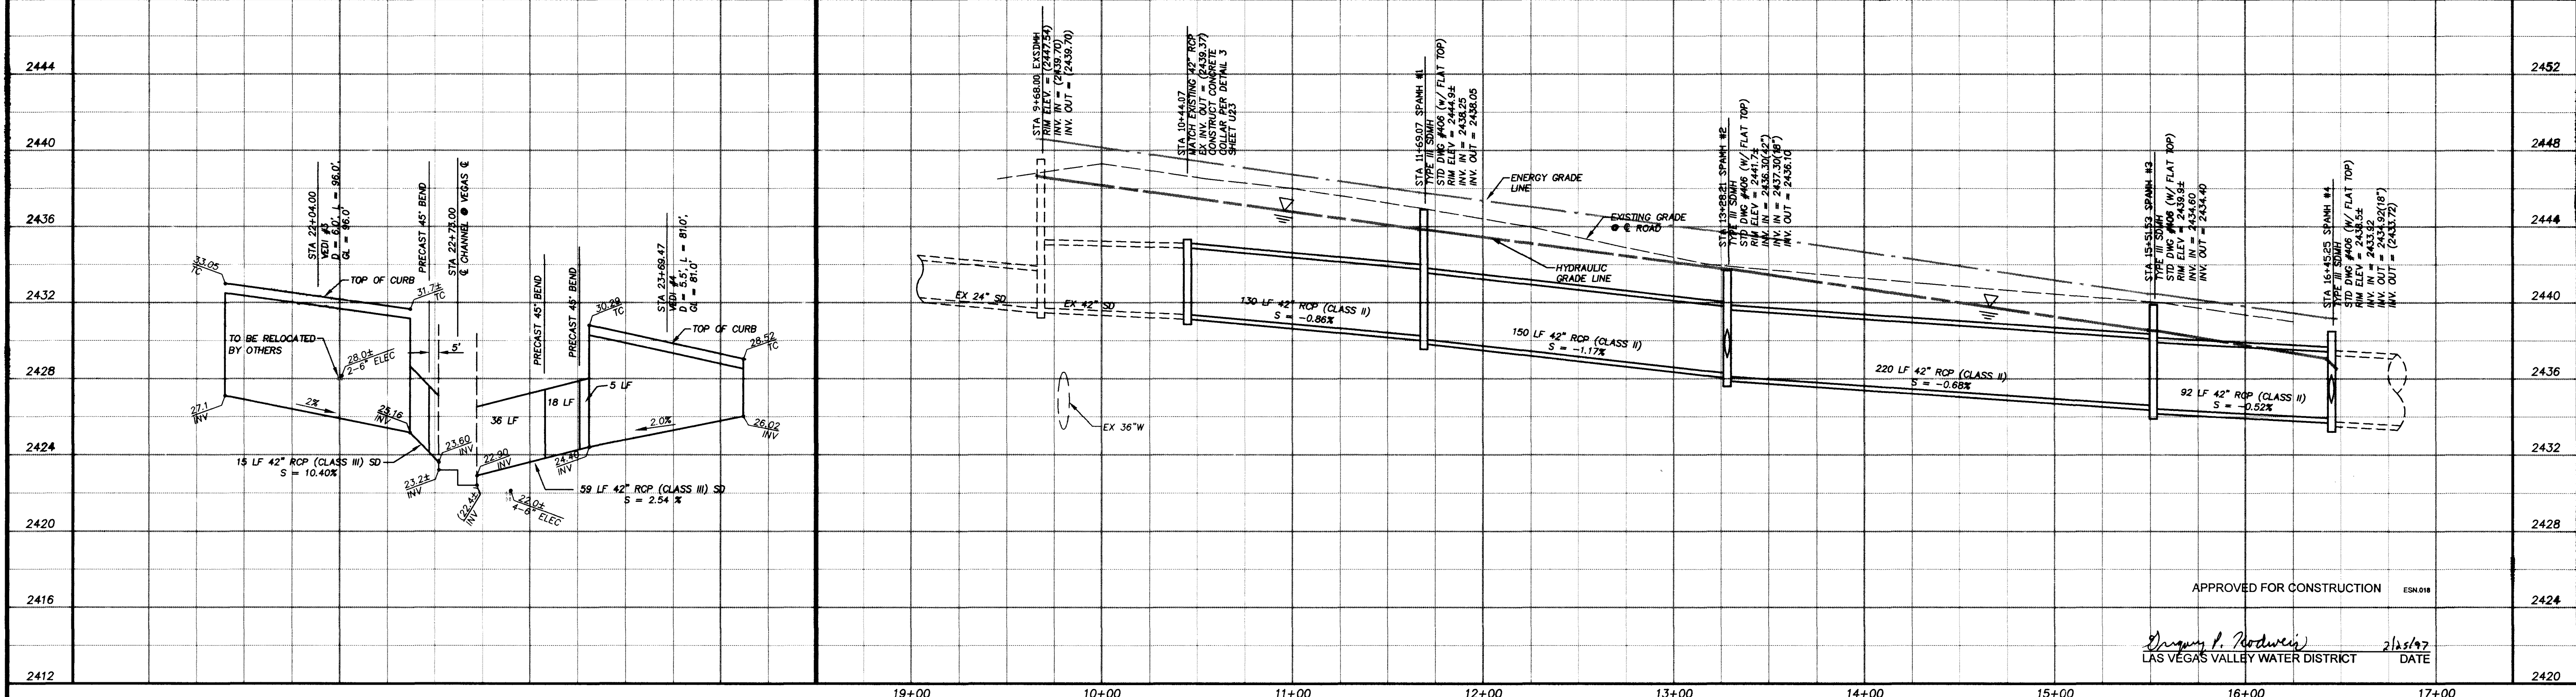


C:\DWG5\705\705-U18 Sat Oct 7 13:54:34 1995 POST, BUCKLEY, SCHUH & JERNIGAN, INC. - SCOTT

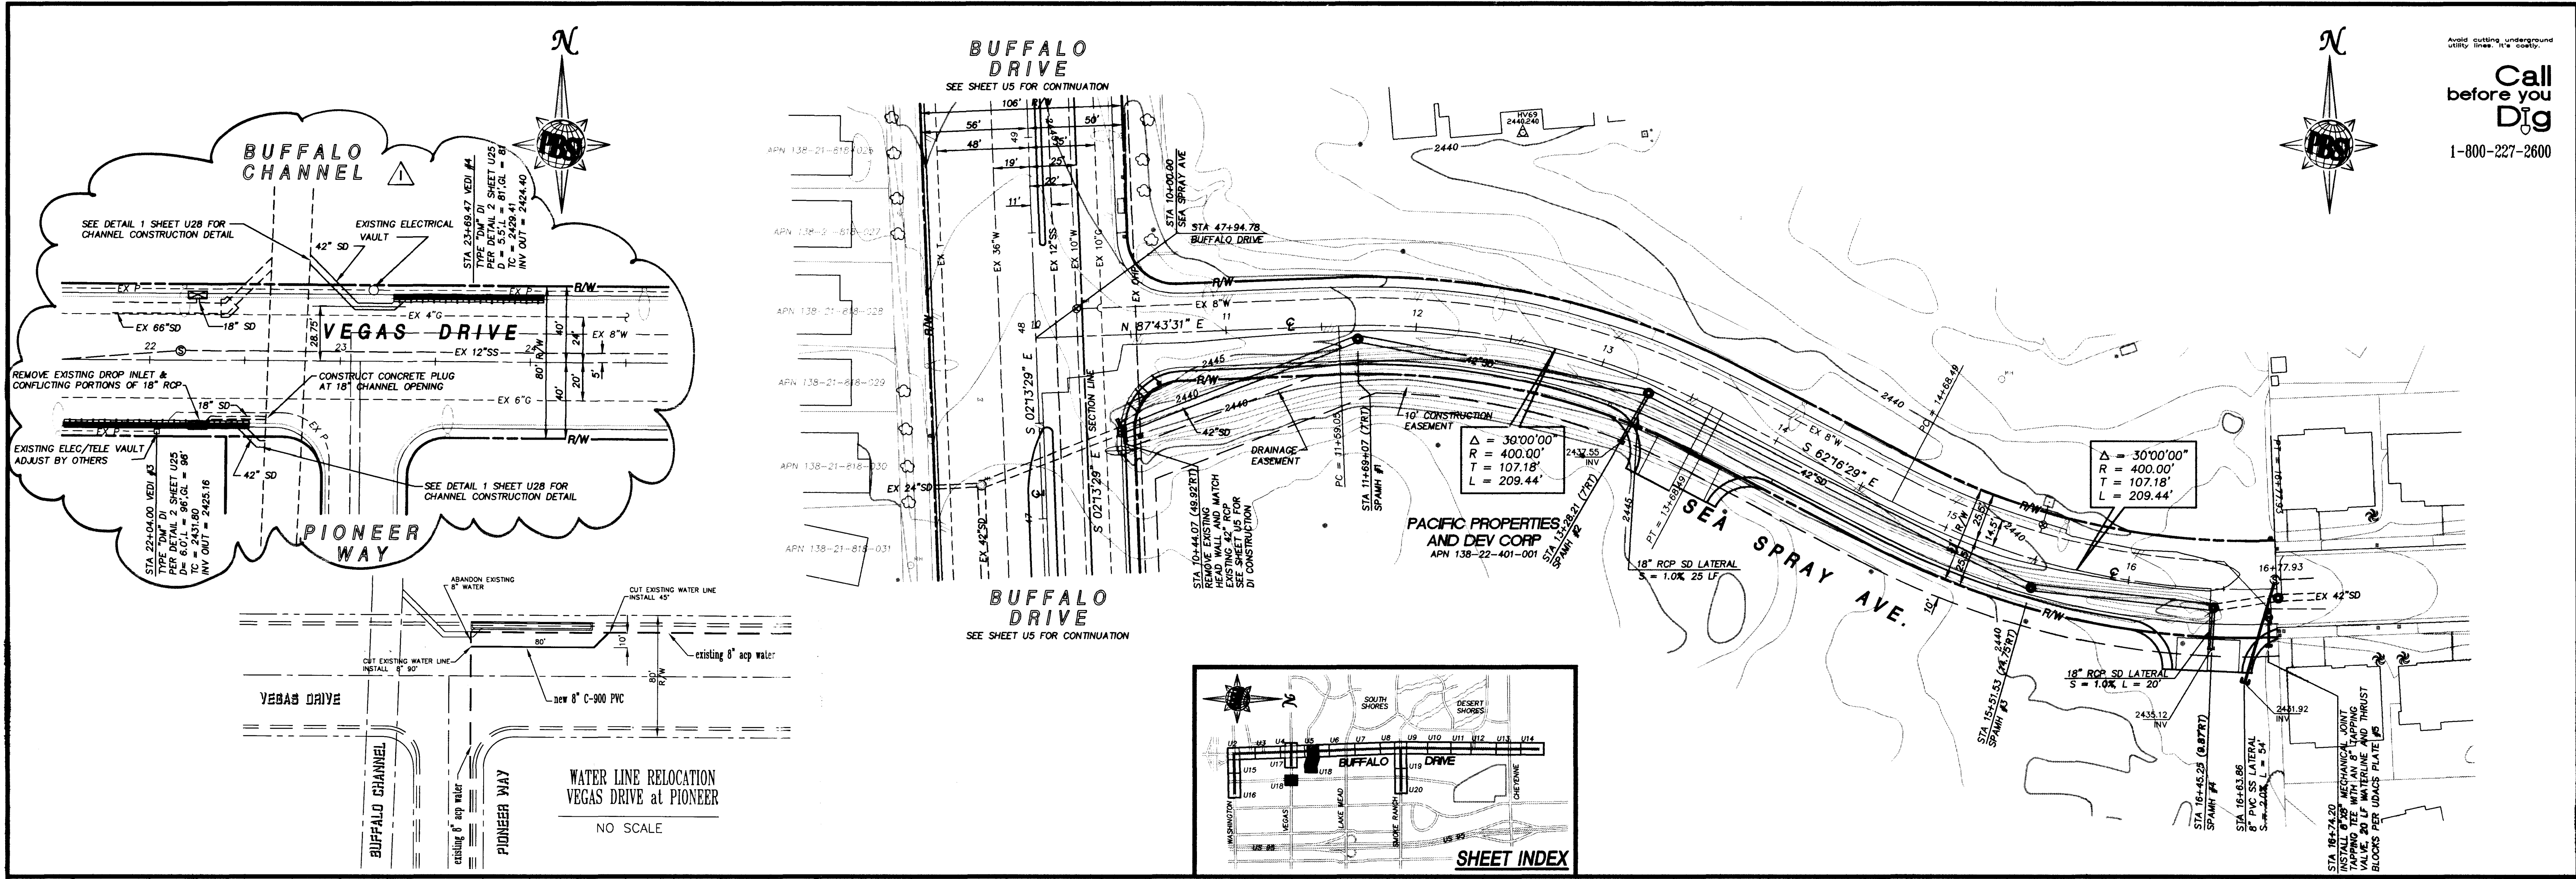

REVISIONS				
REV.	DESCRIPTION	BY	DATE	APPROVAL
1	RELOCATE WATER LINE	CLV		

Scale

HORIZONTAL : 1" = 40'

VERTICAL : 1" = 4'

Job No. 7158.705

POST, BUCKLEY, SCHUH & JERNIGAN

901 North Green Valley Pkwy
Suite 100
Henderson, Nevada 89014
Telephone: 703/263-7275
Fax: 703/263-7200

ENGINEERING • PLANNING • SURVEYING • CONSTRUCTION SERVICES

DESIGNED BY : AAS Date : 09/15/95

DRAWN BY : JMA Date : 09/15/95

CHECKED BY : WEH Date : 09/15/95



FILE NO. : 705IMP Dwg No. : 705-U18

CITY OF LAS VEGAS

BUFFALO DRIVE ROADWAY IMPROVEMENTS
BID NO. 96.173035
SEA SPRAY AVENUE
UTILITY PLAN AND PROFILE STA 10+00 TO STA 17+00

CITY OF LAS VEGAS DRAWING No. 107-V2314 SHEET U18

ENGINEERING BY MR. T. A. BROWN AND THE BROWN ENGINEERING CO., INC.

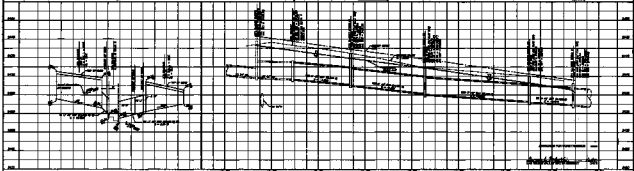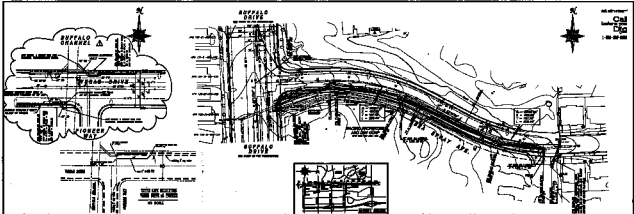

PROJECTIONS		NOTES		REVISIONS		APPROVALS	
No.	Description	Date	By	Checked	Approved	Date	By

HORIZONTAL: $P = 100'$
 VERTICAL: $P = 100'$

Prepared by: Date:
 Checked by: Date:
 Approved by: Date:

City of Las Vegas
 PUBLIC WORKS DEPARTMENT
 100 SOUTH MAIN STREET
 LAS VEGAS, NEVADA
 CITY OF LAS VEGAS ENGINEER NO. 10-10000

AS BUILT