



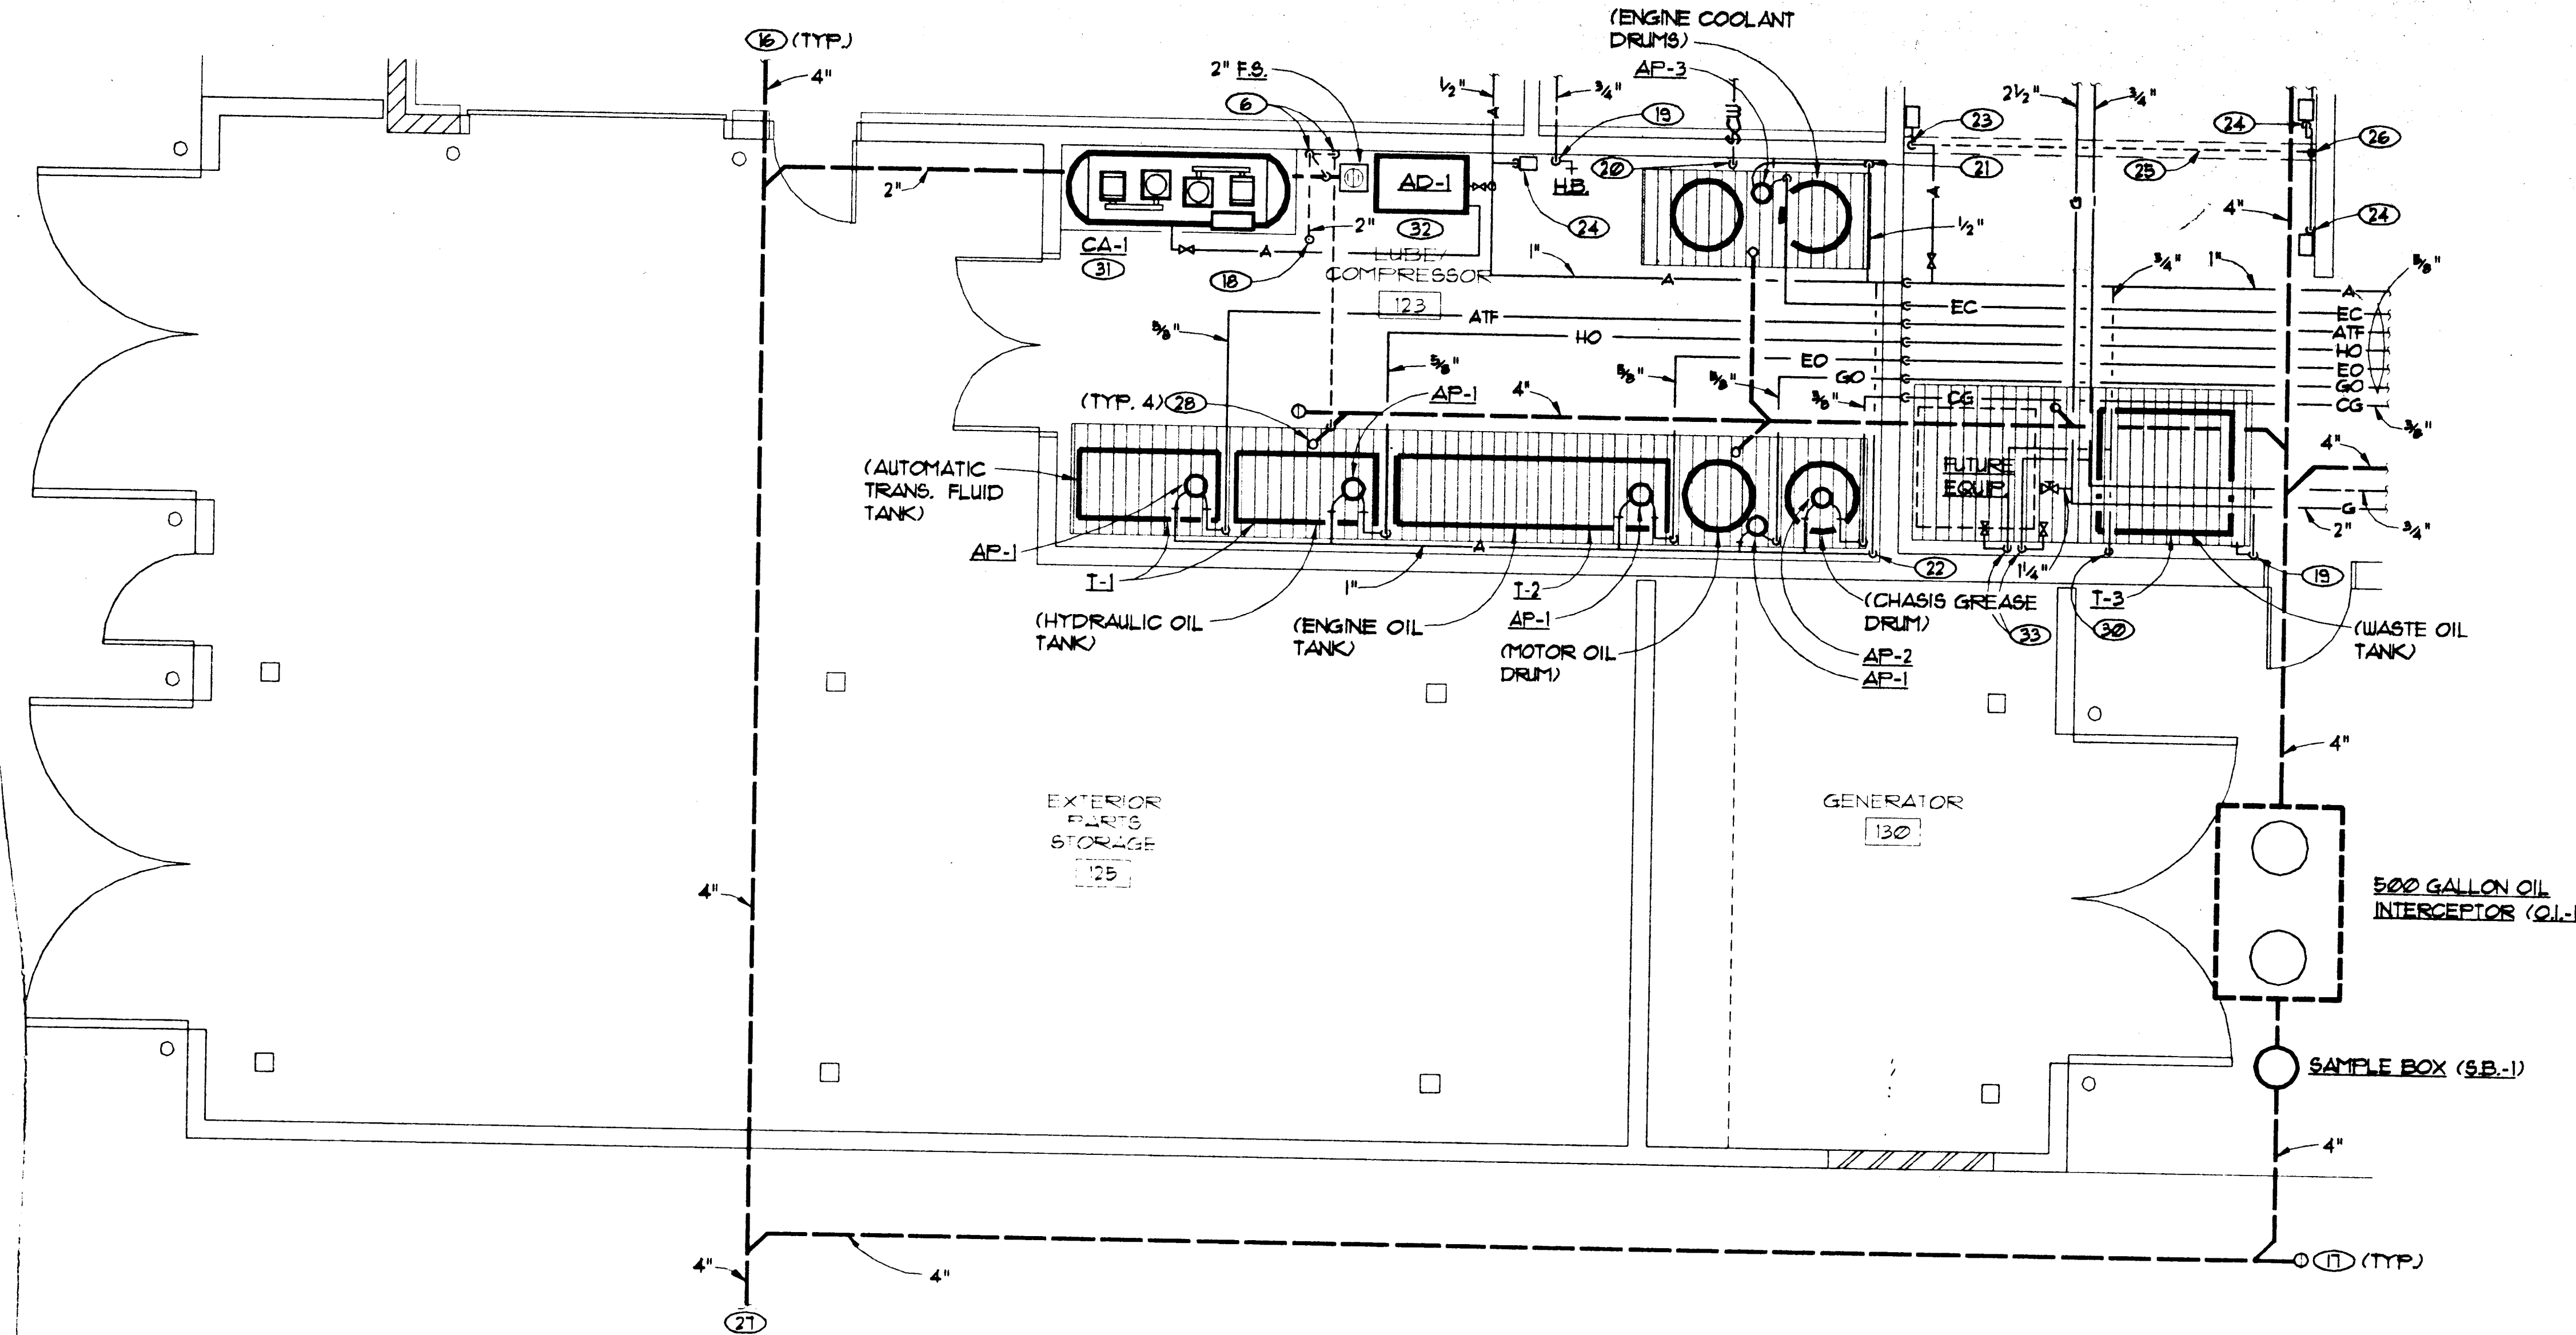

PARTIAL PLAN - LUBE/COMPRESSOR - PLUMBING
1/4" = 1'-0"

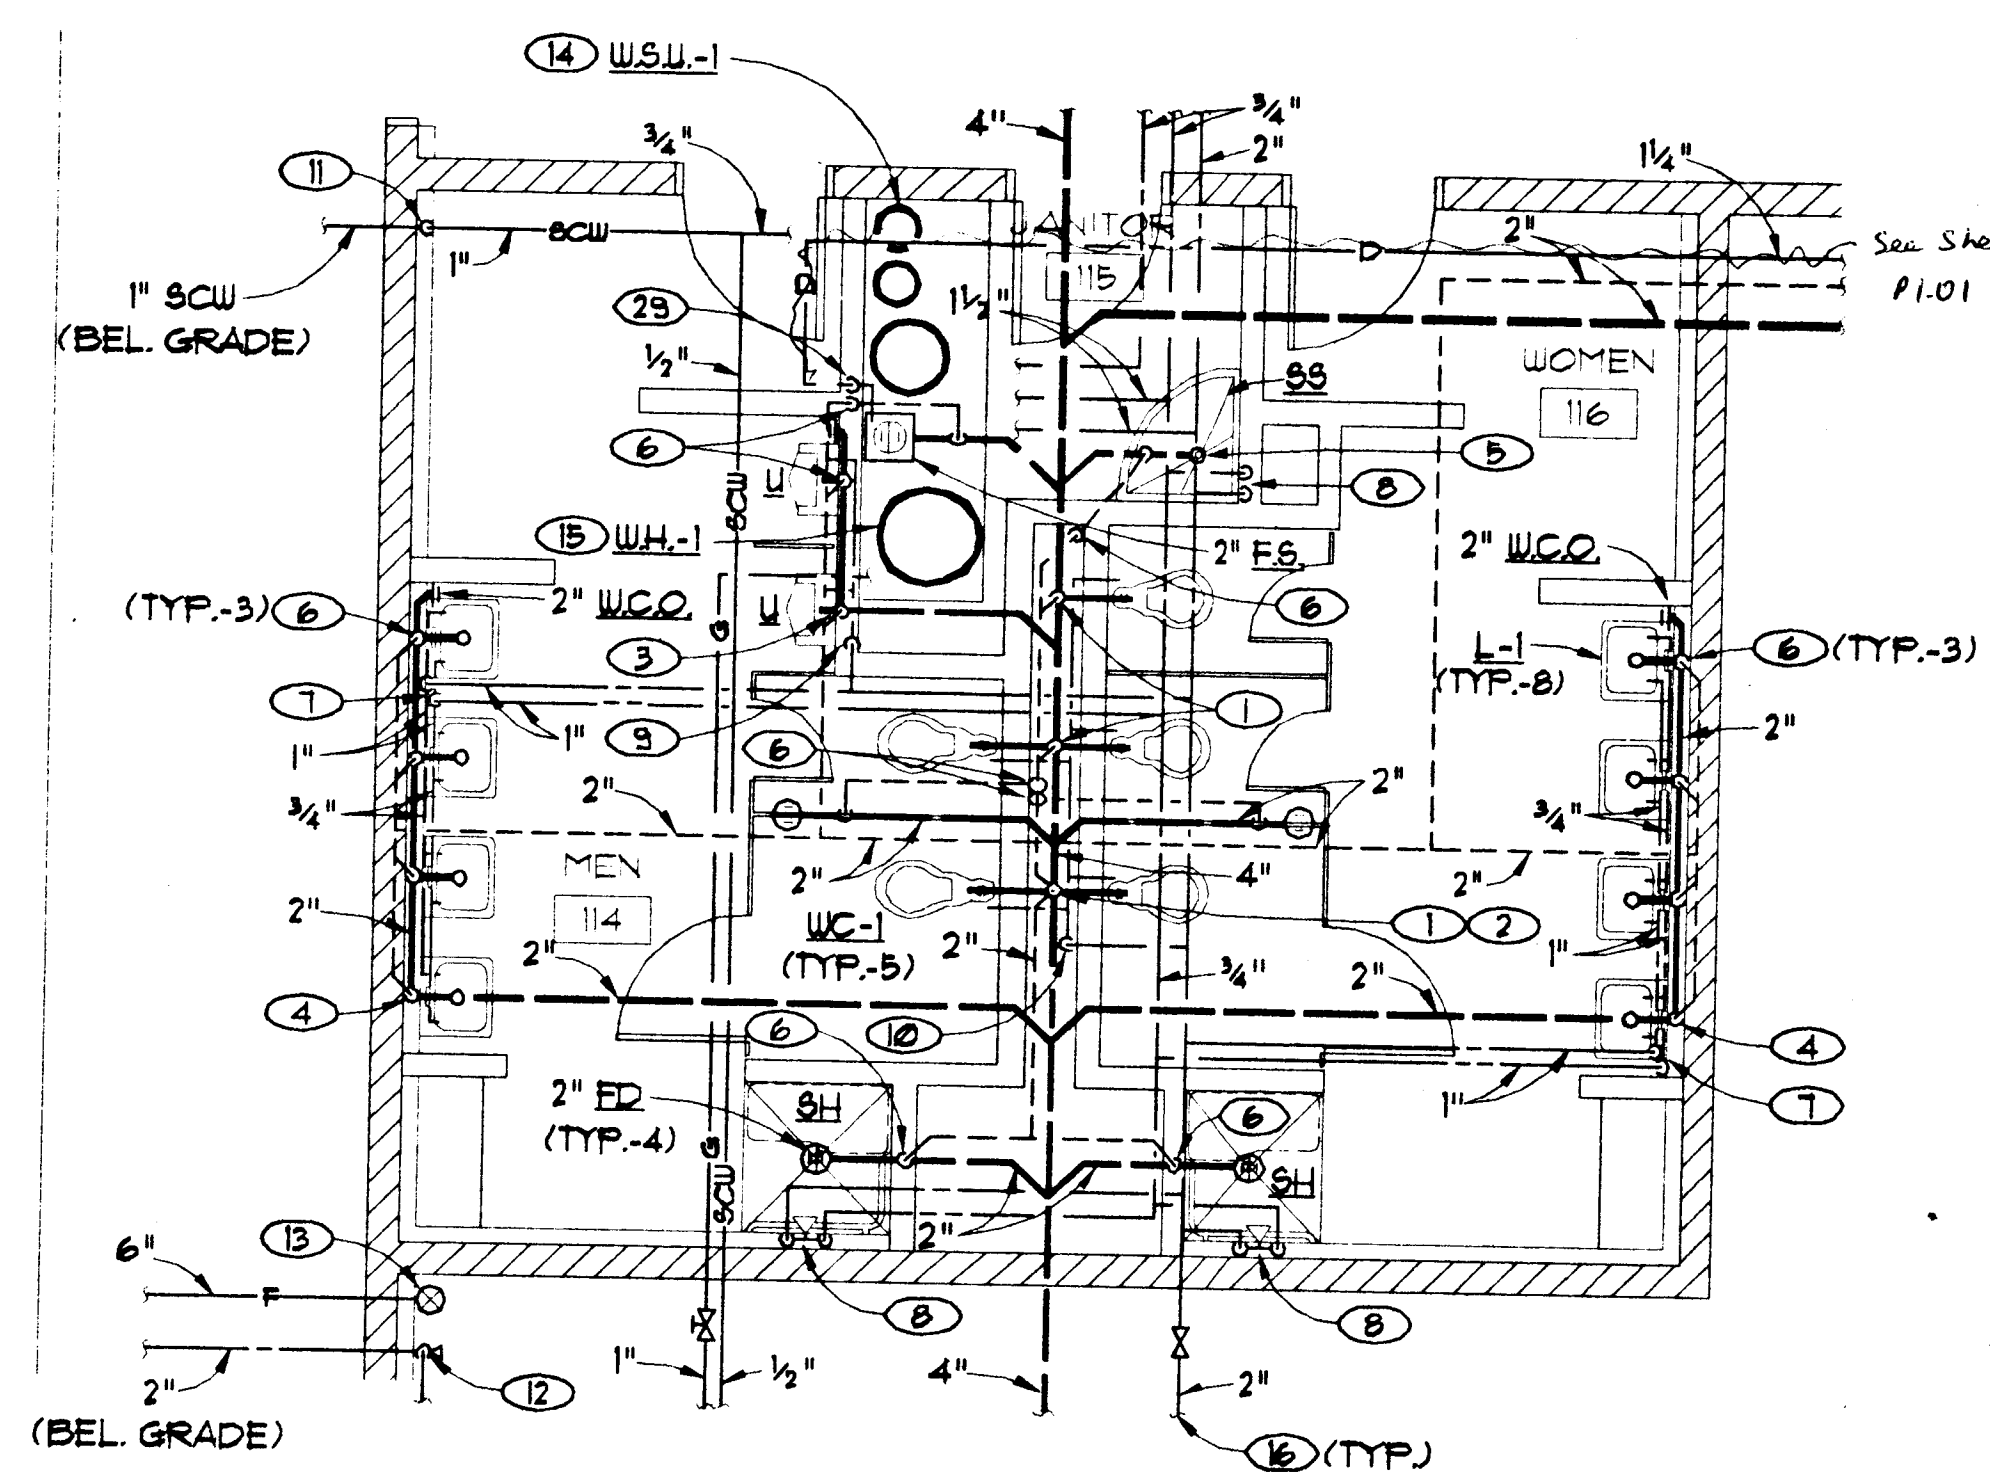


PARTIAL PLAN - TOILET ROOMS - PLUMBING
1/4" = 1'-0"

Shirley E. Linn
Anytime Plumbing
9-15-97

- NOTES:**
- (1) 4" S. DN, 2" V. UP.
 - (2) 4" V.T.R.
 - (3) 2" S. DN, 1 1/2" V. UP.
 - (4) 2" W. DN, 1 1/2" V. UP.
 - (5) 2" W. DN.
 - (6) 1 1/2" V. UP.
 - (7) 1" H. & C.W. DN.
 - (8) 1/2" H. & C.W. DN.
 - (9) 1" C.W. DN. & HEADER IN WALL.
 - (10) 2" C.W. DN. & HEADER IN CHASE.
 - (11) 1" S.C.W. DN. IN FURRED WALL TO BEL. GRADE.
 - (12) 2" C.W. RISER W/ S.O.V.
 - (13) FIRE SPRINKLER RISER.
 - (14) SEE DETAIL (6) (P. 101).
 - (15) SEE DETAIL (4) (P. 101).
 - (16) FOR CONTIN. SEE SHT. P. 101.
 - (17) SEE DETAIL (1) (P. 101).
 - (18) 2" V.T.R.
 - (19) 3/4" C.W. DN. TO H.B. # 36" ABV. FLR.
 - (20) 1/2" S.C.W. DN. TO EC MIXING TANKS.
 - (21) 1/2" A. DN. ON WALL.
 - (22) 1" A. DN. ON WALL & MANFOLD ALONG WALL.
 - (23) 3/4" A. DN. W/ S.O.V. & TO TRENCH. TEE 1/2" A. TO (23).
 - (24) 1/2" A. TO S.O.V. FILTER, REGULATOR, LUBRICATOR & 3/8" QUICK DISC. # 42" ABV. FLR.
 - (25) 3/4" A. IN TRENCH.
 - (26) 3/4" A. UP. STRAP TO 48" CMV. WALL # 26" ABV. FLR.
 - (27) FOR CONTIN. SEE CIVIL.
 - (28) 2" REMOVABLE STANDPIPE TO EXTEND TO WITHIN 3" OF THE BOTTOM OF GRATE.
 - (29) 1 1/2" D. DN. IN WALL & TERMINATE OVER F.S. W/ 90° ELL. TURNED DN.
 - (30) 1/2" DN. ON WALL W/ S.O.V. REGULATOR & LUBRICATOR CONN. TO PUMP.
 - (31) PROVIDE 4" HIGH CONCRETE HOUSE KEEPING PAD.
 - (32) SUPPORT FROM MASONRY WALL.


ARCHITECTS

709 Valle Verde Court
Henderson, Nevada 89014
Tel. 702.456.3000
Fax. 702.898.6209

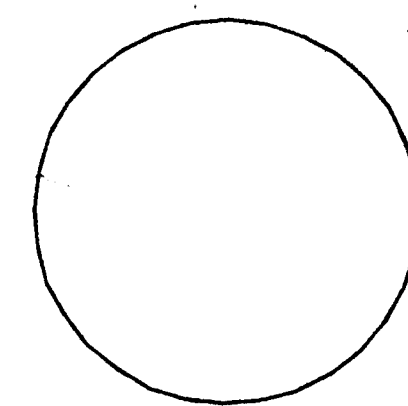

THESE DRAWINGS AND ANY INFORMATION CONTAINED HEREIN ARE THE PROPERTY OF THE CONSULTING ENGINEERS AND SHALL BE KEPT IN CONFIDENTIALITY. NO PART OF THESE DRAWINGS SHALL BE REPRODUCED OR TRANSMITTED IN ANY FORM OR BY ANY MEANS, ELECTRONIC OR MECHANICAL, INCLUDING PHOTOCOPYING, RECORDING, OR BY ANY INFORMATION STORAGE AND RETRIEVAL SYSTEM, WITHOUT THE WRITTEN PERMISSION OF THE CONSULTING ENGINEERS.

CONSULTING
ENGINEERS

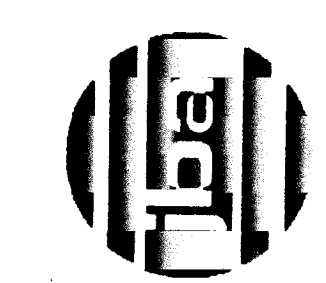


Consultant

Sheet Title
1/4" PARTIAL PLANS - PLUMBING

Project
CITY OF LAS VEGAS
WEST VEHICLE SERVICE CENTER

Revisions

Date:
2/5/96
Sheet No. 36
P2.01
522-V61

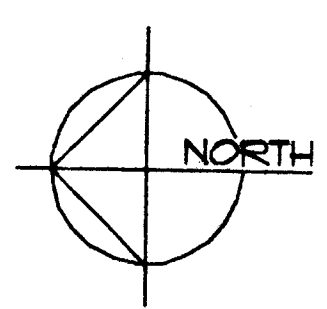

AS-BUILT