



SHEET PLOT SCALE: 1/4" = 1'-0"  
SHEET FILE NAME: UES69021

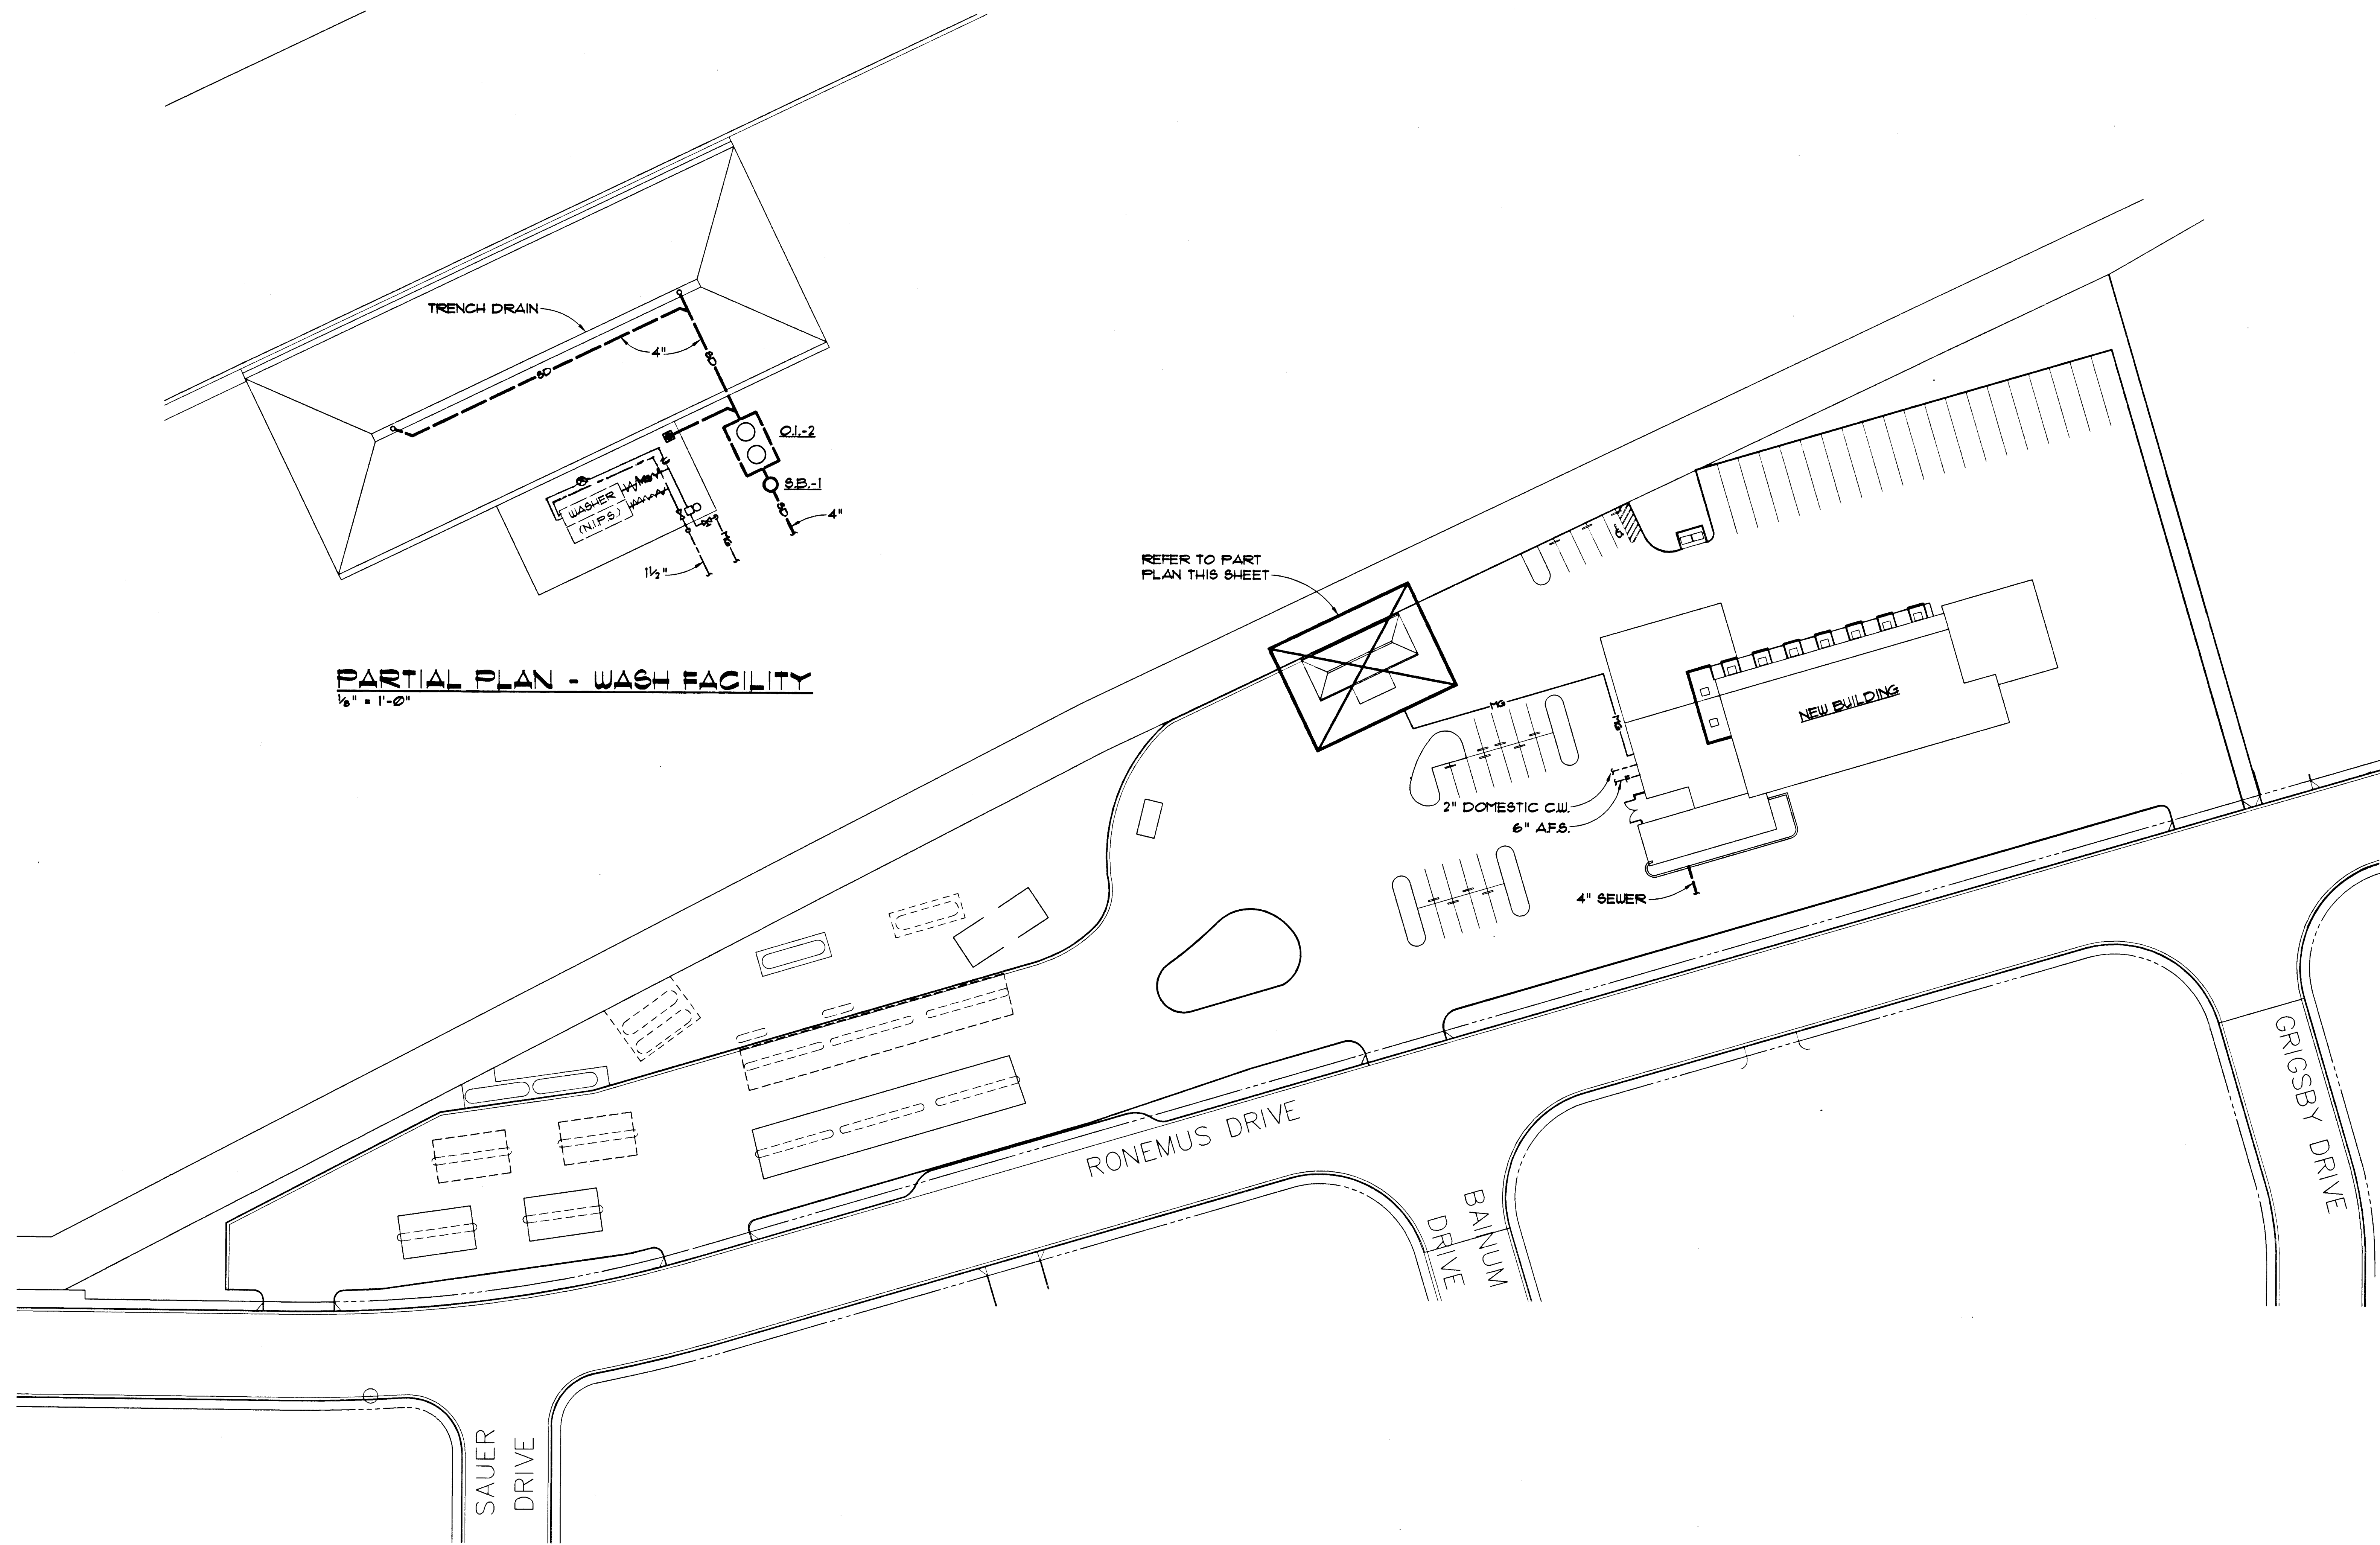

**PARTIAL PLAN - WASH FACILITY**  
1/2" = 1'-0"

**SITE PLAN**  
SCALE: 1" = 40'-0"

A

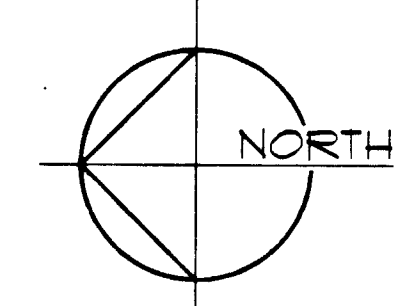


ISSUED FOR CONTRACTORS  
PREP OF AS BUILT DOCUMENTS

4432

HALL & SANDERSON ARCHITECTS

709 Valle Verde Court  
Henderson, Nevada 89014  
Tel. 702 . 456 . 3000  
Fax. 702 . 898 . 6209

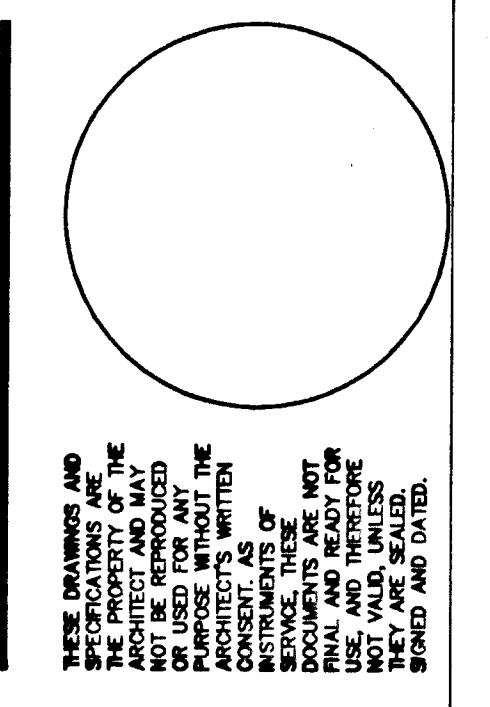

Consultant

**CONSULTING ENGINEERS**

**JH&S**

James H. Sanderson  
Professional Engineer  
State of Nevada  
License No. 10000

Sheet Title  
**SITE PLAN & PARTIAL PLAN - PLUMBING**

Project  
**CITY OF LAS VEGAS  
WEST VEHICLE SERVICE CENTER**

Revisions

Date: 03.21.95  
Sheet No. 33  
**PS1.01**  
522-161

AS-BUILT