


LEGEND

- RECESSED FLUORESCENT FIXTURE
- LINEAR FLUORESCENT FIXTURE
- RECESSED INCANDESCENT FIXTURE
- SUPPLY AIR DIFFUSER
- RETURN AIR GRILLE
- 24" x 24" SECTIONAL RETURN AIR GRILLE
- LINEAR AIR DIFFUSER
- SIDE OR OVERHEAD COILING GRILLE AS NOTED PER FLOOR PLANS
- METAL LINEAR PAN CEILING
- CEILING FAN

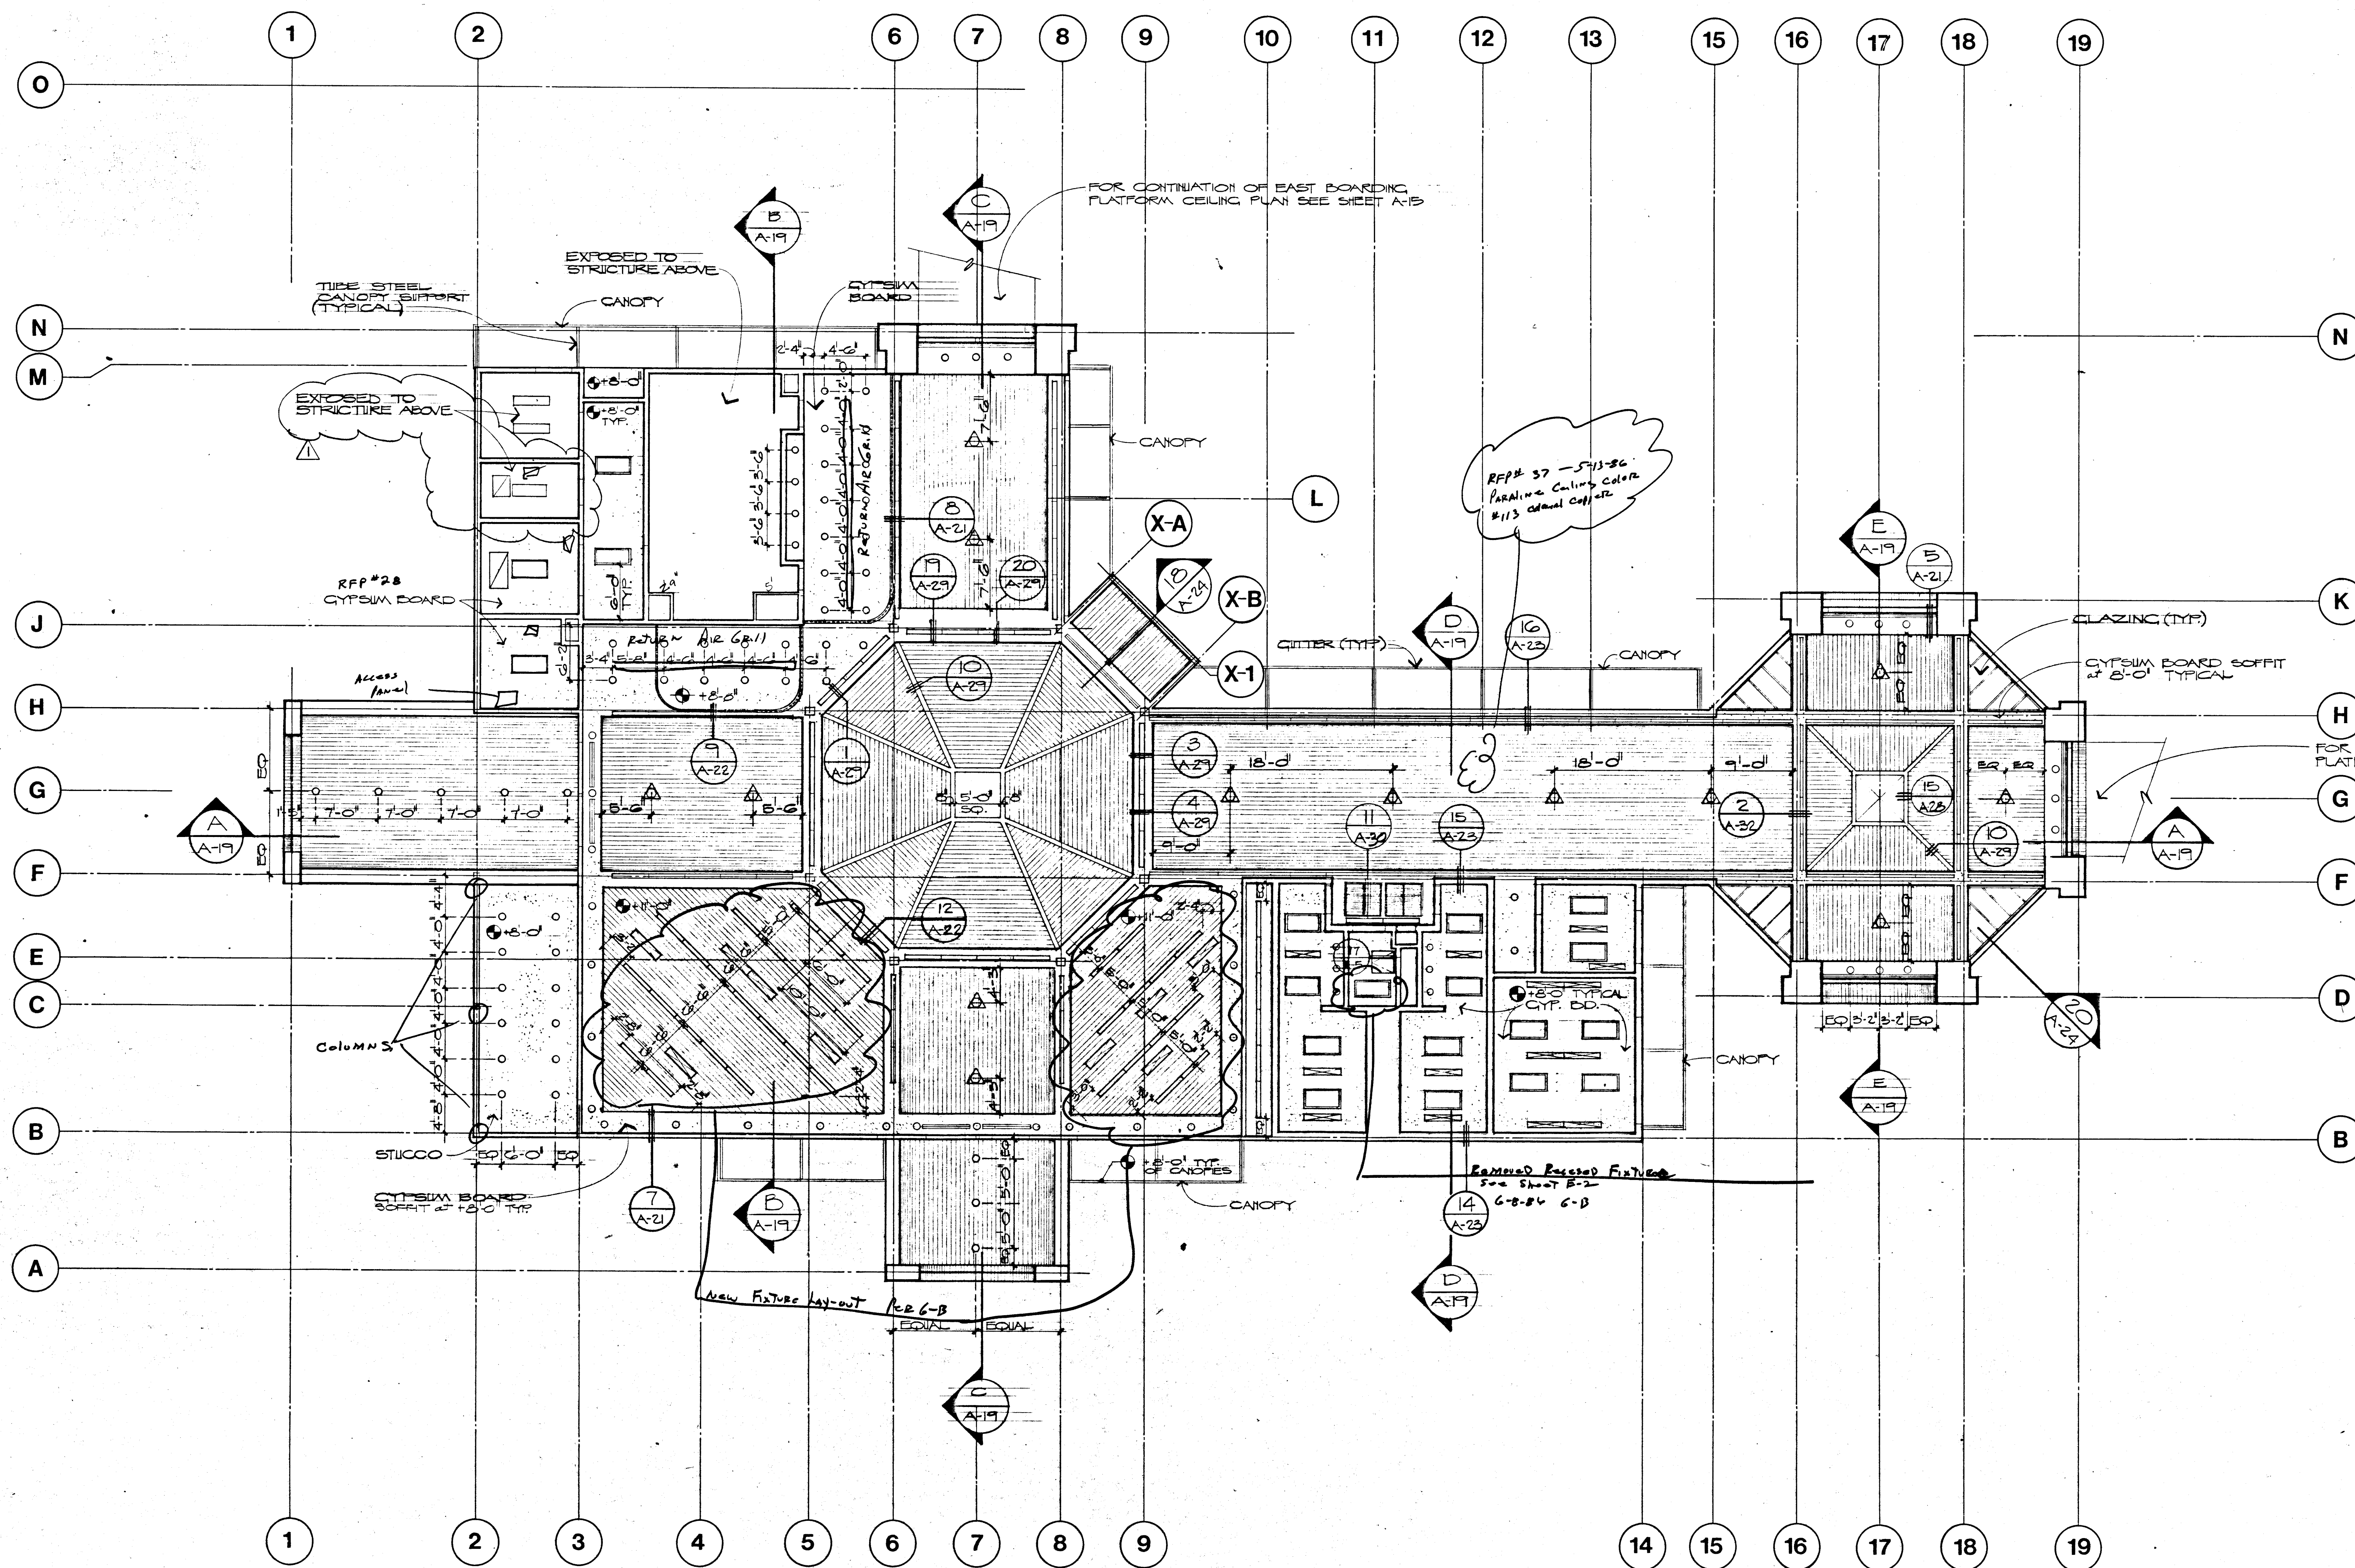

GENERAL NOTES

- IT IS THE INTENT OF THE CEILING PLAN TO ALIGN ITEMS WITHIN THE CEILING SYSTEM AS SHOWN OR DIMENSIONED. CONTRACTOR SHALL COORDINATE LOCATION PER THIS PLAN.
- ITEMS NOT SHOWN SHALL BE ALIGNED WITHIN THE CEILING SYSTEMS RELATIVE TO EACH MATERIAL; i.e., SPRINKLER HEADS SHALL BE CENTERED WITHIN A LINEAR CEILING PAN OR CENTERED WITHIN TWO CEILING PANS. HVAC DIFFUSERS SHALL BE PLACED AND ALIGNED WITHIN THE MODULE OF THE CEILING SYSTEM. SEE SHEET A-21 FOR TYPICAL CEILING DETAILS.
- SEE SHEET A-22 FOR UPPER SOFFIT AND HIGH SOFFIT PLANS.

REFLECTED CEILING PLAN

SCALE: 1/8" = 1'-0"



11-15-85 ISSUED FOR ADDENDUM #1

DATE	11-15-85
DRAWN	LRC
CHECKED	SK
BY	SK
NO.	251-111

DOBROSKY KITTRELL GARLOCK
Architects
3833 CAMDEN ST. LAS VEGAS, NEVADA 89109 (702) 733-0433

Downtown Transportation Center
Las Vegas, Nevada

SHEET
A-14
232 65
392-81

Tablets Plus - 1813 TELEGRAPH PRINTING FILM