


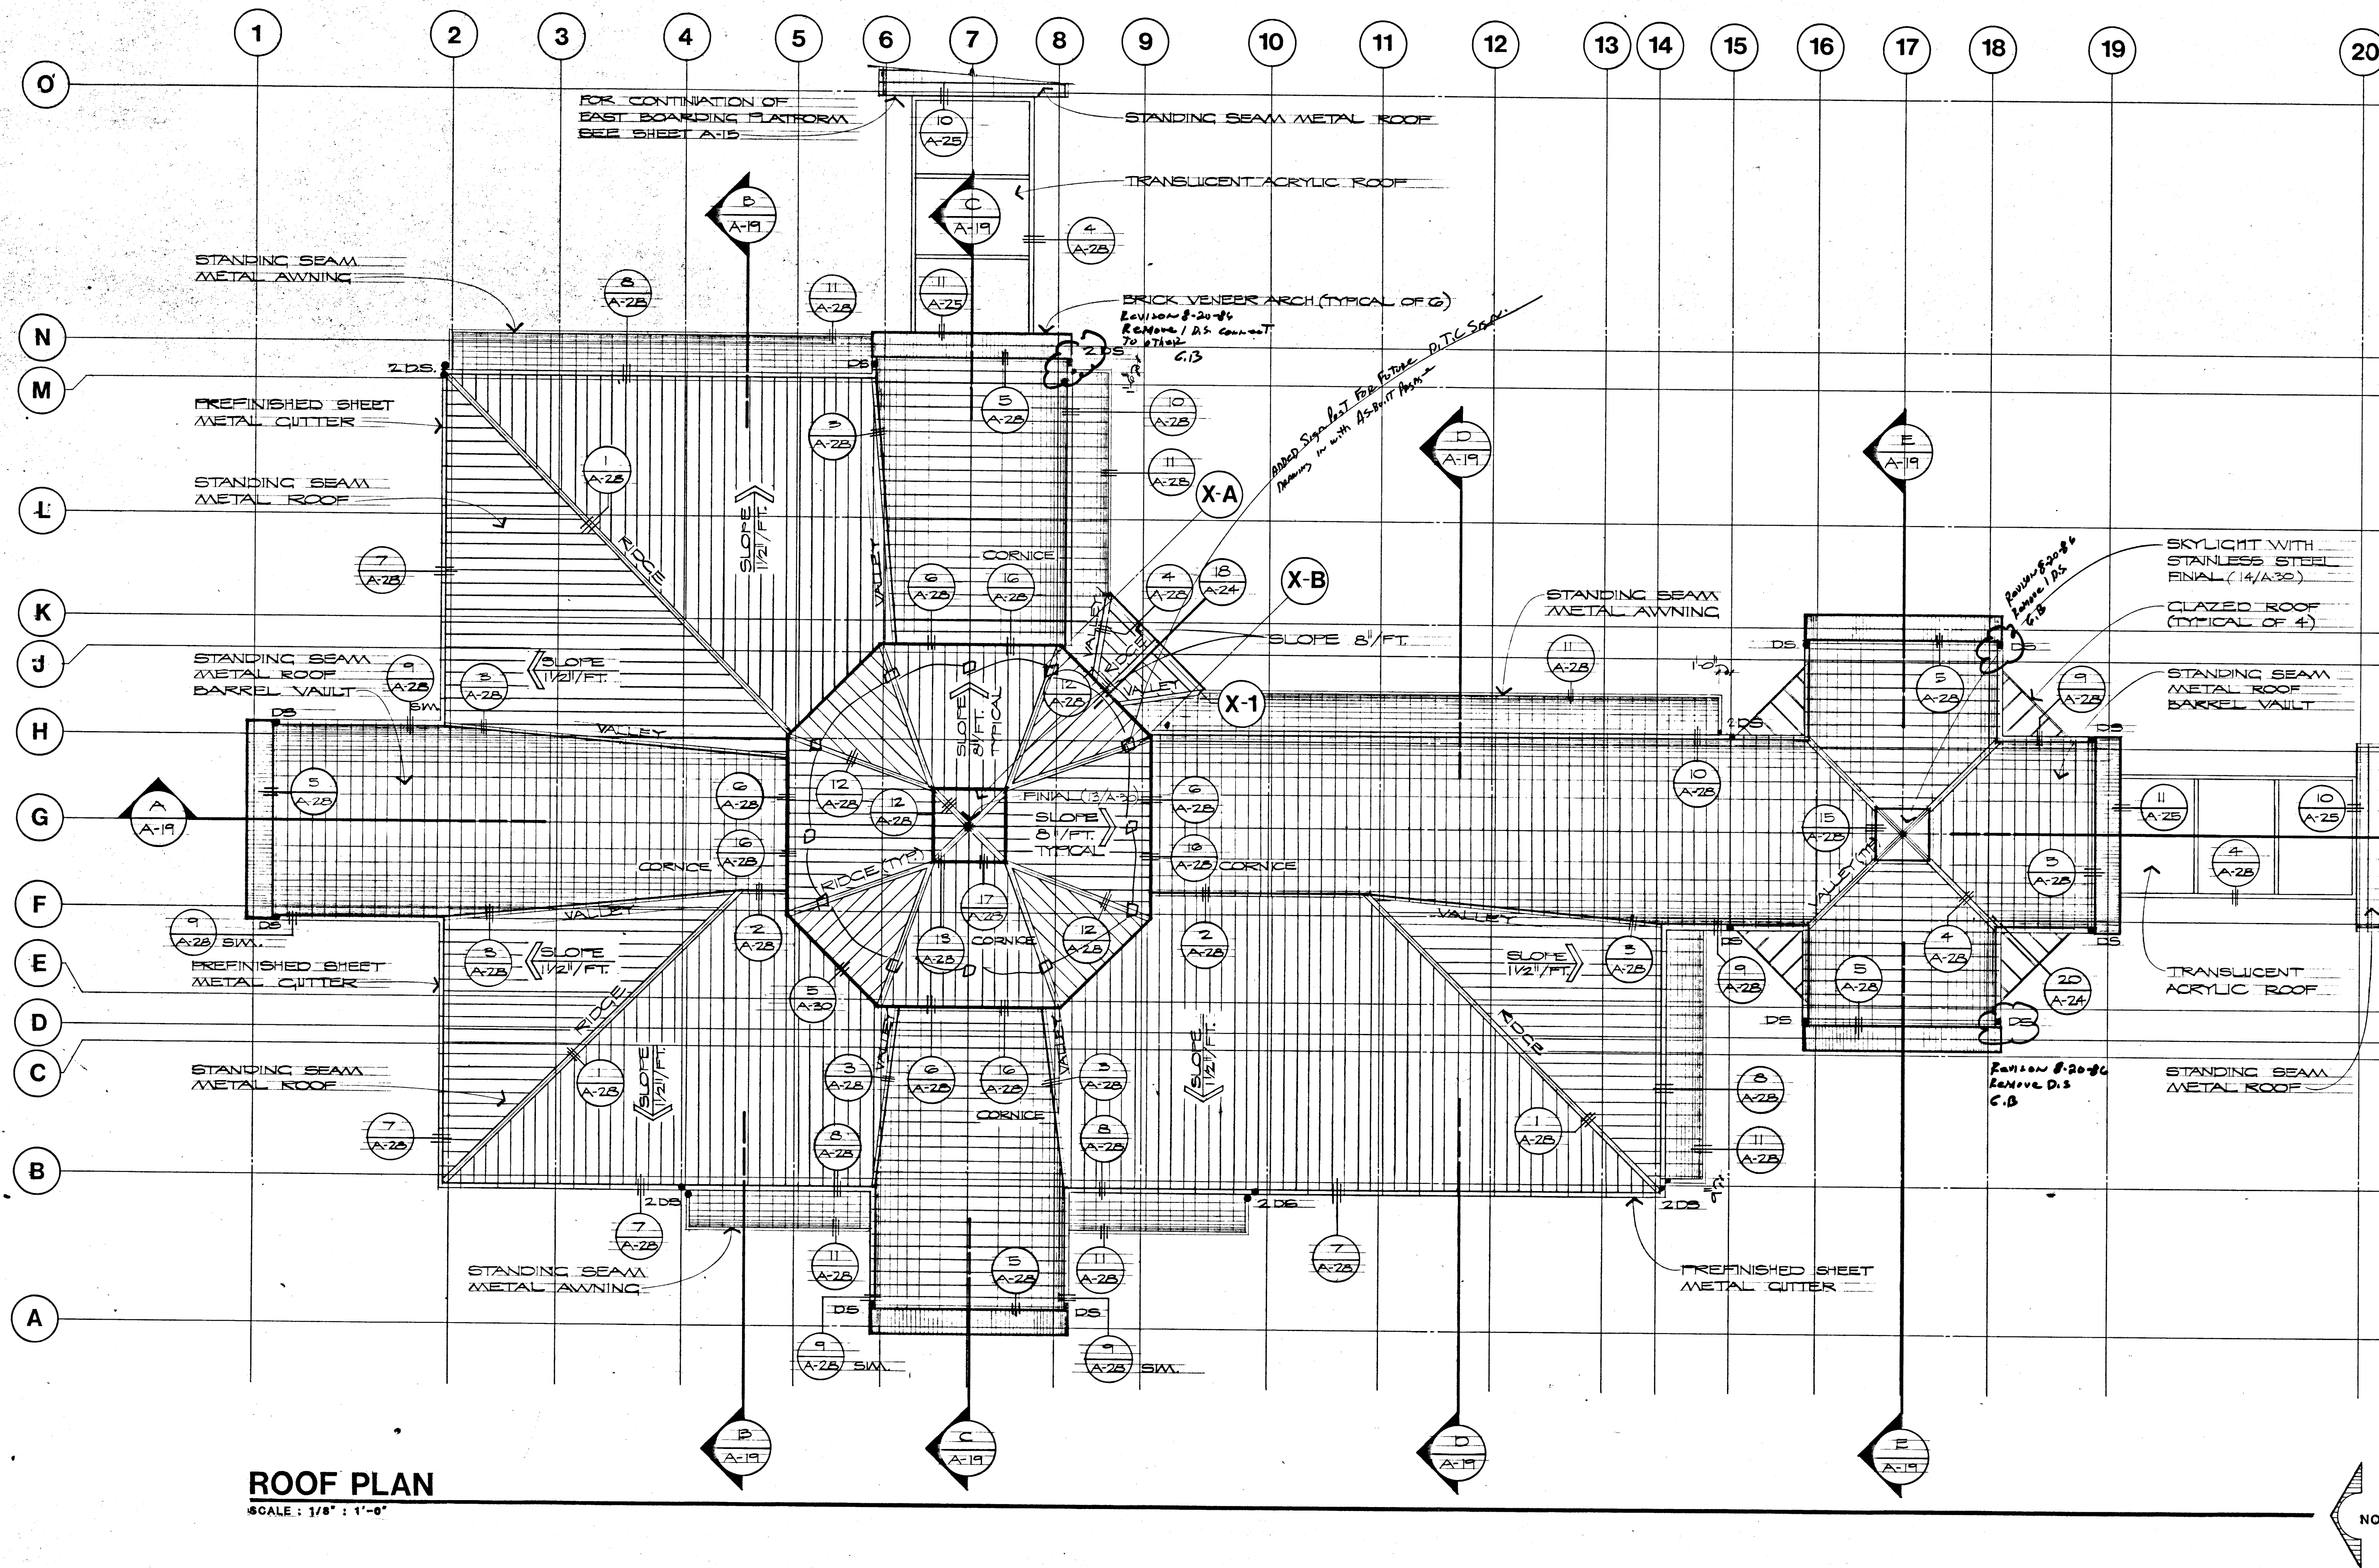


NOTES:
 DS - INDICATES CUTTER DOWN
 SPOT LOCATION

ROOF PLAN
 SCALE: 1/8" = 1'-0"

NORTH

DOBRSKY KITRELL GARLOCK
 Architects
 3333 CAMBRIDGE ST. LAS VEGAS, NEVADA 89169
 (702) 735-0435

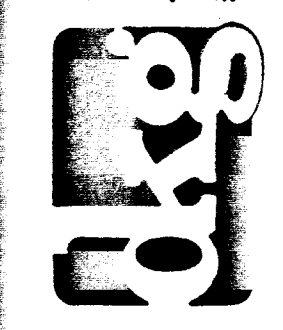

City of Las Vegas
 Transportation Center
 Downtown Las Vegas, Nevada

SHEET
A-17
 2/21/05
 FILE NUMBER
 340-21