



KEYED NOTES:

1. Locate main in soffit behind light pockets. Locate sidewall heads above signage. Refer to Architectural sections on sheet A-19 and large scale detail as appropriate.
2. Provide heads in attic space and for room below as required by code for all areas with suspended ceilings as required by code.
3. Provide attic sprinklers for future kitchen area & provide for future extension of heads to future kitchen ceiling.
4. Provide deflectors as required in Electrical Switchboard Room.

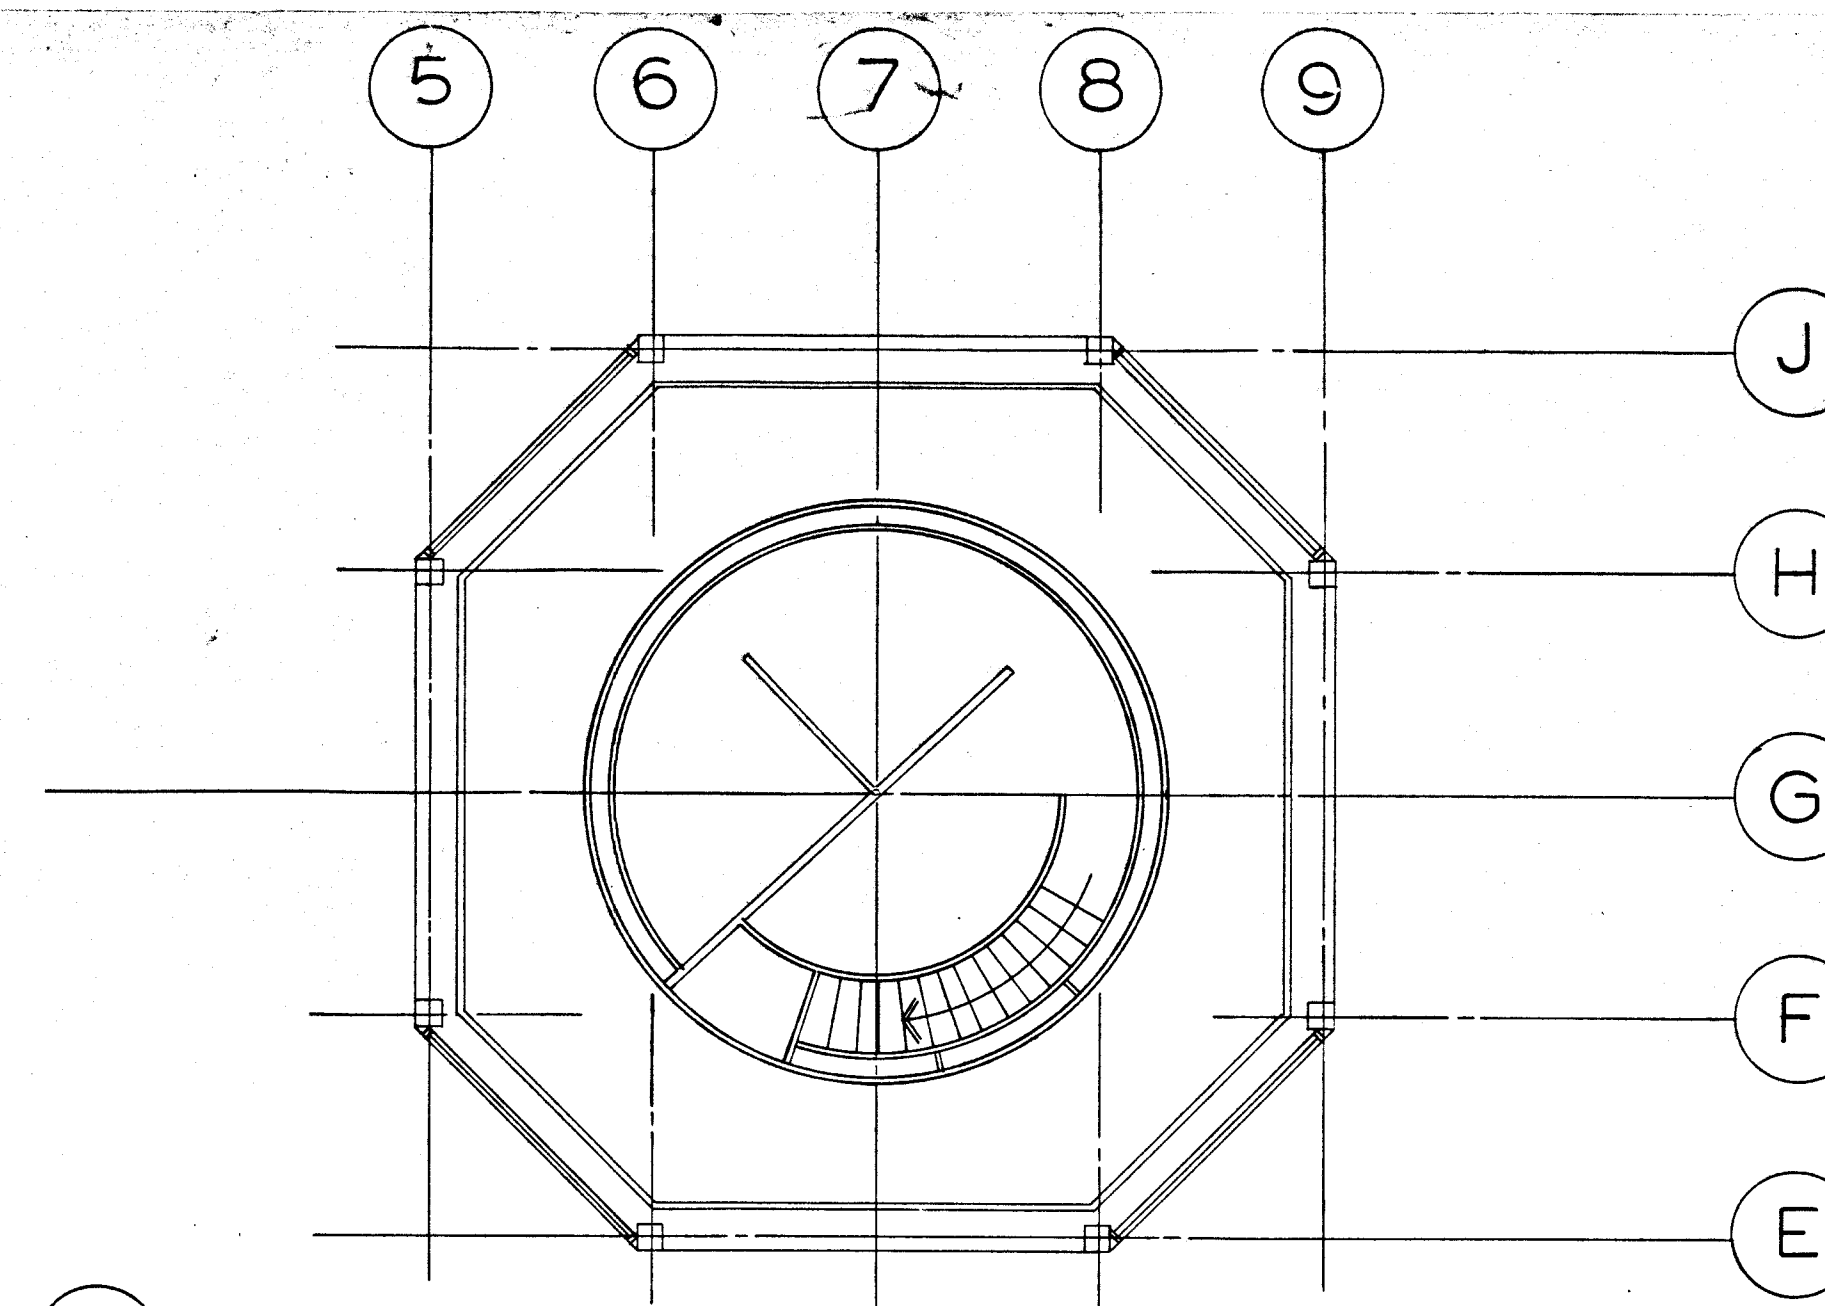

UPPER LEVEL
SCALE: 1/8" = 1'-0"

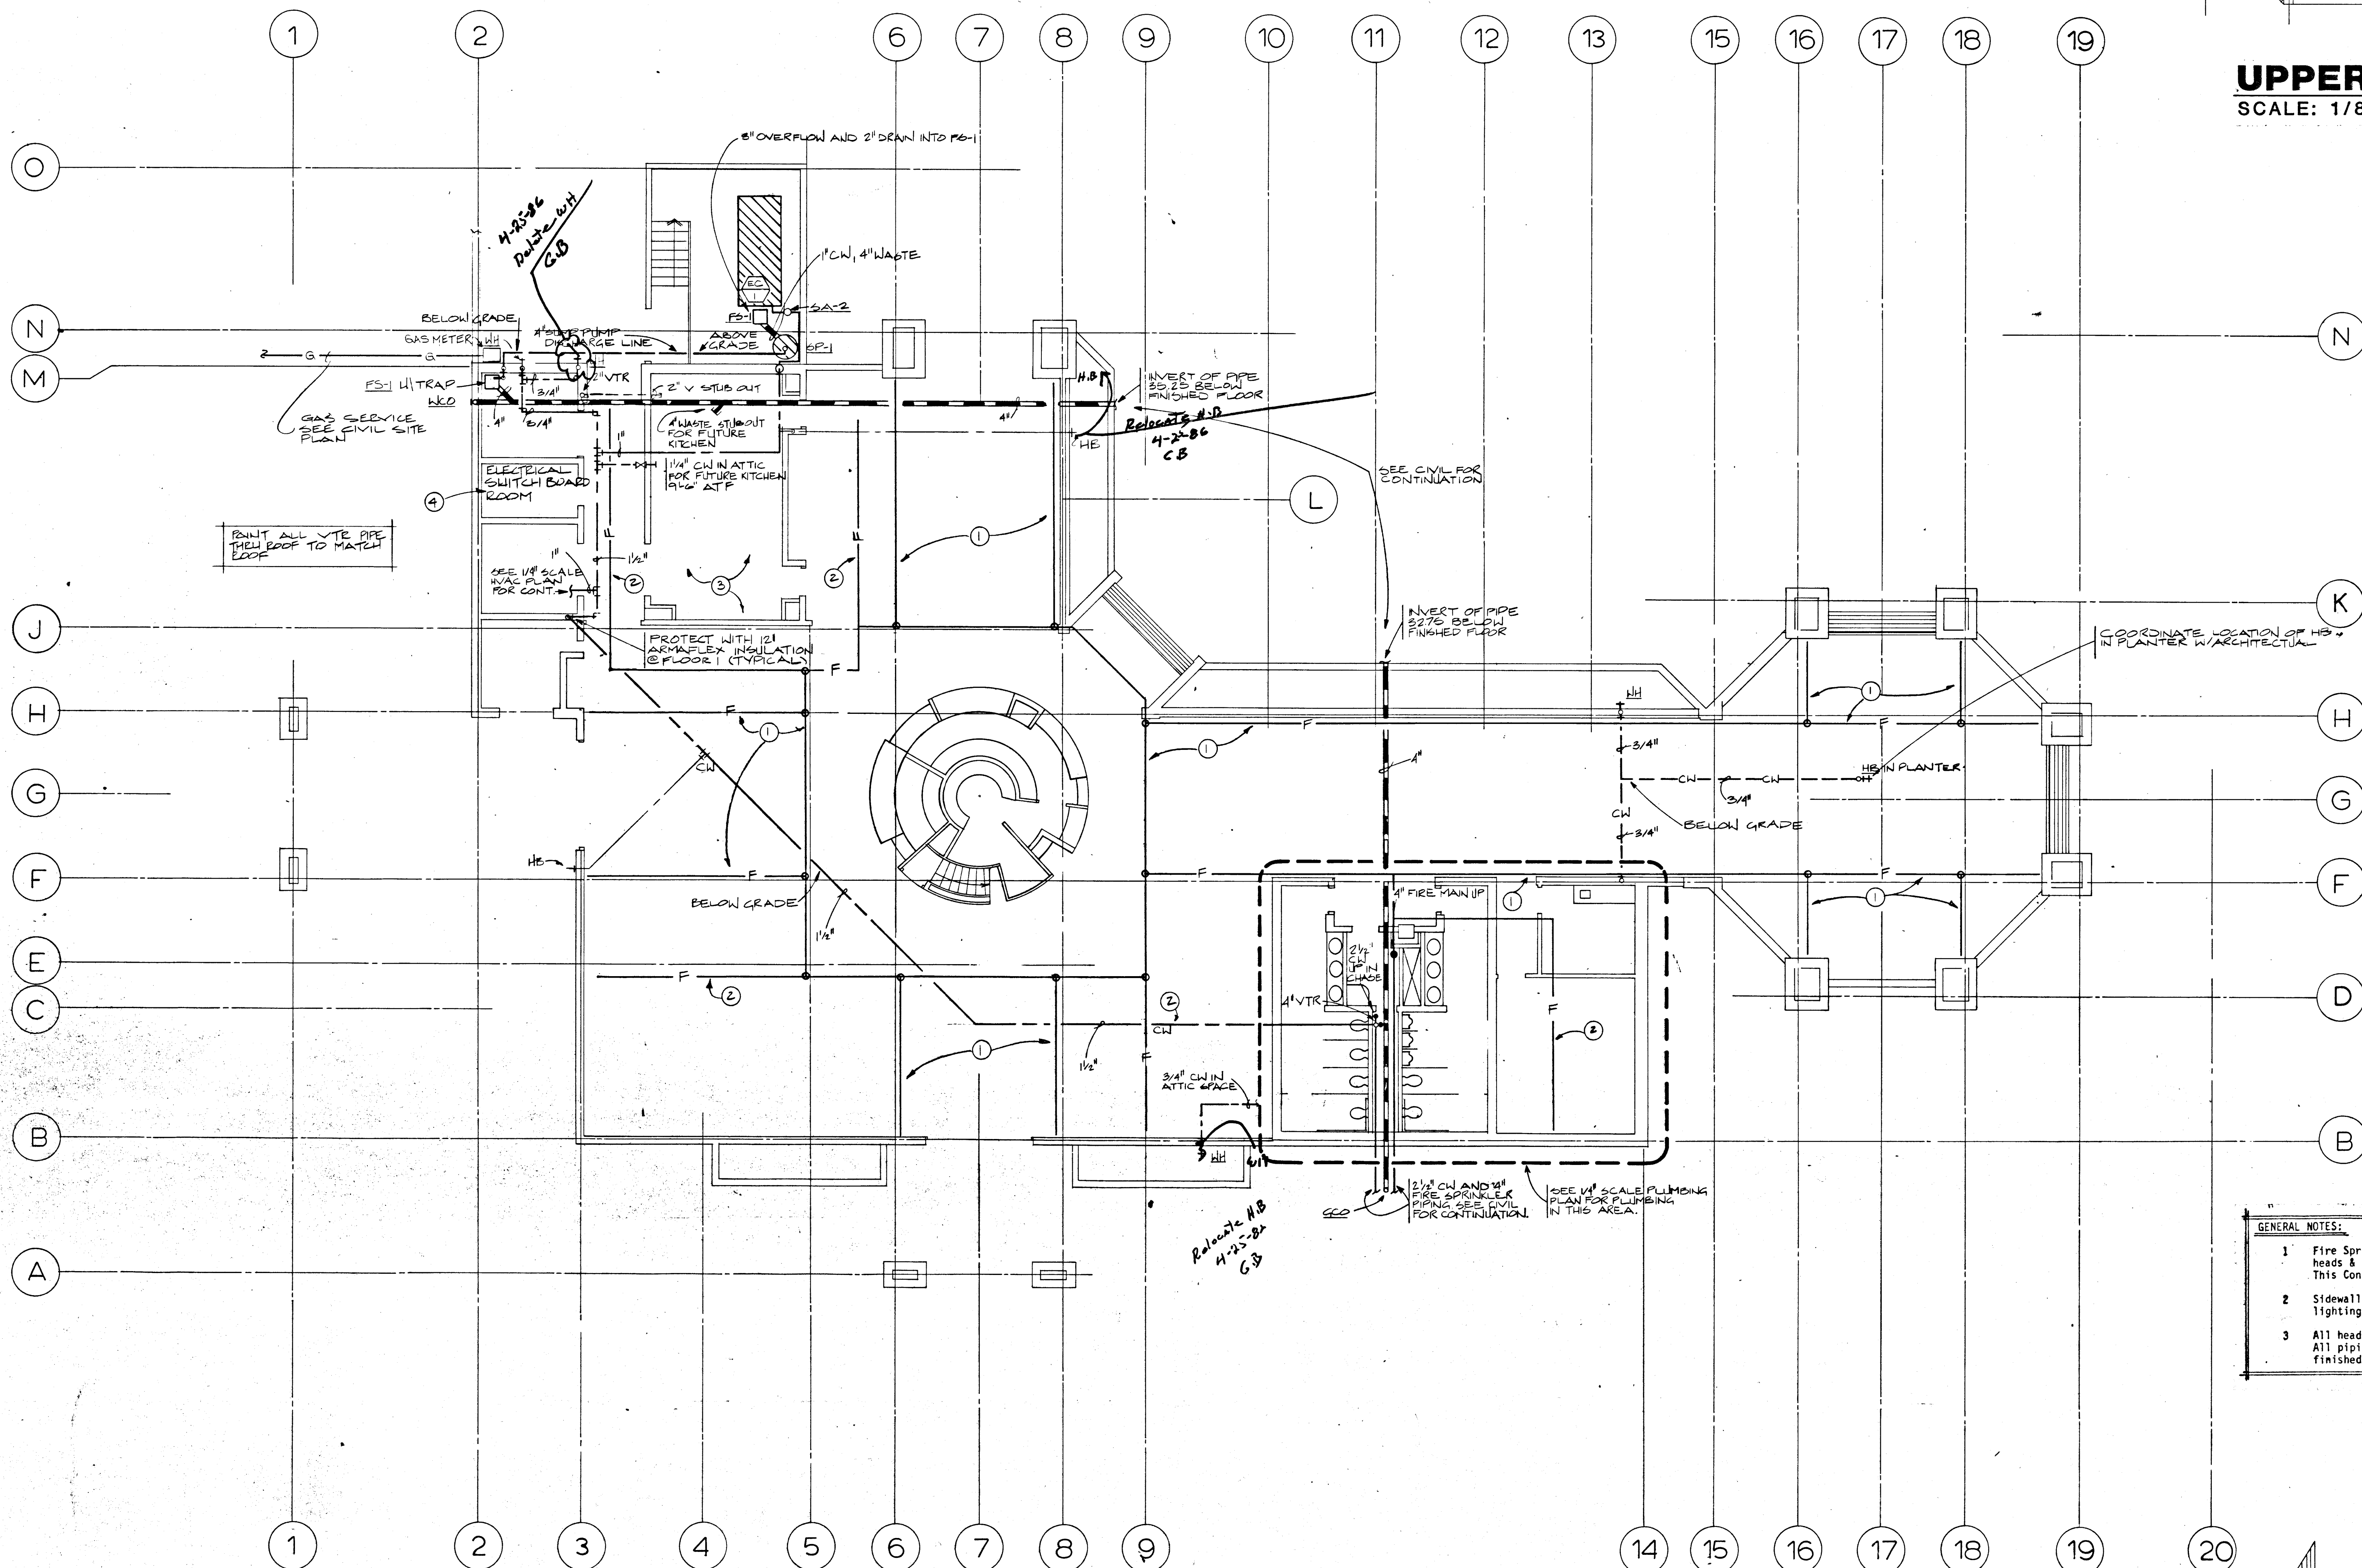

PLUMBING PLAN LOWER LEVEL
SCALE: 1/8" = 1'-0"

GENERAL NOTES:

1. Fire Sprinkler Shop Drawings shall show locations of all heads & routing of mains on reflected ceiling plan backgrounds. This Contractor is bound by NOTES #1 AND #2 on A-14.
2. Sidewall sprinkler heads shall be located above signage & back lighting as shown on Architectural Drawings.
3. All heads in finished spaces shall be brass colored, recessed. All piping shall not be visible from normal viewing angle in finished spaces.

DOB RUSKY KITTRELL GARLOCK
Architects
3333 CAMBRIDGE ST., LAS VEGAS, NEVADA 89109 (702) 733-0433

City of Las Vegas
Downtown Transportation Center
Las Vegas, Nevada

SHEET
M-2
36 of 45
DATE
5/20/01
PROJECT
DOWNTOWN TRANSPORTATION CENTER

DESIGNED BY
CHECKED BY
DATE
5/20/01

PROJECT
DOWNTOWN TRANSPORTATION CENTER