



NOTE:
MECH. CONTRACTOR SHALL PROVIDE CUPOLA LOUVERS. SEE SCHEDULE. NORTH & EAST LOUVERS SHALL BE REMOVABLE AND SHALL BE BLANKED OFF. WEST & SOUTH LOUVERS SHALL BE FIXED IN PLACE AND BLANKED OFF WITH 16 GA. SHEET METAL EXCEPT FOR ONE (1) 36" X 24" BAROMETRIC EXHAUST DAMPER ATTACHED TO THE SOUTH LOUVER. SEE ARCHITECTURAL DETAILS.

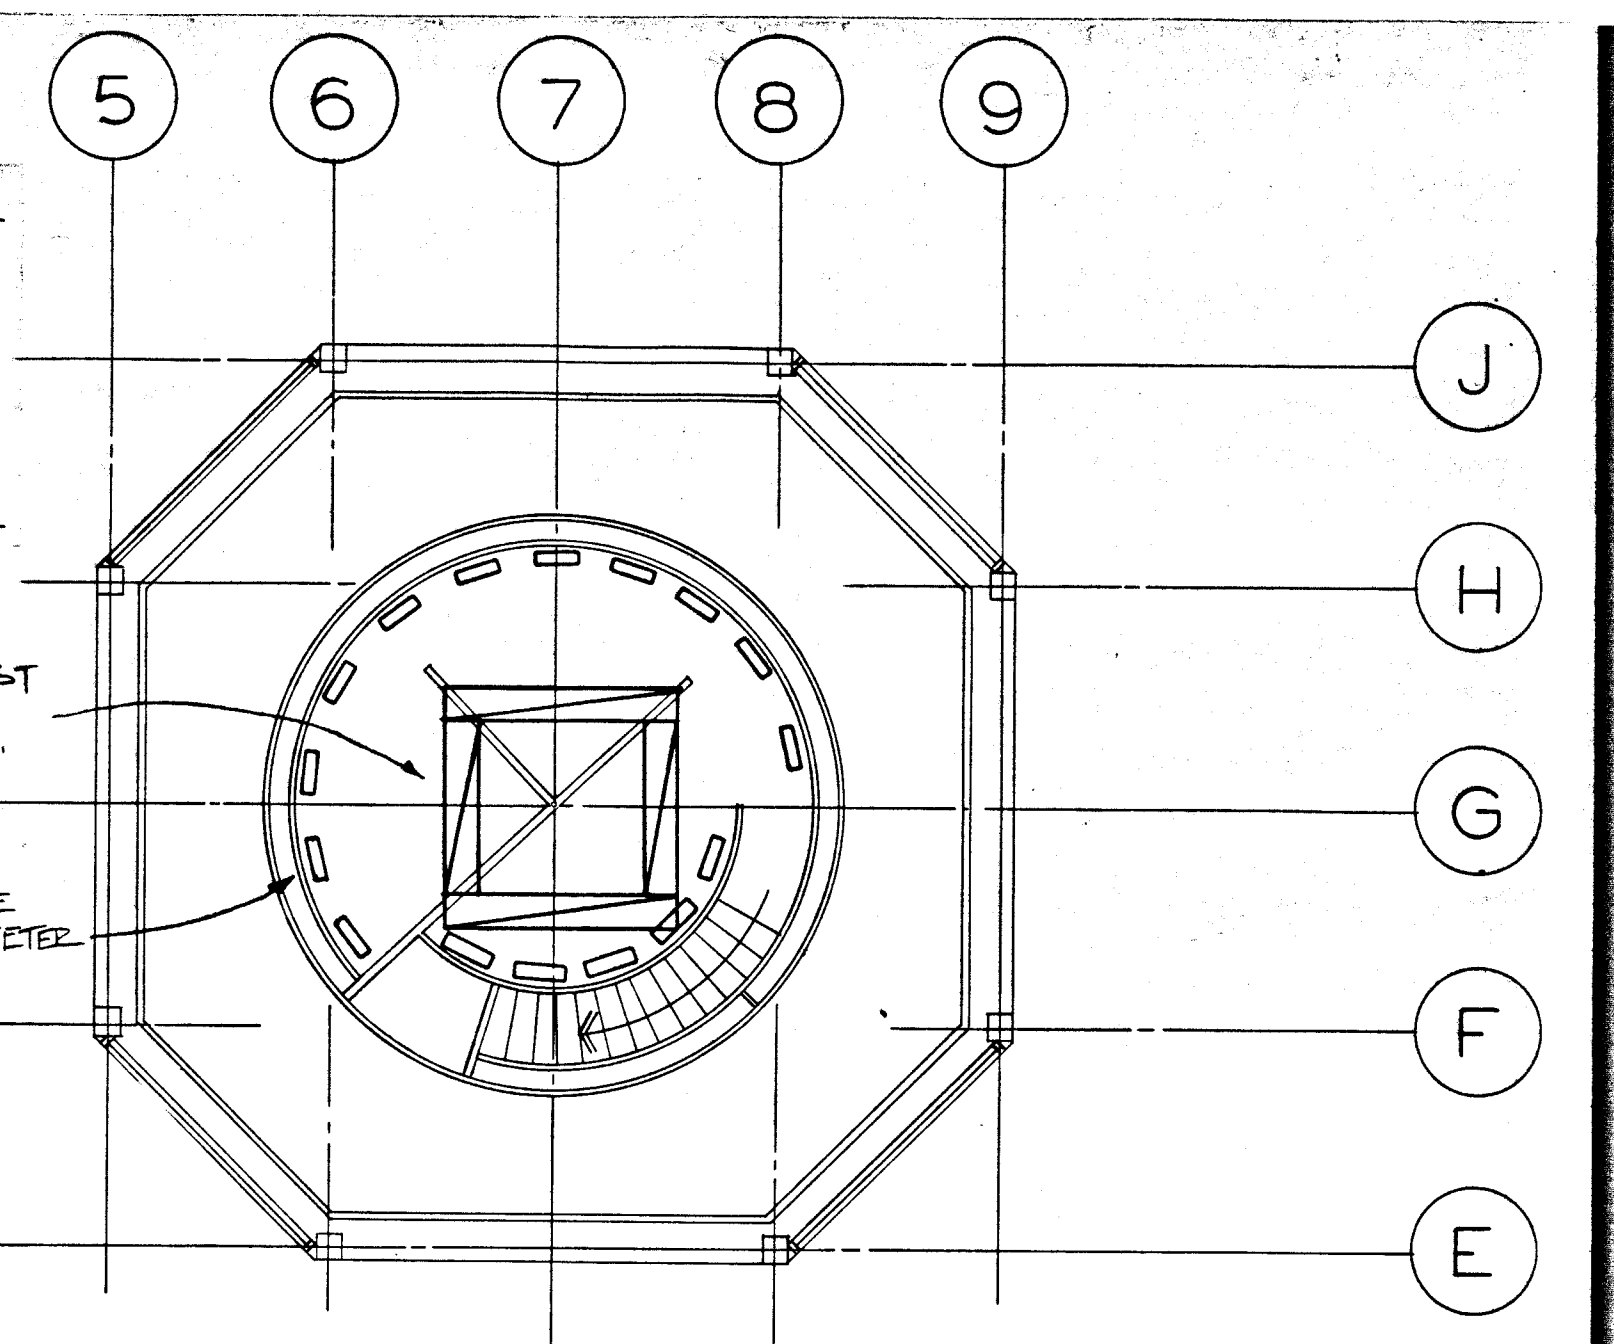

CONTINUOUS EXHAUST AIR GRILLE 4'-3" AT CUPOLA SEE ARCH. PLANS.
(17) D-B 100 CFM EA. FLOOR GRILLES SPACE EVENLY AROUND PERIMETER. PROVIDE SLEEVE TO CEILING SUPPLY AIR PLENUM BELOW.

UPPER LEVEL
SCALE: 1/8" = 1'-0"

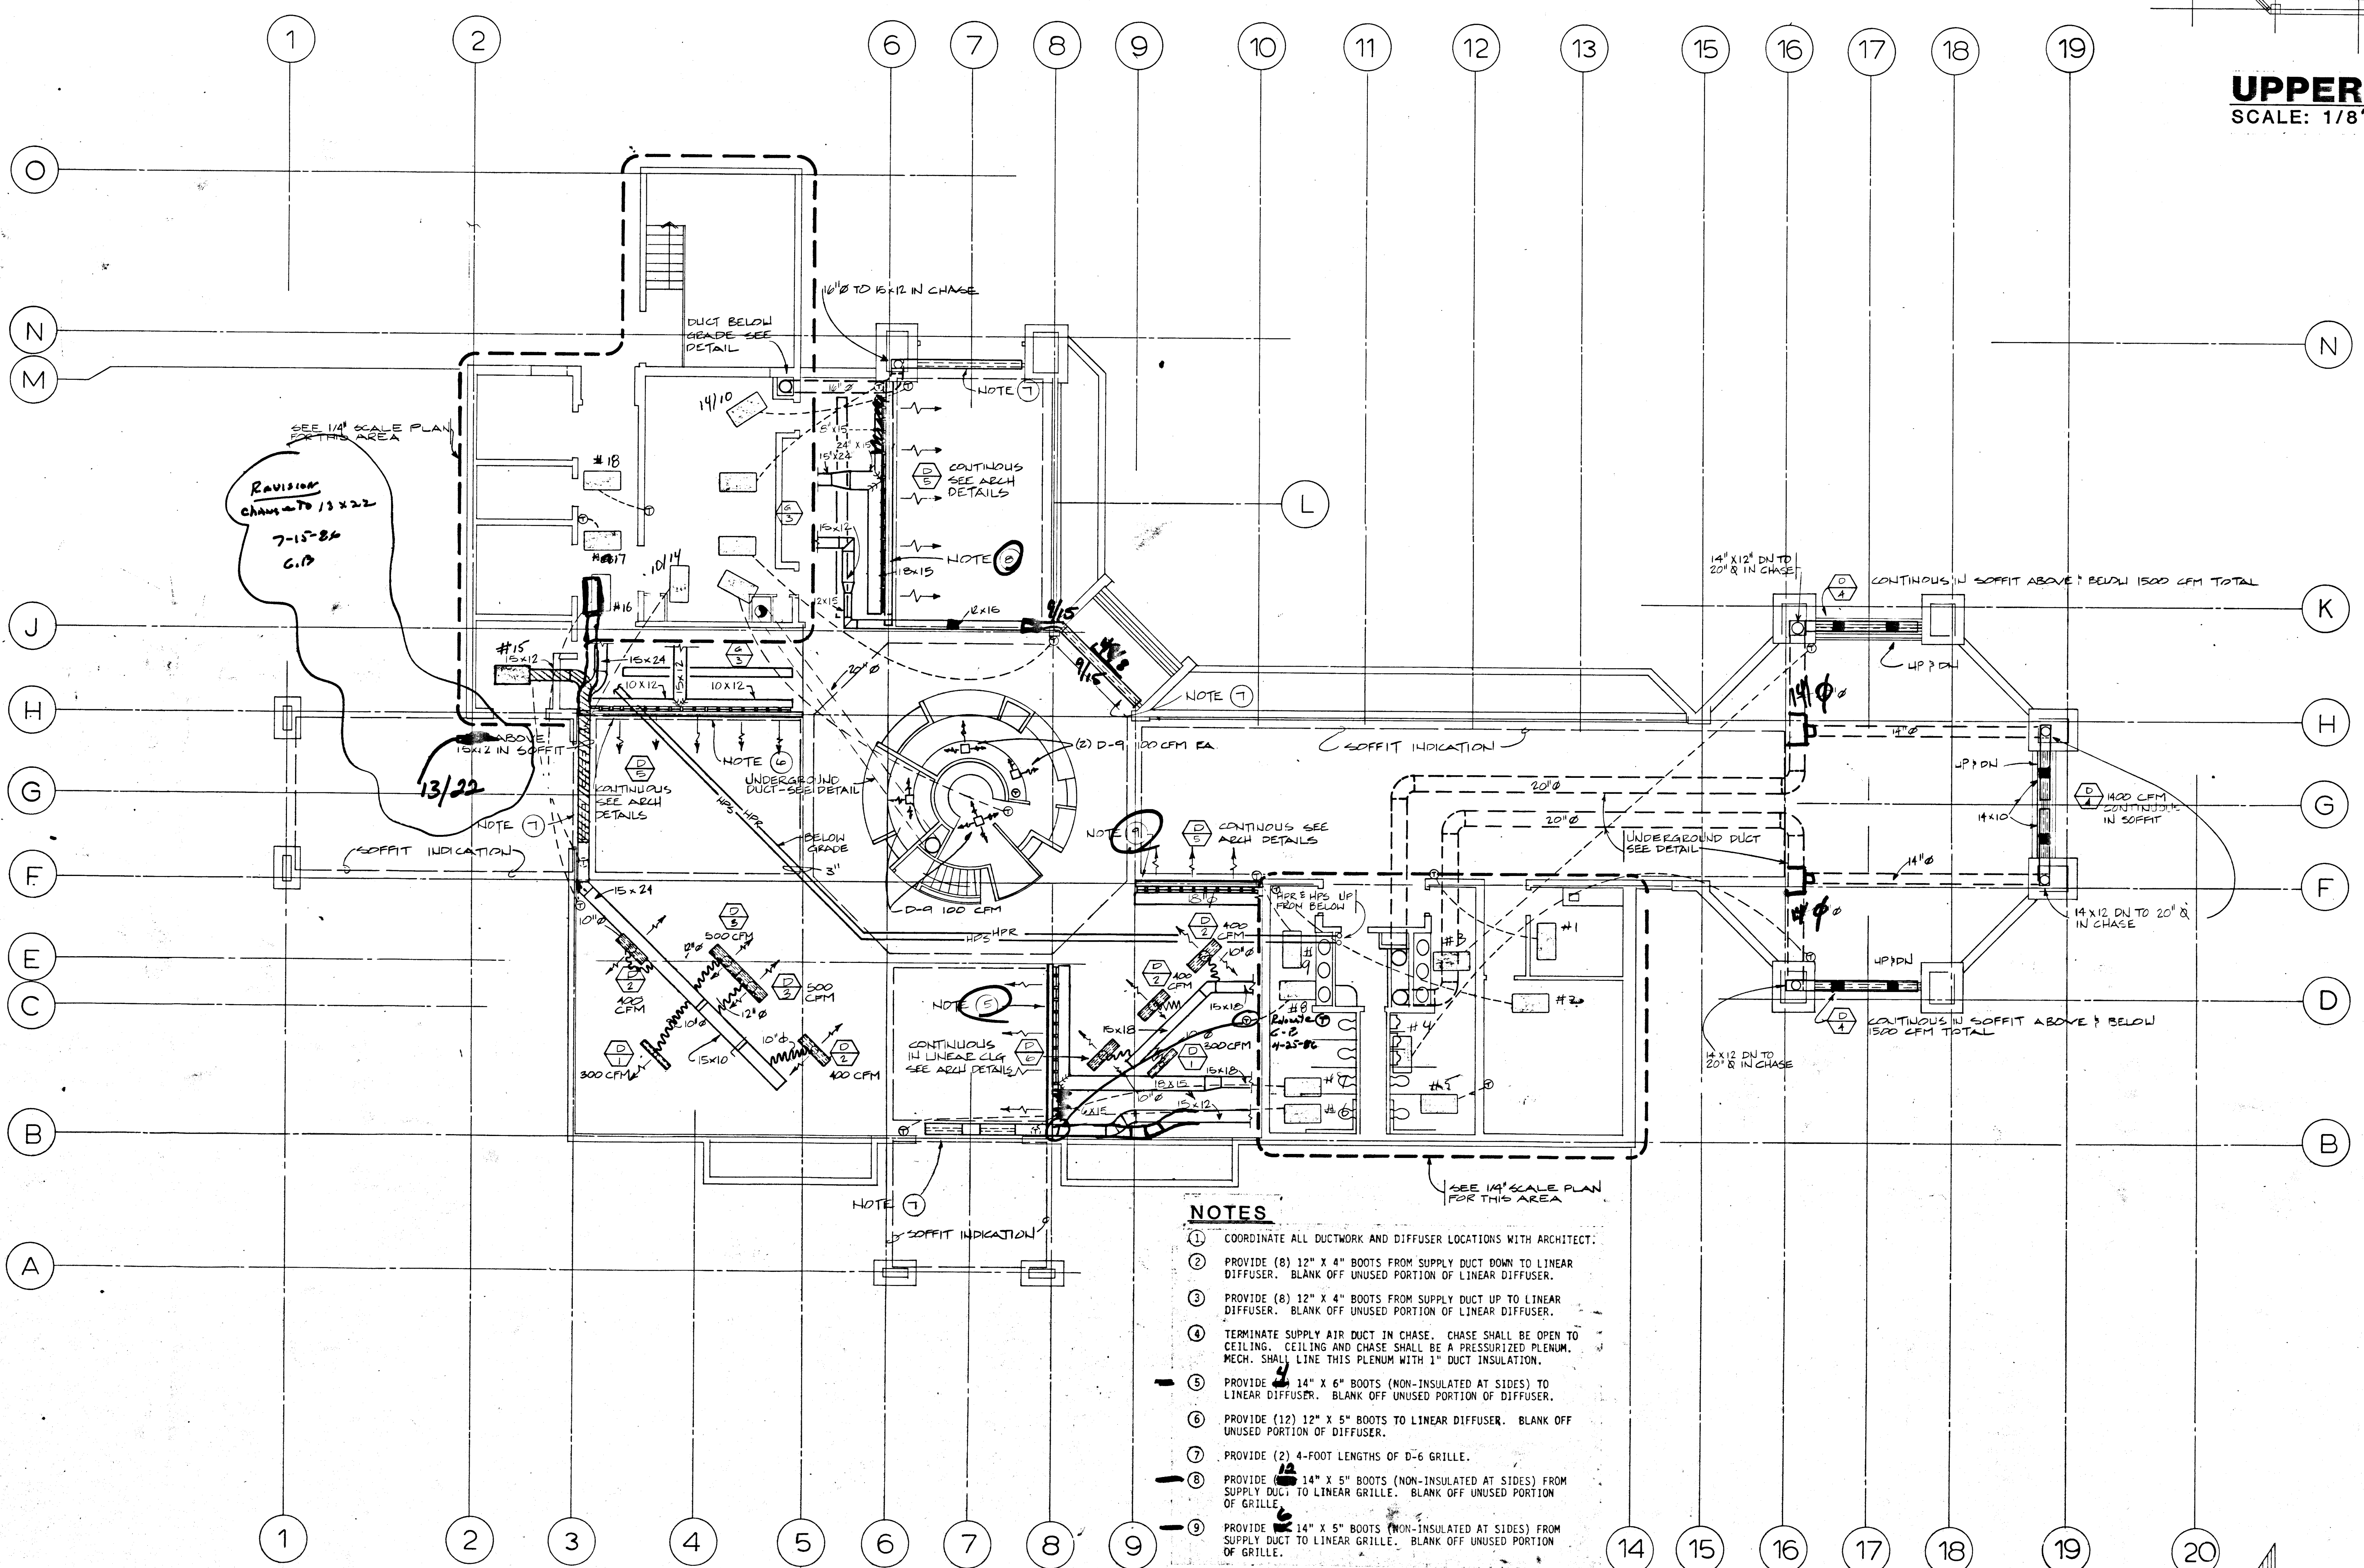

Revision
Change to 13x22
7-15-84
G.P.

NOTES

1. COORDINATE ALL DUCTWORK AND DIFFUSER LOCATIONS WITH ARCHITECT.
2. PROVIDE (8) 12" X 4" BOOTS FROM SUPPLY DUCT DOWN TO LINEAR DIFFUSER. BLANK OFF UNUSED PORTION OF LINEAR DIFFUSER.
3. PROVIDE (8) 12" X 4" BOOTS FROM SUPPLY DUCT UP TO LINEAR DIFFUSER. BLANK OFF UNUSED PORTION OF LINEAR DIFFUSER.
4. TERMINATE SUPPLY AIR DUCT IN CHASE. CHASE SHALL BE OPEN TO CEILING. CEILING AND CHASE SHALL BE A PRESSURIZED PLENUM. MECH. SHALL LINE THIS PLENUM WITH 1" DUCT INSULATION.
5. PROVIDE 14" X 6" BOOTS (NON-INSULATED AT SIDES) TO LINEAR DIFFUSER. BLANK OFF UNUSED PORTION OF DIFFUSER.
6. PROVIDE (12) 12" X 5" BOOTS TO LINEAR DIFFUSER. BLANK OFF UNUSED PORTION OF DIFFUSER.
7. PROVIDE (2) 4-FOOT LENGTHS OF D-6 GRILLE.
8. PROVIDE 14" X 5" BOOTS (NON-INSULATED AT SIDES) FROM SUPPLY DUCT TO LINEAR GRILLE. BLANK OFF UNUSED PORTION OF GRILLE.
9. PROVIDE 14" X 5" BOOTS (NON-INSULATED AT SIDES) FROM SUPPLY DUCT TO LINEAR GRILLE. BLANK OFF UNUSED PORTION OF GRILLE.

LOWER LEVEL HVAC PLAN
SCALE: 1/8" = 1'-0"

NORTH

DUNHAM ASSOCIATES INC.
CONSULTING ENGINEERS

198 E. HAWAIIAN AVE.
SUITE 200
LAS VEGAS, NV 89101
(702) 733-0455

DOBRSKY KITRELL GARLOCK
Architects

3000 CAMDEN DR. LAS VEGAS, NEVADA 89109
(702) 733-0455

City of Las Vegas

Downtown

Transportation Center

Las Vegas, Nevada

SHEET

M-3

DATE

5/24/84

BY

5/24/84