
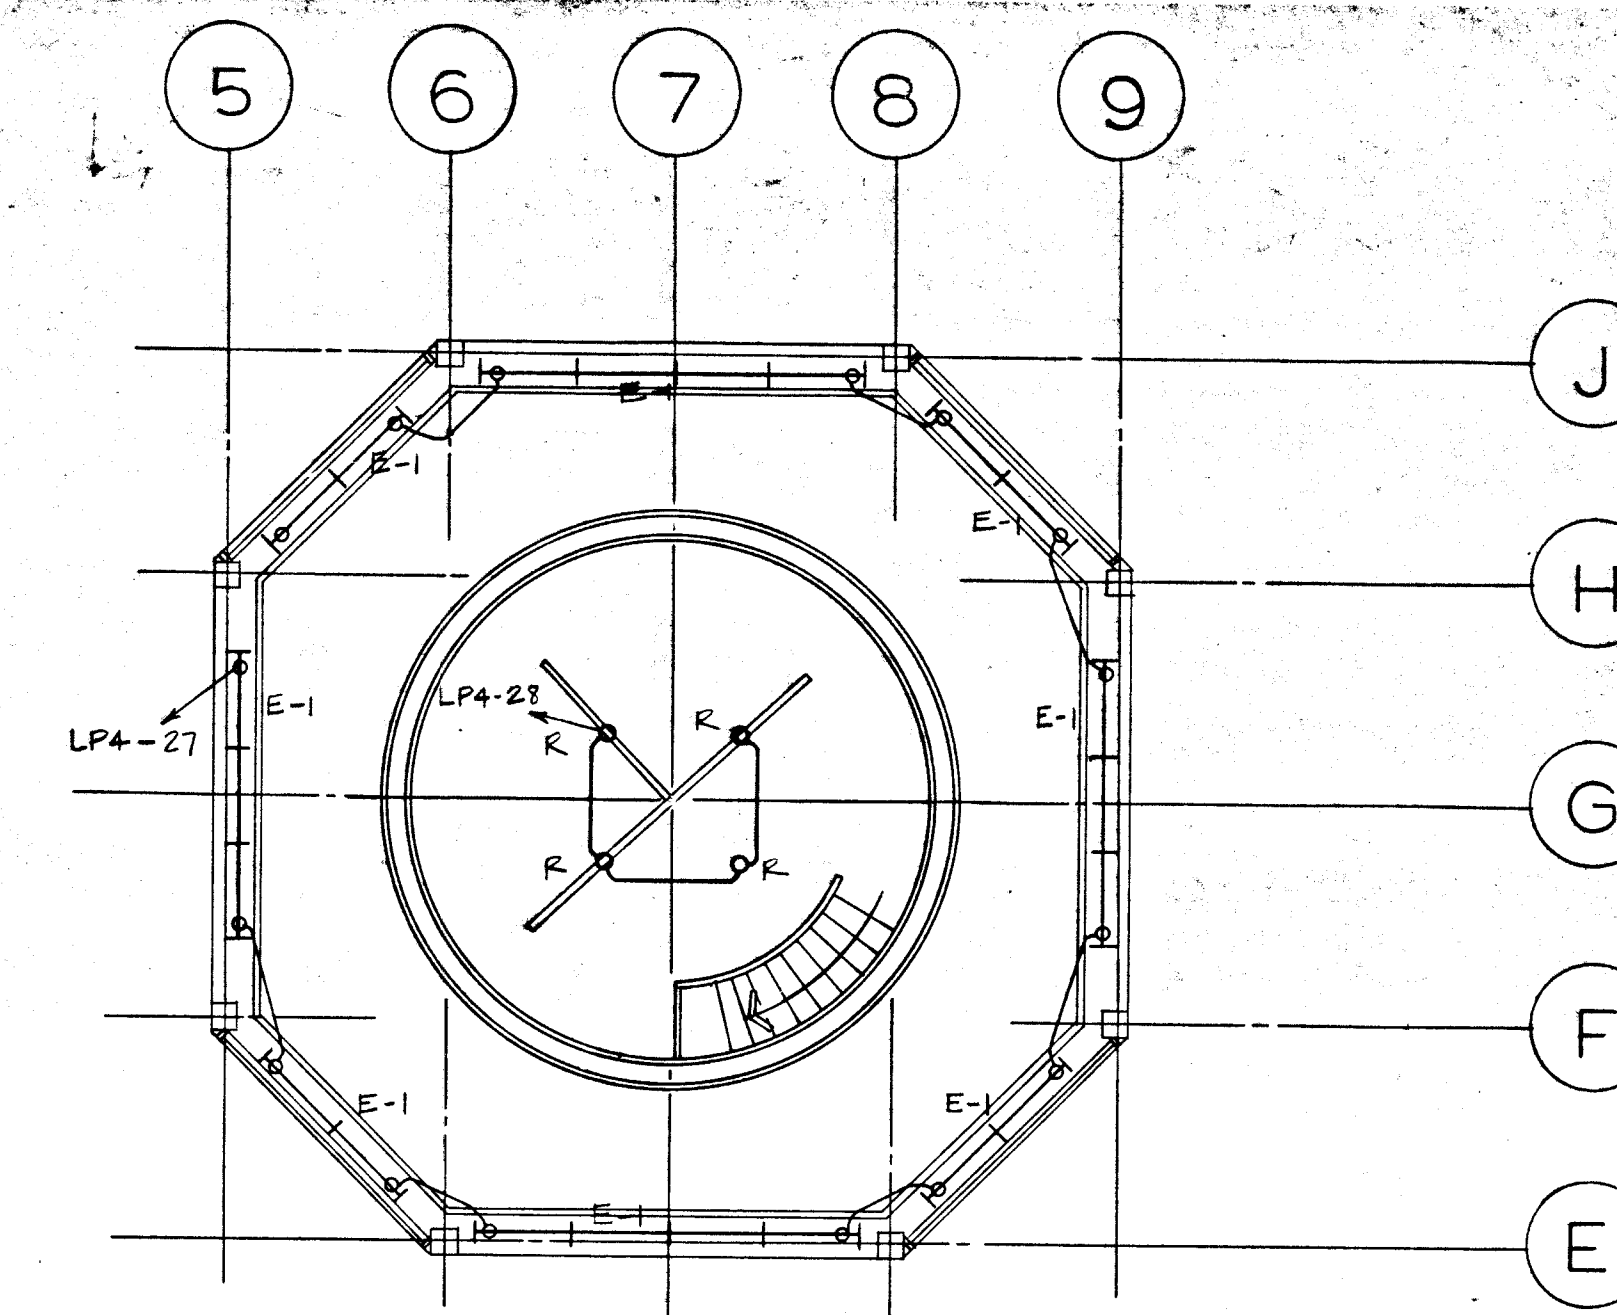


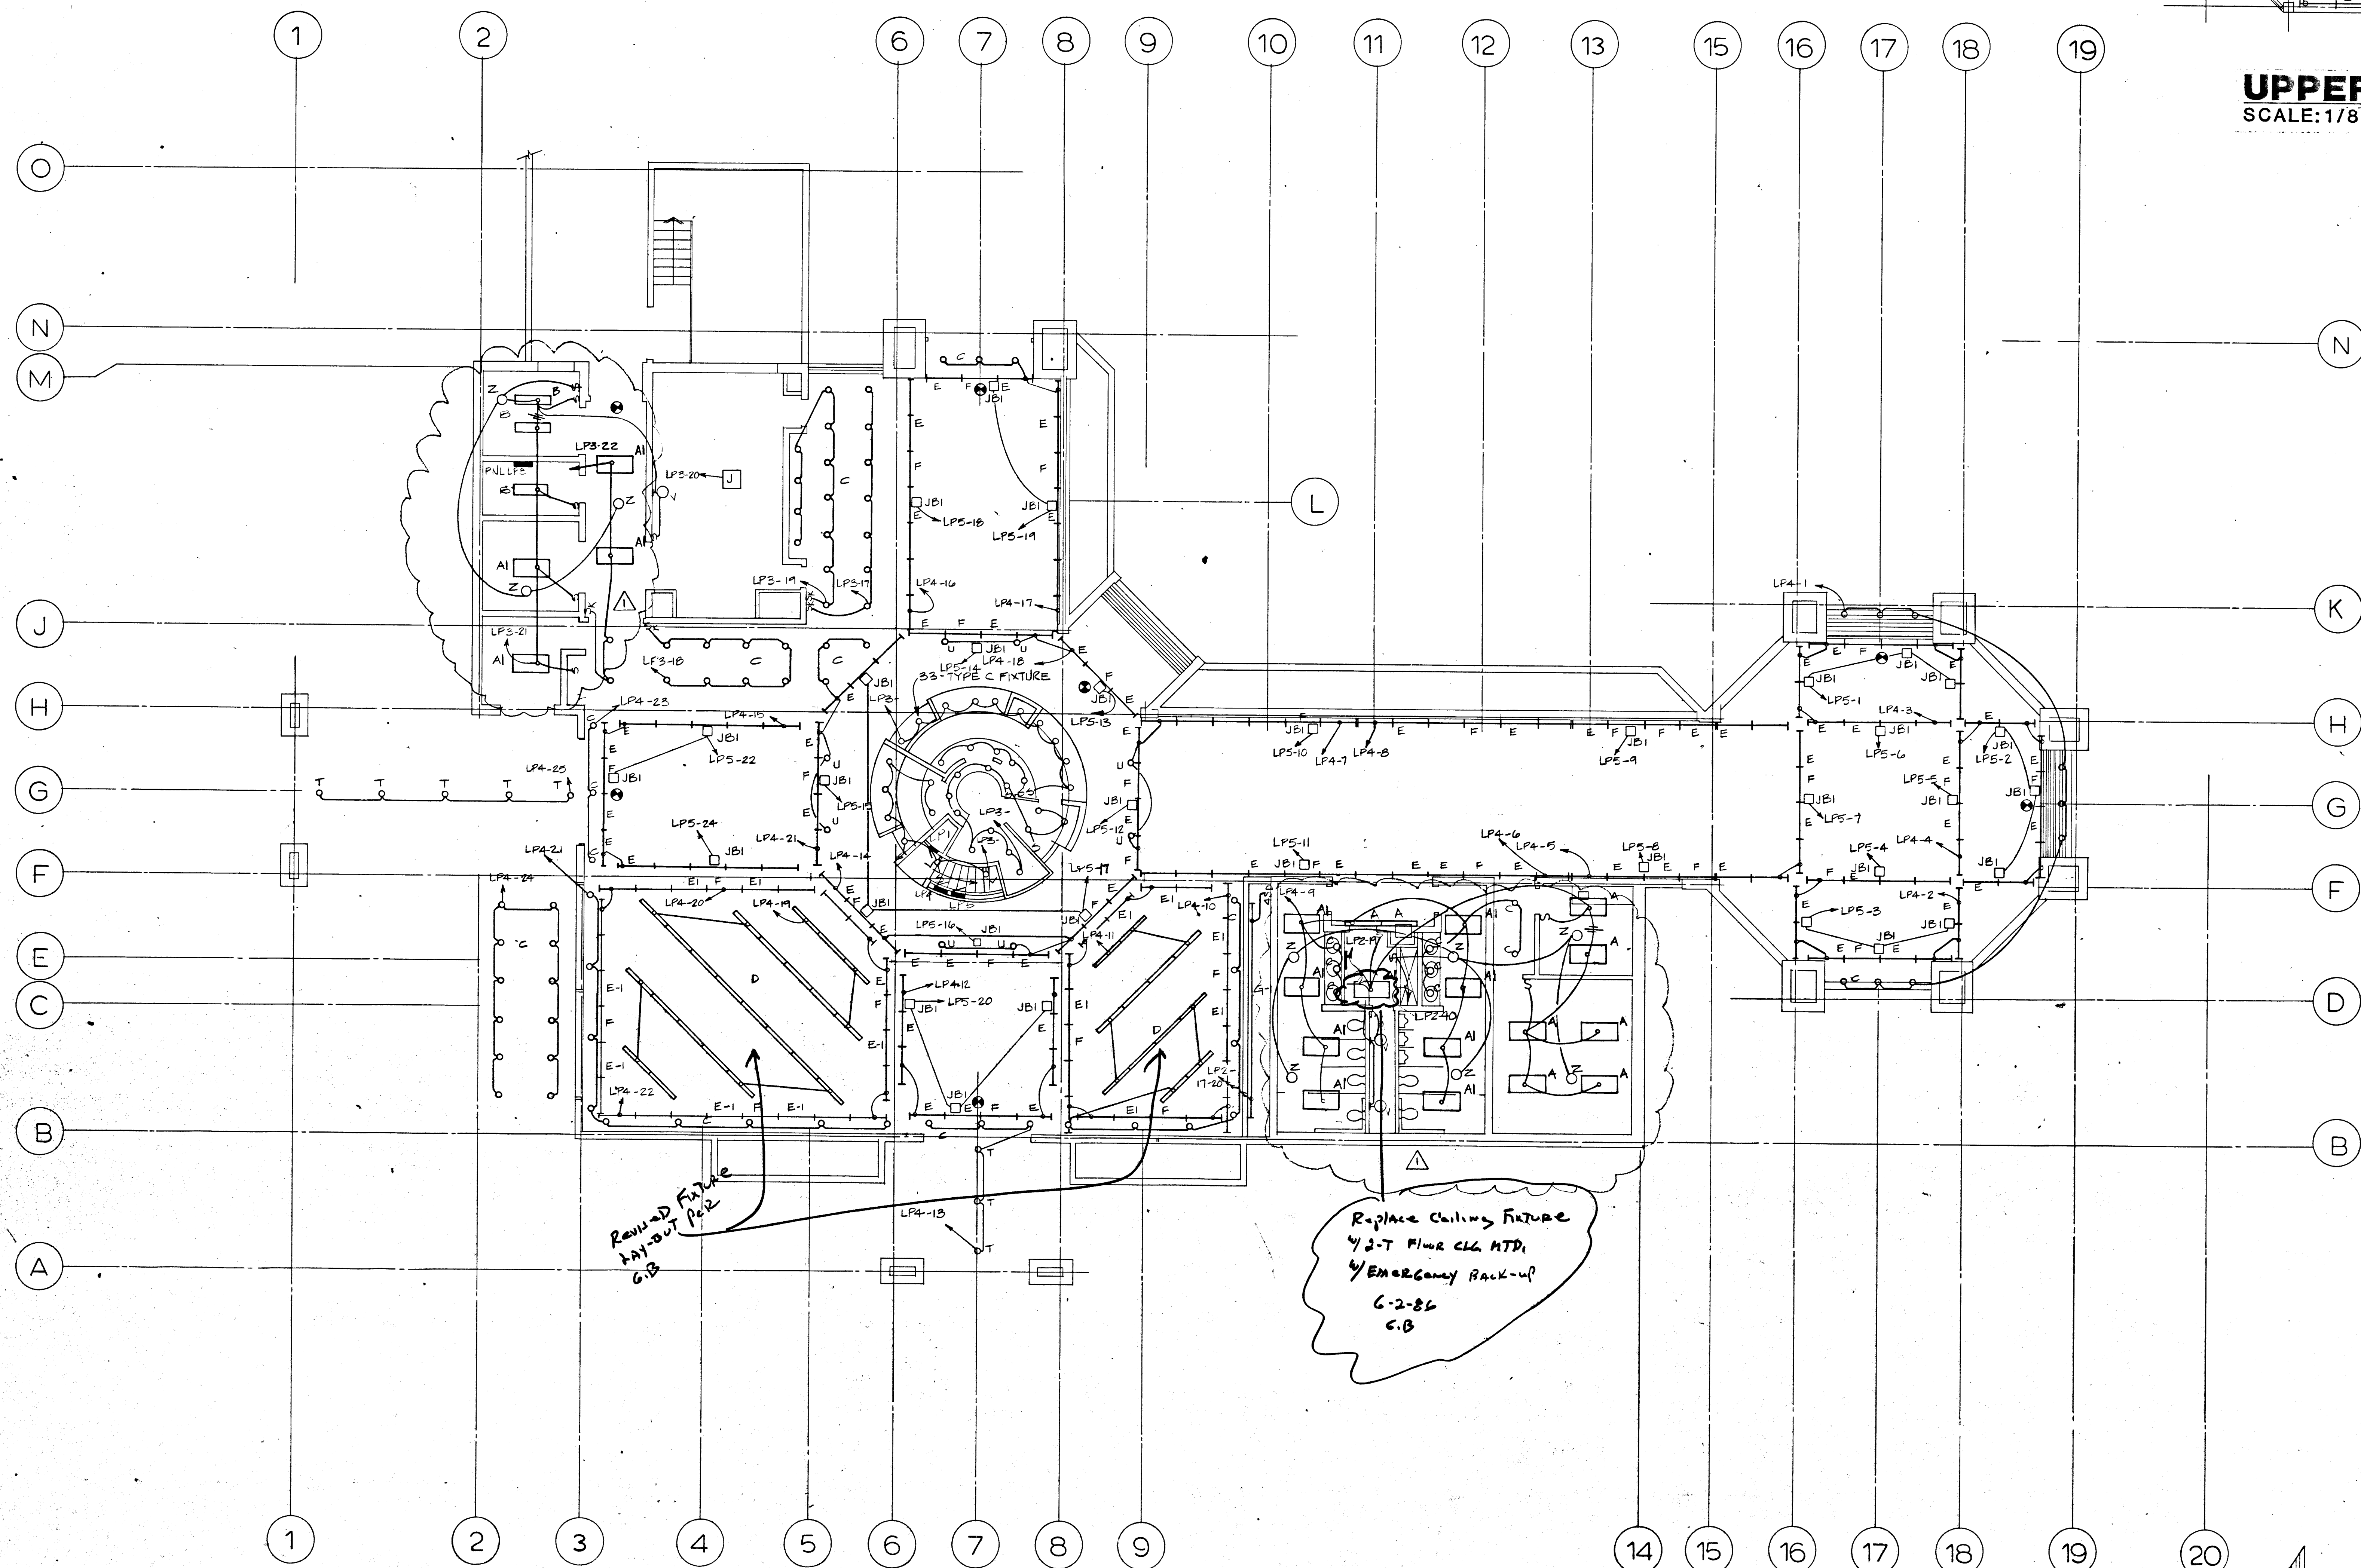

UPPER LEVEL
SCALE: 1/8" = 1'-0"

INTERIOR LIGHTING PLAN
SCALE: 1/8" = 1'-0"

NORTH