


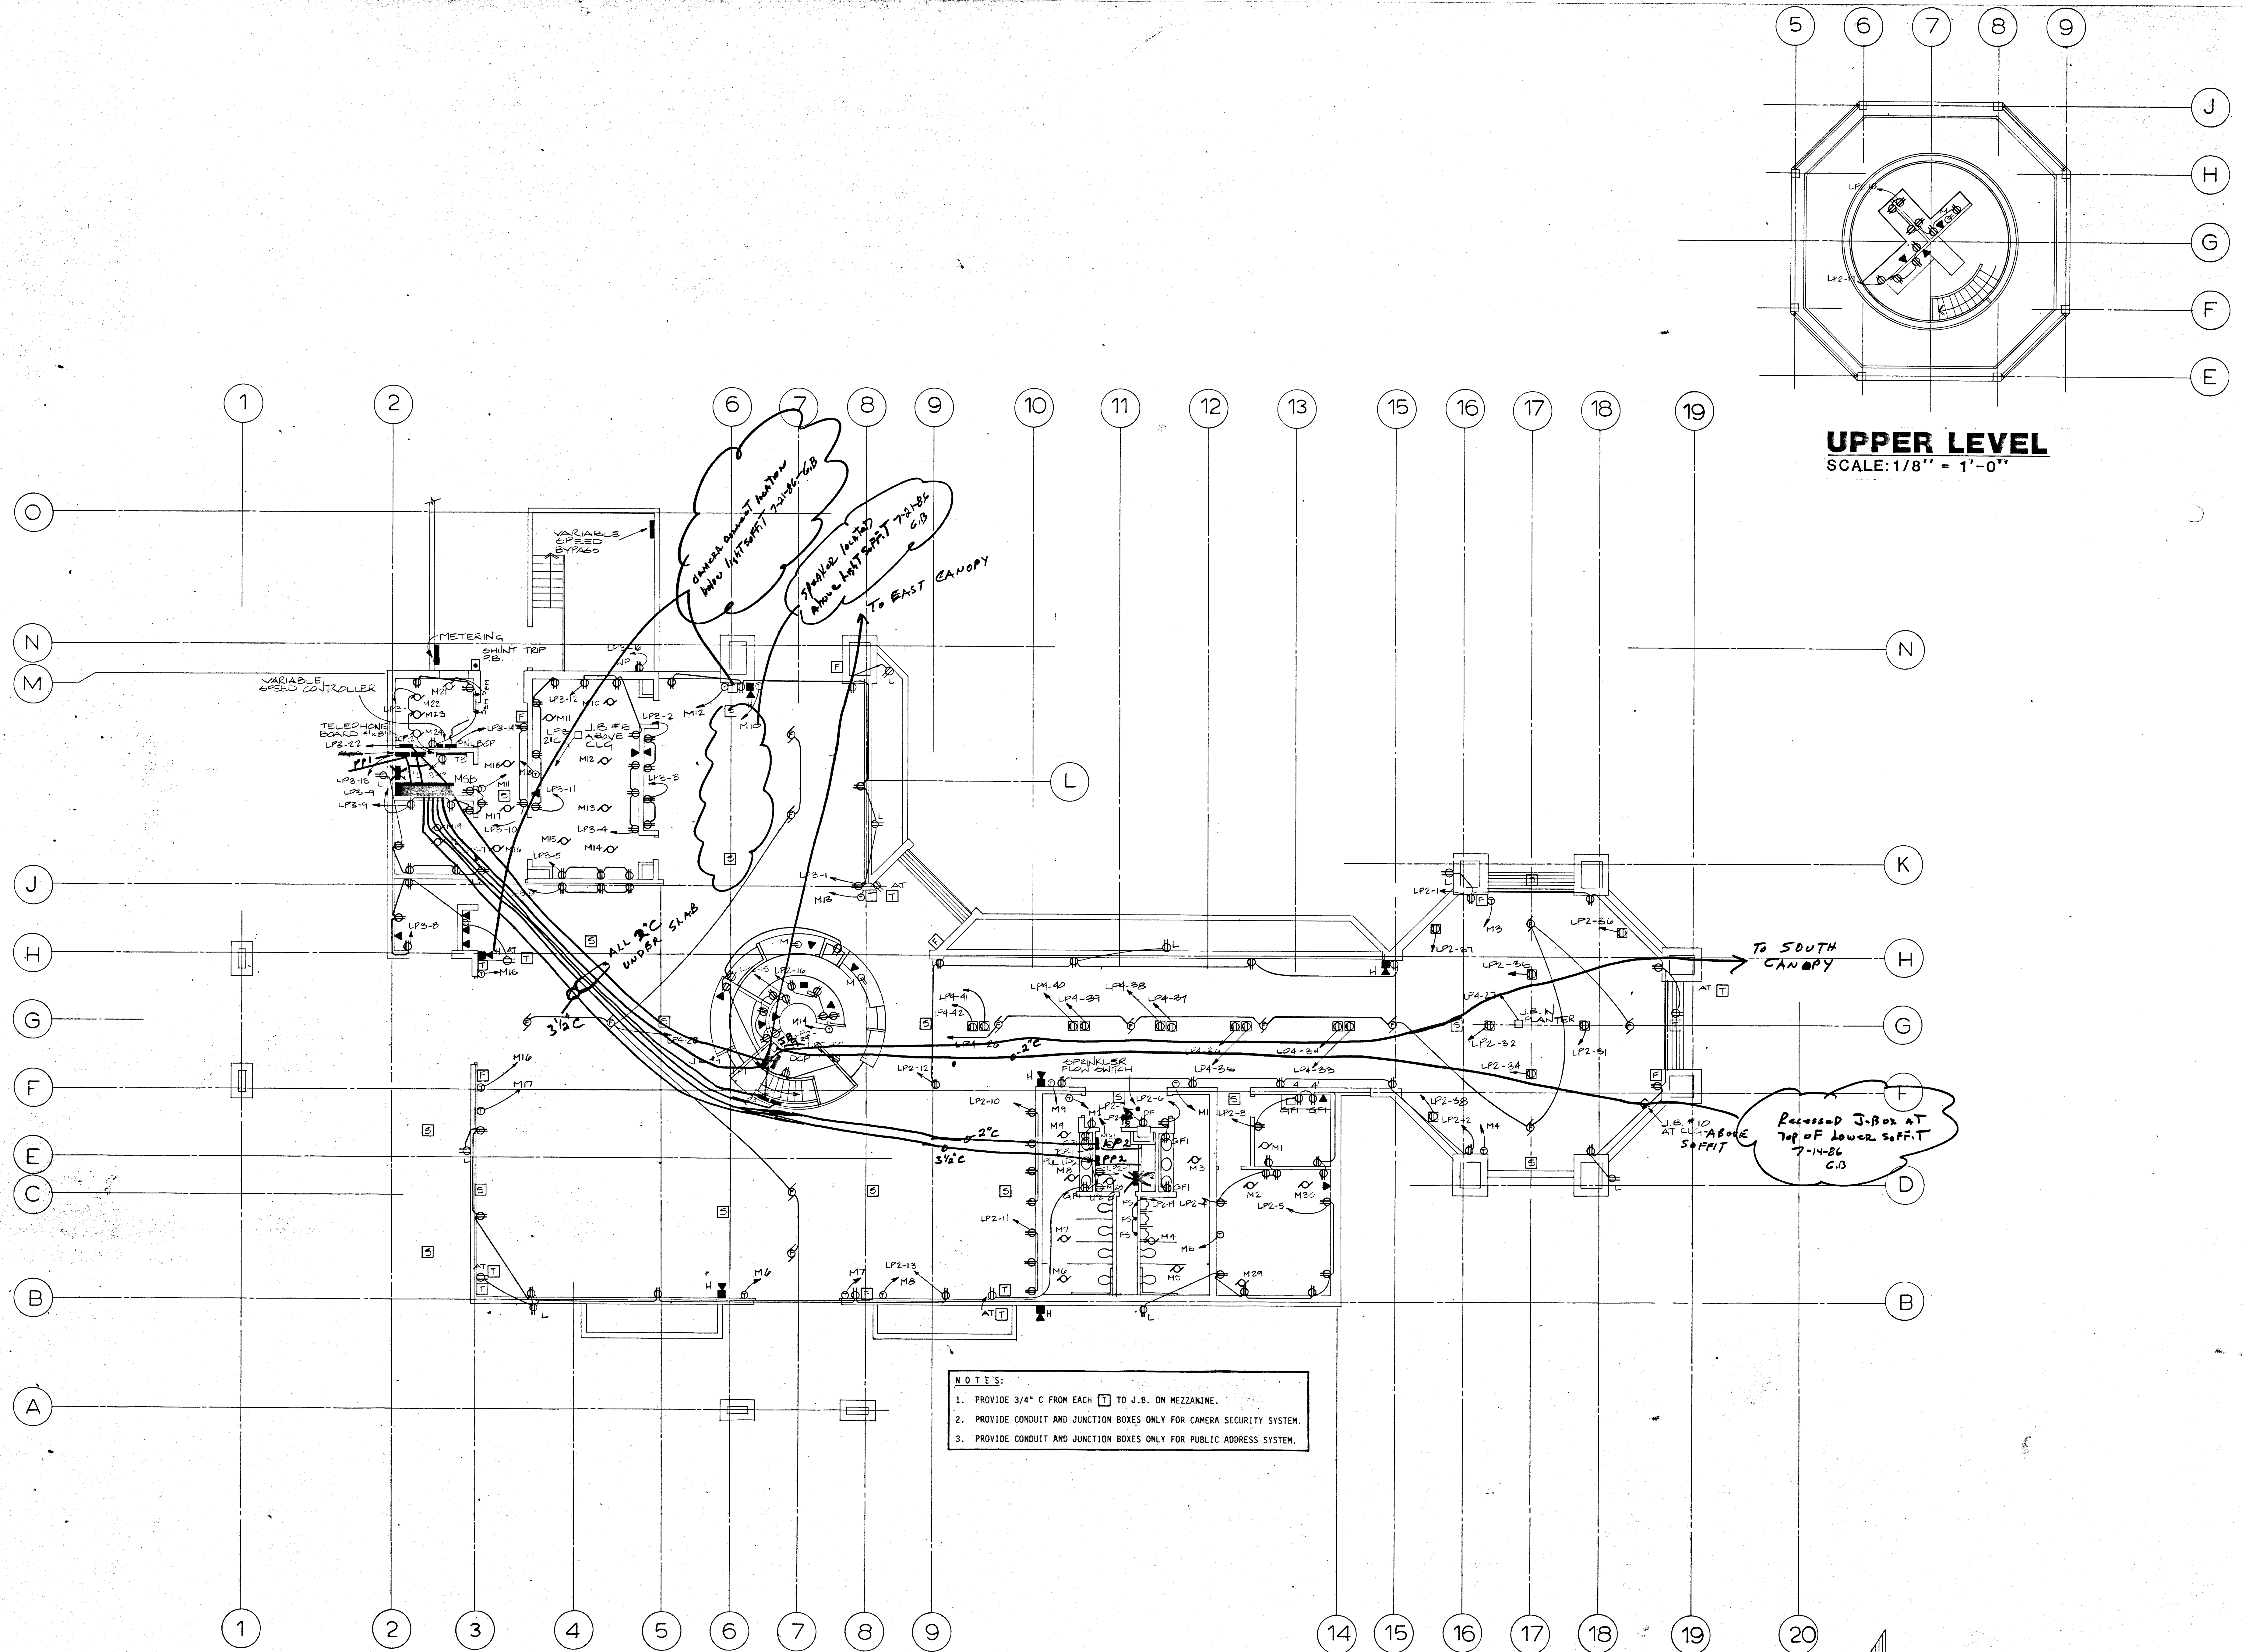

UPPER LEVEL
SCALE: 1/8" = 1'-0"

INTERIOR POWER, TELEPHONE & FIRE ALARM PLAN
SCALE: 1/8" = 1'-0"

- NOTES:
1. PROVIDE 3/4" C FROM EACH [] TO J.B. ON MEZZANINE.
 2. PROVIDE CONDUIT AND JUNCTION BOXES ONLY FOR CAMERA SECURITY SYSTEM.
 3. PROVIDE CONDUIT AND JUNCTION BOXES ONLY FOR PUBLIC ADDRESS SYSTEM.

NORTH

DUNHAM ASSOCIATES INC.
CONSULTING ENGINEERS
1001 JEFFERSON BLVD.
LAS VEGAS, NEVADA 89101

DOBBSKY KITRELL GARLOCK
Architects
3003 CAMBRIDGE ST. LAS VEGAS, NEVADA 89102 (702) 733-4455

City of Las Vegas
Downtown Transportation Center
Las Vegas, Nevada

SHEET
E-3

DATE: 4/1/82
DRAWN: J.E.P.
CHECKED: J.E.P.
BY: J.E.P.