


CONSTRUCTION NOTES

- D-1 REMOVE ASPHALT PAVEMENT, CONCRETE CURB AND SIDEWALK. PAVED AREAS TO BE REMOVED ARE SHOWN SHADED. REMOVE LANDSCAPING AND OTHER APPURTENANCES AS REQUIRED FOR NEW CONSTRUCTION.
- D-2 OUTLINE OF NEW PAVING, CURB AND/OR SIDEWALK. REFER TO SHEETS CG1.1 - CG1.12.
- D-3 REMOVE EXISTING BUILDING, ASPHALT PAVEMENT, CURBS, SIDEWALKS, LANDSCAPING, IRRIGATION, UTILITIES AND OTHER APPURTENANCES AS REQUIRED FOR NEW CONSTRUCTION. REFER TO ARCHITECTURAL DEMOLITION AND PHASING DRAWINGS FOR ADDITIONAL INFORMATION.
- D-4 EXISTING PAVEMENT STRIPPING TO BE REMOVED.
- D-5 OUTLINE OF EXISTING BUILDING TO BE REMOVED.
- D-6 EXISTING WALK TO REMAIN.
- D-7 EXISTING TRAILERS TO REMAIN. PROTECT EXISTING UTILITIES.
- D-8 EXISTING SWITCH GEAR TO BE REMOVED.
- D-9 EXISTING SWITCH GEAR TO REMAIN.
- D-10 EXISTING NEVADA POWER TRANSFORMER AND SWITCH TO REMAIN.
- D-11 SAWCUT EXISTING CURB AND REMOVE.
- D-12 SAWCUT EXISTING PAVEMENT AND REMOVE.
- D-13 SAWCUT EXISTING SIDEWALK AND REMOVE.
- D-14 EXISTING FENCING. REFER TO ARCHITECTURAL SITE PLAN AND CONSTRUCTION PHASING DRAWINGS.
- D-15 EXISTING ELECTRICAL AND/OR TELECOMMUNICATIONS UTILITY OR ELEMENT. REFER TO SITE ELECTRICAL PLAN FOR RELOCATION'S AND/OR REMOVALS.
- D-16 EXISTING ELECTRICAL LIGHT POLE TO BE RELOCATED. REFER TO SHEETS CG1.1 - CG1.12.
- D-17 SAWCUT AND REMOVE EXISTING SIDEWALK, ASPHALT PAVEMENT, CURB AND GUTTER AS REQUIRED FOR NEW OR RECONSTRUCTED DRIVEWAY.
- D-18 EXISTING FIRE HYDRANT TO BE RELOCATED. SEE SHEET C-4.1 FOR NEW LOCATION.

CITY FIRE MARSHAL
[Signature] Date: 4-27-99

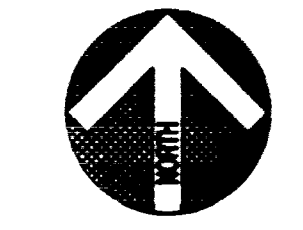

SCALES 1"=40'

DMJM

DMJM P.C.
 A Division of
 DANIEL, MANN, JOHNSON, & MENDENHALL
 1455 East Tropicana, Suite 400
 Las Vegas, Nevada 89119
 (702) 251-0806 (702) 222-2232 fax


In association with
Perlman
 ARCHITECTS
 2230 Corporate Circle, Suite 200
 Henderson, NV 89014
 (702) 990-9900 (702) 932-3222 fax

DMJM Arizona, Inc.
 Architecture, Structure, Civil,
 Mechanical, Electrical, Plumbing
 2777 East Camelback Road, Suite 200
 Phoenix, AZ 85016-4302 (602) 537-2777

**CLARK COUNTY
 DEPARTMENT OF
 FAMILY AND
 YOUTH SERVICES**

601 North Pease Road
 Las Vegas, NV 89101-2417
 (702) 456-6210 phone (702) 456-6218 fax
 Kirby L. Burgess, Director
 Cranford L. Crawford, Asst. Director
 Adrienne B. Cox, Asst. Director


**CITY
 RESUBMITTAL**

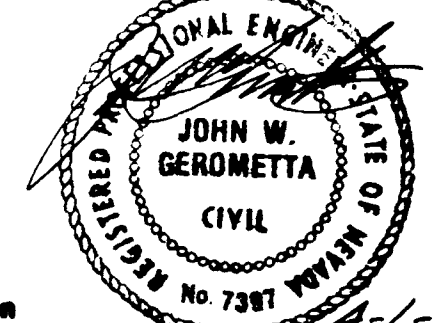

Registration No. 7381 4-6-99

Revisions	No.	Description
△	11-09-98	ADENDUM #1
△	12/15/98	CITY REVISION
△	04/06/99	CITY REVISION

Date: FEBRUARY 12, 1999
 Drawn By: SMS/SAS
 DMJM Job No.: 5745.03

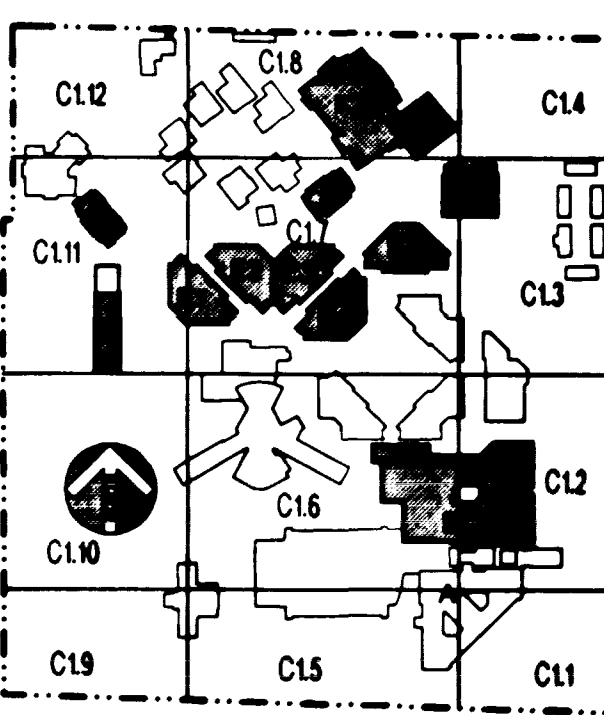

**Key Plan
 EXISTING UTILITIES
 AND DEMOLITION**

C-1.3

