


CONSTRUCTION NOTES

- D-1 REMOVE ASPHALT PAVEMENT, CONCRETE CURB AND SIDEWALK. PAVED AREAS TO BE REMOVED ARE SHOWN SHADED. REMOVE LANDSCAPING AND OTHER APPURTENANCES AS REQUIRED FOR NEW CONSTRUCTION.
- D-2 OUTLINE OF NEW PAVING, CURB AND/OR SIDEWALK. REFER TO SHEETS CG1.1 - CG1.2.
- D-3 REMOVE EXISTING BUILDING, ASPHALT PAVEMENT, CURBS, SIDEWALKS, LANDSCAPING, IRRIGATION, UTILITIES AND OTHER APPURTENANCES AS REQUIRED FOR NEW CONSTRUCTION. REFER TO ARCHITECTURAL DEMOLITION AND PHASING DRAWINGS FOR ADDITIONAL INFORMATION.
- D-4 EXISTING PAVEMENT STRIPPING TO BE REMOVED.
- D-5 OUTLINE OF EXISTING BUILDING TO BE REMOVED.
- D-6 EXISTING WALK TO REMAIN.
- D-7 EXISTING TRAILERS TO REMAIN. PROTECT EXISTING UTILITIES.
- D-8 EXISTING SWITCH GEAR TO BE REMOVED.
- D-9 EXISTING SWITCH GEAR TO REMAIN.
- D-10 EXISTING NEVADA POWER TRANSFORMER AND SWITCH TO REMAIN.
- D-11 SAWCUT EXISTING CURB AND REMOVE.
- D-12 SAWCUT EXISTING PAVEMENT AND REMOVE.
- D-13 SAWCUT EXISTING SIDEWALK AND REMOVE.
- D-14 EXISTING FENCING. REFER TO ARCHITECTURAL SITE PLAN AND CONSTRUCTION PHASING DRAWINGS.
- D-15 EXISTING ELECTRICAL AND/OR TELECOMMUNICATIONS UTILITY OR ELEMENT. REFER TO SITE ELECTRICAL PLAN FOR RELOCATION'S AND/OR REMOVALS.
- D-16 EXISTING ELECTRICAL LIGHT POLE TO BE RELOCATED. REFER TO SHEETS CG1.1 - CG1.2.
- D-17 SAWCUT AND REMOVE EXISTING SIDEWALK, ASPHALT PAVEMENT, CURB AND GUTTER AS REQUIRED FOR NEW OR RECONSTRUCTED DRIVEWAY.
- D-18 EXISTING FIRE HYDRANT TO BE RELOCATED. SEE SHEET C-4.1 FOR NEW LOCATION.

CITY FIRE MARSHAL
[Signature]
 Date: 4-27-99

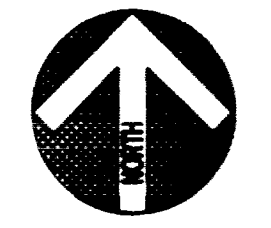

SCALE 1"=20'

DMJM

DMJM P.C.
 A Division of
 DANIEL, MANN, JOHNSON, & MENDENHALL
 1465 East Tropiana, Suite 460
 Las Vegas, Nevada 89119
 (702) 251-0805 (702) 222-2282 fax

In association with
Perlman
 ARCHITECTS
 2230 Corporate Circle, Suite 200
 Henderson, NV 89014
 (702) 990-9900 (702) 932-3222 fax

DMJM Arizona, Inc.
 Architecture, Structure, Civil,
 Mechanical, Electrical, Plumbing
 2777 East Camelback Road, Suite 200
 Phoenix, AZ 85016-4502 (602) 337-2777

**CLARK COUNTY
 DEPARTMENT OF
 FAMILY AND
 YOUTH SERVICES**

601 North Peccoe Road
 Las Vegas, NV 89107-2417
 (702) 455-6210 phone (702) 455-6218 fax
 Kirby L. Burgess- Director
 Cranford L. Crawford- Asst. Director
 Adrienne B. Cox- Asst. Director

**CITY
 RESUBMITTAL**




Registration 4-699

Revisions


No.	Description
△ 11-09-98	ADENDUM #1
△ 12/15/98	CITY REVISION
△ 04/06/99	CITY REVISION

Date: FEBRUARY 12, 1999
 Drawn By: SMS/SAS
 DMJM Job No. 5748.03

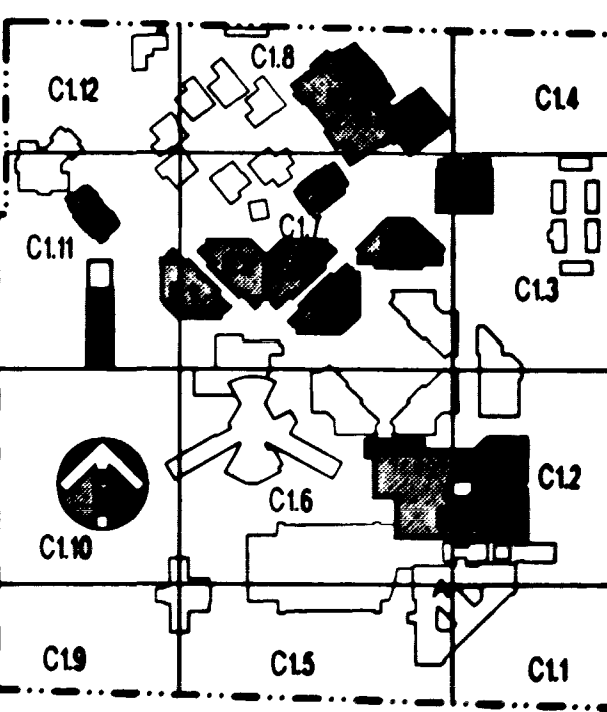

**EXISTING UTILITIES
 AND DEMOLITION**

C-1.4

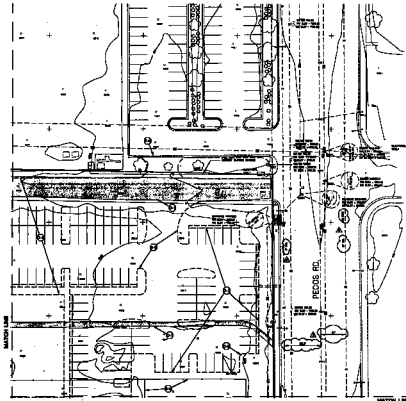

○ CONSTRUCTION NOTES

- 1. ALL WORK SHALL BE DONE IN ACCORDANCE WITH THE SPECIFICATIONS AND STANDARDS OF THE CITY OF CLARK COUNTY, MISSOURI.
- 2. ALL WORK SHALL BE DONE IN ACCORDANCE WITH THE CITY OF CLARK COUNTY, MISSOURI.
- 3. ALL WORK SHALL BE DONE IN ACCORDANCE WITH THE CITY OF CLARK COUNTY, MISSOURI.
- 4. ALL WORK SHALL BE DONE IN ACCORDANCE WITH THE CITY OF CLARK COUNTY, MISSOURI.
- 5. ALL WORK SHALL BE DONE IN ACCORDANCE WITH THE CITY OF CLARK COUNTY, MISSOURI.
- 6. ALL WORK SHALL BE DONE IN ACCORDANCE WITH THE CITY OF CLARK COUNTY, MISSOURI.
- 7. ALL WORK SHALL BE DONE IN ACCORDANCE WITH THE CITY OF CLARK COUNTY, MISSOURI.
- 8. ALL WORK SHALL BE DONE IN ACCORDANCE WITH THE CITY OF CLARK COUNTY, MISSOURI.
- 9. ALL WORK SHALL BE DONE IN ACCORDANCE WITH THE CITY OF CLARK COUNTY, MISSOURI.
- 10. ALL WORK SHALL BE DONE IN ACCORDANCE WITH THE CITY OF CLARK COUNTY, MISSOURI.
- 11. ALL WORK SHALL BE DONE IN ACCORDANCE WITH THE CITY OF CLARK COUNTY, MISSOURI.
- 12. ALL WORK SHALL BE DONE IN ACCORDANCE WITH THE CITY OF CLARK COUNTY, MISSOURI.
- 13. ALL WORK SHALL BE DONE IN ACCORDANCE WITH THE CITY OF CLARK COUNTY, MISSOURI.
- 14. ALL WORK SHALL BE DONE IN ACCORDANCE WITH THE CITY OF CLARK COUNTY, MISSOURI.
- 15. ALL WORK SHALL BE DONE IN ACCORDANCE WITH THE CITY OF CLARK COUNTY, MISSOURI.
- 16. ALL WORK SHALL BE DONE IN ACCORDANCE WITH THE CITY OF CLARK COUNTY, MISSOURI.
- 17. ALL WORK SHALL BE DONE IN ACCORDANCE WITH THE CITY OF CLARK COUNTY, MISSOURI.
- 18. ALL WORK SHALL BE DONE IN ACCORDANCE WITH THE CITY OF CLARK COUNTY, MISSOURI.
- 19. ALL WORK SHALL BE DONE IN ACCORDANCE WITH THE CITY OF CLARK COUNTY, MISSOURI.
- 20. ALL WORK SHALL BE DONE IN ACCORDANCE WITH THE CITY OF CLARK COUNTY, MISSOURI.

DMJM

DRINKING WATER
SEWERAGE
GAS

Perman
ENGINEERS

CLARK COUNTY, MISSOURI

1000 N. 10th Street
St. Joseph, MO 64506

PHONE: 452-1111
FAX: 452-1112

CLARK COUNTY
DEPARTMENT OF
FAMILY AND
YOUTH SERVICES

1000 N. 10th Street
St. Joseph, MO 64506
PHONE: 452-1111
FAX: 452-1112



DATE: 10/15/98

BY: [Signature]

11/15/98 CITY ENGINEER

12/15/98 CITY ENGINEER

DATE: FEBRUARY 6, 2000
DRAWN BY: [Signature]
CHECKED BY: [Signature]



NO. 10000

EXISTING UTILITIES
AND DEMOLITION

BY: [Signature] DATE: 10/15/98



C-14