

**CONSTRUCTION NOTES**

- D-1 REMOVE ASPHALT PAVEMENT, CONCRETE CURB AND SIDEWALK. PAVED AREAS TO BE REMOVED ARE SHOWN SHADED. REMOVE LANDSCAPING AND OTHER APPURTENANCES AS REQUIRED FOR NEW CONSTRUCTION.
- D-2 OUTLINE OF NEW PAVING, CURB AND/OR SIDEWALK. REFER TO SHEETS CG11 - CG12.
- D-3 REMOVE EXISTING BUILDING, ASPHALT PAVEMENT, CURBS, SIDEWALKS, LANDSCAPING, IRRIGATION, UTILITIES AND OTHER APPURTENANCES AS REQUIRED FOR NEW CONSTRUCTION. REFER TO ARCHITECTURAL DEMOLITION AND PHASING DRAWINGS FOR ADDITIONAL INFORMATION.
- D-4 EXISTING PAVEMENT STRIPPING TO BE REMOVED.
- D-5 OUTLINE OF EXISTING BUILDING TO BE REMOVED.
- D-6 EXISTING WALK TO REMAIN.
- D-7 EXISTING TRAILERS TO REMAIN. PROTECT EXISTING UTILITIES.
- D-8 EXISTING SWITCH GEAR TO BE REMOVED.
- D-9 EXISTING SWITCH GEAR TO REMAIN.
- D-10 EXISTING NEVADA POWER TRANSFORMER AND SWITCH TO REMAIN.
- D-11 SAWCUT EXISTING CURB AND REMOVE.
- D-12 SAWCUT EXISTING PAVEMENT AND REMOVE.
- D-13 SAWCUT EXISTING SIDEWALK AND REMOVE.
- D-14 EXISTING FENCING. REFER TO ARCHITECTURAL SITE PLAN AND CONSTRUCTION PHASING DRAWINGS.
- D-15 EXISTING ELECTRICAL AND/OR TELECOMMUNICATIONS UTILITY OR ELEMENT. REFER TO SITE ELECTRICAL PLAN FOR RELOCATION'S AND/OR REMOVALS.
- D-16 EXISTING ELECTRICAL LIGHT POLE TO BE RELOCATED. REFER TO SHEETS CG11 - CG12.
- D-17 SAWCUT AND REMOVE EXISTING SIDEWALK, ASPHALT PAVEMENT, CURB AND GUTTER AS REQUIRED FOR NEW OR RECONSTRUCTED DRIVEWAY.
- D-18 EXISTING FIRE HYDRANT TO BE RELOCATED. SEE SHEET C-4.1 FOR NEW LOCATION.

CITY FIRE MARSHAL Date: 4-27-99



SCALE 1"=40'

**DMJM**

DMJM P.C.  
A Division of  
DANIEL, MANN, JOHNSON & MENDENHALL  
1456 East Tropicana, Suite 480  
Las Vegas, Nevada 89119  
(702) 261-0808 (702) 222-2282 fax

In association with  
**Perlman**  
ARCHITECTS  
2230 Corporate Circle, Suite 200  
Henderson, NV 89014  
(702) 990-9900 (702) 932-3222 fax


DMJM Arizona, Inc.  
Architecture, Structure, Civil,  
Mechanical, Electrical, Plumbing  
2777 East Camelback Road, Suite 200  
Phoenix, AZ 85016-4302 (602) 337-2777

**CLARK COUNTY**  
DEPARTMENT OF  
FAMILY AND  
YOUTH SERVICES

801 North Pecos Road  
Las Vegas, NV 89101-2417  
(702) 455-6210 phone (702) 455-6218 fax

Kirby L. Burgess- Director  
Cranford L. Crawford- Asst. Director  
Adrienne B. Cox- Asst. Director

CITY  
RESUBMITTAL

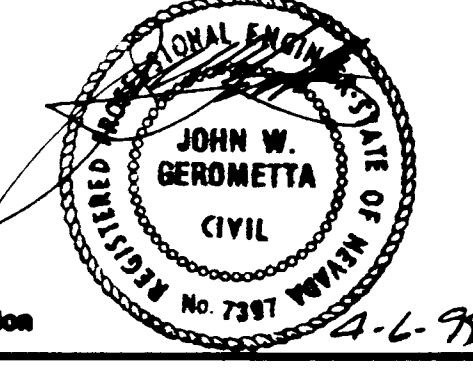


Registration No. 7387 4-6-99

Revisions


No.	Description
A	11-09-98 ADENDUM #1
B	12/15/98 CITY REVISION
C	04/06/99 CITY REVISION

Date: FEBRUARY 12, 1999  
Drawn By: SMS/SAS  
DMJM Job No.: 5745.03

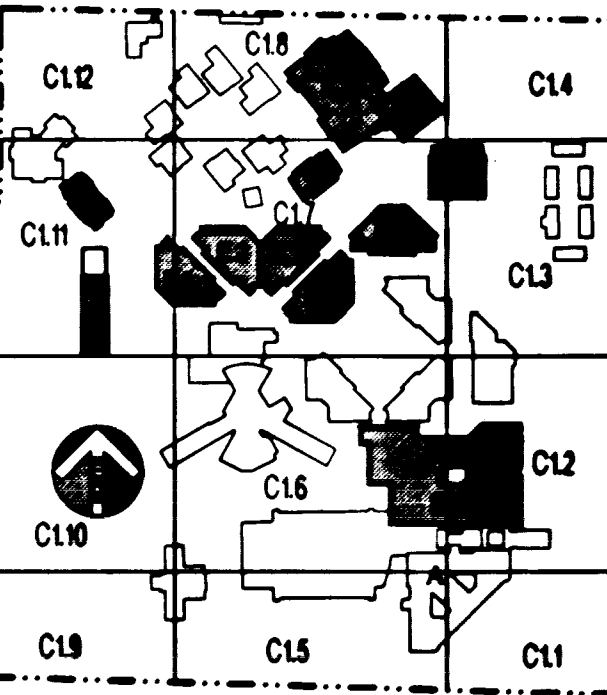

Key Plan  
**EXISTING UTILITIES  
AND DEMOLITION**

**C-1.9**

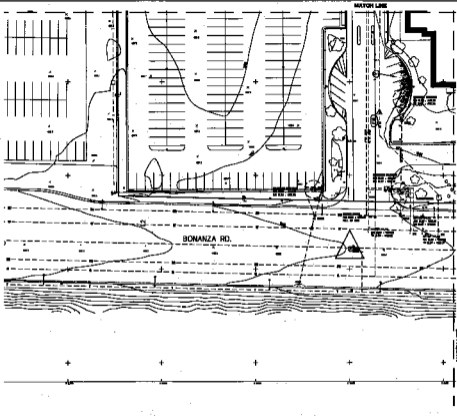

**CONSTRUCTION NOTES**

- 0-1 EXISTING ASPHALT DRIVEWAY, CONCRETE CURB AND SIDEWALK FORMS SHALL BE IN PLACE AND SHALL REMAIN UNLESS OTHERWISE SPECIFIED BY THE CONTRACTOR. ALL UTILITIES SHALL BE PROTECTED AND SHALL REMAIN IN PLACE UNLESS OTHERWISE SPECIFIED BY THE CONTRACTOR.
- 0-2 EXISTING ASPHALT DRIVEWAY, CONCRETE CURB AND SIDEWALK FORMS SHALL BE IN PLACE AND SHALL REMAIN UNLESS OTHERWISE SPECIFIED BY THE CONTRACTOR. ALL UTILITIES SHALL BE PROTECTED AND SHALL REMAIN IN PLACE UNLESS OTHERWISE SPECIFIED BY THE CONTRACTOR.
- 0-3 EXISTING ASPHALT DRIVEWAY, CONCRETE CURB AND SIDEWALK FORMS SHALL BE IN PLACE AND SHALL REMAIN UNLESS OTHERWISE SPECIFIED BY THE CONTRACTOR. ALL UTILITIES SHALL BE PROTECTED AND SHALL REMAIN IN PLACE UNLESS OTHERWISE SPECIFIED BY THE CONTRACTOR.
- 0-4 EXISTING ASPHALT DRIVEWAY, CONCRETE CURB AND SIDEWALK FORMS SHALL BE IN PLACE AND SHALL REMAIN UNLESS OTHERWISE SPECIFIED BY THE CONTRACTOR. ALL UTILITIES SHALL BE PROTECTED AND SHALL REMAIN IN PLACE UNLESS OTHERWISE SPECIFIED BY THE CONTRACTOR.
- 0-5 EXISTING ASPHALT DRIVEWAY, CONCRETE CURB AND SIDEWALK FORMS SHALL BE IN PLACE AND SHALL REMAIN UNLESS OTHERWISE SPECIFIED BY THE CONTRACTOR. ALL UTILITIES SHALL BE PROTECTED AND SHALL REMAIN IN PLACE UNLESS OTHERWISE SPECIFIED BY THE CONTRACTOR.
- 0-6 EXISTING ASPHALT DRIVEWAY, CONCRETE CURB AND SIDEWALK FORMS SHALL BE IN PLACE AND SHALL REMAIN UNLESS OTHERWISE SPECIFIED BY THE CONTRACTOR. ALL UTILITIES SHALL BE PROTECTED AND SHALL REMAIN IN PLACE UNLESS OTHERWISE SPECIFIED BY THE CONTRACTOR.
- 0-7 EXISTING ASPHALT DRIVEWAY, CONCRETE CURB AND SIDEWALK FORMS SHALL BE IN PLACE AND SHALL REMAIN UNLESS OTHERWISE SPECIFIED BY THE CONTRACTOR. ALL UTILITIES SHALL BE PROTECTED AND SHALL REMAIN IN PLACE UNLESS OTHERWISE SPECIFIED BY THE CONTRACTOR.
- 0-8 EXISTING ASPHALT DRIVEWAY, CONCRETE CURB AND SIDEWALK FORMS SHALL BE IN PLACE AND SHALL REMAIN UNLESS OTHERWISE SPECIFIED BY THE CONTRACTOR. ALL UTILITIES SHALL BE PROTECTED AND SHALL REMAIN IN PLACE UNLESS OTHERWISE SPECIFIED BY THE CONTRACTOR.
- 0-9 EXISTING ASPHALT DRIVEWAY, CONCRETE CURB AND SIDEWALK FORMS SHALL BE IN PLACE AND SHALL REMAIN UNLESS OTHERWISE SPECIFIED BY THE CONTRACTOR. ALL UTILITIES SHALL BE PROTECTED AND SHALL REMAIN IN PLACE UNLESS OTHERWISE SPECIFIED BY THE CONTRACTOR.
- 0-10 EXISTING ASPHALT DRIVEWAY, CONCRETE CURB AND SIDEWALK FORMS SHALL BE IN PLACE AND SHALL REMAIN UNLESS OTHERWISE SPECIFIED BY THE CONTRACTOR. ALL UTILITIES SHALL BE PROTECTED AND SHALL REMAIN IN PLACE UNLESS OTHERWISE SPECIFIED BY THE CONTRACTOR.

**DMJM**  
 DAVIS-McKEE  
 ENGINEERS, ARCHITECTS & PLANNERS  
 1000 Peachtree Street, N.E.  
 Atlanta, Georgia 30309  
 Telephone: (404) 525-8800  
 Fax: (404) 525-8801  
 www.davis-mckee.com

**CLARK COUNTY**  
 DEPARTMENT OF  
 PUBLIC AND  
 YOUTH SERVICES  
 1000 Peachtree Street, N.E.  
 Atlanta, Georgia 30309  
 Telephone: (404) 525-8800  
 Fax: (404) 525-8801  
 www.clarkcountyga.gov



- Address: 11-10-10 ADDRESS #1  
 City: ATLANTA CITY ADDRESS  
 State: GA CITY ADDRESS

Date: 11/10/10  
 Drawn by: [Signature]  
 Scale: AS SHOWN



EXISTING UTILITIES  
 AND DEMOLITION

DATE: 11/10/10  
 DRAWN BY: [Signature]

