

CONSTRUCTION NOTES

- D-1 REMOVE ASPHALT PAVEMENT, CONCRETE CURB AND SIDEWALK. PAVED AREAS TO BE REMOVED ARE SHOWN SHADED. REMOVE LANDSCAPING AND OTHER APPURTENANCES AS REQUIRED FOR NEW CONSTRUCTION.
- D-2 OUTLINE OF NEW PAVING, CURB AND/OR SIDEWALK REFER TO SHEETS CG1.1 - CG1.2.
- D-3 REMOVE EXISTING BUILDING, ASPHALT PAVEMENT, CURBS, SIDEWALKS, LANDSCAPING, IRRIGATION, UTILITIES AND OTHER APPURTENANCES AS REQUIRED FOR NEW CONSTRUCTION. REFER TO ARCHITECTURAL DEMOLITION AND PHASING DRAWINGS FOR ADDITIONAL INFORMATION.
- D-4 EXISTING PAVEMENT STRIPPING TO BE REMOVED.
- D-5 OUTLINE OF EXISTING BUILDING TO BE REMOVED.
- D-6 EXISTING WALK TO REMAIN.
- D-7 EXISTING TRAILERS TO REMAIN. PROTECT EXISTING UTILITIES.
- D-8 EXISTING SWITCH GEAR TO BE REMOVED.
- D-9 EXISTING SWITCH GEAR TO REMAIN.
- D-10 EXISTING NEVADA POWER TRANSFORMER AND SWITCH TO REMAIN.
- D-11 SAWCUT EXISTING CURB AND REMOVE.
- D-12 SAWCUT EXISTING PAVEMENT AND REMOVE.
- D-13 SAWCUT EXISTING SIDEWALK AND REMOVE.
- D-14 EXISTING FENCING. REFER TO ARCHITECTURAL SITE PLAN AND CONSTRUCTION PHASING DRAWINGS.
- D-15 EXISTING ELECTRICAL AND/OR TELECOMMUNICATIONS UTILITY OR ELEMENT. REFER TO SITE ELECTRICAL PLAN FOR RELOCATION'S AND/OR REMOVALS.
- D-16 EXISTING ELECTRICAL LIGHT POLE TO BE RELOCATED REFER TO SHEETS CG1.1 - CG1.2.
- D-17 SAWCUT AND REMOVE EXISTING SIDEWALK, ASPHALT PAVEMENT, CURB AND GUTTER AS REQUIRED FOR NEW OR RECONSTRUCTED DRIVEWAY.
- D-18 EXISTING FIRE HYDRANT TO BE RELOCATED. SEE SHEET C-4.1 FOR NEW LOCATION.

DMJM

DMJM P.C.
A Division of
DANIEL, MANN, JOHNSON, & MENDENHALL
1466 East Tropicana, Suite 400
Las Vegas, Nevada 89119
(702) 261-0805 (702) 222-2282 fax


In association with
Perlman
ARCHITECTS
2230 Corporate Circle, Suite 200
Henderson, NV 89014
(702) 990-9900 (702) 932-3222 fax

DMJM Arizona, Inc.
Architecture, Structure, Civil,
Mechanical, Electrical, Plumbing
2777 East Camelback Road, Suite 200
Phoenix, AZ 85016-4302 (602) 337-2777

CLARK COUNTY
DEPARTMENT OF
FAMILY AND
YOUTH SERVICES

801 North Pease Road
Las Vegas, NV 89107-2417
(702) 455-5210 phone (702) 455-5218 fax
Kirby L. Burgess- Director
Cranford L. Crawford- Asst. Director
Adrienne B. Cox- Asst. Director


CITY
RESUBMITTAL

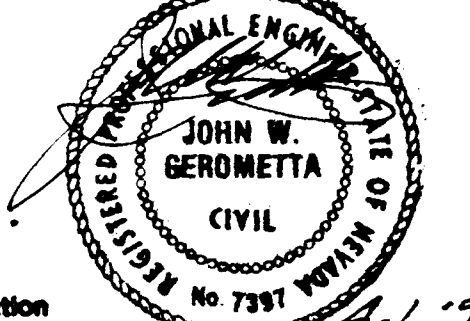

Revisions

No.	Description
△ 11-09-98	ADENDUM #1
△ 12/15/98	CITY REVISION
△ 04/06/99	CITY REVISION

Date: FEBRUARY 12, 1999
Drawn By: SMS/SAS
DMJM Job No.: 5745.03

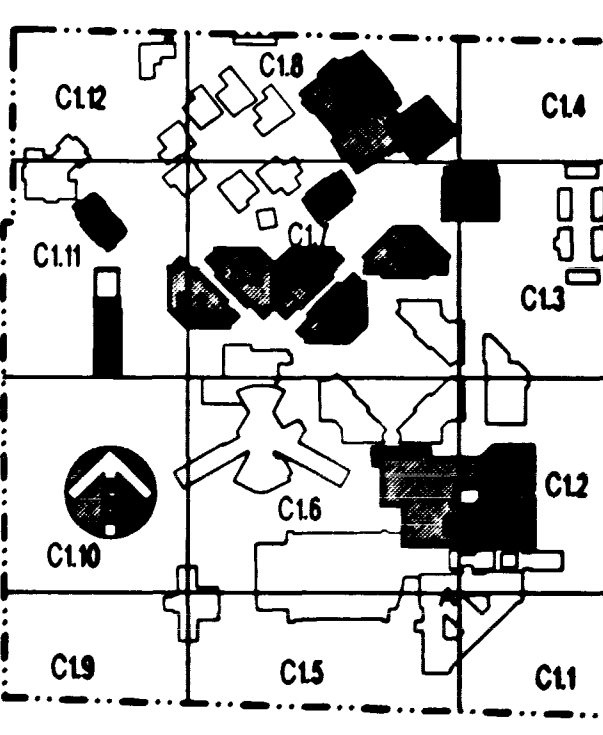

Key Plan
**EXISTING UTILITIES
AND DEMOLITION**

CITY FIRE MARSHAL Date: 4-27-99



SCALE 1"=40'

C-1.10

