


**CONSTRUCTION NOTES**

- D-1 REMOVE ASPHALT PAVEMENT, CONCRETE CURB AND SIDEWALK. PAVED AREAS TO BE REMOVED ARE SHOWN SHADED. REMOVE LANDSCAPING AND OTHER APPURTENANCES AS REQUIRED FOR NEW CONSTRUCTION.
- D-2 OUTLINE OF NEW PAVING, CURB AND/OR SIDEWALK. REFER TO SHEETS CG1.1 - CG1.12.
- D-3 REMOVE EXISTING BUILDING, ASPHALT PAVEMENT, CURBS, SIDEWALKS, LANDSCAPING, IRRIGATION, UTILITIES AND OTHER APPURTENANCES AS REQUIRED FOR NEW CONSTRUCTION. REFER TO ARCHITECTURAL DEMOLITION AND PHASING DRAWINGS FOR ADDITIONAL INFORMATION.
- D-4 EXISTING PAVEMENT STRIPPING TO BE REMOVED.
- D-5 OUTLINE OF EXISTING BUILDING TO BE REMOVED.
- D-6 EXISTING WALK TO REMAIN.
- D-7 EXISTING TRAILERS TO REMAIN. PROTECT EXISTING UTILITIES.
- D-8 EXISTING SWITCH GEAR TO BE REMOVED.
- D-9 EXISTING SWITCH GEAR TO REMAIN.
- D-10 EXISTING NEVADA POWER TRANSFORMER AND SWITCH TO REMAIN.
- D-11 SAWCUT EXISTING CURB AND REMOVE.
- D-12 SAWCUT EXISTING PAVEMENT AND REMOVE.
- D-13 SAWCUT EXISTING SIDEWALK AND REMOVE.
- D-14 EXISTING FENCING. REFER TO ARCHITECTURAL SITE PLAN AND CONSTRUCTION PHASING DRAWINGS.
- D-15 EXISTING ELECTRICAL AND/OR TELECOMMUNICATIONS UTILITY OR ELEMENT. REFER TO SITE ELECTRICAL PLAN FOR RELOCATION'S AND/OR REMOVALS.
- D-16 EXISTING ELECTRICAL LIGHT POLE TO BE RELOCATED. REFER TO SHEETS CG1.1 - CG1.12.
- D-17 SAWCUT AND REMOVE EXISTING SIDEWALK, ASPHALT PAVEMENT, CURB AND GUTTER AS REQUIRED FOR NEW OR RECONSTRUCTED DRIVEWAY.
- D-18 EXISTING FIRE HYDRANT TO BE RELOCATED. SEE SHEET C-4.1 FOR NEW LOCATION.

CITY FIRE MARSHAL Date: 4-27-99

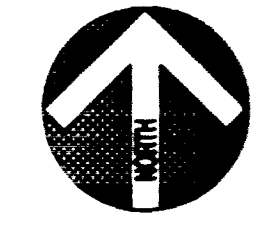

SCALE 1"=20'

**DMJM**

DMJM P.C.  
A Division of  
DANIEL, MANN, JOHNSON, & MENDENHALL  
1456 East Tropicana, Suite 400  
Las Vegas, Nevada 89119  
(702) 261-0806 (702) 222-2282 fax

In association with  
**Perlman**  
ARCHITECTS  
2230 Corporate Circle, Suite 200  
Henderson, NV 89014  
(702) 990-9900 (702) 932-3222 fax


DMJM Arizona, Inc.  
Architecture, Structure, Civil,  
Mechanical, Electrical, Plumbing  
2777 East Camelback Road, Suite 200  
Phoenix, AZ 85016-4302 (602) 357-2777

**CLARK COUNTY**  
DEPARTMENT OF  
FAMILY AND  
YOUTH SERVICES

801 North Peoria Road  
Las Vegas, NV 89101-2417  
(702) 455-8210 phone (702) 455-8218 fax

Kirby L. Burgess- Director  
Cranford L. Crawford- Asst. Director  
Adrienne B. Cox- Asst. Director


CITY  
RESUBMITTAL

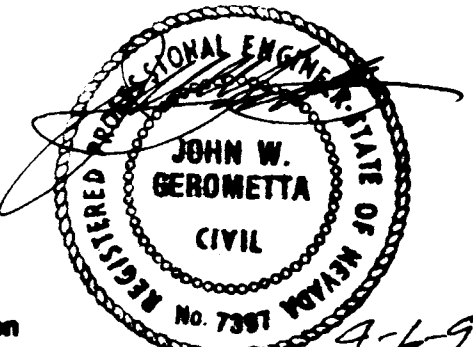

Revisions


No.	Description
△ 11-09-98	ADENDUM #1
△ 12/15/98	CITY REVISION
△ 04/06/99	CITY REVISION

Date: FEBRUARY 12, 1999  
Drawn By: SMS/SAS  
DMJM Job No.: 5745.03

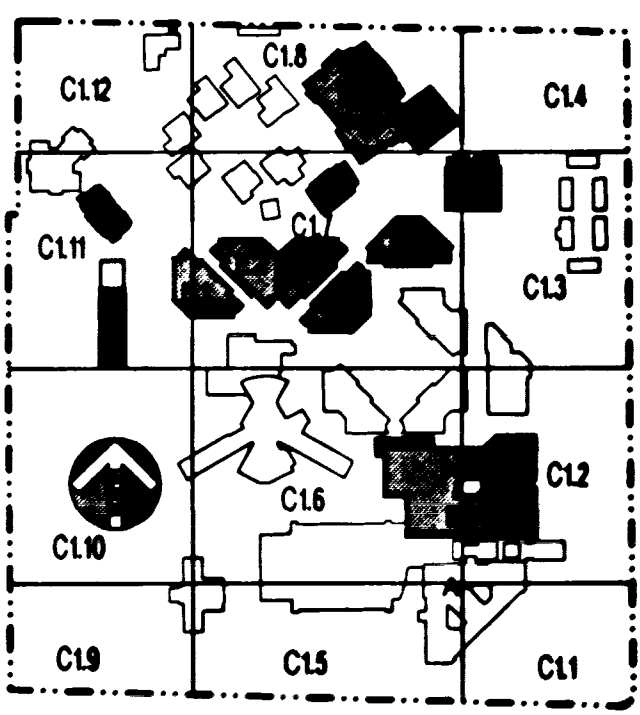

Key Plan  
**EXISTING UTILITIES  
AND DEMOLITION**

**C-1.12**

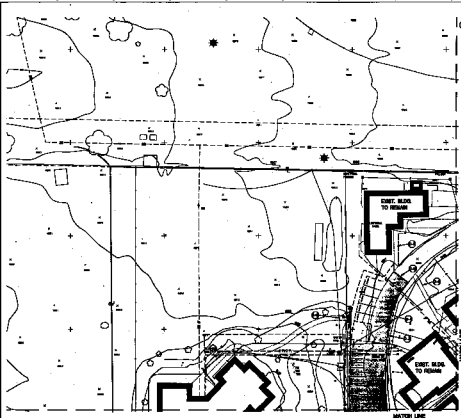

**CONSTRUCTION NOTES**

- 01 REMOVE EXISTING EXTERIOR WALLS AND FOUNDATION WALLS TO EXPOSE INTERIOR WALLS TO BE DEMOLISHED.
- 02 EXISTING EXTERIOR WALLS TO BE DEMOLISHED TO EXPOSE INTERIOR WALLS TO BE DEMOLISHED.
- 03 EXISTING EXTERIOR WALLS TO BE DEMOLISHED TO EXPOSE INTERIOR WALLS TO BE DEMOLISHED.
- 04 EXISTING EXTERIOR WALLS TO BE DEMOLISHED TO EXPOSE INTERIOR WALLS TO BE DEMOLISHED.
- 05 EXISTING EXTERIOR WALLS TO BE DEMOLISHED TO EXPOSE INTERIOR WALLS TO BE DEMOLISHED.
- 06 EXISTING EXTERIOR WALLS TO BE DEMOLISHED TO EXPOSE INTERIOR WALLS TO BE DEMOLISHED.
- 07 EXISTING EXTERIOR WALLS TO BE DEMOLISHED TO EXPOSE INTERIOR WALLS TO BE DEMOLISHED.
- 08 EXISTING EXTERIOR WALLS TO BE DEMOLISHED TO EXPOSE INTERIOR WALLS TO BE DEMOLISHED.
- 09 EXISTING EXTERIOR WALLS TO BE DEMOLISHED TO EXPOSE INTERIOR WALLS TO BE DEMOLISHED.
- 10 EXISTING EXTERIOR WALLS TO BE DEMOLISHED TO EXPOSE INTERIOR WALLS TO BE DEMOLISHED.
- 11 EXISTING EXTERIOR WALLS TO BE DEMOLISHED TO EXPOSE INTERIOR WALLS TO BE DEMOLISHED.
- 12 EXISTING EXTERIOR WALLS TO BE DEMOLISHED TO EXPOSE INTERIOR WALLS TO BE DEMOLISHED.
- 13 EXISTING EXTERIOR WALLS TO BE DEMOLISHED TO EXPOSE INTERIOR WALLS TO BE DEMOLISHED.
- 14 EXISTING EXTERIOR WALLS TO BE DEMOLISHED TO EXPOSE INTERIOR WALLS TO BE DEMOLISHED.
- 15 EXISTING EXTERIOR WALLS TO BE DEMOLISHED TO EXPOSE INTERIOR WALLS TO BE DEMOLISHED.
- 16 EXISTING EXTERIOR WALLS TO BE DEMOLISHED TO EXPOSE INTERIOR WALLS TO BE DEMOLISHED.
- 17 EXISTING EXTERIOR WALLS TO BE DEMOLISHED TO EXPOSE INTERIOR WALLS TO BE DEMOLISHED.
- 18 EXISTING EXTERIOR WALLS TO BE DEMOLISHED TO EXPOSE INTERIOR WALLS TO BE DEMOLISHED.
- 19 EXISTING EXTERIOR WALLS TO BE DEMOLISHED TO EXPOSE INTERIOR WALLS TO BE DEMOLISHED.
- 20 EXISTING EXTERIOR WALLS TO BE DEMOLISHED TO EXPOSE INTERIOR WALLS TO BE DEMOLISHED.

DATE: 11/12/08  
 DRAWN BY: [Signature]  
 CHECKED BY: [Signature]



**DMJM**  
 DESIGN & CONSTRUCTION  
 10000 N. ...  
 ...  
**Periman**  
 ARCHITECTS  
 10000 N. ...  
 ...

**CLARK COUNTY**  
 DEPARTMENT OF  
 FAMILY AND  
 YOUTH SERVICES  
 10000 N. ...  
 ...



- ▲ 11-01-08 KICKOFF #1
- ▲ 11/13/08 CITY MEETING
- ▲ 3/24/09 CITY MEETING

DATE: 11/12/08  
 DRAWN BY: [Signature]  
 CHECKED BY: [Signature]



**EXISTING UTILITIES AND OBSTRUCTIONS**

**C-1.12**  
 11/12/08