

**DMJM**  
 DMJM P.C.  
 A Division of  
 DANIEL, MANN, JOHNSON & MENDERHALL  
 1455 East Tropicana, Suite 480  
 Las Vegas, Nevada 89119  
 (702) 261-0806 (702) 222-2282 fax


In association with  
**Perlman**  
 ARCHITECTS  
 2230 Corporate Circle, Suite 200 Inc.  
 Henderson, NV 89014  
 (702) 990-9900(702) 932-3222 fax

DMJM Arizona, Inc.  
 Architecture, Structure, Civil,  
 Mechanical, Electrical, Plumbing  
 2777 East Camelback Road, Suite 200  
 Phoenix, AZ 85016-4302 (602) 357-2777

**CLARK COUNTY**  
 DEPARTMENT OF  
 FAMILY AND  
 YOUTH SERVICES

601 North Peccos Road  
 Las Vegas, NV 89101-2417  
 (702) 456-5210 phone (702) 456-5218 fax


Kirby L. Burgess- Director  
 Cranford L. Crawford- Asst. Director  
 Adrienne B. Cox- Asst. Director

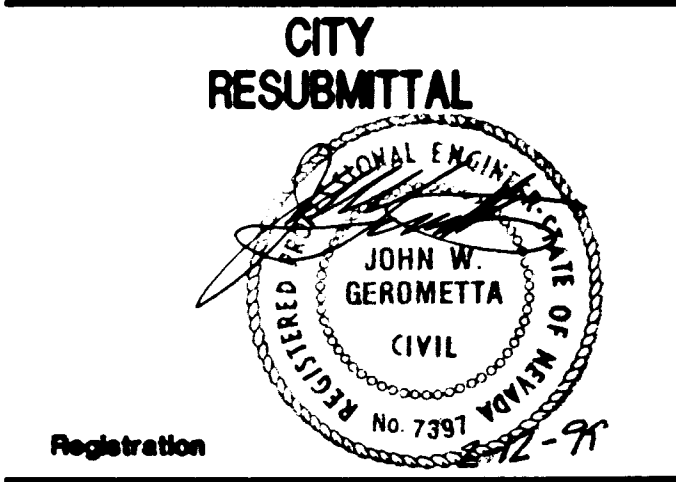

Revisions



No.	Description
1	11-09-98 ADENDUM #1
A	12/15/98 CITY REVISION

Date: FEBRUARY 12, 1999  
 Drawn By: SMS/SAS  
 DMJM Job No.: 5745.03

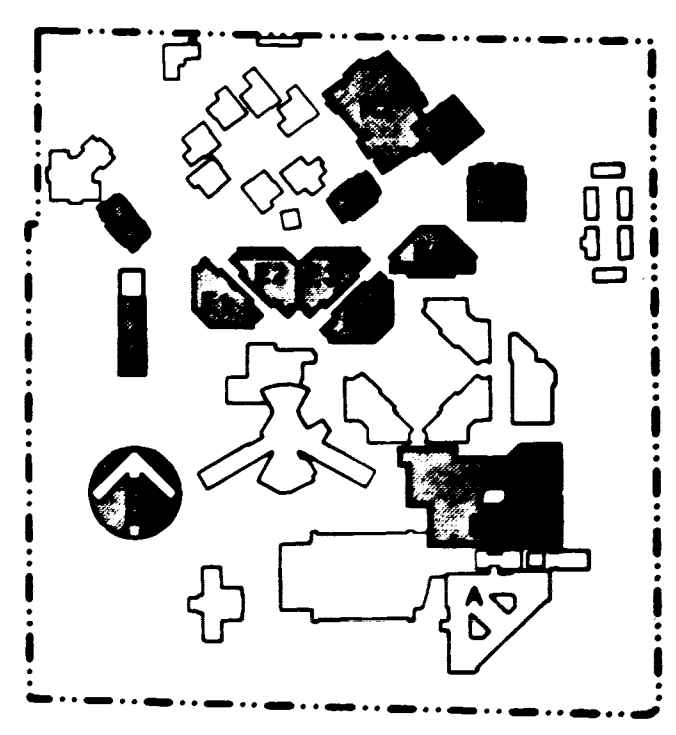

Key Plan

**STORM DRAIN  
 PLAN AND PROFILE**

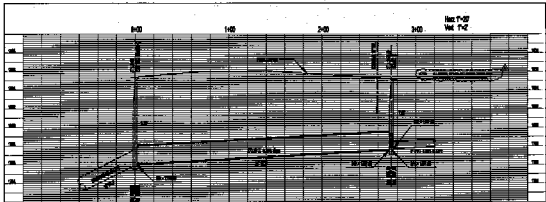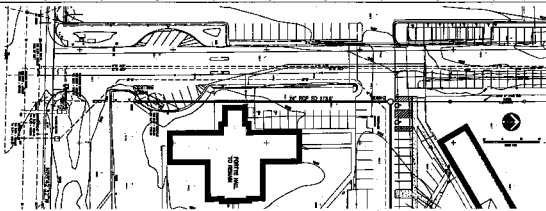

**DMJM**

DRIVE PLS.  
 1000 S. W. 10th St.  
 Ft. Lauderdale, Fla. 33304

**Redman**  
 ENGINEERS  
 1000 S. W. 10th St.  
 Ft. Lauderdale, Fla. 33304

STATE ADDRESS FOR  
 GOVERNMENTAL  
 RECORDS PURPOSES

CLARK COUNTY  
 DEPARTMENT OF  
 PUBLIC & YOUTH SERVICES

ATTENTION:  
 Mr. L. Eugene Brown  
 1000 S. W. 10th St.  
 Ft. Lauderdale, Fla. 33304



- Revisions:  
 1. 11-09-68 ADDITION #1  
 2. 12/15/68 BY 408004

Scale: 1" = 20' PLAN & 1" = 10' PROFILE  
 Date: 12/15/68



Key Plan

STORM DRAIN  
 PLAN AND PROFILE

**C-3.1**  
 (17-1307) 22 OF 28