


GENERAL NOTES

1. ALL STATIONING IS ALONG THE HORIZONTAL CENTERLINE OF THE NEW PIPELINE.
2. ALL PIPELINE ELEVATIONS ARE INVERT ELEVATIONS UNLESS SHOWN OTHERWISE.
3. PIPELINE SLOPES ARE CALCULATED FROM MANHOLE CENTERLINE. MANHOLE CHANNEL INVERTS SHALL BE TRANSITIONED TO MATCH.
4. UTILITY INVERTS SHOWN HAVE BEEN CALCULATED FROM CLOSEST MANHOLE AND SHALL BE VERIFIED BEFORE CONSTRUCTION.

SHEET NOTES

- ① VERIFY EXACT HORIZONTAL AND VERTICAL LOCATION OF EXISTING 10-INCH PIPE BEFORE BEGINNING CONSTRUCTION. PROVIDE 12"x10" REDUCER.


N I C 1

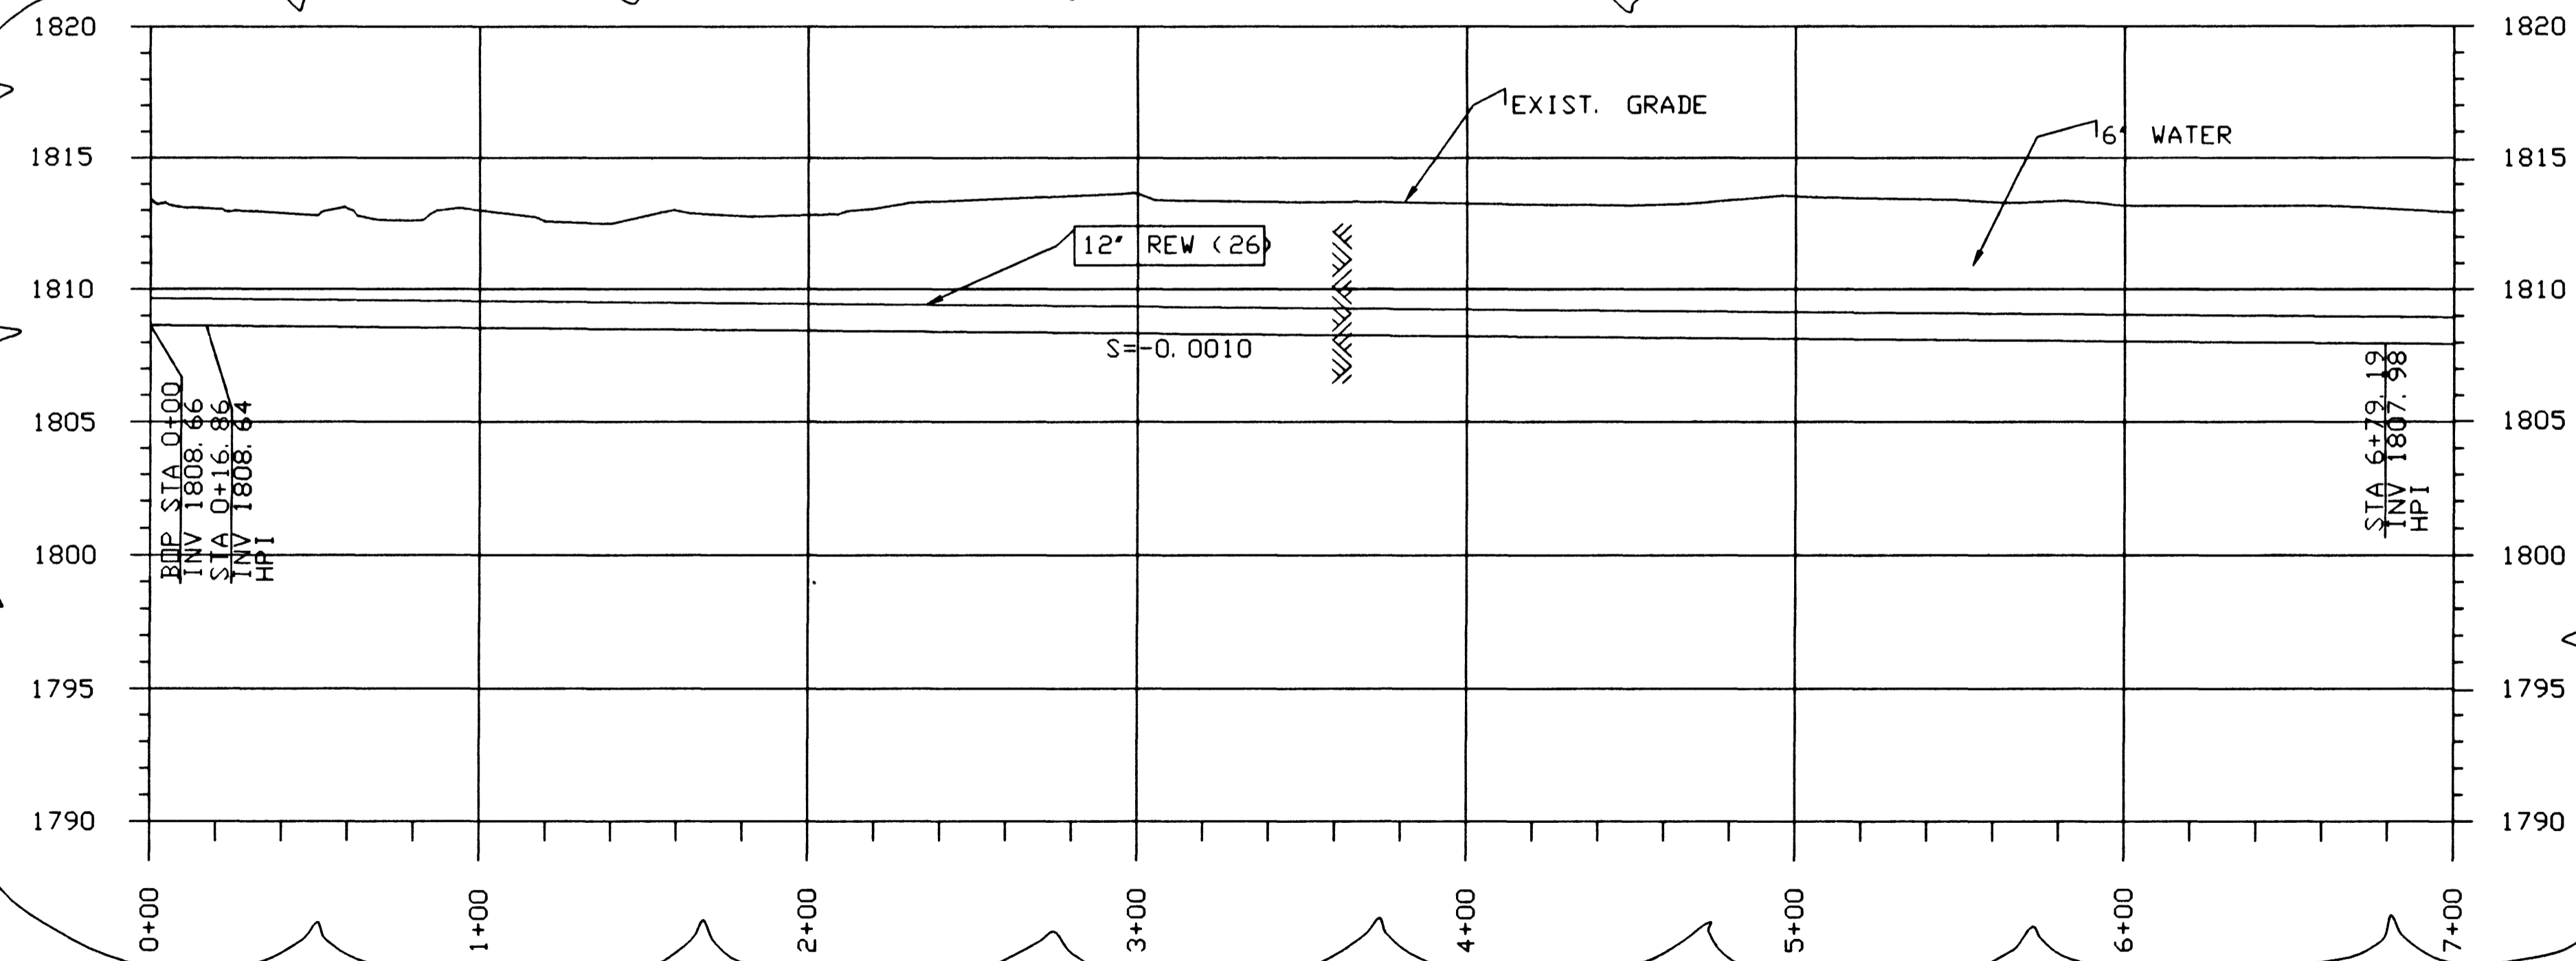

N I C 1

AS BUILT DATE
 9 APR 99

Call before you Dig.
 1-800-227-2600

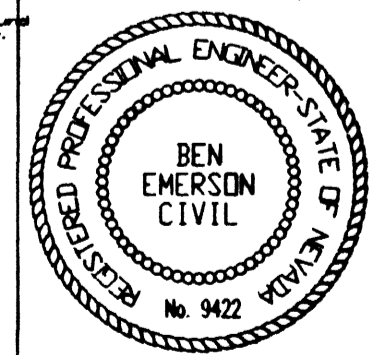

THE ORIGINAL CONTRACT DOCUMENT WAS SEALED AND SIGNED BY BEN EMERSON

DATE/TIME\$\$\$\$\$date\$\$\$\$\$time\$\$\$\$\$

JOB No: 1540.0131 FILE No: \$\$\$\$\$\$directory/filename\$\$\$\$\$

REV	DATE	BY	DESCRIPTION

SCALE: HORZ: 1"=40' VERT: 1"=5'
 WARNING: IF THIS BAR DOES NOT MEASURE 1" THEN DRAWING IS NOT TO SCALE.
 DESIGNER: McCLELLAND
 DRAWN: McCLELLAND
 CHECKED: B. EMERSON

SUBMITTED THE ORIGINAL CONTRACT DOCUMENT WAS SIGNED BY BEN EMERSON
 PROJECT ENGINEER R. C. E. NO. DATE
 RECOMMENDED THE ORIGINAL CONTRACT DOCUMENT WAS SIGNED BY VICKI J SCARNHORST
 MONTGOMERY WATSON R. C. E. NO. DATE



MONTGOMERY WATSON
 3014 WEST CHARLESTON BLVD
 LAS VEGAS, NV. 89102-1944
 (702) 878-8010
 COPYRIGHT © 1997 BY MONTGOMERY WATSON
 ALL RIGHTS RESERVED

CITY OF LAS VEGAS
 BONANZA/MOJAVE WATER RESOURCE CENTER
 DESERT PINES RECLAIMED WATER LINE
 PLAN AND PROFILE STA 0+00 TO STA 7+00
 DWG. C-5
 513-64

26263