


DATE/TIME DD-MMM-YYYY HH:MM

FILE No. E:\pro\lwrt\st\bzrn0\*s\*.dgn

JOB No.

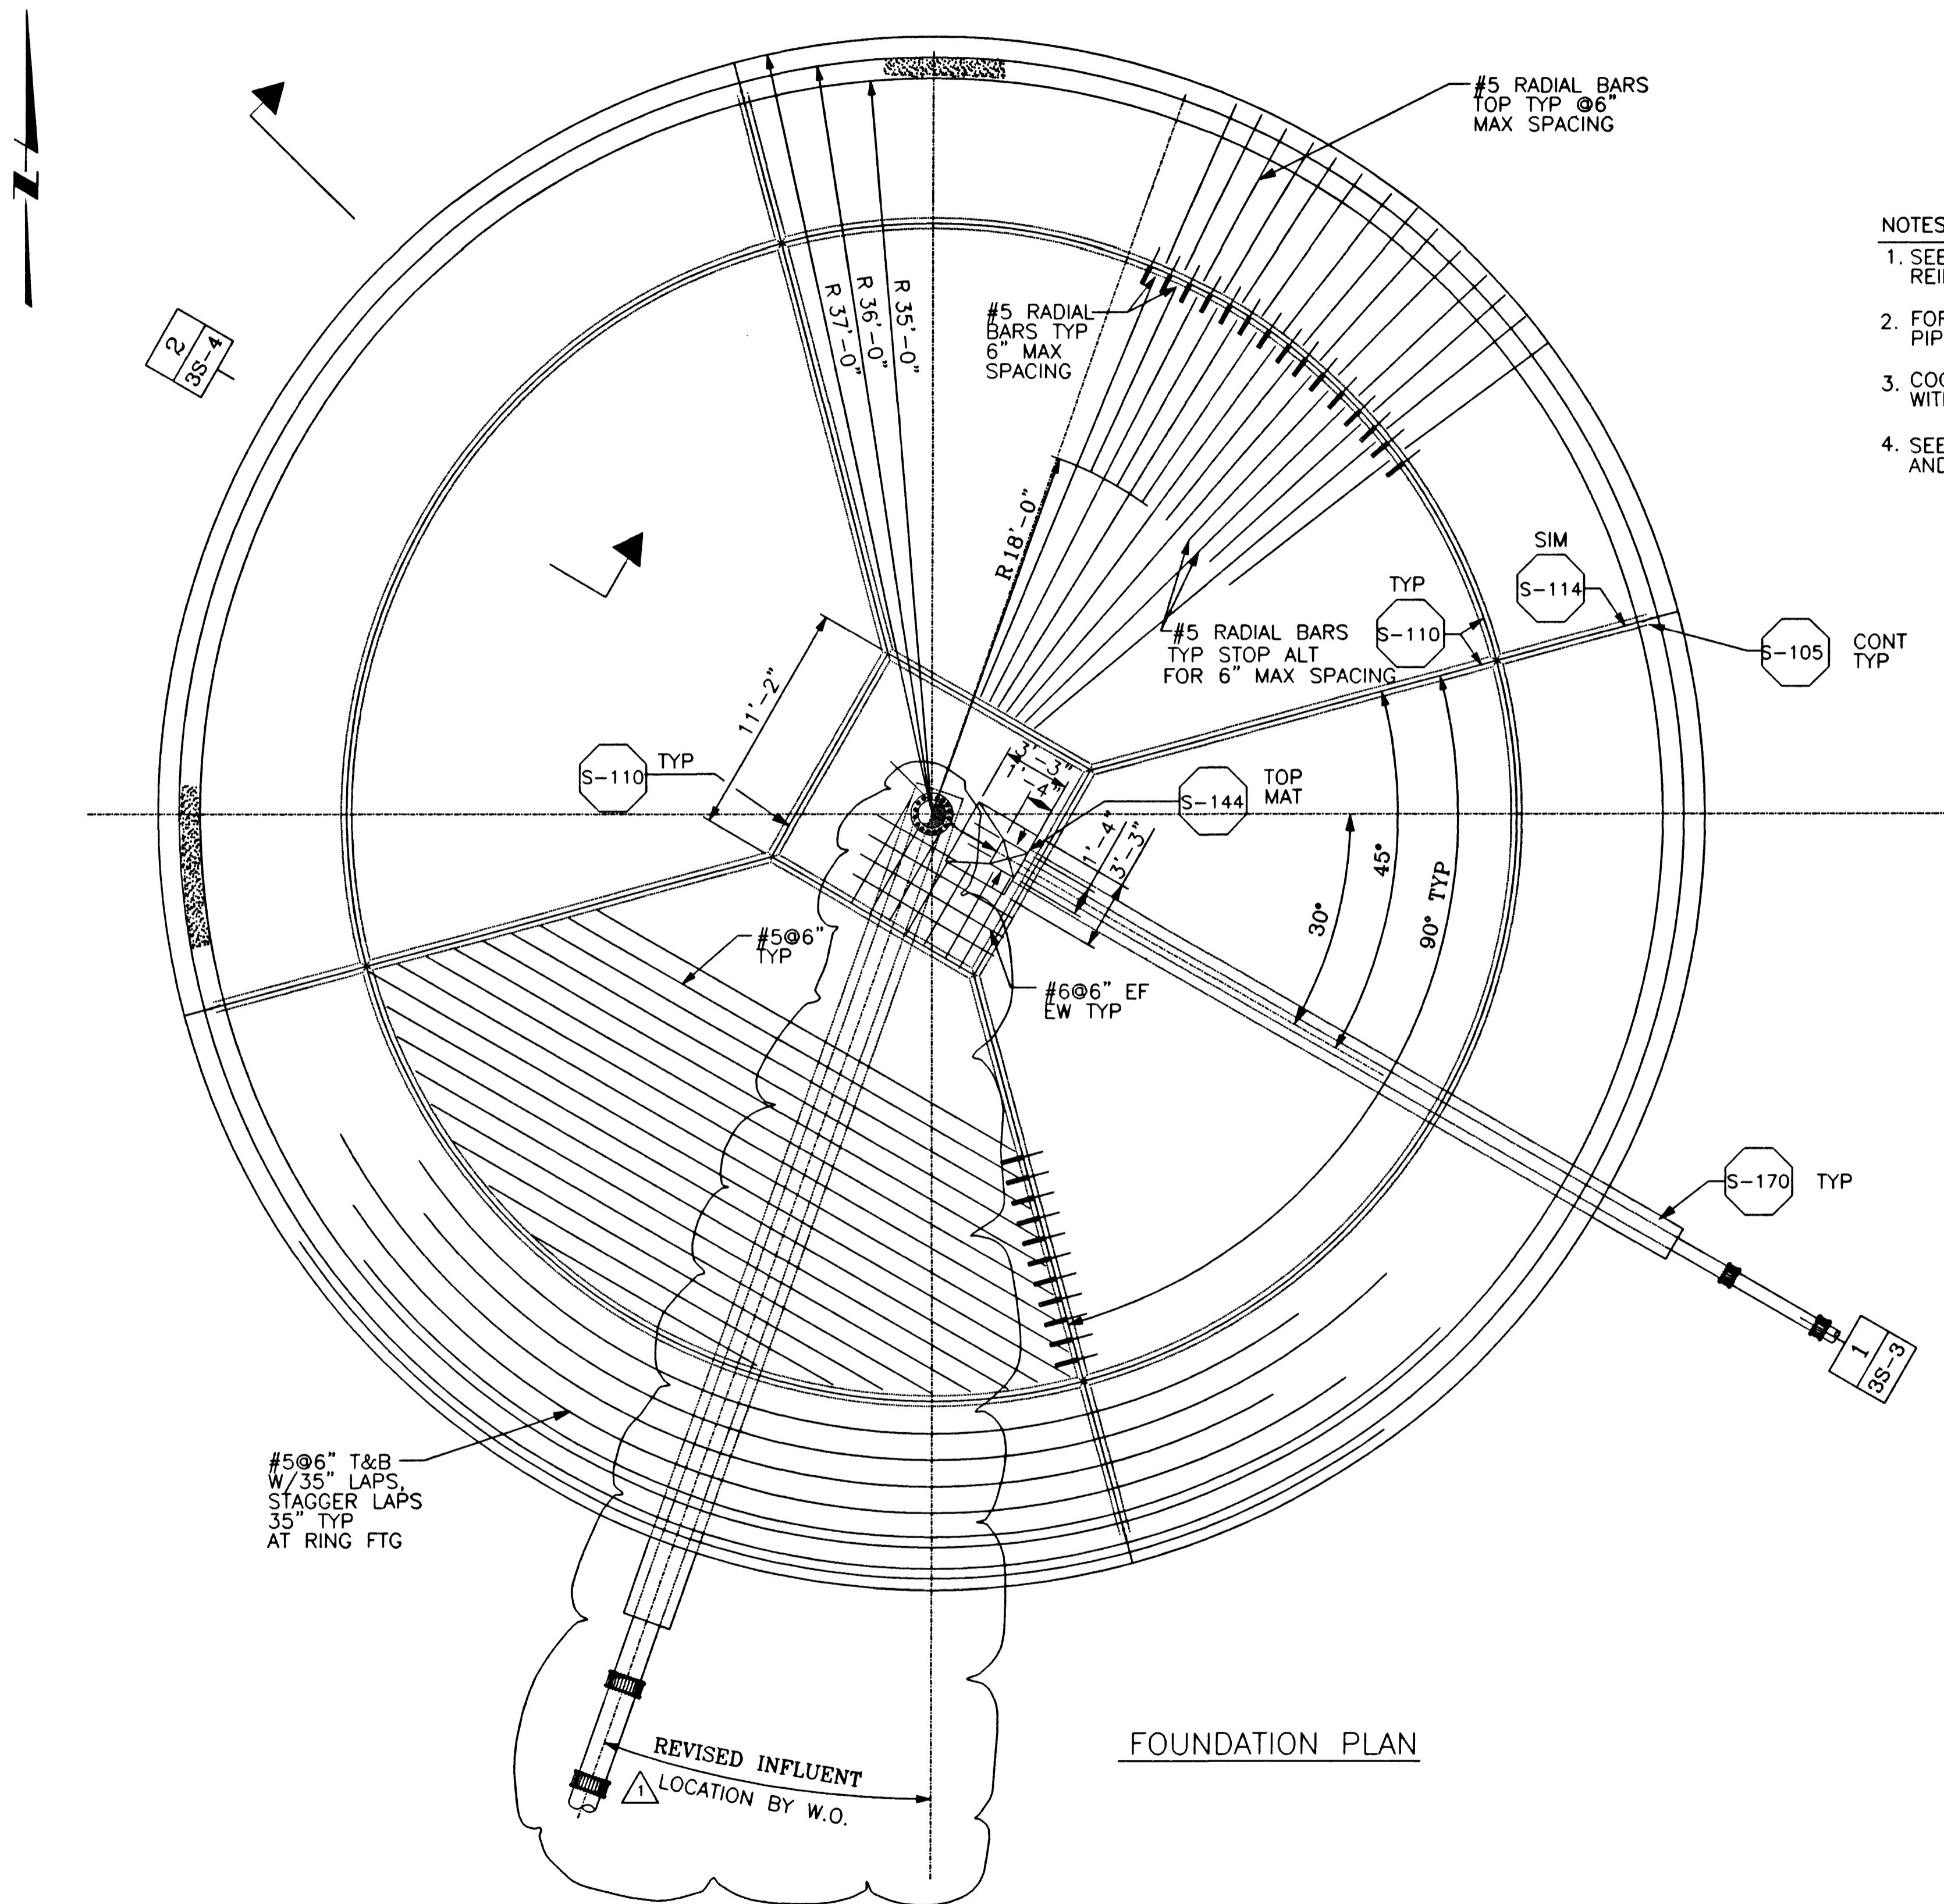

- NOTES:
1. SEE DWG 3S-2 FOR CLARIFIER WALL HORIZONTAL REINF LAP DETAIL.
  2. FOR EXACT LOCATION AND ORIENTATION OF PIPES, SEE MECH'L DWGS.
  3. COORDINATE ALL FINISHED GRADE ELEVATIONS WITH CIVIL DWGS.
  4. SEE GC-4 AND S-207 AND S-208 FOR UNDERDRAIN AND DRAINROCK CONFIGURATION TYP.

FOUNDATION PLAN

THE ORIGINAL CONTRACT DOCUMENT WAS SEALED AND SIGNED BY SAM MOUAWAD

	<b>AS BUILT</b>
	DATE
	10 APR 99


REV	DATE	BY	DESCRIPTION

SCALE: 3/16" = 1'-0"

WARNING: IF THIS BAR DOES NOT MEASURE 1" THEN DRAWING IS NOT TO SCALE.

DESIGNED: L. FAIRBANKS  
 DRAWN: L. FAIRBANKS  
 CHECKED: C. LEE

SUBMITTED THE ORIGINAL CONTRACT DOCUMENT WAS SIGNED BY SAM MOUAWAD  
 PROJECT ENGINEER R. C. E. NO. DATE  
 RECOMMENDED THE ORIGINAL CONTRACT DOCUMENT WAS SIGNED BY VICKI J. SCHARHORST  
 MONTGOMERY WATSON R. C. E. NO. DATE

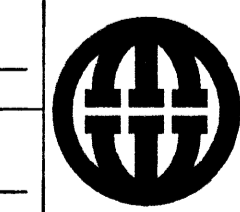

**MONTGOMERY WATSON**  
 Las Vegas, Nevada

MONTGOMERY WATSON  
 3014 WEST CHARLESTON BLVD  
 LAS VEGAS, NV 89102-1944  
 (702) 878-8010  
 COPYRIGHT © 1996 BY MONTGOMERY WATSON  
 ALL RIGHTS RESERVED

CITY OF LAS VEGAS  
 BONANZA/MOJAVE WATER RESOURCE CENTER  
 SECONDARY CLARIFIER  
 FOUNDATION PLAN

DWG. 59  
 3S-1  
 513-64

26296