



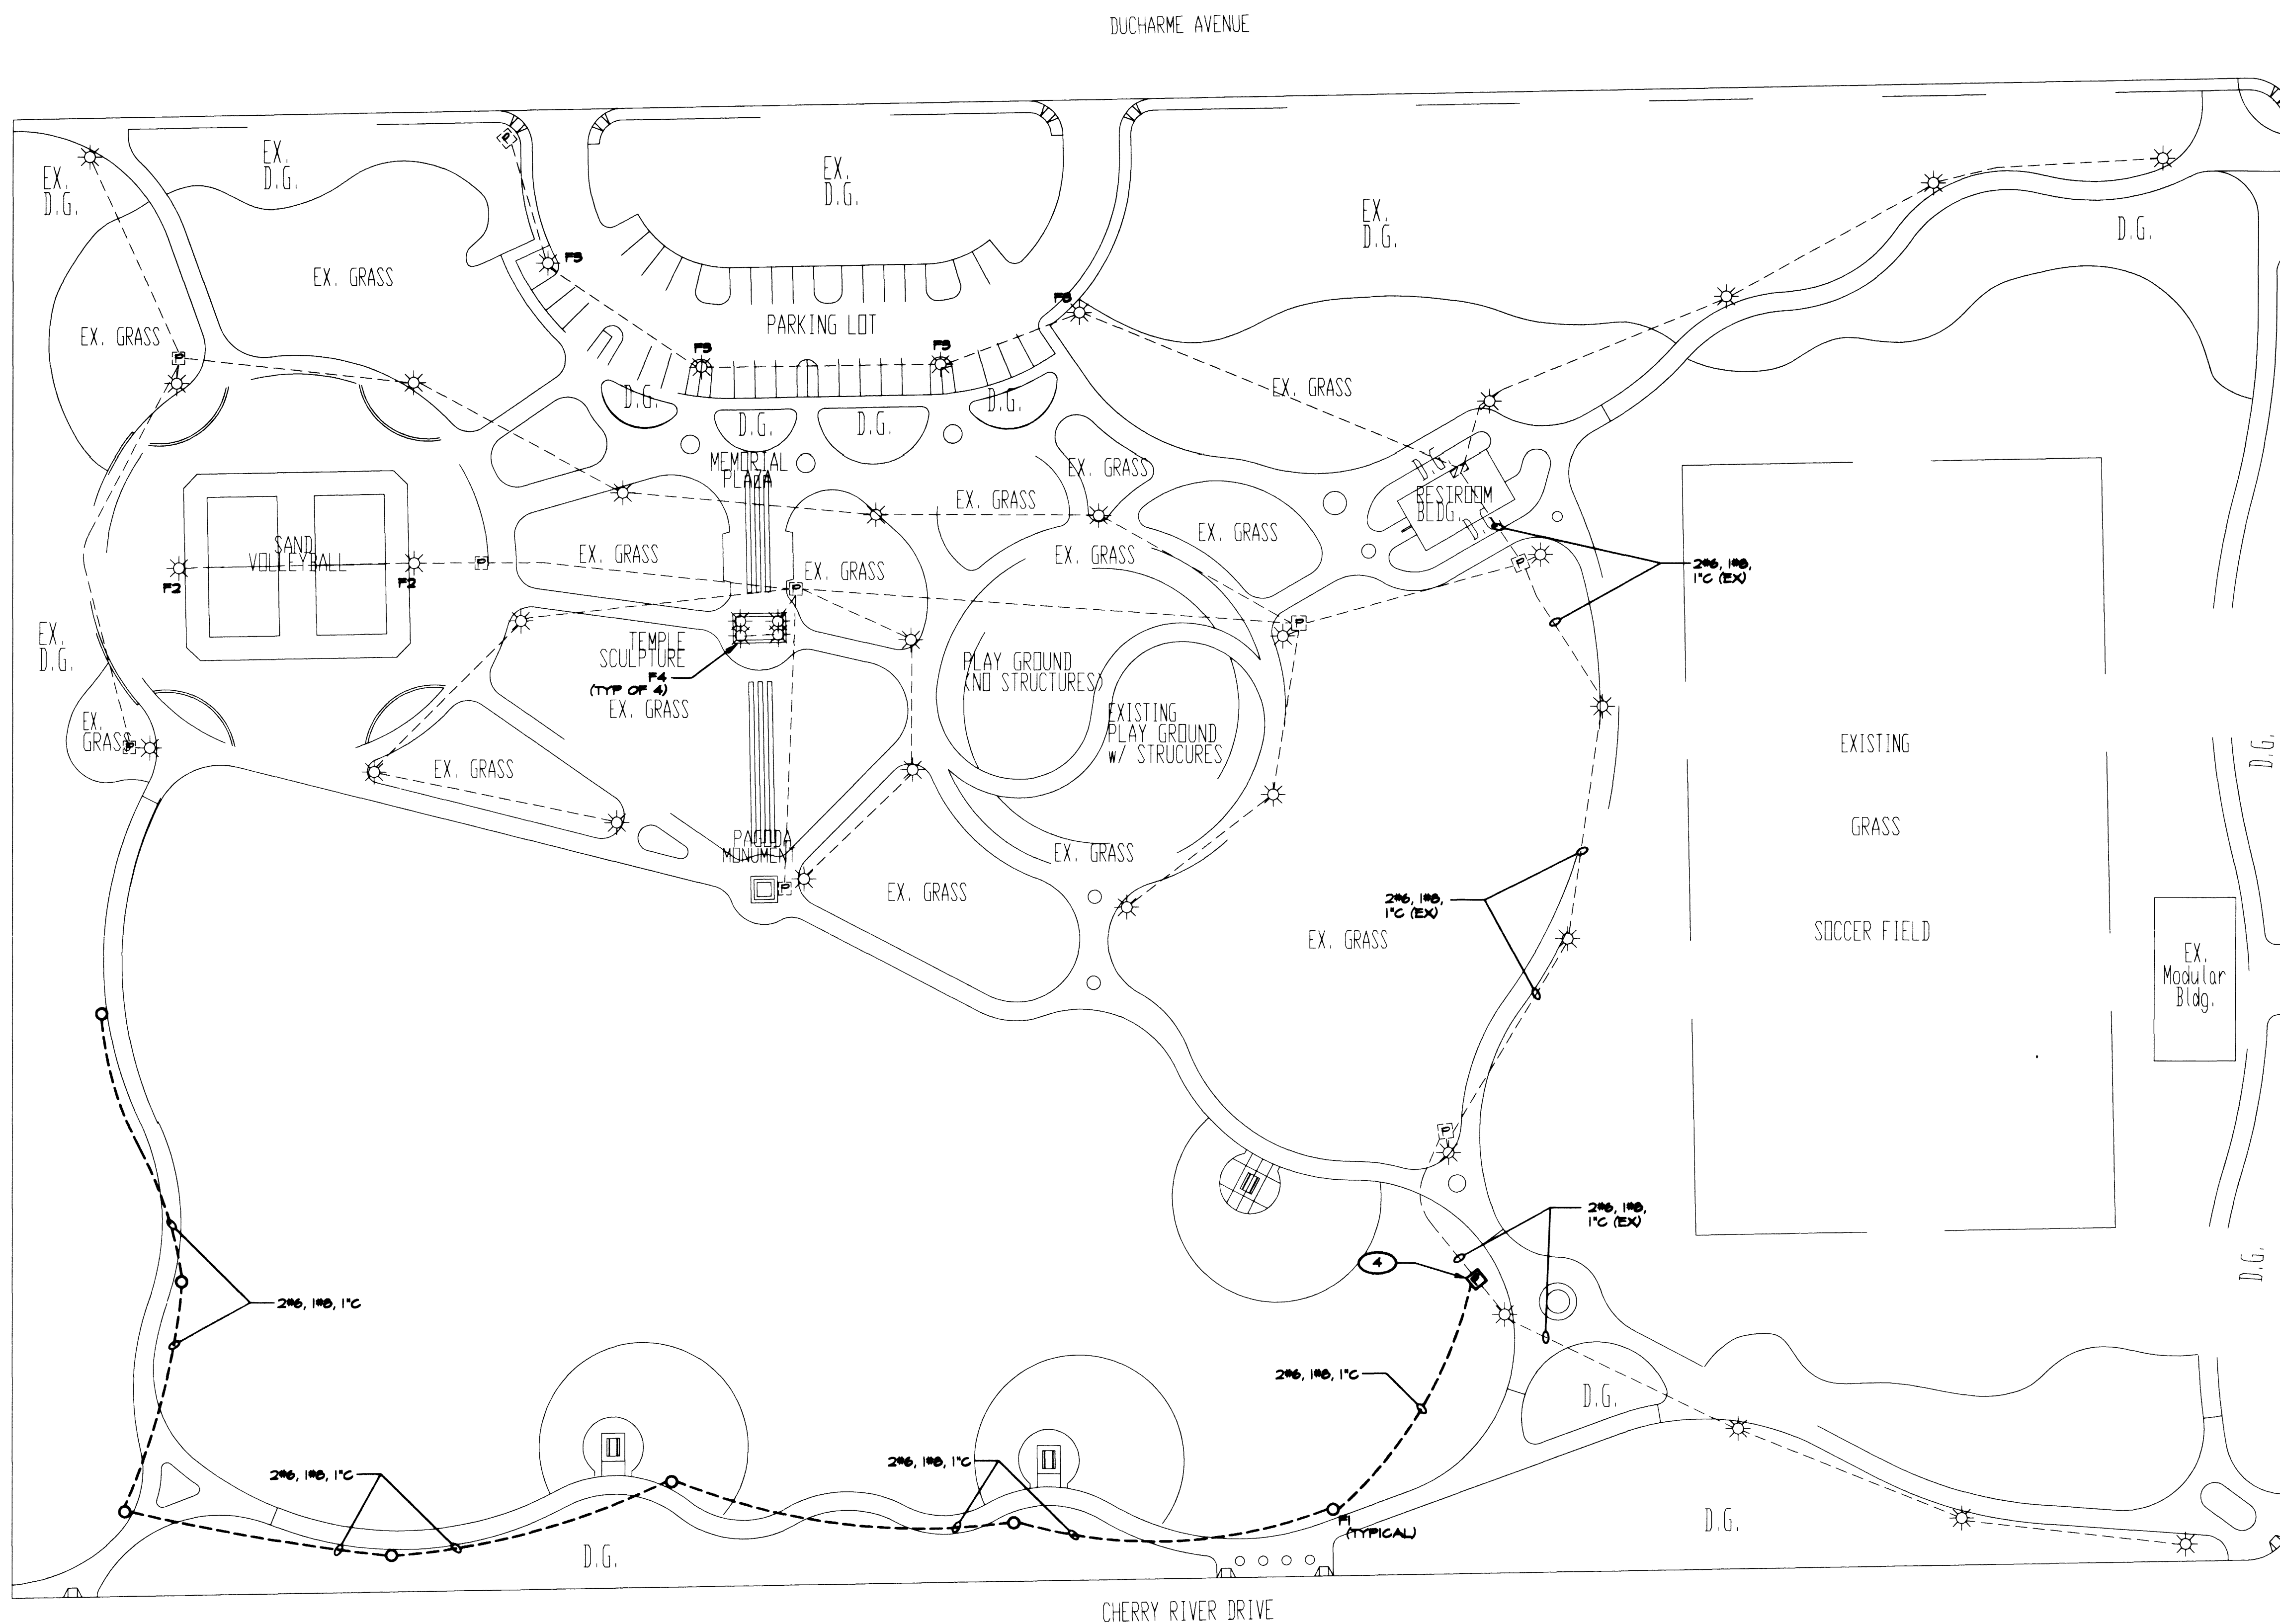

LEGEND

- PANELBOARD SURFACE MOUNTED
- SWITCHBOARD
- TRANSFORMER
- HID OR INCANDESCENT FIXTURE
- EXISTING HID POST TOP FIXTURE
- ELECTRIC SHEET NOTE DESIGNATION
- BRANCH CIRCUIT CONSISTING OF 2#12 IN MINIMUM SIZE CONDUIT NOT INCLUDING GROUND WIRE
- HOME RUN TO PANELBOARD OR DEVICE - NUMBER OF ARROW HEADS INDICATES NUMBER OF CIRCUITS
- BRANCH CIRCUIT - SHORT SLASHES INDICATE NUMBER OF PHASE OR SWITCH LESS, LONG SLASHES INDICATE NUMBER OF NEUTRALS, LONG SLASH W/ A DOT INDICATES A SEPARATE ISOLATED GROUND WIRE.
- CONDUIT IN SLAB OR UNDERGROUND
- EXISTING CONDUIT
- INTERRUPTER SWITCH
- FUSE
- CIRCUIT BREAKER
- METERING
- MOTOR OUTLET
- CONDUIT
- CONDUIT ONLY
- PULLBOX - SIZE NO. 3-1/2" UNLESS NOTED OTHERWISE
- EXISTING PULLBOX

VILLA MONTEREY DRIVE

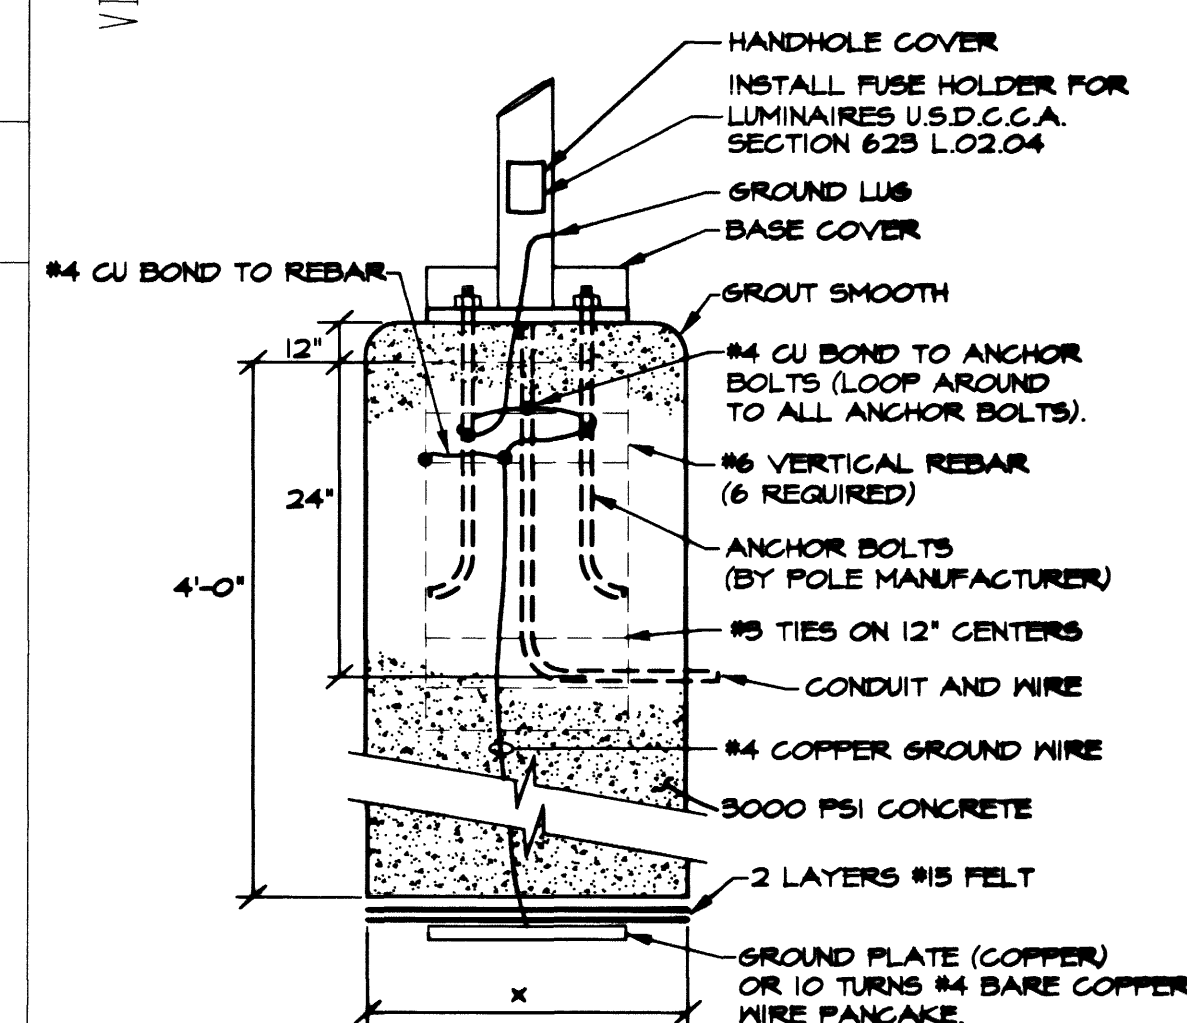


POLE BASE DETAIL

SCALE: NOT TO SCALE

NOTES:

- 1 ALL FIXTURES ARE TYPE FI UNLESS NOTED OTHERWISE.
- 2 ALL PULLBOXES ARE NO. 3-1/2 UNLESS NOTED OTHERWISE.
- 3 WIRING IS 2#6, 1#6, 1" C UNLESS NOTED OTHERWISE.
- 4 INTERCEPT EXISTING CONDUIT AND WIRE WITH NEW PULLBOX, CONNECT NEW WIRE TO EXISTING CIRCUIT 5 AT PULLBOX. INSTALL CONCRETE COLLAR AROUND PULLBOX IN GRASS OR DIRT PER U.S.D.C.C.A. D146-324.
- 5 NOT USED.
- 6 REMOVE 2#6 PHASE WIRES FROM CIRCUIT BREAKER TO CONTACTOR. REPLACE WITH 2#6 THIN IN EXISTING CONDUIT.

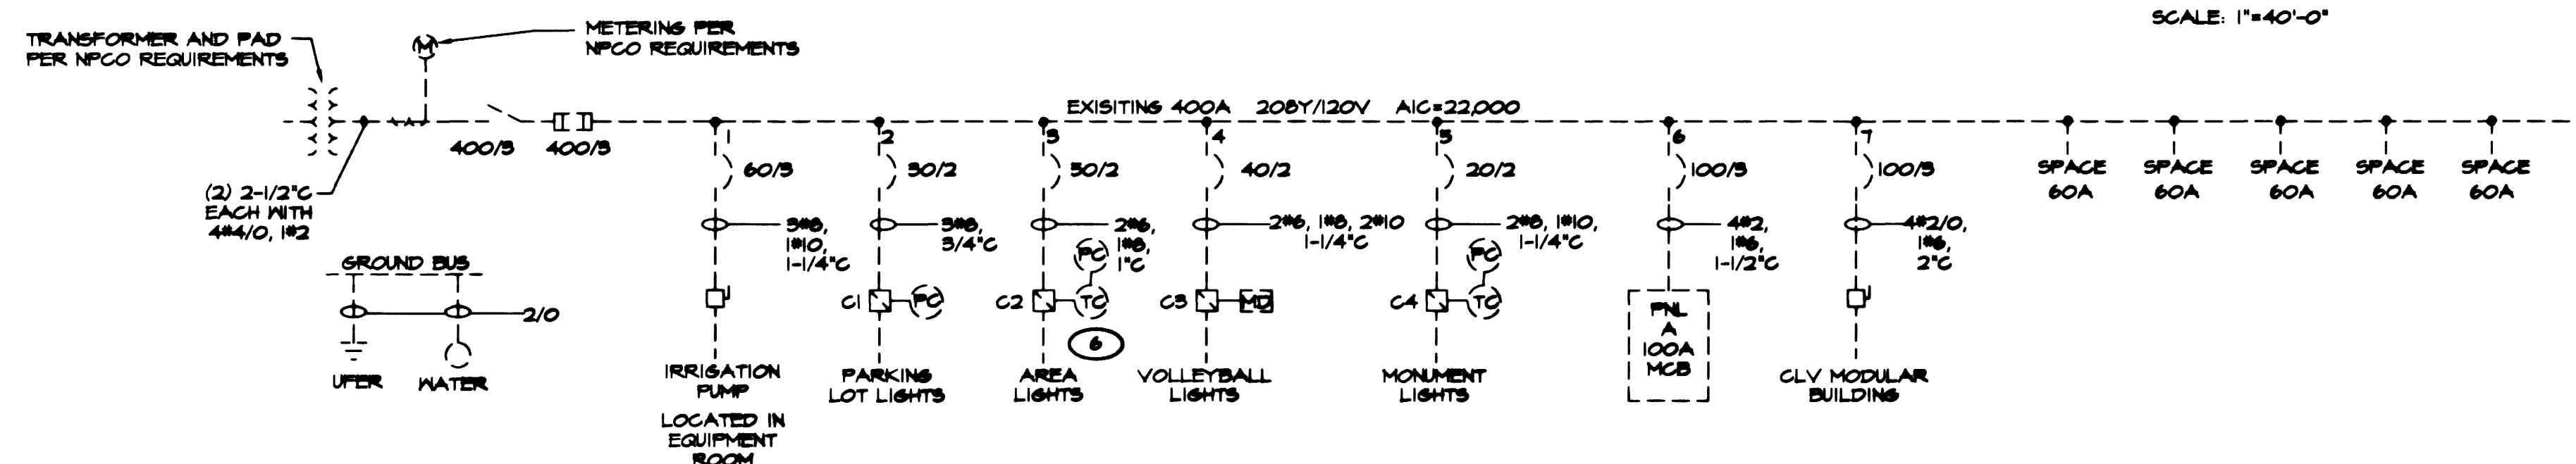

ELECTRICAL SITE PLAN

SCALE: 1"=40'-0"

DESCRIPTION

DATE

REV

TJKROB
CONSULTING
ENGINEERS, INC.
7151 CASCADE VALLEY COURT SUITE 200
LAS VEGAS, NEVADA 89128
(702) 671-3621
ELECTRICAL ENGINEERING

SHEET TITLE: **ELECTRICAL SITE PLAN**

PROJECT: **ANSAN SISTER CITY PARK, PHASE III**

JOB NUMBER:

0184/SITE

DATE:

05/02/99


DRAWN BY:

DSN/CRS

CHECKED BY:

TOM KROB

RECOMMENDED

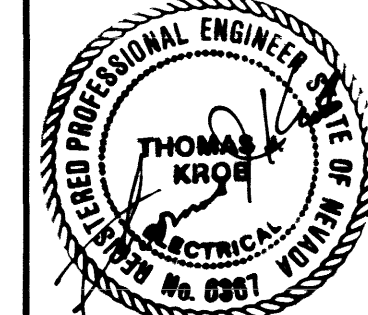

DATE: 5/13/99

SHEET:

E1

OF: 2

26964

650.36-4