



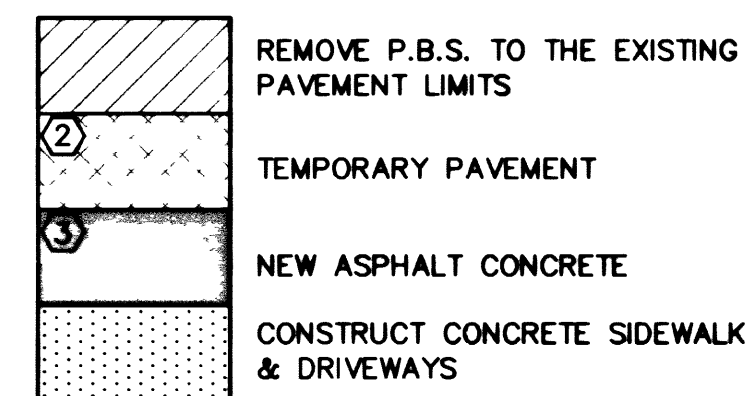

EXISTING SPOT ELEVATION ARE TAKEN FROM
FIELD MEASUREMENTS SHOWING EXISTING CONDITIONS

GRAPHIC SCALE

(IN FEET)
1 inch = 30 ft.

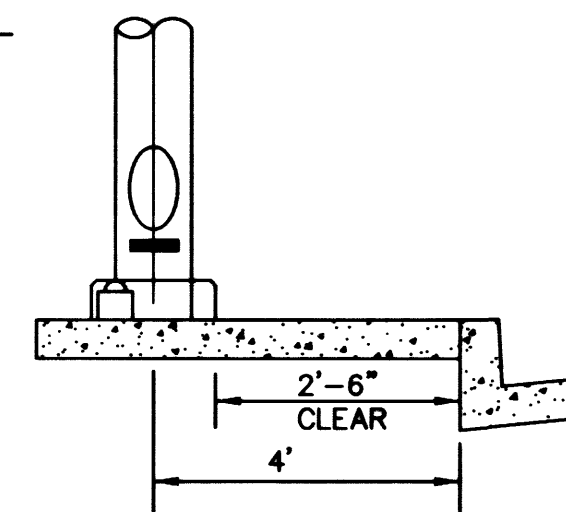


ALL HAND HOLE COVERS MUST BE INSTALLED,
POLE CAPS POURED, & PULL BOX LIDS BOLTED
DOWN PRIOR TO ENERGIZING CIRCUIT. ALL WIRE
MUST HAVE THW INSULATION

- ① INSTALL STREET LIGHT PER USD. NO. 313, NO. 314, 8" MAST ARM, FOUNDATION PER USD NO. 319 AND 200W HIGH PRESSURE SODIUM LUMINAIRE
- ② INSTALL NO. 3-1/2 PULL BOX PER USD NO. 404,110
- ③ INSTALL 2" STREET LIGHT CONDUIT, UNLESS OTHERWISE SHOWN, IN ACCORDANCE WITH SPECIFICATION 623C.02.01 (WITH 2-#4, 1-#8 THW WIRES TYP)
- ④ INSTALL 200 AMP PAD MOUNT SERVICE
- ⑤ INSTALL PHOTO ELECTRIC CELL PER USD NO. 335



Call
before you
Dig
1-800-227-2687

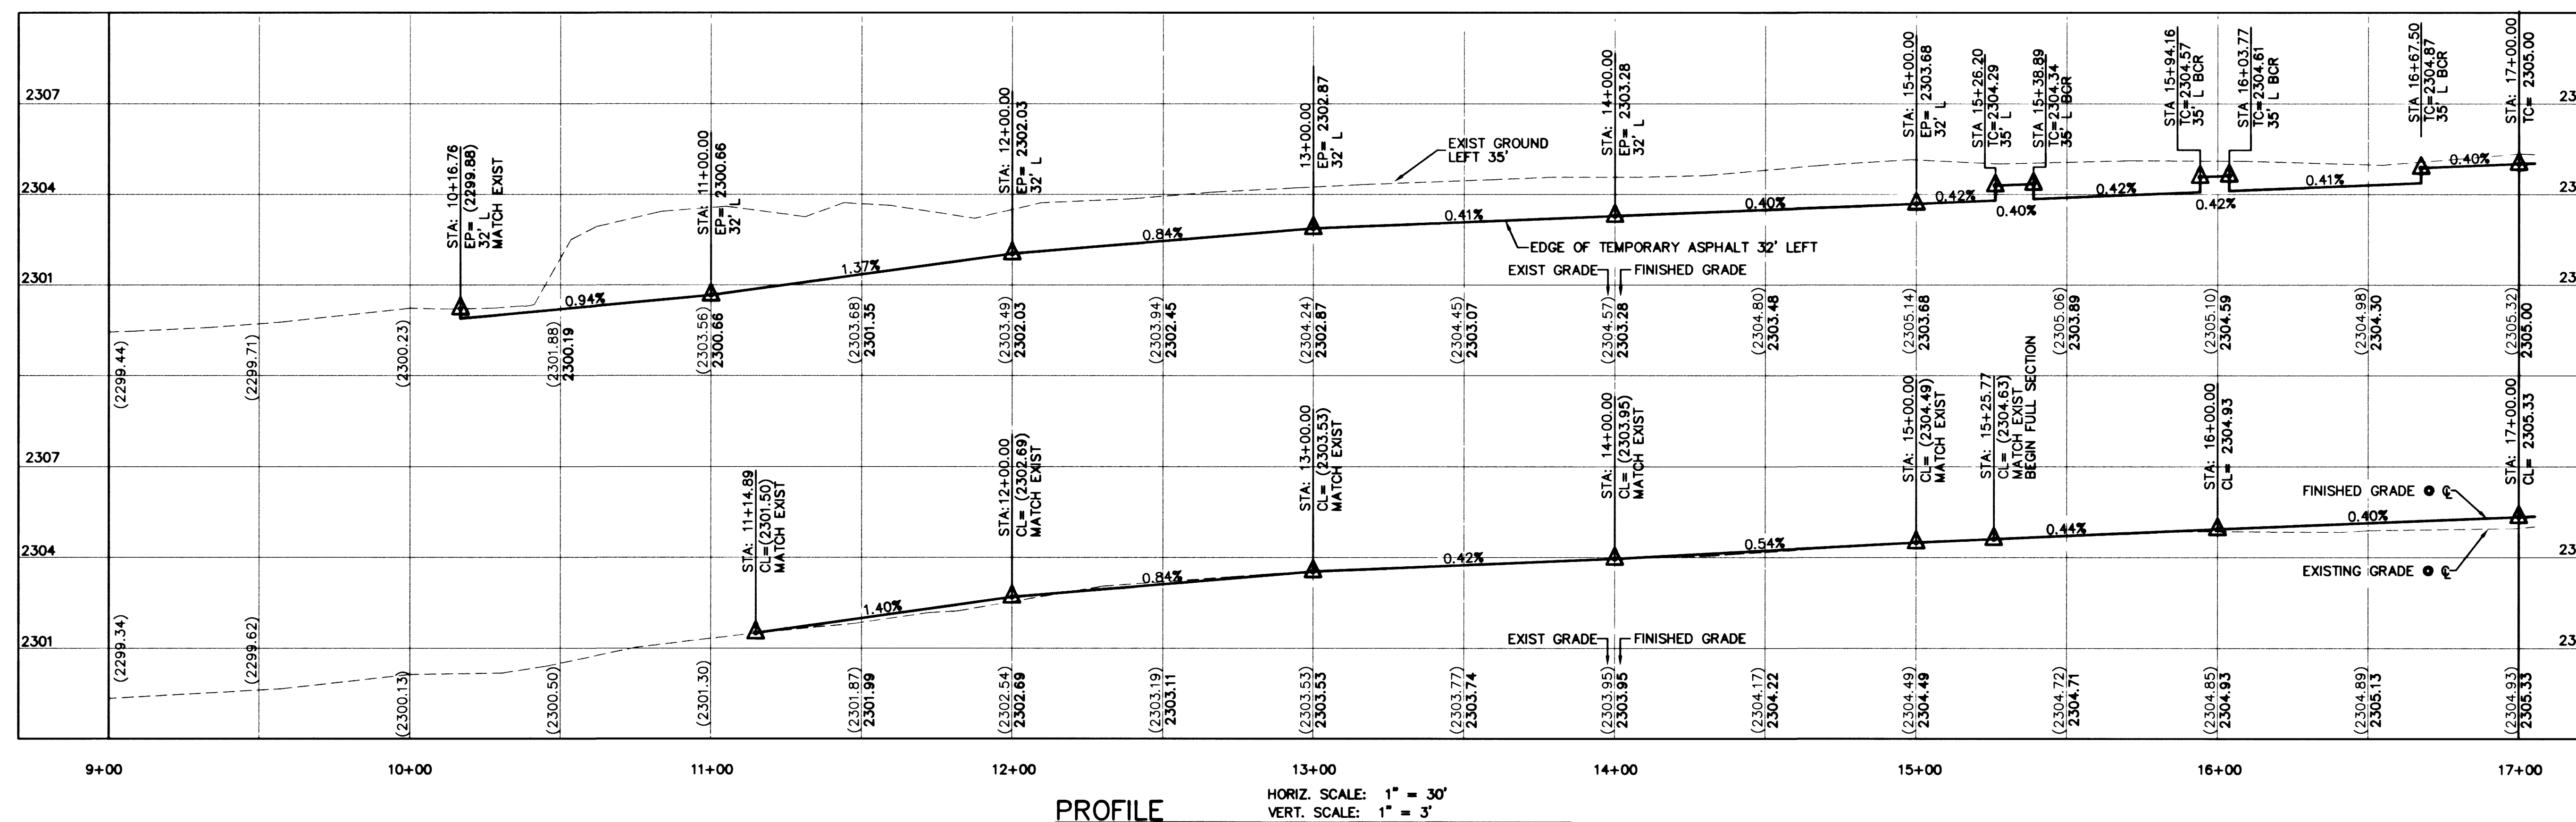

C:\601PRF.dwg 11-29-00 2:47:06 pm PST

28453

TWA FRANCIS CONSTRUCTION

P.O. BOX 71371
SALT LAKE CITY, UTAH 84171
(801) 973-0774

POGGEMEYER DESIGN GROUP
ENGINEERS PLANNERS SURVEYORS
LANDSCAPE ARCHITECTS
(801) 973-9774

LANDSCAPE ARCHITECTS
3601 NORTH TENAYA WAY LAS VEGAS, NEVADA 89128 (702) 255-8100

OFF-SITE PLAN / PROFILE
TORREY PINES DRIVE

BLM STORAGE BUILDING
RANCHO DR. /TORREY PINES DR.

DRAWN BY:	
BCK	09.07.00

DESIGNED BY:

SGW	09.07.00
CHECKED BY:	

KLS	09.07.00
-----	----------

PROJECT NO:	SCALE: 1" = 30' HOR.
-------------	----------------------

SHEET

C6
9 OF **13** SHEET

CLV DRAWING NO.
107-V 3368