


THE REPRODUCTION, COPY, OR USE OF THIS DRAWING WITHOUT THEIR PRIOR WRITTEN CONSENT IS PROHIBITED, AND ANY INFRINGEMENT WILL BE SUBJECT TO LEGAL ACTION.

NOTE: DO NOT SCALE DRAWING. FOLLOW DIMENSIONS. THIS DRAWING AND DESIGN CONCEPTS SHOWN THEREIN ARE THE SOLE PROPERTY OF WESTAR ARCHITECTURAL GROUP / NEVADA, INCORPORATED.

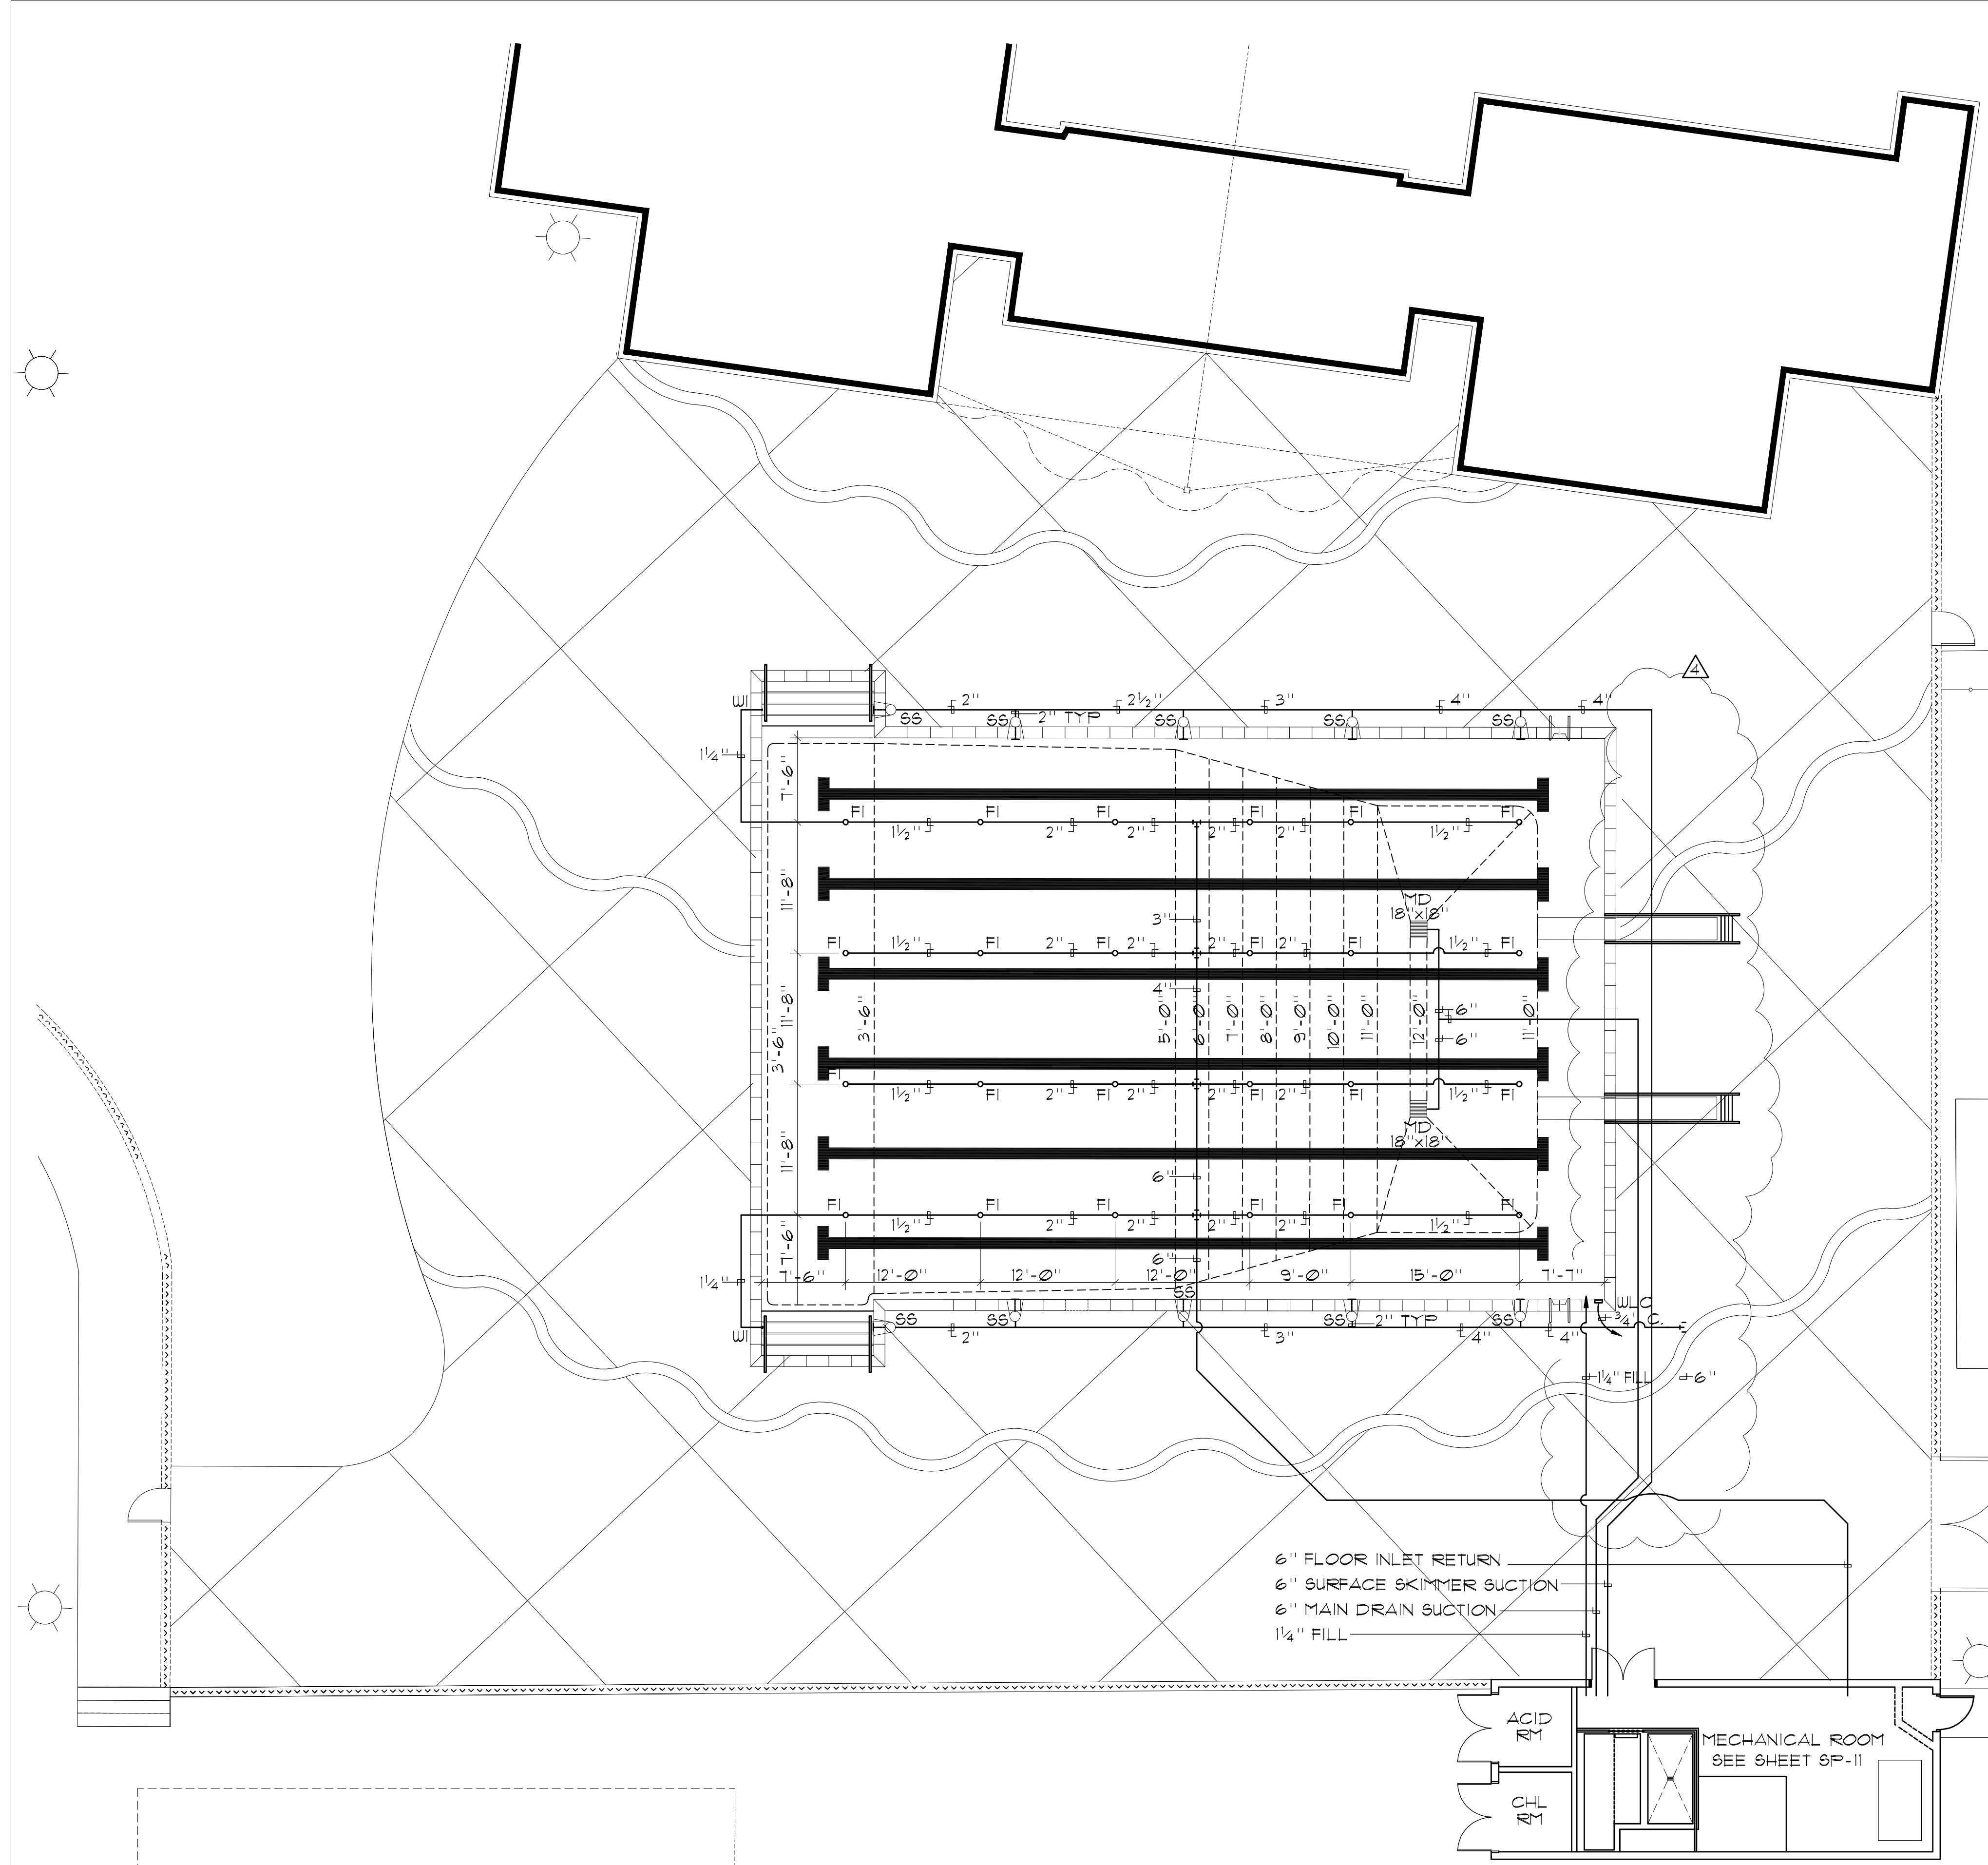

SWIMMING POOL DATA

SURFACE AREA	=	3,800 SQ. FT.
PERIMETER	=	260 FT.
DEPTHS	=	3'-6" TO 12'-0"
VOLUME	=	191,600 GAL.
6 HR TURNOVER	=	532 GPM

LEGEND

MD	=	MAIN DRAIN	(4) (6P-6)
FI	=	FLOOR INLET	(4) (6P-7)
SS	=	SURFACE SKIMMER	(5) (6P-7)
WLC	=	WATER LEVEL CONTROLLER	(2) (6P-7)
WI	=	WALL INLET	(6) (6P-7)
HB	=	HOSE BIB CONNECTION (BY OTHERS)	

MATERIAL SPECIFICATION(S):

1. CONCRETE/SHOTCRETE $f'c = 4500$ psi @ 28 DAYS (DUE TO SEVERE SULFATE EXPOSURE).
2. REBAR $f_y = 40,000$ psi.
2. AT REST SOIL PRESSURE = 50 pcf PER SOILS REPORT BY KLEINFELDER DATED 1/12/00


RECORD DRAWINGS
 AS-BUILT INFORMATION WAS PROVIDED BY THE CONTRACTOR. AQUATIC DESIGN GROUP ASSUMES NO LIABILITY FOR ACCURACY OF IT'S CONTENTS.



AQUATIC DESIGN GROUP
 850 KELLOGG AVE
 CARLSBAD, CALIFORNIA
 92008
 (760) 438-9400

REVISIONS
 CITY CORRECTION 12/1/00
 AS BUILT CHANGES 08/24/03

WESTAR
 ARCHITECTURAL GROUP / NEVADA INC.
 LAS VEGAS * PHOENIX
 ARCHITECTURE * PLANNING * PROJECT MANAGEMENT
 3900 MEADOWS LANE SUITE 220 LAS VEGAS, NEVADA 89107
 TELEPHONE: (702) 878-0000 FAX: (702) 878-8430

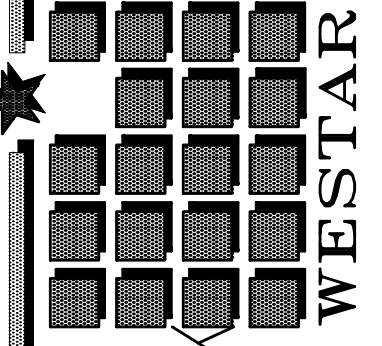

MASTERPLAN REDESIGN FOR:
CITY OF LAS VEGAS - BAKER PARK
 1020 E. ST. LOUIS AVE.
 LAS VEGAS, NEVADA

DRAWN BY: GMK
 REVIEWED BY: SJF
 PROJECT NUMBER: 99110
 ISSUE DATE: 12-1-00

021818SE 8902SP11/78
SP
 SWIMMING POOL PIPING PLAN