
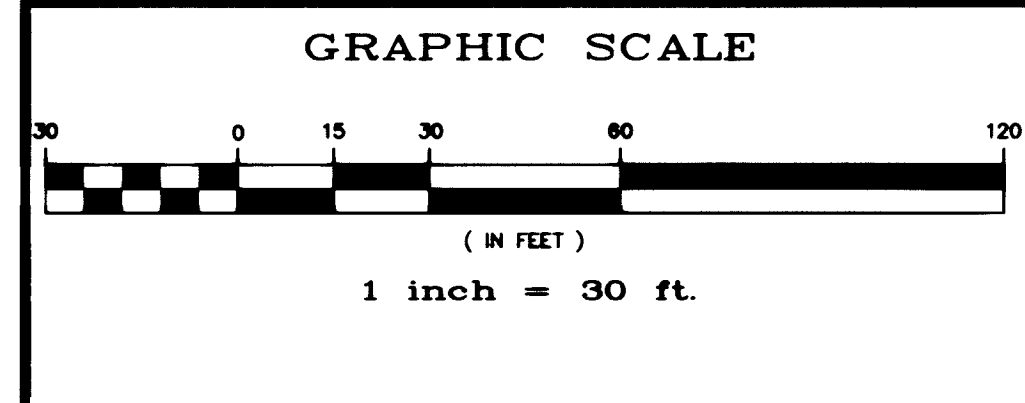
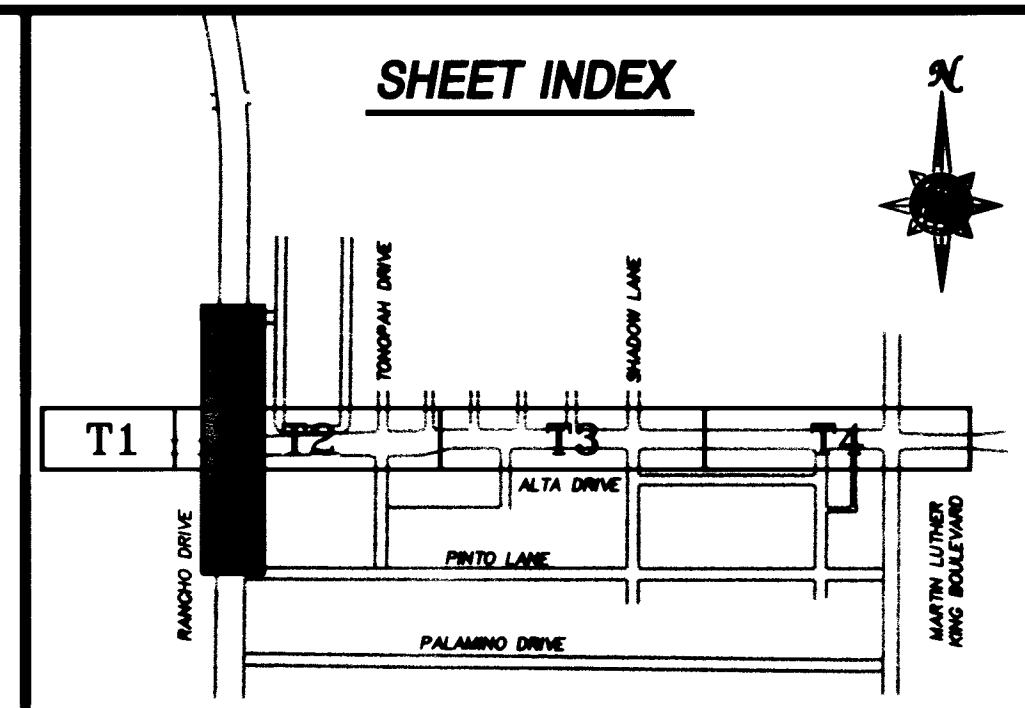
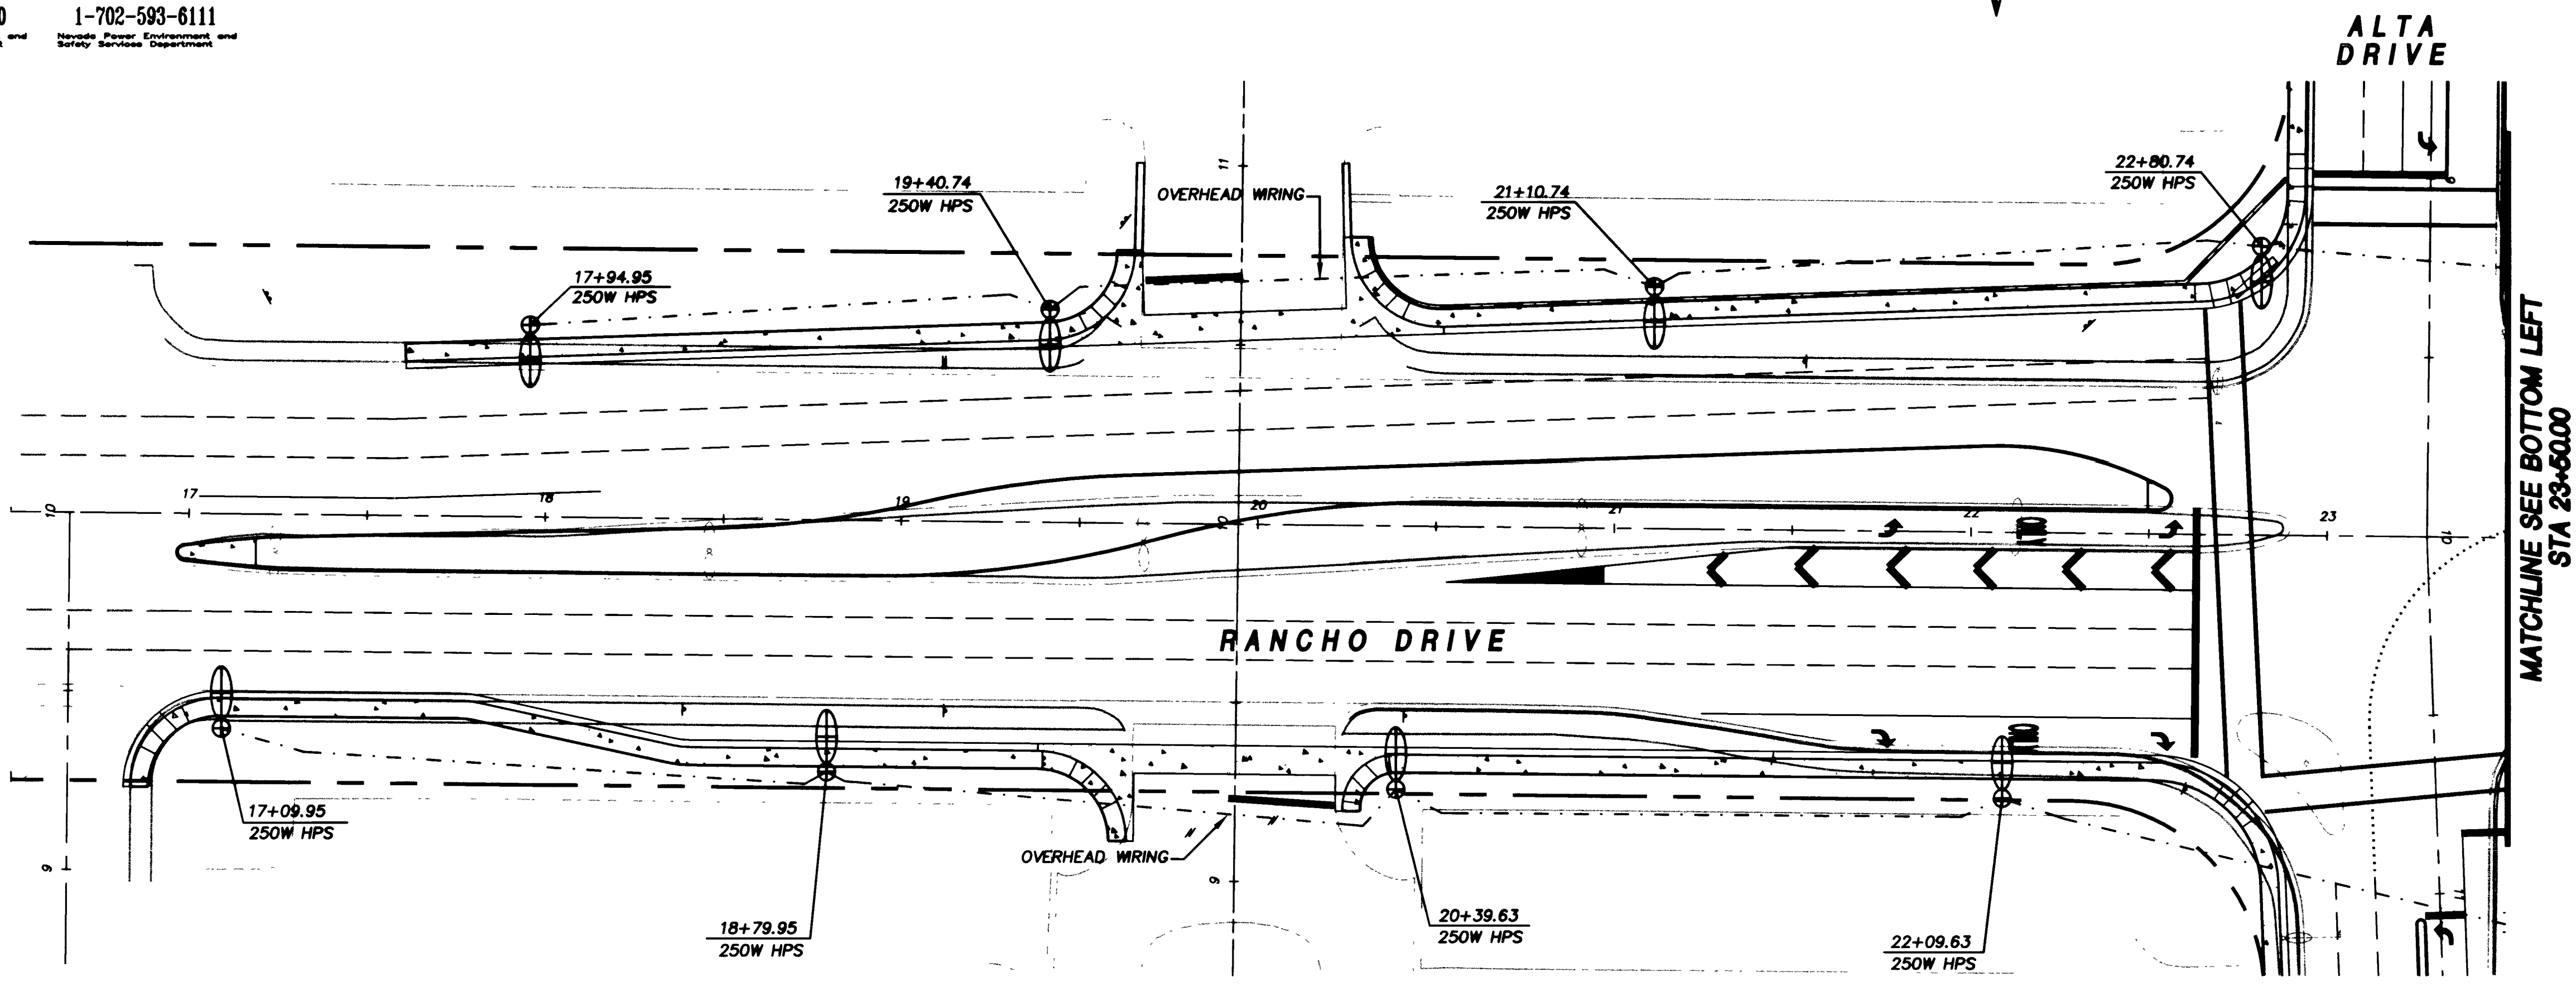


Call before you Dig  
1-800-227-2600  
Nevada Power, Environment and Safety Agency

Call before you Overhead  
1-702-593-6111  
Nevada Power, Environment and Safety Agency

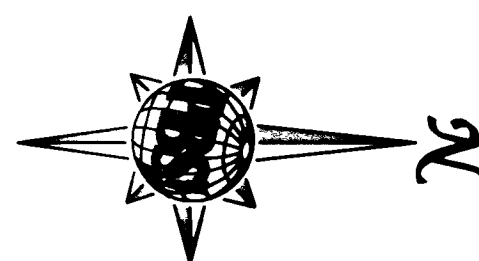

**BASIS OF BEARING**  
N89°28'51" BEING CENTERLINE OF ALTA DRIVE PER BOOK 10, PAGE 57, REC. FEB. 2, 1965

**BENCHMARK**  
CLV BENCHMARK BM 1LV0132SE6, CLV DATUM (2071.68') BRASS DISK AT THE NORTHWEST CORNER OF RANCHO DRIVE AND PALOMINO DRIVE.

**CAUTION**  
EXISTING UTILITIES ARE LOCATED ON THE PLANS FROM A SEARCH OF AVAILABLE RECORDS. CONTRACTOR TO VERIFY LOCATIONS AND DEPTHS PRIOR TO CONSTRUCTION.



REVISIONS		NO.	DATE	DESCRIPTION	APPROVED

ENGINEERING DESIGN SECTION  
 DRAWN BY: J. XIE  
 CHECKED BY: W. HORLACHER  
 DATE: DECEMBER 06, 2000  
 JOB NO.: 51736  
 901 N. Green Valley Pkwy.  
 Henderson, Nevada 89014  
 Telephone: 702/265-7275  
 Fax: 702/265-7261  
**PBS&J**  
 PROFESSIONAL ENGINEERING SERVICES

**TEMPORARY LIGHTING NOTE**

TEMPORARY LIGHTING SHALL BE PROVIDED ON BOTH SIDES OF RANCHO DR. IF PERMANENT LIGHTING IS NOT OPERATIONAL DURING CONSTRUCTION.

THE TEMPORARY LIGHTING SHALL USE WOOD POLES AND 250W LUMINAIRES AT 170 FEET SPACING WITH OVERHEAD WIRING. LUMINAIRE MOUNTING HEIGHT SHALL BE 32 FEET. THE LOCATIONS OF THE WOOD POLES ARE SHOWN ON THIS SHEET. CONTACT CITY OF LAS VEGAS TRAFFIC/ELECTRIC FIELD OPERATIONS (TEFO) FOR POWER CONNECTION. TEL: (702) 229-6075

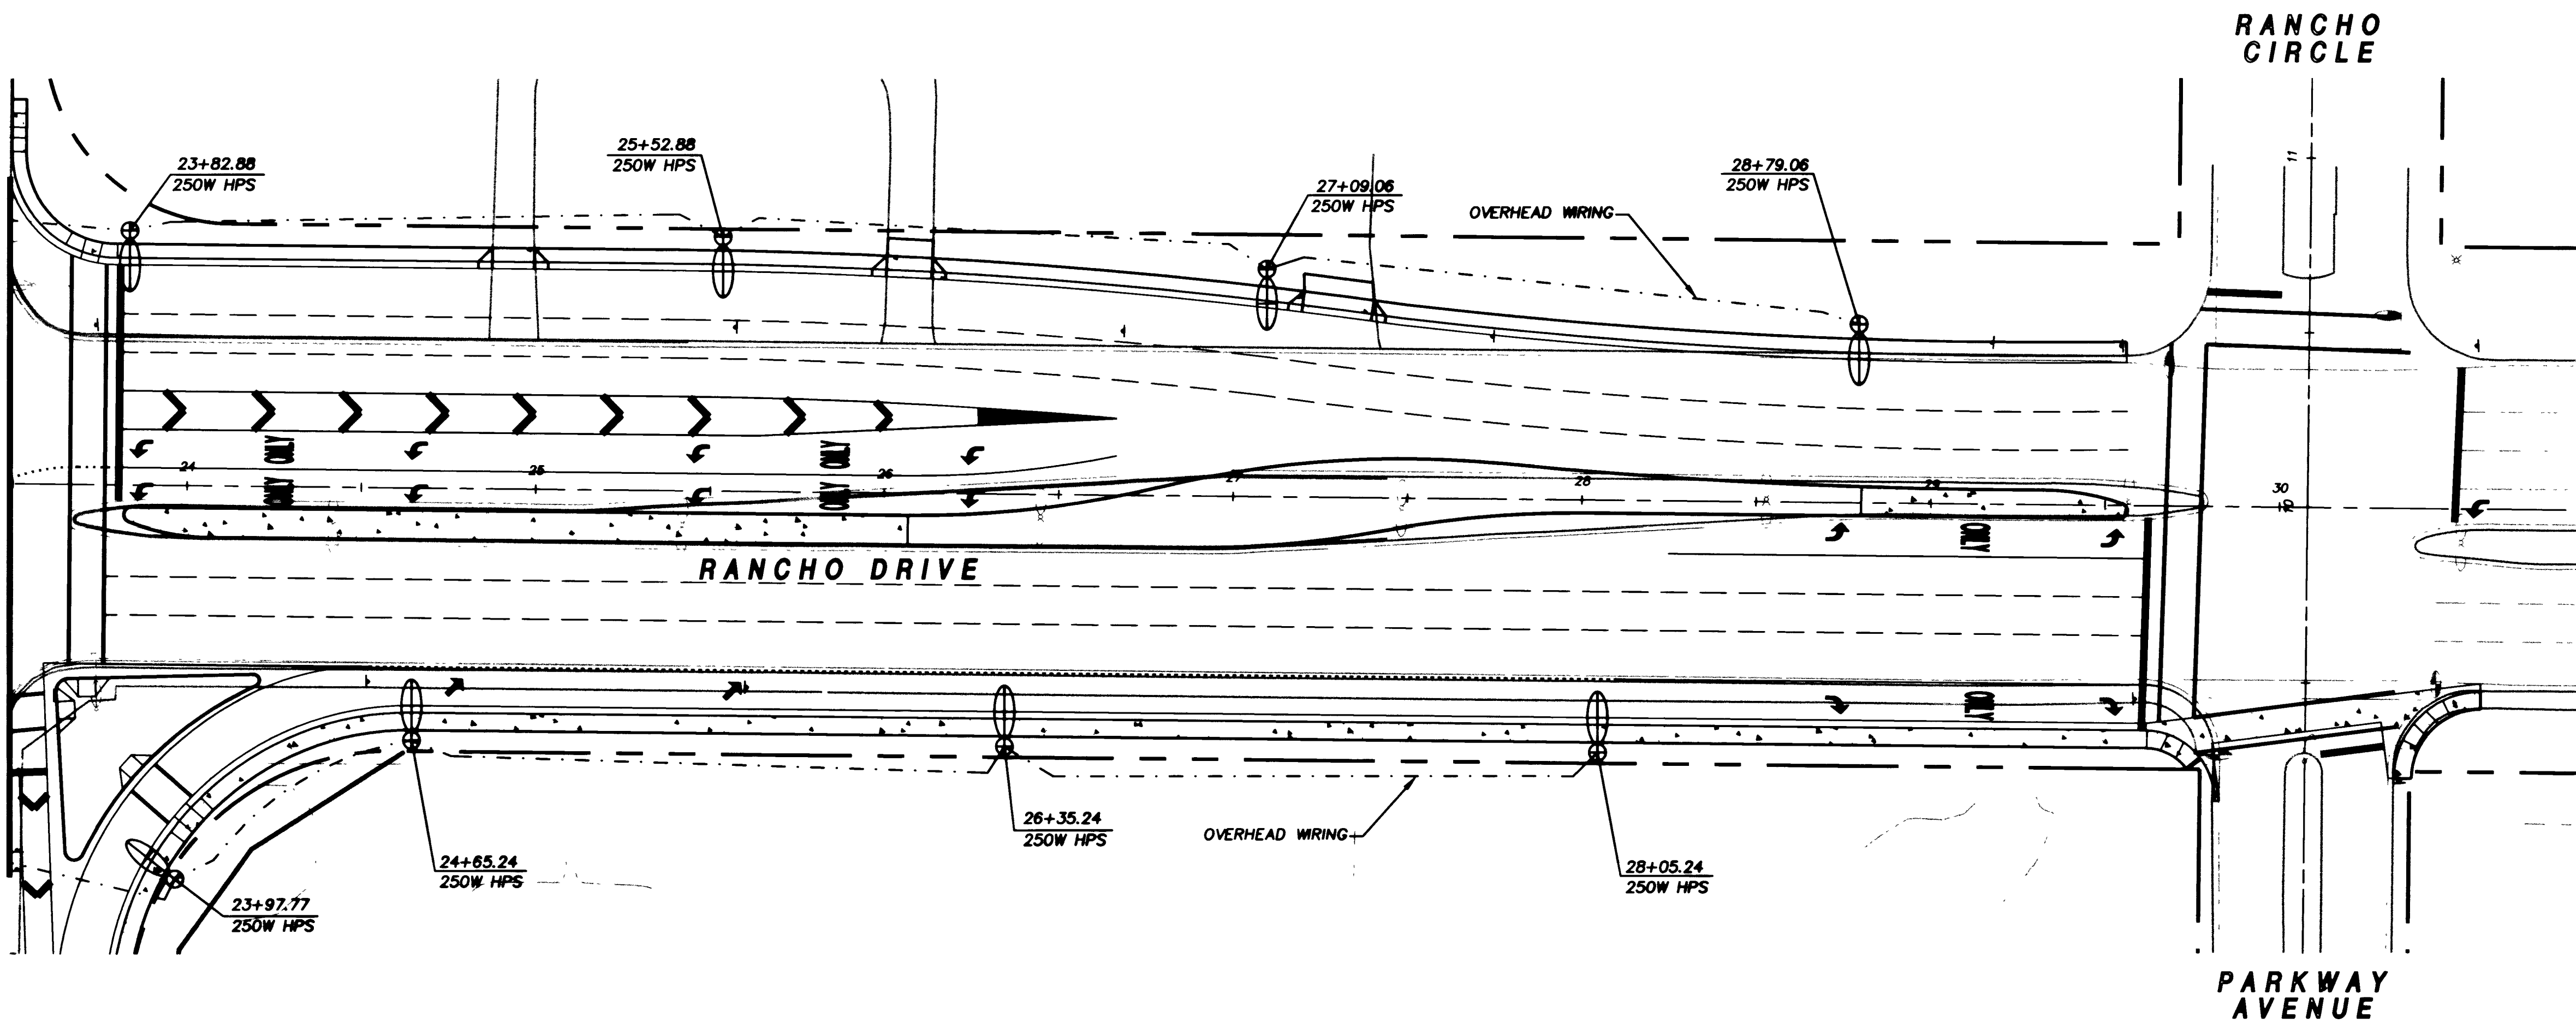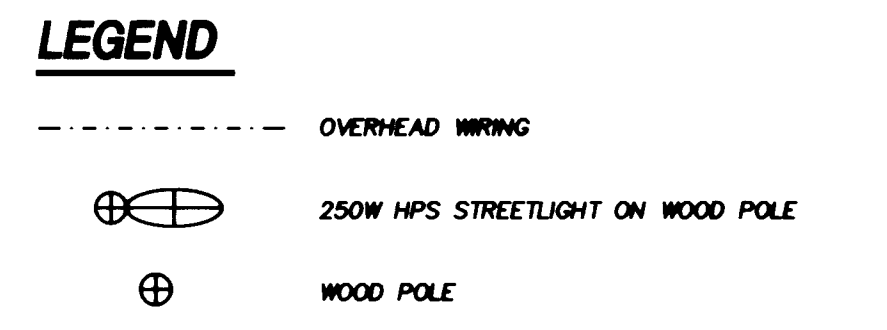

Department of Public Works  
 ALTA/RANCHO IMPROVEMENTS PHASE II  
 TEMPORARY LIGHTING PLAN  
 RANCHO DRIVE



DRAWING No. 53  
 T6  
 PLAN# 107-V3126 55