

HIGH POINT ELEV = 2831.37
 HIGH POINT STA = 3+12.16
 GB STA = 3+00
 GB ELEV = 2831.56
 A.D. = 3.92
 K = 12.76
 50.00' VC
 STA. 2+50 ELEV. 2830.10
 BEG. PAVEMENT TRANSITION

NOTE:
 1. FINAL A.C. PAVEMENT SURFACE SHALL BE 1/2" ABOVE UP OF GUTTER.
 2. NATIVE SOILS ARE TO BE USED IN LIEU OF TYPE I AGGREGATE BASE PER SOILS REPORT

APPLE DRIVE - TYPICAL 80' PRIVATE DRIVE SECTION (FULL STREET)
 (NOT TO SCALE)

NOTE 'A'
 CLOSE EX. 6" GATE VALVE IN EX. VALVE VAULT PRIOR TO RELOCATING EX. B.O. VALVE.


NOTE 'B'
 INSTALL "H" FOUNDATIONS PER CLV STD. DWG. NO. 404.209 WITH BASE ADAPTOR PLATES PER CLV STD. DWG. NO. 404.408. W/ STD. STREET LIGHT POLE, 250 W. HPS LUMINAIR AND 8' ARM
 NOTE: EXISTING 6" LINE FROM VALVE TO FIRE HYDRANT TO BE REMOVED.

REDUCED PRESSURE PRINCIPLE ASSEMBLY (1-27)
 APPROVED REDUCED PRESSURE ASSEMBLY(S) SHALL BE INSTALLED PER THE UDACS PLATE NO. 11A. NO WATER SHALL BE TAKEN FROM A SERVICE REQUIRING BACKFLOW PREVENTION UNTIL THE REDUCED PRESSURE PRINCIPLE ASSEMBLY HAS BEEN SUCCESSFULLY TESTED BY THE LVWD.
 ANY BLOCK WALL OR OTHER FENCE MATERIAL SHALL BE DESIGNED AND CONSTRUCTED AROUND THE OUTSIDE OF THE EASEMENT(S) TO ALLOW THE DISTRICT DIRECT ACCESS FROM THE ADJACENT RIGHT-OF-WAY.

Call before you Dig
 1-800-227-2600

APPLE DRIVE (PRIVATE DRIVE)

ABANDONED VALVE CUT AND CAP
 ALL VALVES TO BE ABANDONED IN THE CLOSED POSITION UNLESS SHOWN OTHERWISE, BY REMOVING A MINIMUM OF THE TOP 12 INCHES OF THE VALVE BOX AND THEN FILLING THE REMAINING PORTION OF THE VALVE BOX WITH CONCRETE HAVING A COMPRESSIVE STRENGTH OF AT LEAST 2,000 PSI.
 THE CONTRACTOR SHALL CUT THE EXISTING PIPE 3' BEYOND THE ABANDONED VALVE AND INSTALL A CAP WHERE A JOINT OR COUPLING IN THE EXISTING PIPE IS UNCOVERED AT THE CUT AND CAP LOCATION. THE INSTALLATION OF A PLUG MAY BE PERMITTED WITH DISTRICT APPROVAL. THE CONTRACTOR SHALL INSTALL A CONCRETE THRUST BLOCK IN ACCORDANCE WITH THE PROVISIONS OF THE UDACS PLATE NO. 5 AT ALL CAP OR PLUG LOCATIONS.

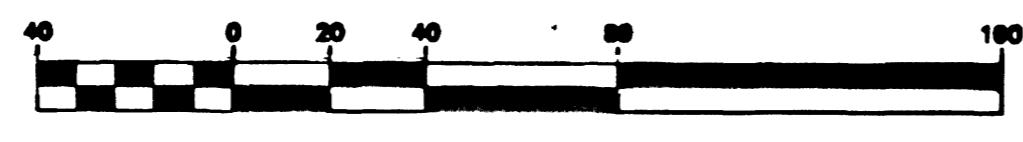

45934 LAS VEGAS VALLEY WATER DISTRICT DATE 4/11/96

NO.	REVISION	DATE	DESCRIPTION
1	REVISE ENTRY B STREET LOCATION, SEWER	7/20/94	
2	REVISE ENTRY B STREET LOCATION	7/20/94	
3	REVISE ENTRY B STREET LOCATION	7/20/94	
4	REVISE ENTRY B STREET LOCATION	7/20/94	
5	REVISE ENTRY B STREET LOCATION	7/20/94	
6	REVISE ENTRY B STREET LOCATION	7/20/94	
7	REVISE ENTRY B STREET LOCATION	7/20/94	
8	REVISE ENTRY B STREET LOCATION	7/20/94	
9	REVISE ENTRY B STREET LOCATION	7/20/94	
10	REVISE ENTRY B STREET LOCATION	7/20/94	

DATE: 3/12/94
 DRAWN BY: [Signature]
 CHECKED BY: [Signature]
 JOB NO.: 0145.0018
 SCALE: 1"=40'

PENTACORE
 Engineering, Inc.
 6763 West Charleston Boulevard
 Las Vegas, Nevada 89102
 (702) 258-0115

PECCOLE NEVADA CORP.
 APPLE DRIVE IMPROVEMENTS
 UTILITY PLAN AND PROFILE

SHEET
3A
 OF 14

AS BUILT 27-200 REVISED 107-V 2448