
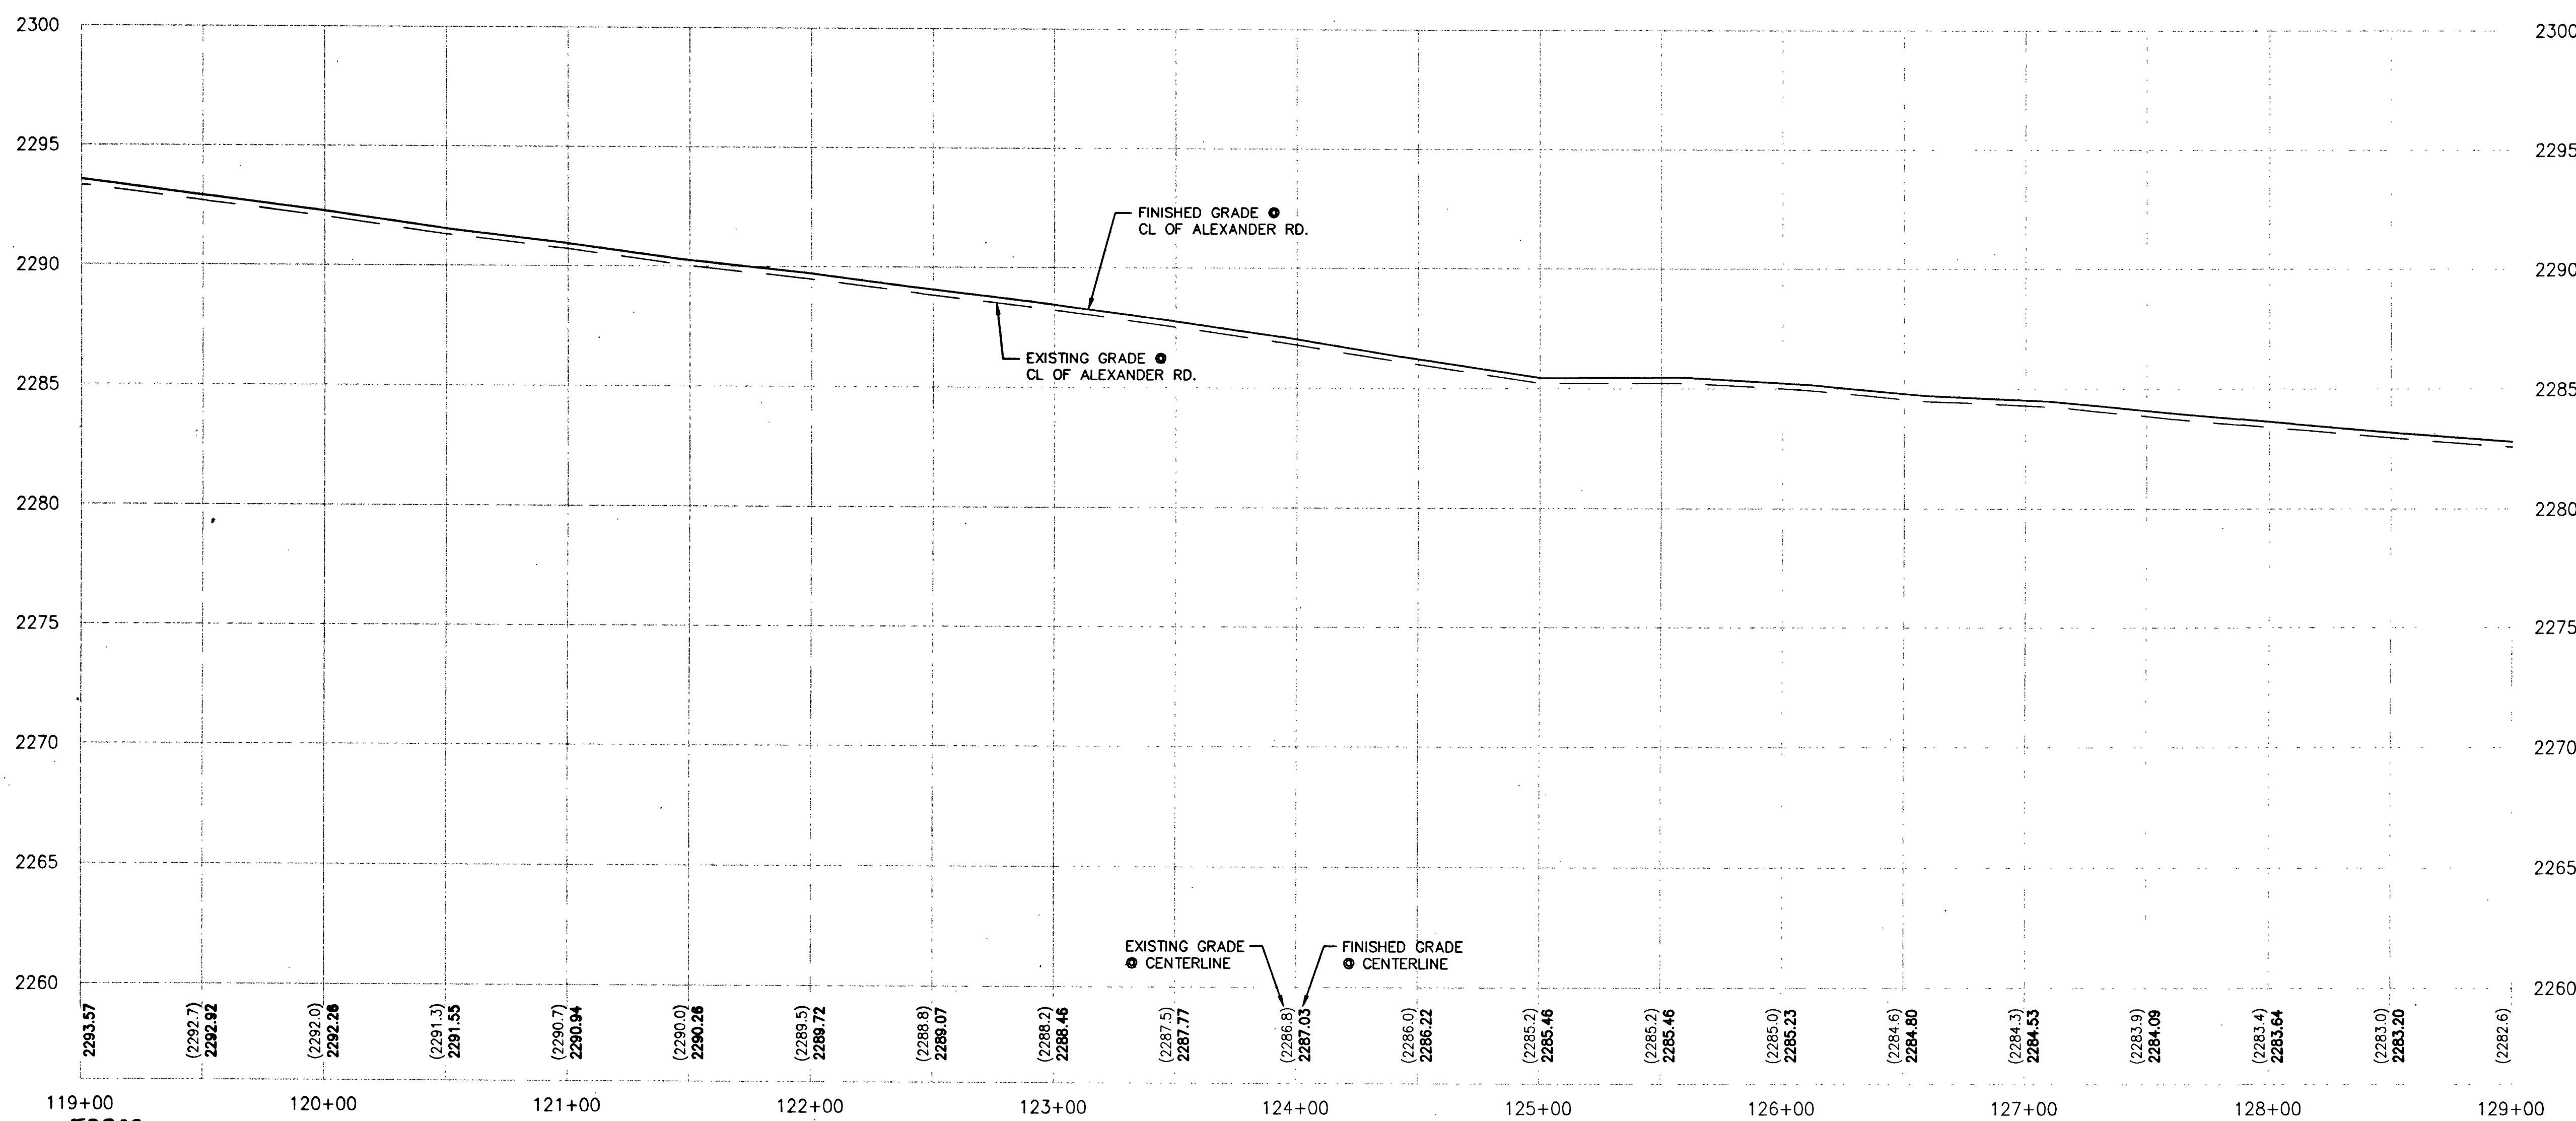


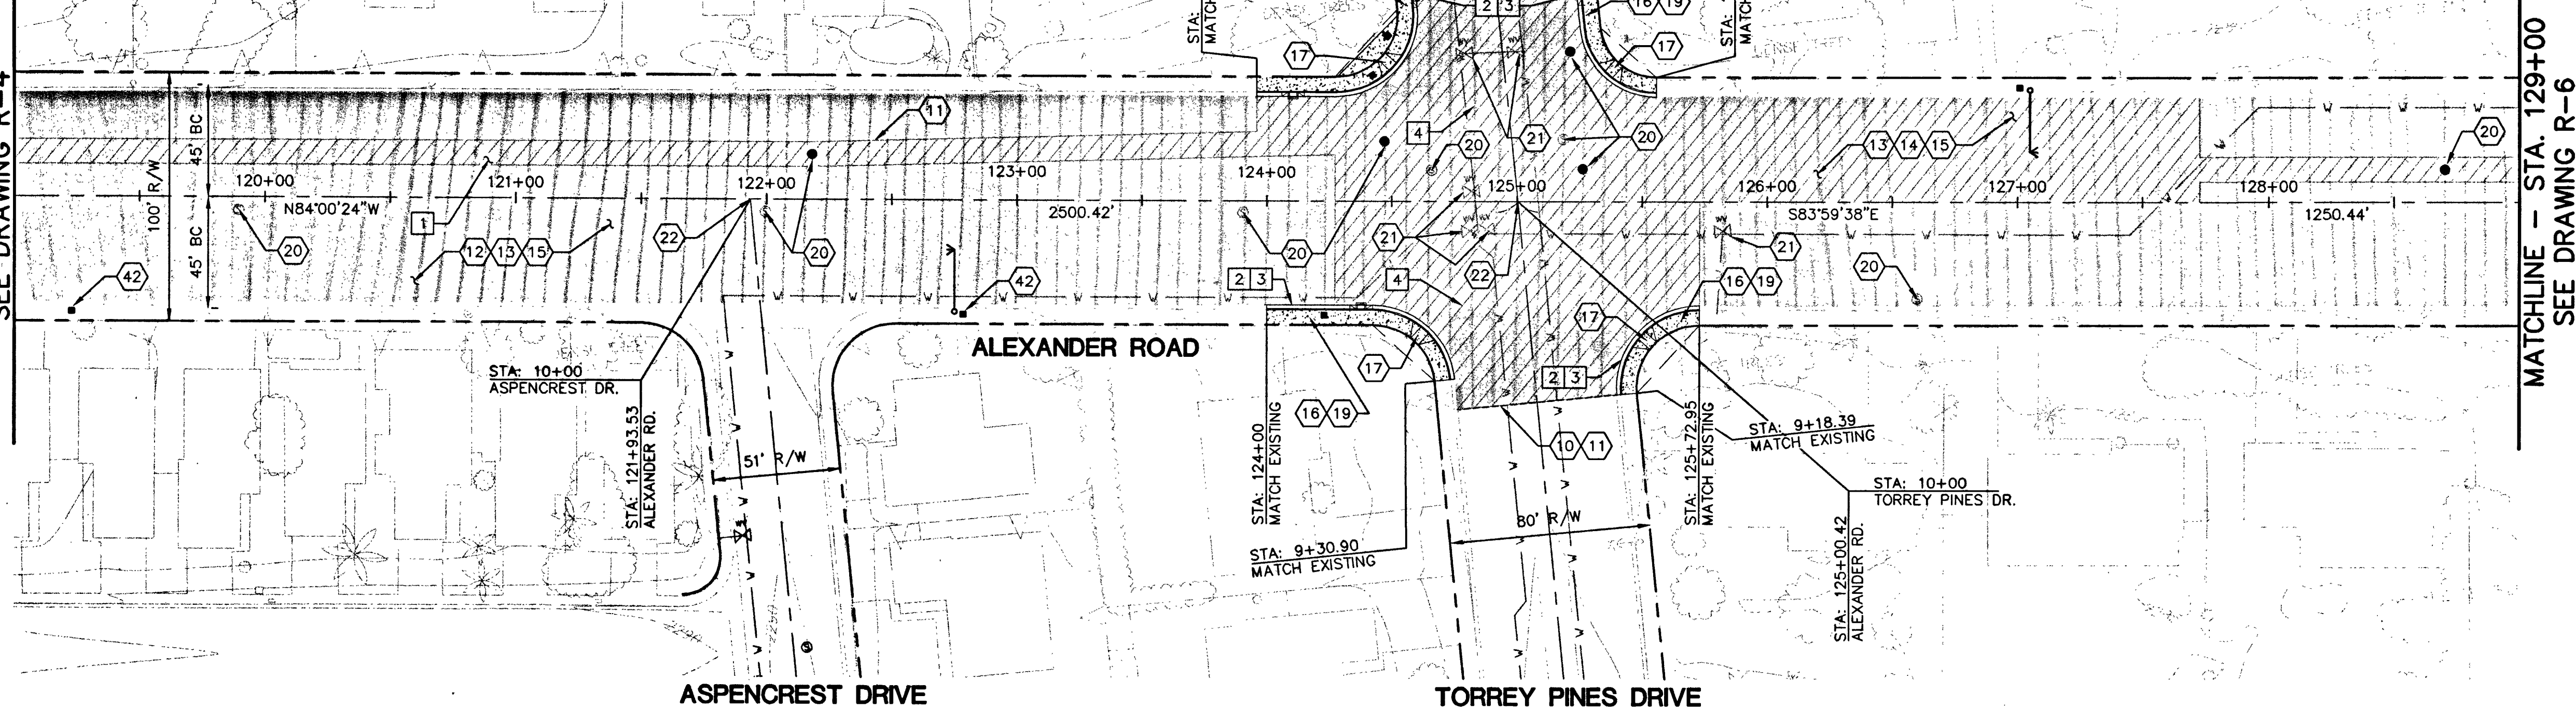

Stantec Consulting Inc.
6763 W. Charleston Blvd.
Las Vegas NV U.S.A.
89146-1049
Tel. 702.258.0115
Fax. 702.258.4956
www.stantec.com

- REMOVAL NOTES:

- | | |
|---|---------------|
| 1 | AC PAVEMENT |
| 2 | SIDEWALK |
| 3 | CURB & GUTTER |
| 4 | VALLEY GUTTER |

- CONSTRUCTION NOTES:

- (10) MATCH EXISTING
- (11) SAWCUT
- (12) ROTOMILL (SEE NOTE 2)
- (13) 3" AC PAVEMENT OVERLAY
- (14) 2" AC PAVEMENT REPLACEMENT
- (15) 3/4" OPEN GRADE
- (16) L TYPE CURB & GUTTER PER USD NO. 216
- (17) TYPE III SIDEWALK RAMP PER USD NO. 235
- (19) SIDEWALK PER USD NO. 234
- (20) ADJUST MANHOLE WITH COLLAR PER USD NO. 408
- (21) ADJUST WATER VALVE BOX TO FINISHED GRADE PER UDACS PLATE 8. VALVE SHALL BE ACCESSIBLE AT ALL TIMES.
- (22) RE-ESTABLISH SURVEY MARKER
- (42) P30 PULLBOX

 
- NOTES:

1. ALL GEOMETRY ON MEDIAN CURBS IS TO FACE OF CURB.
2. ROTOWILL QUANTITY EXCLUDES TRENCH AND PAVEMENT REPLACEMENT.
3. CENTERLINE GRADE SHOWN IS SURFACE OF OPEN GRADE SEE SECTION

4. SEE SHEET R-8 FOR ALEXANDER ROAD - TORREY PINES DRIVE GRADING PLAN.
5. SEE SHEETS U-1 THRU U-6 FOR UTILITY PLANS.
6. SEE SHEETS T-1 THRU T-2 FOR STRIPING PLANS.

3" AC PAVEMENT
2" AC PAVEMENT

LVVWD Patty Pearson 4/14/03 DATE



Avoid overhead power line contact. It's costly.

Avoid cutting underground utility lines. It's costly.

Call
before you
OVERHEAD

**Call
before you
Dig**

1-702-593-6111


1-800-227-2600


 DEPARTMENT OF PUBLIC WORKS
 ENGINEERING DESIGN SECTION

CHARLES KAJKOWSKI JR., P.E.

CITY ENGINEER:


DESIGNED BY: JQ,DD
DRAWN BY: DD
CHECKED BY: MW
HORIZONTAL SCALE: 1" = 40'
VERTICAL SCALE: 1" = 4'
DATE: 06/11/02

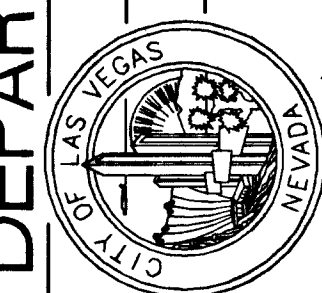

**ALEXANDER ROAD
US 95 TO RANCHO DRIVE
BROADWAY PLAN + PROFILE
STA. 119+00 TO 129+00**

UNIT 1

1

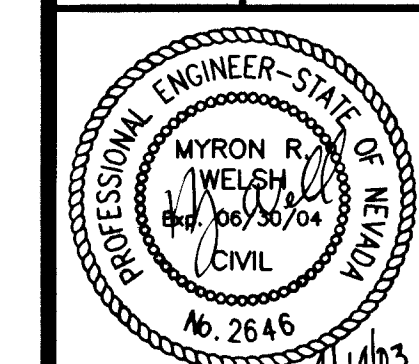

Sheet

R-5

13 of 35

DRAWING NO.

07-V3634