




Call before you Dig.
1-800-227-2600
UNDERGROUND SERVICE ALERT (USA)

SAFETY ALERT
Call before you Overhead
593-6111
OVERHEAD SERVICE ALERT

BASIS OF BEARINGS
Centerline of Desert Inn Road, being the South line of Southwest quarter of Section 8, Township 21 South, Range 80 East, M.D.M., Clark County Nevada, Bears N89°22'10"W, as shown on plot of the final map of "LAKE SHORE ESTATES NO.2 BY LEWIS HOMES", recorded in Book 35, Page 30 of Clark County, Nevada, Recorder's Office.

UTILITY NOTE:
UTILITY LOCATIONS SHOWN HEREON ARE APPROXIMATE ONLY. SHALL BE THE CONTRACTOR'S RESPONSIBILITY TO DETERMINE THE EXACT VERTICAL AND HORIZONTAL LOCATION OF ALL EXISTING UNDERGROUND UTILITIES PRIOR TO COMMENCING CONSTRUCTION. NO REPRESENTATION IS MADE THAT ALL EXISTING UTILITIES ARE SHOWN HEREON. THE ENGINEER ASSUMES NO RESPONSIBILITY FOR UTILITIES NOT SHOWN OR UTILITIES NOT SHOWN IN THEIR PROPER LOCATION.


BENCHMARK
1/4" BM 1170824: River & Plate in top of curb, N.W. return of Desert Inn Road and Crystal Water Way.
Elev. 2679.87 (NAVD83)

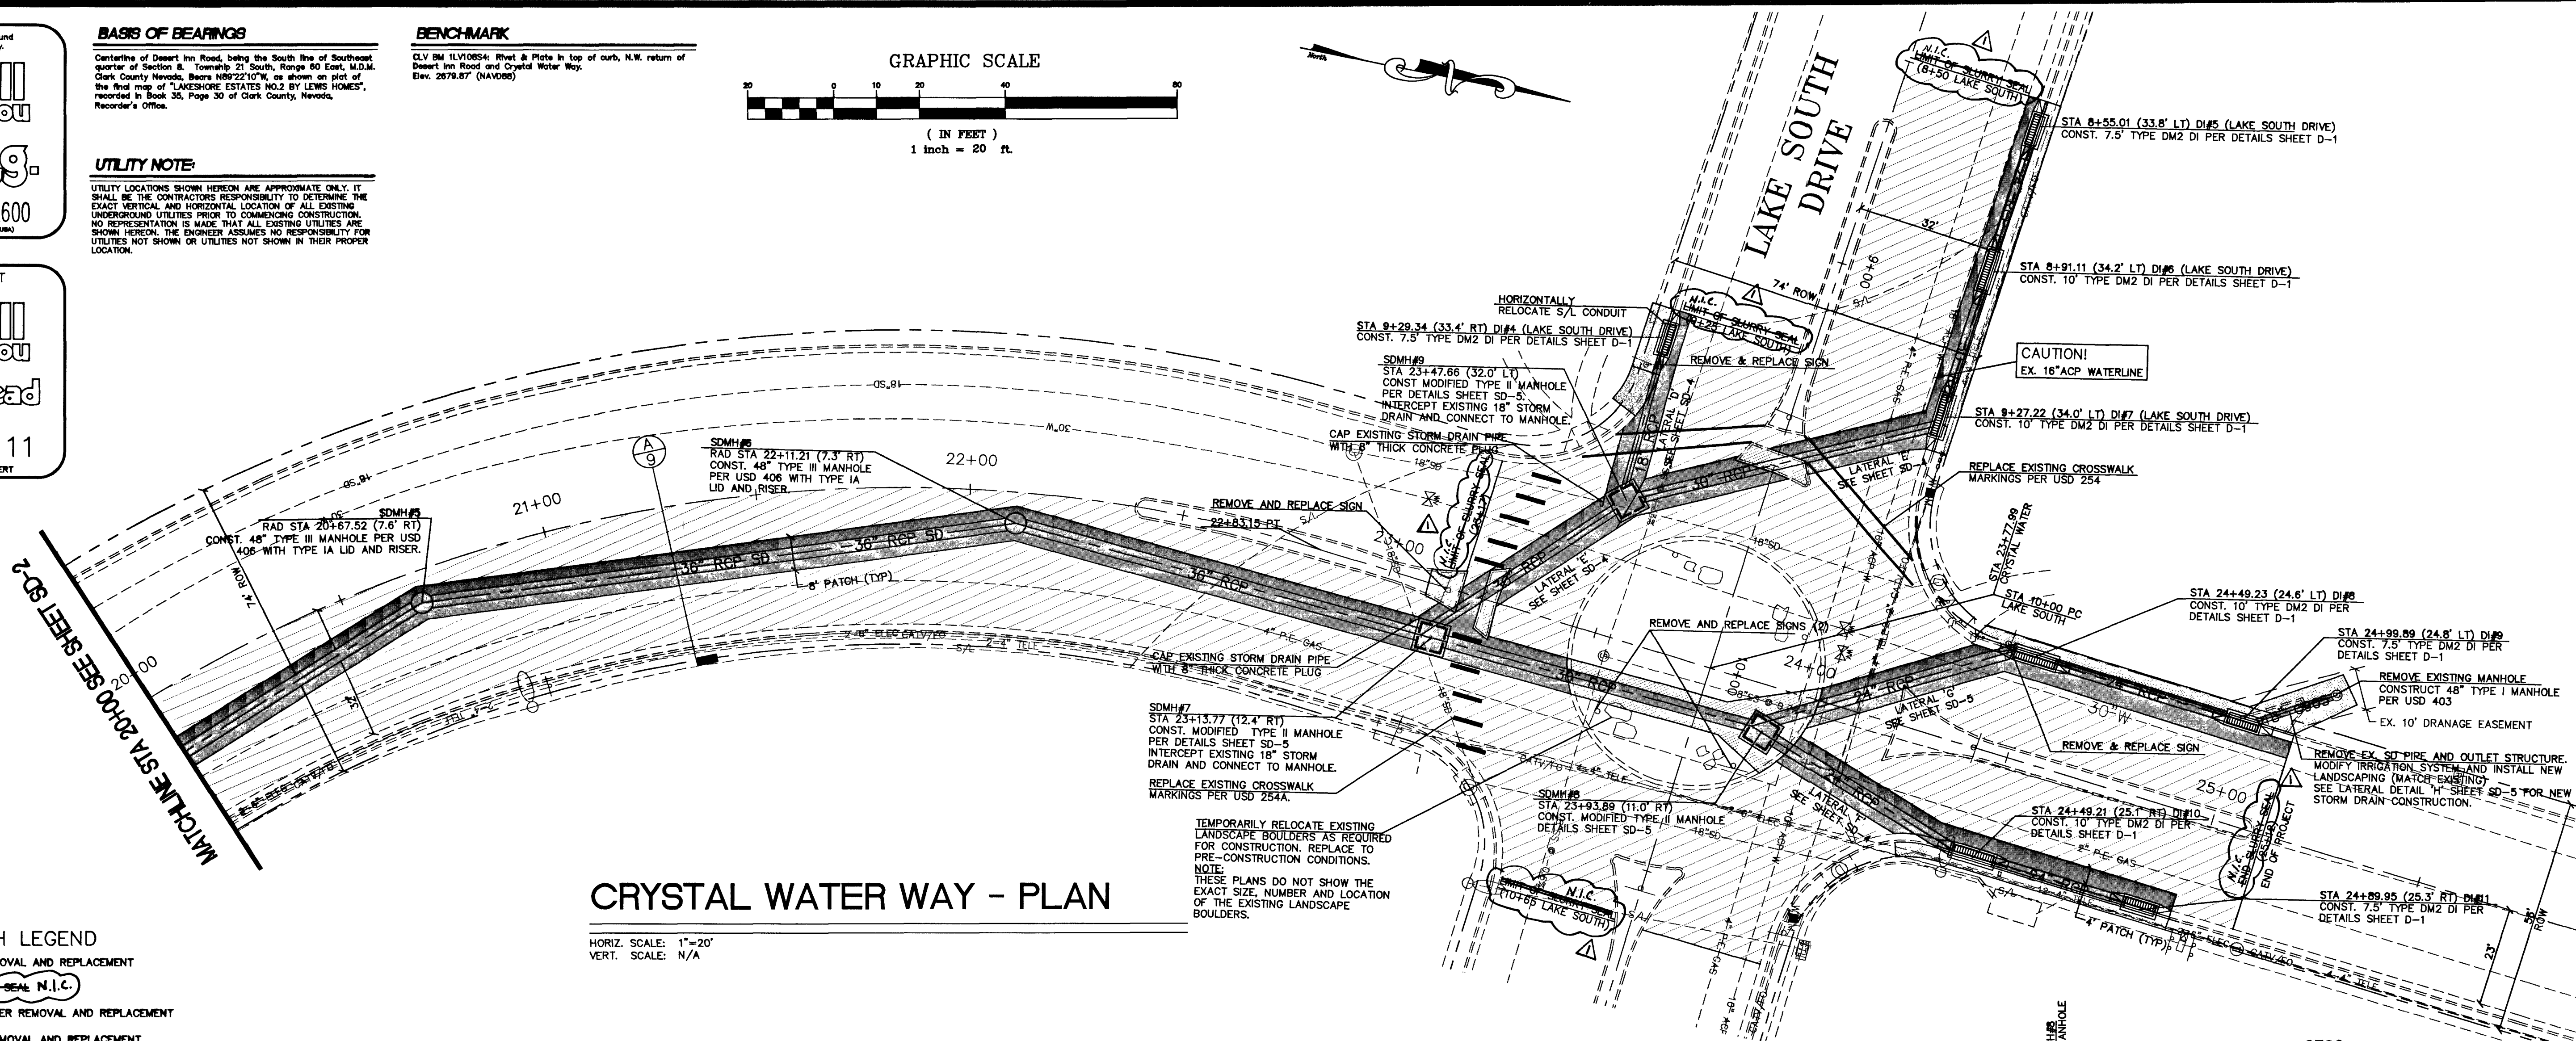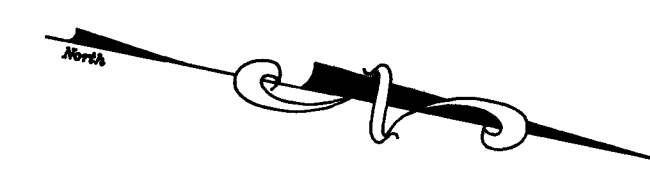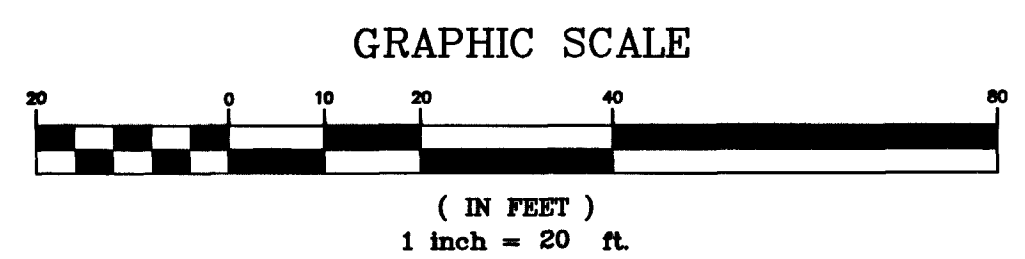

CRYSTAL WATER WAY - PLAN

HORIZ. SCALE: 1"=20'
VERT. SCALE: N/A

- HATCH LEGEND**
- AC REMOVAL AND REPLACEMENT
 - SLURRY SEAL N.I.C.
 - X-GUTTER REMOVAL AND REPLACEMENT
 - S/W REMOVAL AND REPLACEMENT
 - MEDIAN REMOVAL AND REPLACEMENT. MATCH EXISTING MEDIAN COLOR, TEXTURE AND PAINT MARKINGS.
 - LANDSCAPE/IRRIGATION SYSTEM RELOCATION/RECONSTRUCTION

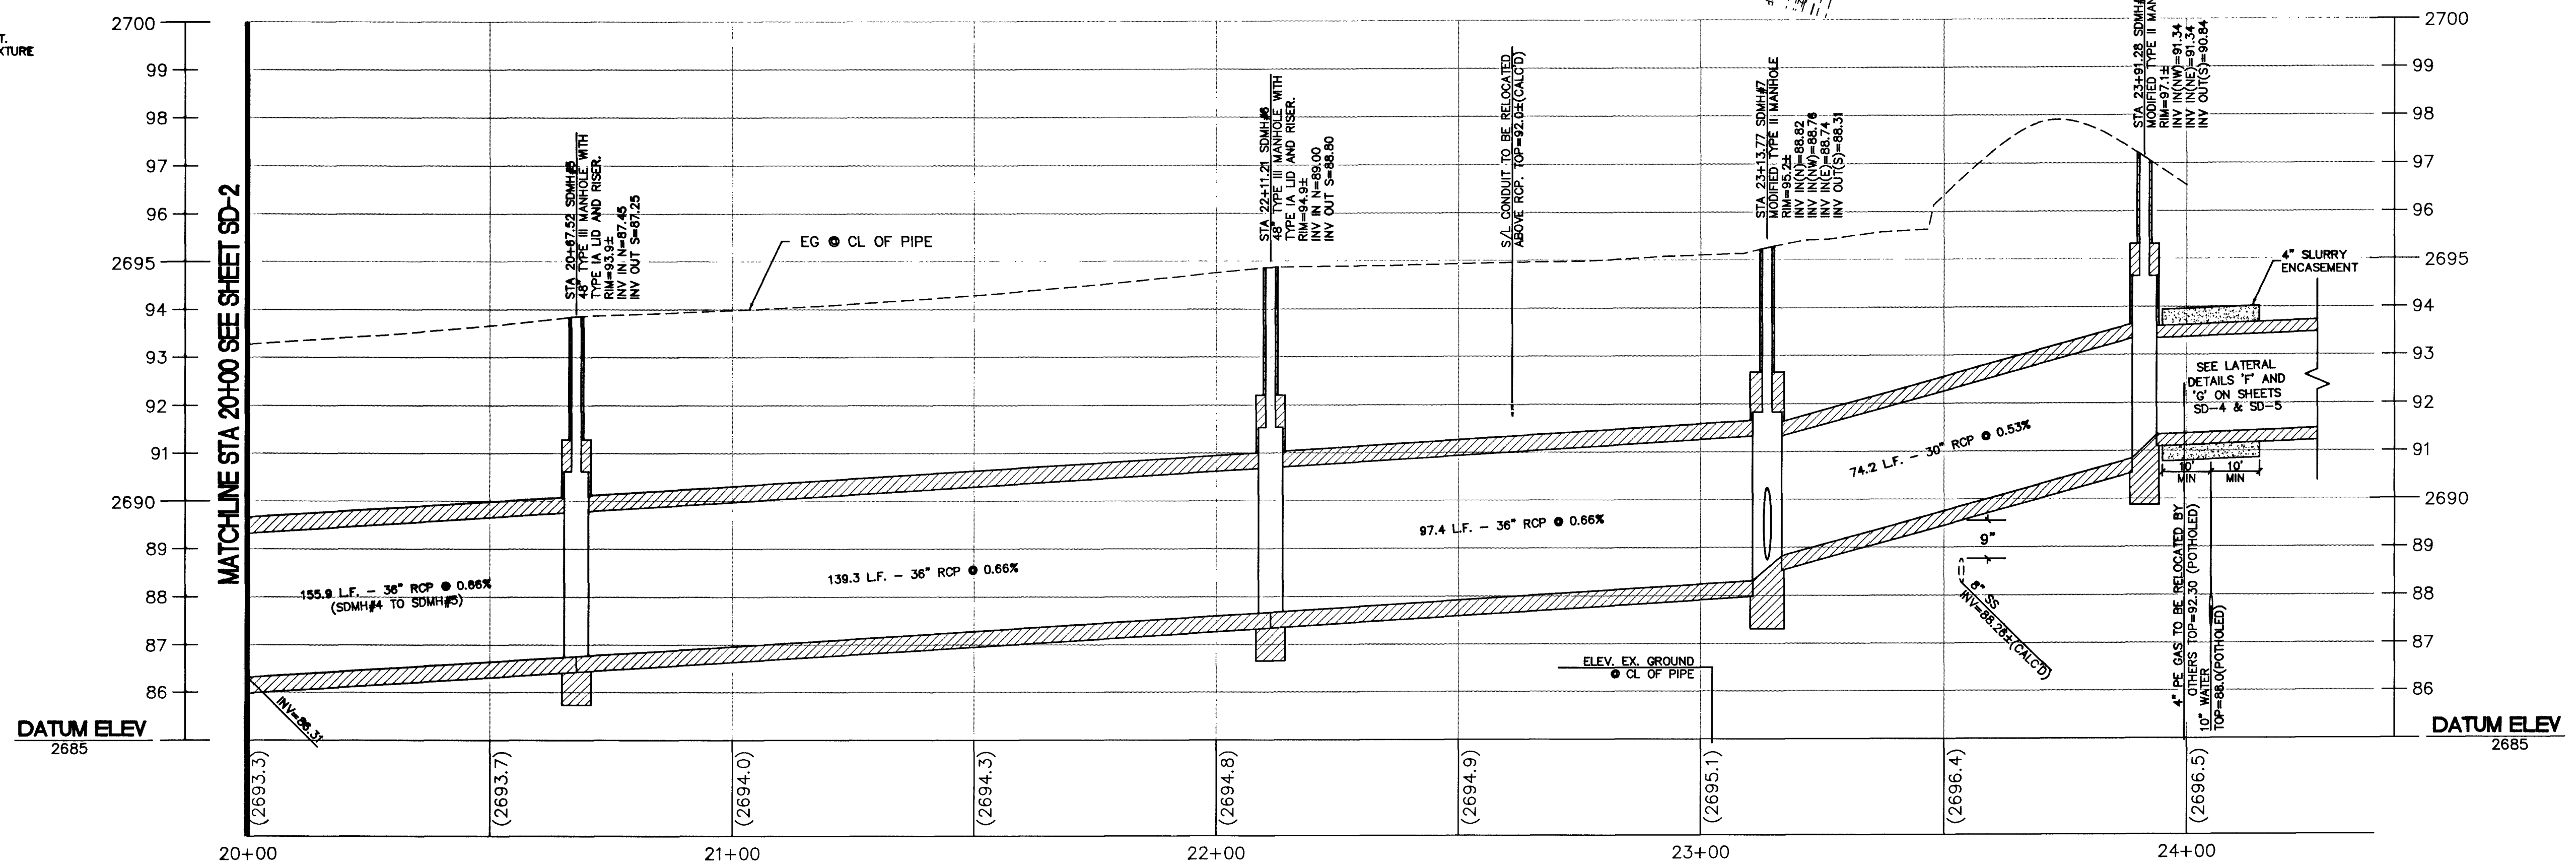

CRYSTAL WATER WAY - PROFILE


HORIZ. SCALE: 1"=20'
VERT. SCALE: 1"=2'

DEPARTMENT OF PUBLIC WORKS
ENGINEERING DESIGN SECTION

CITY ENGINEER: CHARLES KAJKOWSKI JR., P.E.
PROJECT MANAGER: TOM HAYES, P.E.
DESIGNED BY: MAS
DRAWN BY: MAS
CHECKED BY: EON

CRYSTAL WATER WAY
NOMINAL STORM DRAIN

PLAN AND PROFILE
STA 20+00 TO STA 25+00

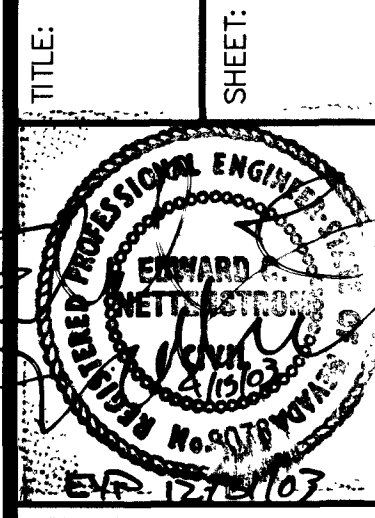

Sheet
SD-3
7 of 10
DRAWING NO.
327-V119

52054