
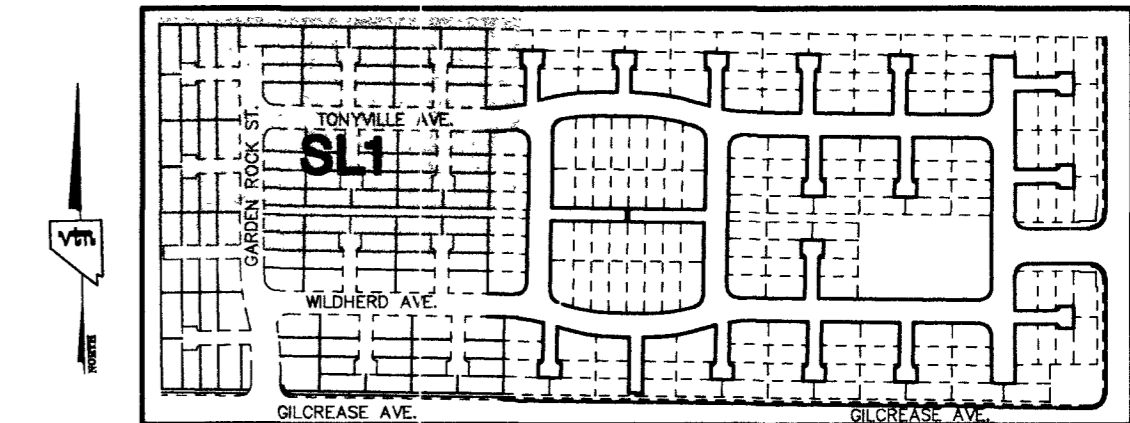
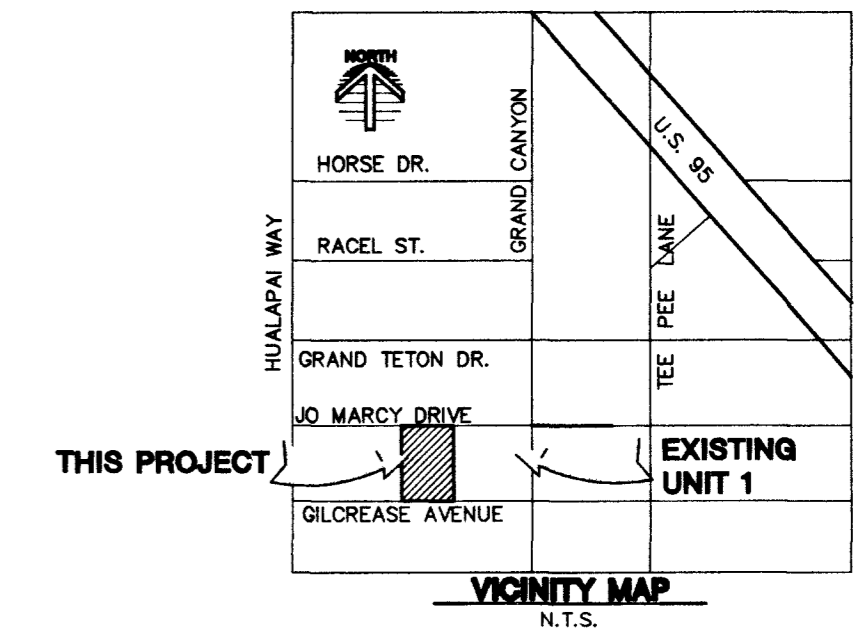


Avoid overhead power line contact  
**Call before you OVERHEAD**  
 1-702-593-6111


Avoid cutting underground utility lines. It's costly.  
**Call before you Dig**  
 1-800-227-2600

**TRAFFIC DELINEATION AND SIGNAGE PLAN**

- (A) INSTALL (2) D3 "STREET NAME" SIGNS—PRIVATE STREET STANDARDS (WHITE LETTERS ON BROWN BACKGROUND)
- (B) INSTALL 30" RI-1 "STOP" SIGN AND (2) 9" D3 "STREET NAME" SIGNS
- (C) INSTALL OM4-1 "END OF ROAD MARKER" SIGN

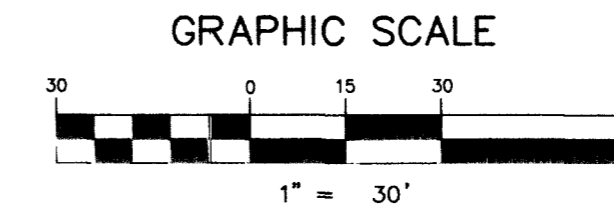

**KEY MAP**

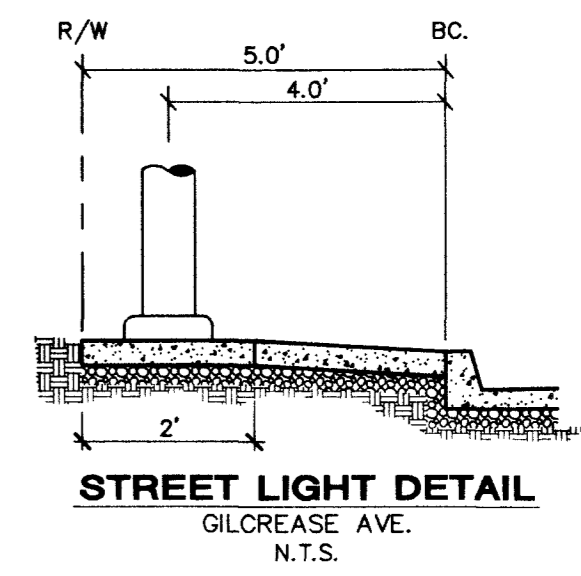

**STREET LIGHT DETAIL**  
 GILCREASE AVE.  
 N.T.S.

**NOTE:**

- ALL STREET LIGHTING INSTALLATION EXCEPT AS NOTED ON THE STREET LIGHTING PLANS SHALL CONFORM TO THE IMPROVEMENT STANDARDS, DEPARTMENT OF PUBLIC WORKS, CLARK COUNTY, NEVADA, AND THE UNIFORM STANDARDS SPECIFICATIONS FOR PUBLIC WORKS CONSTRUCTION, OFF-SITE IMPROVEMENTS, CLARK COUNTY AREA, NEVADA.
- ALL POLES TO BE GALVANIZED.
- ALL HANG HOLE COVERS MUST BE INSTALLED, POLE CAPS POURED, AND PULL BOX LIDS BOLTED DOWN PRIOR TO ENERGIZING CIRCUIT. ALL WIRE MUST HAVE THW INSULATION.

**NOTE:**

CONTRACTOR SHALL VERIFY HORIZONTAL AND VERTICAL LOCATION OF EXISTING UTILITIES AND NOTIFY THE DESIGN ENGINEER IMMEDIATELY OF ANY DISCREPANCIES PRIOR TO CONSTRUCTION.

**LEGEND/ESTIMATE OF QUANTITIES**


- 150 WATT HPS LUMINAIRE 4 EA
- 1 1/4" PVC CONDUIT 584 LF

APN: 125-18-101-004

**FUTURE BEAZER AT GRAND TETON VILLAGE  
 BY BEAZER HOMES**

APN: 125-18-101-004

FUTURE BEAZER AT GRAND TETON VILLAGE  
 BY BEAZER HOMES

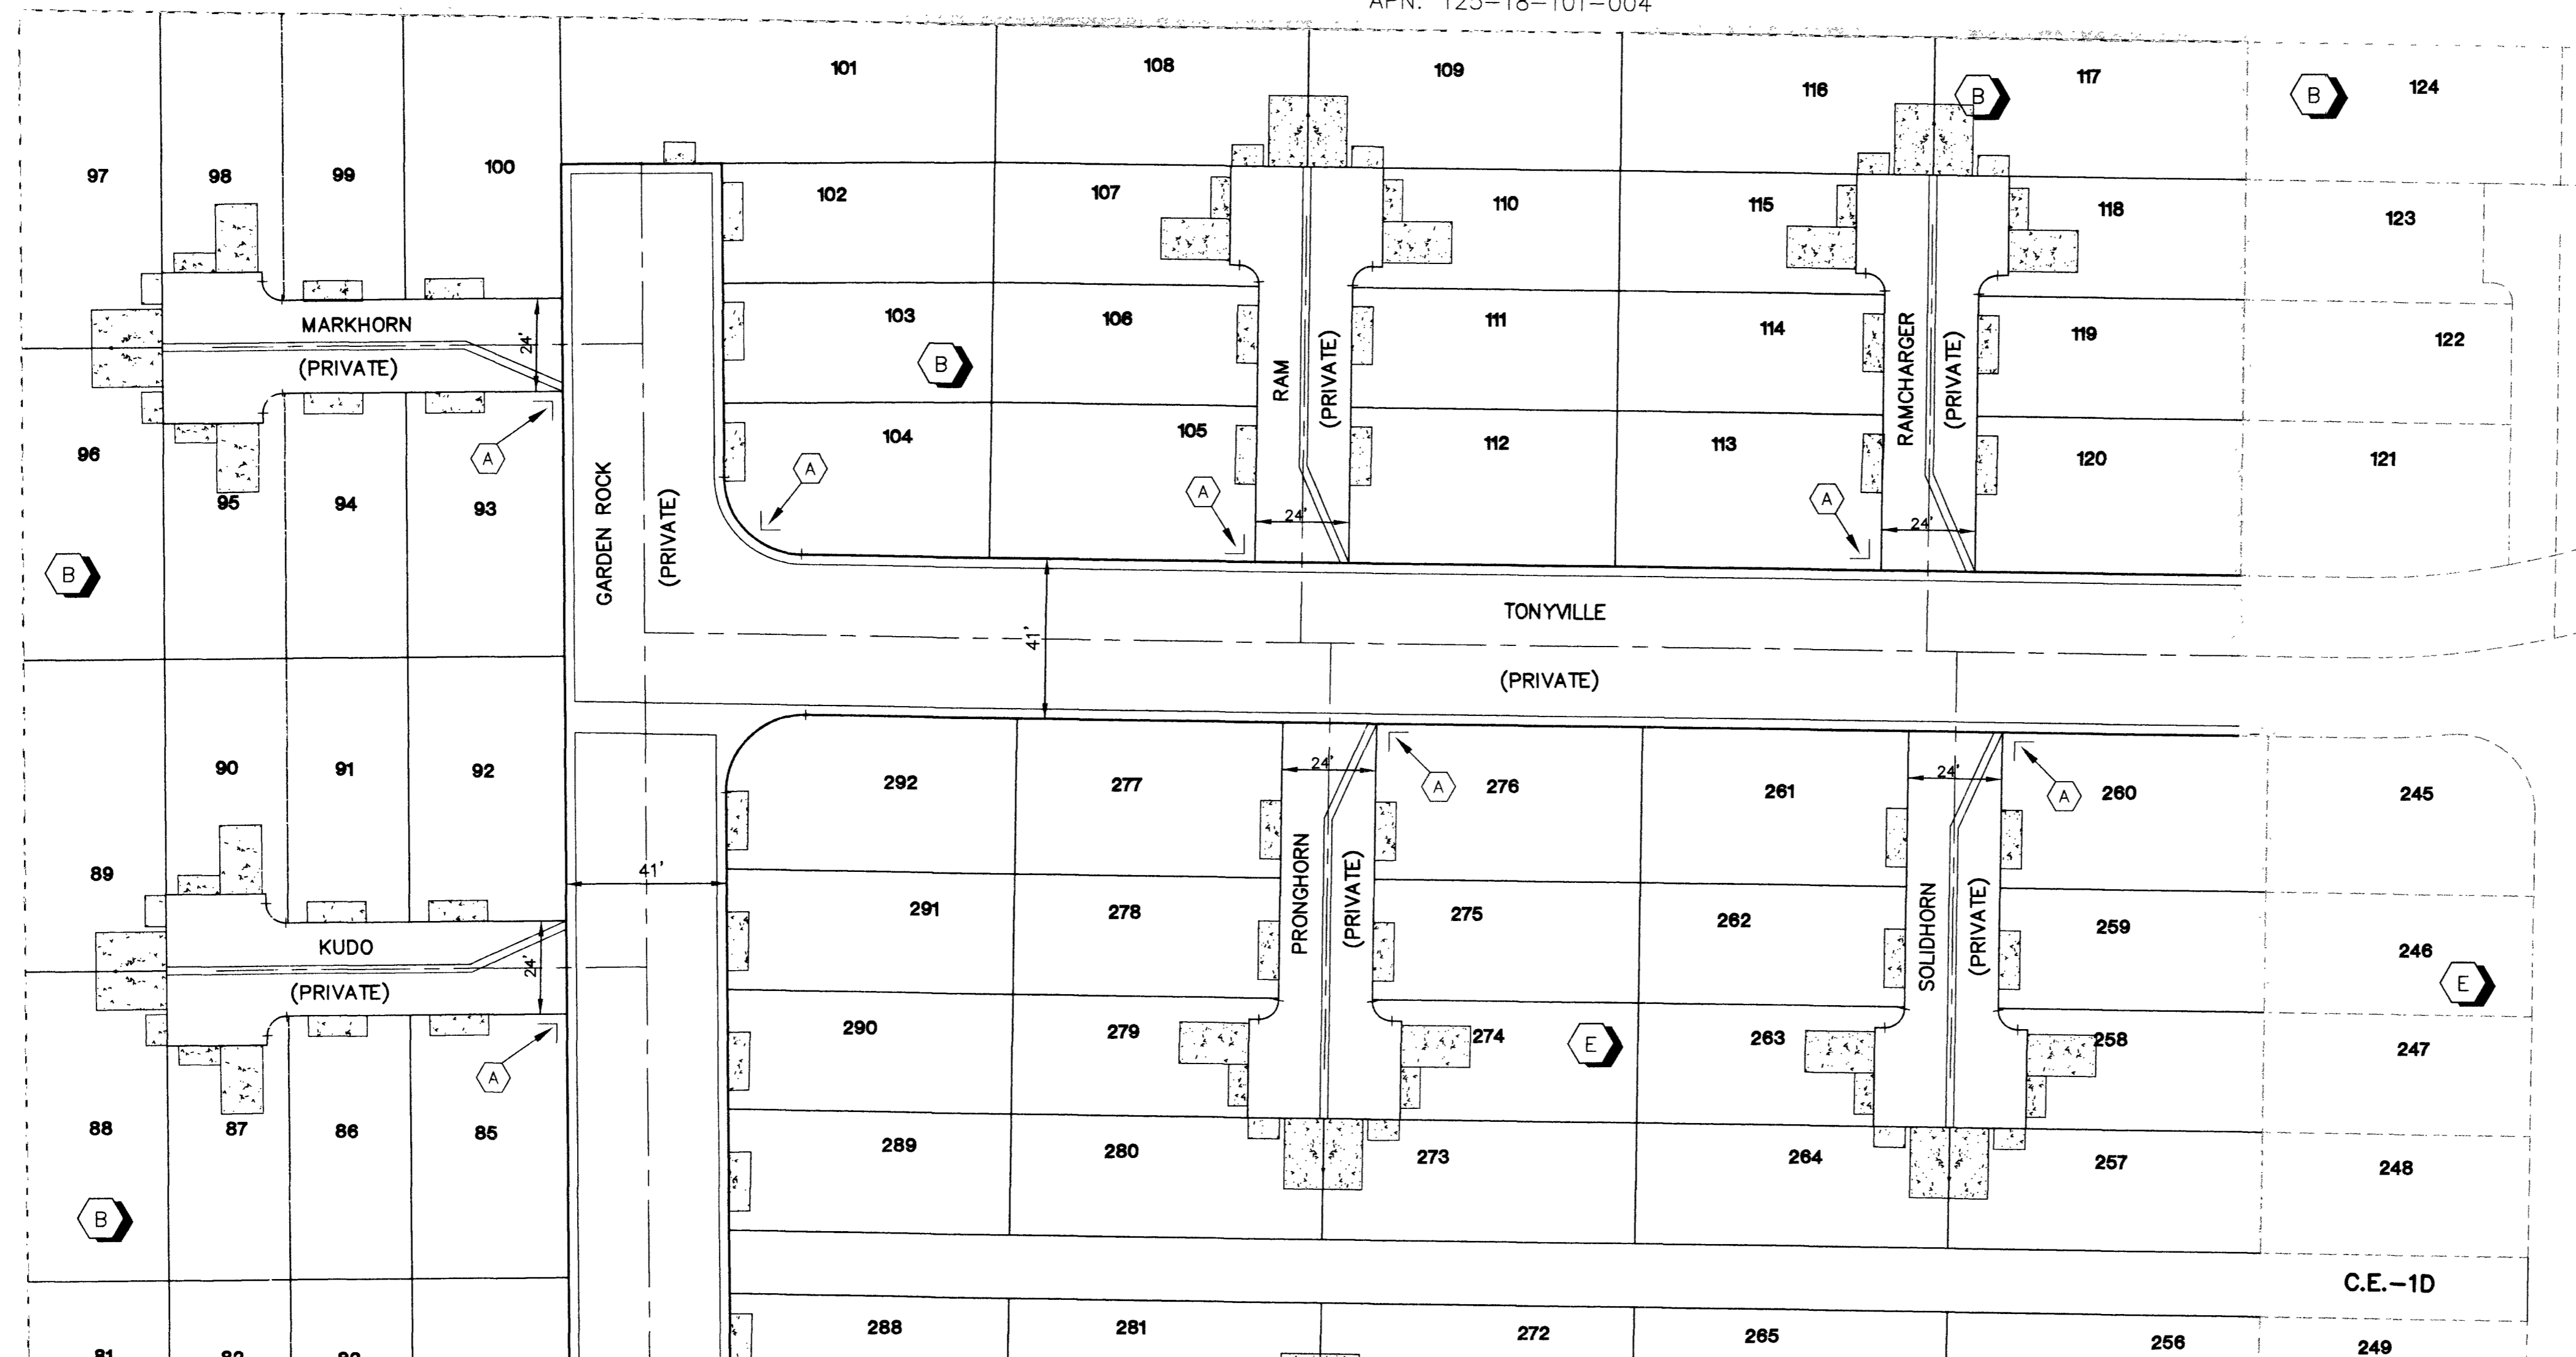

SEE SHEET SL2

C.E.-1D

**GREYSTONE HOMES**  
 3785 E. SUNSET BL  
 LAS VEGAS, NV 89120  
 (702) 648-1700


**CITY OF LAS VEGAS, NEVADA**  
 2727 SOUTH RAINBOW BOULEVARD LAS VEGAS, NEVADA 89146-5148  
 PH. (702) 973-7500 FAX (702) 362-7597  
**nevada** CONSULTING ENGINEERS • PLANNERS • LAND SURVEYORS

**TRAFFIC &  
 STREETLIGHT PLAN**

**ANTELOPE  
 UNIT 2**

DRAWN BY:	AUG. 2003
DESIGNED BY:	AUG. 2003
CHECKED BY:	AUG. 2003
PROJECT NO:	SCALE: 1"=30' HORIZ. 1"=10' VERT.

EXPIRES 06-30-05

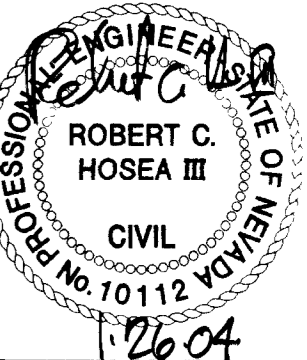

12604  
 SHEET  
**SL1**  
 24 of 25 SHEETS  
 DRAWING NO.  
 10744781-2