

- CONSTRUCTION NOTES**
- (40) CONSTRUCT STD ECCENTRIC MH; DIA=48"
 - (41) CONSTRUCT 8" PVC SEWER
 - (42) INSTALL FIRE HYDRANT
 - (43) CONSTRUCT MH OVER EXISTING PIPE
 - (44) CONSTRUCT 6" PVC SEWER LATERAL
 - (45) CONSTRUCT 6" WATER LATERAL
 - (46) CONSTRUCT 8" WATER LATERAL
 - (47) CONSTRUCT 8"x6" TAPPING SLEEVE
 - (48) CONSTRUCT 8"x8" TAPPING SLEEVE
 - (49) REMOVE EXISTING SEWER
 - (93) CONSTRUCT 12"x6" TAPPING SLEEVE
 - (94) CONSTRUCT 16" WATERLINE
 - (95) PROVIDE PIPE CAP AND LATERAL MARKER
 - (96) CONSTRUCT 8" WATERLINE
 - (97) CONSTRUCT 12" WATERLINE
 - (98) CONSTRUCT 10" WATERLINE
 - (99) PROVIDE CAP AND BLOW-OFF
- CCSD & UDACS STANDARD DRAWING REFERENCE SHOWN ON SHEET G3
- # INDICATES LATERAL OR RELOCATION NUMBER SEE SHEETS U14, U15, U16, AND U17

APPROVED FOR CONSTRUCTION

[Signature] 6/14/03
LAS VEGAS VALLEY WATER DISTRICT DATE

DEPARTMENT OF PUBLIC WORKS
400 EAST STEWART
LAS VEGAS, NEVADA, NV 89101
(702) 229-4276


G.C. WALLACE, INC.
Engineers/Planners/Surveyors
155 SOUTH KANAW BLVD., LAS VEGAS, NEVADA 89146
(702) 804-5000

BUFFALO DRIVE
UTILITY PLAN AND PROFILE
"B" 198+60.00 TO "B" 202+13.00

BUFFALO DRIVE
CHEYENNE TO LONE MOUNTAIN

DRAWN BY: KLT 2/10/03
DESIGNED BY: KLT 2/10/03
CHECKED BY: BOR 2/10/03
PROJECT NO: 412-405
SCALE: 1" = 40' HOR 1" = 4' VERT

SEAL
BRADFORD G. ROCKWELL
Exp. 12/31/2008
CIVIL
No. 4253
SHEET
U11
67 OF 93 SHEETS
DRAWING NO:
107-V3593

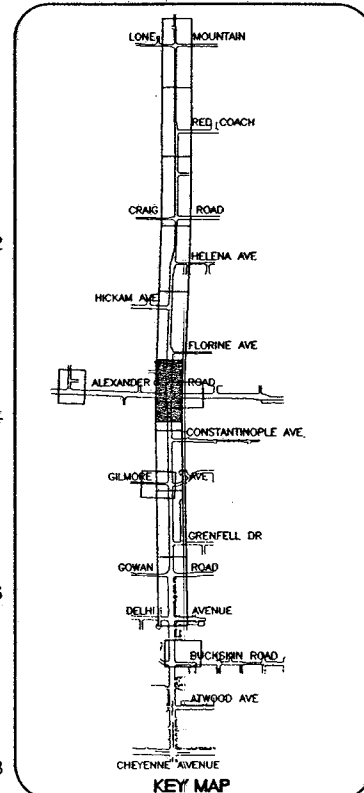

Call before you Dig.
1-800-227-2600
UNDERGROUND SERVICE (USA)

CALL BEFORE YOU DIG
1-702-593-6111

