
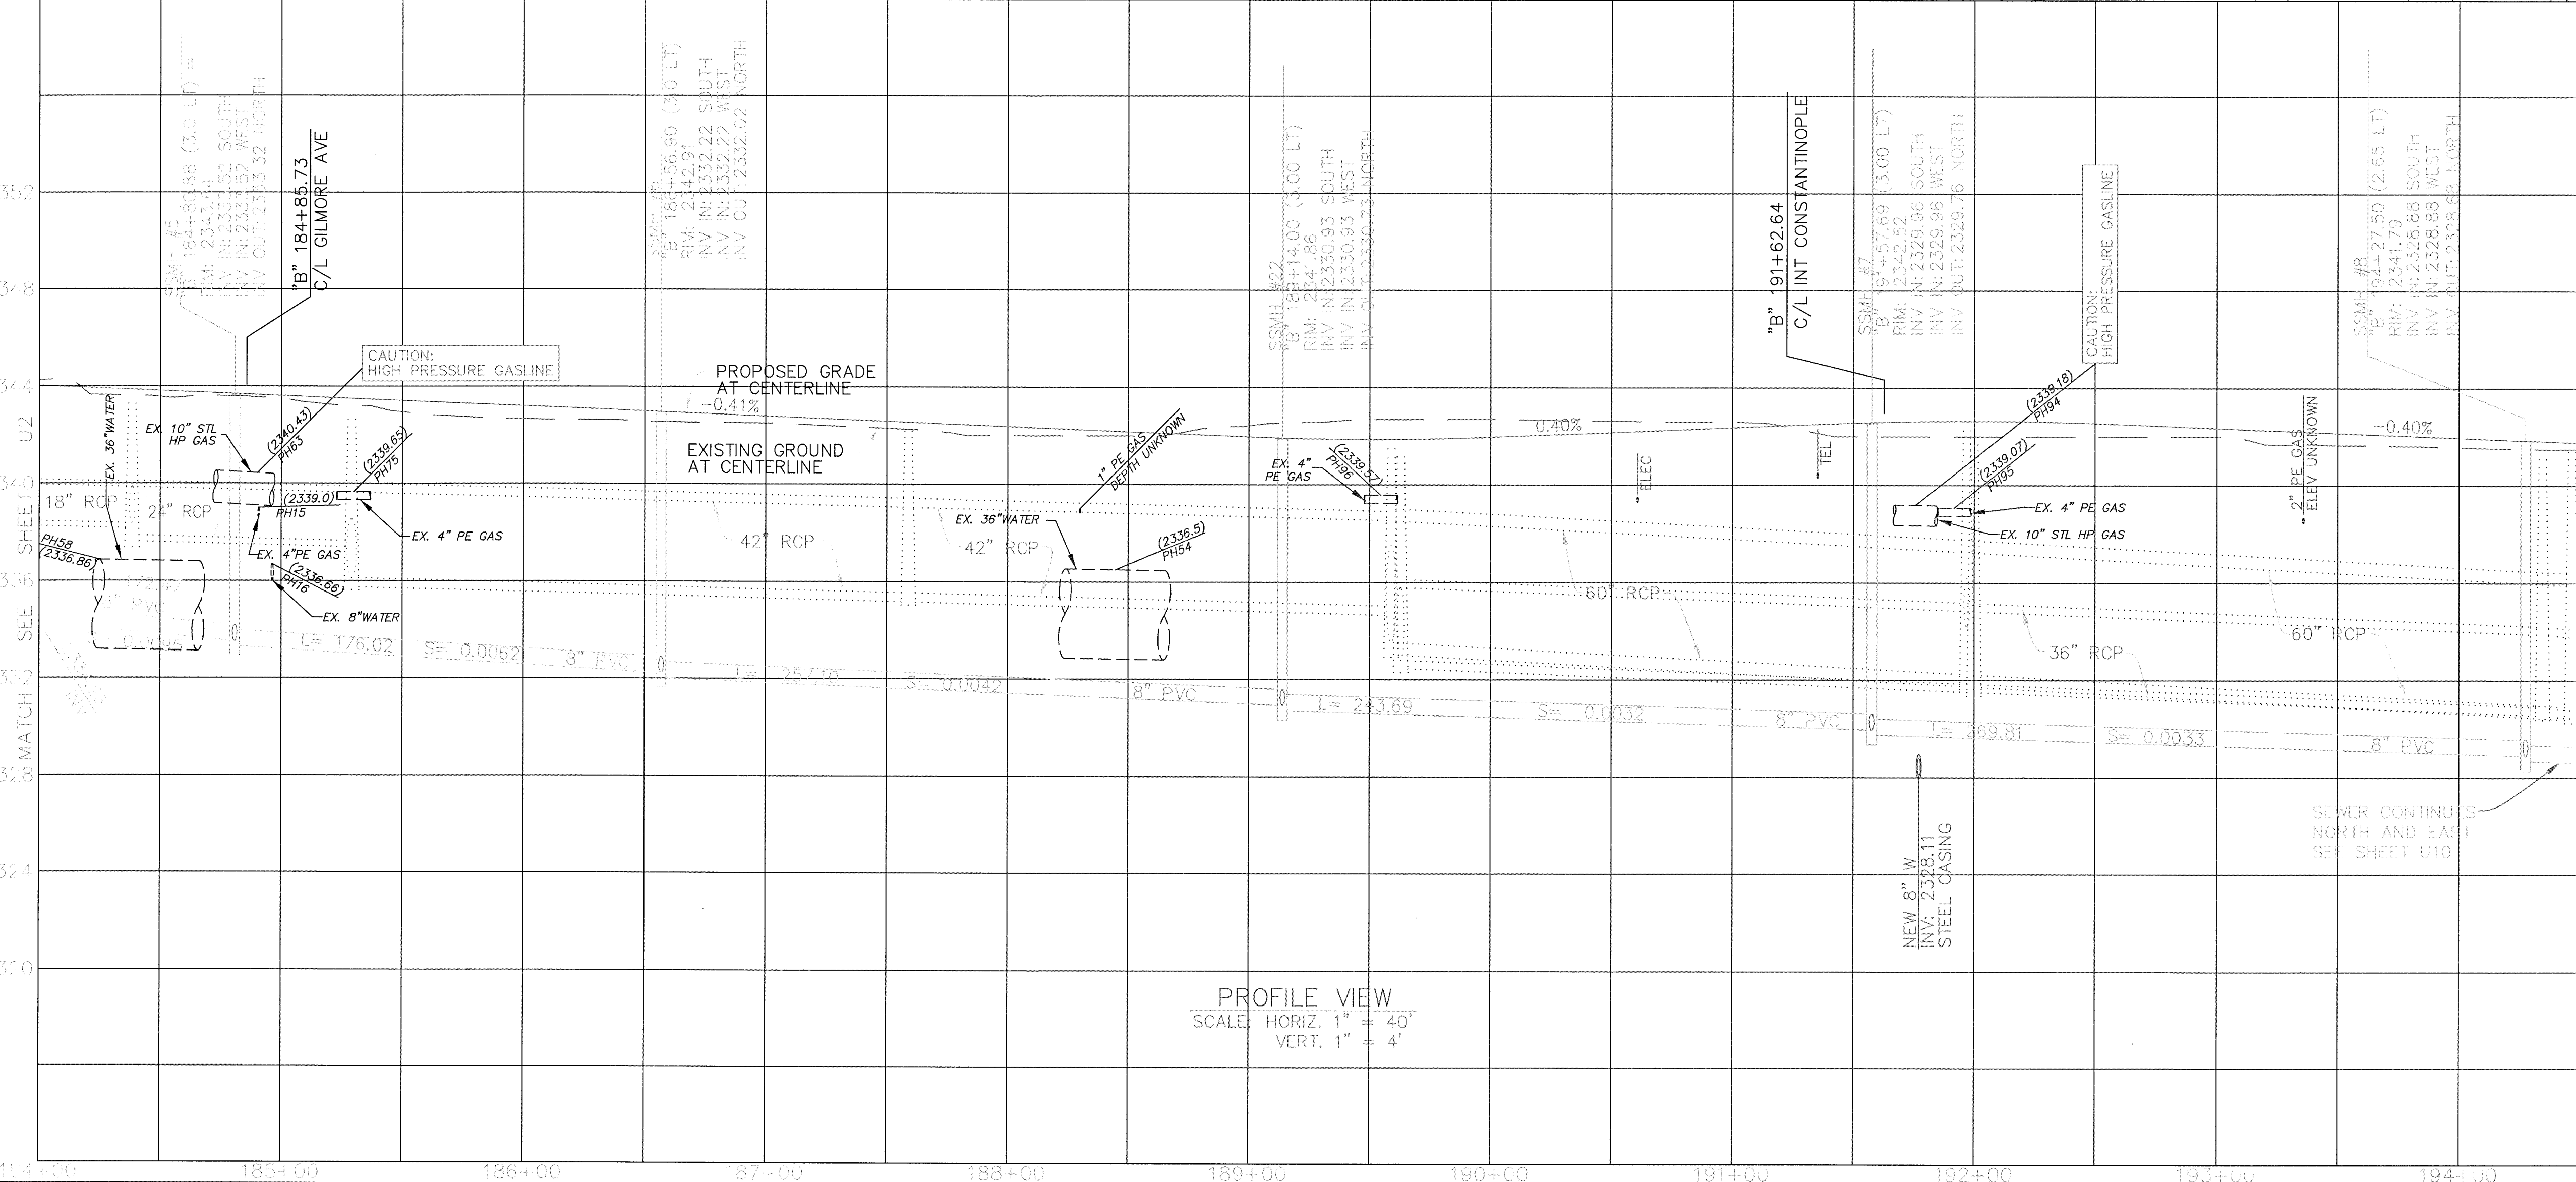


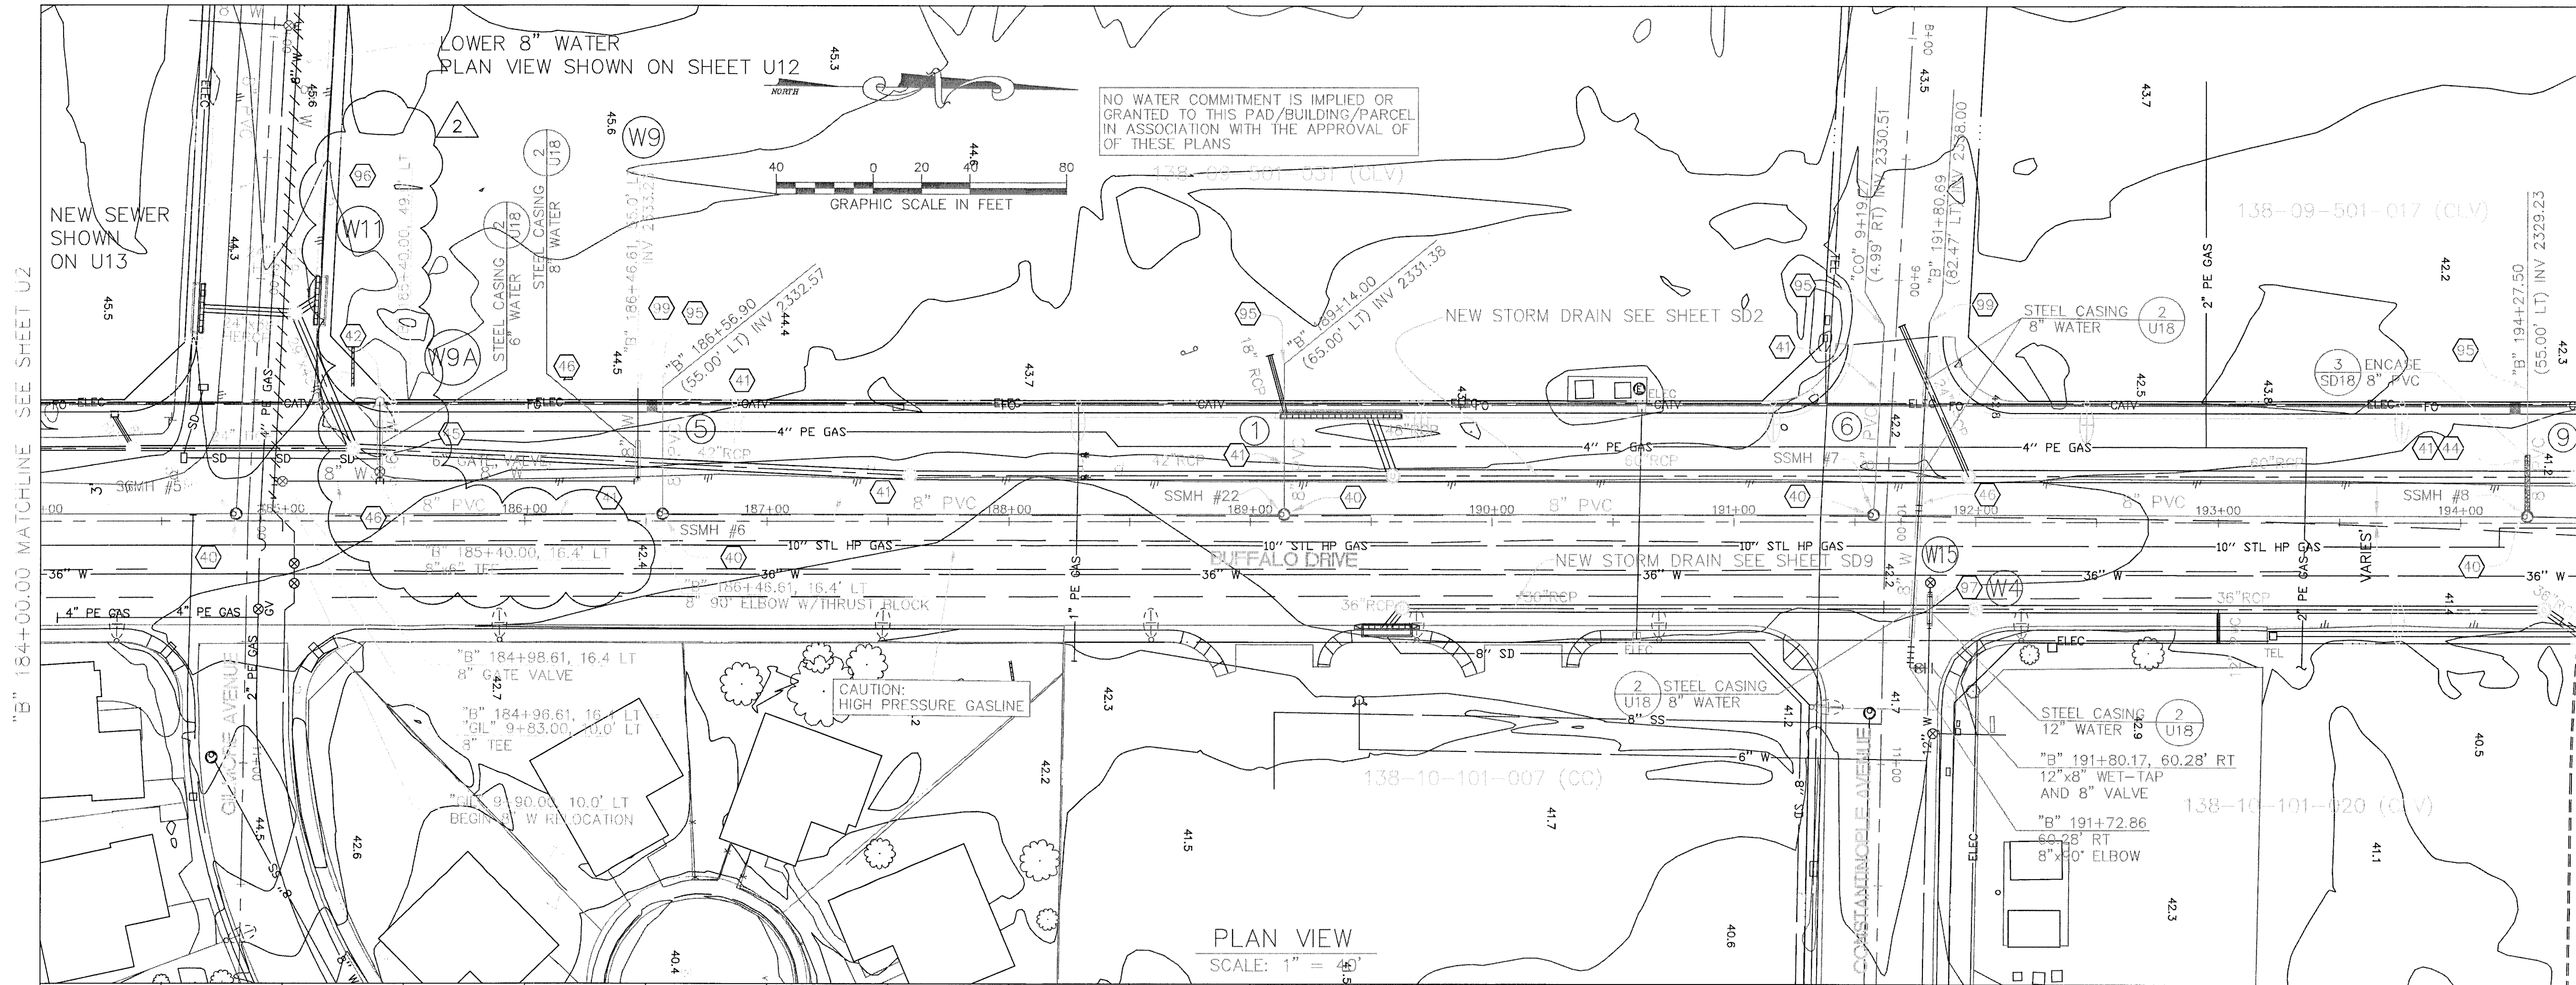

CONSTRUCTION NOTES

- 40 CONSTRUCT STD ECCENTRIC MH; DIA=48"
- 41 CONSTRUCT 8" PVC SEWER
- 42 INSTALL FIRE HYDRANT
- 43 CONSTRUCT MH OVER EXISTING PIPE
- 44 CONSTRUCT 6" PVC SEWER LATERAL
- 45 CONSTRUCT 6" WATER LATERAL
- 46 CONSTRUCT 8" WATER LATERAL
- 47 CONSTRUCT 8"x6" TAPPING SLEEVE
- 48 CONSTRUCT 8"x8" TAPPING SLEEVE
- 49 REMOVE EXISTING SEWER
- 50 CONSTRUCT 12"x6" TAPPING SLEEVE
- 51 CONSTRUCT 16" WATERLINE
- 52 PROVIDE PIPE CAP AND LATERAL MARKER
- 53 CONSTRUCT 8" WATERLINE
- 54 CONSTRUCT 12" WATERLINE
- 55 CONSTRUCT 10" WATERLINE
- 56 PROVIDE CAP AND BLOW-OFF

CSD & UDACS STANDARD DRAWING REFERENCE SHOWN ON SHEET G3


INDICATES LATERAL OR RELOCATION NUMBER SEE SHEETS U14, U15, U16, AND U17

APPROVED FOR CONSTRUCTION

LAS VEGAS VALLEY WATER DISTRICT DATE

APPROVED FOR CONSTRUCTION

CITY FIRE PROTECTION ENGINEER DATE

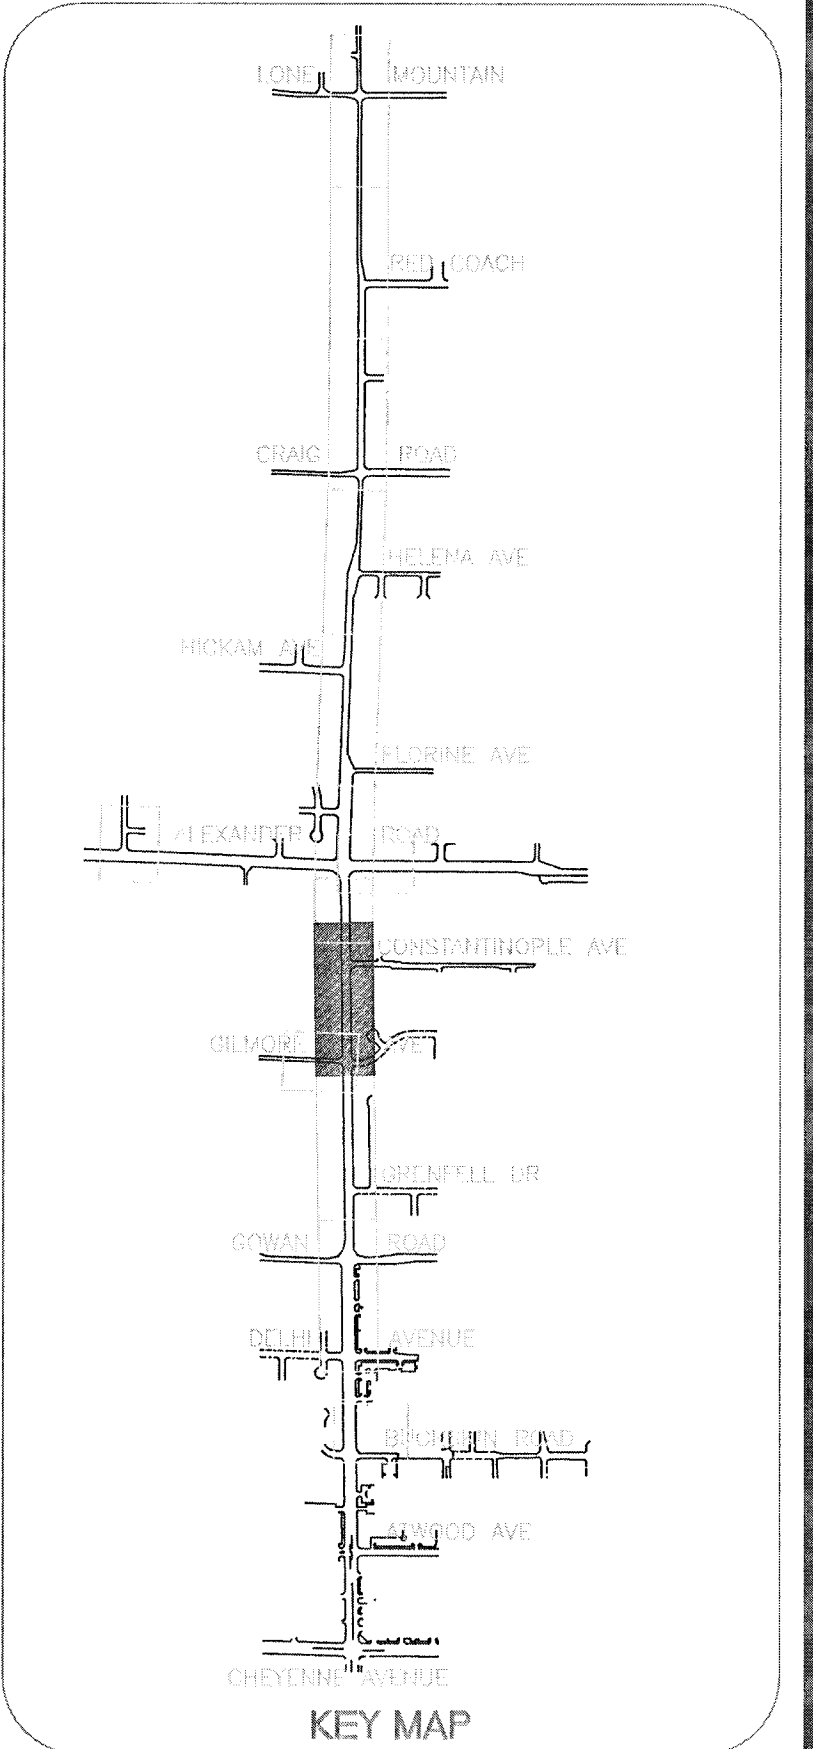

Call before you Dig
1-800-227-2600
UNDERGROUND SERVICE (USA)

CALL BEFORE YOU DO OVERHEAD
1-702-593-6111

DEPARTMENT OF PUBLIC WORKS
400 EAST STEWART
LAS VEGAS NEVADA, NV 89101
(702) 229-6276



G.C. WALLACE, INC.
Engineers/Planners/Surveyors

BUFFALO DRIVE
UTILITY PLAN AND PROFILE
"B" 184+00.00 TO "B" 194+50.00

SHEET

TITLE

SCALE

PROJECT NO:

DRAWN BY:

DESIGNED BY:

CHECKED BY:

PROJECT NO:

SCALE:

PROJECT NO:

SCALE:

U3
59 93

107-V3593
AS-BUILT