

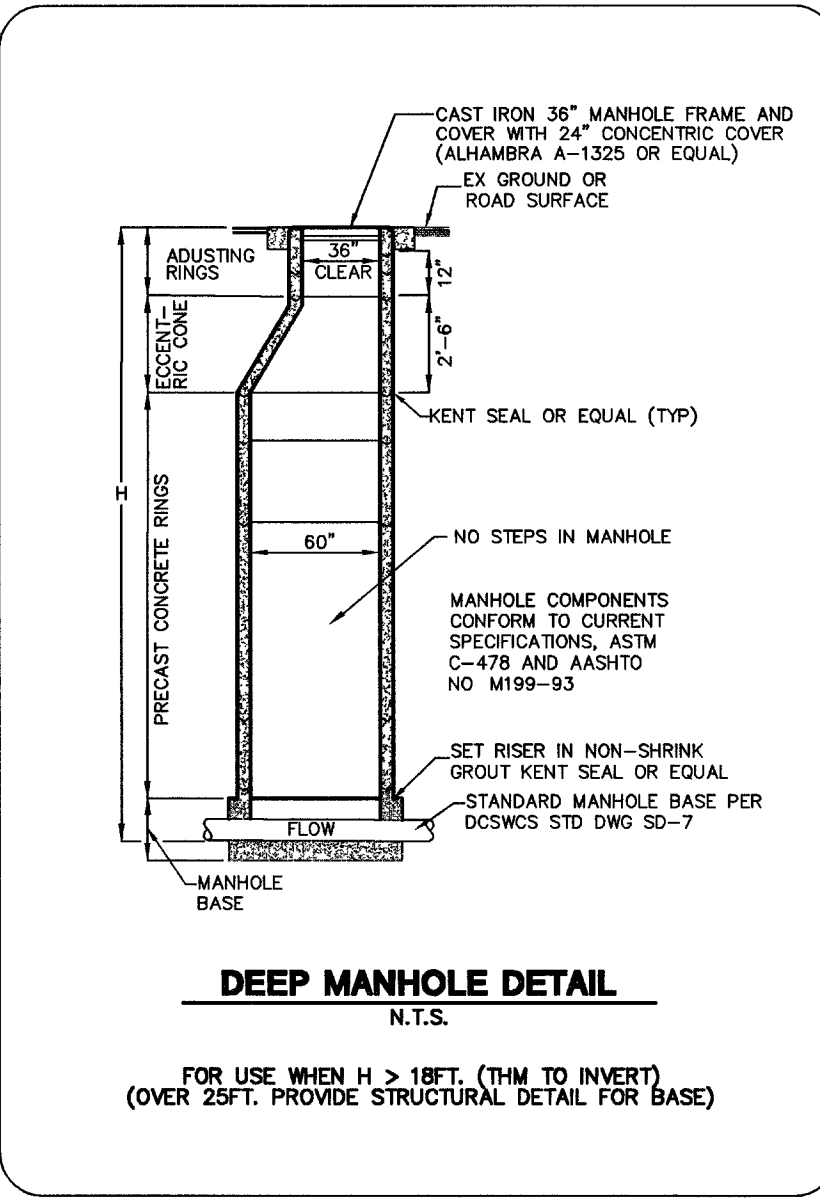


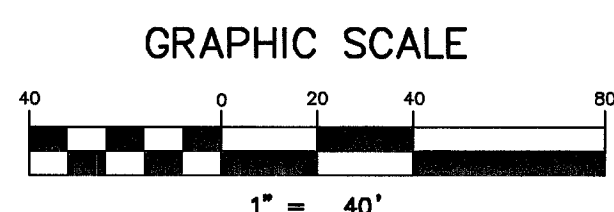

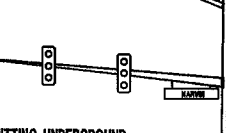

AVOID HITTING UNDERGROUND TRAFFIC SIGNAL SYSTEMS AND STREET LIGHT SYSTEM CONDUITS IT'S COSTLY

CALL BEFORE YOU GO UNDERGROUND

Call
before you

Underground

1-702-455-7511

CLARK COUNTY TRAFFIC OPERATIONS
AND

1-702-229-6611

LAS VEGAS AREA COMPUTERIZED TRAFFIC SYSTEM

Avoid cutting underground utility lines. It's costly

Call
before you

Dig

1-800-227-2600

Avoid overhead power line contact. It's costly

Call
before you

Overhead

1-702-227-2929

BASIS OF BEARINGS
THE BASIS OF BEARINGS FOR THIS PROJECT IS NORTH 00°08'16" EAST BEING THE EAST LINE OF THE NORTHWEST QUARTER (NE 1/4) OF THE SECTION 24, TOWNSHIP 19 SOUTH, RANGE 59 EAST, M.D.M., CLARK COUNTY, NEVADA, AS SHOWN ON A RECORD OF SURVEY ON FILE IN THE CLARK COUNTY, NEVADA, RECORDER'S OFFICE IN FILE 125 AT PAGE 32.

PROJECT BENCHMARK
PROJECT DATUM: NORTH AMERICAN VERTICAL DATUM OF 1988 (NAVDD88)

CLARK COUNTY VERTICAL CONTROL: 1C00-6N6
NAVDD88 ELEVATION: 787.794 METERS (2584.62 FEET)

RIVET AND SQUARE ALUMINUM PLATE IN A CONCRETE CYLINDER, LOCATED 25' SOUTH & 50' EAST OF GRAND CANYON DRIVE AND RED COACH AVENUE, 1' WEST OF ELECTRICAL VAULT.

CITY OF LAS VEGAS BENCHMARK
DATUM: NORTH AMERICAN VERTICAL DATUM OF 1988 (NAVDD88)

CITY OF LAS VEGAS BENCHMARK: BLV99-13SES
NAVDD88 ELEVATION: 869.608 METERS (2853.03 FEET)

RIVET AND PLATE IN CONCRETE CYLINDER NW CORNER OF HUALAPAI AND ELKHORN

NOTE: ADD 0.34" TO ABOVE CITY OF LAS VEGAS BENCHMARK BLV99-13SES TO MATCH ORIGIN PROJECT BENCHMARK, CLARK COUNTY BENCHMARK 1C00-6N6 (2584.62 FEET) AS SHOWN ON RECORD OF SURVEY FILE 124 PAGE 94.

1074 4816-05-44 DRAWING NO.		SHEET SS4 7 OF 33 SHEETS		EXPIRES 06-30-05 PROFESSIONAL ENGINEER STATE OF CALIFORNIA DANIEL H. HOOG CIVIL NO. 12811 (06/01)		DRAWN BY: _____ S.P. _____ DESIGNED BY: _____ B.F. _____ CHECKED BY: _____ L.M. _____ PROJECT NO: 5899 SCALE: 1"=40' HORIZ. 1"=4' VERT.		SEWER PLAN AND PROFILE GRAND TETON DRIVE STA. 38+00.00 TO 47+50.00		CLIFFS EDGE GRAND TETON DRIVE SEWER IMPROVEMENTS		CLIFFS EDGE LLC 3435 CLIFF SHADOWS PARKWAY, SUITE 280 LAS VEGAS, NEVADA 89128 (702) 777-1221		CITY OF LAS VEGAS, NEVADA 2727 SOUTH RAINBOW BOULEVARD LAS VEGAS, NEVADA 89146-5148 PH. (702) 873-7550 FAX (702) 362-2597 vtm nevada CONSULTING ENGINEERS • PLANNERS • LAND SURVEYORS		7 6 5 4 3 2 1		7 6 5 4 3 2 1		12/15/04 3/20/05 12/15/04 REV. DATE BY ADD STORM DRAIN CROSSINGS, REVISE WATERLINE REVISE EGAN CLIENT SURFACES ADD STORM DRAIN CROSSINGS, REVISE WATERLINE REV. DATE BY		REVISION	
--------------------------------	--	---------------------------------------	--	---	--	---	--	---	--	---	--	--	--	--	--	---------------------------------	--	---------------------------------	--	--	--	----------	--