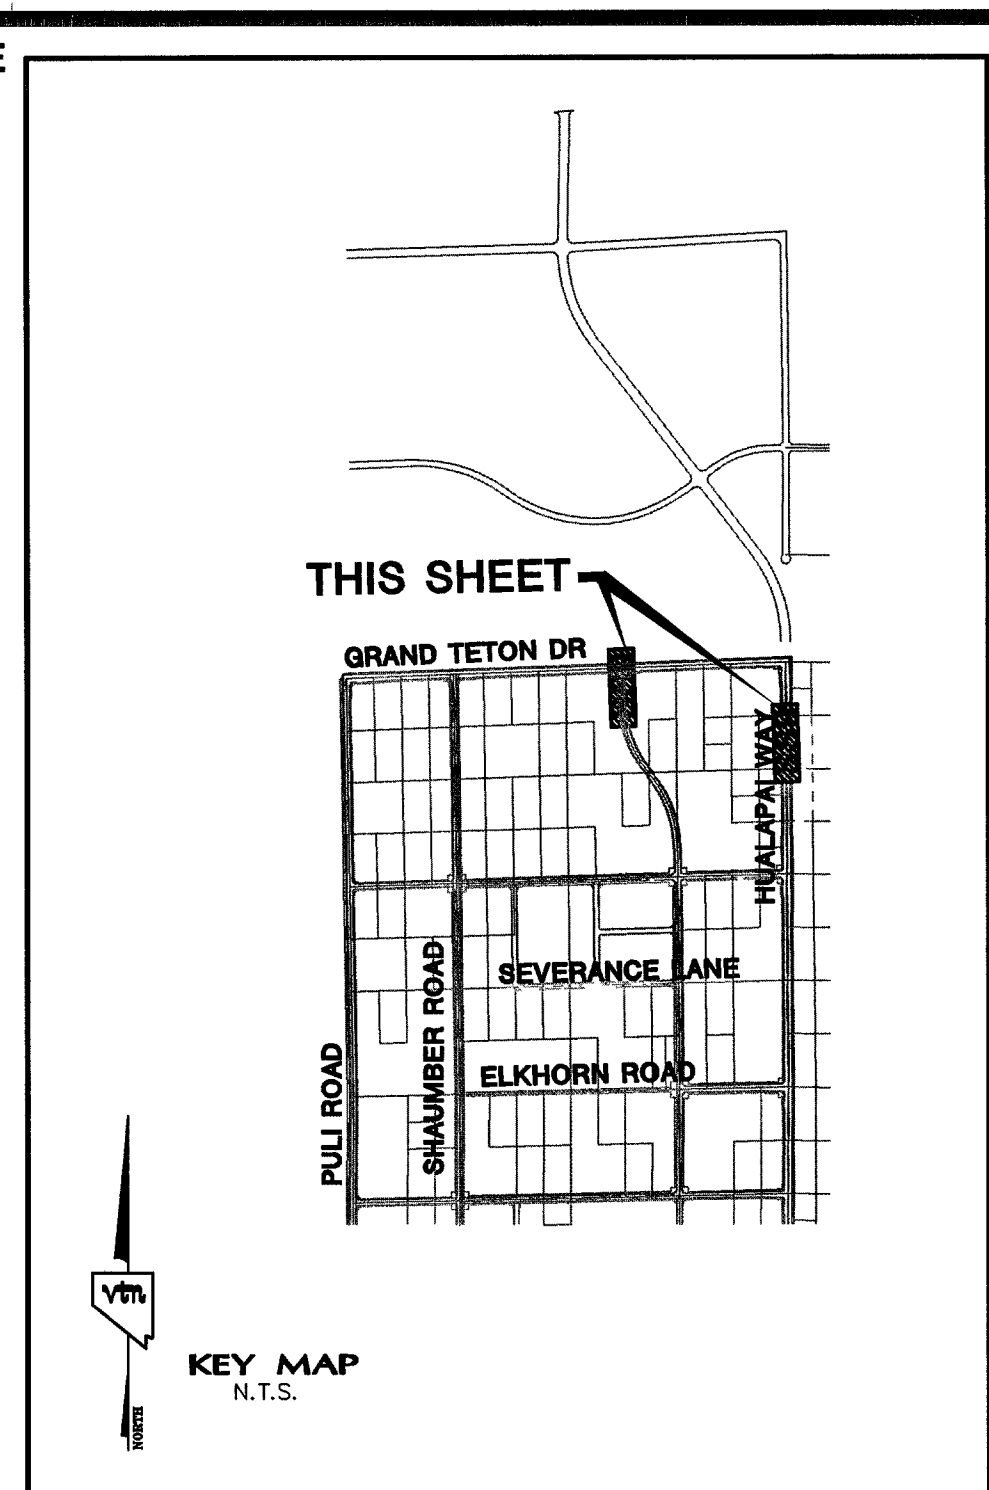


AVOID HITTING UNDERGROUND
TRAFFIC SIGNAL SYSTEM
AND STREET LIGHT SYSTEM CONDUITS
ITS CORTLY

CALL BEFORE
YOU DO
UNDERGROUND

Call
before you
Underground

1-702-455-7511
CLARK COUNTY TRAFFIC OPERATIONS
AND
1-702-229-5611
LAS VEGAS AREA COMPUTERIZED TRAFFIC SYSTEM

Avoid overhead power
line contact. It's costly

Call
before you
Overhead
1-702-227-2929

Avoid cutting underground
utility lines. It's costly.

**Call
before you
Dig**

1-800-227-2600

BASIS OF BEARINGS

THE BASIS OF BEARINGS FOR THIS PROJECT IS NORTH 00°08'16" EAST BEING THE EAST LINE OF THE NORTHWEST QUARTER (NE 1/4)' OF THE SECTION 24, TOWNSHIP 15 SOUTH, RANGE 58 EAST, M.D.M., CLARK COUNTY, NEVADA, AS SHOWN ON A RECORD OF SURVEY ON FILE IN THE CLARK COUNTY, NEVADA, RECORDER'S OFFICE IN FILE 123 AT PAGE 32.

PROJECT BENCHMARK
PROJECT DATUM: NORTH AMERICAN VERTICAL DATUM OF 1988 (NAVD88)

CLARK COUNTY VERTICAL CONTROL: 1C00:6N6
NAVD88 ELEVATION: 787.794 METERS (2584.62 FEET)

AND RED COACH AVENUE, 1' WEST OF ELECTRICAL VAULT.

CITY OF LAS VEGAS BENCHMARK
DATUM: NORTH AMERICAN VERTICAL DATUM OF 1988 (NAVD88)

CITY OF LAS VEGAS BENCHMARK: 8LV99:13SES
NAVD88 ELEVATION: 869.606 METERS (2853.03 FEET)

RIVER AND FERTIL IN CONCRETE STENDER NW CORNER OF TIGER AND
AND ELKHORN

NOTE: ADD 0.34' TO ABOVE CITY OF LAS VEGAS BENCHMARK BLV99:13SES TO MATCH ORIGINAL PROJECT BENCHMARK, CLARK COUNTY BENCHMARK 1C00-6N6 (2584.62 FEET) AS SHOWN ON RECORD OF SURVEY FILE 124 PAGE 94.

EXPIRES 06-30-05 		DRAWN BY: _____ S.P. _____ DESIGNED BY: _____ B.C. _____		APRIL '04 APRIL '04 APRIL '04 APRIL '04	
SHEET SS9 12 OF 13 SHEETS		CHECKED BY: _____ L.M. _____		PROJECT NO: 5989 SCALE: 1"=40' HORIZ. 1"=4' VERT.	
DRAWING NO. 10445-05-03		CITY OF LAS VEGAS, NEVADA 2727 SOUTH RAINBOW BOULEVARD LAS VEGAS, NEVADA 89146-5148 PH. (702) 875-7500 FAX (702) 362-2337 vtm nevada CONSULTING ENGINEERS • PLANNERS • LAND SURVEYORS			
SEWER PLAN AND PROFILE EGAN CREST WAY STA. 18+00.00 TO 20+85.02 HUALLAPAI WAY STA. 18+00.00 TO 18+60.00		CLIFFS EDGE GRAND TETON DRIVE SEWER IMPROVEMENTS			
3455 CLIFF SHADOWS PARKWAY, SUITE 290 LAS VEGAS, NEVADA 89129 (702) 771-1221		3 2 1 0			
1 2 3 4 5 6		REVISION FOR WORK IN BLM ROW GRANT FUTURE AND ADDED SEWER LATERALS REVISION DATE BY 4/12/05 KDP			