

GENERAL NOTES

- CONTRACTOR SHALL REFER TO THE SPECIFICATIONS FOR ACCEPTABLE MANUFACTURERS OF FIRE ALARM SYSTEM TO MEET CITY AND LOCAL FIRE DEPARTMENT REQUIREMENTS.
- FIRE ALARM CABLE ROUTING, CONDUIT ROUTING, CABLE AND ALARM DEVICES ARE DIAGRAMMATIC. CONTRACTOR SHALL FOLLOW AND COMPLY WITH DRAWINGS FURNISHED BY FIRE ALARM CONTRACTOR.

ELECTRICAL PLAN KEYNOTES

- 2#12 - 3/4" C
- 4#12 - 3/4" C
- FIRE ALARM SMOKE DETECTOR. (SEE SPECIFICATIONS FOR ACCEPTABLE MANUFACTURERS)
- FIRE ALARM STROBE WITH HORN. (SEE SPECIFICATIONS FOR ACCEPTABLE MANUFACTURERS)
- FIRE ALARM PULL STATION. (SEE SPECIFICATIONS FOR ACCEPTABLE MANUFACTURERS)



REVISIONS

10-06-04	
10-22-04	

CONSULTANT


JVC
ARCHITECTS

atelier

4280 CAMERON ST. #2
LAS VEGAS, NV 89103
PH: 702.671.3416
FAX: 702.871.2830

© JVC ASSOCIATES, INC. 2004

CITY OF LAS VEGAS
RECORDS ARCHIVAL
MATERIALS STORAGE FACILITY
BUFFALO & PEAK
LAS VEGAS, NEVADA

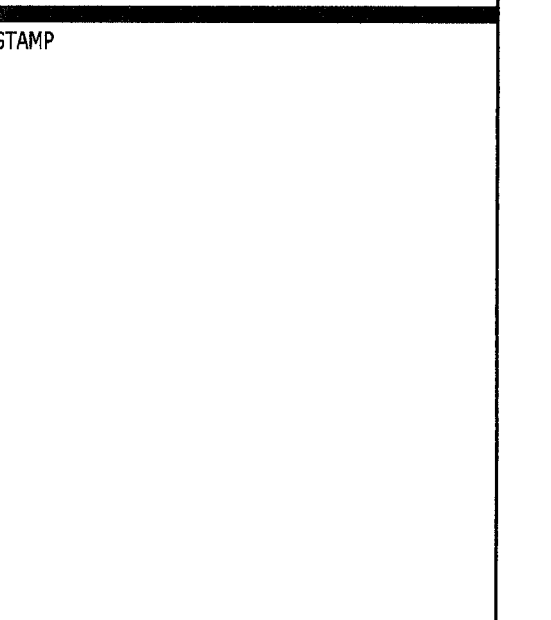


OWNER: CITY OF LAS VEGAS
DEPARTMENT OF PUBLIC WORKS
ARCHITECTURAL SERVICES

400 EAST STEWART AVENUE
LAS VEGAS, NEVADA 89103
PHONE: (702) 259-6535
FAX: (702) 382-3232
TDD: (702) 386-9408

DRAWN: DJP
CHECK: SMH
FILE: 21N23191
DATE: 03.29.04
SCALE: SEE SHEET
SHEET NO: 04.15341.03
CLV DWG NO: 521-288
SHT NO:

E3.04A

A FIRE ALARM PLAN - ADDITIVE DEDUCTIVE #1
SCALE: 1/8" = 1'-0"

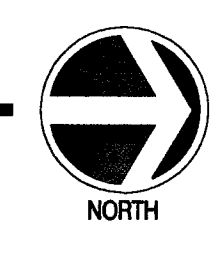

87251

