
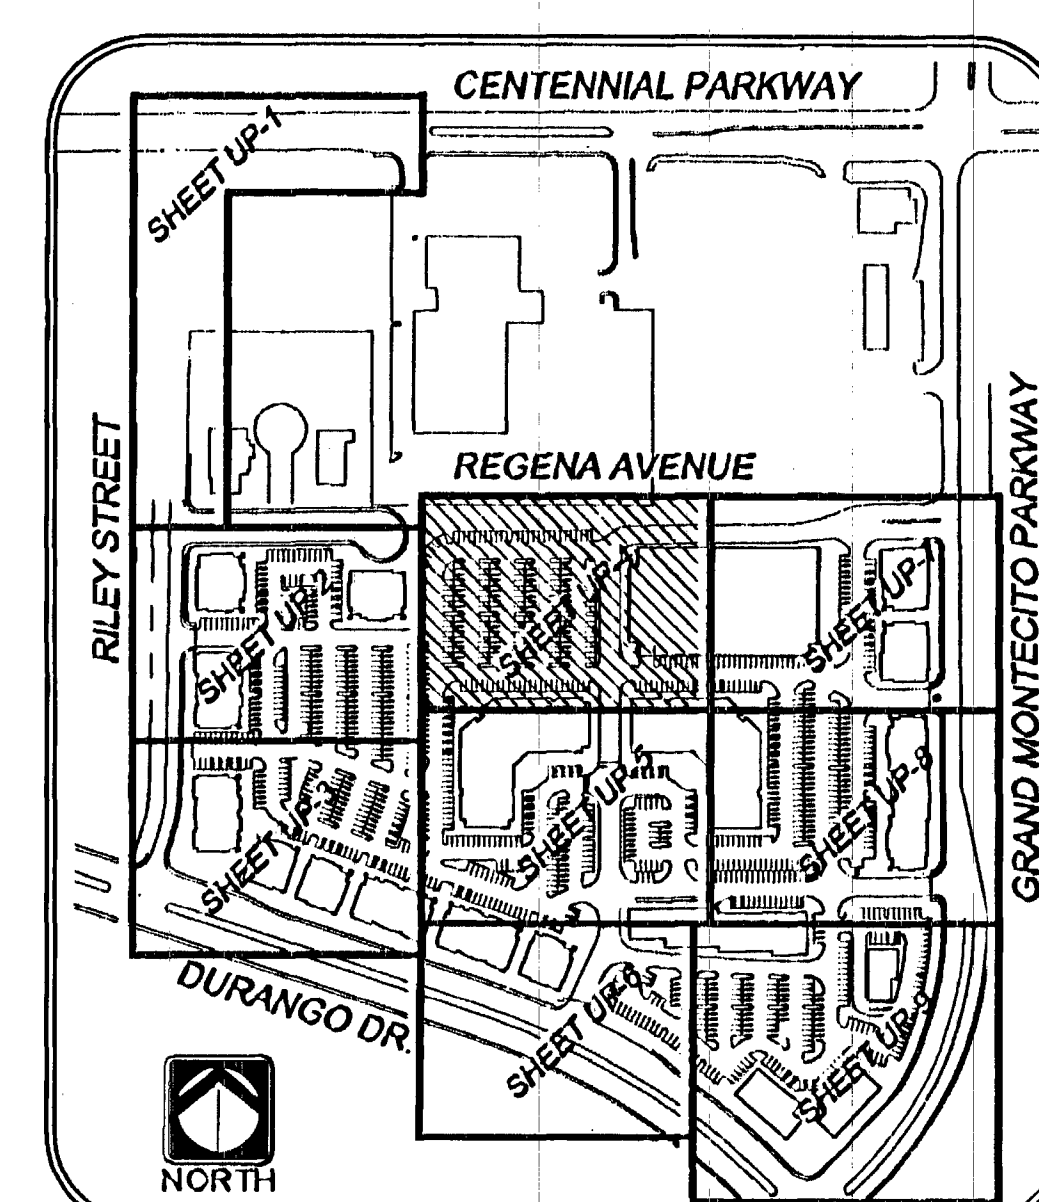


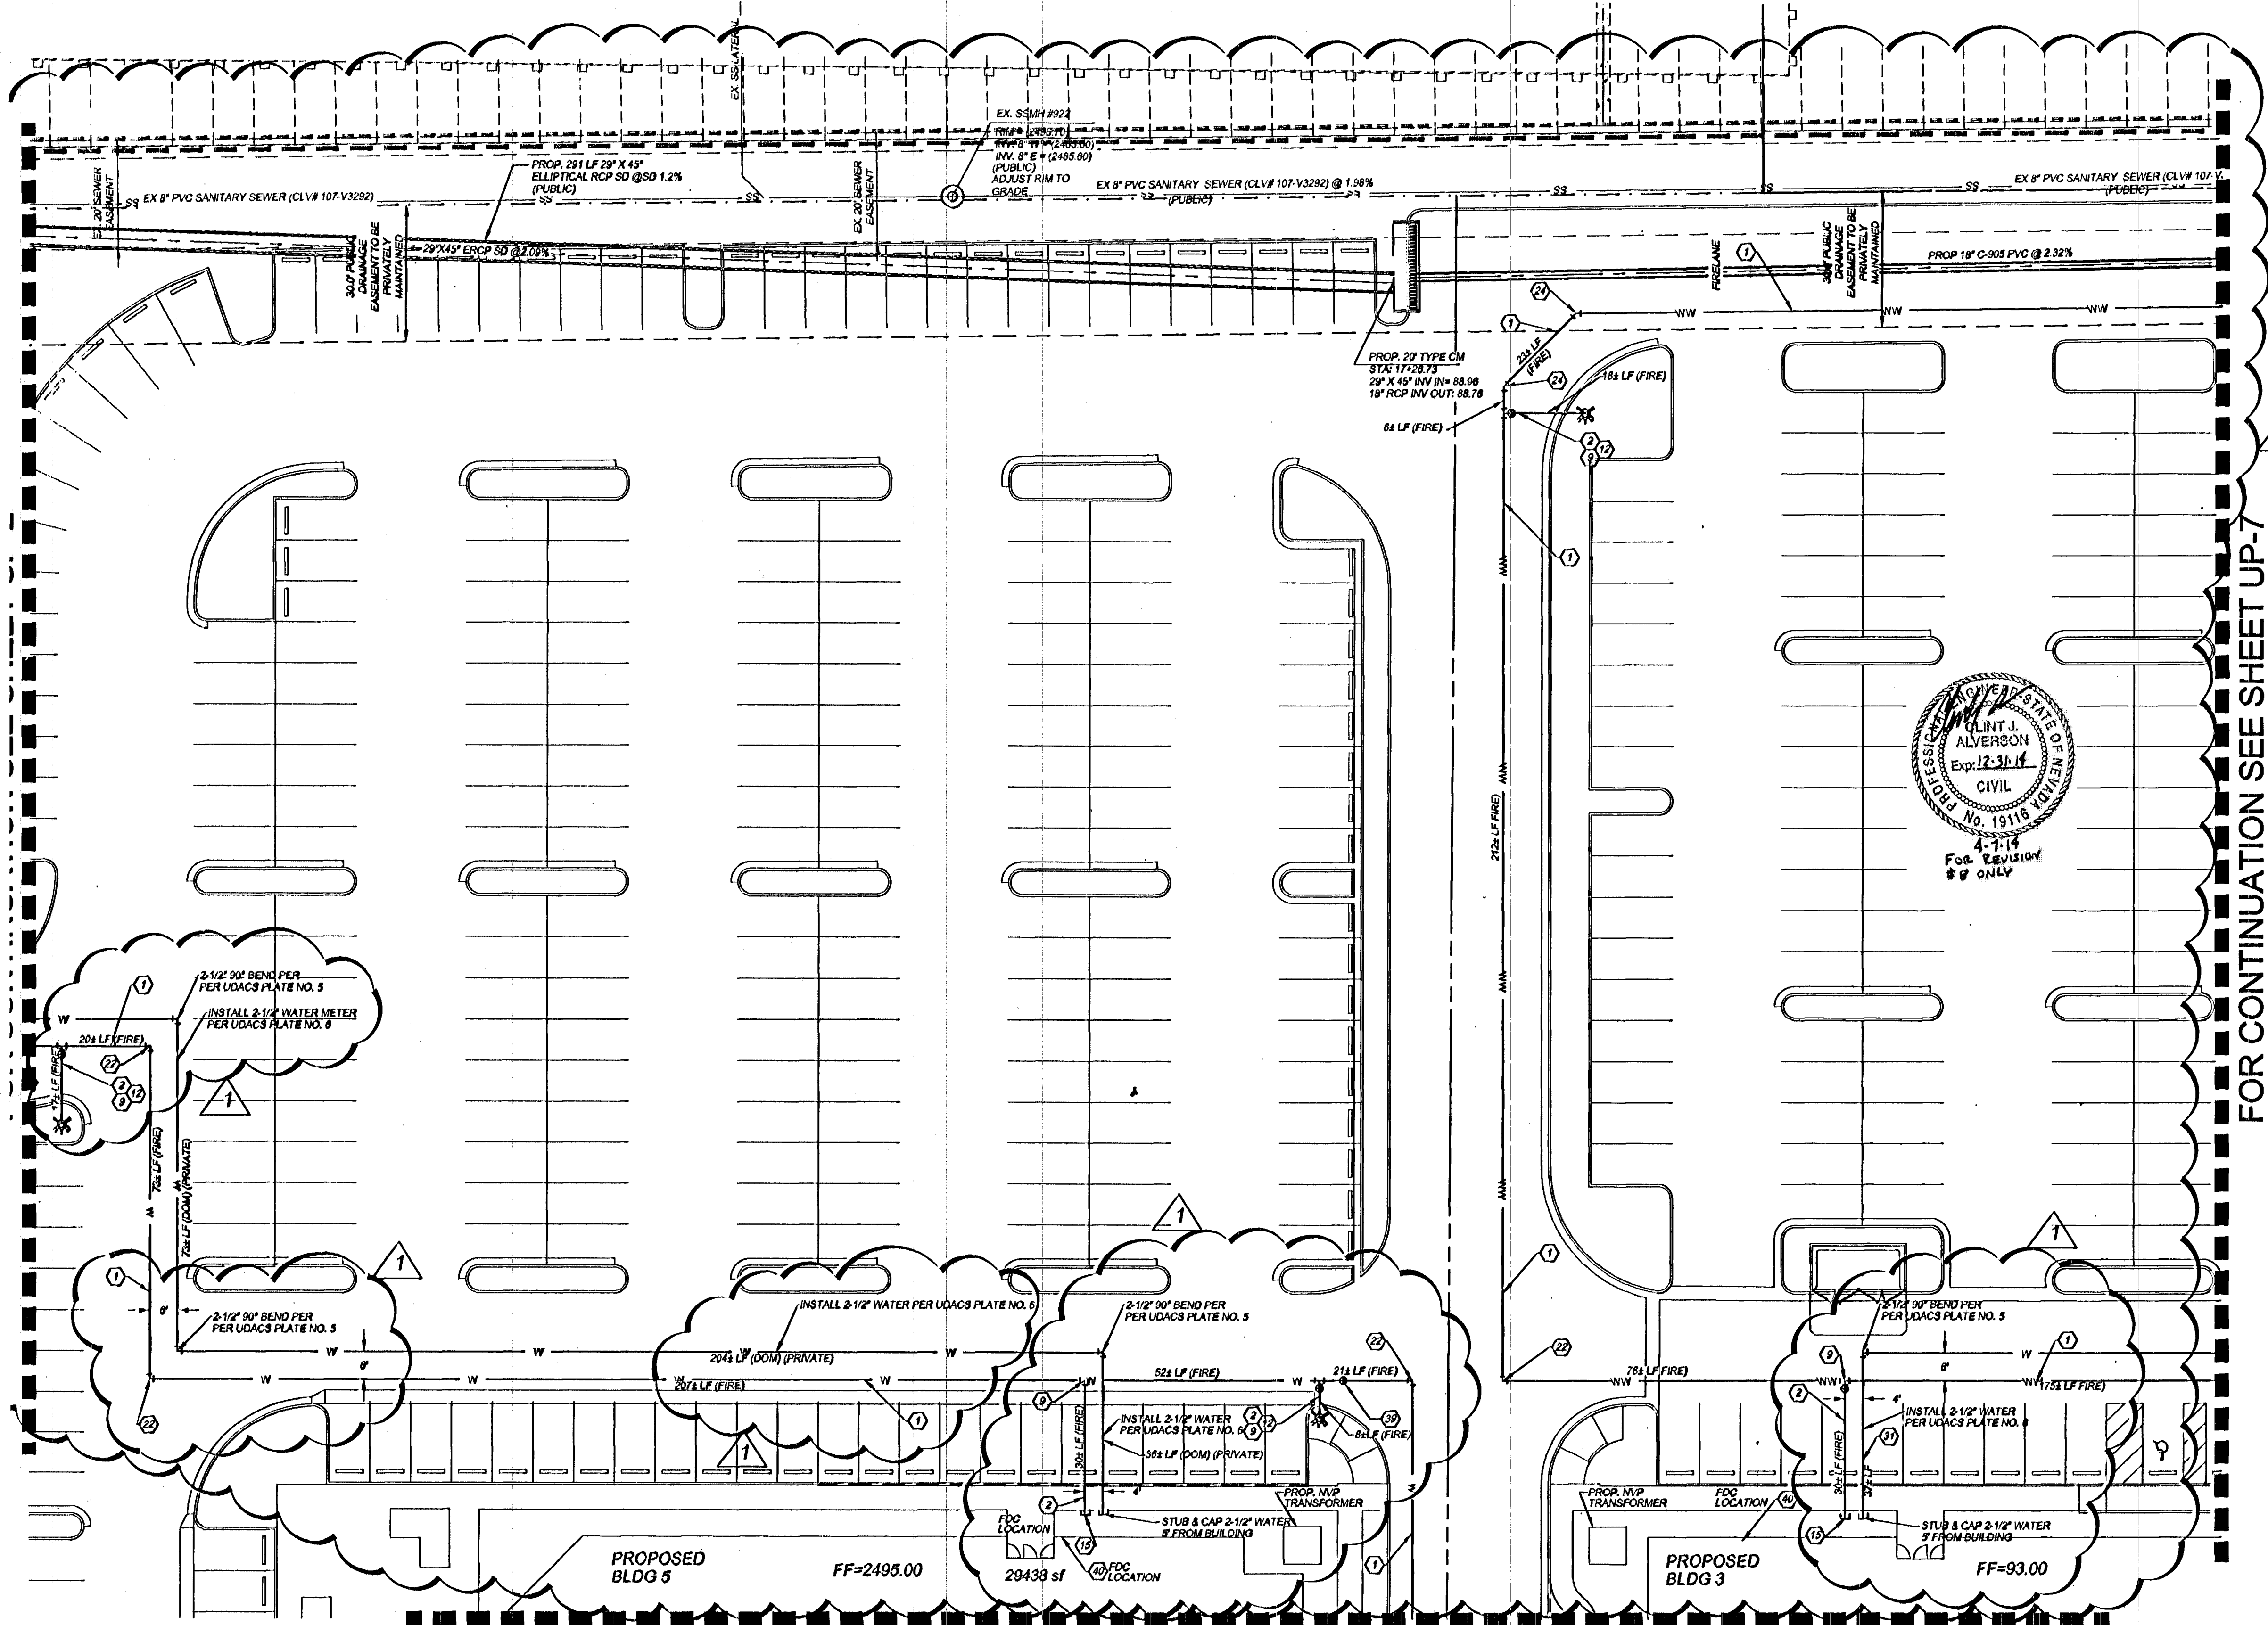

WATER NOTES			
No.	ITEM	UNIT	PUBLIC QUANTITY
1	INSTALL 8" PVC WATER LINE (FPM), PER UDACS PLATE NO. 6A & 6B & 6C (PVC, C-200, CL-150)	LF	383
2	INSTALL 8" WATER LINE (FPM), PER UDACS PLATE NO. 6A & 6B & 6C (PVC, C-200, CL-150)	LF	142
3	INSTALL 1" TAPPING HUB, 1" RITA PER UDACS PLT. NO. 18-11A	EA	2
4	INSTALL 1" TAPPING VALVE PER UDACS PLATE NO. 22 & 8	EA	6
5	INSTALL 1" TAPPING VALVE PER UDACS PLATE NO. 22 & 8	EA	6
6	INSTALL 1" TAPPING VALVE PER UDACS PLATE NO. 22 & 8	EA	6
7	INSTALL 1" TAPPING VALVE PER UDACS PLATE NO. 22 & 8	EA	6
8	INSTALL 1" TAPPING VALVE PER UDACS PLATE NO. 22 & 8	EA	6
9	INSTALL 1" TAPPING VALVE PER UDACS PLATE NO. 22 & 8	EA	6
10	INSTALL 1" TAPPING VALVE PER UDACS PLATE NO. 22 & 8	EA	6
11	INSTALL 1" TAPPING VALVE PER UDACS PLATE NO. 22 & 8	EA	6
12	INSTALL 1" TAPPING VALVE PER UDACS PLATE NO. 22 & 8	EA	6
13	INSTALL 1" TAPPING VALVE PER UDACS PLATE NO. 22 & 8	EA	6
14	INSTALL 1" TAPPING VALVE PER UDACS PLATE NO. 22 & 8	EA	6
15	INSTALL 1" TAPPING VALVE PER UDACS PLATE NO. 22 & 8	EA	6
16	INSTALL 1" TAPPING VALVE PER UDACS PLATE NO. 22 & 8	EA	6
17	INSTALL 1" TAPPING VALVE PER UDACS PLATE NO. 22 & 8	EA	6
18	INSTALL 1" TAPPING VALVE PER UDACS PLATE NO. 22 & 8	EA	6
19	INSTALL 1" TAPPING VALVE PER UDACS PLATE NO. 22 & 8	EA	6
20	INSTALL 1" TAPPING VALVE PER UDACS PLATE NO. 22 & 8	EA	6
21	INSTALL 1" TAPPING VALVE PER UDACS PLATE NO. 22 & 8	EA	6
22	INSTALL 1" TAPPING VALVE PER UDACS PLATE NO. 22 & 8	EA	6
23	INSTALL 1" TAPPING VALVE PER UDACS PLATE NO. 22 & 8	EA	6
24	INSTALL 1" TAPPING VALVE PER UDACS PLATE NO. 22 & 8	EA	6
25	INSTALL 1" TAPPING VALVE PER UDACS PLATE NO. 22 & 8	EA	6
26	INSTALL 1" TAPPING VALVE PER UDACS PLATE NO. 22 & 8	EA	6
27	INSTALL 1" TAPPING VALVE PER UDACS PLATE NO. 22 & 8	EA	6
28	INSTALL 1" TAPPING VALVE PER UDACS PLATE NO. 22 & 8	EA	6
29	INSTALL 1" TAPPING VALVE PER UDACS PLATE NO. 22 & 8	EA	6
30	INSTALL 1" TAPPING VALVE PER UDACS PLATE NO. 22 & 8	EA	6
31	INSTALL 1" TAPPING VALVE PER UDACS PLATE NO. 22 & 8	EA	6
32	INSTALL 1" TAPPING VALVE PER UDACS PLATE NO. 22 & 8	EA	6
33	INSTALL 1" TAPPING VALVE PER UDACS PLATE NO. 22 & 8	EA	6
34	INSTALL 1" TAPPING VALVE PER UDACS PLATE NO. 22 & 8	EA	6
35	INSTALL 1" TAPPING VALVE PER UDACS PLATE NO. 22 & 8	EA	6
36	INSTALL 1" TAPPING VALVE PER UDACS PLATE NO. 22 & 8	EA	6
37	INSTALL 1" TAPPING VALVE PER UDACS PLATE NO. 22 & 8	EA	6
38	INSTALL 1" TAPPING VALVE PER UDACS PLATE NO. 22 & 8	EA	6
39	INSTALL 1" TAPPING VALVE PER UDACS PLATE NO. 22 & 8	EA	6
40	INSTALL 1" TAPPING VALVE PER UDACS PLATE NO. 22 & 8	EA	6
41	INSTALL 1" TAPPING VALVE PER UDACS PLATE NO. 22 & 8	EA	6
42	INSTALL 1" TAPPING VALVE PER UDACS PLATE NO. 22 & 8	EA	6
43	INSTALL 1" TAPPING VALVE PER UDACS PLATE NO. 22 & 8	EA	6
44	INSTALL 1" TAPPING VALVE PER UDACS PLATE NO. 22 & 8	EA	6
45	INSTALL 1" TAPPING VALVE PER UDACS PLATE NO. 22 & 8	EA	6
46	INSTALL 1" TAPPING VALVE PER UDACS PLATE NO. 22 & 8	EA	6
47	INSTALL 1" TAPPING VALVE PER UDACS PLATE NO. 22 & 8	EA	6
48	INSTALL 1" TAPPING VALVE PER UDACS PLATE NO. 22 & 8	EA	6
49	INSTALL 1" TAPPING VALVE PER UDACS PLATE NO. 22 & 8	EA	6
50	INSTALL 1" TAPPING VALVE PER UDACS PLATE NO. 22 & 8	EA	6


SANITARY SEWER MANHOLE TABLE					
SSMH #	NORTHING	EASTING	RIM	INV IN	INV OUT
SSMH #1	N81413.0307	E45174.7234	2494.65	2495.29	2495.09
SSMH #2	N81480.2372	E45083.2187	2496.11	2497.30	2497.10
SSMH #3	N81553.8777	E44776.1828	2495.17	2495.83	2495.83
SSMH #4	N81584.4748	E44743.3557	2500.11	2499.59	2499.09
SSMH #5	N81948.0397	E44743.0844	2505.54	—	2497.80
SSMH #6	N82054.3534	E45731.5502	2494.11	2492.04	71.84
SSMH #7	N81781.7050	E45731.1740	2492.28	—	2497.70
SSMH #8	N81502.9716	E4519.1011	2495.19	2497.13	2497.08
SSMH #9	N81502.9716	E45087.0455	2493.32	—	2498.59

SEWER NOTES			
No.	ITEM	UNIT	QUANTITY
1	INSTALL 8" PVC SDR35 SEWER LINE (PRIVATE)	LF	1413
2	INSTALL 8" PVC SEWER CLEANOUT 5' FROM BUILDING (PRIVATE)	EA	15
3	INSTALL 8" PVC SDR 35 SEWER LATERAL PER SD-17 (PRIVATE)	LF	943
4	INSTALL SEWER MANHOLE PER SD-1 (PRIVATE)	EA	7
5	NOT USED	EA	—
6	INSTALL 8" PVC SEWER CLEANOUT (PRIVATE) SEE DETAIL 8 SHT DE-3	EA	5
7	INSTALL SEWER MANHOLE PER SD-1 (PUBLIC)	EA	2

Call before you Dig.
1-800-227-2600
UNDERGROUND SERVICES

Call before you OVERHEAD.
1-702-227-2929
NEVADA OVERHEAD SERVICES

Call before you UnderGround.
1-702-458-7511
CLARK COUNTY TRAFFIC OPERATIONS AND SAFETY SERVICES

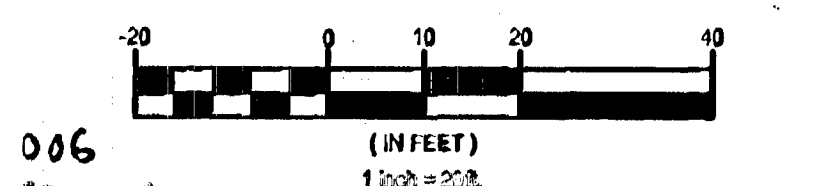

VENTURE CORPORATION
CENTENNIAL HILLS PROFESSIONAL CENTER
UTILITY PLAN
JOB # 052058.01
SHEET NO. UP-4
58 OF 87 SHEETS
11/13/09 (CLV # 10774958)