

CITY OF LAS VEGAS STREETLIGHT NOTES

1. ALL STREET LIGHTING INSTALLATIONS SHALL BE IN ACCORDANCE WITH THE STREET LIGHTING PLANS, THE UNIFORM STANDARD SPECIFICATIONS FOR PUBLIC WORKS CONSTRUCTION OFF-SITE IMPROVEMENTS, CLARK COUNTY AREA, NEVADA; LATEST REVISION (USS), AND THE UNIFORM STANDARD DRAWINGS FOR PUBLIC WORKS CONSTRUCTION OFF-SITE IMPROVEMENTS, CLARK COUNTY AREA, NEVADA (USD), LATEST REVISION.
2. DESIGN PROFESSIONAL AND CONTRACTOR SHALL VERIFY CITY'S LATEST LED FIXTURE SPECIFICATIONS AND APPROVED FIXTURES PER CLV WEBSITE, UNDER BUILDING AND SAFETY FORMS, PRIOR TO ORDERING MATERIALS.
3. NO DEVIATION OF STREET LIGHT, PULL BOX, CONDUITS (ETC.), LOCATIONS SHALL BE PERMITTED WITHOUT WRITTEN APPROVAL OF TRAFFIC AND CITY ENGINEER. ANY DEVIATION FROM THE PLAN LOCATION WILL REQUIRE COMPLIANCE WITH SECTION 623 OF THE USS.
4. ALL EXISTING STREET LIGHTING SHALL REMAIN OPERATIONAL DURING CONSTRUCTION IN ACCORDANCE WITH SECTION 623 G.03.01 OF THE USS.
5. ALL EMPTY CONDUIT SHALL HAVE AT LEAST ONE GREEN #8 AWG WIRE INSTALLED AS TRACER WIRE IN ACCORDANCE WITH SECTION 623 G.02.01 OF THE USS PRIOR TO BACKFILLING AND FINAL INSPECTION.
6. ANY STRUCTURE SUCH AS BLOCK WALLS, CHAIN LINK FENCES, RETAINING WALLS, ETC., SHALL LEAVE A MINIMUM CLEARANCE IN COMPLIANCE WITH THE USD NO. 320A, WHEN POLE IS INSTALLED BEHIND SIDEWALK AND SHALL AT NO TIME COMPLETELY ENCLOSE THE STREET LIGHTING POLE.
7. AS-BUILT DRAWINGS SHALL BE SUPPLIED TO THE TRAFFIC ENGINEERING DIVISION PRIOR TO ANY PRE-FINAL INSPECTION. THE AS-BUILT DRAWING NEEDS TO BE STAMPED AS-BUILT AND SIGNED BY THE PREPARER.
8. SERVICE POINTS SHALL BE COORDINATED WITH NV ENERGY, AND WHEREVER POSSIBLE, BE LOCATED NEAR THE CENTER OF THE CIRCUIT. SERVICE POINTS SHALL BE SHOWN ON THE PLANS.
9. WHEREVER THERE IS AN OVERHEAD UTILITY THAT MAY CONFLICT WITH THE INSTALLATION OF STREET LIGHTING CIRCUITS AND/OR POLES, THESE CONFLICTS MUST BE RESOLVED BETWEEN THE DEVELOPER AND THE UTILITIES INVOLVED BEFORE STREETLIGHT BASES ARE INSTALLED, AT NO EXPENSE TO THE CITY OF LAS VEGAS.
10. THE CONTRACTOR SHALL FURNISH COMPLETE CONDUIT, WIRE, ETC. FROM SERVICE TO TRANSFORMERS AND CONTROL SYSTEMS IF REQUIRED ON PLANS.
11. THE DEVELOPER/OWNER WILL BE REQUIRED TO SUPPLY POWER TO ALL NEW PUBLIC STREET LIGHTS INSTALLED UNDER THIS DESIGN PRIOR TO BOND RELEASE. THE CONTRACTOR SHALL BE RESPONSIBLE FOR ALL ITEMS ASSOCIATED WITH THE INSTALLATION, CONSTRUCTION, ENERGIZING, MAINTENANCE AND OPERATIONAL COST OF SAID STREET LIGHTS PRIOR TO PROJECT COMPLETION. AFTER TO THE PLAN FOR ANY NEW SERVICE REQUIREMENTS, THE TRANSFER OF OWNERSHIP FROM THE DEVELOPER/OWNER TO THE CITY OF LAS VEGAS, THE PUBLIC STREET LIGHTS AND/OR SERVICE/S INSTALLED UNDER THIS PLAN DESIGN WILL BE IN CONJUNCTION WITH THIS PROJECT COMPLETION. COORDINATE ALL MAINTENANCE AND OPERATIONAL TRANSFERS WITH THE CITY OF LAS VEGAS TRAFFIC ENGINEERING DEPARTMENT (TEPD) AT (702) 229-6331.

REVISED 06/04/2018

CITY OF LAS VEGAS GRADING NOTES

1. IN THE EVENT THAT ANY UNFORESEEN CONDITIONS NOT COVERED BY THESE NOTES ARE ENCOUNTERED DURING GRADING OPERATIONS, THE OWNER/ENGINEER SHALL BE IMMEDIATELY NOTIFIED FOR DIRECTION.
2. IT SHALL BE THE RESPONSIBILITY OF THE CONTRACTOR TO PERFORM ALL NECESSARY CUTS AND FILLS WITHIN THE LIMITS OF THIS PROJECT AND THE RELATED OFF-SITE WORK, SO AS TO GENERATE THE DESIRED SUBGRADE, FINISH GRADES AND SLOPES SHOWN.
3. CONTRACTOR SHALL TAKE FULL RESPONSIBILITY FOR ALL EXCAVATION, ADEQUATE SHORING SHALL BE DESIGNED AND PROVIDED BY THE CONTRACTOR TO PREVENT UNDERMINING OF ANY ADJACENT FEATURES OR FACILITIES AND/OR CAVING OF THE EXCAVATION.
4. THE CONTRACTOR IS WARNED THAT AN EARTHWORK BALANCE WAS NOT NECESSARILY THE INTENT OF THIS PROJECT. ADDITIONAL MATERIAL REQUIRED OR EXCESS MATERIAL FOLLOWING EARTHWORK OPERATIONS BECOMES THE RESPONSIBILITY OF THE CONTRACTOR.
5. THE GRADING CONTRACTOR IS RESPONSIBLE TO COORDINATE WITH THE OWNER TO PROVIDE FOR THE REQUIREMENTS OF THE PROJECT STORM WATER POLLUTION PREVENTION PLAN (SWPPP) AND ASSOCIATED PERMIT.
6. CONTRACTOR SHALL GRADE TO THE LINES AND ELEVATIONS SHOWN ON THE PLANS WITHIN THE FOLLOWING HORIZONTAL AND VERTICAL TOLERANCES AND DEGREES OF COMPACTION, IN THE AREAS INDICATED:

	HORIZONTAL	VERTICAL	COMPACTION
A. PAVEMENT AREA SUBGRADE	0.1"	+0.0" TO -0.1"	SEE SOILS REPORT
B. ENGINEERED FILL	0.5"	+0.1" TO -0.1"	SEE SOILS REPORT
COMPACTION TESTING WILL BE PERFORMED BY THE OWNER OR HIS REPRESENTATIVE.			
7. ALL CUT AND FILL SLOPES SHALL BE PROTECTED UNTIL EFFECTIVE EROSION CONTROL HAS BEEN ESTABLISHED.
8. THE USE OF POTABLE WATER WITHOUT A SPECIAL PERMIT FOR BUILDING OR CONSTRUCTION PURPOSES INCLUDING CONSOLIDATION OF BACKFILL OR DUST CONTROL IS PROHIBITED. THE CONTRACTOR SHALL OBTAIN ALL NECESSARY PERMITS FOR CONSTRUCTION WATER.
9. THE CONTRACTOR SHALL MAINTAIN THE STREETS, SIDEWALKS AND ALL OTHER PUBLIC RIGHT-OF-WAY IN A CLEAN, SAFE AND USABLE CONDITION. ALL SPILLS OF SOIL, ROCK OR CONSTRUCTION DEBRIS SHALL BE PROMPTLY REMOVED FROM THE PUBLICLY OWNED PROPERTY DURING CONSTRUCTION AND UPON COMPLETION OF THE PROJECT. ALL ADJACENT PROPERTY, PRIVATE OR PUBLIC SHALL BE MAINTAINED IN A CLEAN, SAFE AND USABLE CONDITION.
10. IN THE EVENT THAT ANY TEMPORARY CONSTRUCTION ITEM IS REQUIRED THAT IS NOT SHOWN ON THESE DRAWINGS, THE OWNER AGREES TO PROVIDE AND INSTALL SUCH ITEM AT HIS OWN EXPENSE AND AT THE DIRECTION OF THE CITY ENGINEER. TEMPORARY CONSTRUCTION INCLUDES DITCHES, BERM, ROAD SIGNS AND BARRICADES, ETC.

REVISED 04/15/10

CITY OF LAS VEGAS SEWER NOTES

1. ALL CONSTRUCTION AND MATERIALS SHALL BE IN ACCORDANCE WITH THE LATEST EDITION OF THE DESIGN AND CONSTRUCTION STANDARDS FOR WASTEWATER COLLECTION SYSTEMS AND THE UNIFORM STANDARD SPECIFICATIONS FOR PUBLIC WORKS CONSTRUCTION OFF-SITE IMPROVEMENTS, CLARK COUNTY AREA, NEVADA, AS AMENDED. IT WILL BE THE RESPONSIBILITY OF THE CONTRACTOR TO BE AWARE OF THE CONTENTS OF THE ABOVE SPECIFICATIONS.
2. IT SHALL BE THE CONTRACTOR'S RESPONSIBILITY TO PERFORM CONSTRUCTION AS PER PLANS. ANY ADDITIONS, DELETIONS, OR CHANGES SHALL FIRST MEET WITH THE APPROVAL OF THE CITY ENGINEER.
3. CHISEL "S" OR "G" IN CURBS WHERE SEWER OR GAS LATERALS PASS UNDER THE CURB.
4. POLYVINYL (PVC) SEWER PIPE SHALL MEET ASTM D-3034 SDR 35 SPECIFICATIONS, INSTALLED WITH SAND BEDDING AND BACKFILL OF TYPE II AGGREGATE BASE.
5. ALL MANHOLES PAVED IN STREETS (80') FOOT R/W AND LARGER SHALL HAVE CONCRETE COLLARS. STREETS LESS THAN EIGHTY (80') FOOT R/W WILL REQUIRE RETROFIT IF PAVING DOES NOT CONFORM TO CITY STANDARDS AT THE MANHOLE.
6. TEE SADDLES SHALL BE USED TO CONNECT SEWER LATERALS TO EXISTING MAIN LINES UP TO TWELVE INCH (12") DIAMETER. CONNECTIONS TO FIFTEEN INCH (15") OR LARGER MAINS SHALL REQUIRE SPECIAL PROCEDURES. IN LINE "Y" S SHALL BE USED ON LINES TWELVE INCHES (12") OR ABOVE.
7. WATER MAINS SHALL BE PROTECTED IN ACCORDANCE WITH LVVWD STANDARDS WHENEVER A SEWER MAIN CROSSES OVER A WATER MAIN OR THE SEWER IS LESS THAN EIGHTEEN INCH (18") UNDER A WATER MAIN.
8. ALL CONTRACTORS INSTALLING SEWER MAINS THAT WILL BE UNDER THE JURISDICTION OF THE CITY OF LAS VEGAS MUST BE STATE OF NEVADA CLASS "A" CONTRACTORS.
9. THE CITY OF LAS VEGAS WILL NOT ACCEPT ANY SEWER MAINS WHICH HAVE A VERTICAL DEFLECTION OF MORE THAN ONE TENTH (0.1) OF A FOOT FROM THE APPROVED CONSTRUCTION PLANS AT ANY LOCATION. SEWER MAINS FOUND TO EXCEED THIS TOLERANCE WILL HAVE TO BE REPAIRED OR REMOVED OR REPLACED TO THE SATISFACTION OF THE CITY ENGINEER PRIOR TO ACCEPTANCE BY THE CITY OF LAS VEGAS.
10. INSTALLATION OF CURVED SEWER REQUIRES THE USE OF C-900 PIPE WHICH ALLOWS FOR PIPE DEFLECTION AT THE JOINTS.

REVISED 04/15/10

CITY OF LAS VEGAS FIRE DEPARTMENT NOTES

1. ALL WORK SHALL BE DONE IN STRICT ACCORDANCE WITH THE LAS VEGAS FIRE & RESCUE ADOPTED FIRE CODE ORDINANCE #6325 FOR HYDRANT SPECIFICATIONS AND HYDRANT INSTALLATION SPECIFICATIONS.
2. ONLY FIRE HYDRANTS THAT ARE ON THE LAS VEGAS VALLEY WATER DISTRICT'S - APPROVED PRODUCTS LIST ARE ALLOWED TO BE INSTALLED.
3. A PERMIT IS REQUIRED FROM LAS VEGAS FIRE & RESCUE FOR THE INSTALLATION OF ON-SITE WATER LINES AND FIRE HYDRANTS. THE PERMIT AND CONTRACTORS MATERIAL TEST CERTIFICATE FOR UNDERGROUND PIPING FORM SHALL BE OBTAINED FROM THE FIRE PROTECTION ENGINEER BEFORE COMMENCEMENT OF WORK. [IFC § 507.1.2]
4. ON ANY RESIDENTIAL OR COMMERCIAL INSTALLATIONS, FIRE HYDRANTS SHALL BE INSTALLED AND FIRE APPARATUS ACCESS ROADS SHALL BE MAINTAINED BEFORE COMMENCEMENT OF ANY COMBUSTIBLE CONSTRUCTION. ALL FIRE HYDRANTS SHALL BE IN GOOD WORKING ORDER AND SHALL BE CAPABLE OF DELIVERING THE REQUIRED FIRE FLOW. [IFC § 3310, § 3312]
5. TO IDENTIFY THE FIRE HYDRANT LOCATIONS, THE CONTRACTOR SHALL PLACE A BLUE REFLECTIVE MARKER AT THE CENTER LINE OF STREET ADJACENT TO THE FIRE HYDRANTS. [IFC § 507.5.7.3]
6. ALL UNDERGROUND INSPECTIONS, PRESSURE AND FLUSH VERIFICATIONS OF ALL FIRE HYDRANTS AND FIRE LINES, SHALL BE CONDUCTED BEFORE COVERING THE LINES. CENTER LOADING IS ACCEPTABLE FOR THE HYDRO TESTS WITH PRIOR FIRE PREVENTION APPROVAL. [IFC § 106.3]
7. ALL ON-SITE UNDERGROUND WATER MAINS AND MATERIALS SHALL BE U.L. LISTED A.W.W.A. APPROVED AND SHALL BE RATED FOR THE APPROPRIATE WORKING PRESSURE. [IFC § 507.2.1, NFPA 24]
8. PAINTING OF CURBS, FIRE HYDRANTS, PADS, PROTECTION OF FIRE HYDRANTS FROM PHYSICAL DAMAGE, AND ALL OTHER WORK NECESSARY PER PLANS SHALL BE COMPLETED BEFORE APPROVAL BY LAS VEGAS FIRE AND RESCUE, FIRE PREVENTION DIVISION. [IFC § 507]
9. PRIVATE HYDRANTS SHALL BE PAINTED RED. [IFC § 507.5.7.1]
10. PRIOR TO THE FINAL OCCUPANCY, A FIRE FLOW TEST SHALL BE WITNESSED BY LAS VEGAS FIRE AND RESCUE, FIRE PREVENTION DIVISION TO VERIFY AVAILABILITY OF THE REQUIRED FIRE FLOW. [IFC § 507]
11. FIRE HYDRANT SPACING SHALL BE AS FOLLOWS: [IFC § C102]

	RESIDENTIAL	COMMERCIAL
500 FEET UNSPRINKLERED; 600 FEET SPRINKLERED.		
300 FEET UNSPRINKLERED; 400 FEET SPRINKLERED.		
12. WHERE THE WATER MAINS ARE EXTENDED ALONG STREETS OR NEW STREETS ARE INSTALLED WHERE FIRE HYDRANTS ARE NOT NEEDED FOR PROTECTION OF STRUCTURES, FIRE HYDRANTS SHALL BE INSTALLED AT A MAXIMUM OF 1000 FT SPACING, TO PROVIDE FOR TRANSPORTATION HAZARDS. WHERE STREETS ARE PROVIDED WITH MEDIAN DIVIDERS OR HAVE FOUR (4) OR MORE TRAFFIC LANES AND HAVE A TRAFFIC COUNT OF MORE THAN 30,000 PER DAY, HYDRANTS ARE REQUIRED ON EACH SIDE OF THE STREET SPACED AT 500 FT ON AN ALTERNATING BASIS. [IFC § C102.8]
13. NO FIRE HYDRANTS SHALL BE LOCATED WITHIN THE RADIUS OF A CUL-DE-SAC OR WITHIN 20 FT OF THE PERIMETER OF THE RADIUS OF THE CUL-DE-SAC.
14. NO FIRE HYDRANTS SHALL BE LOCATED WITHIN 6 FT OF ANY CURB RETURN, DRIVEWAY, POWER POLE, STREETLIGHT OR ANY OTHER OBSTRUCTION. [IFC § C102.12]
15. A MAXIMUM DISTANCE FROM A FIRE HYDRANT TO A ONE-TWO-FAMILY DWELLING SHALL NOT EXCEED 300 FT, AS MEASURED BY AN APPROVED ROUTE. [IFC § C102.4]
16. THE MAXIMUM DISTANCE FROM A FIRE HYDRANT TO A FIRE DEPARTMENT CONNECTION (FDC) SHALL NOT EXCEED 100 FT, AS MEASURED BY AN APPROVED ROUTE. [IFC § C102.7]
17. THE MAXIMUM DISTANCE FROM A HYDRANT TO THE END OF A DEAD-END STREET SHALL NOT EXCEED 200 FT. [IFC § C102.6]
18. TWO (2) SOURCES OF SUPPLY ARE REQUIRED WHENEVER THERE IS 4 OR MORE FIRE HYDRANTS/SPRINKLER LEADS ARE INSTALLED ON A SINGLE SYSTEM. SECTIONAL CONTROL VALVES SHALL BE INSTALLED SO THAT NO MORE THAN 2 FIRE HYDRANTS CAN BE OUT OF SERVICE DUE TO A BREAK IN A WATER MAIN. [IFC § C104]
19. ALL FIRE APPARATUS ACCESS ROADS SHALL BE PAVED TO PROVIDE ALL-WEATHER DRIVING CAPABILITIES, AND SHALL BE DESIGNED AND MAINTAINED TO SUPPORT THE IMPOSED LOADS OF THE FIRE APPARATUS. [IFC § 503.2.3]
20. THE GRADIENT FOR THE FIRE APPARATUS ROADS SHALL NOT EXCEED 12% ANGLES OF APPROACH AND ANGLES OF DEPARTURE SHALL NOT EXCEED 6% FOR 25 FT PRIOR TO OR AFTER THE GRADE CHANGE. ADJACENT TO THE STRUCTURES GRADIENT SHALL NOT EXCEED 6%. [IFC § 503.2.7, § 503.2.8]
21. THE TURNING RADIUS OF THE FIRE APPARATUS ACCESS ROADS SHALL BE NO LESS THAN 52 FT OUTSIDE AND 28 FT INSIDE TURNING RADIUS. [IFC § 503.2.4]
22. VERTICAL CLEARANCE OF ALL FIRE APPARATUS ACCESS ROADS SHALL NOT BE LESS THAN 13 FT 6 INS. [IFC § 503.2.1]
23. FIRE DEPARTMENT ACCESS ROADS SHALL HAVE A MINIMUM UNOBSTRUCTED WIDTH OF NOT LESS THAN 40 FT FLOW LINE TO FLOW LINE WITH PARALLEL PARKING PERMITTED ON BOTH SIDES. NOT LESS THAN 32 FT WIDE, FLOW-LINE TO FLOW-LINE, WHERE PARKING IS PERMITTED ONLY ON ONE SIDE OF THE FIRE APPARATUS ACCESS ROAD, NOT LESS THAN 24 FT WIDE, FLOW-LINE TO FLOW-LINE, WHERE NO PARKING IS PERMITTED ON EITHER SIDE. FIRE LINES THROUGH PARKING LOTS SHALL NOT BE LESS THAN 24 FT. [IFC § 503.2.1.1]
24. FIRE APPARATUS ACCESS ROAD SHALL BE REQUIRED WHEN ANY PORTION OF AN EXTERIOR WALL OF THE FIRST STORY IS LOCATED MORE THAN 150 FT FROM A FIRE DEPARTMENT VEHICLE ACCESS. THIS DISTANCE COULD BE INCREASED TO 250 FT IF THE BUILDING IS SPRINKLERED. [IFC § 503.1.1]
25. APPROVED SECONDARY FIRE APPARATUS ACCESS SHALL BE PROVIDED FOR 100 OR MORE DWELLING UNITS, ROAD(S) WITH DEAD-ENDS OR WITH A SINGLE POINT OF ACCESS IN EXCESS OF 600 FT. COMMERCIAL AND INDUSTRIAL DEVELOPMENTS WHERE BUILDINGS EXCEED 2 STORIES OR 30 FT IN HEIGHT, OR EXCEEDING 62,000 SQ FT IN AREA. [IFC § 503.1.2]
26. ALL DEAD-END FIRE APPARATUS ROADS AND/OR FIRE LINES, PUBLIC OR PRIVATE, IN EXCESS OF 150 FT IN LENGTH SHALL BE PROVIDED WITH AN APPROVED TURN AROUND HAVING A MINIMUM DIAMETER OF 81 FT. [IFC § 503.2.5]
27. ALL FIRE APPARATUS ACCESS ROADS SHALL BE MARKED BY PLACING APPROVED SIGNS AT THE START OF THE DESIGNATED FIRE LANE, ONE SIGN AT THE END OF THE FIRE LANE AND WITH SIGNS AT INTERVALS OF 100 FT ALONG THE DESIGNATED FIRE LINES. SIGNS TO BE PLACED ON BOTH SIDES OF AN ACCESS ROADWAY IF NEEDED TO PREVENT PARKING ON EITHER SIDE. SIGNS TO BE INSTALLED NO HIGHER THAN 10 FT OR LESS THAN 6 FT FROM THE ROADWAY LEVEL. THE CURB ALONG OR ON THE PAVEMENT OR CEMENT (IF NO CURB IS PROVIDED) SHALL BE PAINTED WITH RED WEATHER RESISTANT PAINT IN ADDITION TO THE SIGNS. [IFC § 503.3]
28. ELECTRONICALLY CONTROLLED ACCESS GATES SHALL BE PROVIDED WITH AN APPROVED EMERGENCY VEHICLE DETECTOR/RECEIVER SYSTEM. SAID SYSTEM SHALL BE INSTALLED IN ACCORDANCE WITH THE IFC § 503.6 AND IFC APPENDIX M.

EFFECTIVE DATE 03-01-2016

DEVIATIONS FROM STANDARDS

NONE.

CITY OF LAS VEGAS GENERAL NOTES

1. ALL CONSTRUCTION AND MATERIALS SHALL BE IN ACCORDANCE WITH THE UNIFORM STANDARD SPECIFICATIONS FOR PUBLIC WORKS CONSTRUCTION OFF-SITE IMPROVEMENTS, CLARK COUNTY AREA NEVADA; LATEST REVISION (USS), THE UNIFORM STANDARD DRAWINGS FOR PUBLIC WORKS CONSTRUCTION, CLARK COUNTY AREA NEVADA; LATEST REVISION EDITION; THE "SUMMERLIN IMPROVEMENT STANDARDS" FOR WORK IN THE SUMMERLIN AREA; AND OTHER APPLICABLE APPROVED STANDARDS ISSUED BY THE CONTROLLING AGENCY, THE UNIFORM BUILDING CODE; AND ALL LOCAL CITY CODES AND ORDINANCES APPLICABLE, EXCEPT AS NOTED ON THIS SHEET AS DEVIATIONS FROM STANDARDS.
2. THE EXISTENCE AND LOCATION OF ANY OVERHEAD OR UNDERGROUND UTILITY LINES, PIPES, OR STRUCTURES SHOWN ON THESE PLANS ARE OBTAINED BY A RESEARCH OF THE AVAILABLE RECORDS. EXISTING UTILITIES AS SHOWN FROM CLV PLANS LIBRARY ARE APPROXIMATE AND FOR RECORD PURPOSES. EXISTING UTILITIES ARE LOCATED ON PLANS ONLY FOR THE CONVENIENCE OF THE CONTRACTOR. EXISTING UTILITY SERVICE LATERALS MAY NOT BE SHOWN ON THE PLANS. THE CONTRACTOR SHALL, AT HIS OWN EXPENSE, LOCATE ALL UNDERGROUND AND OVERHEAD INTERFERENCES WHICH MAY AFFECT HIS OPERATION DURING CONSTRUCTION AND SHALL TAKE ALL NECESSARY PRECAUTIONS TO AVOID DAMAGE TO SAME. THE CONTRACTOR SHALL USE EXTREME CAUTION WHEN WORKING NEAR OVERHEAD UTILITIES SO AS TO SAFELY PROTECT ALL PERSONNEL AND EQUIPMENT, AND SHALL BE RESPONSIBLE FOR ALL COST AND LIABILITY IN CONNECTION THEREWITH.
3. THE CONTRACTOR SHALL TAKE ALL PRECAUTIONARY MEASURES NECESSARY TO PROTECT EXISTING UTILITY LINES, STRUCTURES AND STREET IMPROVEMENTS WHICH ARE TO REMAIN IN PLACE, FROM DAMAGE, AND ALL SUCH IMPROVEMENTS OR STRUCTURES DAMAGED BY THE CONTRACTOR'S OPERATIONS SHALL BE REPAIRED OR REPLACED SATISFACTORY TO THE CITY ENGINEER AND OWNING ENTITY COMPANY AT THE EXPENSE OF THE CONTRACTOR.
4. ALL CONSTRUCTION SHALL BE AS SHOWN ON THESE PLANS. ANY REVISIONS SHALL HAVE THE PRIOR WRITTEN APPROVAL OF THE CITY ENGINEER.
5. TYPE V CEMENT SHALL BE USED IN ALL OFF-SITE CONCRETE WORK. CONCRETE TO BE 3000 P.S.I. MINIMUM @ 28 DAYS. MIX DESIGNS TO BE APPROVED BY THE CITY, PRIOR TO THE USE ON THE PROJECT.
6. PERMITS ARE REQUIRED FOR ANY WORK IN THE PUBLIC RIGHT-OF-WAY. THE CONTRACTOR SHALL SECURE ALL PERMITS AND INSPECTIONS REQUIRED FOR THIS CONSTRUCTION.
7. EXPANSION JOINTS REQUIRED, MAXIMUM EVERY 300' IN EXTRUDED-TYPE CURB.
8. AC PAVEMENT TO BE ONE-HALF INCH (1/2") ABOVE LIP OF ALL GUTTERS AFTER COMPACTION, EXCEPT AT SIDEWALK RAMPS AND CROSS GUTTERS.
9. CURB AND GUTTER FOUND TO BE UNACCEPTABLE TO THE CITY OF LAS VEGAS SHALL BE REMOVED AND REPAIRED PER STANDARD DRAWING 216.
10. SIDEWALK RAMPS SHALL BE CONSTRUCTED IN EACH QUADRANT OF AN INTERSECTION PER STANDARD DRAWING 235. EXACT LOCATION OF RAMPS MAY BE ADJUSTED IN THE FIELD BY A CITY INSPECTOR.
11. CONTRACTOR SHALL PROVIDE ALL NECESSARY HORIZONTAL AND VERTICAL TRANSITIONS BETWEEN NEW CONSTRUCTION AND EXISTING SURFACES TO PROVIDE FOR PROPER DRAINAGE AND FOR INGRESS AND EGRESS TO NEW CONSTRUCTION. THE EXTENT OF THE TRANSITIONS TO BE AS SHOWN ON PLANS.
12. ALL GRADING WORK SHALL CONFORM TO THE SOILS REPORT AS PREPARED BY THE (COMPANY , - REPORT #, DATE) APPROVED BY THE CITY ENGINEER, AND AS SHOWN ON THESE PLANS.
13. EXACT LOCATION OF ALL SAWCUT LINES MAY BE ADJUSTED OR DETERMINED IN THE FIELD BY A CITY OF LAS VEGAS ENGINEER IF LOCATION ON PLANS IS NOT CLEARLY SHOWN, OR EXISTING PAVEMENT CONDITION REQUIRES RELOCATIONS.
14. THE CONTRACTOR SHALL TAKE ALL PRECAUTIONS NECESSARY TO PROTECT EXISTING PERMANENT SURVEY MONUMENTS. ANY MONUMENTS DISTURBED SHALL BE REPLACED AND ADJUSTED PER AVAILABLE RECORDS IN ACCORDANCE WITH N.R.S. STATUTE NO. 625.380 & CITY OF LAS VEGAS TITLE 18, APPENDIX D.
15. UTILITY COMPANY METER BOXES, MANHOLE LIDS, VALVE COVERS, ETC., SHALL BE LOCATED OUT OF DRIVEWAYS, DRIVEWAY APRONS, FLOWLINES, AND CROSS GUTTERS UNLESS WRITTEN APPROVAL IS GRANTED BY THE UTILITY COMPANY AND THE CITY ENGINEER.
16. WALL NOTES:
 16. ALL WALLS, NEW OR EXISTING, ARE ONLY SHOWN ON CIVIL PLANS FOR THE PURPOSE OF REVIEWING GRADING RELATIONSHIPS, FLOOD CONTROL AND SIGHT DISTANCE AT INTERSECTIONS. NEW WALLS REQUIRE A SEPARATE PERMIT AND INSPECTION BY THE BUILDING DEPARTMENT.
 17. ASPHALT MIX DESIGN MUST BE SUBMITTED AND APPROVED BY THE CITY ENGINEER PRIOR TO THE PLACEMENT OF ASPHALT WITHIN CITY RIGHT OF WAY.
 18. CONTRACTOR SHALL ADJUST ALL NEW AND EXISTING INLETS, VALVE BOXES, MANHOLE RIMS, AND SEWER CLEAN OUTS, ETC. TO FINISH GRADE AS APPLICABLE WHETHER OR NOT THEY ARE SHOWN ON THE PLANS.
 19. MATERIALS, HANDLING AND PLACEMENT OF PORTLAND CEMENT CONCRETE SHALL BE IN ACCORDANCE WITH APPLICABLE SECTIONS OF MOOT OR THE CLARK COUNTY AREA SPECIFICATIONS (AS APPLICABLE) AND THE PLANS AND DETAILS SHOWN HEREON.
 20. WHEN INSTALLING UNDERGROUND FACILITIES THAT REQUIRE UNDERGROUND LOCATING DEVICES SUCH AS MARKER BALLS, LOCATING RIBBON, ETC. THE CONTRACTOR SHALL PROVIDE WRITTEN DOCUMENTATION TO OFFSITE INSPECTION AND TESTING CERTIFYING THAT ALL DEVICES HAVE BEEN PLACED AND VERIFIED TO BE IN GOOD WORKING CONDITION PRIOR TO THE CONSTRUCTION OF ANY ROAD BASE.
 21. AFTER HAUNCHING AND PRIOR TO BACKFILL OPERATIONS WHICH WOULD COVER SANITARY SEWER AND STORM DRAIN FACILITIES, CONTRACTOR IS REQUIRED TO SCHEDULE CLV OPEN-TRENCH UTILITY SURVEY INSPECTION FOR DETERMINATION OF FINAL LOCATION COORDINATES. FACILITIES TO BE LOCATED BY CLV SHALL INCLUDE AT A MINIMUM THE HORIZONTAL AND VERTICAL (INVERT) LOCATION OF PUBLIC SEWER MANHOLES, STORM DRAIN MANHOLES, AND TRANSITION STRUCTURES. STORM DRAIN LATERALS AT THE CONNECTION TO THE STORM DRAIN MAIN AND AT THE CONNECTION TO A DROP INLET, THE CONNECTION OF SEWER SERVICE LATERALS TO THE SEWER MAIN AND WHERE THE SEWER SERVICE LATERALS EXIT THE PUBLIC RIGHT-OF-WAY, SEWER AND STORM DRAIN MAIN ALIGNMENT, INCLUDING DEFLECTION POINTS.
 22. CCTV VIDEO INSPECTION IS REQUIRED FOR ALL SEWER AND STORM DRAINS. THE CCTV VIDEO INSPECTIONS NEED TO BE PERFORMED PER THE DESIGN AND CONSTRUCTION STANDARDS FOR WASTEWATER COLLECTION SYSTEMS LATEST EDITION.
 23. A SEPARATE BORING PERMIT IS REQUIRED FOR ALL BORING ACTIVITIES.

REVISED 06/04/2018

SOUTHERN NEVADA - SOUTHWEST GAS CORPORATION GENERAL NOTES:

1. IN THE EVENT OF NATURAL GAS EMERGENCIES CALL 911 AND 1-877-860-6020.
2. THERE SHALL BE A MINIMUM HORIZONTAL AND VERTICAL CLEARANCE OF 12-INCHES BETWEEN NATURAL GAS FACILITIES AND ANY UNDERGROUND FACILITIES AND/OR STRUCTURES INCLUDING BUT NOT LIMITED TO WATER, SEWER, STORM DRAIN, COMMUNICATIONS, AND ELECTRIC.
3. FOR VALVE ADJUSTMENT CONTACT 702-668-6107 48 HOURS PRIOR TO CONSTRUCTION.
4. IN THE EVENT OF A NATURAL GAS CONFLICT WITH PROPOSED UTILITIES AND/OR STRUCTURES CONTACT 702-365-2099.

ALL CIVIL IMPROVEMENT PLANS MUST INCLUDE SOUTHWEST GAS CORPORATION HIGH PRESSURE NOTES ON THE NOTES SHEET AND ALL SHEETS DEPICTING HIGH PRESSURE NATURAL GAS MAINS AS INDICATED BELOW.

CAUTION: HIGH PRESSURE GAS!!
CALL SOUTHWEST GAS AT 702-400-1789 FOR STANBY
WHEN EXCAVATING OVER OR NEAR HIGH PRESSURE GAS
LINES 48 HOURS PRIOR TO CONSTRUCTION.

CITY OF LAS VEGAS TRAFFIC NOTES

1. ALL CONSTRUCTION SIGNING, BARRICADING, AND TRAFFIC DELINEATION SHALL CONFORM TO THE "MANUAL ON UNIFORM TRAFFIC CONTROL DEVICES", LATEST EDITION.
2. THE STREET SIGN CONTRACTOR SHALL OBTAIN STREET NAMES AND BLOCK NUMBERING FROM THE PLANNING DEPARTMENT PRIOR TO CONSTRUCTION.
3. BEFORE ANY WORK IS STARTED IN THE RIGHT-OF-WAY, THE CONTRACTOR SHALL INSTALL ALL ADVANCE WARNING SIGNS FOR THE CONSTRUCTION ZONE. THE CONTRACTOR SHALL INSTALL TEMPORARY STOP SIGNS AT ALL NEW STREET ENCROACHMENTS INTO EXISTING CITY STREETS WHERE WARRANTED IMMEDIATELY AFTER FIRST GRADING WORK IS ACCOMPLISHED, AND SHALL MAINTAIN SAID SIGNS UNTIL PERMANENT SIGNS ARE INSTALLED.
4. WHEN A DESIGNATED "SUGGESTED ROUTE TO SCHOOL" IS ENCLOSED UPON BY A CONSTRUCTION WORK ZONE AND PUBLIC WORKS STAFF IDENTIFIES A NEED FOR STUDENTS TO BE ASSISTED IN THE SAFE CROSSING THROUGH THAT WORK ZONE, THE CONTRACTOR SHALL BE REQUIRED TO PROVIDE A QUALIFIED "CROSSING GUARD". THE GUARD SHALL BE PRESENT FOR THE FULL DURATION OF TIME THAT CHILDREN ARE LIKELY TO BE PRESENT.
5. IF THE IMPROVEMENTS NECESSITATE THE OBLITERATION, TEMPORARY OBSTRUCTION, TEMPORARY REMOVAL OR RELOCATION OF ANY EXISTING TRAFFIC PAVEMENT MARKING, SUCH PAVEMENT MARKING SHALL BE RESTORED OR REPLACED WITH LIKE MATERIALS TO THE SATISFACTION OF THE CITY TRAFFIC ENGINEER.
6. THE CONTRACTOR SHALL BE RESPONSIBLE FOR PROVIDING AND INSTALLING ALL PERMANENT SIGNS SHOWN ON THE PLANS. THE CONTRACTOR SHALL BE RESPONSIBLE FOR THE SAFETY OF THE STREETWORK. THE CONTRACTOR SHALL HAVE IN ACCORDANCE WITH CCAUSS 627 AND 716 AND SHALL HAVE AN ANTI-GRAFFITI PROTECTIVE OVERLAY FILM THAT IS A MATCHING COMPONENT TO, AND OF THE SAME MANUFACTURER AS RETROREFLECTIVE SHEETING TO WHICH IT IS APPLIED. STREET NAME SIGNS SHALL CONFORM IN THEIR ENTIRETY TO CURRENT CITY STANDARDS. ALL OTHER SIGNS SHALL BE STANDARD SIZE UNLESS OTHERWISE SPECIFIED ON THE PLANS. ALL SIGN POSTS SHALL BE INSTALLED IN ACCORDANCE WITH THE CURRENT CITY STANDARDS.
7. WHEN A PROPOSED STREET LIGHT STANDARD IS LOCATED WITHIN FIVE (5') FEET OF ANY PROPOSED SIGN SHOWN ON THE PLANS TO BE REMOVED OR A SIGNPOST, THE SIGN SHALL BE MOUNTED ON THE STREET LIGHT STANDARD AND THE SIGNPOST SHALL BE ELIMINATED.
8. ALL PERMANENT TRAFFIC CONTROL DEVICES CALLED FOR HEREON SHALL BE IN PLACE AND IN FINAL POSITION PRIOR TO ALLOWING ANY PUBLIC TRAFFIC ONTO THE PORTIONS OF THE ROAD(S) BEING IMPROVED HERE UNDER, REGARDLESS OF THE STATUS OF COMPLETION OF PAVING OR OTHER OFF-SITE IMPROVEMENTS CALLED FOR BY THESE PLANS.
9. STREET SIGNS AND STOP SIGNS SHALL BE INSTALLED PER CITY STANDARD SPECIFICATIONS FOR PLACEMENT OF STREET NAME SIGNS.
10. THE CONTRACTOR SHALL PROVIDE ALL NECESSARY TRAFFIC CONTROL DEVICES AND FLAGGERS TO INSURE THE SAFETY OF THE PUBLIC IN OR AROUND THE WORK AREA. THE CONTRACTOR SHALL HAVE A CERTIFIED ATISSA TRAFFIC CONTROL TECHNICIAN OR ISMA WORK ZONE SAFETY SPECIALIST SET UP, MAINTAIN AND/OR REMOVE ALL TRAFFIC CONTROL DEVICES IN THE CITY OF LAS VEGAS RIGHT OF WAY.
11. WORK IN PUBLIC STREETS, ONCE BEGUN, SHALL BE EXPEDITED TO COMPLETION SO AS TO PROVIDE MINIMUM INCONVENIENCE TO ADJACENT PROPERTY OWNERS AND TO THE TRAVELING PUBLIC.
12. THE CONTRACTOR SHALL BE RESPONSIBLE FOR NOTIFYING REGIONAL TRANSPORTATION COMMISSION OF SOUTHERN NEVADA (RTC). IF THE CONSTRUCTION INTERRUPTS OR RELOCATES A BUS STOP OR HAS AN ADVERSE EFFECT ON BUS SERVICE ON THAT STREET TO ARRANGE FOR TEMPORARY RELOCATION OF STOP.
13. GUARDS SHALL BE OBTAINED BY CONTACTING THE METROPOLITAN POLICE DEPARTMENT SPECIAL EVENTS UNIT (PHONE # 828-3442) WHO WILL PROVIDE OFFICERS PROPERLY TRAINED IN TRAFFIC CONTROL. FEES FOR THE USE OF THESE OFFICERS SHALL BE SET BY METRO AND WILL BE PAID BY THE CONTRACTOR. THE CONTRACTOR IS RESPONSIBLE FOR ALL ARRANGEMENTS WITH METRO.
14. ANY WORK WITHIN 300' OF A SIGNALIZED INTERSECTION WILL BE NIGHT WORK, UNLESS OTHERWISE DIRECTED BY THE CITY OF LAS VEGAS TRAFFIC ENGINEER.
15. THE CONTRACTOR SHALL CONTACT THE TRAFFIC ENGINEERING DIVISION (TRANSPORTATION SECTION) THROUGH THE PROJECT'S OFFSITE INSPECTOR PRIOR TO INITIATING PAVING TO RECEIVE DIRECTION FOR ALL PERMANENT OR TEMPORARY MODIFICATIONS TO THE APPROVED DRAWINGS REGARDING FINAL PAVEMENT TRANSITIONS, MARKINGS AND SIGNING THAT ARE REQUIRED TO MATCH ADJACENT ROADWAY SEGMENTS. THE CONTRACTOR SHALL PROVIDE A DRAWING FOR APPROVAL BY THE TRAFFIC ENGINEERING DIVISION. THE DRAWING SHALL BE SUBMITTED TO THE MARKINGS AND SIGNAGE, WHICH MAY INCLUDE OMITTING, ADDING OR MODIFYING PAVEMENT MARKINGS AND TRAFFIC CONTROL SIGNS SUCH THAT ADEQUATE TRANSITIONS AND LANE TERMINATIONS BETWEEN ADJACENT ROADWAY SEGMENTS ARE CONSTRUCTED.

REVISED 06/04/2018

LAS VEGAS VALLEY WATER DISTRICT NOTES

LVVWD PROJECT # 125851

1. NO WORK SHALL BEGIN UNTIL THE WATER PLANS HAVE BEEN APPROVED FOR CONSTRUCTION BY THE LVVWD. FOLLOWING WATER PLAN APPROVAL, NOTICE SHALL BE GIVEN TO THE LVVWD COMMUNICATION SUPPORT CENTER (258-7171) TWO (2) WORKING DAYS PRIOR TO THE START OF CONSTRUCTION. THE LVVWD WILL CONDUCT VISUAL INSPECTIONS. IF THE LVVWD BUSINESS DAY PRIOR TO THE REQUESTED LVVWD INSPECTION, WHEN REQUESTING INSPECTIONS, PLEASE REFER TO THE PROJECT # IDENTIFIED ABOVE.
2. ALL WORK SHALL CONFORM TO THE LVVWD STANDARD PLATES, DRAWINGS, AND SPECIFICATIONS, AND TO THE 2010 EDITION OF THE UNIFORM DESIGN AND CONSTRUCTION STANDARDS FOR POTABLE WATER SYSTEMS (UDACS). THE LATEST EDITION OF UDACS SHALL SUPERSEDE ANY CONFLICTS CONTAINED IN THE APPROVED DRAWINGS AND/OR SPECIFICATIONS.
3. ALL WORK, EXCEPT AS MODIFIED BY THESE PLANS OR BY NOTE 2 ABOVE, SHALL BE DONE IN ACCORDANCE WITH THE LATEST DRAFT OR EDITION OF THE UNIFORM STANDARD SPECIFICATIONS FOR PUBLIC WORKS CONSTRUCTION OFF-SITE IMPROVEMENT, CLARK COUNTY AREA.
4. A SINGLE PIPE MATERIAL SHALL BE USED THROUGHOUT THE PROJECT UNLESS OTHERWISE APPROVED BY THE LVVWD.
5. ALL SERVICE LATERALS TWO (2) INCHES IN DIAMETER AND SMALLER SHALL BE TYPE K COPPER TUBING WITH LVVWD APPROVED SERVICE SADDLES.
6. ALL WATER METER BOXES SHALL BE LOCATED OUTSIDE OF DRIVEWAY AREAS.
7. ALL VALVES SHALL BE LOCATED OUTSIDE OF DRIVEWAYS, VALLEY AND CURB GUTTERS.
8. ALL WATER AND STORM DRAIN OR SANITARY SEWER CROSSINGS SHALL CONFORM TO SECTION 2.22 OF THE 2010 EDITION OF THE UDACS.
9. ALL WATER FACILITIES SHALL BE FILLED, DISINFECTED, PRESSURE TESTED, FLUSHED, FILLED, AND AN ACCEPTABLE WATER SAMPLE OBTAINED, PRIOR TO CONNECTION TO THE LVVWD DISTRIBUTION SYSTEM.
10. THE CONTRACTOR MUST OBTAIN ALL METERS TWO (2) INCHES AND SMALLER FROM LVVWD CENTRAL STORES. TELEPHONE 258-3152 OR 258-3802, TWO (2) WORKING DAYS PRIOR TO METER PICKUP.
11. ANY INTERRUPTION OF SERVICE MUST BE PERFORMED IN ACCORDANCE WITH U.D.A.C.S. SECTION 3.14.01, AND APPROVED BY THE LVVWD INSPECTION DIVISION PRIOR TO SHUTDOWN. PROPER WRITTEN NOTIFICATION MUST BE GIVEN TO ALL AFFECTED CUSTOMERS.
12. ALL WATER FACILITY CONSTRUCTION MATERIALS USED MUST BE AS LISTED ON THE LVVWD PRE-APPROVED MATERIALS AND MANUFACTURER'S LISTING FOR NEW FACILITIES, LATEST REVISION, OR SPECIFICALLY APPROVED ON THESE PLANS.
13. TELEPHONE "CALL BEFORE YOU DIG" AT "811" OR 1-800-227-2600.
14. THE INSTALLATION OF LAS VEGAS VALLEY WATER DISTRICT (LVVWD) MUNICIPAL WATER FACILITIES WITHIN ALL STREETS IS ASSUMED TO BE IN COMPLIANCE WITH THE UNIFORM STANDARD SPECIFICATIONS FOR PUBLIC WORKS CONSTRUCTION OFF-SITE IMPROVEMENTS, CLARK COUNTY AREA, NEVADA; LATEST REVISION (USS), THE UNIFORM STANDARD DRAWINGS FOR PUBLIC WORKS CONSTRUCTION, CLARK COUNTY AREA NEVADA; LATEST REVISION EDITION; THE "SUMMERLIN IMPROVEMENT STANDARDS" FOR WORK IN THE SUMMERLIN AREA; AND OTHER APPLICABLE APPROVED STANDARDS ISSUED BY THE CONTROLLING AGENCY, THE UNIFORM BUILDING CODE; AND ALL LOCAL CITY CODES AND ORDINANCES APPLICABLE, EXCEPT AS NOTED ON THIS SHEET AS DEVIATIONS FROM STANDARDS.

ANY DECORATIVE PAVING SURFACE WITHIN THE STREET IS THE RESPONSIBILITY OF THE OWNER'S ASSOCIATION, OR THE INDIVIDUAL PROPERTY OWNERS IF NO OWNER'S ASSOCIATION IS IN EXISTENCE, OR THE AGENCY HAVING JURISDICTION. DECORATIVE SURFACE MATERIALS PLACED WITHIN THE TEN FOOT EASEMENT ABUTTING A PUBLIC OR PRIVATE STREET, IF DISTURBED BY THE LVVWD DURING THE REPAIR OR OPERATION OF ITS FACILITIES, WILL BE REPLACED BY LVVWD WITH AN APPROPRIATELY SIZED PLANT FINISH CONCRETE PATCH. THE LVVWD WILL NOT RESTORE, AND WILL NOT BE RESPONSIBLE FOR THE RESTORATION OF ANY DECORATIVE PAVING SURFACE WITHIN THE STREET. THE LVVWD WILL NOT ATTEMPT TO MATCH COLOR OR FINISH OF ANY ADJACENT MATERIALS.

APPROVED FOR CONSTRUCTION


James W. Shadler
LAS VEGAS VALLEY WATER DISTRICT ENGINEERING SERVICES
PROJECT NO. 125851 FIRST APPROVED DATE: 12-17-18

QUANTITIES

DESCRIPTION	PUBLIC QUANTITY	PRIVATE QUANTITY
3-INCH ASPHALT CONCRETE PAVING	41 SY	SY
TYPE II GRAVEL	5 CY	CY
CURB AND GUTTER "L" CURB	8 LF	845 LF
CONCRETE VALLEY GUTTER	SF	2014 SF
4-INCH CONCRETE SIDEWALK	40 SF	9395 SF
6-INCH SEWER	LF	87 LF
2-INCH WATER COPPER	8 LF	LF
3-INCH WATER MAIN	LF	318 LF
6-INCH WATER MAIN	16 LF	316 LF
8-INCH WATER MAIN	71 LF	232 LF
10-INCH WATER MAIN	LF	311 LF
FIRE HYDRANT ASSEMBLY	EA	1 EA
FIRE HYDRANT RELOCATION	EA	1 EA
FIRE DEPARTMENT CONNECTION	EA	1 EA
8-INCH RPDA	1 EA	EA
8-INCH TAPPING TEE & VALVE	1 EA	EA
6-INCH GATE VALVE	EA	1 EA
8-INCH GATE VALVE	1 EA	EA
3-INCH 11.25' BEND	EA	1 EA
3-INCH 90° BEND	EA	1 EA
6-INCH 22.5' BEND	EA	1 EA
6-INCH 45° BEND	EA	1 EA
8-INCH 90° BEND	EA	1 EA
10-INCH 11.25' BEND	EA	1 EA
10-INCH 90° BEND	EA	1 EA
10-INCH TEE	EA	1 EA
POWER SERVICE TO LOTS	EA	1 EA
SIDEWALK UNDERDRAIN	EA	1 EA
10" X 8" REDUCER	EA	1 EA
COMMERCIAL DRIVEWAY	EA	1 EA
2" WATER METER & 2" RPDA	2 EA	EA
SIGNS	EA	19 EA

NOTE: THIS QUANTITY ESTIMATE IS FOR BONDING PURPOSES ONLY. CONTRACTOR TO DETERMINE INDEPENDENT ESTIMATIONS.

REVISIONS:		
REV.	DESCRIPTION	DATE

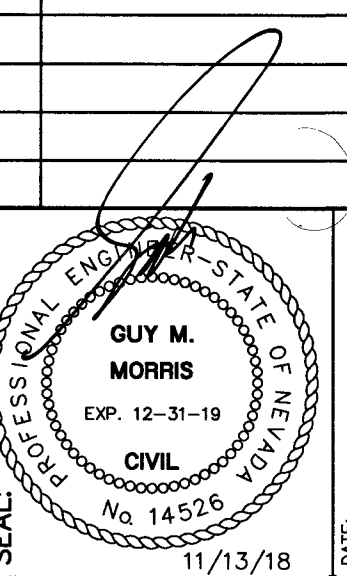

GUY M. MORRIS
CIVIL ENGINEER
No. 14526
STATE OF NEVADA
EXP. 12-31-19

3883 Howard Hughes Pkwy
Suite 650
Las Vegas, NV 89169
Tel: 702.893.2800
Fax: 702.893.2805

Gensler


CONSULTANT:

CLARK COUNTY SCHOOL DISTRICT
CONSTRUCTION MANAGEMENT 1180 MILITARY TRIBUTE PL. HENDERSON NV 89074 PHONE: 702-799-8710

PROJECT: JOHN W. BONNER E.S. ADDITION
DRAWING TITLE: GENERAL NOTE SHEET
FACILITY: JOHN W. BONNER E.S. - LOCATION 309

0013529

REQUIRED ☐ NOT REQUIRED

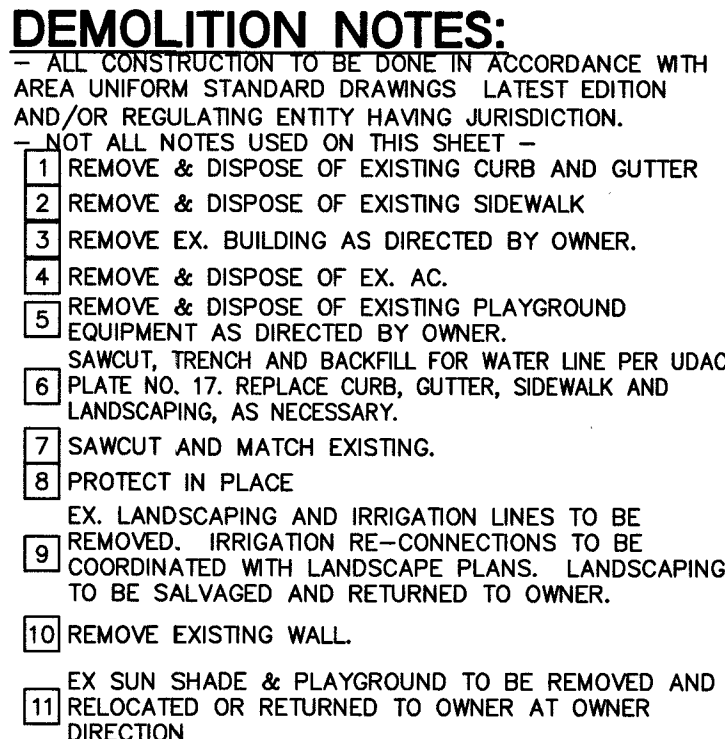

DEMOLITION NOTES:

ALL CONSTRUCTION TO BE DONE IN ACCORDANCE WITH AREA UNIFORM STANDARD DRAWINGS LATEST EDITION AND/OR REGULATING ENTITY HAVING JURISDICTION.

NOTES TO BE USED ON THIS SHEET

- 1 REMOVE & DISPOSE OF EXISTING CURB AND GUTTER
- 2 REMOVE & DISPOSE OF EXISTING SIDEWALK
- 3 REMOVE EX. BUILDING AS DIRECTED BY OWNER.
- 4 REMOVE & DISPOSE OF EX. AC.
- 5 REMOVE & DISPOSE OF EXISTING PLAYGROUND EQUIPMENT AS DIRECTED BY OWNER.
- 6 SAWCUT, TRENCH AND BACKFILL FOR WATER LINE PER UDAC
- 6 PLATE NO. 17. REPLACE CURB, GUTTER, SIDEWALK AND LANDSCAPING, AS NECESSARY.
- 7 SAWCUT AND MATCH EXISTING.
- 8 PROTECT IN PLACE
- 8 EX. LANDSCAPING AND IRRIGATION LINES TO BE REMOVED. IRRIGATION RE-CONNECTIONS TO BE COORDINATED WITH LANDSCAPE PLANS. LANDSCAPING TO BE SALVAGED AND RETURNED TO OWNER.
- 10 REMOVE EXISTING WALL.
- 10 EX SUN SHADE & PLAYGROUND TO BE REMOVED AND RETURNED OR RETURNED TO OWNER AT OWNER

[illegible]

8883 Howard Hughes Pkwy
Suite 650
Las Vegas NV 89169
Tel: 702.893.2800
Fax: 702.893.2805

Gensler

Lochsa
engineering
6345 South Jones Blvd.
Suite 100
Phone (702) 365-5312
Fax (702) 365-5317

CONCILIUM TANT;

CONSTRUCTION MGMT:		DATE:
PROJECT MANAGER:		
COORDINATOR:		
BUILDING DEPARTMENT:		
CODE COMPLIANCE:		
AHJRA REVIEW:		

ASBESTOS WORK IS:	
REQUIRED ☐	NOT REQUIRED ☐
MPID:	
0013529	

 CLARK COUNTY SCHOOL DISTRICT CONSTRUCTION MANAGEMENT DEPARTMENT 1180 MILITARY TRIBUTE PL. HENDERSON NV 89074 PHONE: 702-799-8710	PROJECT: JOHN W. BONNER E.S. ADDITION
	DRAWING TITLE: DEMOLITION PLANS SHEET 1 OF 1
	FACILITY: JOHN W. BONNER E.S. - LOCATION 309

SHEET NO: 715-210
C2.01
SHEET 3 OF 15 L18-0246

SHADOWLAND AVENUE (PUBLIC)

SYCAMORE RIDGE UNIT 2

CRESTDALE LANE (PUBLIC)

WESTRIDGE AT SUMMERLIN PHASE 1

OXFORD CROSS DRIVE (PUBLIC)

DISCOVERY POINT UNIT 2

DISCOVERY POINT UNIT 1

CARLTON KAY PLACE

EX. BUILDING

EX. BUILDING TO BE REMOVED

STATIONING: STA: 15+16.34, STA: 15+24.34, STA: 15+24.58, STA: 15+16.47, STA: 21+39.21, STA: 22+11.51

OFFSETS: OFF: 23.13'R, OFF: 44.00'L, OFF: 23.11'R

RIGHT-OF-WAY: 50.00' ROW, 72.00' ROW

APNs: 137-25-713-001 through 137-25-713-009, 137-25-713-010 through 137-25-713-012, 137-25-713-013 through 137-25-713-015, 137-25-713-016 through 137-25-713-018, 137-25-713-019 through 137-25-713-021, 137-25-713-022 through 137-25-713-024, 137-25-713-025 through 137-25-713-027, 137-25-713-028 through 137-25-713-030, 137-25-713-031 through 137-25-713-033, 137-25-713-034 through 137-25-713-036, 137-25-713-037 through 137-25-713-039, 137-25-713-040 through 137-25-713-042, 137-25-713-043 through 137-25-713-045, 137-25-713-046 through 137-25-713-048, 137-25-713-049 through 137-25-713-051, 137-25-713-052 through 137-25-713-054, 137-25-713-055 through 137-25-713-057, 137-25-713-058 through 137-25-713-060, 137-25-713-061 through 137-25-713-063, 137-25-713-064 through 137-25-713-066, 137-25-713-067 through 137-25-713-069, 137-25-713-070 through 137-25-713-072, 137-25-713-073 through 137-25-713-075, 137-25-713-076 through 137-25-713-078, 137-25-713-079 through 137-25-713-081, 137-25-713-082 through 137-25-713-084, 137-25-713-085 through 137-25-713-087, 137-25-713-088 through 137-25-713-090, 137-25-713-091 through 137-25-713-093, 137-25-713-094 through 137-25-713-096, 137-25-713-097 through 137-25-713-099, 137-25-713-100 through 137-25-713-102, 137-25-713-103 through 137-25-713-105, 137-25-713-106 through 137-25-713-108, 137-25-713-109 through 137-25-713-111, 137-25-713-112 through 137-25-713-114, 137-25-713-115 through 137-25-713-117, 137-25-713-118 through 137-25-713-120, 137-25-713-121 through 137-25-713-123, 137-25-713-124 through 137-25-713-126, 137-25-713-127 through 137-25-713-129, 137-25-713-130 through 137-25-713-132, 137-25-713-133 through 137-25-713-135, 137-25-713-136 through 137-25-713-138, 137-25-713-139 through 137-25-713-141, 137-25-713-142 through 137-25-713-144, 137-25-713-145 through 137-25-713-147, 137-25-713-148 through 137-25-713-150, 137-25-713-151 through 137-25-713-153, 137-25-713-154 through 137-25-713-156, 137-25-713-157 through 137-25-713-159, 137-25-713-160 through 137-25-713-162, 137-25-713-163 through 137-25-713-165, 137-25-713-166 through 137-25-713-168, 137-25-713-169 through 137-25-713-171, 137-25-713-172 through 137-25-713-174, 137-25-713-175 through 137-25-713-177, 137-25-713-178 through 137-25-713-180, 137-25-713-181 through 137-25-713-183, 137-25-713-184 through 137-25-713-186, 137-25-713-187 through 137-25-713-189, 137-25-713-190 through 137-25-713-192, 137-25-713-193 through 137-25-713-195, 137-25-713-196 through 137-25-713-198, 137-25-713-199 through 137-25-713-201, 137-25-713-202 through 137-25-713-204, 137-25-713-205 through 137-25-713-207, 137-25-713-208 through 137-25-713-210, 137-25-713-211 through 137-25-713-213, 137-25-713-214 through 137-25-713-216, 137-25-713-217 through 137-25-713-219, 137-25-713-220 through 137-25-713-222, 137-25-713-223 through 137-25-713-225, 137-25-713-226 through 137-25-713-228, 137-25-713-229 through 137-25-713-231, 137-25-713-232 through 137-25-713-234, 137-25-713-235 through 137-25-713-237, 137-25-713-238 through 137-25-713-240, 137-25-713-241 through 137-25-713-243, 137-25-713-244 through 137-25-713-246, 137-25-713-247 through 137-25-713-249, 137-25-713-250 through 137-25-713-252, 137-25-713-253 through 137-25-713-255, 137-25-713-256 through 137-25-713-258, 137-25-713-259 through 137-25-713-261, 137-25-713-262 through 137-25-713-264, 137-25-713-265 through 137-25-713-267, 137-25-713-268 through 137-25-713-270, 137-25-713-271 through 137-25-713-273, 137-25-713-274 through 137-25-713-276, 137-25-713-277 through 137-25-713-279, 137-25-713-280 through 137-25-713-282, 137-25-713-283 through 137-25-713-285, 137-25-713-286 through 137-25-713-288, 137-25-713-289 through 137-25-713-291, 137-25-713-292 through 137-25-713-294, 137-25-713-295 through 137-25-713-297, 137-25-713-298 through 137-25-713-300, 137-25-713-301 through 137-25-713-303, 137-25-713-304 through 137-25-713-306, 137-25-713-307 through 137-25-713-309, 137-25-713-310 through 137-25-713-312, 137-25-713-313 through 137-25-713-315, 137-25-713-316 through 137-25-713-318, 137-25-713-319 through 137-25-713-321, 137-25-713-322 through 137-25-713-324, 137-25-713-325 through 137-25-713-327, 137-25-713-328 through 137-25-713-330, 137-25-713-331 through 137-25-713-333, 137-25-713-334 through 137-25-713-336, 137-25-713-337 through 137-25-713

NOTE:

LOCHSA ENGINEERING ASSUMES NO RESPONSIBILITY FOR EXISTING UTILITY LOCATIONS AND ELEVATIONS. THE UTILITIES SHOWN ON THIS PLAN ARE FROM THE BEST AVAILABLE INFORMATION. IT IS THE CONTRACTOR'S RESPONSIBILITY TO FIELD VERIFY THE LOCATION AND ELEVATION OF ALL UTILITIES, INCLUDING BUT NOT LIMITED TO, THE WATER, FIRE, SANITARY, SEWER, STORM SEWER, TELEPHONE, POWER, GAS, AND IRRIGATION LINES PRIOR TO THE COMMENCEMENT OF CONSTRUCTION. IF CONFLICT EXISTS IN THE FIELD, THE CONTRACTOR IS TO NOTIFY THE PROJECT ARCHITECT, OWNER'S REPRESENTATIVE AND THE PROJECT ENGINEER IMMEDIATELY.

Safety Alert

Call before you dig
Avoid setting underground utility lines. It's costly!

Call Before You Overhead

Call before you Underground

Call 811

1-702-432-5300 or 4-366-9226

A.P.N.:
137-25-310-002
BASIS OF BEARINGS
SEE COVER SHEET
BENCHMARK:
CITY OF LAS VEGAS BENCHMARK
11V0925C4 RIVET AND PLATE
IN TOP OF CURB AT SOUTHWEST CORNER
OF CRESTDALE LANE AND RED FALLS
LANES ELEVATION= 2941.

LEGEND	CL OR SURVEY LINE		EASEMENT LINE		DESCRIPTION:	CONTOUR LINES	EDGE OF PAVEMENT	"A" TYPE CURBS	"L" TYPE CURBS	WALLS	FENCES	AC PAVEMENT	CONCRETE	SPOT ELEVATIONS	SIGNS	MANHOLE W/ DESCRIPTION	FEET / 896.57 METERS									
	PROPERTY LINE		SAWCUT LINE		EXISTING:	---	---	---	---	---	---	---	---	(12.34)	---	Ⓢ	1-102-221-2828 RETURN AND RETAIL CROSS BY DRAINAGE 1-800-227-2800									
	ROW LINE		SCARP LINE		PROPOSED:	---	---	---	---	---	---	---	---	12.34 BC	---	Ⓢ	Ⓢ = SANITARY SEWER									
						---	---	---	---	---	---	---	---	---	---	Ⓢ	Ⓢ = STORM DRAIN Ⓢ = ELECTRICAL Ⓢ = TELEPHONE									



CONSTRUCTION NOTES:

- ALL CONSTRUCTION TO BE DONE IN ACCORDANCE WITH "CLARK COUNTY AREA UNIFORM STANDARD DRAWINGS (C.C.A.U.S.D.)" LATEST EDITION AND/OR REGULATING ENTITY HAVING JURISDICTION. NOT ALL NOTES ON THIS SHEET.
- CONSTRUCT AC PAVEMENT PER DETAIL 2 ON C6.01.
- CONSTRUCT "A" TYPE CURB PER DETAIL 1 ON C6.01.
- CONSTRUCT "L" TYPE CURB PER CCAUSD No. 216.
- CONSTRUCT CONC. SIDEWALK PER CCAUSD No. 234. REFER TO ARCH. PLANS FOR FINISH SPECIFICATIONS.
- CONSTRUCT 2' VALLEY GUTTER PER DETAIL 3 ON C6.01.
- CONSTRUCT 12" CHANNEL PER DETAIL 8 ON C6.01.
- CONSTRUCT SIDEWALK UNDER DRAIN PER CCAUSD No. 236.
- SAWCUT AND MATCH EXISTING.
- FENCE PER ARCHITECTURAL PLANS.
- PLAYGROUND PER ARCHITECTURAL PLANS.
- CONSTRUCT CONC. SIDEWALK PER DETAIL 8 ON C6.01. REFER TO ARCH. PLANS FOR FINISH SPECIFICATIONS.
- CONSTRUCT CONC. PAD UNDER STAIRS PER DETAIL 5 ON SHEET C6.01.
- CONSTRUCT SIDEWALK PER CCAUSD No. 234.
- TRENCH, BACKFILL, AND AC RESTORATION CCAUSD Nos. 503, 500.3, 500.4, AND 500.5.
- CONSTRUCT 3' VALLEY GUTTER PER DETAIL 10 ON C6.01.
- CONSTRUCT SIDEWALK TO BE REMOVED AND REPLACED AFTER GRADING.
- CONSTRUCT RETAINING WALL PER STRUCTURAL DETAILS.
- CONSTRUCT WALL PER SOUTHERN NEVADA BUILDING OFFICIAL REGIONAL STANDARDS PLATE B-100-1.
- INSTALL DSO - 3" RIP RAP. THICKNESS (T) = 6"
- INSTALL 2' WIDE CURB OPENING.
- CONSTRUCT RETAINING WALL PER STRUCTURAL DETAIL 6/C6.03. THIS WALL IS TO BE CONSTRUCTED SECOND.
- CONSTRUCT CONC. SIDEWALK PER DETAIL 4/C6.03. THIS WALL MUST BE CONSTRUCTED FIRST.
- CONSTRUCT RETAINING WALL PER STRUCTURAL DETAIL 7/C6.03.

GRADING NOTES:

- SLOPES 4:1 OR STEEPER AND FINE-GRAINED MATERIALS THAT HAVE BEEN DISTURBED (SANDY AND SILTY MATERIALS) SHOULD BE PROTECTED WITH BURLAP OR OTHER EXISTING CONTROL FABRIC/MATERIAL, UNLESS OTHERWISE SPECIFIED BY LANDSCAPE DRAWINGS AND SPECIFICATIONS OR THE SOILS REPORT.
- CONTRACTOR SHALL DETERMINE HIS OWN FOOTING OR BASEMENT EXCAVATION QUANTITIES, EVEN THOUGH SHOWN ON ROUGH GRADING PLANS. ADDITIONALLY, STRUCTURE BACKFILL COSTS SHOULD BE INCLUDED IN THE COST OF THE STRUCTURE, UNLESS OTHERWISE SPECIFIED IN THE CONTRACT DOCUMENTS.
- CONTRACTOR SHALL NOTIFY LOCHSA ENGINEERING WITHIN 24 HOURS OF OMISSIONS AND ERRORS DISCOVERED ON PLANS. LOCHSA ENGINEERING WILL NOT BE RESPONSIBLE FOR ANY "CORRECTIVE" WORK DONE BY OTHERS.
- CONTRACTOR TO ENSURE POSITIVE DRAINAGE, NO PONDING ALLOWED. CONTRACTOR TO FOLLOW RECOMMENDATIONS AS OUTLINED IN THE PROJECT GEOTECHNICAL REPORT INCLUDING BUT NOT LIMITED TO EXCAVATION, GRADING AND COMPACTION. REFER TO THE REPORT PREPARED BY: NINYO & MOORE, PROJECT No. 304100001.

EXISTING UTILITY NOTE:

CONTRACTOR TO ADJUST ALL EXISTING UTILITIES TO MATCH PROPOSED FINISH GRADE ELEVATIONS.

LAS VEGAS VALLEY CONSTRUCTION SITE BEST MANAGEMENT PRACTICES GUIDANCE MANUAL SECTION 3.5.1 STANDARD NOTES 1-5

- THE OWNER, SITE DEVELOPER, CONTRACTOR, AND/OR THEIR AUTHORIZED AGENTS SHALL EACH DAY REMOVE ALL SEDIMENT, MUD, CONSTRUCTION DEBRIS, OR OTHER POTENTIAL POLLUTANTS THAT MAY HAVE BEEN DISCHARGED TO, OR ACCUMULATED IN, THE PUBLIC RIGHT-OF-WAY OF THE CITY OF LAS VEGAS AS A RESULT OF CONSTRUCTION ACTIVITIES ASSOCIATED WITH THIS SITE DEVELOPMENT OR CONSTRUCTION PROJECT. SUCH MATERIAL SHALL BE PREVENTED FROM ENTERING THE STORM SEWER SYSTEM.
- ADDITIONAL CONSTRUCTION SITE DISCHARGE BEST MANAGEMENT PRACTICES MAY BE REQUIRED OF THE OWNER AND HIS OR HER AGENTS DUE TO UNFORESEEN EROSION PROBLEMS OR IF THE SUBMITTED PLAN DOES NOT MEET THE PERFORMANCE STANDARDS SPECIFIED IN THE CITY OF LAS VEGAS AND THE LAS VEGAS VALLEY CONSTRUCTION SITE BMP GUIDANCE MANUAL.
- TEMPORARY OR PERMANENT STABILIZATION PRACTICES WILL BE INSTALLED ON DISTURBED AREAS AS SOON AS PRACTICABLE AND NO LATER THAN 14 DAYS AFTER THE CONSTRUCTION ACTIVITY IN THAT PORTION OF THE SITE HAS TEMPORARILY OR PERMANENTLY CEASED. SOME EXCEPTIONS MAY APPLY; REFER TO THE NEVADA STORMWATER GENERAL PERMIT FOR CONSTRUCTION ACTIVITY NVR100000, SECTION III.A.5.
- AT A MINIMUM, THE CONTRACTOR OR HIS AGENT SHALL INSPECT ALL DISTURBED AREAS, AREAS USED FOR STORAGE OF MATERIALS AND EQUIPMENT THAT ARE EXPOSED TO PRECIPITATION, VEHICLE ENTRANCE AND EXIT LOCATIONS, AND ALL BMPs WEEKLY, AND WITHIN 24 HOURS AFTER ANY RAIN EVENT OR 0.5 INCHES OR MORE. THE CONTRACTOR OR HIS AGENT SHALL UPDATE OR MODIFY THE STORMWATER POLLUTION PREVENTION PLAN AS NECESSARY. SOME EXCEPTIONS TO WEEKLY INSPECTIONS MAY APPLY, SUCH AS SUSPENSION OF LAND DISTURBANCE ACTIVITIES. REFER TO THE NEVADA STORMWATER GENERAL PERMIT FOR CONSTRUCTION ACTIVITY NVR100000, SECTION III.A.12.
- ACCUMULATED SEDIMENT IN BMP'S SHALL BE REMOVED WITHIN SEVEN DAYS AFTER A STORMWATER RUNOFF EVENT OR PRIOR TO THE NEXT ANTICIPATED STORM EVENT, WHICHEVER IS EARLIER. SEDIMENT MUST BE REMOVED WHEN BMP DESIGN CAPACITY HAS BEEN REACHED BY 50 PERCENT OR MORE.

CL OR SURVEY LINE	EASEMENT LINE	DESCRIPTION:	CONTOUR LINES	EDGE OF PAVEMENT	"A" TYPE CURBS	"L" TYPE CURBS	WALLS	FENCES	AC PAVEMENT	CONCRETE	SPOT ELEVATIONS	SIGNS	MANHOLE W/ DESCRIPTION	MANHOLE DESCRIPTIONS	HYDRANTS	GATE VALVES	REDUCERS	CLEAN OUTS	UTILITY BOX OR VAULT	BACKWATER VALVES	100W HPS STREETLIGHTS	150W HPS STREETLIGHTS
---	---	EXISTING: PROPOSED:	---(22.0)-- ---(21.22)--	---	---	---	---	---	---	---	(12.34) BC 12.34 BC	---	---	---	---	---	---	---	---	---	---	---

CUT	FILL
3025 CY	1816 CY

NOTE: CUT/FILL QUANTITIES ARE TO FINISHED GRADE & DO NOT INCLUDE MATERIAL THICKNESS'S, FOOTINGS, ETC.

GRADING PLAN CERTIFICATION


NAME: GUY M. MORRIS PE # 14526 DATE: 11-13-18
I CERTIFY THAT THIS GRADING PLAN IS IN CONFORMANCE WITH APPROVED DRAINAGE STUDY FOR THIS SITE ON FILE AT THE CITY OF LAS VEGAS FOR THIS PROJECT.

BASIS OF BEARINGS:

SEE COVER SHEET

BENCHMARK:

CITY OF LAS VEGAS BENCHMARK 1LV09254 IN TOP OF CURB AT SOUTHWEST CORNER OF CRESTDALE LANE AND RED FALLS LANES ELEVATION= 2941.51 FEET / 896.573 METERS

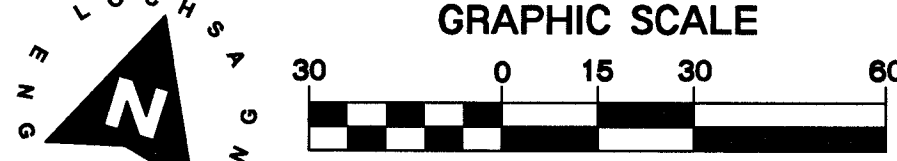

NOTE:

LOCHSA ENGINEERING ASSUMES NO RESPONSIBILITY FOR EXISTING UTILITY LOCATIONS AND ELEVATIONS. THE UTILITIES SHOWN ON THIS PLAN ARE FROM THE BEST AVAILABLE INFORMATION. IT IS THE CONTRACTOR'S RESPONSIBILITY TO FIELD VERIFY THE LOCATION AND ELEVATION OF ALL UTILITIES, INCLUDING BUT NOT LIMITED TO, THE WATER, FIRE, SANITARY SEWER, STORM SEWER, TELEPHONE, POWER, GAS, AND IRRIGATION LINES PRIOR TO THE COMMENCEMENT OF CONSTRUCTION. IF CONFLICT EXISTS IN THE FIELD, THE CONTRACTOR IS TO NOTIFY THE PROJECT ARCHITECT, OWNER'S REPRESENTATIVE AND THE PROJECT ENGINEER IMMEDIATELY.

SAFETY ALERT

Call Before You Dig. Avoid cutting underground utility lines. It's costly.

Call Before You Dig. 1-702-227-2929. 1-702-432-5300. 1-800-227-2800.

REVISIONS:

REV.	DESCRIPTION:	DATE:

SEAL: PROFESSIONAL ENGINEER STATE OF NEVADA
GUY M. MORRIS
EXP. 12-31-19
CIVIL
No. 14526
11/13/18

DATE: 11/13/18
DRAWN BY: NMG
SUBMITTAL: MYAR
A/E PROJECT NO.: 171058

3883 Howard Hughes Pkwy
Suite 650
Las Vegas NV 89169
Tel: 702.893.2800
Fax: 702.893.2805



Gensler

CONSULTANT:

CLARK COUNTY SCHOOL DISTRICT
CONSTRUCTION MANAGEMENT DEPARTMENT 1180 MILITARY TRIBUTE PL. HENDERSON NV 89074 PHONE: 702-799-8710

PROJECT: JOHN W. BONNER E.S. ADDITION
DRAWING TITLE: GRADING PLANS SHEET 1 OF 1
FACILITY: JOHN W. BONNER E.S. - LOCATION 309

SHEET NO: 715-210
C4.01
SHEET 5 OF 15 L18-02468

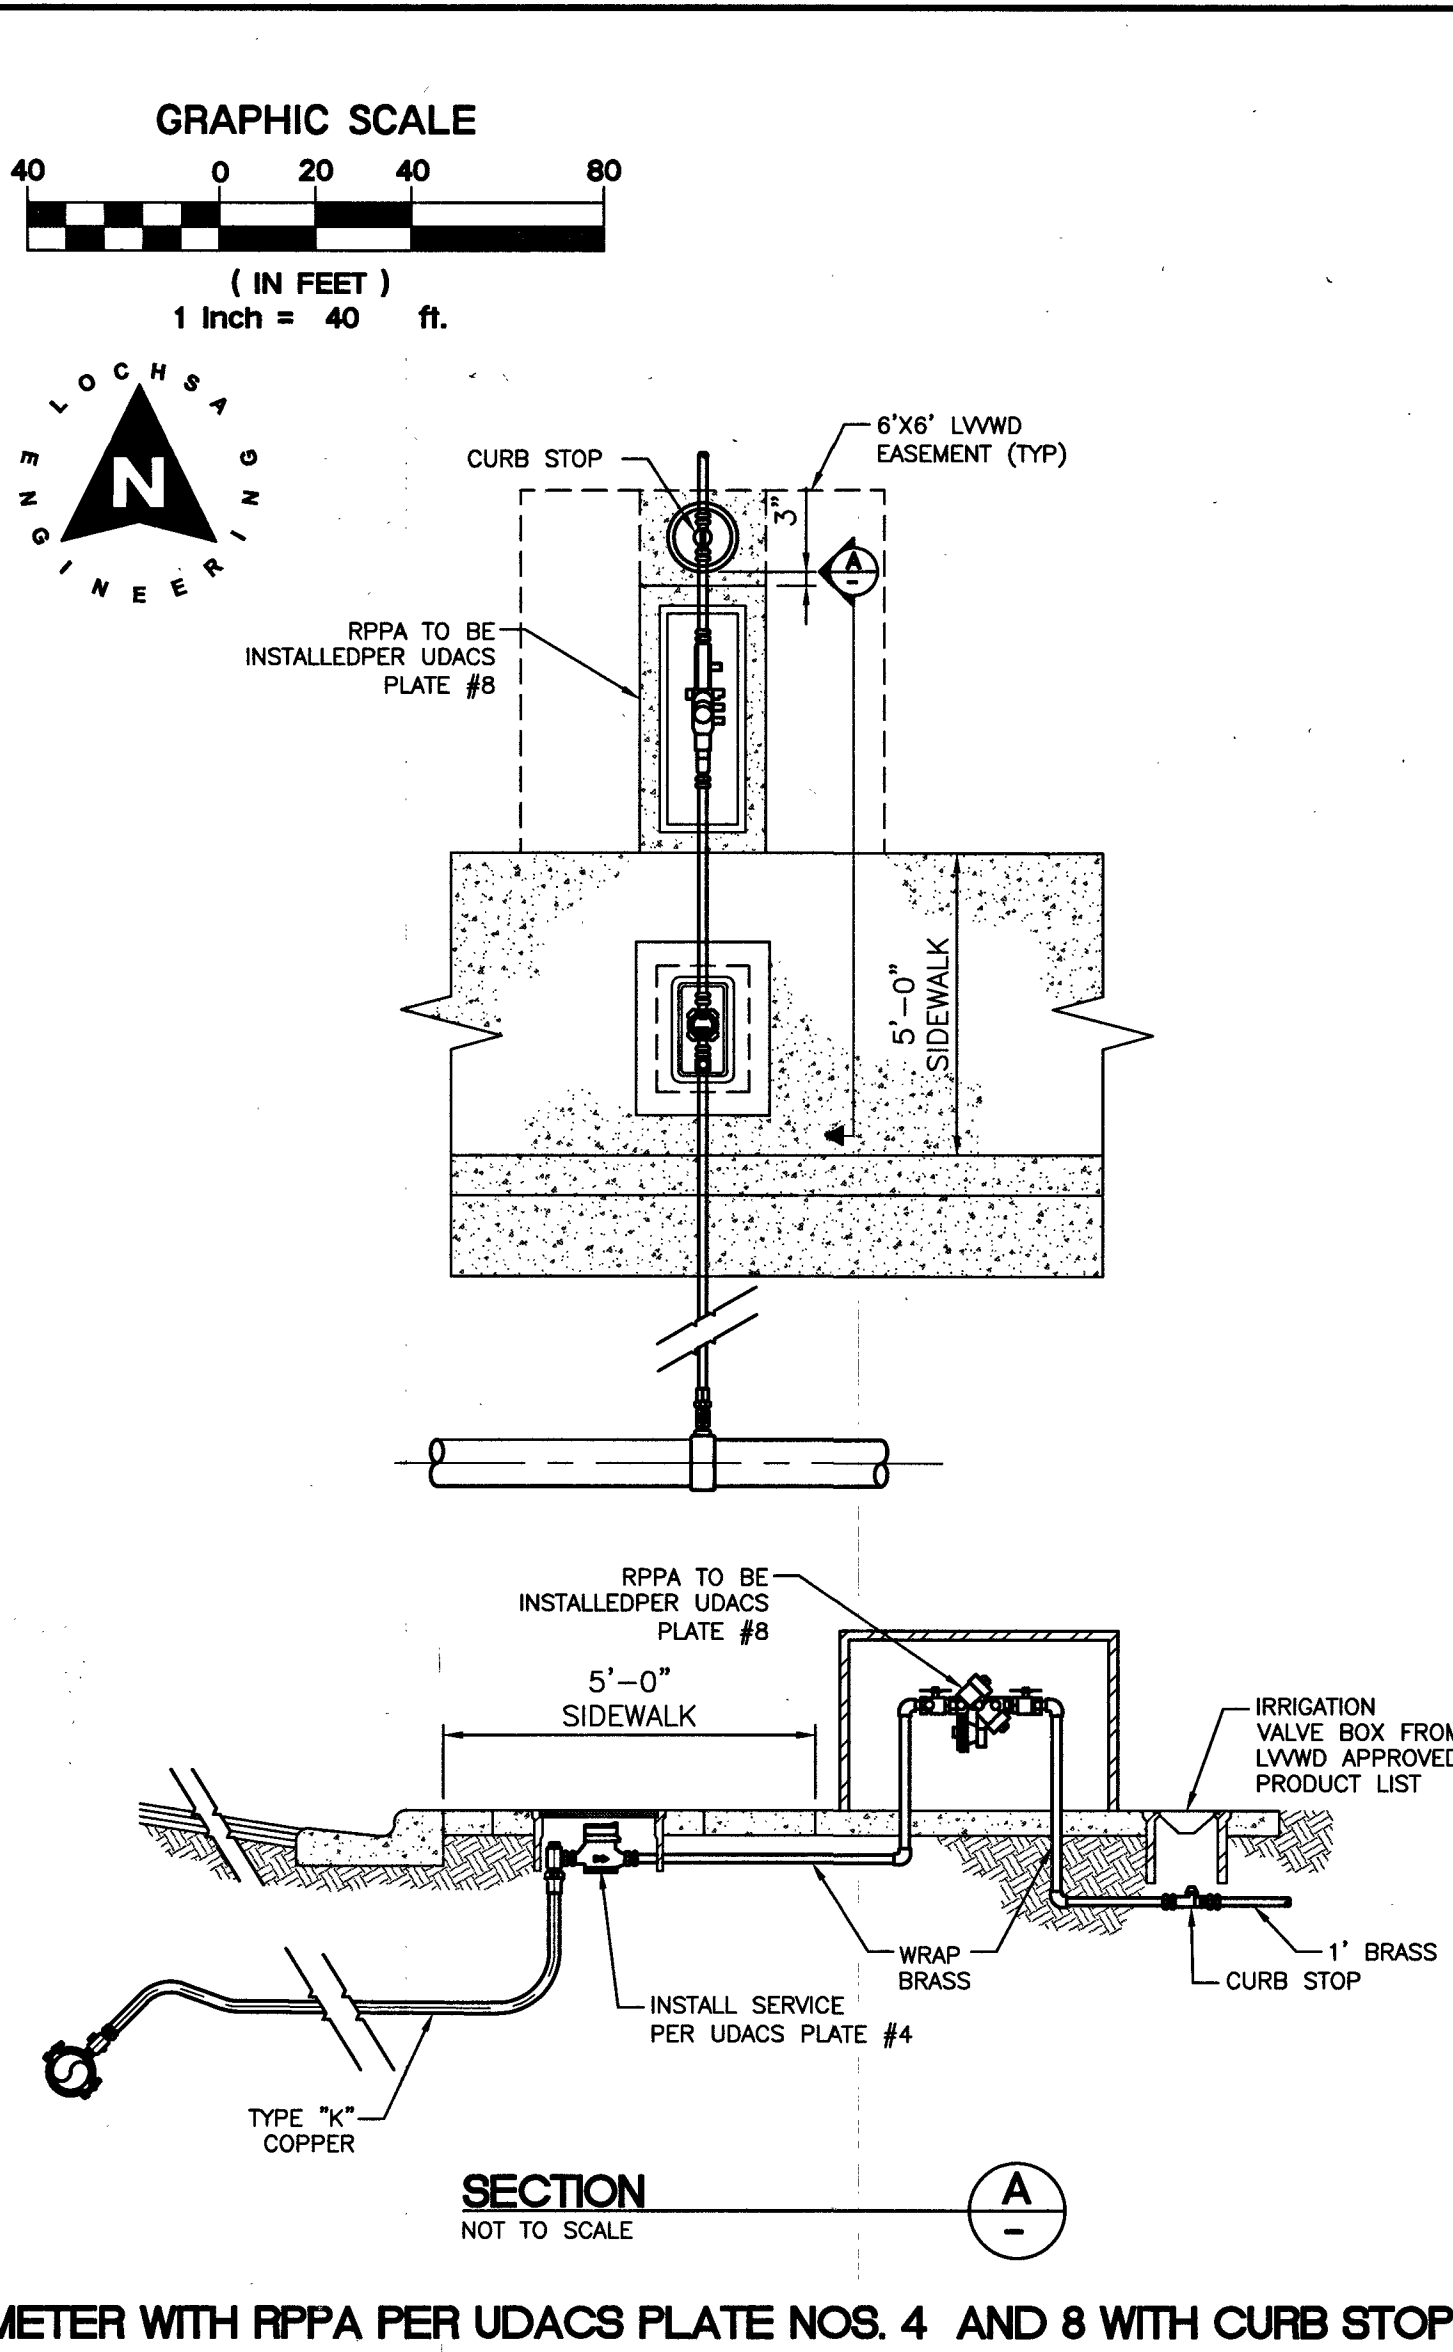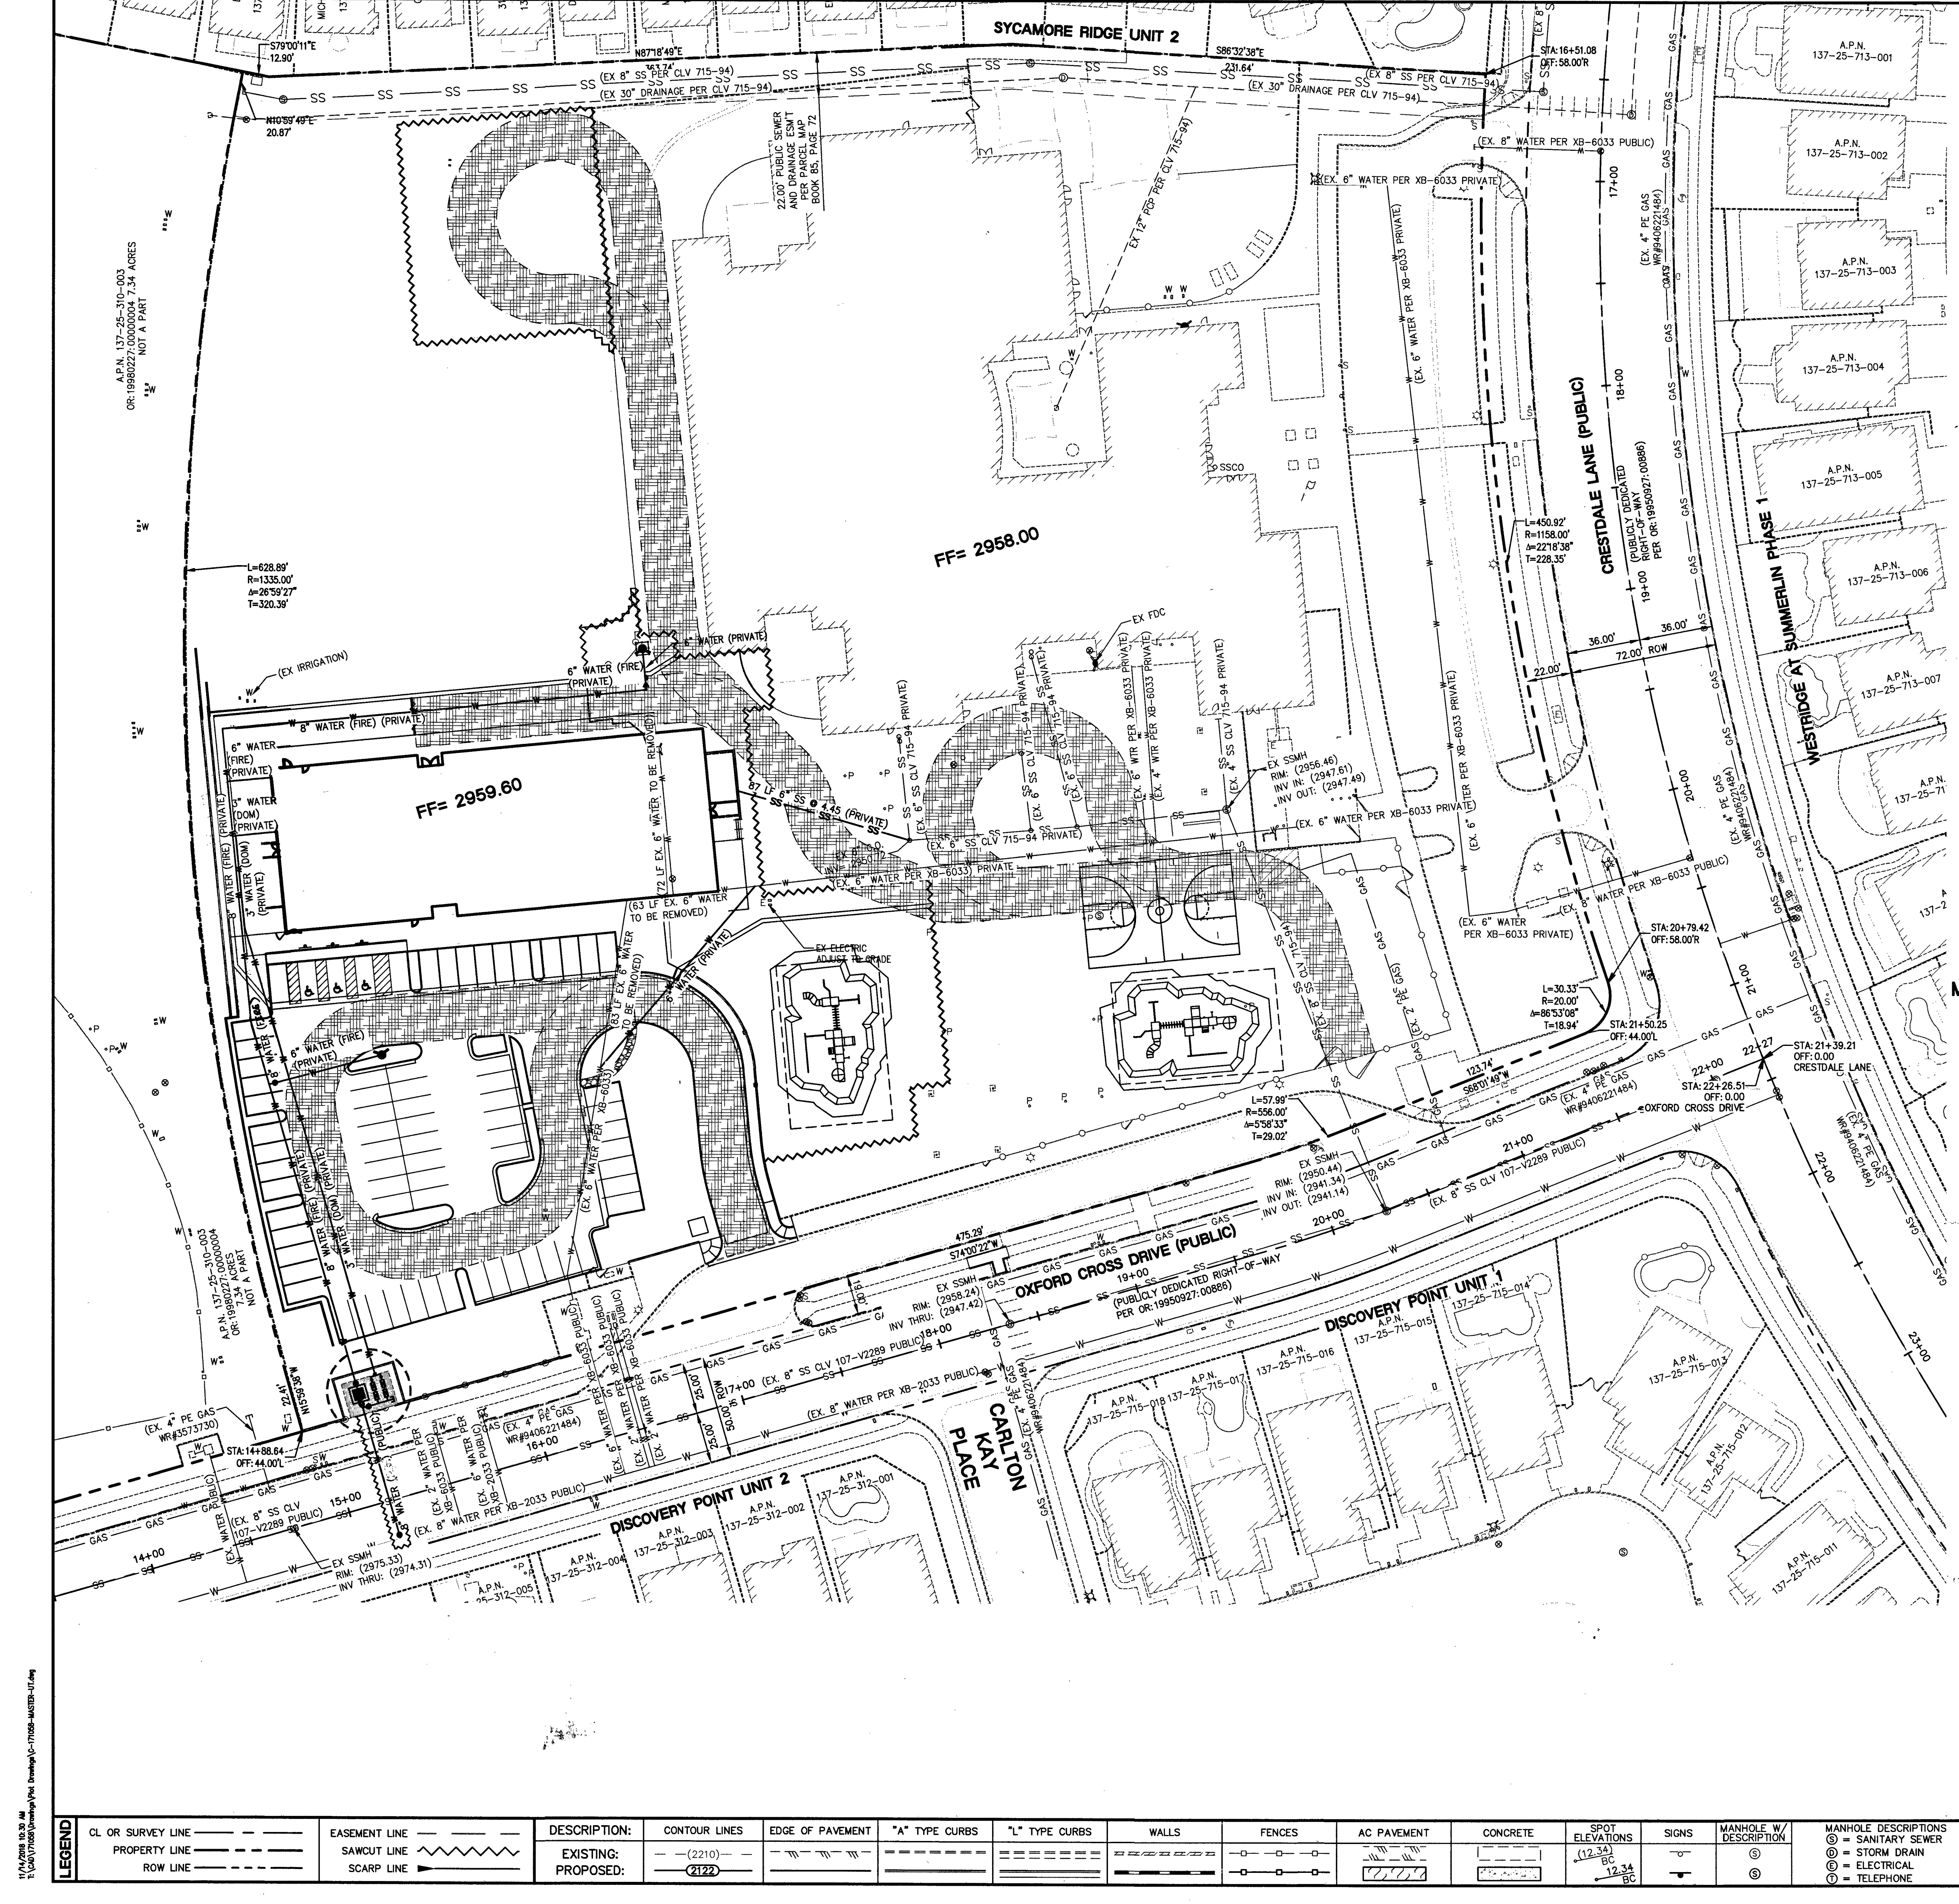

SOUTHWEST GAS CORPORATION
DATE: 11/15/18

**CITY OF LAS VEGAS
FIRE DEPARTMENT APPROVAL**
BY: [Signature] DATE: 11/26/18
APPROVAL OF THESE PLANS SHALL NOT BE CONSTRUED TO BE A PERMIT FOR OR AN APPROVAL OF, ANY VIOLATION OF ANY OF THE PROVISIONS OF THE STATE OR COUNTY LAWS, FIRE FLOW 2500 GPM AT 20 P.S.I. RESIDUAL.

FIRE DEPARTMENT APPROVAL
APPROVAL BY THE FIRE DEPARTMENT HAVING JURISDICTION IS REQUIRED PRIOR TO OBTAINING FINAL APPROVAL FROM THE LAS VEGAS VALLEY WATER DISTRICT.

APPROVED FOR CONSTRUCTION
LAS VEGAS VALLEY WATER DISTRICT ENGINEERING SERVICES
DATE: 12-17-18 PROJECT No. 125851
LVVWD APPROVED FIRE FLOW = 2500 GPM AT 20 PSI RESIDUAL

NOTE:
LOCHSA ENGINEERING ASSUMES NO RESPONSIBILITY FOR EXISTING UTILITY LOCATIONS AND ELEVATIONS. THE UTILITIES SHOWN ON THIS PLAN ARE FROM THE BEST AVAILABLE INFORMATION. IT IS THE CONTRACTOR'S RESPONSIBILITY TO FIELD VERIFY THE LOCATION AND ELEVATION OF ALL UTILITIES, INCLUDING BUT NOT LIMITED TO THE WATER, FIRE, SANITARY SEWER, STORM SEWER, TELEPHONE, POWER, GAS, AND IRRIGATION LINES PRIOR TO THE COMMENCEMENT OF CONSTRUCTION. IF CONFLICT EXISTS IN THE FIELD, THE CONTRACTOR IS TO NOTIFY THE PROJECT ARCHITECT, OWNER'S REPRESENTATIVE AND THE PROJECT ENGINEER IMMEDIATELY.

SAFETY ALERT
Call Before You Dig
Call before you dig
Underground
Call 811

1-702-227-2929 1-702-432-5300
FOLLOW THE UTILITY SYSTEM OF DISCOVERY POINT 1-800-227-2800

REVISIONS:		
REV.	DESCRIPTION	DATE

Gensler	
3883 Howard Hughes Pkwy Suite 650 Las Vegas NV 89169 Tel: 702.893.2800 Fax: 702.893.2805	CONSULTANT:

Lochsa Engineering	
6345 South Jones Blvd. Suite 100 Las Vegas, NV 89118 Phone (702) 365-8912 Fax (702) 365-8317 www.lochsa.com	ENGINEER:


CLARK COUNTY SCHOOL DISTRICT	
CONSTRUCTION MANAGEMENT 1180 MILITARY TRIBUTE PL HENDERSON NV 89074 PHONE: 702-799-8710	PROJECT:

JOHN W. BONNER E.S. ADDITION	
UTILITY PLANS MASTER UTILITY PLAN	DRAWING TITLE:


JOHN W. BONNER E.S. - LOCATION 309	
171058	PROJECT NO.:

SHEET NO. 715-210	
C5.00	SHEET 6 OF 15 L18-02468


11/1/2018 10:51 AM
C:\Users\jbonner\OneDrive\Public\Drawings\CL-171058-401-DT.dwg

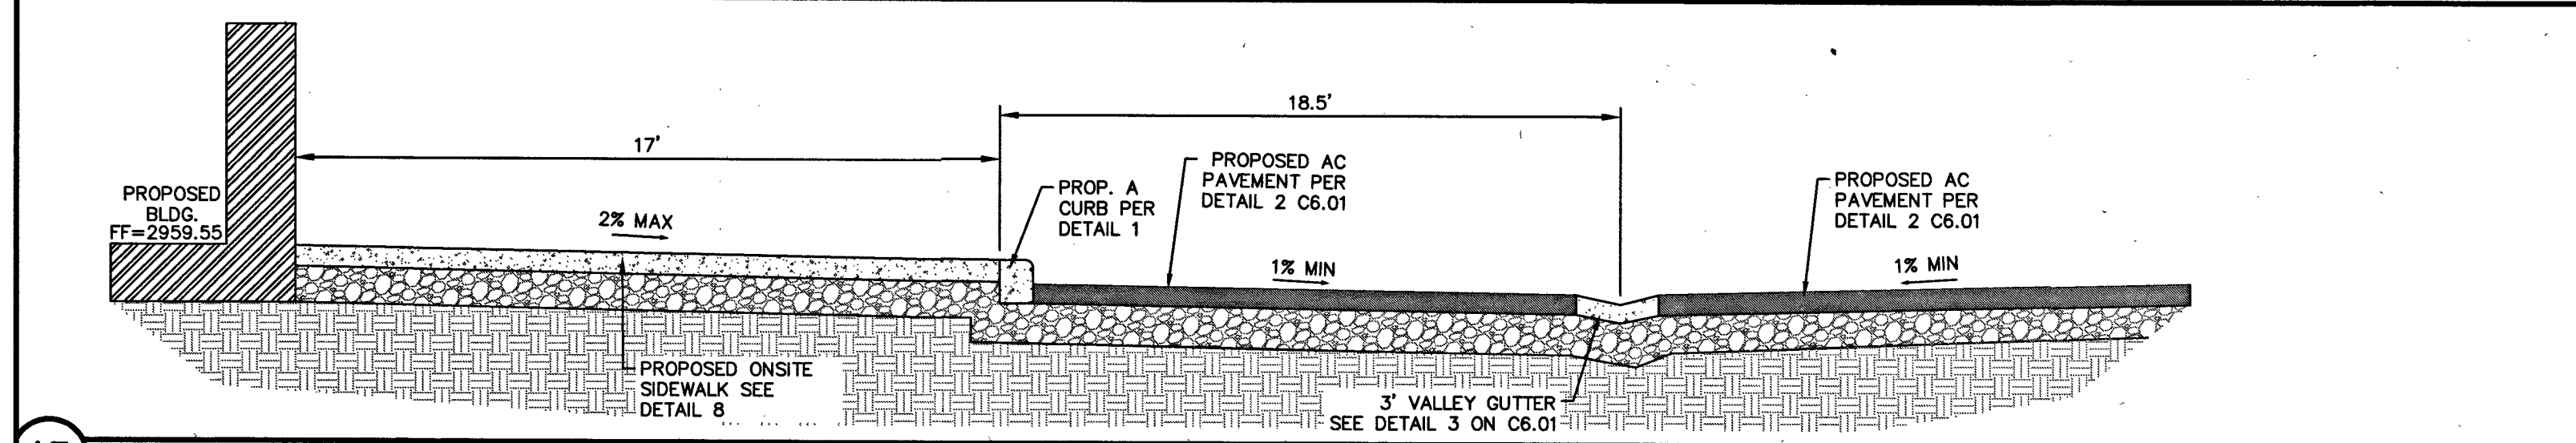


15 SECTION THROUGH SOUTHSIDE OF BUILDING NOT TO SCALE

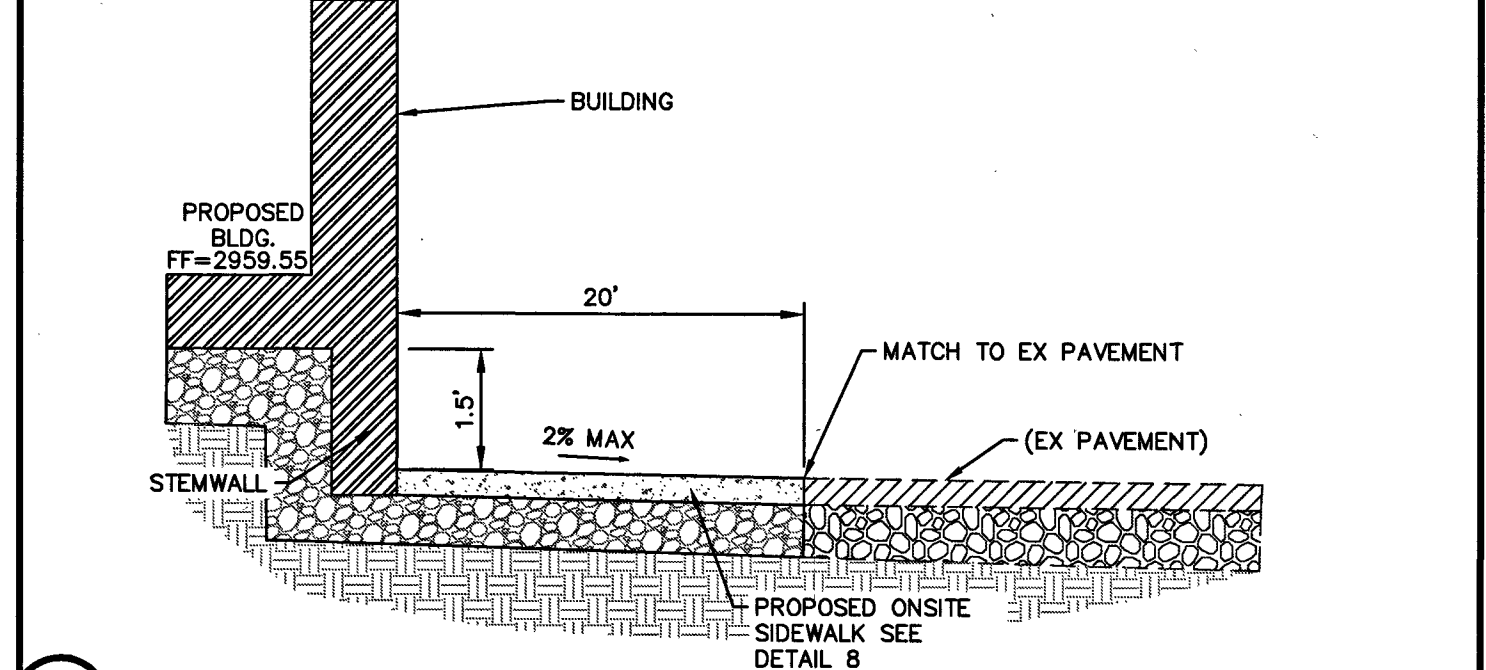


14 SECTION THROUGH EAST SIDE OF BUILDING NOT TO SCALE

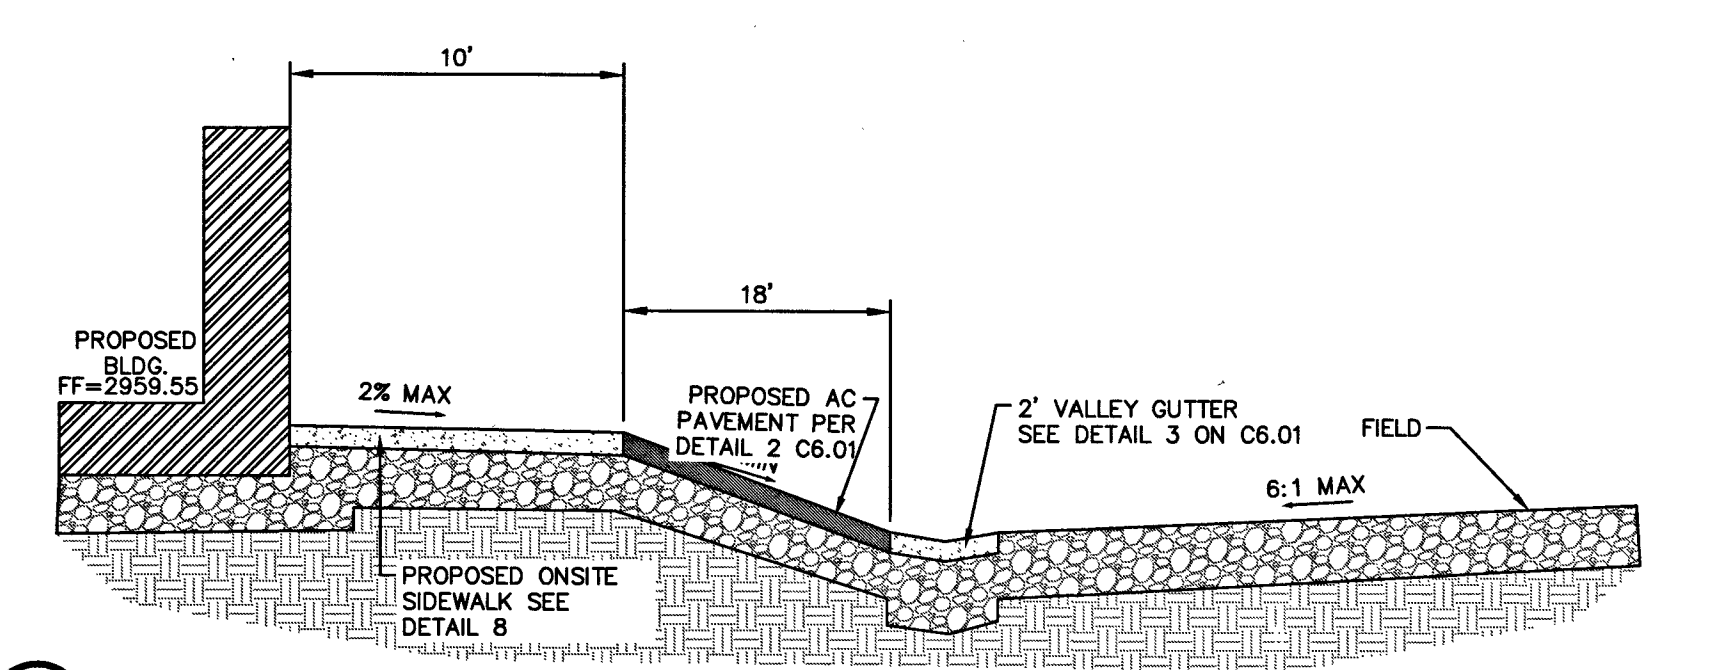


13 SECTION THROUGH NORTHSIDE OF BUILDING NOT TO SCALE

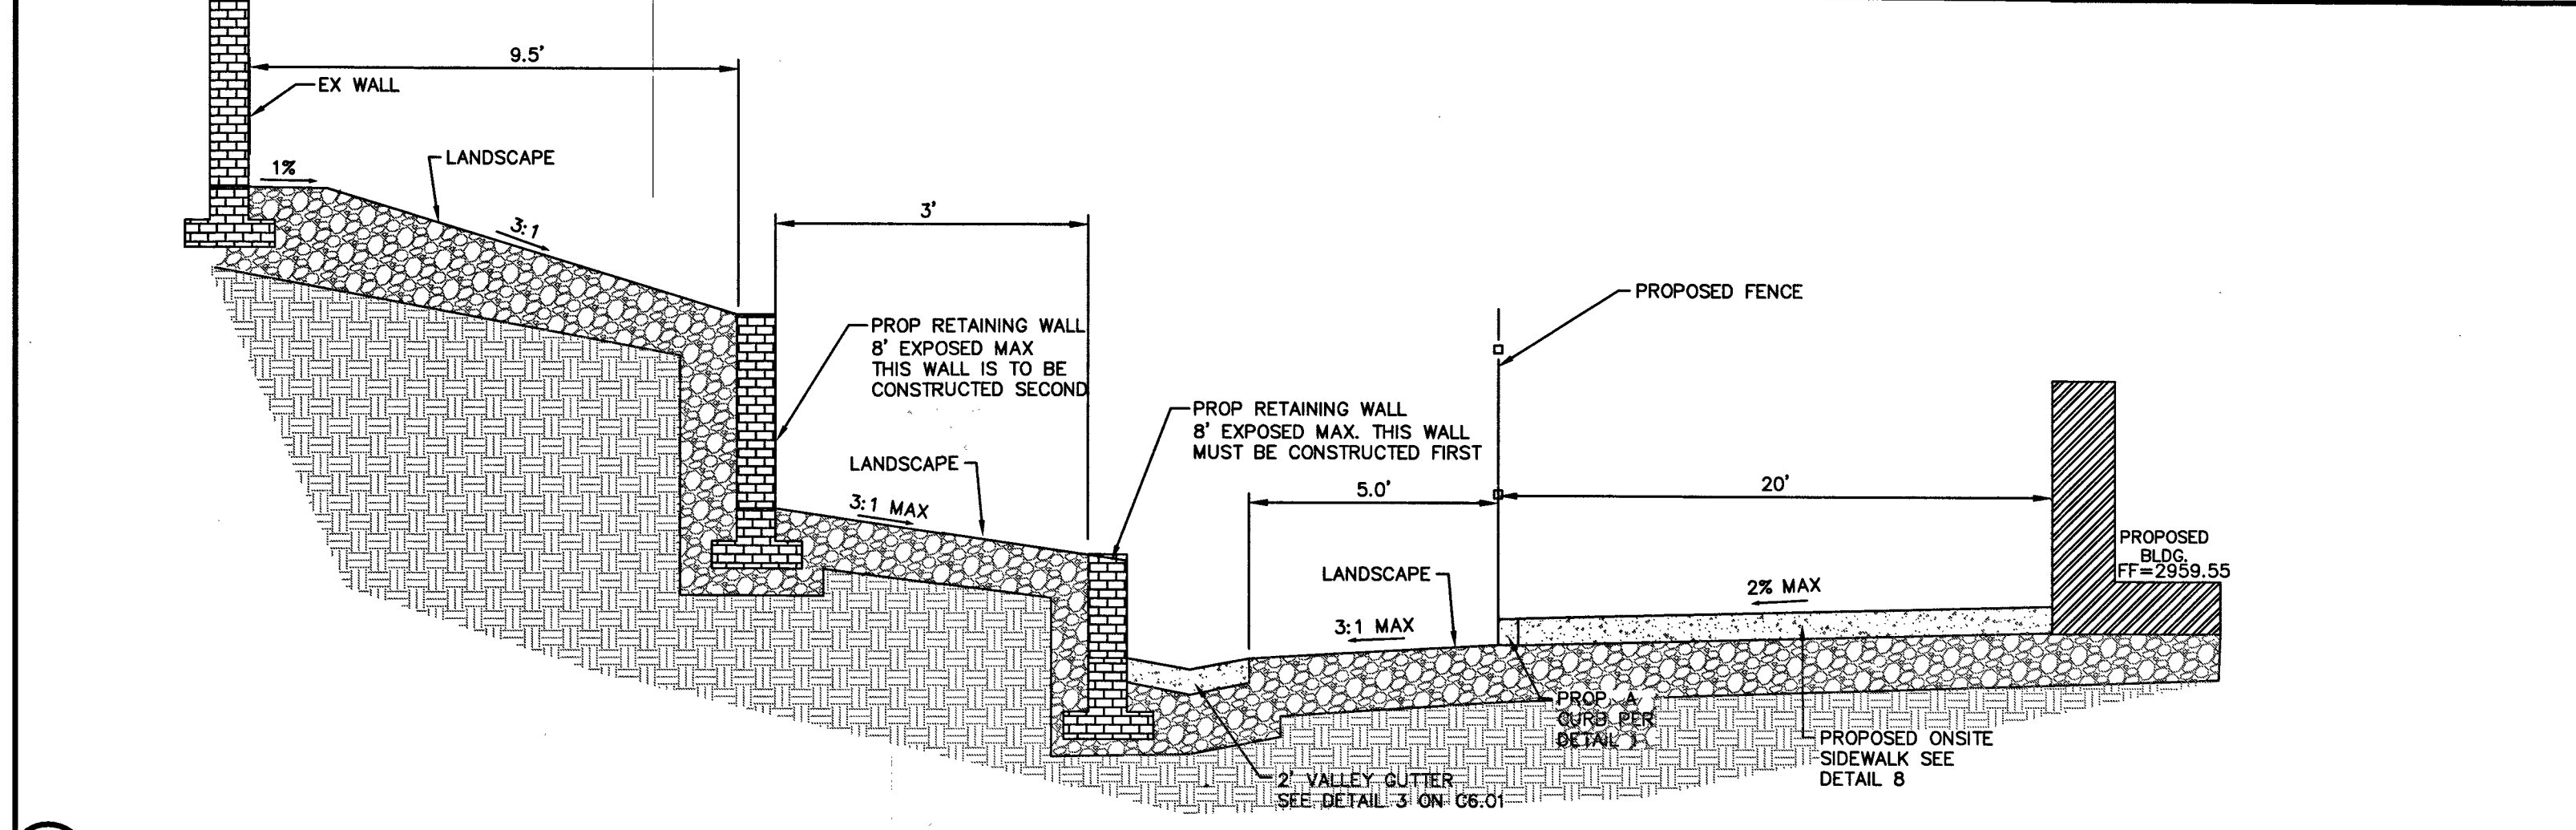


12 SECTION THROUGH WESTSIDE OF BUILDING. NOT TO SCALE

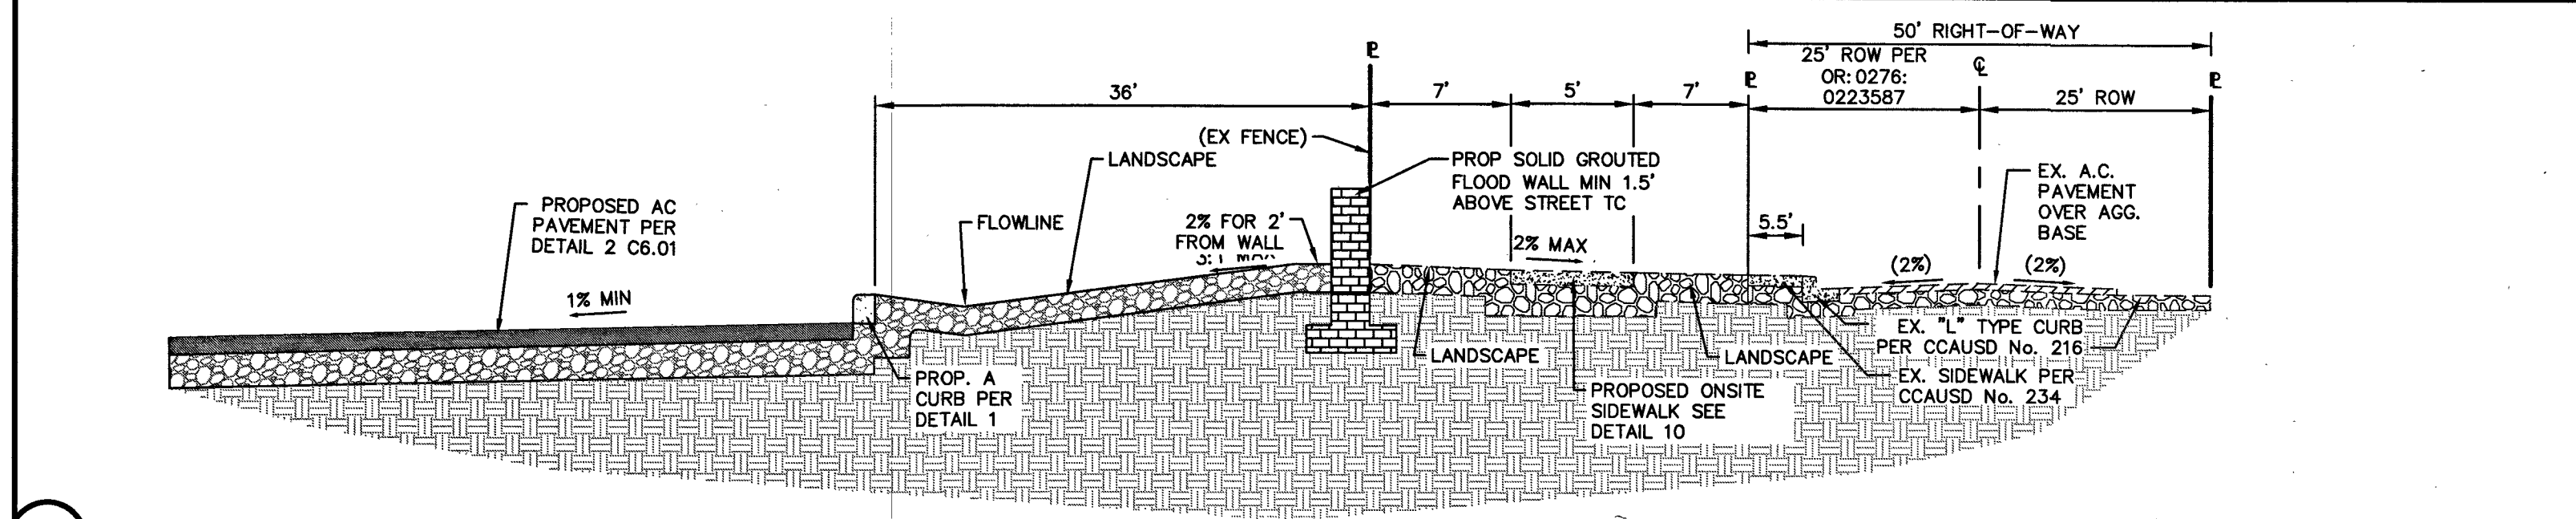


11 SECTION THROUGH PROPERTY LINE ON THE SOUTHSIDE NOT TO SCALE

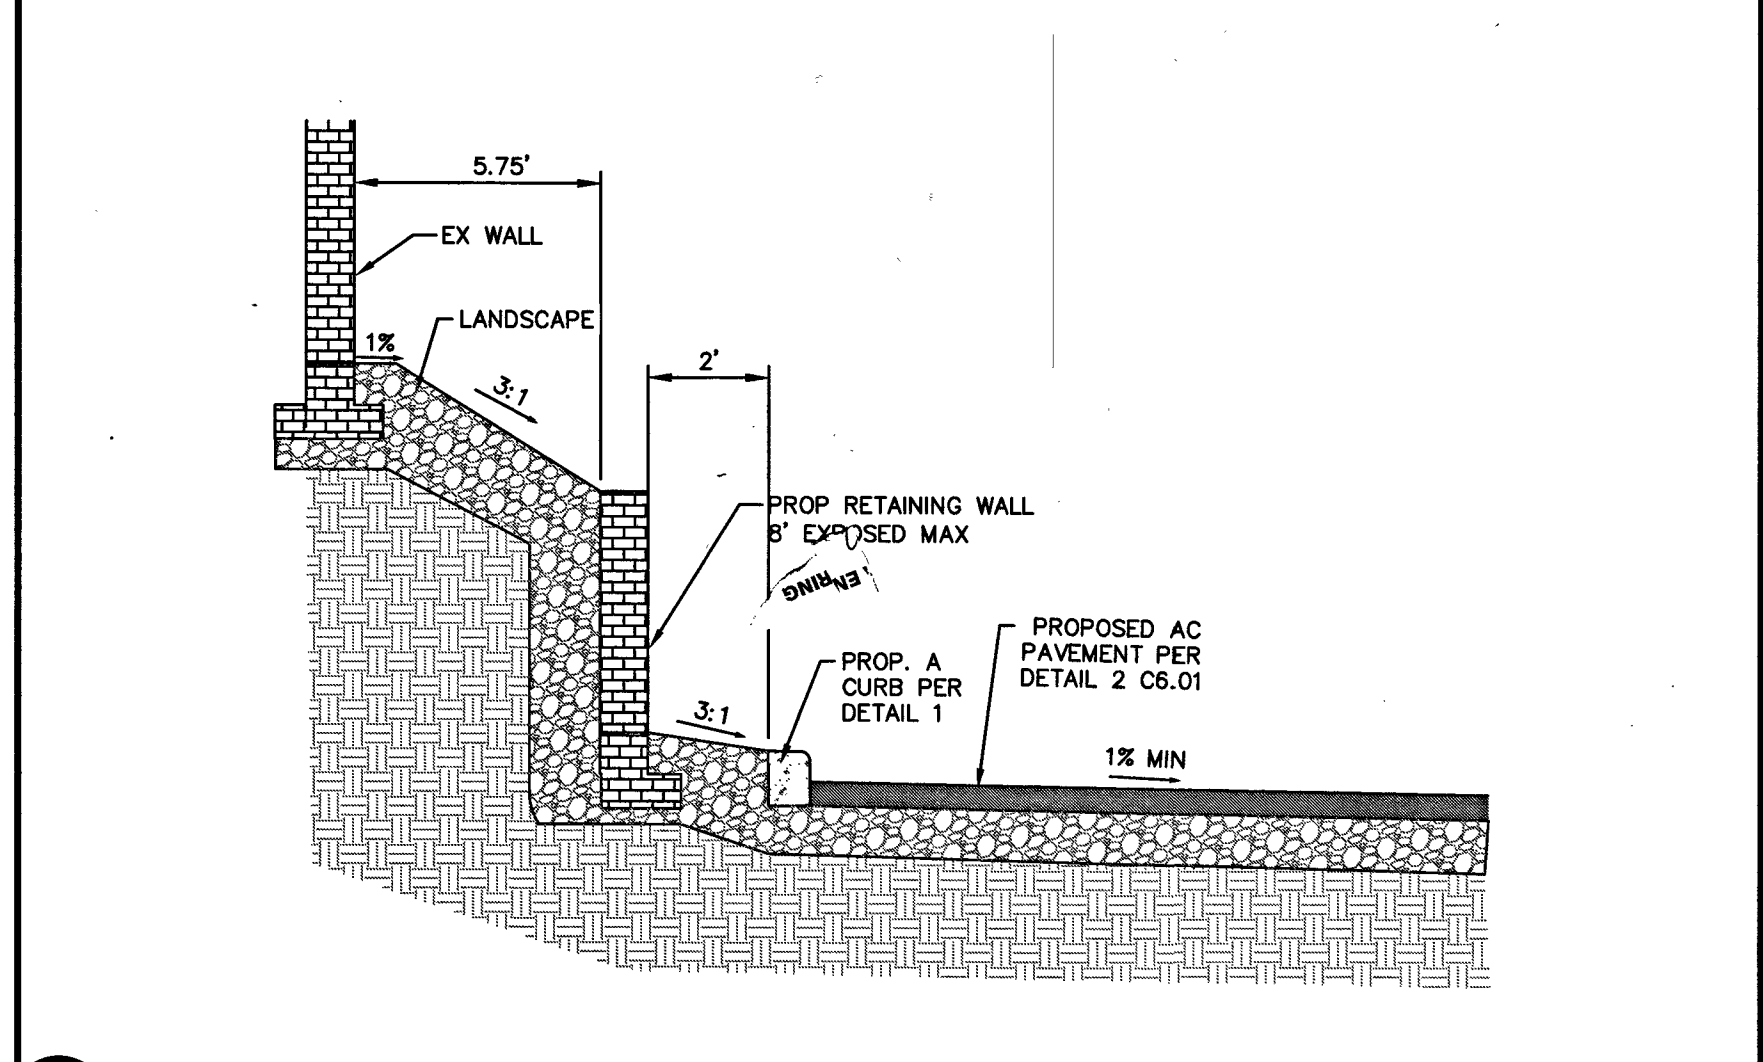


16 SECTION THROUGH WESTSIDE PARKING NOT TO SCALE

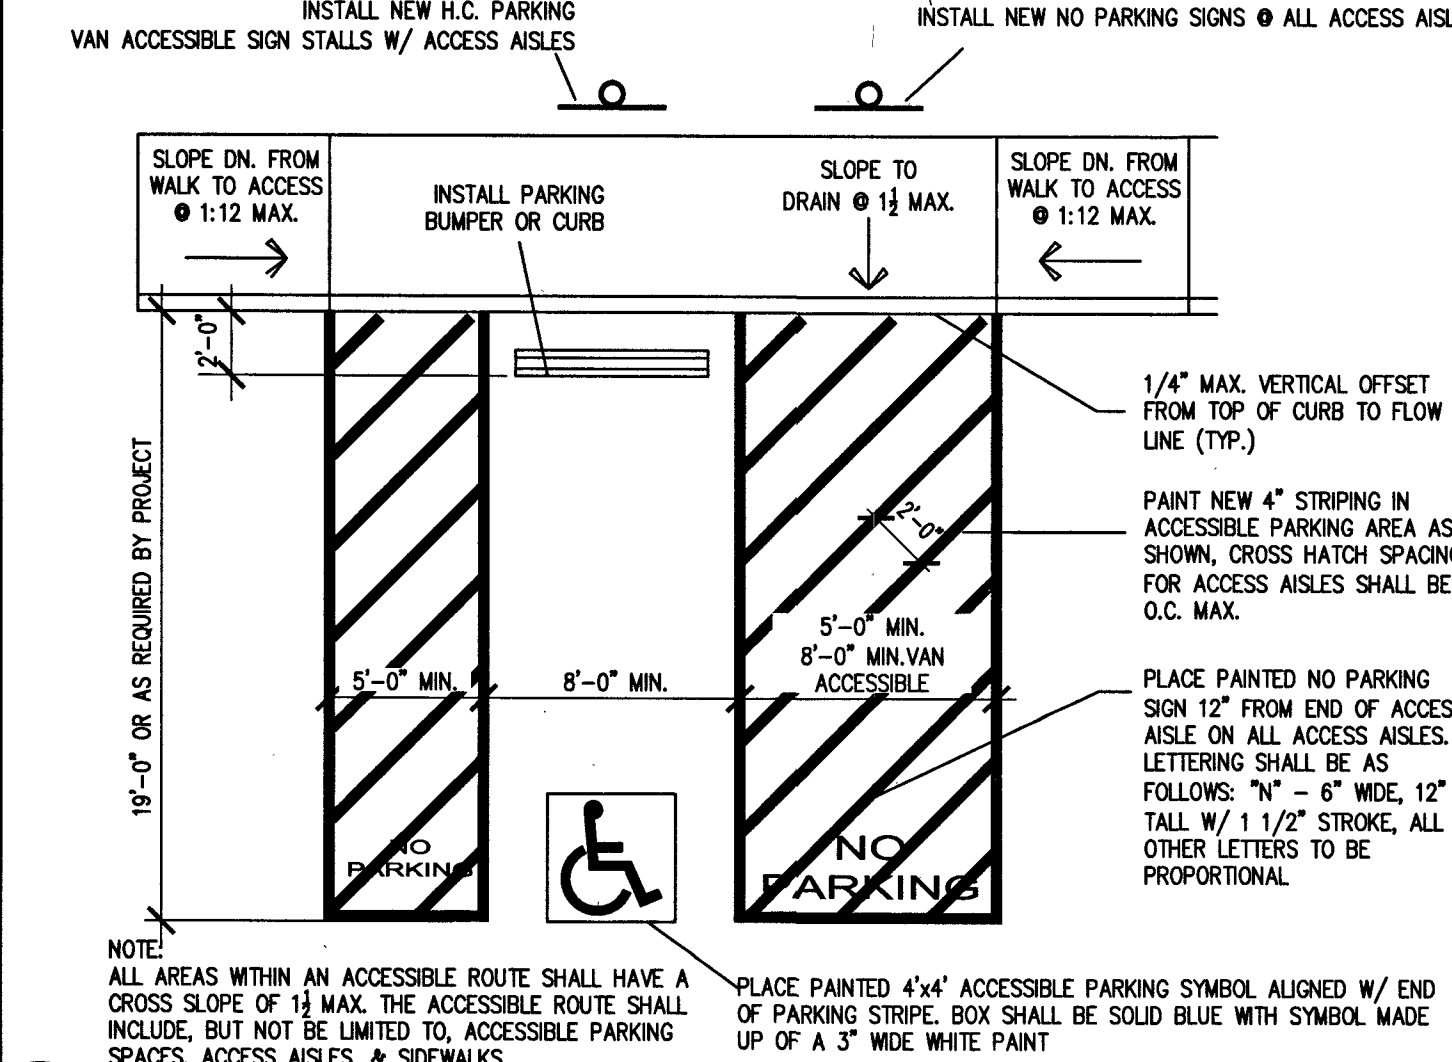


9 ACCESSIBLE PARKING DETAIL NOT TO SCALE

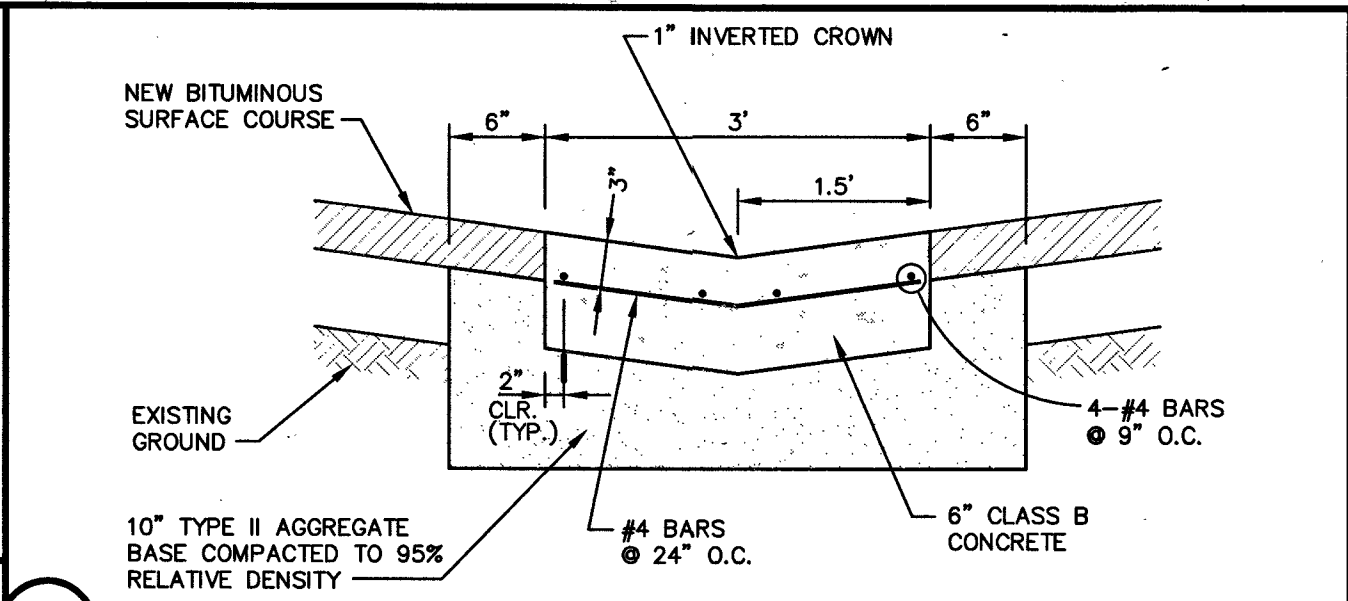


10 3' VALLEY GUTTER

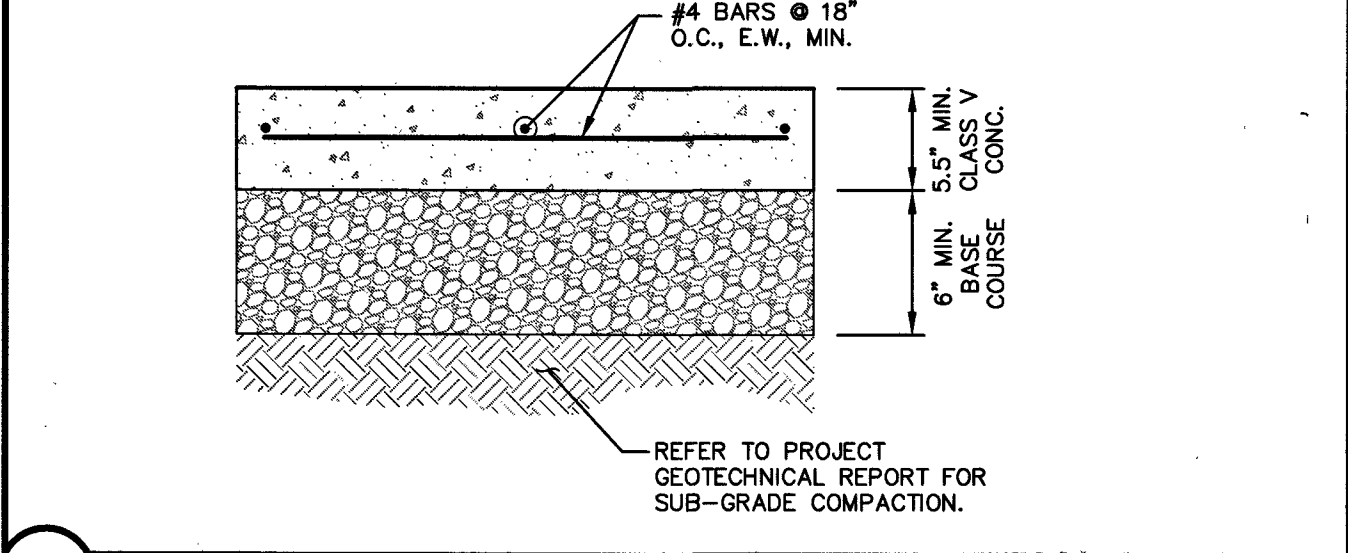


8 CONCRETE PAVEMENT SECTION (ON-SITE) NOT TO SCALE

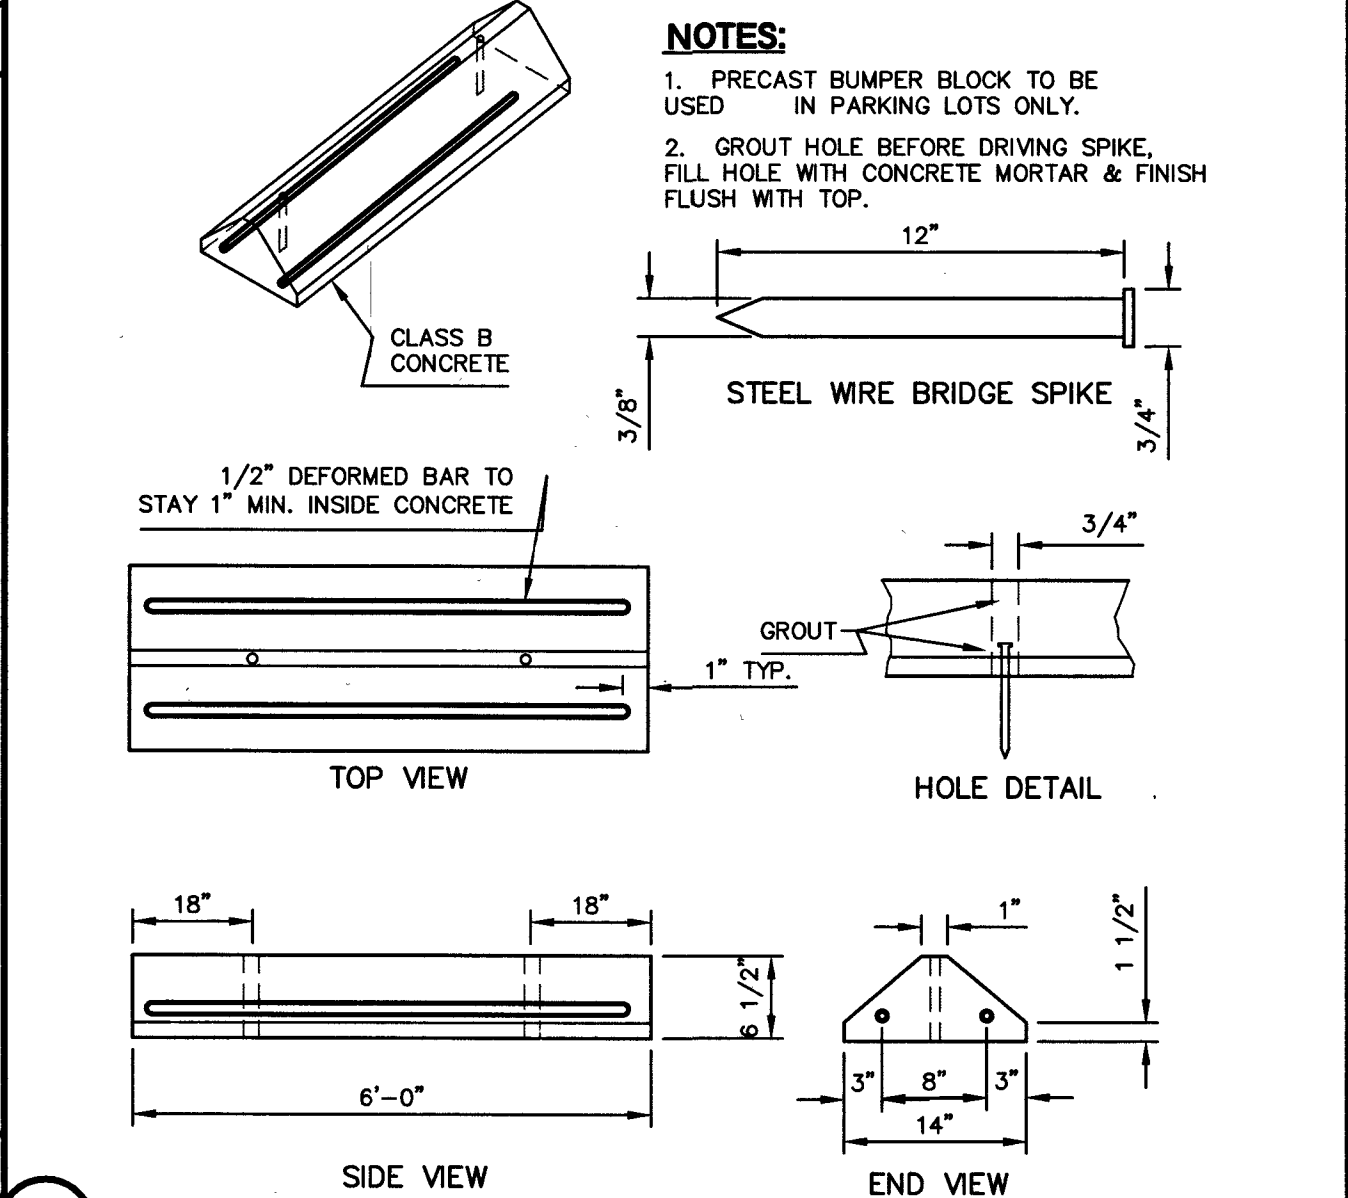


7 WHEEL STOP NOT TO SCALE

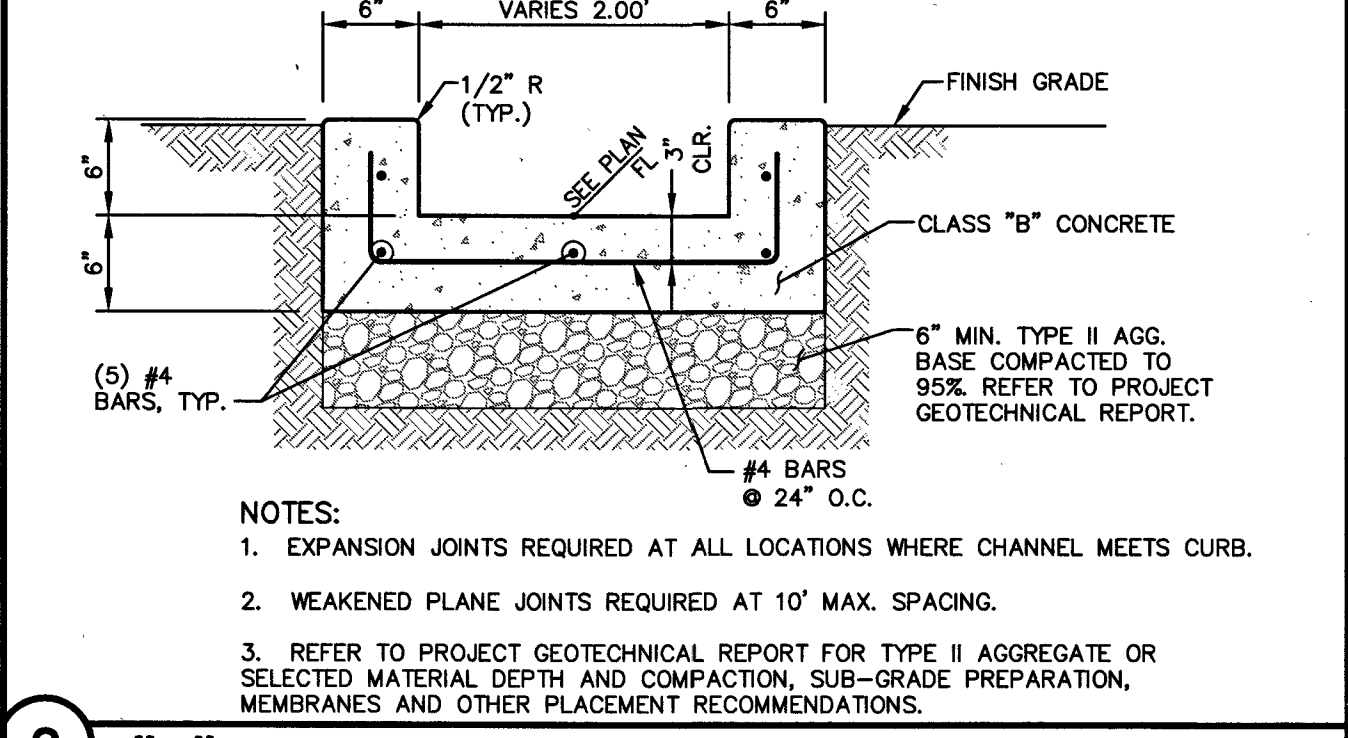


6 \"U\" CHANNEL NOT TO SCALE

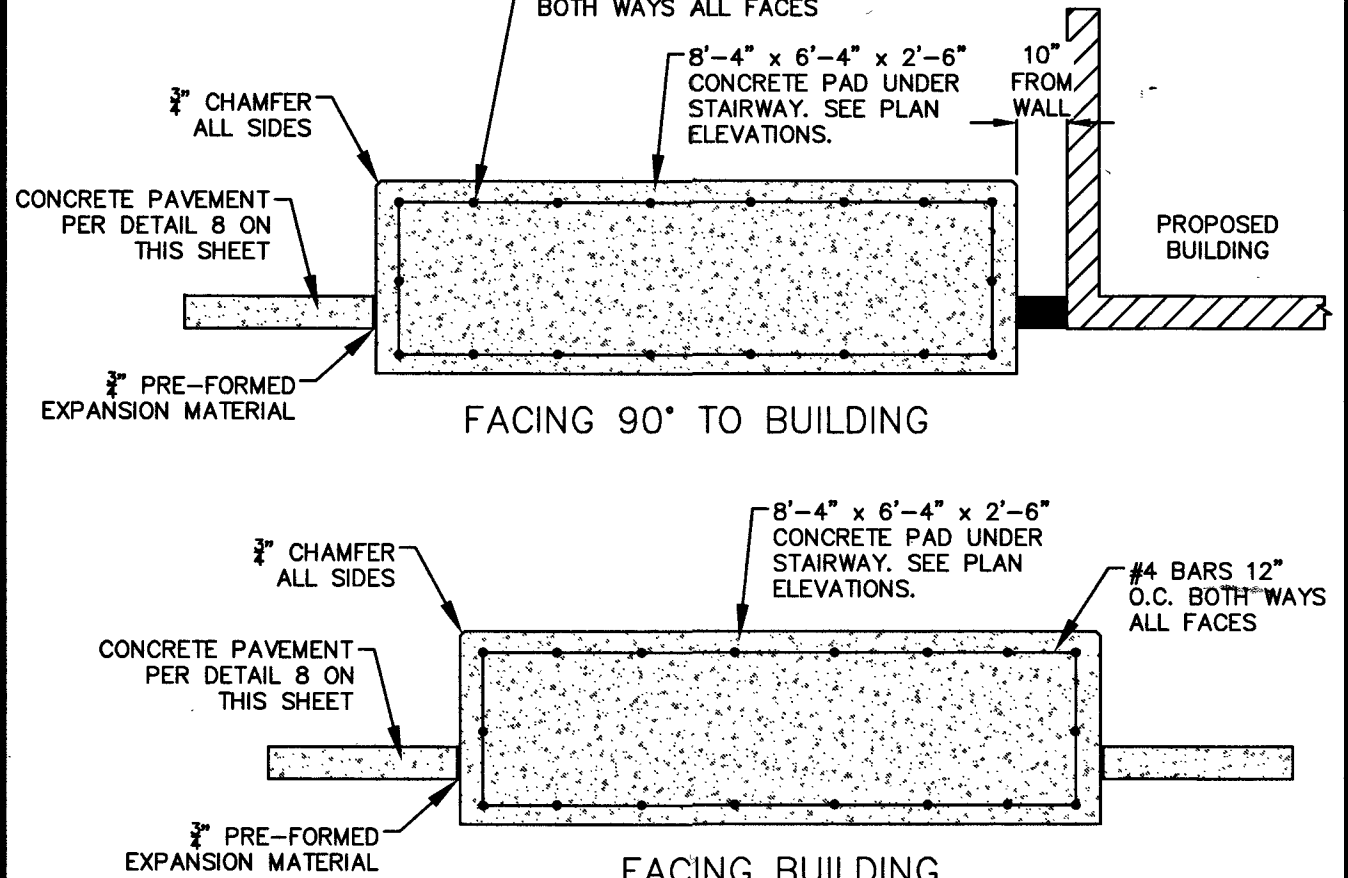


5 PROP. CONCRETE PAD UNDER STAIRWAY NOT TO SCALE

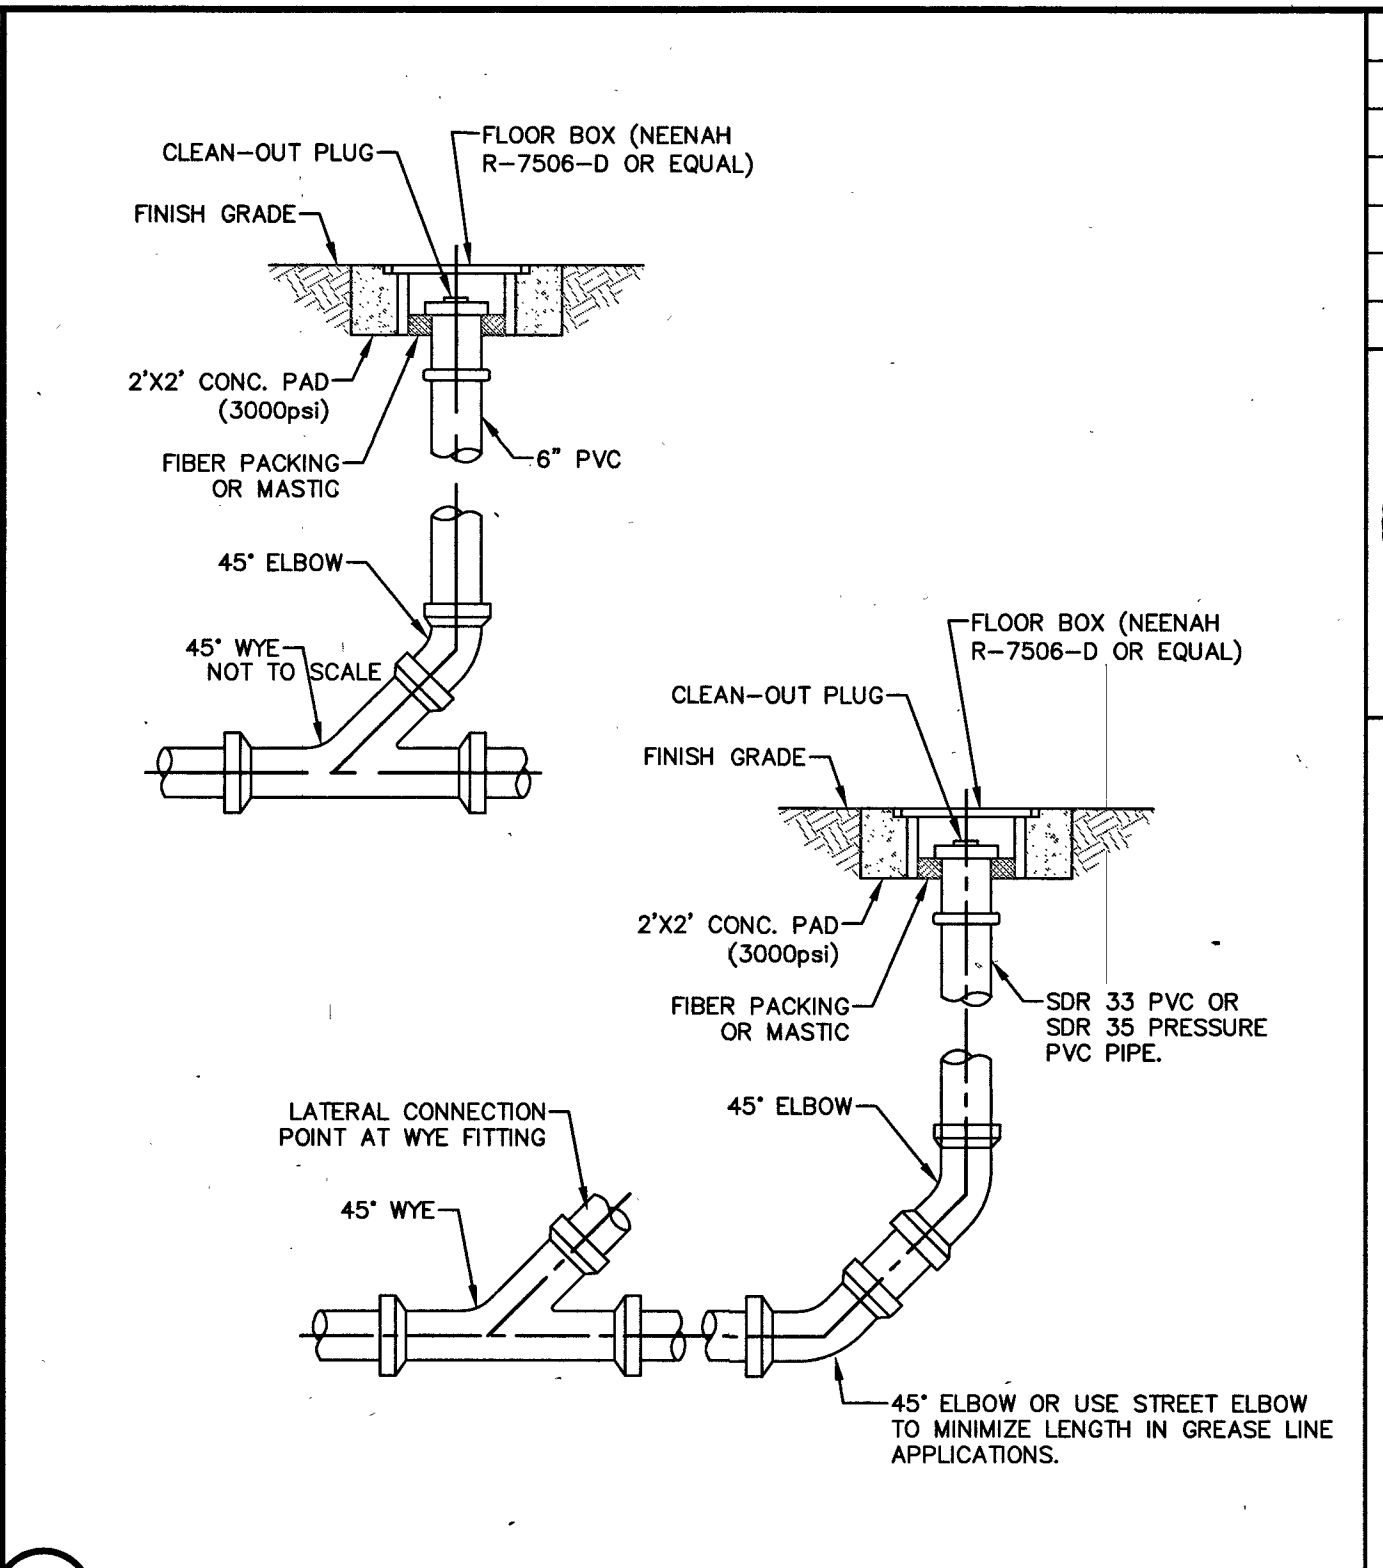


4 SEWER CLEAN-OUT NOT TO SCALE

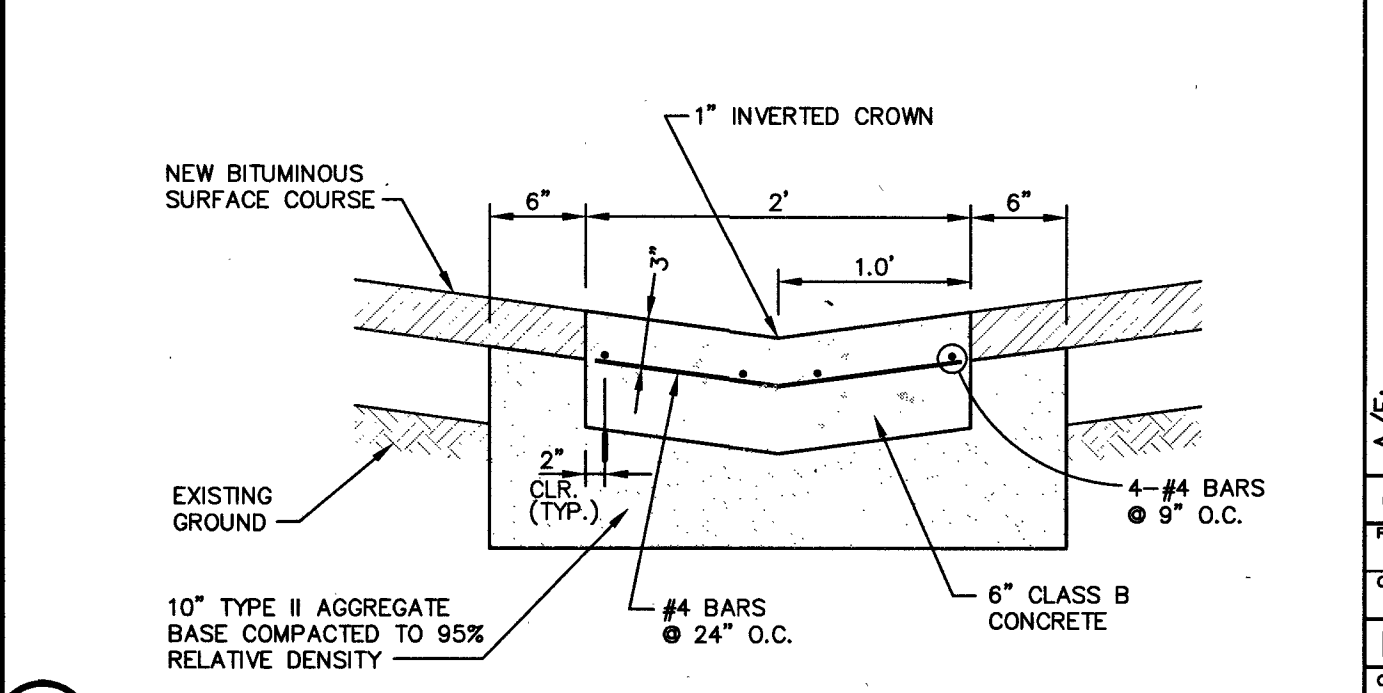

3 2' VALLEY GUTTER NOT TO SCALE

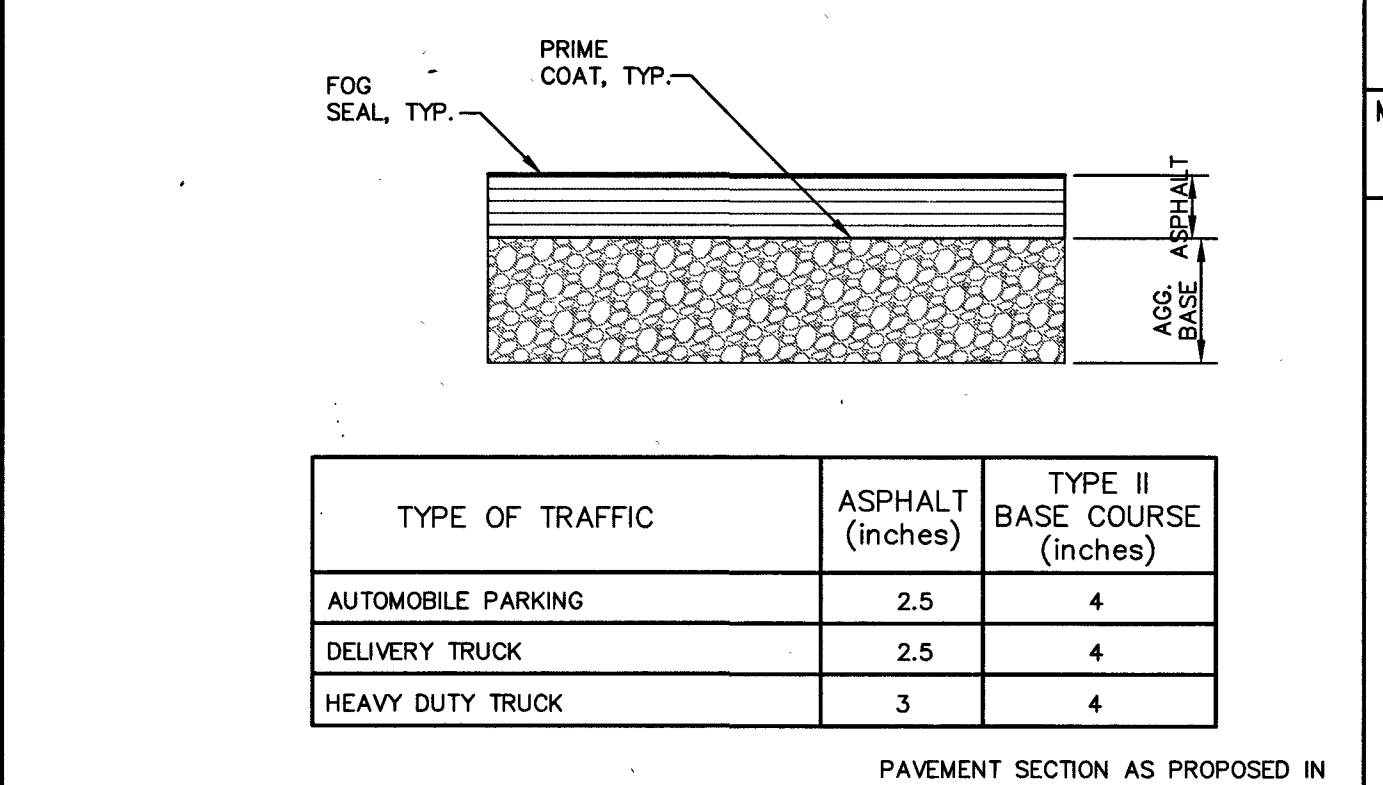

2 AC PAVEMENT SECTION NOT TO SCALE

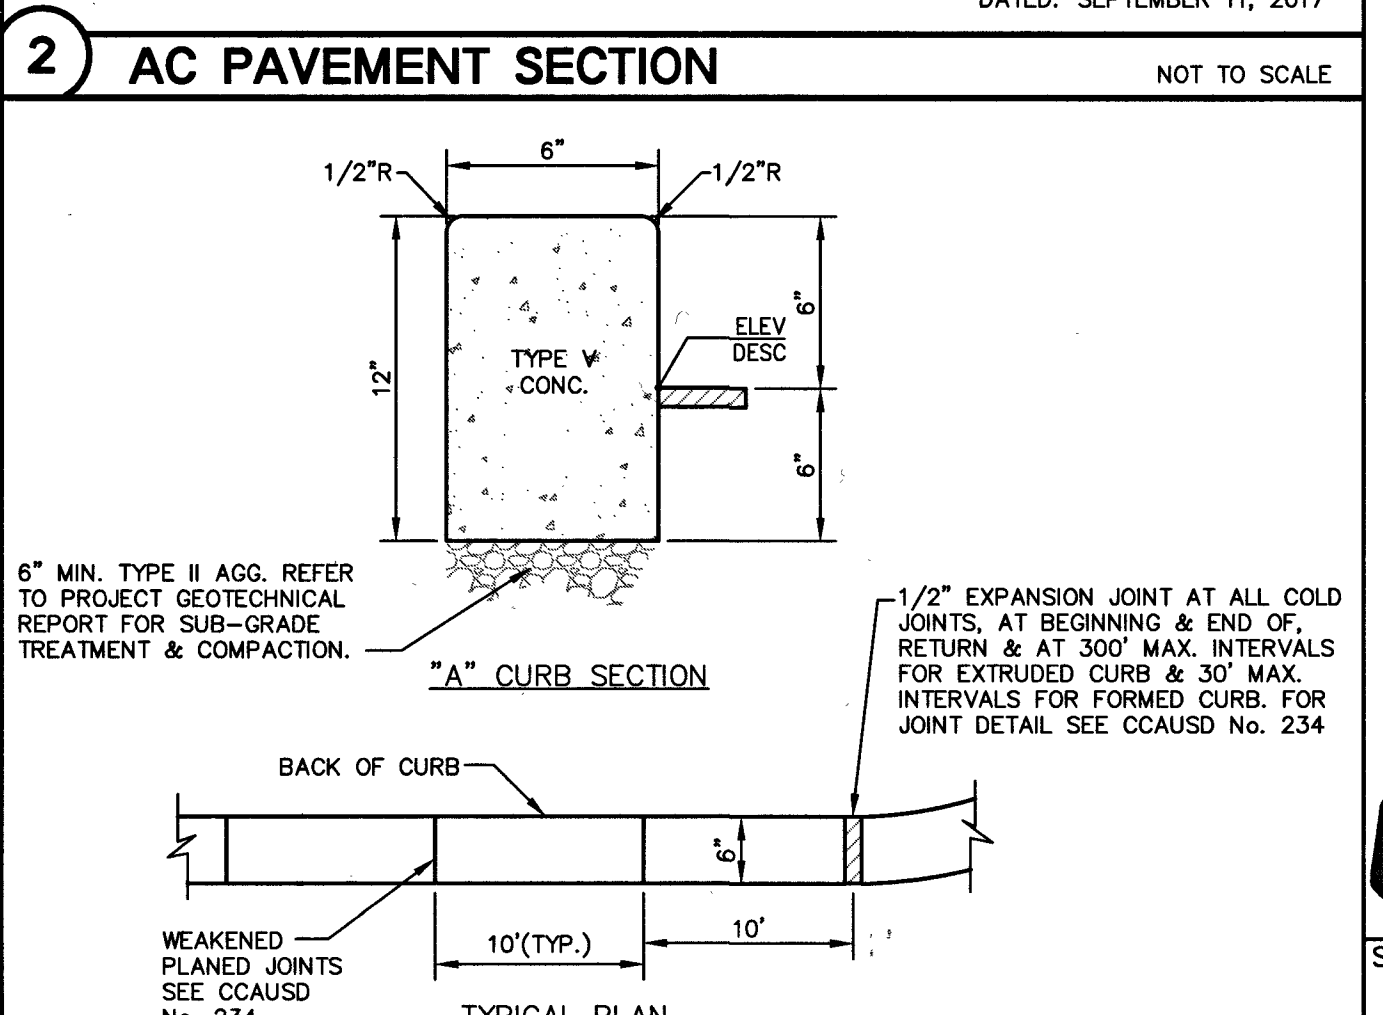

1 ON-SITE \"A\" TYPE CURB NOT TO SCALE

REVISIONS:

REV.	DESCRIPTION	DATE

SEAL:

CLARK COUNTY SCHOOL DISTRICT

ENGINEER

GUO M. MORRIS

EXP. 12-31-19

CIVIL

No. 14596

11/13/18

DATE

11/13/18

DRAWN BY

NMG

SUBMITTAL

MYLAR

PROJECT NO.

171058

3883 Howard Hughes Pkwy
Suite 650
Las Vegas, NV 89169
Tel: 702.893.2800
Fax: 702.893.2805

Gensler

CONSULTANT:

3883 Howard Hughes Pkwy
Suite 650
Las Vegas, NV 89169
Tel: 702.893.2800
Fax: 702.893.2805

Lochsa
engineering
6345 South Jones Blvd.
Suite 100
Las Vegas, NV 89118
Phone (702) 365-9312
Fax (702) 365-9317
www.lochsa.com

A/E:

CONSTRUCTION MGMT:

DATE:

COORDINATOR:

BUILDING DEPARTMENT:

CODE COMPLIANCE:

ASBESTOS WORK IS:

REQUIRED ☐ NOT REQUIRED ☐

MPID:

0013529

CLARK COUNTY SCHOOL DISTRICT

CONSTRUCTION MANAGEMENT 1180 MILITARY TRIBUTE PL. HENDERSON NV 89074 PHONE: 702-799-9710

PROJECT:

JOHN W. BONNER E.S. ADDITION

DRAWING TITLE:

DETAIL SHEETS SHEET 1 OF 3

FACILITY:

 
 





JOHN W. BONNER E.S. - LOCATION 309

SHEET NO:


C6.01

715-210


SHEET 8 OF 15 L18-02468

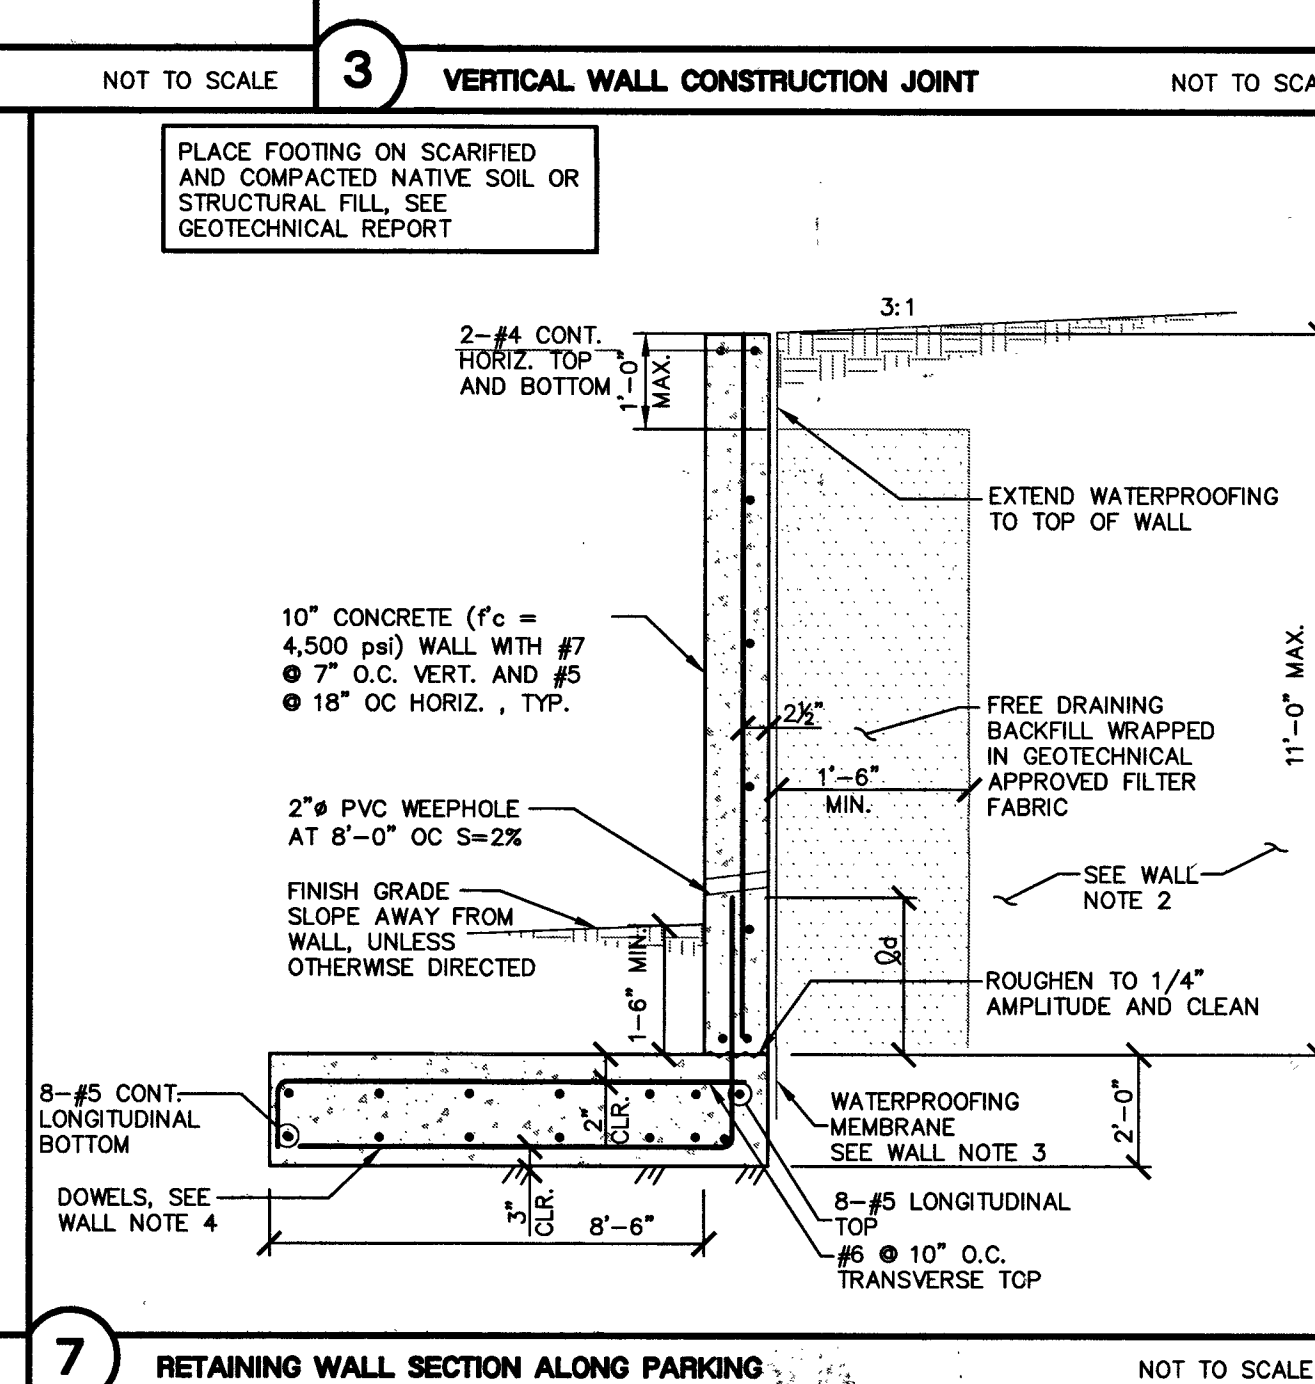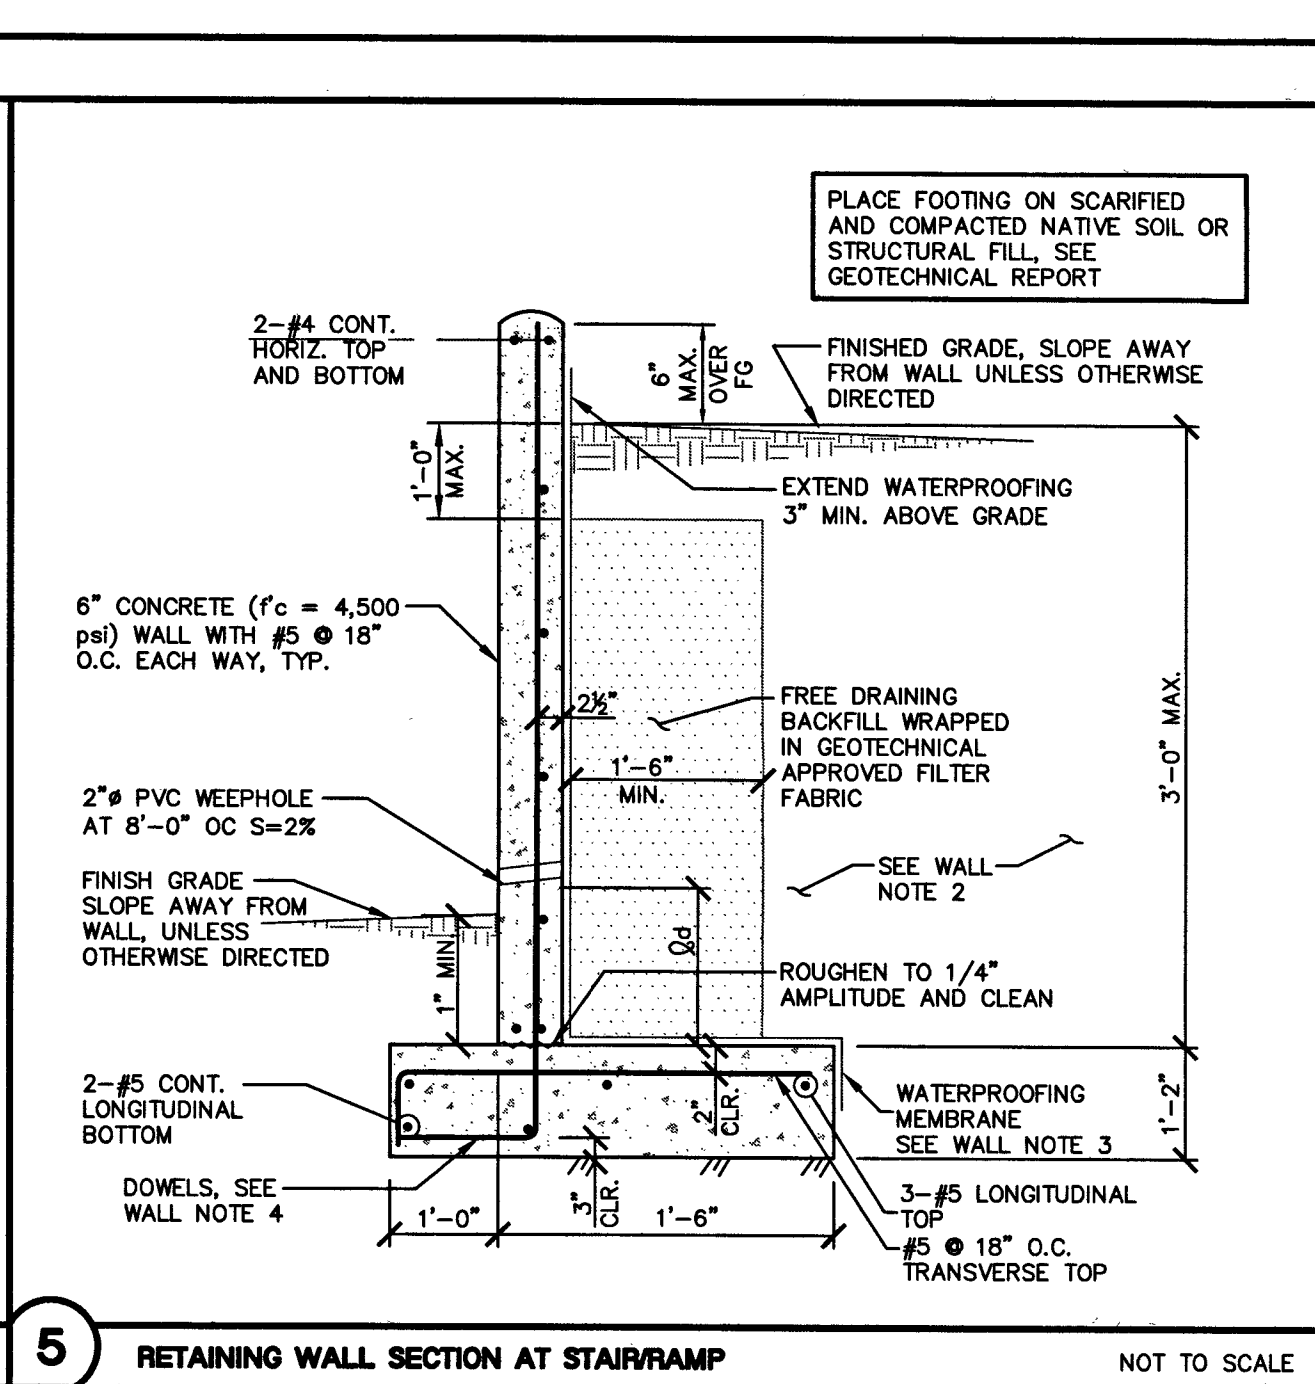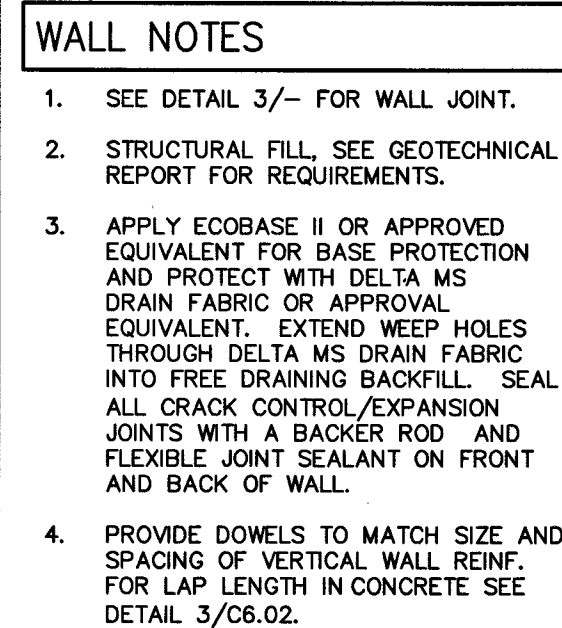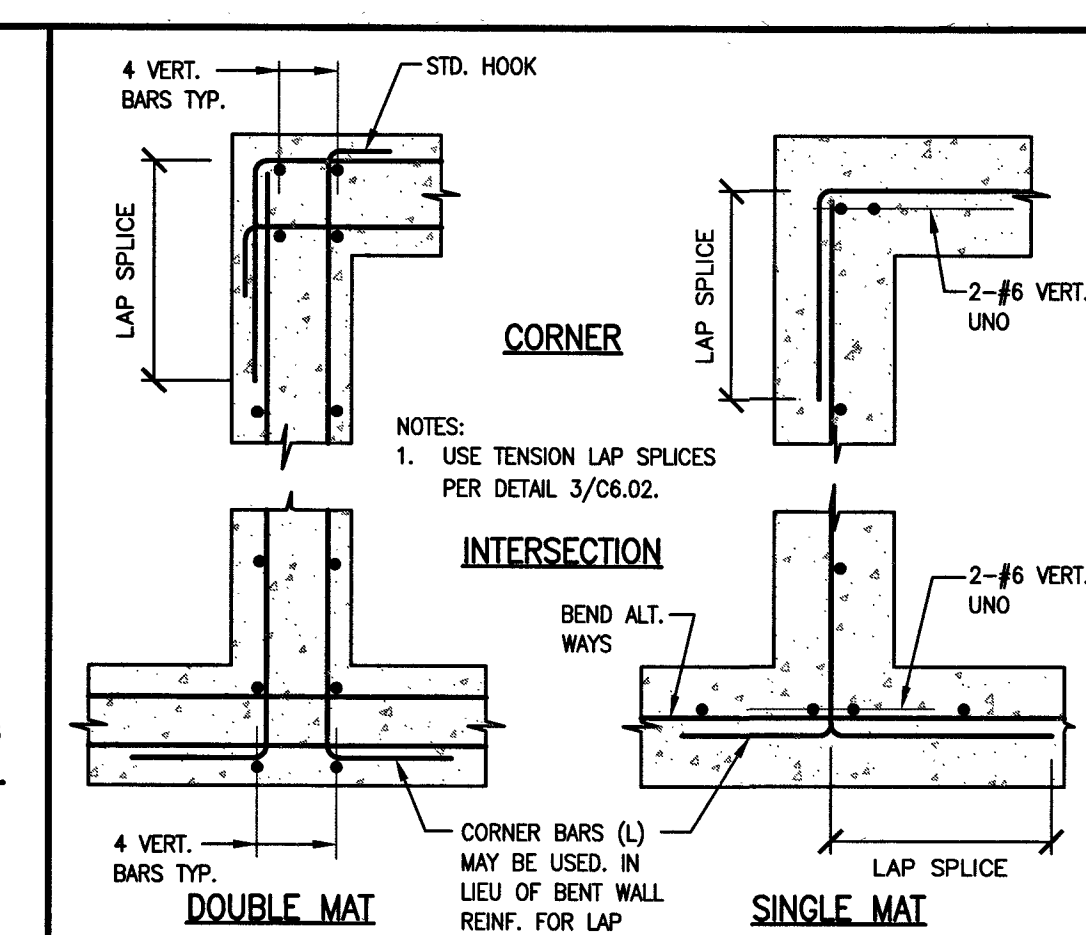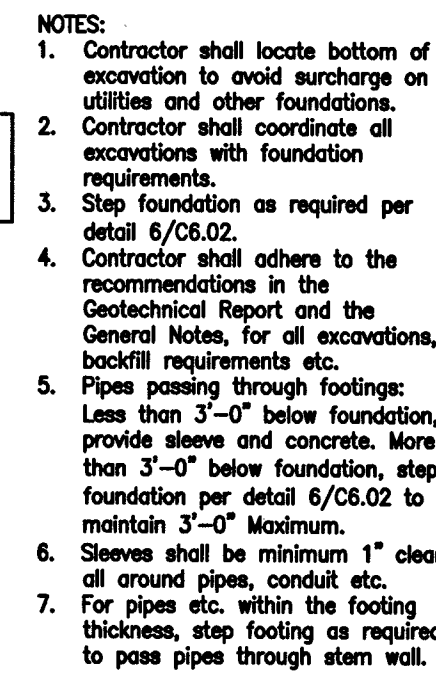

REVISIONS:					
REV.	DESCRIPTION				DATE:
SEAL:	GUY M. MORRIS EXP. 12-31-18 CIVIL No. 14526 11/13/18		DATE:	DRAWN BY:	SUBMITTAL:
A/E:			11/13/18	NMC	MYLAR
					171058
3883 Howard Hughes Pkwy Suite 650 Las Vegas NV 89169 Tel: 702.893.2800 Fax: 702.893.2805 Gensler			 Lochsa engineering 6345 South Jones Blvd. Suite 100 Las Vegas, NV 89118 Phone (702) 365-6312 Fax (702) 365-6317 www.lochsa.com		
CONSULTANT:					
CONSTRUCTION MGMT:				DATE:	
PROJECT MANAGER:					
COORDINATOR:					
BUILDING DEPARTMENT:					
CODE COMPLIANCE:					
AHERA REVIEW:					
ASBESTOS WORK IS:					
REQUIRED ☐ NOT REQUIRED ☐					
MPID:					
0013529					
CLARK COUNTY SCHOOL DISTRICT CONSTRUCTION MANAGEMENT DEPARTMENT 1180 MILITARY TRIBUTE PL HENDERSON NY 89074 PHONE: 702-799-8710					
PROJECT: JOHN W. BONNER E.S. ADDITION					
DRAWING TITLE: DETAIL SHEETS SHEET 3 OF 3					
FACILITY: JOHN W. BONNER E.S. - LOCATION 309					
SHEET NO: C6.03 SHEET 100F 15 L18--0246B					

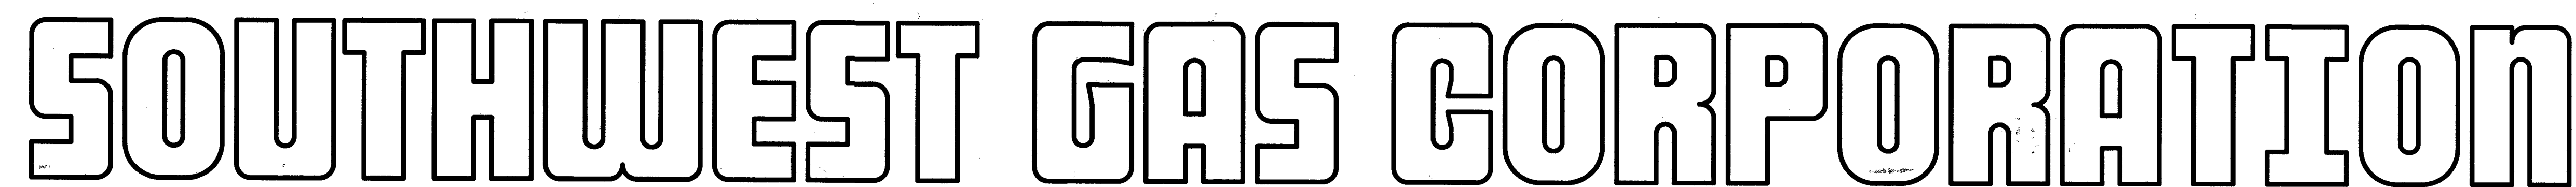

BONNER ES ADDITION
CITY OF LAS VEGAS
WR #3486151

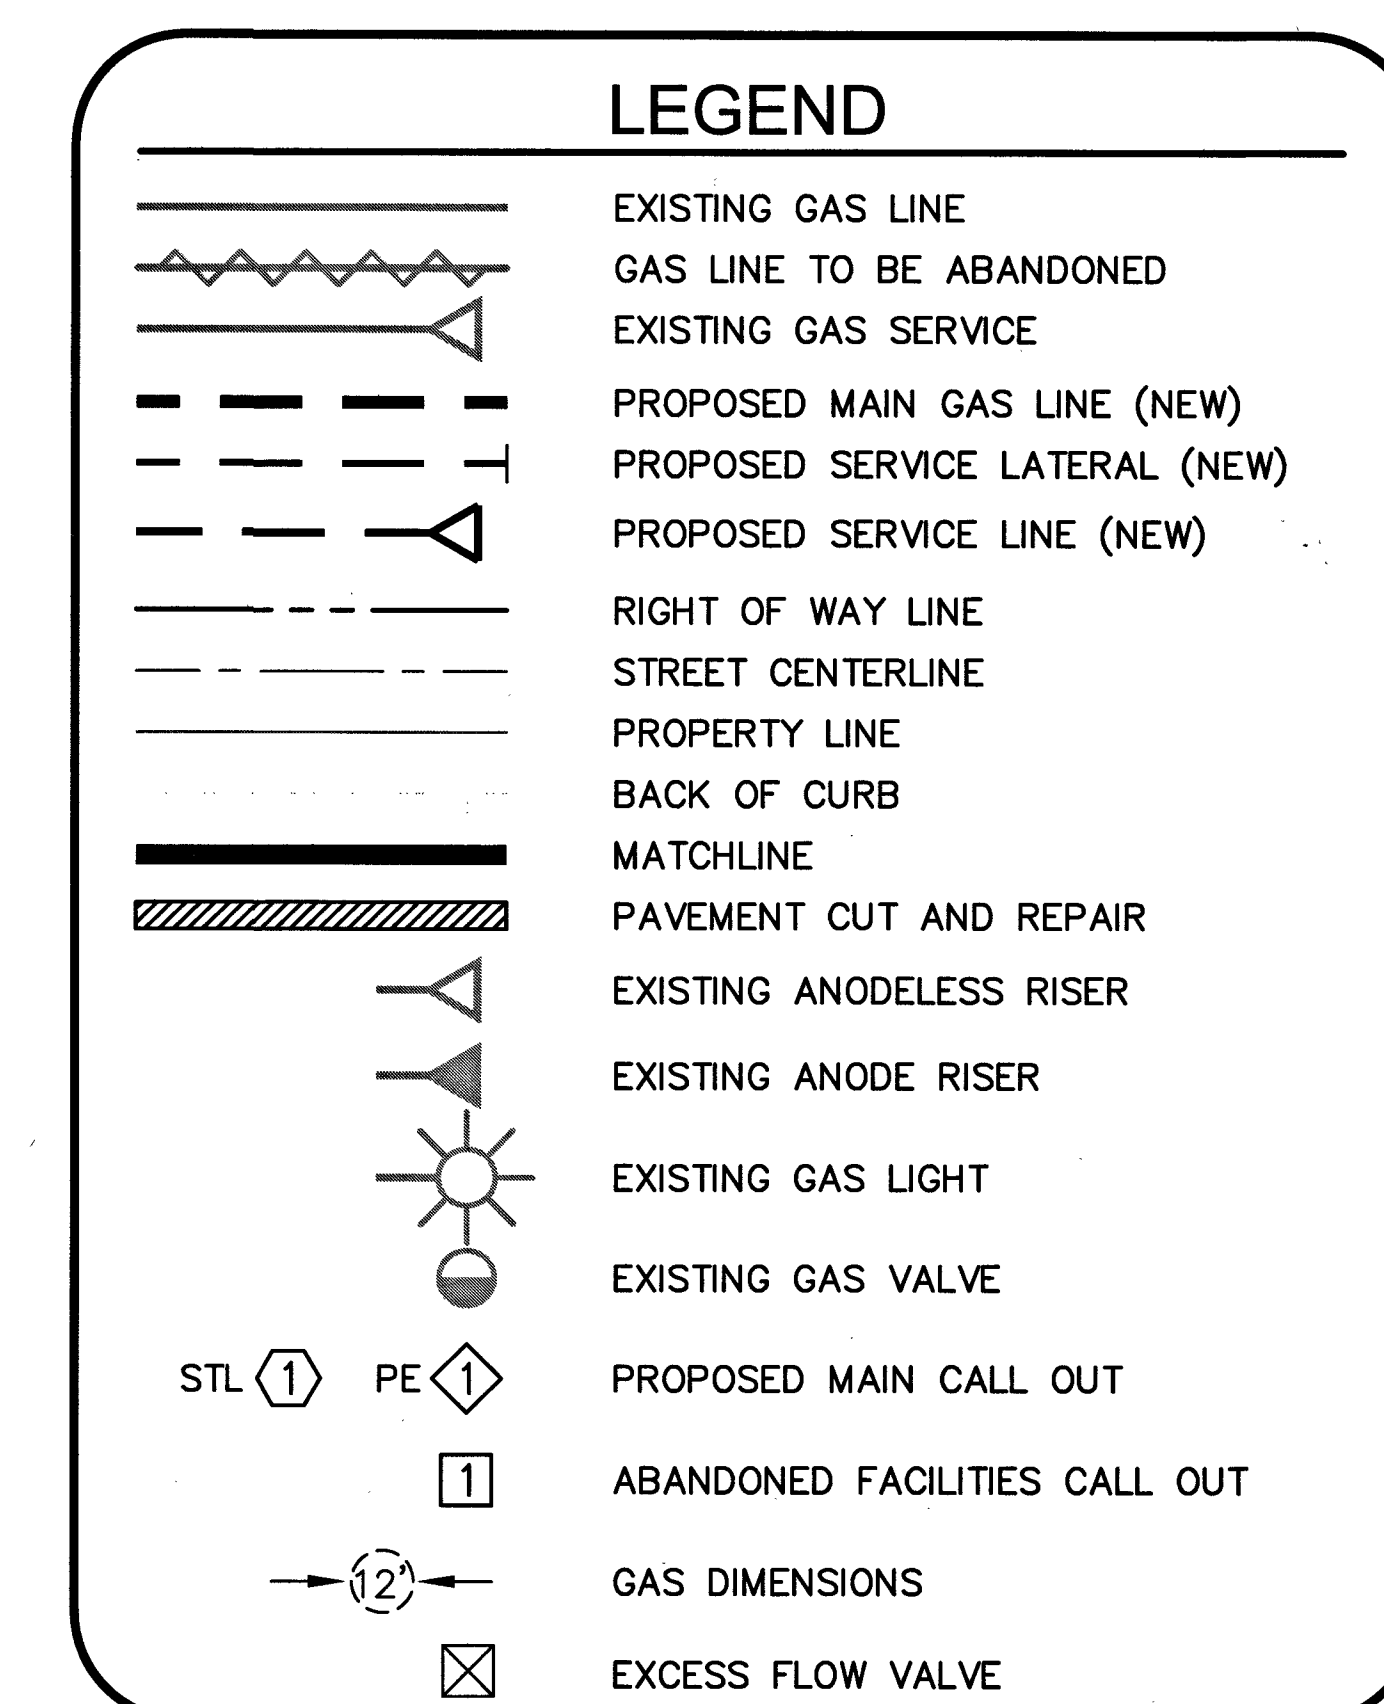

SHEET INDEX

1. COVER SHEET
2. ABBREVIATIONS & NOTES
3. MATERIALS & SIGNATURES
4. DESIGN PLAN
5. TYPICAL SWPPP BMP DETAILS






CUSTOMERS 1


[illegible]

SHEET 1 OF 5

DOC_3486151

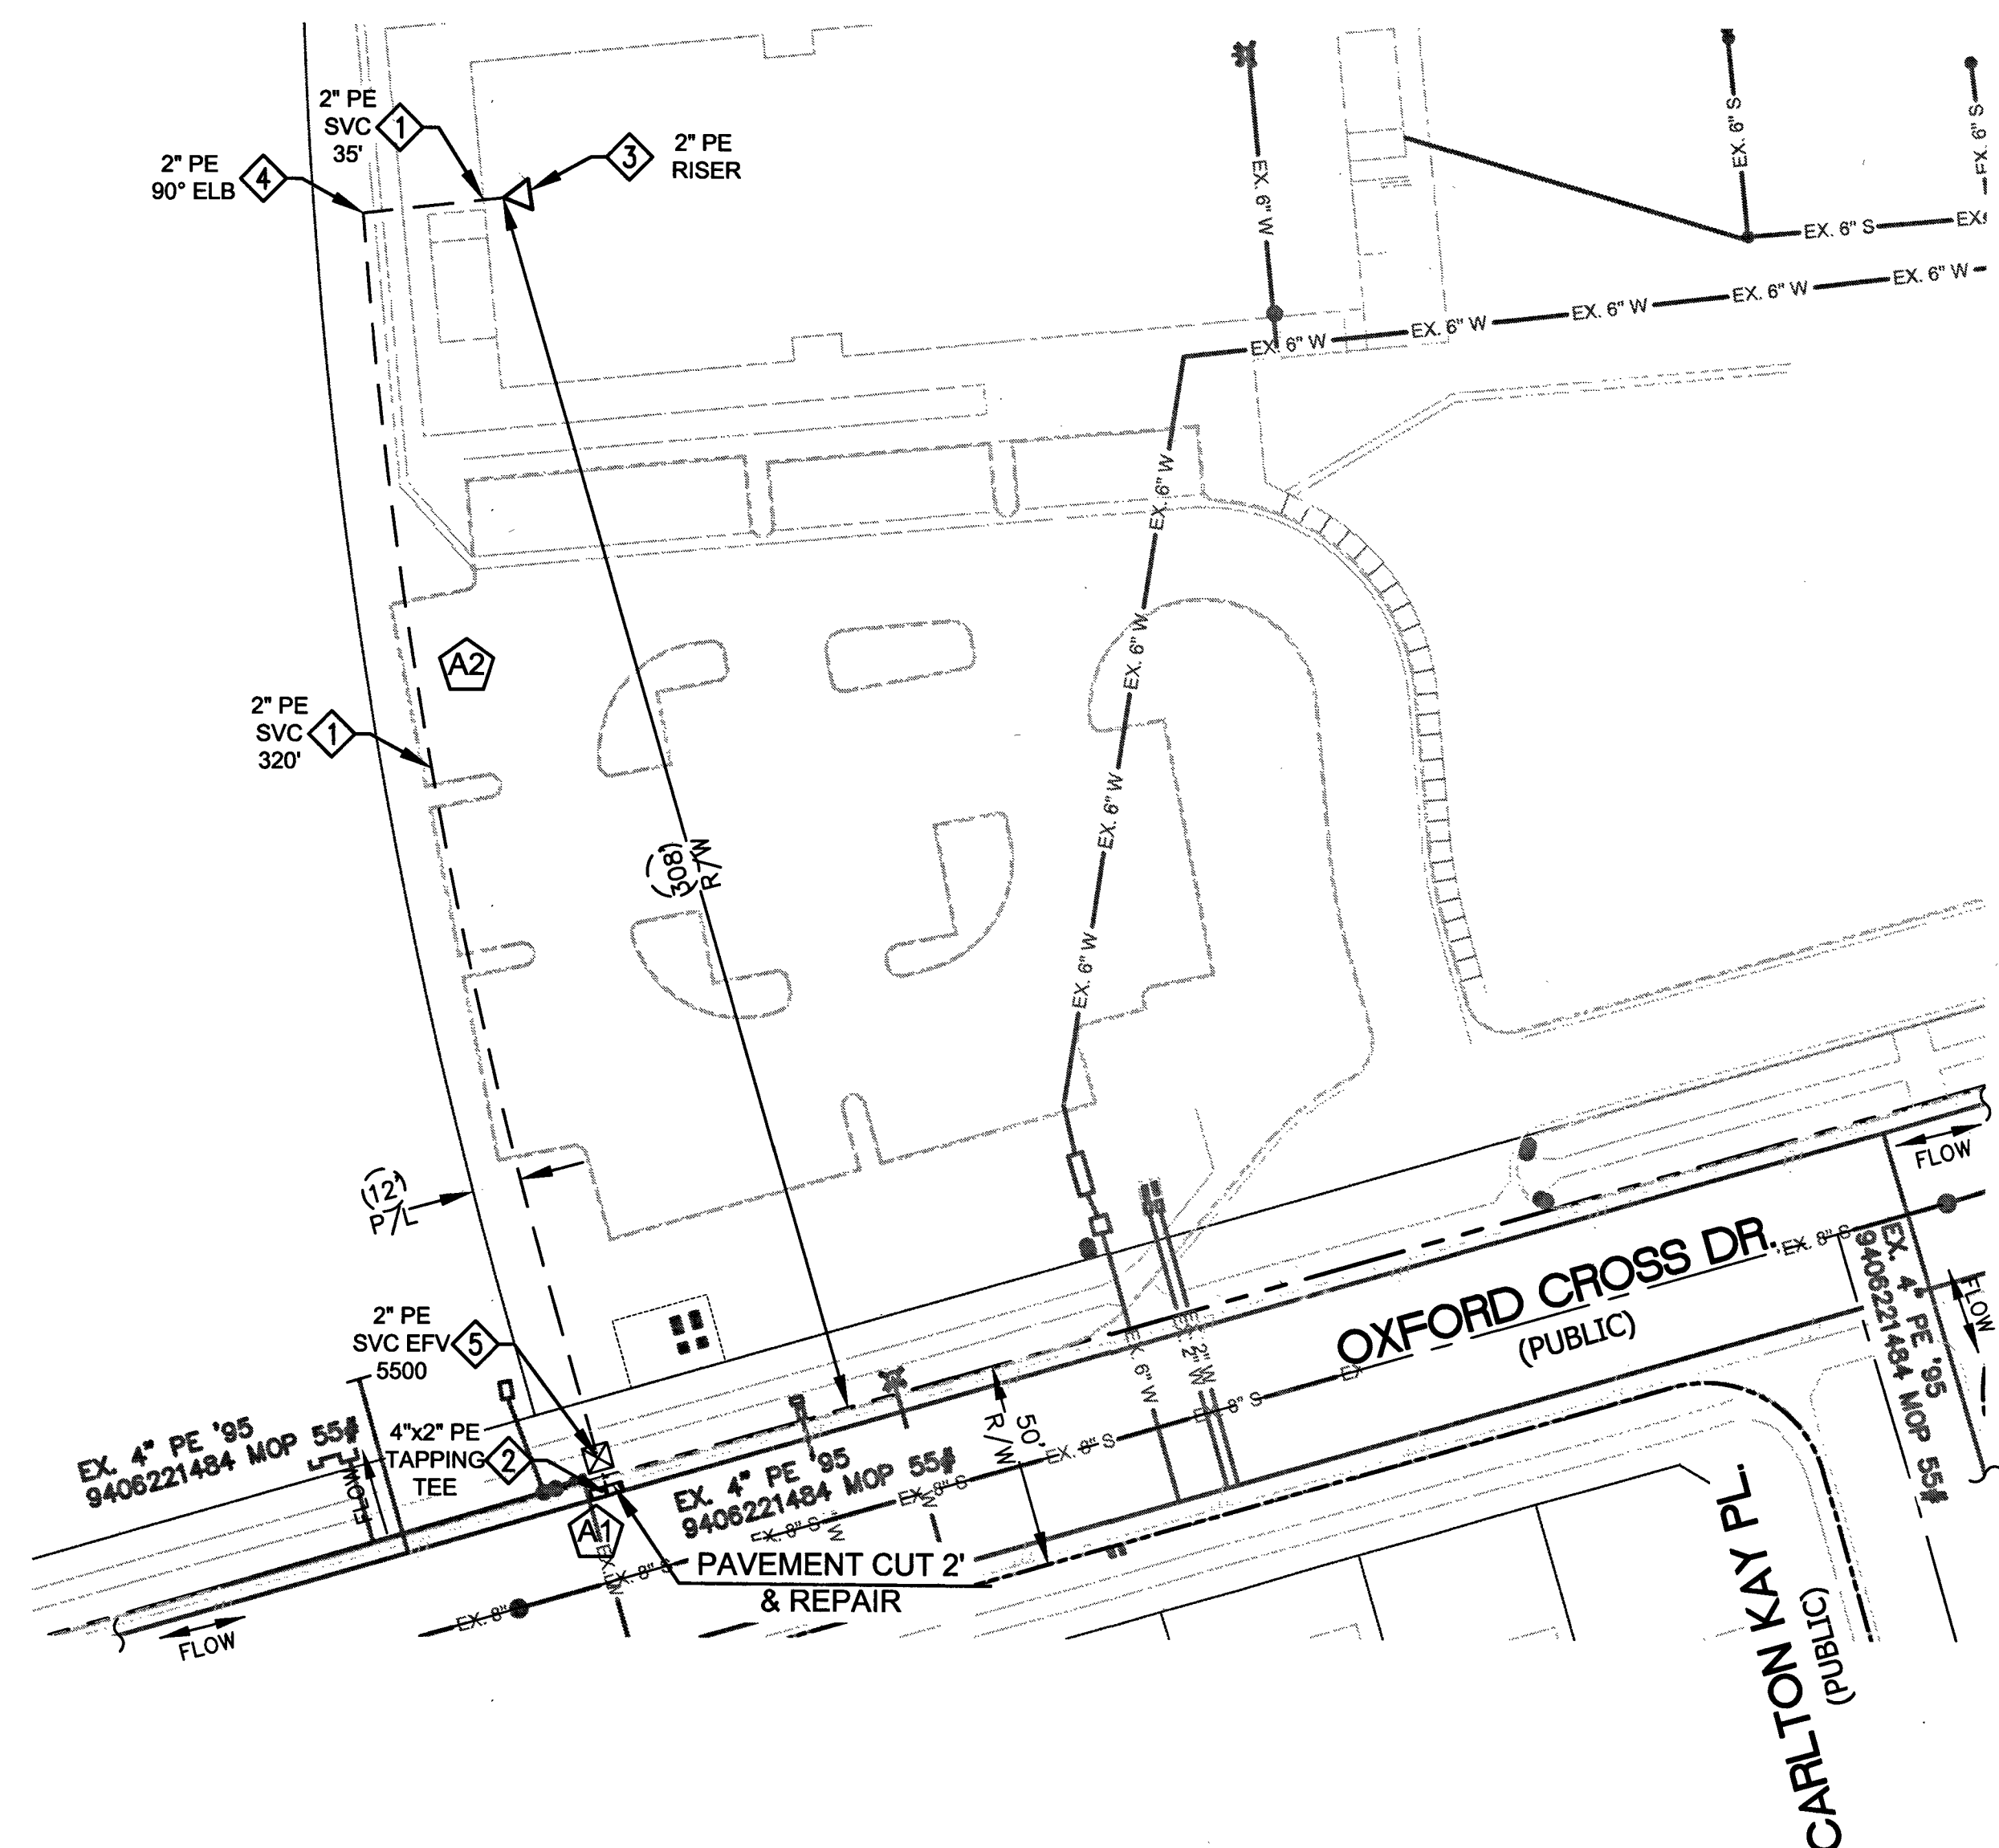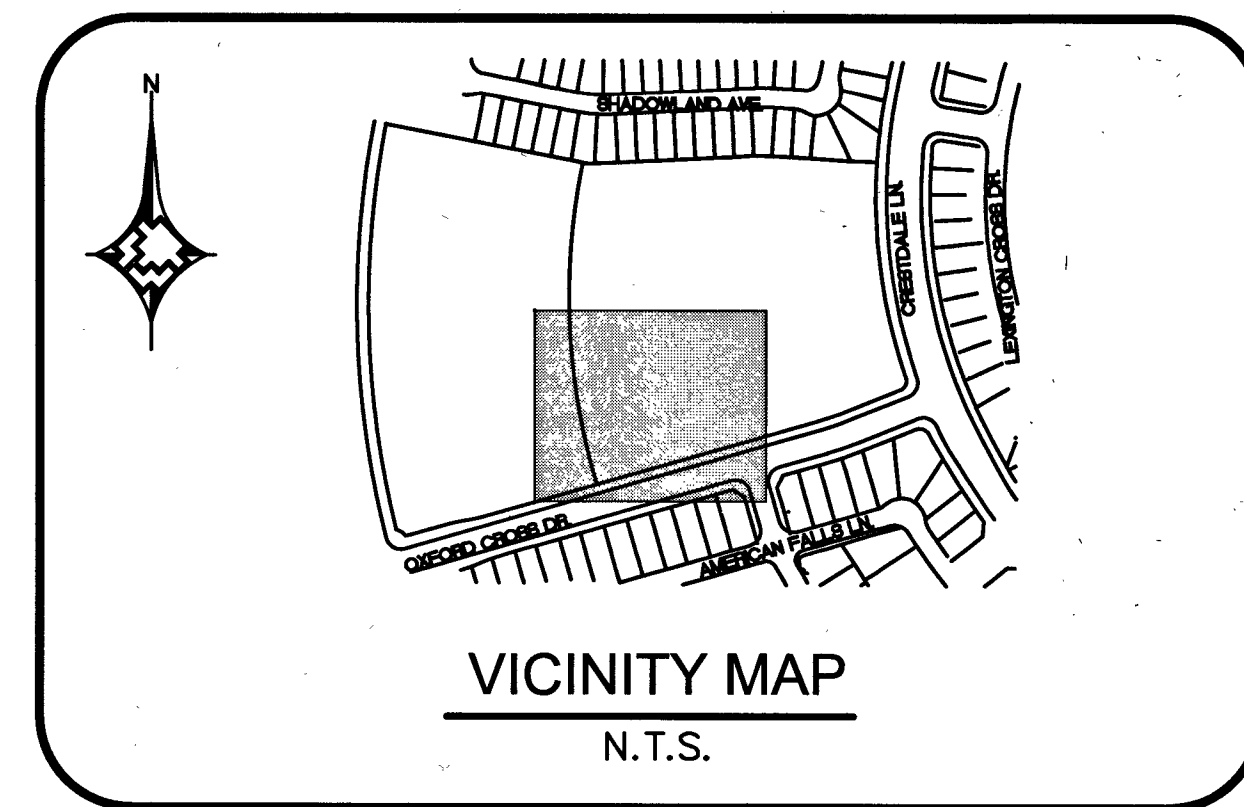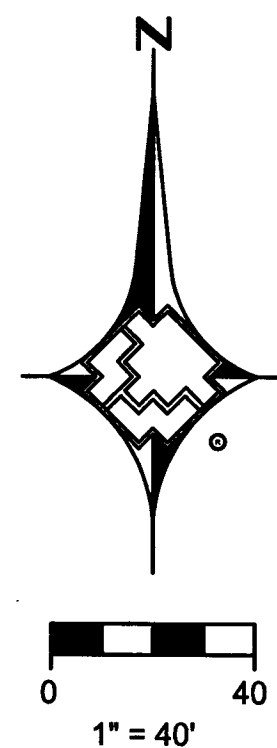


MATERIAL LIST FOR PROPOSED DISTRIBUTION FACILITIES		
ITEM#	STOCK ID#	DESCRIPTION
1	100-5101	PROPOSED 2" PE SERVICE
2	160-8174	PROPOSED 4"x2" PE TAPPING TEE
3	161-7661	PROPOSED 2" PE RISER
4	140-3067	PROPOSED 2" PE ELBOW 90°
5	160-8403	PROPOSED 2" PE EFV COUPLING (5500)

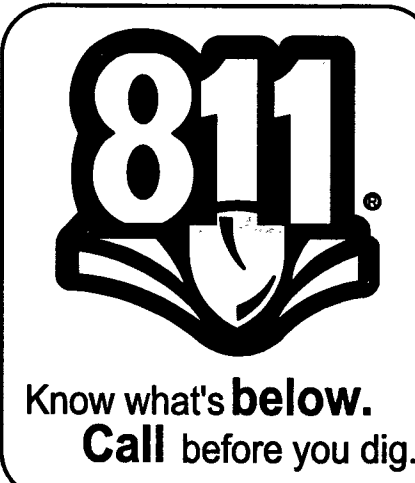


RTC NOTES:
PAVEMENT REPAIR SHALL CONFORM TO RTC:
A1 500.4
A2 503

1. 2. 3. 4.								AS-BUILT DRAWING-PRESSURE TEST DATA PIPE DIA. PIPE LENGTH PIPE TYPE MIN. DURATION TEST MEDIUM TEST METHOD TEST PRES. (PSIG) TIME DATE PERFORMED BY				VISUAL INSPECTION CERTIFICATION I HAVE VISUALLY INSPECTED ALL HEATED FUSIONS, SOLVENT CEMENT, MECHANICAL JOINTS, AND WELDS THAT I HAVE PERFORMED NAME DATE AS-BUILTS ACCEPTED BY POSTED BY POSTING QCD BY				CONSTRUCTION INSPECTOR FOREMAN REVIEWED BY PERMIT INFORMATION CITY OF LAS VEGAS 02-0200				ISOLATION AREA ISO_21 DIST_299 LOCATION SEC 25 T20S R59E M.D.M.		W.R. NO. 3486151 ATLAS #/TILE # x576y520		ENGINEER/TECHNICIAN DAVID FRIEDLANDER PHONE 702-365-2203 ACCOUNT REP. MICHAEL COOPER PHONE 702-365-2580 PROJECT CONTACT CHRIS FENTON PHONE 702-893-2868 SHEET NO. 4 OF 5 SCALE: 1"=40' DATE 12/01/2017 DWN. BY SEI CHKD. BY APPVD. BY			
REVISIONS NO. DESCRIPTION BY DATE APPVD.				TAX CODES UNIT NO. UNIT TYPE INSTL. RETIRED INSTL. RETIRED				PROPERTY UNITS PAVEMENT CUT 2' & REPAIR				BONNER ES ADDITION DESIGN PLAN SHEET 4 OF 5															


TYPICAL SWPPP BMP DETAILS

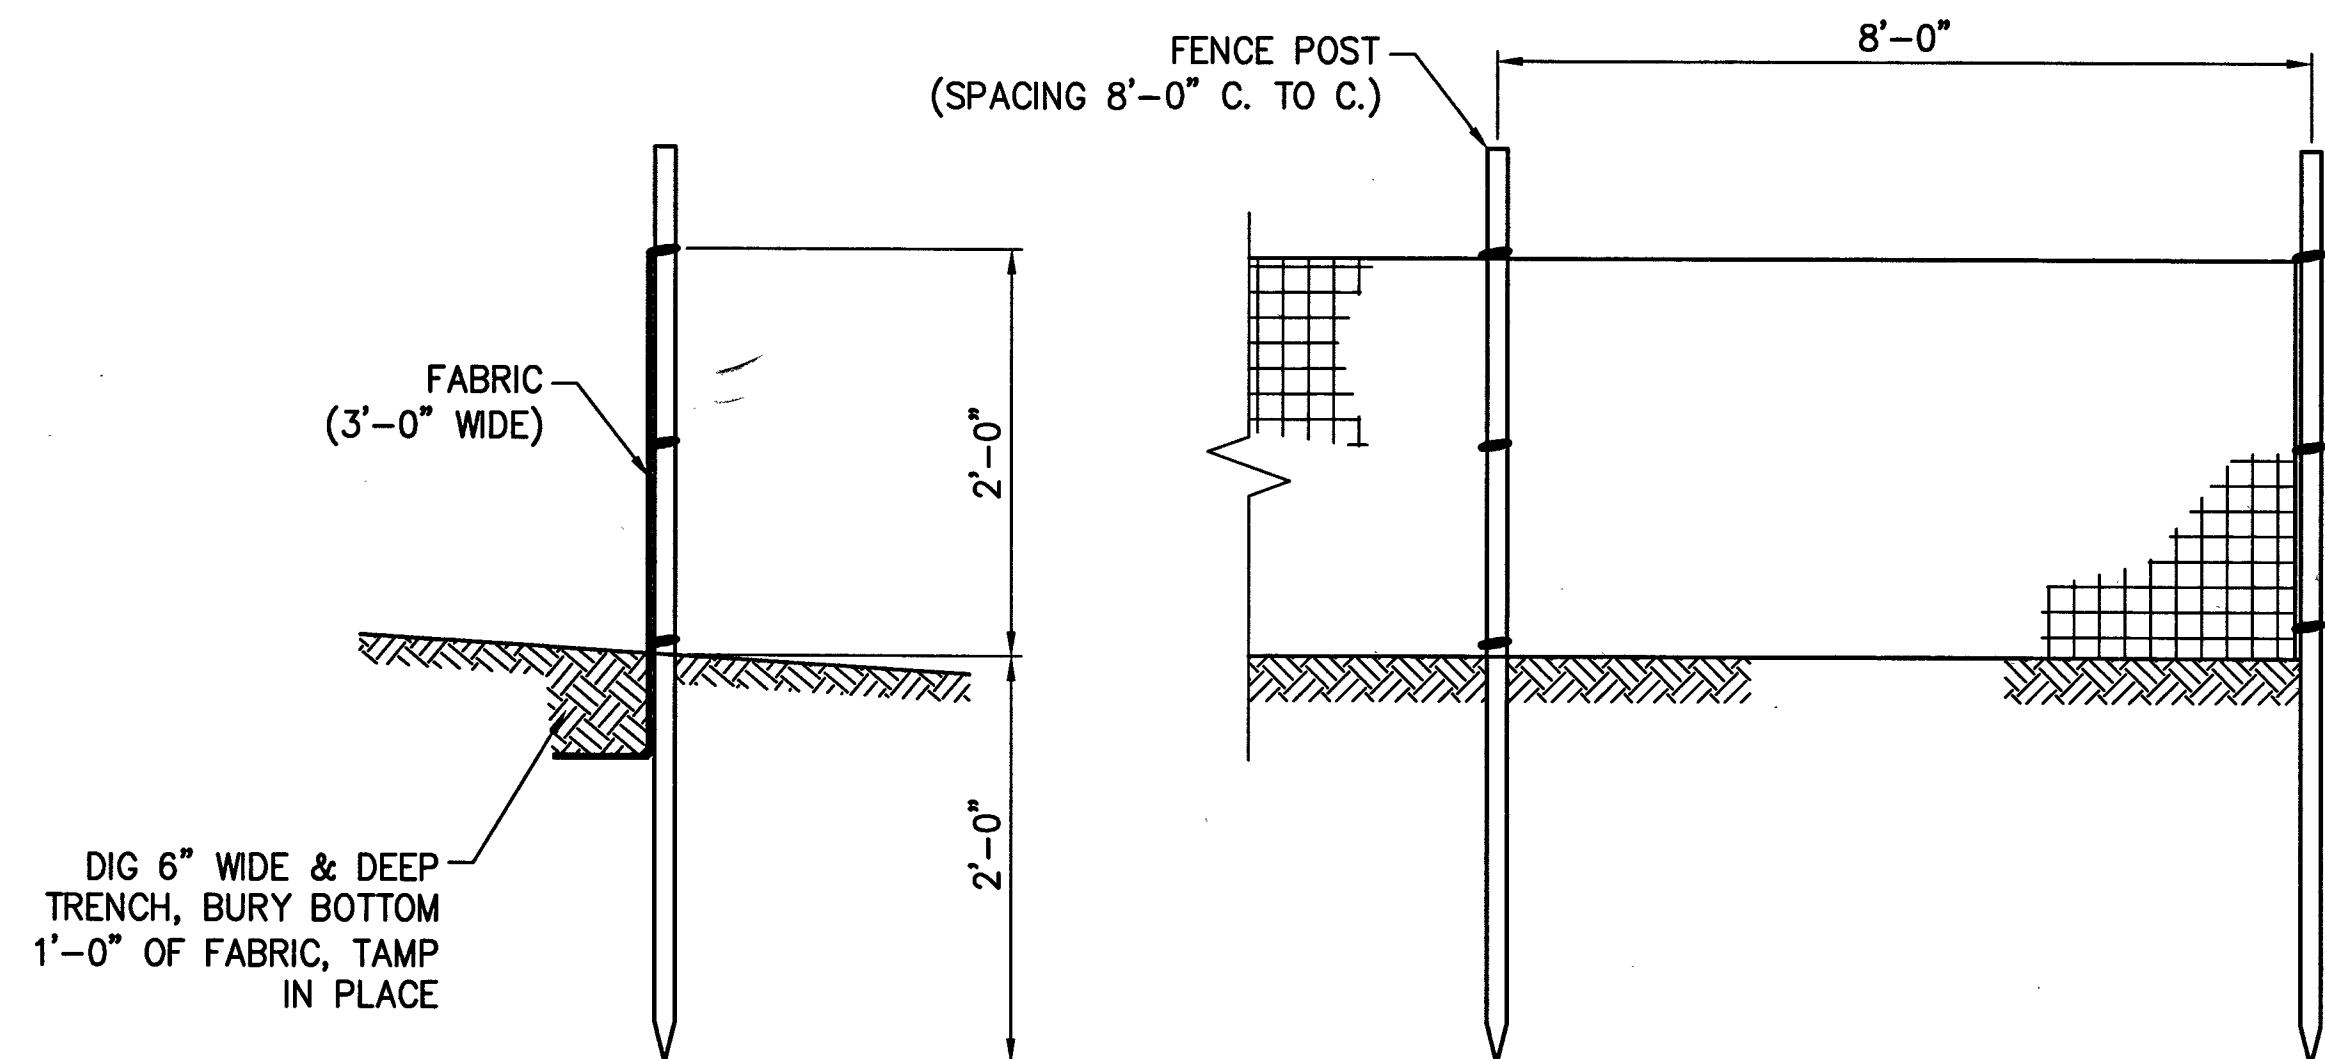


1 SILT FENCE
N.T.S.

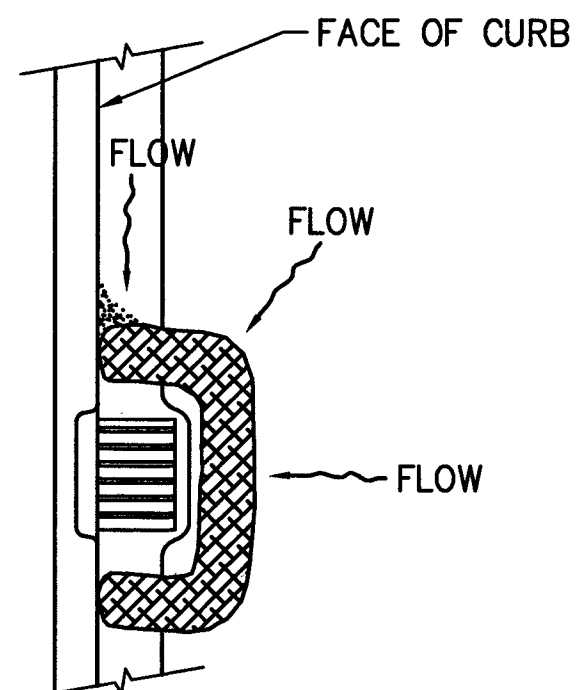


2 FIBER ROLL
N.T.S.

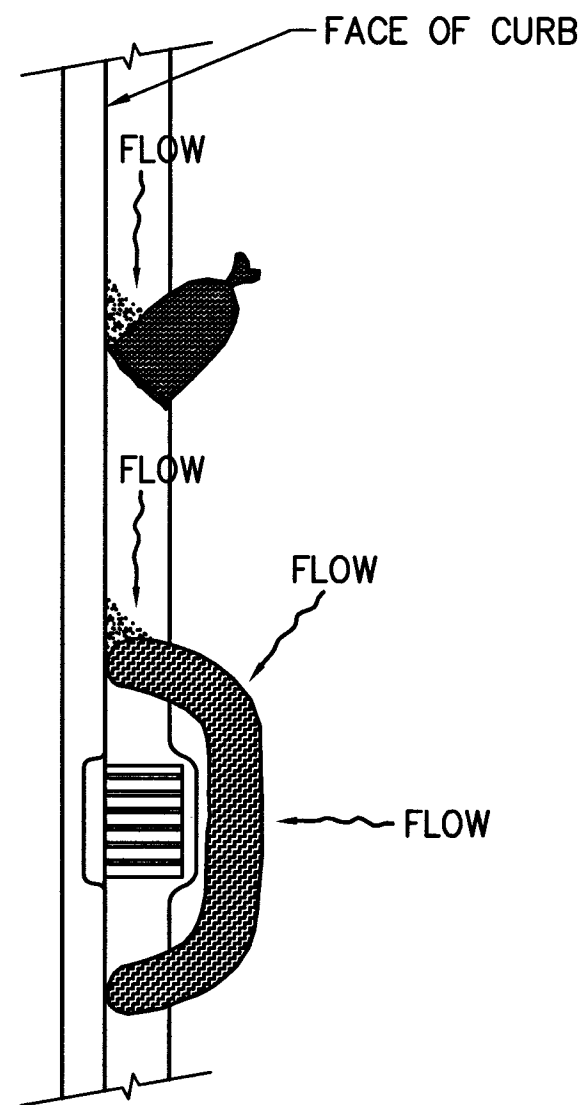


3 SAND BAG/ ROLL
N.T.S.

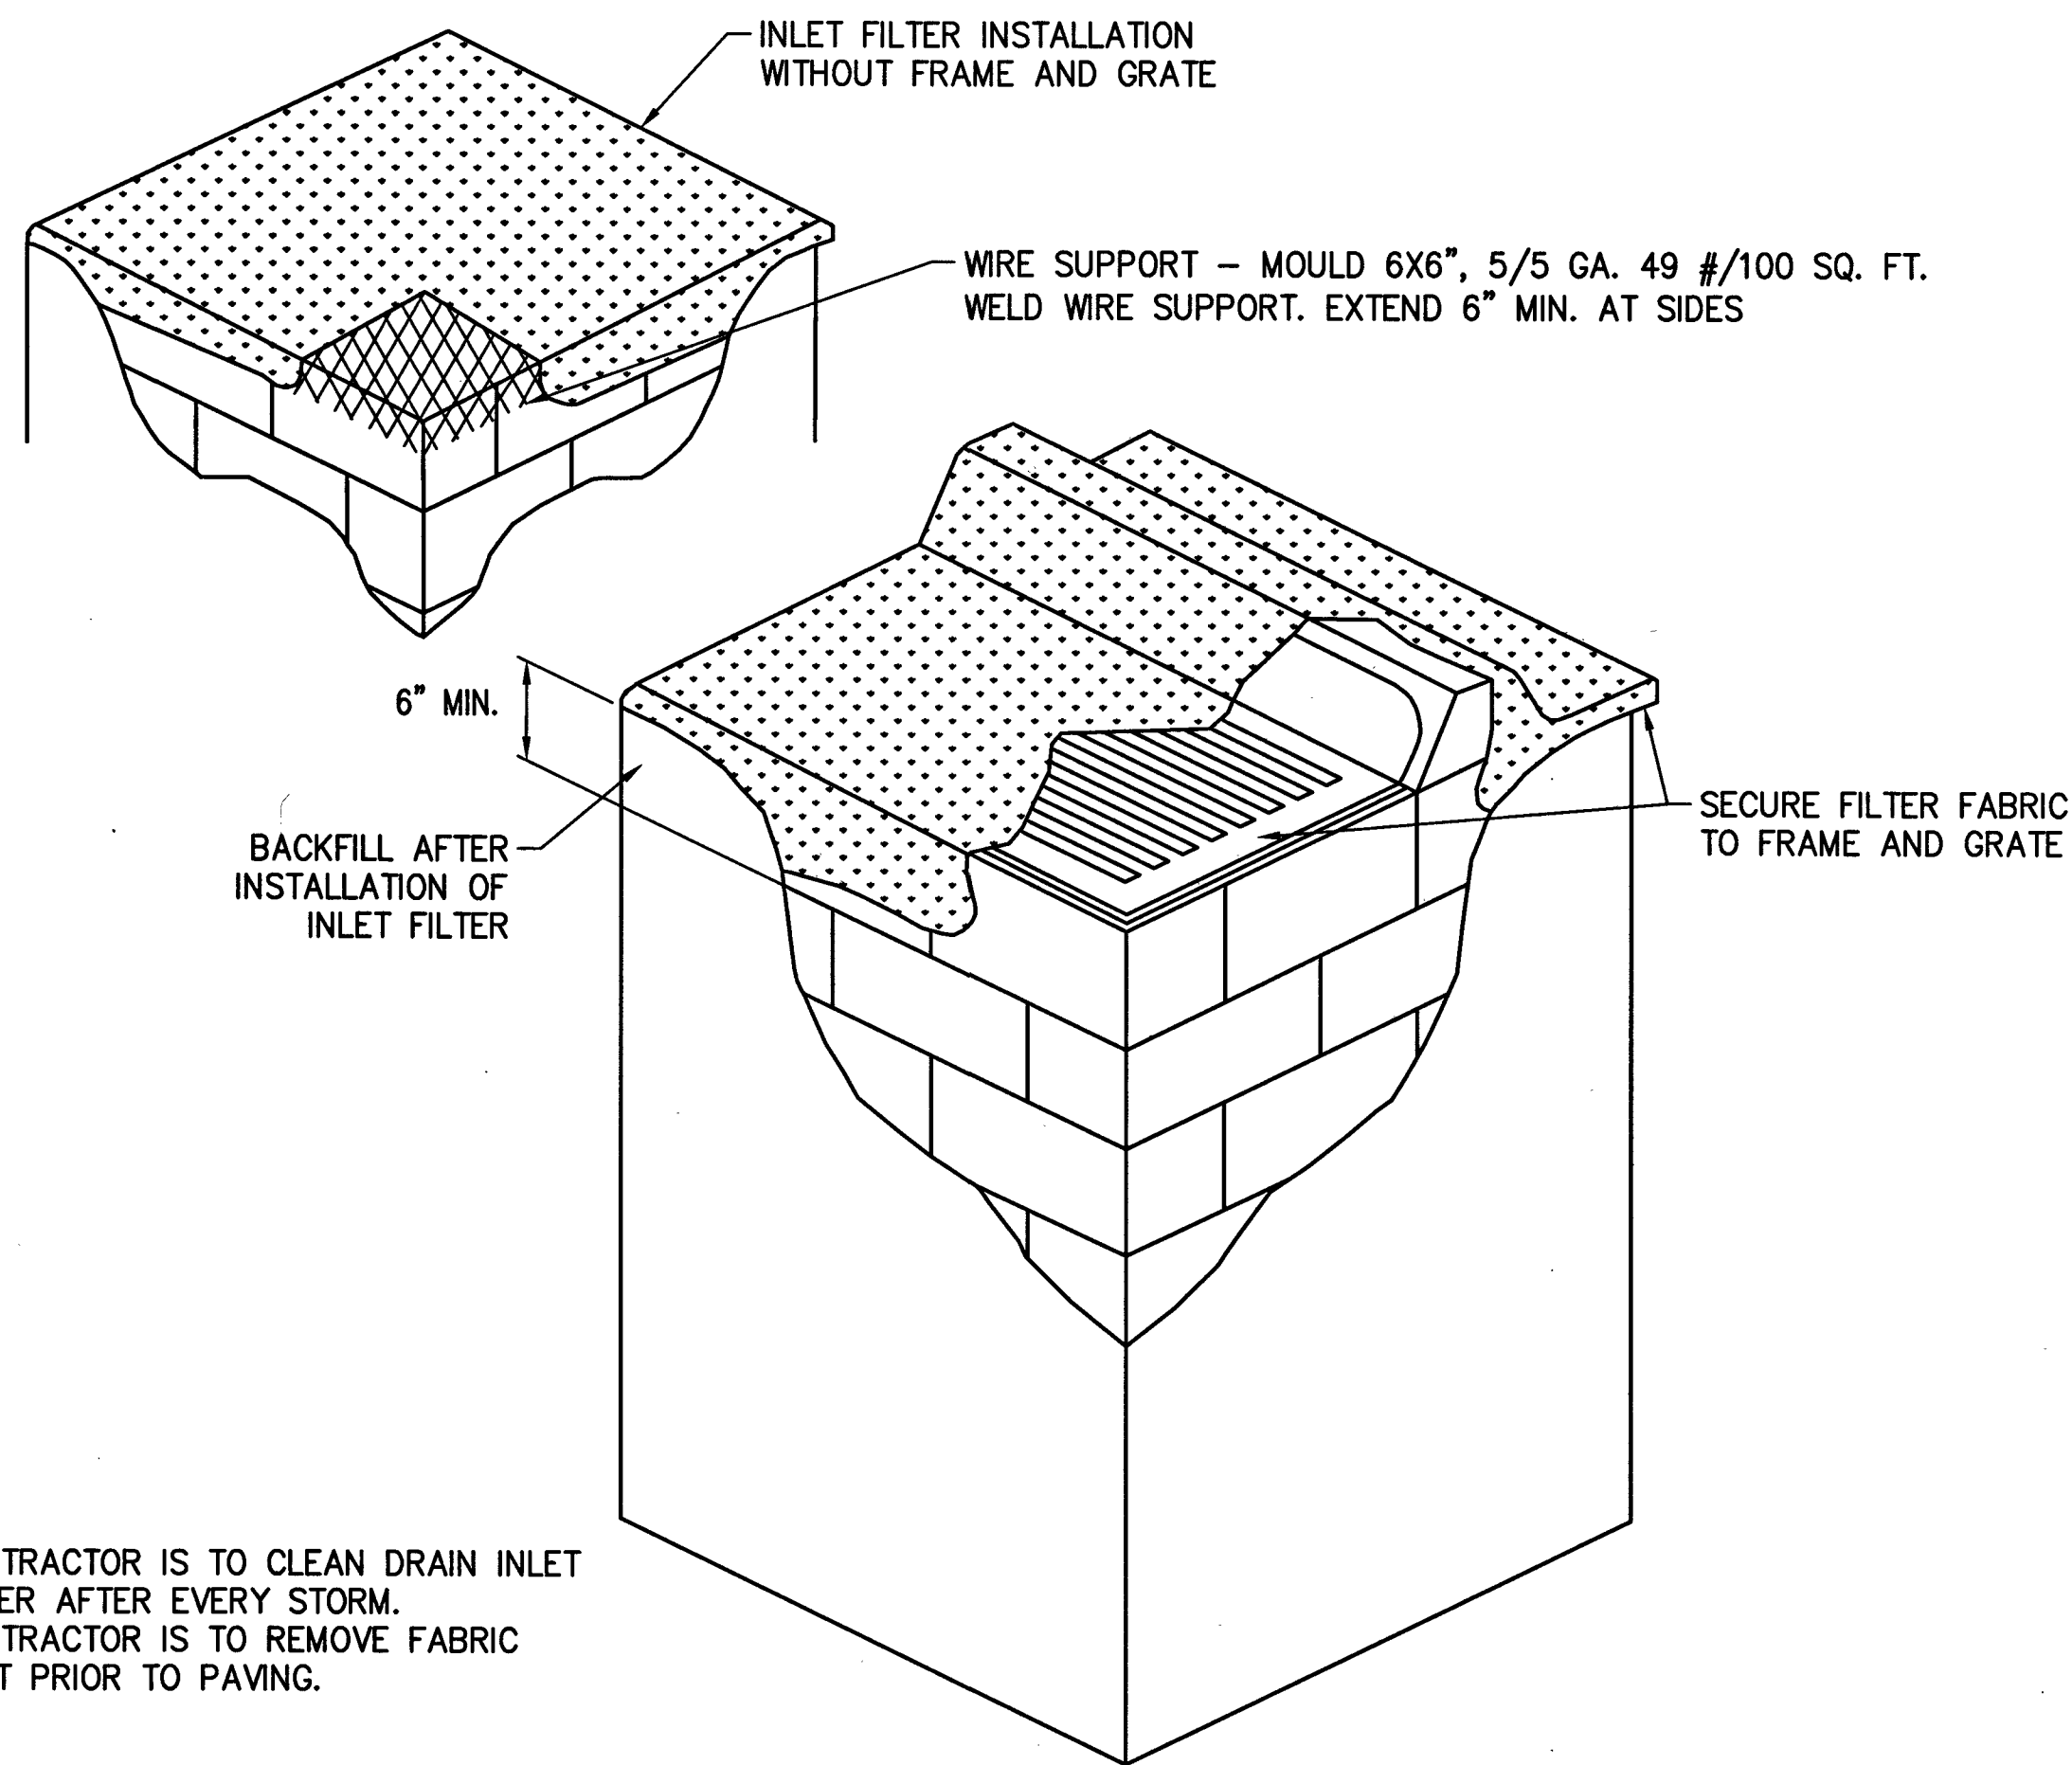


4 DRAIN INLET FILTER
N.T.S.

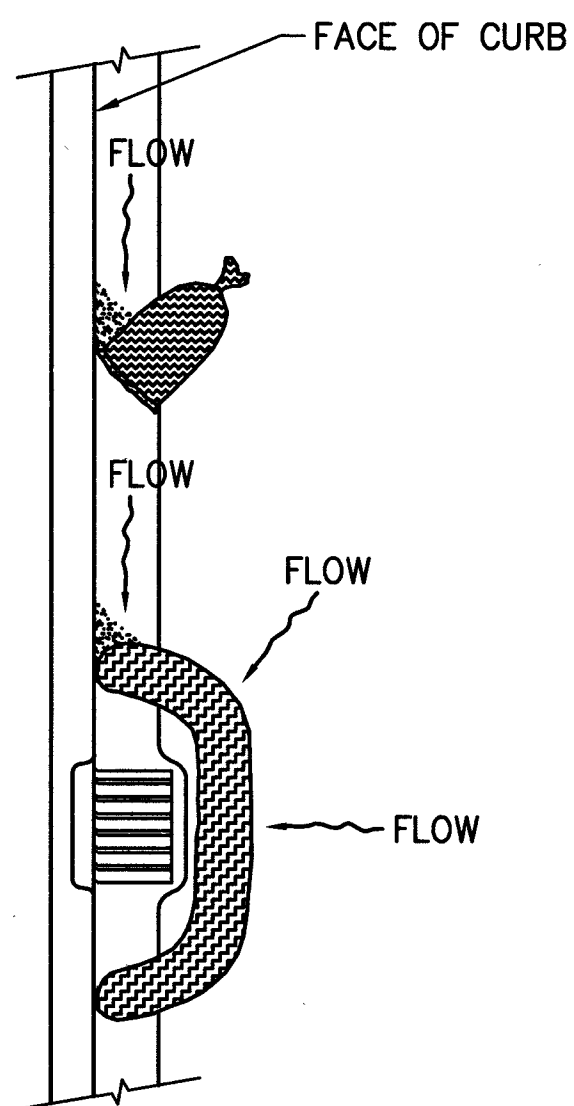

5 GRAVEL BAG/ ROLL
N.T.S.

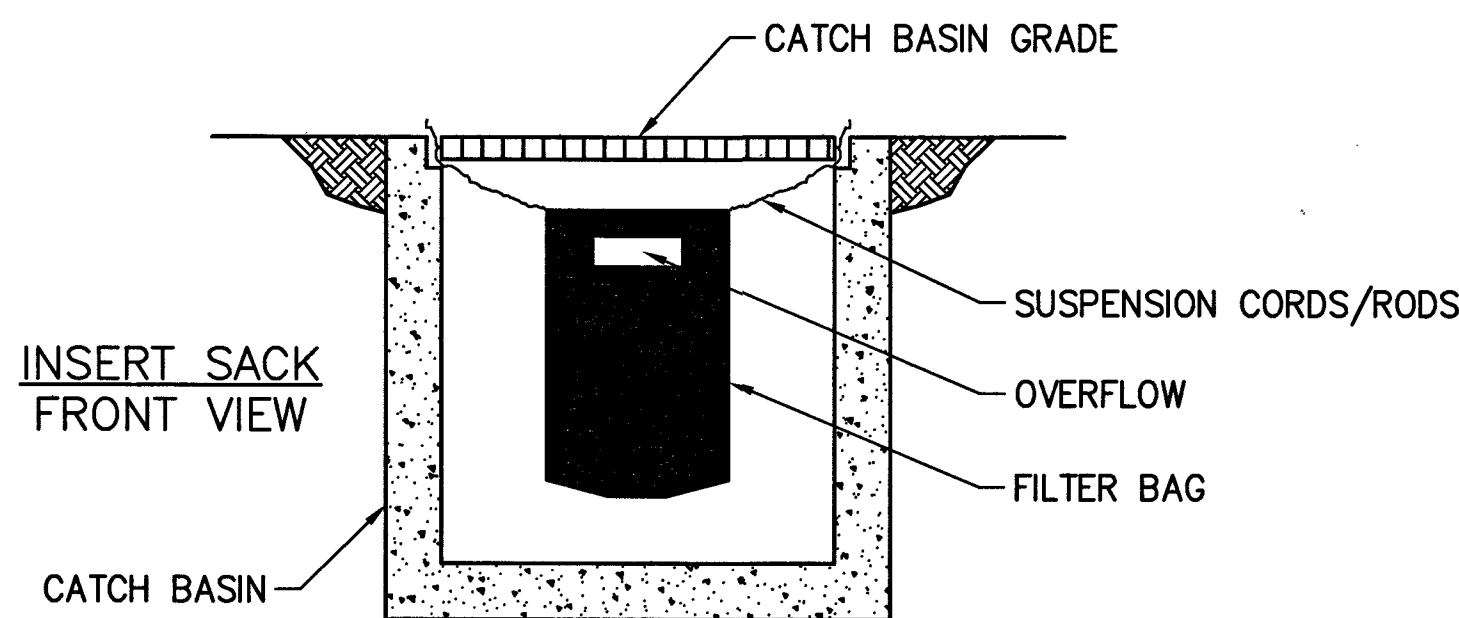

6 SEDIMENT FILTER BAG
N.T.S.

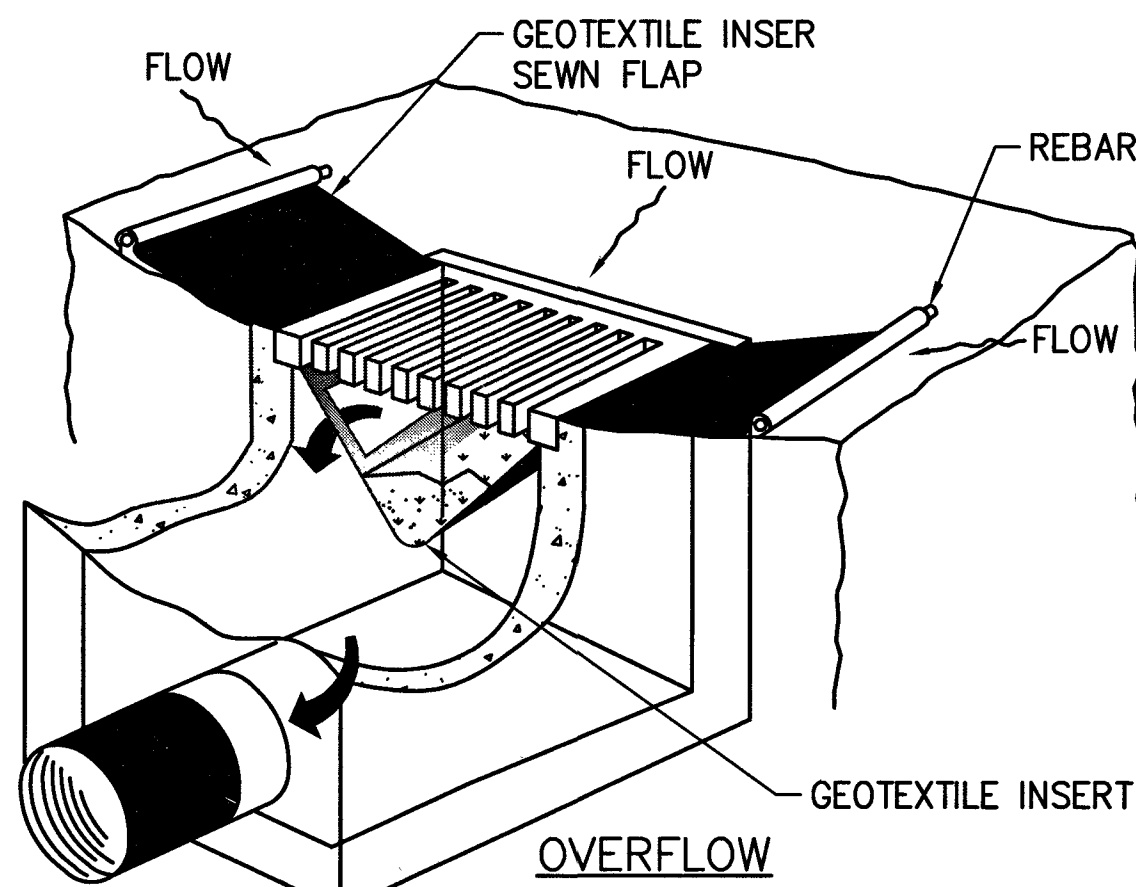

NOTE: RECESSED CURB INLET MUST BE BLOCKED WHEN USING FILTER FABRIC INLET SACKS. SIZE OF FILTER FABRIC INLET SACK TO BE DETERMINED BY MANUFACTURER.

SWPPP NOTES

1. SOUTHWEST GAS CORPORATION, ITS CONTRACTOR, AND/OR THEIR AUTHORIZED AGENTS SHALL INSTALL ONE OF THE APPROPRIATE BMP'S FOR THE PROTECTION OF EXISTING STORM DRAIN INLETS, WITHIN OR SIGNIFICANTLY NEAR ANY IMPROVED RIGHT-OF-WAY, FROM DEBRIS AND SEDIMENT RESULTING FROM CONSTRUCTION OF NATURAL GAS FACILITIES.
2. SOUTHWEST GAS CORPORATION, ITS CONTRACTOR, AND/OR THEIR AUTHORIZED AGENTS SHALL EACH DAY REMOVE ALL SEDIMENT, MUD CONSTRUCTION DEBRIS, OR OTHER POTENTIAL POLLUTANTS THAT MAY HAVE BEEN DISCHARGED TO, OR ACCUMULATED IN, THE PUBLIC RIGHTS OF WAY OF CLARK COUNTY AS A RESULT OF CONSTRUCTION ACTIVITIES ASSOCIATED WITH THIS SITE DEVELOPMENT OR CONSTRUCTION PROJECT. SUCH MATERIALS SHALL BE PREVENTED FROM ENTERING THE STORM SEWER SYSTEM, USING BEST MANAGEMENT PRACTICES DETAIL ON THIS SHEET.
3. ADDITIONAL CONSTRUCTION SITE DISCHARGE BEST MANAGEMENT PRACTICES MAY BE REQUIRED OF SOUTHWEST GAS CORPORATION, ITS CONTRACTOR, AND/OR THEIR AUTHORIZED AGENTS DUE TO UNFORESEEN EROSION PROBLEMS OR IF THE LISTED BMP'S ON THIS SHEET DO NOT MEET THE PERFORMANCE STANDARDS SPECIFIED IN THE CLARK COUNTY CODE - CHAPTER 24.0/STORM SEWER SYSTEM DISCHARGE AND THE LAS VEGAS VALLEY CONSTRUCTION SITE BMP GUIDANCE MANUAL.
4. ACCUMULATED SEDIMENT IN BMP'S SHALL BE REMOVED WITH SEVEN DAYS AFTER A STORM WATER RUNOFF EVENT OR PRIOR TO THE NEXT ANTICIPATED STORM EVENT, WHICHEVER IS EARLIER. SEDIMENT MUST BE REMOVED WHEN BMP DESIGN CAPACITY HAS BEEN REDUCED BY 50 PERCENT OR MORE.

- NOTE:
1. CONTRACTOR IS TO CLEAN DRAIN INLET FILTER AFTER EVERY STORM.
 2. CONTRACTOR IS TO REMOVE FABRIC JUST PRIOR TO PAVING.



Know what's below.
Call before you dig.

NO.	DESCRIPTION	BY	DATE	APPVD.
1.				
2.				
3.				
4.				
REVISIONS				
SOUTHWEST GAS CORPORATION				
TAX CODES	UNIT NO.	UNIT TYPE	INSTL. PROPOSED	RETIRED COMPLETED
PROPERTY UNITS				

AS-BUILT DRAWING-PRESSURE TEST DATA			
PIPE DIA.	TEST MEDIUM	TEST METHOD	
PIPE LENGTH	☐ AIR	☐ GAUGE	
PIPE TYPE	☐ NITROGEN	☐ CHART	
MIN. DURATION	☐ WATER	☐ GAUGE/ PRESS REC SN#	
TEST PRES. (PSIG)	START	END	
TIME			
DATE			
PERFORMED BY			

VISUAL INSPECTION CERTIFICATION	
I HAVE VISUALLY INSPECTED ALL HEATED FUSIONS, SOLVENT CEMENT, MECHANICAL JOINTS, AND WELDS THAT I HAVE PERFORMED	
NAME	DATE
INSPECTOR	
FOREMAN	
REVIEWED BY	
PERMIT INFORMATION	
CITY OF LAS VEGAS 02-0200	
AS-BUILTS ACCEPTED BY	DATE
POSTED BY	DATE
POSTING QCD BY	DATE

CONSTRUCTION	
ISO _21 DIST _299	W.R. NO. 3486151
ENGINEER/TECHNICIAN DAVID FRIEDLANDER	PHONE 702-365-2203
ACCOUNT REP. MICHAEL COOPER	PHONE 702-365-2580
PROJECT CONTACT CHRIS FENTON	PHONE 702-893-2868
SHEET NO. 5 OF 5	SCALE: N.T.S.
DWN. BY SEI	CHKD. BY
DATE 12/01/2017	APPVD. BY
TITLE	
LOCATION	ATLAS #/TILE #
SEC 25 T20S R59E M.D.M.	x576y520

ISOLATION AREA	
ISO _21 DIST _299	W.R. NO. 3486151
ENGINEER/TECHNICIAN DAVID FRIEDLANDER	PHONE 702-365-2203
ACCOUNT REP. MICHAEL COOPER	PHONE 702-365-2580
PROJECT CONTACT CHRIS FENTON	PHONE 702-893-2868
SHEET NO. 5 OF 5	SCALE: N.T.S.
DWN. BY SEI	CHKD. BY
DATE 12/01/2017	APPVD. BY
TITLE	
LOCATION	ATLAS #/TILE #
SEC 25 T20S R59E M.D.M.	x576y520

CONSTRUCTION	
ISO _21 DIST _299	W.R. NO. 3486151
ENGINEER/TECHNICIAN DAVID FRIEDLANDER	PHONE 702-365-2203
ACCOUNT REP. MICHAEL COOPER	PHONE 702-365-2580
PROJECT CONTACT CHRIS FENTON	PHONE 702-893-2868
SHEET NO. 5 OF 5	SCALE: N.T.S.
DWN. BY SEI	CHKD. BY
DATE 12/01/2017	APPVD. BY
TITLE	
LOCATION	ATLAS #/TILE #
SEC 25 T20S R59E M.D.M.	x576y520

BONNER ES ADDITION
TYPICAL SWPPP BMP DETAILS

SHEET 5 OF 5