

ABBREVIATIONS (SEE C.V.R. SHT. FOR COMPLETE LIST)		
AC	ASPHALTIC CONCRETE	
ADJ	ADJUST	
AGG	AGGREGATE	
BC	BACK OF CURB	
BOR	BEGINNING OF CURB RETURN	
BEG	BEGIN	
BSW	BACK OF SIDEWALK	
BVC	BEGINNING OF VERTICAL CURVE	
CATV	CABLE TV	
CCAUSD	CLARK COUNTY AREA	
CCRFCD	CLARK COUNTY REGIONAL FLOOD CONTROL DISTRICT	
CL	CENTERLINE	
CLV	CITY OF LAS VEGAS	
CMU	CONCRETE MASONRY UNIT	
CO	CLEAN OUT	
COMM	COMMUNICATIONS	
CONC	CONCRETE	
COND	CONDUIT	
CULV	CULVERT	
DC	DEPRESSED CURB	
DG	DECOMPOSED GRANITE	
DIP	DUCTILE IRON PIPE	
DOM	DOMESTIC	
ELEC	ELECTRIC	
EAC	EDGE OF AC	
ECR	END OF CURB RETURN	
EG	EXISTING GRADE	
ELEV	ELEVATION	
EP	EDGE OF PAVEMENT	
EVCL	EDGE OF VERTICAL CURVE	
EX	EXISTING	
FAST	FREWAY & ARTERIAL SYSTEM OF TRANSPORTATION	
FF	FINISH FLOOR	
FG	FINISH GRADE	
FH	FIRE HYDRANT	
FL	FLOW LINE	
FO	FIBER OPTICS	
FS	FINISHED SURFACE	
GB	GRADE BREAK	
BDPE	HIGH DENSITY POLYETHYLENE	
HDWL	HEADWALL	
HL	HYDRAULIC GRADE LINE	
HP	HIGH POINT	
INV	INVERT	
IR	IRRIGATION	
LAT	LATERAL	
LF	LINEAL FEET	
LS	LANDSCAPE	
LT	LEFT	
LVWD	LAS VEGAS VALLEY WATER DISTRICT	
MAX	MAXIMUM	
MH	MANHOLE	
MIN	MINIMUM	
MTR	METER	
PB	PULL BOX	
PL	PROPERTY LINE	
PP	POWER POLE	
PROP	PROPOSED	
PVC	POLY VINYL CHLORIDE PIPE	
PWMT	PAVEMENT	
RIM	RIM OF MANHOLE OR CLEANOUT	
RT	RIGHT	
ROW	RIGHT-OF-WAY	
RS	SANITARY SEWER	
SD	STORM DRAIN	
SNWA	SOUTHERN NEVADA WATER AUTHORITY	
STA	STATION	
STLT	STREET LIGHT	
SVZ	SIGHT VISIBILITY ZONE	
SW	SIDEWALK	
TEL	TELEPHONE	
TC	TOP OF CURB	
TF	TOP OF FOOTING	
TH	TOP OF WALL	
TYP	TYPICAL	
UDACS	UNIFORM DESIGN AND CONSTRUCTION STANDARDS	
VG	VALLEY GUTTER	
WL	WATER LINE	
WQSW	WATER QUALITY SWALE	

LEGEND		
DESCRIPTION	EXISTING	PROPOSED
UTILITIES		
B.O. VALVE		
FIRE HYDRANTS		
CLEAN OUT		
GATE VALVE		
METER		
REDUCER		
CAP		
11.25" ELBOW		
22.5" ELBOW		
45" ELBOW		
90" ELBOW		
CROSS		
TEE		
MANHOLES		
ELECTRICAL		
SANITARY SEWER		
STORM DRAIN		
TELEPHONE		
STREET LIGHTS		
100W HPS STLT		
150W HPS STLT		
200W HPS STLT		
250W HPS STLT		
400W HPS STLT		
GRADING		
SPOT ELEV.		
SLOPE		
5' CONT.		
1' CONT.		
SITE		
SIGN		
"L" CURB		
"A" CURB		
EDGE OF P.W.M.T.		
WALL		
LINE TYPES		
CL OR SECTION LINE		
RIGHT OF WAY LINE		
EASEMENT LINE		
SAWCUT LINE		
FLOW LINE		
SHADES		
HEAVY AC PAVEMENT		
LIGHT AC PAVEMENT		
CONCRETE PAVEMENT		

STORM WATER MANAGEMENT NOTES	
1.	THE OWNER, SITE DEVELOPER, CONTRACTOR, AND/OR THEIR AUTHORIZED AGENTS SHALL EACH DAY REMOVE ALL SEDIMENT, MUD, CONSTRUCTION DEBRIS OR OTHER POTENTIAL POLLUTANTS THAT MAY HAVE BEEN DISCHARGED TO, OR ACCUMULATED IN, THE PUBLIC RIGHTS OF WAY OF CLARK COUNTY AS A RESULT OF CONSTRUCTION ACTIVITIES ASSOCIATED WITH THIS SITE DEVELOPMENT OR CONSTRUCTION PROJECT. SUCH MATERIALS SHALL BE PREVENTED FROM ENTERING THE STORM SEWER SYSTEM.
2.	ADDITIONAL CONSTRUCTION SITE DISCHARGE BEST MANAGEMENT PRACTICES MAY BE REQUIRED OF THE OWNER AND HIS OR HER AGENTS DUE TO UNFORESEEN EROSION PROBLEMS OR IF THE SUBMITTED PLAN DOES NOT MEET THE PERFORMANCE STANDARDS SPECIFIED IN CLARK COUNTY TITLE 24.40 AND THE LAS VEGAS VALLEY CONSTRUCTION SITE BMP GUIDANCE MANUAL.
3.	TEMPORARY OR PERMANENT STABILIZATION PRACTICES WILL BE INSTALLED ON DISTURBED AREAS AS SOON AS PRACTICABLE AND NO LATER THAN 14 DAYS AFTER THE CONSTRUCTION ACTIVITY IN THAT PORTION OF THE SITE HAS TEMPORARILY OR PERMANENTLY CEASED. SOME EXCEPTIONS MAY APPLY; REFER TO THE NEVADA STORM WATER GENERAL PERMIT FOR CONSTRUCTION ACTIVITY NVR100000, SECTION III.A.5.
4.	AT A MINIMUM, THE CONTRACTOR OR HIS AGENT SHALL INSPECT ALL DISTURBED AREAS, AREAS USED FOR STORAGE OF MATERIALS AND EQUIPMENT THAT ARE EXPOSED TO PRECIPITATION, VEHICLE ENTRANCE AND EXIT LOCATIONS, AND ALL BMPs WEEKLY, AND WITHIN 24 HOURS AFTER ANY RAIN EVENT OF 0.5 INCHES OR MORE. THE CONTRACTOR OR HIS AGENT SHALL UPDATE OR MODIFY THE STORM WATER POLLUTION PREVENTION PLAN AS NECESSARY. SOME EXCEPTIONS TO WEEKLY INSPECTIONS MAY APPLY, SUCH AS SUSPENSION OF LAND DISTURBANCE ACTIVITIES. REFER TO THE NEVADA STORM WATER GENERAL PERMIT FOR CONSTRUCTION ACTIVITY NVR100000, SECTION III.A.12.
5.	ACCUMULATED SEDIMENT IN BMPs SHALL BE REMOVED WITHIN SEVEN DAYS AFTER A STORMWATER RUNOFF EVENT OR PRIOR TO THE NEXT ANTICIPATED STORM EVENT, WHICHEVER IS EARLIER. SEDIMENT MUST BE REMOVED WHEN BMP DESIGN CAPACITY HAS BEEN REDUCED BY 50 PERCENT OR MORE.

CLARK COUNTY FIRE DEPARTMENT	
A.	ALL WORK SHALL BE DONE IN STRICT ACCORDANCE WITH CLARK COUNTY FIRE CODE AS AMENDED, AND THE CURRENT EDITION OF NATIONAL FIRE PROTECTION ASSOCIATION PAMPHLET #24.
B.	FIRE HYDRANTS AND WATER SUPPLIES FOR FIRE PROTECTION SHALL BE AND MAINTAINABLE PRIOR TO AND DURING THE TIME OF CONSTRUCTION IN ACCORDANCE WITH SECTION 1412 OF THE CLARK COUNTY FIRE CODE, AS AMENDED.
C.	IF DURING CONSTRUCTION IT BECOMES NECESSARY TO CLOSE ANY CONTROL VALVE OR PLACE A HYDRANT OUT OF SERVICE, APPROVAL SHALL BE OBTAINED FROM THE FIRE DEPARTMENT PRIOR TO PLACING THE HYDRANT OUT OF SERVICE.
D.	PAINTING OF CURBS AND/OR STRIPING OF ASPHALT AREAS AND PROTECTION OF HYDRANTS FROM PHYSICAL INJURY SHALL BE PER THE FIRE HYDRANT INSTALLATION SPECIFICATIONS OF THE FIRE PREVENTION DIVISION.
E.	NO FIRE HYDRANT SHALL BE LOCATED WITHIN 25 FEET OF ANY STRUCTURE, OR 6 FEET OF A DRIVEWAY, POWER POLE, LIGHT STANDARD, OR ANY OTHER OBSTRUCTION. FOR WALL, FENCE AND PLANTER LOCATIONS, A PERIMETER AROUND THE HYDRANT MEASURING A MINIMUM OF 3 FEET FROM ITS EXTERIOR SHALL BE MAINTAINED CLEAR OF ALL OBSTRUCTION AT ALL TIMES.
F.	FIRE APPARATUS ACCESS ROADS SHALL BE DESIGNED AND MAINTAINED TO SUPPORT THE WEIGHT OF FIRE APPARATUS, WITH A MINIMUM VEHICLE LOAD OF 33,000 POUNDS PER AXLE, AND SHALL BE SURFACED AND PAVED SO AS TO PROVIDE ALL-WEATHER DRIVING CAPABILITIES.
EXCEPTION: TEMPORARY ACCESS ROADS SERVING ONLY BUILDING UNDER CONSTRUCTION SHALL NOT BE REQUIRED TO BE PAVED, BUT SHALL COMPLY WITH ALL OTHER REQUIREMENTS OF SECTION 503.2.3 OF THE CLARK COUNTY FIRE CODE.	
G.	PRIOR TO ACCEPTANCE OF ANY FIRE SERVICE MAIN, A SATISFACTORY HYDROSTATIC TEST WITH PIPING JOINTS UNCOVERED MUST BE CONDUCTED. APPROVED PLANS, AN INSTALLATION PERMIT AND A CONTRACTOR'S MATERIALS AND TEST CERTIFICATE MUST BE PROVIDED AT TIME OF INSPECTION. SCHEDULE INSPECTION AT http://www.clarkcountynv.gov/building/fire-prevention/pages/inspectionServices.aspx
H.	FIRE HYDRANTS SHALL BE LOCATED 4' TO 7' FROM BACK OF CURB AND A MINIMUM OF 6 FEET AWAY FROM TURNS.
I.	BLUE REFLECTIVE MARKERS MUST BE INSTALLED BEFORE FINAL HYDRANT ACCEPTANCE CAN BE ATTAINED (SECTION C107 OF THE CLARK COUNTY FIRE CODE, AS AMENDED).
J.	HYDRANTS THAT ARE PROPOSED FOR INSTALLATION IN PUBLIC WATER SYSTEMS SHALL BE IN ACCORDANCE WITH APPROVED FIRE HYDRANTS AS ALLOWED BY THE WATER PURVEYOR. HYDRANTS PROPOSED FOR INSTALLATION ON PRIVATE WATER SYSTEMS SHALL BE IN ACCORDANCE WITH APPROVED FIRE HYDRANTS AS ALLOWED BY THE FIRE DEPARTMENT.

SOUTHWEST GAS CORPORATION GENERAL NOTES	
1.	IN THE EVENT OF NATURAL GAS EMERGENCIES CALL 911 AND 1-877-860-6020
2.	THERE SHALL BE A MINIMUM HORIZONTAL AND VERTICAL CLEARANCE OF 12-INCHES BETWEEN NATURAL GAS FACILITIES AND ANY UNDERGROUND FACILITIES AND/OR STRUCTURES, INCLUDING BUT NOT LIMITED TO WATER, SEWER, STORM DRAIN, COMMUNICATIONS, AND ELECTRIC.
3.	FOR VALVE ADJUSTMENT CONTACT 702-668-6107 48 HOURS PRIOR TO CONSTRUCTION.
4.	IN THE EVENT OF A NATURAL GAS CONFLICT WITH PROPOSED UTILITIES AND/OR STRUCTURES CONTACT 702-365-2099.
CAUTION: HIGH PRESSURE GAS!	
CALL SOUTHWEST GAS AT 702-400-1789 FOR STANDBY WHEN EXCAVATING OVER OR NEAR HIGH PRESSURE GAS LINES 48 HOURS PRIOR TO CONSTRUCTION	
	DATE <u>3/14/19</u>
SOUTHWEST GAS CORPORATION	

CLARK COUNTY DEPARTMENT OF PUBLIC WORKS NOTES	
1.	INSPECTIONS ARE REQUIRED. CALL 24 HOURS IN ADVANCE. (702) 455-4610. THE PERMIT APPROVED PLANS, AND BARRICADE PLANS FOR THIS WORK MUST BE ON THE JOB SITE AT ALL TIMES.
2.	EXACT LOCATION OF ALL SAW-CUT LINES SHALL BE DETERMINED IN THE FIELD BY A CLARK COUNTY INSPECTOR.
3.	CURB AND GUTTER WITH A GRADE OF LESS THAN 4/10 OF ONE PERCENT SHALL BE CONSTRUCTED BY FORMING. EACH JOINT SHALL BE CHECKED FOR GRADE PRIOR TO CONSTRUCTION AND WATER TESTED AS SOON AS POSSIBLE AFTER CONSTRUCTION.
4.	FINAL ASPHALTIC CONCRETE (AC) PAVEMENT SURFACES SHALL BE ONE-HALF (1/2") INCH ABOVE THE LIP OF THE GUTTER (INCLUDING OPEN GRADE).
5.	ALL OFF-SITE IMPROVEMENT CONSTRUCTION SHALL CONFORM TO THE UNIFORM STANDARD SPECIFICATIONS AND STANDARD DRAWINGS CLARK COUNTY AREA NEVADA AND CLARK COUNTY SUPPLEMENT TO UNIFORM STANDARD DRAWINGS AND SPECIFICATIONS, LATEST REVISION EXCEPT FOR LUMINAIRES. REFER TO CLARK COUNTY PUBLIC WORKS QUALIFIED PRODUCTS LIST "OPL" FOR LED LUMINAIRES. OPL CAN BE FOUND ONLINE AT HTTP://WWW.CLARKCOUNTYNV.GOV/PUBLIC-WORKS/PAGES/DEFAULT.ASPX .
6.	PRIVATE STREETS, CURB & GUTTER AND VALLEY GUTTERS REFLECTED ON THESE PLANS ARE TO BE INSPECTED BY A CLARK COUNTY INSPECTOR.
7.	WHEEL CHAIR RAMPS SHALL BE CONSTRUCTED IN EACH QUADRANT OF AN INTERSECTION PER STANDARD DRAWING 235. EXACT LOCATION OF RAMPS SHALL BE DETERMINED IN THE FIELD BY A CLARK COUNTY INSPECTOR.
8.	PROPER SIGNS, BARRIERS, BARRICADES AND LIGHTS SHALL BE PLACED AND MAINTAINED IN ACCORDANCE WITH THE LATEST "MANUAL ON UNIFORM TRAFFIC CONTROL DEVICES FOR STREETS AND HIGHWAYS" TRAFFIC, SCHOOL, OR STREET SIGNS OF ANY KIND ARE NOT TO BE MOVED FOR ANY REASON WITHOUT FIRST COORDINATING WITH THE DEPARTMENT OF PUBLIC WORKS OFFSITE INSPECTOR @ (702) 455-4610.
9.	THIS PLAN DOES NOT AUTHORIZE CLOSURE OF ANY ROAD OR STREET.
10.	NO OPEN TRENCH SHALL BE ALLOWED ACROSS ANY STREET OR WITHIN TEN (10') FEET OF ANY TRAVEL-WAY, EXCEPT WHEN WORK IS IN ACTUAL PROGRESS. AREAS COVERED BY ACCEPTABLE STEEL PLATE ARE NOT TO BE CONSIDERED AS AN OPEN TRENCH. NO OPEN TRENCH IS PERMITTED IN EXCESS OF 500 FEET OR LENGTH NECESSARY TO ACCOMMODATE PIPE INSTALLATION IN A SINGLE DAY, WHICH EVER IS GREATER. ALL TRENCH CROSSINGS AND BACKFILL SHALL MEET THE STANDARD SPECIFICATION UNLESS OTHERWISE STATED.
11.	A TEMPORARY PATCH IS TO BE IN PLACE AT THE END OF EACH WORK DAY WHERE THE BACKFILL IN THE TRENCH HAS BEEN COMPLETED AND PRIOR TO OPENING THE WORK AREA BACK TO TRAFFIC. THIS IS TO BE MAINTAINED BY THE PERMITTEE. A PERMANENT PATCH IS TO BE IN PLACE WITHIN THIRTY (30) DAYS AFTER THE INSTALLATION OF THE TEMPORARY PATCH.
12.	COMPACTION TESTS ARE REQUIRED.

CLARK COUNTY TRAFFIC NOTES	
1.	ALL PERMANENT TRAFFIC CONTROL DEVICES CALLED FOR HEREIN SHALL BE IN PLACE AND IN FINAL POSITION BEFORE ALLOWING ANY PUBLIC TRAFFIC ONTO THE PORTIONS OF THE ROADWAY BEING IMPROVED HEREUNDER, REGARDLESS OF THE STATUS OF COMPLETION OF PAVING OR OTHER OFF-SITE IMPROVEMENTS CALLED FOR BY THESE PLANS.
2.	BEFORE ANY WORK IS STARTED IN THE RIGHT-OF-WAY, THE CONTRACTOR SHALL INSTALL ALL ADVANCE WARNING SIGNS FOR THE CONSTRUCTION ZONE. THE CONTRACTOR SHALL INSTALL TEMPORARY CONE MOUNTED STOP SIGNS AT ALL NEW STREET ENCROACHMENTS INTO EXISTING COUNTY STREETS IMMEDIATELY AFTER FIRST GRADING WORK IS ACCOMPLISHED, AND SHALL MAINTAIN SAID SIGNS UNTIL PERMANENT SIGNS ARE INSTALLED.
3.	ALL CONSTRUCTION SIGNING, BARRICADE AND PAVEMENT MARKINGS SHALL CONFORM TO THE NEVADA WORK ZONE TRAFFIC HANDBOOK - 1988 AND TO THE MANUAL OF UNIFORM TRAFFIC CONTROL DEVICES FOR STREETS AND HIGHWAYS, CURRENT EDITION.
4.	IF THE IMPROVEMENTS NECESSITATE THE OBLITERATION, TEMPORARY OBSTRUCTION, TEMPORARY REMOVAL, OR RELOCATION OF ANY EXISTING TRAFFIC PAVEMENT MARKING, SUCH PAVEMENT MARKING SHALL BE RESTORED OR REPLACED WITH LIKE MATERIALS TO THE SATISFACTION OF THE COUNTY TRAFFIC MANAGER.
5.	THE DEVELOPER SHALL BE RESPONSIBLE TO PROVIDE AND INSTALL ALL PERMANENT SIGNS SHOWN ON THE PLANS. STREET NAME SIGNS SHALL CONFORM IN THEIR ENTIRETY TO CLARK COUNTY AREA STANDARDS. ALL OTHER SIGNS SHALL BE STANDARD SIZE UNLESS OTHERWISE SPECIFIED ON THE PLANS. ALL SIGNPOSTS SHALL CONFORM TO THE UNIFORM STANDARD DRAWINGS AND SPECIFICATIONS FOR PUBLIC WORKS CONSTRUCTION, OFF-SITE IMPROVEMENTS, CLARK COUNTY AREA NEVADA, LATEST EDITION OF EACH EXCEPT AS NOTED ON THE STREET LIGHTING PLANS AND LUMINAIRES. REFER TO CLARK COUNTY PUBLIC WORKS QUALIFIED PRODUCTS LIST "OPL" FOR LED LUMINAIRES. OPL CAN BE FOUND ONLINE AT HTTP://WWW.CLARKCOUNTYNV.GOV/PUBLIC-WORKS/PAGES/DEFAULT.ASPX .
6.	IF A PROPOSED STREETLIGHT STANDARD IS FIELD LOCATED TO WITHIN FIVE (5) FEET OF ANY SIGN SHOWN HEREON TO BE MOUNTED ON A SIGN POST, CHANGE SIGN MOUNTING TO ONE ON THE STREETLIGHT STANDARD.
7.	PRIOR TO CONSTRUCTION, THE STREET SIGN CONTRACTOR SHALL OBTAIN STREET NAMES AND BLOCK NUMBERING FROM THE CURRENT PLANNING DIVISION OF THE DEPARTMENT OF COMPREHENSIVE PLANNING.
8.	ALL TRAFFIC SIGNAL POLE ASSEMBLIES, STEEL PESTLEDS FOR CABINETS AND STREETLIGHT POLES SHALL BE GALVANIZED PER ASTM A-123.
9.	ALL STREET LIGHTING INSTALLATIONS SHALL CONFORM TO THE UNIFORM STANDARD DRAWINGS AND SPECIFICATIONS FOR PUBLIC WORKS CONSTRUCTION, OFF-SITE IMPROVEMENTS, CLARK COUNTY AREA NEVADA, LATEST EDITION OF EACH EXCEPT AS NOTED ON THE STREET LIGHTING PLANS AND LUMINAIRES. REFER TO CLARK COUNTY PUBLIC WORKS QUALIFIED PRODUCTS LIST "OPL" FOR LED LUMINAIRES. OPL CAN BE FOUND ONLINE AT HTTP://WWW.CLARKCOUNTYNV.GOV/PUBLIC-WORKS/PAGES/DEFAULT.ASPX .
10.	THE FOLLOWING CLARK COUNTY UNDERGROUND FACILITIES MAY BE LOCATED IN YOUR PROJECT AREA: STREET LIGHTING, TRAFFIC SIGNALS, AND FREEWAY AND ARTERIAL SYSTEM OF TRANSPORTATION (F.A.S.T.) INTERCONNECT CABLE. YOU MUST CONTACT CLARK COUNTY TRAFFIC MANAGEMENT DIVISION, OPERATIONS UNIT AT (702) 455-6000 FOR LOCATIONS AT LEAST 48 HOURS PRIOR TO WORKING IN THE AREA. CLARK COUNTY IS NOT A MEMBER OF "CALL BEFORE YOU DIG" (UNDERGROUND SERVICE ALERT), AND A CALL TO THAT ORGANIZATION DOES NOT RELIEVE YOU OF LIABILITY FOR CLARK COUNTY FACILITIES.
11.	F.A.S.T. INTERCONNECT CABLE POLICY IS IN EFFECT. INTERCONNECT CABLE MUST BE MAINTAINED AT ALL TIMES. DEVELOPER/CONTRACTOR SHALL PROVIDE TEMPORARY OVERHEAD INTERCONNECT CABLE WHILE PERMANENT CABLE IS BEING RELOCATED. TEMPORARY AERIAL INSTALLATION MUST BE ACCEPTABLE TO THE COUNTY TRAFFIC MANAGER AND TO F.A.S.T. ANY DAMAGE TO THIS CABLE IS DEEMED IN EMERGENCY BY F.A.S.T., CITY OF LAS VEGAS, CLARK COUNTY, AND NOTED MUST BE REPAIRED IMMEDIATELY TO F.A.S.T. ACCEPTANCE. \$2,500 PER DAY DAMAGES MAY BE ASSESSED AFTER 24 HOURS HAS ELAPSED FROM TIME OF BREAK OR DAMAGE.
12.	ALL NEW OR REPLACEMENT TRAFFIC SIGNAL LOOPS SHALL BE INSTALLED USING CABLE-IN-DUCT WIRING. SHALL HAVE INDEPENDENT LEAD-IN WIRES FOR EACH LOOP FROM THE CONTROLLER TO THE PULL-BOX, AND EACH LEAD-IN SHALL BE INDIVIDUALLY TAGGED.
13.	TRAFFIC SIGNAL PEDESTRIAN HEADS SHALL BE THE L.E.D. TYPE.
14.	ELECTRICAL POWER SERVICE POINT LOCATION(S) FOR STREET LIGHTING AND TRAFFIC SIGNALS MUST BE INDICATED ON THE PLANS. IF CONNECTING TO AN EXISTING CIRCUIT, INDICATE LOCATION OF EXISTING SERVICE POINT FOR EACH CIRCUIT.
15.	WHEN STREET LIGHTS ARE TO BE CONNECTED TO AN EXISTING CIRCUIT, THE ENGINEER SHALL CERTIFY THAT THE EXISTING CIRCUIT IS CAPABLE OF HANDLING THE ADDITIONAL CIRCUIT LOAD.
16.	CLARK COUNTY RESERVES THE RIGHT TO REJECT STREETLIGHT AND TRAFFIC SIGNAL POLES AND ASSEMBLIES WHICH HAVE A "STRIPED" APPEARANCE.
17.	TWO WEEKS PRIOR TO BEGINNING OF CONSTRUCTION, MODIFICATION, OR RELOCATION OF ANY TRAFFIC SIGNAL SYSTEM, WRITTEN NOTICE SHALL BE SUBMITTED TO THE CLARK COUNTY TRAFFIC MANAGEMENT DIVISION OF THE DATE THAT WORK WILL BEGIN.
18.	THREE (3) NORMAL WORKING DAYS PRIOR TO TURN-ON OR COMPLETION OF MODIFICATION(S) TO A TRAFFIC SIGNAL SYSTEM, WRITTEN NOTICE SHALL BE SUBMITTED TO THE CLARK COUNTY TRAFFIC MANAGEMENT DIVISION THAT WORK IS BEING COMPLETED AND THE PROPOSED DATE OF COMPLETION.

ENGINEER'S GENERAL NOTES	
1.	THE CONTRACTOR IS TO VISIT THE SITE AND VERIFY ALL DIMENSIONS AND SITE CONDITIONS BEFORE BIDDING AND STARTING WORK, AND ACCEPT THEM AS HE FINDS THEM. UNLESS NOTIFYING THE ARCHITECT, ENGINEER AND/OR OWNER IN WRITING AND RECEIVING WRITTEN INSTRUCTIONS PRIOR TO BIDDING THE WORK, NO EXTRA COST TO THE CONSTRUCTION CONTRACT, THE ARCHITECT, ENGINEER AND/OR OWNER SHALL BE ALLOWED DUE TO THE PRIOR CONDITIONS.
2.	SHOULD CONFLICT AND/OR DISCREPANCY APPEAR IN/OR BETWEEN THE DRAWINGS AND THE SPECS, OR WORK PERFORMED BY OTHERS, WHICH AFFECTS THE WORK, THE CONTRACTOR IS TO NOTIFY THE ARCHITECT, ENGINEER AND/OR OWNER IN WRITING AT ONCE AND RECEIVE WRITTEN INSTRUCTIONS PRIOR TO PROCEEDING. SHOULD THE CONTRACTOR PROCEED PRIOR TO RECEIPT OF THE ARCHITECT'S, ENGINEER'S AND/OR OWNER'S WRITTEN INSTRUCTIONS, THE CONTRACTOR SHALL MAKE GOOD AND CORRECT ANY WORK AND/OR DAMAGES RESULTING FROM THE PROCEDURE. NO EXTRA COST TO THE CONSTRUCTION CONTRACT, THE ARCHITECT, ENGINEER AND/OR OWNER SHALL BE ALLOWED FOR SUCH CORRECTIONS.
3.	SHOULD CONFLICT AND/OR DISCREPANCY APPEAR IN/OR BETWEEN THE DRAWINGS AND SPECS, IT IS DEEMED THE CONTRACTOR TO HAVE ESTIMATED THE MOST EXPENSIVE CONSTRUCTION METHOD OR MATERIAL INVOLVED UNLESS THE CONTRACTOR HAD ASKED FOR AND RECEIVED WRITTEN DECISIONS FROM THE ARCHITECT, ENGINEER AND/OR OWNER PRIOR TO SIGNING OF THE CONTRACT. NO EXTRA COST TO THE CONSTRUCTION CONTRACT, THE ARCHITECT, ENGINEER AND/OR OWNER SHALL BE ALLOWED FOR THESE ITEMS.
4.	SHOULD DIMENSIONAL ERRORS OCCUR THE CONTRACTOR SHALL NOTIFY THE ARCHITECT, ENGINEER AND/OR OWNER PRIOR TO COMMENCEMENT OF THAT PORTION OF THE WORK. DIMENSIONS SHALL TAKE PRECEDENCE OVER SCALE MEASUREMENTS AND DETAIL DRAWINGS SHALL TAKE PRECEDENCE OVER GENERAL SMALL SCALE DRAWINGS. DETAILS REPRESENTATIONS HAVING THE LARGER SCALE SHALL GOVERN. WORK INDICATED BUT NOT PARTICULARLY DETAILED OR SPECIFIED SHALL BE EQUAL TO SIMILAR PARTS THAT ARE DETAILED OR SPECIFIED. THE CONTRACTOR SHALL VERIFY ALL DIMENSIONS IN THE FIELD BEFORE SHOP DRAWINGS ARE MADE AND BEFORE ANY WORK IS CONSTRUCTED OR FABRICATED.
5.	THE CONTRACTOR IS TO CONFIRM ADA ACCESS RAMPS AND AREAS ARE WITHIN THE ADA STANDARDS/REQUIREMENTS FOR CROSS SLOPE AND RUNNING SLOPE PRIOR TO CONSTRUCTION. THE CONTRACTOR SHALL NOTIFY THE ARCHITECT, ENGINEER AND/OR OWNER, IN WRITING IMMEDIATELY OF ANY ADA ACCESS AREAS THAT DO NOT MEET ADA STANDARDS/REQUIREMENTS. SHOULD THE CONTRACTOR PROCEED PRIOR TO RECEIPT OF THE ARCHITECT'S, ENGINEER'S AND/OR OWNER'S WRITTEN INSTRUCTIONS, THE CONTRACTOR SHALL CORRECT THE WORK RESULTING FROM PROCEDURE. NO EXTRA COST TO THE CONSTRUCTION CONTRACT SHALL BE ALLOWED FOR SUCH CORRECTIONS.

GENERAL UTILITY NOTES	
1.	ALL WATER LINES 4" OR GREATER TO BE CL 150, C900 PVC. ALL WATER LINES SMALLER THAN 4" TO BE SCH. 40 PVC. ALL WATER LINES CONNECTED TO REMOTE FIRE DEPT. CONNECTIONS TO BE CL 200, C900 PVC.
2.	ALL GRAVITY SANITARY SEWER LINES TO BE SDR-35 PVC.
3.	WATER LINES TO HAVE THRUST BLOCKS CONSTRUCTED PER U.D.A.C.S. PLATE No. 5. THRUST BLOCKS TO BE LOCATED AT ALL ANGLE FITTINGS (BENDS), TEE'S, AND FIRE HYDRANTS. ANCHOR BLOCKS TO BE CONSTRUCTED, PER U.D.A.C.S. PLATE No. 3. ANCHOR BLOCKS TO BE LOCATED AT ALL IN-LINE REDUCERS AND GATE VALVES.
4.	WET TAPS TO BE CONSTRUCTED IN CONFORMANCE WITH U.D.A.C.S. PLATE No. 22.
5.	THE FIRE SAFETY CONTRACTOR IS RESPONSIBLE FOR ESTABLISHING THE SIZE OF PIPING THAT IS REQUIRED TO CONNECT FROM THE FIRE WATER LOOP TO THE FIRE SPRINKLER RISER. LINE SIZE SHOWN FOR INFORMATION PURPOSES ONLY.
6.	TRENCH BACKFILL FOR WATER LINES TO BE CONSTRUCTED PER U.D.A.C.S. PLATE No. 6A, 6B, 6C OR 6D.
7.	TRENCH BACKFILL FOR STORM DRAIN LINES TO BE CONSTRUCTED PER D.C.S.W.C.S. DRAWING No. SD-16B.
8.	ONLY SEWER LINES AND LATERALS MAY BE INSTALLED IN TRENCHES EXCAVATED FOR SEWER LINES. SEE D.C.S.W.C.S. SECTION 2.2.18 (TYPICAL).
9.	WATER AND SEWER SEPARATION OF TRENCHES MUST BE AT LEAST 10" MINIMUM (TYPICAL). SEE D.C.S.W.C.S. SECTION 2.2.21 "A", U.D.A.C.S. SECTION 2.19.01 "A".
10.	CONTRACTOR TO SAWCUT AND REMOVE EXISTING ASPHALT AND CONCRETE AS NECESSARY FOR UTILITY TRENCHES, BACKFILL AND PATCH ALL TRENCHES AS INDICATED ON DETAILS AND/OR ACCORDING TO THE GOVERNING ENTITY.
11.	THESE DRAWINGS MAY NOT INDICATE ALL EXISTING BURIED UTILITY LINES. CONTRACTOR IS TO EXERCISE GREAT CARE DURING EXCAVATION IN ORDER TO AVOID MAKING CONTACT WITH ANY EXISTING UTILITY LINES. IF UTILITY LINES ARE DAMAGED BY THE CONTRACTOR, SUCH DAMAGE SHALL BE REPLACED TO THE SATISFACTION OF THE OWNER AT THE CONTRACTOR'S EXPENSE.
12.	CONTRACTOR TO LOCATE AND VERIFY SIZE, LINE TYPE, CONDITION, DEPTH, PRESSURE, AND LOCATION OF ALL EXISTING UTILITY LINES WITHIN THE CONSTRUCTION AREA PRIOR TO CONSTRUCTION. THE CIVIL ENGINEER SHALL BE CONTACTED ONCE THE UTILITY LINE IS LOCATED.
13.	CONTRACTOR/OWNER TO OBTAIN C.C.P.W. OFF-SITE IMPROVEMENT PERMIT FOR ALL WORK WITHIN PUBLIC RIGHT-OF-WAY.
14.	CONTRACTOR TO VERIFY UTILITY STUB LOCATIONS AND SIZE WITH PLUMBING PLANS PRIOR TO INSTALLATION OF NEW UTILITIES.
15.	LATERALS SHALL NOT BE CONNECTED INTO STUBS EXTENDING FROM MANHOLES, SERVICE LATERALS 6" OR SMALLER WILL NOT BE ALLOWED TO CONNECT INTO MANHOLES. SEE D.C.S.W.C.S. SECTION 2.2.19 (TYPICAL).
16.	ALL EXISTING STREET LIGHTS INDICATED ON THESE PLANS ARE SHOWN FOR INFORMATION PURPOSES ONLY. LOCATION IS APPROXIMATE UNLESS NOTED WITH STATION AND OFFSET.
17.	ALL EXISTING GAS LINE LOCATIONS SHOWN ON THESE PLANS ARE APPROXIMATIONS ONLY. PROPOSED GAS LINES SHOWN ON THESE PLANS ARE FOR COORDINATION ONLY. SEE SOUTHWEST GAS PLANS FOR CONSTRUCTION.
18.	ALL EXISTING ELECTRICAL LINES SHOWN ON THESE PLANS ARE APPROXIMATIONS ONLY. PROPOSED ELECTRICAL LINES SHOWN ON THESE PLANS ARE FOR COORDINATION ONLY. SEE ELECTRICAL PLANS FOR CONSTRUCTION.
19.	SEE LEGEND FOR EXISTING AND PROPOSED UTILITY SYMBOLS.
20.	ALL DIMENSIONS TO UTILITIES LINES ARE TO CENTERLINE OF PIPE UNLESS INDICATED OTHERWISE.
21.	ALL LINEAR FEET OF STORM DRAIN AND SANITARY SEWER PIPE NOTED ON PLANS IS MEASURED FROM CENTER OF MANHOLE TO CENTER OF MANHOLE.

DEVIATIONS FROM STANDARDS	
NONE.	

PROPOSED WASTEWATER FLOW CONTRIBUTIONS:	
PARCEL APN 162-01-601-002	
BUILDING A USAGE 1,600 S.F. = 0.000593 GPD	
BUILDING B USAGE 2,400 S.F. = 0.001186 GPD	
APPROVED POC: 0.00178 MGD	
BUILDINGS (COMMERCIAL)	
AVERAGE FLOW = 11x0.65 ERUA X 0.00025 MGD=0.0017875 MGD	
REMAINING CAPACITY:	
0.00178 - BUILDING TOTAL = 0 MGD	
FUTURE DEVELOPMENT: N/A	

	DATE <u>3/13/2019</u>
CLARK COUNTY WATER RECLAMATION DISTRICT	
CCWRD PIPES NUMBER IS <u>18x208</u>	
SIGNATURE ON THESE PLANS SHALL NOT BE CONSTRUED TO BE A PERMIT FOR OR AN APPROVAL OF ANY VIOLATION OF CLARK COUNTY WATER RECLAMATION DISTRICT RULES, REGULATIONS, OR DESIGN AND CONSTRUCTION STANDARDS.	

LAS VEGAS VALLEY WATER DISTRICT NOTES

LVWD PROJECT #

135214

1. NO WORK SHALL BEGIN UNTIL THE WATER PLANS HAVE BEEN APPROVED FOR CONSTRUCTION BY THE LVWD. FOLLOWING WATER PLAN APPROVAL, NOTICE SHALL BE GIVEN TO THE LVWD COMMUNICATION SUPPORT CENTER (258-7171) TWO (2) WORKING DAYS PRIOR TO THE START OF CONSTRUCTION. FOR FUTURE INSPECTIONS, NOTICE MUST BE GIVEN BY 2:00 P.M. THE BUSINESS DAY PRIOR TO THE REQUESTED LVWD INSPECTION. WHEN REQUESTING INSPECTIONS, PLEASE REFER TO THE PROJECT # IDENTIFIED ABOVE.
2. ALL WORK SHALL CONFORM TO THE LVWD STANDARD PLATES, DRAWINGS, AND SPECIFICATIONS, AND TO THE 2010 EDITION OF THE UNIFORM DESIGN AND CONSTRUCTION STANDARDS FOR POTABLE WATER SYSTEMS (UDACS), THE LATEST EDITION OF UDACS SHALL SUPERSEDE ANY CONFLICTS CONTAINED IN THE APPROVED DRAWINGS AND/OR SPECIFICATIONS.
3. ALL WORK, EXCEPT AS MODIFIED BY THESE PLANS OR BY NOTE 2 ABOVE, SHALL BE DONE IN ACCORDANCE WITH THE MOST RECENT DRAFT OR EDITION OF THE UNIFORM STANDARD SPECIFICATIONS FOR PUBLIC WORKS CONSTRUCTION OFFSITE IMPROVEMENT, CLARK COUNTY AREA.
4. A SINGLE PIPE MATERIAL SHALL BE USED THROUGHOUT THE PROJECT UNLESS OTHERWISE APPROVED BY THE LVWD.
5. ALL SERVICE LATERALS TWO (2) INCHES IN DIAMETER AND SMALLER SHALL BE TYPE K COPPER TUBING WITH LVWD APPROVED SOLDER SADDLES.
6. ALL WATER METER BOXES SHALL BE LOCATED OUTSIDE OF DRIVEWAY AREAS.
7. ALL VALVES SHALL BE LOCATED OUTSIDE OF DRIVEWAYS, VALLEY AND CURB GUTTERS.
8. ALL WATER AND STORM DRAIN OR SANITARY SEWER CROSSINGS SHALL CONFORM TO SECTION 2.22 OF THE 2010 EDITION OF THE UDACS.
9. ALL WATER FACILITIES SHALL BE FILLED, DISINFECTED, PRESSURE TESTED, FLUSHED, FILLED, AND AN ACCEPTABLE WATER SAMPLE OBTAINED, PRIOR TO CONNECTION TO THE LVWD DISTRIBUTION SYSTEM.
10. THE CONTRACTOR MUST OBTAIN ALL METERS TWO (2) INCHES AND SMALLER FROM THE LVWD CENTRAL AREA PHONE 258-3152 OR 258-3602, TWO (2) WORKING DAYS PRIOR TO METER PICKUP.
11. ANY INTERRUPTION OF SERVICE MUST BE PERFORMED IN ACCORDANCE WITH UDACS SECTION 3.14.01, AND APPROVED BY THE LVWD INSPECTION DIVISION PRIOR TO SHUTDOW. PROPER WRITTEN NOTIFICATION MUST BE GIVEN TO ALL AFFECTED CUSTOMERS.
12. ALL WATER FACILITY CONSTRUCTION MATERIALS USED MUST BE AS LISTED ON THE LVWD PRE-APPROVED MATERIALS AND MANUFACTURER'S LISTING FOR NEW FACILITIES, LATEST REVISION, OR SPECIFICALLY APPROVED ON THESE PLANS.
13. TELEPHONE "CALL BEFORE YOU DIG" AT "811" OR 1-800-227-2600.
14. THE INSTALLATION OF LAS VEGAS VALLEY WATER (LVMW) MUNICIPAL WATER FACILITIES WITHIN THE STREET IS ASSUMED TO BE IN COMPLIANCE WITH THE UNIFORM STANDARDS, INCLUDING THE PLACEMENT OF ASPHALT PAVING STREET WORK. ANY REPAIR WORK DONE BY THE LVWD TO THE ANIMAL WATER FACILITIES WILL BE THE RESPONSIBILITY OF THE LVWD. AN INAPPROPRIATELY SIZED ASPHALT REPAIR PATCH ON THE STREET SURFACE. ANY DECORATIVE PAVING SURFACE WITHIN THE STREET IS THE RESPONSIBILITY OF THE OWNER'S ASSOCIATION OR THE INDIVIDUAL PROPERTY OWNERS IF NO OWNER'S ASSOCIATION IS IN EXISTENCE, OR THE AGENCY HAVING JURISDICTION. DECORATIVE SURFACE MATERIALS PLACED WITHIN THE TEN FOOT EASEMENT ABUTTING A PUBLIC OR PRIVATE STREET, IF DISTURBED BY THE LVWD DURING THE REPAIR OR OPERATION OF ITS FACILITIES, WILL BE REPLACED BY LVWD WITH AN APPROPRIATELY SIZED PLANT FINISHING PATCH. THE LVWD WILL NOT RESTORE, AND WILL NOT BE RESPONSIBLE FOR THE RESTORATION OF, ANY DECORATIVE PAVING SURFACE WITHIN THE STREET. THE LVWD WILL NOT ATTEMPT TO MATCH COLOR OR FINISH OF EXISTING ADJACENT DRIVEWAYS.

15. NO LEAD COMPLIANCE NOTE:

TO COMPLY WITH THE FEDERAL SAFE DRINKING WATER ACT, ALL WATER WORKS BRASS PRODUCTS PROPOSED TO BE RELOCATED, OR INSTALLED AS REPLACEMENTS, MUST BE Labeled WITH THE LEAD FREE APPROVED PRODUCT. THE OLD LEADED PRODUCT MAY NOT BE REUSED.

APPROVED FOR CONSTRUCTION

John Shook
 Las Vegas Valley Water District Engineering Services

 
Project No. 135214

First Approved Date: 3-28-19

LVWD Approved Fire Flow: Total 1,500 GPM/Onsite 1,500 GPM

GB	GRADE BREAK
HDPE	HIGH DENSITY POLYETHYLENE
HDWL	HEADWALL
HGL	HYDRAULIC GRADE LINE
HP	HIGH POINT
INV	INVERT
IRR	IRRIGATION
LAT	LATERAL
LF	LINAL FEET
LS	LANDSCAPE
LT	LEFT
LVWD	LAS VEGAS VALLEY WATER DISTRICT
MAX	MAXIMUM
MH	MANHOLE
MTR	MINIMUM
MR	METER
RB	PULL BOX
PL	PROPERTY LINE
PROP	POWER POLE
PROV	PROPOSED POLY VINYL CHLORIDE PIPE
PVMT	PAVEMENT
RM	TOP OF MANHOLE OR CLEANOUT
RT	RIGHT
ROW	RIGHT-OF-WAY
SS	SANITARY SEWER
SD	STORM DRAIN
SNWA	SOUTHERN NEVADA WATER AUTHORITY
STA	STATION
STL	STREET LIGHT
SVZ	SIGHT VISIBILITY ZONE
SW	SIDEWALK
TEL	TELEPHONE
TC	TOP OF CURB
TF	TOP OF FOOTING
TW	TOP OF WALL
TYP	TYPICAL
UDACS	UNIFORM DESIGN AND CONSTRUCTION STANDARDS
VG	VALLEY GUTTER
WL	WATER LINE







LEGAL DESCRIPTION

CONSTRUCTION NOTES

ON STREET PARKING

CLARK COUNTY DEPARTMENT

BY: Ben E 5/7/2019

Call before you dig
Avoid cutting underground

SYSTEM OF TRANSPORTATION

1


5

[illegible]

PRINTS REQUIRE ENGINEER'S SEAL
AND SIGN FOR PROOF OF VALIDITY

ABBREVIATIONS	(SEE CIV. SHT. FOR COMPLETE LIST)
AC	ASPHALTIC CONCRETE
ADJ	ADJUST
AGG	AGGREGATE
BC	BACK OF CURB
BOR	BEGINNING OF CURB RETURN
BEG	BEGIN
BSW	BACK OF SIDEWALK
BVC	BEGINNING OF VERTICAL CURVE
CATV	CABLE TV
CAUSD	CLARK COUNTY AREA
CCRFCD	UNIFORM STANDARD DRAWING
CL	CLARK COUNTY REGIONAL FLOOD CONTROL DISTRICT CENTERLINE
CLV	CITY OF LAS VEGAS
CMU	CONCRETE MASONRY UNIT
CO	CLEAN OUT
COMM	COMMUNICATIONS
CONC	CONCRETE
COND	CONDUIT
CULV	CULVERT
DC	DEPRESSED CURB
DG	DECOMPOSED GRANITE
DIP	DUCTILE IRON PIPE
DOM	DOMESTIC
ELEC	ELECTRIC
EAC	EDGE OF AC
ECR	END OF CURB RETURN
EG	EXISTING GROUND
ELEV	ELEVATION
EP	EDGE OF PAVEMENT
EV	END OF VERTICAL CURVE
EX	EXISTING
FAST	FREEMONT & ARTERIAL SYSTEM OF TRANSPORTATION
FF	FINISH FLOOR
FG	FINISH GRADE
FL	FIRE HYDRANT
FL	FLOW LINE
FO	FIBER OPTICS
FS	FINISHED SURFACE
GB	GRADE BREAK
HDPE	HIGH DENSITY POLYETHYLENE
HQL	HEADWALL
HGL	HYDRAULIC GRADE LINE
HP	HIGH POINT
INV	INVERT
IRR	IRRIGATION
LAT	LATERAL
LF	LINEAL FEET
LS	LANDSCAPE
LVWD	LAS VEGAS VALLEY WATER DISTRICT
MAX	MAXIMUM
MH	MANHOLE
MIN	MINIMUM
MTR	METER
PB	PULL BOX
PL	PROPERTY LINE
PP	POWER POLE
PROP	PROPOSED
PVC	POLY VINYL CHLORIDE PIPE
PVMT	PAVEMENT
RIM	TOP OF MANHOLE OR CLEANOUT
RT	RIGHT
ROW	RIGHT-OF-WAY
SS	SANITARY SEWER
SD	STORM DRAIN
SNWA	SOUTHERN NEVADA WATER AUTHORITY
STA	STATION
STLT	STREET LIGHT
SVZ	SIGHT VISIBILITY ZONE
SW	SEWER
TEL	TELEPHONE
TC	TOP OF CURB
TF	TOP OF FOOTING
TW	TOP OF WALL
TYP	TYPICAL
UDACS	UNIFORM DESIGN AND CONSTRUCTION STANDARDS
VG	VALLEY GUTTER
WL	WATER LINE
WGSW	WATER QUALITY SWALE

DESCRIPTION	EXISTING	PROPOSED
UTILITIES		
B.O. VALVE	⬆	⬆
FIRE HYDRANTS	⊙	⊙
CLEAN OUT	⊙	⊙
GATE VALVE	⊙	⊙
METER	⊙	⊙
REDUCER	⊙	⊙
CAP	⊙	⊙
11.25" ELBOW	⊙	⊙
22.5" ELBOW	⊙	⊙
45" ELBOW	⊙	⊙
90" ELBOW	⊙	⊙
CROSS	⊙	⊙
TEE	⊙	⊙
MANHOLES		
ELECTRICAL	⊙	⊙
SANITARY SEWER	⊙	⊙
STORM DRAIN	⊙	⊙
TELEPHONE	⊙	⊙
STREET LIGHTS		
100W HPS STL.	⊙	⊙
150W HPS STL.	⊙	⊙
200W HPS STL.	⊙	⊙
250W HPS STL.	⊙	⊙
400W HPS STL.	⊙	⊙
GRADING		
SPOT ELEV.	12.34	12.34
SLOPE	1.23%	1.23%
5' CONT.	(2005)	(2005)
1' CONT.	(2007)	(2007)
SITE		
SIGN	—	—
"L" CURB	—	—
"A" CURB	—	—
EDGE OF PAVT.	—	—
WALL	—	—
LINE TYPES		
CL OR SECTION LINE	—	—
PROPERTY LINE	—	—
RIGHT OF WAY LINE	—	—
EASEMENT LINE	—	—
SAWTOOTH	—	—
FLOW LINE	—	—
SHADES		
HEAVY AC PAVEMENT	—	—
LIGHT AC PAVEMENT	—	—
CONCRETE PAVEMENT	—	—

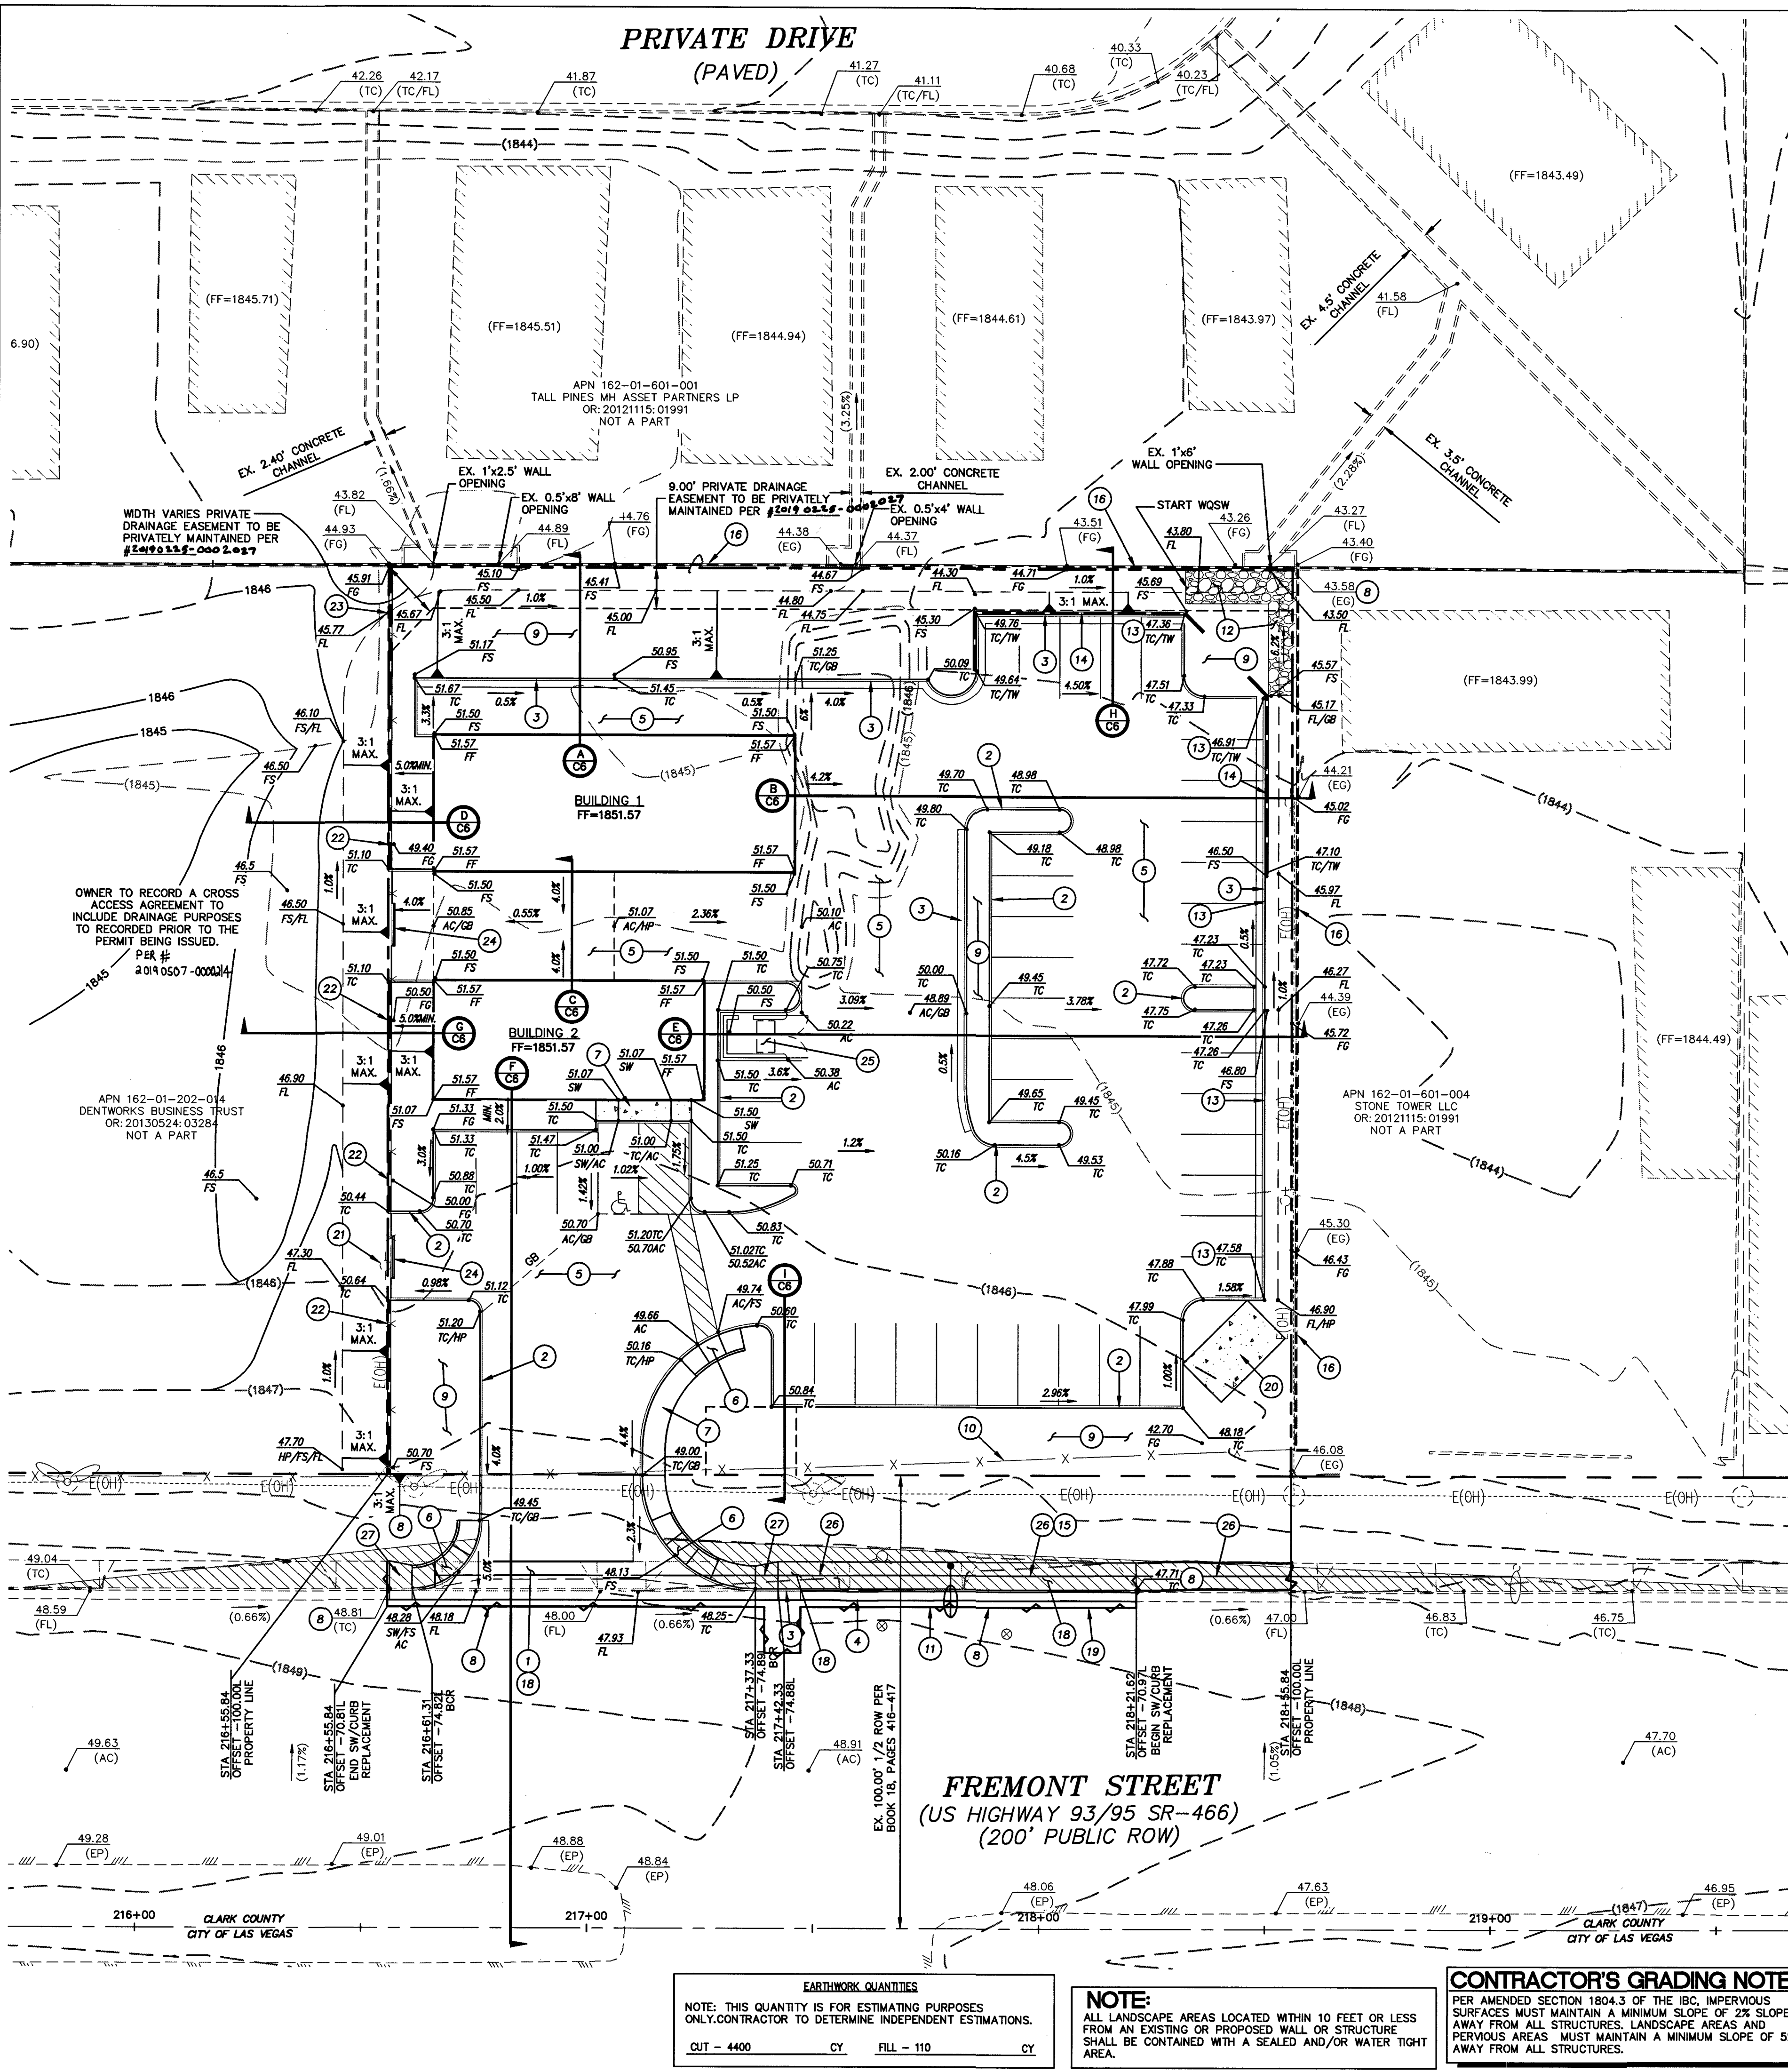

- ### CONSTRUCTION NOTES
- CONSTRUCT COMMERCIAL DRIVEWAY AND CROSS GUTTER PER CCAUSD #225 AND 228, WITH GEOMETRICS PER CCAUSD #222.1.
 - CONSTRUCT "A" TYPE CURB PER CCAUSD #219.
 - CONSTRUCT "L" TYPE CURB & GUTTER PER CCAUSD #216.
 - REMOVE EXISTING CURB AND GUTTER & DISPOSE OF PROPERLY.
 - CONSTRUCT 2.5" AC PAVEMENT OVER 5.5" TYPE II AGGREGATE BASE. SEE GEOTEK INC. REPORT #13381-LV.
 - CONSTRUCT ADA RAMP PER CCAUSD #235, CASE I, A&B=B'.
 - CONSTRUCT 5" WIDE CONCRETE SIDEWALK PER CCAUSD #234.
 - MATCH EXIST. ELEVATION
 - LANDSCAPE AREA. SEE LANDSCAPE ARCHITECT'S PLANS.
 - REMOVE CHAINLINK FENCE AND RETURN TO OWNER.
 - REMOVE EXISTING DRIVEWAY & DISPOSE OF PROPERLY.
 - CONSTRUCT 2.5" AC PAVING, REMOVE AND DISPOSE OF PROPERLY.
 - CONSTRUCT 6" CONCRETE OVER 6" TYPE II AGGREGATE BASE. SEE GEOTEK INC. REPORT #13381-LV.
 - REMOVE EXISTING POLE. CONFIRM ITS OWNER AND RETURN POLE TO OWNER.
 - CONSTRUCT 1'x4' BLOCK WALL OPENING SEE DETAIL PAGE C6.
 - CONSTRUCT 2'x10' BLOCK WALL OPENING SEE DETAIL PAGE C6.
 - CONSTRUCT ROLLING STEEL GATE SEE ARCHITECT PLANS.
 - CONSTRUCT TRASH ENCLOSURE SEE ARCHITECT PLANS.
 - CONSTRUCT 6" WIDE CONCRETE SIDEWALK PER CCAUSD #234.
 - CONSTRUCT 6' TO 5' SIDEWALK TRANSITION FROM BOR TO PL.

FLOODZONE NOTE:


THE SUBJECT LIES WITHIN FEMA ZONE X PER MAP NUMBER 32003X2100. EFFECTIVE DATE NOVEMBER 2011. INDICATES THE SITE IS LOCATED WITHIN FEMA ZONE 'X'. ZONE 'X' IS AN AREA DETERMINED TO BE OUTSIDE THE 0.2% ANNUAL CHANCE FLOOD PLAIN.

STORMWATER MANAGEMENT NOTES:

- THE OWNER, SITE DEVELOPER, CONTRACTOR, AND/OR THEIR AUTHORIZED AGENTS SHALL EACH DAY REMOVE ALL SEDIMENT, MUD, CONSTRUCTION DEBRIS OR OTHER POTENTIAL POLLUTANTS THAT MAY HAVE BEEN DISCHARGED TO, OR ACCUMULATED IN, THE PUBLIC RIGHTS OF WAY OF CLARK COUNTY AS A RESULT OF CONSTRUCTION ACTIVITIES ASSOCIATED WITH THIS SITE DEVELOPMENT OR CONSTRUCTION PROJECT. SUCH MATERIALS SHALL BE PREVENTED FROM ENTERING THE STORM SEWER SYSTEM.
- ADDITIONAL CONSTRUCTION SITE DISCHARGE BEST MANAGEMENT PRACTICES MAY BE REQUIRED OF THE OWNER AND HIS OR HER AGENTS DUE TO UNFORESEEN EROSION PROBLEMS OR IF THE SUBMITTED PLAN DOES NOT MEET THE PERFORMANCE STANDARDS SPECIFIED IN CLARK COUNTY TITLE 24.42 AND THE LAS VEGAS VALLEY CONSTRUCTION SITE BMP GUIDANCE MANUAL.
- TEMPORARY OR PERMANENT STABILIZATION PRACTICES WILL BE INSTALLED ON DISTURBED AREAS AS SOON AS PRACTICABLE AND NO LATER THAN 14 DAYS AFTER THE CONSTRUCTION ACTIVITY IN THAT PORTION OF THE SITE HAS TEMPORARILY OR PERMANENTLY CEASED. SOME EXCEPTIONS MAY APPLY; REFER TO THE NEVADA STORMWATER GENERAL PERMIT FOR CONSTRUCTION ACTIVITY NVR100000, SECTION III.A.5.
- AT A MINIMUM, THE CONTRACTOR OR HIS AGENT SHALL INSPECT ALL DISTURBED AREAS, AREAS USED FOR STORAGE OF MATERIALS AND EQUIPMENT THAT ARE EXPOSED TO PRECIPITATION, VEHICLE ENTRANCE AND EXIT LOCATIONS, AND ALL BMPs WEEKLY, AND WITHIN 24 HOURS AFTER ANY RAIN EVENT OF 0.5 INCHES OR MORE. THE CONTRACTOR OR HIS AGENT SHALL UPDATE OR MODIFY THE STORMWATER POLLUTION PREVENTION PLAN AS NECESSARY. SOME EXCEPTIONS TO WEEKLY INSPECTIONS MAY APPLY, SUCH AS SUSPENSION OF LAND DISTURBANCE ACTIVITIES. REFER TO THE NEVADA STORMWATER GENERAL PERMIT FOR CONSTRUCTION ACTIVITY NVR 100000, SECTION III.A.12.
- ACCUMULATED SEDIMENT IN BMPs SHALL BE REMOVED WITHIN SEVEN DAYS AFTER STORMWATER RUNOFF OR PRIOR TO THE NEXT ANTICIPATED STORM EVENT, WHICHEVER IS EARLIER. SEDIMENT MUST BE REMOVED WHEN BMP DESIGN CAPACITY HAS BEEN REDUCED BY 50 PERCENT OR MORE.

SIGHT VISIBILITY ZONES

SIGHT VISIBILITY ZONE - NO WALLS, FENCES, SHRUBS, UTILITY APPURTENANCES OR ANY OTHER OBJECT, OTHER THAN TRAFFIC CONTROL DEVICES, FIRE HYDRANTS, TREES, AND STREET LIGHT POLES, MAY BE CONSTRUCTED OR INSTALLED WITHIN THE SIGHT VISIBILITY ZONE UNLESS SAID OBJECT IS MAINTAINED AT LESS THAN 24 INCHES HEIGHT, MEASURED FROM THE TOP OF CURB, OR WHERE NO CURB EXISTS, A HEIGHT OF 27 INCHES MEASURED FROM THE TOP OF ADJACENT ASPHALT, GRAVEL OR PAVEMENT STREET SURFACE. THIS RESTRICTION EXTENDS ALONG SIGHT VISIBILITY LINE THROUGH LANDSCAPE MEDIANS.

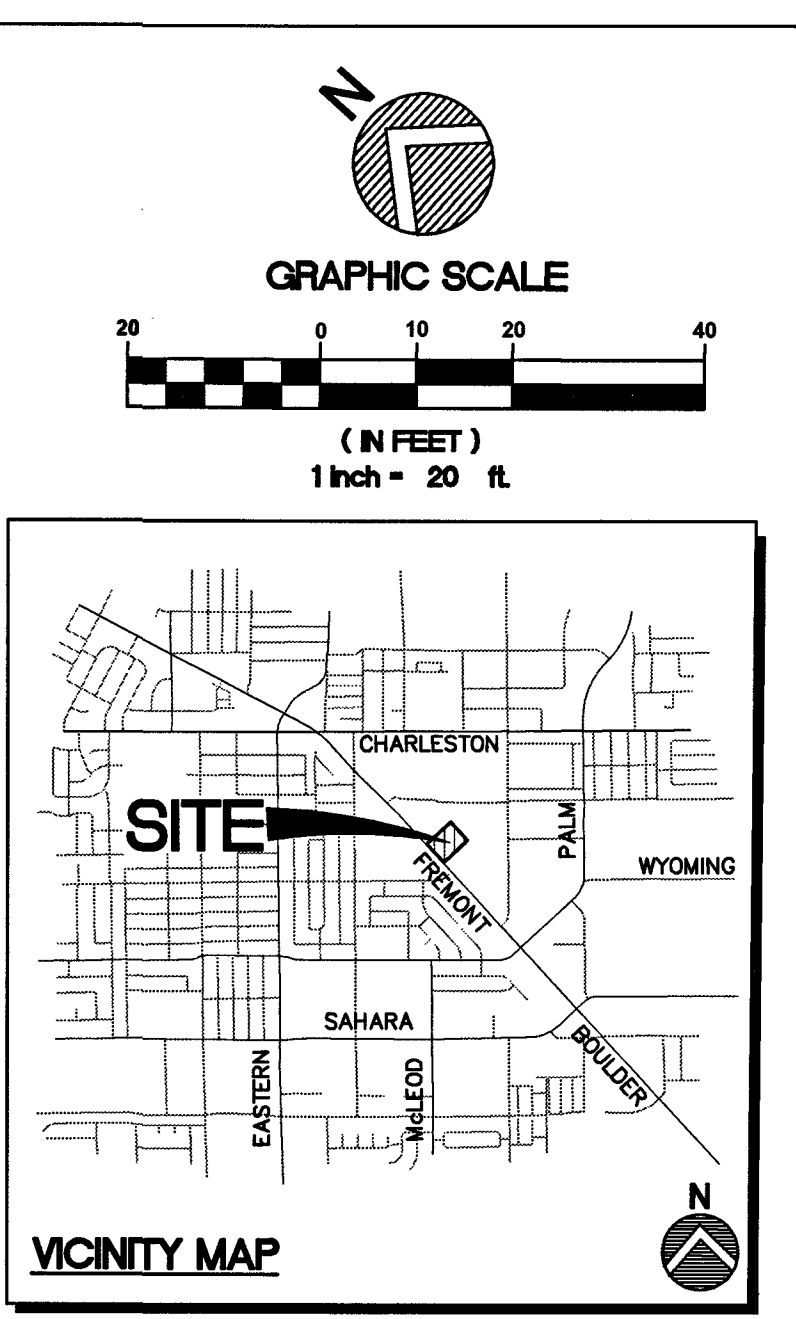

BASIS OF BEARING

NORTH 001°30'33" WEST BEING THE WEST LINE OF THE SOUTHEAST QUARTER (SE 1/4) OF THE NORTHWEST QUARTER (NW 1/4) OF SECTION 21 SOUTH, RANGE 61 EAST, M.D.M., CLARK COUNTY, NEVADA, AS SHOWN IN FILE 120 PAGE 28 OF PARCEL MAPS, OFFICIAL RECORDS, CLARK COUNTY, NEVADA.

BENCHMARK

CLARK COUNTY BOULEVARD 2 AZI. NO. 3 1977 (NAVD 1988)
4" NGS BRASS CAP IN TOP OF CURB ON EAST SIDE OF FREMONT ST. AT 2965 FREMONT STREET.
ELEVATION=1847.05 FEET/562.983 METERS (NAVD 88 DATUM)

GRADING NOTES:

- SLOPES 4:1 OR STEEPER AND FINE-GRAINED MATERIALS THAT HAVE BEEN DISTURBED (SANDY AND SILTY MATERIALS) SHOULD BE PROTECTED WITH BURLAP OR OTHER EROSION CONTROL FABRIC/MATERIAL, UNLESS OTHERWISE SPECIFIED BY LANDSCAPE DRAWINGS AND SPECIFICATIONS OR THE SOILS REPORT.
- CONTRACTOR SHALL DETERMINE HIS OWN FOOTING OR BASEMENT EXCAVATION QUANTITIES, EVEN THOUGH SHOWN ON ROUGH GRADING PLANS. ADDITIONALLY, STRUCTURE BACKFILL COSTS SHOULD BE INCLUDED IN THE COST OF THE STRUCTURE, UNLESS OTHERWISE SPECIFIED IN THE CONTRACT DOCUMENTS.
- CONTRACTOR SHALL NOTIFY CIVILWORKS INC WITHIN 24 HOURS OF OMISSIONS AND ERRORS DISCOVERED ON PLANS. CIVILWORKS INC WILL NOT BE RESPONSIBLE FOR ANY "CORRECTIVE" WORK DONE BY OTHERS.

GEOTECHNICAL NOTES:

A GEOLOGIST OR GEOTECHNICAL ENGINEER SHALL BE ON SITE DURING EXCAVATION AND MASS GRADING OPERATIONS TO EXAMINE THE SOIL CHARACTERISTICS AND GEOLOGICAL CONDITIONS ENCOUNTERED, AND TO PROVIDE PROFESSIONAL ADVICE TO THE OWNER IN THE EVENT THAT UNANTICIPATED SOIL PROBLEMS ARISE AND/OR SUBSURFACE SITE CONDITIONS ARE FOUND TO BE SIGNIFICANTLY DIFFERENT THAN DEFINED BY PRE-DESIGN EXPLORATION AND TESTING.

CONTRACTOR TO ENSURE POSITIVE DRAINAGE. NO PONDING ALLOWED. CONTRACTOR TO FOLLOW RECOMMENDATIONS AS OUTLINE IN THE PROJECT GEOTECHNICAL REPORT, INCLUDING BUT NOT LIMITED TO EXCAVATION, GRADING AND COMPACTION. REFER TO THE REPORT PREPARED BY:

GEOTEK INC.
DATE: MARCH 7, 2017 (ORIGINAL) JUNE 1, 2018 (UPDATE)
SEPT. 5, 2018 (ADDENDUM)
PROJECT NUMBER: 13381-LV

CLARK COUNTY DEPARTMENT OF PUBLIC WORKS DEVELOPMENT REVIEW

ACCEPTANCE OF PLANS FOR FILING:

BY: *Brandon A. Potts* DATE: *5/7/2019*

ACCEPTANCE OF THESE PLANS FOR FILING SHALL NOT BE CONSTRUED TO BE A PERMIT FOR, OR AN APPROVAL OF, ANY VIOLATION OF ANY OF THE PROVISIONS OF THE STATE OR COUNTY LAWS AND/OR SPECIFICATIONS. CLARK COUNTY SHALL BE HELD FREE FROM DAMAGES WHICH MAY RESULT FROM THE CONSTRUCTION OF THE IMPROVEMENTS FROM THE ENGINEERING DESIGN DEPICTED HEREIN. NOTE: POWER POLES AND/OR OTHER EXISTING FACILITIES NOT IN PROPER LOCATION, BASED ON PROPOSED IMPROVEMENTS SHOWN HEREON WILL BE RELOCATED AT NO EXPENSE TO CLARK COUNTY.

GRADING PLAN CERTIFICATION

BRANDON A. POTTS PE #13121 DATE: 3-7-19

CERTIFY THAT THIS GRADING PLAN IS IN CONFORMANCE WITH APPROVED DRAINAGE STUDY PW17-36719-DS FOR THIS SITE ON FILE AT CLARK COUNTY FOR THIS PROJECT.

FAST
Call before you dig
811
Underground
1-800-227-2600 1-702-432-5300 1-702-227-2929

CivilworksInc
Engineering with "sensible" solutions tailored to your "specific" needs.

Las Vegas, NV 89118
4945 W. Patrick Lane
Office#: (702)534-1816 Fax#: (702)534-1825

STUCKEY CAR SALES
© 2925 FREMONT STREET

OWNER FRANK STUCKEY
2625 FREMONT STREET
LAS VEGAS, NV
CONTACT: FRANK STUCKEY
PHONE: 702-403-2621

GRADING PLAN

DATE: 07/19/19
DRAWN BY: BAP
CHECKED BY: BAP
REVISIONS: 1

PRINTS REQUIRE ENGINEER'S SEAL AND SIGN FOR PROOF OF VALIDITY

BRANDON A. POTTS
PE #13121
Exp: 12/31/19
CIVIL

3-7-19

SHEET # *18-02521* 207V259
C4
4 OF 6

PW18-14518





ABBREVIATIONS
(SEE C.V.R. SHT. FOR COMPLETE LIST)

AC	ADJUST
AGG	AGGREGATE
BC	BACK OF CURB
BGR	BEGINNING OF CURB RETURN
BEG	BEGIN
BSW	BACK OF SIDEWALK
BVC	BEGINNING OF VERTICAL CURVE
CATV	CABLE TV
CAUSID	CLARK COUNTY AREA
CCRFCD	UNIFORM STANDARD DRAWING
CL	CLARK COUNTY REGIONAL FLOOD CONTROL DISTRICT CENTERLINE
CLV	CITY OF LAS VEGAS
CMU	CONCRETE MASONRY UNIT
CO	CLEAN OUT
COMM	COMMUNICATIONS
COND	CONDUIT
CULV	CULVERT
DC	DECOMPOSED CURB
DG	DECOMPOSED GRANITE
DIP	DUCTILE IRON PIPE
DOM	DOMESTIC
ELEC	ELECTRIC
EAC	EDGE OF AC
END	END OF CURB RETURN
EG	EXISTING GROUND
ELEV	ELEVATION
EP	EDGE OF PAVEMENT
EV	END OF VERTICAL CURVE
EX	EXISTING
FAST	FREEWAY & ARTERIAL SYSTEM OF TRANSPORTATION
FF	FINISH GRADE
FG	FINISH GRADE
FL	FIRE HYDRANT
FL	FLOW LINE
FO	FIBER OPTICS
FS	FINISHED SURFACE

GB	GRADE BREAK
HDPE	HIGH DENSITY POLYETHYLENE
HDWL	HEADWALL
HGL	HYDRAULIC GRADE LINE
HP	HIGH POINT
INV	INVERT
IRR	IRRIGATION
LAT	LATERAL
LF	LINEAL FEET
LS	LANDSCAPE
LT	LEFT
LVWD	LAS VEGAS VALLEY WATER DISTRICT
MAX	MAXIMUM
MIN	MINIMUM
MTR	METER
PL	PULL BOX
PP	PROPERTY LINE
PROP	PROPOSED
PVC	POLY VINYL CHLORIDE PIPE
PVMT	PAVEMENT
RM	TOP OF MANHOLE OR CLEANOUT
RT	RIGHT-OF-WAY
SS	SANITARY SEWER
SD	STORM DRAIN
SNWA	SOUTHERN NEVADA WATER AUTHORITY
STA	STATION
STLT	STREET LIGHT
SVZ	SIGHT VISIBILITY ZONE
SW	SIDEWALK
TEL	TELEPHONE
TC	TOP OF CURB
TF	TOP OF FOOTING
TW	TOP OF WALL
TYP	TYPICAL
UDACS	UNIFORM DESIGN AND CONSTRUCTION STANDARDS
VG	VALLEY GUTTER
WL	WATER LINE

LEGEND

DESCRIPTION	EXISTING	PROPOSED
UTILITIES		
B.O. VALVE		
FIRE HYDRANTS		
CLEAN OUT		
GATE VALVE		
METER		
REDUCER		
CAP		
11.25' ELBOW		
22.5' ELBOW		
45' ELBOW		
90' ELBOW		
CROSS		
TEE		
MANHOLES		
ELECTRICAL		
SANITARY SEWER		
STORM DRAIN		
TELEPHONE		
STREET LIGHTS		
100W HPS STL.		
150W HPS STL.		
200W HPS STL.		
250W HPS STL.		
400W HPS STL.		
GRADING		
SPT. ELEV.	12.35	12.34
TO	(1.2%)	1.23%
5' CONT.	(2005)	(2005)
1' CONT.	(2007)	(2007)
SITE		
SIGN		
"L" CURB		
"A" CURB		
EDGE OF PAVT.		
WALL		
LINE TYPES		
CL OR SECTION LINE		
PROPERTY LINE		
RIGHT OF WAY LINE		
EASEMENT LINE		
SAWTOOTH LINE		
FLOW LINE		
SHADES		
HEAVY AC PAVEMENT		
LIGHT AC PAVEMENT		
CONCRETE PAVEMENT		

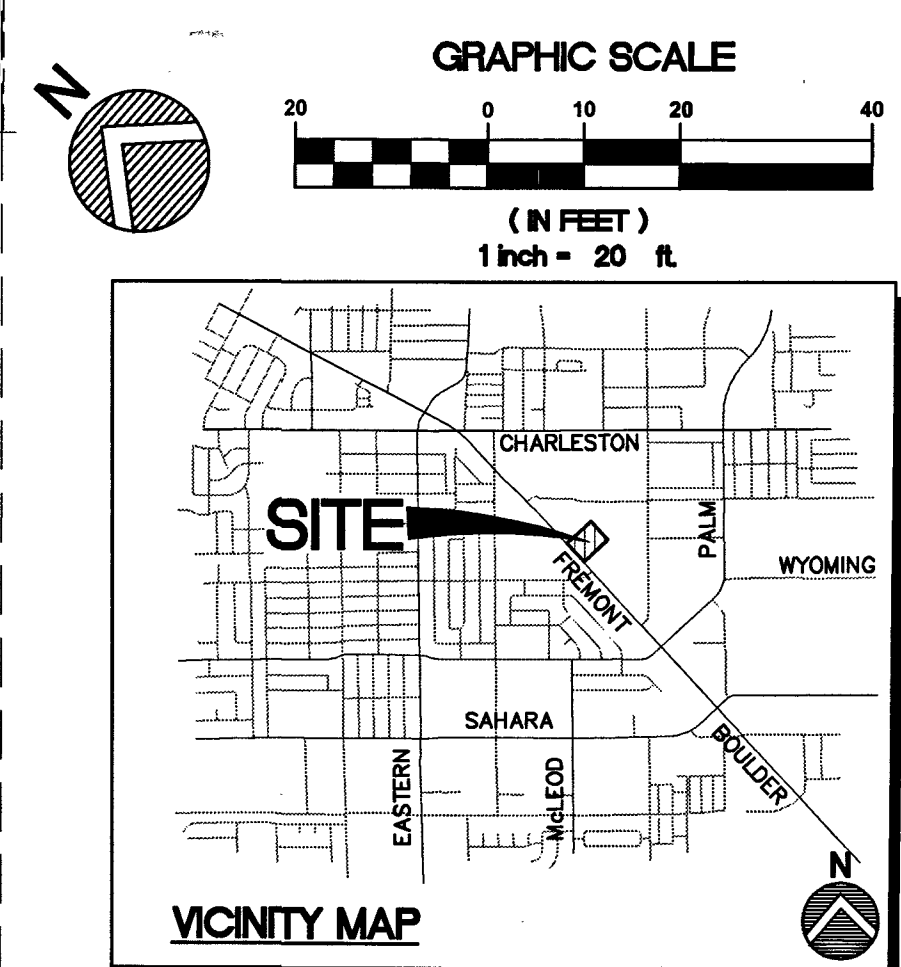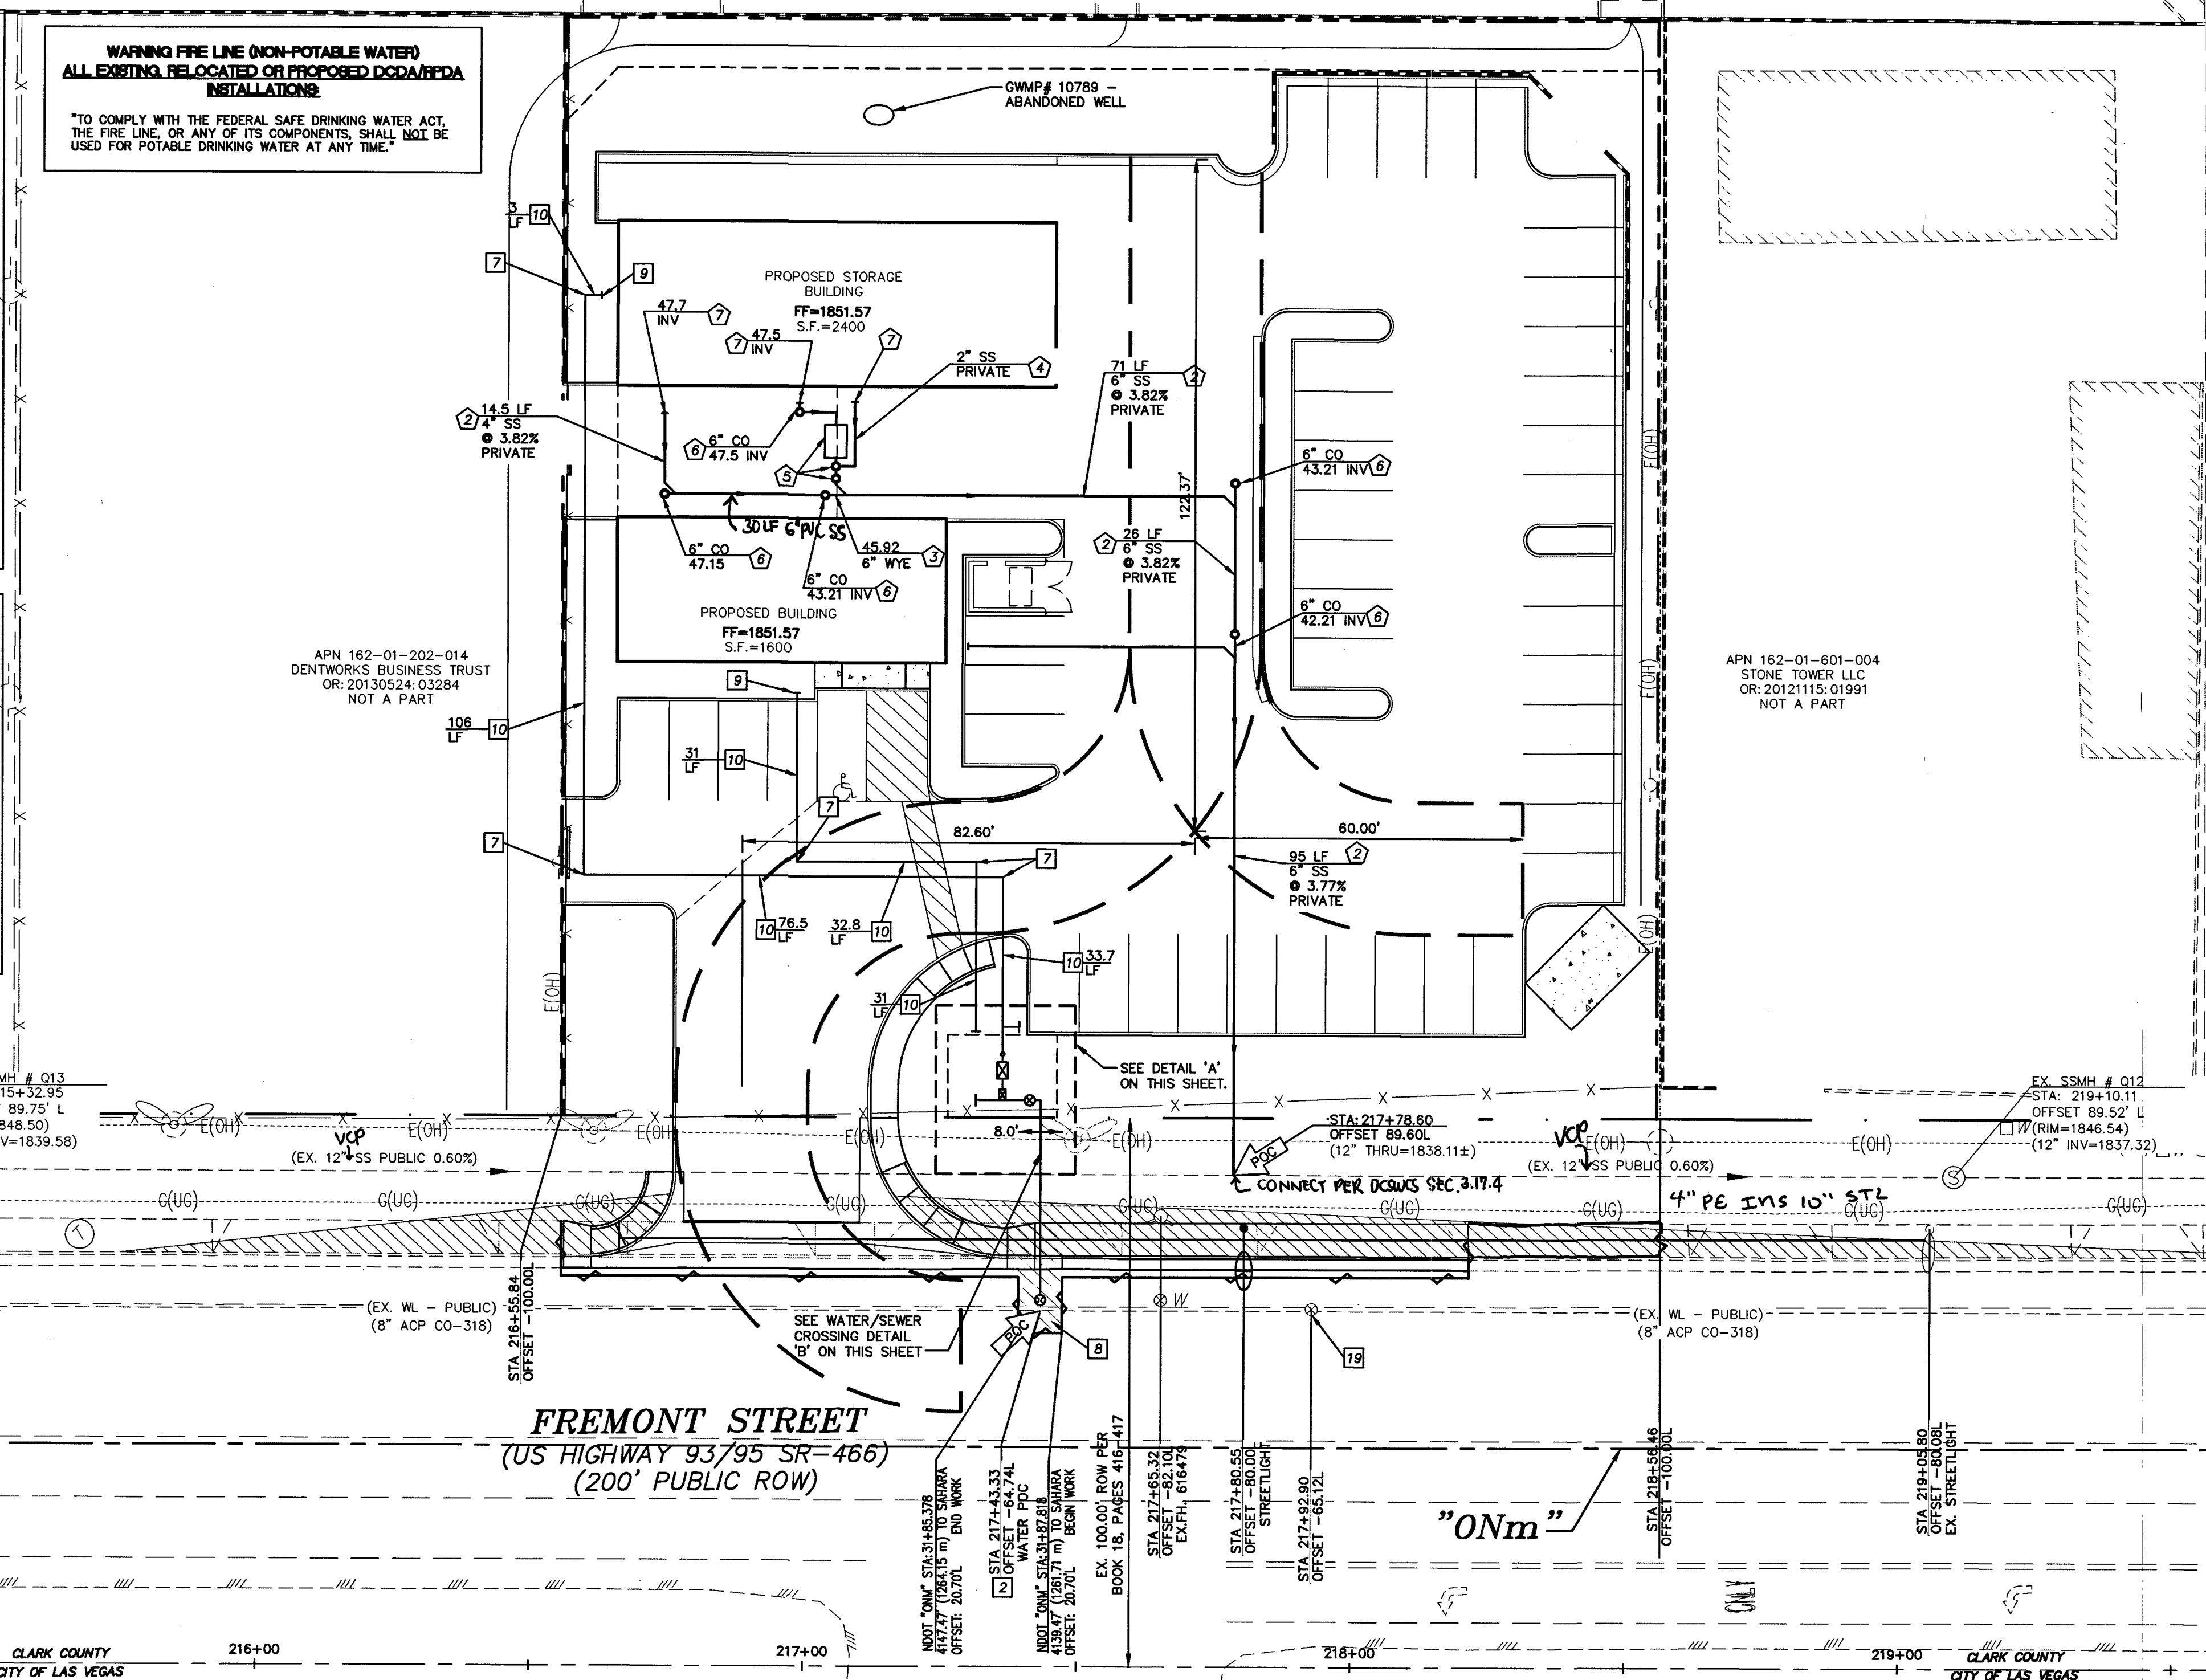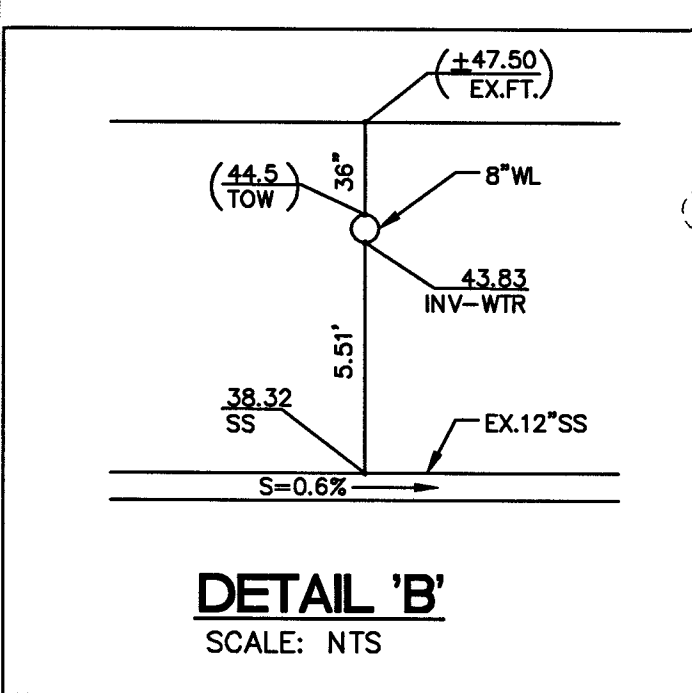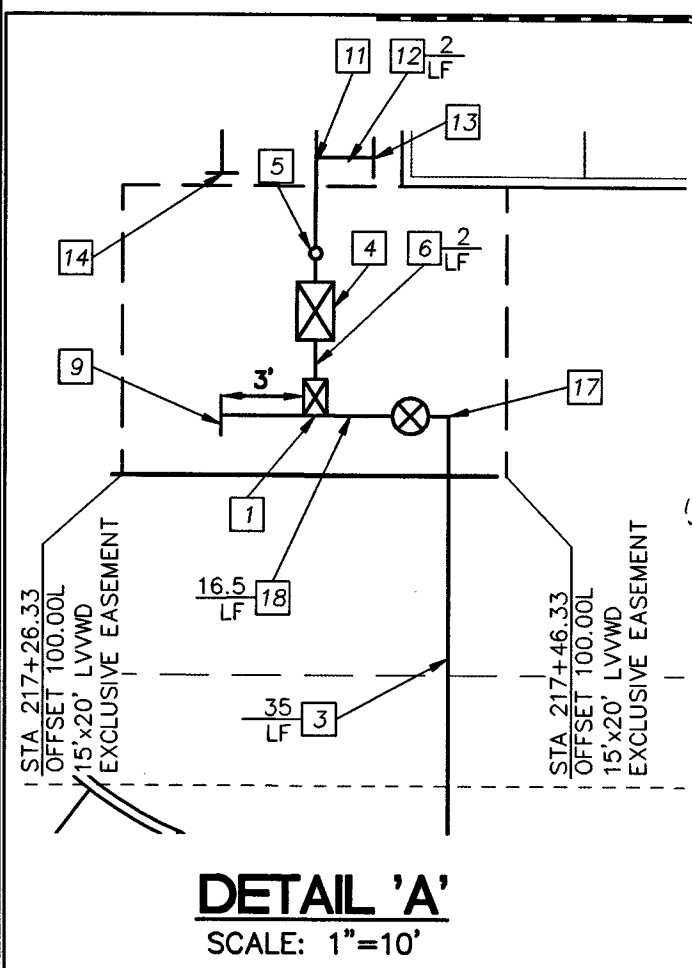

BASIS OF BEARING
NORTH 0°13'03" WEST BEING THE WEST LINE OF THE SOUTHEAST QUARTER (SE 1/4) OF THE NORTHWEST QUARTER (NW 1/4) OF SECTION 1, TOWNSHIP 21 SOUTH, RANGE 61 EAST, M.D.M., CLARK COUNTY, NEVADA, AS SHOWN IN FILE 120 PAGE 28 OF PARCEL MAPS, OFFICIAL RECORDS, CLARK COUNTY, NEVADA.

BENCHMARK
CLARK COUNTY BOULEVARD 2 AZI. NO. 3 1977 (NAVD 1988)
4" NGS BRASS CAP IN TOP OF CURB ON EAST SIDE OF FREMONT ST. AT 2985 FREMONT STREET.
ELEVATION=1847.05 FEET/562.983 METERS (NAVD 88 DATUM)

- SEWER CONSTRUCTION NOTES**
- INSTALL 6" PVC SS LATERAL PER DCSWCS SD-18, SD-23, SD-25.
 - INSTALL 6" PVC SS LATERAL PER SD-23 AND SD-25 (SLOPE PER PLAN). TRENCH & BACK FILL PER DCSWCS NO SD-18.
 - INSTALL WYE PER DCSWCS SD-12.
 - INSTALL 2" PVC SS VENT LATERAL PER SD-23 AND SD-25 (SLOPE PER PLAN). TRENCH & BACK FILL PER DCSWCS NO SD-18.
 - INSTALL SAND/OIL INTERCEPTOR, SAMPLE BOX, AND CLEANOUTS PER PLUMBING PLANS.
 - INSTALL 6" TRAFFIC-RATED SS CLEANOUT PER DCSWCS NO SD-26.
 - STUB AND CAP. SEE PLUMBING PLANS FOR CONTINUATION.

FWWD SURVEY NOTE
CONTRACTOR SHALL EMPLOY A NEVADA LICENSED PROFESSIONAL LAND SURVEYOR (PLS) TO FIELD STAKE THE EXTENT OF THE PROPOSED/EXISTING FWWD EASEMENT WITHIN THE PROJECT SITE. THESE STAKES SHALL BE CONTINUOUSLY MAINTAINED DURING THE CONSTRUCTION OF THE PROJECT. THE PLS SHALL ALSO FIELD STAKE THE PROPOSED EXTENT OF ADJACENT PROJECT BUILDING IMPROVEMENTS IMMEDIATELY ADJACENT TO THE EASEMENT. CONTRACTOR SHALL NOTIFY THE FWWD INSPECTOR AT LEAST FORTY-EIGHT (48) HOURS PRIOR TO PROPOSED INITIAL BUILDING EXCAVATION AND FOUNDATION CONSTRUCTION ACTIVITY. FWWD WILL INSPECT THE FIELD STAKING FOR COMPLIANCE WITH SEPARATION REQUIREMENTS. THE CONTRACTOR SHALL NOTIFY FWWD PRIOR TO UTILITY TRENCHING OR ANY OTHER SUBGRADE EFFORTS WITHIN THE PROPOSED/EXISTING FWWD EASEMENT.

FIRE FLOW CALCULATIONS
STUCKEY CAR SALES

BASED ON: SQUARE FOOTAGE:
TYPE OF CONSTRUCTION: V-B
BLDG 1: 1,600 S.F.
BLDG 2: 2,400 S.F.

SQUARE FOOTAGE:
NUMBER OF STORIES: 1
BUILDING HEIGHT: 25'
OCCUPANCY: B-OFFICE/S-1 AUTOMOTIVE REPAIR

SPRINKLER SYSTEM: NO
NUMBER OF HYDRANTS: 1 EXISTING
FLOW REQUIRED @ 20 PSI RESIDUAL: 1500 GPM

NOTE:
NEVADA DEPARTMENT OF TRANSPORTATION PERMIT REQUIRED:
AN APPROVED NDOT OCCUPANCY PERMIT SHALL BE OBTAINED THROUGH THE AGENCY PRIOR TO ANY CONSTRUCTION WITHIN THE NDOT RIGHT-OF-WAY. THE DEVELOPER ASSUMES ALL LIABILITY FOR WORK CONDUCTED UNDER THE AGENCY OBTAINED PERMIT THROUGH WARRANTY EXPIRATION.

NOTE:
PRETREATMENT INTERCEPTOR
INTERCEPTOR (GREASE OR SAND) SHOWN FOR REFERENCE PURPOSES ONLY
SIZING REQUIREMENTS FOR CWRD REVIEW AND APPROVAL TO BE INCLUDED ON THE CLARK COUNTY BUILDING DEPARTMENT TENANT IMPROVEMENT PLANS/PERMIT OR ON THE ARCHITECTURAL PLUMBING PLANS.

NOTE:
ALL ABOVE GROUND UTILITY APPURTENANCES SHALL CONFORM TO THE REQUIREMENTS OF TITLE 19.08.010.

NOTE:
CONTRACTOR TO VERIFY UTILITY STUB LOCATIONS AND SIZE WITH PLUMBING PLANS PRIOR TO INSTALLATION OF NEW UTILITIES. CONTRACTOR SHALL LOCATE EXISTING UTILITIES AND VERIFY UTILITY CONNECTION LOCATIONS, AND ANY DISCREPANCIES SHALL BE COORDINATED WITH THE OWNER, ARCHITECT AND ENGINEER PRIOR TO CONSTRUCTION.

ENGINEER NOTE: POINT OF CONNECTION
CONTRACTOR SHALL NOTIFY ENGINEER PRIOR TO CONSTRUCTION ACTIVITIES AND CONSTRUCTION OF SANITARY SEWER AND SEWER LATERALS OF ALL INVERT ELEVATIONS, ONCE INVERT INFORMATION IS RECEIVED, THE SLOPE AND INVERTS WILL BE REVISED ACCORDINGLY. IF THE CONTRACTOR DOES NOT PROVIDE THE INFORMATION, THE ENGINEER WILL NOT BE RESPONSIBLE FOR THE SANITARY SEWER DESIGN.

SOUTHWEST GAS APPROVAL
3/14/19
DATE

NOTE:
IF ANY OF THE EXISTING SERVICES ARE INCORRECTLY LOCATED OR NOT USED FOR ANY REASON, THE DEVELOPER SHALL ABANDON THE LATERALS AT THE CONNECTION TO THE ACTIVE MAIN IN ACCORDANCE WITH THE UDACS STANDARDS, AND AT THE DEVELOPER'S EXPENSE.

SIGHT VISIBILITY ZONES
SIGHT VISIBILITY ZONE - NO WALLS, FENCES, SHRUBS, UTILITY APPURTENANCES OR ANY OTHER OBJECT, OTHER THAN TRAFFIC CONTROL DEVICES, FIRE HYDRANTS, TREES, AND STREET LIGHT POLES, MAY BE CONSTRUCTED OR INSTALLED WITHIN THE SIGHT VISIBILITY ZONE UNLESS SAID OBJECT IS MAINTAINED AT LESS THAN 24 INCHES IN HEIGHT, MEASURED FROM THE TOP OF CURB, OR WHERE NO CURB EXISTS, A HEIGHT OF 27 INCHES MEASURED FROM THE TOP OF ADJACENT ASPHALT, GRAVEL OR PAVEMENT STREET SURFACE. THIS RESTRICTION EXTENDS ALONG SIGHT VISIBILITY LINE THROUGH LANDSCAPE MEDIANS.

WATER CONSTRUCTION NOTES

- INSTALL 1.5" SERVICE SADDLE, 1.5" TYPE K COPPER WATERLINE, & INSTALL 1.5" METER PER UDACS PLATE #4.
- INSTALL 8"x8" TAPPING SLEEVE WITH 8" TAPPING VALVE PER UDACS PLATE #34 AND #39
- INSTALL 8" CLASS 53 DIP WATER LINE. (PUBLIC)
- INSTALL 1.5" RPPA PER UDACS PLATE #8.
- INSTALL 1.5" CURB STOP (BALL VALVE) IN APPROVED BOX.
- INSTALL 1.5" BRASS WATER. (PUBLIC)
- INSTALL 90° BEND, (MATCH SIZE)
- TRENCH, SAWCUT, BACKFILL & AC PAVEMENT RESTORATION PER UDACS PLATE #17 & CCAUSD #503. PAVEMENT RESTORATION PER CCAUSD #500.4, 500.5, AND 503. TRENCH AND BACKFILL TO LANE LINE.
- STUB AND CAP. SEE PLUMBING PLANS.
- INSTALL 1.5" PVC WATER LINE. (PRIVATE)
- INSTALL 1" SERVICE SADDLE
- INSTALL 1" PVC WATER LINE FOR IRRIGATION. (PRIVATE)
- STUB AND CAP. SEE LANDSCAPE PLANS. (PRIVATE)
- STUB AND CAP FOR FUTURE CONNECTION
- INSTALL 8" GATE VALVE PER UDACS PLATE #30.
- INSTALL 1" SERVICE SADDLE, 1" TYPE K COPPER WATERLINE, & INSTALL 1" METER BOX PER UDACS PLATE #4.
- INSTALL 8" ELBOW W/ 6" REDUCER
- INSTALL 6" CLASS 53 DIP WATER LINE. (PUBLIC)
- INSTALL 8" ZONE VALVE IN CLOSED POSITION

CLARK COUNTY FIRE DEPARTMENT APPROVAL
3-14-19
DATE

APPROVAL OF THESE PLANS SHALL NOT BE CONSTRUED TO BE A PERMIT FOR, OR AN APPROVAL OF, ANY VIOLATION OF ANY OF THE PROVISIONS OF THE STATE OR COUNTY LAWS. FIRE FLOW 1500 GPM AT 20 P.S.I. RESIDUAL.

CLARK COUNTY WATER RECLAMATION DISTRICT
3/14/2019
DATE

CWRD PIPES NUMBER IS 18-708

SIGNATURE ON THESE PLANS SHALL NOT BE CONSTRUED TO BE A PERMIT FOR, OR AN APPROVAL OF, ANY VIOLATION OF CLARK COUNTY WATER RECLAMATION DISTRICT RULES, REGULATIONS, OR DESIGN AND CONSTRUCTION STANDARDS.

UTILITY PLAN

DATE: 07/20/19
DRAWN BY: BAP
CHECKED BY: BAP
REVISIONS:

PRINTS REQUIRE ENGINEER'S SEAL AND SIGN FOR PROOF OF VALIDITY

BRANDON A. POTTS
Exp: 12/31/19
CIVIL
No. 13171

3-14-19

18-02-521 207V2 59
C5
5 OF 6

FW18-14518

CivilWorksInc
Engineering with "sensible" solutions tailored to your "specific" needs.

STUCKEY CAR SALES
© 2925 FREMONT STREET











OWNER FRANK STUCKEY
2625 FREMONT STREET
LAS VEGAS, NV
CONTACT: FRANK STUCKEY
PHONE: 702-403-2621

Las Vegas, NV 89118
4945 W. Patrick Lane
Office#: (702)534-1816
Fax#: (702)534-1825


PROJ# 135214A QS162-01-NE

ABBREVIATIONS	
AC	ASPHALTIC CONCRETE
ADJ	ADJUST
AGG	AGGREGATE
BCR	BACK OF CURB
BEG	BEGINNING OF CURB RETURN
BEG	BEGIN
BSW	BACK OF SIDEWALK
BVC	BEGINNING OF VERTICAL CURVE
CATV	CABLE TV
CCAUUSD	CLARK COUNTY AREA
CORFCD	CLARK COUNTY REGIONAL FLOOD CONTROL DISTRICT CENTERLINE
CL	CITY OF LAS VEGAS
COMU	COMMUNICATIONS UNIT
CO	CLEAN OUT
COMM	COMMUNICATIONS
CONC	CONCRETE
COND	CONDUIT
CULV	CULVERT
DC	DEPRESSED CURB
DIG	DECOMPOSED GRANITE
DIP	DIUOTILE IRON PIPE
DOM	DOMESTIC
ELEC	ELECTRIC
EAC	EDGE OF AC
EOR	END OF CURB RETURN
EG	EXISTING GROUND
ELEV	ELEVATION
ED	EDGE OF PAVEMENT
ESC	END OF VERTICAL CURVE
EX	EXISTING
FAST	FREEMONT & ARTERIAL SYSTEM OF TRANSPORTATION
FF	FINISH FLOOR
FG	FINISH GRADE
FL	FIRE HYDRANT
FO	FIBER OPTICS
FS	FINISHED SURFACE
GB	GRADE BREAK
HDPE	HIGH DENSITY POLYETHYLENE
HDWL	HEADWALL
HGL	HYDRAULIC GRADE LINE
HP	HIGH POINT
INV	INVERT
IRR	IRRIGATION
LAT	LATERAL
LF	LINEAL FEET
LS	LANDSCAPE
LT	LEFT
LVVWD	LAS VEGAS VALLEY WATER DISTRICT
MAX	MAXIMUM
MH	MANHOLE
MIN	MINIMUM
MTR	METER
PB	PULL BOX
PL	PROPERTY LINE
PP	POWER POLE
PROP	PROPOSED
PVC	POLY VINYL CHLORIDE PIPE
PVMT	PAVEMENT
RIM	TOP OF MANHOLE OR CLEANOUT
RT	RIGHT
ROW	RIGHT-OF-WAY
SS	SANITARY SEWER
SD	STORM DRAIN
SNWA	SOUTHERN NEVADA WATER AUTHORITY
STA	STATION
STL	STREET LIGHT
SVZ	SIGHT VISIBILITY ZONE
SW	SIDEWALK
TEL	TELEPHONE
TC	TOP OF CURB
TF	TOP OF FOOTING
TW	TOP OF WALL
TYP	TYPICAL
UDACS	UNIFORM DESIGN AND CONSTRUCTION STANDARDS
VG	VALLEY GUTTER
WL	WATER LINE

LEGEND	
DESCRIPTION	EXISTING PROPOSED
UTILITIES	
B.O. VALVE	↑
FIRE HYDRANTS	○
CLEAN OUT	○
GATE VALVE	⊗
METER	⊗
REDUCER	⊗
CAP	⊗
11-25' ELBOW	⊗
22-25' ELBOW	⊗
45' ELBOW	⊗
90' ELBOW	⊗
CROSS	⊗
TEE	⊗
MANHOLES	
ELECTRICAL	⊗
SANITARY SEWER	⊗
STORM DRAIN	⊗
TELEPHONE	⊗
STREET LIGHTS	
100W HPS STL.	⊗
150W HPS STL.	⊗
200W HPS STL.	⊗
250W HPS STL.	⊗
400W HPS STL.	⊗
GRADING	
SPOT ELEV.	12.34 (TC)
SLOPE	1.23%
5' CONT.	(2005)
1' CONT.	(2007)
SITE	
SIGN	⊗
"L" CURB	⊗
"A" CURB	⊗
EDGE OF PAVT.	⊗
WALL	⊗
LINE TYPES	
CL OR SECTION LINE	⊗
PROPERTY LINE	⊗
RIGHT OF WAY LINE	⊗
EASEMENT LINE	⊗
SAWTOOTH LINE	⊗
FLOW LINE	⊗
SHADES	
HEAVY AC PAVEMENT	⊗
LIGHT AC PAVEMENT	⊗
CONCRETE PAVEMENT	⊗

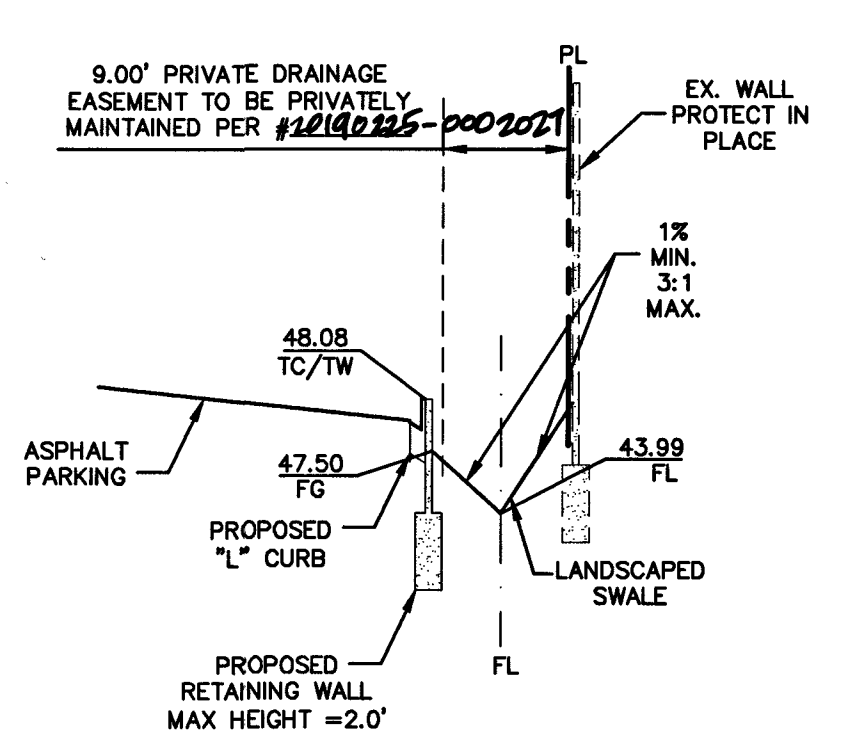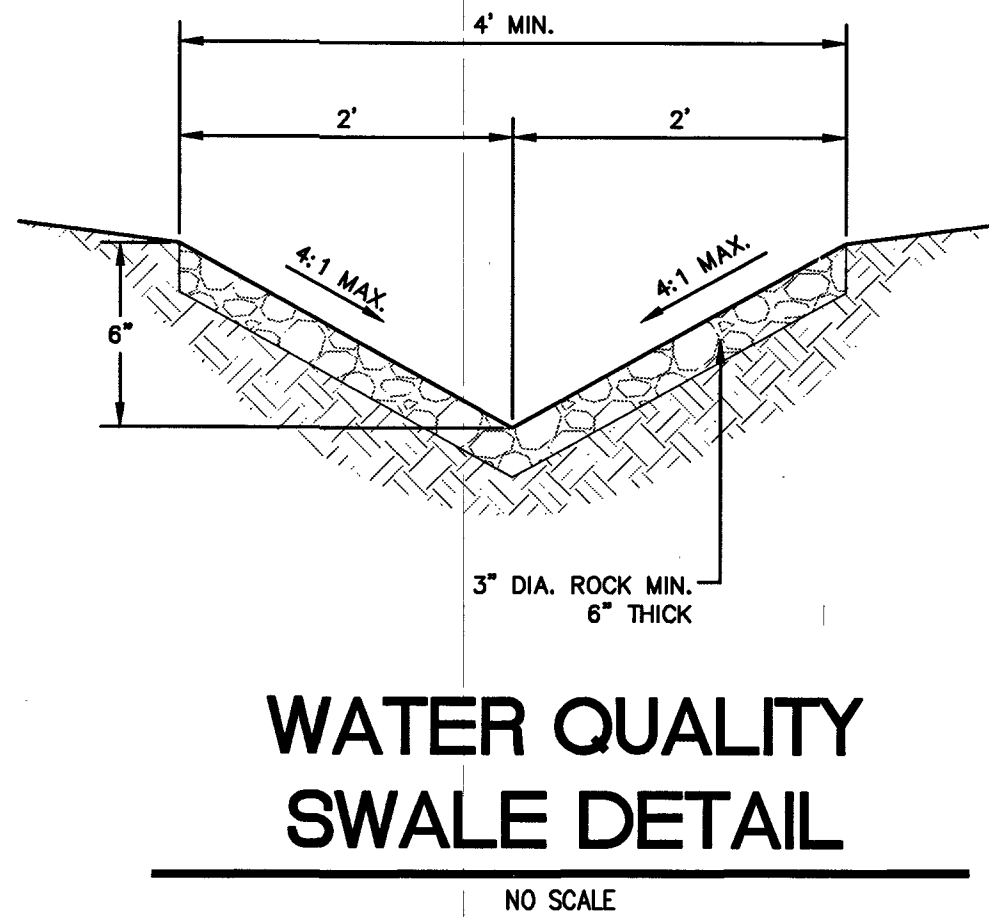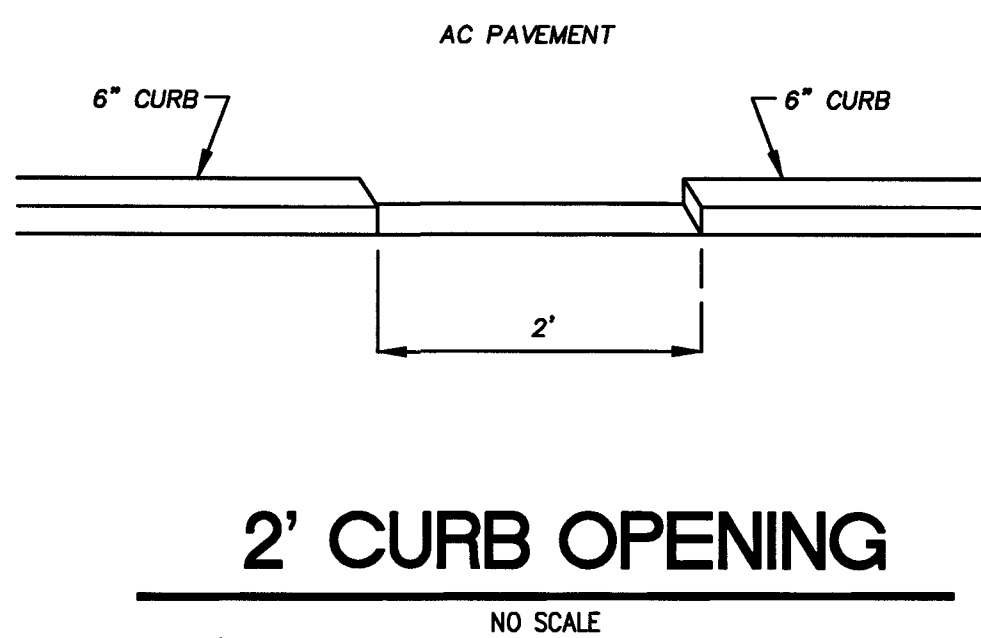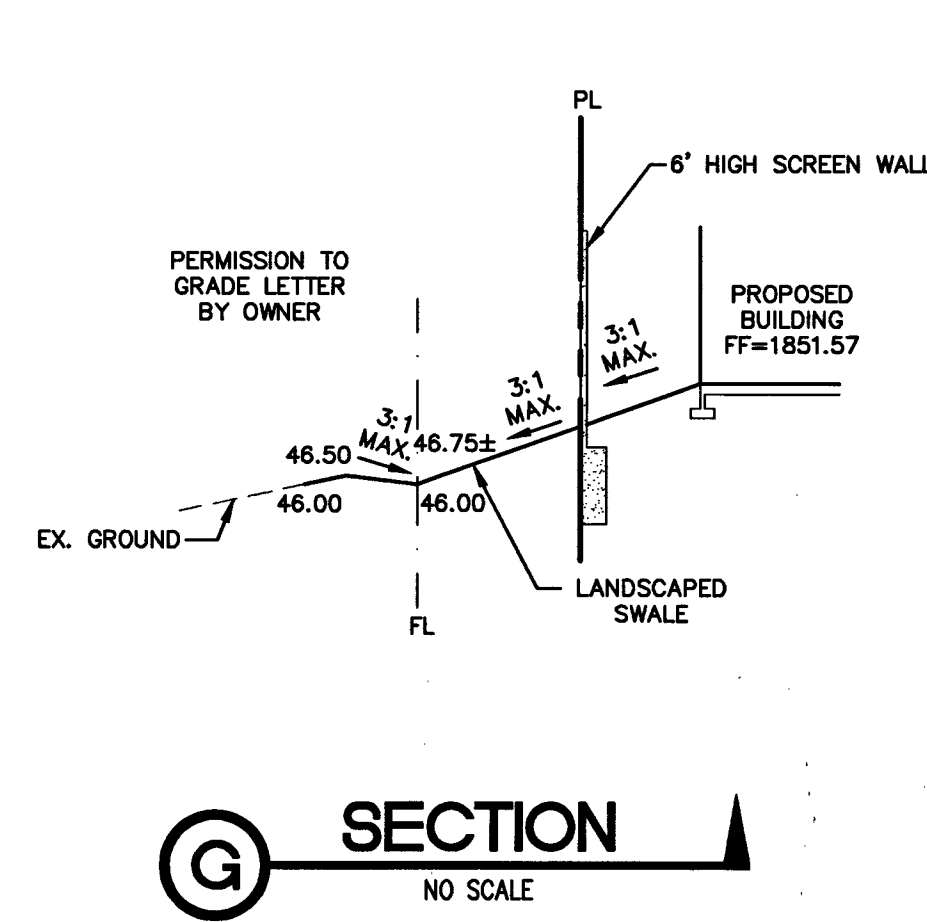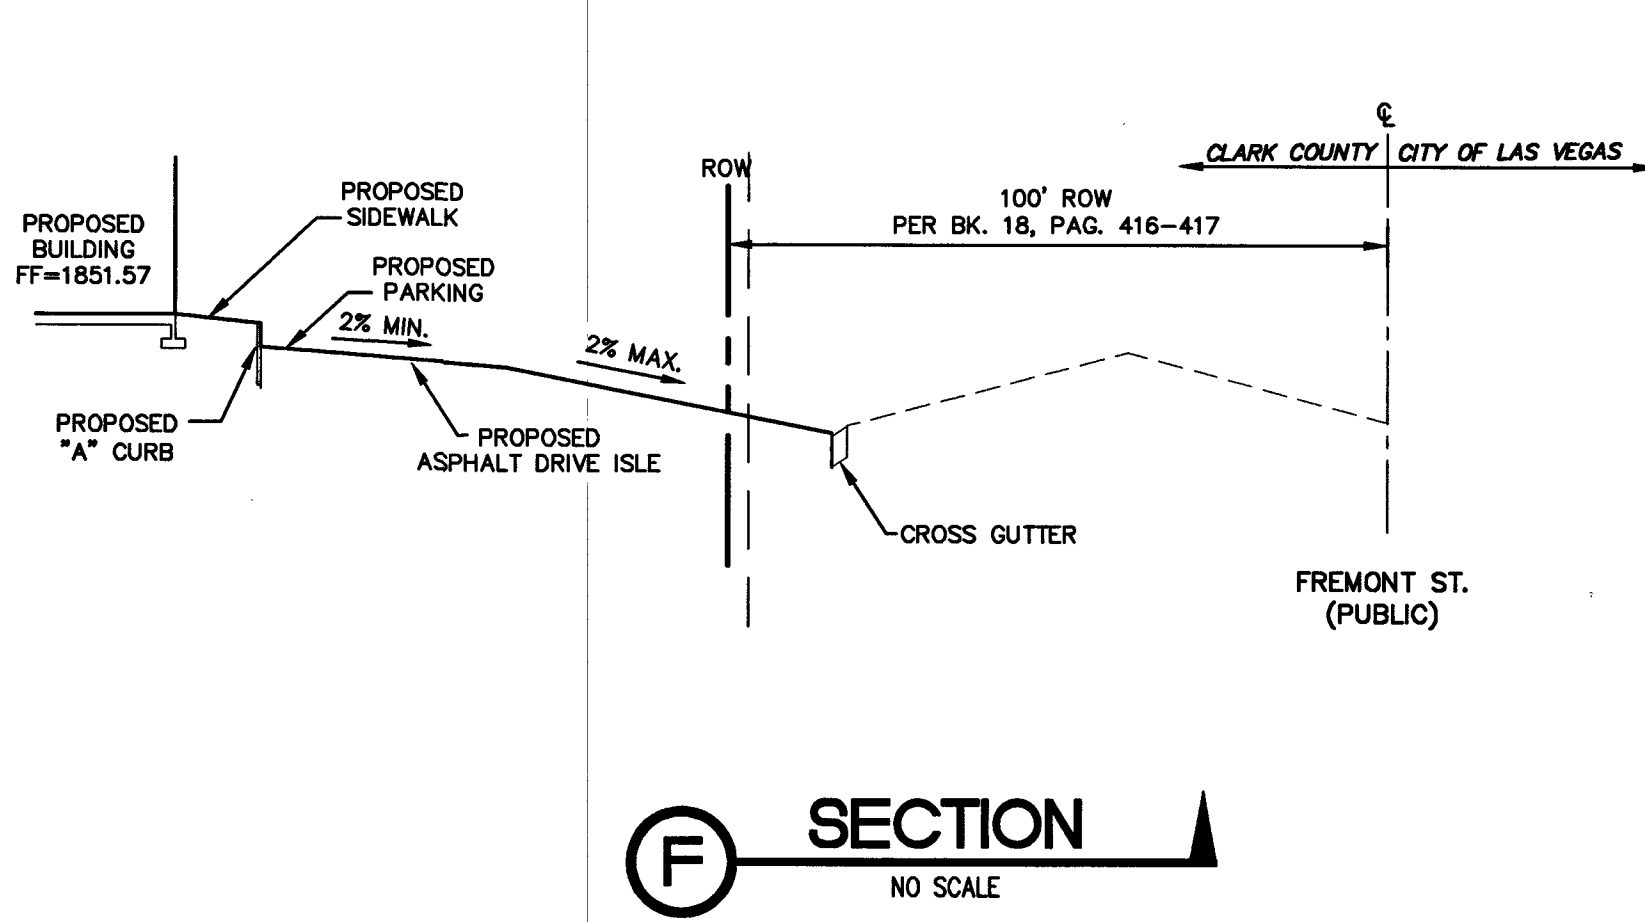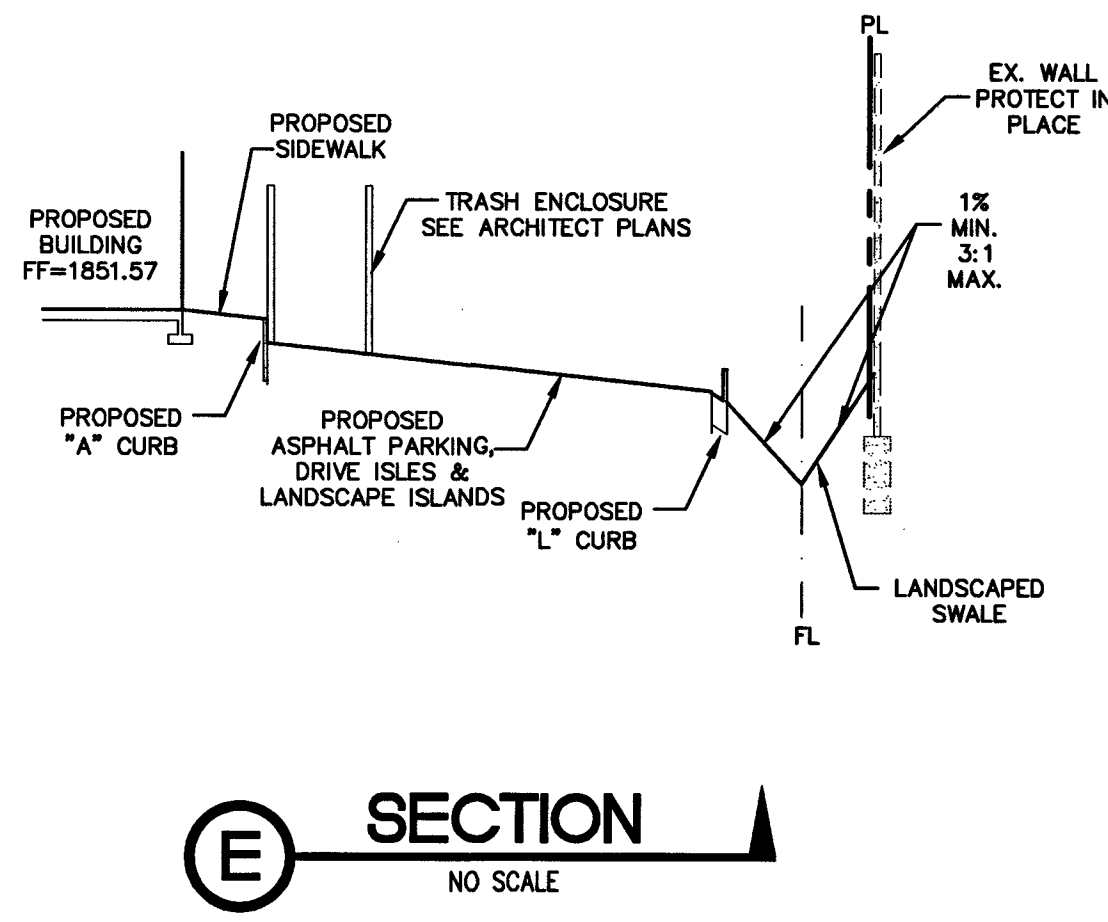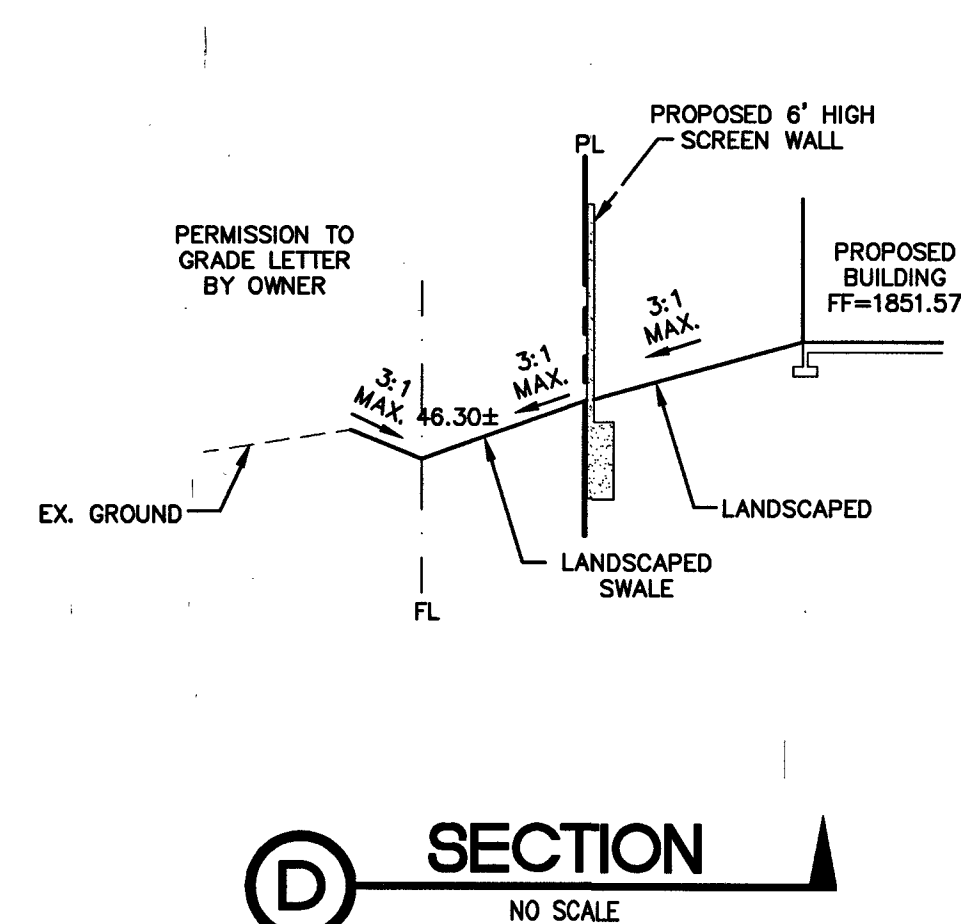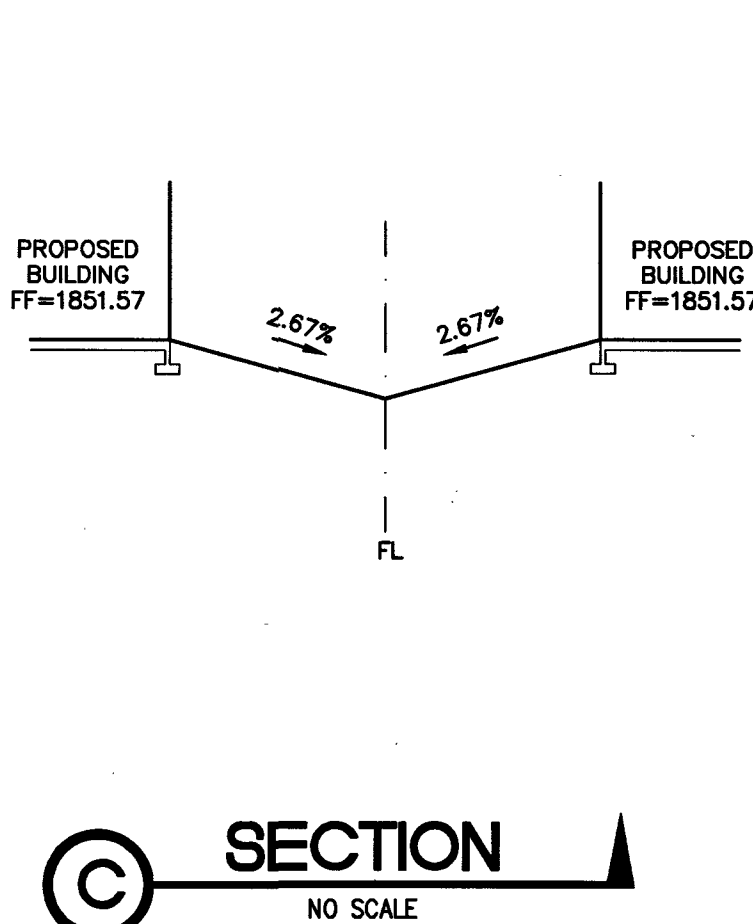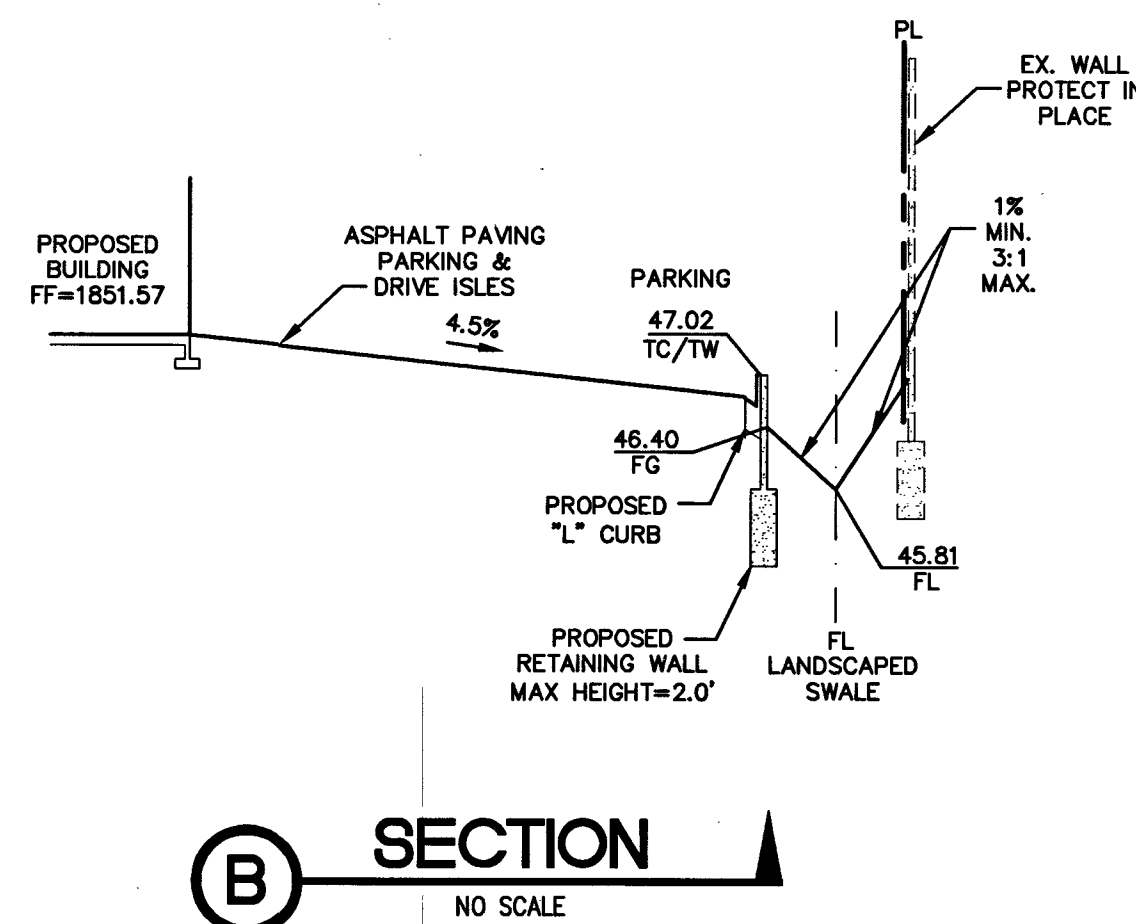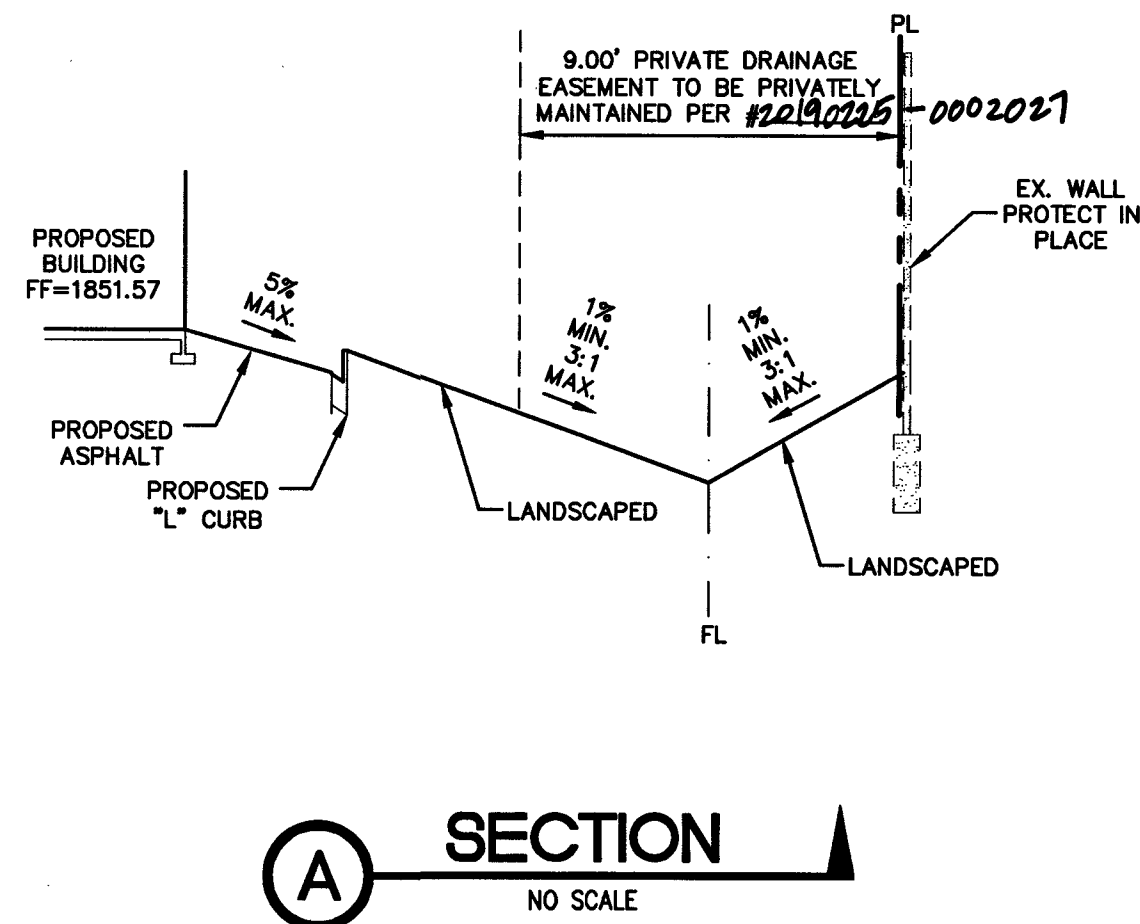




APPROVED FOR CONSTRUCTION
 Las Vegas Valley Water District Engineering Services
 Project No. 135214 First Approved Date: 3-28-19
 LVVWD Approved Fire Flow: Total 1,500 GPM/ Onsite 1,000 GPM

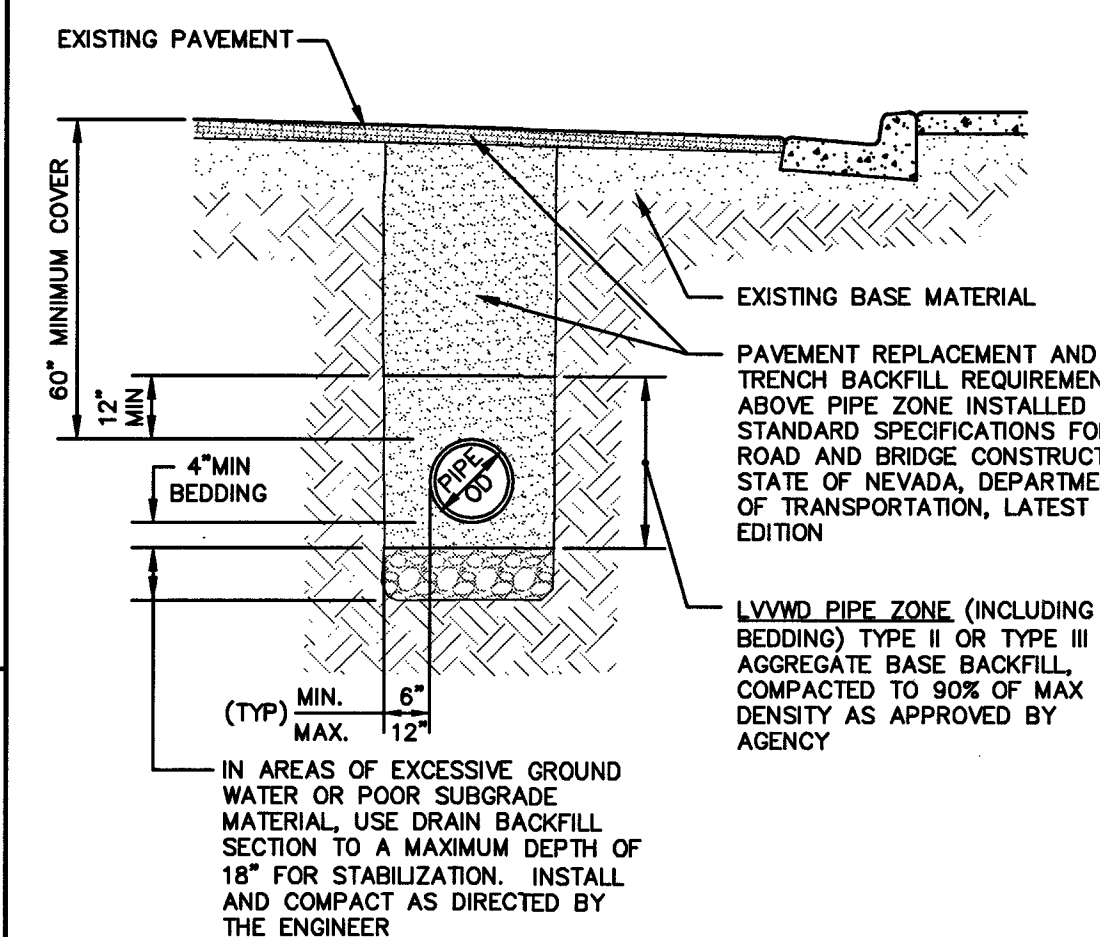

TRENCH SECTION BACKFILL SPECIFICATIONS
 (FOR LVVWD WATER FACILITIES)
 IMPROVED AND UNIMPROVED AREAS
 (NDOT STREET R/W)

NDOT TRENCH DETAIL
 NO SCALE

Call before you dig
 811
 1-800-227-2600 1-702-432-5300 1-702-227-2929

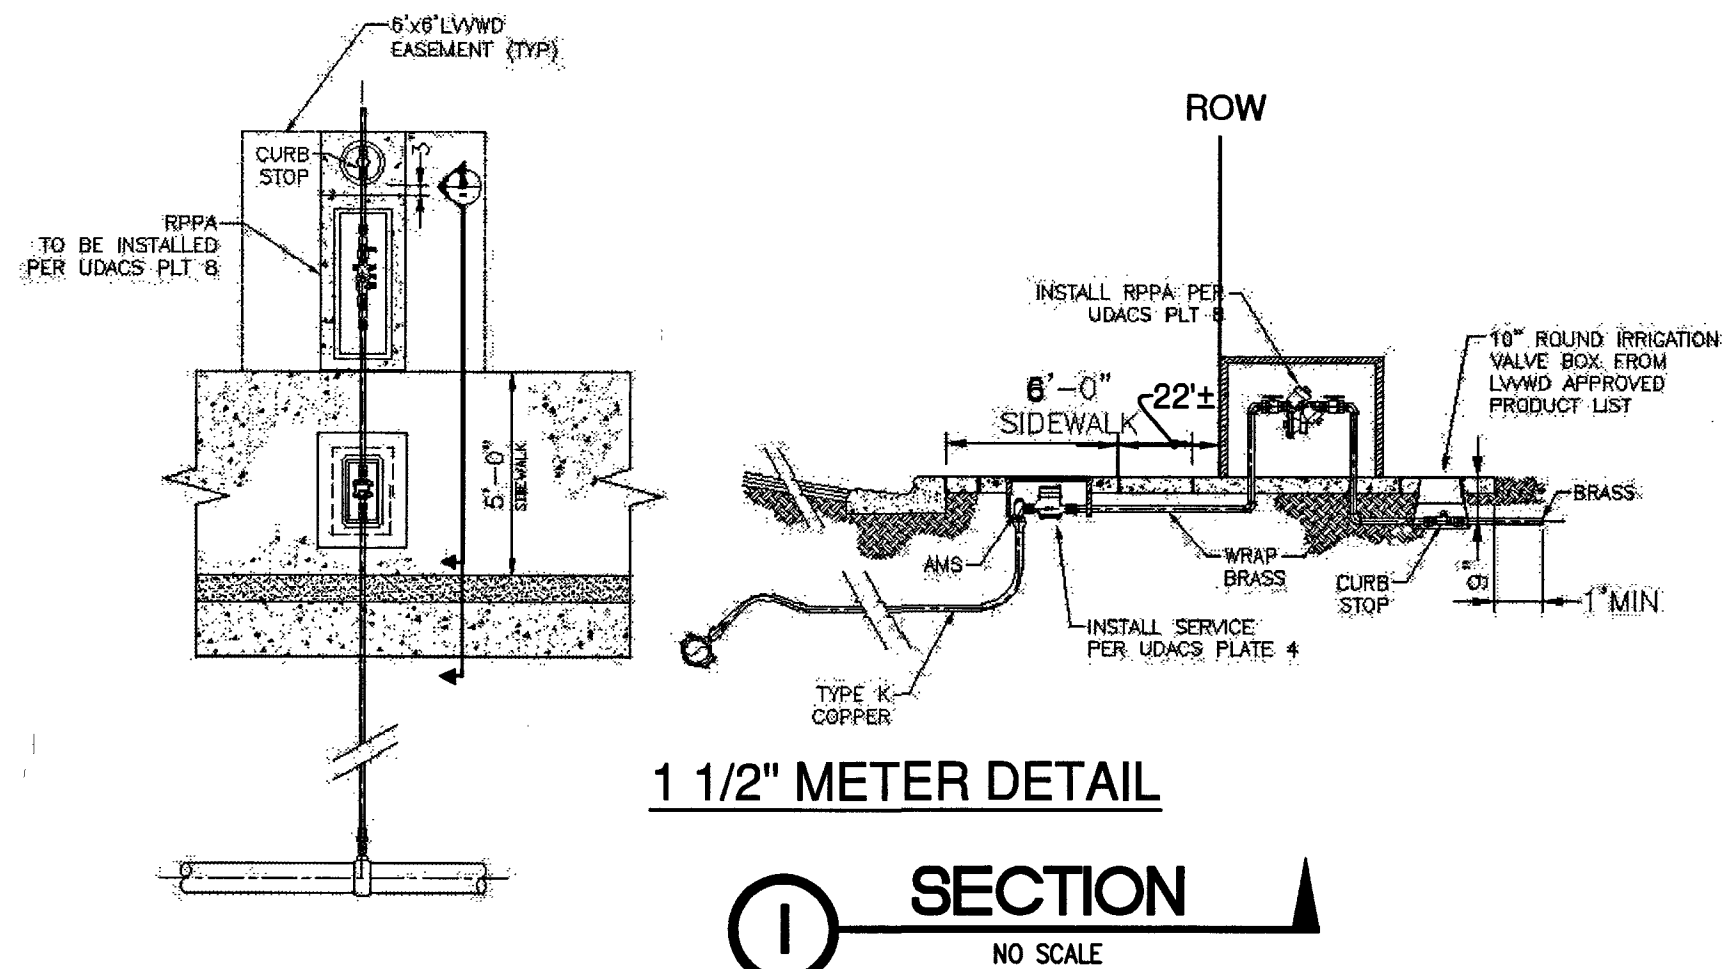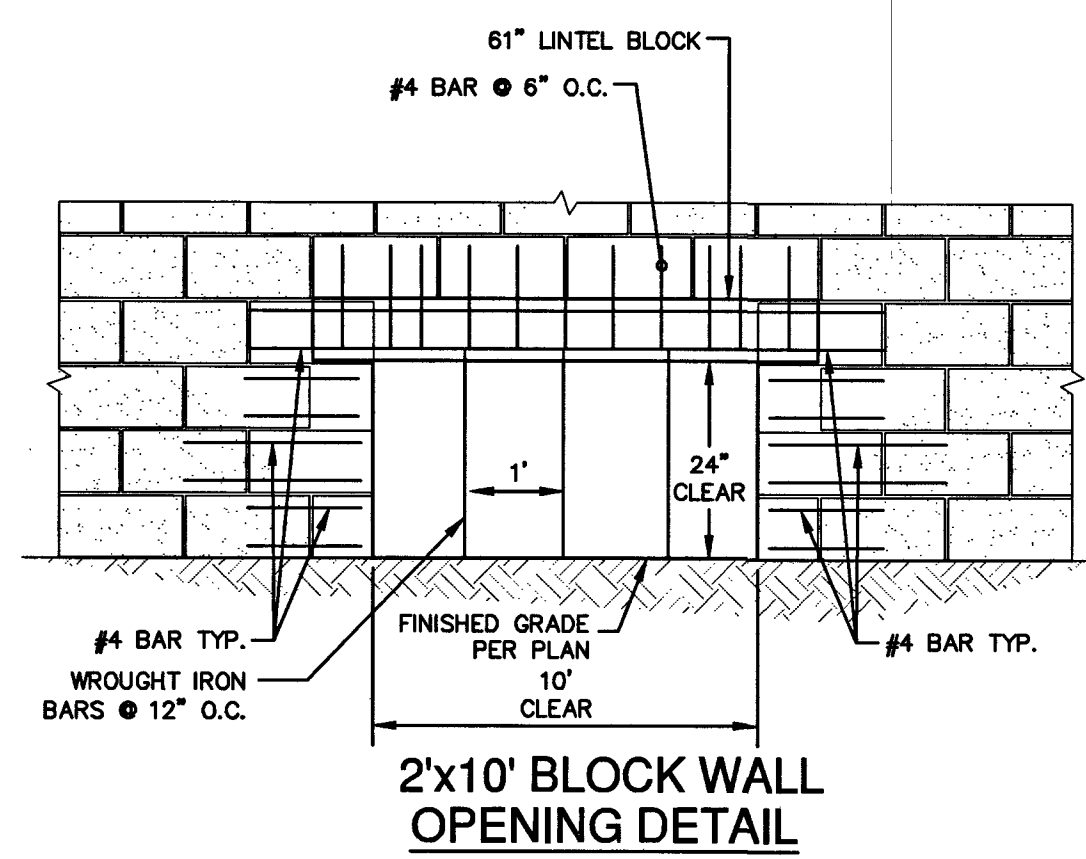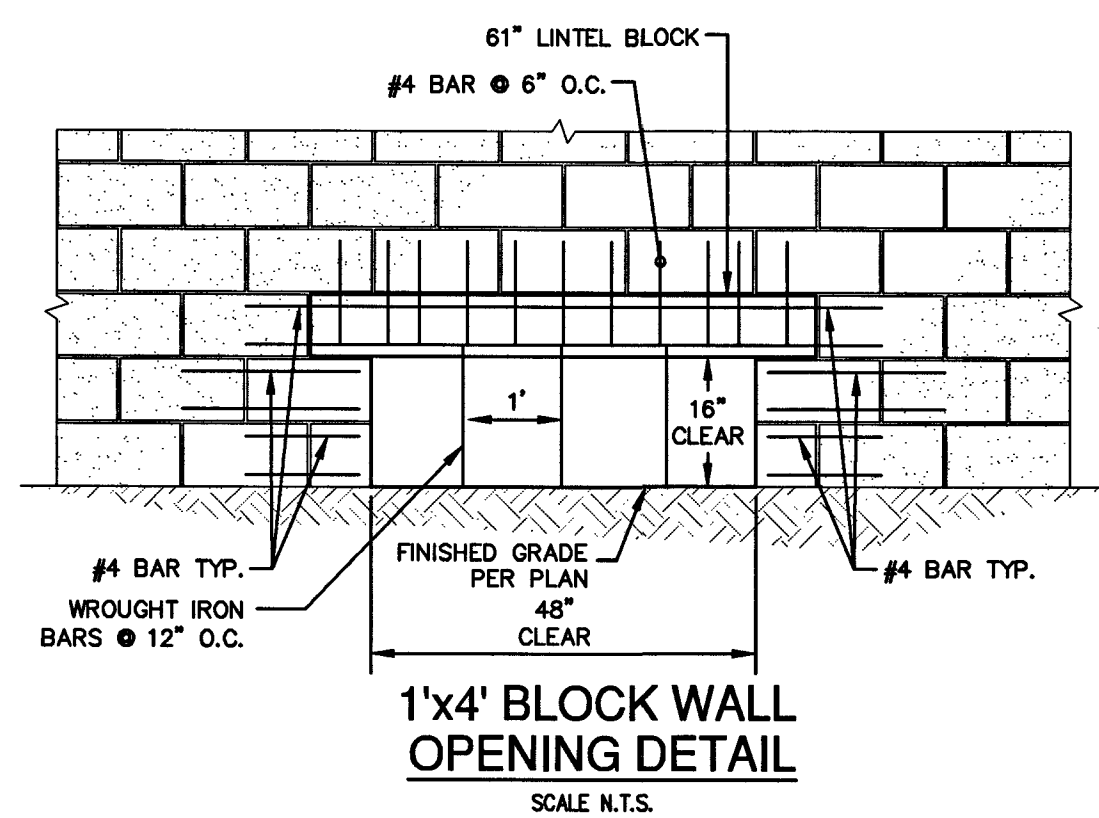

DETAIL SHEET

CONSULTANT LIST:
 HNSurveyingInc
 Las Vegas, NV 89101
 PHONE: 702-403-2821

STUCKEY CAR SALES
 @ 2925 FREMONT STREET

OWNER FRANK STUCKEY
 2825 FREMONT STREET
 LAS VEGAS, NV
 CONTACT FRANK STUCKEY
 PHONE: 702-403-2821

REVISIONS

NO.	DATE	DESCRIPTION
1	07/05/00	FOR CONSTRUCTION

PRINTS REQUIRE ENGINEER'S SEAL AND SIGN FOR VALIDITY

PROFESSIONAL ENGINEER
 RANDON A. POTTS
 Exp: 12/31/19
 CIVIL
 No. 13121

Sheet # 118-02521 207V259
 C6
 6 OF 6

PW18-14518

CivilworksInc
 Engineering with "sensible" solutions tailored to your "specific" needs.
 Las Vegas, NV 89118
 4945 W. Patrick Lane
 Office#: (702)534-1816 Fax#: (702)534-1825