
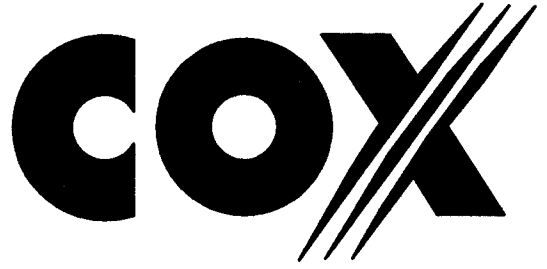


1. SUBMITTAL OF BID INDICATES CONTRACTOR IS COGNIZANT OF ALL JOB SITE CONDITIONS AND WORK TO BE PERFORMED UNDER THIS CONTRACT.
2. CONTRACTOR SHALL PERFORM ALL VERIFICATION OBSERVATION TESTS, AND EXAMINATION WORK PRIOR TO THE ORDERING OF THE ELECTRICAL EQUIPMENT AND THE ACTUAL CONSTRUCTION. CONTRACTOR SHALL ISSUE A WRITTEN NOTICE OF ALL FINDINGS TO THE ARCHITECT LISTING ALL MALFUNCTIONS, FAULTY EQUIPMENT AND DISCREPANCIES.
3. HEIGHTS SHALL BE VERIFIED WITH OWNER TO INSTALLATION.
4. THESE PLANS ARE DIAGRAMMATIC ONLY, FOLLOW AS CLOSELY AS POSSIBLE.
5. EACH CONDUCTOR OF EVERY SYSTEM SHALL BE PERMANENTLY TAGGED IN EACH PANELBOARD, PULLBOX, J-BOX, SWITCH BOX, ETC., IN COMPLIANCE WITH OCCUPATIONAL SAFETY AND HEALTH ACT (O.S.H.A.).
6. CONTRACTOR SHALL PROVIDE ALL LABOR, MATERIALS, INSURANCE, EQUIPMENT, INSTALLATION, CONSTRUCTION TOOLS, TRANSFORMATION, ETC., FOR A COMPLETE AND PROPERLY OPERATIVE SYSTEM ENERGIZED THROUGHOUT AND AS INDICATED ON DRAWINGS, AS SPECIFIED HEREIN AND/OR AS OTHERWISE REQUIRED.
7. ALL MATERIALS AND EQUIPMENT SHALL BE NEW AND IN PERFECT CONDITION WHEN INSTALLED AND SHALL BE OF THE BEST GRADE AND OF THE SAME MANUFACTURER THROUGHOUT FOR EACH CLASS OR GROUP OF EQUIPMENT. MATERIALS SHALL BE LISTED AND APPROVED BY UNDERWRITER'S LABORATORY AND SHALL BEAR THE INSPECTION LABEL "U" WHERE SUBJECT TO SUCH APPROVAL. MATERIALS SHALL MEET WITH APPROVAL OF THE DIVISION OF INDUSTRIAL SAFETY AND ALL GOVERNING BODIES HAVING JURISDICTION. MATERIALS SHALL BE MANUFACTURED IN ACCORDANCE WITH APPLICABLE STANDARDS ESTABLISHED BY ANSI, NEMA & NBFU.
8. CONTRACTOR SHALL CARRY OUT HIS WORK IN ACCORDANCE WITH ALL GOVERNING STATE, COUNTY AND LOCAL CODES AND O.S.H.A.
9. CONTRACTOR SHALL SECURE ALL NECESSARY BUILDING PERMITS.
10. COMPLETE JOB SHALL BE GUARANTEED FOR A PRIOR OF ONE (1) YEAR AFTER THE DATE OF JOB ACCEPTANCE BY OWNER. ANY WORK, MATERIAL OR EQUIPMENT FOUND TO BE FAULTY DURING THAT PERIOD SHALL BE CORRECTED AT ONCE, UPON WRITTEN NOTIFICATION, AT THE EXPENSE OF THE CONTRACTOR.
11. ALL CONDUIT ONLY (C.O.) SHALL HAVE A PULL WIRE OR ROPE.
12. PROVIDE PROJECT MANAGER WITH ONE SET OF COMPLETE ELECTRICAL "AS INSTALLED" DRAWINGS AT THE COMPLETION OF THE JOB, SHOWING ACTUAL DIMENSIONS, ROUTINGS, AND CIRCUITS.
13. ALL BROCHURES, OPERATING MANUALS, CATALOGS, SHOP DRAWINGS, ETC. SHALL BE TURNED OVER TO OWNER AT JOB COMPLETION.
14. USE T-TAP CONNECTIONS ON ALL MULTI -CIRCUITS WITH COMMON NEUTRAL CONDUCTOR FOR LIGHTING FIXTURE.
15. ALL CONDUCTORS SHALL BE COPPER.
16. ALL CIRCUIT BREAKERS, FUSES AND ELECTRICAL EQUIPMENT SHALL HAVE AN INTERRUPTING RATING NOT LESS THE MAXIMUM SHORT CIRCUIT CURRENT TO WHICH THEY MAY BE SUBJECTED, AND A MINIMUM OF 10,000 A.I.C.
17. THE ENTIRE ELECTRICAL INSTALLATION SHALL BE GROUNDED AS REQUIRED BY ALL APPLICABLE CODES AND DRAWINGS.
18. PATCH, REPAIR AND PAINT ANY AREA THAT HAS BEEN DAMAGED IN THE COURSE OF THE ELECTRICAL WORK.
19. IN DRILLING HOLES INTO CONCRETE WHETHER FOR FASTENING OR ANCHORING PURPOSES, OR PENETRATIONS THROUGH THE FLOOR FOR CONDUIT RUNS, PIPE RUNS, ETC., IT MUST BE CLEARLY UNDERSTOOD THAT TENDONS AND/OR REINFORCING STEEL WILL NOT BE DRILLED INTO, CUT OR DAMAGED UNDER ANY CIRCUMSTANCES.
20. LOCATION OF TENDONS AND/OR REINFORCING STEEL ARE NOT DEFINITELY KNOWN AND THEREFORE MUST BE SEARCHED FOR BY APPROPRIATE METHODS AND EQUIPMENT VIA X-RAY OR OTHER DEVICES THAT CAN ACCURATELY LOCATE THE REINFORCING AND/OR STEEL TENDONS.
21. WIRE AND CABLE CONDUCTORS SHALL BE COPPER #12 AWG MINIMUM, NO BX OR ROMEX CABLE IS PERMITTED UNLESS SPECIFICALLY NOTED OTHERWISE ON DRAWINGS.
22. GROUNDING CONDUCTORS SHALL BE SOLD TINED COPPER AND ANNEALED #2.
23. GROUND RODS SHALL BE COPPER CLAD STEEL, 5/8" ROUND AND 10' LONG. COPPERWELD OR APPROVED EQUAL.
24. METER SOCKET AMPERES, VOLTAGE, NUMBER OF PHASES SHALL BE AS NOTED ON THE DRAWINGS. MANUFACTURED BY SQUARE D COMPANY OR APPROVED EQUAL. ALL MATERIALS SHALL BE U.L. LISTED.
25. CONDUIT:
 - a. RIGID CONDUIT SHALL BE U.L. LABEL GALVANIZED ZINC COATED WITH INTERIOR AND SHALL BE USED WHEN INSTALLED IN OR UNDER CONCRETE SLABS, IN CONTACT WITH THE EARTH, UNDER PUBLIC ROADWAYS, IN MASONRY WALLS OR EXPOSED ON BUILDING EXTERIOR RIGID CONDUIT IN CONTACT WITH EARTH SHALL BE 1/2 LAPPED WRAPPED WITH HUNTS WRAP PROCESS NO. 3.
 - b. ELECTRICAL METALLIC TUBING SHALL HAVE U.L. LABEL, FITTINGS SHALL BE GLAND RING COMPRESSION TYPE. EMT SHALL BE USED ONLY FOR INTERIOR RUNS.
 - c. FLEXIBLE METALLIC CONDUIT SHALL HAVE U.L. LISTED LABEL AND MAY BE USED WHERE PERMITTED BY CODE. FITTINGS SHALL BE "JAKE" OR "SQUEEZE" TYPE, SEAL TIGHT FLEXIBLE CONDUIT. ALL CONDUIT IN EXCESS OF SIX FEET IN LENGTH SHALL HAVE FULL SIZE GROUND WIRE.
 - d. ALL UNDERGROUND CONDUIT SHALL BE PVC SCHEDULE 40 (UNLESS NOTED OTHERWISE) AT A MINIMUM DEPTH OF 24" BELOW GRADE.
26. ALL ELECTRICAL EQUIPMENT SHALL BE LABELED WITH PERMANENT ENGRAVED PLASTIC LABELS.
27. UPON COMPLETION OF WORK, CONDUCT CONTINUITY, SHORT CIRCUIT, AND FALL POTENTIAL GROUNDING TESTS FOR APPROVAL. SUBMIT TEST REPORTS TO PROJECT MANAGER. CLEAN PREMISES OF ALL DEBRIS RESULTING FROM WORK AND LEAVE WORK IN A COMPLETE AND UNDAMAGED CONDITION.
28. CONTRACTOR TO COORDINATE WITH UTILITY COMPANY FOR CONNECTION OF TEMPORARY AND PERMANENT POWER TO THE SITE. THE TEMPORARY POWER AND ALL HOOKUP COSTS TO BE PAID BY CONTRACTOR.
29. THE ELECTRICAL INSTALLATION WORK SHALL COMPLY WITH ALL LOCAL, STATE AND NATIONAL CODES, LAWS AND ORDINANCES APPLICABLE TO ELECTRICAL WORK.
30. ELECTRICAL CONTRACTOR SHALL VISIT JOB SITE AND VERIFY EXISTING CONDITIONS BEFORE BIDDING AND SHALL INCLUDE IN HIS BID THE NECESSARY COSTS TO CONSTRUCT THIS PROJECT IN ACCORDANCE WITH INTENT OF THE ELECTRICAL DRAWINGS, SPECIFICATIONS, AND ALL APPLICABLE CODES.

30. ALL MATERIAL AND EQUIPMENT FURNISHED AND INSTALLED UNDER THIS CONTRACT SHALL BE NEW, FREE FROM DEFECTS AND SHALL BE GUARANTEED FOR A PERIOD OF ONE YEAR FROM DATE OF FINAL ACCEPTANCE BY OWNER OR HIS REPRESENTATIVE. SHOULD ANY TROUBLE DEVELOP DURING THIS PERIOD DUE TO FAULTY WORKMANSHIP, MATERIAL OR EQUIPMENT, THE CONTRACTOR SHALL FURNISH ALL NECESSARY MATERIAL AND LABOR TO CORRECT THE TROUBLE WITHOUT COST TO THE OWNER.
31. ALL WORK TO BE EXECUTED IN WORKMANLIKE MANNER AND SHALL PRESENT A NEAT MECHANICAL APPEARANCE WHEN COMPLETED.
32. ALL ELECTRICAL MATERIALS AND EQUIPMENT SHALL BE LISTED BY UNDERWRITER'S LABORATORIES.
33. ELECTRICAL CONTRACTOR SHALL BE RESPONSIBLE FOR ALL CUTTING AND PATCHING RELATED TO ELECTRICAL WORK, UNLESS NOTED OTHERWISE AND CO-ORDINATED WITH THE GENERAL CONTRACTOR.
34. ELECTRICAL CONTRACTOR SHALL CO-ORDINATE ALL WORK WITH CIVIL AND ARCHITECTURAL PLANS. THE REQUIREMENTS OF ALL EQUIPMENT ACTUALLY BEING INSTALLED SHALL BE VERIFIED PRIOR TO INSTALLING THE ELECTRICAL WORK.
35. ALL BRANCH CIRCUIT CONDUCTORS SHALL BE COPPER TYPE THWN-2, THW-2, RHW-2, XHHW-2 #14, #12, & #10 SOLID, #8 AND LARGER STRANDED, UNLESS NOTED OTHERWISE.
36. ON COMPLETION OF THE WORK, THE INSTALLATION SHALL BE FREE FROM GROUNDS AND SHORT CIRCUITS.
37. ELECTRICAL CONTRACTOR SHALL FURNISH AS-BUILT DRAWINGS TO THE ARCHITECT AND CUSTOMER UPON COMPLETION OF THE JOB.
38. ELECTRICAL WORK SHALL INCLUDE ALL LABOR, MATERIALS AND EQUIPMENT REQUIRED, INCLUDING BUT NOT LIMITED, TO COMPLETE ELECTRICAL SYSTEMS: POWER AND LIGHTING, TELEPHONE CONDUIT SYSTEM, SIGNAL SYSTEMS, PANEL BOARDS(S), CONTROL WIRING, GROUNDING, CONDUIT ONLY SYSTEMS, ETC., AS INDICATED ON ELECTRICAL DRAWINGS AND/OR REQUIRED BY GOVERNING CODES.
39. RACEWAYS SHALL BE: RIGID STEEL CONDUIT: HOT-DIP GALVANIZED HEAVY WALL AS MANUFACTURED BY REPUBLIC, TRIANGLE OR EQUAL, RIGID POLYVINYL CHLORIDE CONDUIT (PVC): HEAVY WALLS SCHEDULE 40 AS MANUFACTURED BY CARLON ELECTRICAL, VISOQUEN OR EQUAL, ELECTRICAL METALLIC TUBING (EMT): ZINC-COATED THIN WALL AS MANUFACTURED BY TRIANGLE, REPUBLIC OR EQUAL.
40. FUSE TYPE SHALL BE BUSSMANN RK-1 OR CLASS "J" FUSE.
41. PROVIDE ENGRAVED PLASTIC LABELS TO IDENTIFY ALL PANEL BOARDS, XFMRs., DISTRIBUTION PANELS, DISCONNECT SWITCHES, AND TRANSFER SWITCHES, LABELS SHALL READ IN THIS FASHION "A" 208Y/120V 3PH, 4W, 225A, CKT. BKR OR FUSES TYPE AND SIZES.
42. E.C. SHALL VERIFY AND TEST GROUND TO SOURCE TO A MAXIMUM OF 5 OHMS. IF THE GROUND TEST DOES NOT ACHIEVE THE 5 OHMS LESS, E.C. SHALL BE RESPONSIBLE FOR PROVIDING THE NECESSARY CONDUCTORS AND GROUND RODS TO ACHIEVE 5 OHMS MAXIMUM.
43. BEFORE SUBMITTING BID, VERIFY EXISTING SITE CONDITIONS, ELECTRICAL SERVICE REQUIREMENTS AND THE EXACT SERVING UTILITY POINTS OF CONNECTION.
44. THE ELECTRICAL CONTRACTOR (E.C) SHALL FURNISH AND PAY FOR ALL PERMITS AND RELATED FEES.
45. UNLESS SPECIFICALLY NOTED OTHERWISE, ALL ELECTRICAL MATERIALS, EQUIPMENT AND WORK, SHOWN ON THESE PLANS ARE TO BE PROVIDED AND INSTALLED BY THE ELECTRICAL CONTRACTOR.
46. E.C. SHALL FURNISH AND INSTALL ALL SWITCHES, CONDUITS, WIRES, BOXES, LIGHT FIXTURES (INCLUDING LAMPS), SERVICE DEVICES, RECEPTACLES, SWITCHBOARDS AND PANEL BOARDS, ETC. REQUIRED FOR A COMPLETE AND OPERATING ELECTRICAL SYSTEM.
47. SEE ARCHITECTURAL DRAWINGS FOR DIMENSIONAL/LOCATION INFORMATION RELATING TO THE ELECTRICAL DRAWINGS.
48. ELECTRICAL CONTRACTOR SHALL VERIFY VOLTAGES AND HORSEPOWER RATINGS OF ALL MECHANICAL EQUIPMENT.
49. PRIOR TO INSTALLING ANY ELECTRICAL WORK, THE ELECTRICAL CONTRACTOR SHALL VERIFY EXACT LOCATIONS AND REQUIREMENTS ON THE JOB AND BY REFERENCE TO ARCHITECTURE, MECHANICAL AND EQUIPMENT SUPPLIERS DRAWINGS. SHOULD THERE BE ANY QUESTION OR PROBLEM CONCERNING THE NECESSARY PROVISIONS TO BE MADE, PROPER DIRECTIONS SHALL BE OBTAINED BEFORE PROCEEDING WITH ANY WORK.
50. OUTLET AND JUNCTION BOXES SHALL BE SIZED PER CODE FOR THE QUANTITY OF WIRES THEY CONTAIN. SEE ARTICLE 370 OF N.E.C. PROVIDE ADDITIONAL BOXES AND EXTENSION RINGS AS REQUIRED.
51. ELECTRICAL CONTRACTOR SHALL COMPLY WITH CABLE BENDING RADIUS REQUIREMENTS PER CABLE MANUFACTURERS SPECIFICATION.
52. CONDUIT LAYOUTS SHOWN ON THE PLANS ARE DIAGRAMMATIC, NOT INDICATING THE ROUTING REQUIRED, THE CONTRACTOR SHALL ROUTE CONDUITS AS REQUIRED BY THE CONDITIONS OF INSTALLATION.
53. ALL EQUIPMENT PROVIDED BY THE ELECTRICAL CONTRACTOR SHALL BE LISTED AND LABELED BY A NATIONALLY-RECOGNIZED TESTING AGENCY, ACCEPTABLE TO THE AUTHORITY HAVING JURISDICTION, FOR THE CONDITIONS OF THE INSTALLATION.
54. PLANS INDICATE THE NUMBER OF PHASE NATURAL, AND GROUND CONDUCTORS WHERE MORE THAN THREE CONDUCTORS ARE TO BE INSTALLED IN A CONDUIT (THREE OR LESS CONDUCTORS ARE NOT SHOWN). ADDITIONAL CONDUCTORS REQUIRED FOR CONTROL SHALL BE INCLUDED EVEN IF NOT EXPLICITLY SHOWN.
55. WHERE SIZE IS NOT SHOWN ON THE DRAWINGS, CIRCUITS SHALL CONSIST OF #12 PHASE AND GROUNDED (NEUTRAL CONDUCTORS) AND A #12 CU GROUND IN A 3/4" CONDUIT.
56. UNLESS SPECIFICALLY NOTED OTHERWISE, THE ELECTRICAL CONTRACTOR SHALL MAKE FINAL CONNECTIONS TO ALL UTILIZATION EQUIPMENT SHOWN ON THE DRAWINGS. VERIFY THE TYPE OF FINAL CONNECTION AND PROVIDE APPROPRIATE WIRING METHOD.
57. PRIOR TO TRENCHING IN ANY AREA THE CONTRACTOR SHALL CONTACT ELECTRICAL, COMMUNICATIONS/DATA, CABLE T.V., GAS, AND WATER UTILITY PROVIDES (BLUE STRIKE) AND HAVE ALL UTILITIES IN THE AREA IDENTIFIED. IN ADDITION, THE CONTRACTOR SHALL OBTAIN THE SERVICES OF A SUBCONTRACTOR SPECIALIZING IN THE LOCATION OF UNDERGROUND STRUCTURES TO IDENTIFY ANY OBSTACLES IN THE PATH OF TRENCHING (PRIOR TO COMMENCING WORK). DAMAGE TO ANY UNDERGROUND STRUCTURES SHALL BE REPAIRED BY THE CONTRACTOR AT NO ADDITIONAL COST TO THE PROJECT.
58. ANY AND ALL WIRE THAT CARRIES A CURRENT MUST BE IN A CONDUIT. (GROUNDING WIRE FOR LOOPS, HALOS, ECT. IS CONSIDERED NON-CURRENT CARRYING.)

1. CONCRETE COLLARS MAY BE DESIRED FOR INSTALLATIONS IN DRIVEWAYS, PARKING LOTS AND OFF-ROADWAY APPLICATIONS WHERE SUBJECT TO OCCASIONAL NON-DELIBERATE TRAFFIC. THIS APPLIES TO BOXES MADE FROM ANY MATERIAL TO PROVIDE ADDED PROTECTION FOR THE TOP LID. THIS IS NOT NECESSARY IN GRASSY AREAS OR AREAS SUBJECT TO PEDESTRIAN TRAFFIC.
2. CONCRETE ENCASEMENT TO BE 3,000 PSI MIN.
3. CONCRETE ENCASEMENT COLLAR DIMENSION "D" TO BE EQUAL TO DESIGN PAVEMENT DEPTH.
4. PAVEMENT AND SUBGRADE TO BE SHOWN ON THE ENGINEERING PLANS.
5. EXCAVATE THE HOLE APPROXIMATELY 6 TO 8" DEEPER THAN SUGGESTED HANDHOLE BURIAL DEPTH.
6. COMPACT THE SUBSOIL WITH A BACK-HOE OR A HYDRAULIC TAMPER. ADD APPROXIMATELY 6 TO 8" OF GRAVEL TO THE BOTTOM OF HOLE.
7. PLACE THE HANDHOLE ON THE LEVELED GRAVEL BED. LEVEL THE HANDHOLE.
8. BACK-FILL WITH LOOSE EARTH MATERIAL UP TO THE TOP SURFACE OF THE HANDHOLE. DO NOT BACK-FILL WITH CHUNKS OF FROZEN MATERIAL OR LARGE ROCKS NEXT TO THE GROUND SLEEVE. PACK THE BACK-FILL MATERIAL BY FOOT TAMPING, NO MACHINE TAMPING.
9. PROVIDE BARRIER HUBBELL QUAZITE # PG 2436BC30.
10. ALL UNDERGROUND CONDUITS SHALL BE SCH 40 PVC, EXCEPT THAT ELBOWS AND RISERS SHALL BE RMC ALL UNDERGROUND ELBOWS SHALL BE SWEEP BENDS, 2'-0" MINIMUM SHALL BE REQUIRED.
11. THREE CONDUITS ARE SHOWN BELOW, ALTHOUGH MULTIPLE CONDUITS CAN BE PLACED IN THE SAME TRENCH. A MINIMUM SEPARATION IS REQUIRED PER THE LOCAL JURISDICTIONS AND UTILITY COMPANIES. IN ALL OTHER CASES, USE THE CONDUIT SPACING SCHEDULE TO MAINTAIN MINIMUM SPACING BETWEEN THE EXTERIOR WALL TO EXTERIOR WALL SEPARATION OF CONDUITS.
12. CONTRACTOR SHALL RESTORE THE TRENCH TO ITS ORIGINAL CONDITIONS BY EITHER SEEDING OR SODDING GRASS AREAS, OR REPLACING ASPHALT OR CONCRETE AREAS TO ITS ORIGINAL CROSS SECTION.
13. TRENCHING SAFETY; INCLUDING, BUT NOT LIMITED TO SOIL CLASSIFICATION, SLOPING, AND SHORING, SHALL BE GOVERNED BY THE CURRENT OSHA TRENCHING AND EXCAVATION SAFETY STANDARDS.
14. ALL CONDUITS SHALL BE INSTALLED IN COMPLIANCE WITH THE NATIONAL ELECTRIC CODE (NEC) OR AS REQUIRED BY THE LOCAL JURISDICTION.

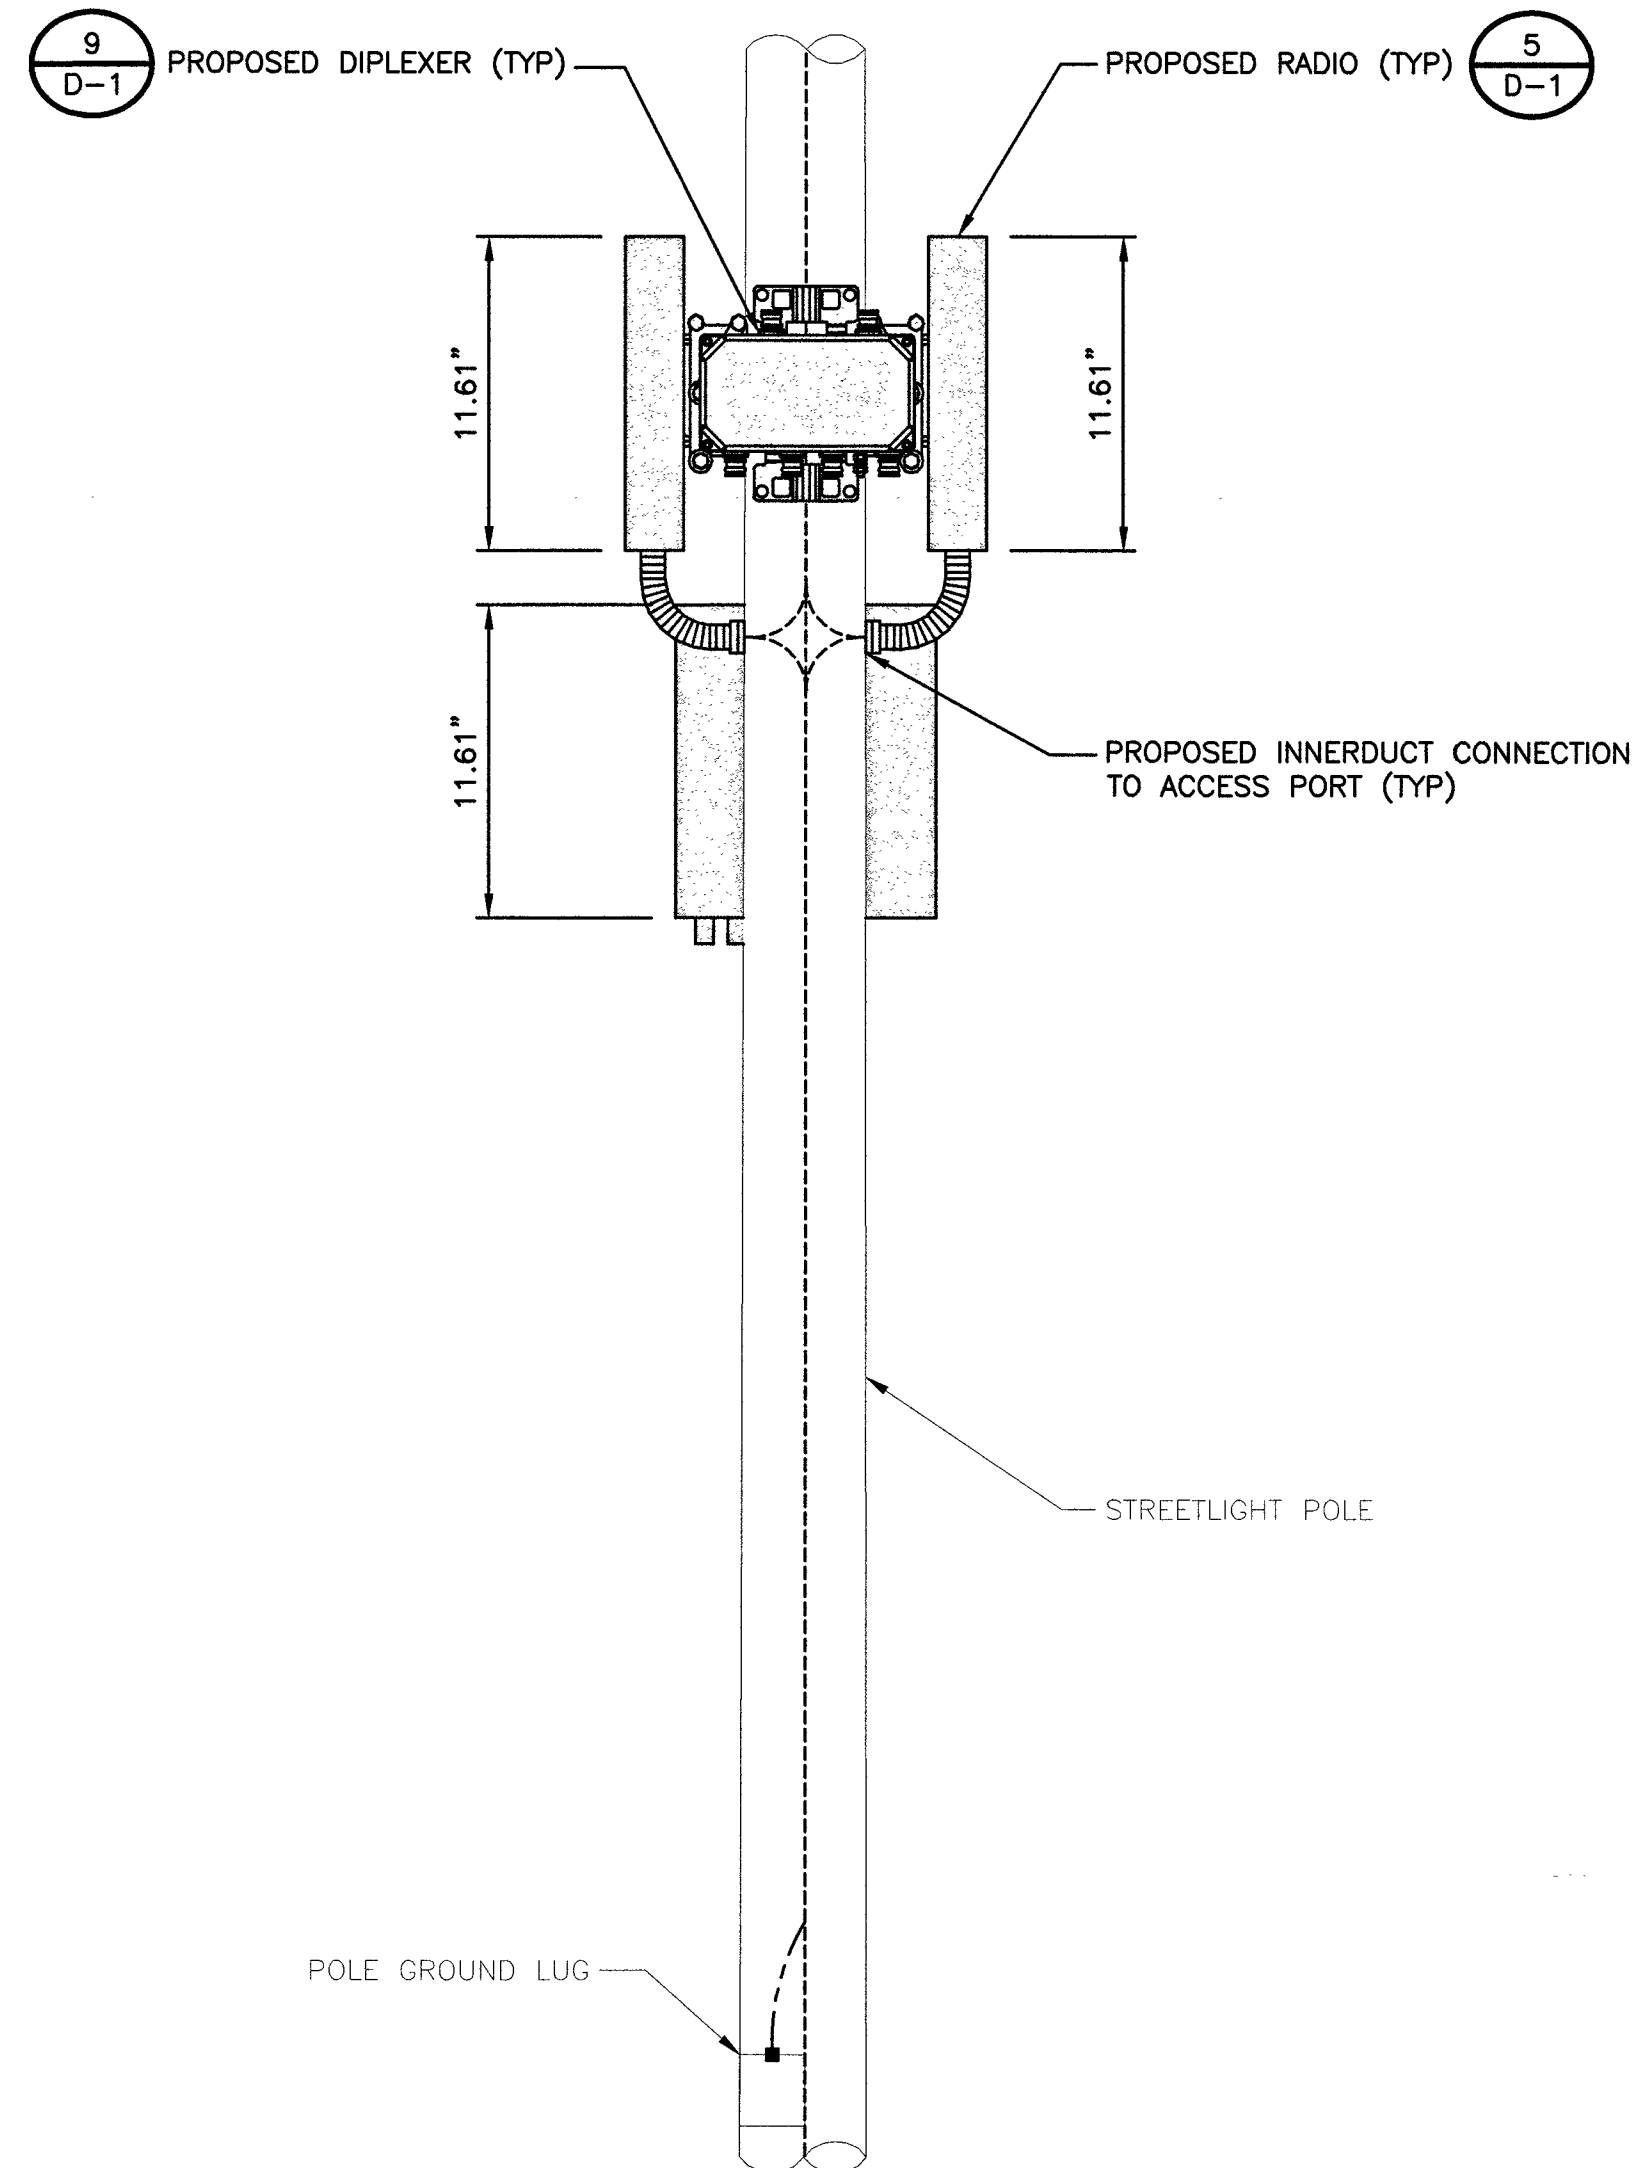


BLACK & VEATCH

BLACK & VEATCH CORPORATION
7760 FRANCE AVENUE SOUTH
SUITE 1200
BLOOMINGTON, MN 55435

THESE DRAWINGS ARE COPYRIGHTED AND ARE THE PROPERTY OF BLACK & VEATCH; PRODUCED SOLELY FOR THE USE OF OUR CLIENT. ANY REPRODUCTION OR USE OF THE INFORMATION CONTAINED WITHIN SAID DRAWINGS IS PROHIBITED WITHOUT WRITTEN CONSENT BY BLACK & VEATCH.

PROJECT NO.	DRAWN BY	CHECKED BY
199064.2047	TCG	LEW

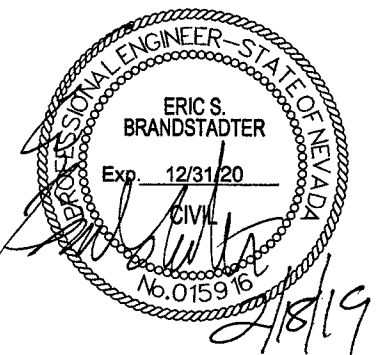[illegible]

IT IS A VIOLATION OF LAW FOR ANY PERSON,
UNLESS THEY ARE ACTING UNDER THE DIRECTION
OF A LICENSED PROFESSIONAL ENGINEER,
TO ALTER THIS DOCUMENT.


SITE ADDRESS

33AT0100SMC
CRAN_NVL08196F_R01
2507.25 VEGAS DR
LAS VEGAS, NV 89106
SMALL CELL

SHEET TITLE
GENERAL CONSTRUCTION
NOTES

SHEET NUMBER

GN-1

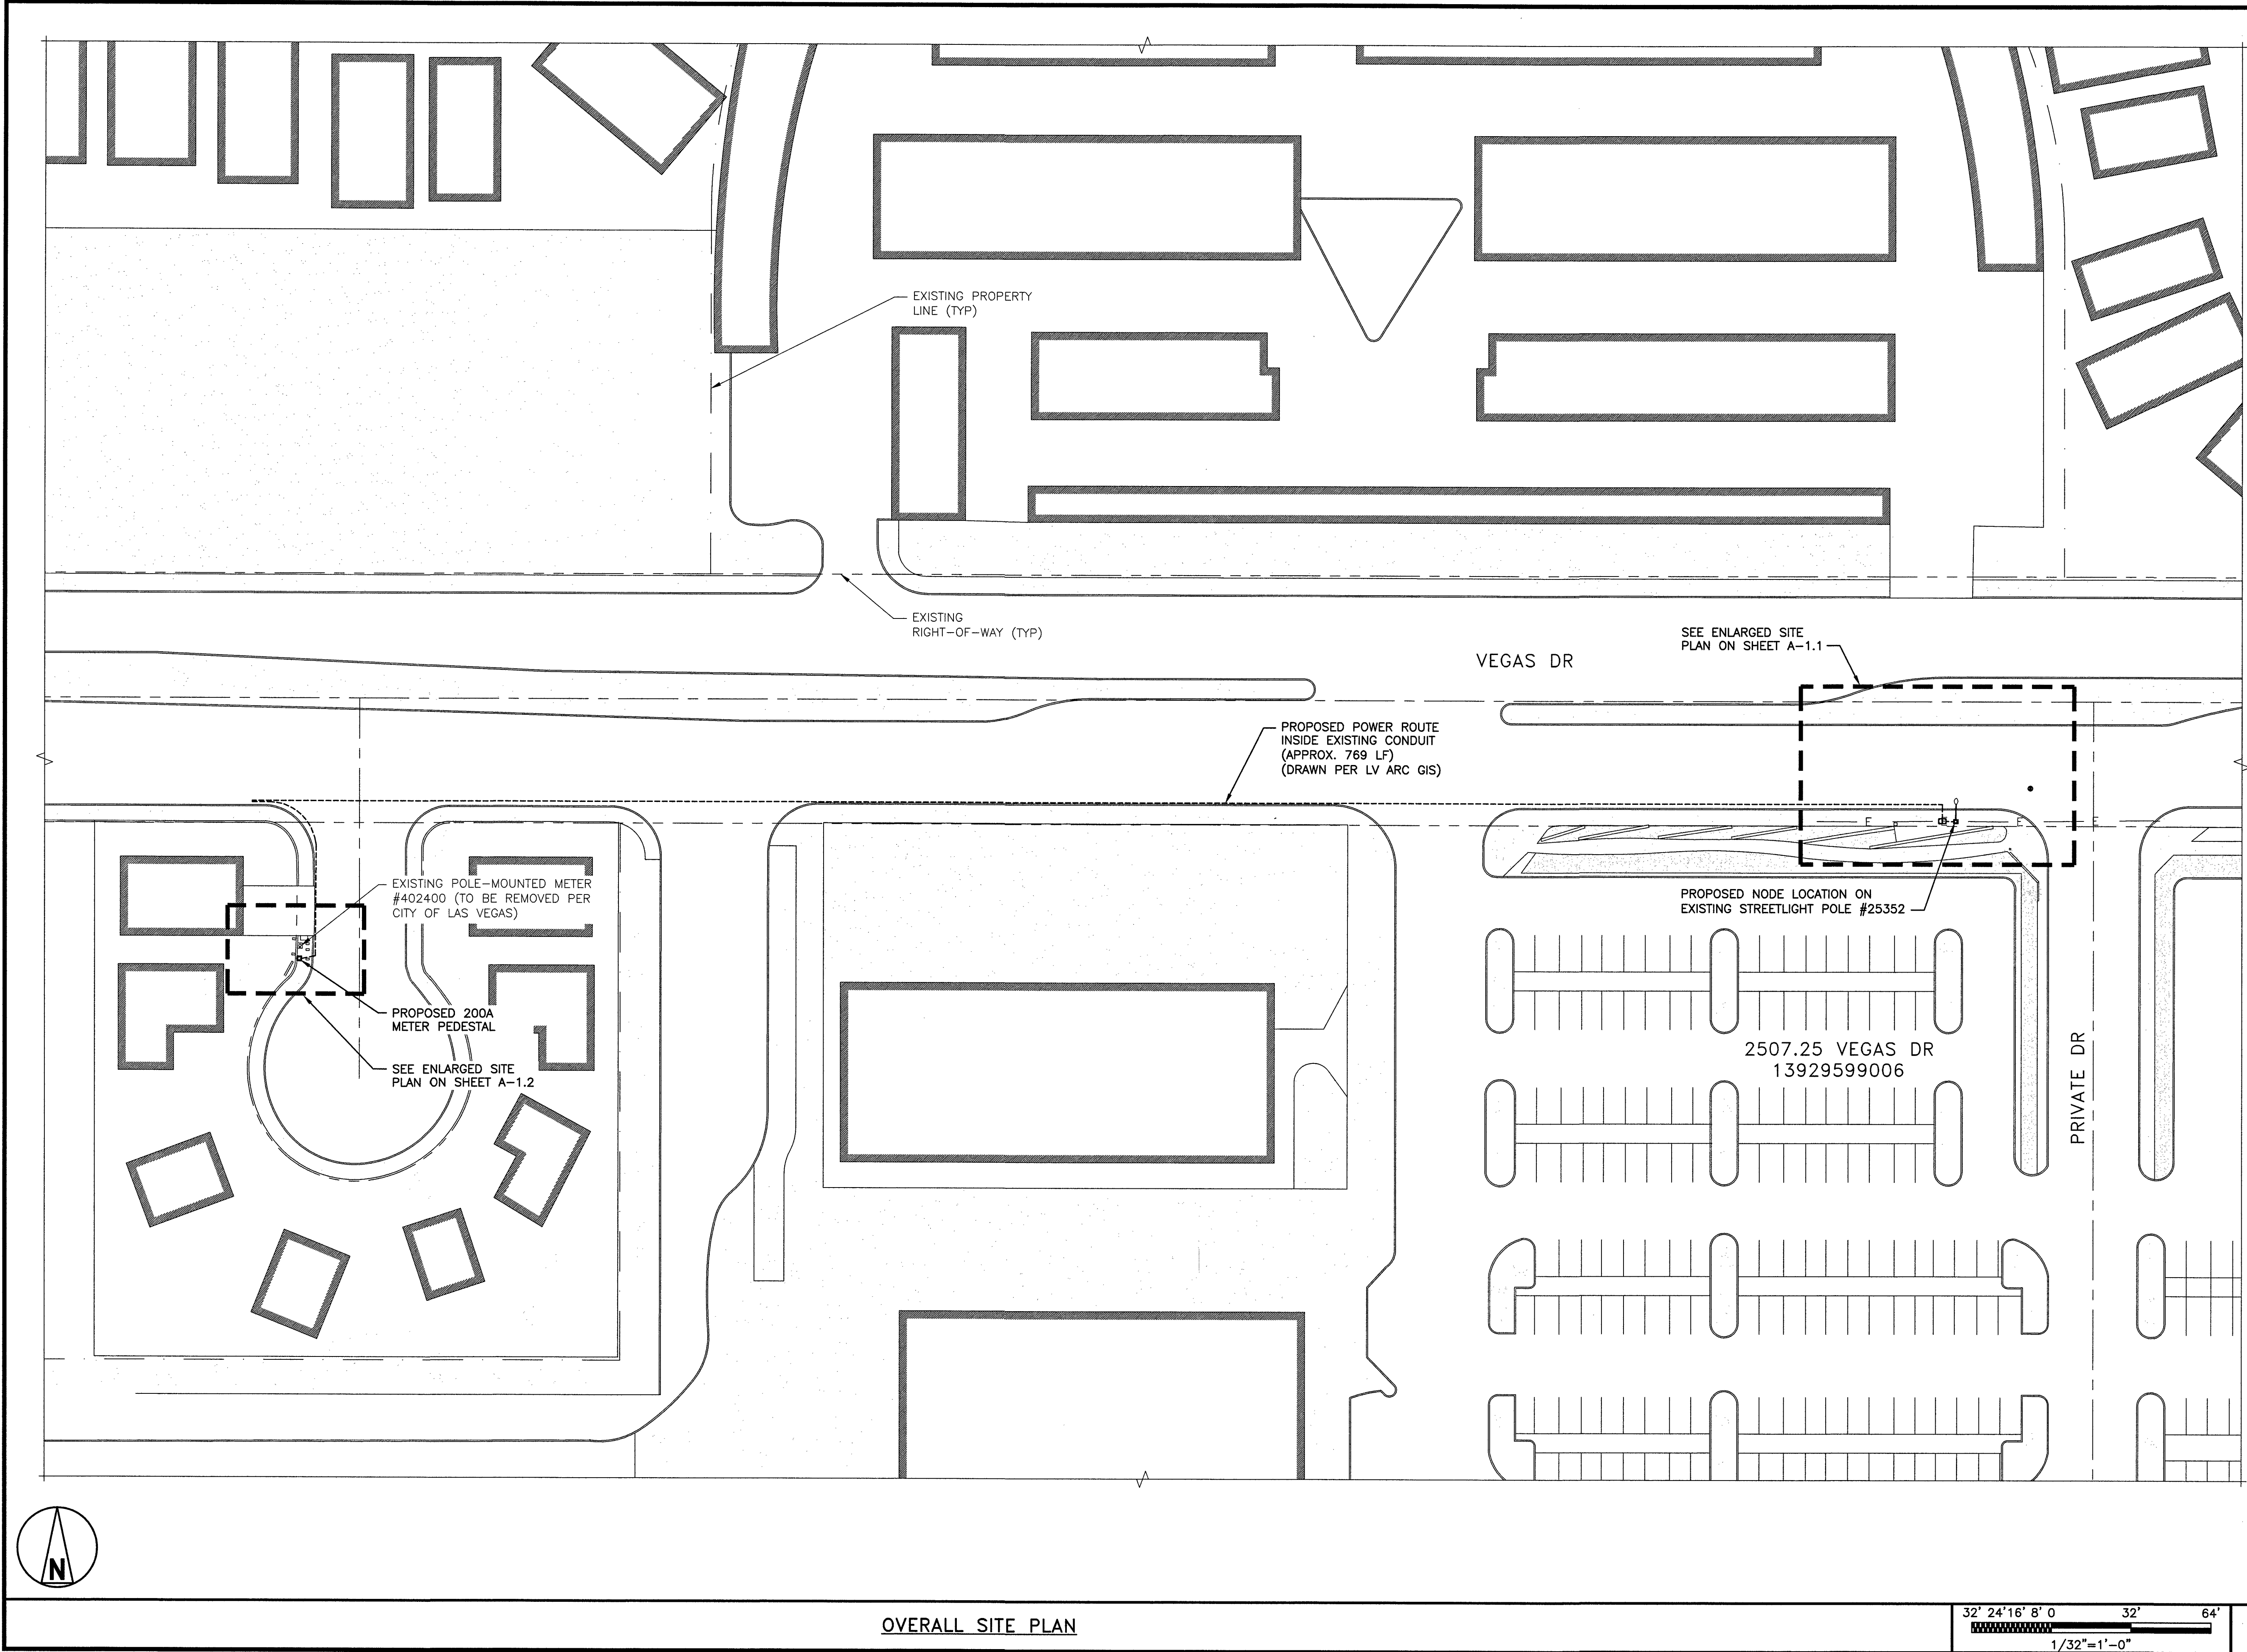

BLACK & VEATCH

BLACK & VEATCH CORPORATION
7760 FRANCE AVENUE SOUTH
SUITE 1200
BLOOMINGTON, MN 55435

THESE DRAWINGS ARE COPYRIGHTED AND
ARE THE PROPERTY OF BLACK & VEATCH;
PRODUCED SOLELY FOR THE USE OF OUR
CLIENT. ANY REPRODUCTION OR USE OF THE
INFORMATION CONTAINED WITHIN SAID
DRAWINGS IS PROHIBITED WITHOUT
WRITTEN CONSENT BY BLACK & VEATCH.

PROJECT NO.	DRAWN BY	CHECKED BY
199064.2047	TCG	LEW

REV	DATE	DESCRIPTION
1	02/13/19	CITY COMMENTS
0	12/05/18	ISSUED FOR CONSTRUCTION



IT IS A VIOLATION OF LAW FOR ANY PERSON,
UNLESS THEY ARE ACTING UNDER THE DIRECTION
OF A LICENSED PROFESSIONAL ENGINEER,
TO ALTER THIS DOCUMENT.

SITE ADDRESS



33AT0100SMC
CRAN_NVL08196F_R01
2507.25 VEGAS DR
LAS VEGAS, NV 89106
SMALL CELL

SHEET TITLE

OVERALL SITE PLAN

SHEET NUMBER

A-1

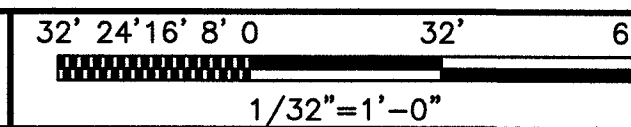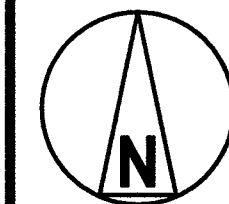

THIS DRAWING IS
NOT A SITE SURVEY

THE PURPOSE OF THIS DRAWING IS
TO SHOW HOW THE DEVELOPED SITE
RELATES TO THE PARENT PARCEL
AND ADJACENT PROPERTIES.



BLACK & VEATCH

BLACK & VEATCH CORPORATION
7760 FRANCE AVENUE SOUTH
SUITE 1200
BLOOMINGTON, MN 55435

THESE DRAWINGS ARE COPYRIGHTED AND
ARE THE PROPERTY OF BLACK & VEATCH;
PRODUCED SOLELY FOR THE USE OF OUR
CLIENT. ANY REPRODUCTION OR USE OF THE
INFORMATION CONTAINED WITHIN SAID
DRAWINGS IS PROHIBITED WITHOUT
WRITTEN CONSENT BY BLACK & VEATCH.

PROJECT NO.	DRAWN BY	CHECKED BY
199064.2047	TCG	LEW

REV	DATE	DESCRIPTION
1	02/13/19	CITY COMMENTS
0	12/05/18	ISSUED FOR CONSTRUCTION



IT IS A VIOLATION OF LAW FOR ANY PERSON,
UNLESS THEY ARE ACTING UNDER THE DIRECTION
OF A LICENSED PROFESSIONAL ENGINEER,
TO ALTER THIS DOCUMENT.

SITE ADDRESS

33AT0100SMC
CRAN_NVL08196F_R01
2507.25 VEGAS DR
LAS VEGAS, NV 89106
SMALL CELL

SHEET TITLE

ENLARGED SITE PLAN

SHEET NUMBER

A-1.1

VEGAS DR

50'-0"±
EXISTING CENTERLINE TO EXISTING R.O.W

48'-7"±
EXISTING CENTERLINE TO EXISTING STREET LIGHT BOX

47'-11"±
EXISTING CENTERLINE TO PROPOSED HANDHOLE

47'-6"±
EXISTING CENTERLINE TO EXISTING POLE

48'-1"±
EXISTING CENTERLINE TO EXISTING ELECTRIC LINE

42'-11"±
EXISTING CENTERLINE TO EXISTING CURB

EXISTING CENTERLINE
OF ROAD (TYP)

EXISTING SEWER MANHOLE

EXISTING
SIDEWALK (TYP)


EXISTING CURB (TYP)

EXISTING ELECTRIC
LINE (TYP)

EXISTING
RIGHT-OF-WAY (TYP)

PROPOSED POWER ROUTE
INSIDE EXISTING CONDUIT
(DRAWN PER LV ARC GIS)


8
D-1
PROPOSED
HANDHOLE

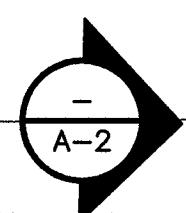

PROPOSED EQUIPMENT
MOUNTED TO EXISTING
STREETLIGHT POLE #25352

EXISTING STREET
LIGHT BOX (TYP)

2507.25 VEGAS DR
13929599006

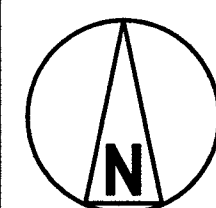

ENLARGED SITE PLAN

4' 2' 0' 4' 8'
1/4"=1'-0"

1

THIS DRAWING IS
NOT A SITE SURVEY

THE PURPOSE OF THIS DRAWING IS
TO SHOW HOW THE DEVELOPED SITE
RELATES TO THE PARENT PARCEL
AND ADJACENT PROPERTIES.

EXISTING
RESIDENTIAL STRUCTURE

EXISTING RIGHT-OF-WAY (TYP)

EXISTING DRIVEWAY

EXODUS CT

EXISTING POLE-MOUNTED METER
#402400 (TO BE REPLACED
PER CITY OF LAS VEGAS)

EXISTING MAILBOX (TYP)

PROPOSED 200A
METER PEDESTAL

PROPOSED CONCRETE CAP

EXISTING LANDSCAPE WALL

23'-6"
PROPOSED PEDESTAL TO CENTERLINE

EXISTING PULL BOX (TYP)

EXISTING SIDEWALK (TYP)

EXISTING CURB (TYP)

EXISTING CENTERLINE
OF ROAD (TYP)




BLACK & VEATCH

BLACK & VEATCH CORPORATION
7760 FRANCE AVENUE SOUTH
SUITE 1200
BLOOMINGTON, MN 55435

THESE DRAWINGS ARE COPYRIGHTED AND
ARE THE PROPERTY OF BLACK & VEATCH;
PRODUCED SOLELY FOR THE USE OF OUR
CLIENT. ANY REPRODUCTION OR USE OF THE
INFORMATION CONTAINED WITHIN SAID
DRAWINGS IS PROHIBITED WITHOUT
WRITTEN CONSENT BY BLACK & VEATCH.

PROJECT NO.	DRAWN BY	CHECKED BY
199064.2047	TCG	LEW

REV	DATE	DESCRIPTION
1	02/13/19	CITY COMMENTS
0	12/05/18	ISSUED FOR CONSTRUCTION

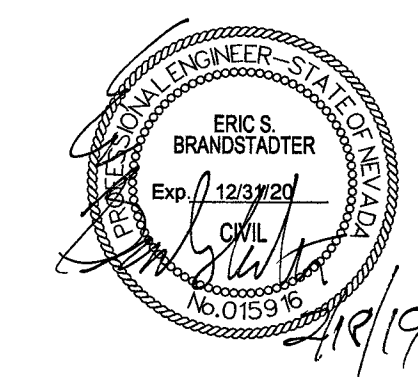

IT IS A VIOLATION OF LAW FOR ANY PERSON,
UNLESS THEY ARE ACTING UNDER THE DIRECTION
OF A LICENSED PROFESSIONAL ENGINEER,
TO ALTER THIS DOCUMENT.


SITE ADDRESS

33AT0100SMC
CRAN_NVL08196F_R01
2507.25 VEGAS DR
LAS VEGAS, NV 89106
SMALL CELL


SHEET TITLE
**ENLARGED METER
SITE PLAN**

SHEET NUMBER




A-1.2

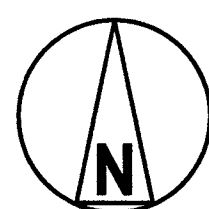

ENLARGED SITE PLAN

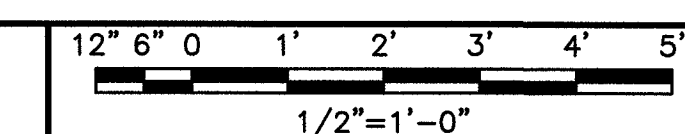

1

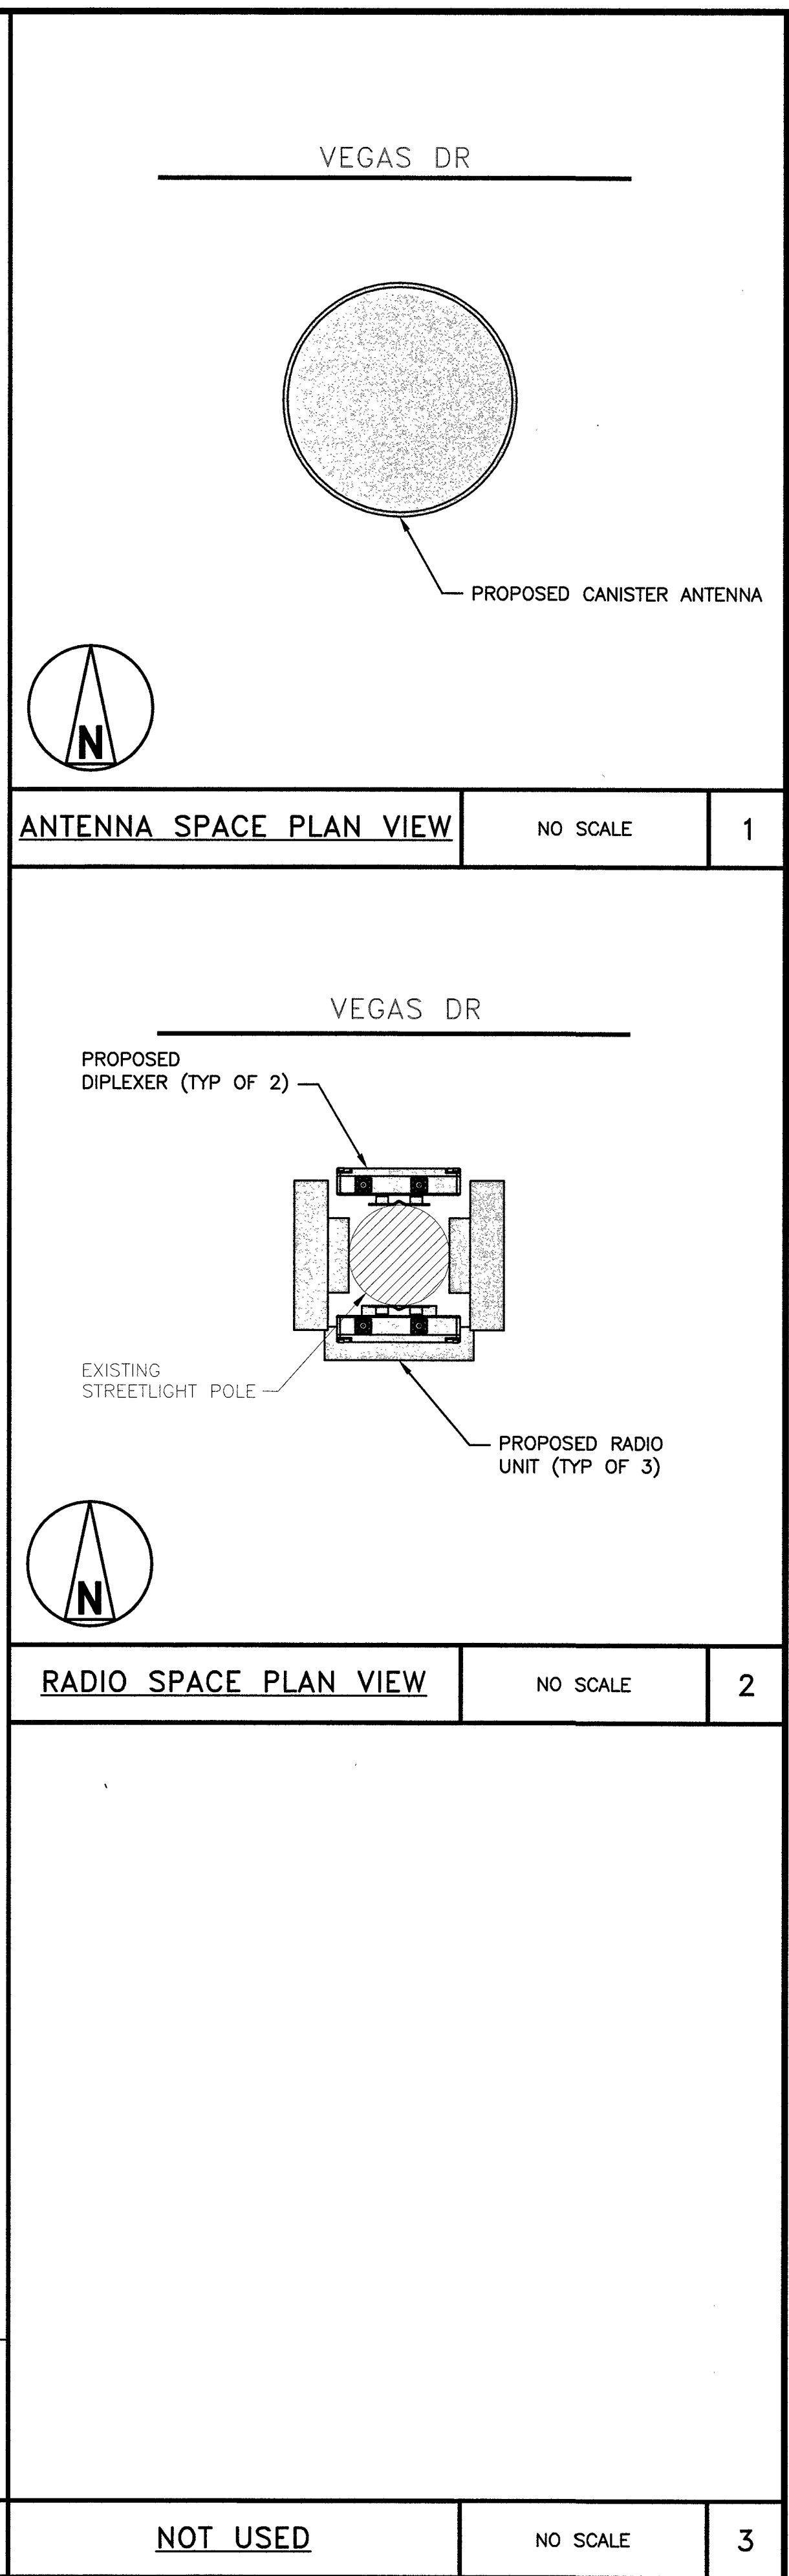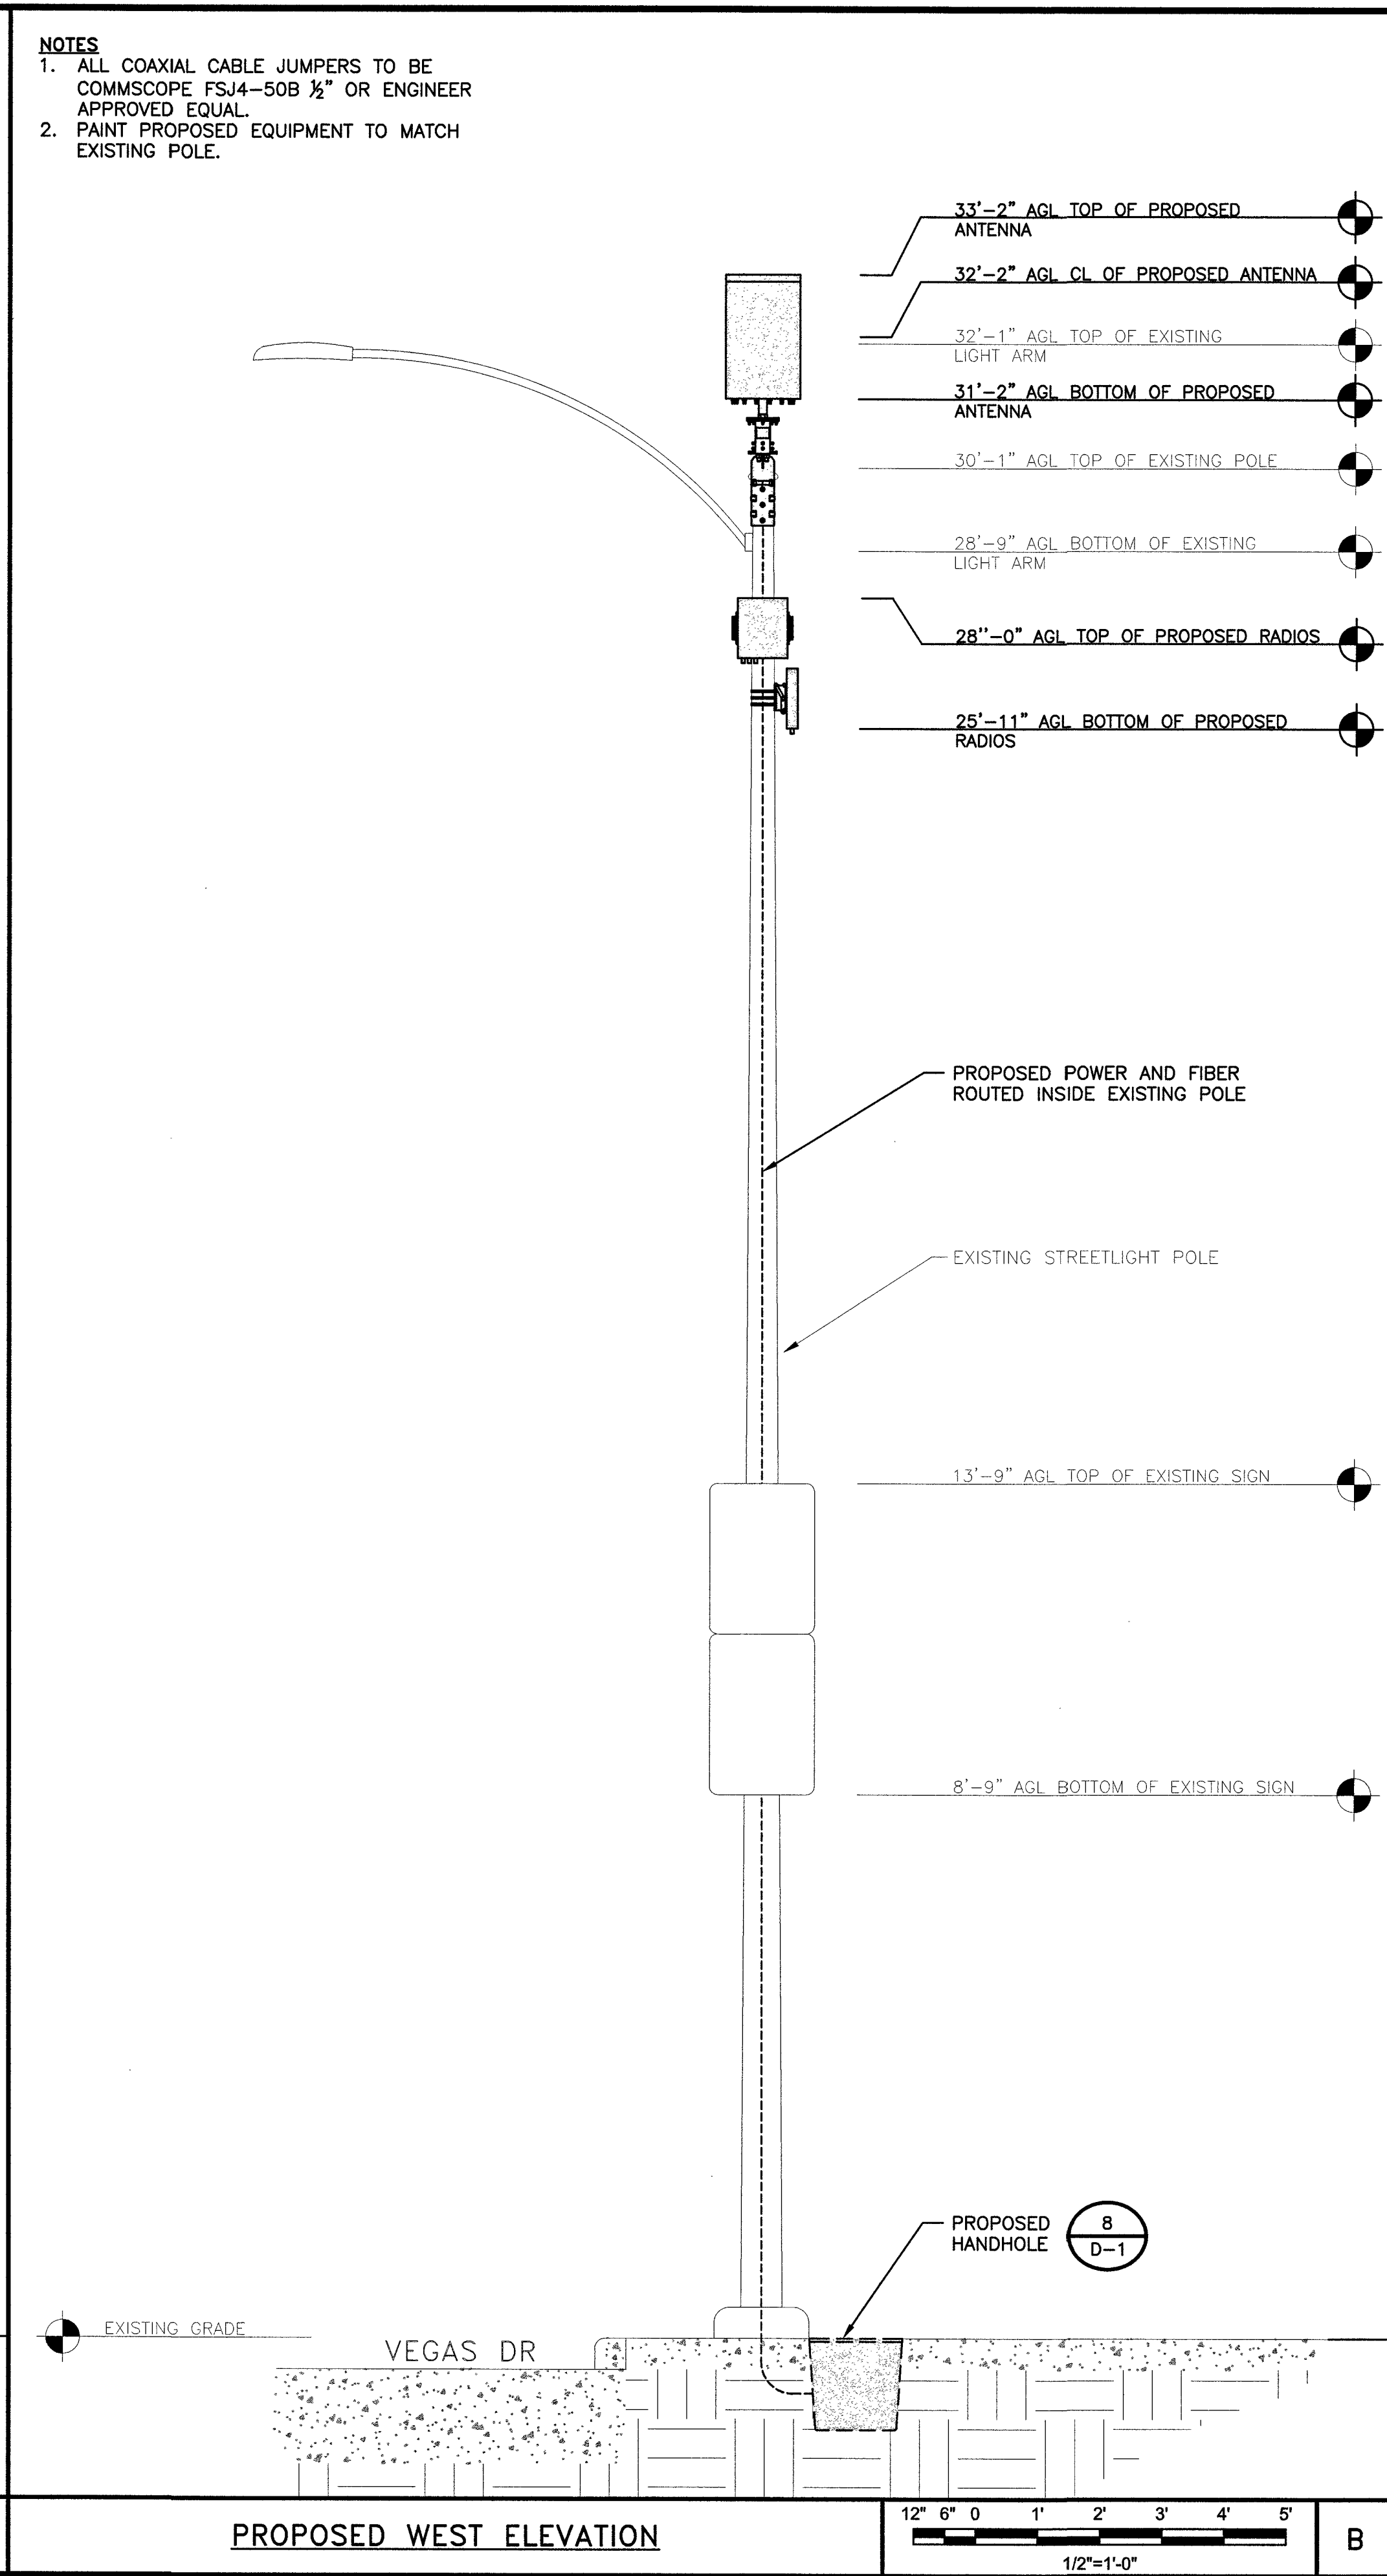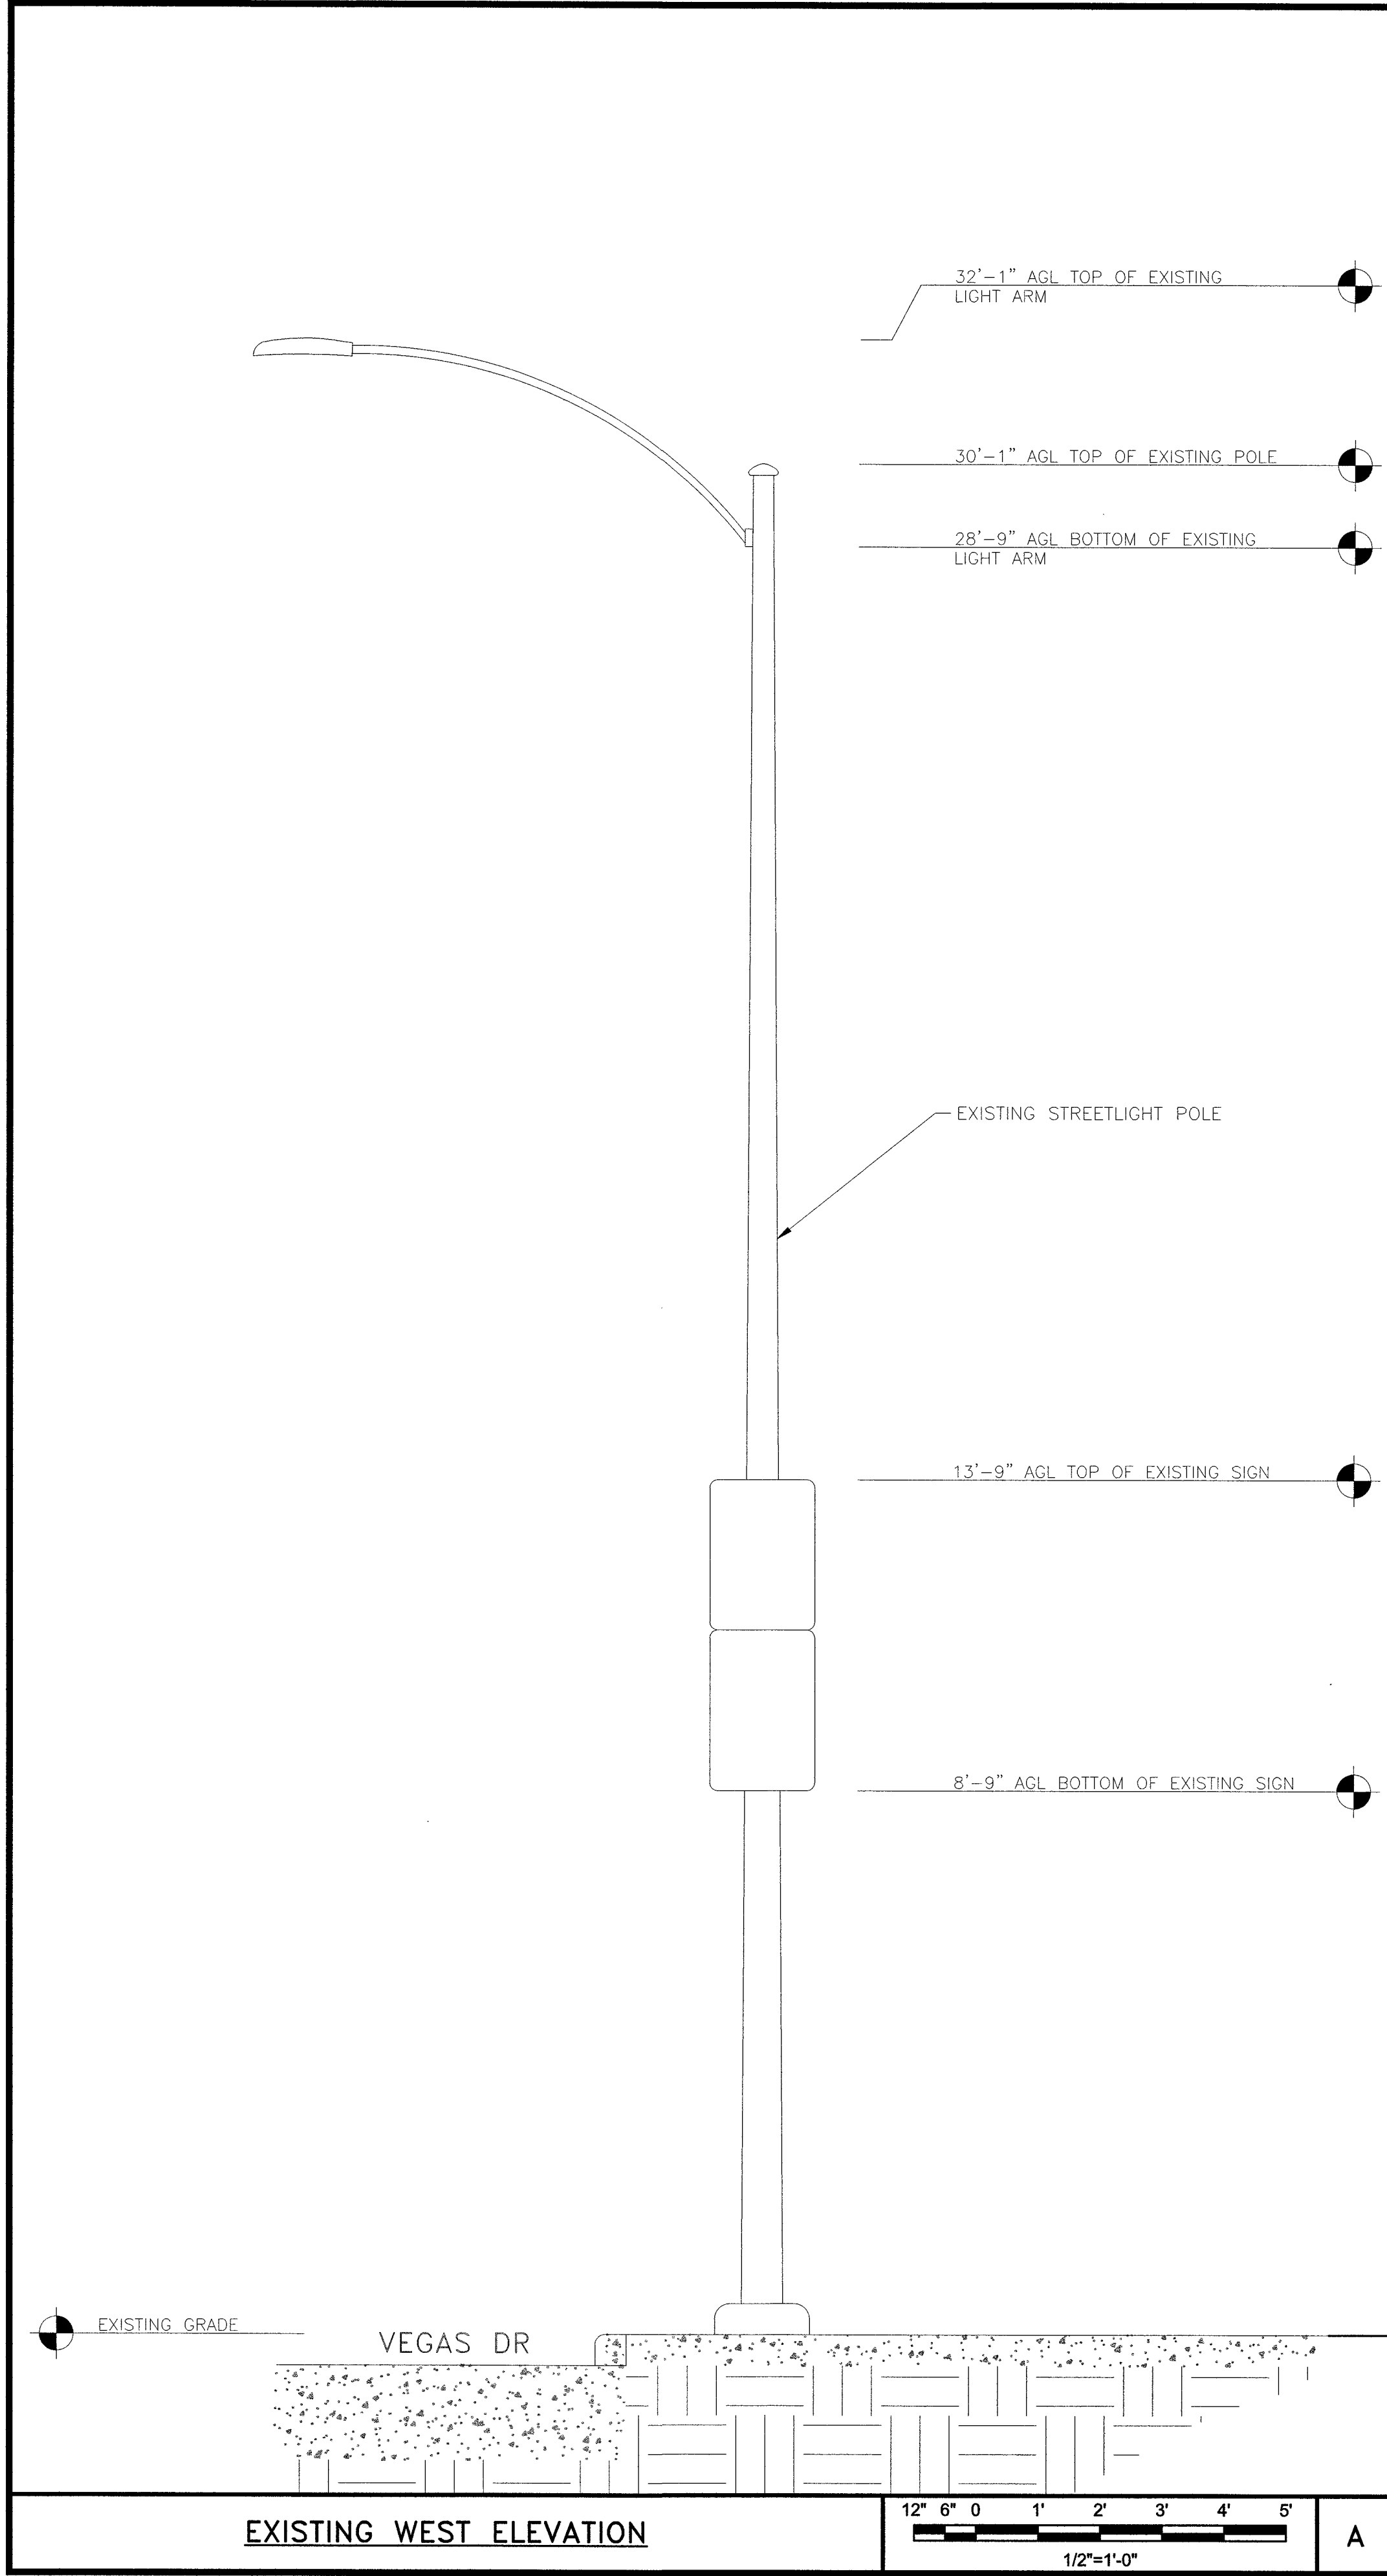

BLACK & VEATCH

BLACK & VEATCH CORPORATION
7760 FRANCE AVENUE SOUTH
SUITE 1200
BLOOMINGTON, MN 55435

THESE DRAWINGS ARE COPYRIGHTED AND ARE THE PROPERTY OF BLACK & VEATCH; PRODUCED SOLELY FOR THE USE OF OUR CLIENT. ANY REPRODUCTION OR USE OF THE INFORMATION CONTAINED WITHIN SAID DRAWINGS IS PROHIBITED WITHOUT WRITTEN CONSENT BY BLACK & VEATCH.

PROJECT NO.	DRAWN BY	CHECKED BY
199064.2047	TCG	LEW

REV	DATE	DESCRIPTION
1	02/13/19	CITY COMMENTS
0	12/05/18	ISSUED FOR CONSTRUCTION

IT IS A VIOLATION OF LAW FOR ANY PERSON, UNLESS THEY ARE ACTING UNDER THE DIRECTION OF A LICENSED PROFESSIONAL ENGINEER, TO ALTER THIS DOCUMENT.

SITE ADDRESS

33AT0100SMC
CRAN_NVL08196F_R01
2507.25 VEGAS DR
LAS VEGAS, NV 89106
SMALL CELL

SHEET TITLE

ELEVATIONS


SHEET NUMBER

A-2

NOT USED	NO SCALE	3
----------	----------	---

- NOTES**
1. ALL COAXIAL CABLE JUMPERS TO BE COMMSCOPE FSJ4-50B 1/2" OR ENGINEER APPROVED EQUAL.
 2. PAINT PROPOSED EQUIPMENT TO MATCH EXISTING POLE.

MYERS MEUG16-M200 CALTRANS TYPE III-BF

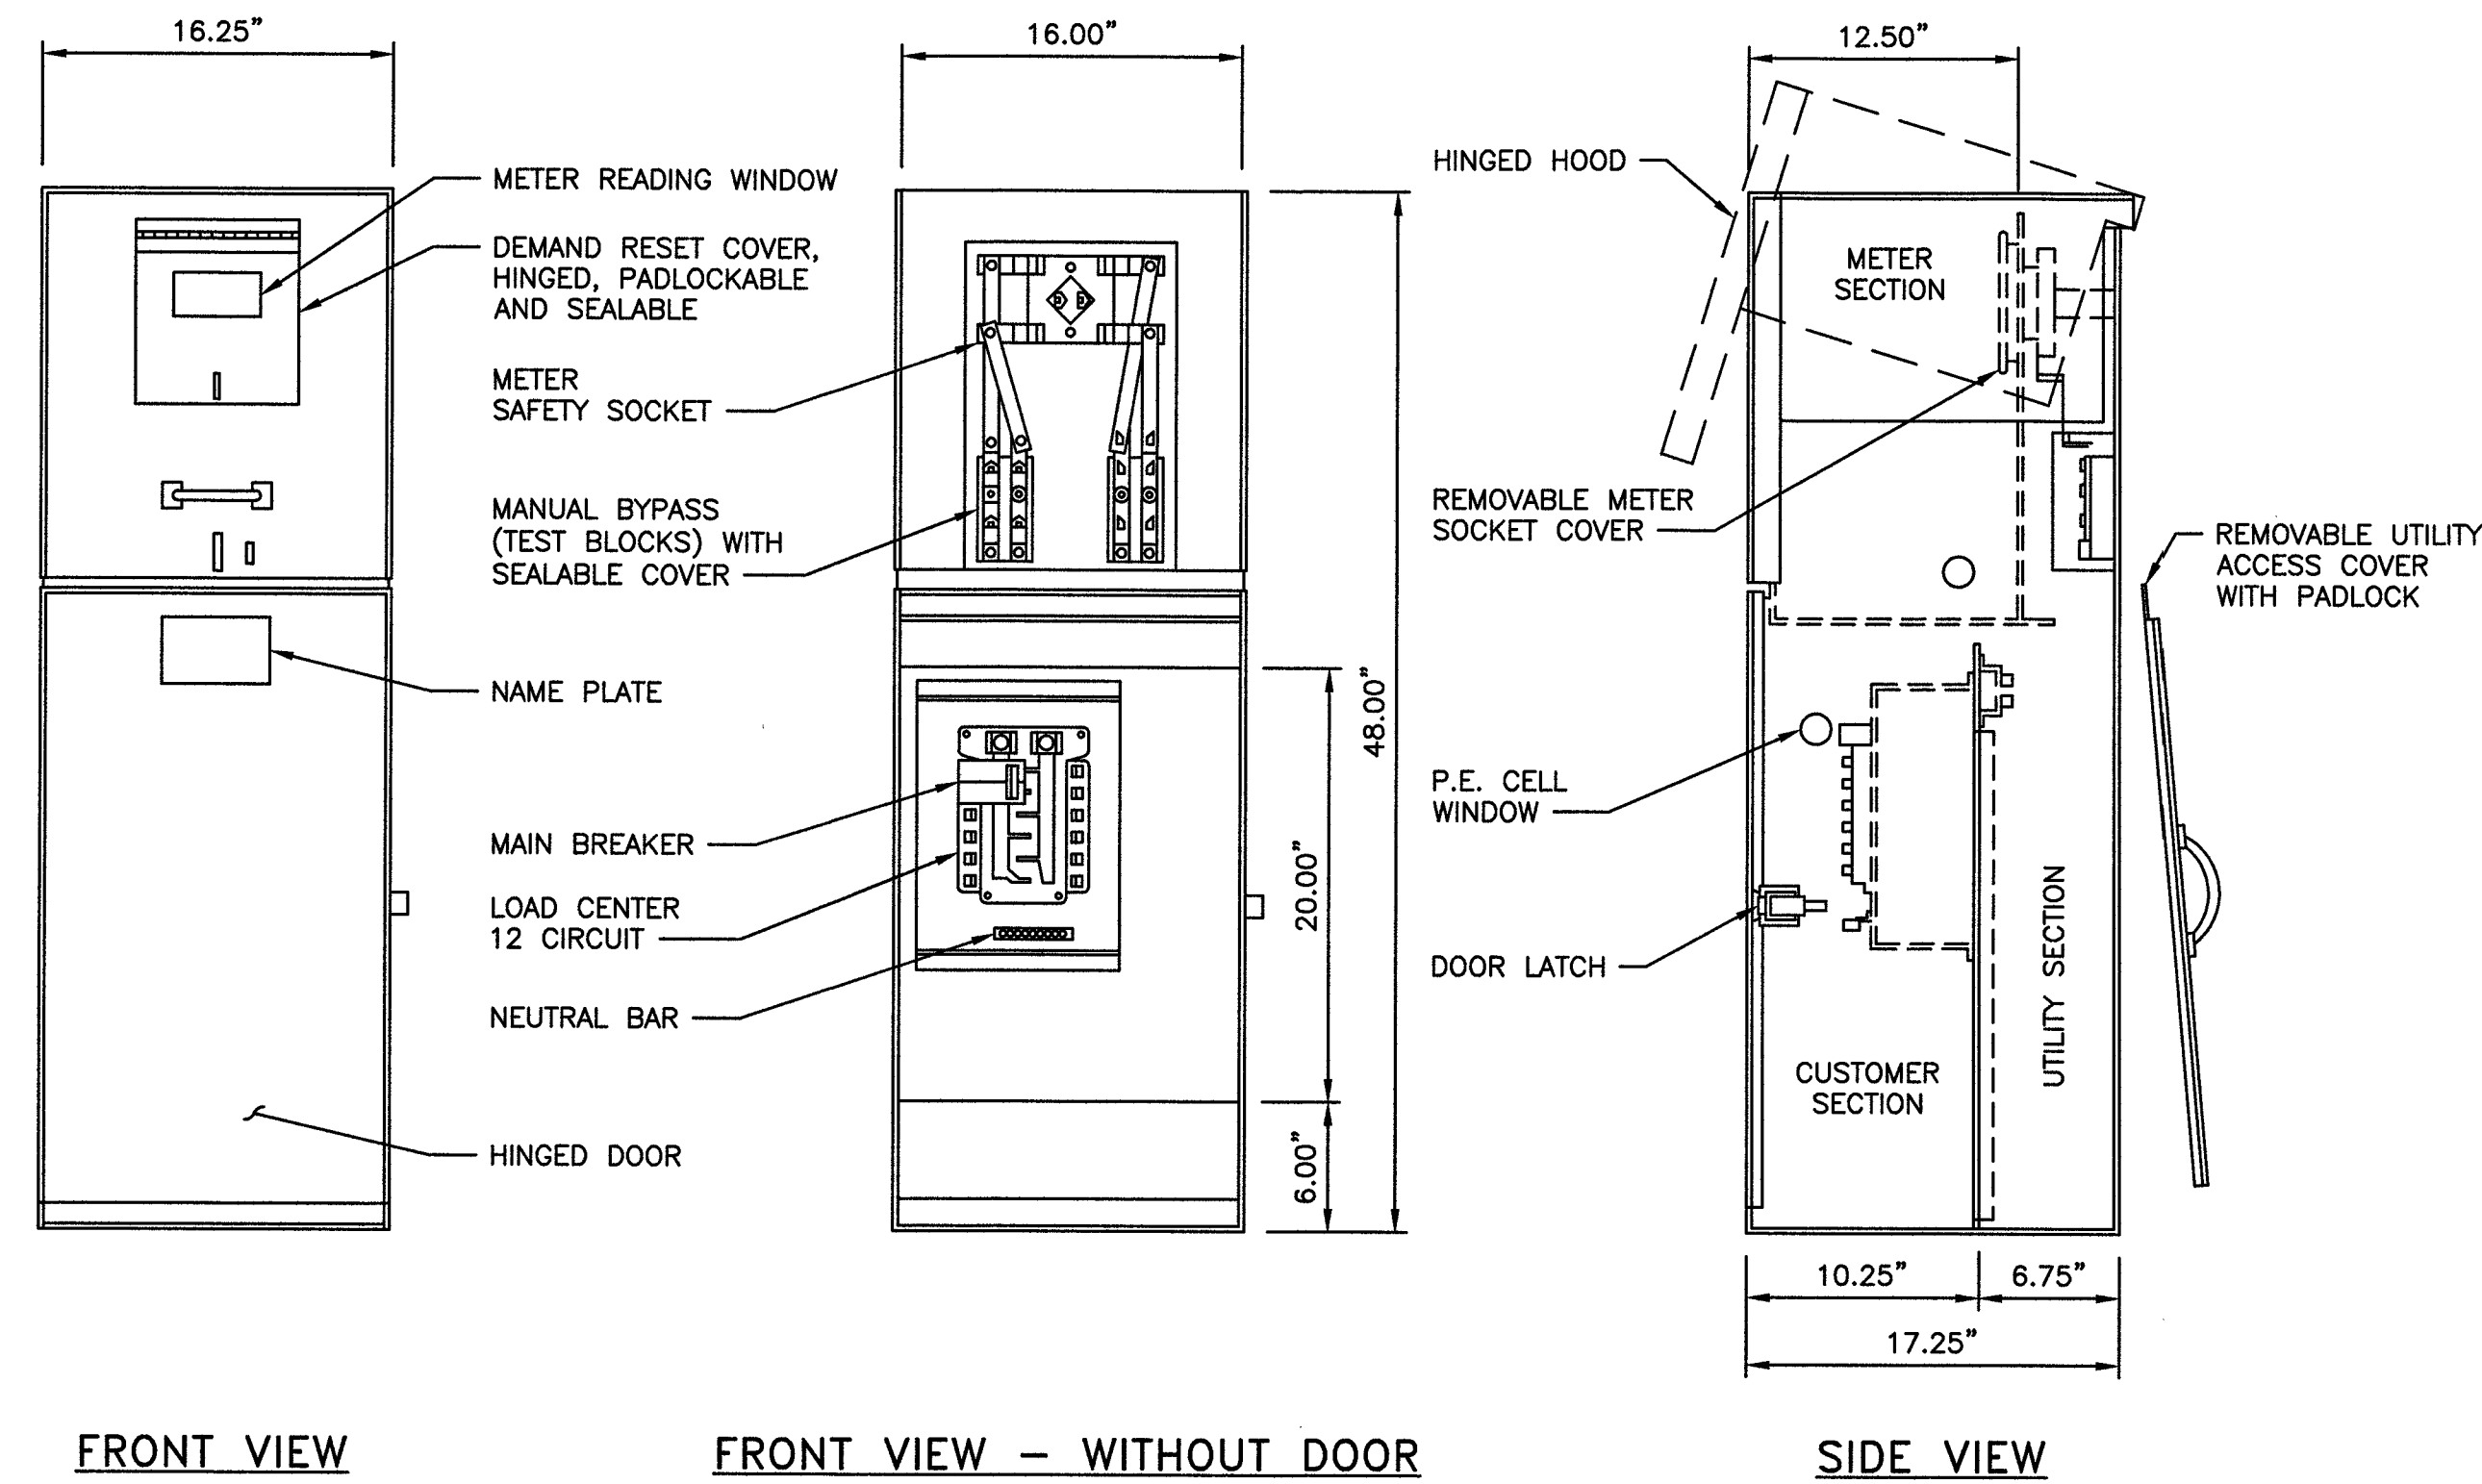


METER PEDESTAL DETAIL

NO SCALE

1

NOTES


1. MINIMUM CLEARANCE REQUIRED 36" PER NEC 110-16, TYPICAL FRONT AND BACK.
2. FOUNDATION DIMENSIONS AND DEPTH PER JOB SPECIFICATIONS.

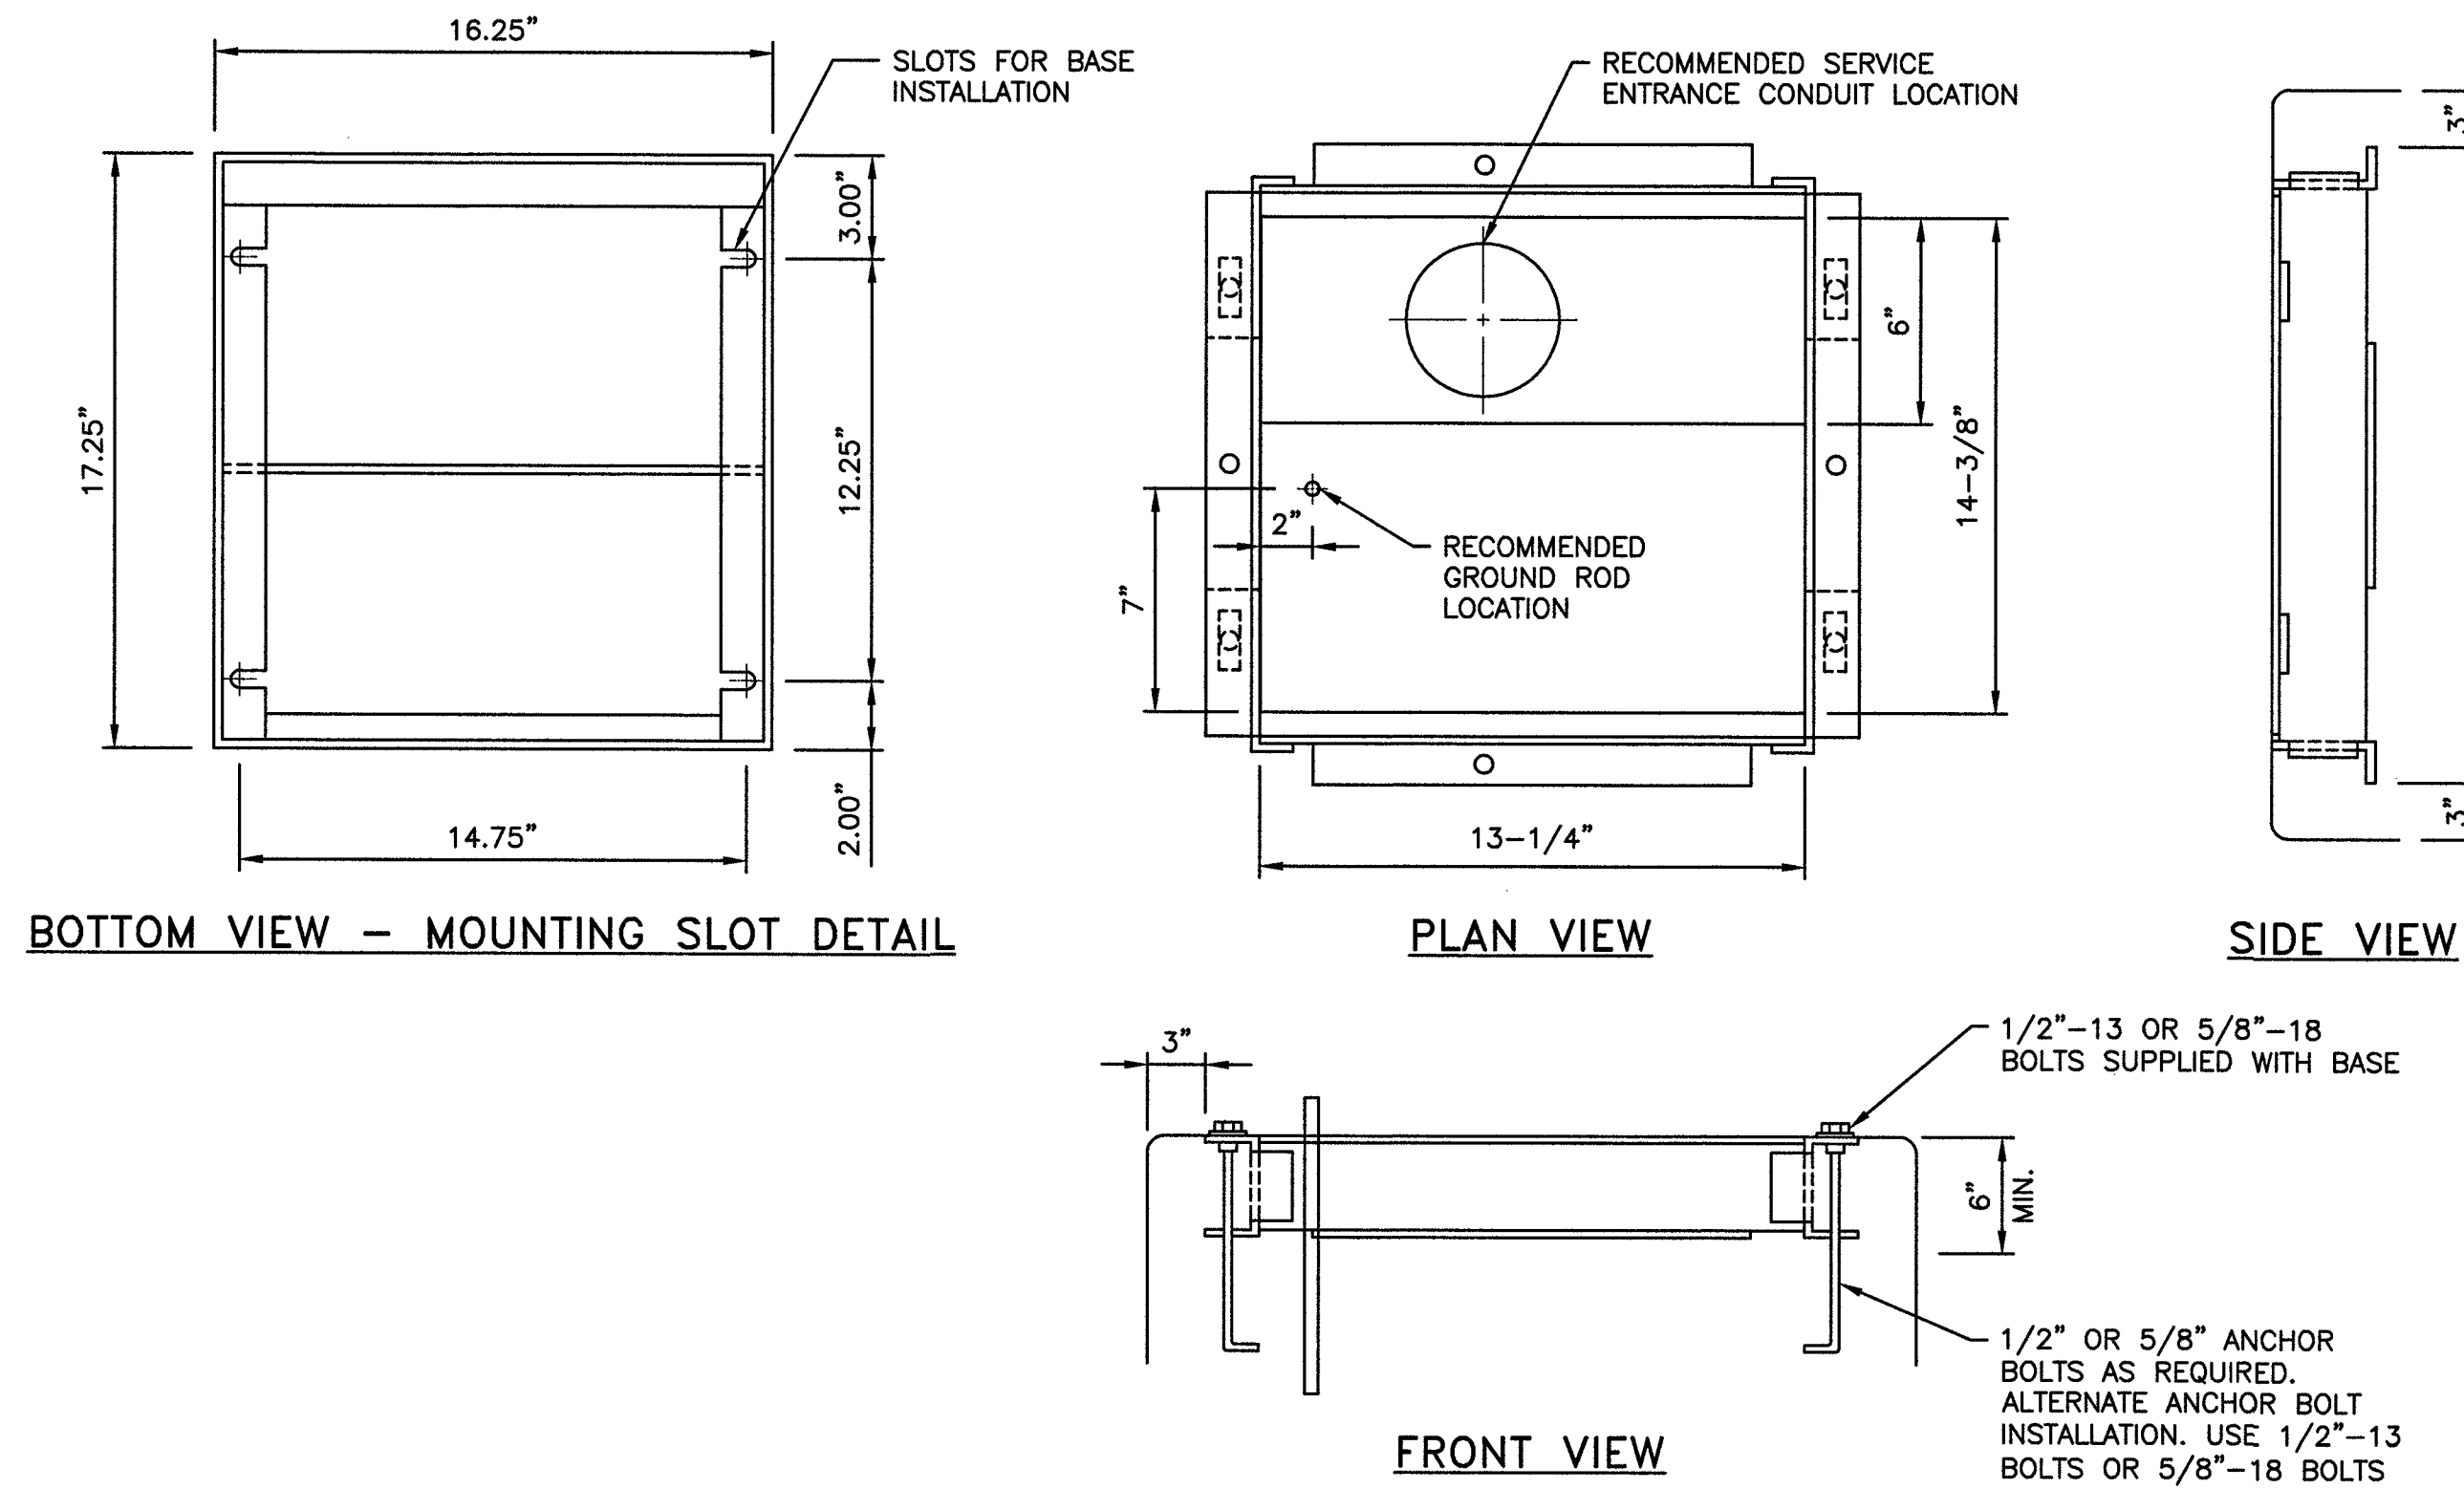

BASEPLATE DETAIL

NO SCALE

3

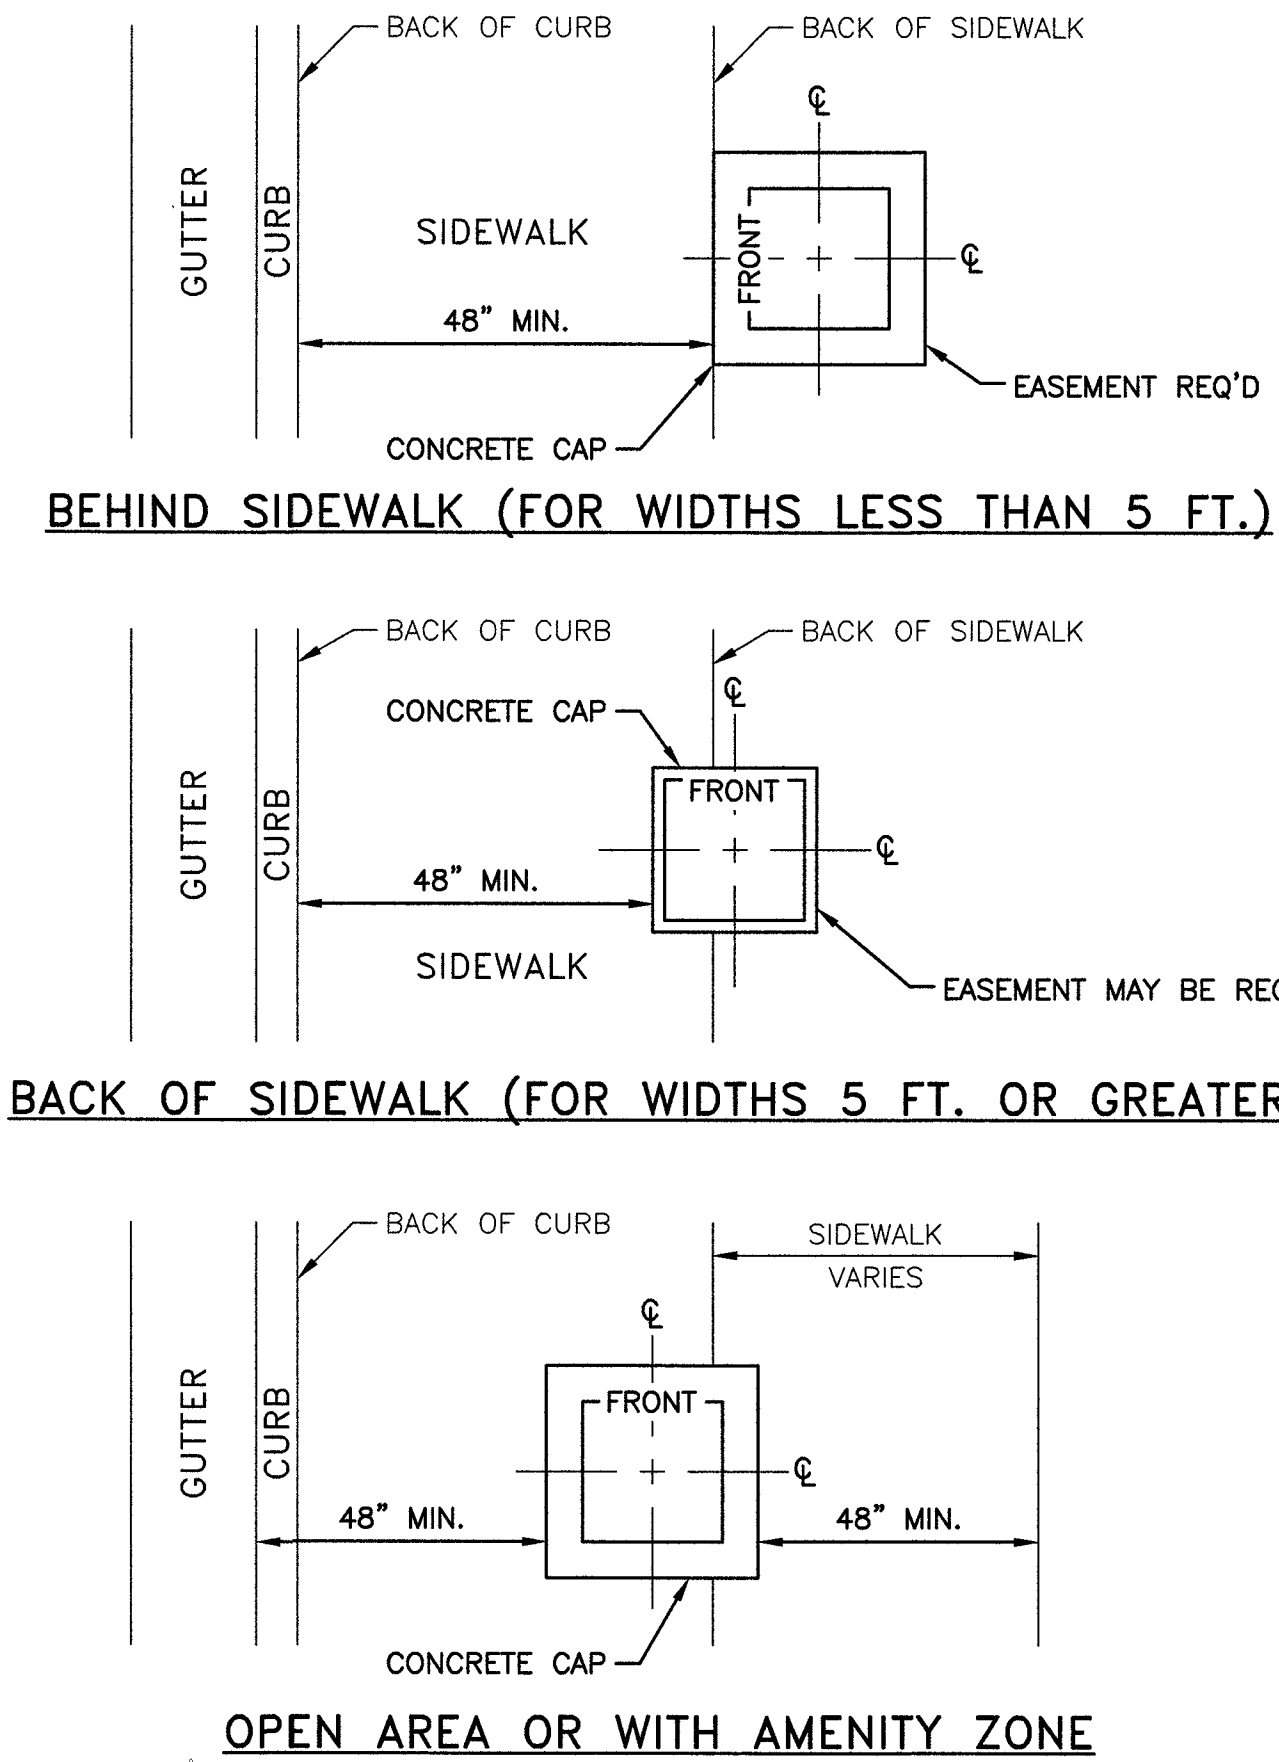


SERVICE PEDESTAL SETBACK DETAILS (USDCCA DRAWING #331)

NO SCALE

2

NOTES

1. BARE COPPER GROUNDING CONDUCTOR SHALL BE LOOPED AROUND ANCHOR BOLTS ONE TIME AND CONNECTED TO EACH ANCHOR BOLT BEFORE CONTINUING DOWN TO THE GROUNDING PLATE.
2. CABINET COVERS SHALL BE PARALLEL WITH CURB.
3. IN AREAS WHERE R/W PERMITS, THE CONCRETE BASE SHALL BE PLACED AT THE BACK EDGE OF THE SIDEWALK.
4. CABINET COVERS SHALL OPEN TOWARDS THE STREET WHEN CABINETS ARE LOCATED AT BACK OF WALK. CABINET COVERS SHALL OPEN PARALLEL TO THE SIDEWALK FACING THE DIRECTION OF TRAFFIC WHEN LOCATED WITHIN THE SIDEWALK.
5. WIRE SIZES ARE BASED ON UNDERGROUND FEED.
6. WIRE SIZES SHALL BE INCREASED FOR VOLTAGE DROP LIMITATION WHEN RUN IS LONG.

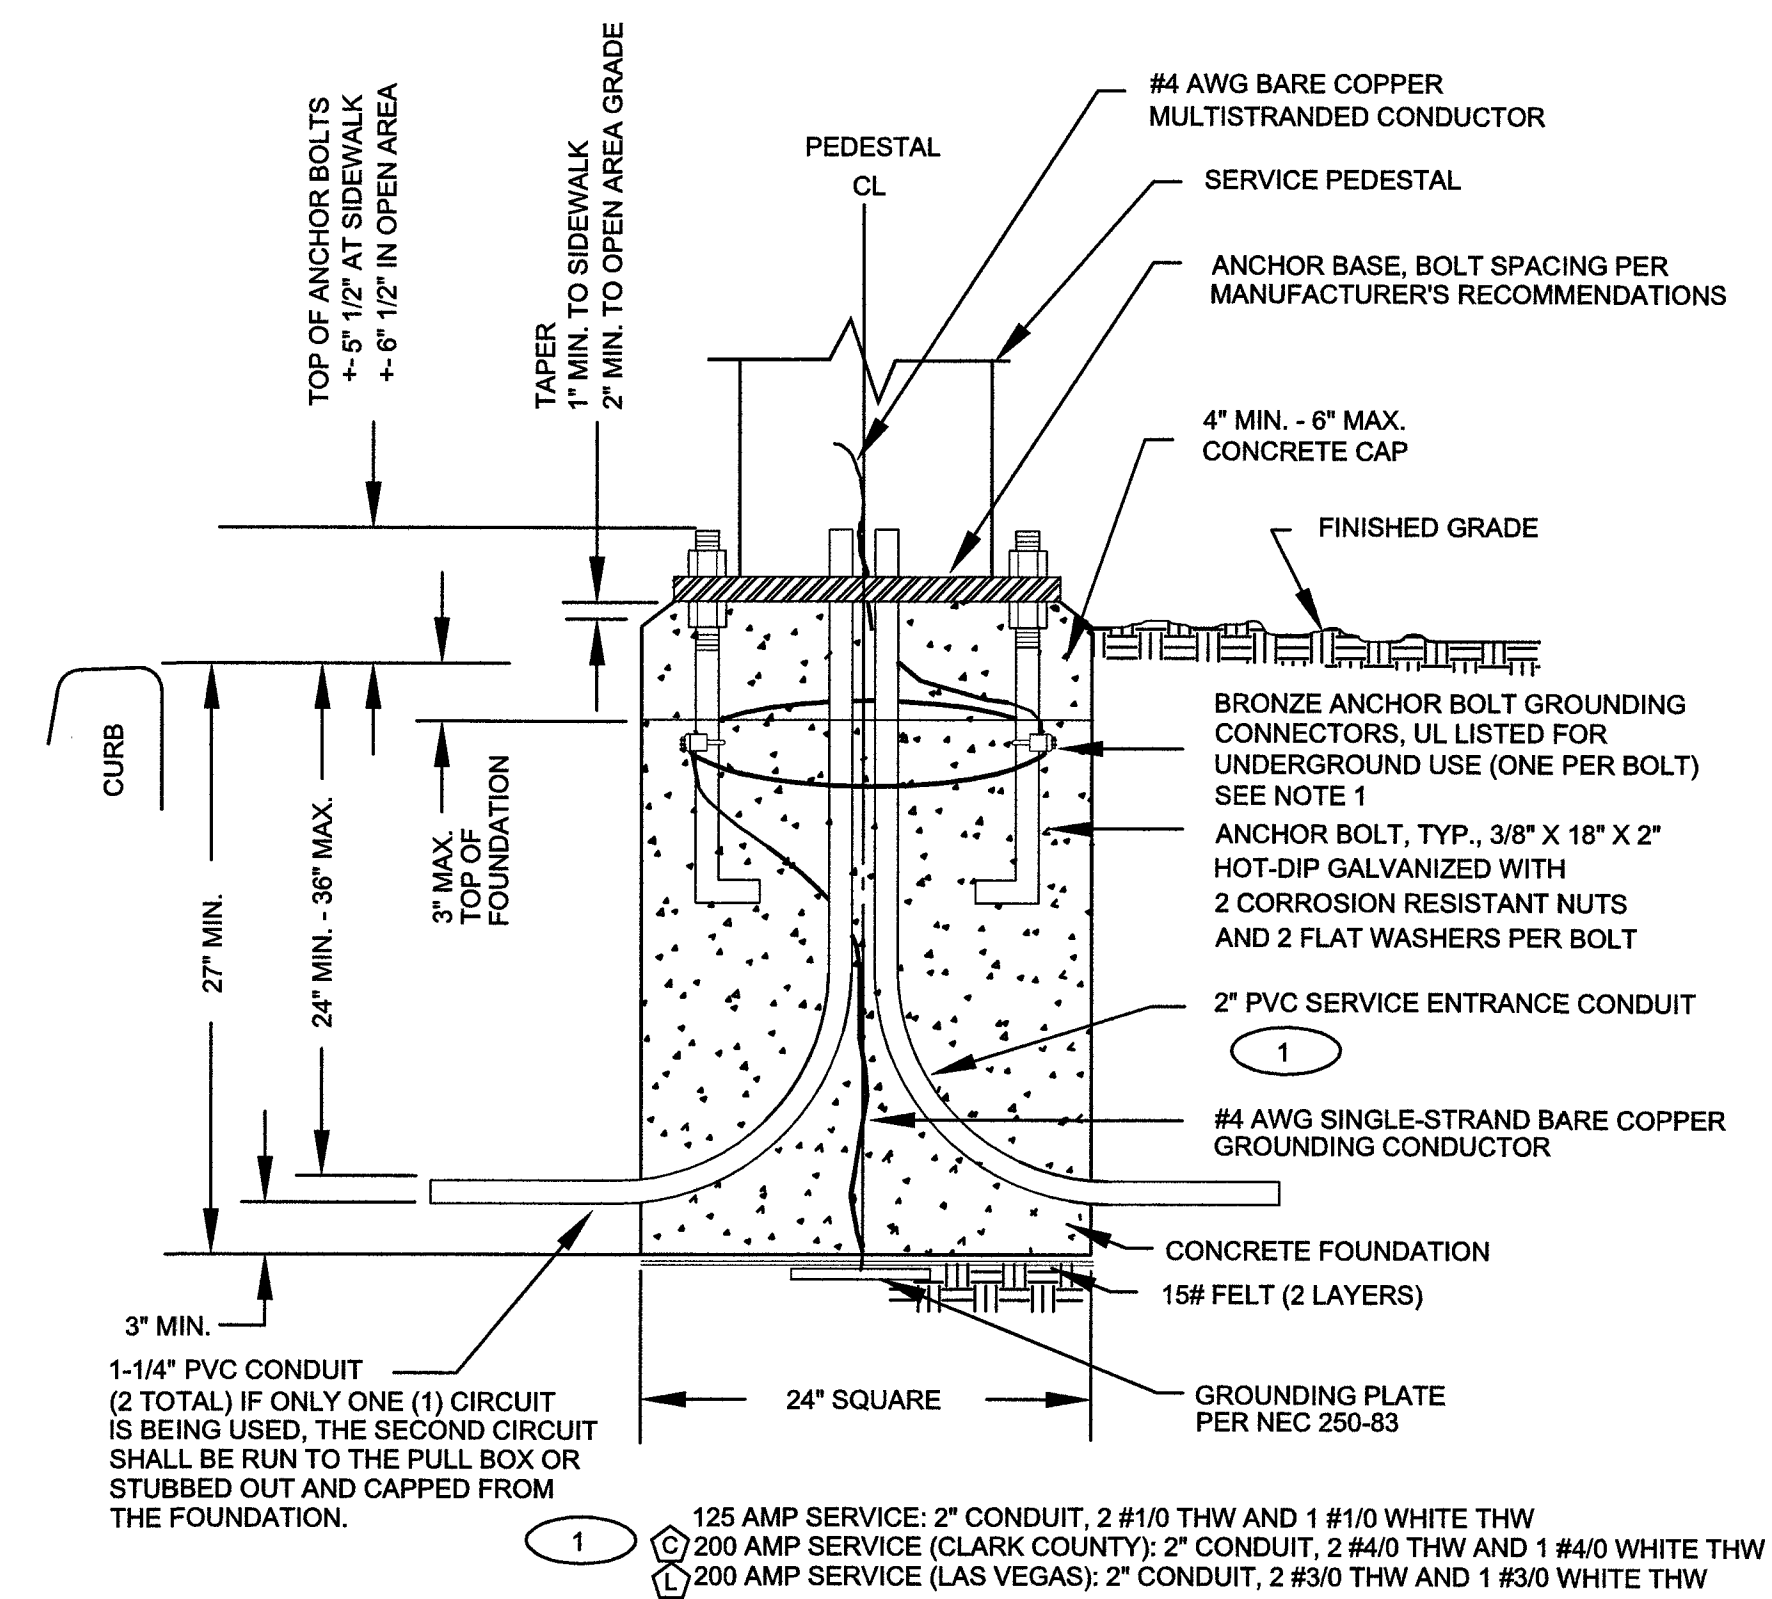

SERVICE PEDESTAL FOUNDATION DETAIL

NO SCALE

4




BLACK & VEATCH

BLACK & VEATCH CORPORATION
7760 FRANCE AVENUE SOUTH
SUITE 1200
BLOOMINGTON, MN 55435

THESE DRAWINGS ARE COPYRIGHTED AND ARE THE PROPERTY OF BLACK & VEATCH; PRODUCED SOLELY FOR THE USE OF OUR CLIENT. ANY REPRODUCTION OR USE OF THE INFORMATION CONTAINED WITHIN SAID DRAWINGS IS PROHIBITED WITHOUT WRITTEN CONSENT BY BLACK & VEATCH.

PROJECT NO.	DRAWN BY	CHECKED BY
199064.2047	TCG	LEW

REV	DATE	DESCRIPTION
1	02/13/19	CITY COMMENTS
0	12/05/18	ISSUED FOR CONSTRUCTION

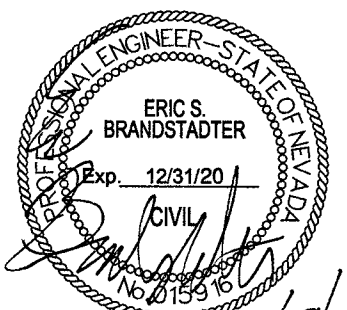

IT IS A VIOLATION OF LAW FOR ANY PERSON, UNLESS THEY ARE ACTING UNDER THE DIRECTION OF A LICENSED PROFESSIONAL ENGINEER, TO ALTER THIS DOCUMENT.

SITE ADDRESS

33AT0100SMC
CRAN_NVLO8196F_R01
2507.25 VEGAS DR
LAS VEGAS, NV 89106
SMALL CELL

SHEET TITLE

METER PEDESTAL
DETAILS

SHEET NUMBER

D-2

CAUTION
STAY BACK 3 ft.
TO PREVENT
RADIO FREQUENCY
EXPOSURES ABOVE FCC
LIMITS. CALL NOC
1-877-897-2475
TO POWER DOWN.
SITE ID: 33AT0100SMC

NOTICE
SMALL CELL SHUT OFF SWITCH
Push switch button turn off radio
while working within 3 ft. of the
device
Note: Once work is completed
turn switch back on

NOTES

1. CONTRACTOR IS TO FIELD VERIFY ALL EXISTING ITEMS SHOWN ON THE ELECTRICAL ONE-LINE DIAGRAM AND NOTIFY THE ENGINEER OF ANY DISCREPANCIES.
2. ALL NEW CONDUCTOR WIRE TO BE INSTALLED SHALL BE COPPER THWN-2, THW-2, RHW-2, XHHW-2 WIRE UNLESS NOTED OTHERWISE.
3. ALL GROUNDING AND BONDING TO BE PER THE RECOGNIZED EDITION OF THE NATIONAL ELECTRIC CODE (NEC).
4. ALL INSTALLED CONDUCTORS AND SIGNAL CABLES TO BE CLEARLY MARKED "COX COMMUNICATIONS" WITH BRASS OR FIBERGLASS TAGS.


120VAC FEEDER CONDUCTOR MAXIMUM DISTANCE			
#12 AWG	385'-0"	3% VOLT DROP @	2.34A
#10 AWG	642'-0"	3% VOLT DROP @	2.34A
#8 AWG	987'-0"	3% VOLT DROP @	2.34A

RF WARNING PLACARDS

NO SCALE

1

MULTI-TAP CONNECTOR WITH CLEAR INSULATION,
DOUBLE-SIDED (PCSB4-4-6Y)

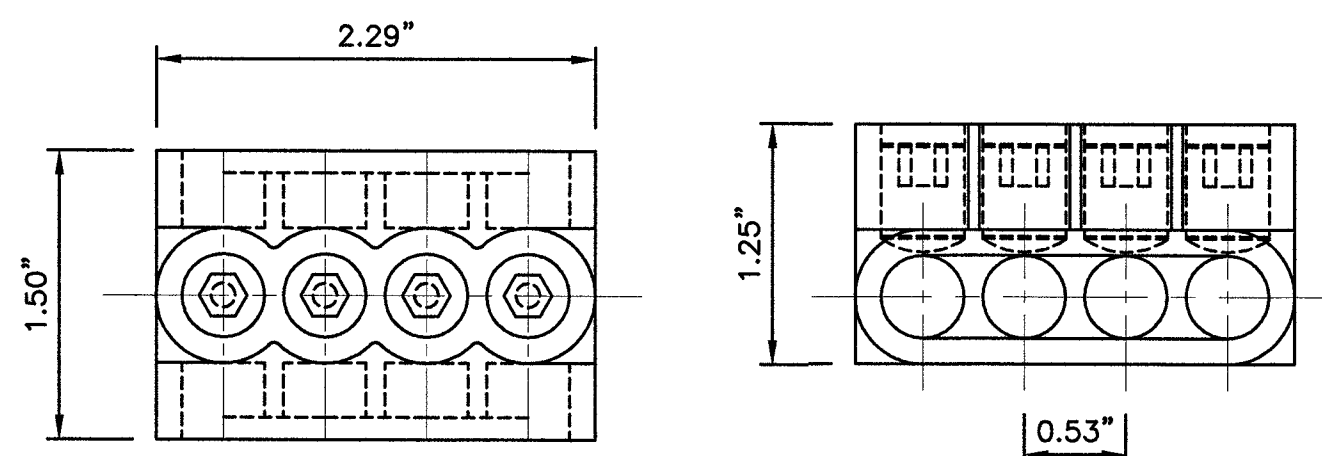

CONNECTOR DETAIL


NO SCALE

2

BUSSMAN HEB-AW-RLC-A

DIMENSIONS, LENGTH: 4.4"



WIRE RANGE: #8-16; (2) #12-16

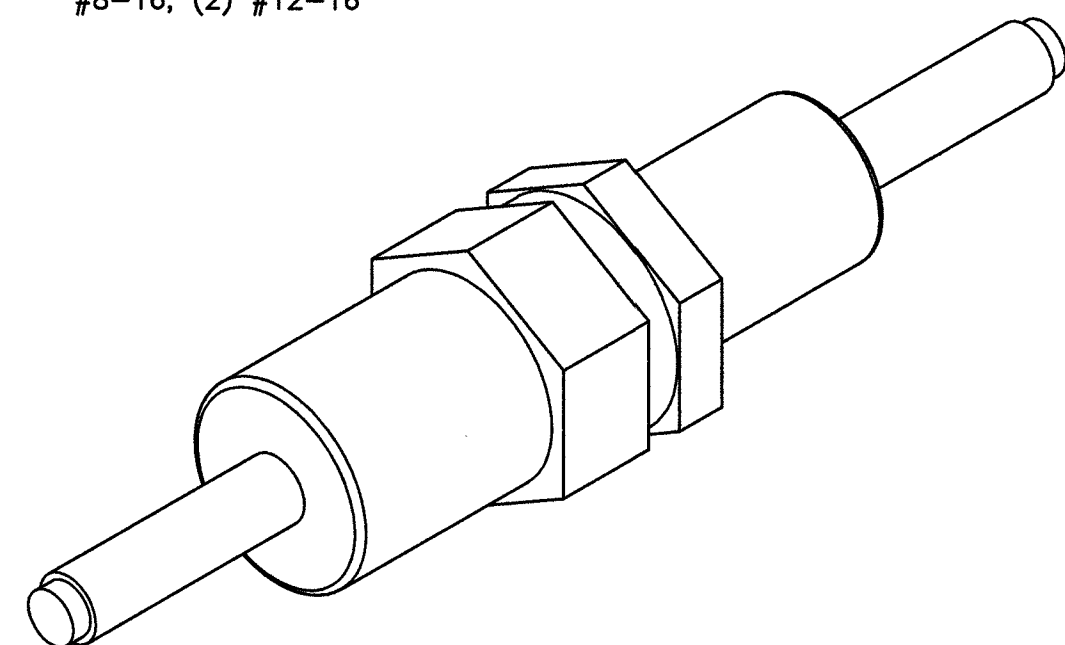

BREAKAWAY FUSE DETAIL

NO SCALE

3

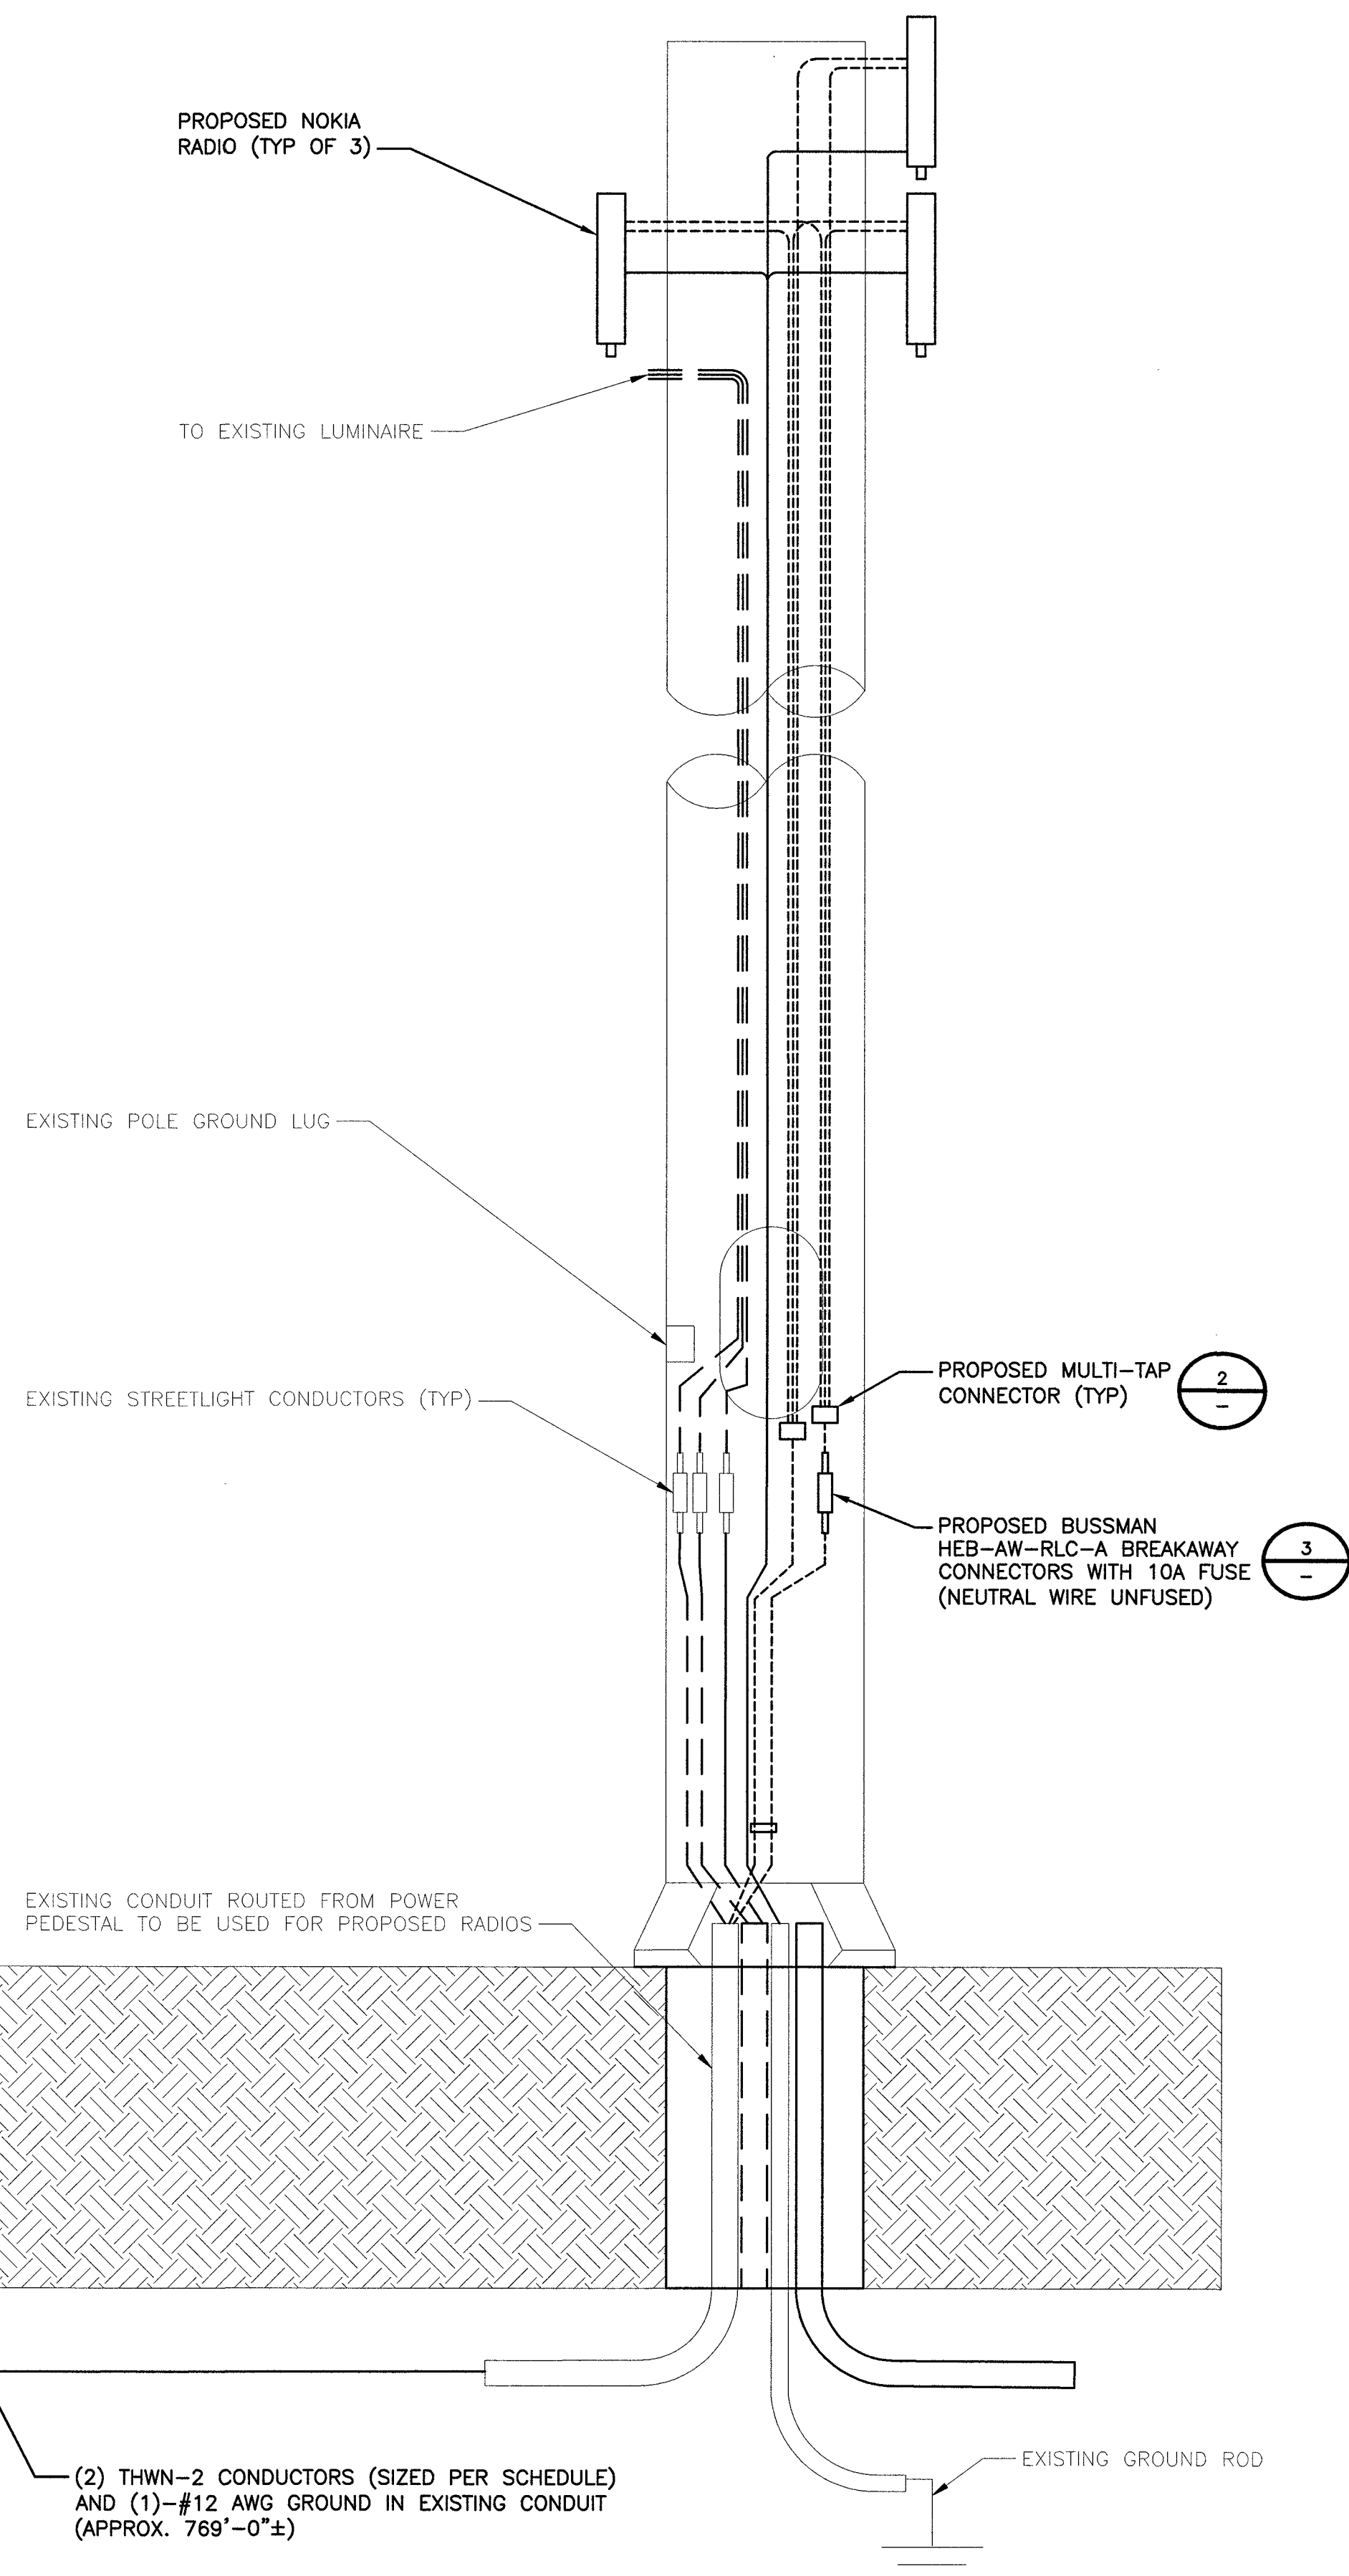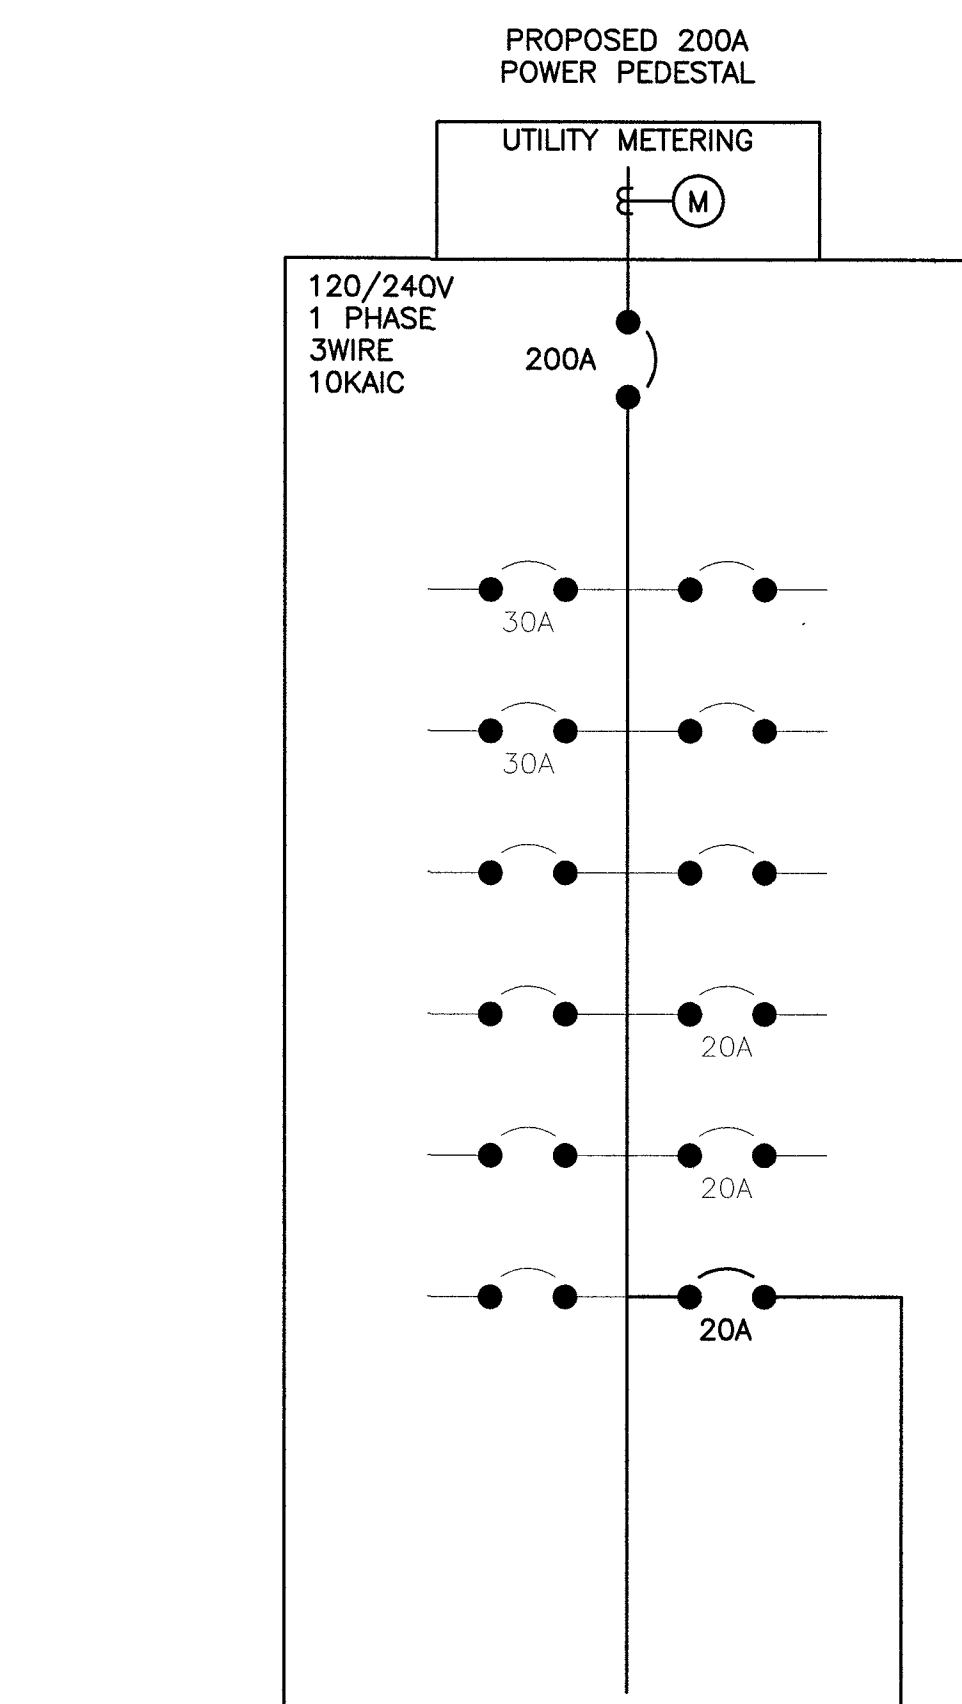

TYPICAL POLE SITE TEMPLATE

NO SCALE

4




BLACK & VEATCH CORPORATION
7760 FRANCE AVENUE SOUTH
SUITE 1200
BLOOMINGTON, MN 55435

THESE DRAWINGS ARE COPYRIGHTED AND
ARE THE PROPERTY OF BLACK & VEATCH;
PRODUCED SOLELY FOR THE USE OF OUR
CLIENT. ANY REPRODUCTION OR USE OF THE
INFORMATION CONTAINED WITHIN SAID
DRAWINGS IS PROHIBITED WITHOUT
WRITTEN CONSENT BY BLACK & VEATCH.

PROJECT NO.	DRAWN BY	CHECKED BY
199064.2047	TCG	LEW

REV	DATE	DESCRIPTION
1	02/13/19	CITY COMMENTS
0	12/05/18	ISSUED FOR CONSTRUCTION

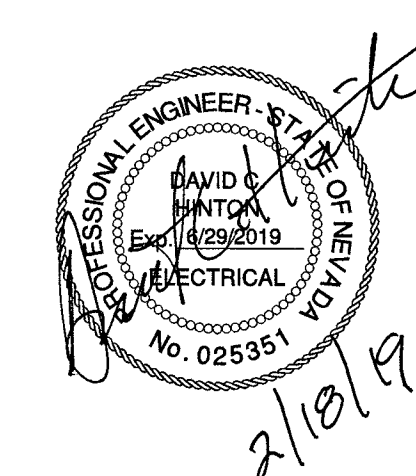

IT IS A VIOLATION OF LAW FOR ANY PERSON,
UNLESS THEY ARE ACTING UNDER THE DIRECTION
OF A LICENSED PROFESSIONAL ENGINEER,
TO ALTER THIS DOCUMENT.

SITE ADDRESS


33AT0100SMC
CRAN_NVLO8196F_R01
2507.25 VEGAS DR
LAS VEGAS, NV 89106
SMALL CELL

SHEET TITLE
ELECTRICAL DETAILS
AND DIAGRAMS


SHEET NUMBER

E-1

EXISTING LOAD.....	24.00	AMPS
ALLOWED LOAD 80%.....	48.00	AMPS

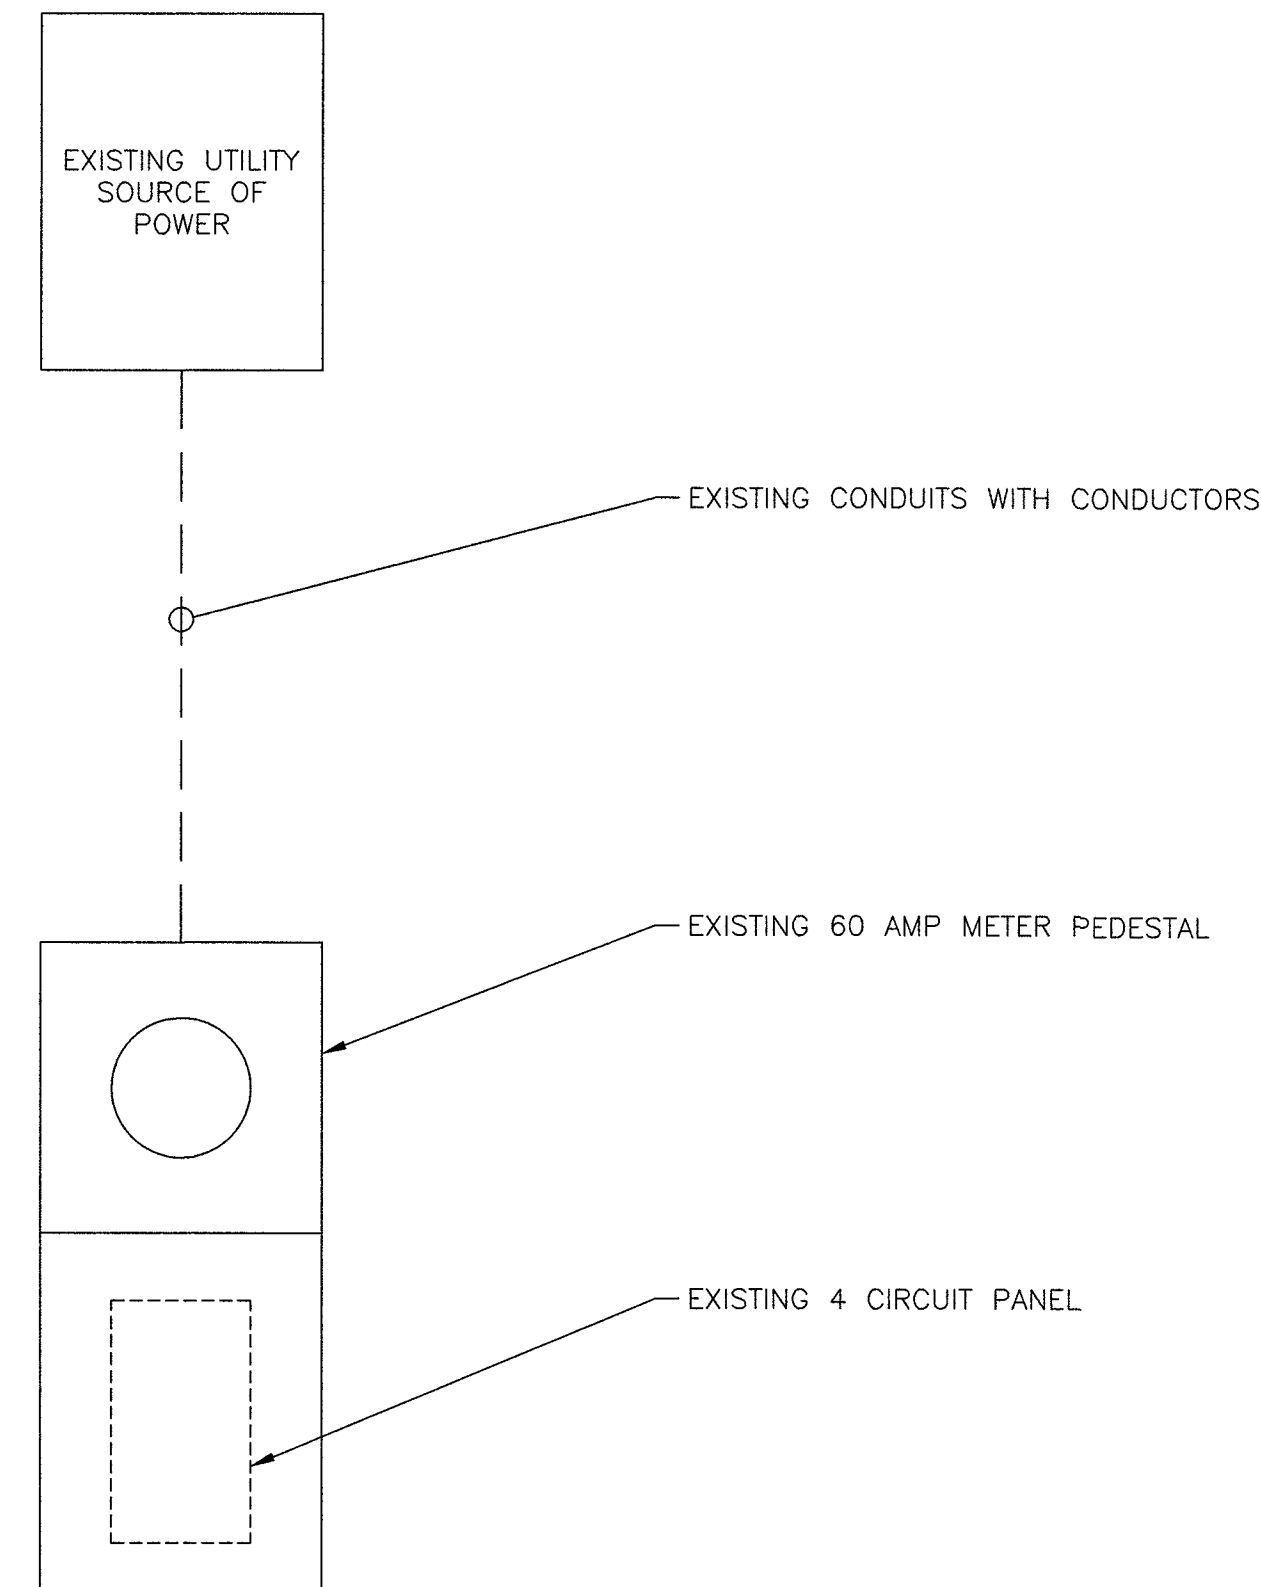

EXISTING LOAD.....	24.00 AMPS
SAFETY FACTOR 125%.....	30.00 AMPS
PROPOSED LOAD.....	2.34 AMPS
TOTAL LOAD.....	32.34 AMPS
ALLOWED LOAD 80% OF 200 AMPS.....	160 AMPS

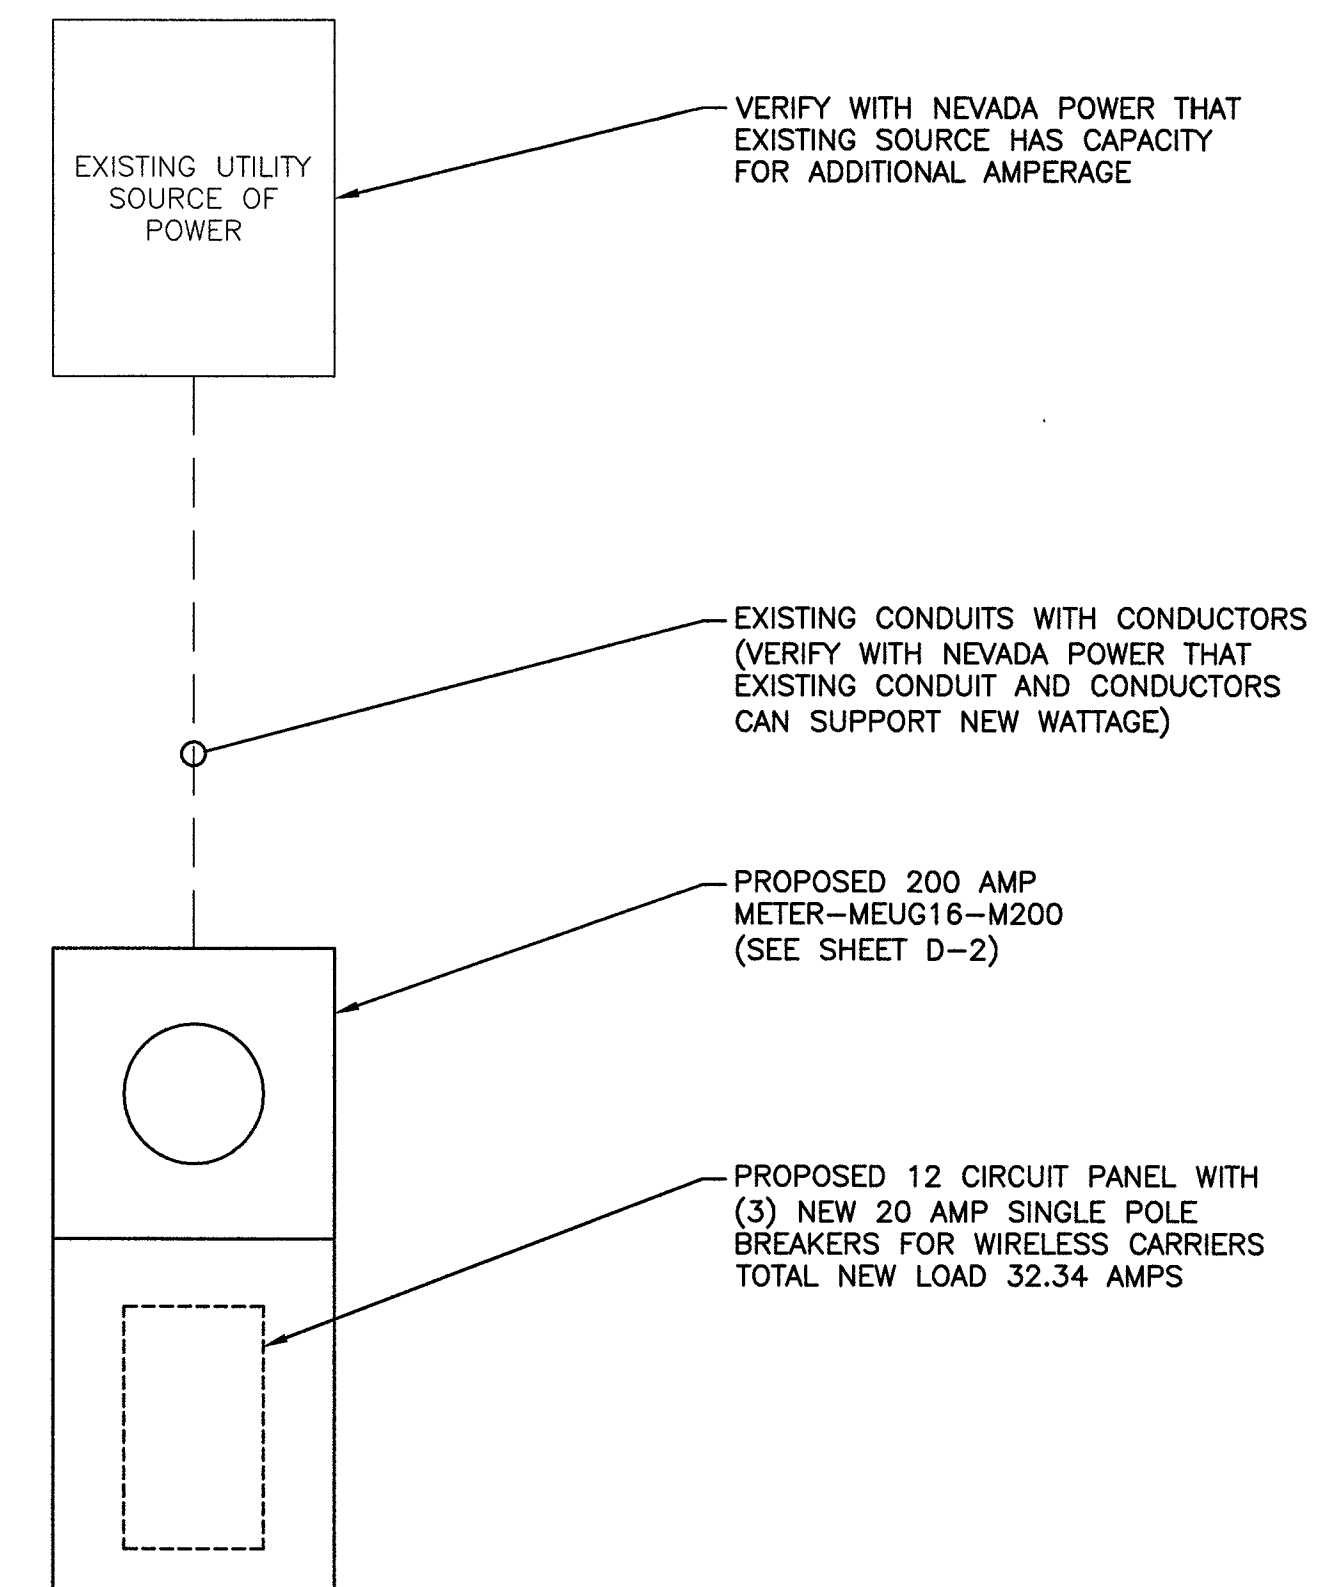


BLACK & VEATCH

BLACK & VEATCH CORPORATION
7760 FRANCE AVENUE SOUTH
SUITE 1200
BLOOMINGTON, MN 55435

THESE DRAWINGS ARE COPYRIGHTED AND ARE THE PROPERTY OF BLACK & VEATCH; PRODUCED SOLELY FOR THE USE OF OUR CLIENT. ANY REPRODUCTION OR USE OF THE INFORMATION CONTAINED WITHIN SAID DRAWINGS IS PROHIBITED WITHOUT WRITTEN CONSENT BY BLACK & VEATCH.

PROJECT NO.	DRAWN BY	CHECKED BY
199064.2047	TCG	LEW

1	02/13/19	CITY COMMENTS
0	12/05/18	ISSUED FOR CONSTRUCTION
REV	DATE	DESCRIPTION

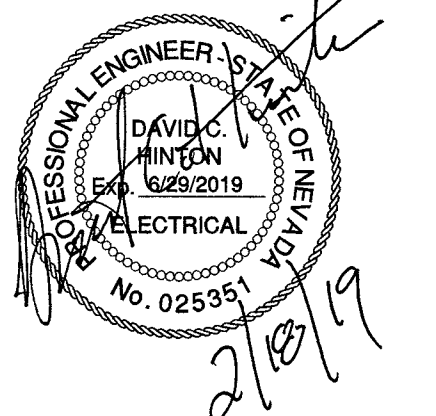

IT IS A VIOLATION OF LAW FOR ANY PERSON,
UNLESS THEY ARE ACTING UNDER THE DIRECTION
OF A LICENSED PROFESSIONAL ENGINEER,
TO ALTER THIS DOCUMENT.

SITE ADDRESS

33AT0100SMC
CRAN_NVLO8196F_R01
2507.25 VEGAS DR
LAS VEGAS, NV 89106
SMALL CELL

SHEET TITLE

**ELECTRICAL SINGLE
LINE DIAGRAMS**


SHEET NUMBER

E-2

EXISTING SINGLE LINE DIAGRAM							NO SCALE		1		PROPOSED SINGLE LINE DIAGRAM										NO SCALE		2	
Site Name:		250 VEGAS DR					MODEL NUMBER:		MYERS MEUG16-M200															
SITE NUMBER:		33AT0100SMC			Volts AC				PHASE:		1		WIRE:		3									
VOLTAGE:		240 /120						BUSS RATING:		200		AMPS												
MAIN BREAKER:		200 AMPS																						
MOUNT:		SURFACE																						
ENCLOSURE TYPE:		NEMA 3R																						
PANEL STATUS:		PROPOSED																						
CKT	LOAD DESCRIPTION	BREAKER AMPS	BREAKER POLES	BREAKER STATUS	SERVICE LOAD VA	Demand Factor	USAGE FACTOR	PHASE A VA	PHASE B VA	USAGE FACTOR	Demand Factor	SERVICE LOAD VA	BREAKER STATUS	BREAKER POLES	BREAKER AMPS	LOAD DESCRIPTION	CKT							
1	LIGHTS	30	2	ON	2880	1.00	1.25	3600									2							
3					2880	1.00	1.25		3600									4						
5								0									6							
7									0	1.00	1.00	0	OFF	1	20	TELECOM (FUTURE)	8							
9								0		1.00	1.00	0	OFF	1	20	TELECOM (FUTURE)	10							
11									563	1.25	1.00	450	NEW	1	20	PROPOSED COX SMALL CELL	12							
								PHASE A	PHASE B															
								3600	4163 VA															
								TOTAL	KVA	7.76														
									AMPS	32.34	≤ 80% OF MAIN BREAKER													
PROPOSED PANEL SCHEDULE AND CALCS																		NO SCALE		3				

NOTES

1. FOR CONDUIT SIZE AND WIRING REQUIREMENTS FOR STREETLIGHT SERVICE, SEE STANDARD DRAWING NO. 332.S2 FOR LAS VEGAS AND CLARK COUNTY ONLY AND 332.S1 FOR ALL OTHER ENTITIES.
2. SEE STANDARD DRAWING NO. 321, 332.S1, OR 332.S2.

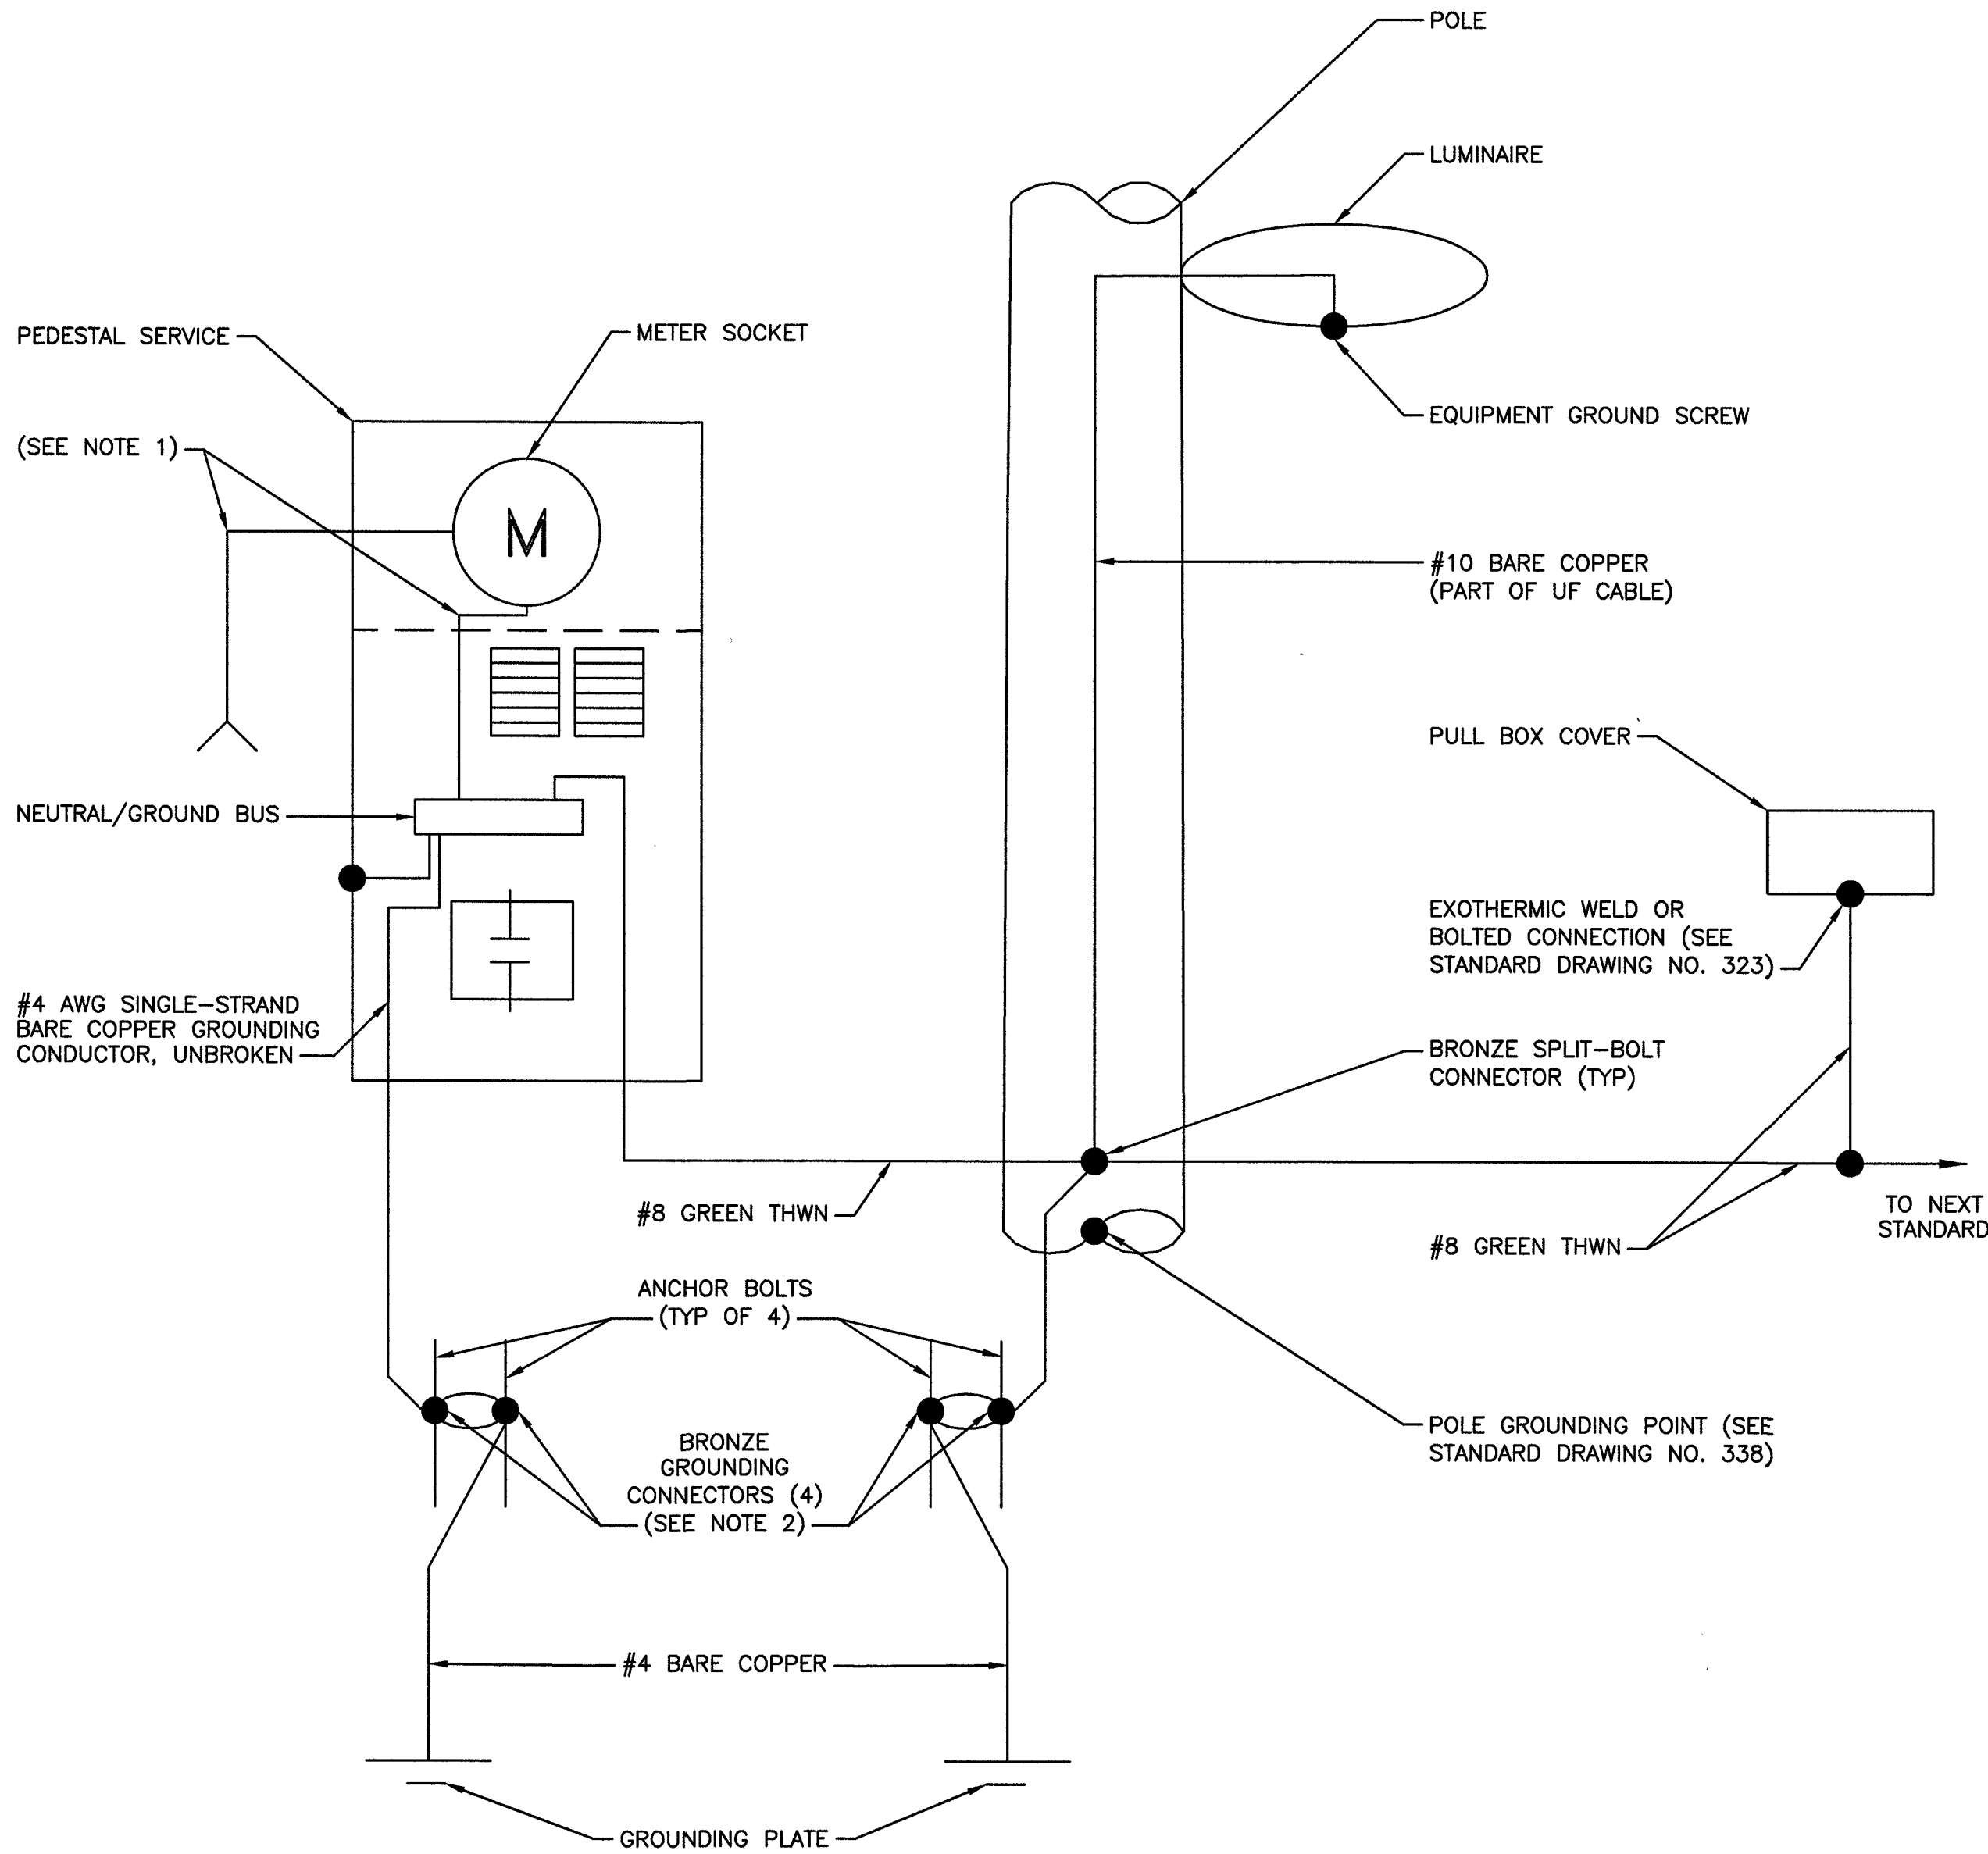


METER PEDESTAL GROUNDING DIAGRAM

NO SCALE

1

NOTES

1. 125 AMP SERVICE: 1 #4 WHITE THW
200 AMP SERVICE: 1 #1/0 WHITE THW

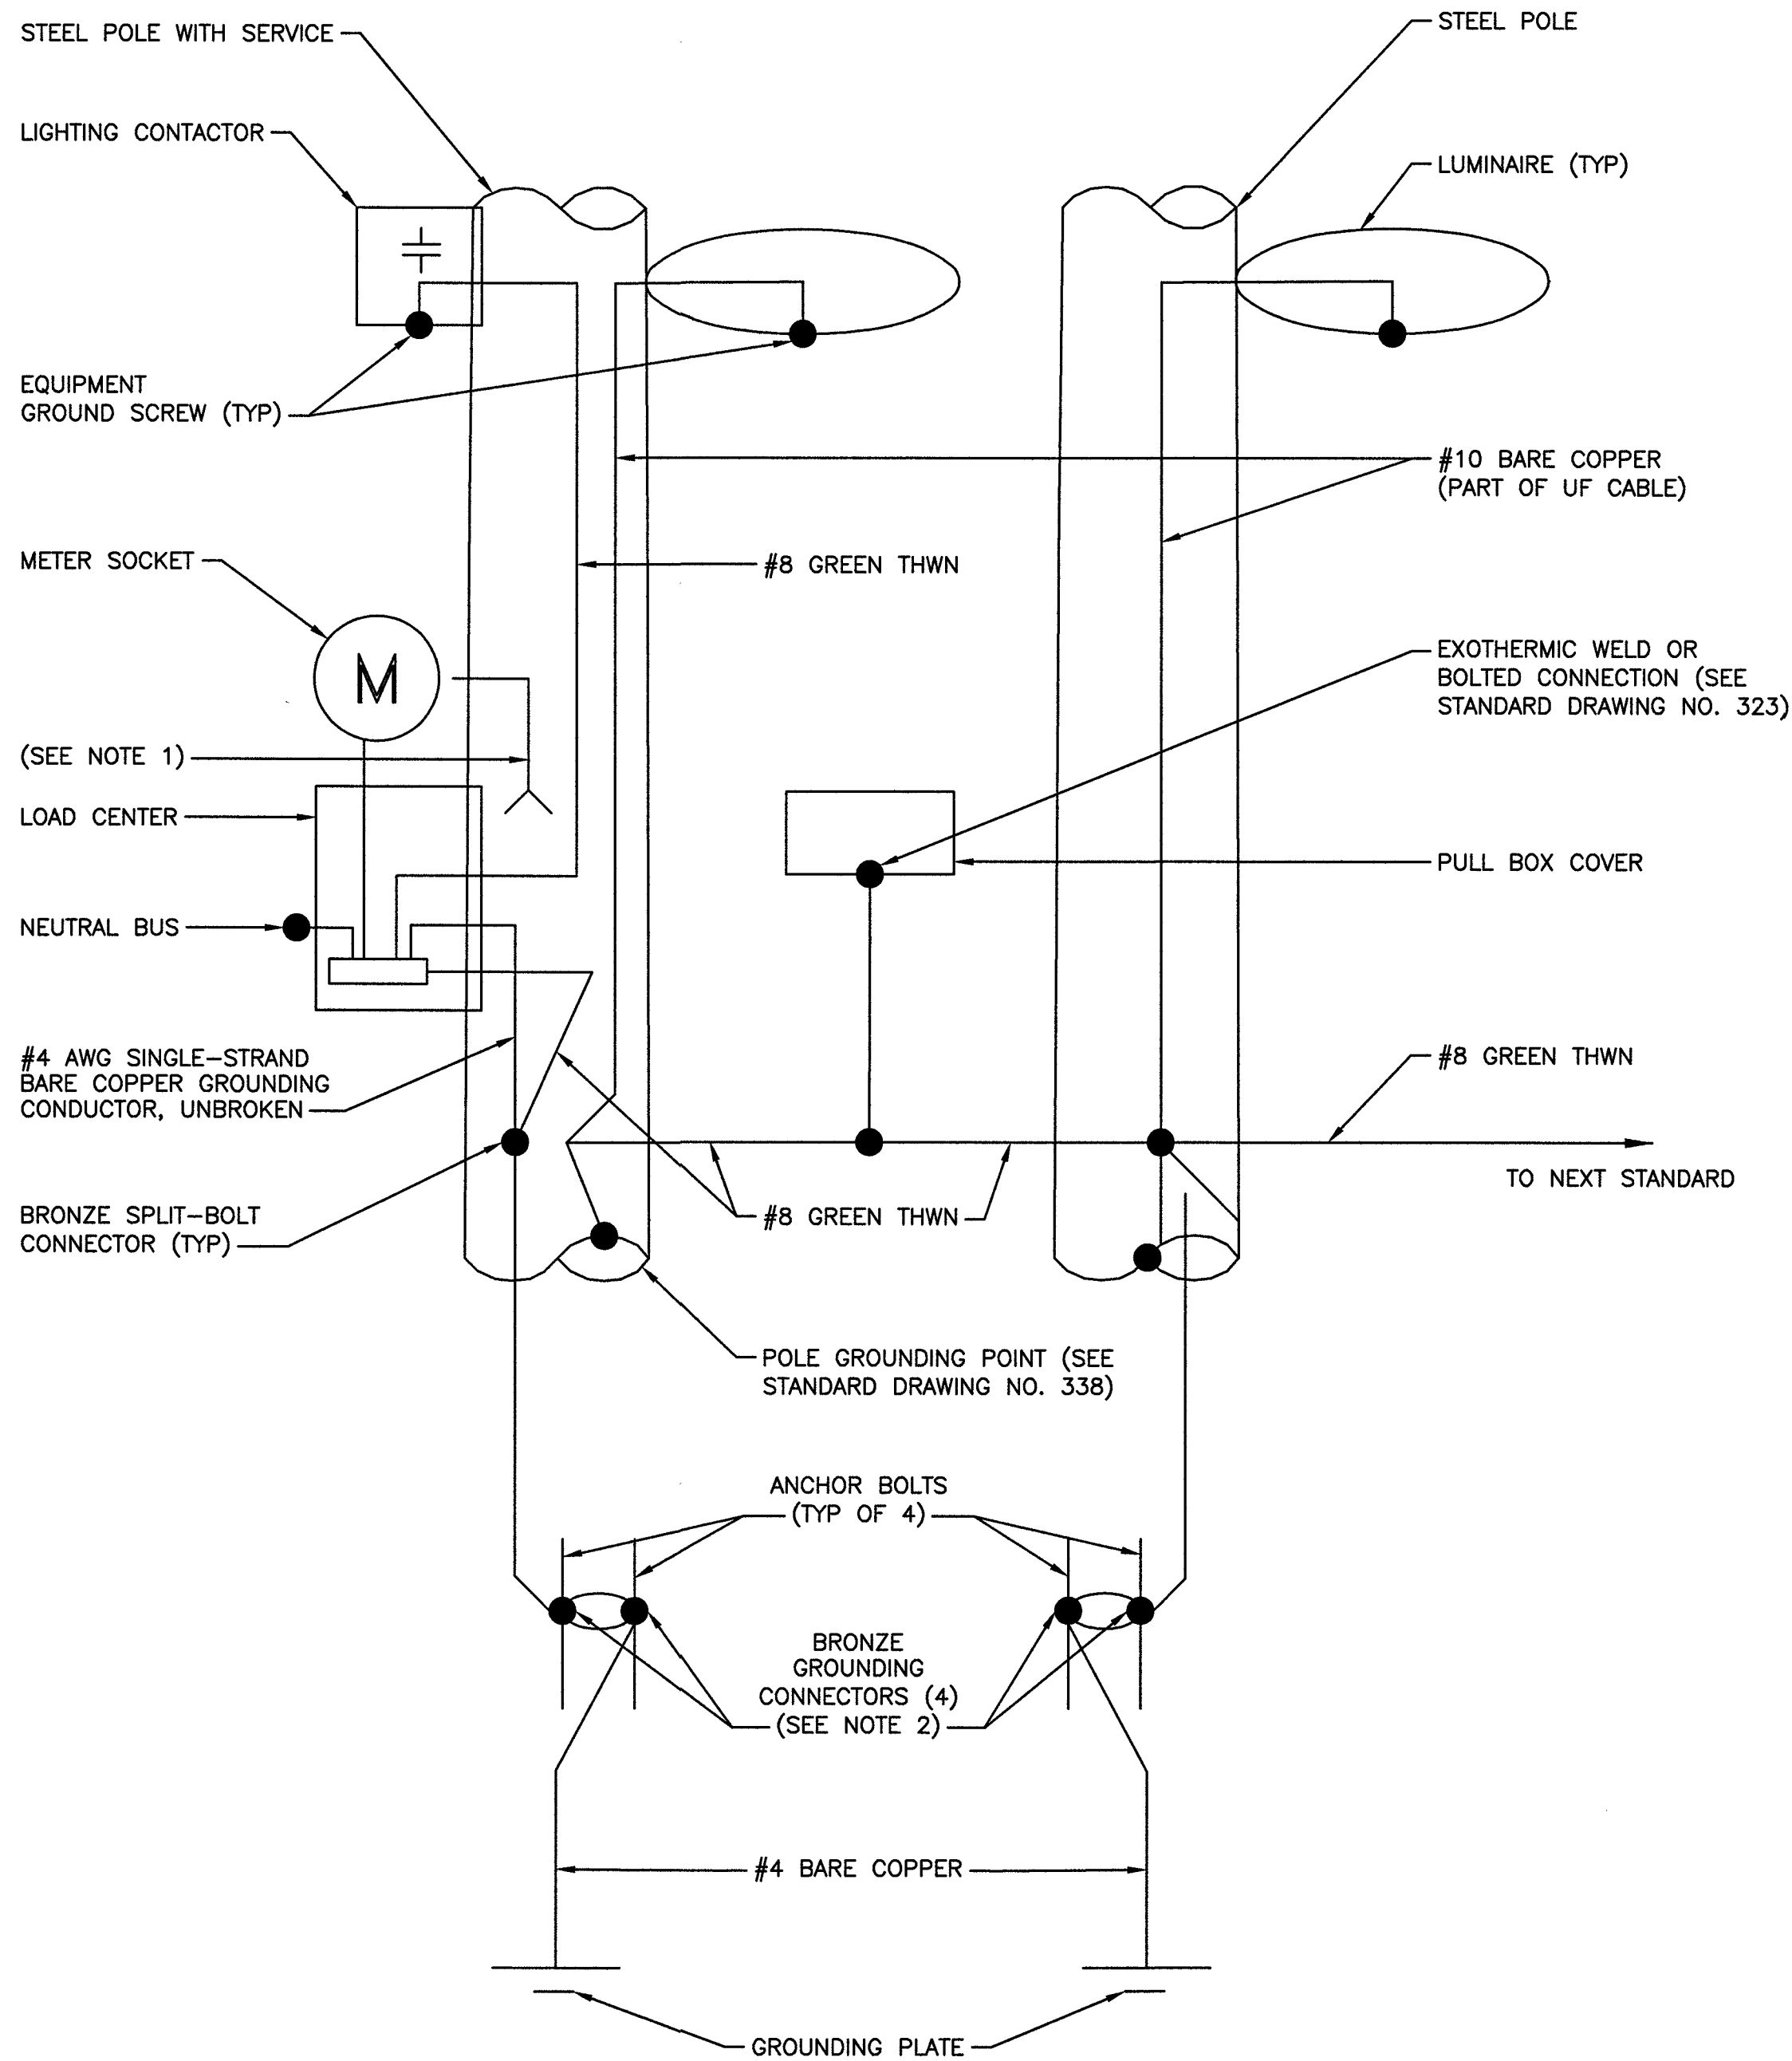

POLE EQUIPMENT GROUNDING DIAGRAM

NO SCALE

2




BLACK & VEATCH

BLACK & VEATCH CORPORATION
7760 FRANCE AVENUE SOUTH
SUITE 1200
BLOOMINGTON, MN 55435

THESE DRAWINGS ARE COPYRIGHTED AND
ARE THE PROPERTY OF BLACK & VEATCH;
PRODUCED SOLELY FOR THE USE OF OUR
CLIENT. ANY REPRODUCTION OR USE OF THE
INFORMATION CONTAINED WITHIN SAID
DRAWINGS IS PROHIBITED WITHOUT
WRITTEN CONSENT BY BLACK & VEATCH.

PROJECT NO.	DRAWN BY	CHECKED BY
199064.2047	TCG	LEW

REV	DATE	DESCRIPTION
1	02/13/19	CITY COMMENTS
0	12/05/18	ISSUED FOR CONSTRUCTION

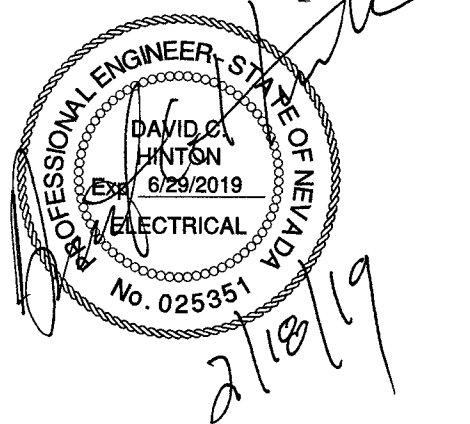

IT IS A VIOLATION OF LAW FOR ANY PERSON,
UNLESS THEY ARE ACTING UNDER THE DIRECTION
OF A LICENSED PROFESSIONAL ENGINEER,
TO ALTER THIS DOCUMENT.

SITE ADDRESS

33AT0100SMC
CRAN_NVLO8196F_R01
2507.25 VEGAS DR
LAS VEGAS, NV 89106
SMALL CELL



SHEET TITLE

GROUNDING DIAGRAMS

SHEET NUMBER

G-1

SMALL CELL SITE SURVEY
SITE: 33AT0100SMC
NW¼NE¼, SECTION 29, TOWNSHIP 20 SOUTH, RANGE 61 EAST

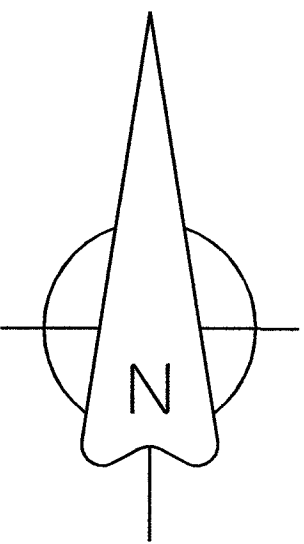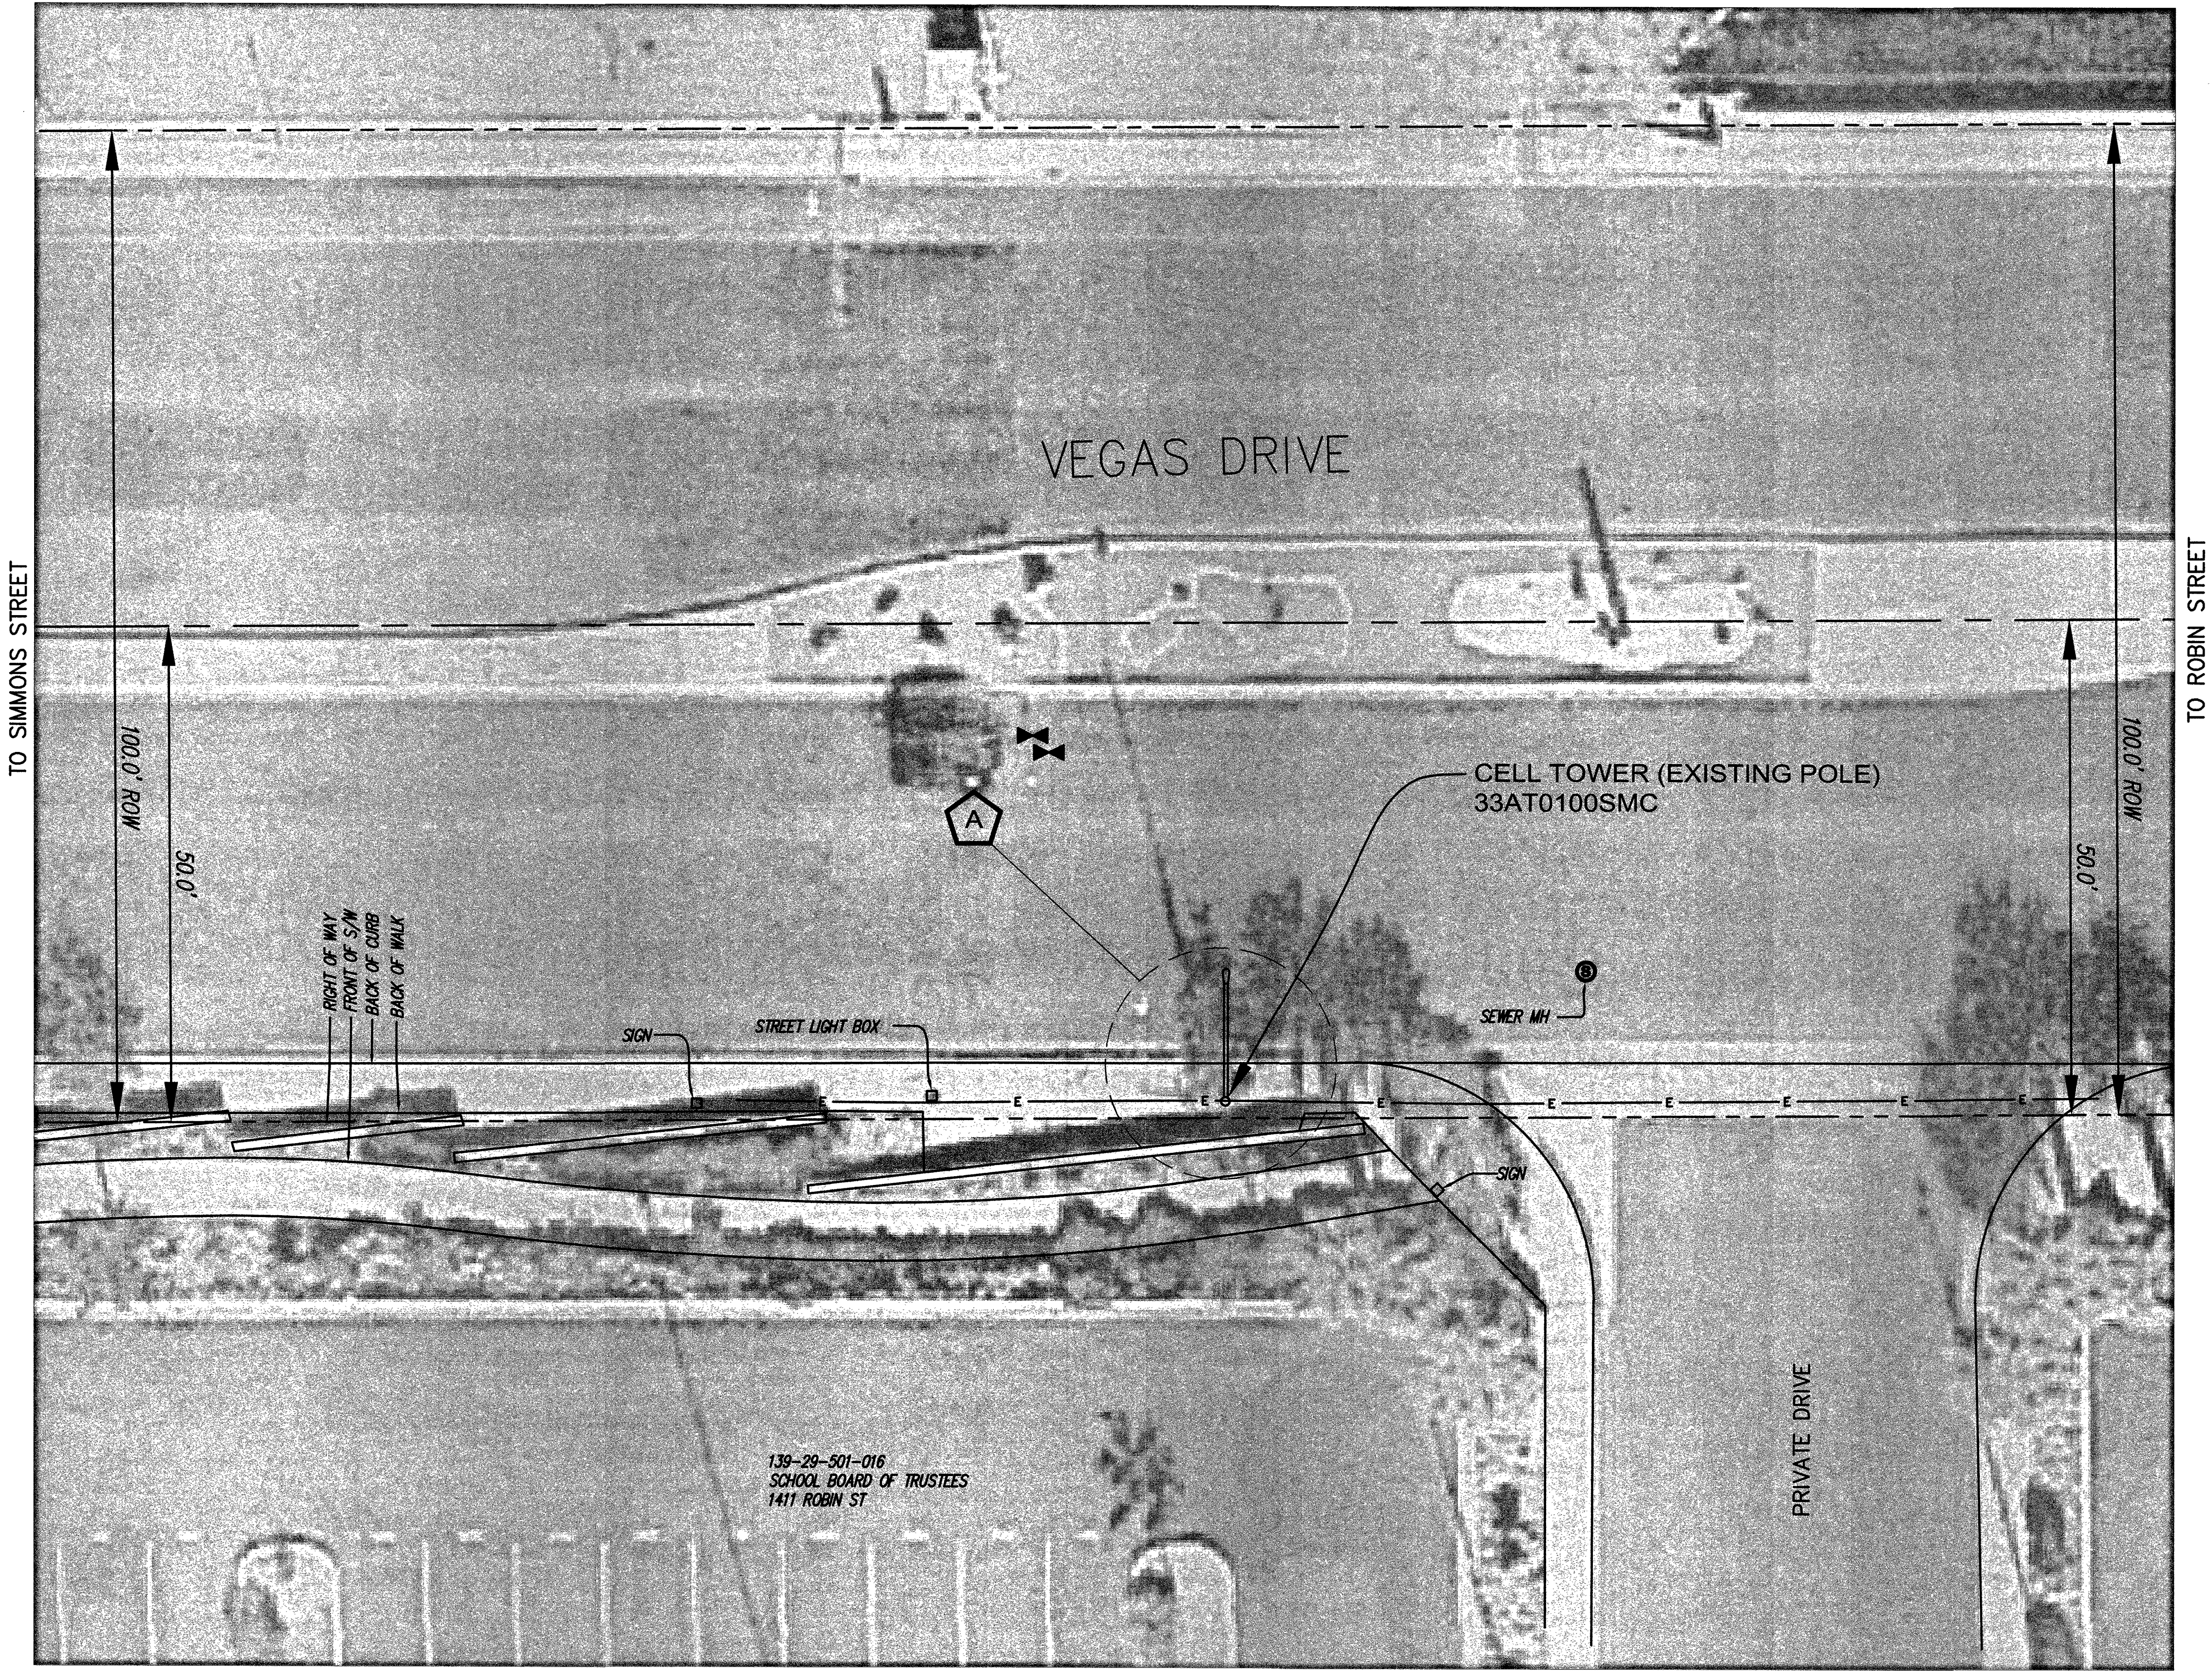

GRAPHIC SCALE

20 0 10 20




FEET

A LATITUDE: 36°11'18.08"N
LONGITUDE: 115°10'33.21"W
GROUND ELEVATION: 2089.89'
NAVD '88

Legend

- MONUMENT
- POLE
- DOWN GUY
- GAS VALVE
- PEDASTAL
- LAMP POST
- WATER VALVE
- FIRE HYDRANT
- WATER MANHOLE
- WATER METER
- SEWER MANHOLE
- UNKNOWN OR LABELED MANHOLE
- SANITARY SEWER MANHOLE
- STORM WATER MANHOLE
- ELECTRIC MANHOLE
- TELECOM MANHOLE
- TREE

- FENCELINE
- ROW LINE
- CENTER LINE
- SEWER
- TELEPHONE
- WATER
- ELECTRIC
- GAS LINE
- OVERHEAD ELEC
- FENCE BARB
- PROPERTY LINE

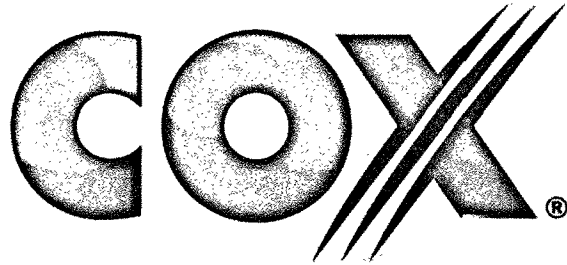

6205-B Peachtree Dunwoody Road NE
Atlanta, GA 30328

ENGINEERS:



BLACK & VEATCH

6 SUNSET WAY
SUITE B108
HENDERSON, NV 89014

SITE NO: 33AT0100SMC

DRAWN BY: KJC

CHECKED BY: CIS

REV	DATE	DESCRIPTION
A	10/30/18	PRELIMINARY SUBMITTAL

SURVEYOR:



CIS JOB NO:
CIS 315-2-4-6

SHEET TITLE
**SMALL CELL
SITE SURVEY**

SHEET NUMBER
1 OF 1



CITY OF LAS VEGAS

TRAFFIC ENGINEERING
FIELD OPERATIONS
3001 RONEMUS DRIVE
LAS VEGAS, NV 89128
PHONE: (702) 229-6331

SMALL CELL SITE SURVEY

- THIS FORM IDENTIFIES THE POTENTIAL POWER SUPPLY SOURCE FOR A PROPOSED SMALL CELL SITE
- THIS ONLY REPRESENTS THE CONDITIONS AT TIME OF SITE SURVEY
- FIELD CONDITIONS MAY CHANGE FROM THE TIME OF THE SITE SURVEY UNTIL THE START OF CONSTRUCTION

CONTRACTOR'S NAME: Cox WIRELESS USE AGREEMENT _____
WIRELESS SERVICE PROVIDER: _____ CONTACT NAME: _____
OFFICE: _____ MOBILE: _____ FAX: _____
POLE LOCATION & ID: 2507 Vegas Dr. SL# 25352
CIRCLE ONE : NEW POLE / EXISTING POLE

PROPOSED SERVICE INFORMATION

Service Location	1511 Exodus Ct.		ID# 402400	
Existing Meter #	CC029952236			
Existing Service Size	<u>60 Amp</u>	100 Amp	125 Amp	200 Amp
Street Light Circuit				
Service Type	Pedestal		<u>Pole Mount</u>	
Current Application	Traffic Signal	<u>St. Lighting</u>	Both	
Existing Load			Amps	
Field Tested By:	B. Bradway		Date:	10/10/18
Notes: Not suitable for use for small cell site without upgrade.				

CLV REPRESENTATIVE

- TO BE COMPLETED BY TEFO STAFF






CLV FIELD REVIEWER'S NAME: B. Bradway FIELD REVIEW DATE: 10/10/2018
SENIOR/SUPERVISOR REVIEW SIGNATURE: [Signature] DATE REVIEWED BY SENIOR TECH: _____

BACKUP DOCUMENTATION

- DRAWINGS, PHOTOS, ETC

FILE NAME: _____ CREATION DATE: _____
FILE NAME: _____ CREATION DATE: _____
FILE NAME: _____ CREATION DATE: _____
Service Size _____ CREATION DATE: _____

NV POWER SERVICE ADDRESS LOAD BAY DOCUMENTATION FOR SPACE UTILIZATION

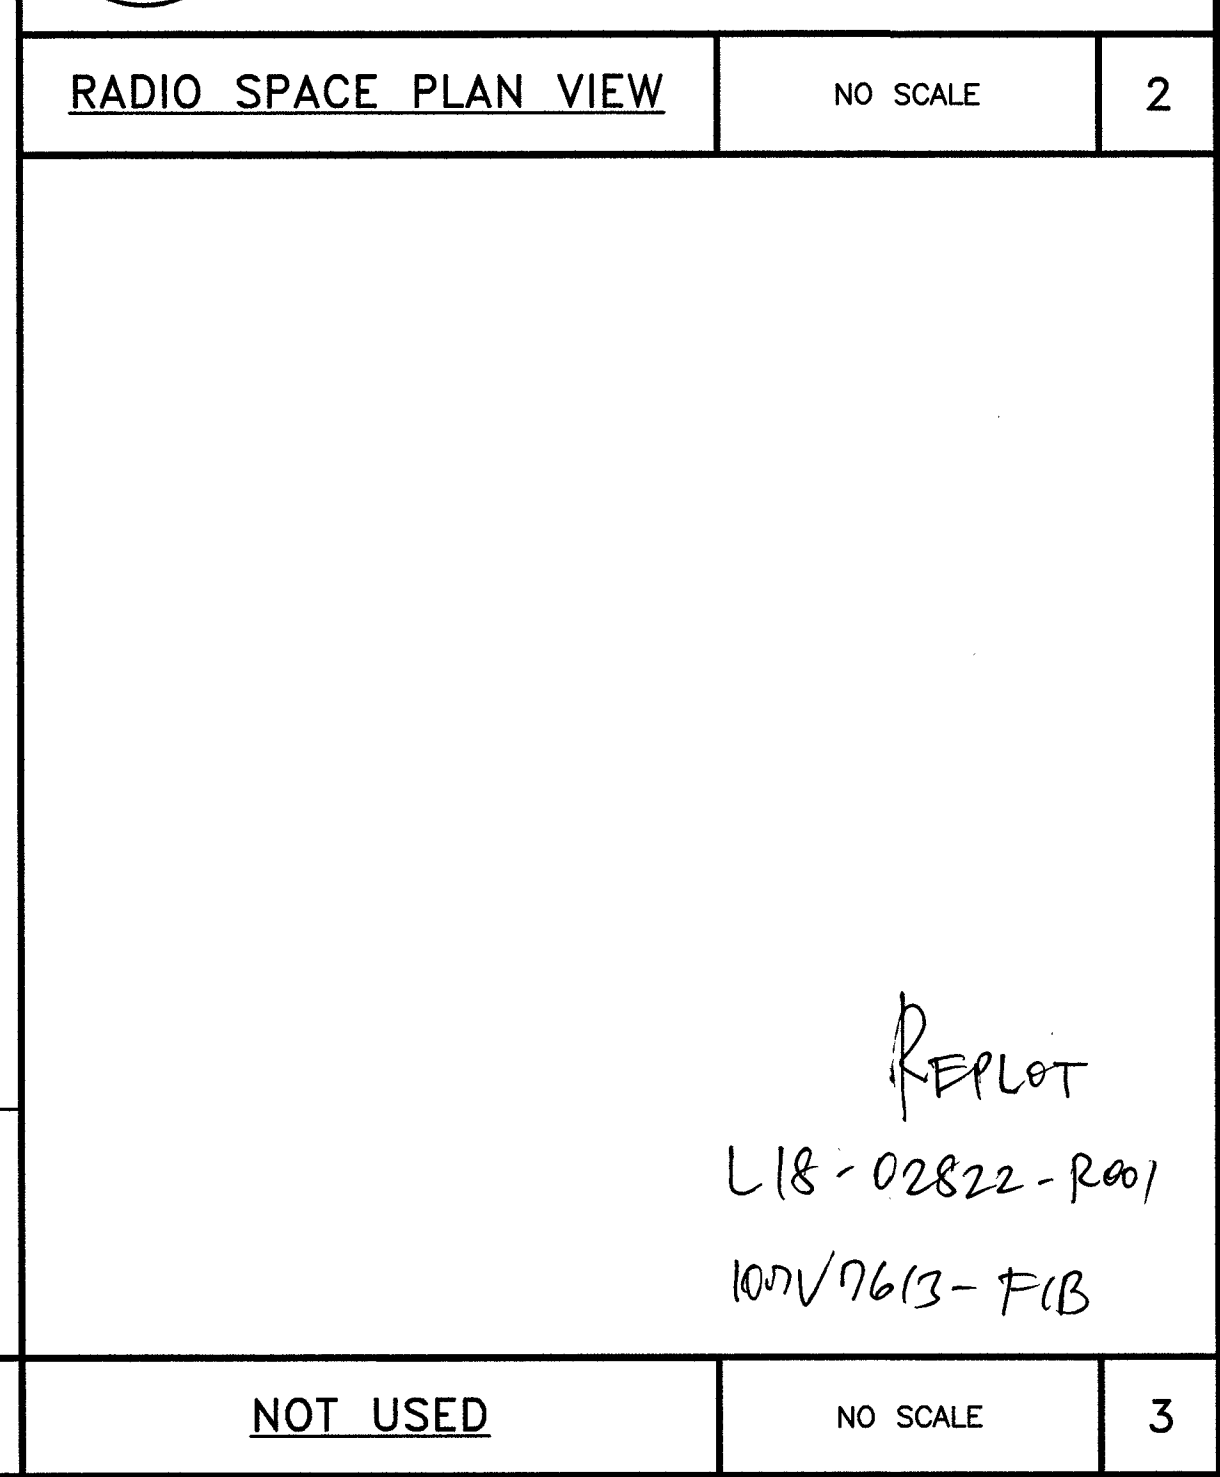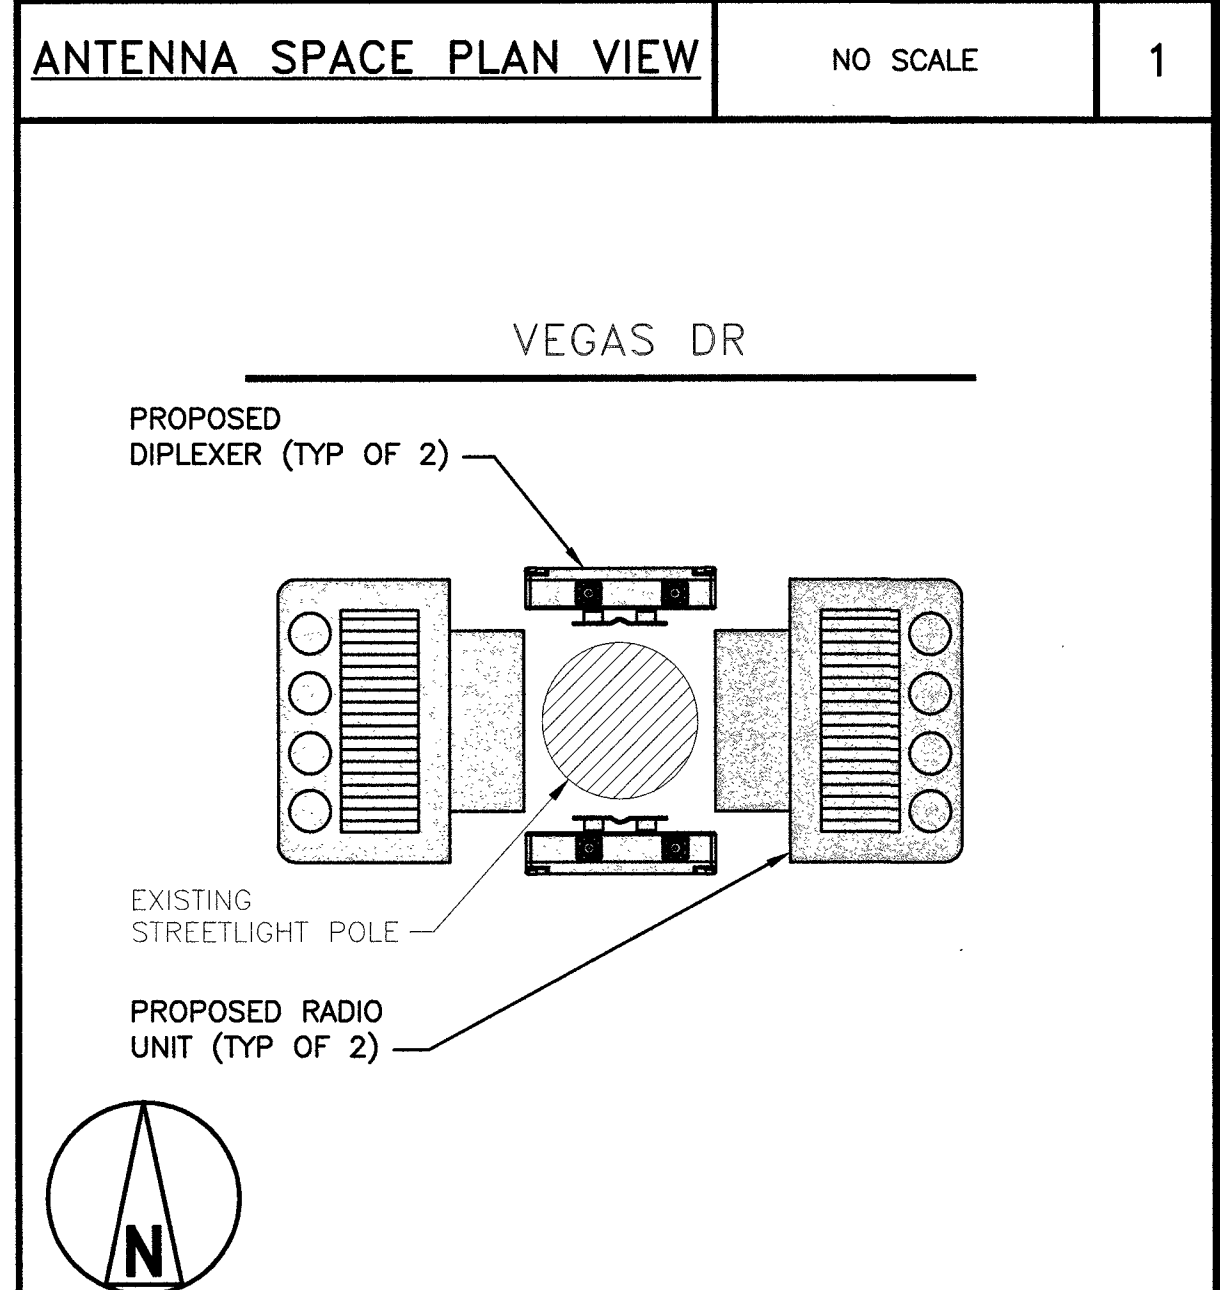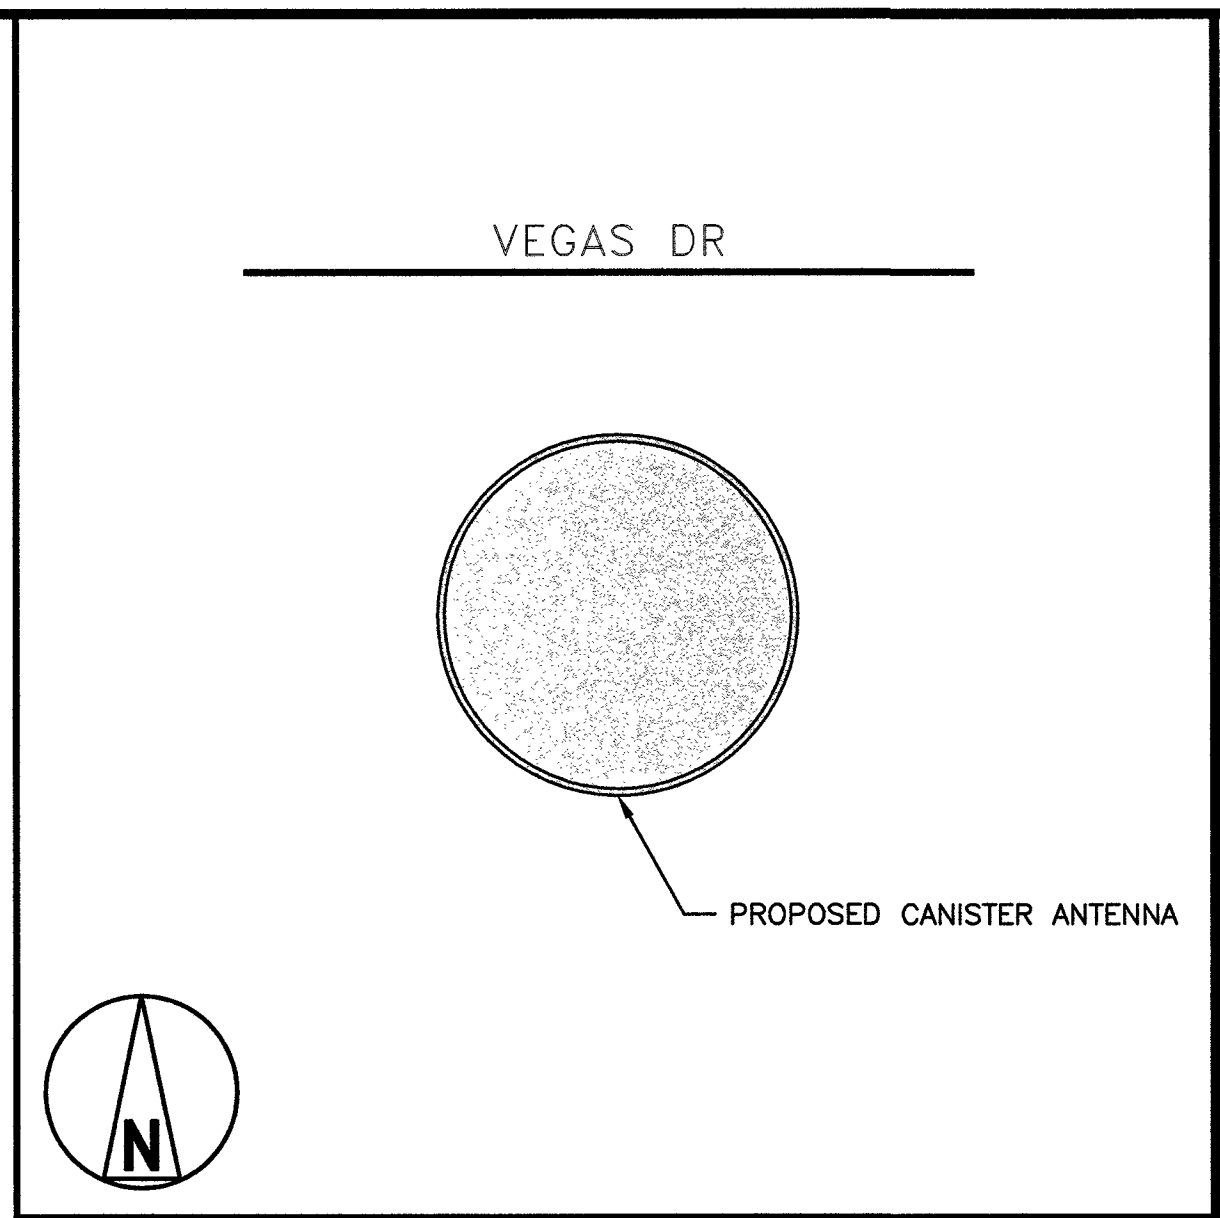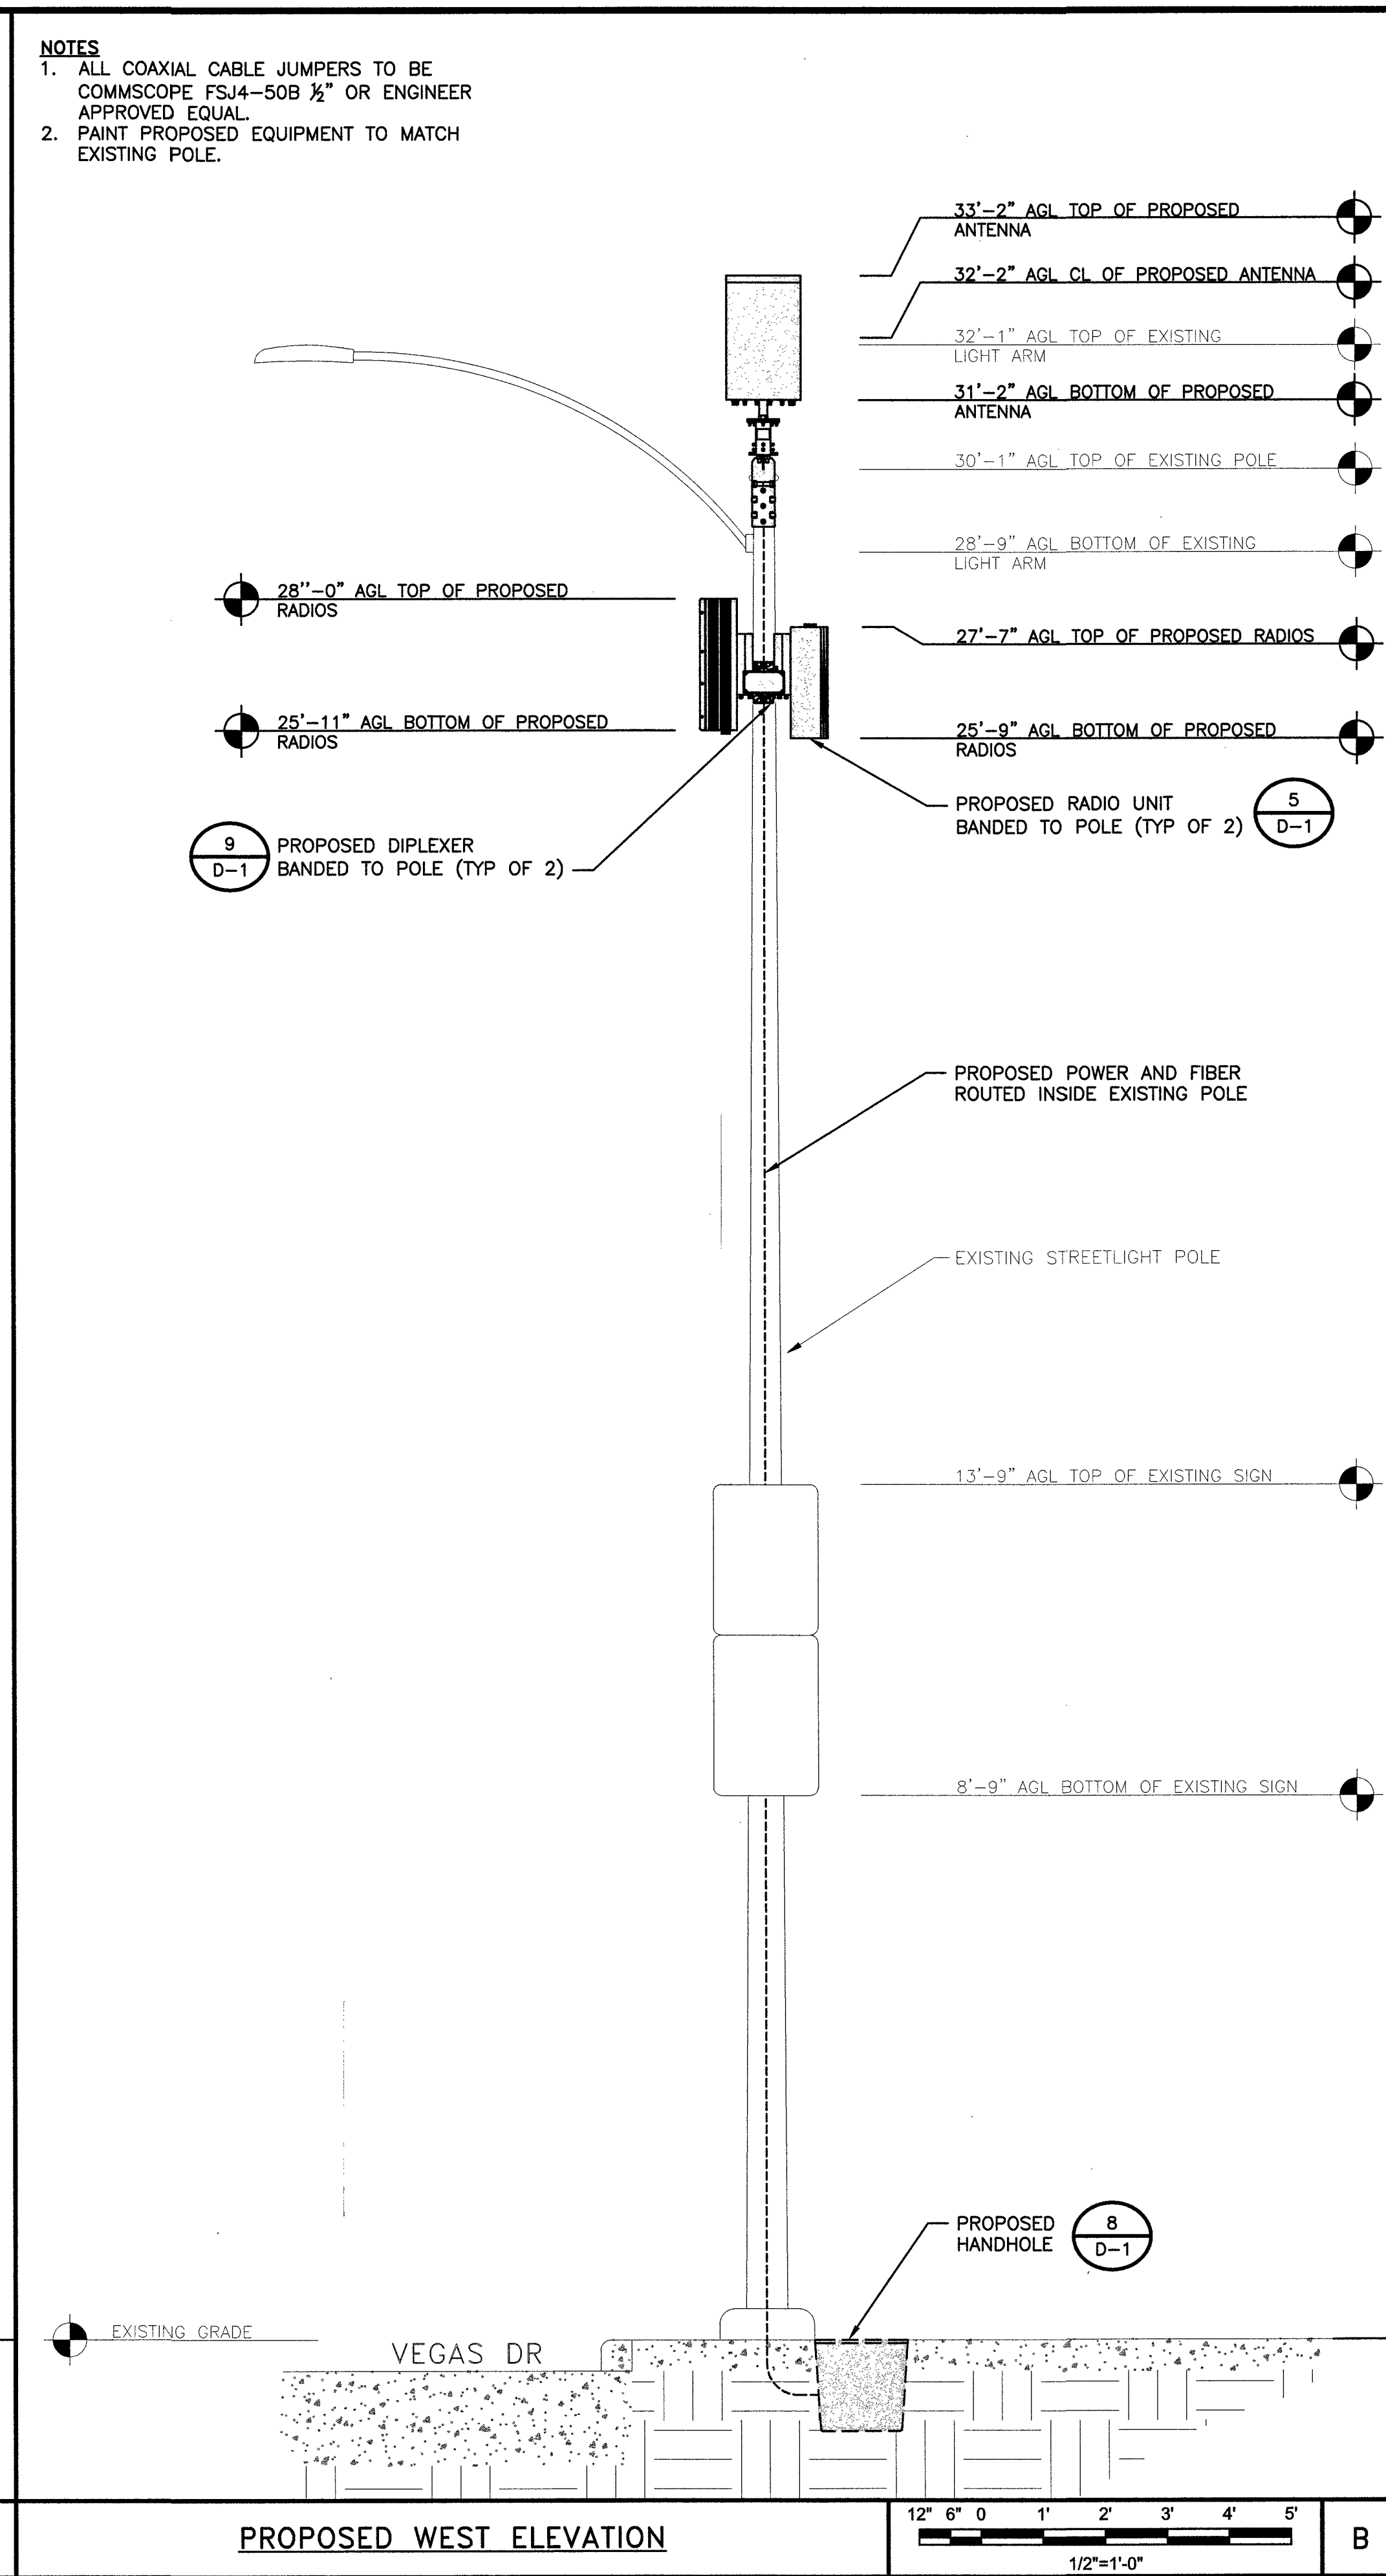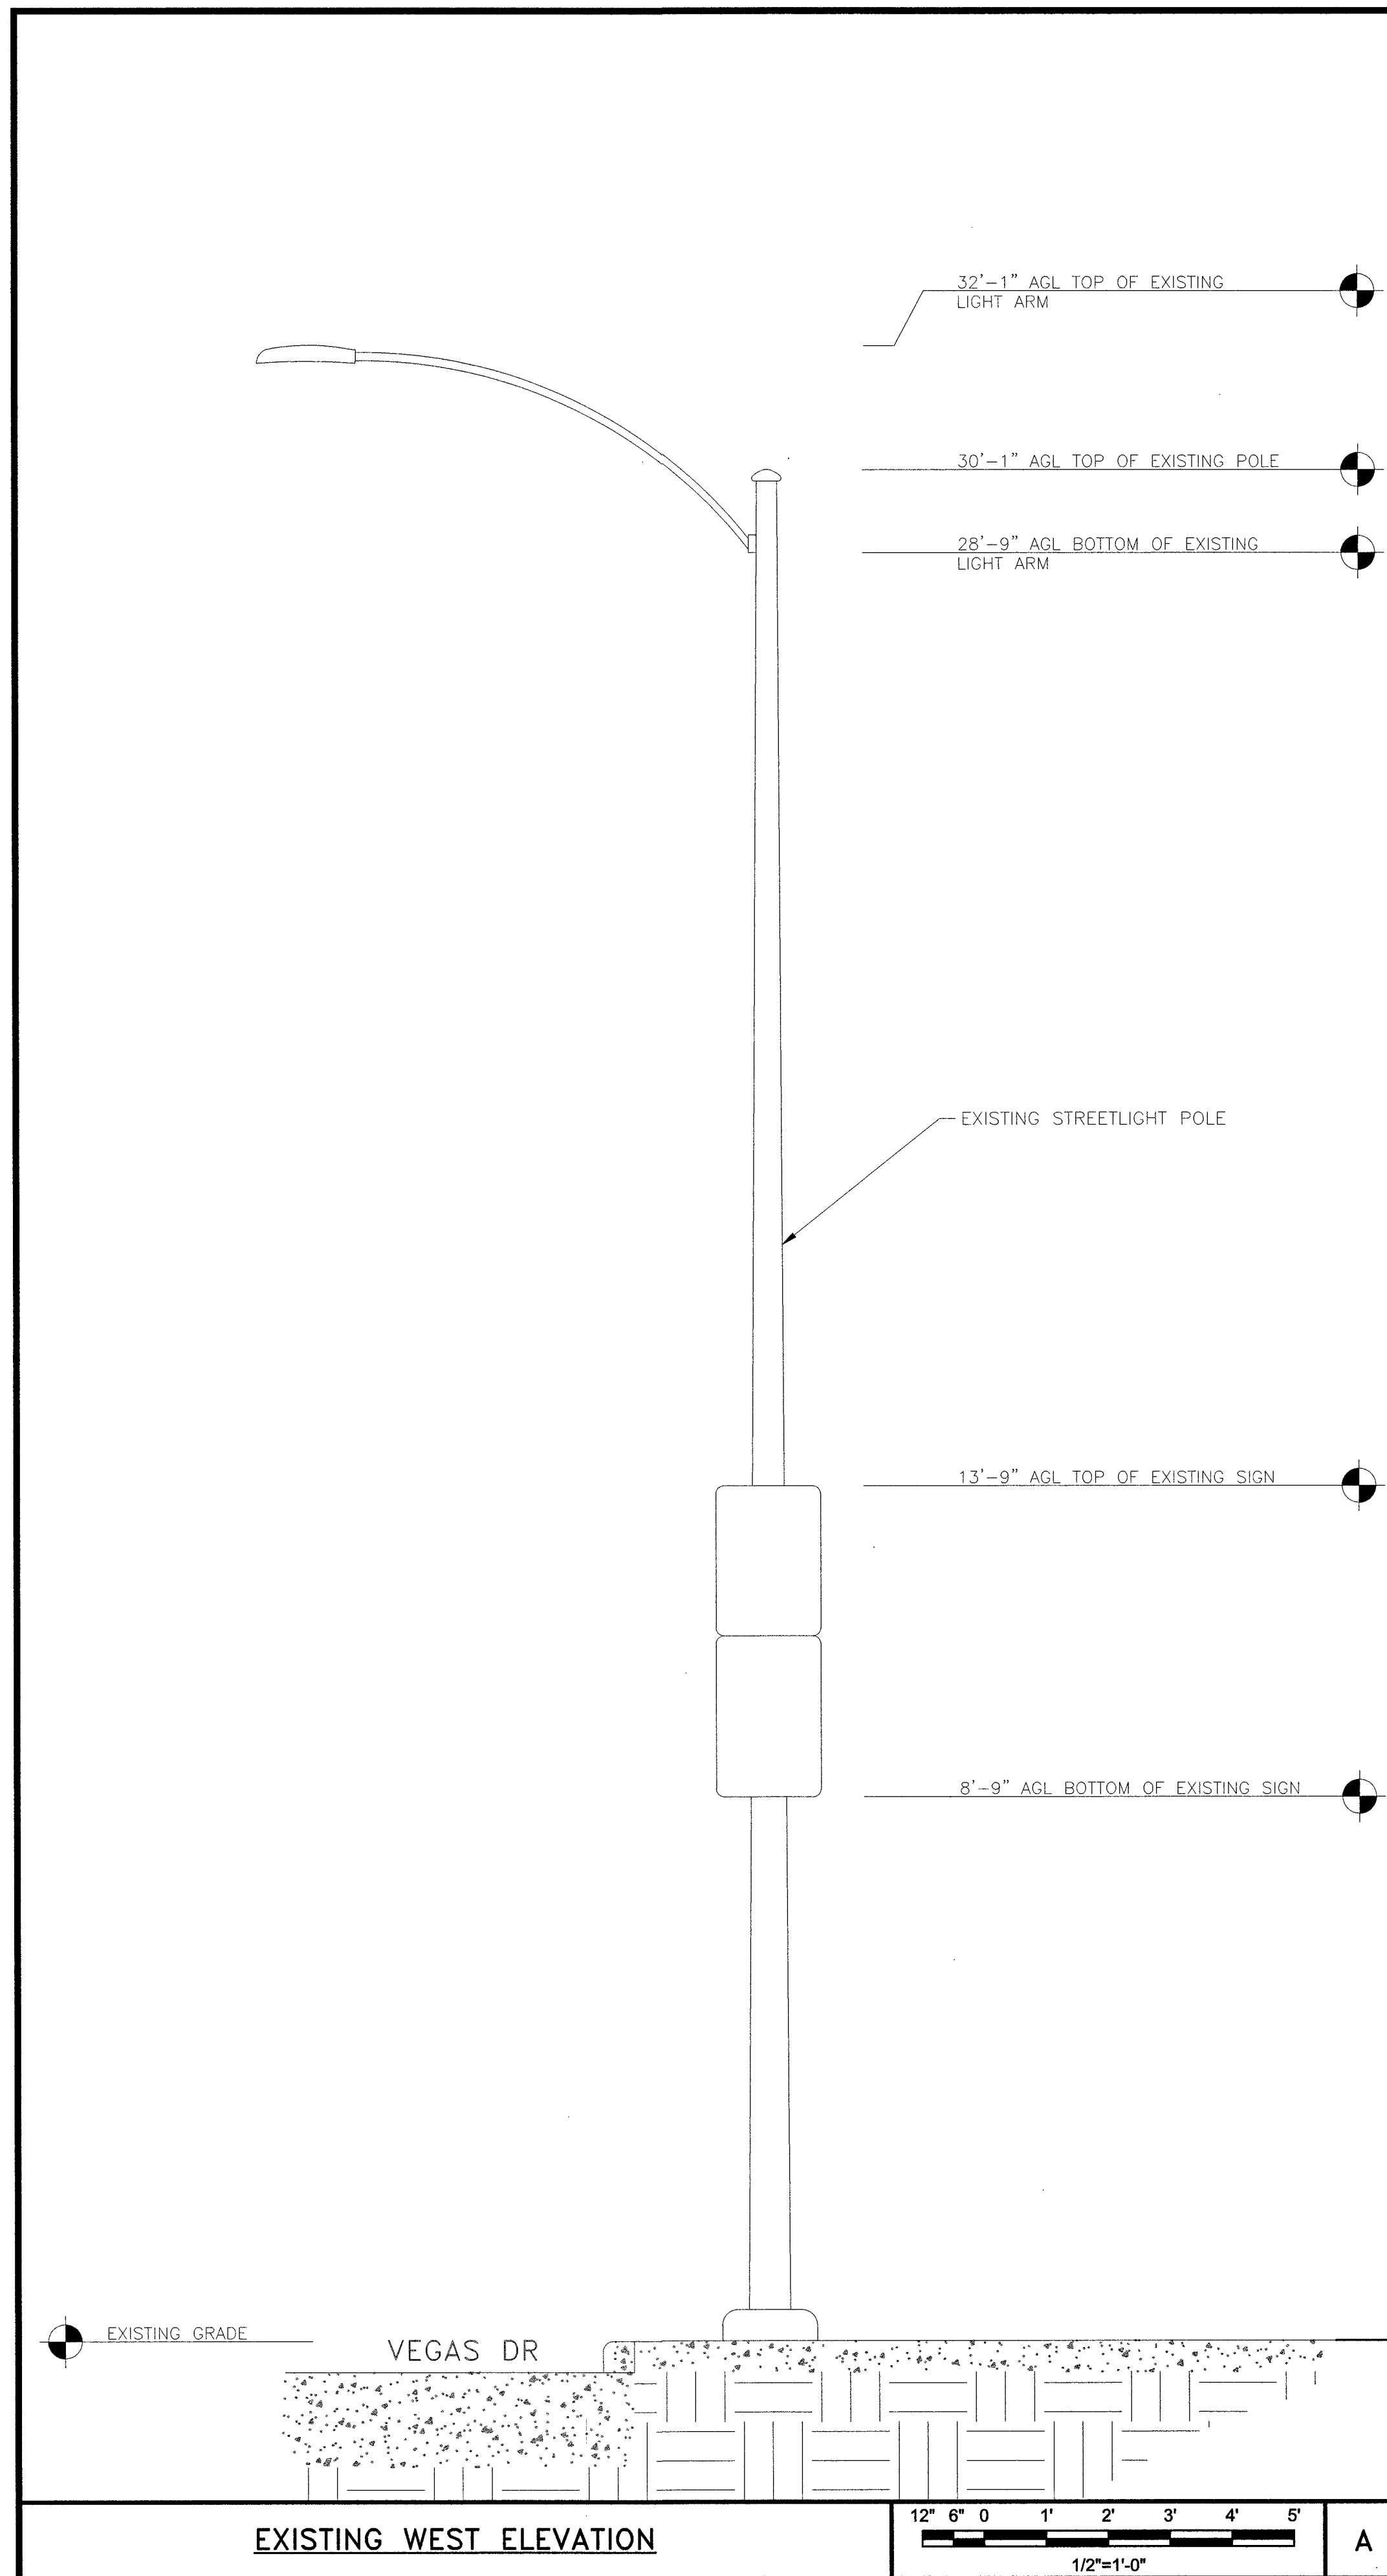

BLACK & VEATCH

BLACK & VEATCH CORPORATION
7760 FRANCE AVENUE SOUTH
SUITE 1200
BLOOMINGTON, MN 55435

THESE DRAWINGS ARE COPYRIGHTED AND ARE THE PROPERTY OF BLACK & VEATCH; PRODUCED SOLELY FOR THE USE OF OUR CLIENT. ANY REPRODUCTION OR USE OF OUR INFORMATION CONTAINED WITHIN SAID DRAWINGS IS PROHIBITED WITHOUT WRITTEN CONSENT BY BLACK & VEATCH.

PROJECT NO.	DRAWN BY	CHECKED BY
199064.2047	TCG	LEW

REV	DATE	DESCRIPTION
2	05/29/19	RADIO SWAP
1	02/13/19	CITY COMMENTS
0	12/05/18	ISSUED FOR CONSTRUCTION

IT IS A VIOLATION OF LAW FOR ANY PERSON, UNLESS THEY ARE ACTING UNDER THE DIRECTION OF A LICENSED PROFESSIONAL ENGINEER, TO ALTER THIS DOCUMENT.

SITE ADDRESS

33AT0100SMC
CRAN_NVLO8196F_R01
2507.25 VEGAS DR
LAS VEGAS, NV 89106
SMALL CELL

SHEET TITLE

ELEVATIONS

SHEET NUMBER

A-2

RELOT
 L18-02822-R001
 10/1/2013-F1B

**CAUTION**

STAY BACK 3 ft.
TO PREVENT
RADIO FREQUENCY
EXPOSURES ABOVE FCC
LIMITS. CALL NOC
1-877-897-2475
TO POWER DOWN.
SITE ID: 33AT0100SMC

**NOTICE**


SMALL CELL SHUT OFF SWITCH
Push switch button turn off radio
while working within 3 ft. of the
device

Note: Once work is completed
turn switch back on

NOTES

- CONTRACTOR IS TO FIELD VERIFY ALL EXISTING ITEMS SHOWN ON THE ELCTRICAL ONE-LINE DIAGRAM AND NOTIFY THE ENGINEER OF ANY DISCREPANCIES.
- ALL NEW CONDUCTOR WIRE TO BE INSTALLED SHALL BE COPPER THWN-2, THW-2, RHW-2, XHHW-2 WIRE UNLESS NOTED OTHERWISE.
- ALL GROUNDING AND BONDING TO BE PER THE RECOGNIZED EDITION OF THE NATIONAL ELECTRIC CODE (NEC).
- ALL INSTALLED CONDUCTORS AND SIGNAL CABLES TO BE CLEARLY MARKED "COX COMMUNICATIONS" WITH BRASS OR FIBERGLASS TAGS.

120VAC FEEDER CONDUCTOR MAXIMUM DISTANCE			
#12 AWG	101'-0"	3% VOLT DROP @	8.85A
#10 AWG	169'-0"	3% VOLT DROP @	8.85A
#8 AWG	261'-0"	3% VOLT DROP @	8.85A
#6 AWG	415'-0"	3% VOLT DROP @	8.85A
#4 AWG	657'-0"	3% VOLT DROP @	8.85A
#3 AWG	814'-0"	3% VOLT DROP @	8.85A

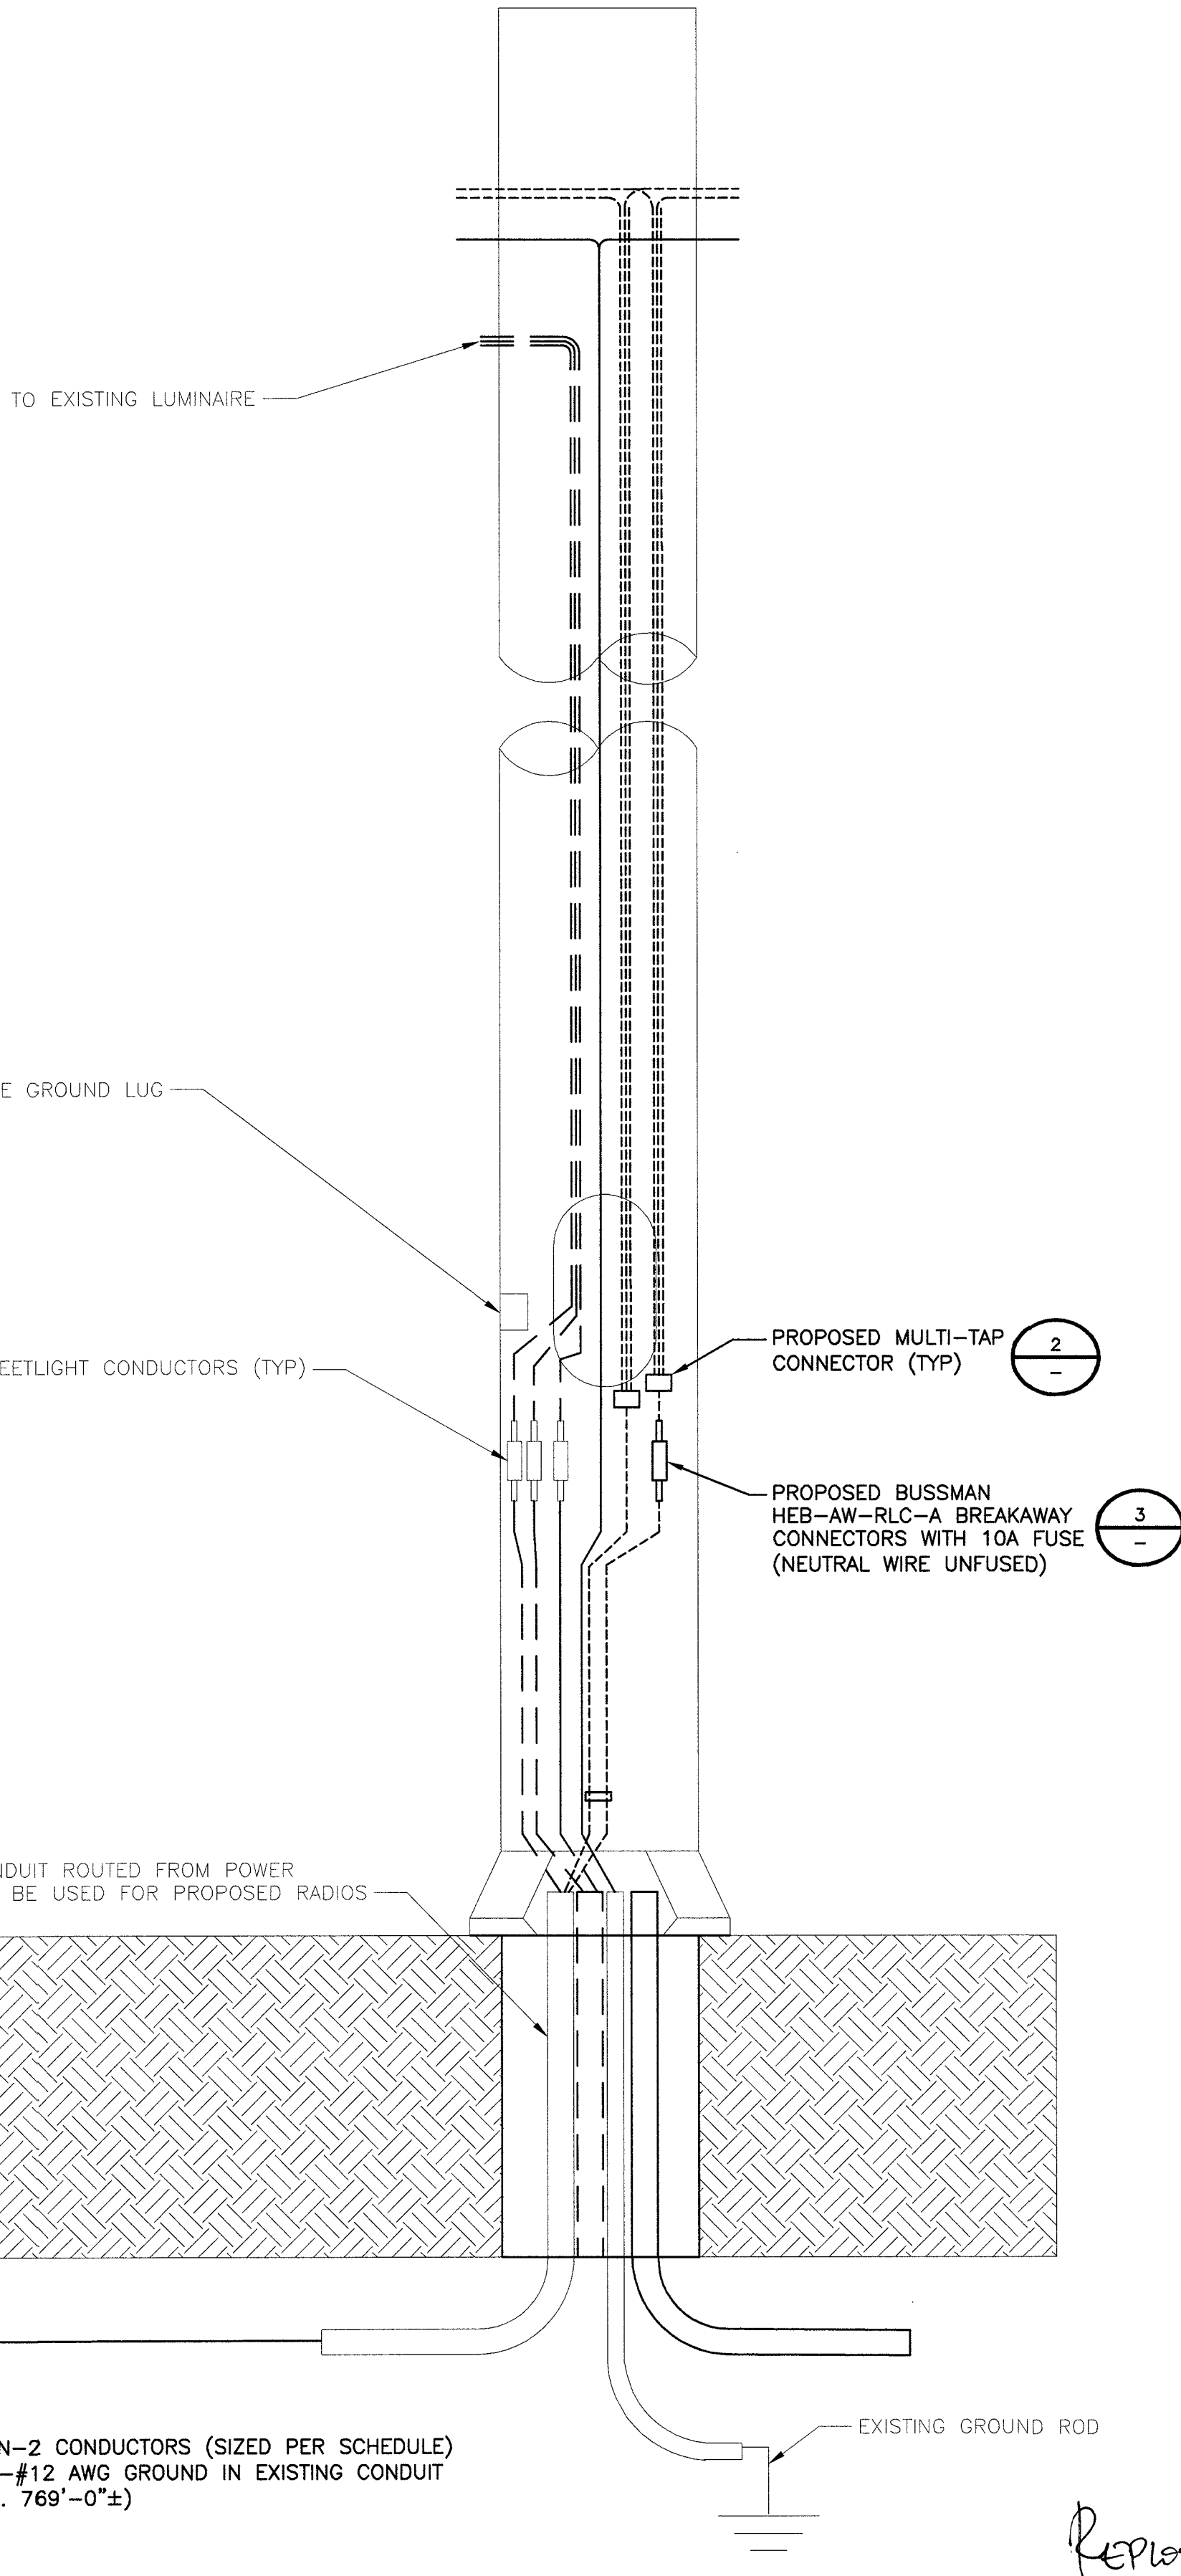


BLACK & VEATCH CORPORATION
7760 FRANCE AVENUE SOUTH
SUITE 1200
BLOOMINGTON, MN 55435

THESE DRAWINGS ARE COPYRIGHTED AND ARE THE PROPERTY OF BLACK & VEATCH; PRODUCED SOLELY FOR THE USE OF OUR CLIENT. ANY REPRODUCTION OR USE OF THE INFORMATION CONTAINED WITHIN SAID DRAWINGS IS PROHIBITED WITHOUT WRITTEN CONSENT BY BLACK & VEATCH.

PROJECT NO.	DRAWN BY	CHECKED BY
199064.2047	TCG	LEW

REV	DATE	DESCRIPTION
2	05/29/19	RADIO SWAP
1	02/13/19	CITY COMMENTS
0	12/05/18	ISSUED FOR CONSTRUCTION

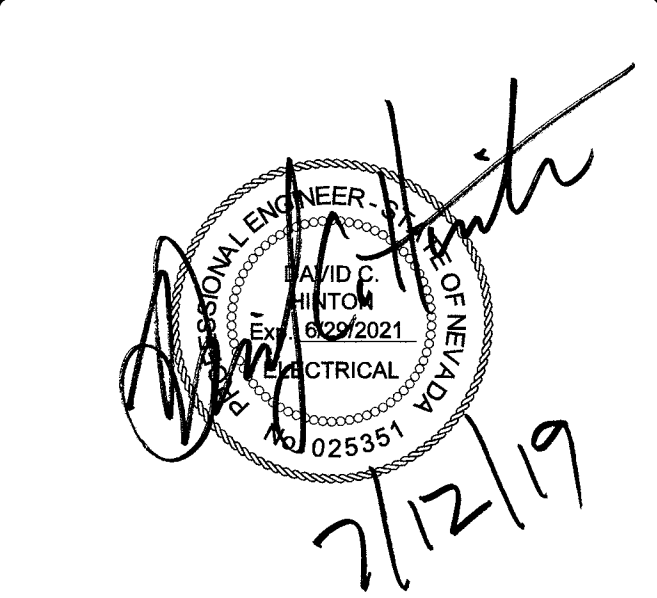

IT IS A VIOLATION OF LAW FOR ANY PERSON, UNLESS THEY ARE ACTING UNDER THE DIRECTION OF A LICENSED PROFESSIONAL ENGINEER, TO ALTER THIS DOCUMENT.

SITE ADDRESS
33AT0100SMC
CRAN_NVL08196F_R01
2507.25 VEGAS DR
LAS VEGAS, NV 89106
SMALL CELL

SHEET TITLE
ELECTRICAL DETAILS
AND DIAGRAMS


SHEET NUMBER
E-1

RF WARNING PLACARDS

NO SCALE

1

MULTI-TAP CONNECTOR WITH CLEAR INSULATION,
DOUBLE-SIDED (PCSB4-4-6Y)

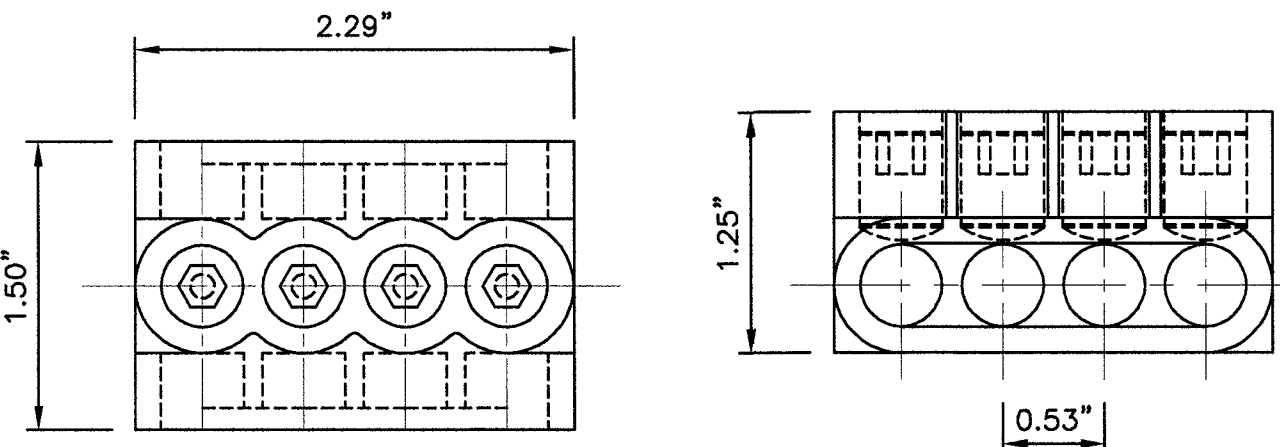


CONNECTOR DETAIL

NO SCALE

2

BUSSMAN HEB-AW-RLC-A

DIMENSIONS, LENGTH: 4.4"
WIRE RANGE: #8-16; (2) #12-16

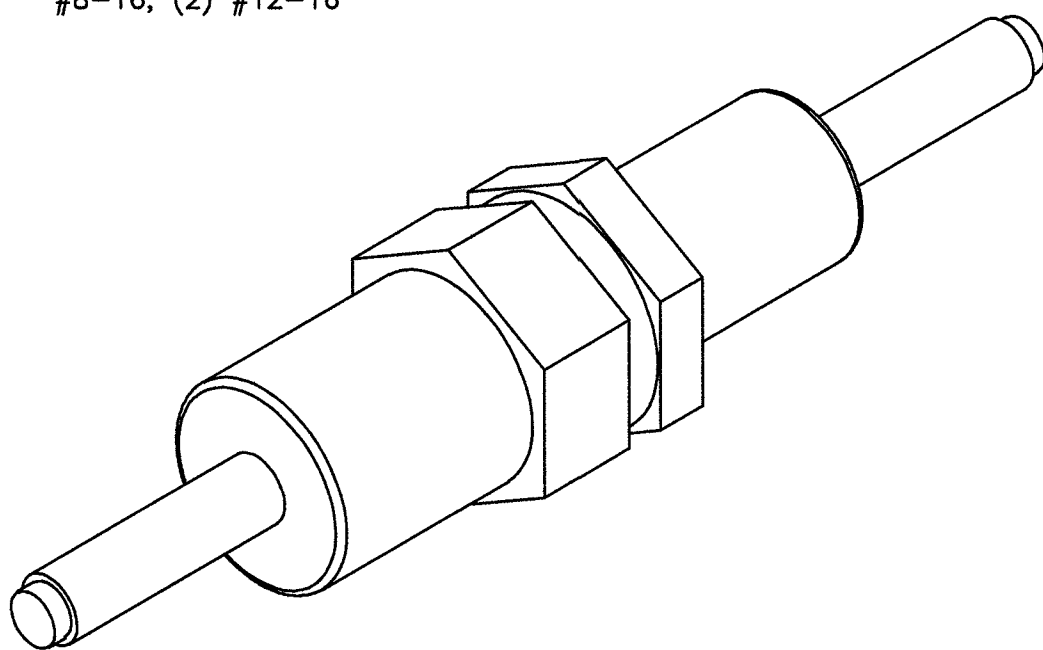

BREAKAWAY FUSE DETAIL

NO SCALE


3

TYPICAL POLE SITE TEMPLATE


NO SCALE

4

EXISTING LOAD.....	48.00	AMPS
ALLOWED LOAD 80%.....	48.00	AMPS

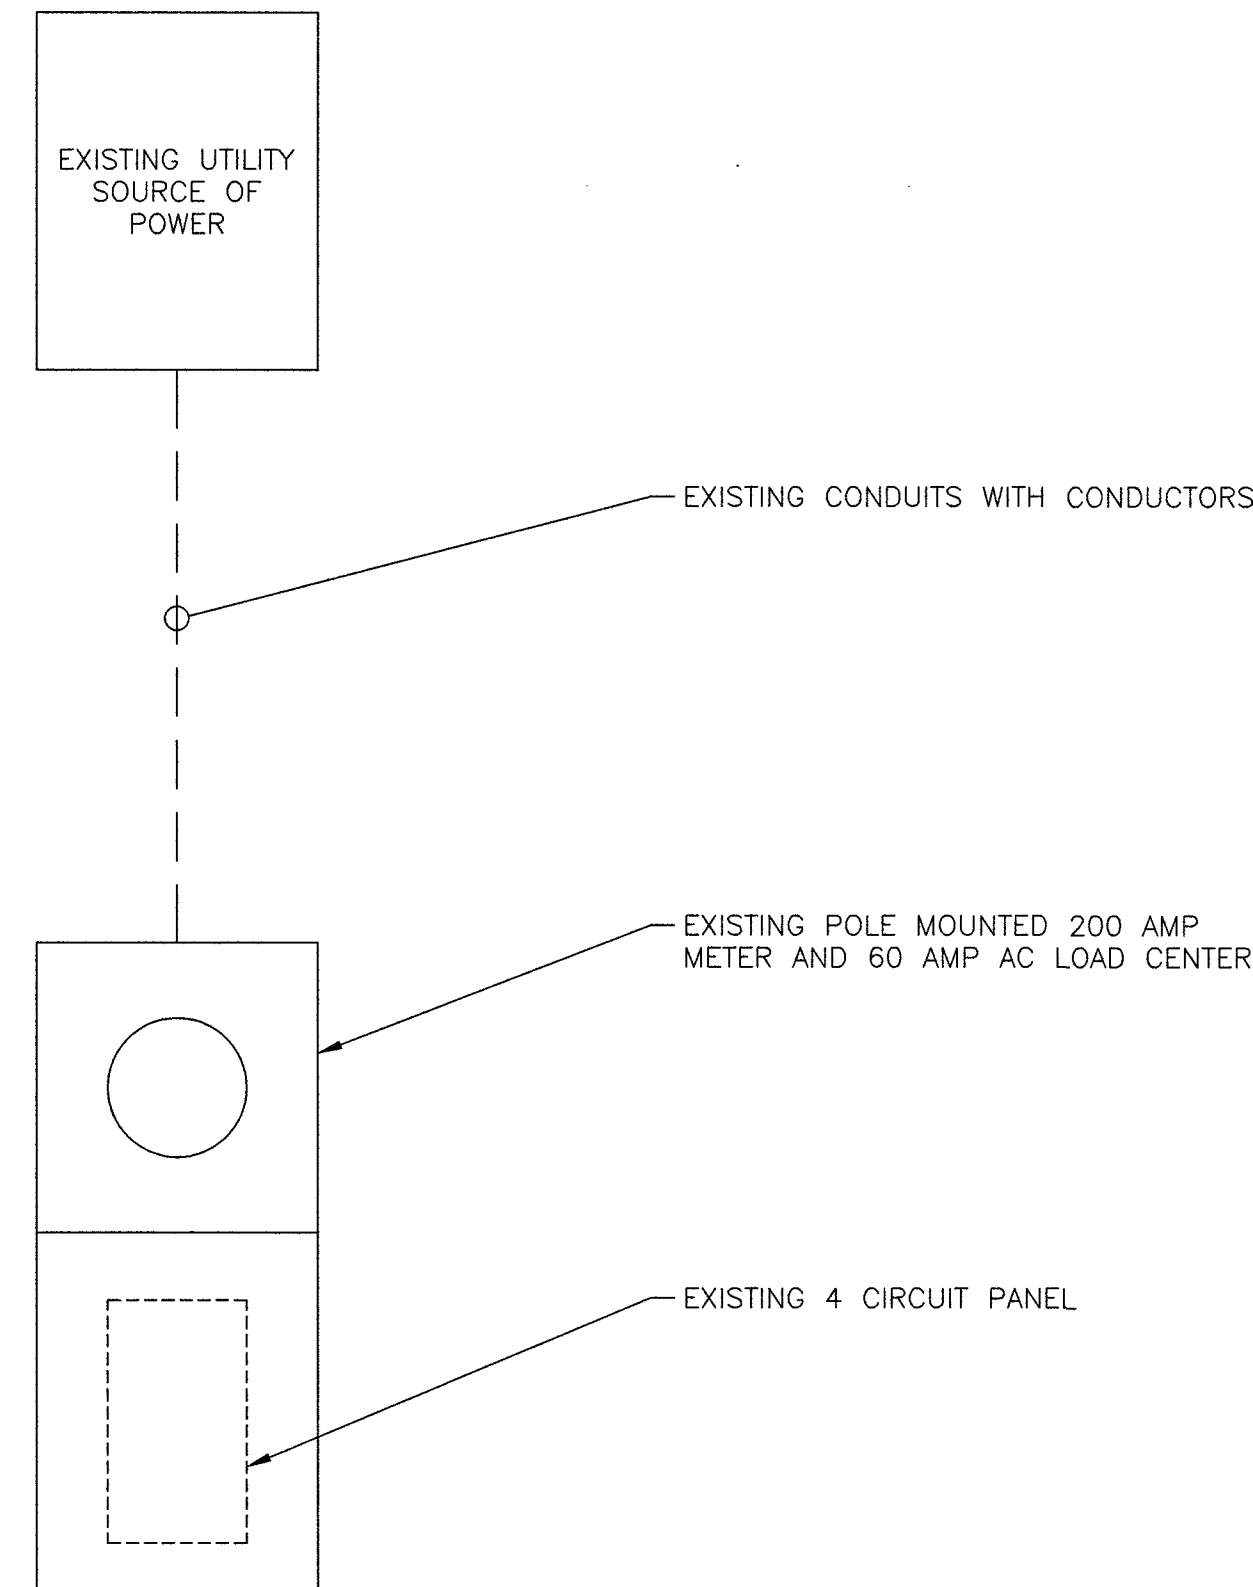

EXISTING LOAD.....	48.00 AMPS
SAFETY FACTOR 125%.....	60.00 AMPS
PROPOSED LOAD.....	4.43 AMPS
TOTAL LOAD.....	64.43 AMPS
ALLOWED LOAD 80% OF 200 AMPS.....	160 AMPS

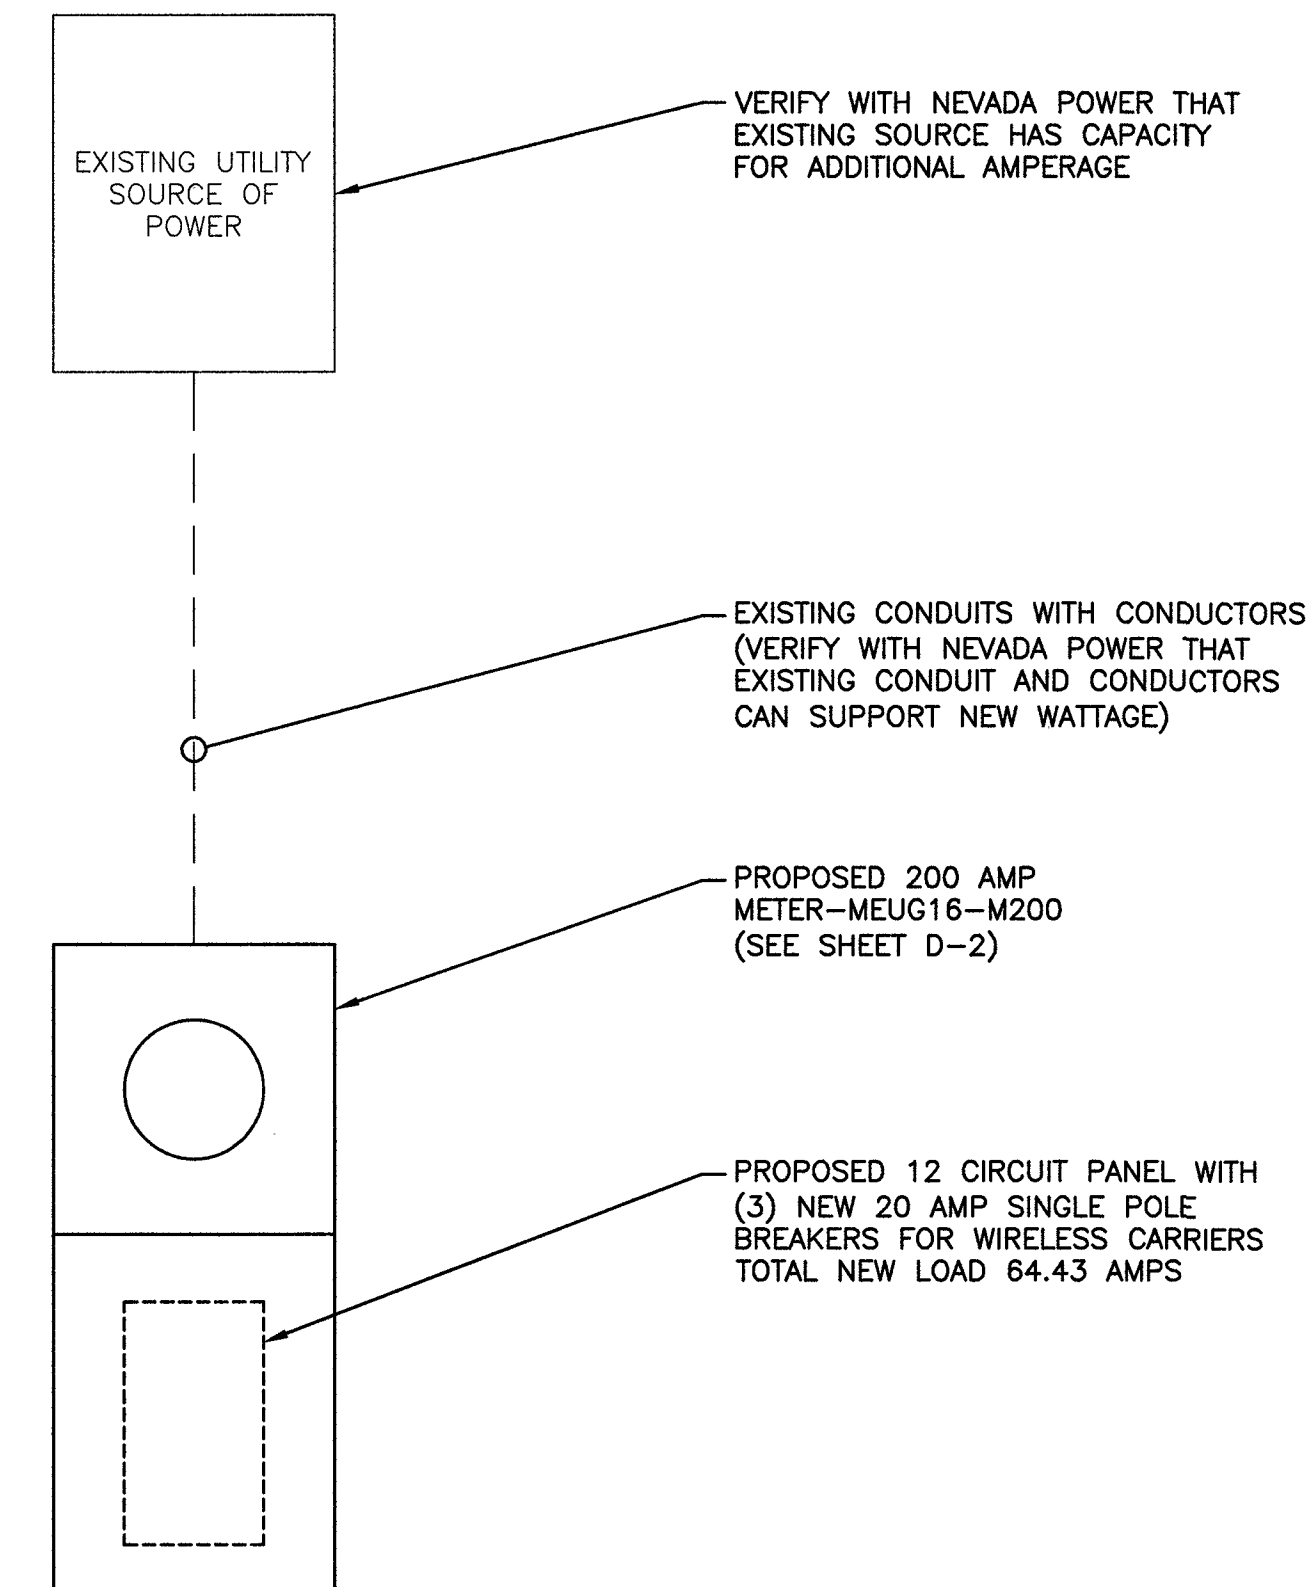

NO SCALE

1

NO SCALE

2

Site Name:		2507 VEGAS DR					MODEL NUMBER:		MYERS MEUG16-M200 CALTRANS TYPE III-BF										
SITE NUMBER:		33AT0100SMC					PHASE:		1				WIRE:		3				
VOLTAGE:		240 /120		Volts AC				BUSS RATING:		200		AMPS							
MAIN BREAKER:		200		AMPS															
MOUNT:		SURFACE																	
ENCLOSURE TYPE:		NEMA 3R																	
PANEL STATUS:		EXISTING																	
CKT	LOAD DESCRIPTION	BREAKE R AMPS	BREAKER POLES	BREAKER STATUS	SERVICE LOAD VA	Demand Factor	USAGE FACTOR	PHASE A VA	PHASE B VA	USAGE FACTOR	Demand Factor	SERVICE LOAD VA	BREAKER STATUS	BREAKER POLES	BREAKER AMPS	LOAD DESCRIPTION	CKT		
	MAIN	200	2	NEW	0	1.00	1.00	0											
					0	1.00	1.00		0										
1	STREET LIGHTS	60	2	ON	5730	1.00	1.25	7163									2		
3					5730	1.00	1.25		7163								4		
5	PHOTO CELL	15	1	ON	60	1.00	1.25	75									6		
7								0		1.00	1.00	0	OFF	1	20	TELECOM (FUTURE)	8		
9								0		1.00	1.00	0	OFF	1	20	TELECOM (FUTURE)	10		
11									1063	1.25	1.00	850	NEW	1	20	PROPOSED COX SMALL CELL	12		
								PHASE A	PHASE B										
								7238	8225	VA									
									TOTAL	KVA	15.46								
										AMPS	64.43								

PROPOSED PANEL SCHEDULE AND CALCS

NO SCALE

3




BLACK & VEATCH CORPORATION
7760 FRANCE AVENUE SOUTH
SUITE 1200
BLOOMINGTON, MN 55435

THESE DRAWINGS ARE COPYRIGHTED AND ARE THE PROPERTY OF BLACK & VEATCH; PRODUCED SOLELY FOR THE USE OF OUR CLIENT. ANY REPRODUCTION OR USE OF THE INFORMATION CONTAINED WITHIN SAID DRAWINGS IS PROHIBITED WITHOUT WRITTEN CONSENT BY BLACK & VEATCH.

PROJECT NO.	DRAWN BY	CHECKED BY
199064.2047	TCG	LEW

J/C 8 15 19

REV	DATE	DESCRIPTION
2	05/29/19	RADIO SWAP
1	02/13/19	CITY COMMENTS
0	12/05/18	ISSUED FOR CONSTRUCTION

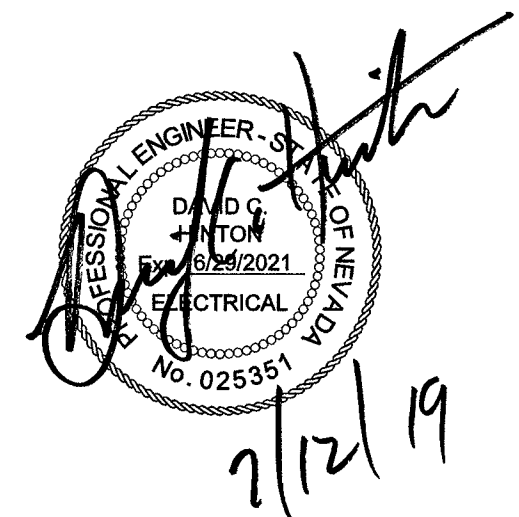

IT IS A VIOLATION OF LAW FOR ANY PERSON,
UNLESS THEY ARE ACTING UNDER THE DIRECTION
OF A LICENSED PROFESSIONAL ENGINEER,
TO ALTER THIS DOCUMENT.

33AT0100SMC
CRAN_NVL08196F_R01
2507.25 VEGAS DR
LAS VEGAS, NV 89106
SMALL CELL

ELECTRICAL SINGLE LINE DIAGRAMS

E-2