




GENERAL CONSTRUCTION NOTES

- SUBMITTAL OF BID INDICATES CONTRACTOR IS COGNIZANT OF ALL JOB SITE CONDITIONS AND WORK TO BE PERFORMED UNDER THIS CONTRACT.
- CONTRACTOR SHALL PERFORM ALL VERIFICATION OBSERVATION TESTS, AND EXAMINATION WORK PRIOR TO THE ORDERING OF THE ELECTRICAL EQUIPMENT AND THE ACTUAL CONSTRUCTION. CONTRACTOR SHALL ISSUE A WRITTEN NOTICE OF ALL FINDINGS TO THE ARCHITECT LISTING ALL MALFUNCTIONS, FAULTY EQUIPMENT AND DISCREPANCIES.
- HEIGHTS SHALL BE VERIFIED WITH OWNER TO INSTALLATION.
- THESE PLANS ARE DIAGRAMMATIC ONLY, FOLLOW AS CLOSELY AS POSSIBLE.
- EACH CONDUCTOR OF EVERY SYSTEM SHALL BE PERMANENTLY TAGGED IN EACH PANELBOARD, PULLBOX, J-BOX, SWITCH BOX, ETC., IN COMPLIANCE WITH OCCUPATIONAL SAFETY AND HEALTH ACT (O.S.H.A.).
- CONTRACTOR SHALL PROVIDE ALL LABOR, MATERIALS, INSURANCE, EQUIPMENT, INSTALLATION, CONSTRUCTION TOOLS, TRANSFORMATION, ETC., FOR A COMPLETE AND PROPERLY OPERATIVE SYSTEM ENERGIZED THROUGHOUT AND AS INDICATED ON DRAWINGS, AS SPECIFIED HEREIN AND/OR AS OTHERWISE REQUIRED.
- ALL MATERIALS AND EQUIPMENT SHALL BE NEW AND IN PERFECT CONDITION WHEN INSTALLED AND SHALL BE OF THE BEST GRADE AND OF THE SAME MANUFACTURER THROUGHOUT FOR EACH CLASS OR GROUP OF EQUIPMENT, MATERIALS SHALL BE LISTED AND APPROVED BY UNDERWRITER'S LABORATORY AND SHALL BEAR THE INSPECTION LABEL "J" WHERE SUBJECT TO SUCH APPROVAL. MATERIALS SHALL MEET WITH APPROVAL OF THE DIVISION OF INDUSTRIAL SAFETY AND ALL GOVERNING BODIES HAVING JURISDICTION. MATERIALS SHALL BE MANUFACTURED IN ACCORDANCE WITH APPLICABLE STANDARDS ESTABLISHED BY ANSI, NEMA & NBFU.
- CONTRACTOR SHALL CARRY OUT HIS WORK IN ACCORDANCE WITH ALL GOVERNING STATE, COUNTY AND LOCAL CODES AND O.S.H.A.
- CONTRACTOR SHALL SECURE ALL NECESSARY BUILDING PERMITS.
- COMPLETE JOB SHALL BE GUARANTEED FOR A PRIOR OF ONE (1) YEAR AFTER THE DATE OF JOB ACCEPTANCE BY OWNER. ANY WORK, MATERIAL OR EQUIPMENT FOUND TO BE FAULTY DURING THAT PERIOD SHALL BE CORRECTED AT ONCE, UPON WRITTEN NOTIFICATION, AT THE EXPENSE OF THE CONTRACTOR.
- ALL CONDUIT ONLY (C.O.) SHALL HAVE A PULL WIRE OR ROPE.
- PROVIDE PROJECT MANAGER WITH ONE SET OF COMPLETE ELECTRICAL "AS INSTALLED" DRAWINGS AT THE COMPLETION OF THE JOB, SHOWING ACTUAL DIMENSIONS, ROUTINGS, AND CIRCUITS.
- ALL BROCHURES, OPERATING MANUALS, CATALOGS, SHOP DRAWINGS, ETC. SHALL BE TURNED OVER TO OWNER AT JOB COMPLETION.
- USE T-TAP CONNECTIONS ON ALL MULTI -CIRCUITS WITH COMMON NEUTRAL CONDUCTOR FOR LIGHTING FIXTURE.
- ALL CONDUCTORS SHALL BE COPPER.
- ALL CIRCUIT BREAKERS, FUSES AND ELECTRICAL EQUIPMENT SHALL HAVE AN INTERRUPTING RATING NOT LESS THE MAXIMUM SHORT CIRCUIT CURRENT TO WHICH THEY MAY BE SUBJECTED, AND A MINIMUM OF 10,000 A.I.C.
- THE ENTIRE ELECTRICAL INSTALLATION SHALL BE GROUNDED AS REQUIRED BY ALL APPLICABLE CODES AND DRAWINGS.
- PATCH, REPAIR AND PAINT ANY AREA THAT HAS BEEN DAMAGED IN THE COURSE OF THE ELECTRICAL WORK.
- IN DRILLING HOLES INTO CONCRETE WHETHER FOR FASTENING OR ANCHORING PURPOSES, OR PENETRATIONS THROUGH THE FLOOR FOR CONDUIT RUNS, PIPE RUNS, ETC., IT MUST BE CLEARLY UNDERSTOOD THAT TENDONS AND/OR REINFORCING STEEL WILL NOT BE DRILLED INTO, CUT OR DAMAGED UNDER ANY CIRCUMSTANCES.
- LOCATION OF TENDONS AND/OR REINFORCING STEEL ARE NOT DEFINITELY KNOWN AND THEREFORE MUST BE SEARCHED FOR BY APPROPRIATE METHODS AND EQUIPMENT VIA X-RAY OR OTHER DEVICES THAT CAN ACCURATELY LOCATE THE REINFORCING AND/OR STEEL TENDONS.
- WIRE AND CABLE CONDUCTORS SHALL BE COPPER #12 AWG MINIMUM, NO BX OR ROMEX CABLE IS PERMITTED UNLESS SPECIFICALLY NOTED OTHERWISE ON DRAWINGS.
- GROUNTING CONDUCTORS SHALL BE SOLD TINED COPPER AND ANNEALED #2.
- METER SOCKET AMPERES, VOLTAGE, NUMBER OF PHASES SHALL BE AS NOTED ON THE DRAWINGS. MANUFACTURED BY SQUARE D COMPANY OR APPROVED EQUAL. ALL MATERIALS SHALL BE U.L. LISTED.
- CONDUIT:
  - RIGID CONDUIT SHALL BE U.L. LABEL GALVANIZED ZINC COATED WITH INTERIOR AND SHALL BE USED WHEN INSTALLED IN OR UNDER CONCRETE SLABS, IN CONTACT WITH THE EARTH, UNDER PUBLIC ROADWAYS, IN MASONRY WALLS OR EXPOSED ON BUILDING EXTERIOR RIGIDCONDUIT IN CONTACT WITH EARTH SHALL BE 1/2 LAPPED WRAPPED WITH HUNTS WRAP PROCESS NO. 3.
  - ELECTRICAL METALLIC TUBING SHALL HAVE U.L. LABEL, FITTINGS SHALL BE GLAND RING COMPRESSION TYPE. EMT SHALL BE USED ONLY FOR INTERIOR RUNS.
  - FLEXIBLE METALLIC CONDUIT SHALL HAVE U.L. LISTED LABEL AND MAY BE USED WHERE PERMITTED BY CODE. FITTINGS SHALL BE "JAKE" OR "SQUEEZE" TYPE, SEAL TIGHT FLEXIBLE CONDUIT. ALL CONDUIT IN EXCESS OF SIX FEET IN LENGTH SHALL HAVE FULL SIZE GROUND WIRE.
  - ALL UNDERGROUND CONDUIT SHALL BE PVC SCHEDULE 40 (UNLESS NOTED OTHERWISE) AT A MINIMUM DEPTH OF 24" BELOW GRADE.
- ALL ELECTRICAL EQUIPMENT SHALL BE LABELED WITH PERMANENT ENGRAVED PLASTIC LABELS.
- UPON COMPLETION OF WORK, CONDUCT CONTINUITY, SHORT CIRCUIT, AND FALL POTENTIAL GROUNTING TESTS FOR APPROVAL. SUBMIT TEST REPORTS TO PROJECT MANAGER. CLEAN PREMISES OF ALL DEBRIS RESULTING FROM WORK AND LEAVE WORK IN A COMPLETE AND UNDAMAGED CONDITION.
- CONTRACTOR TO COORDINATE WITH UTILITY COMPANY FOR CONNECTION OF TEMPORARY AND PERMANENT POWER TO THE SITE. THE TEMPORARY POWER AND ALL HOOKUP COSTS TO BE PAID BY CONTRACTOR.
- THE ELECTRICAL INSTALLATION WORK SHALL COMPLY WITH ALL LOCAL, STATE AND NATIONAL CODES, LAWS AND ORDINANCES APPLICABLE TO ELECTRICAL WORK.
- ELECTRICAL CONTRACTOR SHALL VISIT JOB SITE AND VERIFY EXISTING CONDITIONS BEFORE BIDDING AND SHALL INCLUDE IN HIS BID THE NECESSARY COSTS TO CONSTRUCT THIS PROJECT IN ACCORDANCE WITH INTENT OF THE ELECTRICAL DRAWINGS, SPECIFICATIONS, AND ALL APPLICABLE CODES.

- ALL MATERIAL AND EQUIPMENT FURNISHED AND INSTALLED UNDER THIS CONTRACT SHALL BE NEW, FREE FORM DEFECTS AND SHALL BE GUARANTEED FOR A PERIOD OF ONE YEAR FROM DATE OF FINAL ACCEPTANCE BY OWNER OR HIS REPRESENTATIVE. SHOULD ANY TROUBLE DEVELOP DURING THIS PERIOD DUE TO FAULTY WORKMANSHIP, MATERIAL OR EQUIPMENT, THE CONTRACTOR SHALL FURNISH ALL NECESSARY MATERIAL AND LABOR TO CORRECT THE TROUBLE WITHOUT COST TO THE OWNER.
- ALL WORK TO BE EXECUTED IN WORKMANLIKE MANNER AND SHALL PRESENT A NEAT MECHANICAL APPEARANCE WHEN COMPLETED.
- ALL ELECTRICAL MATERIALS AND EQUIPMENT SHALL BE LISTED BY UNDERWRITER'S LABORATORIES.
- ELECTRICAL CONTRACTOR SHALL BE RESPONSIBLE FOR ALL CUTTING AND PATCHING RELATED TO ELECTRICAL WORK, UNLESS NOTED OTHERWISE AND CO-ORDIANTED WITH THE GENERAL CONTRACTOR.
- ELECTRICAL CONTRACTOR SHALL CO-ORINATE ALL WORK WITH CIVIL AND ARCHITECTURAL PLANS. THE REQUIREMENTS OF ALL EQUIPMENT ACTUALLY BEING INSTALLED SHALL BE VERIFIED PRIOR TO INSTALLING THE ELECTRICAL WORK.
- ALL BRANCH CIRCUIT CONDUCTORS SHALL BE COPPER TYPE THWN-2, THW-2, RHW-2, XHHW-2 #14, #12, & #10 SOLID, #8 AND LARGER STRANDED, UNLESS NOTED OTHERWISE.
- ON COMPLETION OF THE WORK, THE INSTALLATION SHALL BE FREE FORM GROUNDS AND SHORT CIRCUITS.
- ELECTRICAL CONTRACTOR SHALL FURNISH AS-BUILT DRAWINGS TO THE ARCHITECT AND CUSTOMER UPON COMPLETION OF THE JOB.
- ELECTRICAL WORK SHALL INCLUDE ALL LABOR, MATERIALS AND EQUIPMENT REQUIRED, INCLUDING BUT NOT LIMITED, TO COMPLETE ELECTRICAL SYSTEMS POWER AND LIGHTING, TELEPHONE CONDUIT SYSTEM, SIGNAL SYSTEMS, PANEL BOARDS(S), CONTROL WIRING, GROUNTING, CONDUIT ONLY SYSTEMS, ETC., AS INDICATED ON ELECTRICAL DRAWINGS AND/OR REQUIRED BY GOVERNING CODES.
- RACEWAYS SHALL BE: RIGID STEEL CONDUIT: HOT-DIP GALVANIZED HEAVY WALL AS MANUFACTURED BY REPUBLIC, TRIANGLE OR EQUAL, RIGID POLYVINYL CHLORIDE CONDUIT (PVC): HEAVY WALLS SCHEDULE 40 AS MANUFACTURED BY CARLON ELECTRICAL, VISQUEEN OR EQUAL, ELECTRICAL METALLIC TUBING (EMT):ZINC-COATED THIN WALL AS MANUFACTURED BY TRIANGLE, REPUBLIC OR EQUAL
- FUSE TYPE SHALL BE BUSSMANN RK-1 OR CLASS "J" FUSE.
- PROVIDE ENGRAVED PLASTIC LABELS TO IDENTIFY ALL PANEL BOARDS, XFMRs., DISTRIBUTION PANELS, DISCONNECT SWITCHES, AND TRANSFER SWITCHES, LABELS SHALL READ IN THIS FASHION "A" 20BY/120V 3PH, 4W, 225A, CKT. BKR OR FUSES TYPE AND SIZES.
- E.C. SHALL VERIFY AND TEST GROUND TO SOURCE TO A MAXIMUM OF 5 OHMS. IF THE GROUND TEST DOES NOT ACHIEVE THE 5 OHMS LESS, E.C. SHALL BE RESPONSIBLE FOR PROVIDING THE NECESSARY CONDUCTORS AND GROUND RODS TO ACHIEVE 5 OHMS MAXIMUM.
- BEFORE SUBMITTING BID, VERIFY EXISTING SITE CONDITIONS, ELECTRICAL SERVICE REQUIREMENTS AND THE EXACT SERVING UTILITY POINTS OF CONNECTION.
- THE ELECTRICAL CONTRACTOR (E.C) SHALL FURNISH AND PAY FOR ALL PERMITS AND RELATED FEES.
- UNLESS SPECIFICALLY NOTED OTHERWISE, ALL ELECTRICAL MATERIALS, EQUIPMENT AND WORK, SHOWN ON THESE PLANS ARE TO BE PROVIDED AND INSTALLED BY THE ELECTRICAL CONTRACTOR.
- E.C. SHALL FURNISH AND INSTALL ALL SWITCHES, CONDUITS, WIRES, BOXES, LIGHT FIXTURES (INCLUDING LAMPS), SERVICE DEVICES, RECEPTACLES, SWITCHBOARDS AND PANEL BOARDS, ETC. REQUIRED FOR A COMPLETE AND OPERATING ELECTRICAL SYSTEM.
- SEE ARCHITECTURAL DRAWINGS FOR DIMENSIONAL/LOCATION INFORMATION RELATING TO THE ELECTRICAL DRAWINGS.
- ELECTRICAL CONTRACTOR SHALL VERIFY VOLTAGES AND HORSEPOWER RATINGS OF ALL MECHANICAL EQUIPMENT.
- PRIOR TO INSTALLING ANY ELECTRICAL WORK. THE ELECTRICAL CONTRACTOR SHALL VERIFY EXACT LOCATIONS AND REQUIREMENTS ON THE JOB AND BY REFERENCE TO ARCHITECTURE, MECHANICAL AND EQUIPMENT SUPPLIERS DRAWINGS. SHOULD THERE BE ANY QUESTION OR PROBLEM CONCERNING THE NECESSARY PROVISIONS TO BE MADE, PROPER DIRECTIONS SHALL BE OBTAINED BEFORE PROCEEDING WITH ANY WORK.
- OUTLET AND JUNCTION BOXES SHALL BE SIZED PER CODE FOR THE QUANTITY OF WIRES THEY CONTAIN. SEE ARTICLE 370 OF N.E.C. PROVIDE ADDITIONAL BOXES AND EXTENSION RINGS AS REQUIRED.
- ELECTRICAL CONTRACTOR SHALL COMPLY WITH CABLE BENDING RADIUS REQUIREMENTS PER CABLE MANUFACTURES SPECIFICATION.
- CONDUIT LAYOUTS SHOWN ON THE PLANS ARE DIAGRAMMMATIC, NOT INDICATING THE ROUTING REQUIRED, THE CONTRACTOR SHALL ROUTE CONDUITS AS REQUIRED BY THE CONDITIONS OF INSTALLATION.
- ALL EQUIPMENT PROVIDED BY THE ELECTRICAL CONTRACTOR SHALL BE LISTED AND LABELED BY A NATIONALLY- RECOGNIZED TESTING AGENCY, ACCEPTABLE TO THE AUTHORITY HAVING JURISDICTION, FOR THE CONDITIONS OF THE INSTALLATION.
- PLANS INDICATE THE NUMBER OF PHASE NATURAL, AND GROUND CONDUCTORS WHERE MORE THAN THREE CONDUCTORS ARE TO BE INSTALLED IN A CONDUIT (THREE OR LESS CONDUCTORS ARE NOT SHOWN). ADDITIONAL CONDUCTORS REQUIRED FOR CONTROL SHALL BE INCLUDED EVEN IF NOT EXPLICITLY SHOWN.
- WHERE SIZE IS NOT SHOWN ON THE DRAWINGS, CIRCUITS SHALL CONSIST OF #12 PHASE AND GROUNDED (NEUTRAL CONDUCTORS) AND A #12 CU GROUND IN A 3/4" CONDUIT.
- UNLESS SPECIFICALLY NOTED OTHERWISE, THE ELECTRICAL CONTRACTOR SHALL MAKE FINAL CONNECTIONS TO ALL UTILIZATION EQUIPMENT SHOWN ON THE DRAWINGS. VERIFY THE TYPE OF FINAL CONNECTION AND PROVIDE APPROPRIATE WIRING METHOD.
- PRIOR TO TRENCHING IN ANY AREA THE CONTRACTOR SHALL CONTACT ELECTRICAL, COMMUNICATIONS/DATA, CABLE T.V., GAS, AND WATER UTILITY PROVIDES (BLUE STRIKE) AND HAVE ALL UTILITIES IN THE AREA IDENTIFIED. IN ADDITION, THE CONTRACTOR SHALL OBTAIN THE SERVICES OF A SUBCONTRACTOR SPECIALIZING IN THE LOCATION OF UNDERGROUND STRUCTURES TO IDENTIFY ANY OBSTACLES IN THE PATH OF TRENCHING (PRIOR TO COMMENCING WORK). DAMAGE TO ANY UNDERGROUND STRUCTURES SHALL BE REPAIRED BY THE CONTRACTOR AT NO ADDITIONAL COST TO THE PROJECT.
- ANY AND ALL WIRE THAT CARRIES A CURRENT MUST BE IN A CONDUIT. (GROUNDING WIRE FOR LOOPS, HALOS, ECT. IS CONSIDERED NON-CURRENT CARRYING.)

TYPICAL HANDHOLE NOTES

- CONCRETE COLLARS MAY BE DESIRED FOR INSTALLATIONS IN DRIVEWAYS, PARKING LOTS AND OFF-ROADWAY APPLICATIONS WHERE SUBJECT TO OCCASIONAL NON-DELIBERATE TRAFFIC. THIS APPLIES TO BOXES MADE FROM ANY MATERIAL TO PROVIDE ADDED PROTECTION FOR THE TOP LID. THIS IS NOT NECESSARY IN GRASSY AREAS OR AREAS SUBJECT TO PEDESTRIAN TRAFFIC.
- CONCRETE ENCASEMENT TO BE 3,000 PSI MIN.
- CONCRETE ENCASEMENT COLLAR DIMENSION "D" TO BE EQUAL TO DESIGN PAVEMENT DEPTH.
- PAVEMENT AND SUBGRADE TO BE SHOWN ON THE ENGINEERING PLANS.
- EXCAVATE THE HOLE APPROXIMATELY 6 TO 8" DEEPER THAN SUGGESTED HANDHOLE BURIAL DEPTH.
- COMPACT THE SUBSOIL WITH A BACK-HOE OR A HYDRAULIC TAMPER. ADD APPROXIMATELY 6 TO 8" OF GRAVEL TO THE BOTTOM OF HOLE.
- PLACE THE HANDHOLE ON THE LEVELED GRAVEL BED. LEVEL THE HANDHOLE.
- BACK-FILL WITH LOOSE EARTH MATERIAL UP TO THE TOP SURFACE OF THE HANDHOLE. DO NOT BACK-FILL WITH CHUNKS OF FROZEN MATERIAL OR LARGE ROCKS NEXT TO THE GROUND SLEEVE. PACK THE BACK-FILL MATERIAL BY FOOT TAMPING, NO MACHINE TAMPING.
- PROVIDE BARRIER HUBBELL QUAZITE # PG 2436BC30.
- ALL UNDERGROUND CONDUITS SHALL BE SCH 40 PVC. EXCEPT THAT ELBOWS AND RISERS SHALL BE RMC ALL UNDERGROUND ELBOWS SHALL BE SWEEPING BENDS. 2'-0" MINIMUM SHALL BE REQUIRED.
- THREE CONDUITS ARE SHOWN BELOW, ALTHOUGH MULTIPLE CONDUITS CAN BE PLACED IN THE SAME TRENCH. A MINIMUM SEPARATION IS REQUIRED PER THE LOCAL JURISDICTIONS AND UTILITY COMPANIES. IN ALL OTHER CASES, USE THE CONDUIT SPACING SCHEDULE TO MAINTAIN MINIMUM SPACING BETWEEN THE EXTERIOR WALL TO EXTERIOR WALL SEPARATION OF CONDUITS.
- CONTRACTOR SHALL RESTORE THE TRENCH TO ITS ORIGINAL CONDITIONS BY EITHER SEEDING OR SODDING GRASS AREAS, OR REPLACING ASPHALT OR CONCRETE AREAS TO ITS ORIGINAL CROSS SECTION.
- TRENCHING SAFETY; INCLUDING, BUT NOT LIMITED TO SOIL CLASSIFICATION, SLOPING, AND SHORING, SHALL BE GOVERNED BY THE CURRENT OSHA TRENCHING AND EXCAVATION SAFETY STANDARDS.
- ALL CONDUITS SHALL BE INSTALLED IN COMPLIANCE WITH THE NATIONAL ELECTRIC CODE (NEC) OR AS REQUIRED BY THE LOCAL JURISDICTION.

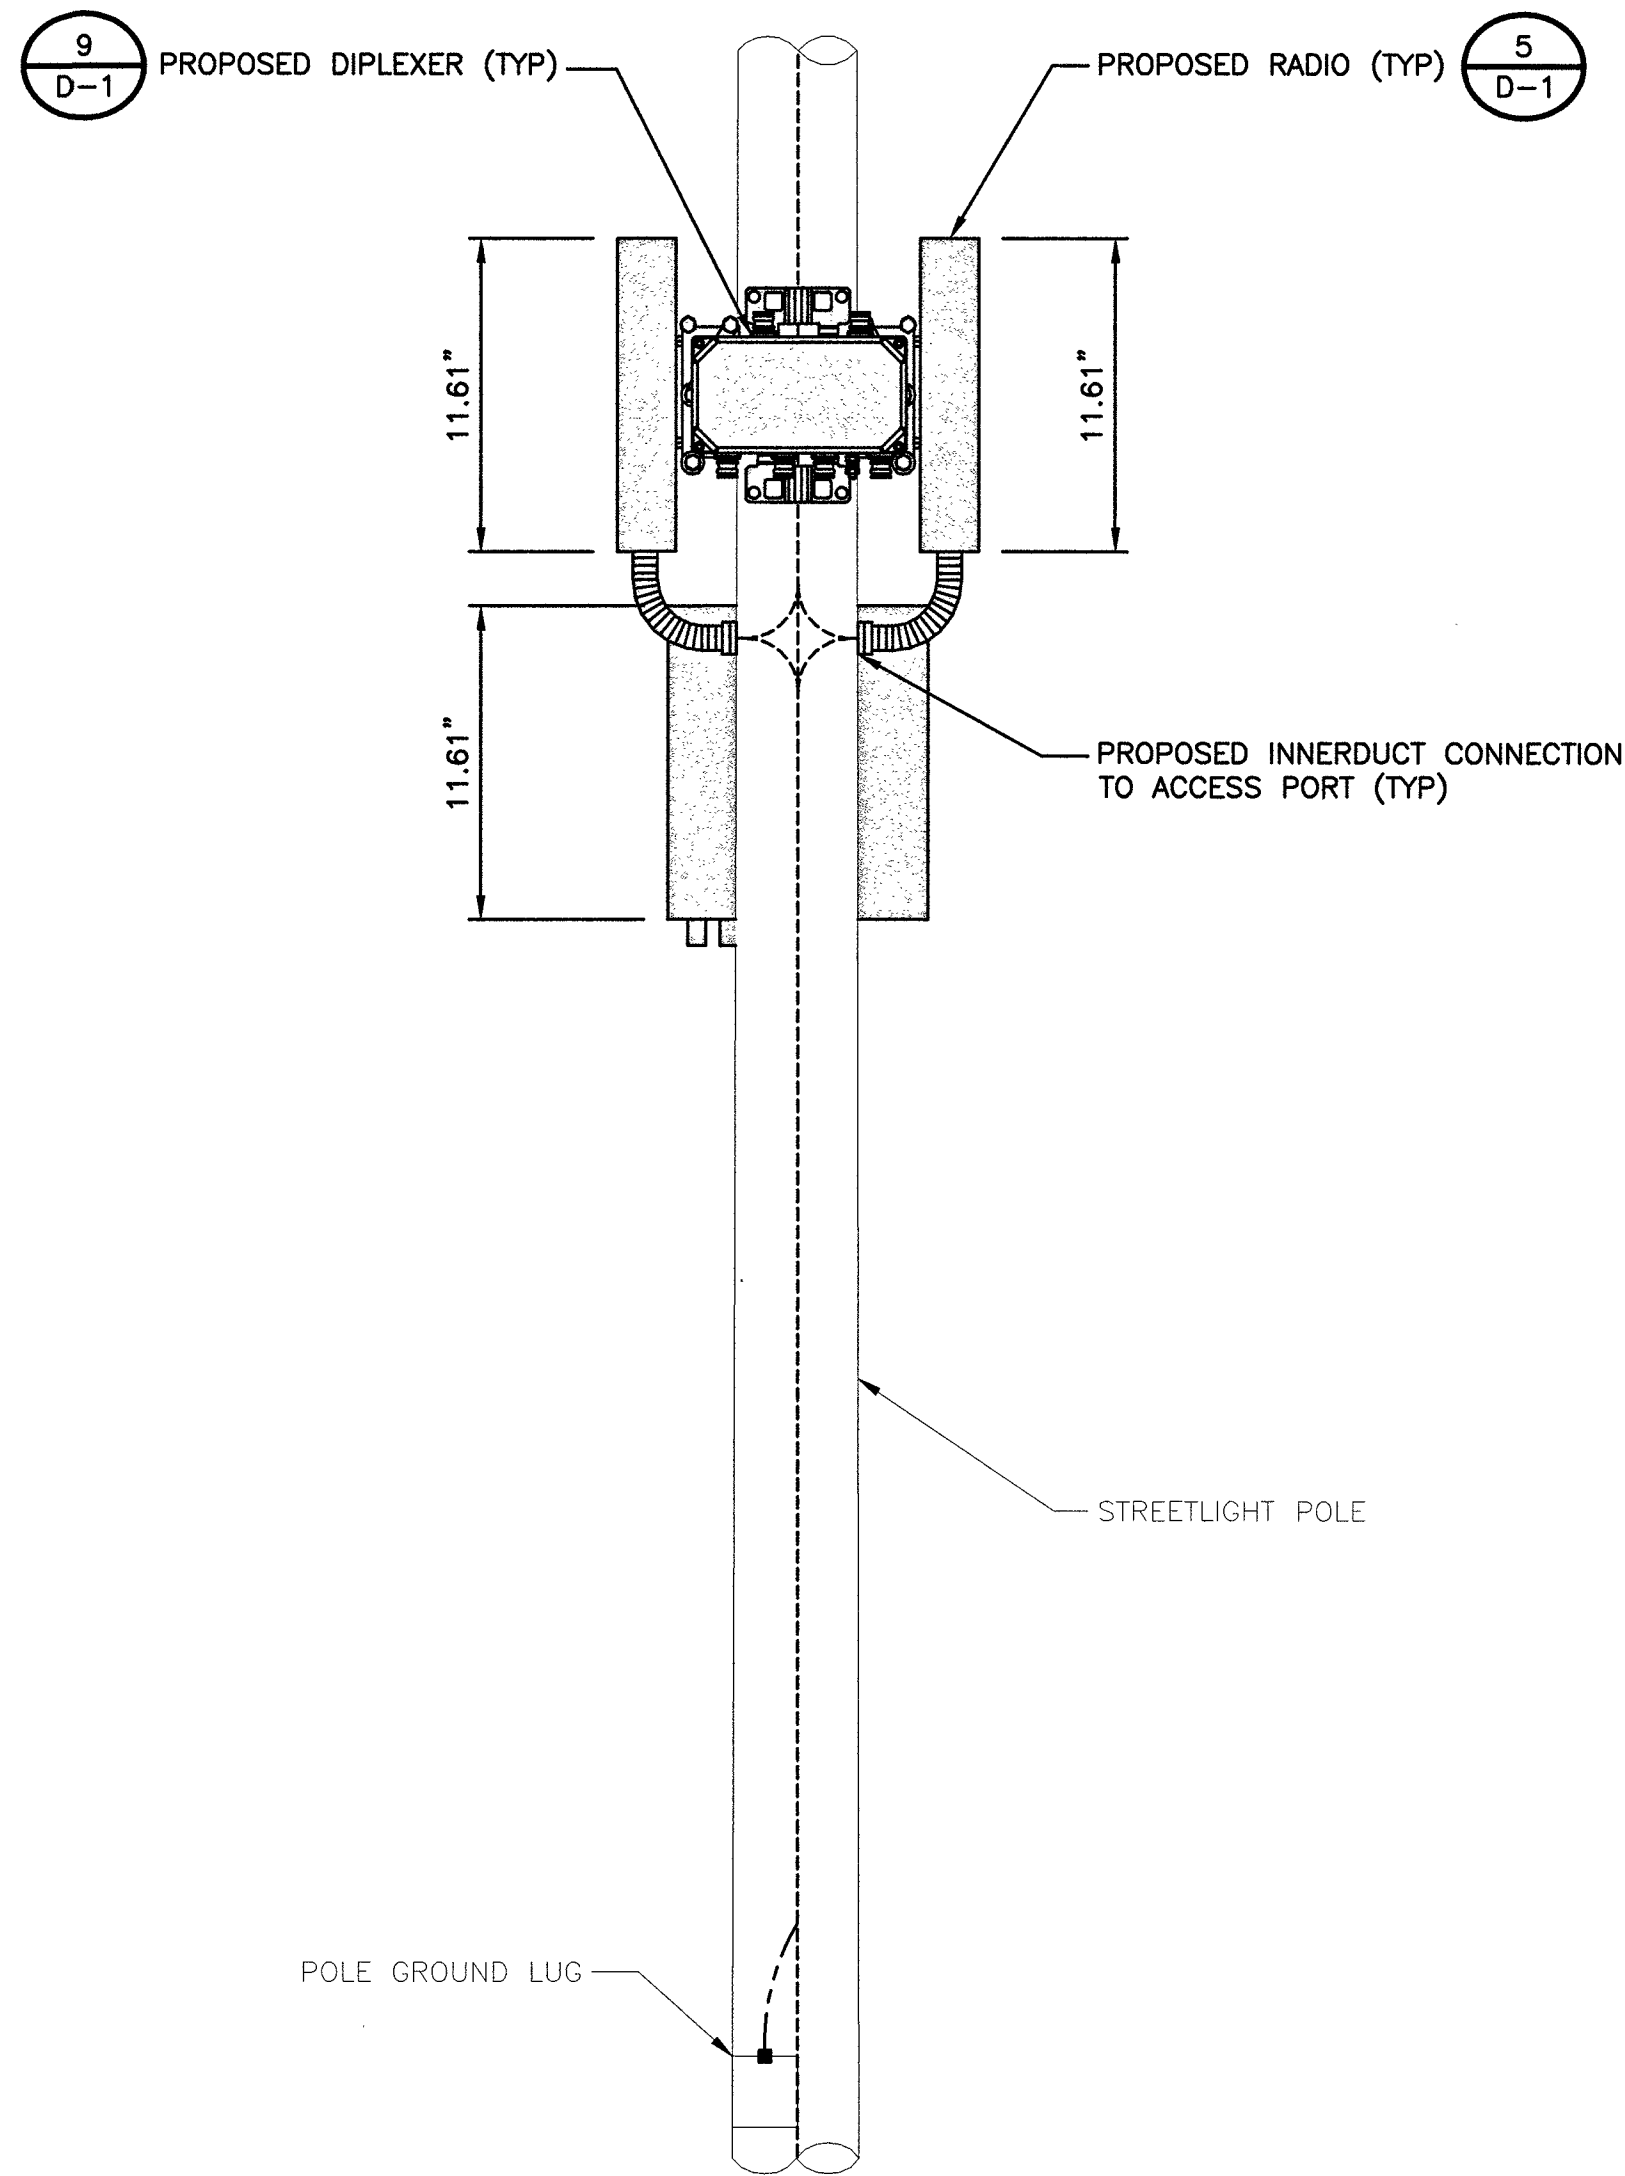

GENERAL NOTES

1

TYPICAL EQUIPMENT PLACEMENT DETAIL

NO SCALE

2




BLACK & VEATCH

BLACK & VEATCH CORPORATION  
7760 FRANCE AVENUE SOUTH  
SUITE 1200  
BLOOMINGTON, MN 55435

THESE DRAWINGS ARE COPYRIGHTED AND ARE THE PROPERTY OF BLACK & VEATCH; PRODUCED SOLELY FOR THE USE OF OUR CLIENT. ANY REPRODUCTION OR USE OF THE INFORMATION CONTAINED WITHIN SAID DRAWINGS IS PROHIBITED WITHOUT WRITTEN CONSENT BY BLACK & VEATCH.

| PROJECT NO. | DRAWN BY | CHECKED BY |
|-------------|----------|------------|
| 199064.2051 | MSC      | LEW        |

| REV | DATE     | DESCRIPTION             |
|-----|----------|-------------------------|
| 0   | 12/05/18 | ISSUED FOR CONSTRUCTION |

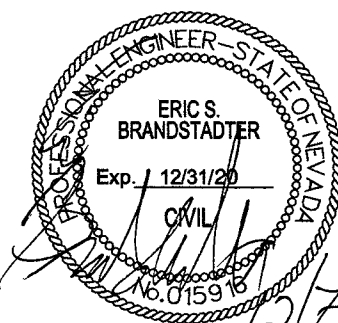

IT IS A VIOLATION OF LAW FOR ANY PERSON, UNLESS THEY ARE ACTING UNDER THE DIRECTION OF A LICENSED PROFESSIONAL ENGINEER, TO ALTER THIS DOCUMENT.

SITE ADDRESS


33AT0104SMC  
CRAN\_NVLO8145F\_R01  
7100.25 N DURANGO DR  
LAS VEGAS, NV 89149  
SMALL CELL

SHEET TITLE

GENERAL CONSTRUCTION  
NOTES

SHEET NUMBER

GN-1

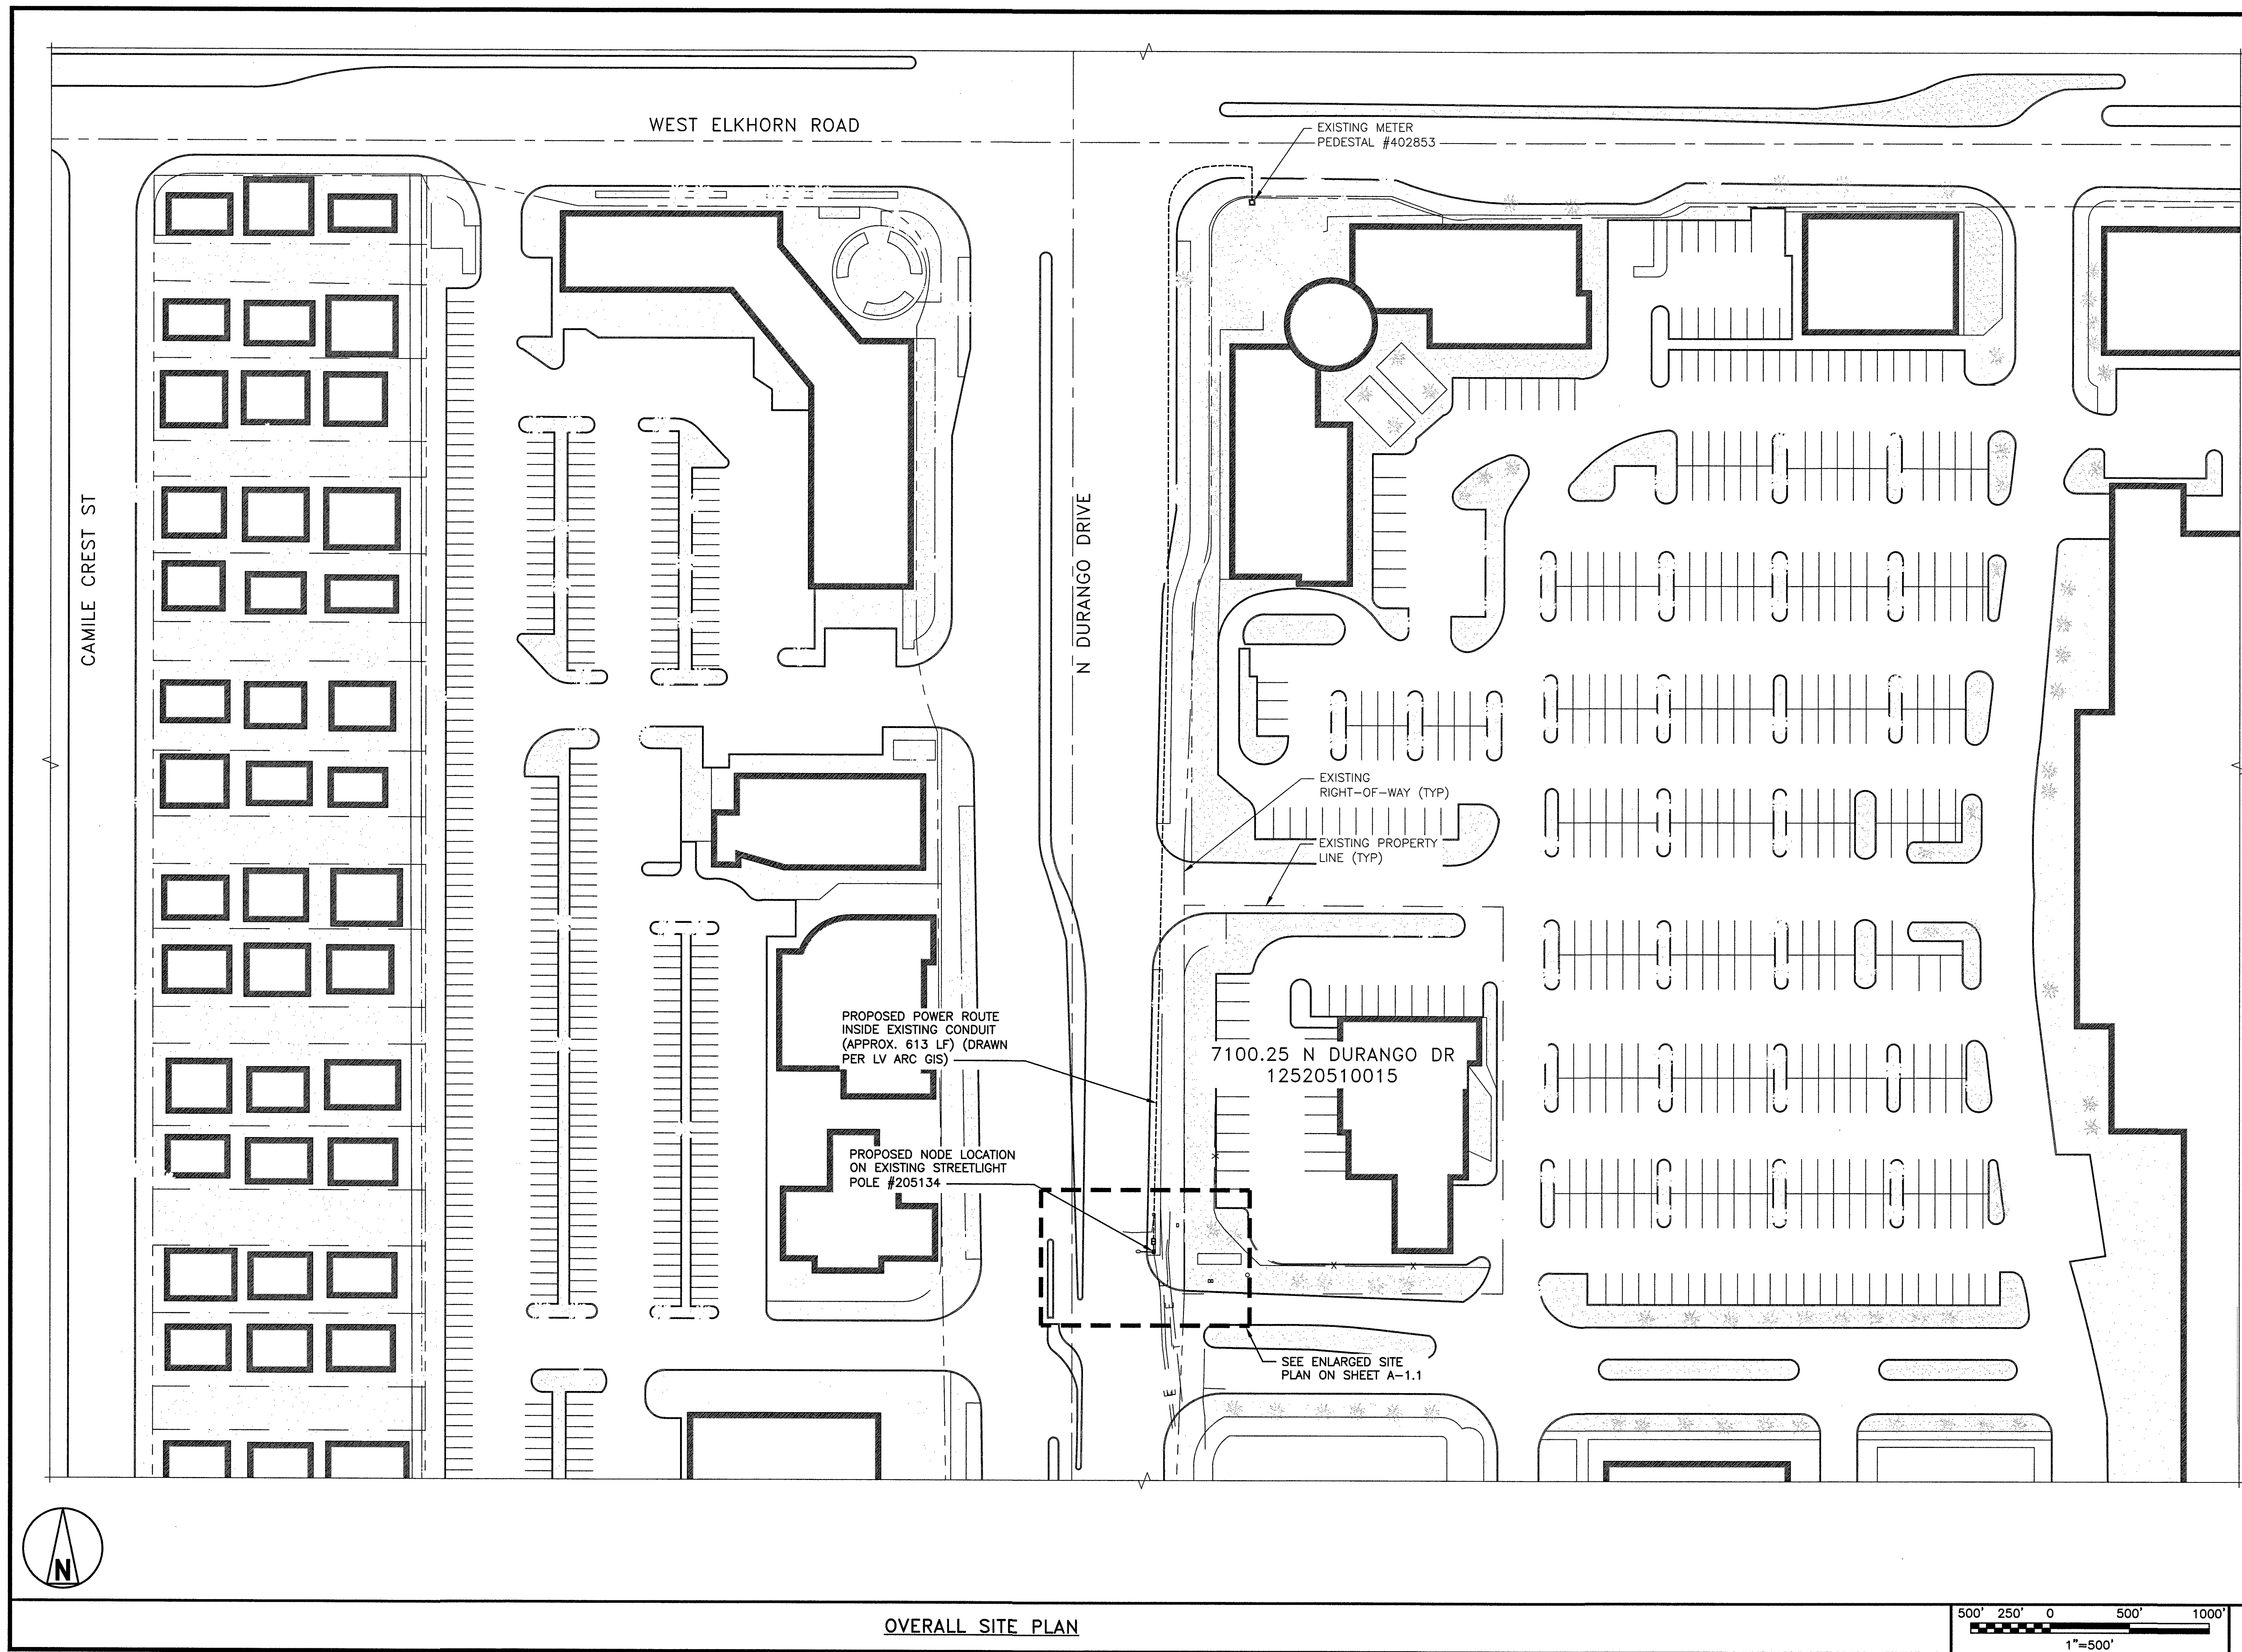


**BLACK & VEATCH**

BLACK & VEATCH CORPORATION  
7760 FRANCE AVENUE SOUTH  
SUITE 1200  
BLOOMINGTON, MN 55435

THESE DRAWINGS ARE COPYRIGHTED AND ARE THE PROPERTY OF BLACK & VEATCH; PRODUCED SOLELY FOR THE USE OF OUR CLIENT. ANY REPRODUCTION OR USE OF THE INFORMATION CONTAINED WITHIN SAID DRAWINGS IS PROHIBITED WITHOUT WRITTEN CONSENT BY BLACK & VEATCH.

| PROJECT NO. | DRAWN BY | CHECKED BY |
|-------------|----------|------------|
| 199064.2051 | MSC      | LEW        |

| REV | DATE     | DESCRIPTION             |
|-----|----------|-------------------------|
| 0   | 12/05/18 | ISSUED FOR CONSTRUCTION |

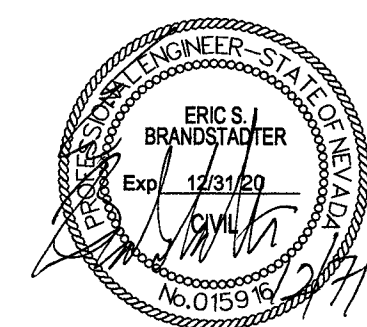

IT IS A VIOLATION OF LAW FOR ANY PERSON, UNLESS THEY ARE ACTING UNDER THE DIRECTION OF A LICENSED PROFESSIONAL ENGINEER, TO ALTER THIS DOCUMENT.

SITE ADDRESS


33AT0104SMC  
CRAN\_NVLO8145F\_R01  
7100.25 N DURANGO DR  
LAS VEGAS, NV 89149  
SMALL CELL

SHEET TITLE




OVERALL SITE PLAN

SHEET NUMBER


**A-1**

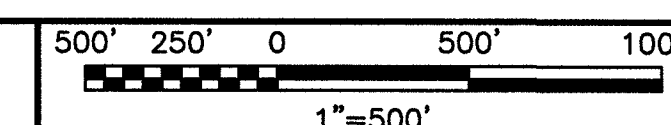

 THE PURPOSE OF THIS DRAWING IS  
TO SHOW HOW THE DEVELOPED SITE  
RELATES TO THE PARENT PARCEL  
AND ADJACENT PROPERTIES.

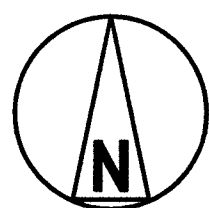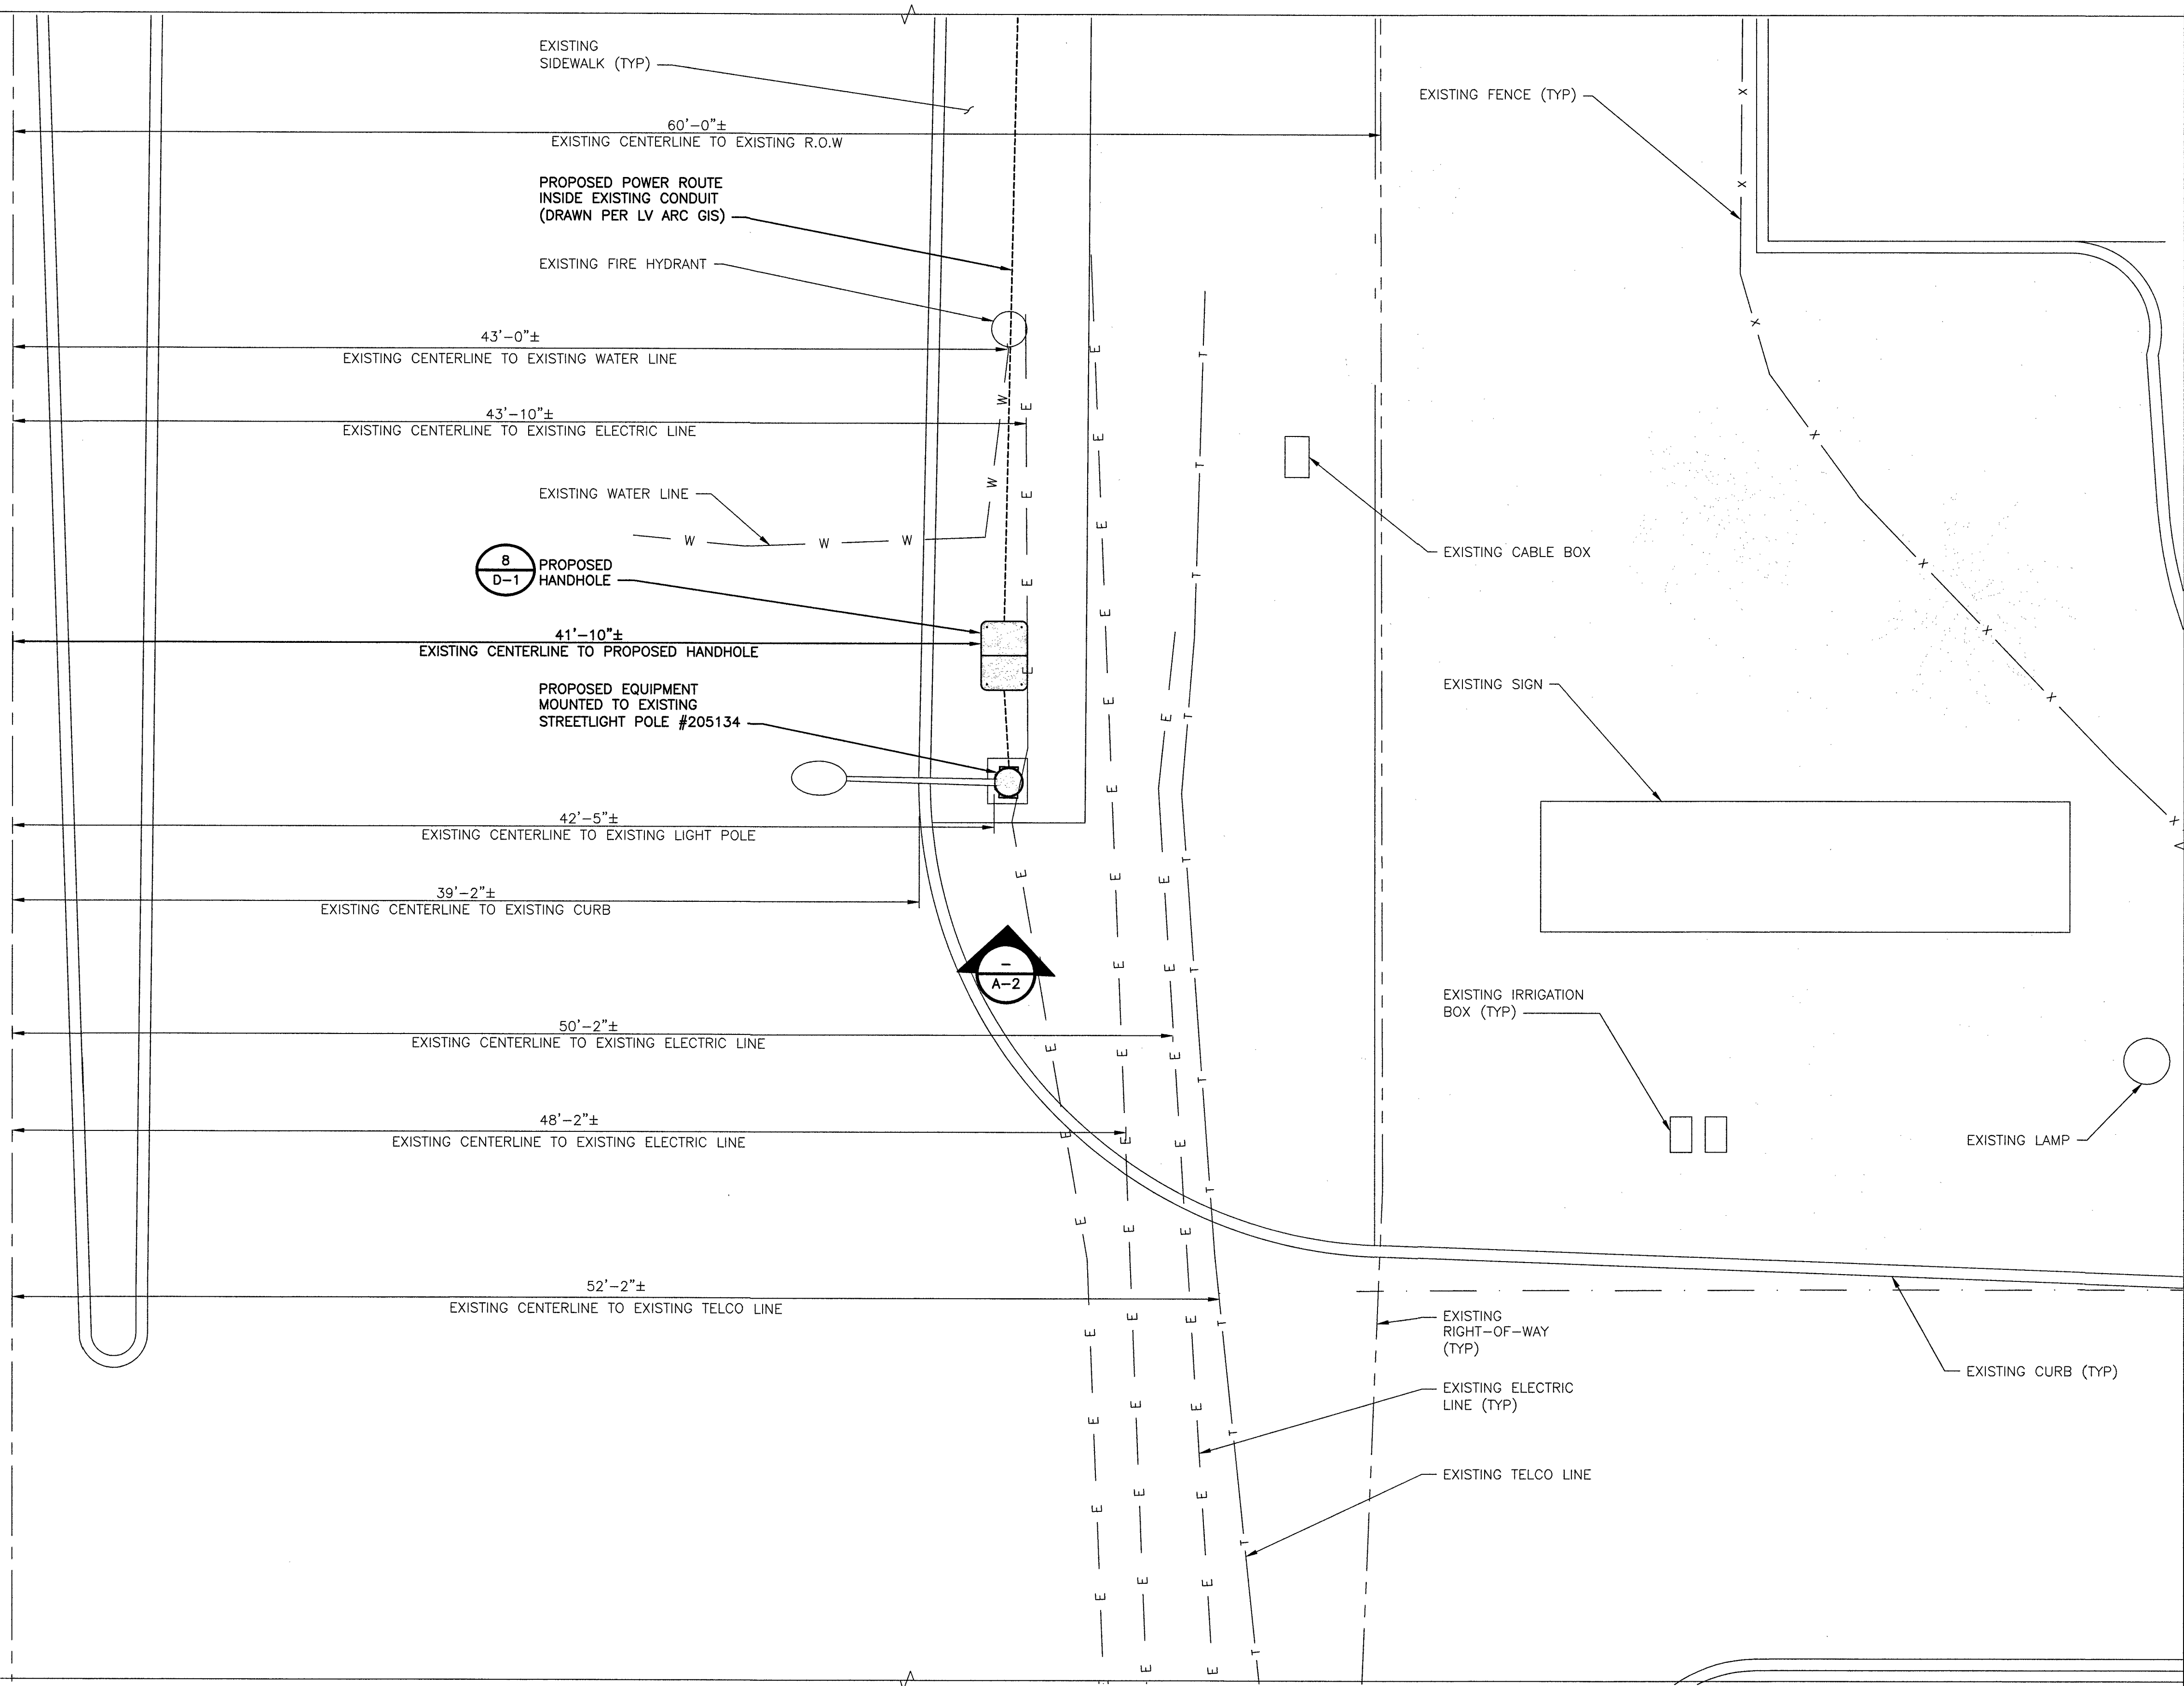

ENLARGED SITE PLAN

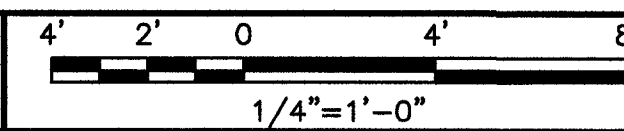

•




**BLACK & VEATCH**

BLACK & VEATCH CORPORATION  
7760 FRANCE AVENUE SOUTH  
SUITE 1200  
BLOOMINGTON, MN 55435

THESE DRAWINGS ARE COPYRIGHTED AND ARE THE PROPERTY OF BLACK & VEATCH; PRODUCED SOLELY FOR THE USE OF OUR CLIENT. ANY REPRODUCTION OR USE OF THE INFORMATION CONTAINED WITHIN SAID DRAWINGS IS PROHIBITED WITHOUT WRITTEN CONSENT BY BLACK & VEATCH.

|             |          |            |
|-------------|----------|------------|
| PROJECT NO. | DRAWN BY | CHECKED BY |
| 199064.2051 | MSC      | LEW        |

|     |          |                         |
|-----|----------|-------------------------|
|     |          |                         |
|     |          |                         |
| 0   | 12/05/18 | ISSUED FOR CONSTRUCTION |
| REV | DATE     | DESCRIPTION             |

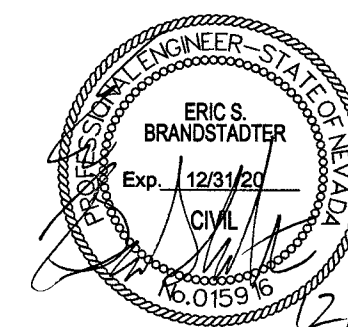

IT IS A VIOLATION OF LAW FOR ANY PERSON,  
UNLESS THEY ARE ACTING UNDER THE DIRECTION  
OF A LICENSED PROFESSIONAL ENGINEER,  
TO ALTER THIS DOCUMENT.

SITE ADDRESS




33AT0104SMC  
CRAN\_NVL08145F\_R01  
7100.25 N DURANGO DR  
LAS VEGAS, NV 89149  
SMALL CELL

SHEET TITLE

ENLARGED SITE PLAN

SHEET NUMBER

## A-1.1

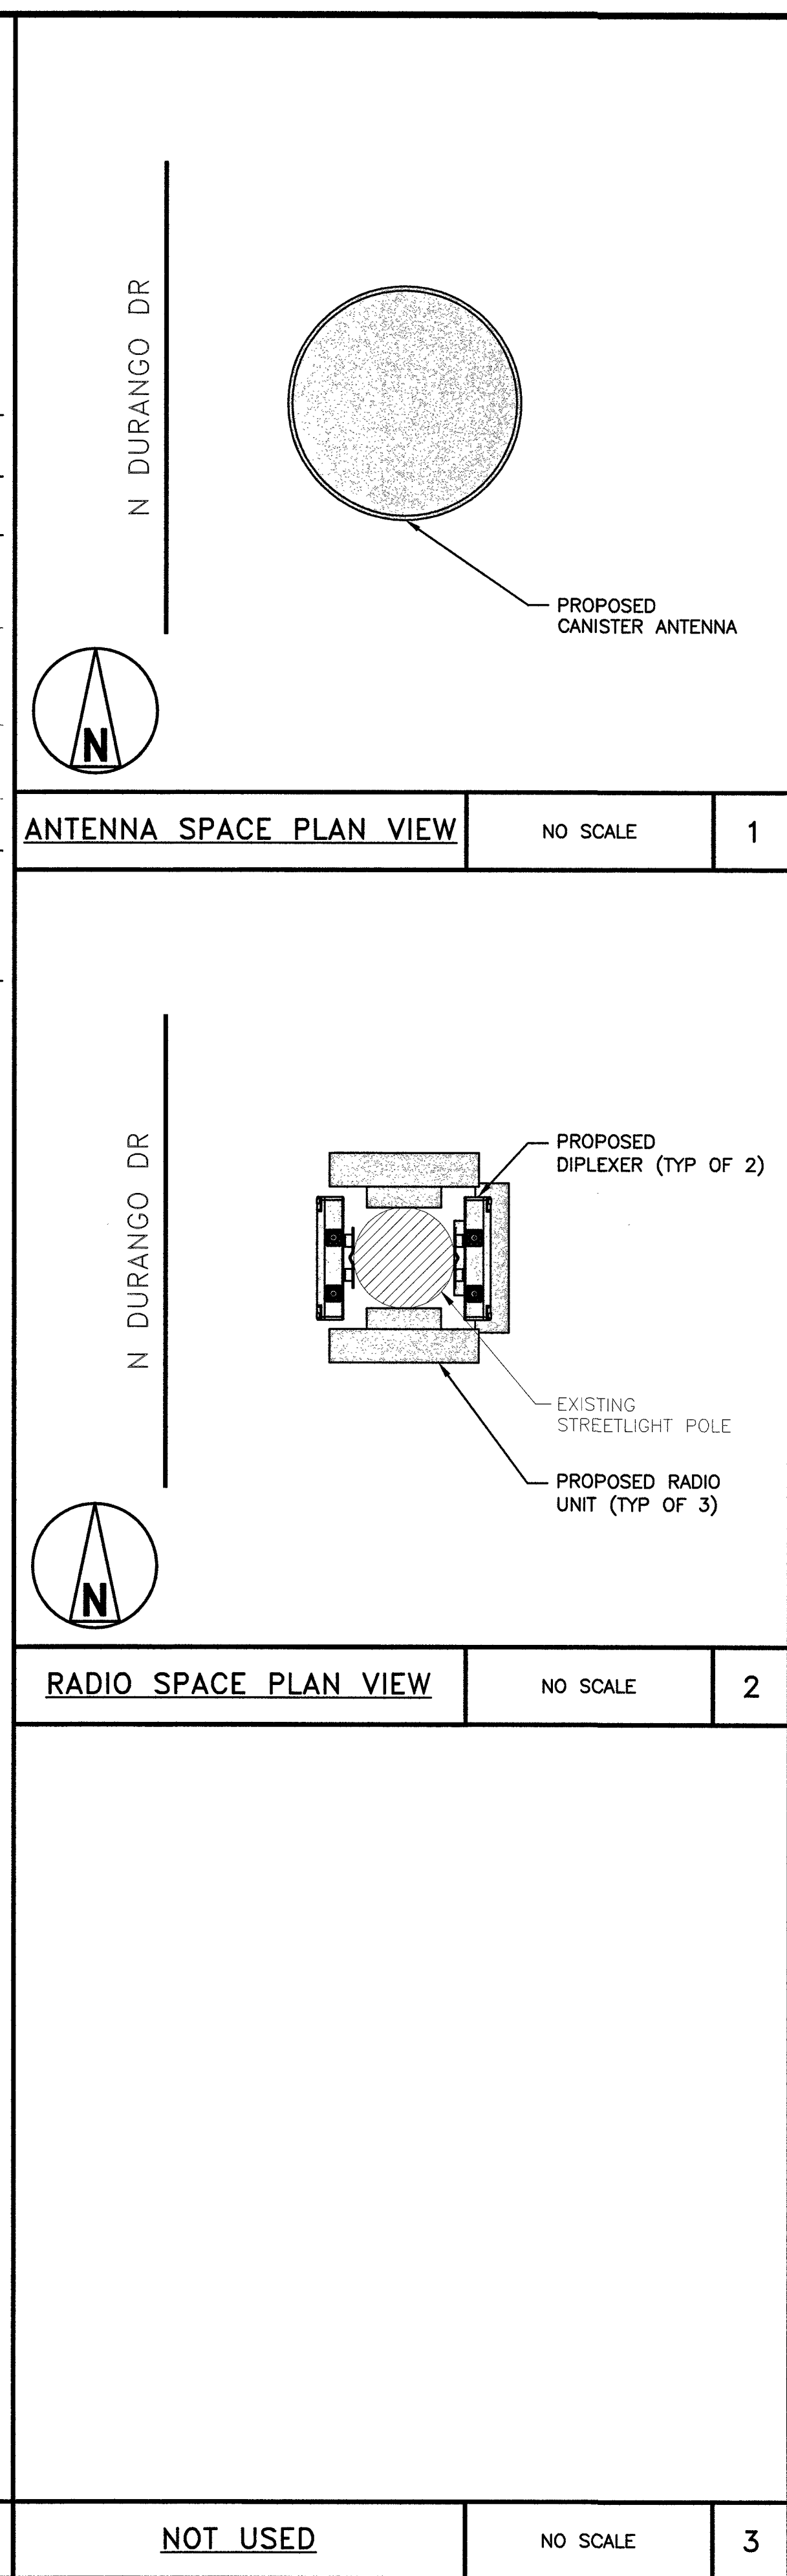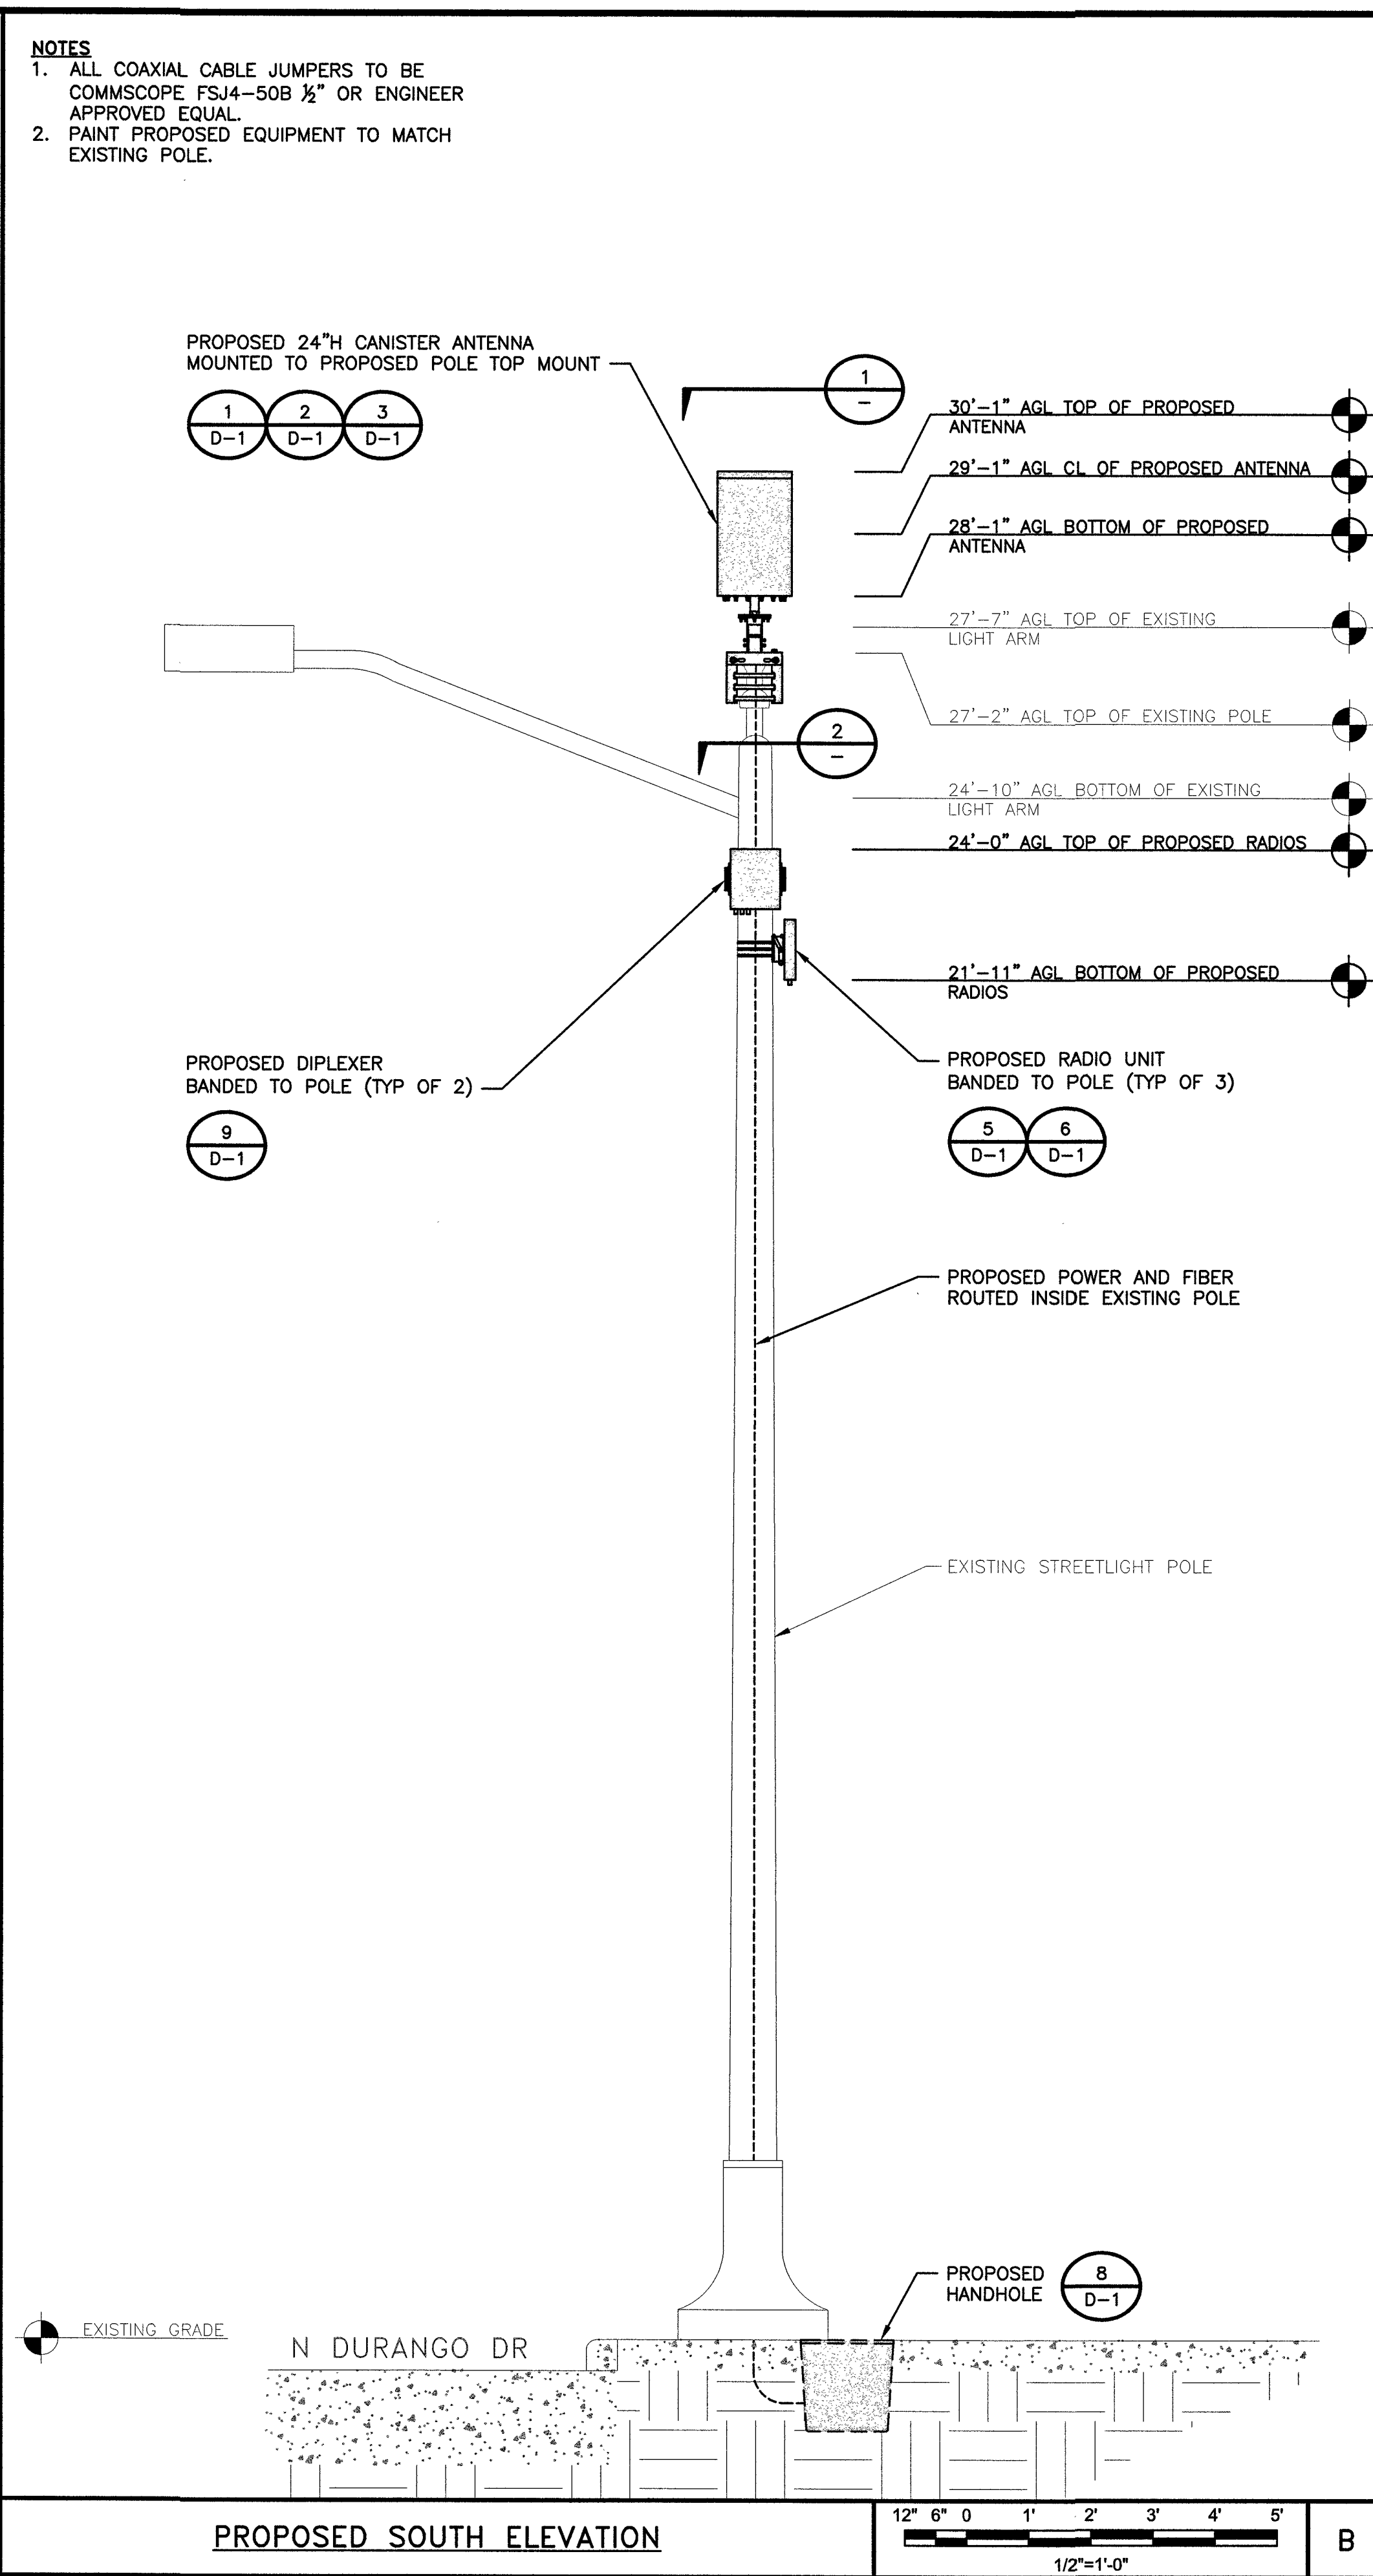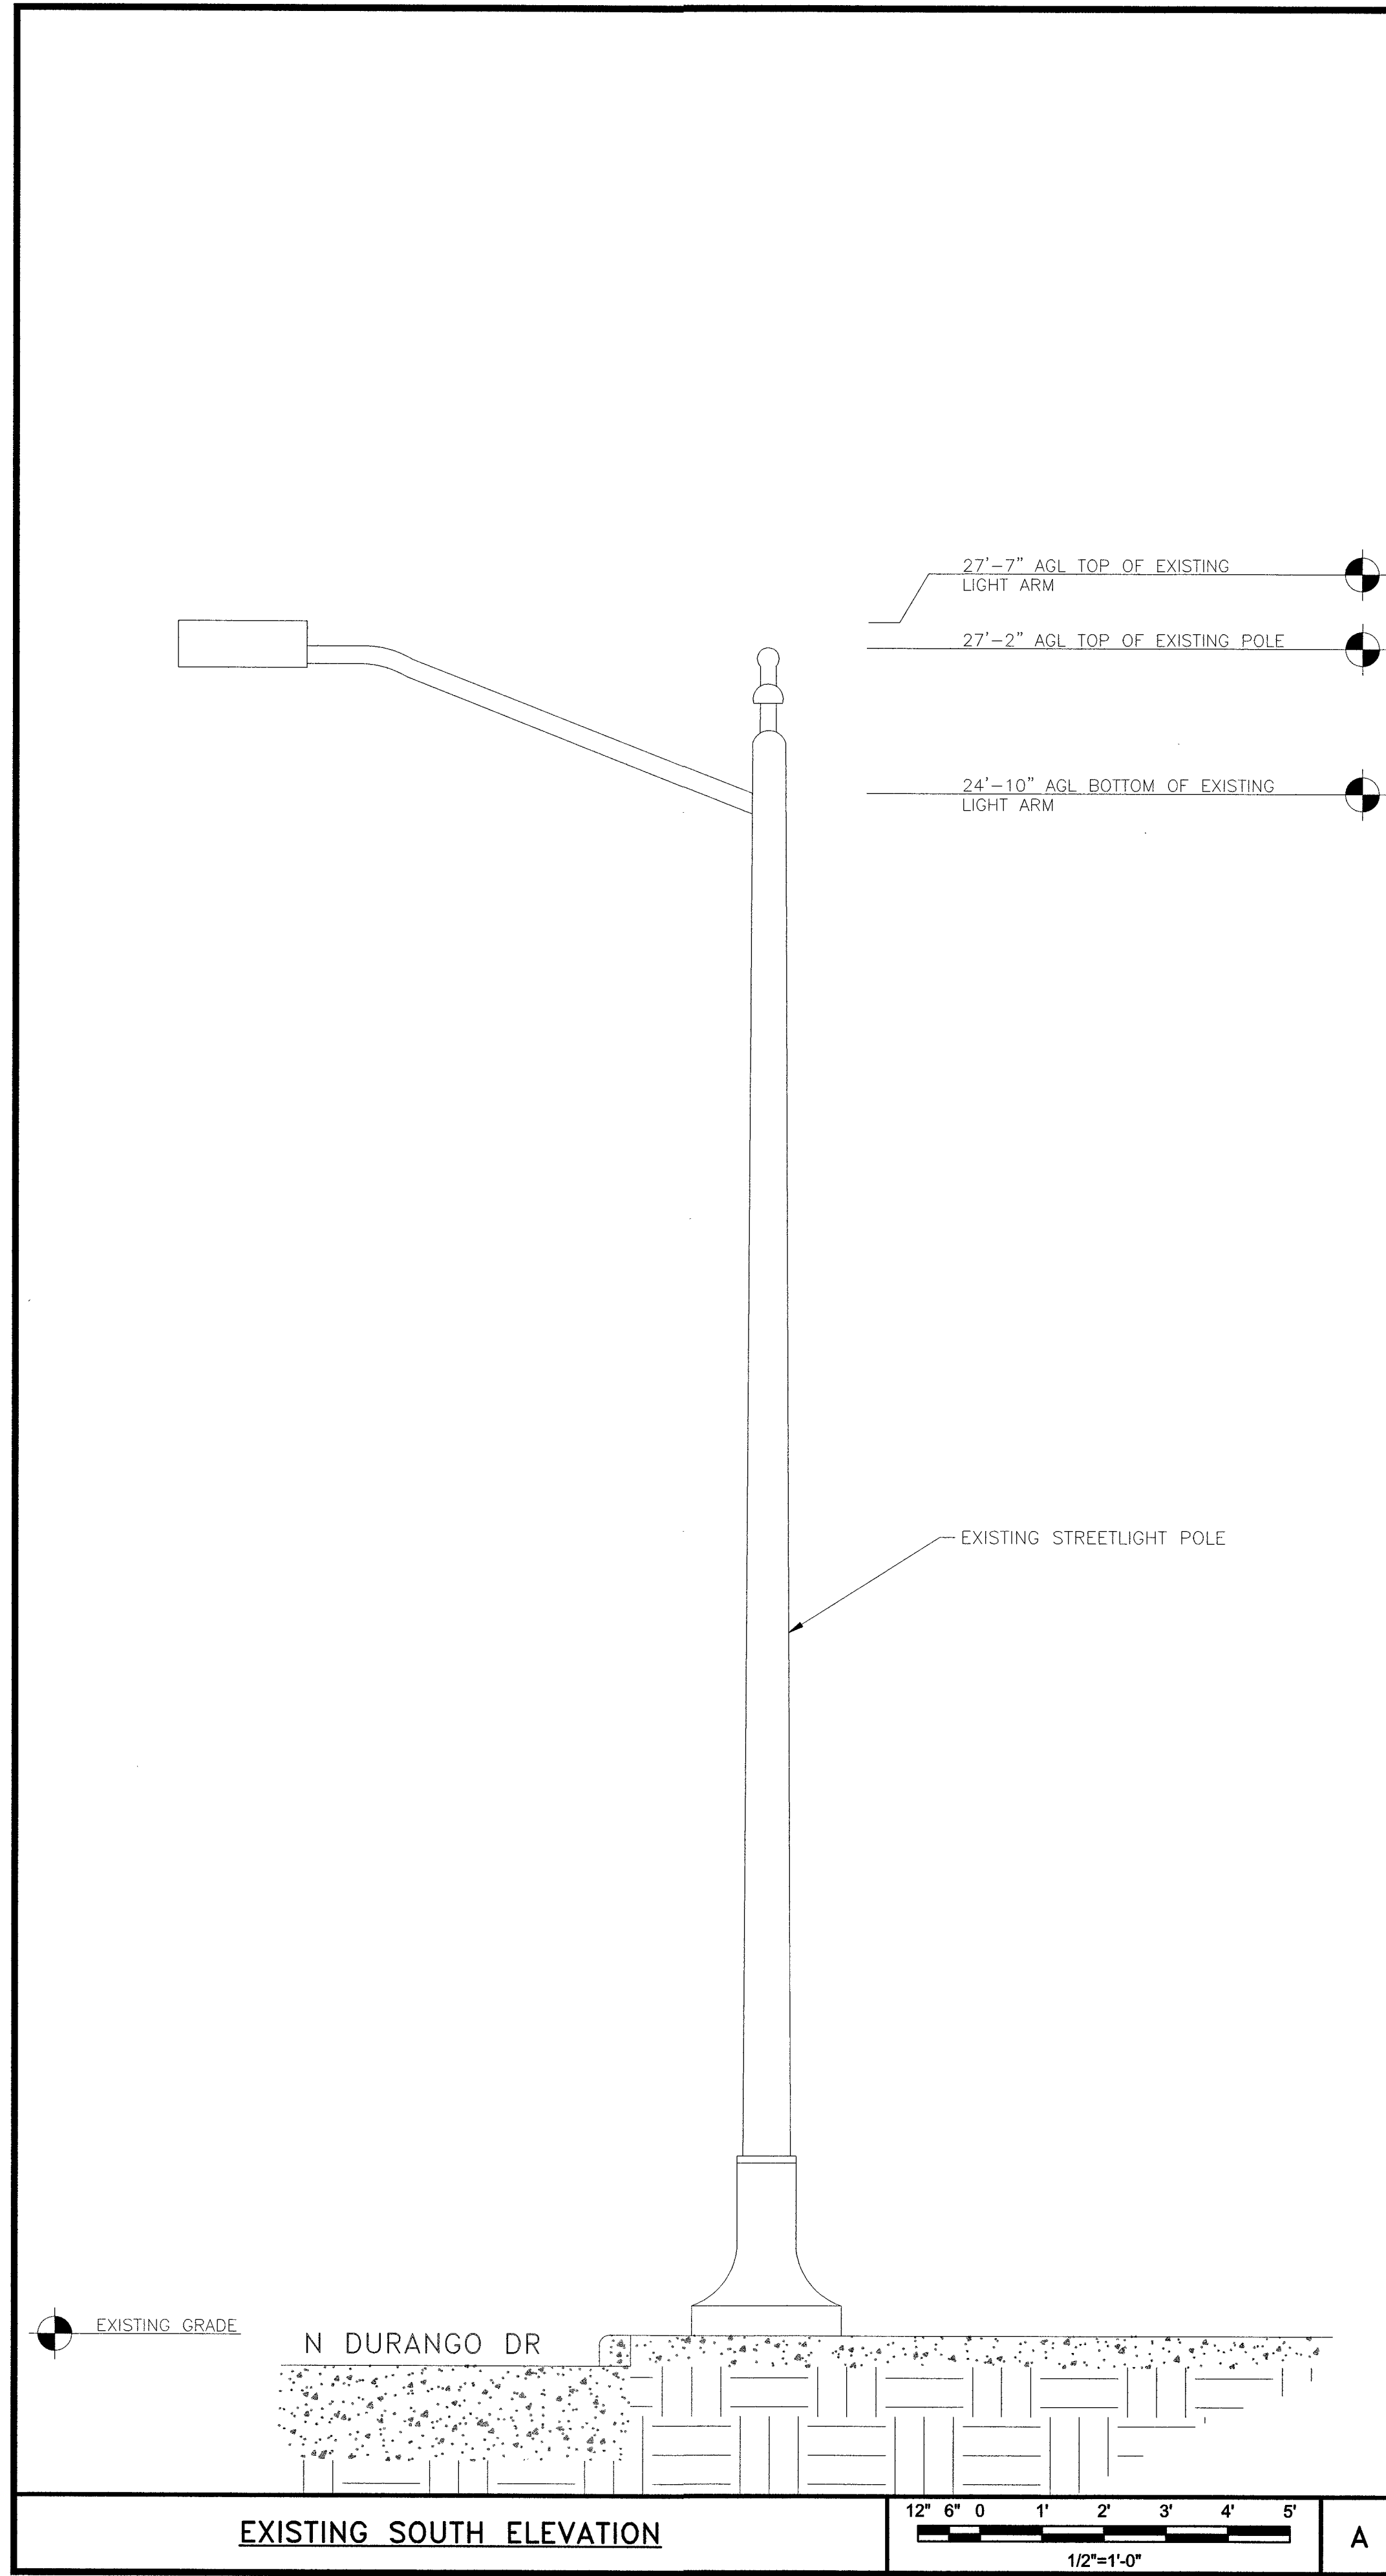






**BLACK & VEATCH**

BLACK & VEATCH CORPORATION  
7760 FRANCE AVENUE SOUTH  
SUITE 1200  
BLOOMINGTON, MN 55435

THESE DRAWINGS ARE COPYRIGHTED AND ARE THE PROPERTY OF BLACK & VEATCH; PRODUCED SOLELY FOR THE USE OF OUR CLIENT. ANY REPRODUCTION OR USE OF THE INFORMATION CONTAINED WITHIN SAID DRAWINGS IS PROHIBITED WITHOUT WRITTEN CONSENT BY BLACK & VEATCH.

| PROJECT NO. | DRAWN BY | CHECKED BY |
|-------------|----------|------------|
| 199064.2051 | MSC      | LEW        |

| REV | DATE     | DESCRIPTION             |
|-----|----------|-------------------------|
| 0   | 12/05/18 | ISSUED FOR CONSTRUCTION |

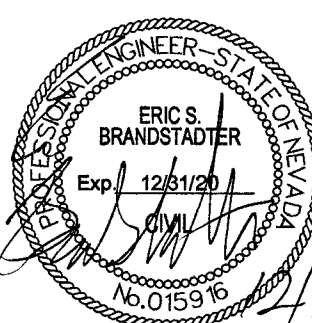

IT IS A VIOLATION OF LAW FOR ANY PERSON, UNLESS THEY ARE ACTING UNDER THE DIRECTION OF A LICENSED PROFESSIONAL ENGINEER, TO ALTER THIS DOCUMENT.

SITE ADDRESS


33AT0104SMC  
CRAN\_NVLO8145F\_R01  
7100.25 N DURANGO DR  
LAS VEGAS, NV 89149  
SMALL CELL

SHEET TITLE

ELEVATIONS

SHEET NUMBER

**A-2**

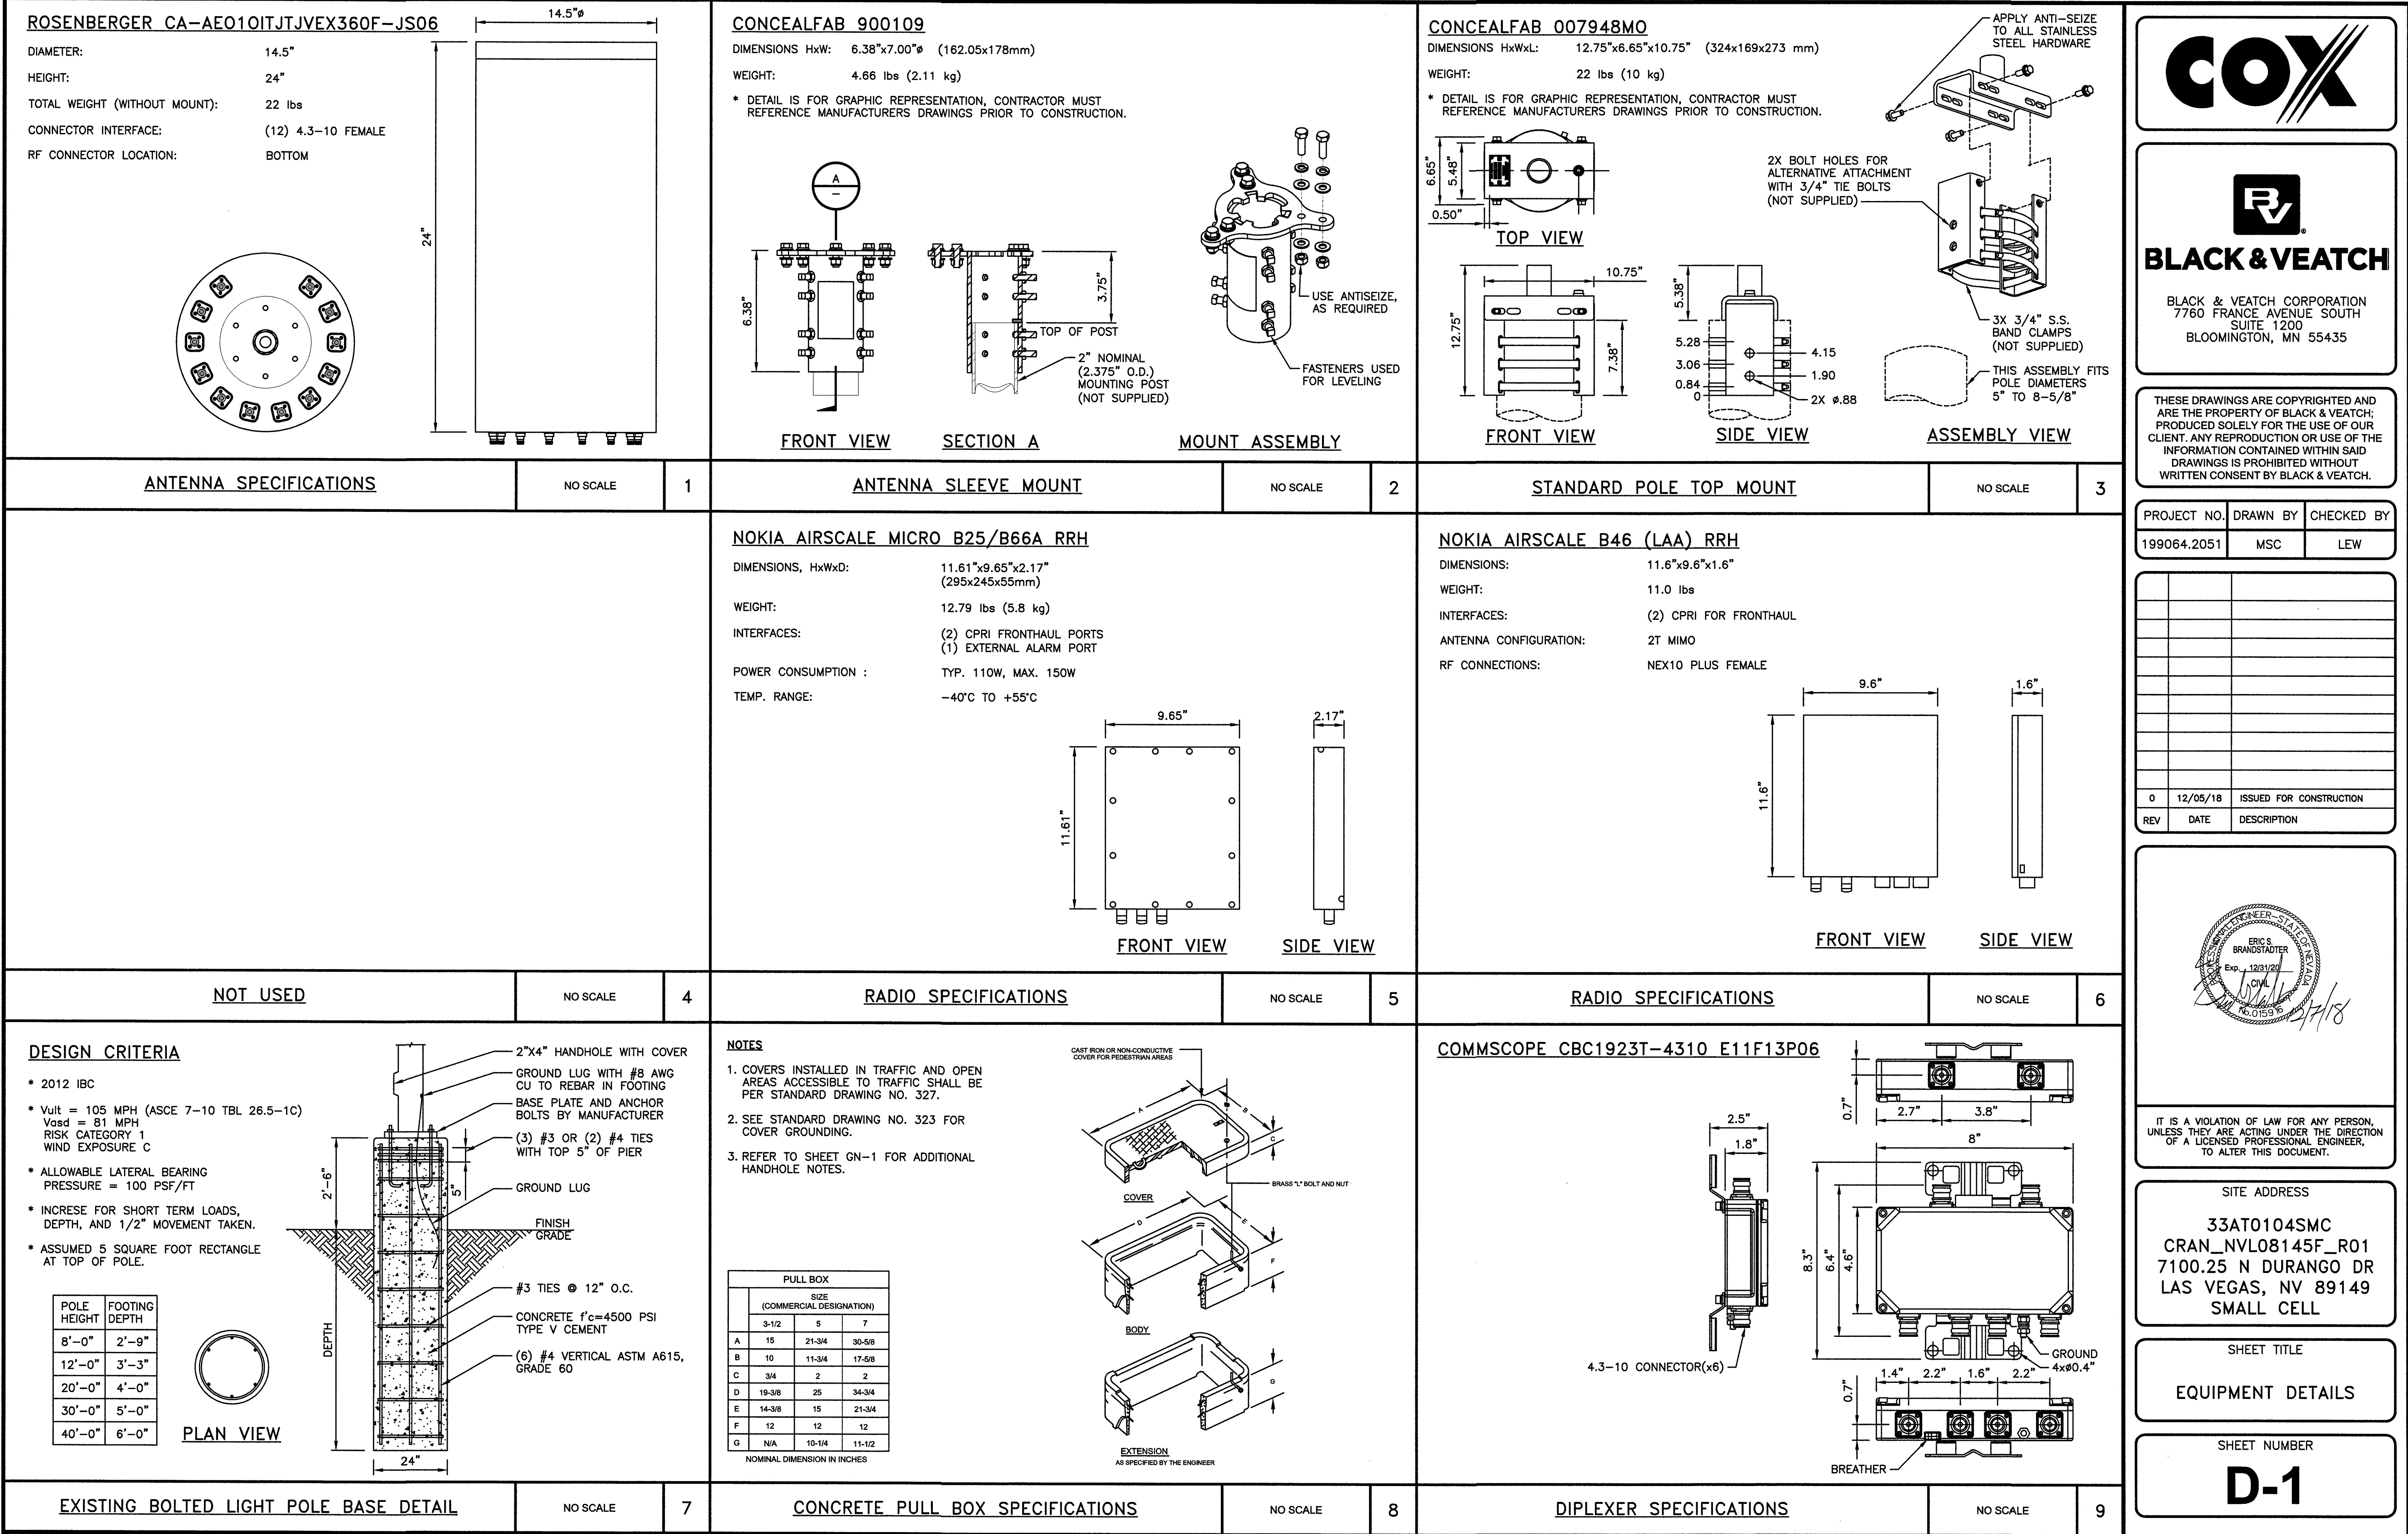

**CAUTION**  
**STAY BACK 3 ft.**  
TO PREVENT  
RADIO FREQUENCY  
EXPOSURES ABOVE FCC  
LIMITS. CALL NOC  
1-877-897-2476  
TO POWER DOWN.  
SITE ID: 33AT0104SMC


**NOTICE**  
**SMALL CELL SHUT OFF SWITCH**  
Push switch button turn off radio  
while working within 3 ft. of the  
device  
Note: Once work is completed  
turn switch back on

RF WARNING PLACARDS

NO SCALE

1

MULTI-TAP CONNECTOR WITH CLEAR INSULATION,  
DOUBLE-SIDED (PCSB4-4-6Y)

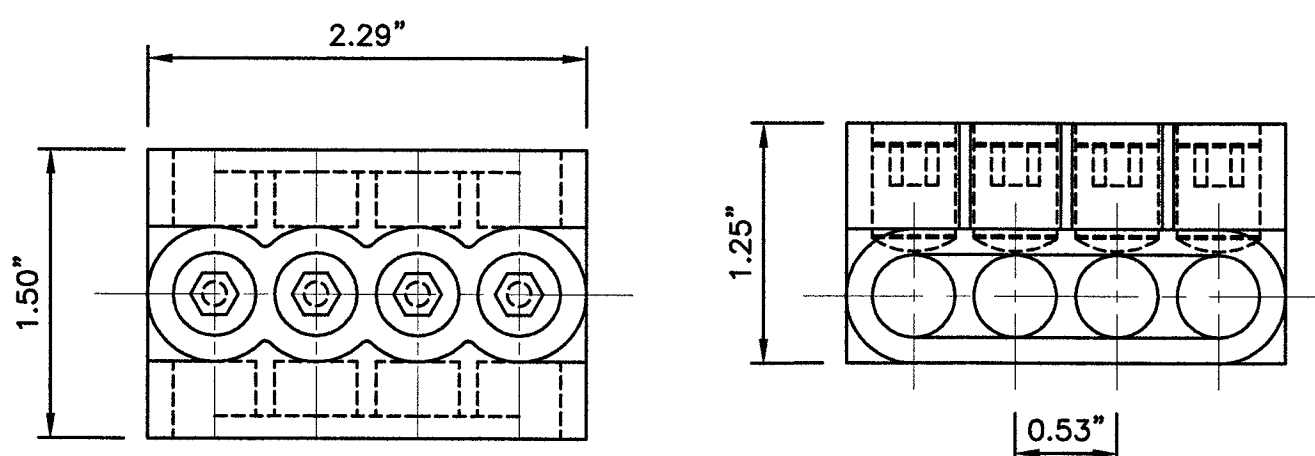


CONNECTOR DETAIL

NO SCALE

2

BUSSMAN HEB-AW-RLC-A

DIMENSIONS, LENGTH: 4.4"  
WIRE RANGE: #8-16; (2) #12-16

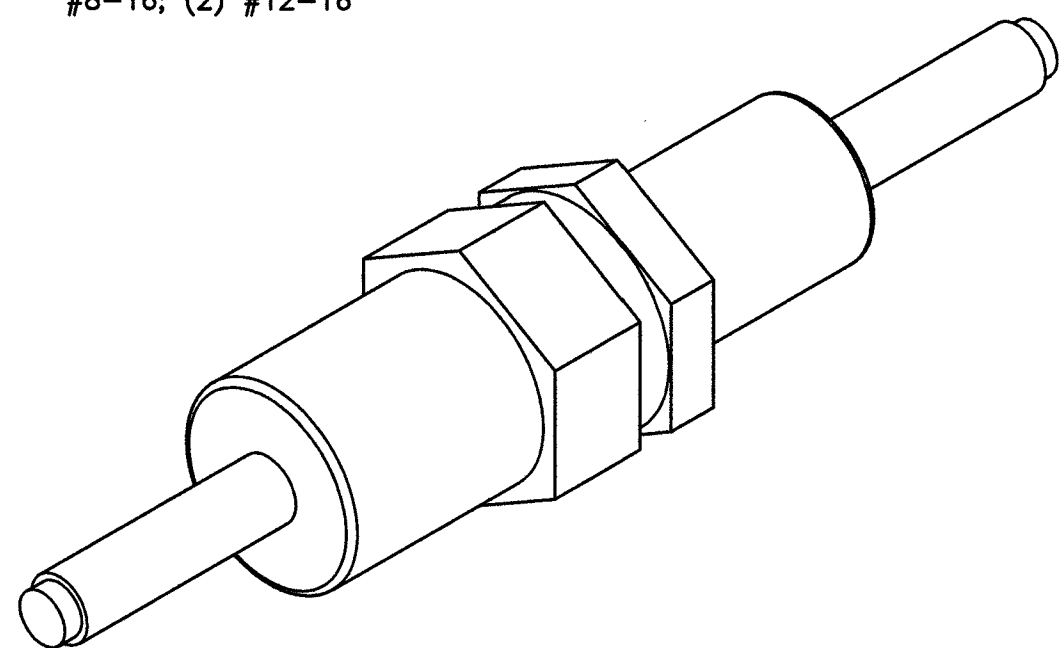

BREAKAWAY FUSE DETAIL

NO SCALE


3

NOTES

- CONTRACTOR IS TO FIELD VERIFY ALL EXISTING ITEMS SHOWN ON THE ELCTRICAL ONE-LINE DIAGRAM AND NOTIFY THE ENGINEER OF ANY DISCREPANCIES.
- ALL NEW CONDUCTOR WIRE TO BE INSTALLED SHALL BE COPPER THWN-2, THW-2, RHW-2, XHHW-2 WIRE UNLESS NOTED OTHERWISE.
- ALL GROUNDING AND BONDING TO BE PER THE RECOGNIZED EDITION OF THE NATIONAL ELECTRIC CODE (NEC).
- ALL INSTALLED CONDUCTORS AND SIGNAL CABLES TO BE CLEARLY MARKED "COX COMMUNICATIONS" WITH BRASS OR FIBERGLASS TAGS.

120VAC FEEDER CONDUCTOR  
MAXIMUM DISTANCE

|         |         |                      |
|---------|---------|----------------------|
| #12 AWG | 385'-0" | 3% VOLT DROP @ 2.34A |
| #10 AWG | 642'-0" | 3% VOLT DROP @ 2.34A |
| #8 AWG  | 987'-0" | 3% VOLT DROP @ 2.34A |

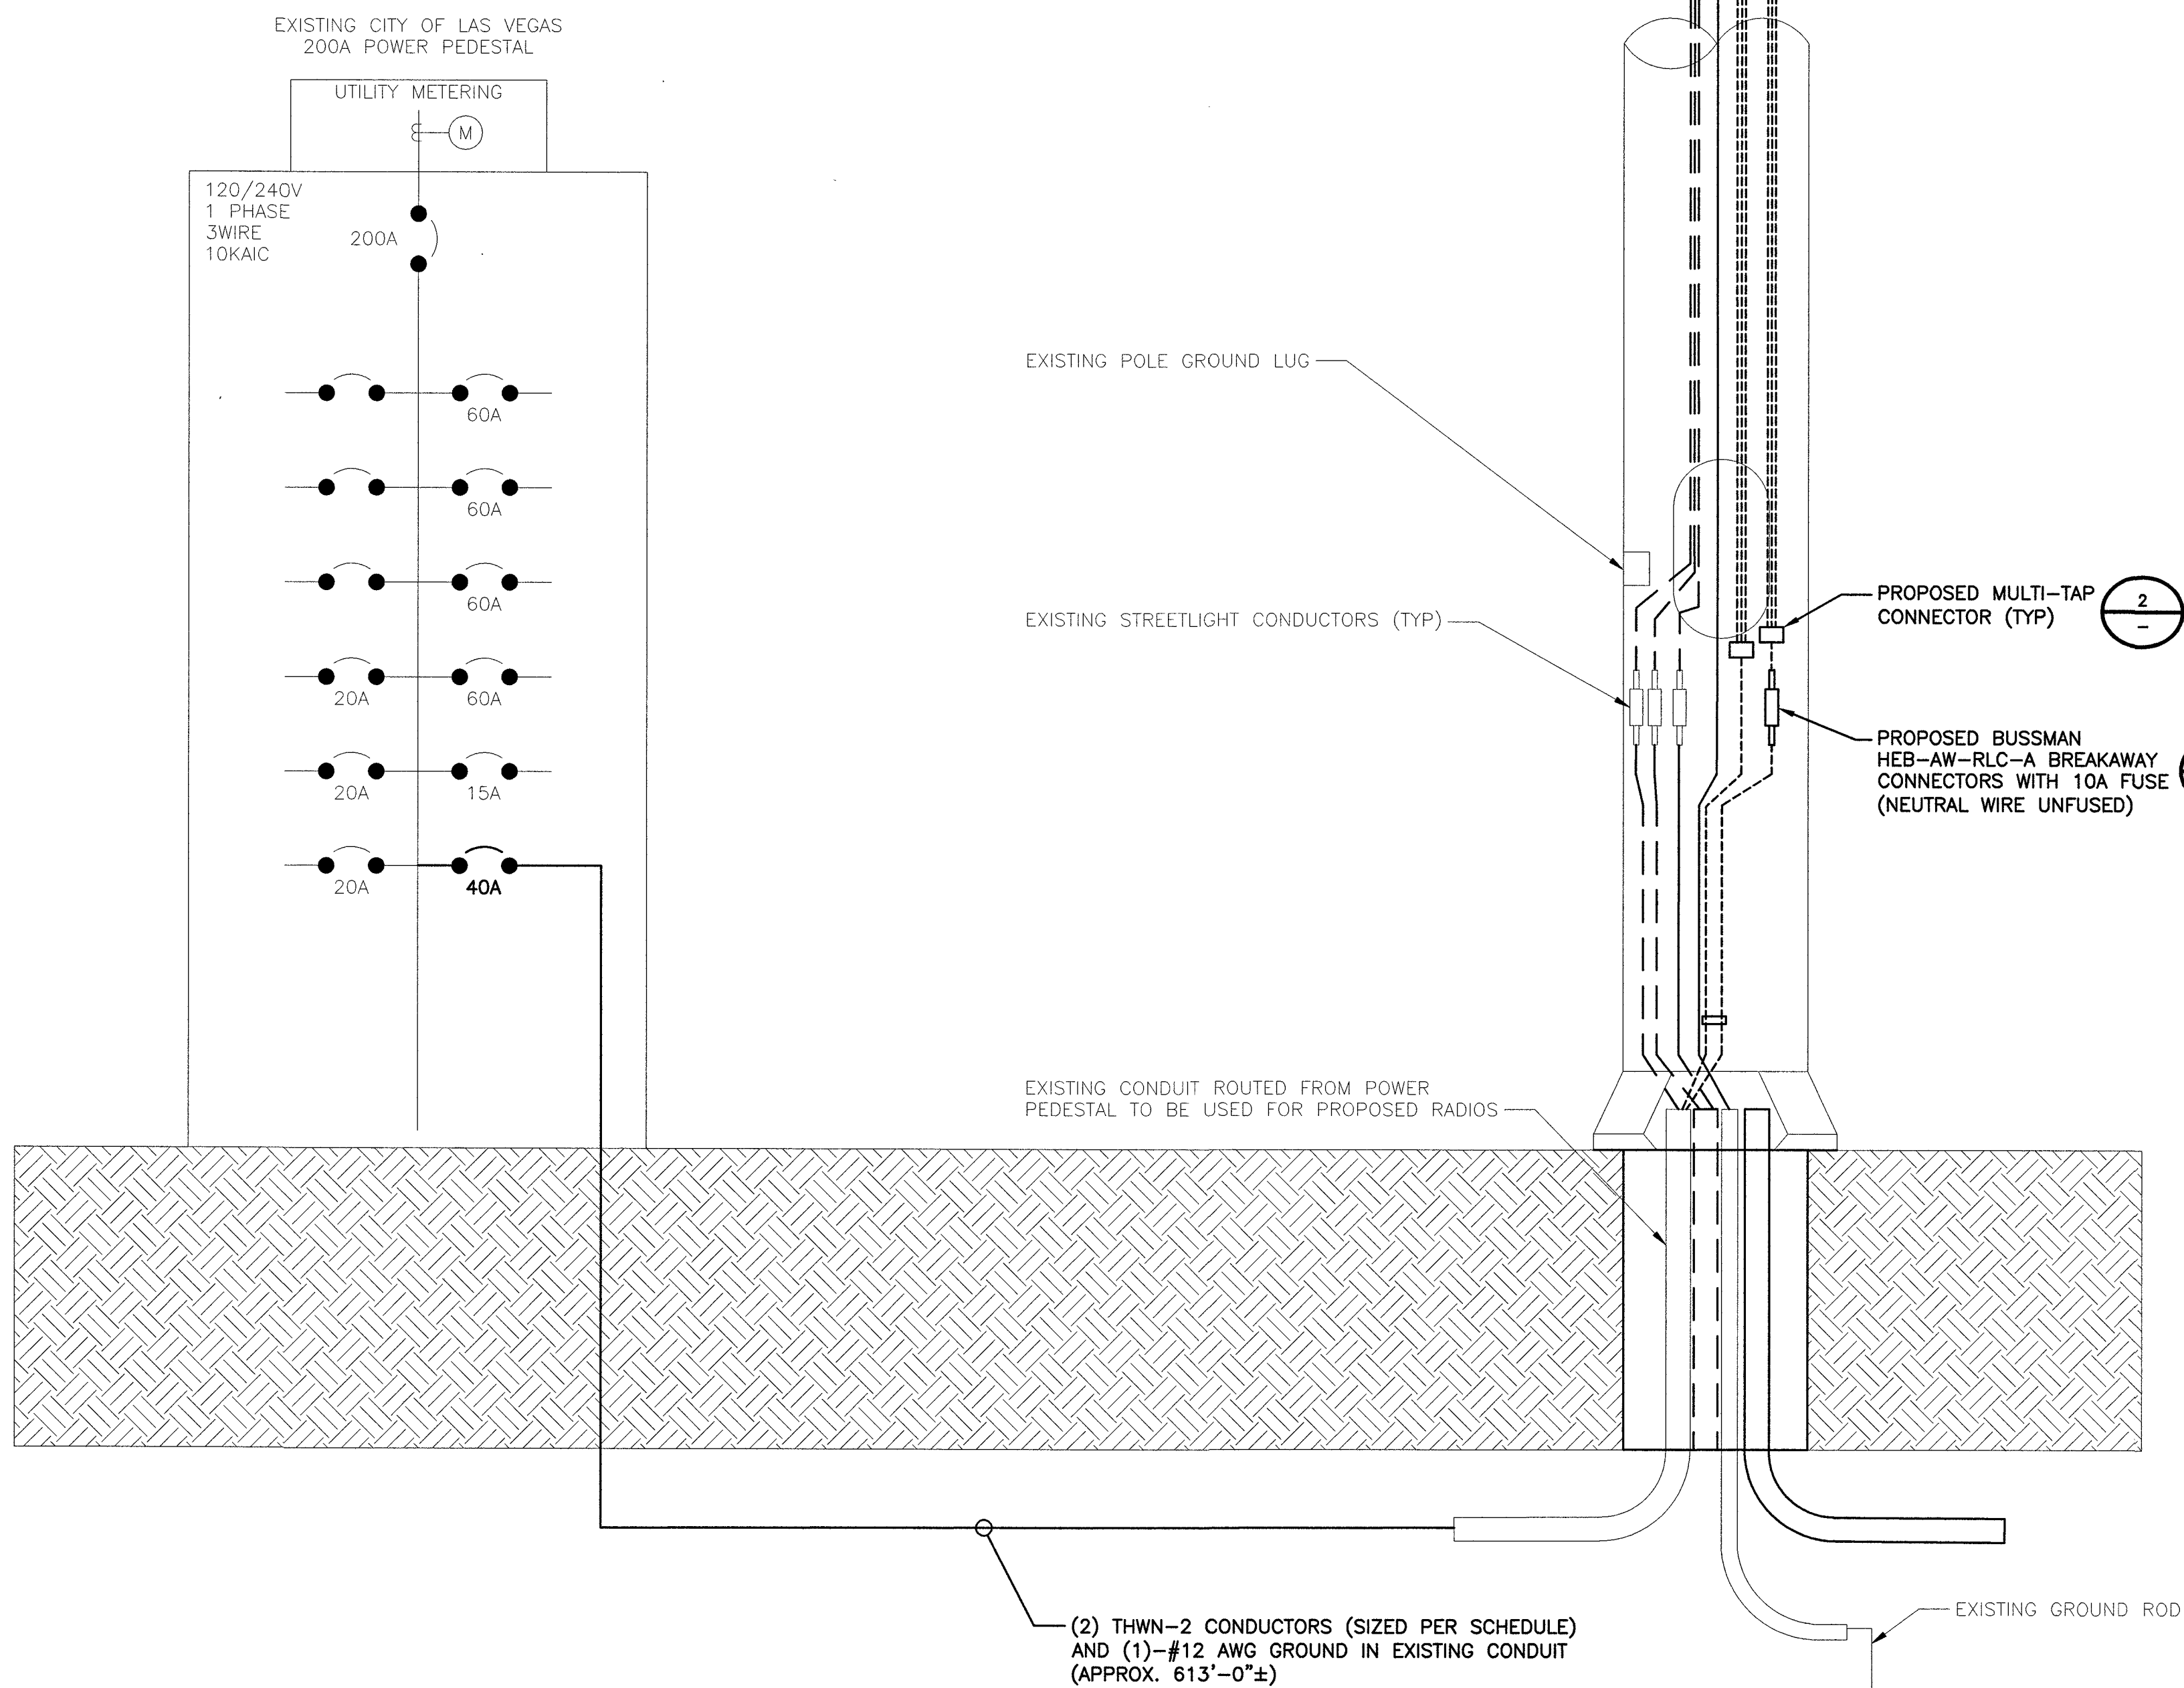

TYPICAL POLE SITE TEMPLATE

NO SCALE

4




BLACK & VEATCH

BLACK & VEATCH CORPORATION  
7760 FRANCE AVENUE SOUTH  
SUITE 1200  
BLOOMINGTON, MN 55435

THESE DRAWINGS ARE COPYRIGHTED AND  
ARE THE PROPERTY OF BLACK & VEATCH;  
PRODUCED SOLELY FOR THE USE OF OUR  
CLIENT. ANY REPRODUCTION OR USE OF THE  
INFORMATION CONTAINED WITHIN SAID  
DRAWINGS IS PROHIBITED WITHOUT  
WRITTEN CONSENT BY BLACK & VEATCH.

| PROJECT NO. | DRAWN BY | CHECKED BY |
|-------------|----------|------------|
| 199064.2051 | MSC      | LEW        |

| REV | DATE     | DESCRIPTION             |
|-----|----------|-------------------------|
| 0   | 12/05/18 | ISSUED FOR CONSTRUCTION |
| 1   |          |                         |
| 2   |          |                         |
| 3   |          |                         |
| 4   |          |                         |
| 5   |          |                         |
| 6   |          |                         |
| 7   |          |                         |
| 8   |          |                         |
| 9   |          |                         |

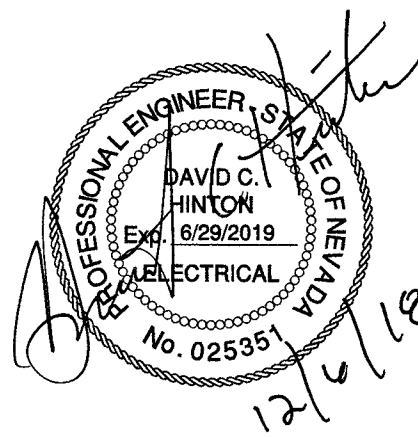

IT IS A VIOLATION OF LAW FOR ANY PERSON,  
UNLESS THEY ARE ACTING UNDER THE DIRECTION  
OF A LICENSED PROFESSIONAL ENGINEER,  
TO ALTER THIS DOCUMENT.

SITE ADDRESS


33AT0104SMC  
CRAN\_NVLO8145F\_R01  
7100.25 N DURANGO DR  
LAS VEGAS, NV 89149  
SMALL CELL

SHEET TITLE  
ELECTRICAL DETAILS  
AND DIAGRAMS


SHEET NUMBER

E-1

|                       |       |      |
|-----------------------|-------|------|
| EXISTING LOAD.....    | 16.15 | AMPS |
| ALLOWED LOAD 80%..... | 160   | AMPS |

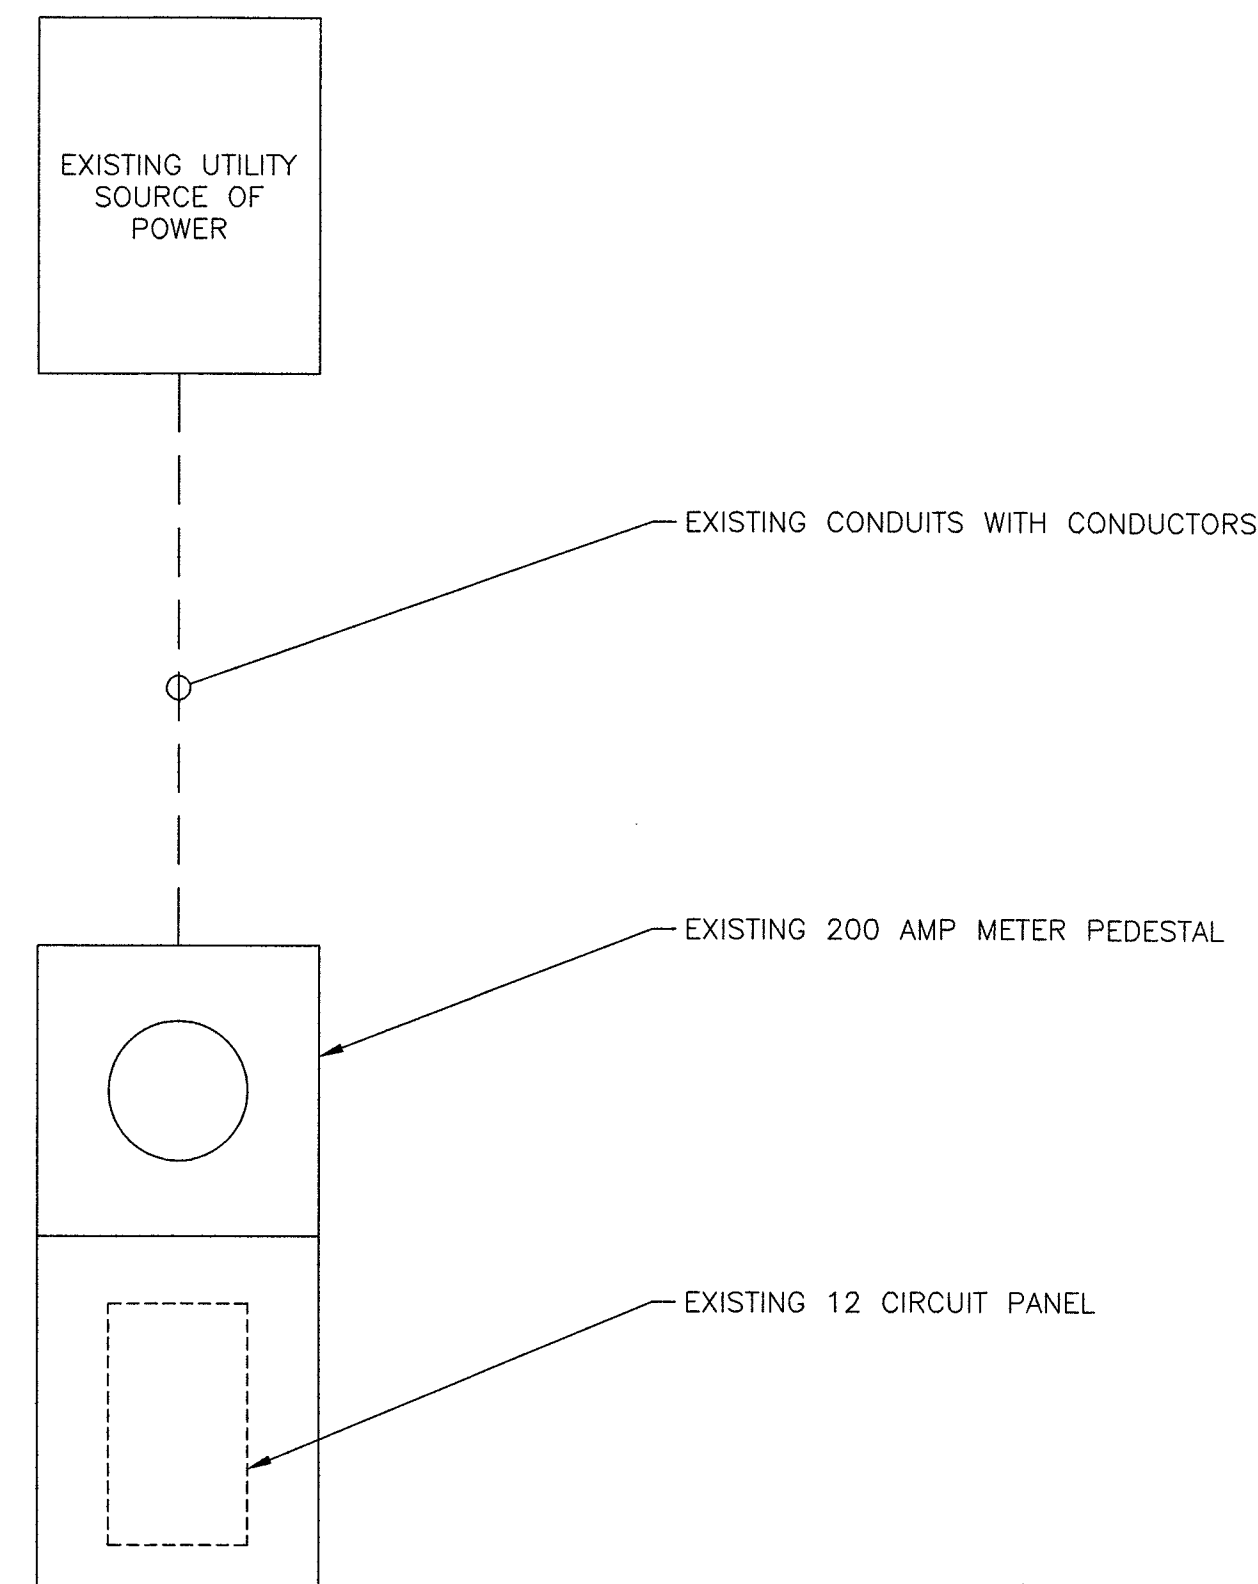

|                                   |            |
|-----------------------------------|------------|
| EXISTING LOAD.....                | 16.15 AMPS |
| SAFETY FACTOR 125%.....           | 20.19 AMPS |
| PROPOSED LOAD.....                | 2.34 AMPS  |
| TOTAL LOAD.....                   | 22.53 AMPS |
| ALLOWED LOAD 80% OF 200 AMPS..... | 160 AMPS   |

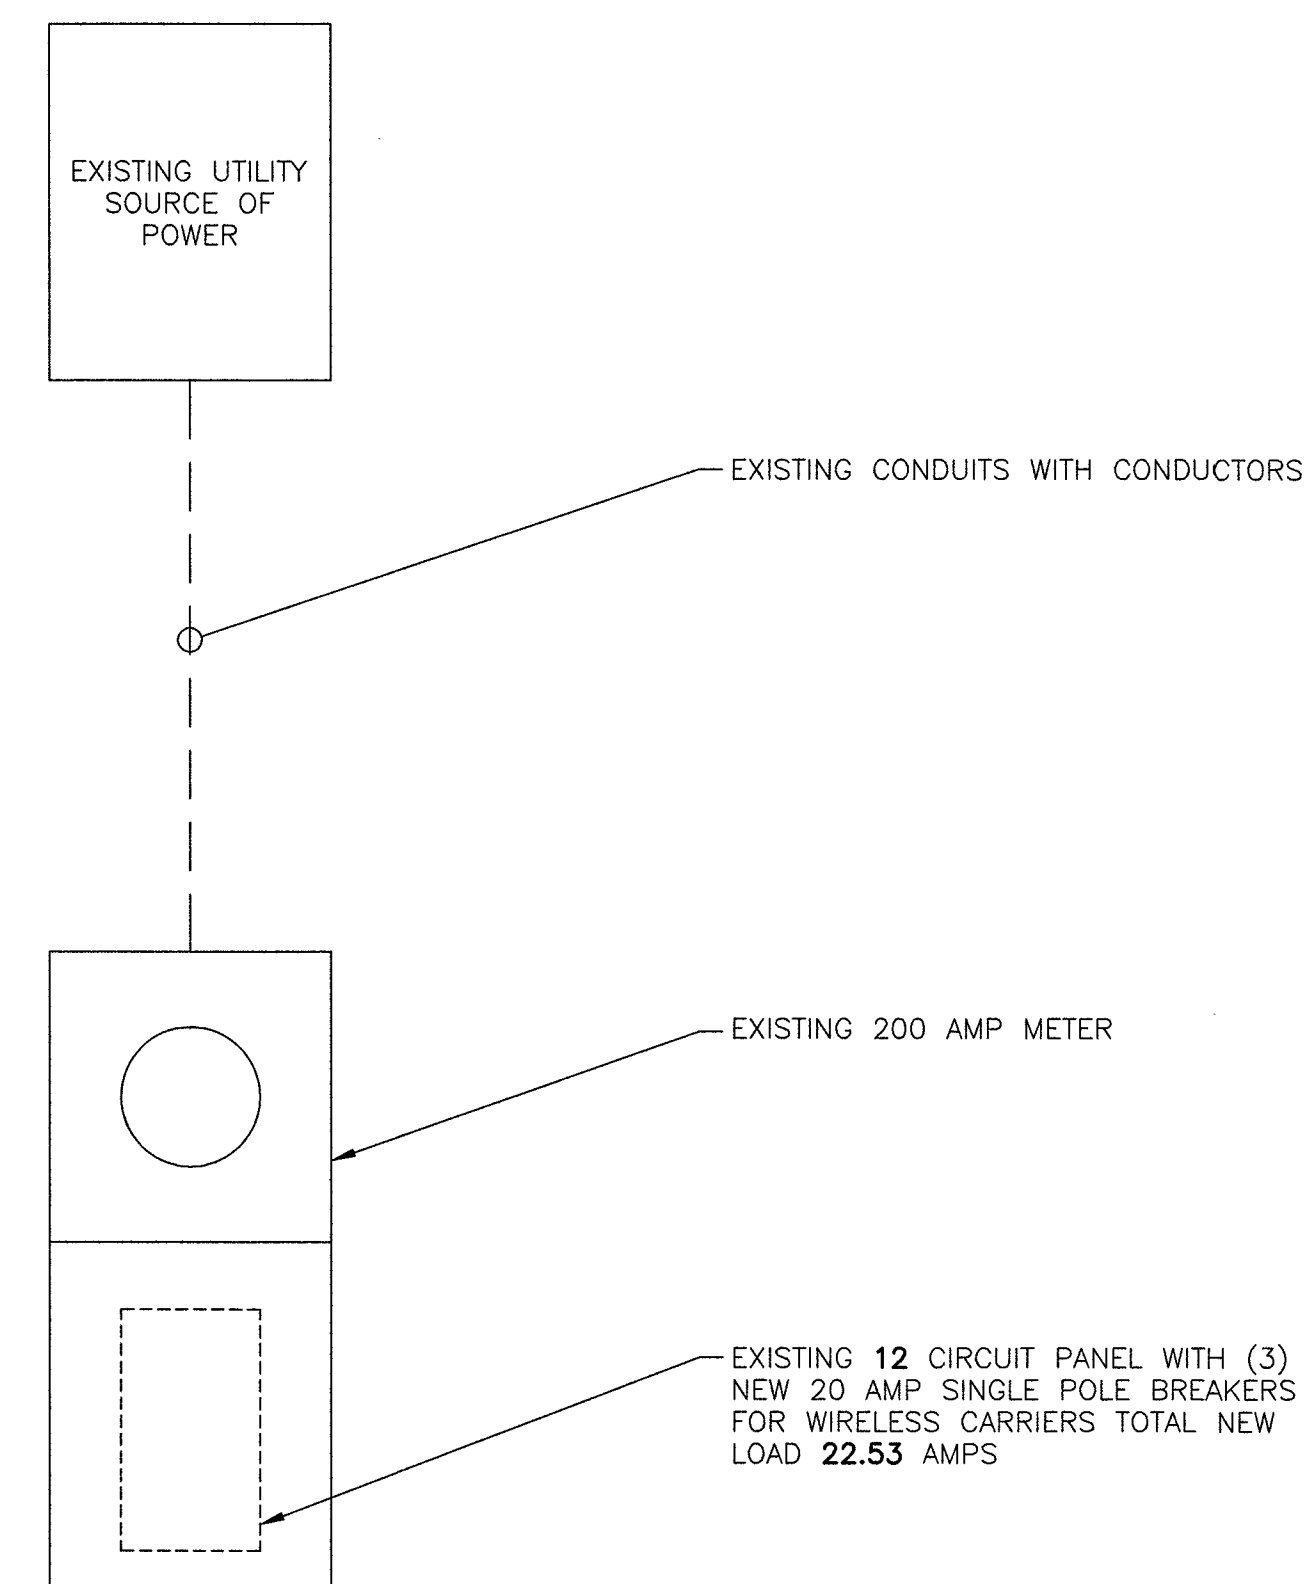

NO SCALE

1


NO SCALE

2

|                 |                  |-----------------|------------------|-------------------|---------------|----------------|-----------------|---------------|--------------|---------------|------------|---------------|---------------|-----------------------|----------------|---------------|--------------|-------------------------|-----|--|--|
| Site Name:      |                  | 6955 N DURANGO DR |               |                |                 |               |              | MODEL NUMBER: |            | CUTLER HAMMER |               |                       |                |               |              |                         |     |  |  |
| SITE NUMBER:    |                  | 33AT0105SMC       |               |                |                 |               |              | PHASE:        |            | 1             |               | WIRE:                 |                | 3             |              |                         |     |  |  |
| VOLTAGE:        |                  | 240 /120          |               | Volts AC       |                 |               |              | BUSS RATING:  |            | 200           |               | AMPS                  |                |               |              |                         |     |  |  |
| MAIN BREAKER:   |                  | 200 AMPS          |               |                |                 |               |              |               |            |               |               |                       |                |               |              |                         |     |  |  |
| MOUNT:          |                  | SURFACE           |               |                |                 |               |              |               |            |               |               |                       |                |               |              |                         |     |  |  |
| ENCLOSURE TYPE: |                  | NEMA 3R           |               |                |                 |               |              |               |            |               |               |                       |                |               |              |                         |     |  |  |
| PANEL STATUS:   |                  | EXISTING          |               |                |                 |               |              |               |            |               |               |                       |                |               |              |                         |     |  |  |
| CKT             | LOAD DESCRIPTION | BREAKER AMPS      | BREAKER POLES | BREAKER STATUS | SERVICE LOAD VA | Demand Factor | USAGE FACTOR | PHASE A VA    | PHASE B VA | USAGE FACTOR  | Demand Factor | SERVICE LOAD VA       | BREAKER STATUS | BREAKER POLES | BREAKER AMPS | LOAD DESCRIPTION        | CKT |  |  |
|                 | MAIN             | 200               | 2             | ON             | 0               | 1.00          | 1.00         | 0             |            |               |               |                       |                |               |              |                         |     |  |  |
|                 |                  |                   |               |                | 0               | 1.00          | 1.00         |               | 0          |               |               |                       |                |               |              |                         |     |  |  |
| 1               | EXISTING LOAD    | 40                | 1             | ON             | 1632            | 1.00          | 1.25         | 3045          |            | 1.25          | 1.00          | 804                   | ON             | 2             | 60           | EXISTING LOAD           | 2   |  |  |
| 3               | TELECOM (FUTURE) | 20                | 1             | OFF            | 0               | 1.00          | 1.00         |               | 975        | 1.25          | 1.00          | 780                   |                |               |              |                         | 4   |  |  |
| 5               |                  |                   |               |                |                 |               |              | 0             |            | 1.25          | 1.00          | 0                     | OFF            | 2             | 60           | SPARE                   | 6   |  |  |
| 7               |                  |                   |               |                |                 |               |              | 0             |            | 1.25          | 1.00          | 0                     |                |               |              |                         | 8   |  |  |
| 9               |                  |                   |               |                |                 |               |              | 75            |            | 1.25          | 1.00          | 60                    | ON             | 1             | 15           | EXISTING LOAD           | 10  |  |  |
| 11              |                  |                   |               |                |                 |               |              |               | 0          | 1.00          | 1.00          | 0                     | OFF            | 1             | 20           | TELECOM (FUTURE)        | 12  |  |  |
| 13              |                  |                   |               |                |                 |               |              | 563           |            | 1.25          | 1.00          | 450                   | NEW            | 1             | 20           | PROPOSED COX SMALL CELL | 14  |  |  |
|                 |                  |                   |               |                |                 |               |              | PHASE A       | PHASE B    |               |               |                       |                |               |              |                         |     |  |  |
|                 |                  |                   |               |                |                 |               |              | 3683          | 975        | VA            |               |                       |                |               |              |                         |     |  |  |
|                 |                  |                   |               |                |                 |               |              |               | TOTAL      | KVA           | 4.66          |                       |                |               |              |                         |     |  |  |
|                 |                  |                   |               |                |                 |               |              |               |            | AMPS          | 19.41         | ≤ 80% OF MAIN BREAKER |                |               |              |                         |     |  |  |

NO SCALE

3

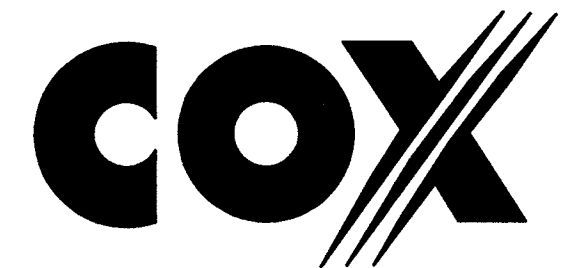


**BLACK & VEATCH**

BLACK & VEATCH CORPORATION  
7760 FRANCE AVENUE SOUTH  
SUITE 1200  
BLOOMINGTON, MN 55435

THESE DRAWINGS ARE COPYRIGHTED AND ARE THE PROPERTY OF BLACK & VEATCH; PRODUCED SOLELY FOR THE USE OF OUR CLIENT. ANY REPRODUCTION OR USE OF THE INFORMATION CONTAINED WITHIN SAID DRAWINGS IS PROHIBITED WITHOUT WRITTEN CONSENT BY BLACK & VEATCH.

|             |          |            |
|-------------|----------|------------|
| PROJECT NO. | DRAWN BY | CHECKED BY |
| 199064.2051 | MSC      | LEW        |

|     |          |                         |
|-----|----------|-------------------------|
|     |          |                         |
|     |          |                         |
| 0   | 12/05/18 | ISSUED FOR CONSTRUCTION |
| REV | DATE     | DESCRIPTION             |

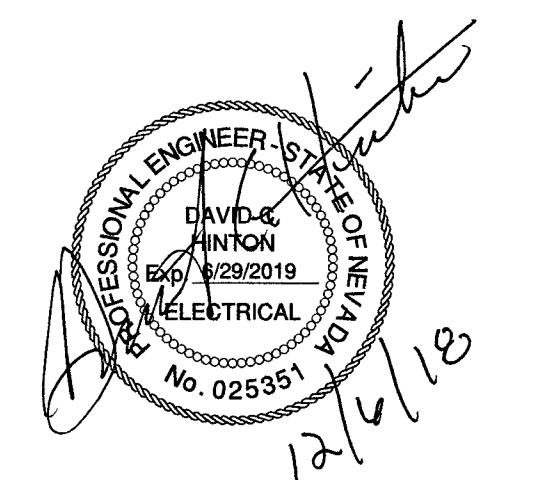

IT IS A VIOLATION OF LAW FOR ANY PERSON,  
UNLESS THEY ARE ACTING UNDER THE DIRECTION  
OF A LICENSED PROFESSIONAL ENGINEER,  
TO ALTER THIS DOCUMENT.

SITE ADDRESS

33AT0104SMC  
CRAN\_NVL08145F\_R01  
7100.25 N DURANGO DR  
LAS VEGAS, NV 89149  
SMALL CELL

SHEET TITLE


## ELECTRICAL SINGLE LINE DIAGRAMS

SHEET NUMBER

**E-2**

NOTES

1. FOR CONDUIT SIZE AND WIRING REQUIREMENTS FOR STREETLIGHT SERVICE, SEE STANDARD DRAWING NO. 332.S2 FOR LAS VEGAS AND CLARK COUNTY ONLY AND 332.S1 FOR ALL OTHER ENTITIES.
2. SEE STANDARD DRAWING NO. 321, 332.S1, OR 332.S2.

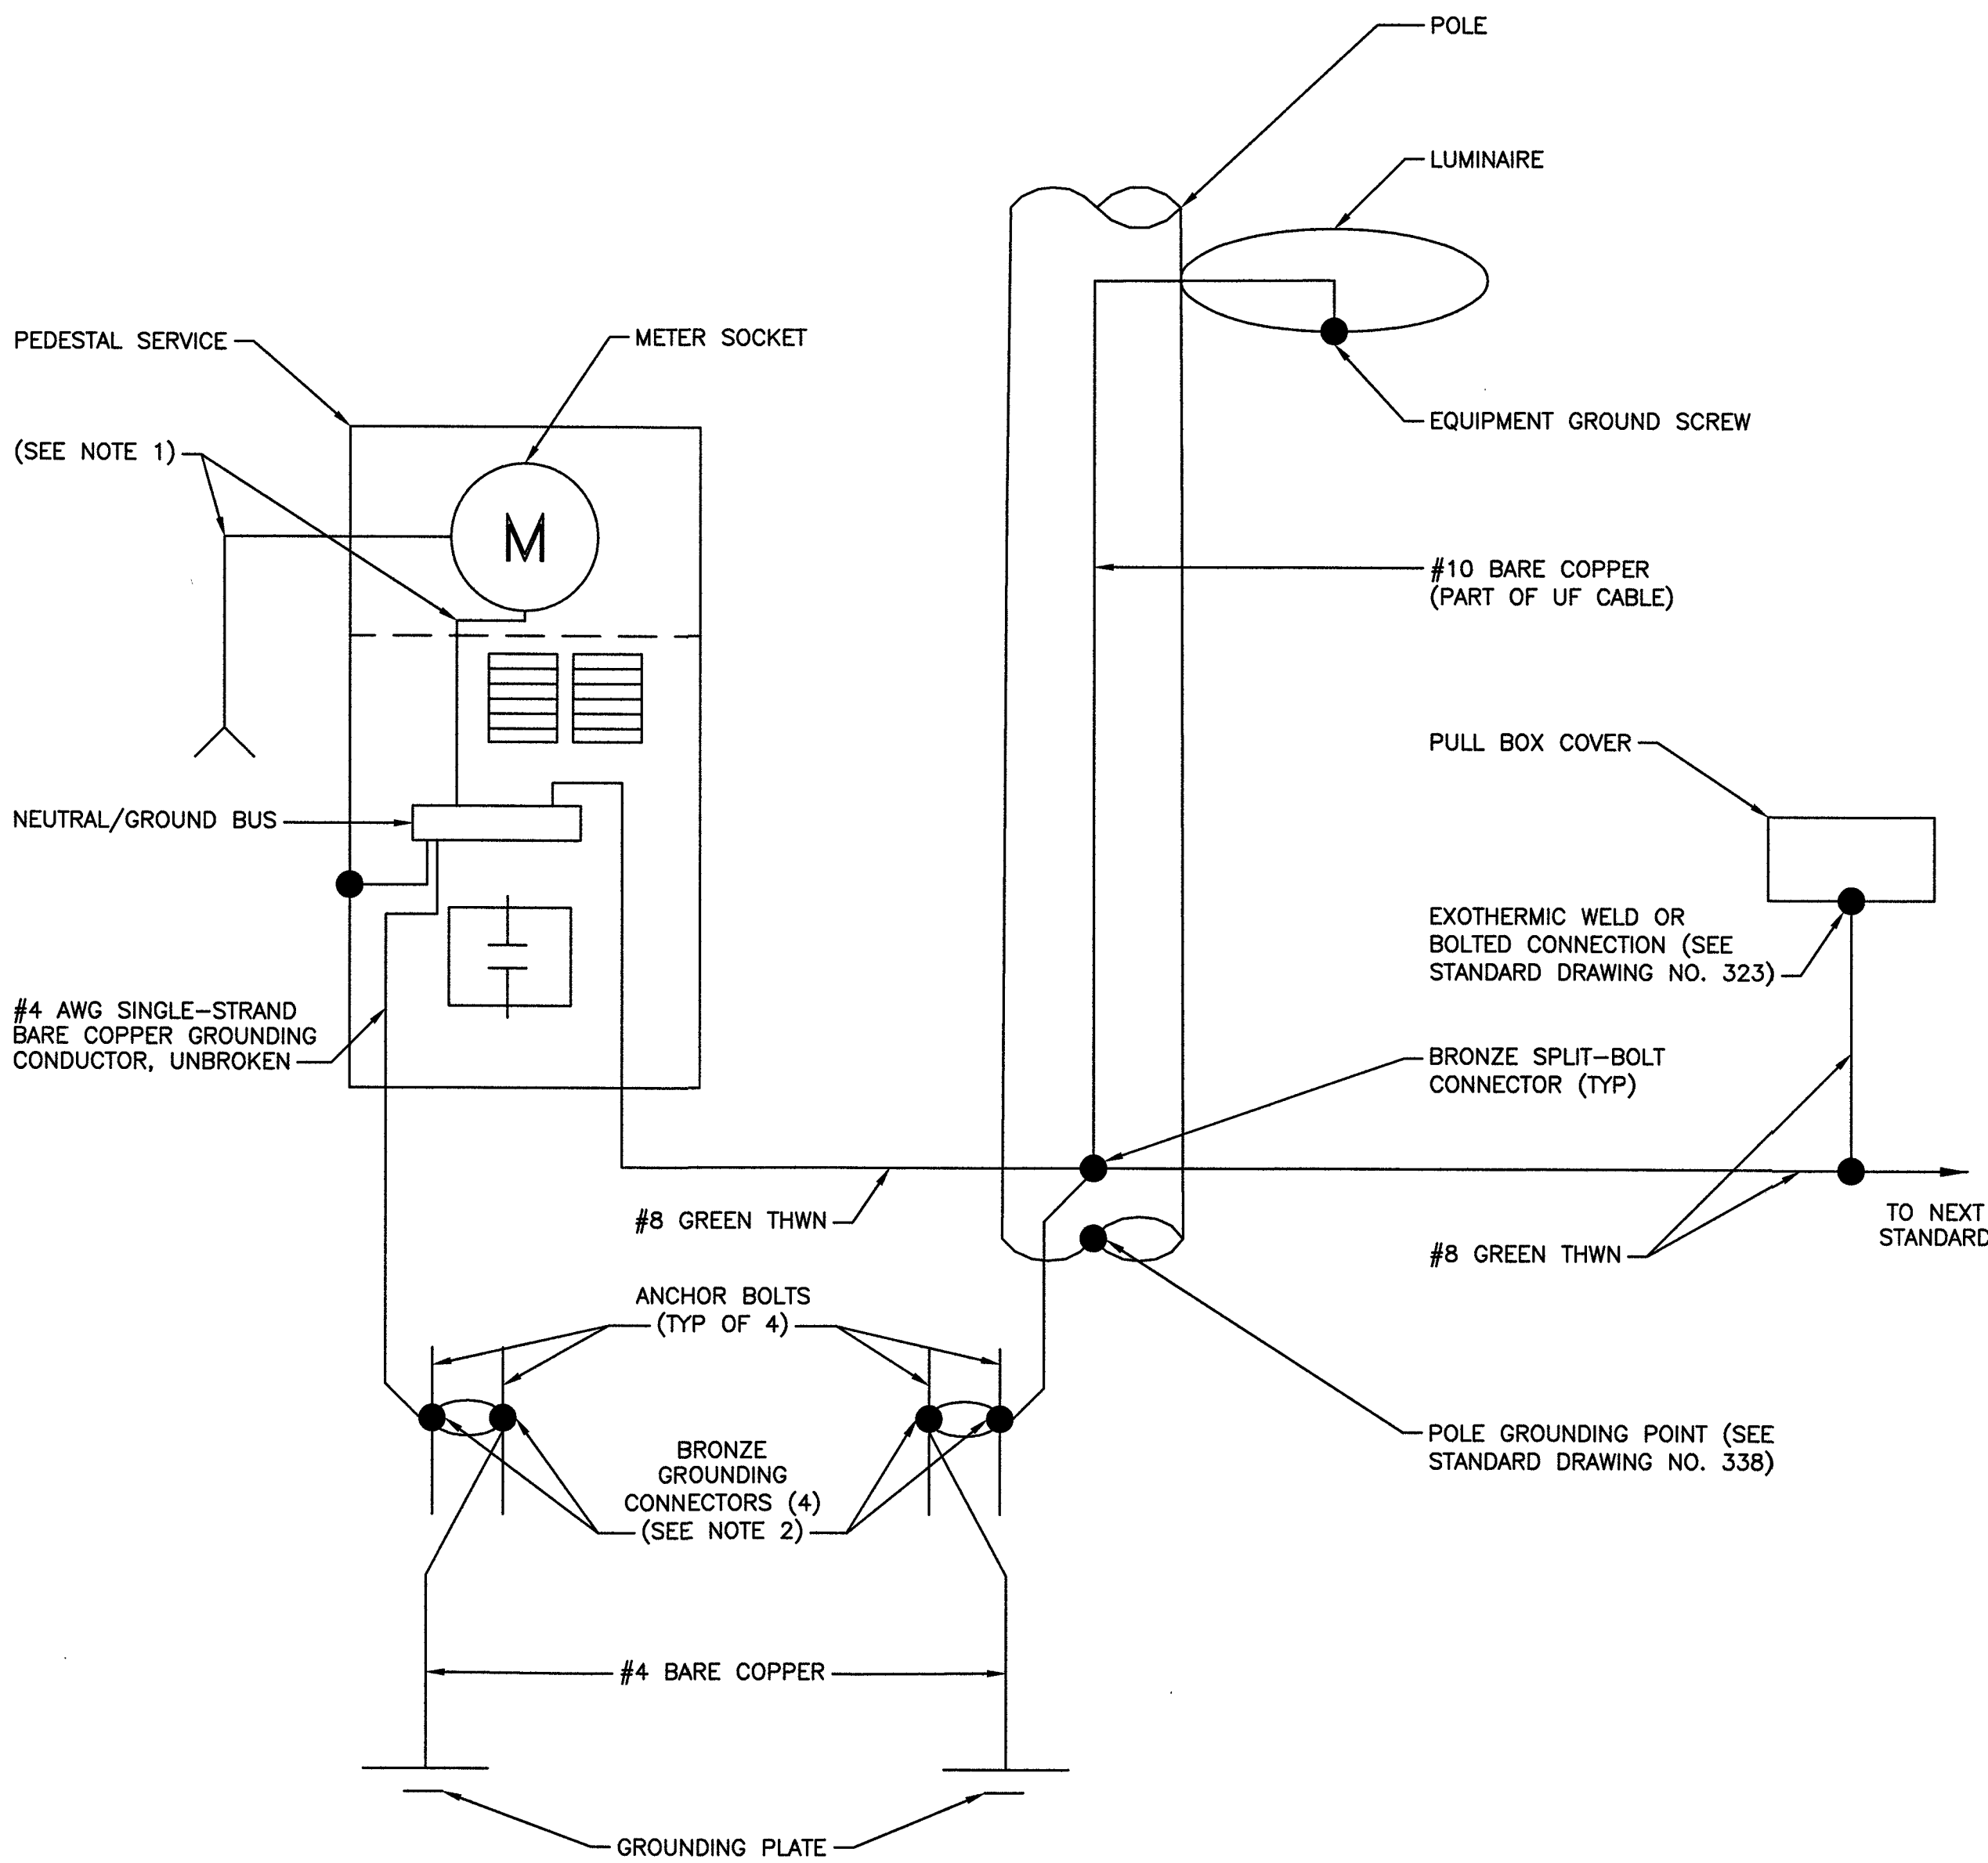


METER PEDESTAL GROUNDING DIAGRAM

NO SCALE

1

NOTES

1. 125 AMP SERVICE: 1 #4 WHITE THW  
200 AMP SERVICE: 1 #1/0 WHITE THW

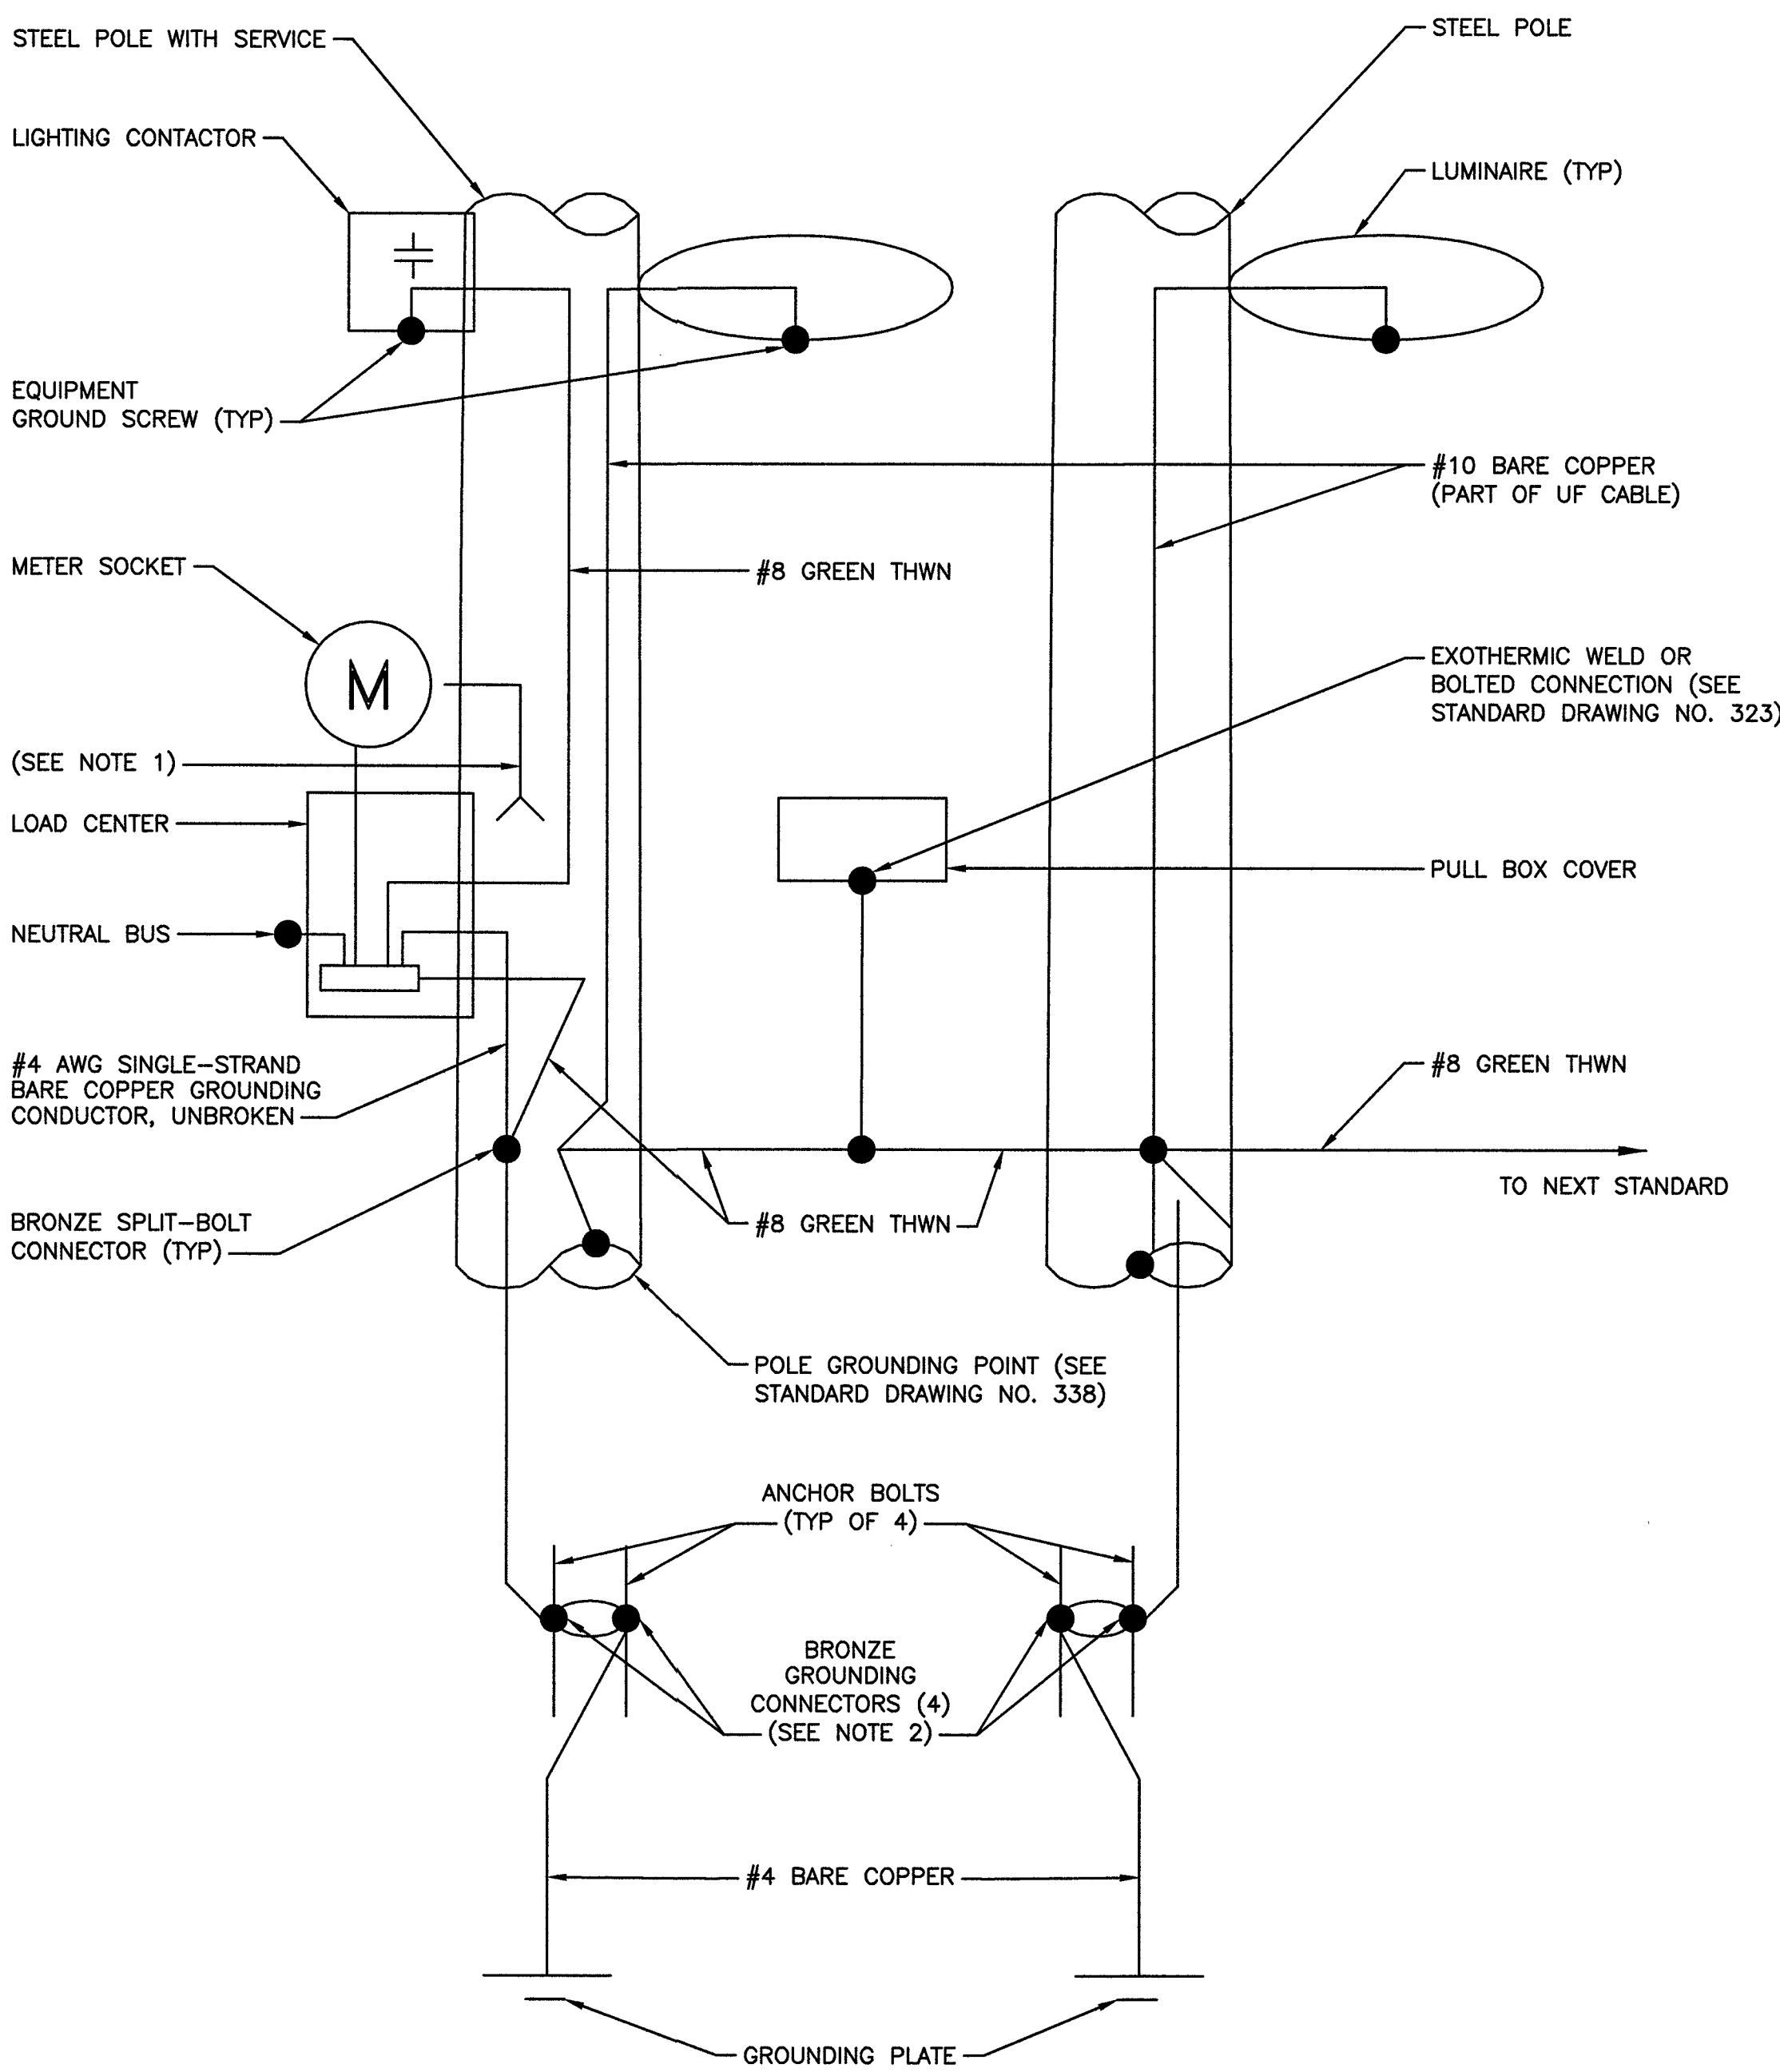

POLE EQUIPMENT GROUNDING DIAGRAM

NO SCALE

2




**BLACK & VEATCH**

BLACK & VEATCH CORPORATION  
7760 FRANCE AVENUE SOUTH  
SUITE 1200  
BLOOMINGTON, MN 55435

THESE DRAWINGS ARE COPYRIGHTED AND ARE THE PROPERTY OF BLACK & VEATCH; PRODUCED SOLELY FOR THE USE OF OUR CLIENT. ANY REPRODUCTION OR USE OF THE INFORMATION CONTAINED WITHIN SAID DRAWINGS IS PROHIBITED WITHOUT WRITTEN CONSENT BY BLACK & VEATCH.

| PROJECT NO. | DRAWN BY | CHECKED BY |
|-------------|----------|------------|
| 199064.2051 | MSC      | LEW        |

| REV | DATE     | DESCRIPTION             |
|-----|----------|-------------------------|
| 0   | 12/05/18 | ISSUED FOR CONSTRUCTION |

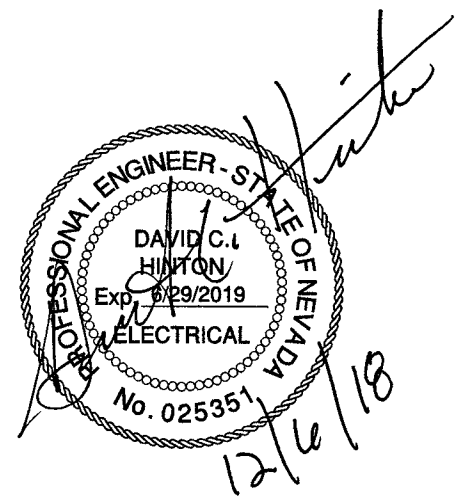

IT IS A VIOLATION OF LAW FOR ANY PERSON, UNLESS THEY ARE ACTING UNDER THE DIRECTION OF A LICENSED PROFESSIONAL ENGINEER, TO ALTER THIS DOCUMENT.

SITE ADDRESS

33AT0104SMC  
CRAN\_NVL08145F\_R01  
7100.25 N DURANGO DR  
LAS VEGAS, NV 89149  
SMALL CELL



SHEET TITLE

GROUNDING DIAGRAMS

SHEET NUMBER


**G-1**

SMALL CELL SITE SURVEY  
 SITE: 33AT0104SMC  
 NW¼NE¼, SECTION 20, TOWNSHIP 19 SOUTH, RANGE 60 EAST

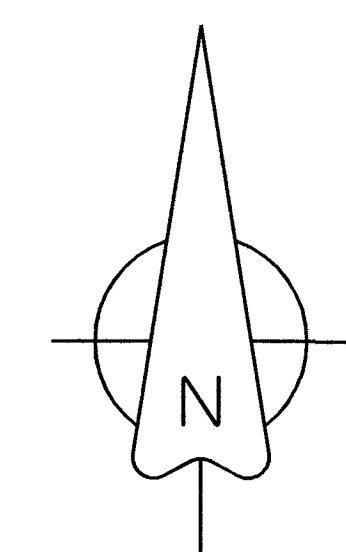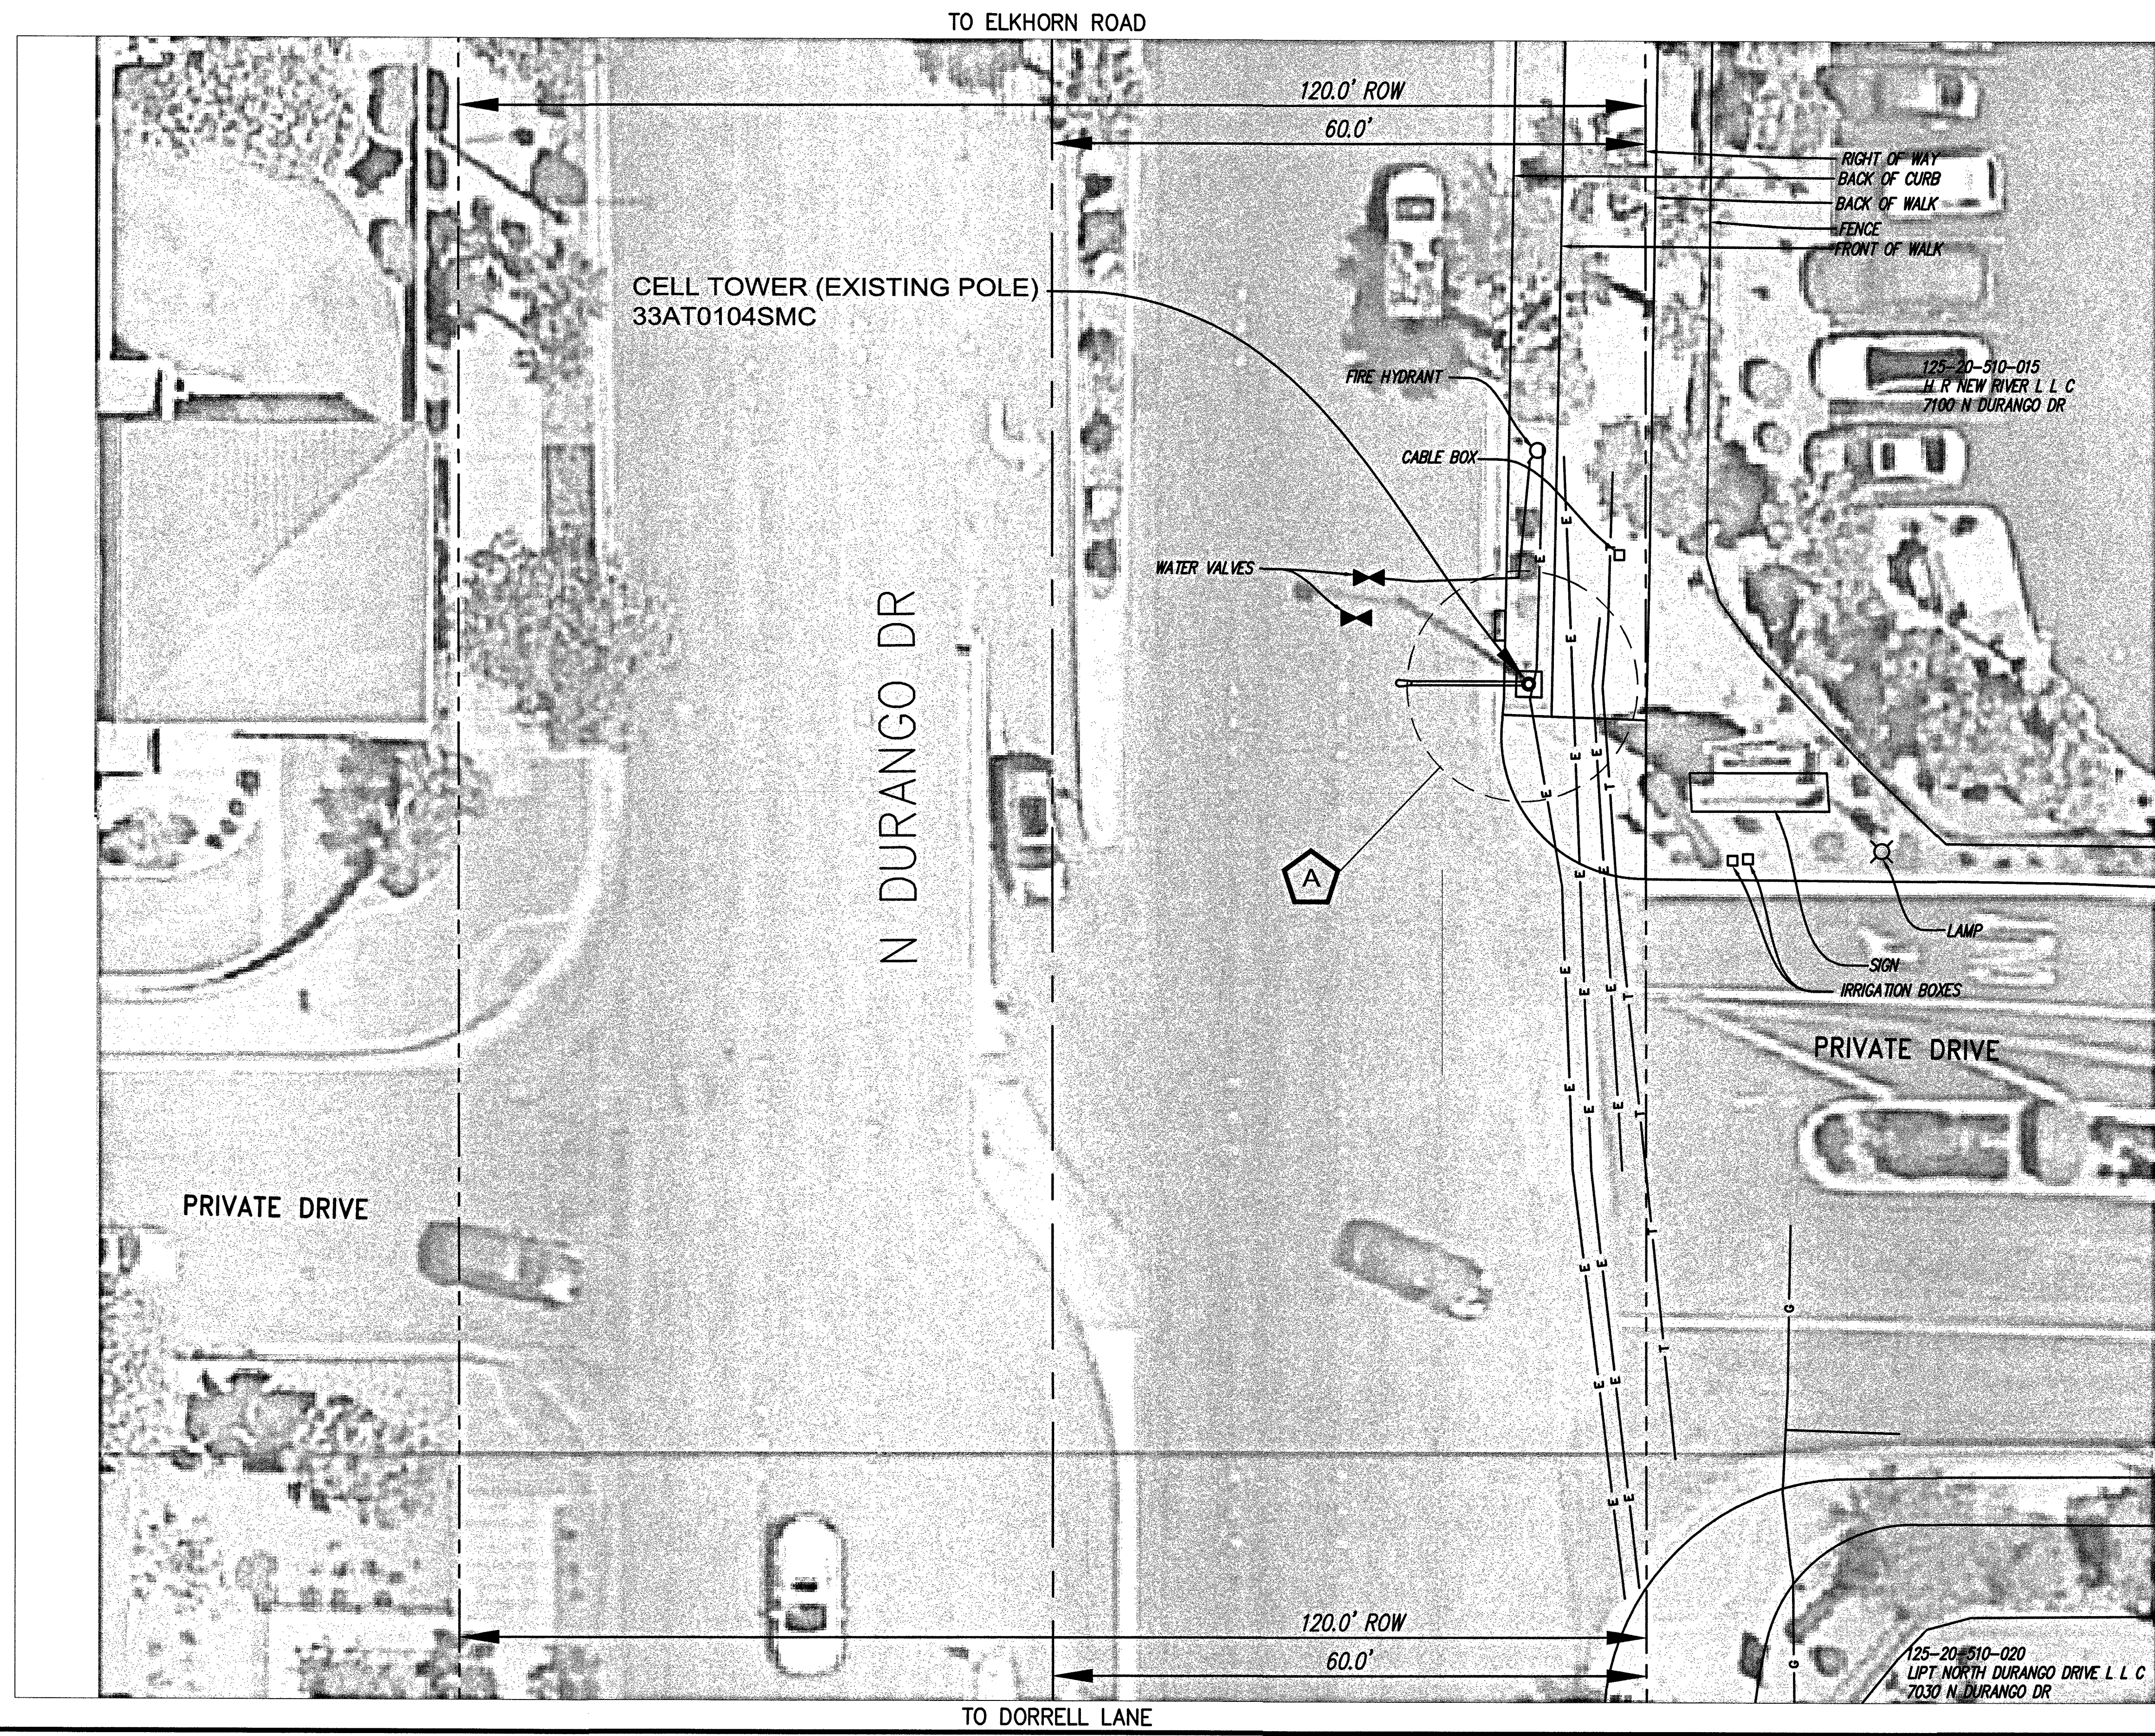

**A** LATITUDE: 36°17'24.41"N  
 LONGITUDE: 115°17'15.60"W  
 GROUND ELEVATION: 2594.40'  
 NAVD '88

| Legend |                            |
|--------|----------------------------|
|        | MONUMENT                   |
|        | POLE                       |
|        | DOWN GUY                   |
|        | GAS VALVE                  |
|        | PEDASTAL                   |
|        | LAMP POST                  |
|        | WATER VALVE                |
|        | FIRE HYDRANT               |
|        | WATER MANHOLE              |
|        | WATER METER                |
|        | SEWER MANHOLE              |
|        | UNKNOWN OR LABELED MANHOLE |
|        | SANITARY SEWER MANHOLE     |
|        | STORM WATER MANHOLE        |
|        | ELECTRIC MANHOLE           |
|        | TELECOM MANHOLE            |
|        | TREE                       |
|        | FENCELINE                  |
|        | ROW LINE                   |
|        | CENTER LINE                |
|        | SEWER S                    |
|        | TELEPHONE T                |
|        | WATER W                    |
|        | ELECTRIC E                 |
|        | GAS LINE G                 |
|        | OVERHEAD ELEC              |
|        | FENCE BARB X               |
|        | PROPERTY LINE              |

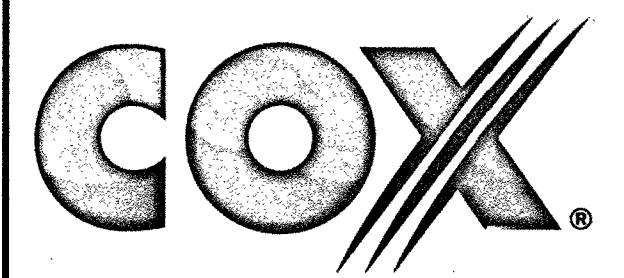

6205-B Peachtree Dunwoody Road NE  
 Atlanta, GA 30328

ENGINEERS:



**BLACK & VEATCH**

6 SUNSET WAY  
 SUITE B108  
 HENDERSON, NV 89014

|             |             |
|-------------|-------------|
| SITE NO:    | 33AT0104SMC |
| DRAWN BY:   | KJC         |
| CHECKED BY: | CIS         |

| REV | DATE     | DESCRIPTION           |
|-----|----------|-----------------------|
| A   | 10/30/18 | PRELIMINARY SUBMITTAL |
|     |          |                       |
|     |          |                       |
SURVEYOR:



CIS JOB NO:  
 CIS 315-2-4-10

SHEET TITLE  
**SMALL CELL  
 SITE SURVEY**

SHEET NUMBER  
**1 OF 1**



# CITY OF LAS VEGAS

TRAFFIC ENGINEERING  
FIELD OPERATIONS  
3001 RONEMUS DRIVE  
LAS VEGAS, NV 89128  
PHONE: (702) 229-6331

## SMALL CELL SITE SURVEY

- THIS FORM IDENTIFIES THE POTENTIAL POWER SUPPLY SOURCE FOR A PROPOSED SMALL CELL SITE
- THIS ONLY REPRESENTS THE CONDITIONS AT TIME OF SITE SURVEY
- FIELD CONDITIONS MAY CHANGE FROM THE TIME OF THE SITE SURVEY UNTIL THE START OF CONSTRUCTION

CONTRACTOR'S NAME: Cox WIRELESS USE AGREEMENT \_\_\_\_\_  
WIRELESS SERVICE PROVIDER: \_\_\_\_\_ CONTACT NAME: \_\_\_\_\_  
OFFICE: \_\_\_\_\_ MOBILE: \_\_\_\_\_ FAX: \_\_\_\_\_  
POLE LOCATION & ID: 7100 N. Durango Dr. SL# 205134  
CIRCLE ONE: NEW POLE ☐ EXISTING POLE ☒

### PROPOSED SERVICE INFORMATION

|                       |                            |                     |                   |                |
|-----------------------|----------------------------|---------------------|-------------------|----------------|
| Service Location      | <b>7198 N. Durango Dr.</b> |                     | <b>ID# 402853</b> |                |
| Existing Meter #      | CC029948839                |                     |                   |                |
| Existing Service Size | 60 Amp                     | 100 Amp             | 125 Amp           | <u>200 Amp</u> |
| Street Light Circuit  |                            |                     |                   |                |
| Service Type          | <u>Pedestal</u>            |                     | Pole Mount        |                |
| Current Application   | Traffic Signal             | <u>St. Lighting</u> | Both              |                |
| Existing Load         |                            | 32.3 Amps           | Amps              |                |
| Field Tested By:      | T. Azbill                  |                     | Date:             | 10/18/18       |
| Notes:                |                            |                     |                   |                |

### CLV REPRESENTATIVE

- TO BE COMPLETED BY TEFO STAFF

CLV FIELD REVIEWER'S NAME: B. Bradway FIELD REVIEW DATE: 10/10/2018  
SENIOR/SUPervisor REVIEW SIGNATURE: [Signature] DATE REVIEWED BY SENIOR TECH: \_\_\_\_\_

Suitable for use to serve small cell site without upgrade.

### BACKUP DOCUMENTATION

- DRAWINGS, PHOTOS, ETC

FILE NAME: \_\_\_\_\_ CREATION DATE: \_\_\_\_\_  
FILE NAME: \_\_\_\_\_ CREATION DATE: \_\_\_\_\_  
FILE NAME: \_\_\_\_\_ CREATION DATE: \_\_\_\_\_  
Service Size \_\_\_\_\_ CREATION DATE: \_\_\_\_\_

NV POWER SERVICE ADDRESS  
LOAD BAY DOCUMENTATION FOR SPACE UTILIZATION