

DRAWING:

Call before you Dig.
1-800-227-2600
UNDERGROUND SERVICE ALERT (USA)


Call before you OVERHEAD
1-702-227-2929
NEVADA POWER ENVIRONMENT AND SAFETY SERVICES DEPARTMENT

EASEMENT WITH TREES, SHRUBS, DECORATIVE ROCKS
BLOCK WALL OR FENCE

Trees, shrubs, or decorative rocks, and any block wall or other fence material, shall be designed and constructed around the easement(s) to allow the District direct access to the vault(s), backflow assemblies, and piping from the adjacent right-of-way.

ABANDONMENT OF EXISTING SERVICES
(2-INCH AND SMALLER)


IF ANY OF THE EXISTING SERVICES ARE INCORRECTLY LOCATED OR NOT TO BE USED WITH THIS PROJECT, THIS PROJECT SHALL ABANDON THE LATERALS AT THE CONNECTION TO THE ACTIVE MAIN IN ACCORDANCE WITH UDACS SECTION 2.17.04 A AND COORDINATED WITH THE LVVWD INSPECTOR.

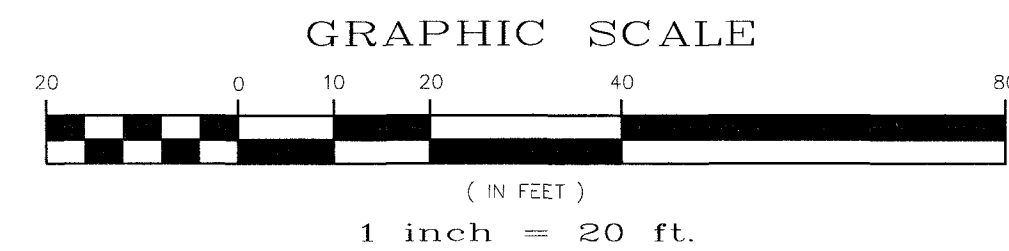

LEGEND

	EXISTING/ ADJACENT RIGHT-OF-WAY LINE
	EXISTING EDGE OF PAVEMENT
	PROPERTY LINE
	CENTER LINE
	SAWCUT LIN
	EXISTING SEWER LINE/ MANHOLE
	PROPOSED SEWER LINE/ CLEANOUT
	EXISTING WATER LINE/ VALVE
	PROPOSED WATER LINE
	EXISTING FIRE HYDRANT
	PROPOSED FIRE HYDRANT
	EXISTING BUILDING
	PROPOSED BUILDING
	PROPOSED SIGN
	PROPOSED FDC

#	DATE / DESCRIPTION

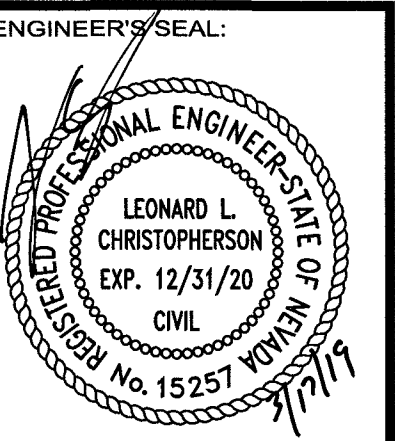

DLC
CONSULTING
DEVELOPMENT / LAND ANALYSIS / CONSTRUCTION
2885 EAST QUAIL AVENUE
LAS VEGAS, NEVADA 89120
PHONE: 702-521-1021

ENGINEER:
CLIENT:

PROJECT:
SEWER CONNECTION
100 E. CALIFORNIA STREET
LAS VEGAS, NV 89104
APN: 162-03-110-081



DATE:
MAR. 16, 2019

SCALE:
1"= 20'

SHEET NUMBER:
307 3 OF 3
L19-00109

UTILITY PLAN

SHEET TITLE:

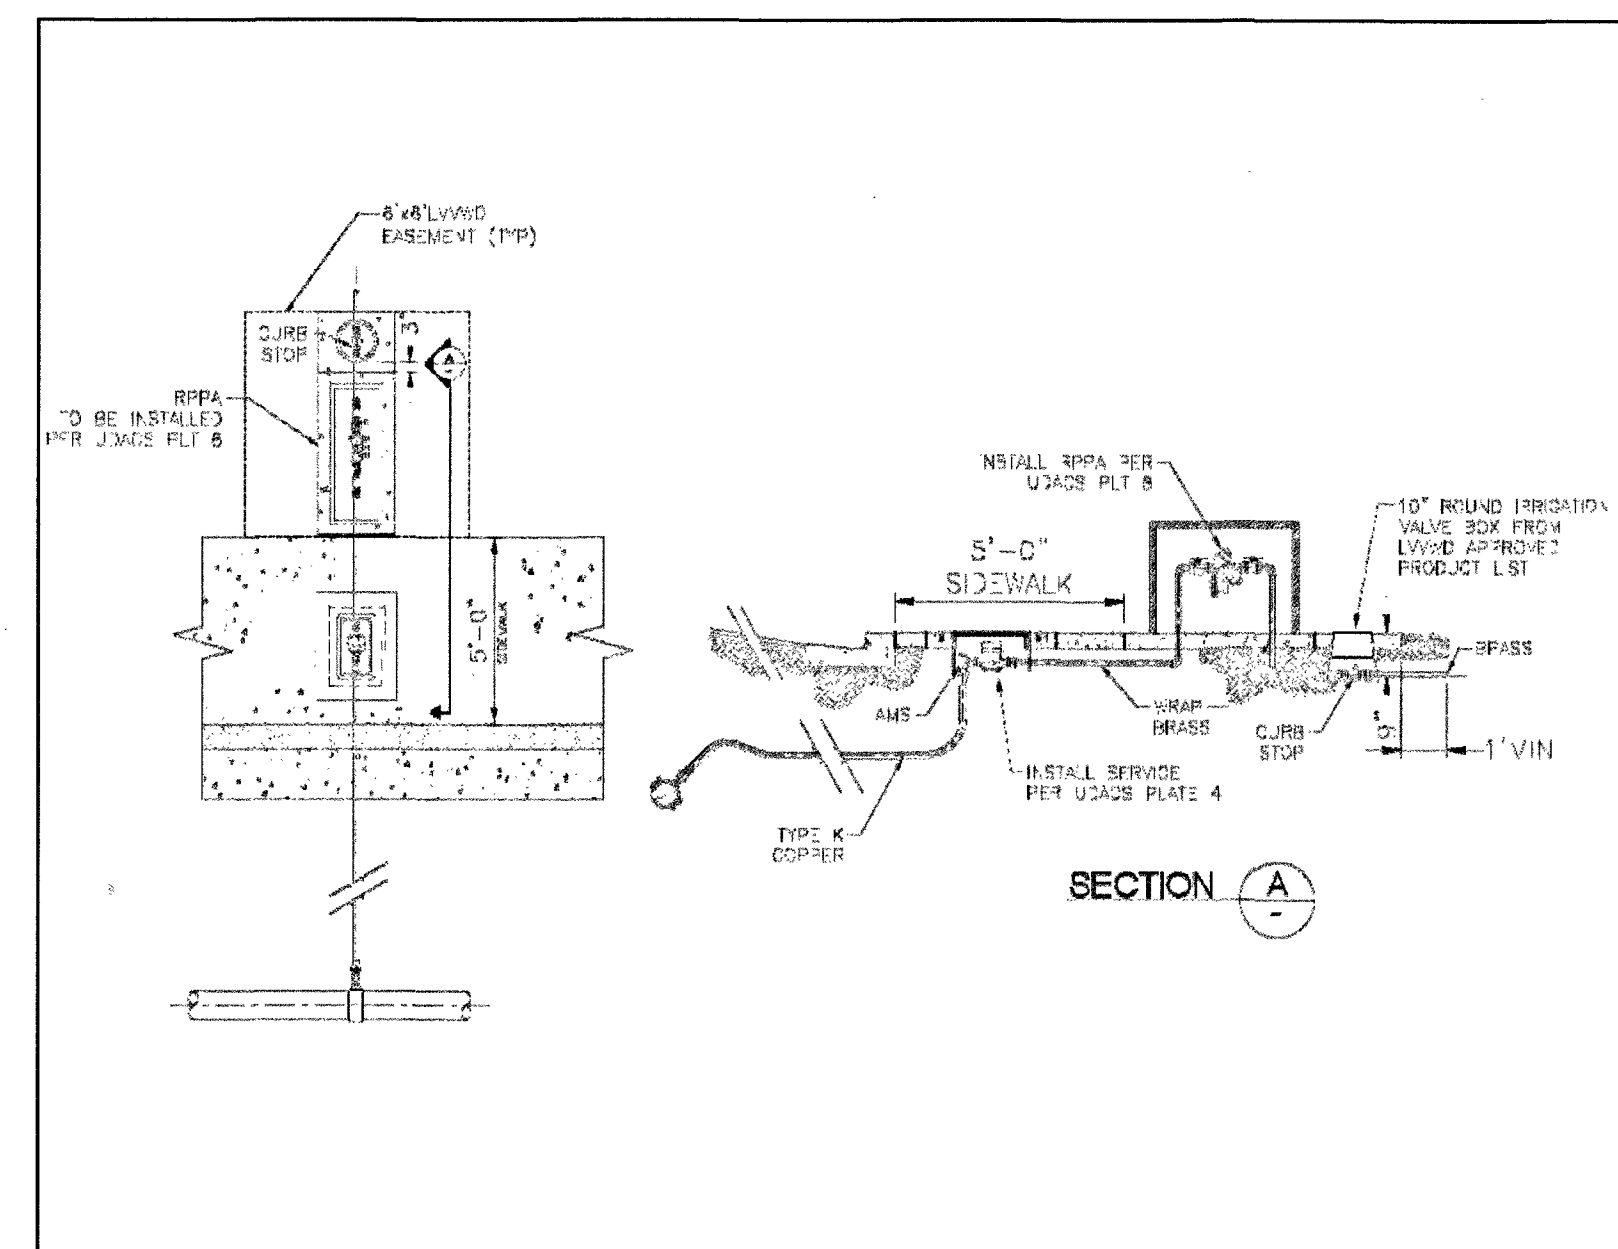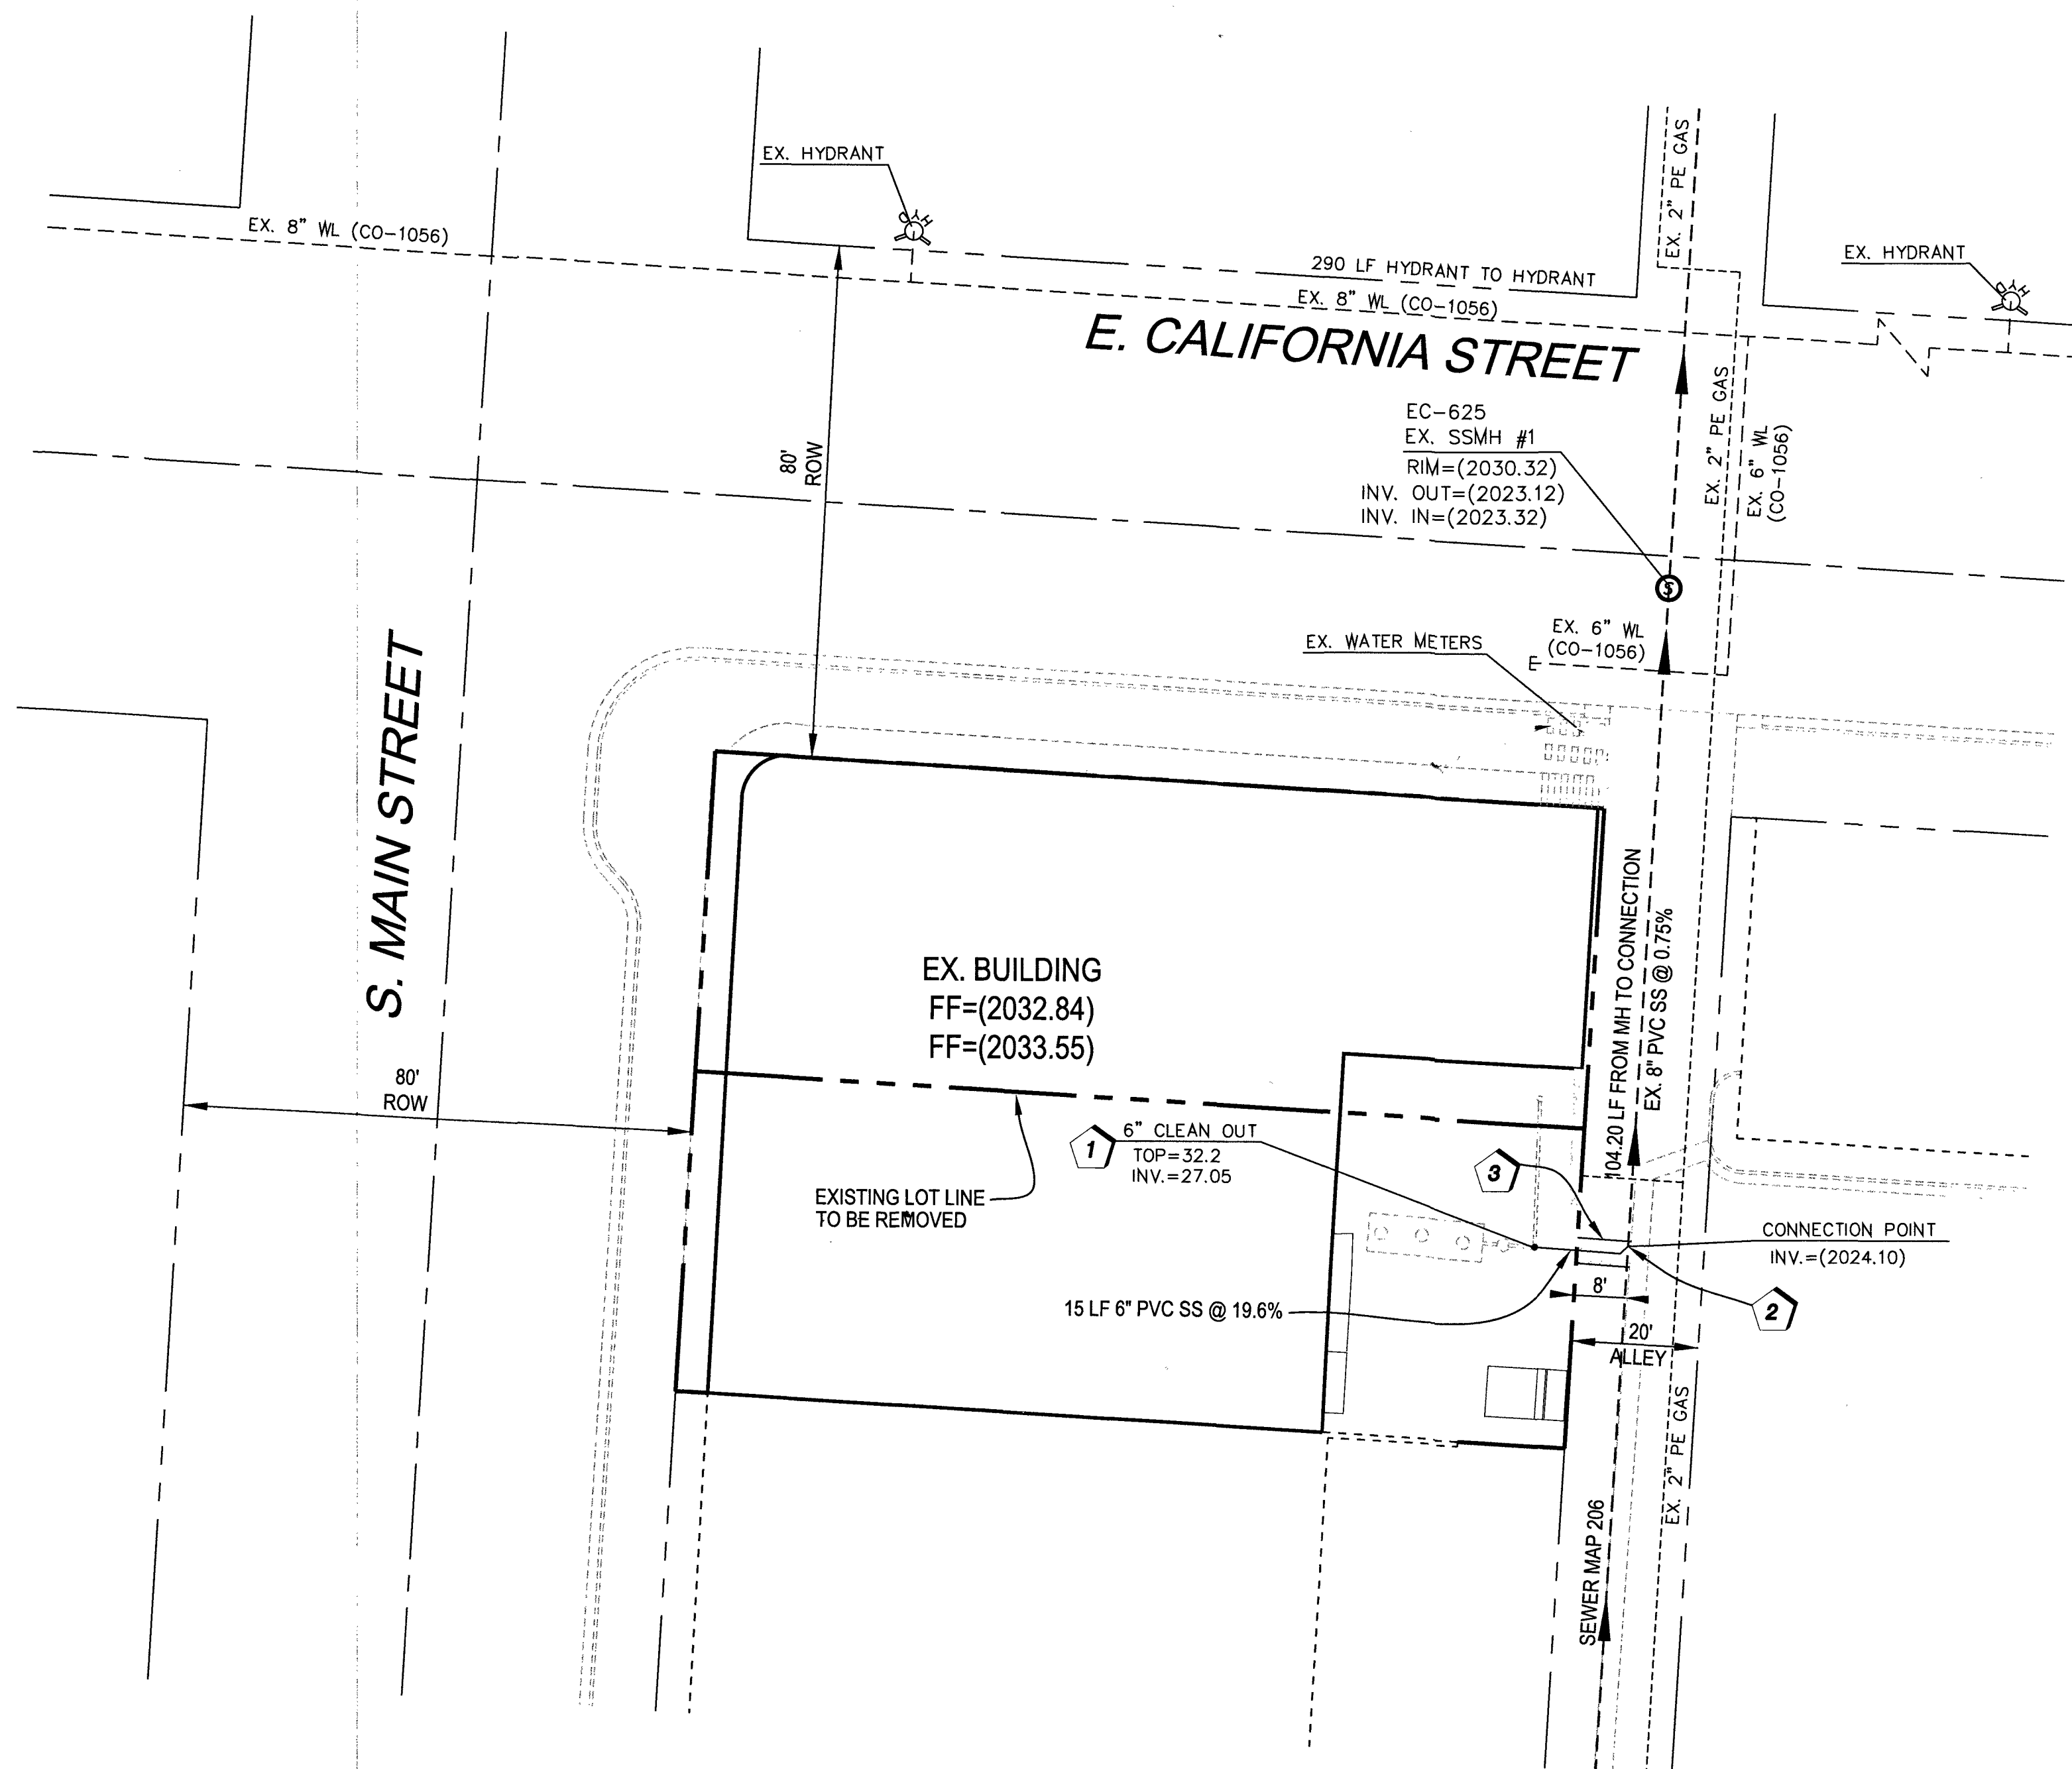

NOTE:
ALL SEWER/ STORM DRAINS CROSSING WATER LINES MUST CONFORM TO SECTION 2.22 OF THE UNIFORM DESIGN AND CONSTRUCTION STANDARDS FOR POTABLE WATER SYSTEMS (UDACS) FOR WATER AND STORM MAIN CROSSINGS AND CLEARANCES. ESN.064 REVISED 06/01/04


NOTE:
INSTALL PIPELINE MARKER BALLS IN TRENCH ABOVE EACH HORIZONTAL ELBOW FITTING PER UDACS PLATE NO. 15

NOTE:
DISPOSAL OF ASBESTOS CEMENT PIPE SHALL BE IN ACCORDANCE WITH ALL LOCAL, STATE AND FEDERAL REGULATIONS.

WATER CONSTRUCTION NOTES

SEWER CONSTRUCTION NOTES

1. INSTALL CLEAN-OUT WITH TRAFFIC RATED LID PER DCSWCS, SD-26.
2. CONNECT TO EXISTING 8" SEWER WITH WYE FITTING
3. SAW CUT & REPLACE AC PAVING AS NEEDED TO INSTALL NEW 6" SS SERVICE

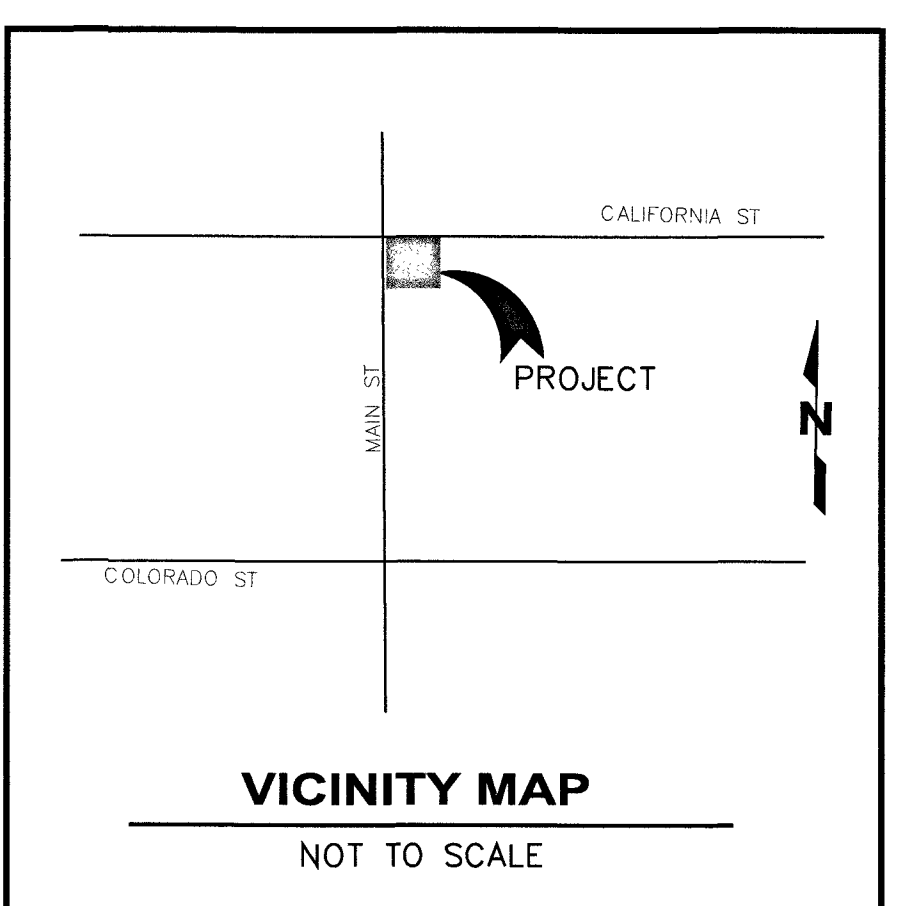

APPROVED FOR CONSTRUCTION
LAS VEGAS VALLEY WATER DISTRICT ENGINEERING SERVICES
PROJECT # 136388 FIRST APPROVED DATE 3-8-19
LVVWD APPROVED FIRE FLOW: TOTAL 0 GPM/ONSITE 0 GPM