
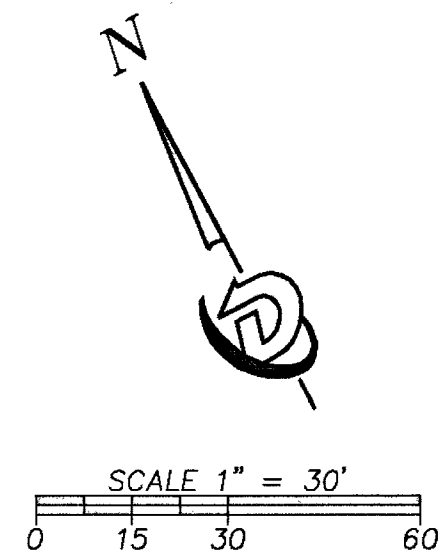


SEC 55 S4
COR 58 S9
T.21S, R.61E, M.D.M.
FOUND 2" BRASS
CAP IN WELL
REF: RS 7197, P.67
CAP IS STAMPED:
CHRIS ALBERS
7215
S5 S4
S8 S9
R61E
PLS 8866

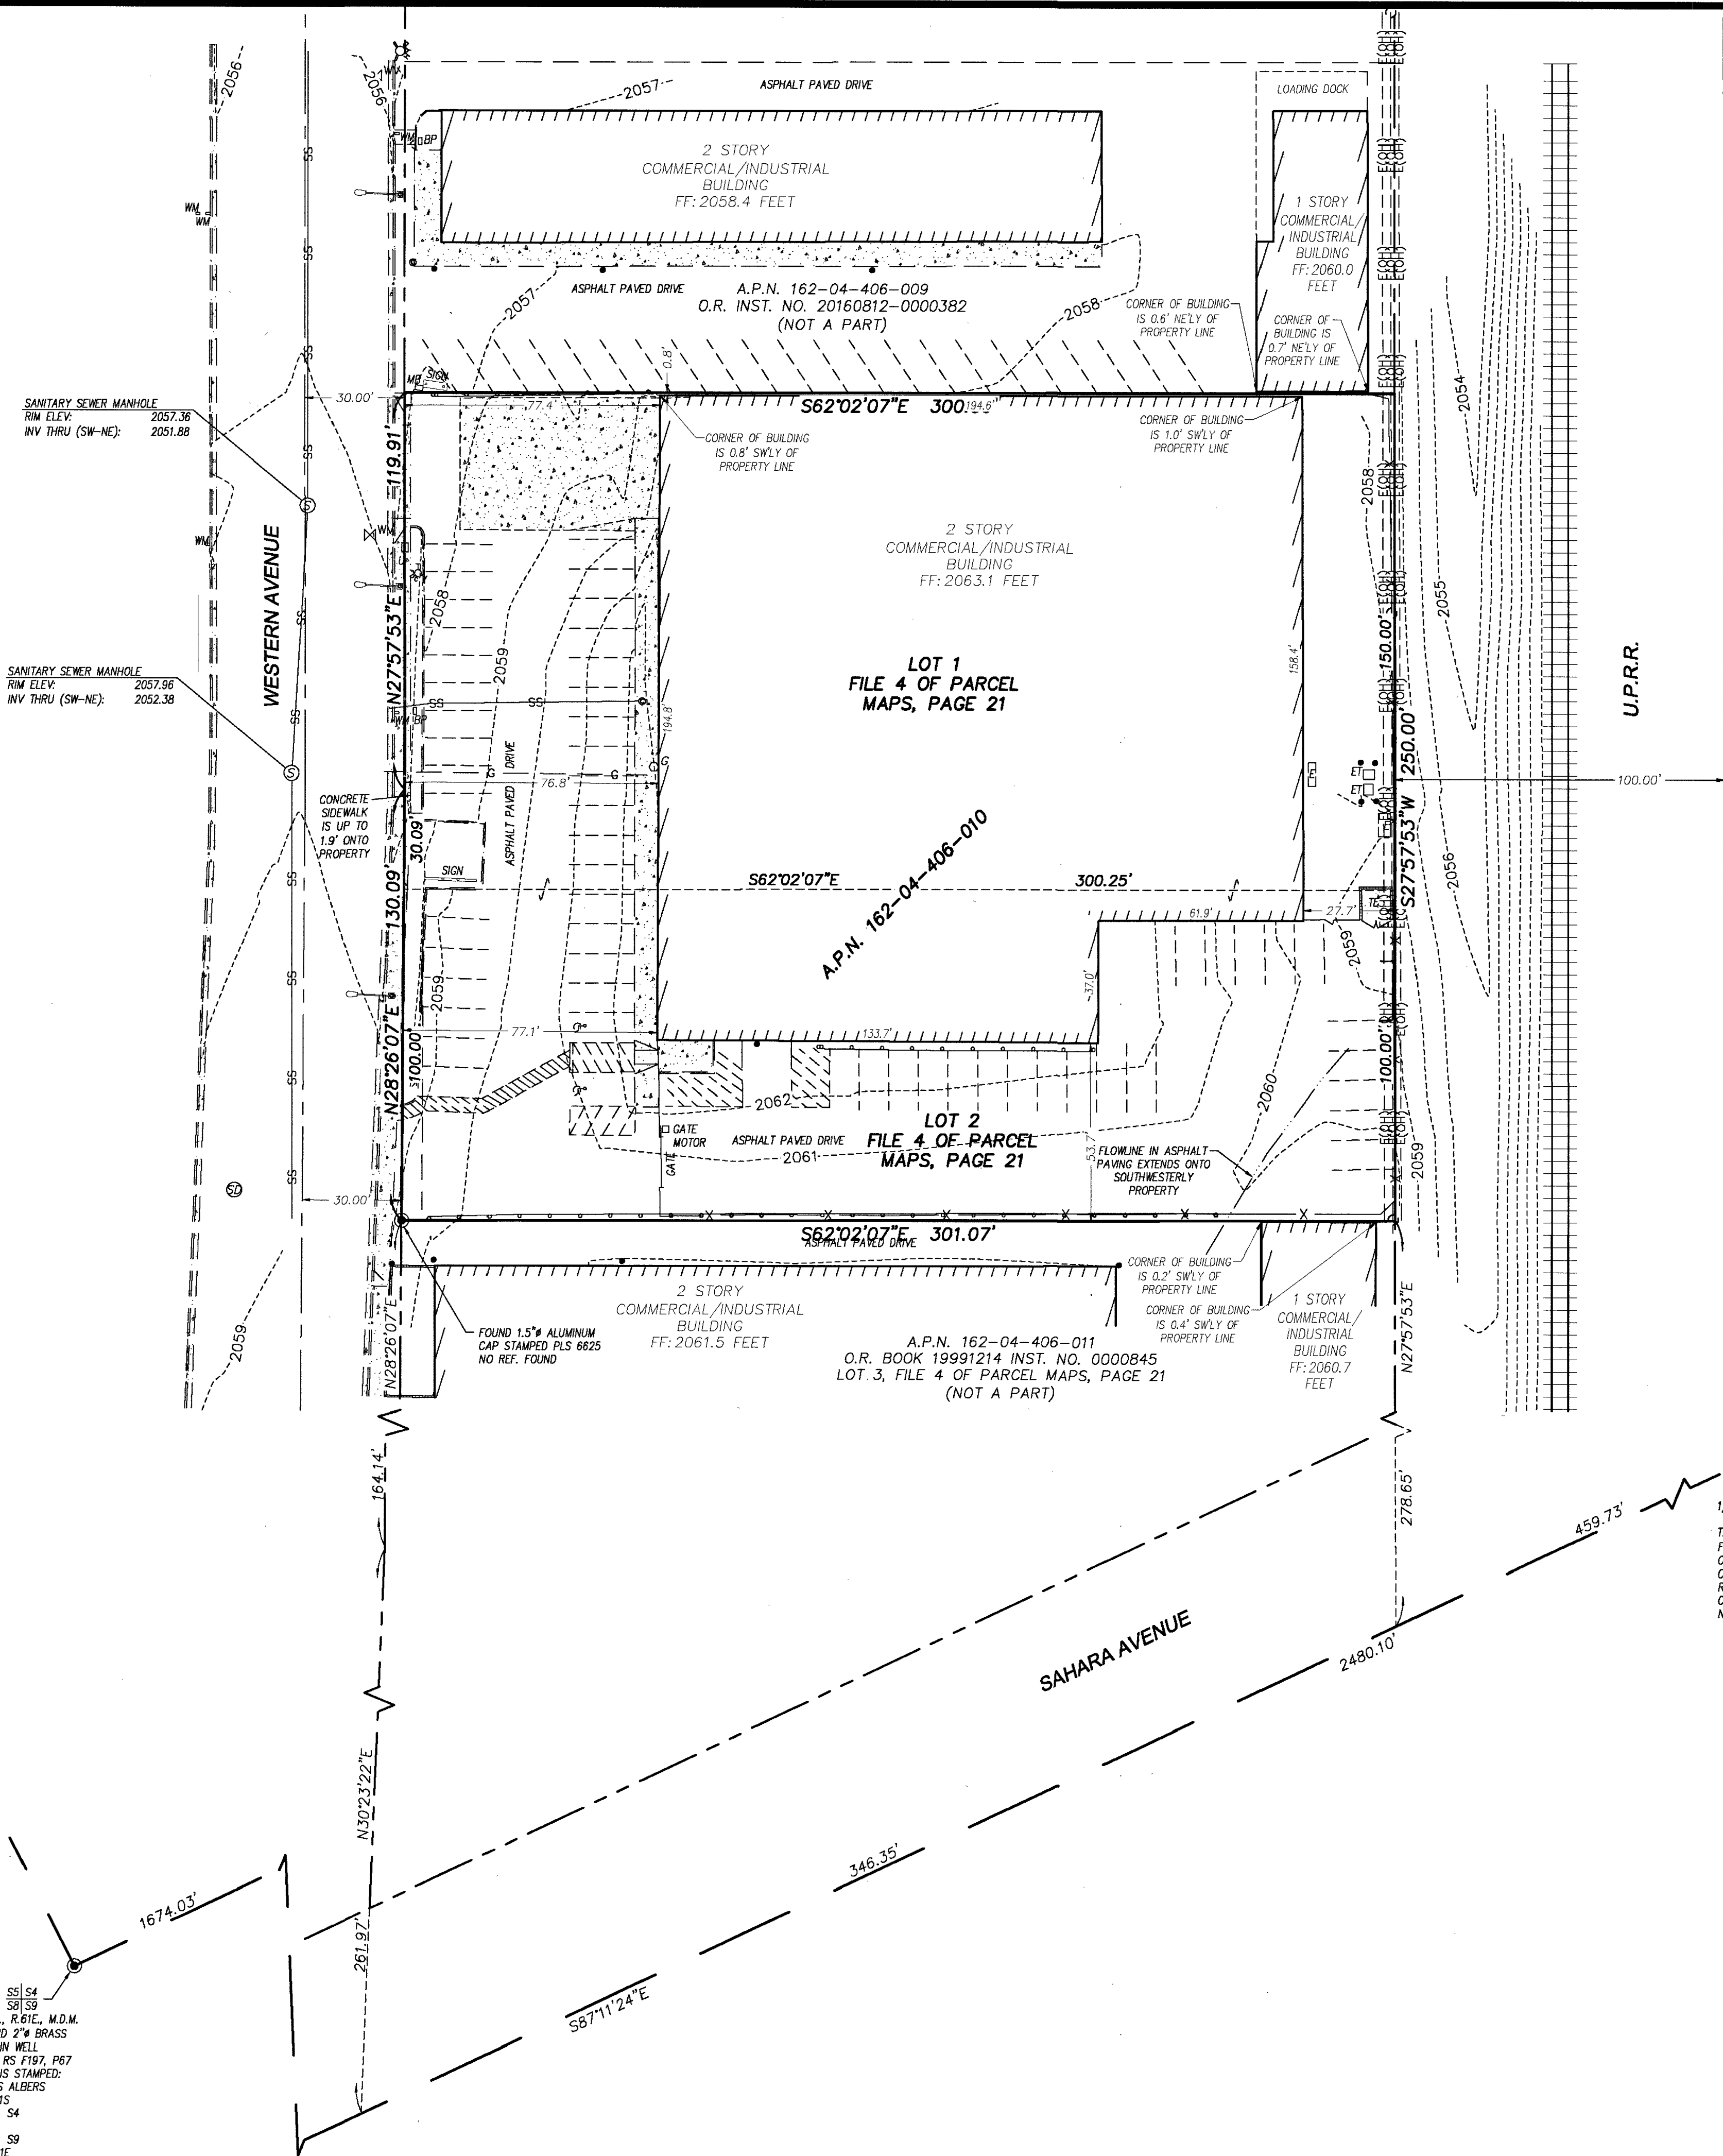

LEGEND

—	CENTERLINE
—	SUBJECT PROPERTY
—	RIGHT-OF-WAY LINE
—	SECTION LINE
—	ONE QUARTER SECTION LINE
—	CONCRETE CURB & GUTTER
—	CHAIN LINK FENCE
—	GUARDRAIL
—	SCREEN WALL
—	OVERHEAD ELECTRICAL
—	GAS LINE
—	WATER LINE
—	SANITARY SEWER LINE
—	BUILDING
—	RAILROAD TRACKS
—	UTILITY POLE
—	ELECTRICAL PULLBOX
—	ELECTRICAL TRANSFORMER
—	STREET LIGHT
—	NATURAL GAS METER ASSEMBLY
—	SANITARY SEWER MANHOLE
—	SANITARY SEWER CLEAN OUT
—	WATER METER
—	WATER LINE BACKFLOW PREVENTER
—	FIRE HYDRANT
—	WATER VALVE
—	REMOTE FDC
—	STORM DRAIN MANHOLE
—	BOLLARD POST
—	HANDICAP PARKING
—	UTILITY PULLBOX - UNKNOWN
—	TRASH ENCLOSURE
—	MAILBOX

BASIS OF BEARINGS

NORTH 04°43'21" EAST, BEING THE BEARING OF THE EAST LINE OF THE SOUTHEAST QUARTER (SE 1/4) OF SECTION 4, TOWNSHIP 21 SOUTH, RANGE 61 EAST, M.D.M., CITY OF LAS VEGAS, CLARK COUNTY, NEVADA, AS SHOWN IN FILE 201 OF SURVEYS, PAGE 15, OFFICIAL RECORDS OF CLARK COUNTY, NEVADA.

BENCHMARK

CITY OF LAS VEGAS BENCHMARK, MONUMENT ID 12LV114S4, BEING A RIVET AND PLATE IN TOP OF CONCRETE BASE OF POWER POLE ON WEST SIDE OF INDUSTRIAL ROAD ACROSS FROM NORTH BRIDGE LANE.


PUBLISHED ELEVATION: 2055.23 (US SURVEY FEET)
626.437 (METERS)

DATE REESTABLISHED: 2012
DATE REOBSERVED: 2012
DATUM: NAVD88

FLOOD ZONE

AS SHOWN BY FLOOD INSURANCE RATE MAP NO. 32003C2170F, DATED NOVEMBER 16, 2011, LOCATED IN THE UNSHADED ZONE X, OTHER AREAS, AREAS DETERMINED TO BE OUTSIDE THE 0.2% ANNUAL CHANCE FLOODPLAIN.

BORING LOCATIONS

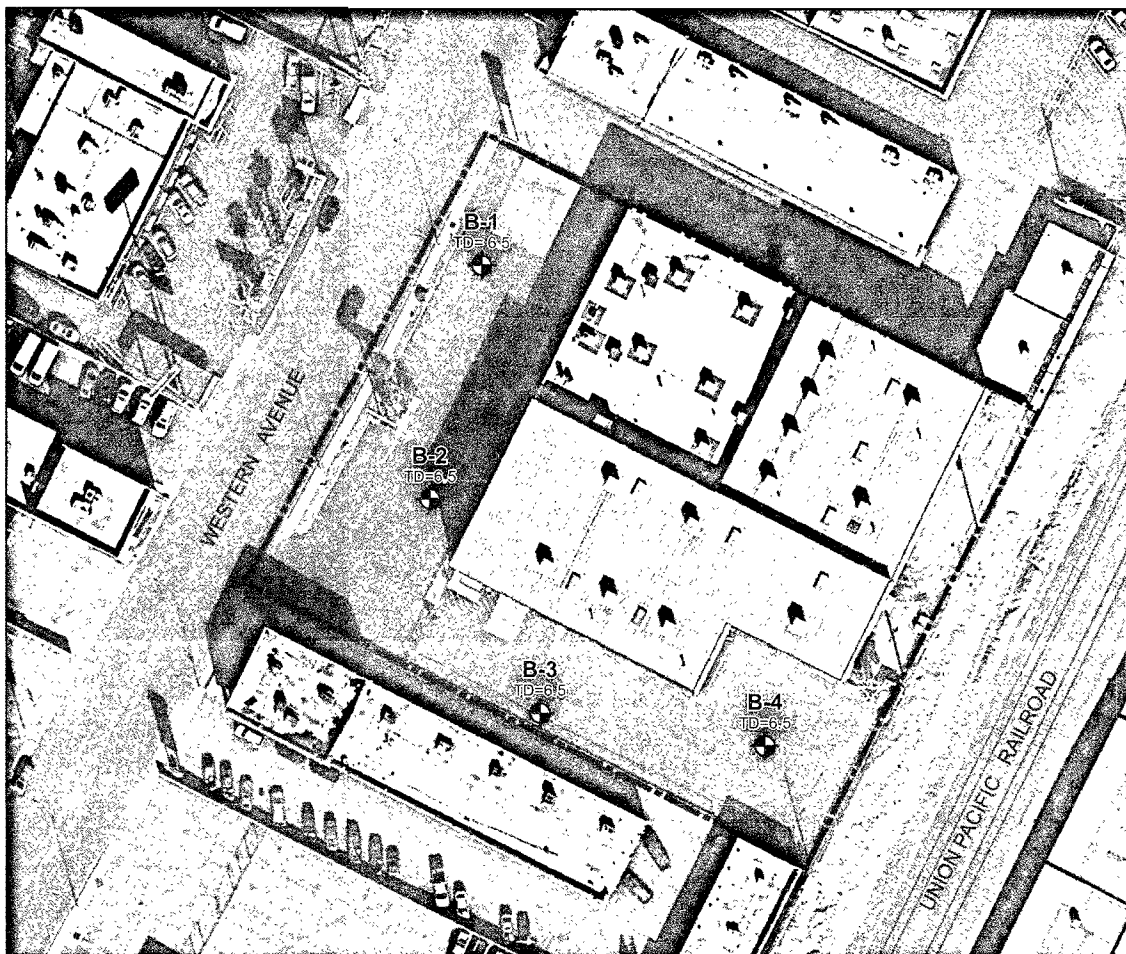

BOUNDARY AND TOPOGRAPHIC SURVEY OF
LOTS 1 AND 2 OF FILE 4 OF PARCEL MAPS, PAGE 21
CITY OF LAS VEGAS, CLARK COUNTY, NEVADA

DATE: 10/30/2018
DRAWN BY: DAW
CHECKED BY: TJK
JOB NO.: 180858

SHEET
C1

LYING WITHIN THE SOUTHWEST QUARTER (SW 1/4) OF SECTION 4, TOWNSHIP 21 SOUTH, RANGE 61 EAST, M.D.M., CITY OF LAS VEGAS, CLARK COUNTY, NEVADA

DESCRIPTION

REV DATE

DESCRIPTION


BOUNDARY AND TOPOGRAPHIC SURVEY OF
LOTS 1 AND 2 OF FILE 4 OF PARCEL MAPS, PAGE 21
CITY OF LAS VEGAS, CLARK COUNTY, NEVADA

DATE: 10/30/2018
DRAWN BY: DAW
CHECKED BY: TJK
JOB NO.: 180858


SHEET
C1

6140 BRANT THURMAN WAY, SUITE 230
LAS VEGAS, NEVADA 89148
(702) 833-9030
(702) 833-9030
diamondbacklandsurveying.com
NEVADA - CALIFORNIA - ARIZONA
UTAH - WASHINGTON


Diamondback
Land Surveying

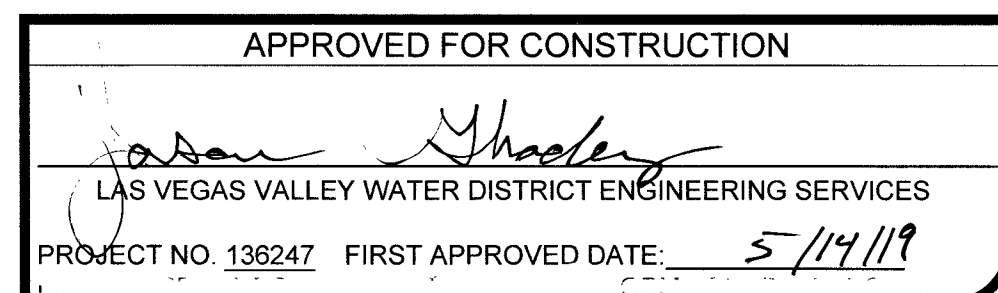

A.P.N. 162-04-406-011
O.R. BOOK 19991214 INST. NO. 0000845
LOT 3, FILE 4 OF PARCEL MAPS, PAGE 21
(NOT A PART)

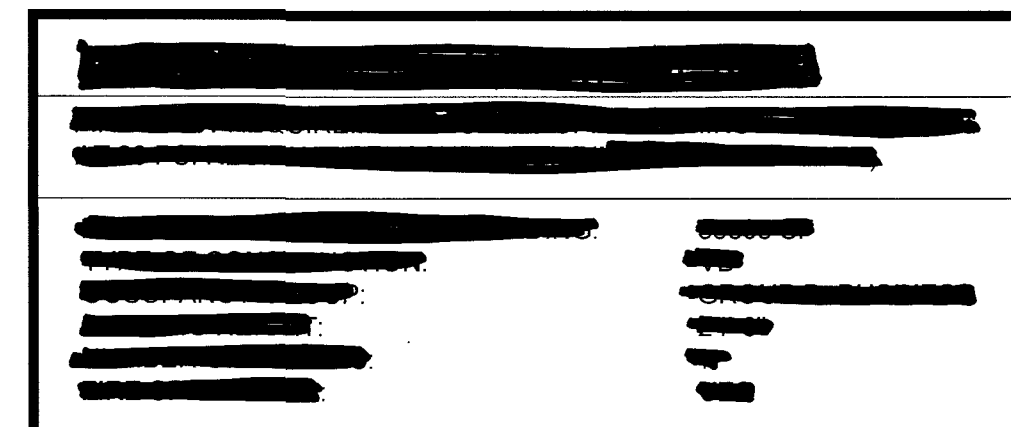

0 20 40 Feet

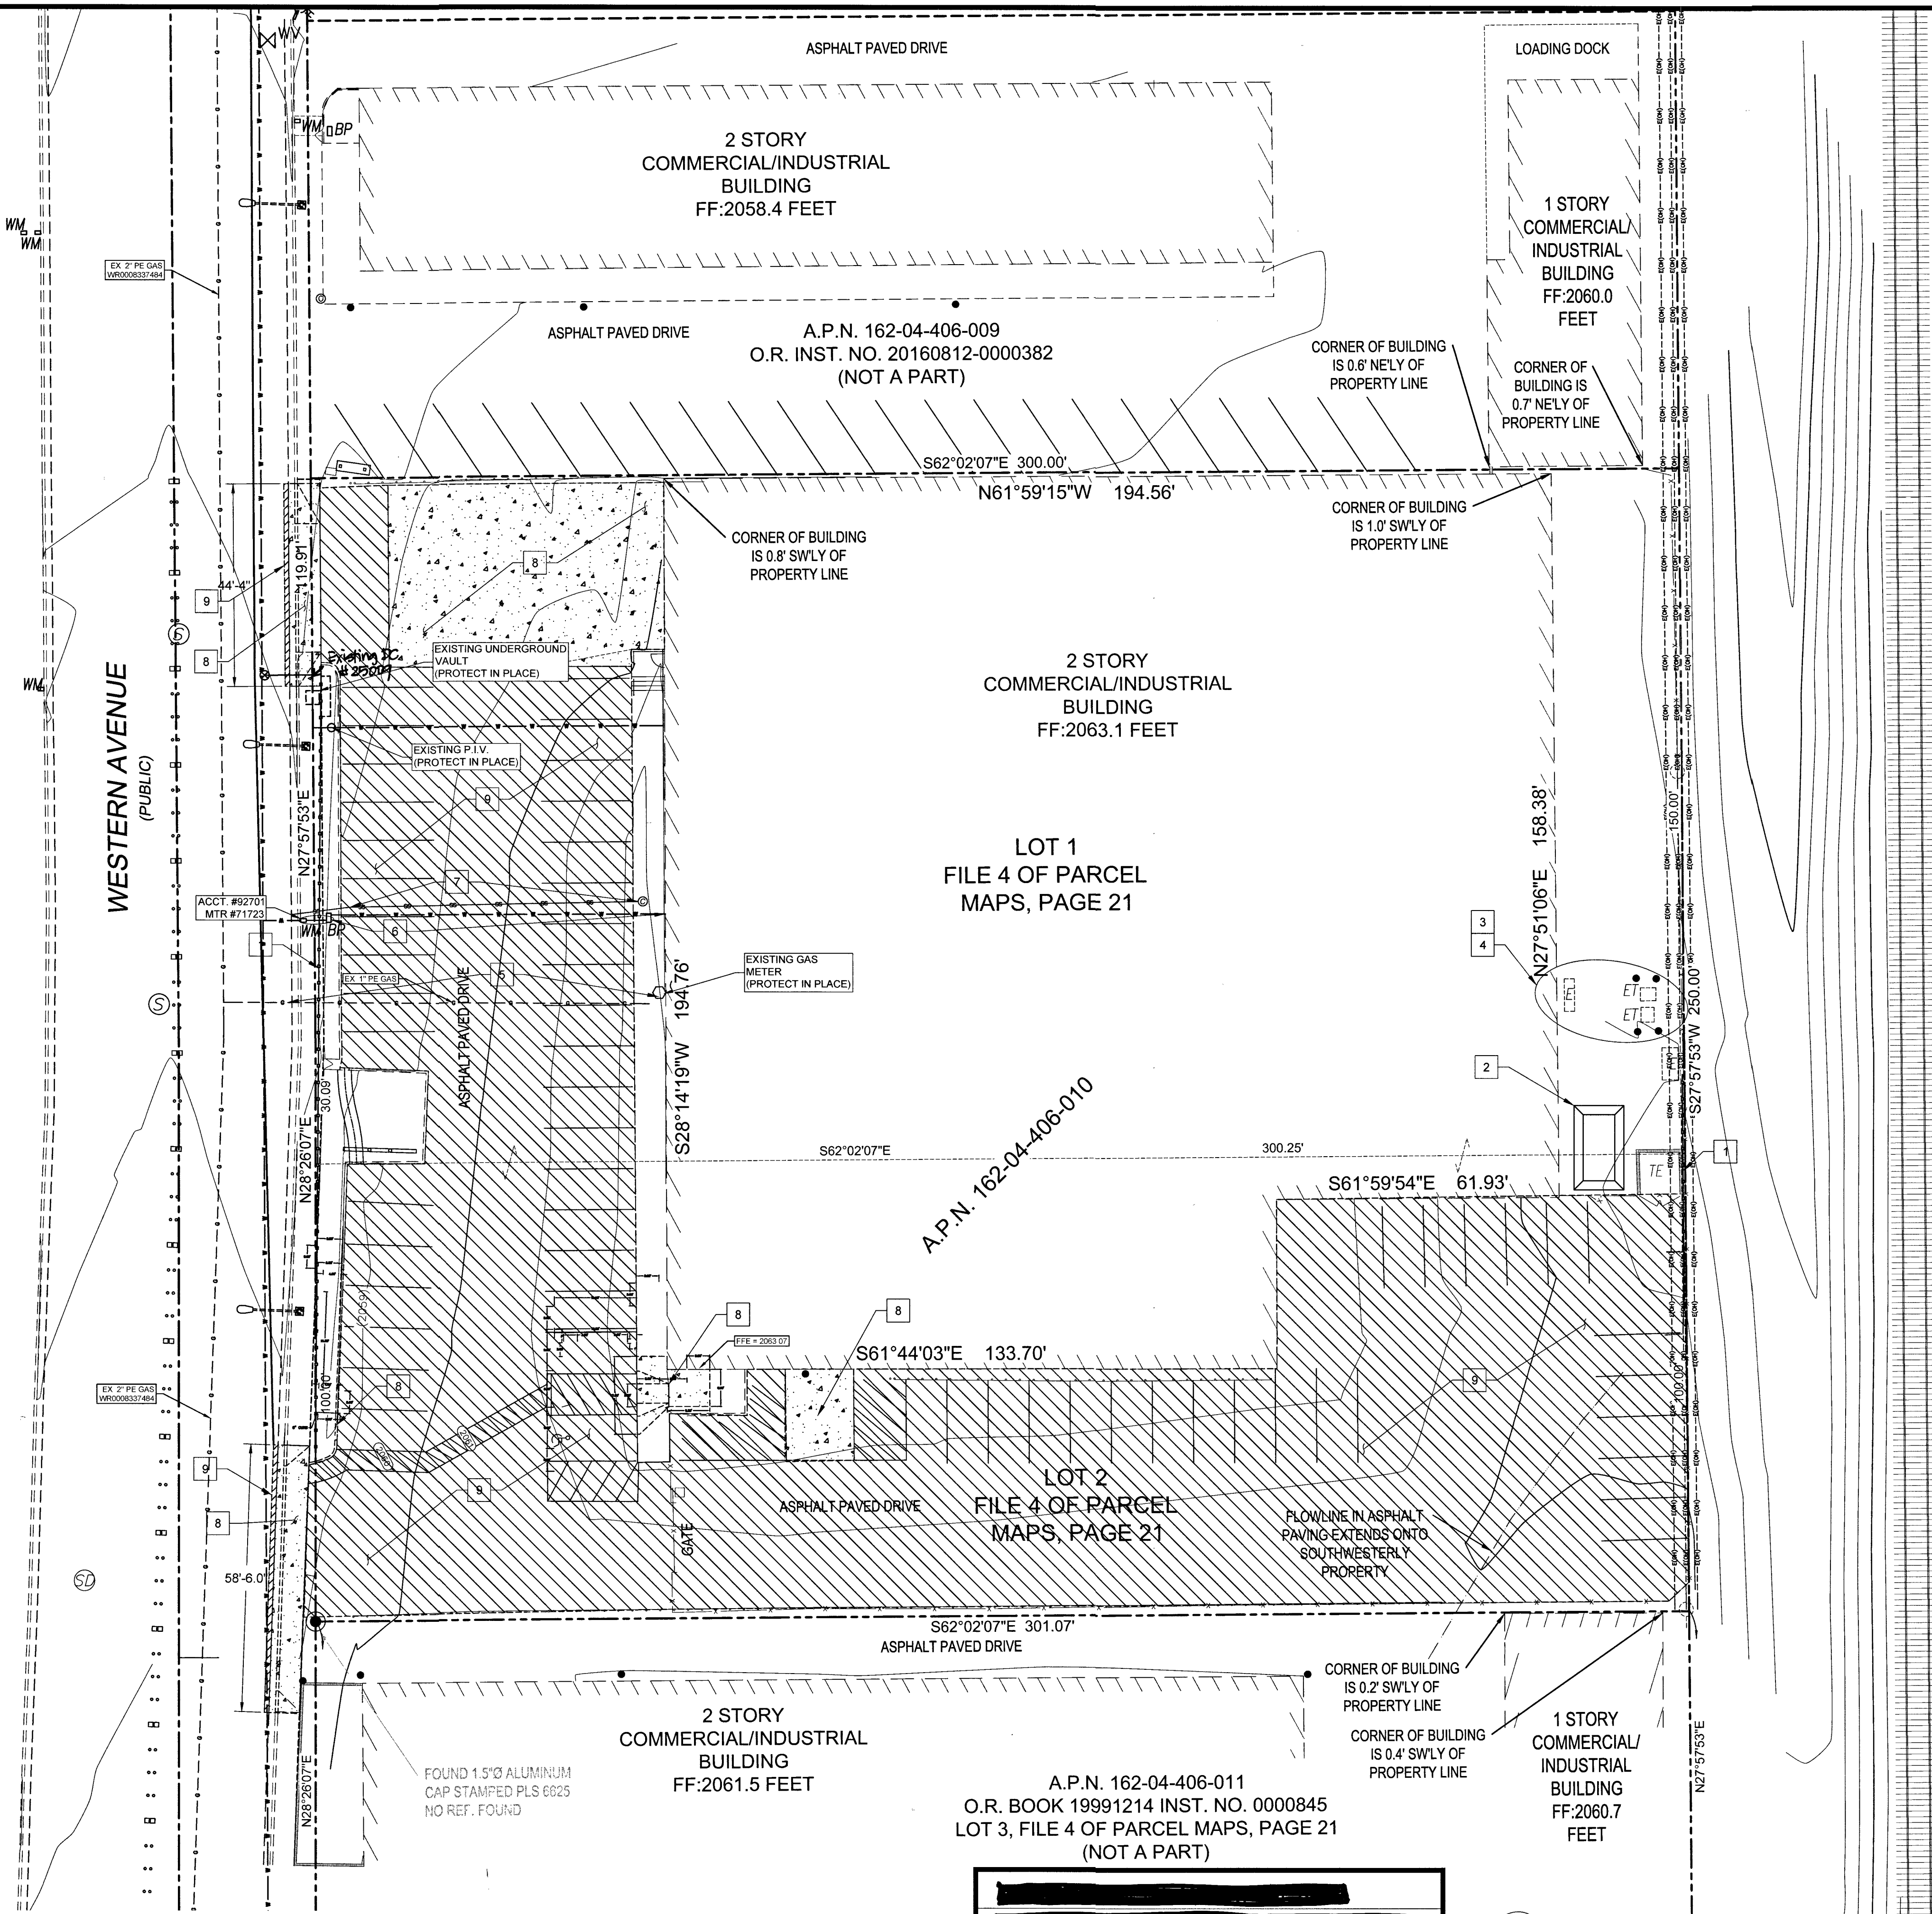


U.P.R.R.

EROSION CONTROL NOTES

- ALL EROSION AND SEDIMENT CONTROLS SHALL BE INSTALLED PER THE STATE OF NEVADA STATE CONSERVATION COMMISSION BEST MANAGEMENT PRACTICE HANDBOOK DATED DECEMBER 7, 1994 (NVBMHP).
- PRIOR TO THE START OF CLEARING, GRUBBING, OR EARTHMOVING ACTIVITIES, THE CONTRACTOR SHALL INSTALL ALL PERIMETER CONTROLS AND THE CONSTRUCTION ENTRANCE PER THE PLANS.
- THE CONTRACTOR SHALL INSTALL PROTECTION AROUND ANY EXISTING INLETS WITHIN THE PUBLIC RIGHT-OF-WAY, PER LOCAL OR STATE STANDARDS.
- THE CONTRACTOR SHALL PROVIDE APPROPRIATE MEANS TO DIRECT NATURAL DRAINAGE AROUND WORK AREAS, AND TO PREVENT OFF-SITE RUN-ON THROUGH THE CONSTRUCTION AREA.
- THE CONTRACTOR SHALL STORE ADEQUATE SEDIMENT CONTROL MATERIALS ONSITE TO CONTROL DISCHARGES AT THE DOWNGRADE PERIMETER AND OPERATIONAL INLETS IN THE EVENT OF A PREDICTED STORM, AS FORECASTED BY THE NWS.
- EQUIPMENT AND WORKERS SHALL BE AVAILABLE FOR EMERGENCY WORK AT ALL TIMES. ALL NECESSARY MATERIALS SHALL BE STOCKPILED ONSITE AT CONVENIENT LOCATIONS TO FACILITATE THE RAPID INSTALLATION/CONSTRUCTION OF TEMPORARY EROSION CONTROL MEASURES WHEN RAIN IS IMMINENT.
- CLEARING AND GRUBBING SHALL BE DONE ONLY IN AREAS WHERE EARTHWORK WILL BE PERFORMED AND ONLY IN AREAS WHERE CONSTRUCTION IS PLANNED TO COMMENCE WITHIN 14 DAYS AFTER THE CLEARING AND GRUBBING.
- DISTURBED AREAS OF THE SITE WHERE CONSTRUCTION ACTIVITY HAS CEASED FOR MORE THAN 14 DAYS SHALL BE TEMPORARILY STABILIZED WITH HYDROSEEDING, HYDROMULCHING, OR WITH A BIODEGRADABLE BONDED FIBER MATRIX.
- THE CONTRACTOR SHALL INSTALL ADDITIONAL EROSION CONTROL MEASURES AS NEEDED OR AS REQUESTED BY A CITY OR STATE OFFICIAL, THE OWNER'S ENGINEER, AND/OR REGULATORY AGENCY.
- THE CONTRACTOR SHALL BE RESPONSIBLE AND TAKE NECESSARY PRECAUTIONS TO PREVENT PUBLIC TRESPASS INTO AREAS WHERE IMPOUNDED WATERS CREATE A HAZARDOUS CONDITION.
- IF CONSTRUCTION OCCURS BETWEEN OCTOBER AND MAY, CONTRACTOR SHALL FURNISH AND INSTALL EROSION CONTROL BLANKET (NORTH AMERICAN GREEN C125N OR EQUAL) ON ALL CUT AND FILL SLOPES.


EROSION & SEDIMENT CONTROL LEGEND

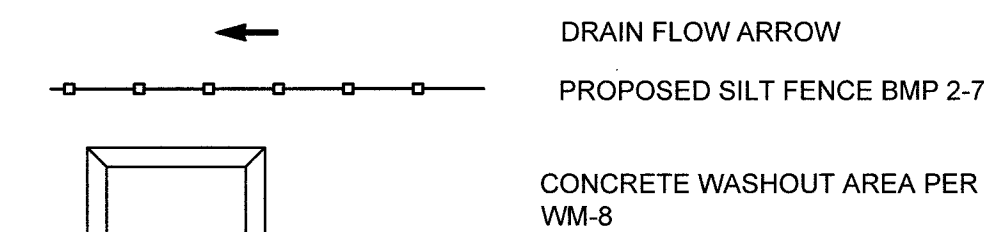

REFER TO THE STATE OF NEVADA STATE CONSERVATION COMMISSION BEST MANAGEMENT PRACTICE HANDBOOK DATED DECEMBER 7, 1994 (NVBMHP)

Concrete Washout Area (CWA)

MM-1

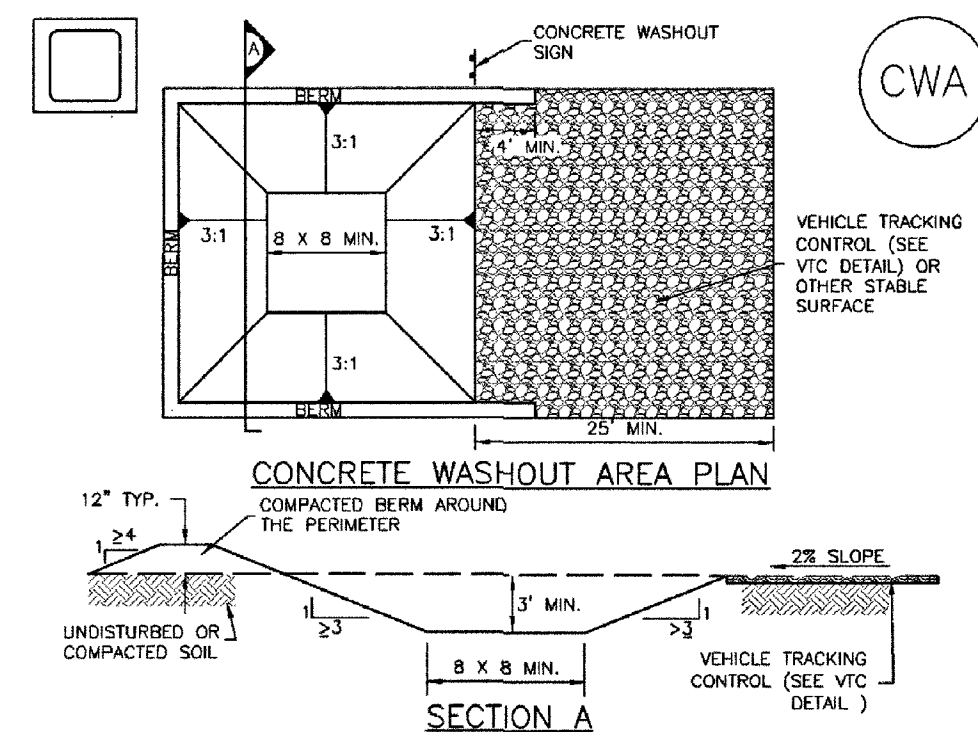


CWA-1. CONCRETE WASHOUT AREA

- CWA INSTALLATION NOTES
- SEE PLAN VIEW FOR CWA INSTALLATION LOCATION.
 - DO NOT LOCATE AN UNLINED CWA WITHIN 400' OF ANY NATURAL DRAINAGE PATHWAY OR WATERBODY. DO NOT LOCATE WITHIN 1,000' OF ANY WELLS OR DRINKING WATER SOURCES. IF SITE CONSTRAINTS MAKE THIS INFEASIBLE, OR IF HIGHLY PERMEABLE SOILS EXIST ON SITE, THE CWA MUST BE INSTALLED WITH AN IMPERMEABLE LINER (16 MIL MIN. THICKNESS) OR SURFACE STORAGE ALTERNATIVES (USING PREFABRICATED CONCRETE WASHOUT DEVICES OR A UNLINED ABOVE GROUND STORAGE ARE SHOULD BE USED).
 - THE CWA SHALL BE INSTALLED PRIOR TO CONCRETE PLACEMENT ON SITE.
 - CWA SHALL INCLUDE A FLAT SUBSURFACE PIT THAT IS AT LEAST 8' BY 8' SLOPES LEADING OUT OF THE SUBSURFACE PIT SHALL BE 3:1 OR FLATTER. THE PIT SHALL BE AT LEAST 3' DEEP.
 - BERM SURROUNDING SIDES AND BACK OF THE CWA SHALL HAVE MINIMUM HEIGHT OF 1'.
 - VEHICLE TRACKING PAD SHALL BE SLOPED 2% TOWARDS THE CWA.
 - SGNS SHALL BE PLACED AT THE CONSTRUCTION ENTRANCE, AT THE CWA, AND ELSEWHERE AS NECESSARY TO CLEARLY INDICATE THE LOCATION OF THE CWA TO OPERATORS OF CONCRETE TRUCKS AND PUMP RIGS.
 - USE EXCAVATED MATERIAL FOR PERIMETER BERM CONSTRUCTION.


November 2010 Urban Drainage and Flood Control District CWA-3
Urban Storm Drainage Criteria Manual Volume 3

DEMOLITION NOTES	
1	INSTALL PERIMETER SILT FENCE AT LOCATIONS SHOWN HEREON
2	CONSTRUCT CONCRETE WASHOUT AREA PER DETAIL HEREON
3	EXISTING TELEPHONE SERVICE (PROTECT IN PLACE)
4	EXISTING ELECTRIC SERVICE (PROTECT IN PLACE)
5	EXISTING GAS SERVICE (PROTECT IN PLACE)
6	EXISTING WATER METER, BACKFLOW DEVICE AND SERVICE LATERAL (PROTECT IN PLACE)
7	EXISTING SEWER SERVICE (PROTECT IN PLACE)
8	SAWCUT AND REMOVE EXISTING CONCRETE
9	SAWCUT AND REMOVE FULL DEPTH ASPHALT PAVEMENT, BASE MATERIAL AND SUBGRADE

SWITCHED GAS CORPORATION 5/14/19 DATE 107V8033

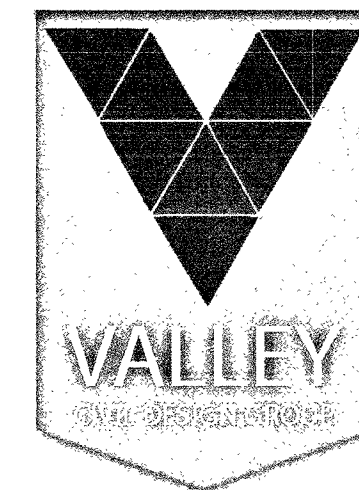


8275 S. EASTERN AVE.
SUITE 200
LAS VEGAS, NV 89123
702.551.2005
www.valley-cdg.com

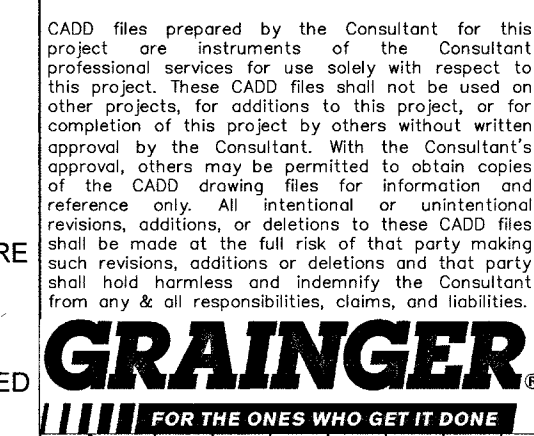

No.	Date	Revision/Issue

GRAINGER #423
2401 WESTERN AVENUE
LAS VEGAS, NV 89102
DEMOLITION PLAN

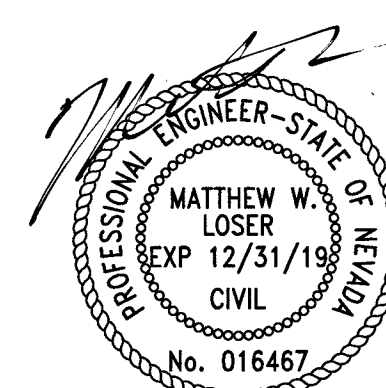


5/7/19

CHECKED BY
MI
VALLEY CIVIL DESIGN JOB NO.
18-517

ISSUE DATE: 12/05/2018
SHEET

C2 3

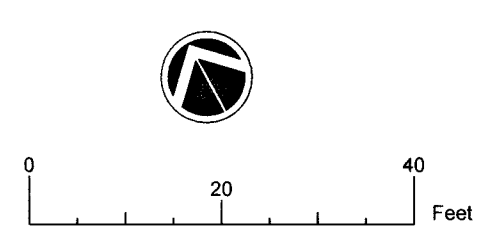

CADD files prepared by the Consultant for this project are the instruments of the Consultant's professional services for use solely with respect to this project. These CADD files shall not be used on other projects, for additions to this project, or for completion of this project by others without written approval by the Consultant. With the Consultant's written approval, others may be permitted to use copies of the CADD drawing files for information and reference only. All intentional or unintentional revisions, additions, or deletions to these CADD files shall be made at the full risk of that party making such revisions, additions, or deletions. The Consultant shall hold harmless and indemnify the Consultant


[illegible]

GRAINGER #423
2401 WESTERN AVENUE
LAS VEGAS, NV 89102

GRADING AND REHABILITATION PLAN

Chubb 5/9/12
SOUTHWEST GAS CORPORATION DATE


PAVING CONSTRUCTION NOTES	
10	CONSTRUCT "L" TYPE CURB AND GUTTER PER CCAUSD #216
11	CONSTRUCT "A" TYPE CURB AND GUTTER PER CCAUSD #219
12	CONSTRUCT COMMERCIAL DRIVEWAY PER CCAUSD # 224
13	CONSTRUCT SIDEWALK PER CCAUSD # 234
14	TRENCH AND PAVEMENT REPAIR PER CCAUSD 500.3, 500.5, 503
15	CONSTRUCT 7" PCC W/ #4 BARS 16" OCEW, OVER 6" CLS II A.B., OVER 6" COMPACTED SUBGRADE
16	CONSTRUCT 2.5" A.C. OVER 4" TYPE II A.B., OVER 6" COMPACTED SUBGRADE
17	CONSTRUCT 2.5" A.C. OVER 5" TYPE II A.B., OVER 6" COMPACTED SUBGRADE
18	CONSTRUCT 3" A.C. OVER 7" TYPE II A.B., OVER 6" COMPACTED SUBGRADE
19	CONSTRUCT 3' WIDE VALLEY GUTTER PER DETAIL 12, C6
20	CONSTRUCT 2' WIDE CURB OPENING
21	CONSTRUCT TYPE 1 ADA RAMP PER DETAIL 1, C6
22	INSTALL WHEEL STOPS PER DETAIL 7, C6
22A	INSTALL TRUNCATED DOMES PER DETAIL A, C6
29	CONSTRUCT 3' WIDE XERISCAPE SWEALE, 6" DEPTH

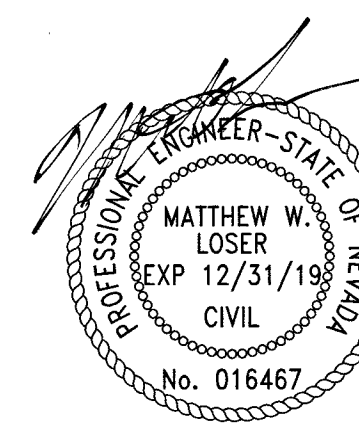

5/7/1



CHECKED BY
MI
VALLEY CIVIL DESIGN JOB No.
18-517
ISSUE DATE: 12/05/2018
SHEET

 C3 4



PARKING REQUIREMENTS :		
	REQUIRED	PROVIDED
PARKING REQ'D WAREHOUSE/ DISTRIBUTION	1 SPACE/ 1000SF	1.28 SPACE/ 1000SF
	36	46
ADA PARKING:	2 (1 VAN STALL)	2 (1 VAN STALL)
LOADING SPACES:	3	3

		SIGNAGE AND STRIPING CONSTRUCTION NOTES
23		4" SOLID WHITE STRIPING
24		4" SOLID BLUE STRIPING
25		INSTALL ADA STENCILING PER DETAIL B, C6
26		ADA PARKING SIGN W/ "VAN ACCESSIBLE" AT STALLS MARKED "VAN" PER DETAIL 9, C6
27		NON-VAN ACCESSIBLE SIGNAGE WITH ISA AND FINE SIGN ONLY PER DETAIL 9, C6
28		ADA DIRECTIONAL SIGNAGE PER DETAIL 6, C6

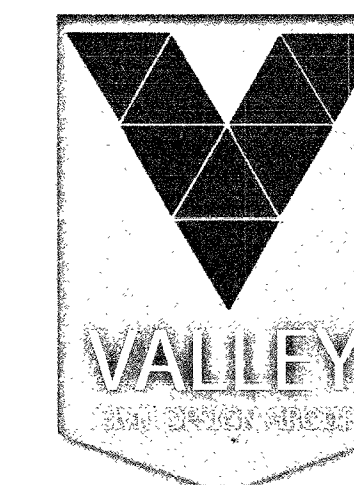 


8275 S. EASTERN AVE
SUITE 200
LAS VEGAS, NV 89123
702.551.2005
www.vallley-cdg.com

CADD files prepared by the Consultant for this project are instruments of the Consultant's professional service for use solely with respect to this project. These CADD files shall not be used for other projects, for additions to this project, or for completion of this project by others without written approval by the Consultant. Indeed, the Consultant's approval, others may be permitted to obtain copies of the CADD drawing files for information and reference only. All intentional or unintentional revisions, additions or deletions to these CADD files shall be made at the Consultant's expense. The Consultant shall have no liability for the work product of such revisions, additions or deletions and that party shall hold harmless and indemnify the Consultant.

[illegible]

GRAINGER #423
2401 WESTERN AVENUE
LAS VEGAS, NV 89102

STRIPING PLAN

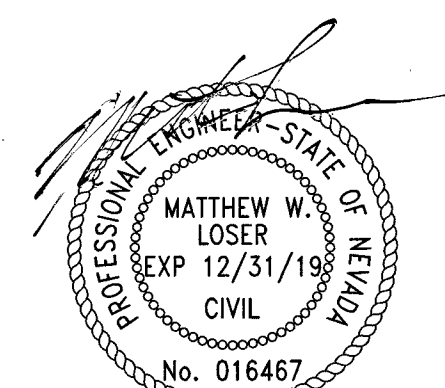



5/7

CHECKED BY MI	
VALLEY CIVIL DESIGN JOB No. 18-517	
ISSUE DATE:	12/05/2018
SHEET	
C4 5	


L19-00139
107V8033

FILE X-TOP-SURV.DWG

 PLOTTED: Tuesday, May 07, 2019

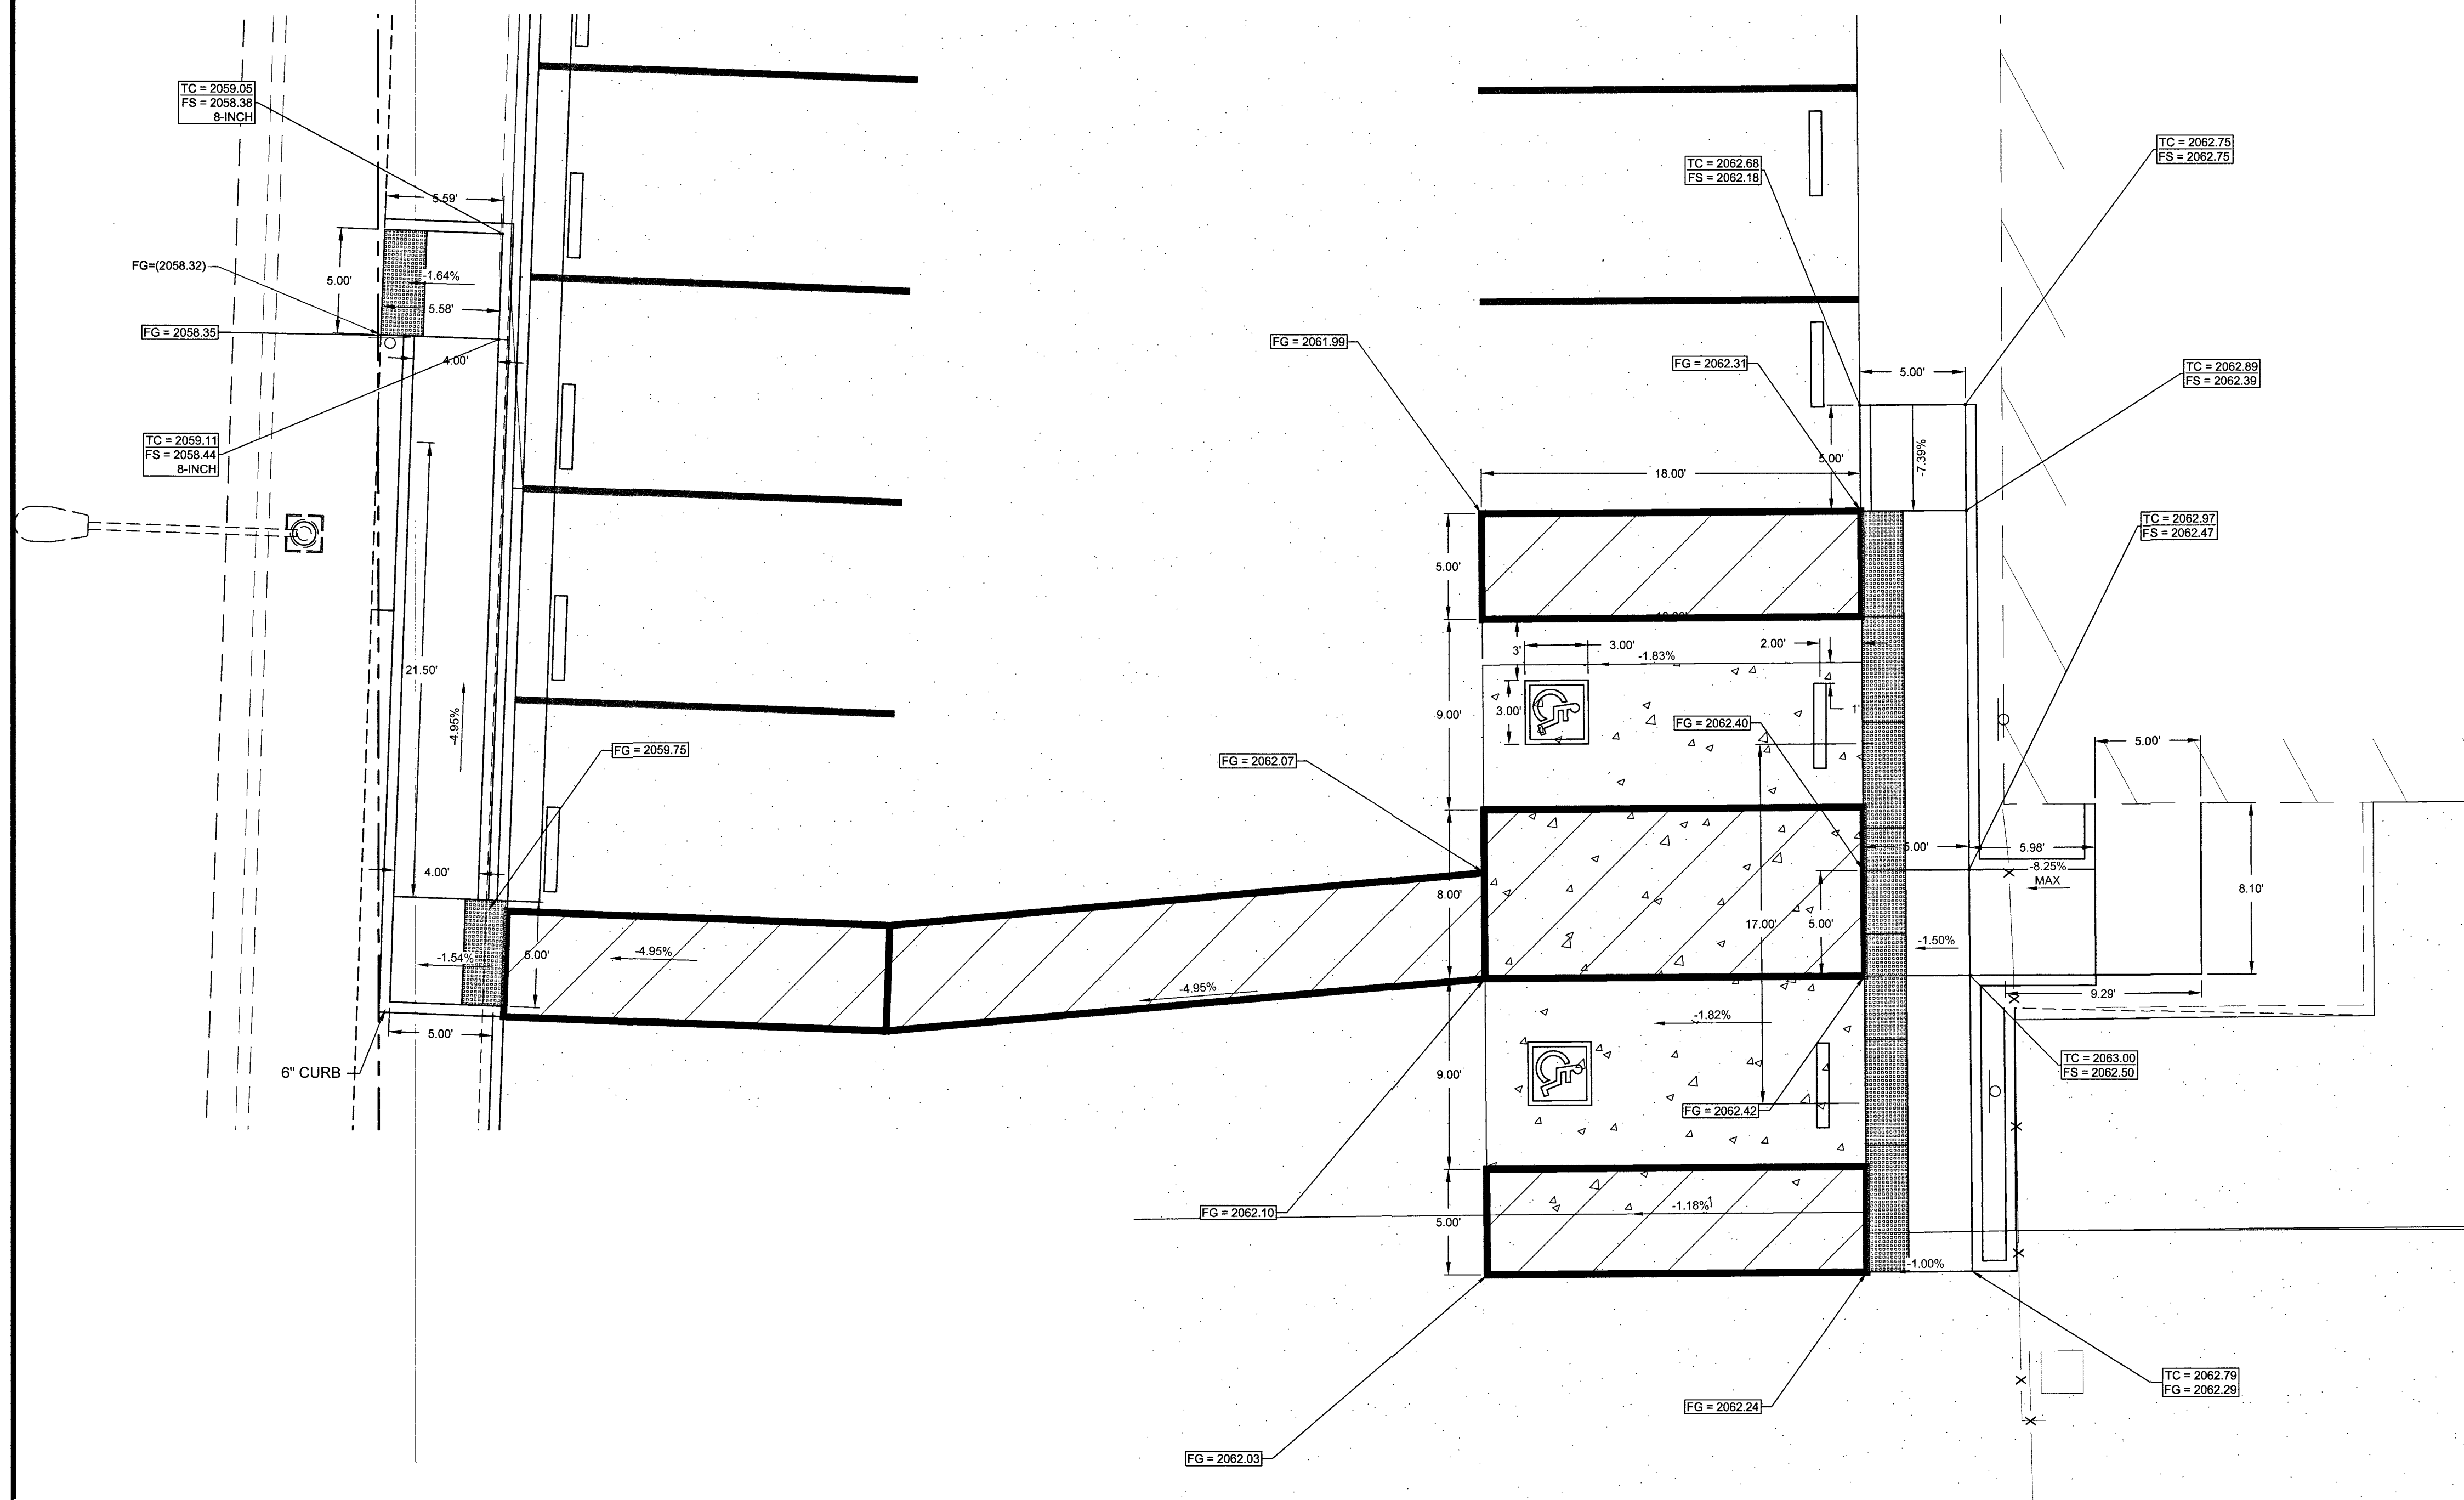

L19-60139
107V 8033

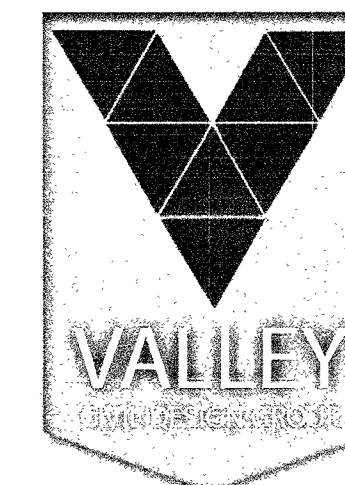


8275 S. EASTERN AVE.
SUITE 200
LAS VEGAS, NV 89123
702.551.2005
www.valley-cdg.com

CADD files prepared by the Consultant for this project are instruments of the Consultant's professional services for use solely with respect to this project. These CADD files shall not be used or other projects, for additions to this project, or for completion of this project by others without written approval by the Consultant. With the Consultant's approval, others may be permitted to obtain copies of the CADD drawing files for information and reference only. All intentional or unintentional revisions, additions, or deletions to these CADD files shall be made at the full risk of that party making such revisions, additions or deletions and that party shall hold harmless and indemnify the Consultant from any & all responsibilities, claims, and liabilities.

GRAINGER
FOR THE ONES WHO GET IT DONE














No.	Revision/Issue	Date

GRAINGER #423
2401 WESTERN AVENUE
LAS VEGAS, NV 89102
ACCESSIBLE PARKING STALL PLAN

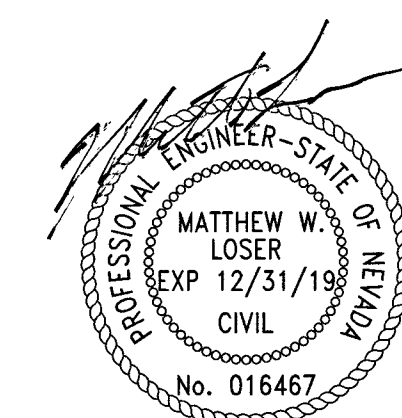

5/7/19

CHECKED BY	MI
VALLEY CIVIL DESIGN JOB No.	18-517
ISSUE DATE:	12/05/2018
SHEET	C5 6

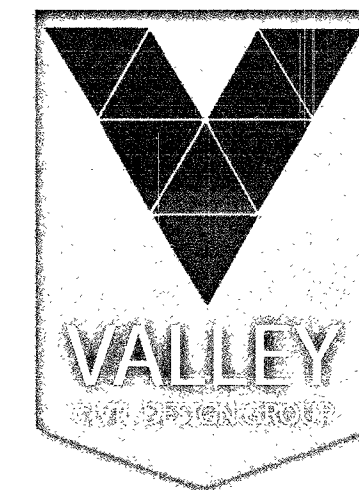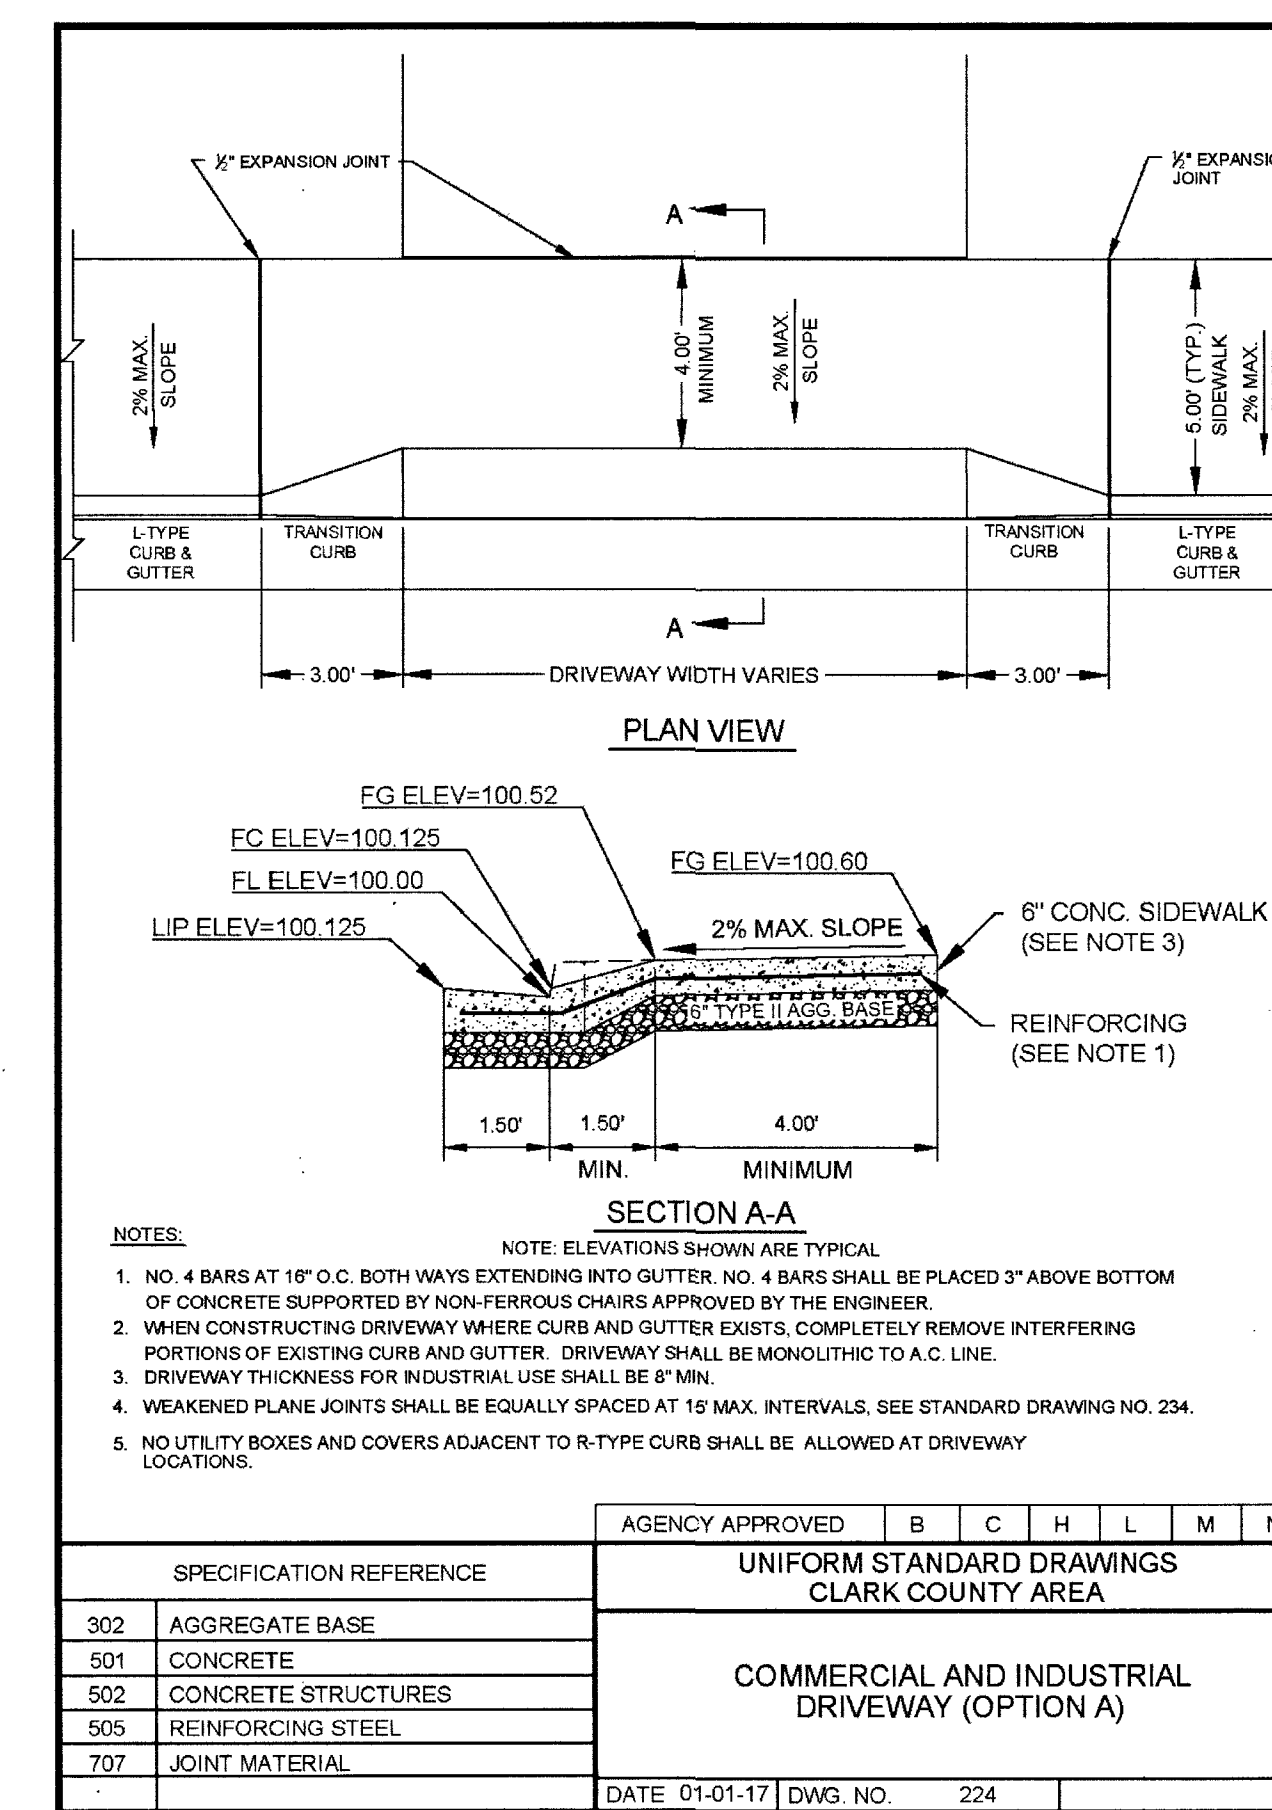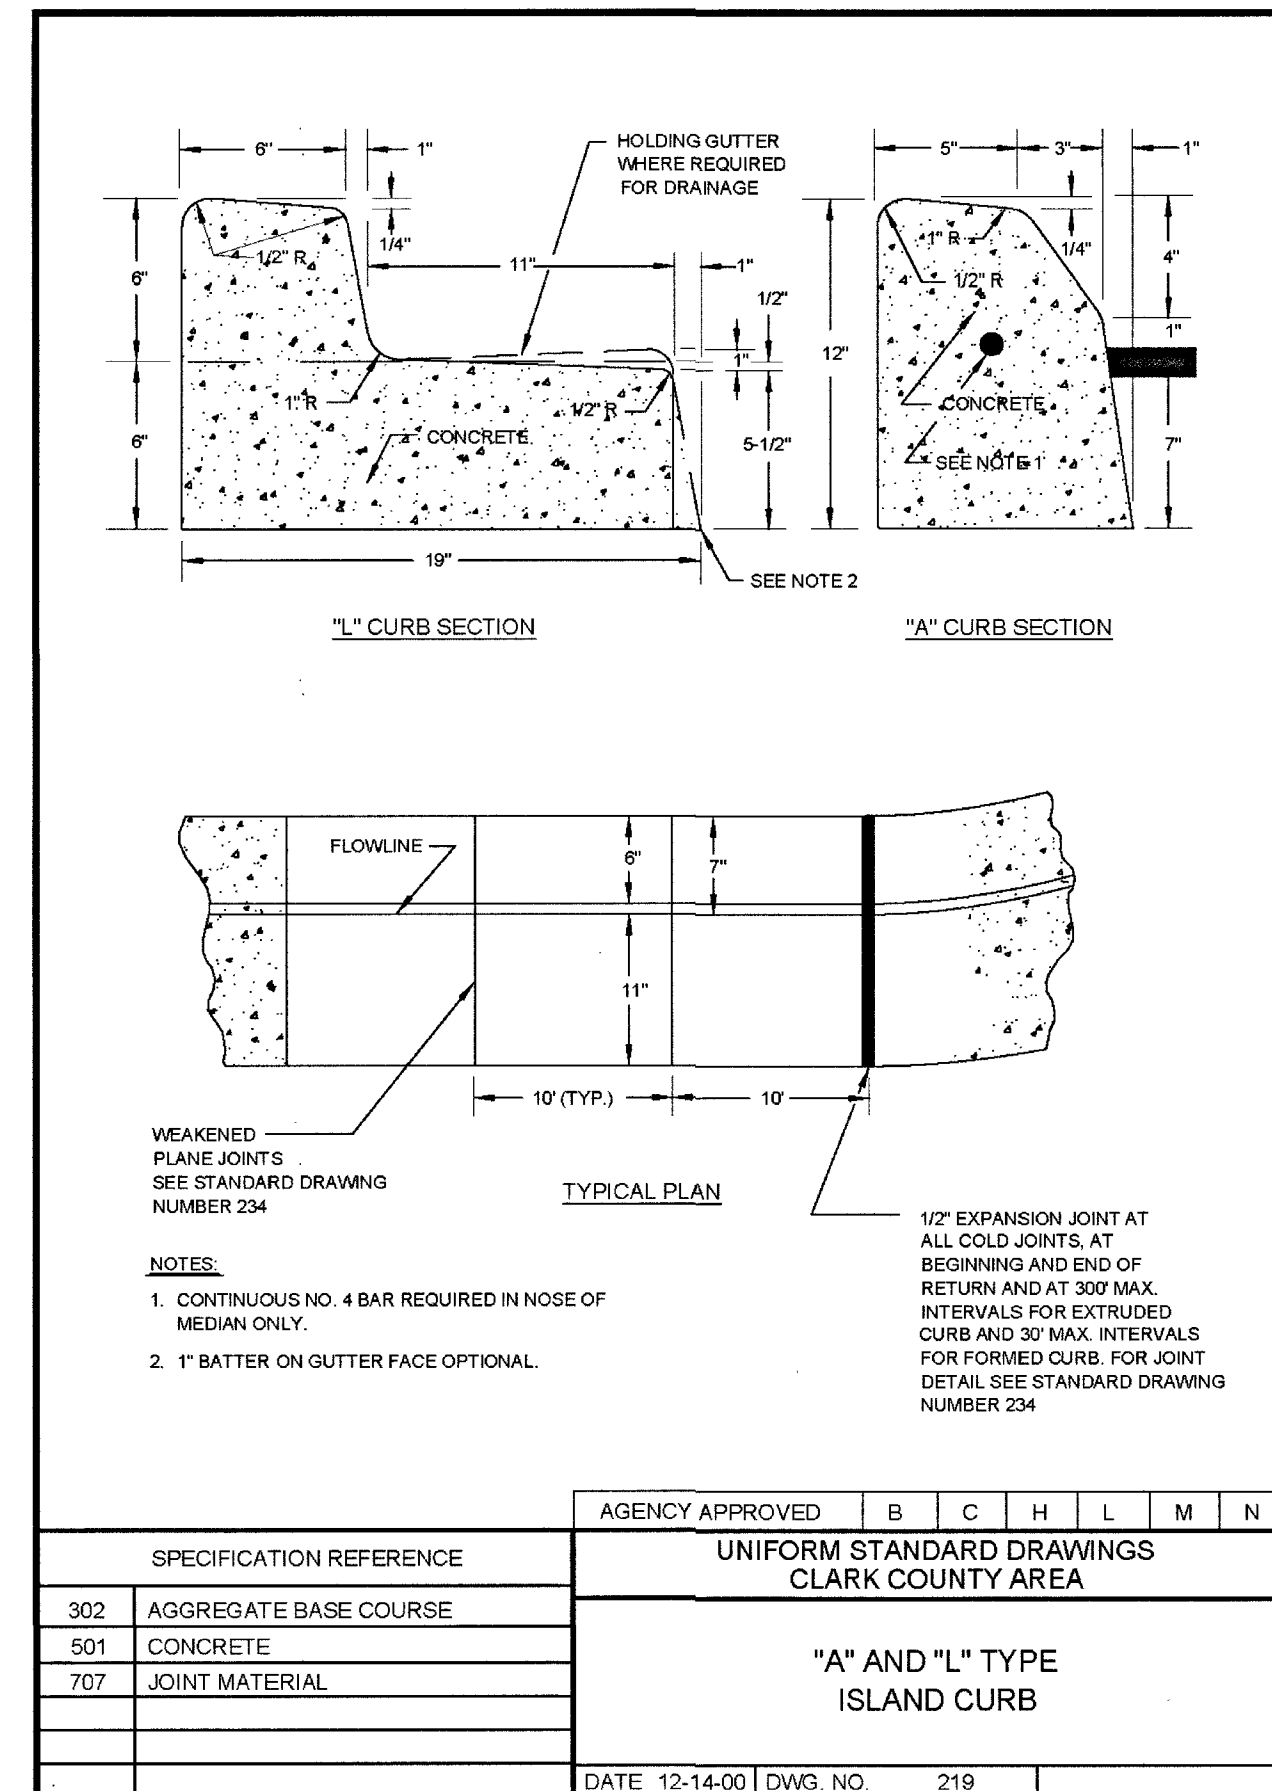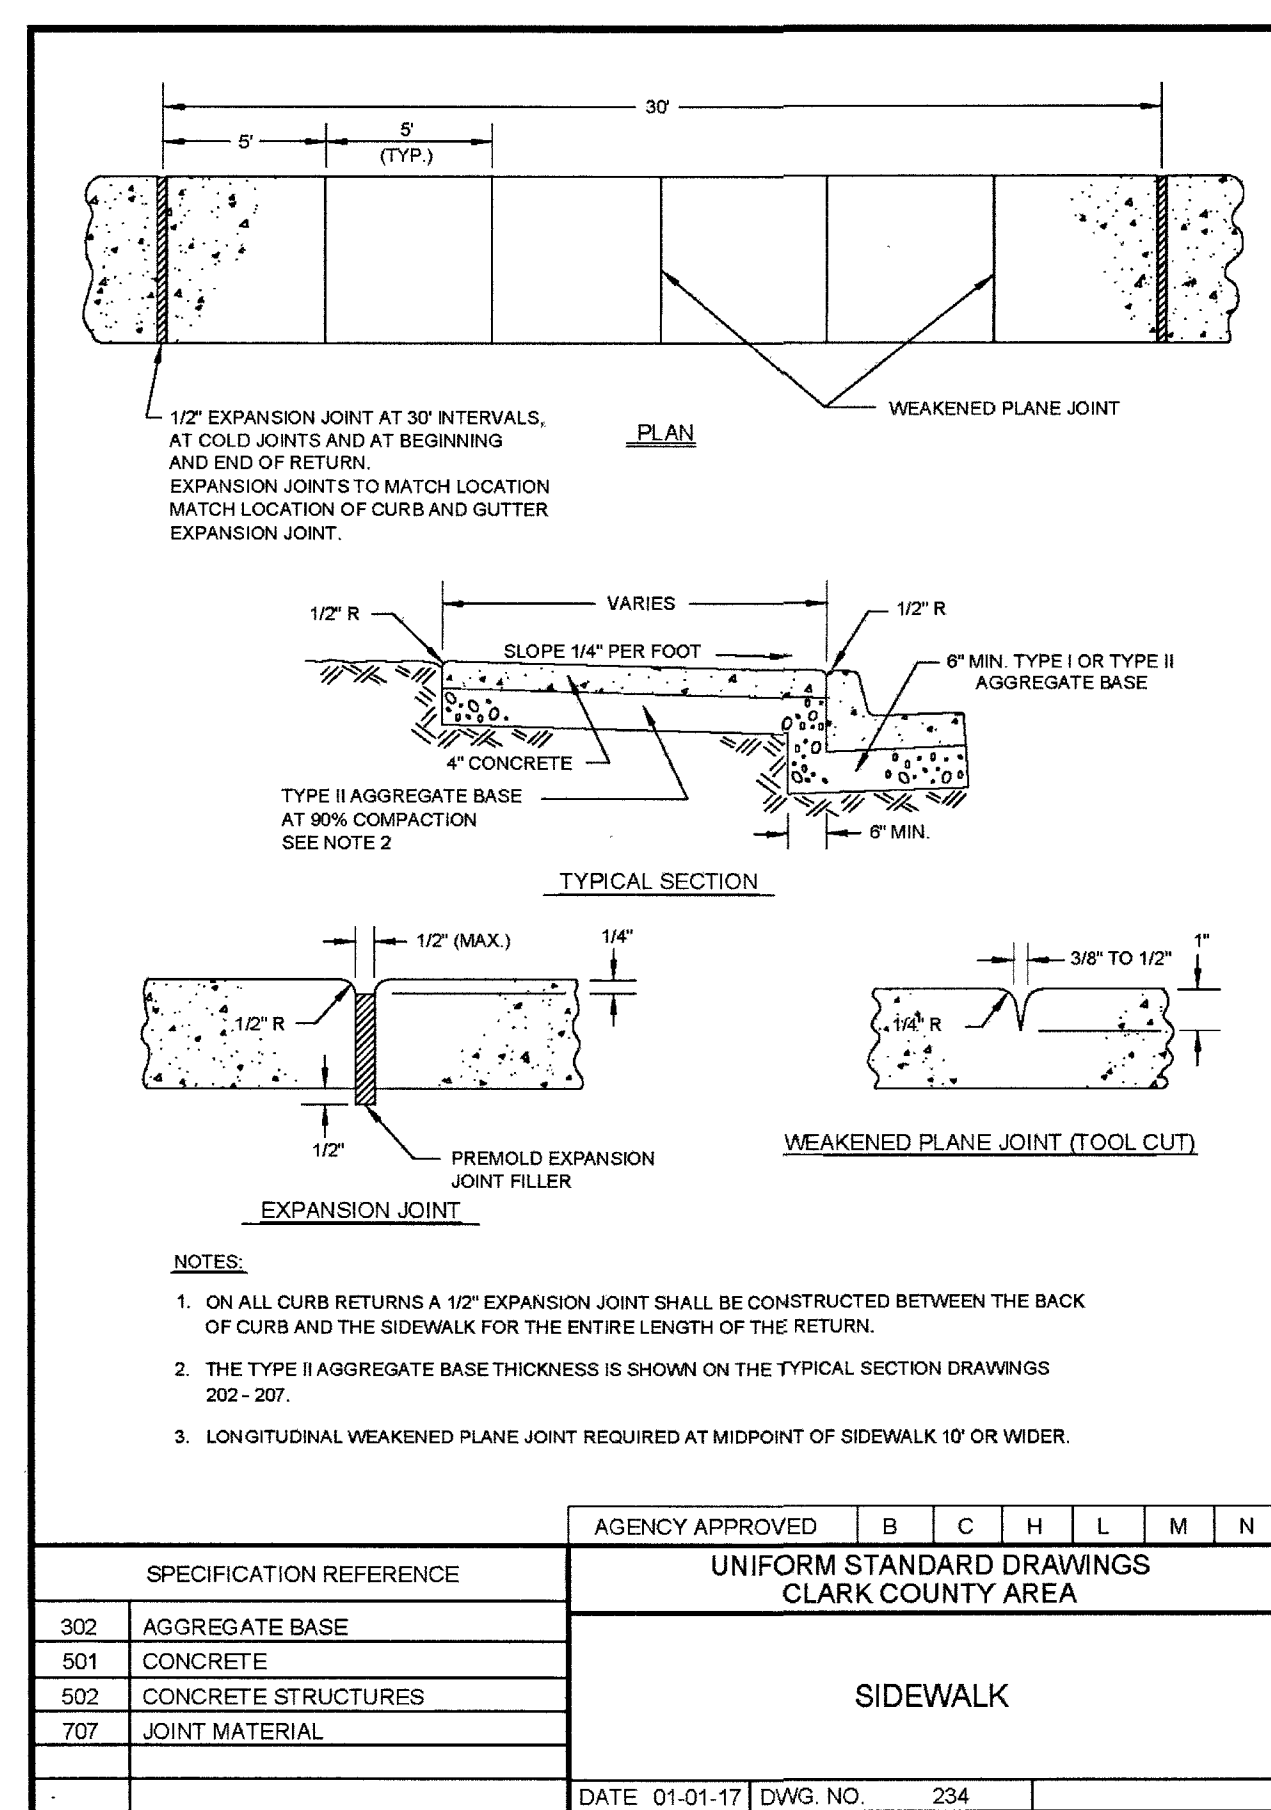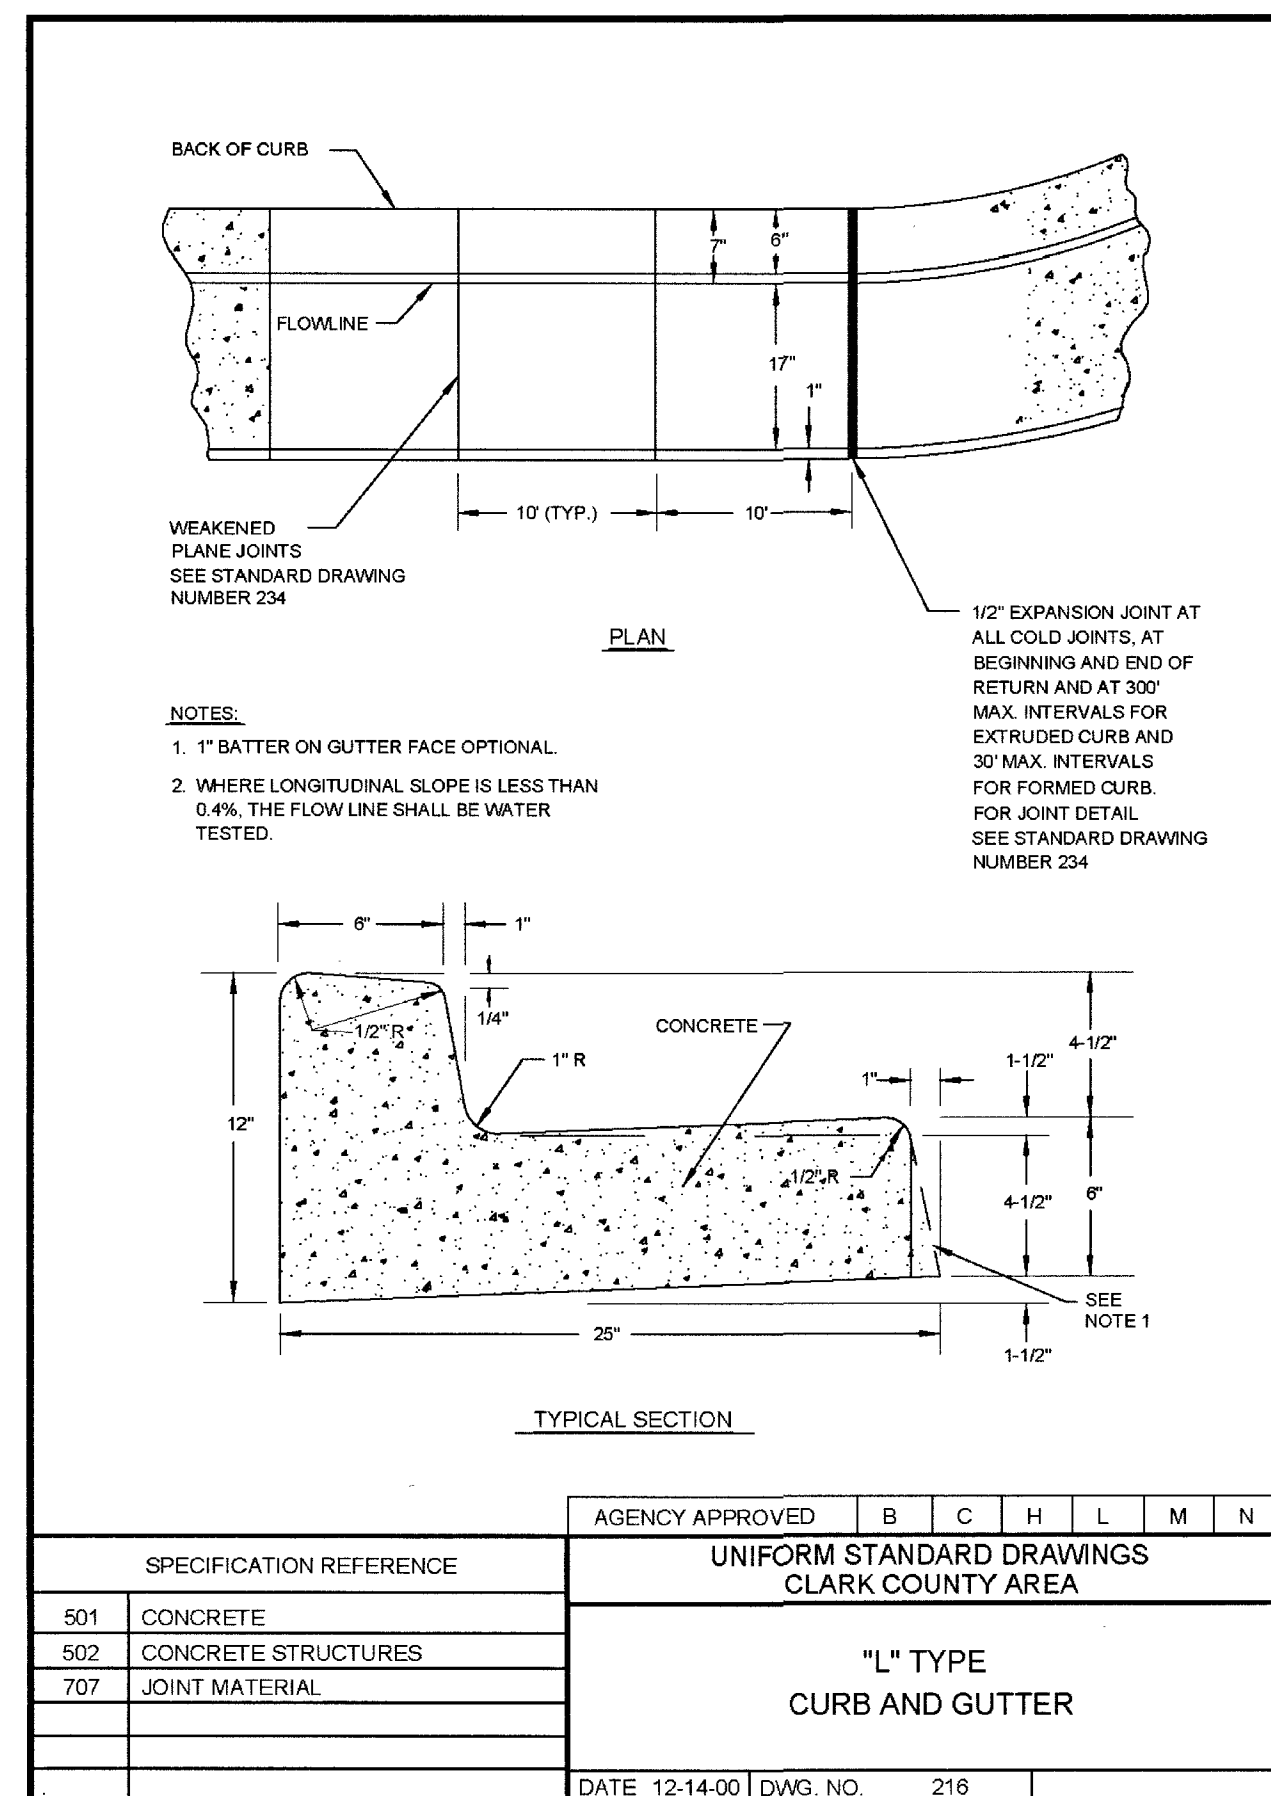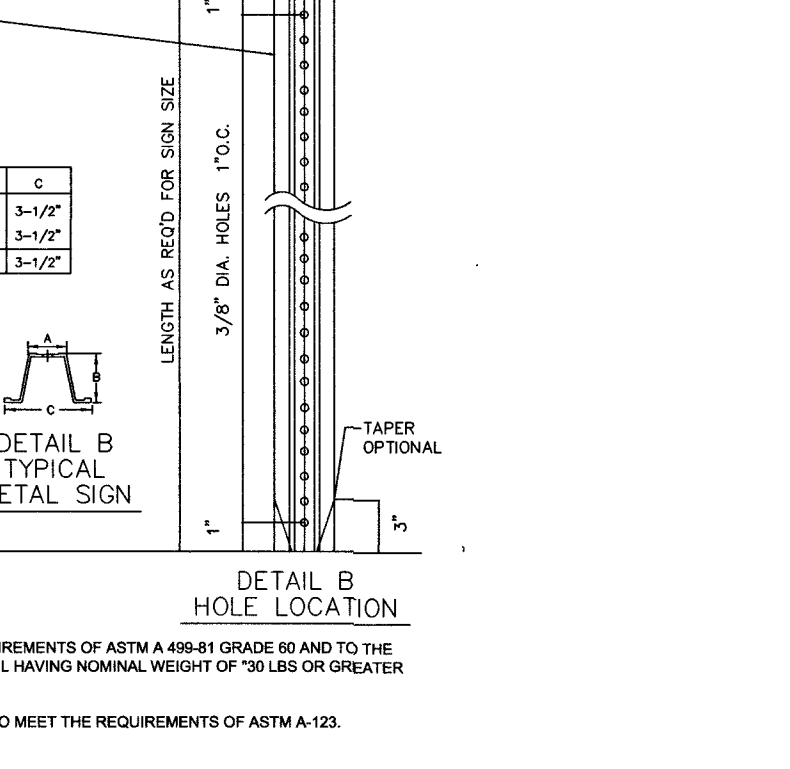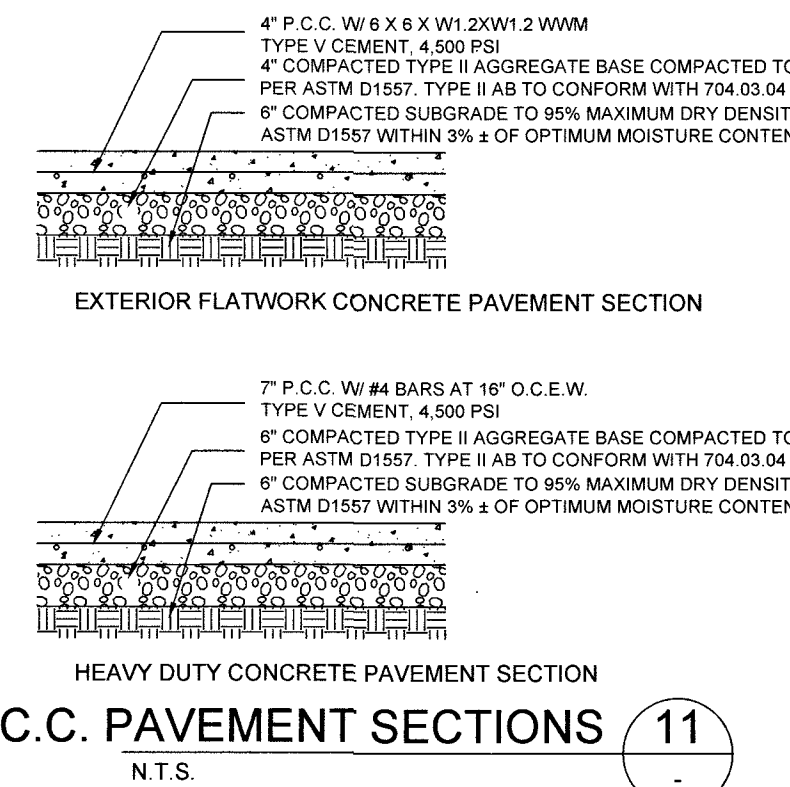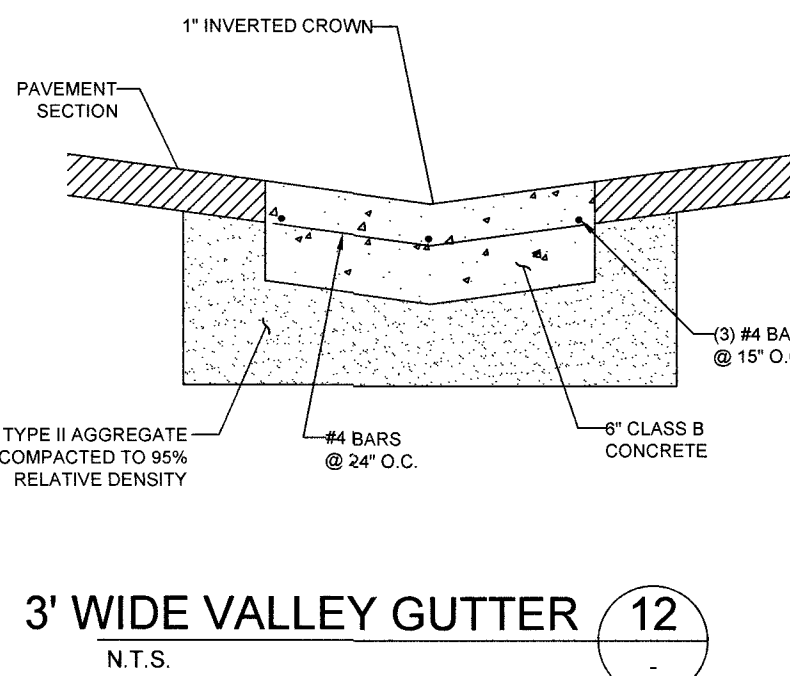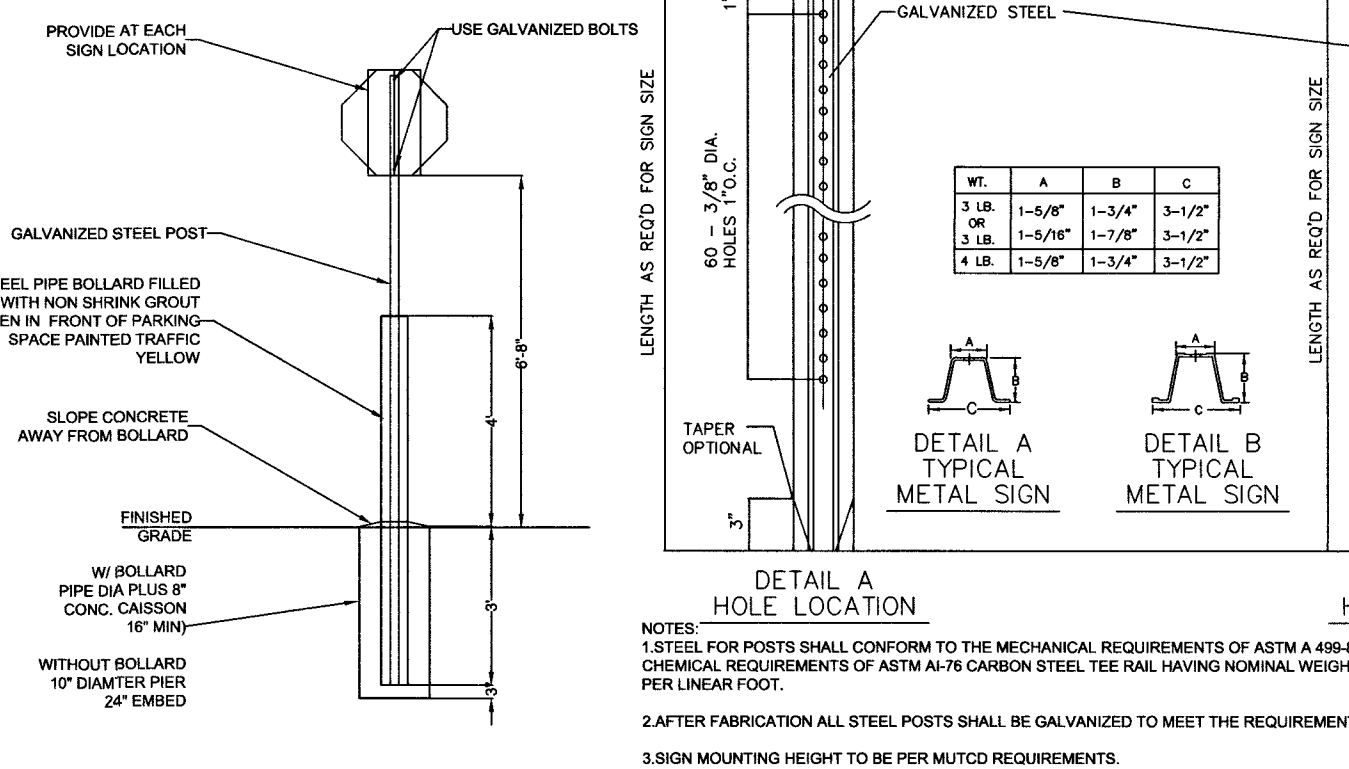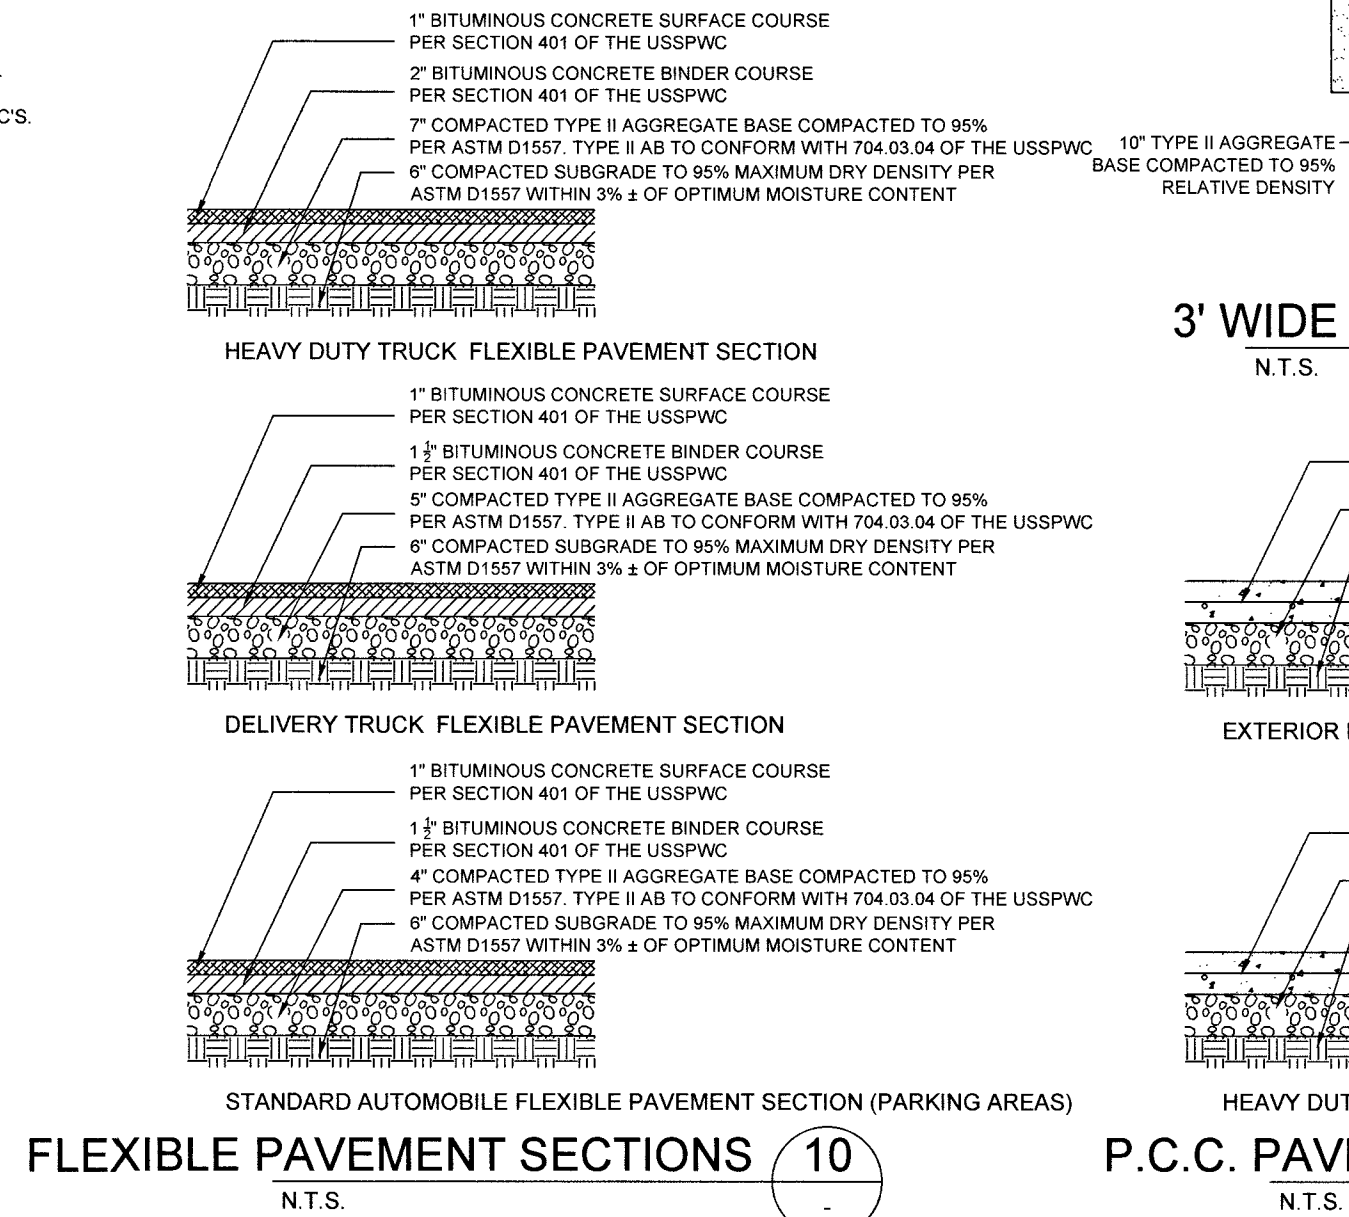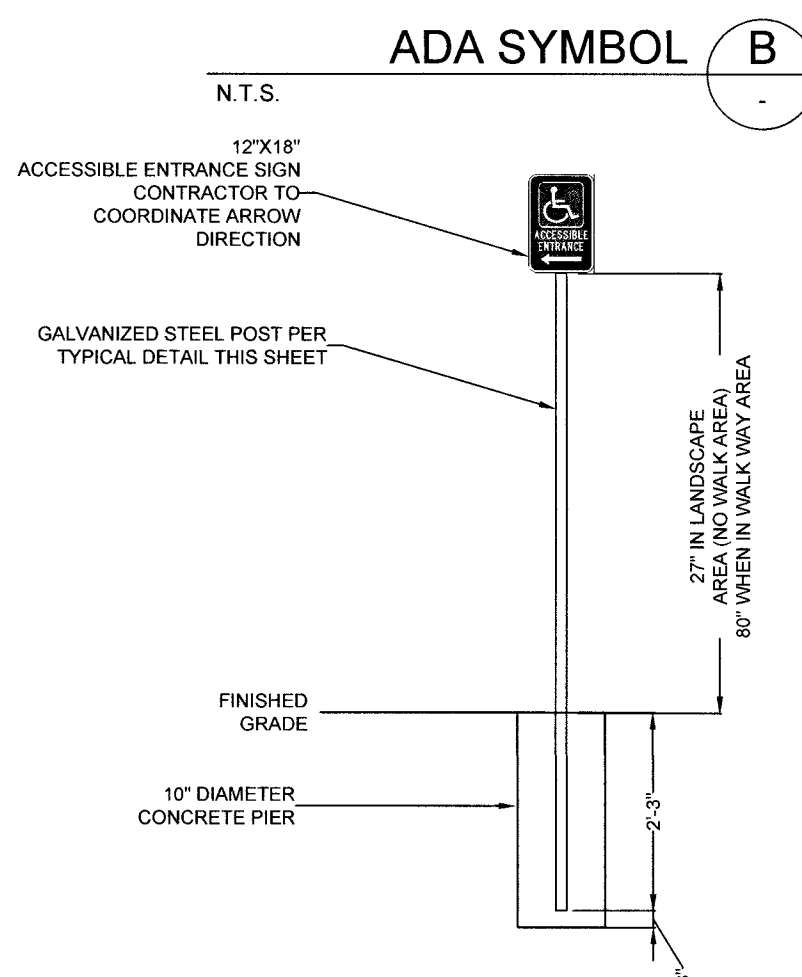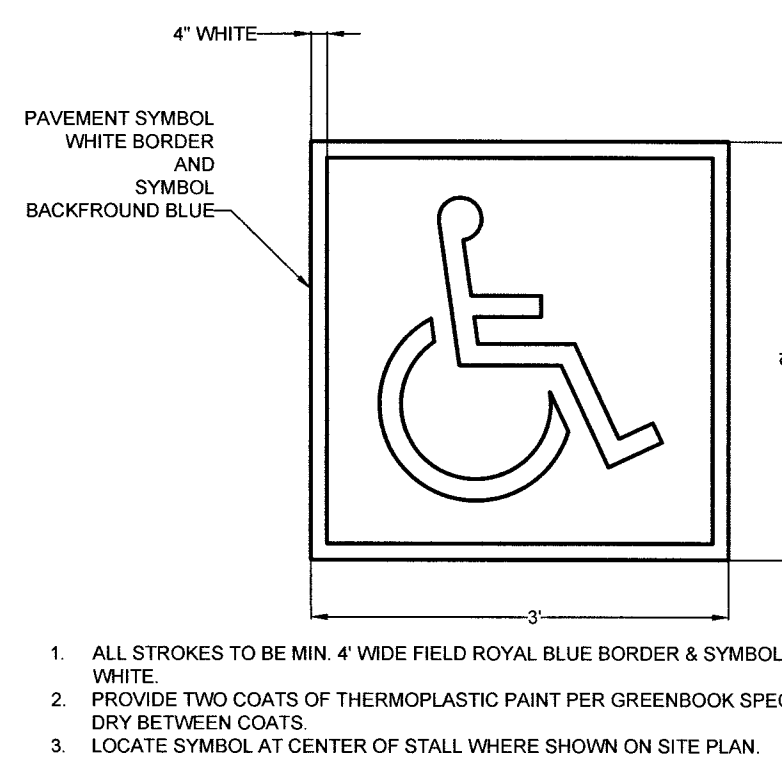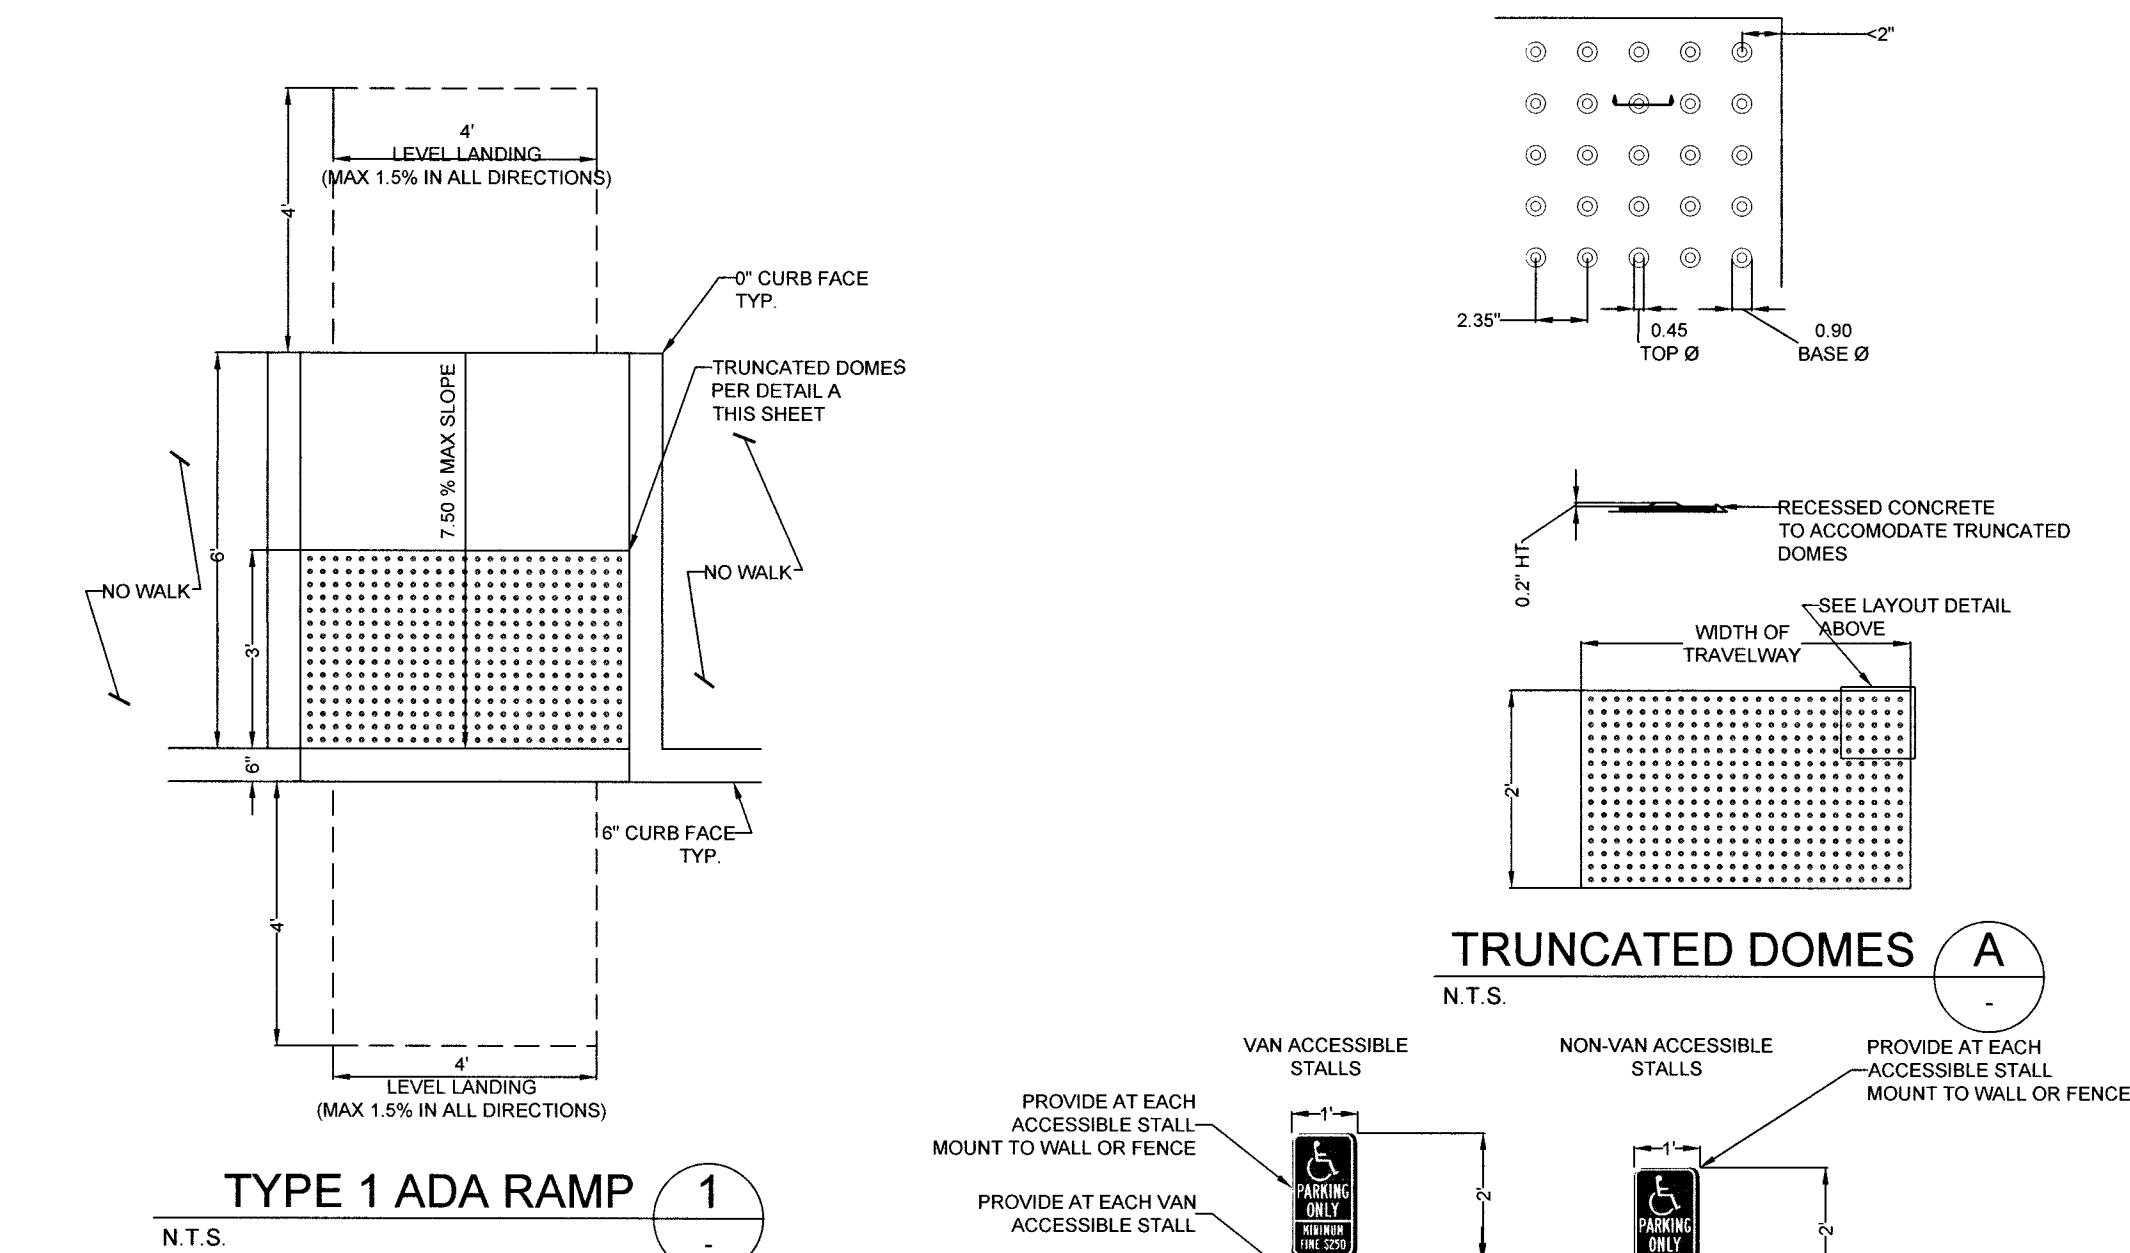

8275 S. EASTERN AVE.
SUITE 200
LAS VEGAS, NV 89123
702.551.2005
www.valley-cdg.com


CADD files prepared by the Consultant for this project are instruments of the Consultant's professional services for use solely with respect to this project. These CADD files shall not be used or other projects for additions to this project, or for completion of this project by others without written approval by the Consultant. With the Consultant's approval, others may be permitted to obtain copies of the CADD drawing files for information and reference only. All intentional or unintentional revisions, additions, or deletions to these CADD files shall be made at the full risk of that party making such revisions, additions or deletions and that party shall hold harmless and indemnify the Consultant from any & all responsibilities, claims, and liabilities.

GRAINGER
FOR THE ONES WHO GET IT DONE

No.	Date	Revision/Issue

GRAINGER #423
2401 WESTERN AVENUE
LAS VEGAS, NV 89102

CONSTRUCTION DETAILS

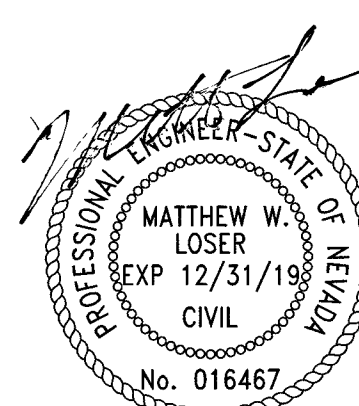

5/7/19

CHECKED BY
MI
VALLEY CIVIL DESIGN JOB NO.
18-517

ISSUE DATE: 12/05/2018

SHEET

C6

119-00139
10748033

CITY OF LAS VEGAS GENERAL NOTES

- ALL CONSTRUCTION AND MATERIALS SHALL BE IN ACCORDANCE WITH THE 'UNIFORM STANDARD SPECIFICATIONS FOR PUBLIC WORKS CONSTRUCTION OFF-SITE IMPROVEMENTS, CLARK COUNTY AREA NEVADA', LATEST ISSUE, THE 'UNIFORM STANDARD DRAWINGS FOR PUBLIC WORKS CONSTRUCTION, CLARK COUNTY AREA NEVADA', LATEST REVISED EDITION, THE 'SUMMERLIN IMPROVEMENT STANDARDS' FOR WORK IN THE SUMMERLIN AREA, AND OTHER APPLICABLE APPROVED STANDARDS ISSUED BY THE CONTROLLING AGENCY, THE 'UNIFORM BUILDING CODE', AND ALL LOCAL CITY CODES AND ORDINANCES APPLICABLE, EXCEPT AS NOTED ON THIS SHEET AS "DEVIATIONS FROM STANDARDS".
 - THE EXISTENCE AND LOCATION OF ANY OVERHEAD OR UNDERGROUND UTILITY LINES, PIPES, OR STRUCTURES SHOWN ON THESE PLANS ARE OBTAINED BY A RESEARCH OF THE AVAILABLE RECORDS. EXISTING UTILITIES AS SHOWN FROM CLV PLANS LIBRARY ARE APPROXIMATE AND FOR RECORD PURPOSES. EXISTING UTILITIES ARE LOCATED ON PLANS ONLY FOR THE CONVENIENCE OF THE CONTRACTOR. EXISTING UTILITY SERVICE LATERALS MAY NOT BE SHOWN ON THE PLANS. THE CONTRACTOR SHALL, AT HIS OWN EXPENSE, LOCATE ALL UNDERGROUND AND OVERHEAD INTERFERENCE WHICH MAY AFFECT HIS OPERATION DURING CONSTRUCTION AND SHALL TAKE ALL NECESSARY PRECAUTIONS TO AVOID DAMAGE TO SAME. THE CONTRACTOR SHALL USE EXTREME CAUTION WHEN WORKING NEAR OVERHEAD UTILITIES SO AS TO SAFELY PROTECT ALL PERSONNEL AND EQUIPMENT, AND SHALL BE RESPONSIBLE FOR ALL COST AND LIABILITY IN CONNECTION THEREWITH.
 - THE CONTRACTOR SHALL TAKE ALL PRECAUTIONARY MEASURES NECESSARY TO PROTECT EXISTING UTILITY LINES, STRUCTURES AND STREET IMPROVEMENTS WHICH ARE TO REMAIN IN PLACE, FROM DAMAGE, AND ALL SUCH IMPROVEMENTS OR STRUCTURES DAMAGED BY THE CONTRACTOR'S OPERATIONS SHALL BE REPAIRED OR REPLACED SATISFACTORY TO THE CITY ENGINEER AND OWNING UTILITY COMPANY AT THE EXPENSE OF THE CONTRACTOR.
 - ALL CONSTRUCTION SHALL BE AS SHOWN ON THESE PLANS. ANY REVISIONS SHALL HAVE THE PRIOR WRITTEN APPROVAL OF THE CITY ENGINEER.
 - TYPE V CEMENT SHALL BE USED IN ALL OFF-SITE CONCRETE WORK. CONCRETE TO BE 3000 P.S.I. MINIMUM @ 28 DAYS. MIX DESIGNS TO BE APPROVED BY THE CITY, PRIOR TO THE USE ON THE PROJECT.
 - PERMITS ARE REQUIRED FOR ANY WORK IN THE PUBLIC RIGHT-OF-WAY. THE CONTRACTOR SHALL SECURE ALL PERMITS AND INSPECTIONS REQUIRED FOR THIS CONSTRUCTION.
 - EXPANSION JOINTS REQUIRED, MAXIMUM EVERY 300' IN EXTRUDED-TYPE CURB.
 - AC PAVEMENT TO BE ONE-HALF INCH (1/2") ABOVE UP OF ALL GUTTERS AFTER COMPACTION, EXCEPT AT SIDEWALK RAMPS AND CROSS GUTTERS.
 - CURB AND GUTTER FOUND TO BE UNACCEPTABLE TO THE CITY OF LAS VEGAS SHALL BE REMOVED AND REPLACED PER STANDARD DRAWING 216.
 - SIDEWALK RAMPS SHALL BE CONSTRUCTED IN EACH QUADRANT OF AN INTERSECTION PER STANDARD DRAWING 235. EXACT LOCATION OF RAMPS MAY BE ADJUSTED IN THE FIELD BY A CITY INSPECTOR.
 - CONTRACTOR SHALL PROVIDE ALL NECESSARY HORIZONTAL AND VERTICAL TRANSITIONS BETWEEN NEW CONSTRUCTION AND EXISTING SURFACES TO PROVIDE FOR PROPER DRAINAGE AND FOR INGRESS AND EGRESS TO NEW CONSTRUCTION. THE EXTENT OF THE TRANSITIONS TO BE AS SHOWN ON PLANS.
 - ALL GRADING WORK SHALL CONFORM TO THE SOILS REPORT AS PREPARED BY THE (COMPANY REPORT # , DATE) APPROVED BY THE CITY ENGINEER, AND AS SHOWN ON THESE PLANS.
 - EXACT LOCATION OF ALL SAWCUT LINES MAY BE ADJUSTED OR DETERMINED IN THE FIELD BY A CITY OF LAS VEGAS ENGINEER IF LOCATION ON PLANS IS NOT CLEARLY SHOWN, OR EXISTING PAVEMENT CONDITION REQUIRES RELOCATIONS.
 - THE CONTRACTOR SHALL TAKE ALL PRECAUTIONS NECESSARY TO PROTECT EXISTING PERMANENT SURVEY MONUMENTS. ANY MONUMENTS DISTURBED SHALL BE REPLACED AND ADJUSTED PER AVAILABLE RECORDS IN ACCORDANCE WITH N.R.S. STATUTE NO. 625.380 & CITY OF LAS VEGAS TITLE 18, APPENDIX D.
 - UTILITY COMPANY METER BOXES, MANHOLE LIDS, VALVE COVERS, ETC., SHALL BE LOCATED OUT OF DRIVEWAYS, DRIVEWAY APRONS, FLOWLINES, AND CROSS GUTTERS UNLESS WRITTEN APPROVAL IS GRANTED BY THE UTILITY COMPANY AND THE CITY ENGINEER.
- WALL NOTES:
- ALL WALLS, NEW OR EXISTING, ARE ONLY SHOWN ON CIVIL PLANS FOR THE PURPOSE OF REVIEWING GRADING RELATIONSHIPS, FLOOD CONTROL, AND SIGHT DISTANCE AT INTERSECTIONS. NEW WALLS REQUIRE A SEPARATE PERMIT AND INSPECTION BY THE BUILDING DEPARTMENT.
 - ASPHALT MIX DESIGN MUST BE SUBMITTED AND APPROVED BY THE CITY ENGINEER PRIOR TO THE PLACEMENT OF ASPHALT WITHIN CITY RIGHT OF WAY.
 - CONTRACTOR SHALL ADJUST ALL NEW AND EXISTING INLETS, VALVE BOXES, MANHOLE RIMS, AND SEWER CLEAN OUTS, ETC. TO FINISH GRADE AS APPLICABLE WHETHER OR NOT THEY ARE SHOWN ON THE PLANS.
 - MATERIALS, HANDLING AND PLACEMENT OF PORTLAND CEMENT CONCRETE SHALL BE IN ACCORDANCE WITH APPLICABLE SECTIONS OF NDOT OR THE CLARK COUNTY AREA SPECIFICATIONS (AS APPLICABLE) AND THE PLANS AND DETAILS SHOWN HEREON.
 - WHEN INSTALLING UNDERGROUND FACILITIES THAT REQUIRE UNDERGROUND LOCATING DEVICES SUCH AS MARKER BALLS, LOCATING RIBBON, ETC., THE CONTRACTOR SHALL PROVIDE WRITTEN DOCUMENTATION TO OFFSITE INSPECTION AND TESTING CERTIFYING THAT ALL DEVICES HAVE BEEN PLACED AND VERIFIED TO BE IN GOOD WORKING CONDITION PRIOR TO THE CONSTRUCTION OF ANY ROAD BASE.
 - AFTER HAUNCHING AND PRIOR TO BACKFILL OPERATIONS WHICH WOULD COVER SANITARY SEWER AND STORM DRAIN FACILITIES, CONTRACTOR IS REQUIRED TO SCHEDULE CIVIL OPEN-TRENCH UTILITY SURVEY INSPECTION FOR DETERMINATION OF FINAL LOCATION COORDINATES. FACILITIES TO BE LOCATED BY GSVL SHALL INCLUDE AT A MINIMUM THE HORIZONTAL AND VERTICAL (INVERT) LOCATION OF PUBLIC SEWER MANHOLES, STORM DRAIN MANHOLES AND TRANSITION STRUCTURES, STORM DRAIN LATERALS AT THE CONNECTION TO THE STORM DRAIN MAIN AND AT THE CONNECTION TO A DROP INLET, THE CONNECTION OF SEWER SERVICE LATERALS TO THE SEWER MAIN AND WHERE THE SEWER SERVICE LATERALS EXIT THE PUBLIC RIGHT-OF-WAY, SEWER AND STORM DRAIN MAIN ALIGNMENT, INCLUDING DEFLECTION POINTS.
 - CCTV VIDEO INSPECTION IS REQUIRED FOR ALL SEWER AND STORM DRAINS. THE CCTV VIDEO INSPECTIONS NEED TO BE PERFORMED PER THE DESIGN AND CONSTRUCTION STANDARDS FOR WASTEWATER COLLECTION SYSTEMS LATEST EDITION.
 - A SEPARATE BORING PERMIT IS REQUIRED FOR ALL BORING ACTIVITIES. REVISED 06/04/2018

APPROVED FOR CONSTRUCTION

[Signature]

LAS VEGAS VALLEY WATER DISTRICT ENGINEERING SERVICES

PROJECT NO. 136247 FIRST APPROVED DATE: 5/14/19

FIRE DEPARTMENT APPROVAL

APPROVAL BY FIRE DEPARTMENT HAVING JURISDICTION IS REQUIRED PRIOR TO OBTAINING FINAL APPROVAL FROM THE LVVWD.

[Signature]

SOUTHWEST GAS CORPORATION

5/9/19

DATE



Call before you UnderGround

1-702-432-5300

SYSTEM OF TRANSPORTATION

NOV OVERHEAD POWER LINE CONTACT

Call before you Dig

1-702-227-2929

MY ENERGY ENVIRONMENT AND SAFETY SERVICES DEPARTMENT

Call before you Dig

811

CR 1-800-227-2600

CITY OF LAS VEGAS TRAFFIC NOTES

- ALL CONSTRUCTION SIGNING, BARRICADING, AND TRAFFIC DELINEATION SHALL CONFORM TO THE 'MANUAL ON UNIFORM TRAFFIC CONTROL DEVICES', LATEST EDITION.
- THE STREET SIGN CONTRACTOR SHALL OBTAIN STREET NAMES AND BLOCK NUMBERING FROM THE PLANNING DEPARTMENT PRIOR TO CONSTRUCTION.
- BEFORE ANY WORK IS STARTED IN THE RIGHT-OF-WAY, THE CONTRACTOR SHALL INSTALL ALL ADVANCE WARNING SIGNS FOR THE CONSTRUCTION ZONE. THE CONTRACTOR SHALL INSTALL TEMPORARY STOP SIGNS AT ALL NEW STREET ENCROACHMENTS INTO EXISTING CITY STREETS WHERE WARRANTED IMMEDIATELY AFTER FIRST GRADING WORK IS ACCOMPLISHED, AND SHALL MAINTAIN SAID SIGNS UNTIL PERMANENT SIGNS ARE INSTALLED.
- WHEN A DESIGNATED "SUGGESTED ROUTE TO SCHOOL" IS ENCLOSED UPON BY A CONSTRUCTION WORK ZONE AND PUBLIC WORKS STAFF IDENTIFIES A NEED FOR STUDENTS TO BE ASSURED IN THE SAFE CROSSING THROUGH THAT WORK ZONE, THE CONTRACTOR SHALL BE REQUIRED TO PROVIDE A QUALIFIED "CROSSING GUARD". THE GUARD SHALL BE PRESENT FOR THE FULL DURATION OF TIME THAT CHILDREN ARE LIKELY TO BE PRESENT.
- IF THE IMPROVEMENTS NECESSITATE THE OBLITERATION, TEMPORARY OBSTRUCTION, TEMPORARY REMOVAL, OR RELOCATION OF ANY EXISTING TRAFFIC PAVEMENT MARKING, SUCH PAVEMENT MARKING SHALL BE RESTORED OR REPLACED WITH LIKE MATERIALS TO THE SATISFACTION OF THE CITY TRAFFIC ENGINEER.
- THE CONTRACTOR SHALL BE RESPONSIBLE FOR PROVIDING AND INSTALLING ALL PERMANENT SIGNS SHOWN ON THE PLANS. ALL NEW TRAFFIC SIGNS SHALL UTILIZE TYPE XI RETROREFLECTIVE SHEETING IN ACCORDANCE WITH CCAUSS 627 AND 716 AND SHALL HAVE AN ANTI-GRAFFITI PROTECTIVE OVERLAY FILM THAT IS A MATCHING COMPONENT TO, AND OF THE SAME MANUFACTURER AS THE RETROREFLECTIVE SHEETING TO WHICH IT IS APPLIED. STREET NAME SIGNS SHALL CONFORM IN THEIR ENTIRETY TO CURRENT CITY STANDARDS. ALL OTHER SIGNS SHALL BE STANDARD SIZE UNLESS OTHERWISE SPECIFIED ON THE PLANS. ALL SIGN POSTS SHALL BE INSTALLED IN ACCORDANCE WITH THE CURRENT CITY STANDARDS.
- WHEN A PROPOSED STREET LIGHT STANDARD IS LOCATED WITHIN FIVE (5) FEET OF ANY PROPOSED SIGN SHOWN ON THE PLANS TO BE LOCATED ON A SIGNPOST, THE SIGN SHALL BE MOUNTED ON THE STREET LIGHT STANDARD AND THE SIGNPOST SHALL BE ELIMINATED.
- ALL PERMANENT TRAFFIC CONTROL DEVICES CALLED FOR HEREON SHALL BE IN PLACE AND IN FINAL POSITION PRIOR TO ALLOWING ANY PUBLIC TRAFFIC ONTO THE PORTIONS OF THE ROAD(s) BEING IMPROVED HERE UNDER, REGARDLESS OF THE STATUS OF COMPLETION OF PAVING OR OTHER OFF-SITE IMPROVEMENTS CALLED FOR BY THESE PLANS.
- STREET SIGNS AND STOP SIGNS SHALL BE INSTALLED PER CITY STANDARD SPECIFICATIONS FOR PLACEMENT OF STREET NAME SIGNS.
- THE CONTRACTOR SHALL PROVIDE ALL NECESSARY TRAFFIC CONTROL DEVICES AND FLAGGERS TO INSURE THE SAFETY OF THE PUBLIC IN OR AROUND THE WORK AREA. THE CONTRACTOR SHALL HAVE A CERTIFIED ATSSA TRAFFIC CONTROL TECHNICIAN OR IMSA WORK ZONE SAFETY SPECIALIST SET UP, MAINTAIN AND/OR REMOVE ALL TRAFFIC CONTROL DEVICES IN THE CITY OF LAS VEGAS RIGHT OF WAY.
- WORK IN PUBLIC STREETS, ONCE BEGUN, SHALL BE EXPEDITED TO COMPLETION SO AS TO PROVIDE MINIMUM INCONVENIENCE TO ADJACENT PROPERTY OWNERS AND TO THE TRAVELING PUBLIC.
- THE CONTRACTOR SHALL BE RESPONSIBLE FOR NOTIFYING REGIONAL TRANSPORTATION COMMISSION OF SOUTHERN NEVADA (RTO). IF THE CONSTRUCTION INTERRUPTS OR RELOCATES A BUS STOP OR HAS AN ADVERSE EFFECT ON BUS SERVICE ON THAT STREET TO ARRANGE FOR TEMPORARY RELOCATION OF STOP.
- GUARDS SHALL BE OBTAINED BY CONTACTING THE METROPOLITAN POLICE DEPARTMENT SPECIAL EVENTS UNIT (PHONE # 828-3442) WHO WILL PROVIDE OFFICERS PROPERLY TRAINED IN TRAFFIC CONTROL. FEES FOR THE USE OF THESE OFFICERS SHALL BE SET BY METRO AND WILL BE PAID BY THE CONTRACTOR. THE CONTRACTOR IS RESPONSIBLE FOR ALL ARRANGEMENTS WITH METRO.
- ANY WORK WITHIN 300' OF A SIGNALIZED INTERSECTION WILL BE NIGHT WORK, UNLESS DIRECTED BY THE CITY OF LAS VEGAS TRAFFIC ENGINEER.
- THE CONTRACTOR SHALL CONTACT THE TRAFFIC ENGINEERING DIVISION (TRANSPORTATION SECTION) THROUGH THE PROJECT'S OFFSITE INSPECTOR PRIOR TO INITIATING PAVING TO RECEIVE DIRECTION FOR ANY PERMANENT OR TEMPORARY MODIFICATIONS TO THE APPROVED DRAWINGS REGARDING FINAL PAVEMENT TRANSITIONS, MARKINGS AND SIGNING THAT ARE REQUIRED TO MATCH ADJACENT ROADWAY SEGMENTS. THE CONTRACTOR SHALL PROVIDE A DRAWING FOR APPROVAL BY THE TRAFFIC ENGINEERING DIVISION DEPICTING ANY ADJUSTMENTS TO THE FINAL PAVEMENT MARKINGS AND SIGNAGE, WHICH MAY INCLUDE OMITTING, ADDING OR MODIFYING PAVEMENT MARKINGS AND TRAFFIC CONTROL SIGNS SUCH THAT ADEQUATE TRANSITIONS AND LANE TERMINATIONS BETWEEN ADJACENT ROADWAY SEGMENTS ARE CONSTRUCTED. REVISED JUNE 4, 2018

LVVWD PROJECT # 136247
(REVISED 08/01/2017)

- NO WORK SHALL BEGIN UNTIL THE WATER PLANS HAVE BEEN APPROVED FOR CONSTRUCTION BY THE LVVWD. FOLLOWING WATER PLAN APPROVAL, NOTICE SHALL BE GIVEN TO THE LVVWD COMMUNICATION SUPPORT CENTER (258-1171) TWO (2) WORKING DAYS PRIOR TO THE START OF CONSTRUCTION. FOR FUTURE INSPECTIONS, NOTICE MUST BE GIVEN BY 2:00 P.M. THE BUSINESS DAY PRIOR TO THE REQUESTED LVVWD INSPECTION. WHEN REQUESTING INSPECTIONS, PLEASE REFER TO THE PROJECT # IDENTIFIED ABOVE.
 - ALL WORK SHALL CONFORM TO LVVWD STANDARD PLATES, DRAWINGS, AND SPECIFICATIONS, AND TO THE 2010 EDITION OF THE UNIFORM DESIGN AND CONSTRUCTION STANDARDS FOR POTABLE WATER SYSTEMS (UDACS). THE LATEST EDITION OF UDACS SHALL SUPERSEDE ANY CONFLICTS CONTAINED IN THE APPROVED DRAWINGS AND/OR SPECIFICATIONS.
 - ALL WORK, EXCEPT AS MODIFIED BY THESE PLANS OR BY NOTE 2 ABOVE, SHALL BE DONE IN ACCORDANCE WITH THE MOST RECENT DRAFT OR EDITION OF THE UNIFORM STANDARD SPECIFICATIONS FOR PUBLIC WORKS CONSTRUCTION OFFSITE IMPROVEMENT, CLARK COUNTY AREA.
 - A SINGLE PIPE MATERIAL SHALL BE USED THROUGHOUT THE PROJECT UNLESS OTHERWISE APPROVED BY THE LVVWD.
 - ALL SERVICE LATERALS TWO (2) INCHES IN DIAMETER AND SMALLER SHALL BE TYPE K COPPER TUBING WITH LVVWD APPROVED SERVICE SADDLES.
 - ALL WATER METER BOXES SHALL BE LOCATED OUTSIDE OF DRIVEWAY AREAS.
 - ALL VALVES SHALL BE LOCATED OUTSIDE OF DRIVEWAYS, VALLEY AND CURB GUTTERS.
 - ALL WATER AND STORM DRAIN OR SANITARY SEWER CROSSINGS SHALL CONFORM TO SECTION 2.22 OF THE 2010 EDITION OF THE UDACS.
 - ALL WATER FACILITIES AND APPURTENANCES SHALL BE DISINFECTED, PRESSURE TESTED, AND HAVE AN ACCEPTABLE PASSING HEALTH WATER SAMPLE OBTAINED, PRIOR TO OPERATION AND USE.
 - THE CONTRACTOR MUST OBTAIN ALL METERS TWO (2) INCHES AND SMALLER FROM LVVWD CENTRAL STORES. TELEPHONE 258-3152 OR 258-3802. TWO (2) WORKING DAYS PRIOR TO METER PICKUP.
 - ANY INTERRUPTION OF SERVICE MUST BE PERFORMED IN ACCORDANCE WITH UDACS SECTION 3.14.01, AND APPROVED BY THE LVVWD INSPECTION DIVISION PRIOR TO SHUTDOWN. PROPER WRITTEN NOTIFICATION MUST BE GIVEN TO ALL AFFECTED CUSTOMERS.
 - ALL WATER FACILITY CONSTRUCTION MATERIALS USED MUST BE AS LISTED ON THE LVVWD APPROVED PRODUCTS LIST FOR NEW FACILITIES. LATEST REVISION, OR SPECIFICALLY APPROVED ON THESE PLANS BY SUBMITTING SHOP DRAWINGS.
 - TELEPHONE "CALL BEFORE YOU DIG" AT "311" OR 1-800-227-2600.
 - THE INSTALLATION OF LVVWD MUNICIPAL WATER FACILITIES WITHIN ALL STREETS IS ASSUMED TO BE IN COMPLIANCE WITH THE UNIFORM STANDARDS, INCLUDING THE PLACEMENT OF ASPHALT PAVING STREET SURFACES. ANY REPAIR WORK DONE BY THE LVVWD TO THE MUNICIPAL WATER FACILITIES WILL INCLUDE THE PLACEMENT OF AN APPROPRIATELY SIZED ASPHALT REPAIR PATCH ON THE STREET SURFACE.
- ANY DECORATIVE PAVING SURFACE WITHIN THE STREET IS THE RESPONSIBILITY OF THE OWNER'S ASSOCIATION, OR THE INDIVIDUAL PROPERTY OWNERS IF NO OWNER'S ASSOCIATION IS IN EXISTENCE, OR THE AGENCY HAVING JURISDICTION. DECORATIVE SURFACE MATERIALS PLACED WITHIN THE TEN FOOT EASEMENT ABUTTING A PUBLIC OR PRIVATE STREET, IF DISTURBED BY THE LVVWD DURING THE REPAIR OR OPERATION OF ITS FACILITIES, WILL BE REPLACED BY LVVWD WITH AN APPROPRIATELY SIZED PLAIN FINISH CONCRETE PATCH. THE LVVWD WILL NOT ATTEMPT TO MATCH COLOR OR FINISH OF ANY ADJACENT MATERIALS.
15. NO LEAD COMPLIANCE NOTE: TO COMPLY WITH THE FEDERAL SAFE DRINKING WATER ACT, ALL WATER WORKS BRASS PRODUCTS PROPOSED TO BE RELOCATED, OR INSTALLED AS NEW MUST BE INSTALLED WITH THE LEAD FREE APPROVED PRODUCT. THE OLD LEADED PRODUCT MAY NOT BE REUSED.

Southwest Gas Corporation General Notes

- In the event of natural gas emergencies call 911 and 1-877-860-6020
- Minimum horizontal and vertical clearances between natural gas facilities and any underground utilities and/or structures, including but not limited to water, sewer, storm drain, communications, and electric shall be at least 12-inches or greater as dictated by local codes and standards
 - any deviation from specified minimum clearances must be approved by all affected utilities and/or municipalities
- For valve adjustment contact 702-668-6107 48 hours prior to construction
- In the event of a natural gas conflict with proposed utilities and structures contact 702-365-2099

CITY OF LAS VEGAS STREETLIGHT NOTES

- CITY OF LAS VEGAS STREET LIGHT NOTES
- ALL STREET LIGHTING INSTALLATIONS SHALL BE IN ACCORDANCE WITH THE STREET LIGHTING PLANS. THE "UNIFORM STANDARD SPECIFICATION FOR PUBLIC WORKS CONSTRUCTION OFF-SITE IMPROVEMENTS, CLARK COUNTY AREA, NEVADA", LATEST REVISION (USS), AND THE "UNIFORM STANDARD DRAWINGS FOR PUBLIC WORKS CONSTRUCTION OFF-SITE IMPROVEMENTS, CLARK COUNTY AREA, NEVADA" (USD), LATEST REVISION.
 - DESIGN PROFESSIONAL AND CONTRACTOR SHALL VERIFY CITY'S LATEST LED FIXTURE SPECIFICATIONS AND APPROVED FIXTURES PER CLV WEBSITE, UNDER BUILDING AND SAFETY FORMS, PRIOR TO ORDERING MATERIALS.
 - NO DEVIATION OF STREET LIGHT, PULL BOX, CONDUITS, ETC., LOCATIONS SHALL BE PERMITTED WITHOUT WRITTEN APPROVAL OF THE TRAFFIC AND CITY ENGINEER. ANY DEVIATION FROM THE PLAN LOCATION WILL REQUIRE COMPLIANCE WITH SECTION 623 OF THE USS.
 - ALL EXISTING STREET LIGHTING SHALL REMAIN OPERATIONAL DURING CONSTRUCTION IN ACCORDANCE WITH SECTION 623 G.03.01 OF THE USS.
 - ALL EMPTY CONDUIT SHALL HAVE AT LEAST ONE GREEN NO. #8 AWG WIRE INSTALLED AS TRACER WIRE IN ACCORDANCE WITH SECTION 623 G.02.01 OF THE USS PRIOR TO BACKFILLING AND FINAL INSPECTION.
 - ANY STRUCTURE SUCH AS BLOCK WALLS, CHAIN LINK FENCES, RETAINING WALLS, ETC., SHALL LEAVE A MINIMUM CLEARANCE IN COMPLIANCE WITH USD NO. 320A WHEN POLE IS INSTALLED BEHIND SIDEWALK, AND SHALL AT NO TIME COMPLETELY ENCLOSE THE STREET LIGHTING POLE.
 - AS-BUILT DRAWINGS SHALL BE SUPPLIED TO THE TRAFFIC ENGINEERING DIVISION PRIOR TO ANY PRE-FINAL INSPECTION. THE AS-BUILT DRAWING NEEDS TO BE STAMPED AS-BUILT AND SIGNED BY THE PREPARER.
 - SERVICE POINTS SHALL BE COORDINATED WITH NV ENERGY, AND WHEREVER POSSIBLE, BE LOCATED NEAR THE CENTER OF THE CIRCUIT. SERVICEPOINTS SHALL BE SHOWN ON THE PLANS.
 - WHEREVER THERE IS AN OVERHEAD UTILITY THAT MAY CONFLICT WITH THE INSTALLATION OF STREETLIGHTING CIRCUITS AND/OR POLES, THESE CONFLICTS MUST BE RESOLVED BETWEEN THE DEVELOPER AND THE UTILITIES INVOLVED BEFORE STREETLIGHT BASES ARE INSTALLED. AT NO EXPENSE TO THE CITY OF LAS VEGAS.
 - THE CONTRACTOR SHALL FURNISH COMPLETE CONDUIT, WIRE, ETC. FROM SERVICE TO TRANSFORMERS AND CONTROL SYSTEMS IF REQUIRED ON THE PLANS. REVISED JUNE 4, 2018 (LD VERSION)

CITY OF LAS VEGAS SEWER NOTES

- ALL CONSTRUCTION AND MATERIALS SHALL BE IN ACCORDANCE WITH THE LATEST EDITION OF THE DESIGN AND CONSTRUCTION STANDARDS FOR WASTEWATER COLLECTION SYSTEMS AND THE UNIFORM STANDARD SPECIFICATIONS FOR PUBLIC WORKS' CONSTRUCTION OFF-SITE IMPROVEMENTS, CLARK COUNTY AREA, NEVADA, AS AMENDED. IT WILL BE THE RESPONSIBILITY OF THE CONTRACTOR TO BE AWARE OF THE CONTENTS OF THE ABOVE SPECIFICATIONS.
 - IT SHALL BE THE CONTRACTOR'S RESPONSIBILITY TO PERFORM CONSTRUCTION AS PER PLANS. ANY ADDITIONS, DELETIONS, OR CHANGES SHALL FIRST MEET WITH THE APPROVAL OF THE CITY ENGINEER.
 - CHISEL "S" OR "G" IN CURBS WHERE SEWER OR GAS LATERALS PASS UNDER THE CURB.
 - POLYVINYL (PVC) SEWER PIPE SHALL MEET ASTM D-3034 SDR 35 SPECIFICATIONS, INSTALLED WITH SAND BEDDING AND BACKFILL OF TYPE II AGGREGATE BASE.
 - ALL MANHOLES PAVED IN STREETS EIGHTY (80) FOOT RWY AND LARGER SHALL HAVE CONCRETE COLLARS. STREETS LESS THAN EIGHTY (80) FOOT RWY WILL REQUIRE RETROFIT IF PAVING DOES NOT CONFORM TO CITY STANDARDS AT THE MANHOLE.
 - TEE SADDLES SHALL BE USED TO CONNECT SEWER LATERALS TO EXISTING MAIN LINES UP TO TWELVE INCH (12") DIAMETER. CONNECTIONS TO FIFTEEN INCH (15") OR LARGER MAINS SHALL REQUIRE SPECIAL PROCEDURES. IN LINE "Y" "S" SHALL BE USED ON LINES TWELVE INCHES (12") OR ABOVE.
 - WATER MAINS SHALL BE PROTECTED IN ACCORDANCE WITH LVVWD STANDARDS WHENEVER A SEWER MAIN CROSSES OVER A WATER MAIN OR THE SEWER IS LESS THAN EIGHTEEN INCH (18") UNDER A WATER MAIN.
 - ALL CONTRACTORS INSTALLING SEWER MAINS THAT WILL BE UNDER THE JURISDICTION OF THE CITY OF LAS VEGAS MUST BE STATE OF NEVADA CLASS "A" CONTRACTORS.
- THE CITY OF LAS VEGAS WILL NOT ACCEPT ANY SEWER MAINS WHICH HAVE A VERTICAL DEFLECTION OF MORE THAN ONE TENTH (0.1) OF A FOOT FROM THE APPROVED CONSTRUCTION PLANS AT ANY LOCATION. SEWER MAINS FOUND TO EXCEED THIS TOLERANCE WILL HAVE TO BE REPAIRED OR REMOVED OR REPLACED TO THE SATISFACTION OF THE CITY ENGINEER PRIOR TO ACCEPTANCE BY THE CITY OF LAS VEGAS.

- INSTALLATION OF CURVED SEWER REQUIRES THE USE OF C-900 PIPE WHICH ALLOWS FOR PIPE DEFLECTION AT THE JOINTS. REVISED 04/15/10
- GRAINGER NOTES**

- CONTRACTOR TO FIELD VERIFY ALL CONDITIONS, DIMENSIONS, ELEVATIONS AND QUANTITIES IN FIELD PRIOR TO BIDDING, FABRICATING AND INSTALLING ANY MATERIALS. COMMENCEMENT OF THE WORK SHALL CONSTITUTE ACCEPTANCE OF THE QUANTITIES INDICATED. ANY DISCREPANCIES BETWEEN THE INFORMATION SHOWN ON THE DRAWINGS AND ACTUAL FIELD CONDITIONS SHALL BE REPORTED IMMEDIATELY TO THE PROJECT MANAGER.
- CONTRACTOR TO PROVIDE FENCING AND TRAFFIC DELINEATORS AS REQUIRED TO DIRECT THE PUBLIC TO DESIGNATED PARKING AREAS.
- CONTRACTOR TO PROVIDE "OPEN DURING CONSTRUCTION" SIGNAGE AS REQUIRED TO DIRECT THE PUBLIC TO SAFE AND ACCESSIBLE ROUTE TO THE ENTRANCE DURING CONSTRUCTION.
- CONTRACTOR SHALL VERIFY THAT ALL WORK TO BE PERFORMED MEETS THE HIGHEST STANDARDS REQUIRED BY LOCAL, STATE, FEDERAL, AND FEDERAL AMERICANS WITH DISABILITIES ACT ACCESSIBILITY GUIDELINES (ADAA) AND THE AMERICAN NATIONAL STANDARDS INSTITUTE (ANSI).
- IN THE EVENT OF A DISCREPANCY BETWEEN STATE, LOCAL OR FEDERAL CODES, THE MOST STRINGENT CODE SHALL APPLY.

- BRANCH OPERATIONS:**
- THE BRANCH SHALL REMAIN OPEN AND ACCESSIBLE AT ALL TIMES DURING CONSTRUCTION. PHASING AND OR AFTER-HOURS WORK MAY BE REQUIRED TO ENSURE ACCESS TO AT LEAST ONE DOCK, THE WILL CALL PICK UP AREA AND BUILDING ENTRANCE AT ALL TIMES.

- SCOPE OF WORK:**
- XXX

- GUARANTY:**
- CONTRACTOR TO PROVIDE A TWO YEAR "MAINTENANCE FREE" WRITTEN WARRANTY FOR ALL MATERIALS AND WORKMANSHIP PERFORMED UNDER THIS CONTRACT INCLUDING LABOR.

- PERMITS:**
- CONTRACTOR TO VERIFY IF PERMITS ARE REQUIRED BY THE LOCAL AGENCIES AND IF SO PAY FOR ALL PERMITS AS REQUIRED

- TESTING SERVICES:**
- CONTRACTOR TO PROVIDE COMPACTION TESTS TO ENSURE COMPACTION OF 95%.
 - THE OWNER MAY EMPLOY AN INDEPENDENT TESTING CONSULTANT TO OBSERVE THE CONSTRUCTION AND TEST MATERIALS DURING PAVEMENT REHABILITATION WORK.

- DAILY AND FINAL CLEAN UP:**
- CONTRACTOR SHALL REMOVE ALL TRASH AND DEBRIS FROM THE AREA OF WORK ON A DAILY BASIS.
 - CONTRACTOR SHALL LEGALLY DISPOSE OF ALL WASTE AND DEBRIS IN LEGAL LANDFILLS AND RECYCLE ALL MATERIALS AS MUCH AS POSSIBLE.
 - FINAL CLEAN UP SHALL INCLUDE PRESSURE WASHING OF ALL AREAS AFFECTED BY THE WORK AND REMOVAL OF ALL CHALK LINES FROM STRIPING.

- MATERIALS:**
- SUBGRADE AGGREGATE BASE COURSE
 - 6" SCARIFIED, MOISTURE CONDITIONED AND (95% RELATIVE ASTM D1557) COMPACTED SUBGRADE BASE COURSE (SEE PLAN FOR THICKNESS)
 - TYPE II AGGREGATE BASE CONFORMING TO SECTION 704.03.04 OF THE USSWP. COMPACTED TO 95% RELATIVE (ASTM D1557) BITUMINOUS CONCRETE (SEE PLAN FOR THICKNESS)
 - ASPHALT CONCRETE MIXED AND PLACED IN ACCORDANCE WITH SECTION 401 OF THE USSWP.
 - PORTLAND CEMENT CONCRETE (PCC) (SEE PLAN FOR THICKNESS)
 - TYPE V CEMENT WITH DESIGN COMPRESSIVE STRENGTH OF 4,500 POUNDS PER SQUARE INCH (PSI)
 - SEAL COAT (IF SPECIFIED IN THE SCOPE OF WORK)
 - OVERKOTE OIL SEALER (OR EQUAL)
 - CRACK FILLER (IF SPECIFIED IN THE SCOPE OF WORK)
 - OVERKOTE COLD POUR CRACK FILLER (OR EQUAL)
 - TRAFFIC PAINT
 - ENNIS OR EQUAL

- LANDSCAPE AREAS:**
- ALL LANDSCAPED AREAS AFFECTED BY THE WORK SHALL BE RESTORED TO THEIR PRE-EXISTING CONDITION UPON COMPLETION OF THE WORK.
 - NEW LANDSCAPE WORK SHALL BE INSTALLED PER THE PLANS. ALL NEW LANDSCAPED AREAS SHALL BE MAINTAINED FOR 90 DAYS AT NO ADDITIONAL COST TO THE OWNER.

- STRIPING AND PAVEMENT MARKINGS**
- CONTRACTOR SHALL PROVIDE NEW PAVEMENT STRIPING IN CONFORMANCE WITH SECTION 02765 OF THE STANDARD SPECIFICATIONS.
 - STRIPING SHALL BE AS SHOWN ON THE PLANS
 - THE COLOR SHALL BE DETERMINED BY LOCAL CODES AND OR AS DETERMINED BY GRAINGER.
 - THE HATCHED LANDINGS FOR ACCESSIBLE PARKING, NO PARKING AND OR LOADING ZONES SHALL BE STENCILED "NO PARKING". "WORDING" SHALL BE PLACED DIAGONALLY AND NOT OVERLAY AND STRIPING.
 - ALL EXISTING STALL MARKINGS SHALL BE ENTIRELY REMOVED MECHANICALLY OR AS REQUIRED.

- OTHER:**
- ALL NEW AND OR EXISTING BOLLARDS AND RAILS SHALL BE PRIMED AND PAINTED WITH A COLOR EQUAL TO "BENJAMIN MOORE" "BLACK TIE".

GENERAL NOTES FOR HYDRANTS AND ACCESS

- ALL WORK SHALL BE DONE IN STRICT ACCORDANCE WITH THE LAS VEGAS FIRE AND RESCUE ADOPTED FIRE CODE ORDINANCE # 6631 FOR HYDRANT SPECIFICATIONS AND HYDRANT INSTALLATION SPECIFICATIONS.
- ONLY FIRE HYDRANTS THAT ARE ON THE LAS VEGAS VALLEY WATER DISTRICTS' - APPROVED PRODUCT LIST ARE ALLOWED TO BE INSTALLED.
- A PERMIT IS REQUIRED FROM LAS VEGAS FIRE AND RESCUE FOR THE INSTALLATION OF ON-SITE WATER LINES AND FIRE HYDRANTS. THE PERMIT AND CONTRACTOR'S MATERIAL TEST CERTIFICATE FOR UNDERGROUND PIPING FORM SHALL BE OBTAINED FROM THE FIRE PROTECTION ENGINEER BEFORE COMMENCEMENT OF WORK. (IFC § 106.8.18)
- ON ANY RESIDENTIAL OR COMMERCIAL INSTALLATIONS, FIRE HYDRANTS SHALL BE INSTALLED AND FIRE APPARATUS ACCESS ROADS SHALL BE MAINTAINED BEFORE COMMENCEMENT OF ANY COMBUSTIBLE CONSTRUCTION. ALL FIRE HYDRANTS SHALL BE IN GOOD WORKING ORDER AND SHALL BE CAPABLE OF DELIVERING THE REQUIRED FIRE FLOW. (IFC § 3310, § 3312)
- TO IDENTIFY THE FIRE HYDRANT LOCATIONS, THE CONTRACTOR SHALL PLACE A BLUE REFLECTIVE MARKER AT THE CENTER LINE OF THE STREET ADJACENT TO THE FIRE HYDRANTS. (IFC § 807.5.7.3)
- ALL UNDERGROUND INSPECTIONS, PRESSURE AND FLUSH VERIFICATIONS OF ALL FIRE HYDRANTS AND FIRE LINES, SHALL BE CONDUCTED BEFORE COVERING THE LINES. CENTER LOADING IS ACCEPTABLE FOR THE HYDRO TESTS WITH PRIOR FIRE PREVENTION APPROVAL. (IFC § 106.3)
- ALL ON-SITE UNDERGROUND WATER MAINS AND MATERIALS SHALL BE U.L. LISTED, A.W.W.A APPROVED AND SHALL BE RATED FOR THE APPROPRIATE WORKING PRESSURE. (IFC § 507.2.1, NFPA 24)
- PAINTING OF CURBS, FIRE HYDRANTS, PADS, PROTECTION OF FIRE HYDRANTS FROM PHYSICAL DAMAGE, AND ALL OTHER WORK NECESSARY PER PLANS SHALL BE COMPLETED BEFORE APPROVAL BY LAS VEGAS FIRE AND RESCUE, FIRE PREVENTION DIVISION. (IFC § 807)
- PRIVATE HYDRANTS SHALL BE PAINTED RED. (IFC § 507.5.7.1)
- PRIOR TO THE FINAL OCCUPANCY, A FIRE FLOW TEST SHALL BE WITNESSED BY LAS VEGAS FIRE AND RESCUE, FIRE PREVENTION DIVISION TO VERIFY AVAILABILITY OF THE REQUIRED FIRE FLOW. (IFC § 507)
- FIRE HYDRANT SPACING SHALL BE AS FOLLOWS: (IFC § C102)
- RESIDENTIAL - 500 FT UNSPRINKLERED, 600 FT SPRINKLERED.
- COMMERCIAL - 300 FT UNSPRINKLERED, 400 FT SPRINKLERED.
- WHERE THE WATER MAINS ARE EXTENDED ALONG STREETS OR NEW STREETS ARE INSTALLED WHERE FIRE HYDRANTS ARE NOT NEEDED FOR PROTECTION OF THE STRUCTURES, FIRE HYDRANTS SHALL BE INSTALLED AT A MAXIMUM OF 1000 FT SPACING, TO PROVIDE FOR TRANSPORTATION HAZARDS. WHERE STREETS ARE PROVIDED WITH MEDIAN DIVIDERS OR HAVE FOUR (4) OR MORE TRAFFIC LANES AND HAVE A TRAFFIC COUNT OF MORE THAN 30,000 PER DAY, HYDRANTS ARE REQUIRED ON EACH SIDE OF THE STREET SPACED AT 500 FT ON AN ALTERNATING BASIS. (IFC § C102.8)
- NO FIRE HYDRANTS SHALL BE LOCATED WITHIN THE RADIUS OF A CUL-DE-SAC OR WITHIN 20 FT OF THE PERIMETER OF THE RADIUS OF THE CUL-DE-SAC.
- NO FIRE HYDRANTS SHALL BE LOCATED WITHIN 6 FT OF ANY CURB RETURN, DRIVEWAY, POWER POLE, STREETLIGHT OR ANY OTHER OBSTRUCTION. (IFC § C102.12)
- A MAXIMUM DISTANCE FROM A FIRE HYDRANT TO A ONE-TWO FAMILY DWELLING SHALL NOT EXCEED 300 FT, AS MEASURED BY AN APPROVED ROUTE. (IFC § C102.4)
- THE MAXIMUM DISTANCE FROM A FIRE HYDRANT TO A FIRE DEPARTMENT CONNECTION (FDC) SHALL NOT EXCEED 100 FT, AS MEASURED BY AN APPROVED ROUTE. (IFC § C102.7)
- THE MAXIMUM DISTANCE FROM A HYDRANT TO THE END OF A DEAD-END STREET SHALL NOT EXCEED 200 FT. (IFC § C102.8)
- TWO (2) SOURCES OF SUPPLY ARE REQUIRED WHENEVER THERE IS 4 OR MORE FIRE HYDRANTS/SPRINKLER LEAD-INS ARE INSTALLED ON A SINGLE SYSTEM. FOR SYSTEMS REQUIRED TO HAVE TWO (2) SOURCES OF WATER SUPPLY, SECTIONAL CONTROL VALVES SHALL BE INSTALLED SO THAT NO MORE THAN 2 FIRE HYDRANTS AND/OR FIRE SPRINKLER LEAD INS CAN BE OUT OF SERVICE DUE TO A SERVICE INTERRUPTION. FOR SYSTEMS PERMITTED TO HAVE ONE SOURCE OF WATER SUPPLY, SECTIONAL CONTROL VALVES SHALL BE INSTALLED SO THAT NO MORE THAN 3 FIRE HYDRANTS AND/OR FIRE SPRINKLER LEAD-INS CAN BE OUT OF SERVICE DUE TO A SERVICE INTERRUPTION. (IFC § C104)
- ALL FIRE APPARATUS ACCESS ROADS SHALL BE PAVED TO PROVIDE ALL WEATHER DRIVING CAPABILITIES, AND SHALL BE DESIGNED AND MAINTAINED TO SUPPORT THE IMPOSED LOADS OF THE FIRE APPARATUS. (IFC § 503.2.3)
- THE GRADIENT FOR THE FIRE APPARATUS ACCESS ROADS SHALL NOT EXCEED 12%, ANGLES OF APPROACH AND ANGLES OF DEPARTURE SHALL NOT EXCEED 6% FOR 25 FT PRIOR TO OR AFTER THE GRADE CHANGE, ADJACENT TO THE STRUCTURES GRADIENT SHALL NOT EXCEED 6%. (IFC § 503.2.7, § 503.2.8)
- THE TURNING RADIUS OF THE FIRE APPARATUS ACCESS ROADS SHALL BE NO LESS THAN 52 FT OUTSIDE AND 28 FT INSIDE TURNING RADIUS. (IFC § 503.2.4)
- VERTICAL CLEARANCE OF ALL FIRE APPARATUS ACCESS ROADS SHALL NOT BE LESS THAN 13FT 6 INS. (IFC § 503.2.1)
- FIRE DEPARTMENT ACCESS ROADS SHALL HAVE A MINIMUM UNOBSTRUCTED WIDTH OF NOT LESS THAN 33 FT WITH PARKING ON BOTH SIDES MEASURED TO FACE OF CURB. NOT LESS THAN 28 FT WIDE WITH PARKING RESTRICTED TO ONE SIDE MEASURED TO FACE OF CURB, NOT LESS THAN 24' WIDE WITH NO PARKING ON EITHER SIDE MEASURED TO FACE OF CURB. FIRE LINES THROUGH PARKING LOTS SHALL NOT BE LESS THAN 24 FT. (IFC § 503.2.1.1)
- A FIRE APPARATUS ACCESS ROAD SHALL BE REQUIRED WHEN ANY PORTION OF AN EXTERIOR WALL OF THE FIRST STORY IS LOCATED MORE THAN 150 FT FROM A FIRE DEPARTMENT VEHICLE ACCESS. THIS DISTANCE COULD BE INCREASED TO 250 FT IF THE BUILDING IS SPRINKLERED. (IFC § 503.1.1)
- APPROVED SECONDARY FIRE APPARATUS ACCESS SHALL BE PROVIDED FOR 200 OR MORE DWELLING UNITS, ROAD(S) WITH DEAD-ENDS, COMMERCIAL AND INDUSTRIAL DEVELOPMENTS WHERE BUILDINGS EXCEED 2 STORIES OR 30 FEET IN HEIGHT, OR EXCEEDING 62,000 SQUARE FEET IN AREA. (IFC § 503.1.2)
- ALL DEAD-END FIRE APPARATUS ROADS AND/OR FIRE LANES, PUBLIC OR PRIVATE, IN EXCESS OF 150 FT IN LENGTH SHALL BE PROVIDED WITH AN APPROVED TURN AROUND HAVING A MINIMUM DIAMETER OF 81 FT. (IFC § 503.2.5)
- FIRE APPARATUS ACCESS ROADS SHALL BE MARKED BY PLACING APPROVED SIGNS AT THE START OF THE DESIGNATED FIRE LANE, ONE SIGN AT THE END OF THE FIRE LANE AND WITH SIGNS AT INTERVALS OF 100 FT ALONG THE DESIGNATED FIRE LANES. SIGNS TO BE PLACED ON BOTH SIDES OF AN ACCESS ROADWAY IF NEEDED TO PREVENT PARKING ON EITHER SIDE. SIGNS TO BE INSTALLED NO HIGHER THAN 10 FT OR LESS THAN 6 FT FROM THE ROADWAY LEVEL. THE CURB ALONG OR ON THE PAVEMENT OR CEMENT (IF NO CURB IS PROVIDED) SHALL BE PAINTED WITH A RED WEATHER RESISTANT PAINT IN ADDITION TO THE SIGNS. (IFC § 503.3)
- ELECTRICALLY CONTROLLED ACCESS GATES SHALL BE PROVIDED WITH AN APPROVED EMERGENCY VEHICLE DETECTOR/RECEIVER SYSTEM. IFC § 503.6.

EFFECTIVE DATE: February 4, 2019

CITY OF LAS VEGAS GRADING NOTES

- IN THE EVENT THAT ANY UNFORESEEN CONDITIONS NOT COVERED BY THESE NOTES ARE ENCOUNTERED DURING GRADING OPERATIONS, THE OWNER/ENGINEER SHALL BE IMMEDIATELY NOTIFIED FOR DIRECTION.
- IT SHALL BE THE RESPONSIBILITY OF THE CONTRACTOR TO PERFORM ALL NECESSARY CUTS AND FILLS WITHIN THE LIMITS OF THIS PROJECT AND THE RELATED OFF-SITE WORK, SO AS TO GENERATE THE DESIRED SUBGRADE, FINISH GRADES AND SLOPES SHOWN.
- CONTRACTOR SHALL TAKE FULL RESPONSIBILITY FOR ALL EXCAVATION. ADEQUATE SHORING SHALL BE DESIGNED AND PROVIDED BY THE CONTRACTOR TO PREVENT UNDERMINING OF ANY ADJACENT FEATURES OR FACILITIES AND/OR CAVING OF THE EXCAVATION.
- THE CONTRACTOR IS WARNED THAT AN EARTHWORK BALANCE WAS NOT NECESSARILY THE INTENT OF THIS PROJECT. ANY ADDITIONAL MATERIAL REQUIRED OR LEFTOVER MATERIAL FOLLOWING EARTHWORK OPERATIONS BECOMES THE RESPONSIBILITY OF THE CONTRACTOR.
- THE GRADING CONTRACTOR IS RESPONSIBLE TO COORDINATE WITH THE OWNER TO PROVIDE FOR THE REQUIREMENTS OF THE PROJECT STORM WATER POLLUTION PREVENTION PLAN (SWPPP) AND ASSOCIATED PERMIT.
- CONTRACTOR SHALL GRADE TO THE LINES AND ELEVATIONS SHOWN ON THE PLANS WITHIN THE FOLLOWING HORIZONTAL AND VERTICAL TOLERANCES AND DEGREES OF COMPACTION, IN THE AREAS INDICATED:


	HORIZONTAL	VERTICAL	COMPACTION
PAVEMENT AREA SUBGRADE	0.1"	+0.0' TO -0.1'	SEE SOILS REPORT
ENGINEERED FILL	0.5"	+0.1' TO -0.1'	SEE SOILS REPORT

COMPACTION TESTING WILL BE PERFORMED BY THE OWNER OR HIS REPRESENTATIVE.

- ALL CUT AND FILL SLOPES SHALL BE PROTECTED UNTIL EFFECTIVE EROSION CONTROL HAS BEEN ESTABLISHED.
- THE USE OF POTABLE WATER WITHOUT A SPECIAL PERMIT FOR BUILDING OR CONSTRUCTION PURPOSES INCLUDING CONSOLIDATION OF BACKFILL OR DUST CONTROL IS PROHIBITED. THE CONTRACTOR SHALL OBTAIN ALL NECESSARY PERMITS FOR CONSTRUCTION WATER.

- THE CONTRACTOR SHALL MAINTAIN THE STREETS, SIDEWALKS AND ALL OTHER PUBLIC RIGHT-OF-WAY IN A CLEAN, SAFE AND USABLE CONDITION. ALL SPILLS OF SOIL, ROCK OR CONSTRUCTION DEBRIS SHALL BE PROMPTLY REMOVED FROM THE PUBLICLY OWNED PROPERTY DURING CONSTRUCTION AND UPON COMPLETION OF THE PROJECT. ALL ADJACENT PROPERTY, PRIVATE OR PUBLIC SHALL BE MAINTAINED IN A CLEAN, SAFE AND USABLE CONDITION.

- IN THE EVENT THAT ANY TEMPORARY CONSTRUCTION ITEM IS REQUIRED THAT IS NOT SHOWN ON THESE DRAWINGS, THE OWNER AGREES TO PROVIDE AND INSTALL SUCH ITEM AT HIS OWN EXPENSE AND AT THE DIRECTION OF THE CITY ENGINEER. TEMPORARY CONSTRUCTION INCLUDES DITCHES, BERMS, ROAD SIGNS AND BARRICADES, ETC. REVISED 04/15/10

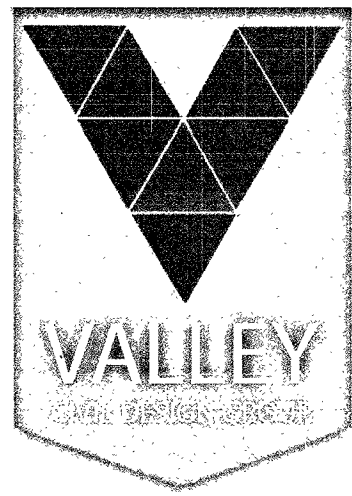

8275 S. EASTERN AVE
SUITE 200
LAS VEGAS, NV 89123
702.551.2005
www.valley-cdg.com

CADD files prepared by the Consultant for this project are instruments of the Consultant's professional services for use solely with respect to this project. These CADD files shall not be used for other projects, for additions to this project, or for completion of this project by others without written approval by the Consultant. With the Consultant's approval, others may be permitted to obtain copies of the CADD drawing files for information and reference only. All intentional or unintentional revisions, additions, or deletions to these CADD files shall be made at the full risk of that party making such revisions, additions or deletions and that party shall hold harmless and indemnify the Consultant from any & all responsibility claims and liabilities.


GRAINGER

FOR THE ONES WHO GET IT DONE

Date	Revision / Issue
No.	

GRAINGER #423
2401 WESTERN AVENUE
LAS VEGAS, NV 89102

GENERAL NOTES

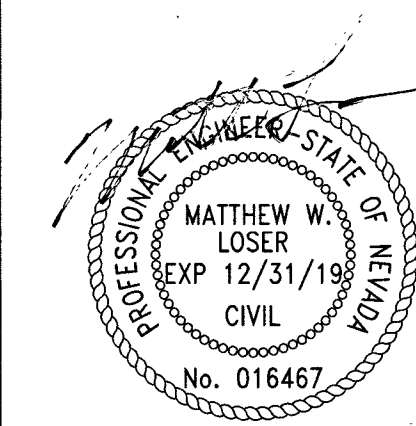

5/7/19

CHECKED BY
MI
VALLEY CIVIL DESIGN JOB NO.
18-517

ISSUE DATE: 12/05/2018

SHEET

C7

419-00139
107V8033