




- ## PROJECT GENERAL NOTES

- ## CONSTRUCTION NOTES



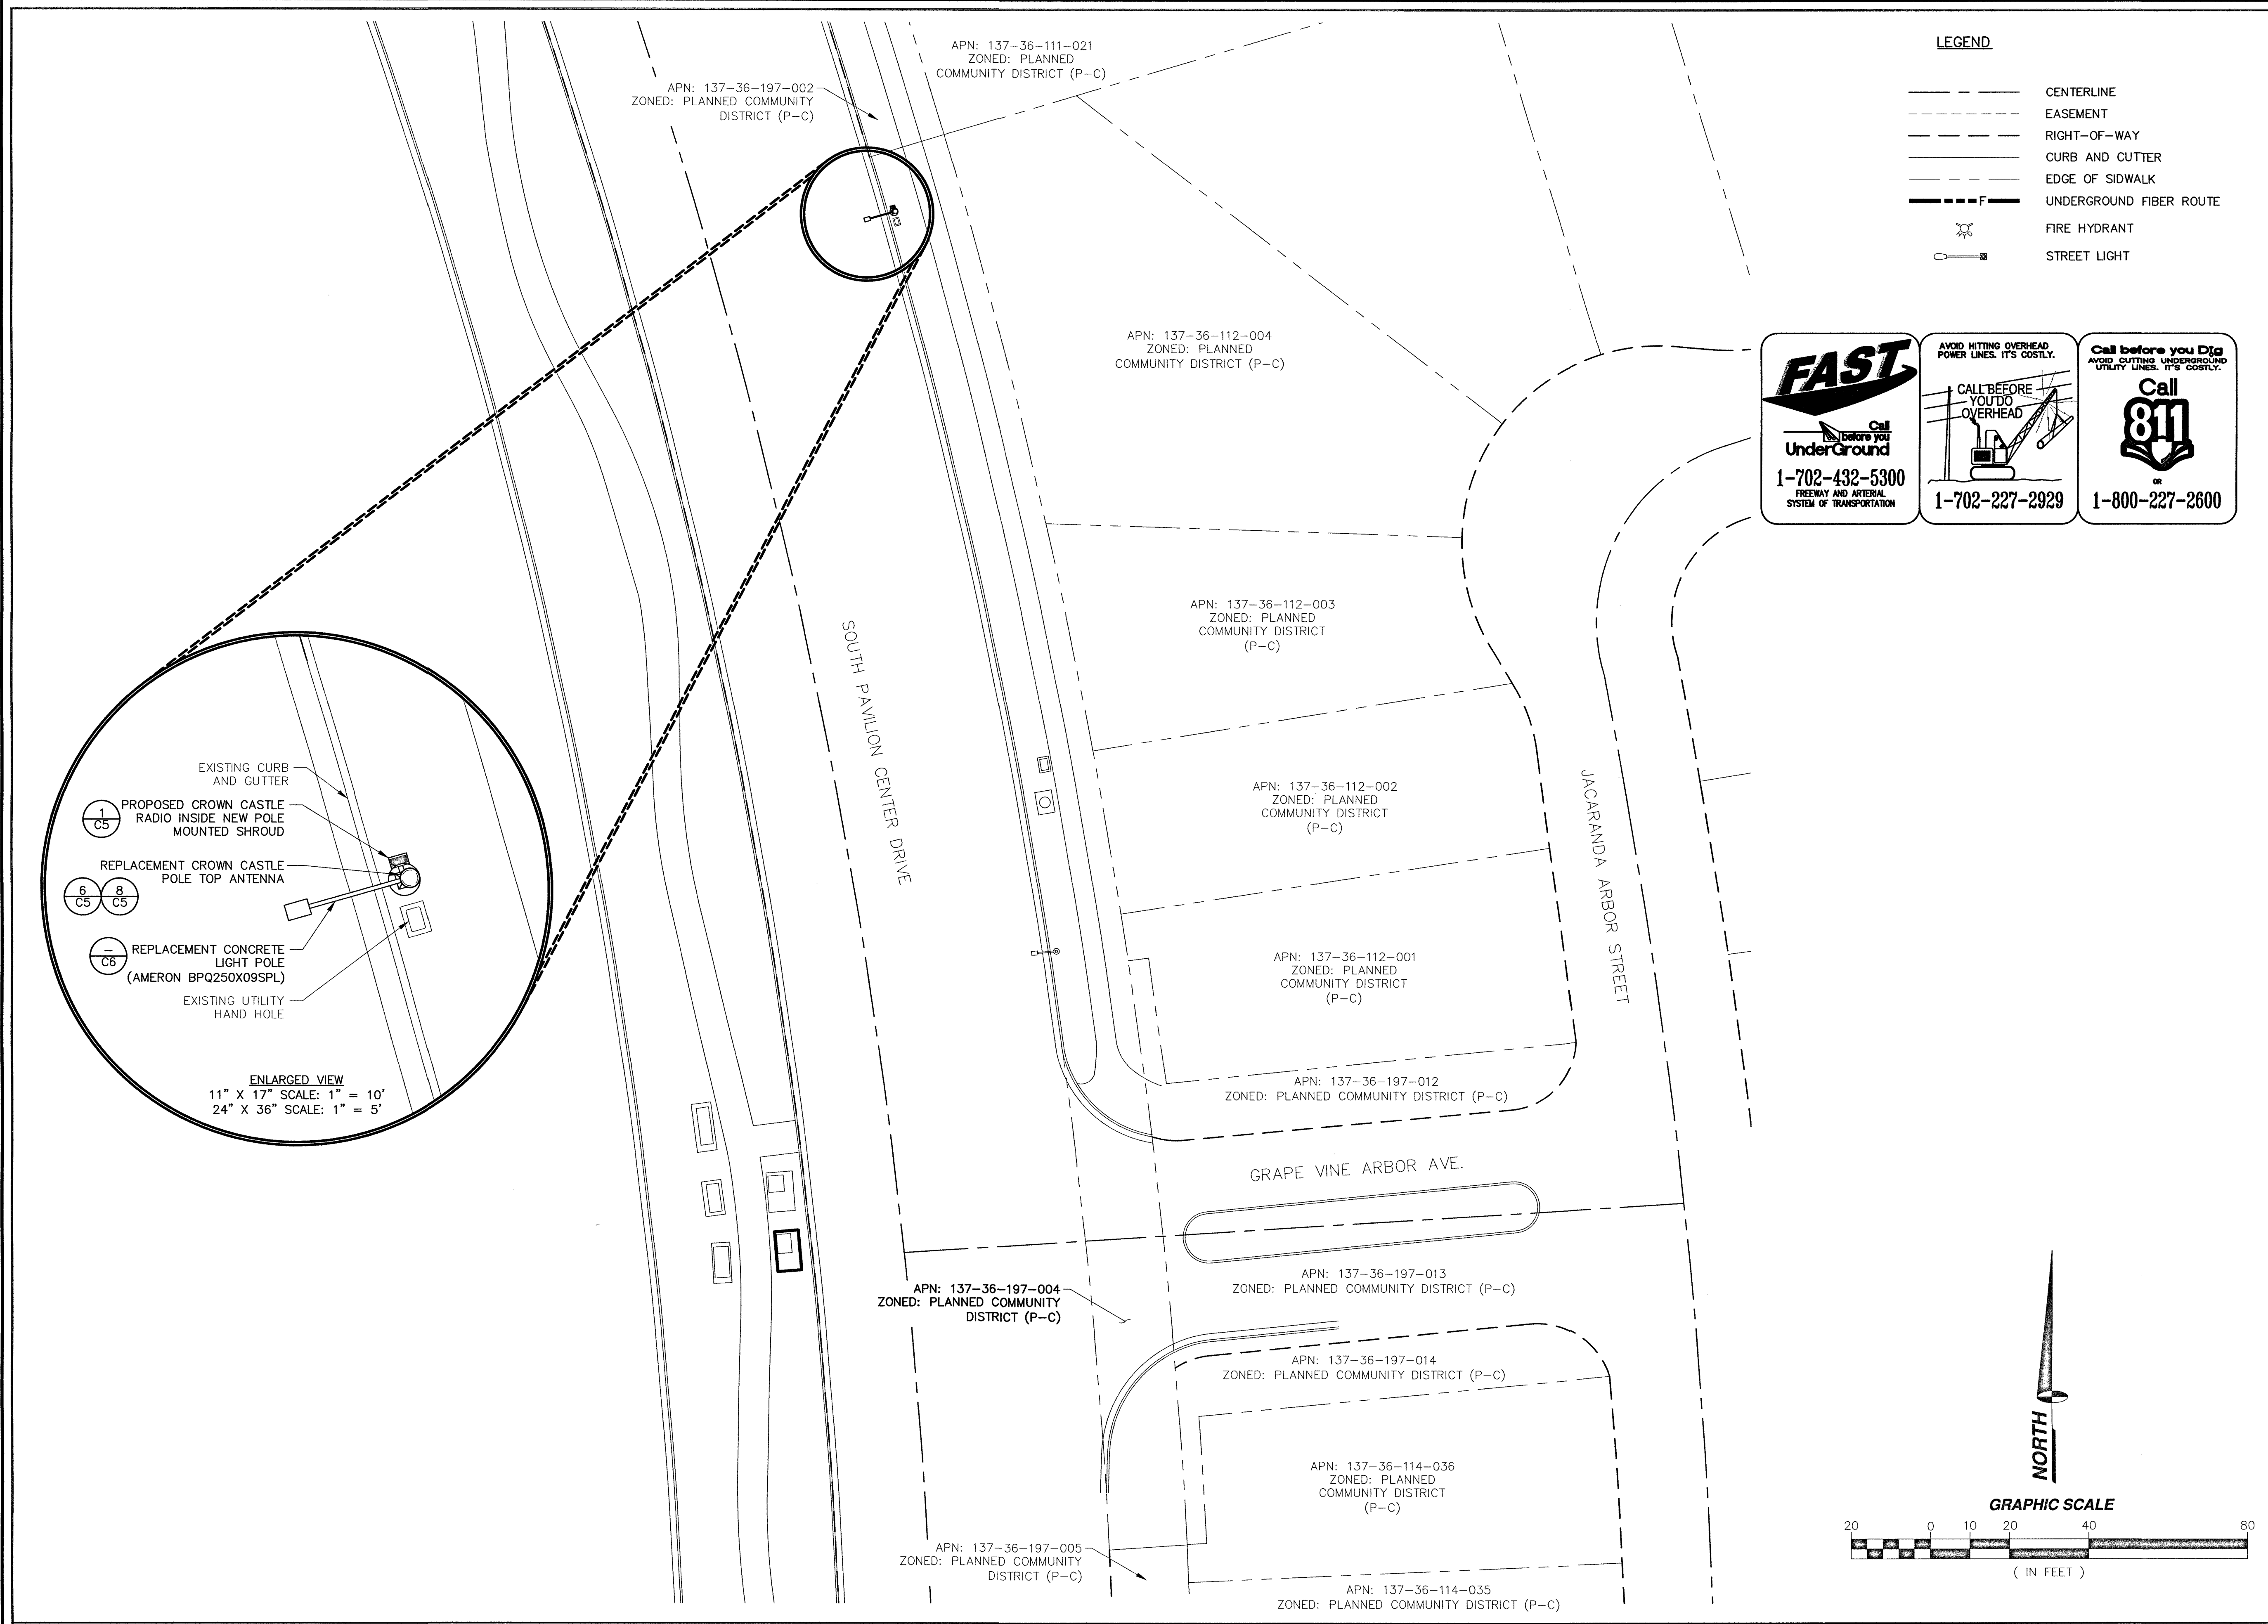

- LEGEND
- CENTERLINE
 - EASEMENT
 - RIGHT-OF-WAY
 - CURB AND CUTTER
 - EDGE OF SIDEWALK
 - UNDERGROUND FIBER ROUTE
 - FIRE HYDRANT
 - STREET LIGHT

FAST
Call before you Dig
UnderGround
1-702-432-5300
FREEWAY AND ARTERIAL
SYSTEM OF TRANSPORTATION

AVOID HITTING OVERHEAD
POWER LINES. IT'S COSTLY.

CALL BEFORE
YOU DO
OVERHEAD
1-702-227-2929

Call before you Dig
AVOID CUTTING UNDERGROUND
UTILITY LINES. IT'S COSTLY.

Call
811
OR
1-800-227-2600

CROWN CASTLE
CROWN CASTLE NG WEST LLC
2055 SOUTH STEARMAN DRIVE
CHANDLER, ARIZONA 85286

PROJECT INFORMATION:

CROWN CASTLE ID #
LV013

256 S PAVILION CENTER DR
LAS VEGAS, NEVADA 89144

CURRENT ISSUE DATE:

04/09/19

ISSUED FOR:

PROPOSED WORK

REV.: DATE: DESCRIPTION: BY:

2	04/04/19	POLE REVISION	D.C.
1	10/16/18	100% PERMITTING	C.P.
0	09/18/18	90% PERMITTING	R.S.

PLANS PREPARED BY:

SPECTRUM SERVICES, INC.
4850 WEST OQUENDO ROAD
LAS VEGAS, NEVADA 89118
PHONE: (702) 367-7705
FAX: (702) 367-8733



LICENSURE:

SHEET TITLE:

SITE PLAN

SHEET NUMBER: REVISION:

C3	2
----	---

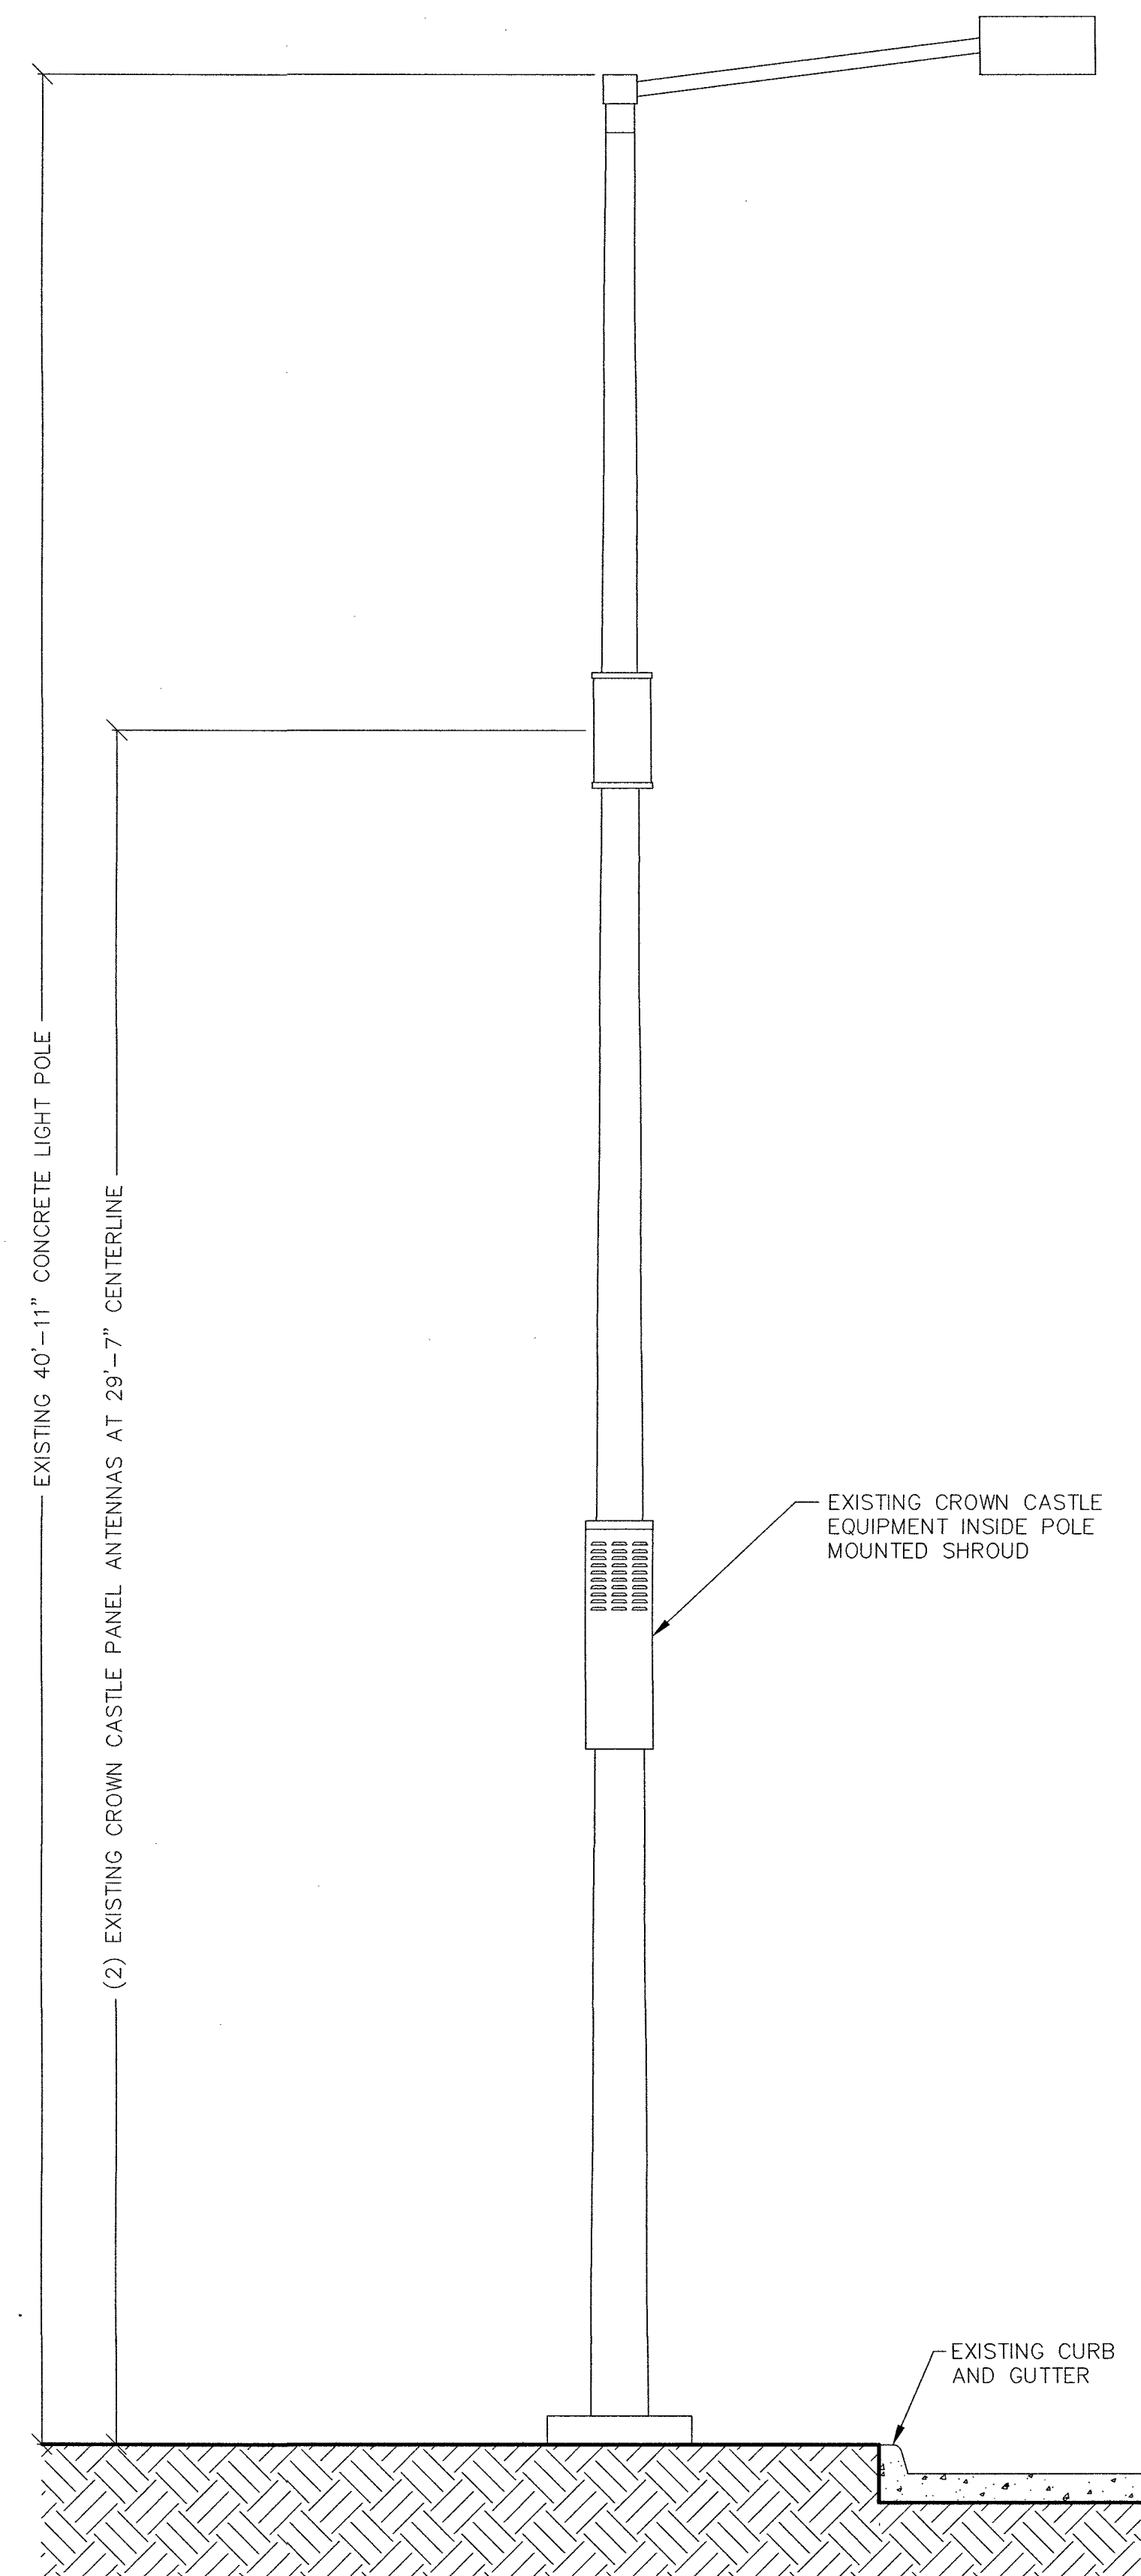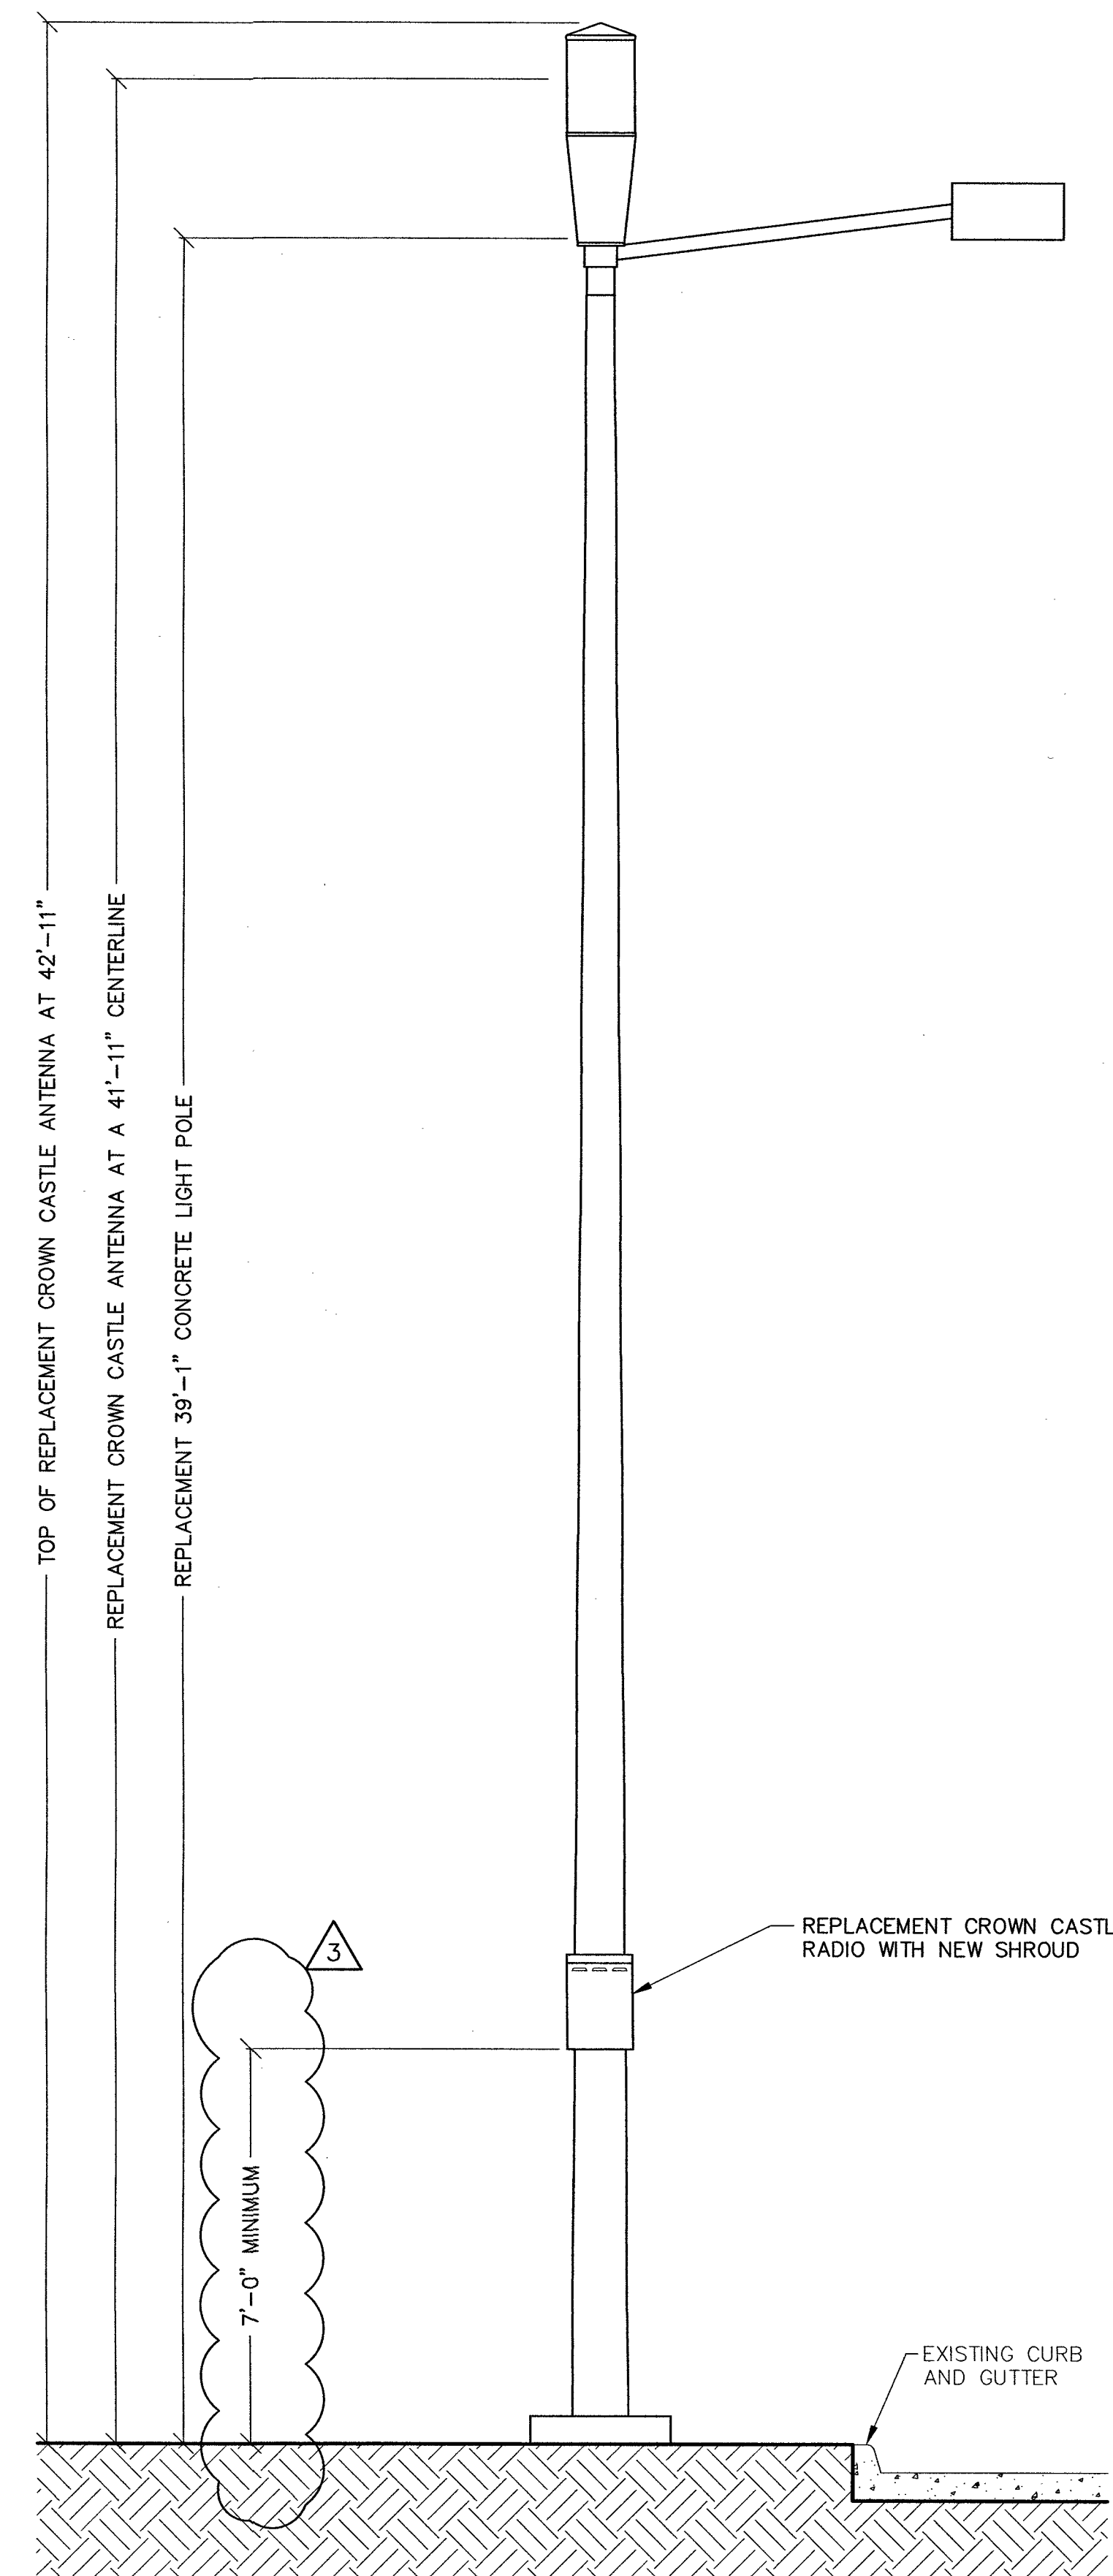

PROPOSED NORTHWEST ELEVATION

11" X 17" SCALE 24" X 36" SCALE
1" = 5' 1" = 2'-6"

2

EXISTING NORTHWEST ELEVATION

11" X 17" SCALE 24" X 36" SCALE
1" = 5' 1" = 2'-6"

1

CROWN CASTLE
CROWN CASTLE NG WEST LLC
2055 SOUTH STEARMAN DRIVE
CHANDLER, ARIZONA 85286

PROJECT INFORMATION:
CROWN CASTLE ID #
LV013
256 S PAVILION CENTER DR
LAS VEGAS, NEVADA 89144

CURRENT ISSUE DATE:
04/09/19

ISSUED FOR:
PROPOSED WORK

REV.	DATE	DESCRIPTION	BY
3	04/09/19	LAND DEV. COMMENTS	R.S.
2	04/04/19	POLE REVISION	D.C.
1	10/16/18	100% PERMITTING	C.P.
0	09/18/18	90% PERMITTING	R.S.


PLANS PREPARED BY:
SPECTRUM
SPECTRUM SERVICES, INC.
4850 WEST OQUENDO ROAD
LAS VEGAS, NEVADA 89118
PHONE: (702) 367-7705
FAX: (702) 367-8733

LICENSURE:

APR 09 2019

SHEET TITLE:
EXISTING AND PROPOSED
NORTHWEST ELEVATION







SHEET NUMBER: C4 REVISION: 3

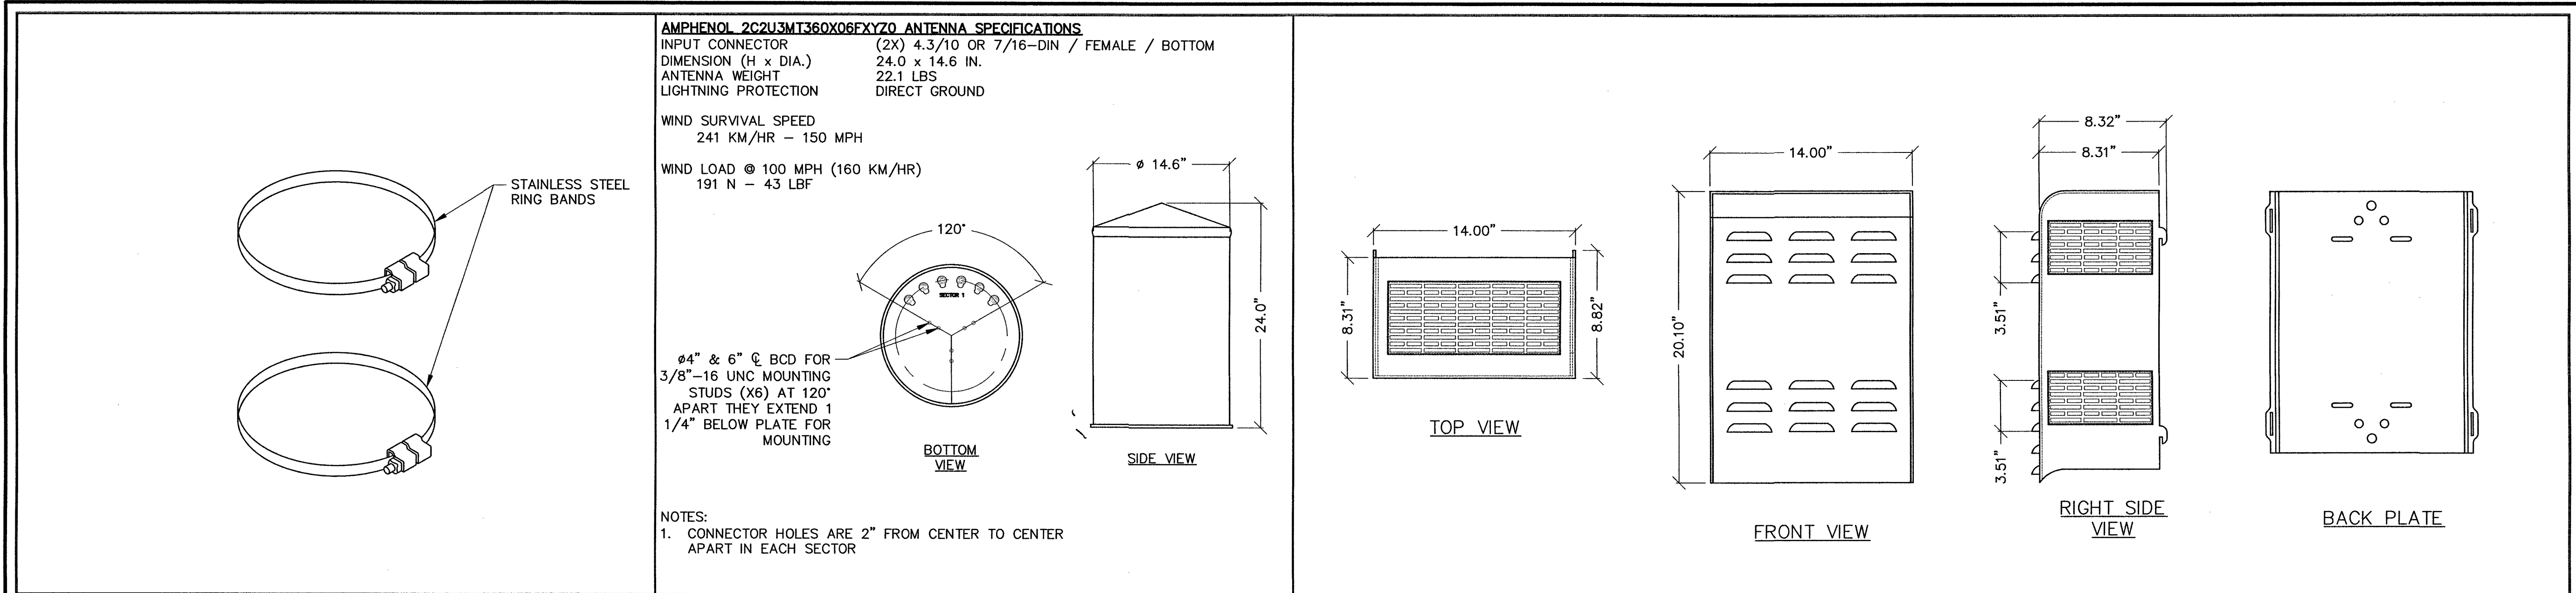

STAINLESS STEEL RING BAND

9 ANTENNA DETAIL

7 RADIO SHROUD

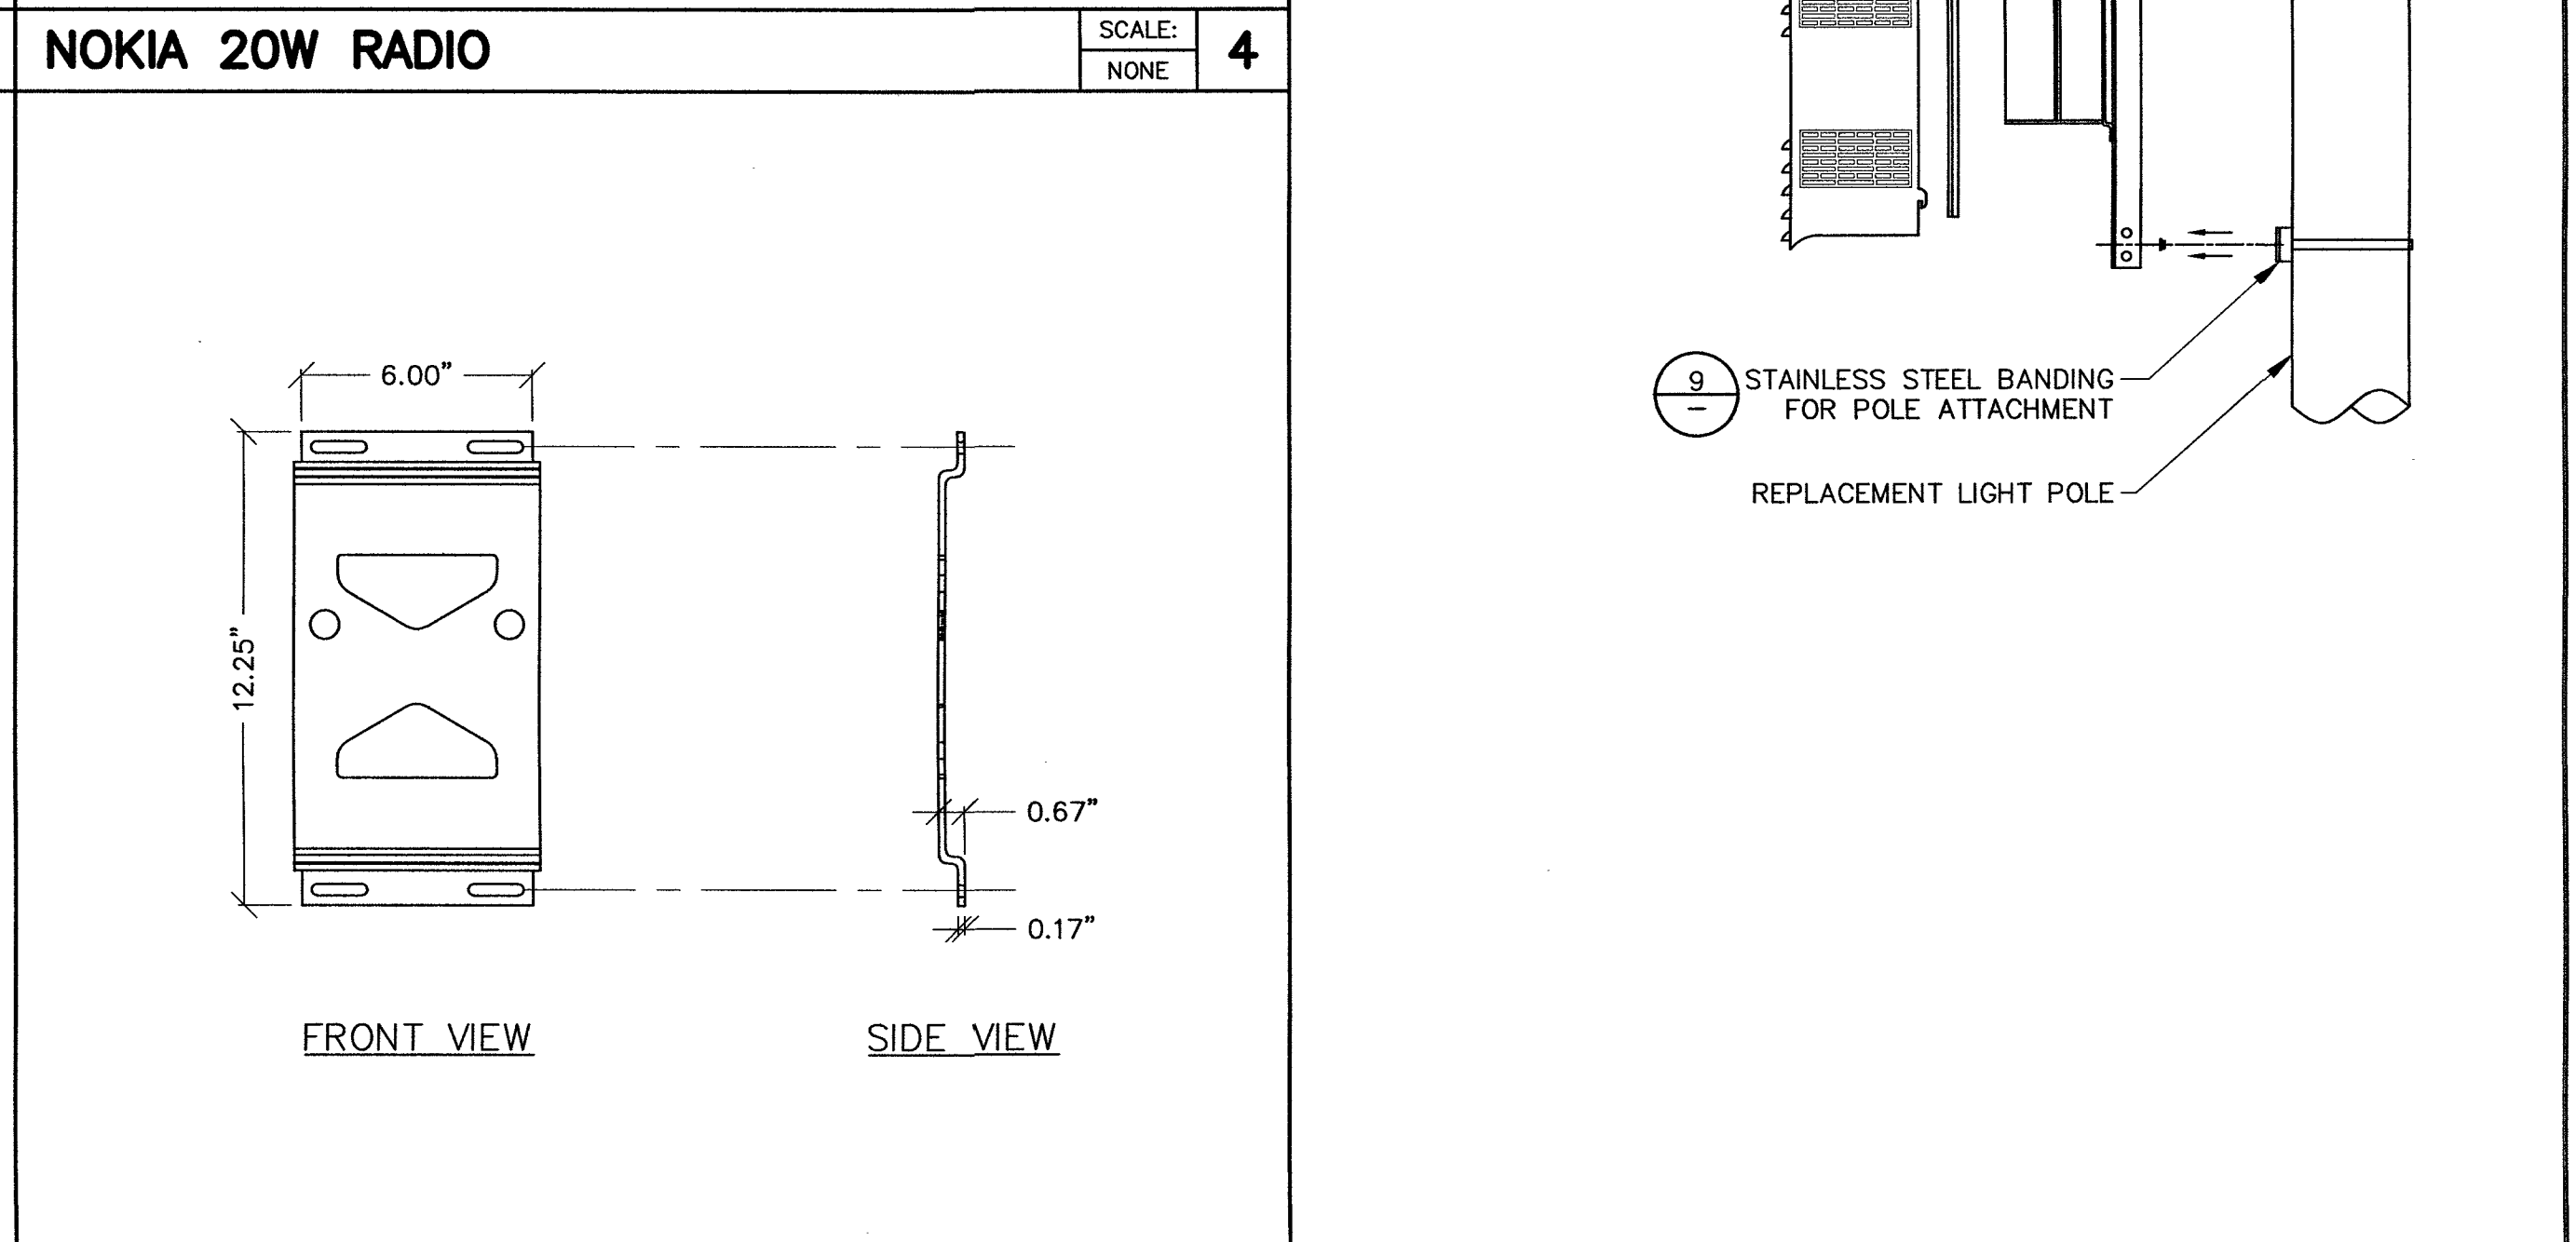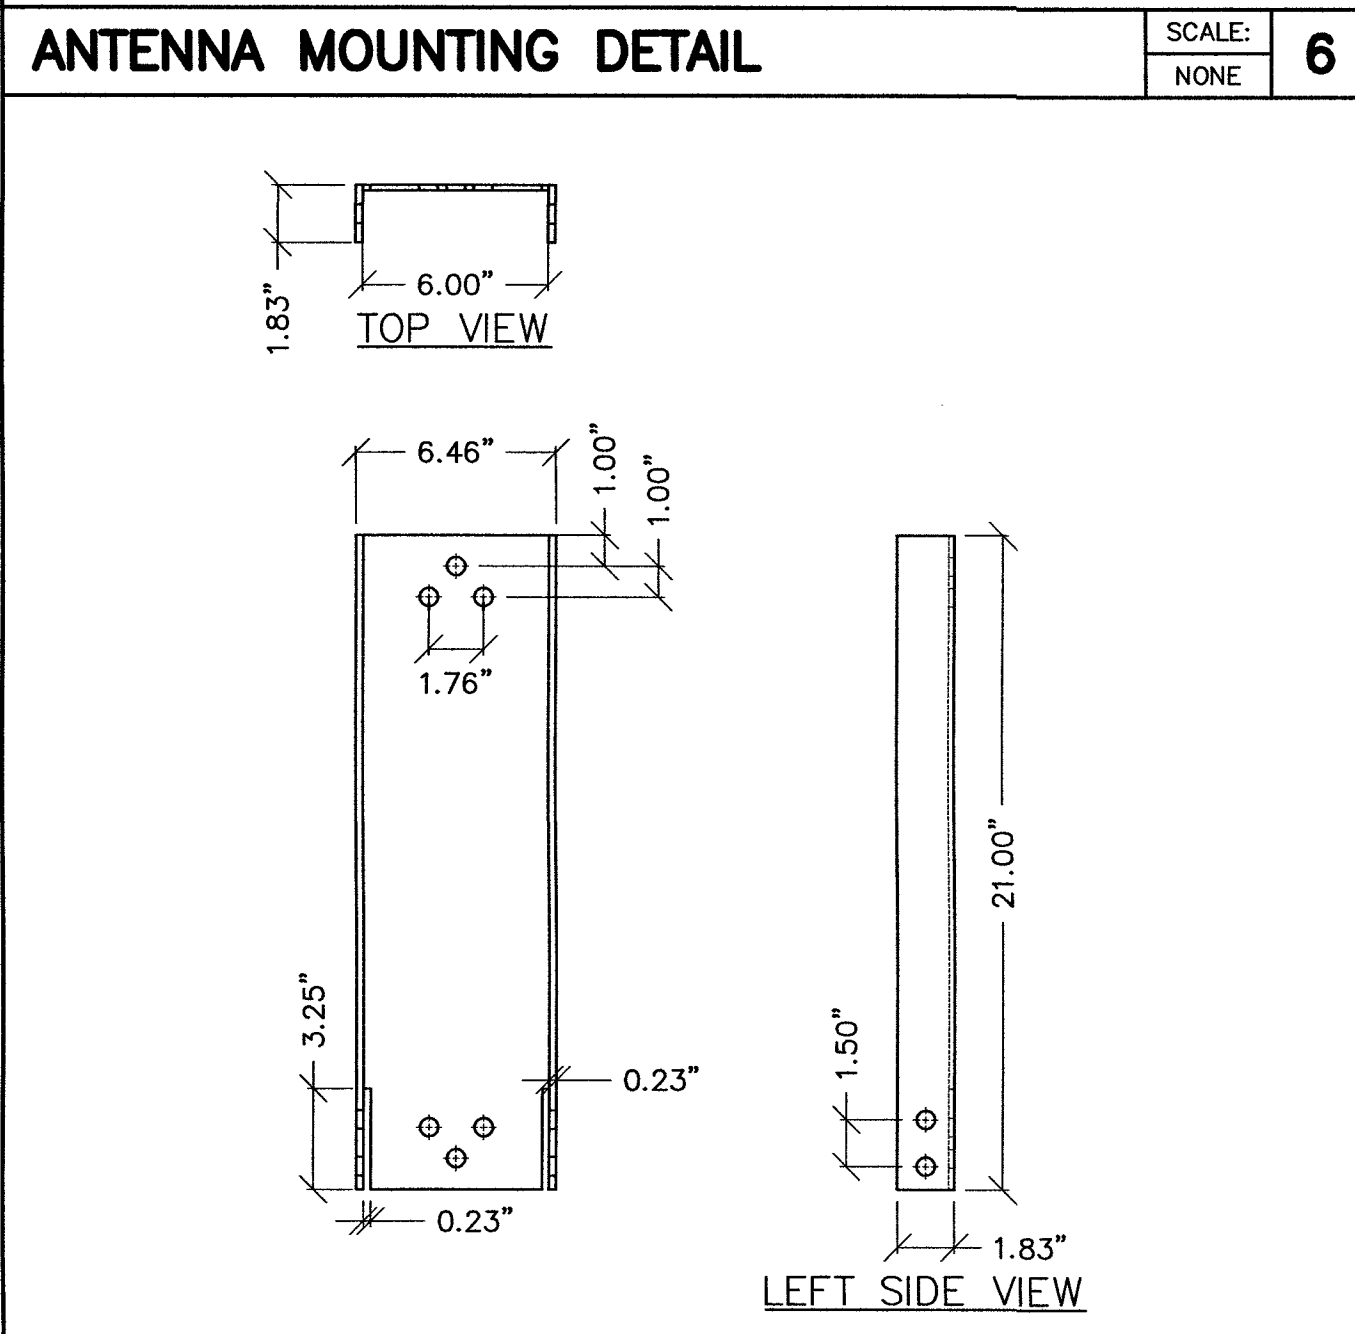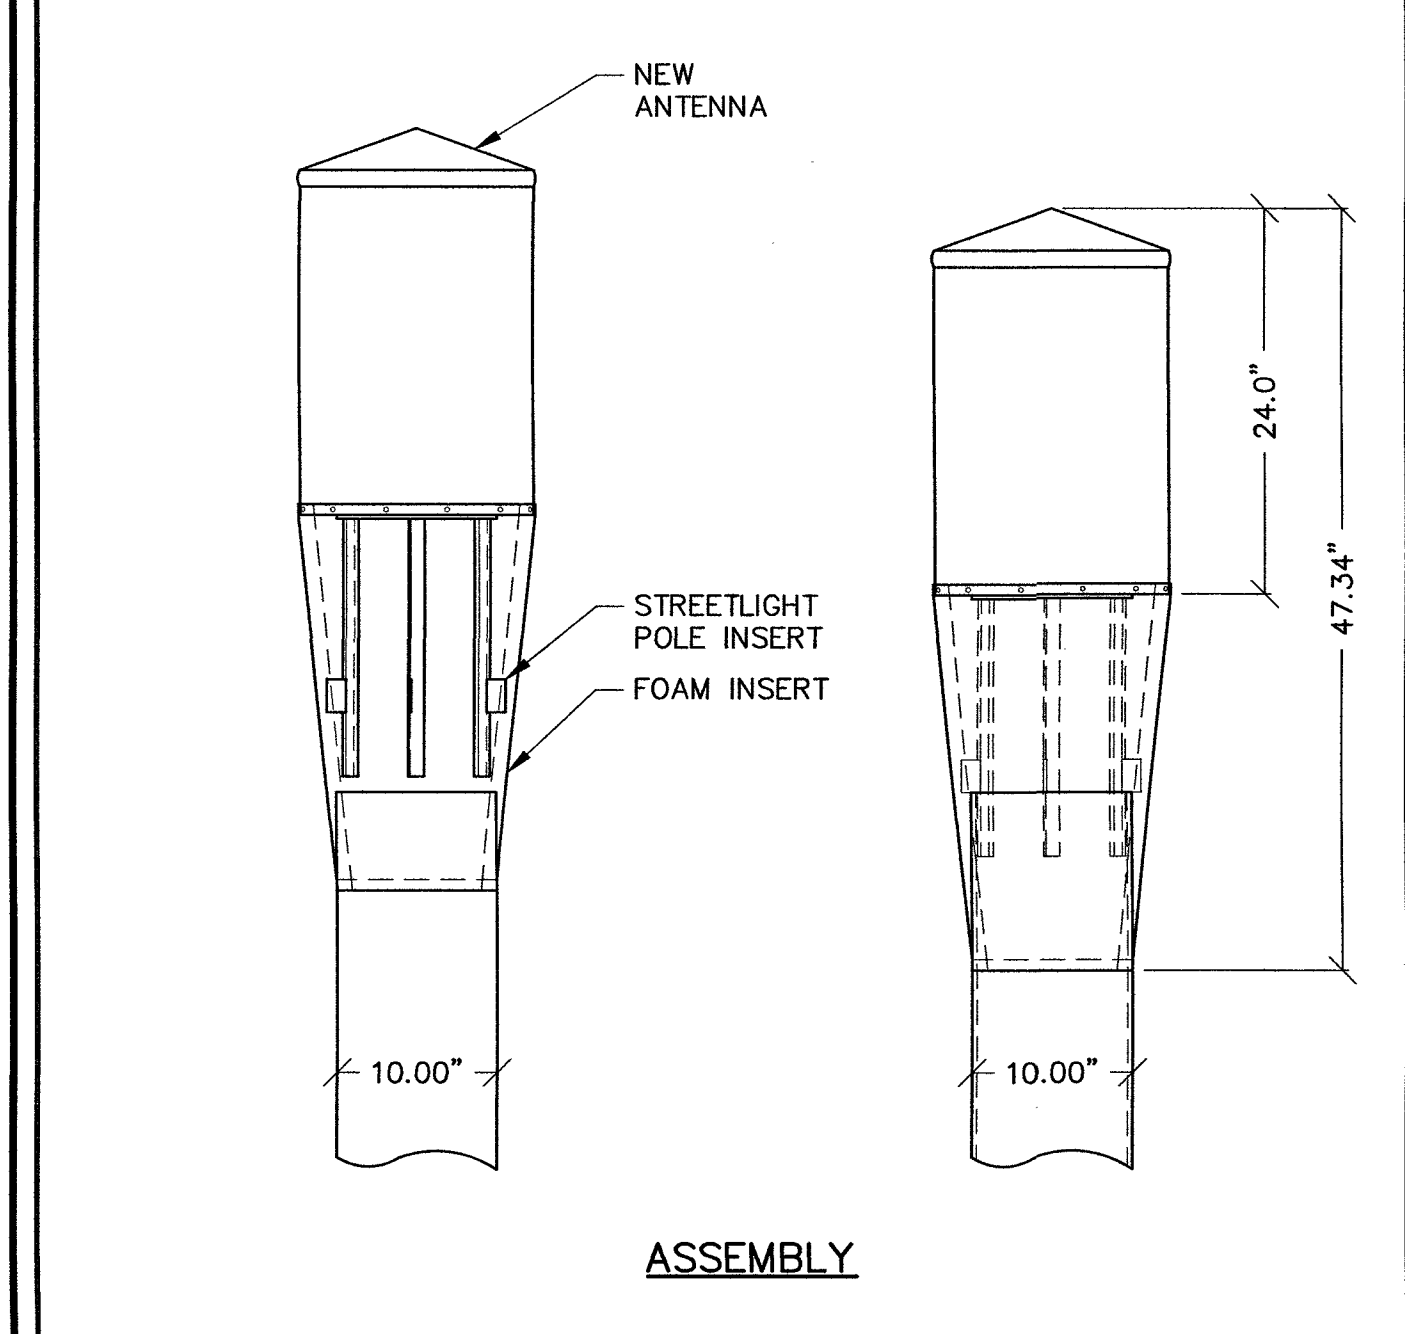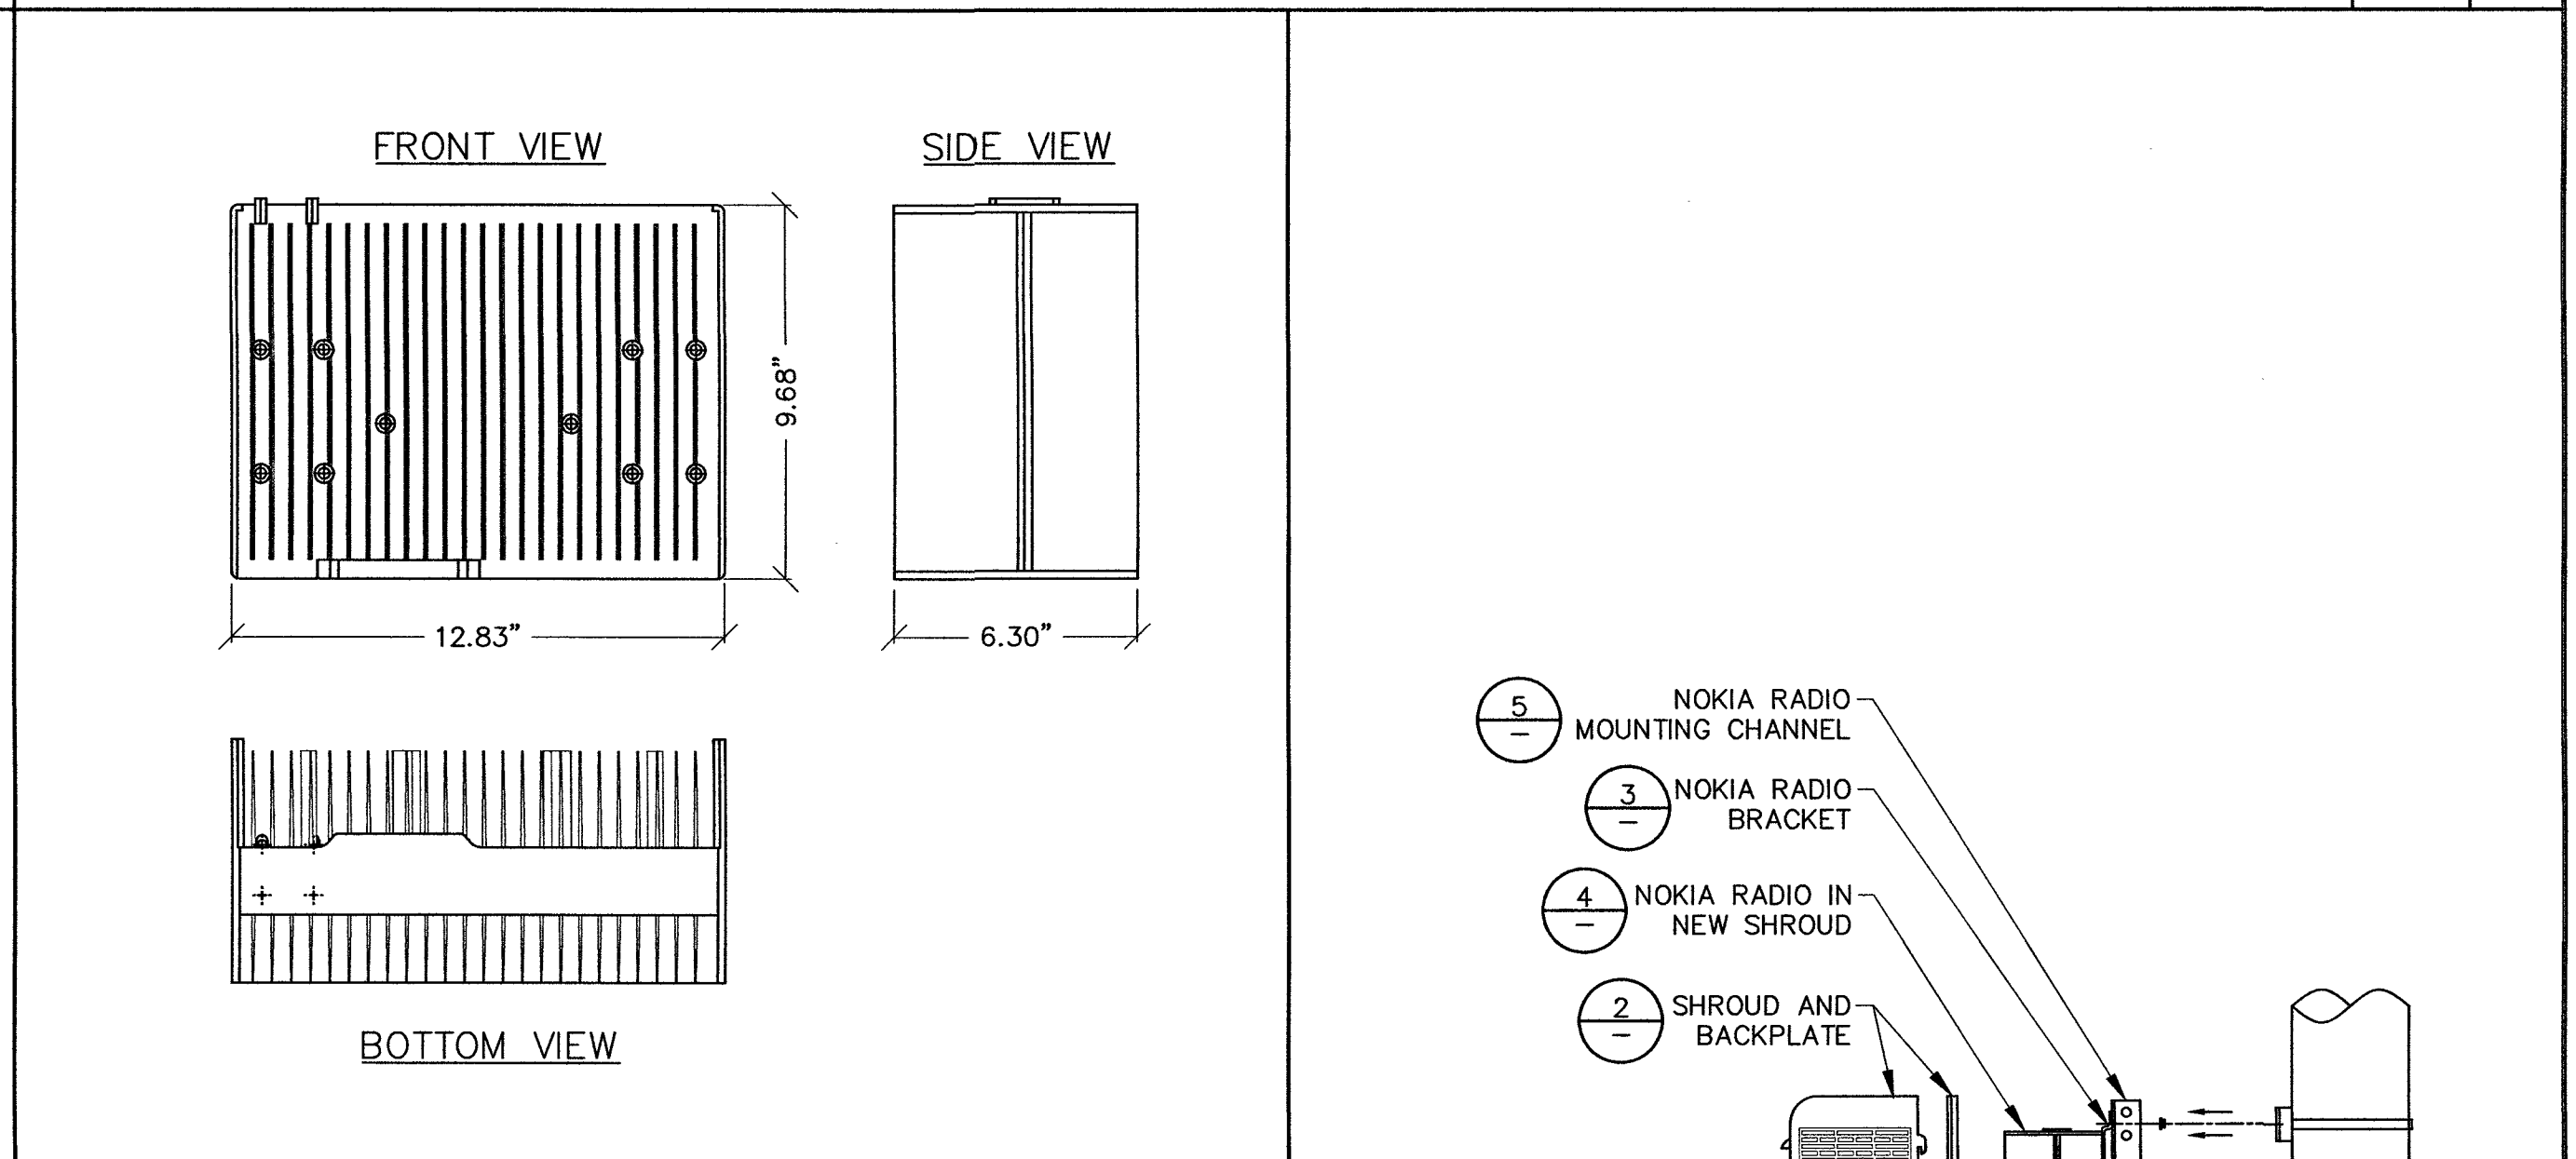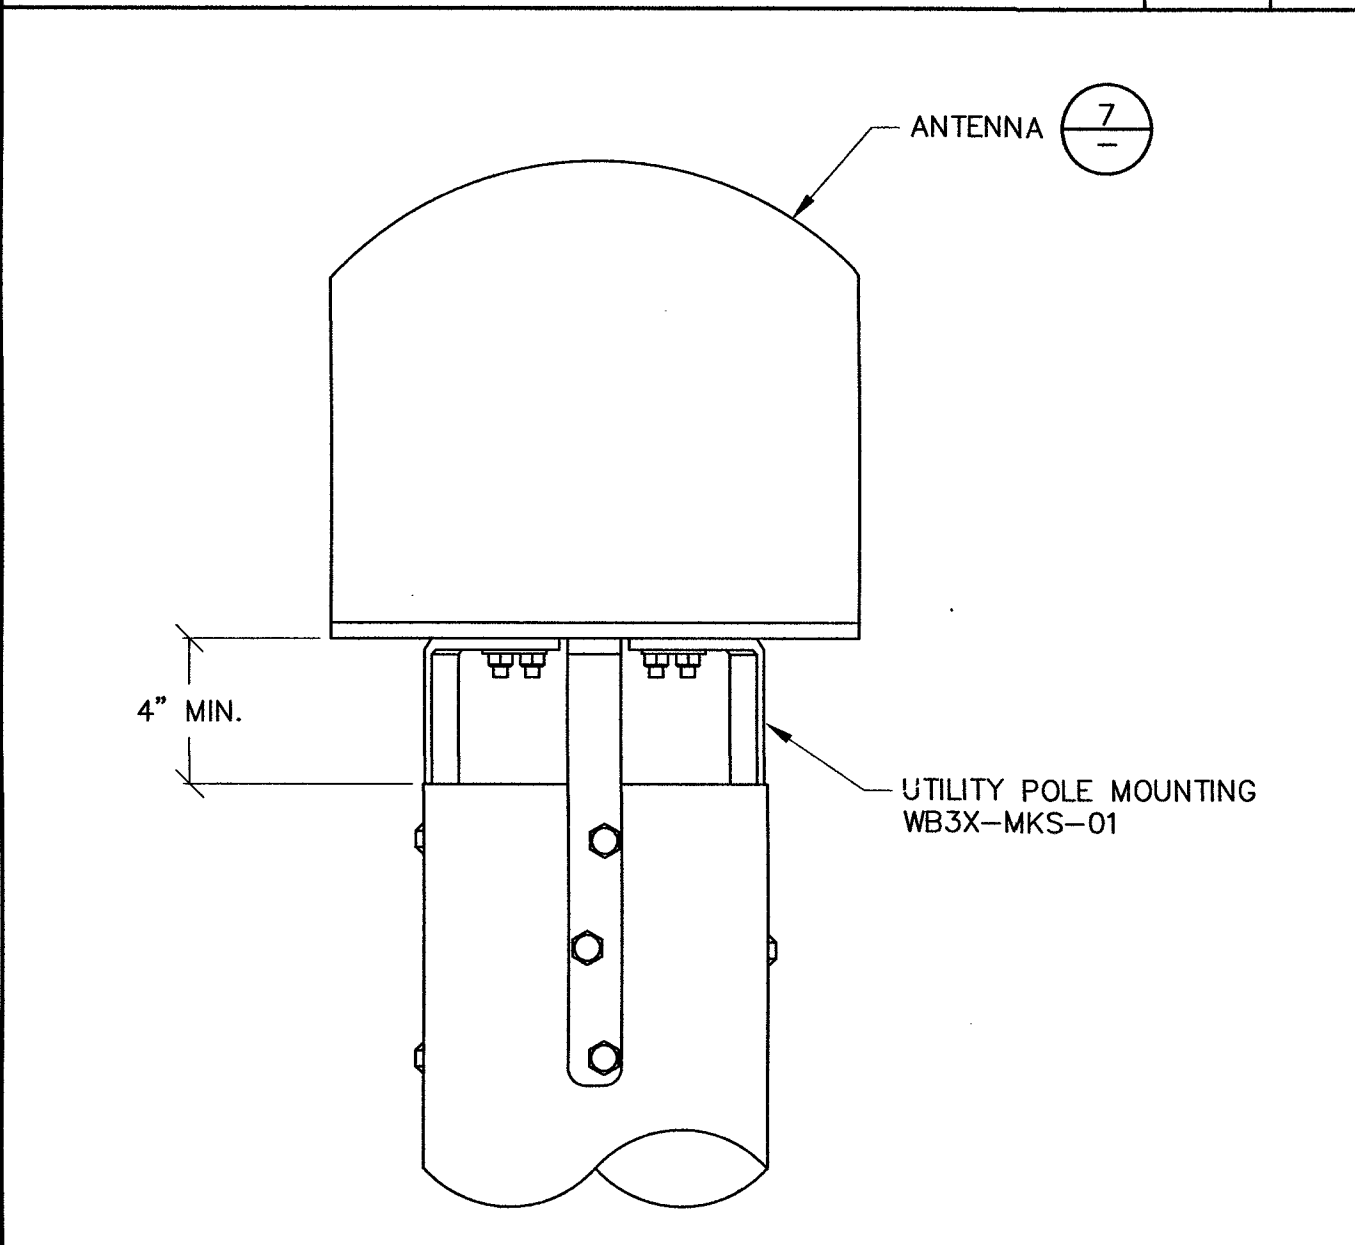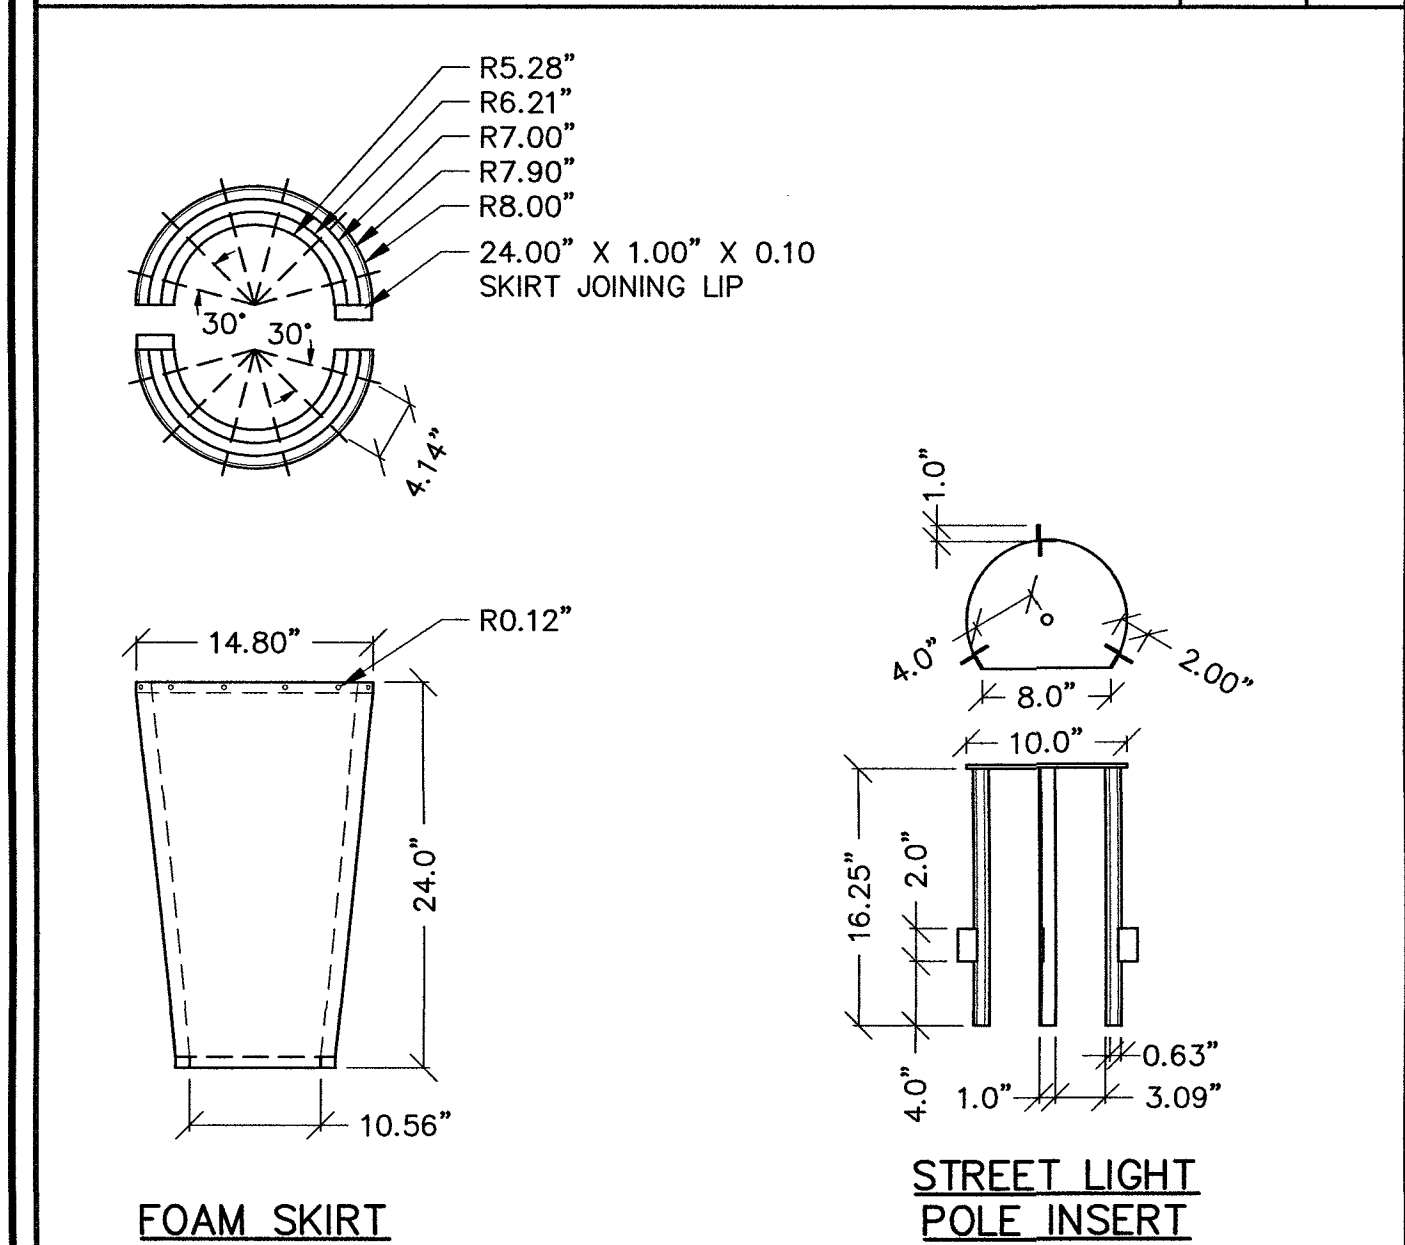



CROWN CASTLE NG WEST LLC
2055 SOUTH STEARMAN DRIVE
CHANDLER, ARIZONA 85286

PROJECT INFORMATION:

CROWN CASTLE ID # LV013

256 S PAVILION CENTER DR
LAS VEGAS, NEVADA 89144

CURRENT ISSUE DATE:

04/09/19

ISSUED FOR:

PROPOSED WORK

REV.: DATE: DESCRIPTION: BY:


REV.	DATE	DESCRIPTION	BY
2	04/04/19	POLE REVISION	D.C.
1	10/16/18	100% PERMITTING	C.P.
0	09/18/18	90% PERMITTING	R.S.

PLANS PREPARED BY:



SPECTRUM SERVICES, INC.
4850 WEST OQUENDO ROAD
LAS VEGAS, NEVADA 89118
PHONE: (702) 367-7705
FAX: (702) 367-8733

LICENSURE:

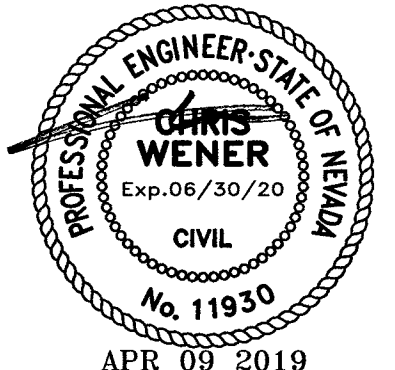

CHRIS WENER
Exp. 06/30/20
CIVIL
No. 11930
APR 09 2019

SHEET TITLE:

CONSTRUCTION DETAILS

SHEET NUMBER: REVISION:

C5

2

PROJECT INFORMATION:

CROWN CASTLE ID #
LV013

256 S PAVILION CENTER DR
LAS VEGAS, NEVADA 89144

CURRENT ISSUE DATE:

04/09/19

ISSUED FOR:

PROPOSED WORK

REV.: DATE: DESCRIPTION: BY:


REV.	DATE	DESCRIPTION	BY
3	04/09/19	LAND DEV. COMMENTS	R.S.
2	04/04/19	POLE REVISION	D.C.
1	10/16/18	100% PERMITTING	C.P.
0	09/18/18	90% PERMITTING	R.S.

PLANS PREPARED BY:

SPECTRUM

SPECTRUM SERVICES, INC.
4850 WEST OQUENDO ROAD
LAS VEGAS, NEVADA 89118
PHONE: (702) 367-7705
FAX: (702) 367-8733

LICENSURE:


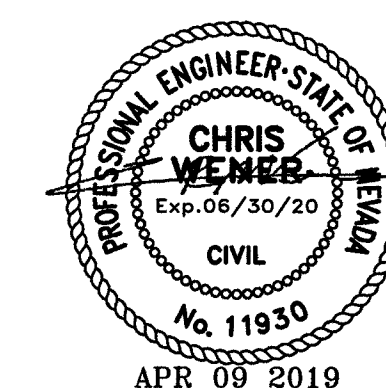




SHEET TITLE:

CONCRETE FOUNDATION
DETAILS

SHEET NUMBER: REVISION:

C6 3

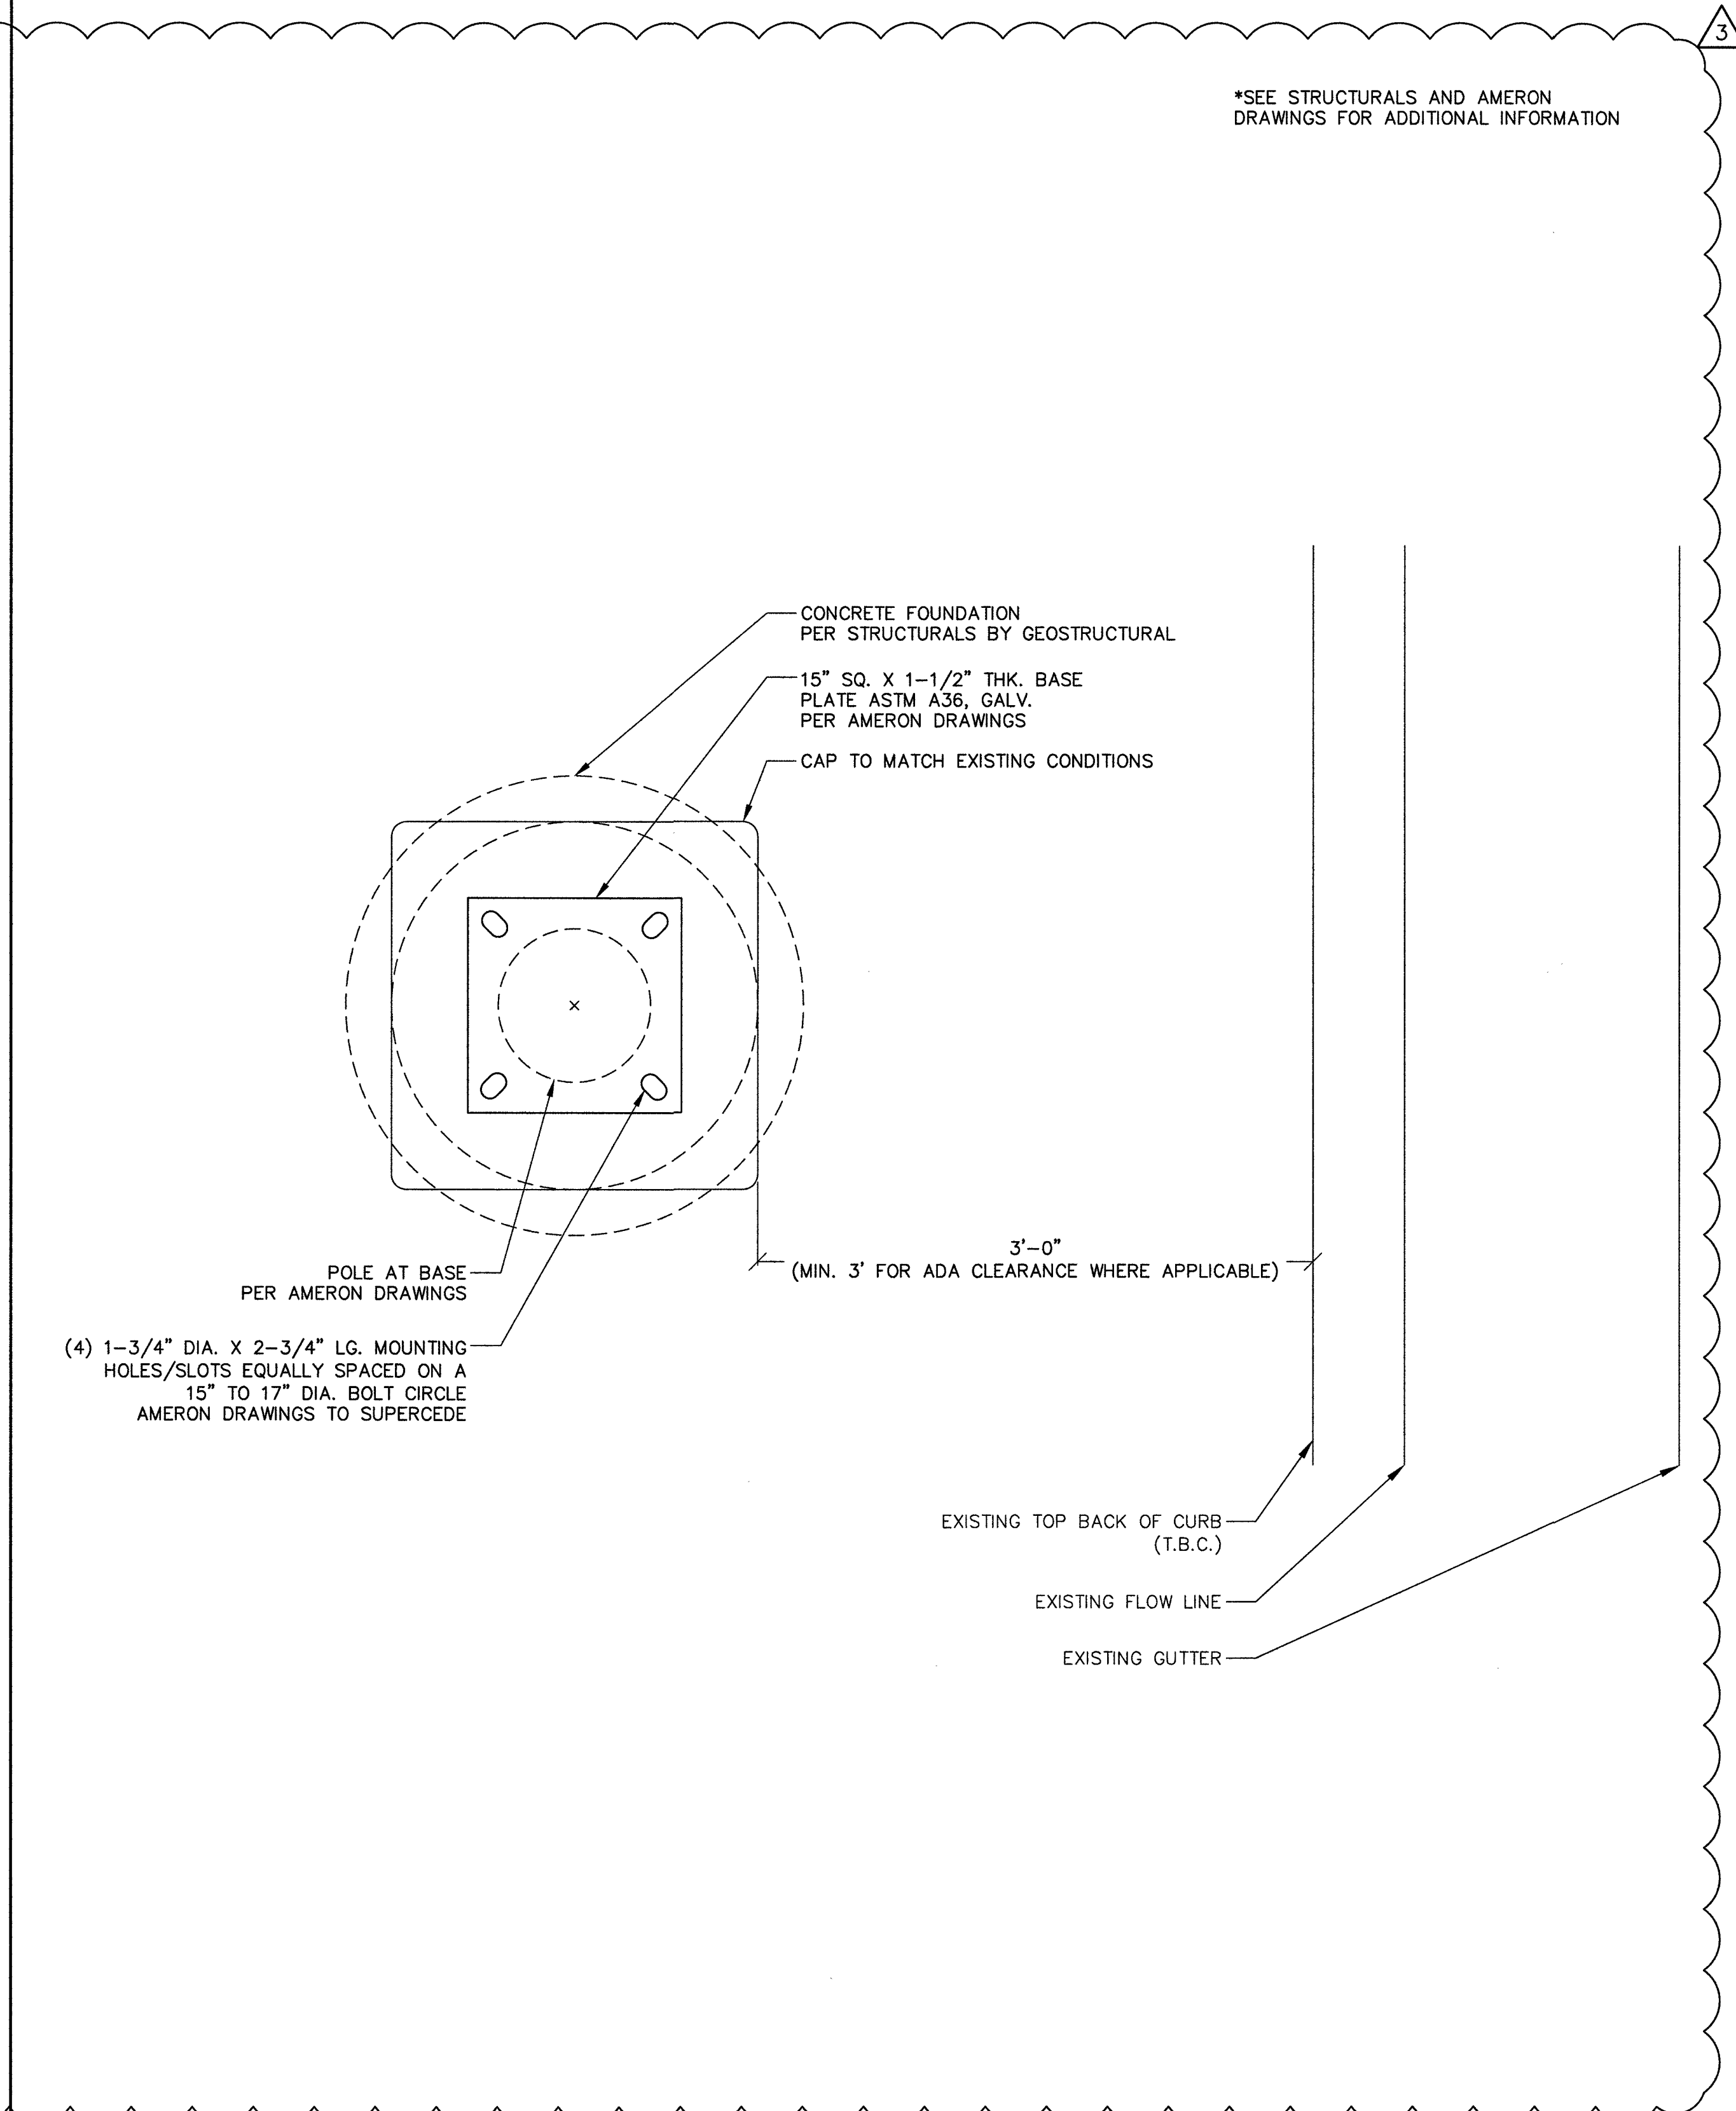
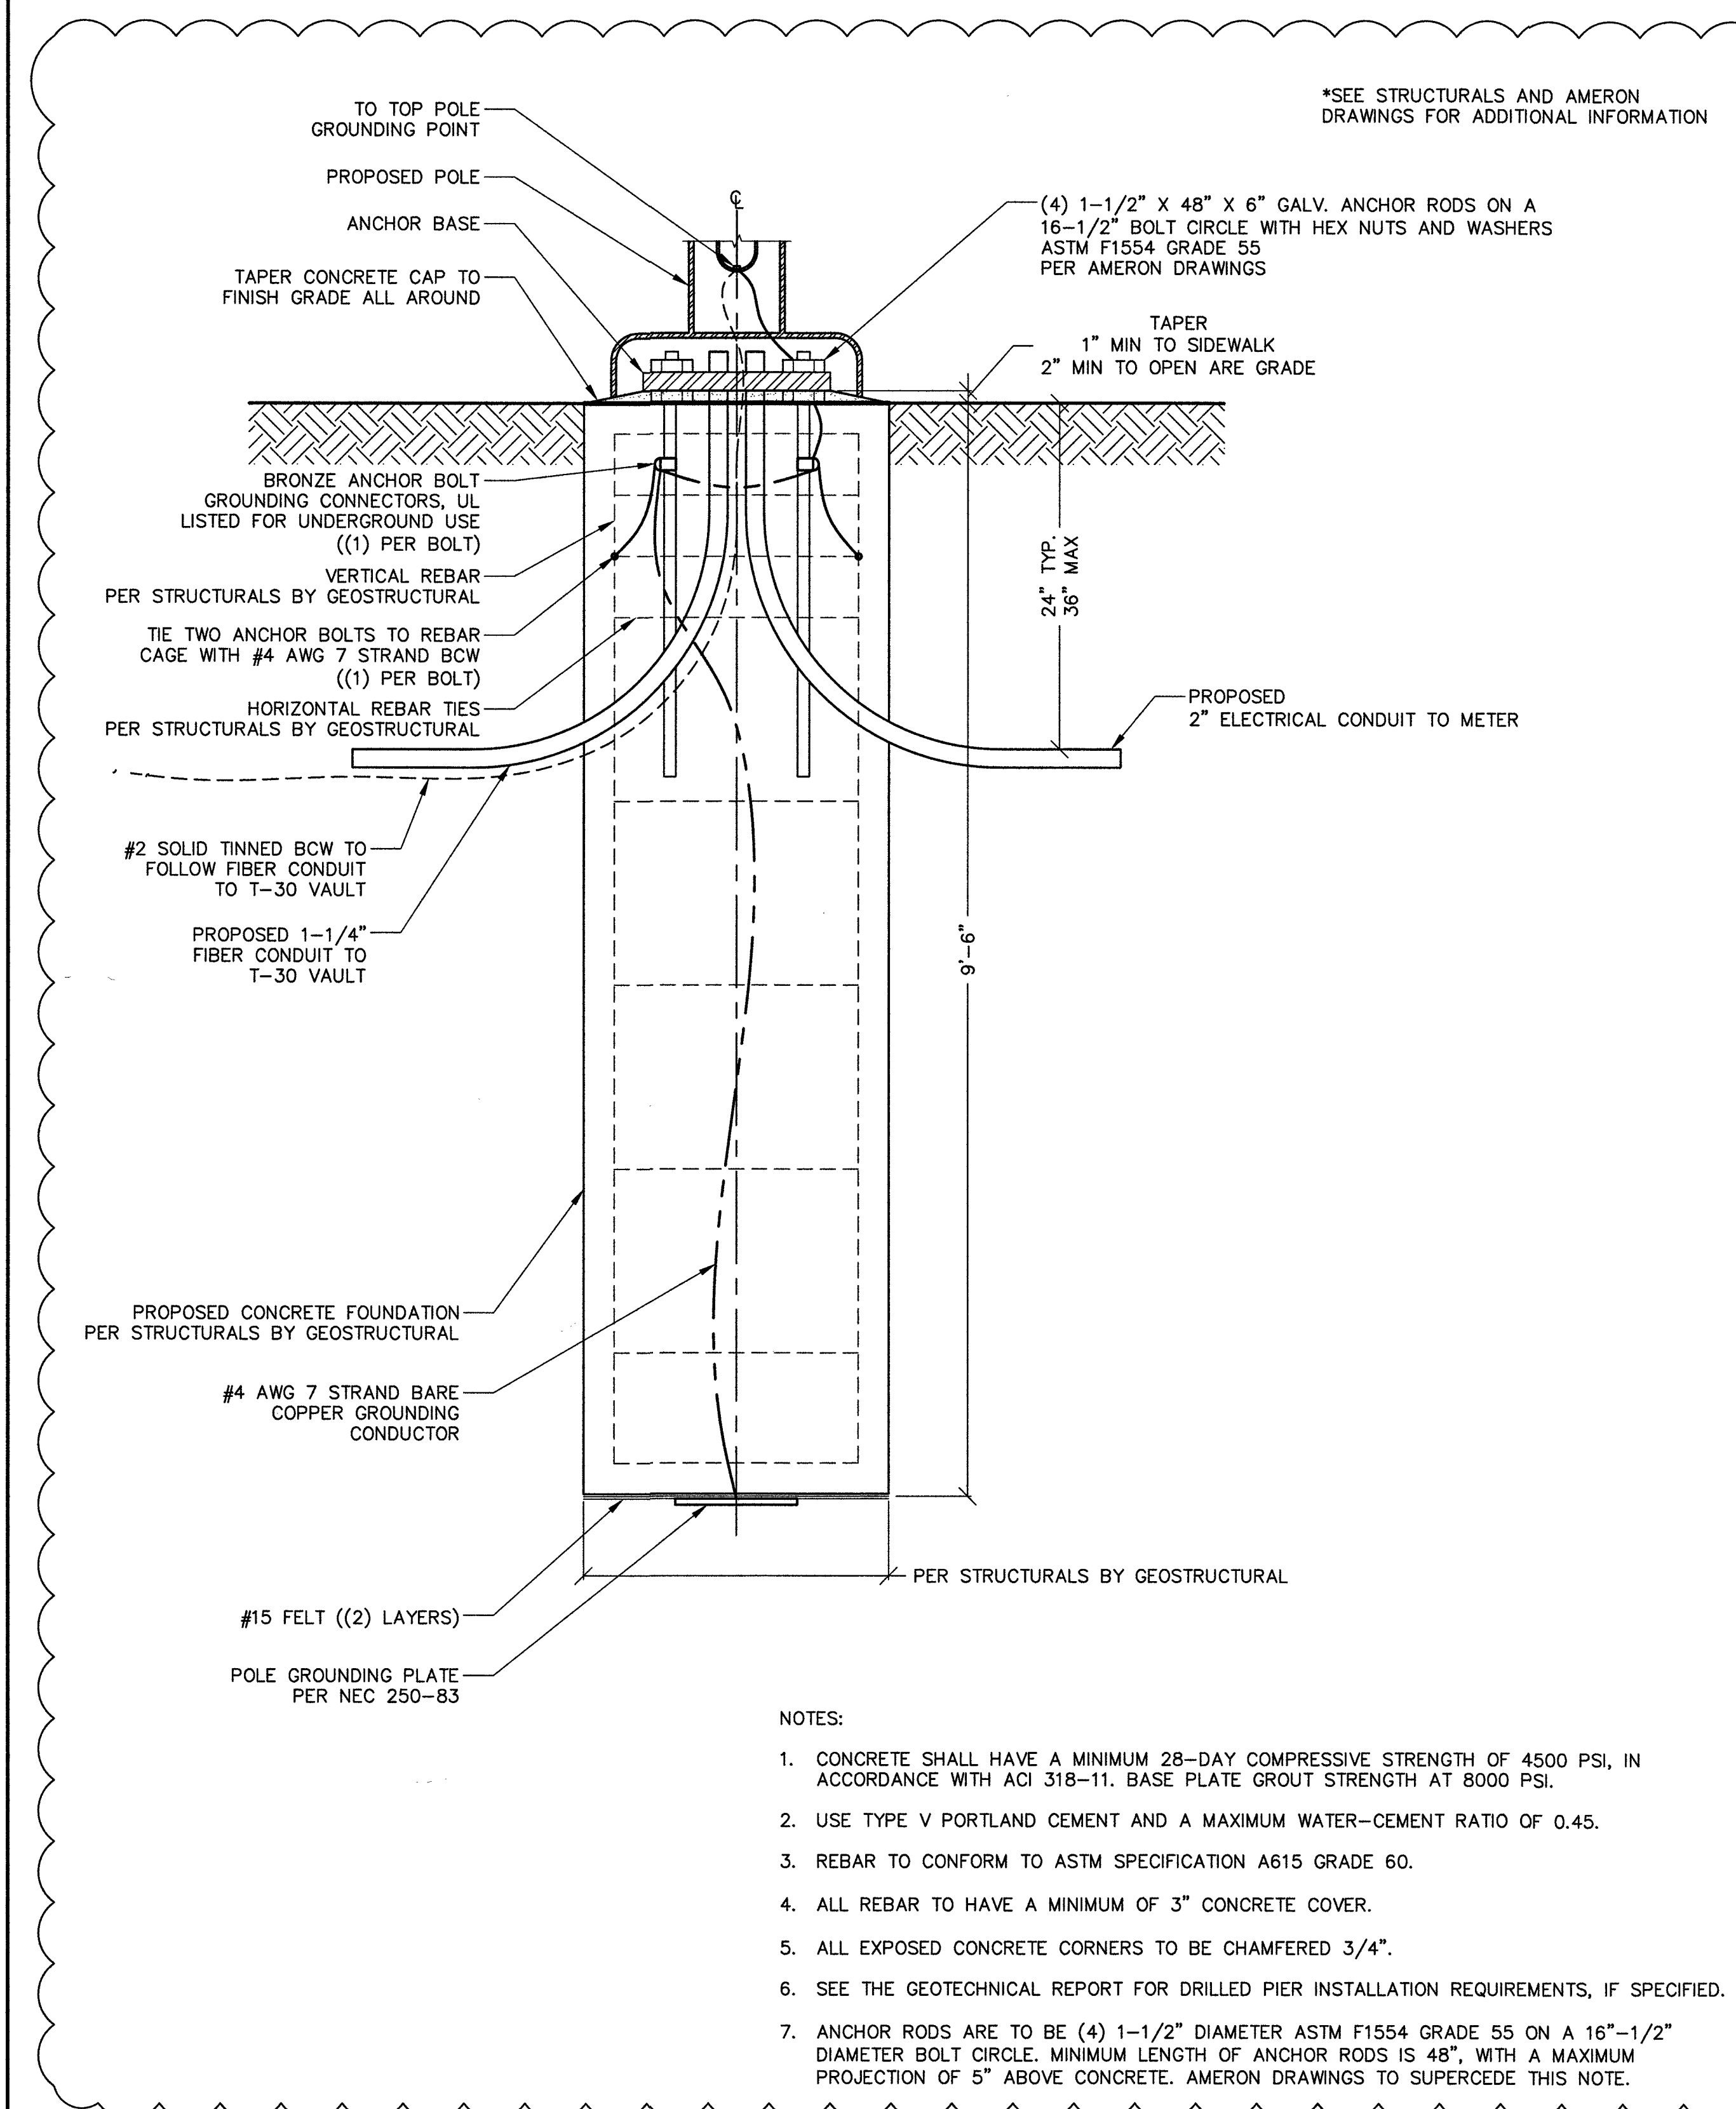


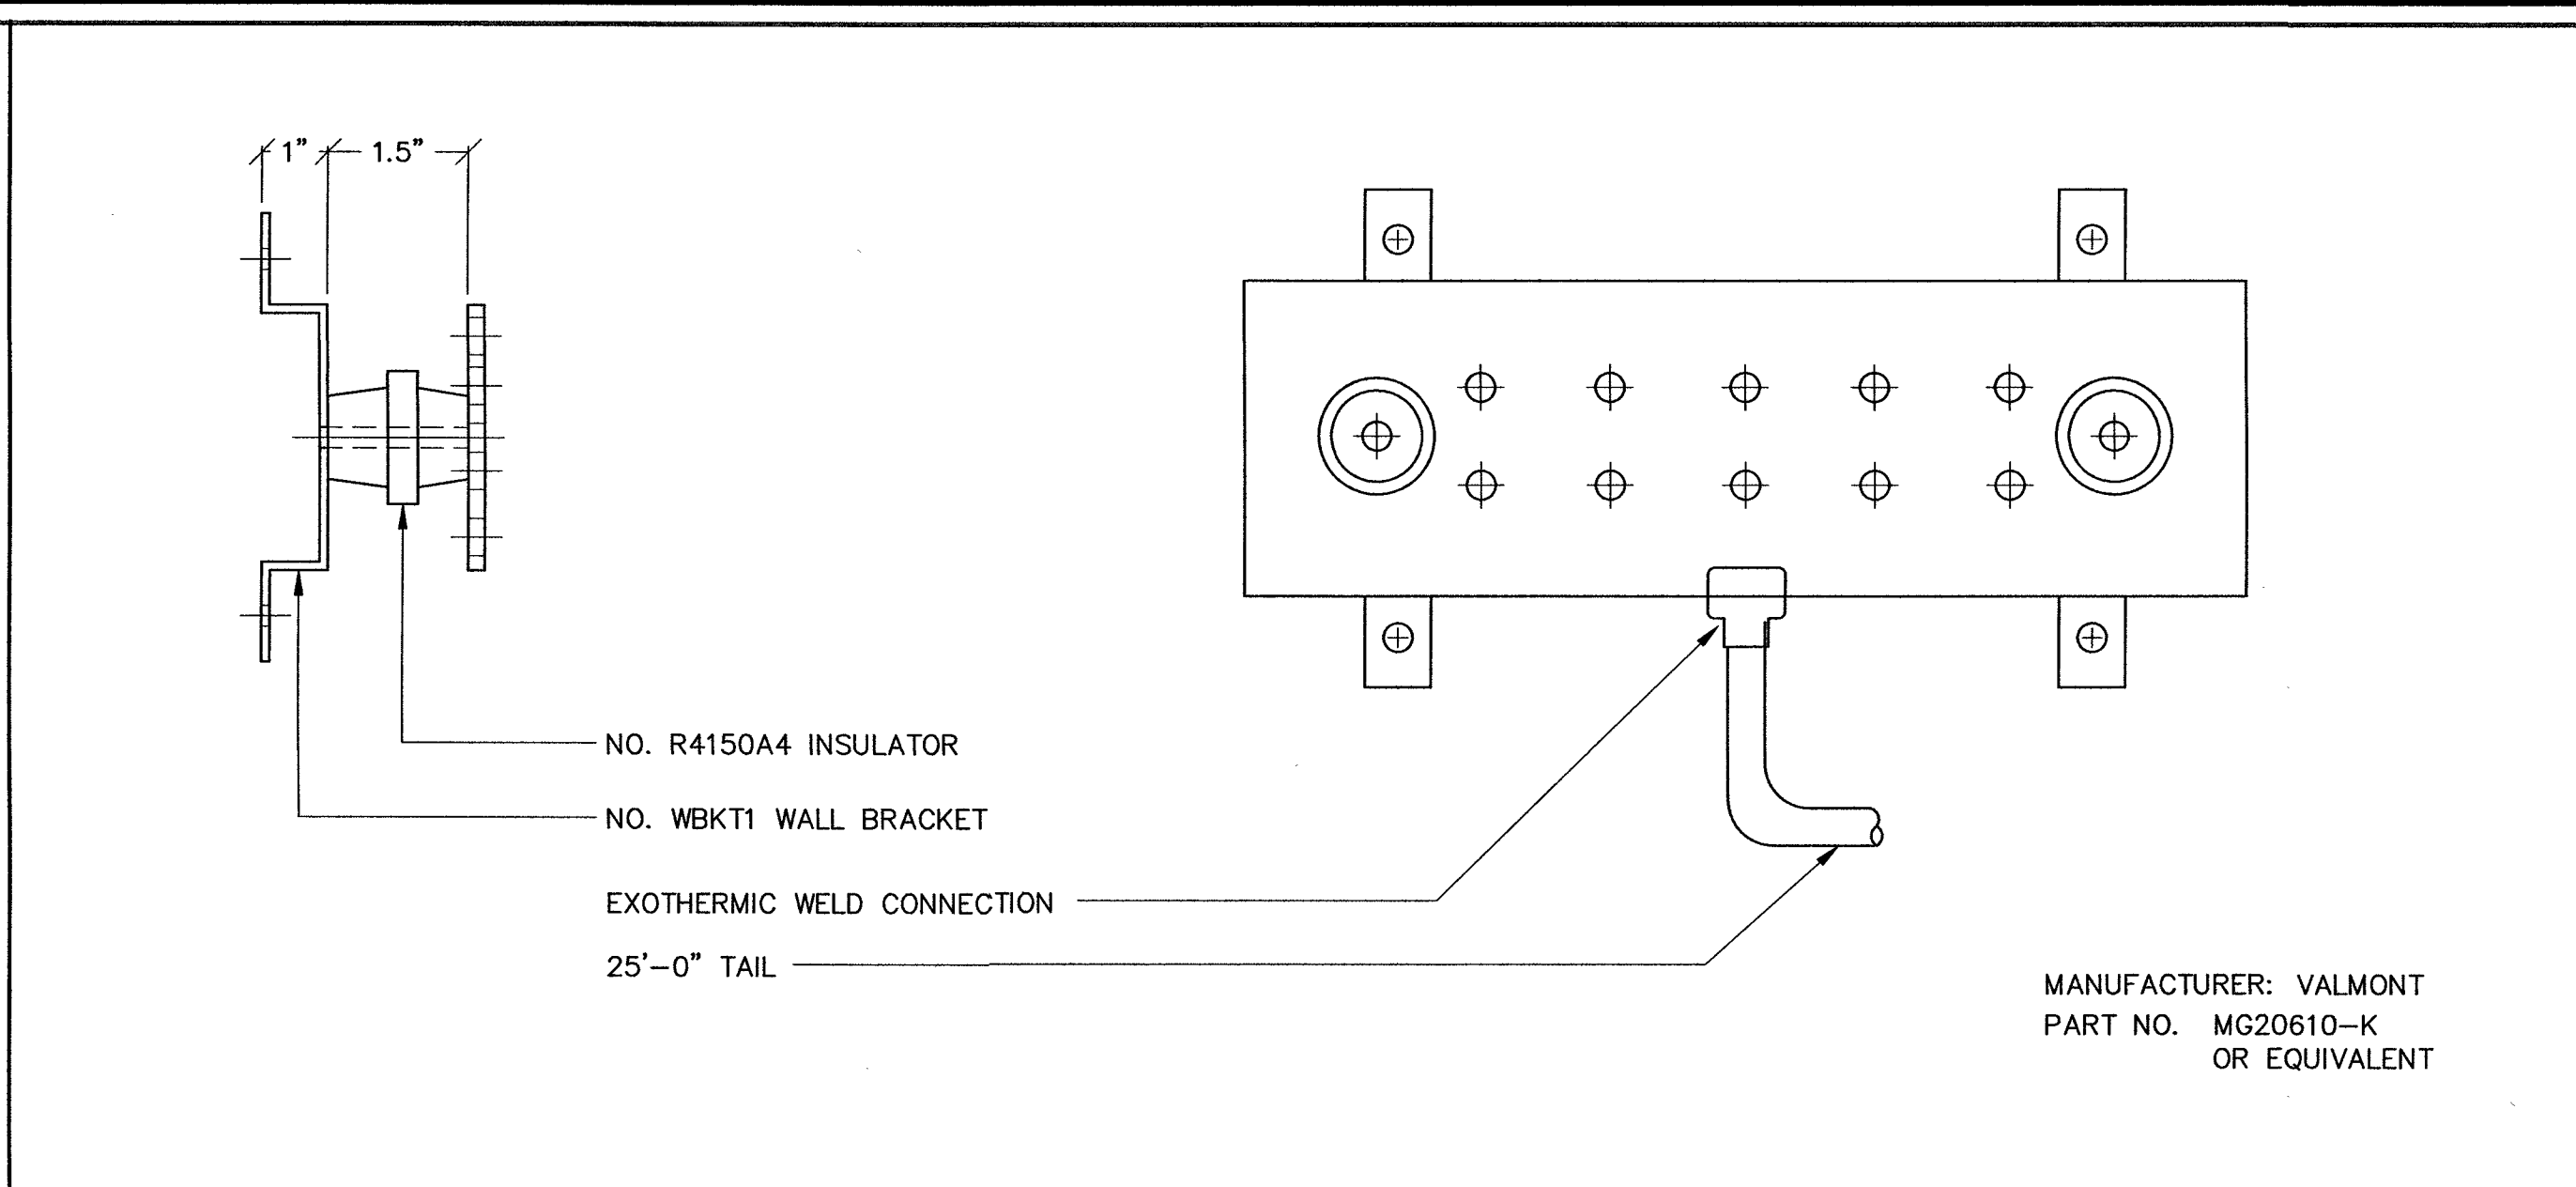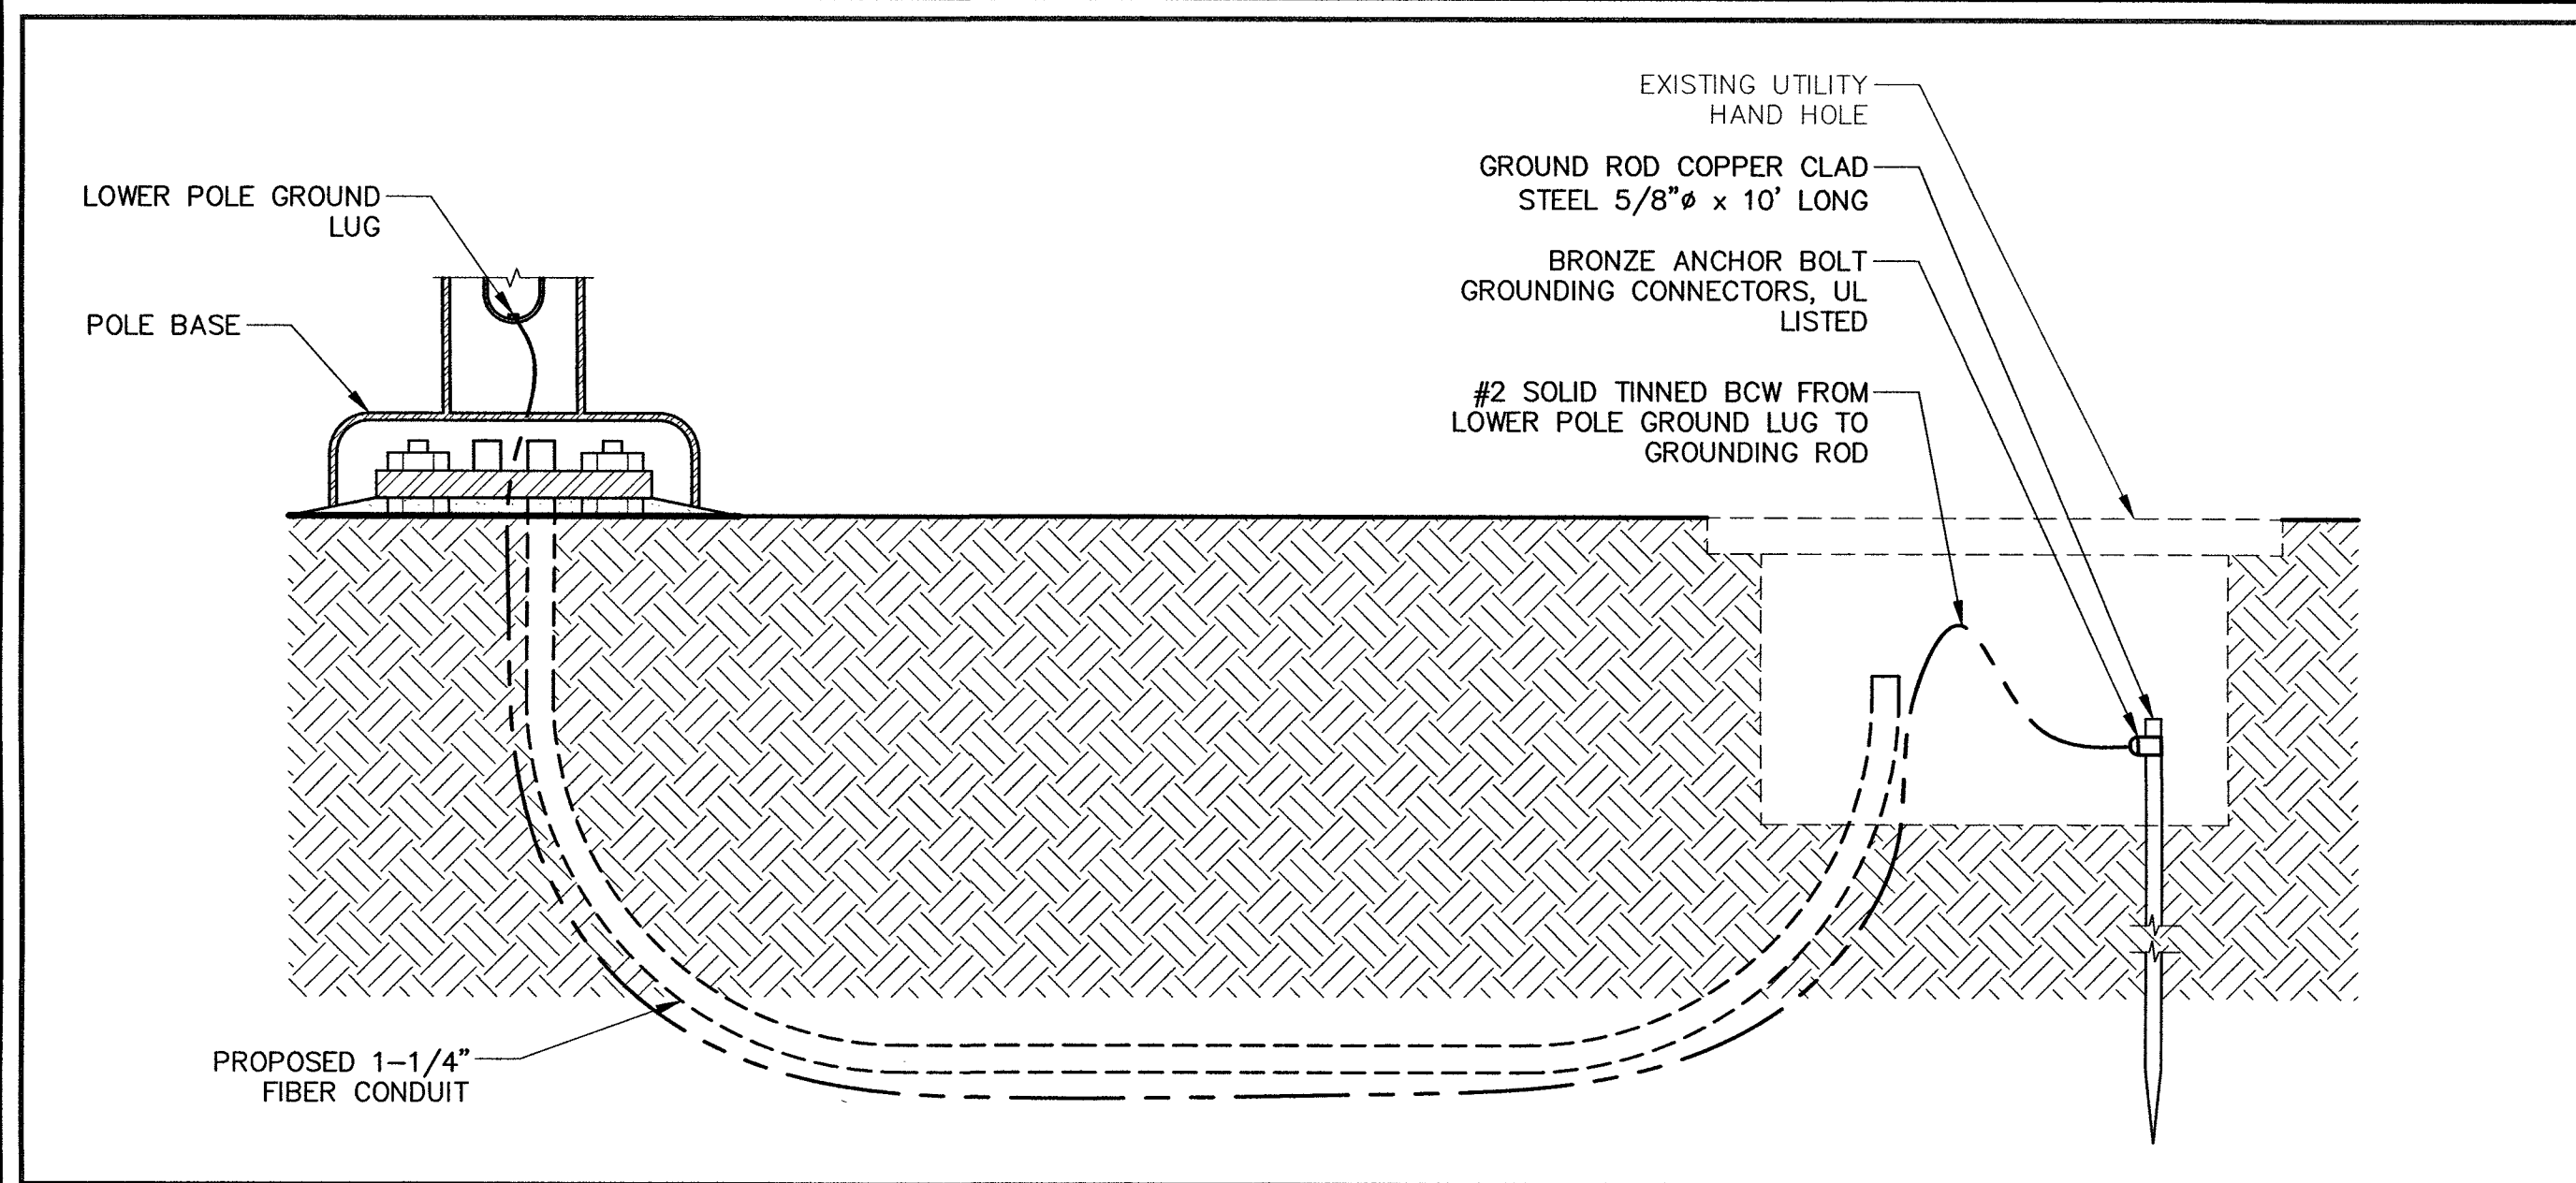

GROUND ROD SCALE: NONE 4

GROUND BAR SCALE: NONE 2

1. ALL DETAILS ARE SHOWN IN GENERAL TERMS. ACTUAL GROUNDING INSTALLATION REQUIREMENTS AND CONSTRUCTION ACCORDING TO SITE CONDITIONS AND CARRIER GROUNDING STANDARD, LATEST REVISION.
2. ALL GROUNDING CONDUCTORS: #2 AWG SOLID BARE TINNED COPPER WIRE UNLESS OTHERWISE NOTED.
3. GROUND RING TO GROUND BAR CONNECTIONS SHALL BE CADWELED QTY. (2) #2 AWG SOLID BARE TINNED COPPER WIRE UNLESS OTHERWISE NOTED.
4. GROUND BAR TO EQUIPMENT AND CABLES SHALL BE #2 AWG BTCW W/ DOUBLE LUG CONNECTIONS.
5. GROUND BAR LOCATED IN BASE OF EQUIPMENT WILL BE PROVIDED, FURNISHED AND INSTALLED BY THE VENDOR.
6. GROUND BAR LOCATED BELOW WAVEGUIDE ENTRY PORT. CABLES SHALL BE #2 AWG BTCW/DOUBLE LUG CONNECTIONS. TWO PATHS TO GROUND RING.
7. ALL BELOW GRADE CONNECTIONS: EXOTHERMIC WELD TYPE, ABOVE GRADE CONNECTIONS: EXOTHERMIC WELD TYPE.
8. EXTERIOR GROUNDING CONDUCTORS: BURIED TO A MINIMUM DEPTH OF 1'-6" BELOW FINISHED GRADE TO ALLOW FOR FUTURE CONSTRUCTION.
9. INSTALL GROUND CONDUCTORS AND GROUND ROD MINIMUM OF 1'-0" FROM EQUIPMENT CONCRETE SLAB, SPREAD FOOTING, OR FENCE.
10. EXOTHERMIC WELD GROUND CONNECTION TO FENCE POST: TREAT WITH A COLD GALVANIZED SPRAY.
11. GROUND BARS:
EQUIPMENT GROUND BUSS BAR (EGB) LOCATED AT BOTTOM OF ANTENNA POLE/MAST FOR MAKING GROUNDING JUMPER CONNECTIONS TO COAX FEEDER CABLES SHALL BE FURNISHED AND INSTALLED BY ELECTRICAL CONTRACTOR. JUMPERS (FURNISHED BY OWNERS) SHALL BE INSTALLED AND CONNECTED BY ELECTRICAL CONTRACTOR.
MAIN GROUND BUSS BAR (MGB) LOCATED NEAR THE BASE OF THE RADIO EQUIPMENT CABINET(S) SHALL BE FURNISHED AND INSTALLED BY ELECTRICAL CONTRACTOR.
12. ALL GROUNDING INSTALLATIONS AND CONNECTIONS SHALL BE MADE BY ELECTRICAL CONTRACTOR.
13. ALL BOLTED TORQUE CONNECTORS SHALL BE LONG-BARRELED TYPES AND HAVE TWO HOLES FOR CONNECTION TO SURFACE AND NON-OXIDIZING AGENT APPLIED TO INHIBIT CORROSION.

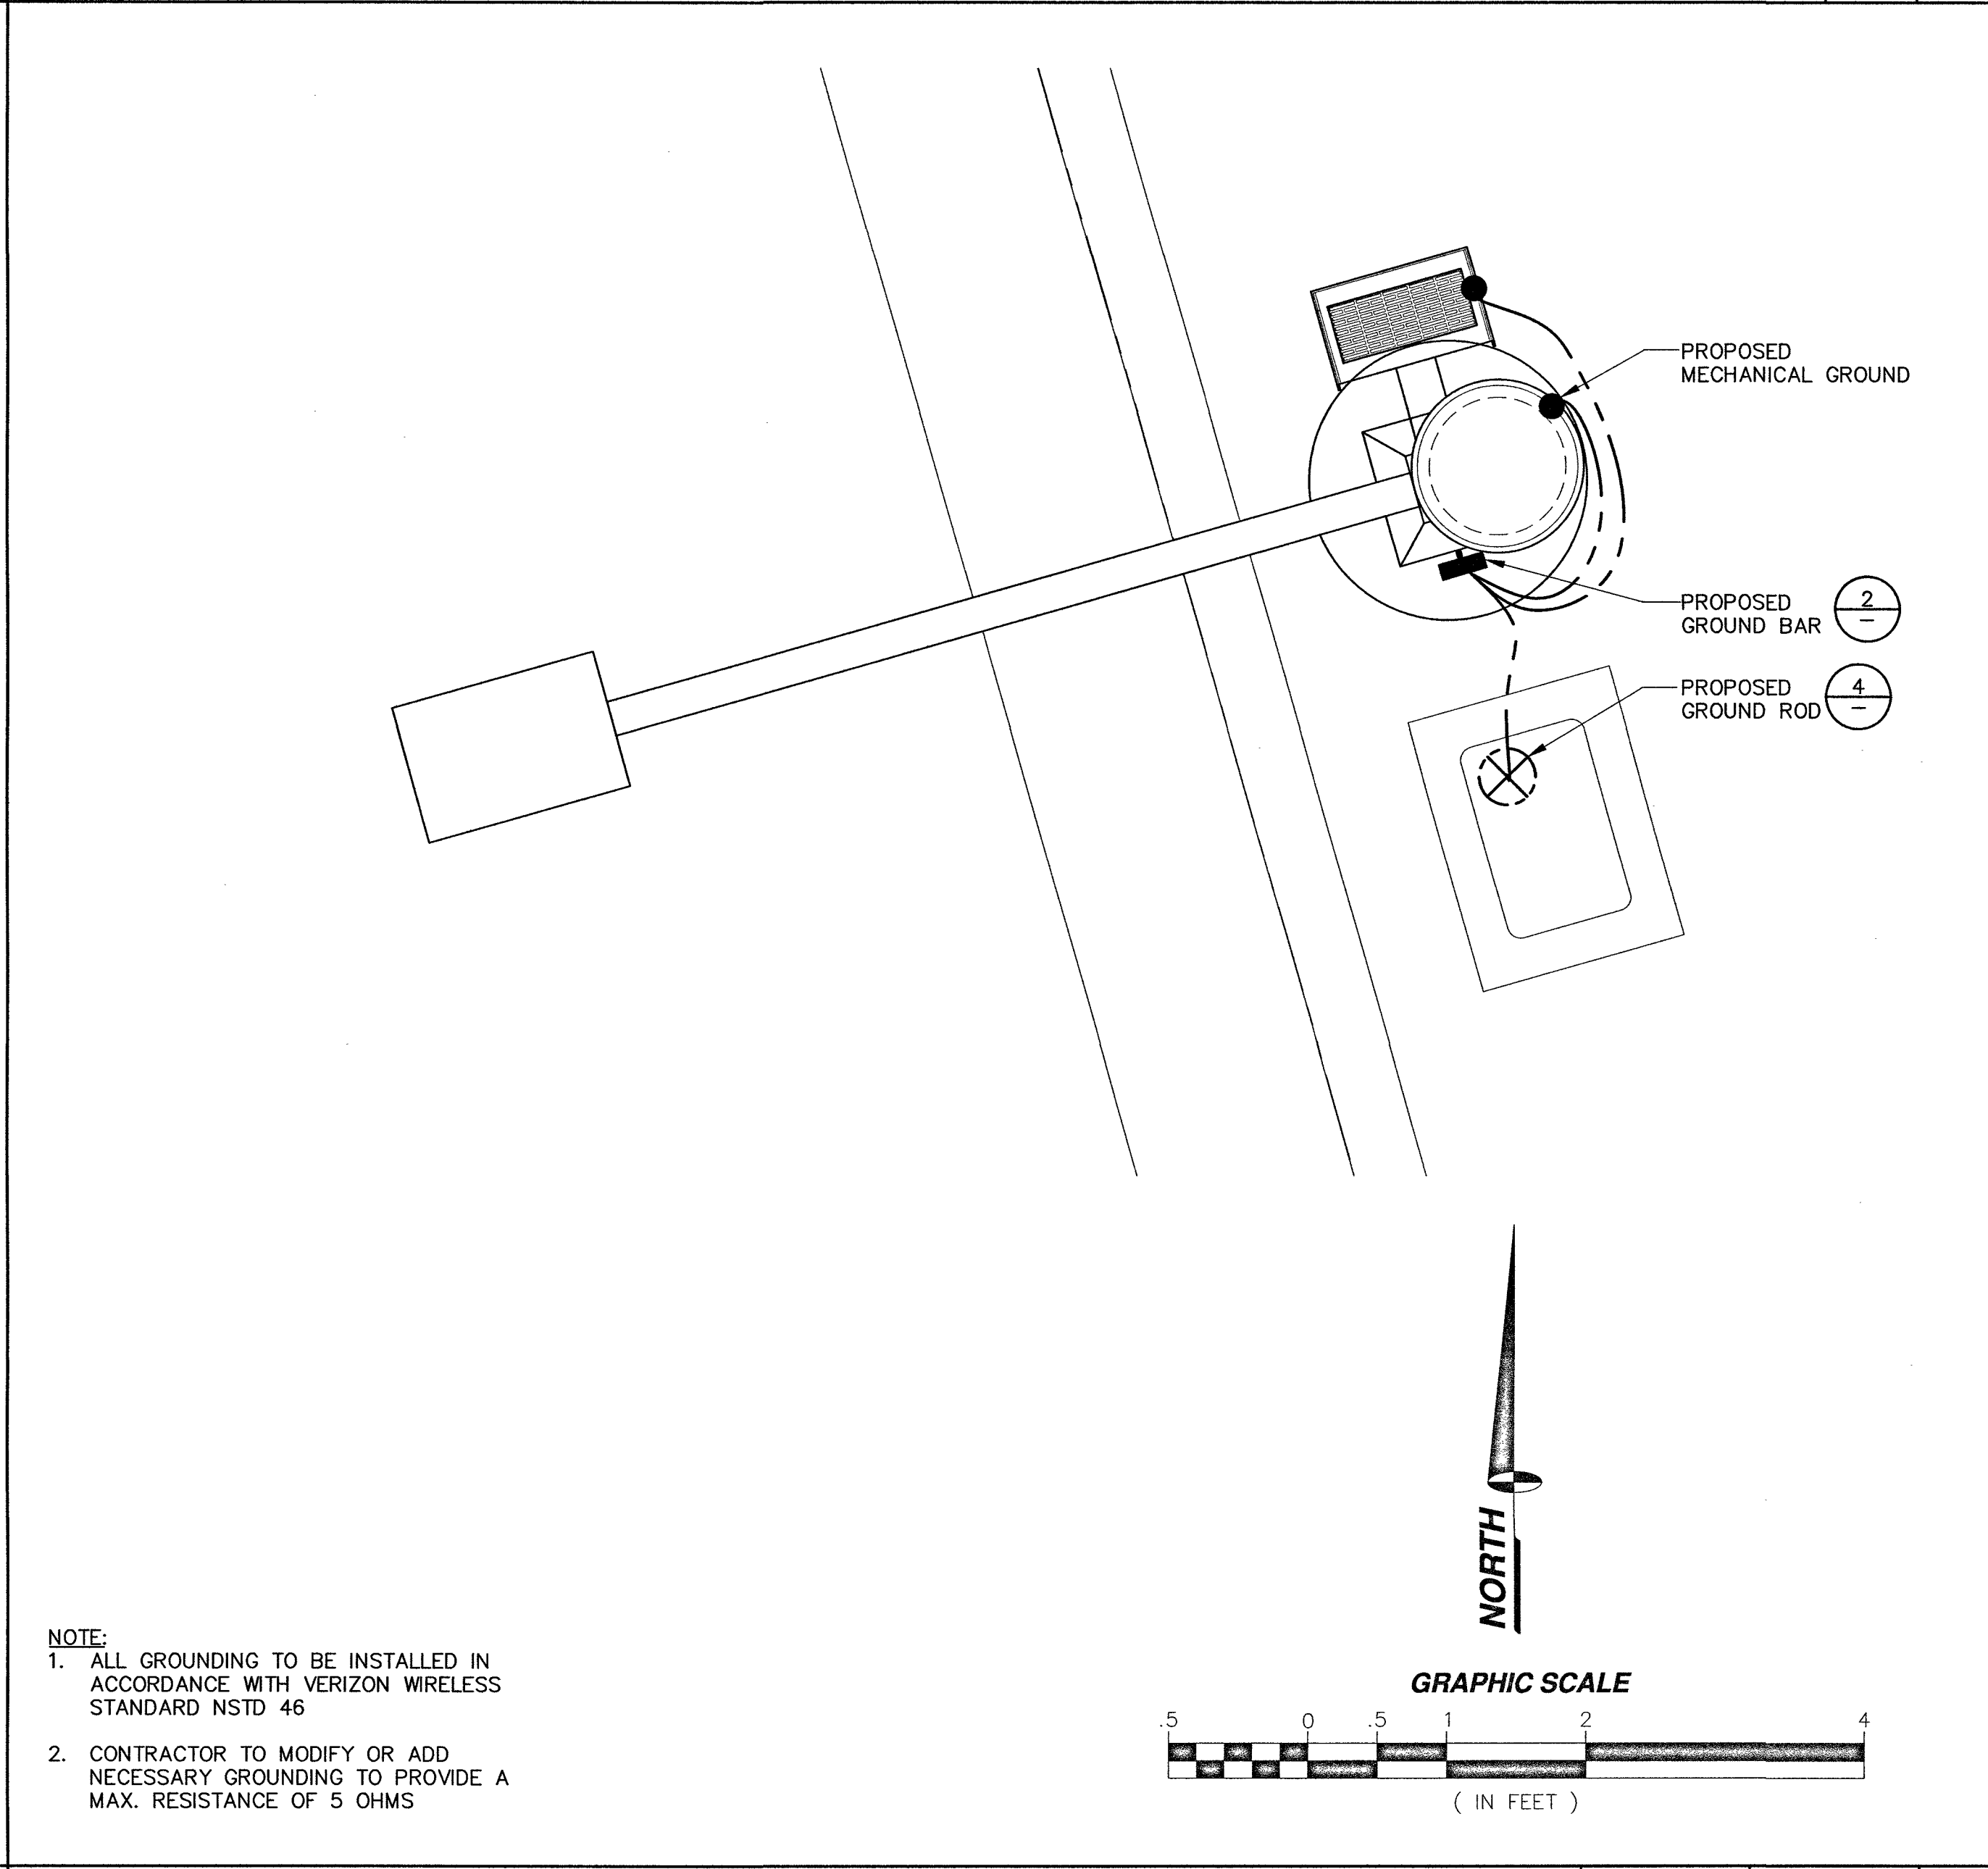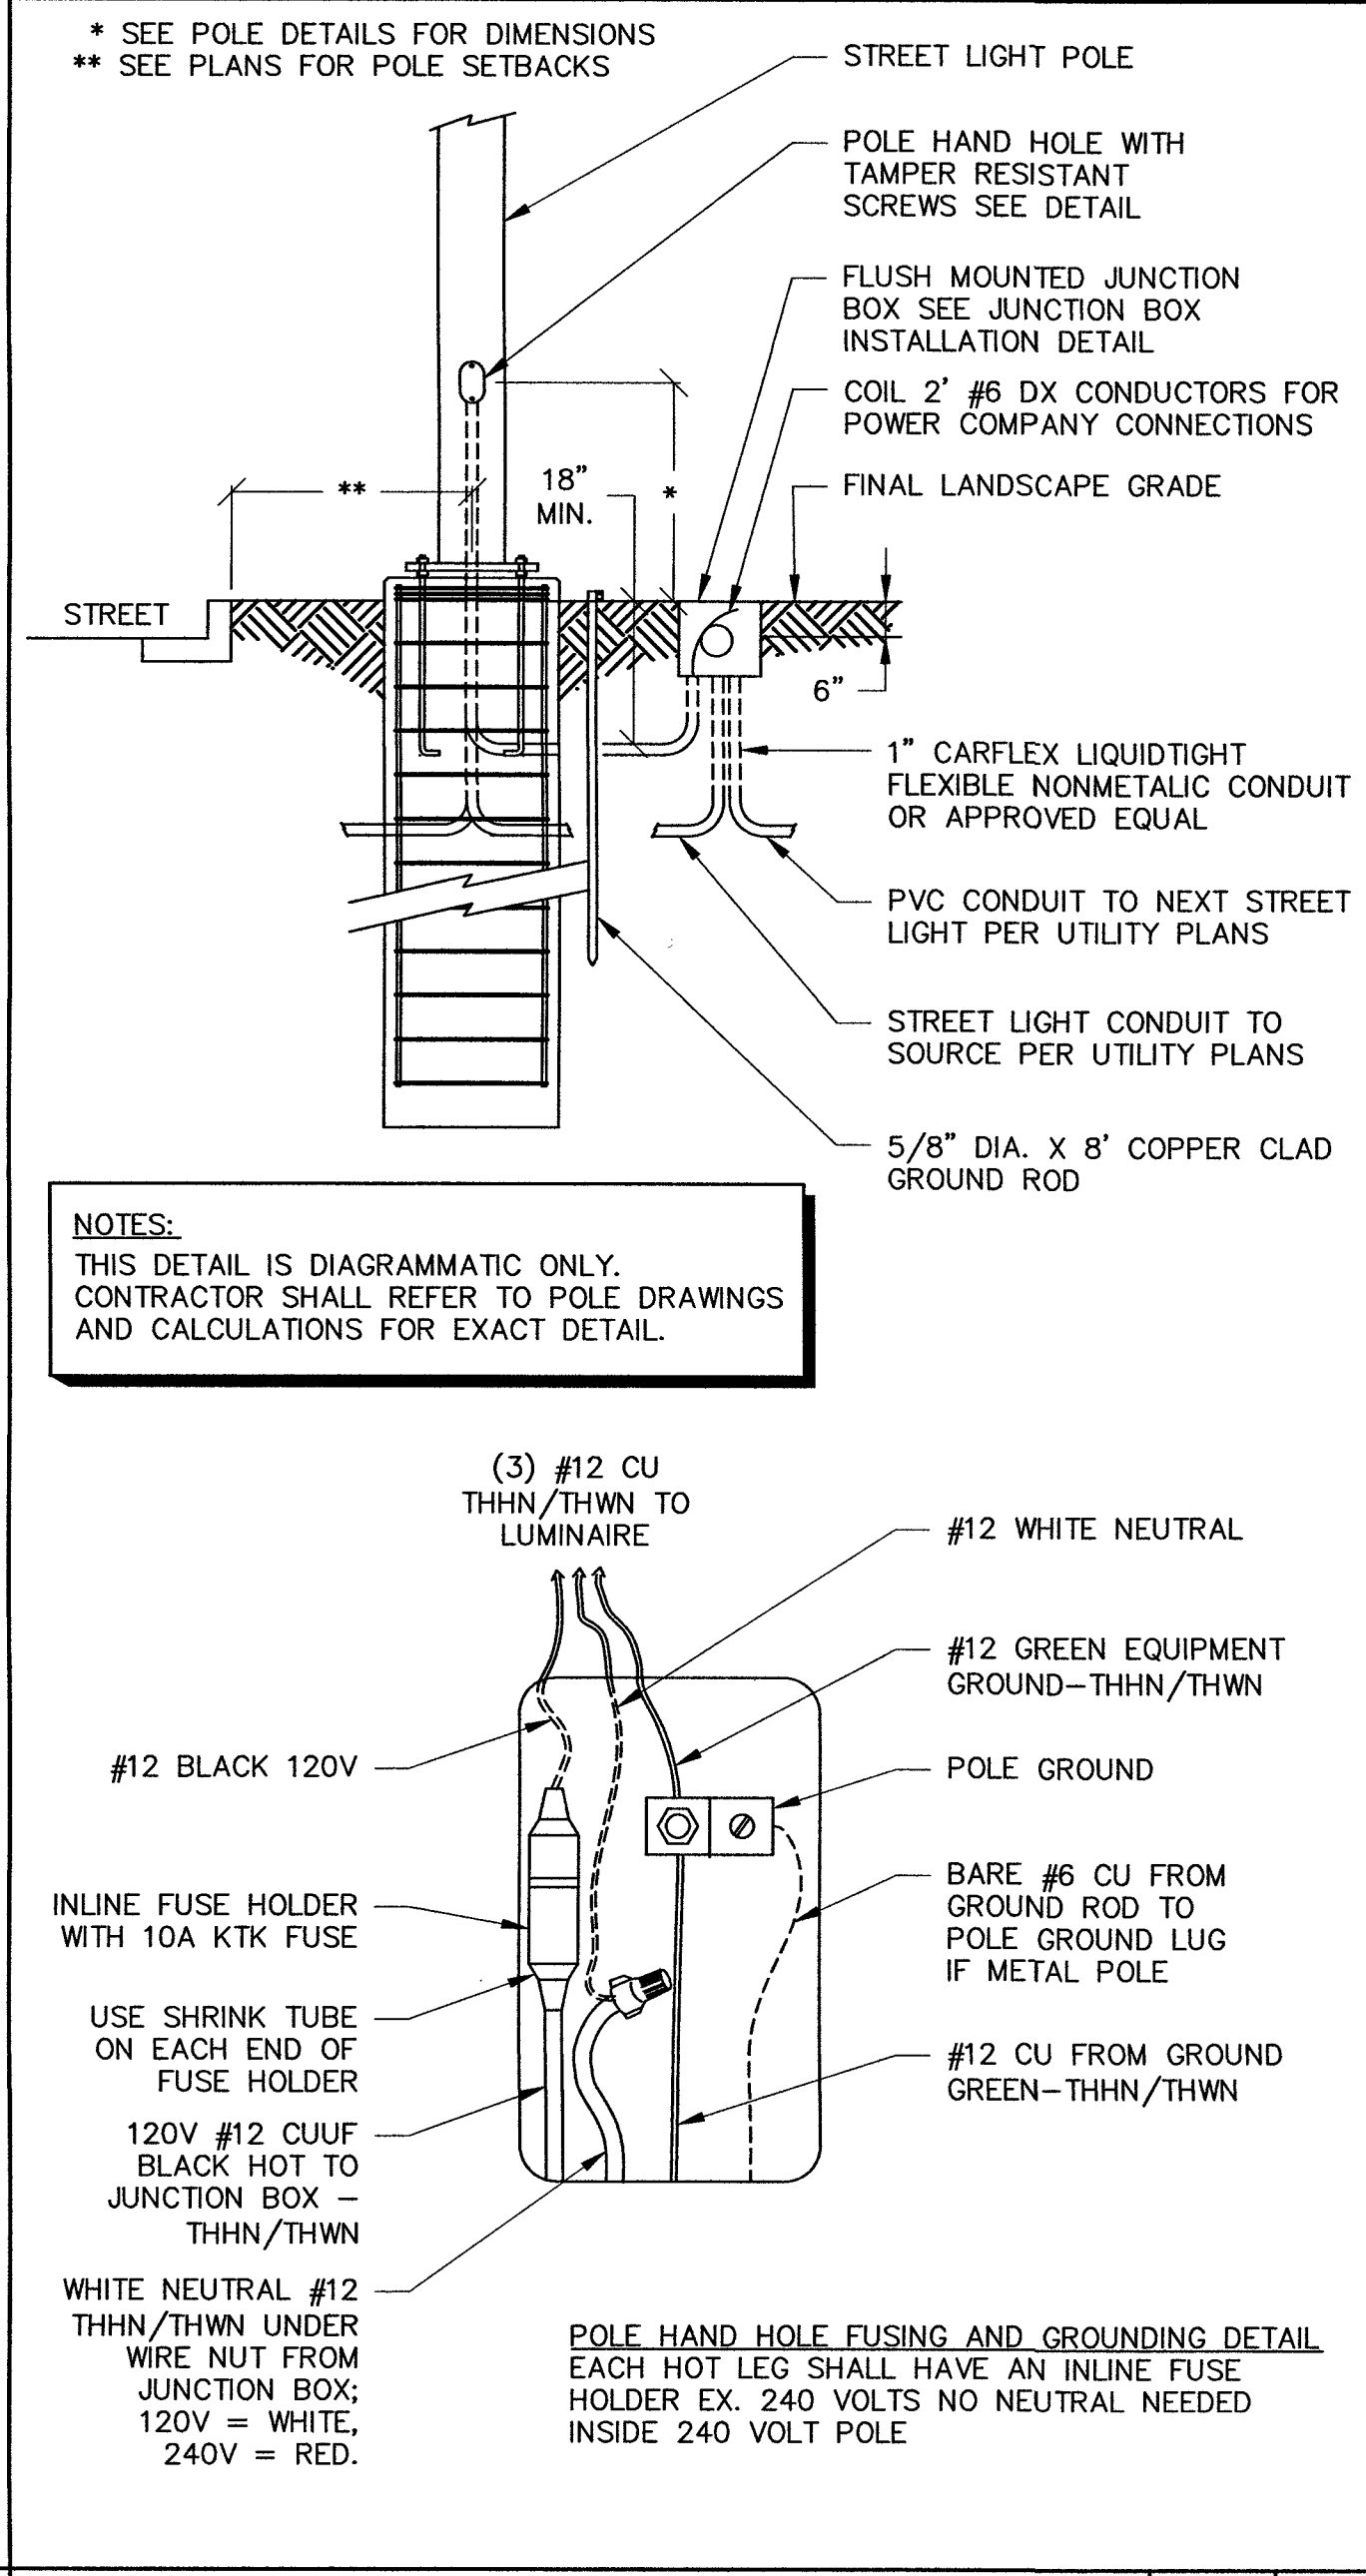

GROUNDING NOTES SCALE: NONE 5

GROUNDING LAYOUT SCALE: NONE 3

CROWN CASTLE NG WEST LLC
2055 SOUTH STEARMAN DRIVE
CHANDLER, ARIZONA 85286

PROJECT INFORMATION:

CROWN CASTLE ID # LV013

256 S PAVILION CENTER DR
LAS VEGAS, NEVADA 89144

CURRENT ISSUE DATE:

04/09/19

ISSUED FOR:

PROPOSED WORK

REV.: DATE: DESCRIPTION: BY:

2	04/04/19	POLE REVISION	D.C.
1	10/16/18	100% PERMITTING	C.P.
0	09/18/18	90% PERMITTING	R.S.

PLANS PREPARED BY:

LICENSURE:

DGS
CONSULTING ENGINEERING SERVICES LLC

SHEET TITLE:

GROUNDING LAYOUT, NOTES & DETAILS

SHEET NUMBER: REVISION:

E1	2
----	---