


61/51b 4/15/79
65-00259
L19-00259

Redlined Construction
Drawings

Theresa Sianez

Theresa Sianez
Spectrum Services

Date
11/13/19

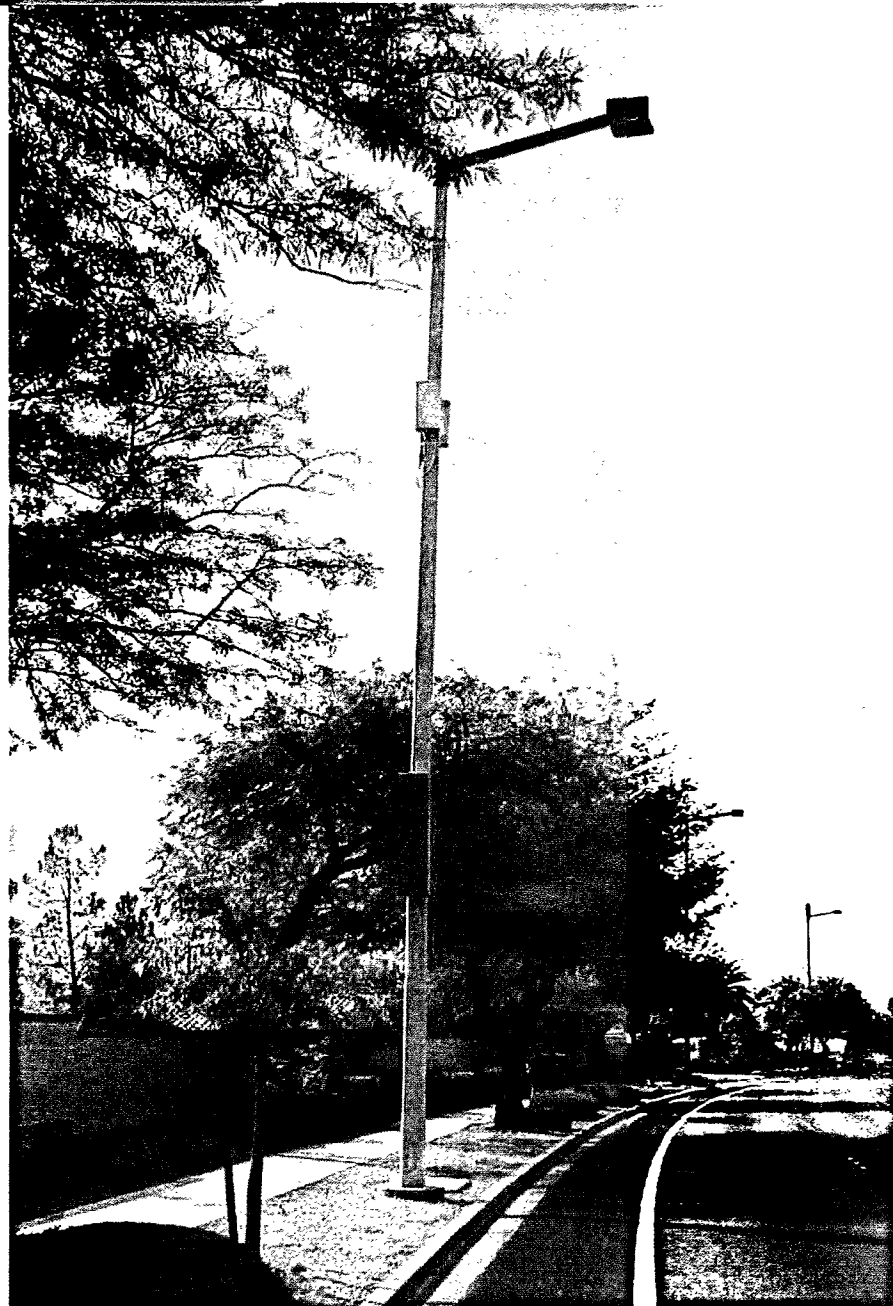

SITE PHOTO

1. THE FACILITY IS AN UNOCCUPIED SPECIALIZED MOBILE RADIO FACILITY.
2. PLANS ARE NOT TO BE SCALED AND ARE INTENDED TO BE A DIAGRAMMATIC OUTLINE ONLY, UNLESS NOTED OTHERWISE. THE WORK SHALL INCLUDE FURNISHING MATERIALS, EQUIPMENT, APPURTENANCES AND LABOR NECESSARY TO COMPLETE ALL INSTALLATIONS AS INDICATED ON THE DRAWINGS.
3. PRIOR TO THE SUBMISSION OF BIDS, THE CONTRACTORS SHALL VISIT THE JOB SITE AND BE RESPONSIBLE FOR ALL CONTRACT DOCUMENTS, FIELD CONDITIONS AND DIMENSIONS AND CONFIRMING THAT THE WORK MAY BE ACCOMPLISHED AS SHOWN PRIOR TO PROCEEDING WITH CONSTRUCTION. ANY DISCREPANCIES ARE TO BE BROUGHT TO THE ATTENTION OF THE PROJECT MANAGER.
4. THE CONTRACTOR SHALL RECEIVE IN WRITING, AUTHORIZATION TO PROCEED BEFORE STARTING WORK ON ANY ITEM NOT CLEARLY DEFINED OR IDENTIFIED BY THE CONTRACT DOCUMENTS.
5. THE CONTRACTOR SHALL INSTALL ALL EQUIPMENT AND MATERIALS IN ACCORDANCE WITH MANUFACTURER'S RECOMMENDATIONS UNLESS SPECIFICALLY OTHERWISE INDICATED OR WHERE LOCAL CODES, OR REGULATION TAKE PRECEDENCE.
6. ALL WORK PERFORMED AND MATERIALS INSTALLED SHALL BE IN STRICT ACCORDANCE WITH ALL APPLICABLE CODES, REGULATIONS AND ORDINANCES. CONTRACTOR SHALL GIVE ALL NOTICES AND COMPLY WITH ALL LAWS, ORDINANCES, RULES, REGULATIONS AND LAWS OF ANY PUBLIC AUTHORITY BEARING ON THE PERFORMANCE OF THE WORK. MECHANICAL AND ELECTRICAL SYSTEMS SHALL BE INSTALLED IN ACCORDANCE WITH ALL APPLICABLE MUNICIPAL AND UTILITY COMPANY SPECIFICATIONS, AND LOCAL AND STATE JURISDICTIONAL CODES, ORDINANCES AND APPLICABLE REGULATIONS.
7. THE GENERAL CONTRACTOR SHALL SUPERVISE AND DIRECT THE WORK, USING BEST SKILLS AND ATTENTION. THE CONTRACTOR SHALL BE SOLELY RESPONSIBLE FOR ALL CONSTRUCTION MEANS, METHODS, TECHNIQUES, SEQUENCES AND PROCEDURES AND FOR COORDINATING ALL PORTIONS OF THE WORK UNDER THE CONTRACT MANAGER AND WITH LANDLORD'S AUTHORIZED REPRESENTATIVE.
8. SEAL PENETRATIONS THROUGH FIRE RATED AREAS WITH U.L. LISTED AND FIRE CODE APPROVED MATERIALS.
9. PROVIDE A PORTABLE FIRE EXTINGUISHER WITH A RATING OF NOT LESS THAN 2-A OR 2-A10BC WITHIN 75 FEET TRAVEL DISTANCE TO ALL PORTIONS OF THE PROJECT AREA DURING CONSTRUCTION.
10. ALL CONSTRUCTION SHALL BE IN ACCORDANCE WITH CHAPTER 16 OF THE INTERNATIONAL BUILDING CODE REGARDING EARTHQUAKE PIPING. LIGHT FIXTURES, CEILING GRID, INTERIOR PARTITIONS AND MECHANICAL EQUIPMENT. ALL WORK MUST BE IN ACCORDANCE WITH LOCAL EARTHQUAKE CODES AND REGULATIONS.
11. THE CONTRACTOR SHALL VERIFY ALL DIMENSIONS AND CONDITIONS ON THE SITE AND NOTIFY THE PROJECT MANAGER OF ANY DISCREPANCIES BEFORE STARTING ANY WORK.
12. DETAILS ARE INTENDED TO SHOW END RESULT OF DESIGN. MINOR MODIFICATIONS MAY BE REQUIRED TO SUIT JOB DIMENSIONS OR CONDITIONS, AND SUCH MODIFICATIONS SHALL BE INCLUDED AS PART OF THE WORK.
13. THE CONTRACTOR SHALL MAKE NECESSARY PROMSIONS TO PROTECT EXISTING IMPROVEMENTS, PAVING, CURBS, GALVANIZED SURFACES, ETC., AND UPON COMPLETION OF WORK, REPAIR ANY DAMAGE THAT OCCURRED DURING CONSTRUCTION TO THE SATISFACTION OF THE PROJECT MANAGER.
14. KEEP GENERAL AREA CLEAN, HAZARD FREE, AND DISPOSE OF ALL DIRT, DEBRIS, RUBBISH AND REMOVE EQUIPMENT NOT SPECIFIED AS REMAINING ON THE PROPERTY. LEAVE PREMISES IN CLEAN CONDITION AND FREE FROM PAINT SPOTS, DUST, OR SMUDGES OF ANY NATURE.
15. CONTRACTOR TO PROVIDE COMPLETE SET OF AS BUILT DRAWINGS WITHIN 10 WORKING DAYS OF PROJECT COMPLETION.
16. CONTRACTOR IS TO SPRAY WITH EPA APPROVED WEED CONTROL PRIOR TO PLACING 4" AGGREGATE BASE GEOTECH FABRIC AND CRUSHED ROCK. TYPICAL INSIDE ENTIRE SITE.

PROJECT GENERAL NOTES

1. ELEVATIONS ARE NORTH AMERICAN VERTICAL DATUM 1988.
2. NO SURVEY PERFORMED; SITE MAPPING ONLY.
3. THE ENGINEER SPECTRUM SERVICES, INC. AND REPRESENTATIVES OF THE OWNER, MUST BE NOTIFIED AT LEAST TWO FULL DAYS PRIOR TO COMMENCEMENT OF CONSTRUCTION AT (702) 367-7705.
4. DO NOT EXCAVATE OR DISTURB BEYOND THE PROPERTY LINES OR LEASE LINES, UNLESS OTHERWISE NOTED.
5. DO NOT SCALE BUILDING DIMENSIONS FROM DRAWINGS.
6. ANY DRAIN AND/OR FIELD TILE ENCOUNTERED DURING CONSTRUCTION SHALL BE RETURNED TO ITS ORIGINAL CONDITION PRIOR TO COMPLETION OF WORK. SIZE, LOCATION AND TYPE OF ANY UNDERGROUND UTILITIES OR IMPROVEMENTS SHALL BE ACCURATELY NOTED AND PLACED ON AS-CONSTRUCTED DRAWINGS BY GENERAL CONTRACTOR AND ISSUED TO ARCHITECT/ENGINEER AT COMPLETION OF PROJECT.
7. ALL EXISTING UTILITIES, FACILITIES, CONDITIONS, AND THEIR DIMENSIONS SHOWN ON PLANS HAVE BEEN PLOTTED FROM AVAILABLE RECORDS. THE ARCHITECT/ENGINEER AND OWNER ASSUME NO RESPONSIBILITY WHATSOEVER AS TO THE SUFFICIENCY OR ACCURACY OF THE INFORMATION SHOWN ON THE PLANS OR THE MANNER OF THEIR REMOVAL OR ADJUSTMENT. CONTRACTOR SHALL BE RESPONSIBLE FOR DETERMINING EXACT LOCATION OF ALL EXISTING UTILITIES AND FACILITIES PRIOR TO START OF CONSTRUCTION. CONTRACTOR SHALL ALSO OBTAIN FROM EACH UTILITY COMPANY DETAILED INFORMATION RELATIVE TO WORKING SCHEDULES AND METHODS OF REMOVING OR ADJUSTING EXISTING UTILITIES.
8. CONTRACTOR SHALL VERIFY ALL EXISTING UTILITIES BOTH HORIZONTALLY AND VERTICALLY PRIOR TO START OF CONSTRUCTION. ANY DISCREPANCIES OR DOUBTS AS TO THE INTERPRETATION OF PLANS SHOULD BE IMMEDIATELY REPORTED TO THE ARCHITECT/ENGINEER FOR RESOLUTION AND INSTRUCTION, AND NO FURTHER WORK SHALL BE PERFORMED UNTIL THE DISCREPANCY IS CHECKED AND CORRECTED BY THE ARCHITECT/ENGINEER. FAILURE TO SECURE SUCH INSTRUCTION MEANS CONTRACTOR WILL HAVE WORKED AT HIS/HER OWN RISK AND EXPENSE. CONTRACTOR SHALL CALL LOCAL DIGGER HOT LINE FOR UTILITY LOCATIONS 48 HOURS PRIOR TO START OF CONSTRUCTION.
9. ALL NEW AND EXISTING UTILITY STRUCTURES ON SITE AND IN AREAS TO BE DISTURBED BY CONSTRUCTION SHALL BE ADJUSTED TO FINISH ELEVATIONS PRIOR TO FINAL INSPECTION OF WORK.
10. THE BUILDING DEPARTMENT ISSUING THE BUILDING PERMIT SHALL BE NOTIFIED AT LEAST TWO WORKING DAYS PRIOR TO THE COMMENCEMENT OF WORK OR AS STIPULATED BY THE CODE ENFORCEMENT OFFICIAL HAVING JURISDICTION.
11. GRADING OF THE SITE WORK AREA IS TO BE SMOOTH AND CONTINUOUS IN SLOPE AND IS TO FEATHER INTO EXISTING GRADES AT THE GRADING LIMITS.
12. ALL TEMPORARY EXCAVATIONS FOR THE INSTALLATION OF FOUNDATIONS, UTILITIES, ETC., SHALL BE PROPERLY LAID BACK OR BRACED IN ACCORDANCE WITH CORRECT OCCUPATIONAL SAFETY AND HEALTH ADMINISTRATION (OSHA) REQUIREMENTS.
13. STRUCTURAL FILLS SUPPORTING PAVEMENTS SHALL BE COMPACTED TO 100% OF MAXIMUM STANDARD PROCTOR DRY DENSITY.
14. NEW GRADES NOT IN BUILDING AND DRIVEWAY IMPROVEMENT AREA TO BE ACHIEVED BY FILLING WITH APPROVED CLEAN FILL AND COMPACTED TO 95% OF STANDARD PROCTOR DENSITY.
15. ALL FILL SHALL BE PLACED IN UNIFORM LIFTS. THE LIFTS THICKNESS SHOULD NOT EXCEED THAT WHICH CAN BE PROPERLY COMPACTED THROUGHOUT ITS ENTIRE DEPTH WITH THE EQUIPMENT AVAILABLE.
16. ANY FILLS PLACED ON EXISTING SLOPES THAT ARE STEEPER THAN 10 HORIZONTAL TO 1 VERTICAL SHALL BE PROPERLY BENCHED INTO THE EXISTING SLOPE AS DIRECTED BY A GEOTECHNICAL ENGINEER.
17. THE GRADES WITHIN THE FENCED IN AREA ARE TO BE ACHIEVED BY COMPACTING CLEAN FILL TO A DENSITY OF 90% OF STANDARD PROCTOR AND REPAVING WITH ASPHALT CONCRETE TO MATCH EXISTING.
18. CONTRACTOR SHALL CLEAN ENTIRE SITE AFTER CONSTRUCTION SUCH THAT NO PAPERS, TRASH, WEEDS, BRUSH OR ANY OTHER DEPOSITS WILL REMAIN. ALL MATERIALS COLLECTED DURING CLEANING OPERATIONS SHALL BE DISPOSED OF OFF-SITE BY THE GENERAL CONTRACTOR.
19. DRIVEWAY CONSTRUCTION, GRADING AND DRAINAGE WORK SHALL CONFORM TO NEVADA DEPARTMENT OF TRANSPORTATION "STANDARD SPECIFICATION FOR THE ROAD AND BRIDGE CONSTRUCTION", LATEST EDITIONS, AND ALL APPLICABLE PROVISIONS OR LOCAL COUNTY ORDINANCES.
20. ALL SITE WORK SHALL BE CAREFULLY COORDINATED BY GENERAL CONTRACTOR WITH LOCAL UTILITY COMPANY, TELEPHONE COMPANY, AND ANY OTHER UTILITY COMPANIES HAVING JURISDICTION OVER THIS LOCATION.
21. SPECIAL INSPECTION:
SPECIAL INSPECTIONS ARE REQUIRED FOR HIGH STRENGTH BOLTING BY THIRD PARTY INSPECTOR.
22. CONCRETE: IF THE CONCRETE MIX ACHIEVES ITS DESIGN STRENGTH PRIOR TO 28 DAY BREAK TEST, IT IS ACCEPTABLE FOR FINAL REPORT.
23. COMPRESSIVE STRENGTH TEST SPECIMENS WITH DIMENSIONS OF 4" X 8" MAY BE USED.

CONSTRUCTION NOTES



CROWN CASTLE NG WEST LLC
2055 SOUTH STEARMAN DRIVE
CHANDLER, ARIZONA 85286

PROJECT INFORMATION:

CROWN CASTLE ID #
LV013

256 S PAVILION CENTER DR
LAS VEGAS, NEVADA 89144

CURRENT ISSUE DATE:

04/09/19

ISSUED FOR:

PROPOSED WORK

REV.: DATE: DESCRIPTION: BY:


2	04/04/19	POLE REVISION	D.C.
1	10/16/18	100% PERMITTING	C.P.
0	09/18/18	90% PERMITTING	R.S.

PLANS PREPARED BY:



SPECTRUM SERVICES, INC.
4850 WEST OQUENDO ROAD
LAS VEGAS, NEVADA 89118
PHONE: (702) 367-7705
FAX: (702) 367-8733

LICENSURE:

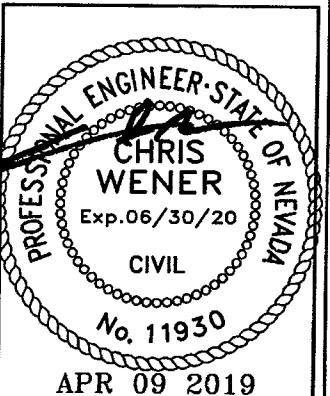

SHEET TITLE:

SITE PHOTO, GENERAL &
CONSTRUCTION NOTES

SHEET NUMBER: REVISION:


C2 2

Redlined Construction
Drawings


Theresa Sianez

Theresa Sianez
Spectrum Services

Date
11/13/19

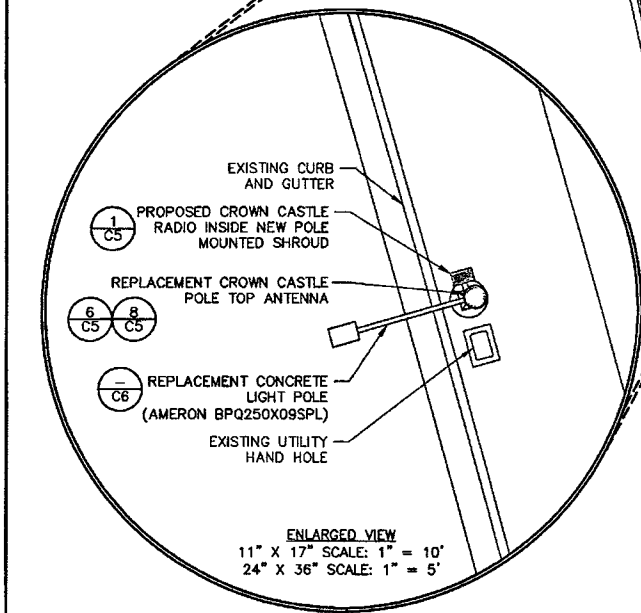

SITE PLAN

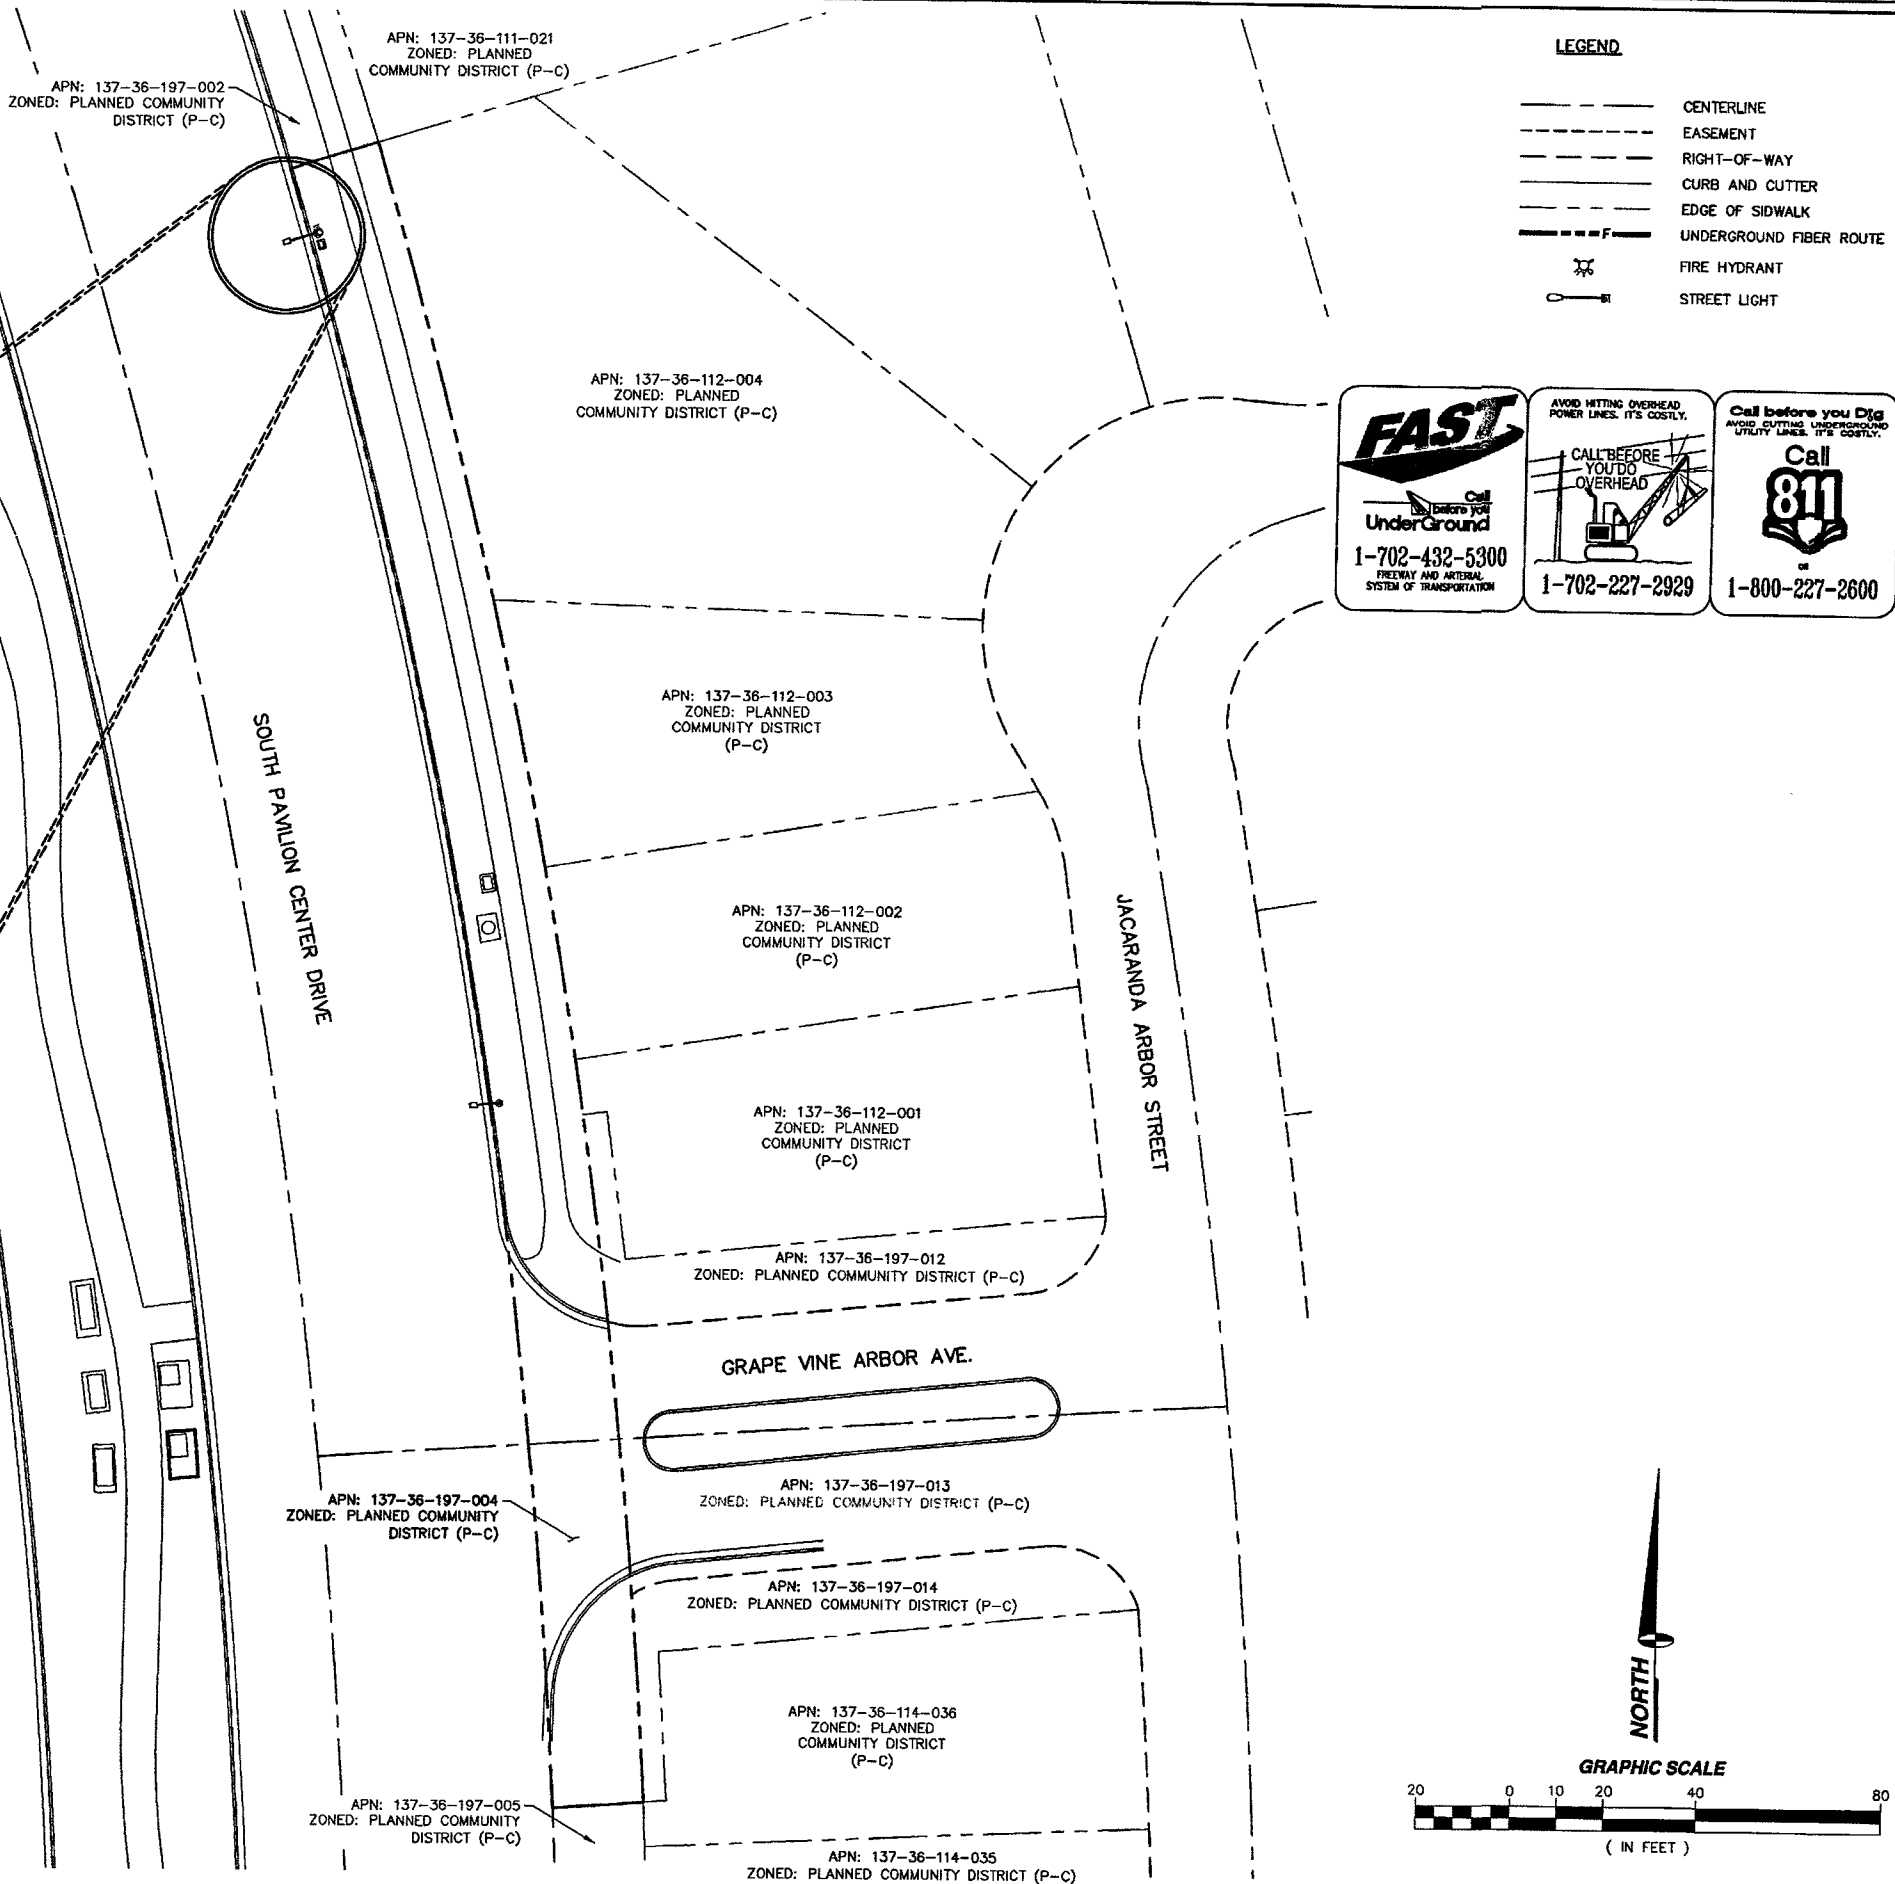

CROWN CASTLE

CROWN CASTLE NG WEST LLC
2055 SOUTH STEARMAN DRIVE
CHANDLER, ARIZONA 85286

PROJECT INFORMATION:

CROWN CASTLE ID #
LV013

256 S PAVILION CENTER DR
LAS VEGAS, NEVADA 89144

CURRENT ISSUE DATE:

04/09/19

ISSUED FOR:

PROPOSED WORK

REV.: DATE: DESCRIPTION: BY:

2	04/04/19	POLE REVISION	D.C.
1	10/16/18	100% PERMITTING	C.P.
0	09/18/18	90% PERMITTING	R.S.

PLANS PREPARED BY:

SPECTRUM SERVICES, INC.
4850 WEST OQUENDO ROAD
LAS VEGAS, NEVADA 89118
PHONE: (702) 367-7705
FAX: (702) 367-8733

LICENSURE:

SHEET TITLE:

SITE PLAN

SHEET NUMBER: REVISION:



C3 2

Redlined Construction Drawings

Theresa Sianez

Theresa Sianez
Spectrum Services

Date
11/13/19

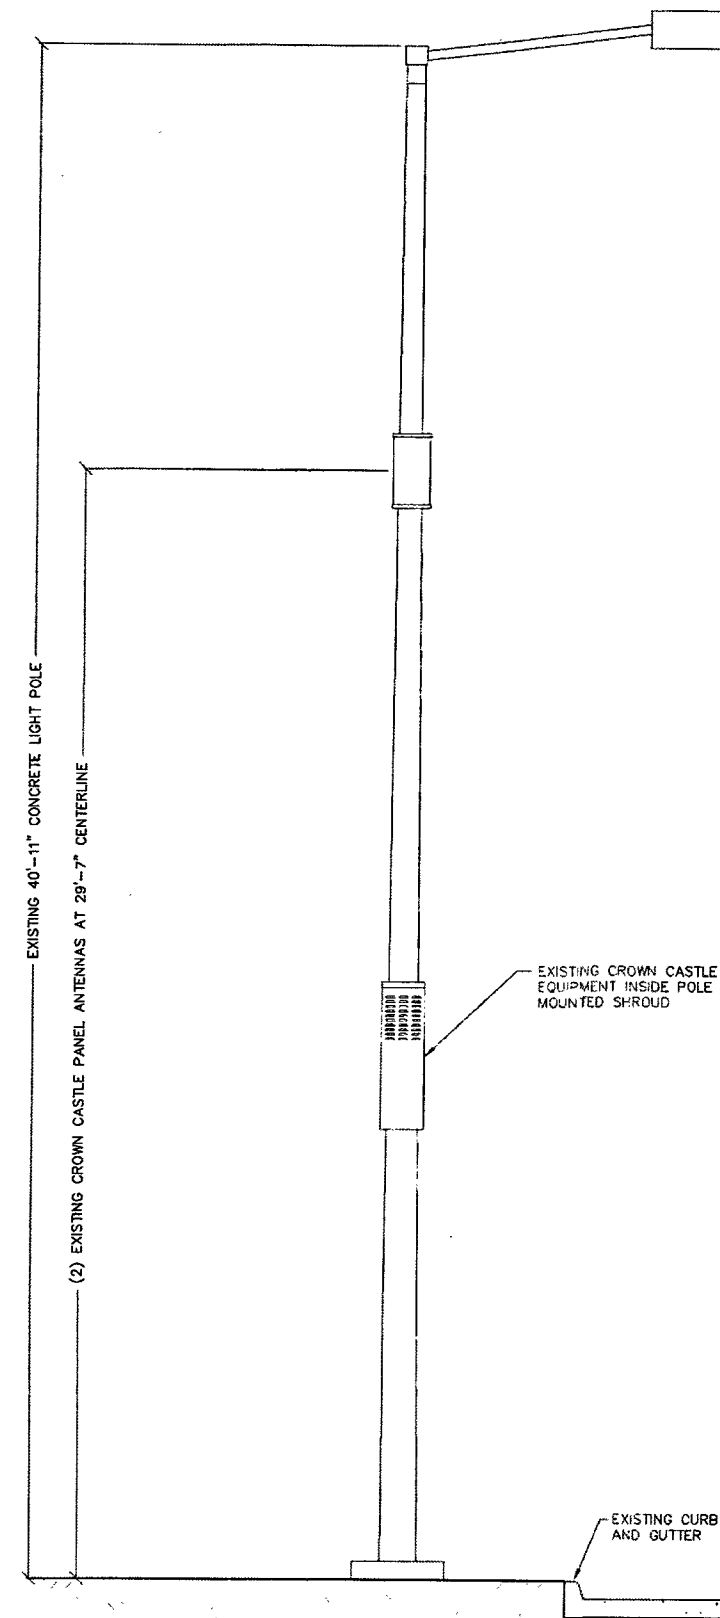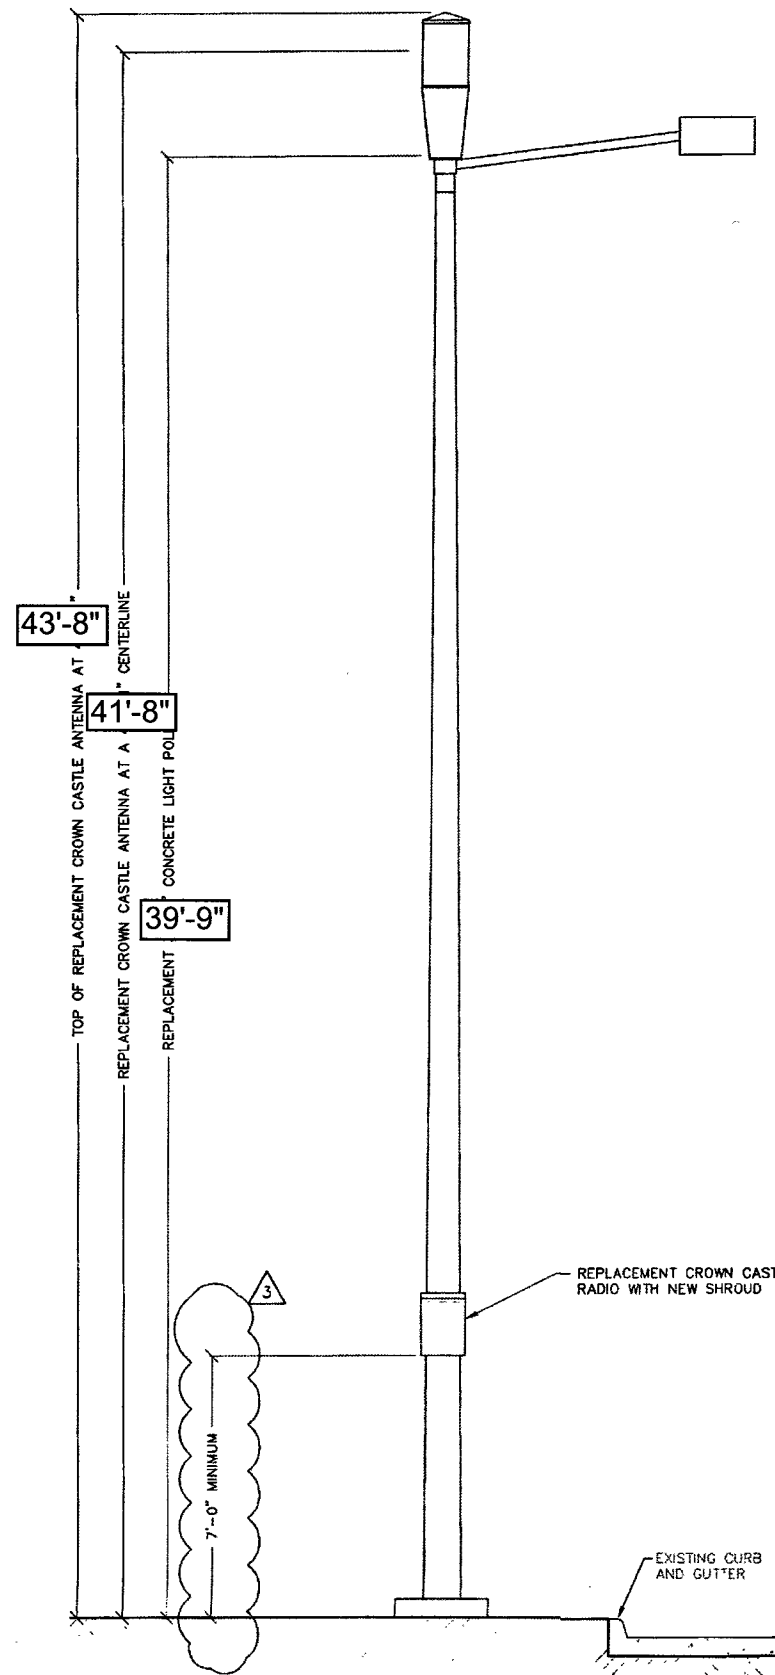

CROWN CASTLE

CROWN CASTLE NG WEST LLC
2055 SOUTH STEARMAN DRIVE
CHANDLER, ARIZONA 85286

PROJECT INFORMATION:

CROWN CASTLE ID #
LV013

256 S PAVILION CENTER DR
LAS VEGAS, NEVADA 89144

CURRENT ISSUE DATE:

04/09/19

ISSUED FOR:

PROPOSED WORK

REV.: DATE: DESCRIPTION: BY:

3	04/09/19	LAND DEV. COMMENTS	R.S.
2	04/04/19	POLE REVISION	D.C.
1	10/16/18	100% PERMITTING	C.P.
0	09/18/18	90% PERMITTING	R.S.

PLANS PREPARED BY:

SPECTRUM SERVICES, INC.
4850 WEST OQUENDO ROAD
LAS VEGAS, NEVADA 89118
PHONE: (702) 367-7705
FAX: (702) 367-8733

LICENSURE:

SHEET TITLE:

EXISTING AND PROPOSED
NORTHWEST ELEVATION

SHEET NUMBER: REVISION:


C4 3

PROPOSED NORTHWEST ELEVATION

11" X 17" SCALE 24" X 36" SCALE
1" = 5' 1" = 2'-6"

EXISTING NORTHWEST ELEVATION

11" X 17" SCALE 24" X 36" SCALE
1" = 5' 1" = 2'-6"

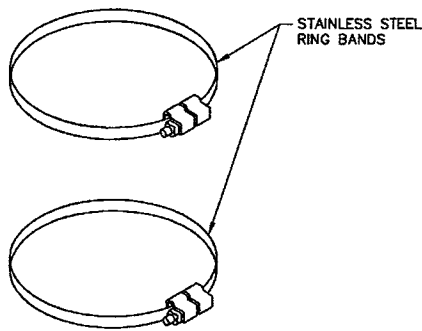






AMPHENOL 2C2U3MT380X06FY20 ANTENNA SPECIFICATIONS
INPUT CONNECTOR (2X) 4.3/10 OR 7/16-DIN / FEMALE / BOTTOM
DIMENSION (H x DIA.) 24.0 x 14.6 IN.
ANTENNA WEIGHT 22.1 LBS
LIGHTNING PROTECTION DIRECT GROUND

WIND SURVIVAL SPEED
241 KM/HR - 150 MPH

WIND LOAD @ 100 MPH (160 KM/HR)
191 N - 43 LBF



#4" & 6" Q BCD FOR
3/8"-16 UNC MOUNTING
STUDS (X6) AT 120°
APART THEY EXTEND 1
1/4" BELOW PLATE FOR
MOUNTING

NOTES:
1. CONNECTOR HOLES ARE 2" FROM CENTER TO CENTER
APART IN EACH SECTOR

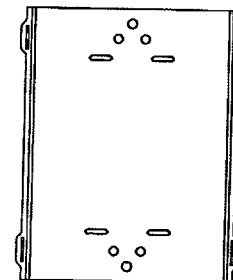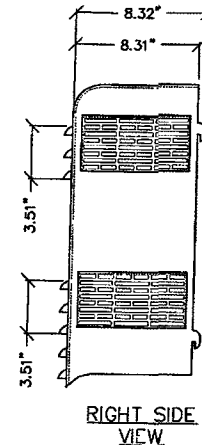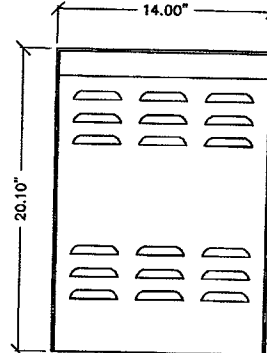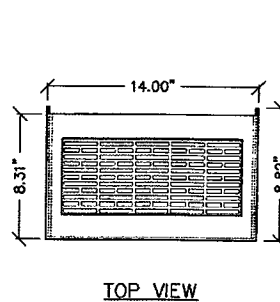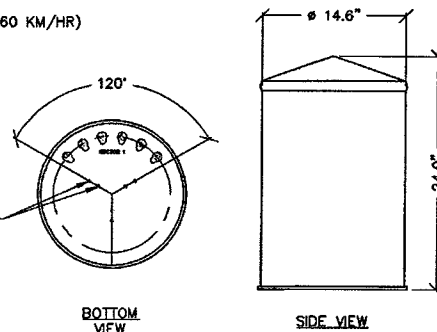


STAINLESS STEEL RING BAND


SCALE: NONE 9

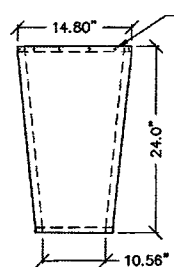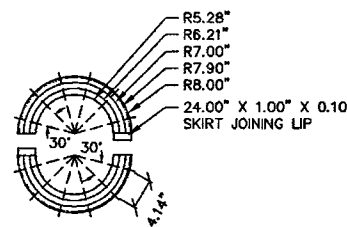

FOAM SKIRT

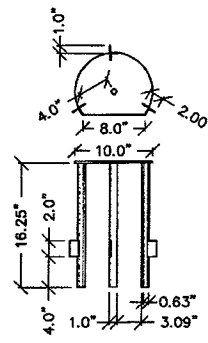

STREET LIGHT
POLE INSERT

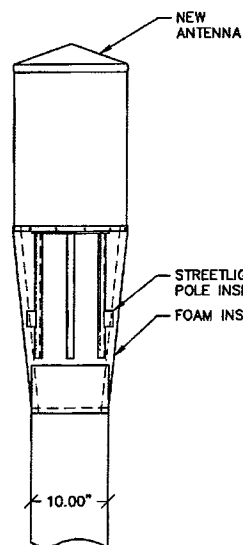


ASSEMBLY

ANTENNA SHROUD

SCALE: NONE 8


ANTENNA DETAIL

SCALE: NONE 7

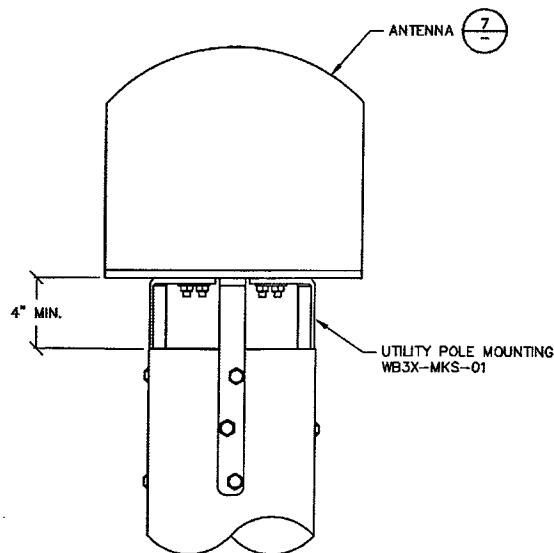

ANTENNA MOUNTING DETAIL

SCALE: NONE 6

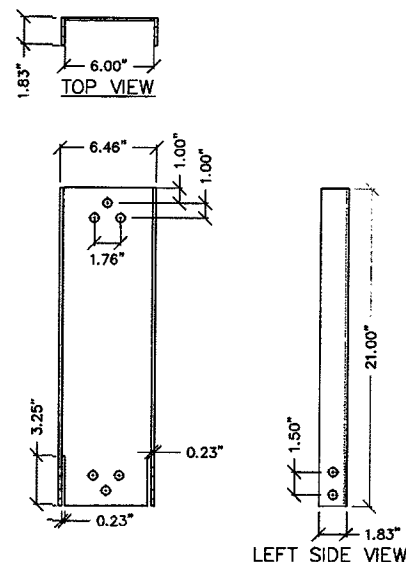


NOKIA 20W RADIO MOUNTING CHANNEL

SCALE: NONE 5


RADIO SHROUD

SCALE: NONE 2

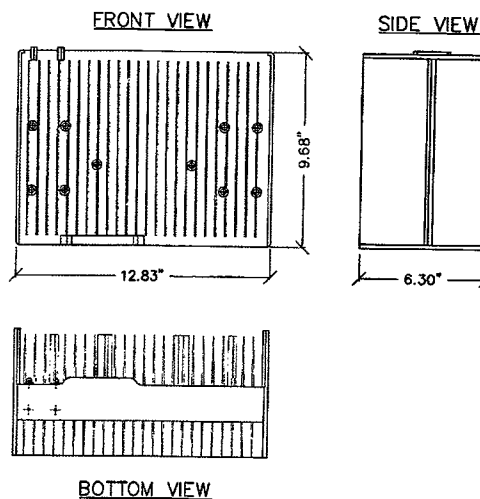

NOKIA 20W RADIO

SCALE: NONE 4

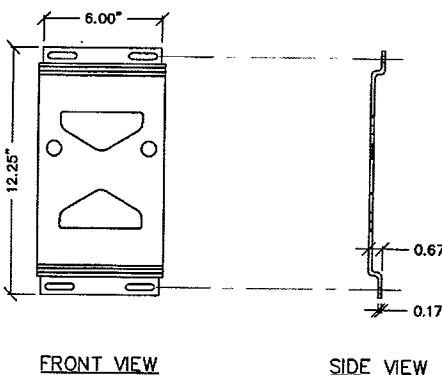

NOKIA 20W RADIO BRACKET


SCALE: NONE 3

Redlined Construction
Drawings

Theresa Sianez

Theresa Sianez
Spectrum Services

Date
11/13/19

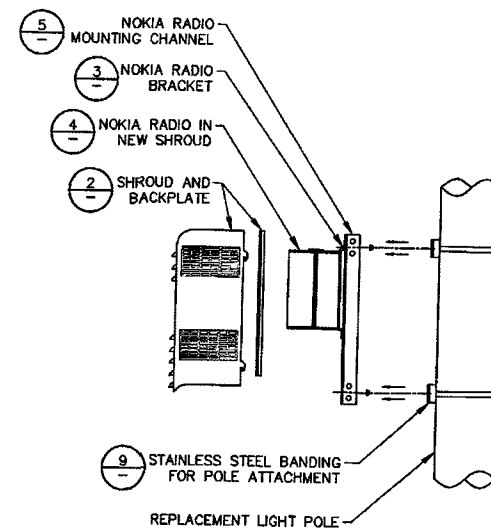

SHROUD ASSEMBLY

SCALE: NONE 1

CROWN
CASTLE

CROWN CASTLE NG WEST LLC
2055 SOUTH STEARMAN DRIVE
CHANDLER, ARIZONA 85286

PROJECT INFORMATION:

CROWN CASTLE ID #
LV013

256 S PAVILION CENTER DR
LAS VEGAS, NEVADA 89144

CURRENT ISSUE DATE:

04/09/19

ISSUED FOR:

PROPOSED WORK

REV.: DATE: DESCRIPTION: BY:


2	04/04/19	POLE REVISION	D.C.
1	10/16/18	100% PERMITTING	C.P.
0	09/18/18	90% PERMITTING	R.S.

PLANS PREPARED BY:

SPECTRUM

SPECTRUM SERVICES, INC.
4850 WEST OQUENDO ROAD
LAS VEGAS, NEVADA 89118
PHONE: (702) 367-7705
FAX: (702) 367-8733

LICENSURE:

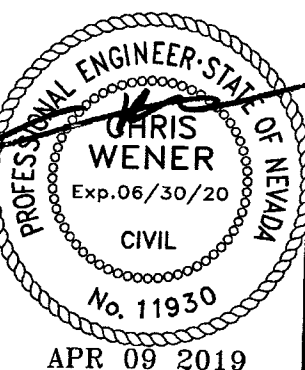

SHEET TITLE:

CONSTRUCTION DETAILS

SHEET NUMBER: REVISION:

C5 2



CROWN CASTLE NG WEST LLC
2055 SOUTH STEARMAN DRIVE
CHANDLER, ARIZONA 85286

PROJECT INFORMATION:

CROWN CASTLE ID #
LV013

256 S PAVILION CENTER DR
LAS VEGAS, NEVADA 89144

CURRENT ISSUE DATE:

04/09/19

ISSUED FOR:

PROPOSED WORK

REV: DATE: DESCRIPTION: BY:


REV	DATE	DESCRIPTION	BY
3	04/09/19	LAND DEV. COMMENTS	R.S.
2	04/04/19	POLE REVISION	D.C.
1	10/16/18	100% PERMITTING	C.P.
0	09/18/18	90% PERMITTING	R.S.

PLANS PREPARED BY:



SPECTRUM SERVICES, INC.
4850 WEST OQUENDO ROAD
LAS VEGAS, NEVADA 89118
PHONE: (702) 367-7705
FAX: (702) 367-8733

LICENSURE:

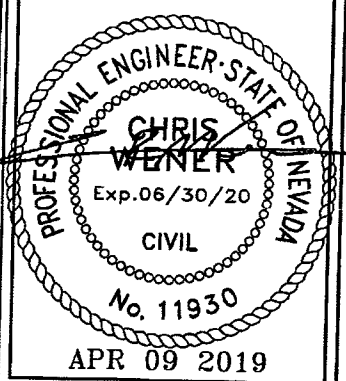

SHEET TITLE:

CONCRETE FOUNDATION
DETAILS

SHEET NUMBER:

C6

REVISION:

3

Redlined Construction
Drawings


Theresa Sianez

Theresa Sianez
Spectrum Services

Date

11/13/19



*SEE STRUCTURALS AND AMERON
DRAWINGS FOR ADDITIONAL INFORMATION

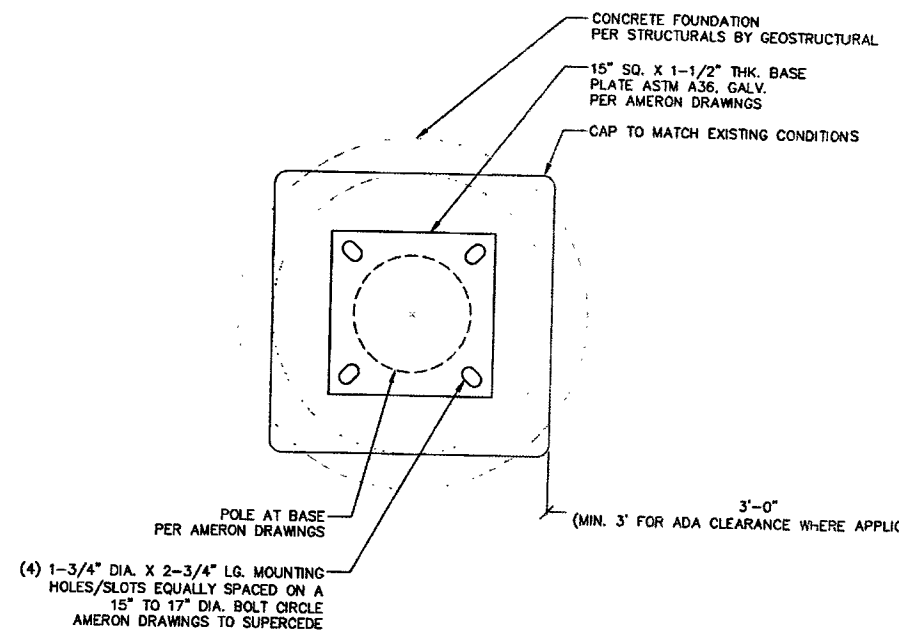

EXISTING TOP BACK OF CURB
(T.B.C.)
EXISTING FLOW LINE
EXISTING GUTTER

NOTES:

1. CONCRETE SHALL HAVE A MINIMUM 28-DAY COMPRESSIVE STRENGTH OF 4500 PSI, IN ACCORDANCE WITH ACI 318-11. BASE PLATE GROUT STRENGTH AT 8000 PSI.
2. USE TYPE V PORTLAND CEMENT AND A MAXIMUM WATER-CEMENT RATIO OF 0.45.
3. REBAR TO CONFORM TO ASTM SPECIFICATION A615 GRADE 60.
4. ALL REBAR TO HAVE A MINIMUM OF 3" CONCRETE COVER.
5. ALL EXPOSED CONCRETE CORNERS TO BE CHAMFERED 3/4".
6. SEE THE GEOTECHNICAL REPORT FOR DRILLED PIER INSTALLATION REQUIREMENTS, IF SPECIFIED.
7. ANCHOR RODS ARE TO BE (4) 1-1/2" DIAMETER ASTM F1554 GRADE 55 ON A 16"-1/2" DIAMETER BOLT CIRCLE. MINIMUM LENGTH OF ANCHOR RODS IS 48", WITH A MAXIMUM PROJECTION OF 5" ABOVE CONCRETE. AMERON DRAWINGS TO SUPERCEDE THIS NOTE.

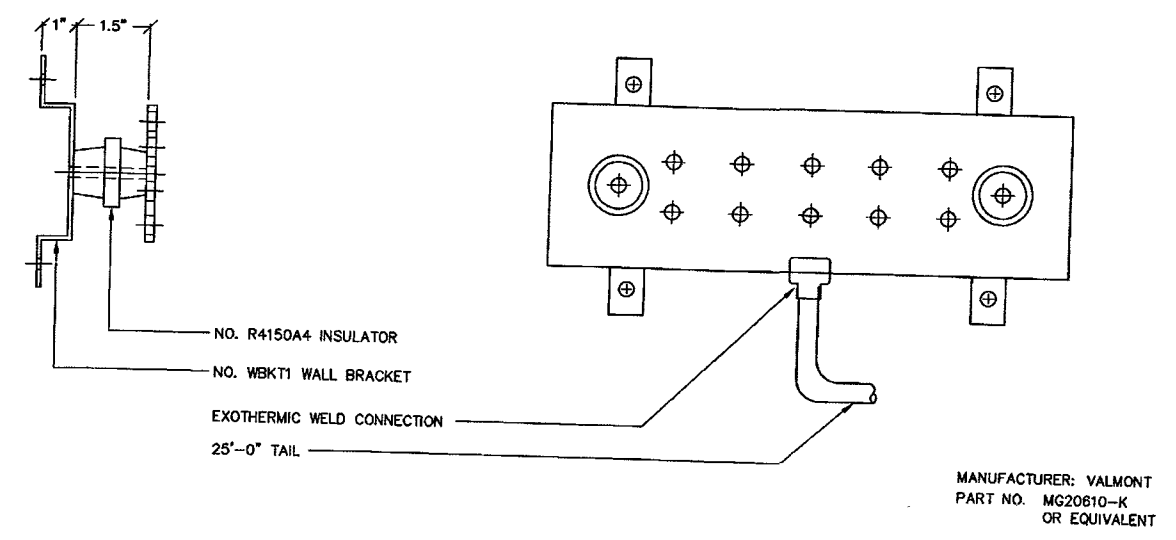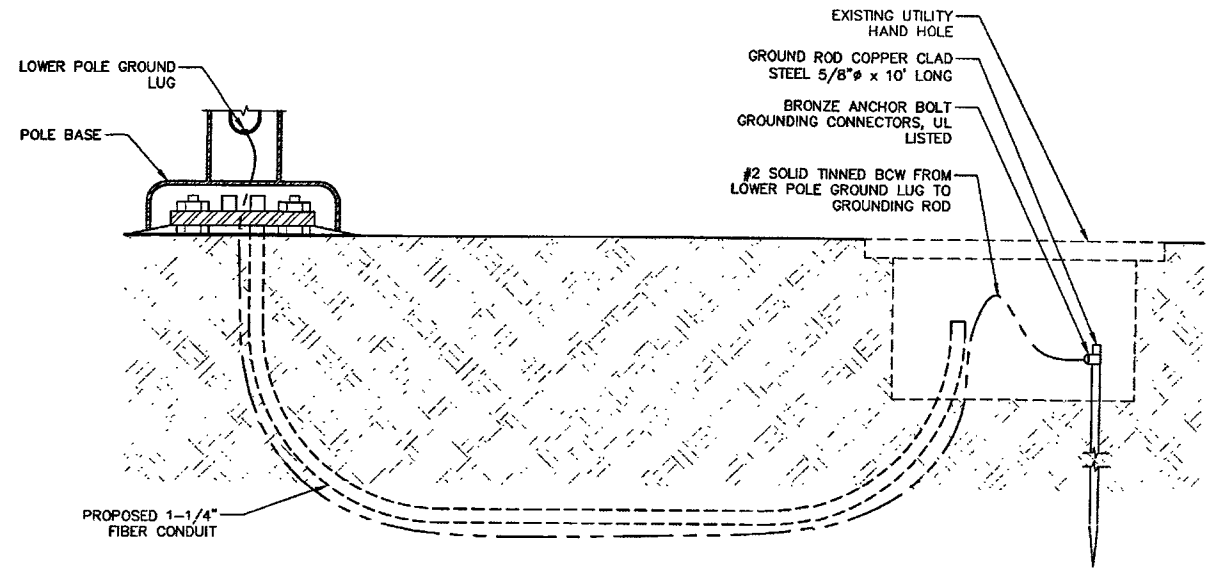


GROUND ROD

SCALE: NONE 4


GROUND BAR

SCALE: NONE 2

1. ALL DETAILS ARE SHOWN IN GENERAL TERMS. ACTUAL GROUNDING INSTALLATION REQUIREMENTS AND CONSTRUCTION ACCORDING TO SITE CONDITIONS AND CARRIER GROUNDING STANDARD, LATEST REVISION.
2. ALL GROUNDING CONDUCTORS: #2 AWG SOLID BARE TINNED COPPER WIRE UNLESS OTHERWISE NOTED.
3. GROUND RING TO GROUND BAR CONNECTIONS SHALL BE CADWELED QTY. (2) #2 AWG SOLID BARE TINNED COPPER WIRE UNLESS OTHERWISE NOTED.
4. GROUND BAR TO EQUIPMENT AND CABLES SHALL BE #2 AWG BTCW W/ DOUBLE LUG CONNECTIONS.
5. GROUND BAR LOCATED IN BASE OF EQUIPMENT WILL BE PROVIDED, FURNISHED AND INSTALLED BY THE VENDOR.
6. GROUND BAR LOCATED BELOW WAVEGUIDE ENTRY PORT. CABLES SHALL BE #2 AWG BTCW/DOUBLE LUG CONNECTIONS. TWO PATHS TO GROUND RING.
7. ALL BELOW GRADE CONNECTIONS: EXOTHERMIC WELD TYPE, ABOVE GRADE CONNECTIONS: EXOTHERMIC WELD TYPE.
8. EXTERIOR GROUNDING CONDUCTORS: BURIED TO A MINIMUM DEPTH OF 1'-6\"
9. INSTALL GROUND CONDUCTORS AND GROUND ROD MINIMUM OF 1'-0\"
10. EXOTHERMIC WELD GROUND CONNECTION TO FENCE POST: TREAT WITH A COLD GALVANIZED SPRAY.
11. GROUND BARS:
EQUIPMENT GROUND BUSS BAR (EGB) LOCATED AT BOTTOM OF ANTENNA POLE/MAST FOR MAKING GROUNDING JUMPER CONNECTIONS TO COAX FEEDER CABLES SHALL BE FURNISHED AND INSTALLED BY ELECTRICAL CONTRACTOR. JUMPERS (FURNISHED BY OWNERS) SHALL BE INSTALLED AND CONNECTED BY ELECTRICAL CONTRACTOR.
MAIN GROUND BUSS BAR (MGB) LOCATED NEAR THE BASE OF THE RADIO EQUIPMENT CABINET(S) SHALL BE FURNISHED AND INSTALLED BY ELECTRICAL CONTRACTOR.
12. ALL GROUNDING INSTALLATIONS AND CONNECTIONS SHALL BE MADE BY ELECTRICAL CONTRACTOR.
13. ALL BOLTED TORQUE CONNECTORS SHALL BE LONG-BARRELED TYPES AND HAVE TWO HOLES FOR CONNECTION TO SURFACE AND NON-OXIDIZING AGENT APPLIED TO INHIBIT CORROSION.

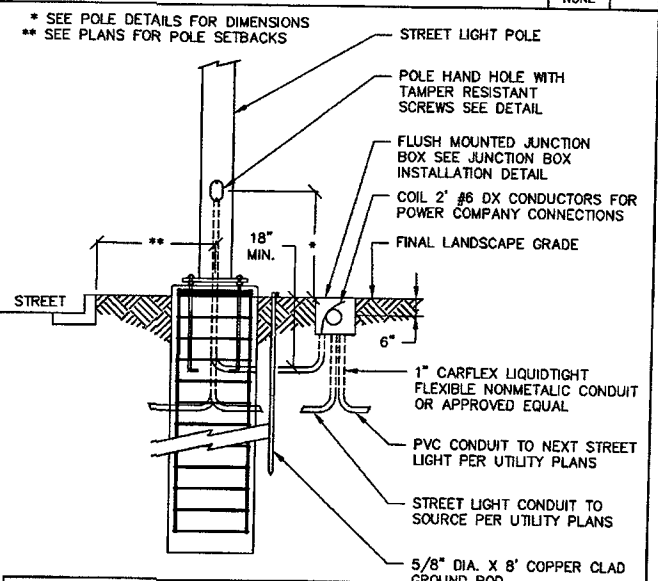

NOTES:
THIS DETAIL IS DIAGRAMMATIC ONLY.
CONTRACTOR SHALL REFER TO POLE DRAWINGS AND CALCULATIONS FOR EXACT DETAIL.

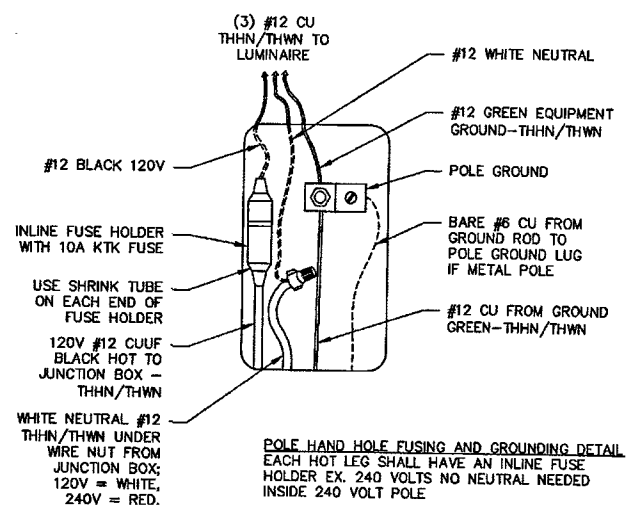


POLE HAND HOLE FUSING AND GROUNDING DETAIL
EACH HOT LEG SHALL HAVE AN INLINE FUSE HOLDER EX. 240 VOLTS NO NEUTRAL NEEDED INSIDE 240 VOLT POLE

- NOTE:
1. ALL GROUNDING TO BE INSTALLED IN ACCORDANCE WITH VERIZON WIRELESS STANDARD NSTD 46
 2. CONTRACTOR TO MODIFY OR ADD NECESSARY GROUNDING TO PROVIDE A MAX. RESISTANCE OF 5 OHMS

Redlined Construction Drawings

Theresa Sianez

Theresa Sianez Date 11/13/19
Spectrum Services

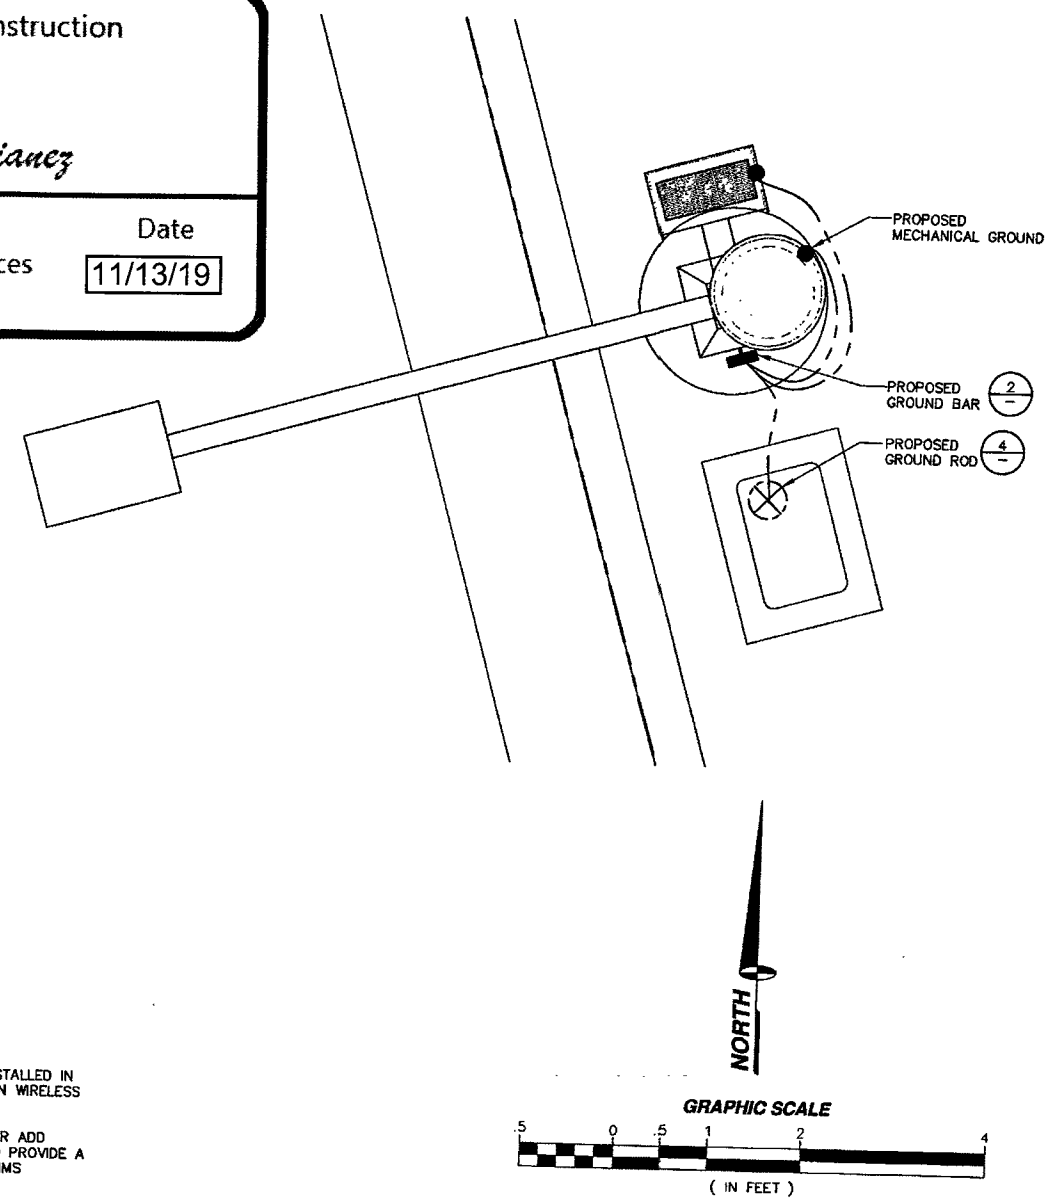

GROUNDING NOTES

SCALE: NONE 5

STREET LIGHT WIRING AND GROUNDING

SCALE: NONE 3

GROUNDING LAYOUT

11" X 17" SCALE 24" X 36" SCALE
1" = 2' 1" = 1'



CROWN CASTLE NG WEST LLC
2055 SOUTH STEARMAN DRIVE
CHANDLER, ARIZONA 85286

PROJECT INFORMATION:

CROWN CASTLE ID # LV013

256 S PAVILION CENTER DR
LAS VEGAS, NEVADA 89144

CURRENT ISSUE DATE:

04/09/19

ISSUED FOR:

PROPOSED WORK

REV.: DATE: DESCRIPTION: BY:


2	04/04/19	POLE REVISION	D.C.
1	10/16/18	100% PERMITTING	C.P.
0	09/18/18	90% PERMITTING	R.S.

PLANS PREPARED BY:



DGS
CONSULTING ENGINEERING SERVICES LLC

LICENSURE:

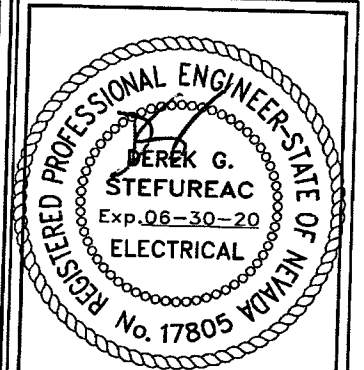

APR 09 2019

SHEET TITLE:

GROUNDING LAYOUT, NOTES & DETAILS

SHEET NUMBER:

E1

REVISION:

2