


LAST PLOT: Mont Brule
FILE NAME: S:\CTT\ADAVEN HOMES\ADV-18-108 - ALPINE RIDGE & 215 BELTWAY\DWG\SS\18-108_SHT_G_1Z.DWG

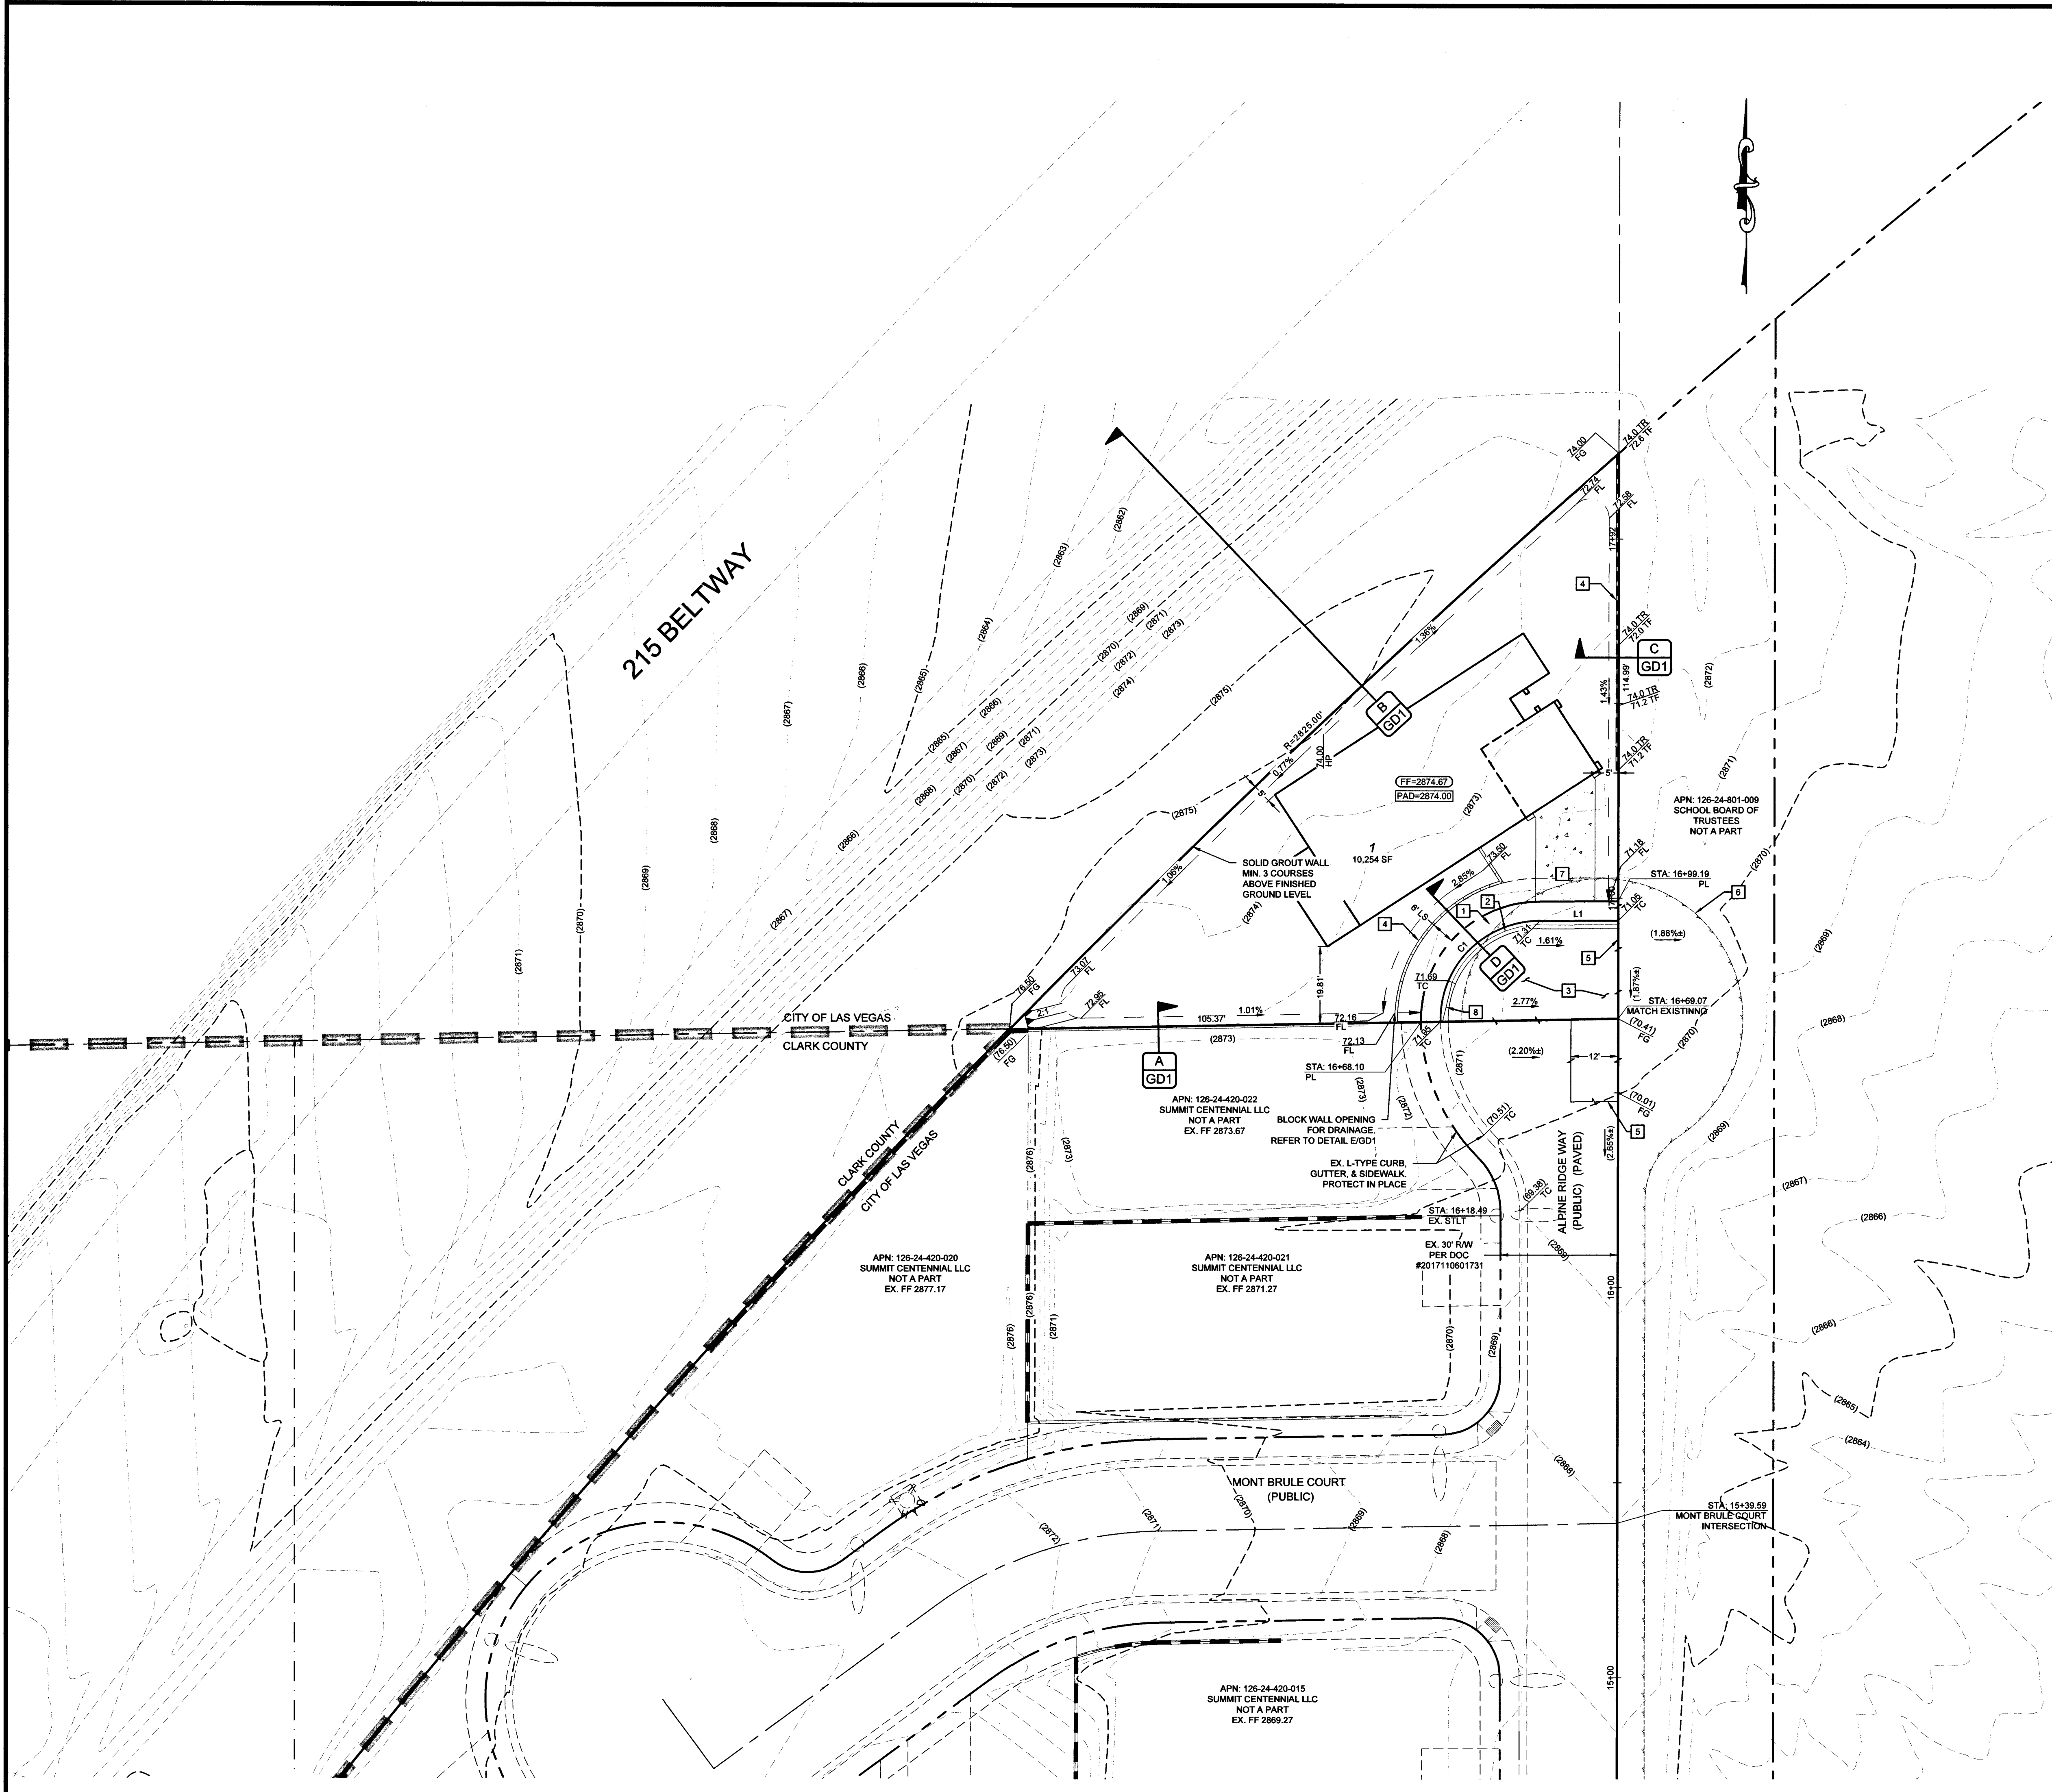

Avoid overhead power line contact. It's costly.

Call before you Overhead


1-702-227-2929

Call before you Dig

Avoid cutting underground utility lines. It's costly.

CALL 811

 OR 1-800-227-2600



- CONSTRUCTION NOTES**
- INSTALL 5' WIDE SIDEWALK (PER CCAUSD #234)
 - INSTALL 24" R-TYPE CURB & GUTTER (PER CCAUSD #217.3.S1)
 - 2.0" AC PAVEMENT OVER 4" TYPE II PER SOILS REPORT #1991-GEO
 - INSTALL 6.0' HIGH DECORATIVE SCREEN WALL
 - SAWCUT AND MATCH EXISTING AC PAVEMENT (PER CCAUSD #500.5 & #503)
 - PROTECT IN PLACE EXISTING AC PAVEMENT
 - INSTALL RESIDENTIAL DRIVEWAY (PER CCAUSD #223)
 - INSTALL 10' L-TYPE TO R-TYPE CURB TRANSITION (PER DETAIL F/GD1)

GEOTECHNICAL
AMERICAN SOILS ENGINEERING, LLC
LAS VEGAS, NV 89119
(702) 889-9617
REPORT NO.: 1991-GEO
DATE: 04/11/19

SEE H21 FOR LINE AND CURVE TABLE AND LOT DIMENSIONS.

EARTHWORK
TOTAL FOR OVERALL DEVELOPMENT: 72 CY CUT / 154 CY FILL / 82 CY NET (FILL)
NOTE: THIS OPINION OF THE CUT AND FILL QUANTITIES IS PROVIDED AS REQUIRED BY THE GOVERNING ENTITY. THIS INFORMATION SHOULD NOT BE USED FOR BIDDING PURPOSES. ALL CONTRACTORS ARE RESPONSIBLE FOR THEIR OWN QUANTITIES. THESE TOTALS ARE RAW AND DO NOT ACCOUNT FOR SHRINKAGE AND SUBSIDENCE.

FLOOD ZONE
THIS PROJECT IS LOCATED IN FLOOD ZONE "X", AN AREA DETERMINED TO BE OUTSIDE OF THE 0.2% ANNUAL CHANCE FLOOD PLAIN PER FIRM PANEL 32003C2150E, REVISED DATE.

UTILITY DISCLAIMER
EXISTING UTILITY LOCATIONS SHOWN HEREIN ARE APPROXIMATE ONLY. IT SHALL BE THE CONTRACTORS RESPONSIBILITY TO DETERMINE THE EXACT VERTICAL AND HORIZONTAL LOCATION OF ALL EXISTING UNDERGROUND UTILITIES PRIOR TO COMMENCING CONSTRUCTION. NO REPRESENTATION IS MADE THAT ALL EXISTING UTILITIES ARE SHOWN HEREON. THE ENGINEER ASSUMES NO RESPONSIBILITY FOR UTILITIES NOT SHOWN OR UTILITIES NOT SHOWN IN THEIR EXISTING LOCATIONS.

GRADING NOTES
COMPLETION OF SECTION II OF DRAINAGE COMPLIANCE REPORT REQUIRED.
ADD 2800 FEET TO ALL GRADE TAGS TO GET ACTUAL ELEVATION.
THE ELEVATION DIFFERENCE BETWEEN THE PAD AND FINISH FLOOR IS DETERMINED FROM THE MINIMUM THICKNESS REQUIRED PER THE GEOTECHNICAL REPORT. FINISH FLOORS MAY INCREASE DEPENDING ON THE TYPE OF SOIL AND FOUNDATION PLAN USED. NOTE THAT THE STRUCTURAL PLANS & GEOTECHNICAL REPORT SHALL SUPERSEDE THE CIVIL IMPROVEMENT PLANS.
ALL PRIVATE STREETS AND DRAINAGE EASEMENTS ARE TO BE PRIVATELY OWNED AND MAINTAINED BY THE HOMEOWNERS ASSOCIATION (H.O.A.).
ALL WORK TO BE PERFORMED OUTSIDE OF THE PROJECT BOUNDARY AND ON PRIVATE PROPERTY SHALL NOT BE PERFORMED UNTIL WRITTEN PERMISSION AND EASEMENTS HAVE BEEN OBTAINED FROM THE OFFSITE OWNER AND GIVEN TO THE GOVERNING ENTITY.
CONTRACTOR SHALL VERIFY HORIZONTAL AND VERTICAL LOCATION OF EXISTING UTILITIES AND NOTIFY THE DESIGN ENGINEER IMMEDIATELY OF ANY DISCREPANCIES PRIOR TO CONSTRUCTION.

BENCHMARK
RIVET AND PLATE TOP CURB SE CORNER ALPINE RIDGE WAY AND CENTENNIAL PARKWAY
ELEVATION: 2856.12

ACCEPTANCE OF PLANS FOR FILING
BY: _____ DATE: _____
DEVELOPMENT AND FLOOD CONTROL

ADAVEN HOMES
3425 CLIFF SHADOWS PKWY
LAS VEGAS, NV 89129
(702) 365-8886 FAX

ADAVEN HOMES
A RESIDENTIAL SUBDIVISION
ALPINE RIDGE & 215

GRADING PLAN

DATE: 6/3/2019
SCALE: 1"=20'
JOB NO: ADV-18-108
DESIGNED BY: BP CHECKED BY: BM
SHEET NAME: G1
SHEET NUMBER: 03 OF 07
CITY: 107Y5105

LAST PLOT: Mohit Khanna
FILE NAME: S:\ACTIVE\ADAVEN HOMES\ADV-18-108 - ALPINE RIDGE & 215\ENGINEERING\DWGS\ADV18108_SHT_DET.DWG

SECTION A
SOUTH BOUNDARY
NTS

SECTION B
NORTH BOUNDARY
NTS

SECTION C
EAST BOUNDARY
NTS

SECTION D
FRONT YARD
NTS

TYPICAL GRADING DETAIL
TYPE A
NTS

DETAIL E
DECORATIVE BLOCK WALL OPENING
NTS

DETAIL F
TRANSITION FROM L-TYPE
TO R-TYPE CURB
NTS

ADAVEN HOMES
5425 CLAYTON DRIVE
LAS VEGAS, NV 89120
(702) 365-6588 FAX

TANNEY & ANEY ENGINEERING
8030 S. JONES BOULEVARD
LAS VEGAS, NV 89118
(702) 362-8844 FAX (702) 362-5233

ALPINE RIDGE & 215
A RESIDENTIAL SUBDIVISION

GRADING DETAILS

6/3/19

DATE: 6/3/2019
SCALE: NTS
JOB NO: ADV-18-108
DESIGNED BY: BP
CHECKED BY: BM
SHEET NAME: GD1
SHEET NUMBER: 04 OF 07
CITY: L19-00760
107Y5105

Call before you Dig
Avoid overhead power line contact, it's costly.
Call before you Dig
Avoid cutting underground utility lines, it's costly.

OR
1-800-227-2600

Call before you Dig
Avoid overhead power line contact, it's costly.
Call before you Dig
Avoid cutting underground utility lines, it's costly.

OR
1-800-227-2600



CONSTRUCTION NOTES

1. INSTALL 5' WIDE SIDEWALK (PER CCAUSD #234)
2. INSTALL 24" R-TYPE CURB & GUTTER (PER CCAUSD #217.3.S1)
3. INSTALL 2.0" AC PAVEMENT OVER 4" TYPE II PER SOILS REPORT #1804.GEO
4. INSTALL 6.0' HIGH DECORATIVE SCREEN WALL
5. SAWCUT AND MATCH EXISTING AC PAVEMENT (PER CCAUSD #500.5 & #503)
6. PROTECT IN PLACE EXISTING AC PAVEMENT
7. INSTALL RESIDENTIAL DRIVEWAY (PER CCAUSD #223)
8. INSTALL 10' L-TYPE TO R-TYPE CURB TRANSITION (PER DETAIL FGD1)
9. INSTALL 6" 90° BEND (PER UDACS PLT. NO. 31)
10. INSTALL 4" SEWER LATERAL AND CURB MARKING (DCSWCS SD-22 & SD-23)
11. INSTALL 1" WATER SERVICE W/ 3/4" METER (UDACS PLT. NO. 1)
12. INSTALL WYE CONNECTION (PER DCSWCS SD-22)
13. INSTALL 6" PVC WATER
14. INSTALL CLEANOUT W/ TRAFFIC RATED LID (SEWER UNDER DRIVEWAY) (PER DCSWCS SD-26)
15. INSTALL CAP AND BLOW OFF ASSEMBLY (PER UDACS PLT. NO. 36)

GEOTECHNICAL —

AMERICAN SOILS ENGINEERING, LLC
LAS VEGAS, NV 89119
(702) 889-9617

REPORT NO: 1991-GEO

UTILITY DISCLAIMER

EXISTING UTILITY LOCATIONS SHOWN HEREIN ARE APPROXIMATE ONLY. IT SHALL BE THE CONTRACTORS RESPONSIBILITY TO DETERMINE THE EXACT VERTICAL AND HORIZONTAL LOCATION OF ALL EXISTING UNDERGROUND UTILITIES PRIOR TO COMMENCING CONSTRUCTION. NO REPRESENTATION IS MADE THAT ALL EXISTING UTILITIES ARE SHOWN HEREON. THE ENGINEER ASSUMES NO RESPONSIBILITY FOR UTILITIES NOT SHOWN OR UTILITIES NOT SHOWN IN THEIR EXISTING LOCATIONS.

LINE AND CURVE DATA

FOR LINE AND CURVE DATA TABLES, SEE THE GRADING PLAN SHEETS FOR THIS PROJECT.

PROFILE NOTES

ADD 2800 FEET TO ALL GRADE TAGS TO GET ACTUAL ELEVATION.

ALL WORK TO BE PERFORMED OUTSIDE OF THE PROJECT BOUNDARY AND ON PRIVATE PROPERTY SHALL NOT BE PERFORMED UNTIL WRITTEN PERMISSION AND EASEMENTS HAVE BEEN OBTAINED FROM THE OFFSITE OWNER AND GIVEN TO GOVERNING ENTITY.

BENCHMARK

RIVET AND PLATE TOP CURB SE CORNER ALPINE RIDGE WAY AND CENTENNIAL PARKWAY
ELEVATION: 2856.12

ACCEPTANCE OF PLANS

11/17/94 6.3.19
SOUTHWEST GAS CORPORATION DATE

APPROVED FOR CONSTRUCTION

LAS VEGAS VALLEY WATER DISTRICT ENGINEERING SERVICES
PROJECT# 136461 FIRST APPROVED DATE 6-19-19
LVVWD APPROVED FIRE FLOW: 1500 GPM AT 20 PSI RESIDUAL
MAXIMUM AVAILABLE FIRE SPRINKLER FLOW 26 PSI
LVVWD APPROVAL IS VALID FOR ONE (1) YEAR FROM THE SIGNATURE DATE. IF CONSTRUCTION
IS NOT STARTED, PLANS MUST BE RESUBMITTED FOR REVIEW AND APPROVAL.

~~ACCEPTANCE OF PLANS FOR FILING~~

BY: _____
DEVELOPMENT AND FLOOD CONTROL _____ DATE _____

DEPTH OF COVER DURING CONSTRUCTION
MAINTAIN MINIMUM TWENTY-FOUR (24) INCH COVER PER UDACS SECTION
2.08.04. GRADING MUST BE COMPLETED PRIOR TO WATERLINE
INSTALLATION.

WATER MAIN JOINT DEFLECTION NOTE (PVC 4"-24")

PVC PIPE SHALL BE DEFLECTED AT THE JOINT ONLY. THE MAXIMUM ALLOWABLE DEFLECTION SHALL BE ONE (1) DEGREE PER JOINT WITH A MAXIMUM RADIUS OF CURVATURE OF 1,150 FEET, PER UDACS 2.07.01 AND 2.07.02.

FOR CHANGES IN DIRECTION EXCEEDING THE MAXIMUM ALLOWABLE JOINT DEFLECTION, FITTING SHALL BE USED.

Call before you Dig
Avoid cutting underground
utility lines. It's costly.

CALL
811

OR
1-800-227-2600

Avoid overhead power
line contact. it's costly.

Call
before you
Overhead
1-702-227-2929

[illegible]


3425 CLIFF SHADOWS PKWY
LAS VEGAS, NV 89129
(702) 365-8588 FAX:

TANEY ENGINEERING
6030 S. JONES BOULEVARD
LAS VEGAS, NV 89118
(702) 362-8844 FAX: (702) 362-5233



A RESIDENTIAL SUBDIVISION

PLAN AND PROFILE

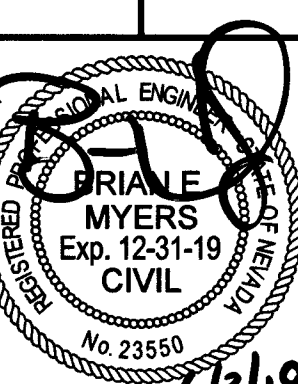

E: 6/3/2019

411-001

NO: ADV-18-108

SIGNED BY:	CHECKED BY:
BP	BM

ET NAME: **DD1**

PPT

 
05 07

00 OF 01

9-00760 — 10775125

PROJ#:136461A QS:126-24-SW

215 BELTWAY



CONSTRUCTION NOTES

1. INSTALL 6" 90° BEND (PER UDACS PLT. NO. 31)
2. INSTALL 4" SEWER LATERAL AND CURB MARKING (DCSWCS SD-22 & SD-23)
3. INSTALL 1" WATER SERVICE W/ 3/4" METER (UDACS PLT. NO. 1)
4. INSTALL WYE CONNECTION (PER DCSWCS SD-22)
5. INSTALL 6" PVC WATER
6. INSTALL CLEANOUT WITH TRAFFIC RATED LID (SEWER UNDER DRIVEWAY) (PER DCSWCS SD-28)
7. INSTALL CAP AND BLOW OFF ASSEMBLY (PER UDACS PLT. NO. 36)

WATER MAIN JOINT DEFLECTION NOTE (PVC 4"-24")

PVC PIPE SHALL BE DEFLECTED AT THE JOINT ONLY. THE MAXIMUM ALLOWABLE DEFLECTION SHALL BE ONE (1) DEGREE PER JOINT WITH A MAXIMUM RADIUS OF CURVATURE OF 1,150 FEET, PER UDACS 2.07.01 AND 2.07.02.

FOR CHANGES IN DIRECTION EXCEEDING THE MAXIMUM ALLOWABLE JOINT DEFLECTION, FITTING SHALL BE USED.

FIRE FLOW CALCULATIONS

FIRE FLOW REQUIREMENT IS 1500 GPM @ 20 PSI RESIDUAL.

BASED ON:
SQUARE FOOTAGE: 4800 SQ FT
OF STORIES/FLOORS: 2
HEIGHT: 28.75 FT
SPRINKLER SYSTEM: YES
ANTICIPATED FIRE SPRINKLER FLOW DEMAND: 26 GPM

IF THE ANTICIPATED FIRE FLOW IS INSUFFICIENT, AND HOMES EXCEED THE DECLARED SQUARE FOOTAGE NOTED ABOVE, A NFPA 13D SPRINKLER SYSTEM SHALL BE REQUIRED.
NUMBER OF HYDRANTS PROVIDED: 2

UTILITY NOTES

1. ALL WATER FACILITIES CONSTRUCTION SHALL BE IN ACCORDANCE WITH THE "UNIFORM DESIGN AND CONSTRUCTION STANDARDS FOR WATER DISTRIBUTION SYSTEMS" (UDACS), LATEST EDITION.
2. FIRE, WATER, AND SEWER SERVICES, AS APPROVED ON THIS PLAN, ARE INTENDED SPECIFICALLY FOR THE LOT AND USE SHOWN, AND ARE NOT INTENDED TO SERVICE ADDITIONAL PARCELS OR STRUCTURES WHICH MAY BE CREATED IN THE FUTURE. IN THE EVENT THAT THE PARCELS AND/OR LOTS SHOWN ON THIS PLAN ARE FURTHER DIVIDED TO CREATE ADDITIONAL PARCELS OR LOTS, THE OWNER IS REQUIRED TO PROVIDE SEPARATE FIRE, WATER, & SEWER SERVICES TO EACH.
3. WATER AND SEWER LATERALS SHALL BE INSTALLED A MINIMUM OF 48" APART IN SEPARATE TRENCHES. WATER LATERALS SHALL BE A MINIMUM OF 12" ABOVE THE SEWER LATERAL. (REF. UNIFORM PLUMBING CODE)
4. LOCATOR RIBBON SHALL BE USED FOR ALL SERVICE LATERALS NOT PERPENDICULAR TO THE MAIN. (TYPICAL)
5. ALL SEWER/STORM DRAINS CROSSING WATER LINES MUST CONFORM TO SECTION 2.22 OF "UNIFORM DESIGN AND CONSTRUCTION STANDARDS FOR WATER DISTRIBUTION SYSTEMS" (UDACS) FOR WATER AND STORM MAIN CROSSINGS AND CLEARANCES.
6. ALL WORK TO BE PERFORMED OUTSIDE OF THE PROJECT BOUNDARY AND ON PRIVATE PROPERTY SHALL NOT BE PERFORMED UNTIL WRITTEN PERMISSION AND EASEMENTS HAVE BEEN OBTAINED FROM THE OFFSITE OWNER AND GIVEN TO CLARK COUNTY.
7. ALL ONSITE STREETS AND DRAINAGE EASEMENTS ARE TO BE PRIVATELY OWNED AND MAINTAINED.
8. INSTALL PIPELINE MARKER BALLS IN TRENCH ABOVE EACH HORIZONTAL ELBOW FITTING. (UDACS PLT 15.)
9. 3' MIN. HORIZONTAL CLEARANCE REQUIRED BETWEEN WATER MAINS AND DRY UTILITIES PER UDACS SECTION 2.04.02
10. 12" MIN. VERTICAL CLEARANCE REQUIRED BETWEEN WATER MAINS AND DRY UTILITIES AND 6' MIN. BETWEEN WATER LATERALS AND DRY UTILITIES PER UDACS SECTION 2.04.06

UTILITY DISCLAIMER

EXISTING UTILITY LOCATIONS SHOWN HEREIN ARE APPROXIMATE ONLY. IT SHALL BE THE CONTRACTORS RESPONSIBILITY TO DETERMINE THE EXACT VERTICAL AND HORIZONTAL LOCATION OF ALL EXISTING UNDERGROUND UTILITIES PRIOR TO COMMENCING CONSTRUCTION. NO REPRESENTATION IS MADE THAT ALL EXISTING UTILITIES ARE SHOWN HEREON. THE ENGINEER ASSUMES NO RESPONSIBILITY FOR UTILITIES NOT SHOWN OR UTILITIES NOT SHOWN IN THEIR EXISTING LOCATIONS.

BENCHMARK

RIVET AND PLATE TOP CURB SE CORNER ALPINE RIDGE WAY AND CENTENNIAL PARKWAY
ELEVATION: 2855.12

ACCEPTANCE OF PLANS


SOUTHWEST GAS CORPORATION
DATE: 6.3.19

APPROVED FOR CONSTRUCTION

LAS VEGAS VALLEY WATER DISTRICT ENGINEERING SERVICES
PROJECT# 136461 FIRST APPROVED DATE: 6-19-19
LWWD APPROVED FIRE FLOW: 1500 GPM AT 20 PSI RESIDUAL
MAXIMUM AVAILABLE FIRE SPRINKLER FLOW 26 GPM
LWWD APPROVAL IS VALID FOR ONE (1) YEAR FROM THE SIGNATURE DATE. IF CONSTRUCTION IS NOT STARTED, PLANS MUST BE RESUBMITTED FOR REVIEW AND APPROVAL.

APPROVED FOR CONSTRUCTION


CITY OF LAS VEGAS FIRE DEPARTMENT
APPROVAL OF THESE PLANS SHALL NOT BE CONSTRUED TO BE A PERMIT FOR, OR AN APPROVAL OF ANY VIOLATION OF ANY OF THE PROVISIONS OF THE STATE OR COUNTY LAWS. FIRE FLOW = 1,500 G.P.M. AT 20 PSI RESIDUAL.

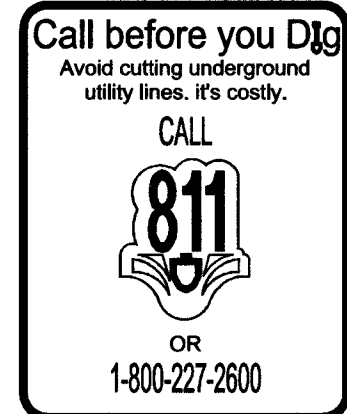


REVISIONS		NO.	DESCRIPTION	BY	SHTS.	APPR.	DATE

ADAVEN HOMES
3425 CLIFF SHADOWS PKWY
LAS VEGAS, NV 89129
(702) 362-6666 FAX

ADAVEN HOMES
3425 CLIFF SHADOWS PKWY
LAS VEGAS, NV 89129
(702) 362-6666 FAX




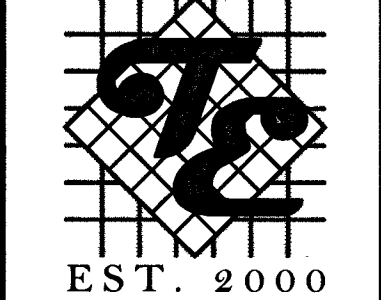


ALPINE RIDGE & 215
A RESIDENTIAL SUBDIVISION
UTILITY PLAN 1

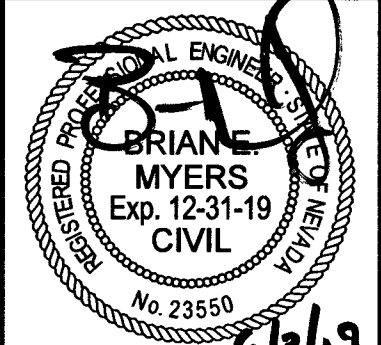

DATE: 6/3/2019
SCALE: 1"=20'
JOB NO: ADV-18-108
DESIGNED BY: BP CHECKED BY: BM
SHEET NAME: UT1
SHEET NUMBER: 06 OF 07
L19-00760
CITY: 107Y5105

PROJ#: 136461A QS:126-24-SW

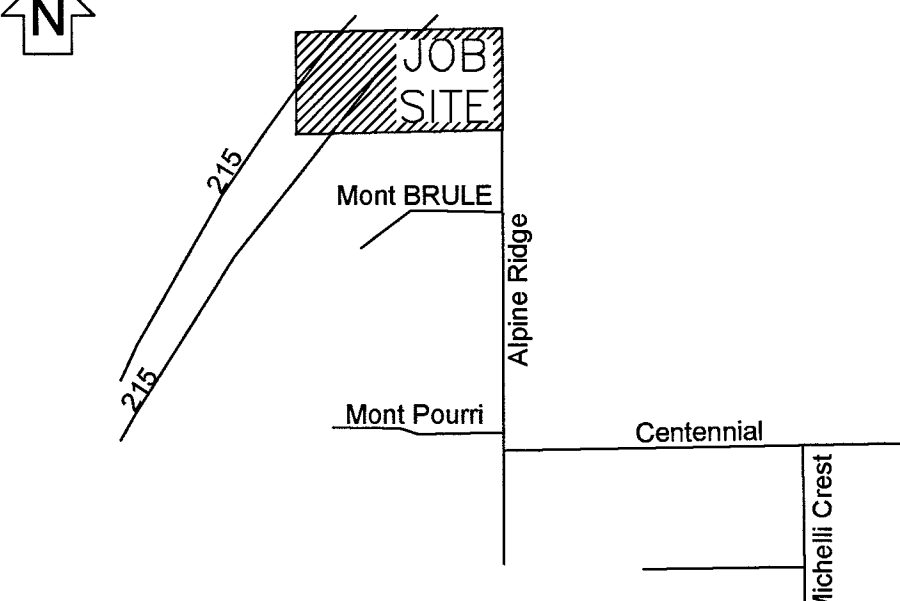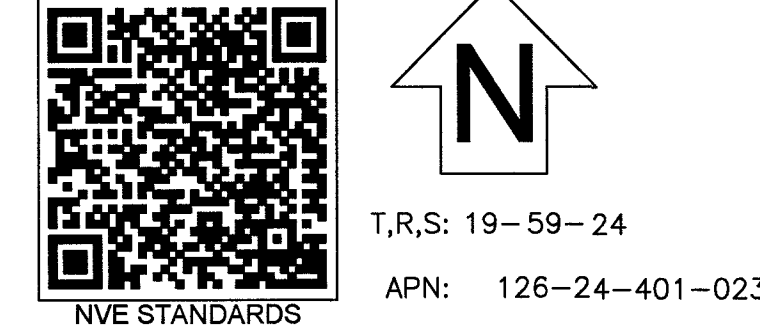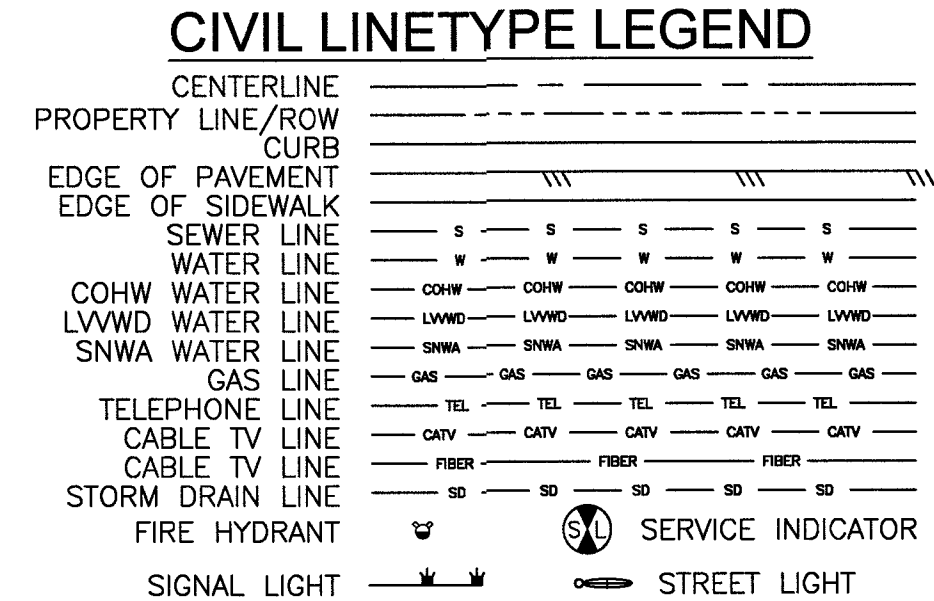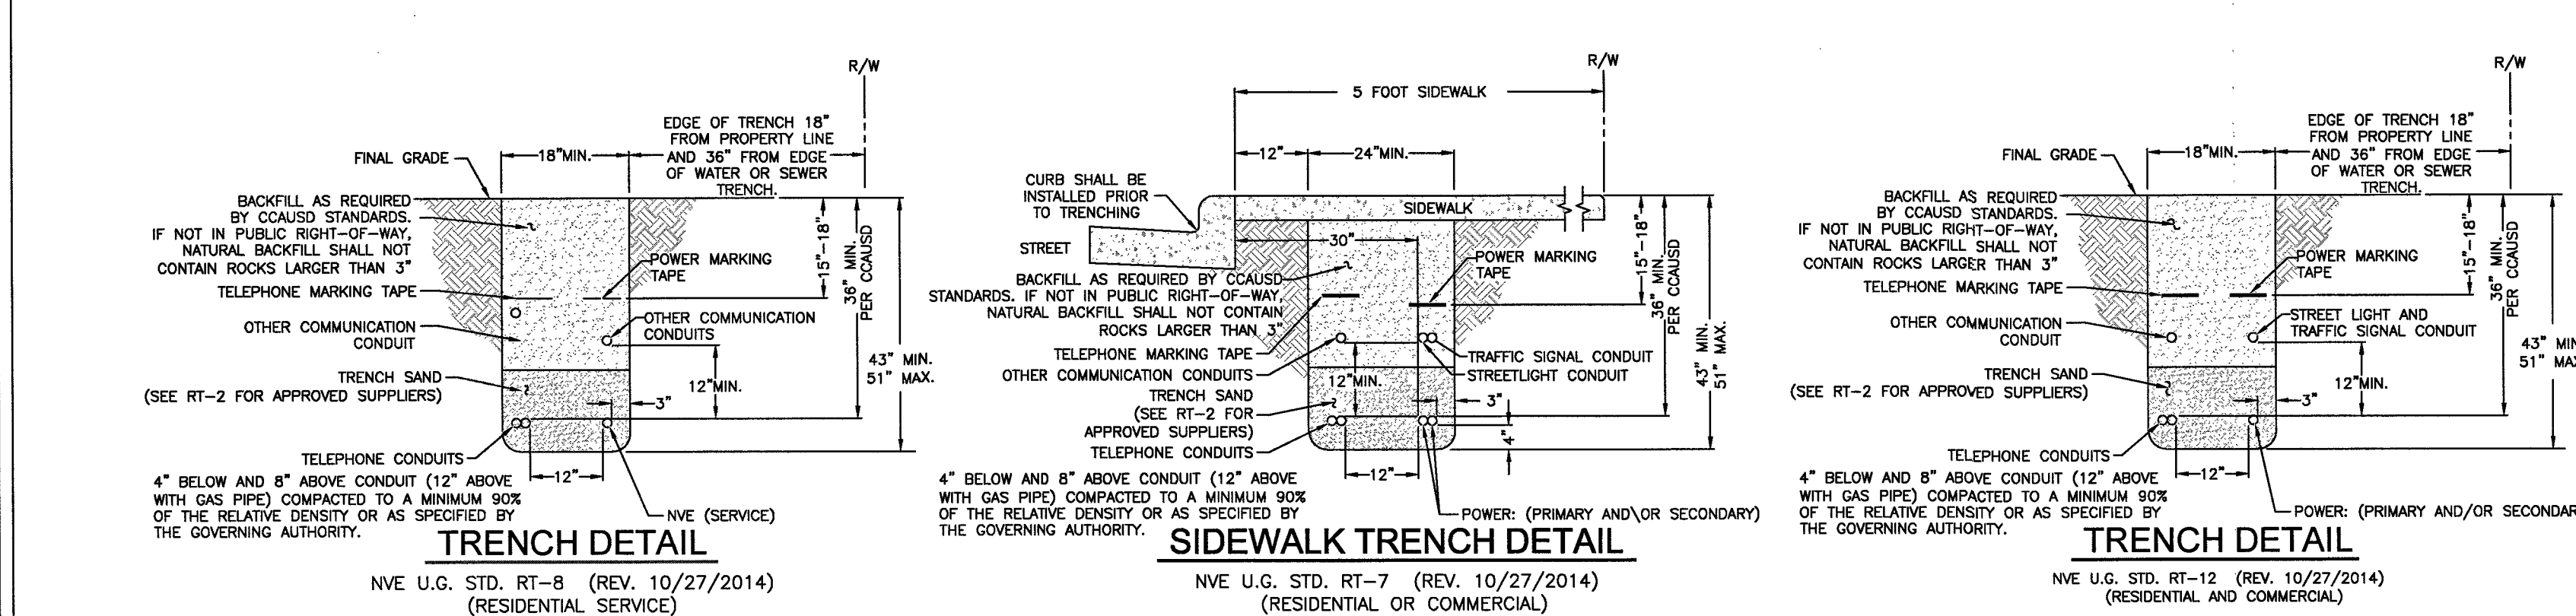

NV ENERGY SCHEDULING NOTE: DAY (NO LANE BLOCKS)
THIS PROJECT WAS ESTIMATED WITH THE ASSUMPTION THAT ALL THE WORK BEING PERFORMED ON THIS PROJECT BY NV ENERGY CREWS CAN BE DONE DURING THE DAYTIME WITH NO TRAFFIC CONTROL REQUIRED.

GOVERNMENT APPROVAL OF THESE DRAWINGS DOES NOT INDICATE APPROVAL OF TRAFFIC CONTROL. PLEASE REFER TO THE BARRICADE PLAN FOR APPROVED TRAFFIC CONTROL REQUIREMENTS.

SOURCE	PROJECT CONNECTED LOAD (3Ø)				LOOP
FC OR RISER	PH.	EX: KVA	ADDED KVA	TOTAL KVA	FC OR RISER
FC2191	A	975	0	975	<u>RADIAL</u>
UGM4630	B	900	0	900	-----
ELC1218	C	835	0	835	-----

STREETLIGHT CLEARANCE:
NPC FACILITIES (SUBSTRUCTURES) ARE NOT TO BE WITHIN 5' OF STREET LIGHT BASES, AND NPC CONDUITS ARE NOT TO CONFLICT WITH STREET LIGHT BASES

CUSTOMER NOTE:
UNLESS OTHERWISE NOTED, ALL CONDUIT, BENDS AND SUBSTRUCTURES ARE THE RESPONSIBILITY OF THE CUSTOMERS CONTRACTOR, OR ASSIGNED DCA CONTRACTOR (RESIDENTIAL ONLY)

TRANSFORMER CONNECTED LOAD			
TRANSFORMER #: PM804098			
APD	EPD	TOTAL	
C Ø	87.5	8	95.5

!!!! CAUTION !!!!
ENERGIZED CABLES...
CALL BEFORE YOU DIG

FIRE HYDRANT CLEARANCE:
6' RADIUS FROM CENTER OF HYDRANT TO ALL ABOVE GROUND PADS AND/OR EQUIPMENT AND ALL MANHOLES AND SWITCHBOXES.
6' RADIUS FROM CENTER OF HYDRANT TO ALL UNDERGROUND HANDHOLES, PULLBOXES AND SPLICEBOXES. ALL PER NVEnergy STD. RS-5

CONDUIT SEALING REQUIREMENT:
CONDUIT SEALING PER NESC AND OR NEC LATEST VERSION.
ALL ELECTRIC CONDUITS ENTERING BUILDING THROUGH OR PENETRATING CONCRETE SLAB SHALL BE SEALED AT BOTH ENDS WITH EXPANDING PLUG(S) AFTER CONDUIT IS MANDRILLED.
NVE WILL INSTALL A PERMANENT SEAL AFTER CONDUCTORS ARE INSTALLED.

NOTICE:
THIS EXHIBIT IS THE EXCLUSIVE AND CONFIDENTIAL PROPERTY OF NV ENERGY AND MAY NOT BE USED, REPRODUCED OR DISTRIBUTED WITHOUT THE EXPRESSED, WRITTEN APPROVAL OF NV ENERGY.
THE IMAGES HEREON ARE NOT ORTHOPHOTOGRAPHIC. ANY LOCATIONS DEPICTED HEREON ARE APPROXIMATE ONLY. THIS EXHIBIT WAS CREATED FOR GENERAL PRESENTATION AND DISCUSSION PURPOSES ONLY AND IS NOT PURPORTED TO REPRESENT ANY MEASURE OF ACCURACY. THIS EXHIBIT IS NOT TO BE UTILIZED IN ANY MANNER NOT CONSISTENT WITH THE INTENT OF ITS' CREATION AS STATED ABOVE.

CONSTRUCTION / INSPECTION REQUIREMENTS
WORK MUST CONFORM TO NVE ELECTRIC SERVICE STANDARDS, AVAILABLE AT: www.nvenergy.com/business/newconstruction/newconstruction/servicesstandards.cfm
NVE INSPECTOR MUST BE PRESENT TO INSPECT TRENCHING (SCHEDULE AT LEAST 72 HOURS IN ADVANCE) AT EACH OF THE FOLLOWING STAGES:
1. BOTTOM SAND AND CONDUIT INSTALLED
2. TOP SAND INSTALLED
3. BACKFILL INSTALLED
CONDUIT MUST BE MANDRILLED PRIOR TO RELEASE (COORDINATE WITH INSPECTOR).
NVE STAND BY CREW IS REQUIRED WHEN WORKING AT AN ENERGIZED VAULT OR TRANSFORMER. CALL STAND BY NUMBER (SEE TITLE BLOCK) TO SCHEDULE.
NVE ELECTRICAL INSTALLATION WILL NOT BE SCHEDULED UNTIL AFTER THE NVE INSPECTOR HAS COMPLETED THE OFFICIAL RELEASE.
METER(S) WILL NOT BE SET UNTIL ALL OF THE FOLLOWING ARE COMPLETE:
• [INSTRUMENT-RATED ONLY] METERING EQUIPMENT HAS BEEN SUBMITTED TO NVE METERING ENGINEER AND APPROVED. (submit to: southern@nvenergy.com)
• APPLICATION FOR METER SET HAS BEEN SUBMITTED TO NVE'S NEW DEVELOPMENT CENTER. FORM AVAILABLE AT: www.nvenergy.com/brochures_arch/new_construction/meter_set.pdf
• THE LOCAL BUILDING AUTHORITY HAS INSPECTED AND APPROVED THE METERING EQUIPMENT.
• METERING EQUIPMENT IS ACCESSIBLE AND CLEARLY IDENTIFIED WITH PERMANENT MARKINGS, ADDRESSES, SUITE NUMBERS, AND STREET SIGNS ARE POSTED IN PERMANENT LOCATIONS (SEE RPI-0).
TRACK PROJECT STATUS ONLINE WITH NVE'S DEVELOPER DASHBOARD: www.nvenergy.com/business/newconstruction/newconstruction/developerdashboard.cfm


RTC NOTES:
BACKFILL AND RIGHT OF WAY RESTORATION SHALL CONFORM TO CLARK COUNTY UNIFORM STANDARD DRAWINGS

1	500.1	0 TO 5 YEARS PAVEMENT RESTORATION LONGITUDINAL CUT
2	500.2	0 TO 5 YEARS PAVEMENT RESTORATION TRANSVERSE CUT
3	500.3	OVER 5 YEARS PAVEMENT RESTORATION LONGITUDINAL CUT. GREATER THAN 60' R.O.W
4	500.4	OVER 5 YRS PAVEMENT RESTORATION LONGITUDINAL CUT. 60' R.O.W OR LESS
5	500.5	OVER 5 YRS PAVEMENT RESTORATION TRANSVERSE ALL R.O.W WIDTHS
6	501	TYPICAL UNDERGROUND UTILITY LOCATIONS IN RESIDENTIAL STREETS 60' OR LESS R.O.W.
7	501.1	TYPICAL UTILITY UNDERGROUND LOCATIONS IN STREETS WITH GREATER THAN 60' R.O.W.
8	503	METHOD B FOR RIGID AND FLEXIBLE PIPE TRENCH BACKFILL - PAVED AREAS
9	503.1	METHOD A FOR FLEXIBLE PIPE TRENCH BACKFILL - PAVED AREAS
10	234	SIDEWALK
11	506	UTILITY POTHOLE REPAIR
12	216	"L" TYPE CURB AND GUTTER

METER LOCATION & ACCESS REQUIREMENTS
(NV ENERGY STANDARDS RPI-2 & RPI-6)
MIN. 3'x3' CLEAR, LEVEL SPACE (SAFE WORK SPACE) REQUIRED DIRECTLY IN FRONT OF METER. THIS SPACE SHALL NOT BE PART OF A DRIVEWAY OR SUBJECT TO VEHICULAR TRAFFIC.
SERVICE POINT TO BE NO GREATER THAN 100' FROM BACK OF CURB OR PUBLIC EASEMENT (NO GREATER THAN 25' FROM SIDE STREET OR ALLEY).
A SERVICE PEDESTAL MUST BE 5' MIN. FROM BACK OF CURB, 6' MIN. FROM DRIVEWAY OR OTHER TRAFFIC AREA.
BOTH SERVICE POINT AND SAFE WORK SPACE TO BE DIRECTLY VISIBLE FROM BACK OF CURB OR PUBLIC EASEMENT, AND MUST BE READILY ACCESSIBLE TO NV ENERGY AT ALL TIMES WITHOUT REQUIRING PASSAGE THROUGH RESTRICTED AREAS OR REQUIRING CUSTOMER CONTACT. FENCES, GATES, WALLS, OR OTHER OBSTRUCTIONS IN FRONT OF THE SERVICE POINT ARE PROHIBITED.
VISIBILITY, ACCESSIBILITY, AND SAFE WORK SPACE MUST BE MAINTAINED FOR THE ENTIRE LIFE OF THE SERVICE.

DEVELOPER'S OFFSITE ENCROACHMENT PERMIT
TO BE UTILIZED FOR THE INSTALLATION OF NVEnergy FACILITIES
NOTE: ALL THE ABOVE GROUND UTILITY APPURTENANCES SHALL CONFORM TO THE REQUIREMENTS OF CLV UNIFIED DEVELOPMENT CODE TITLE 19.06 AND 19.08
APPROVED FOR CONSTRUCTION
THIS APPROVAL IS FOR WORK IN CLV R/W & EASEMENT ONLY. OBTAINING PERMISSIONS OR EASEMENTS FOR WORK SHOWN ON PRIVATE PROPERTY IS THE RESPONSIBILITY OF THE UTILITY.
APPROVAL BY: 7/11/19 DATE

CITY OF LAS VEGAS PERMIT REQUIRED*
CONTACT CLV LAND DEVELOPMENT (229-6371) CLV CONSTRUCTION SERVICES MUST BE NOTIFIED 24 HOURS PRIOR TO COMMENCING CONSTRUCTION (229-6337)
HANSEN 107551-05
419-00760---
DATE: 7/11/19
*NVE INSPECTOR MUST BE NOTIFIED BY FAX 48 HOURS PRIOR TO COMMENCING CONSTRUCTION & WILL VERIFY CITY PERMIT FOR WORK DONE IN STREETS OR SIDEWALK.
LAS VEGAS NORTH (RYAN CENTER): 402-4354
LAS VEGAS SOUTH (BELTWAY CENTER): 402-6864

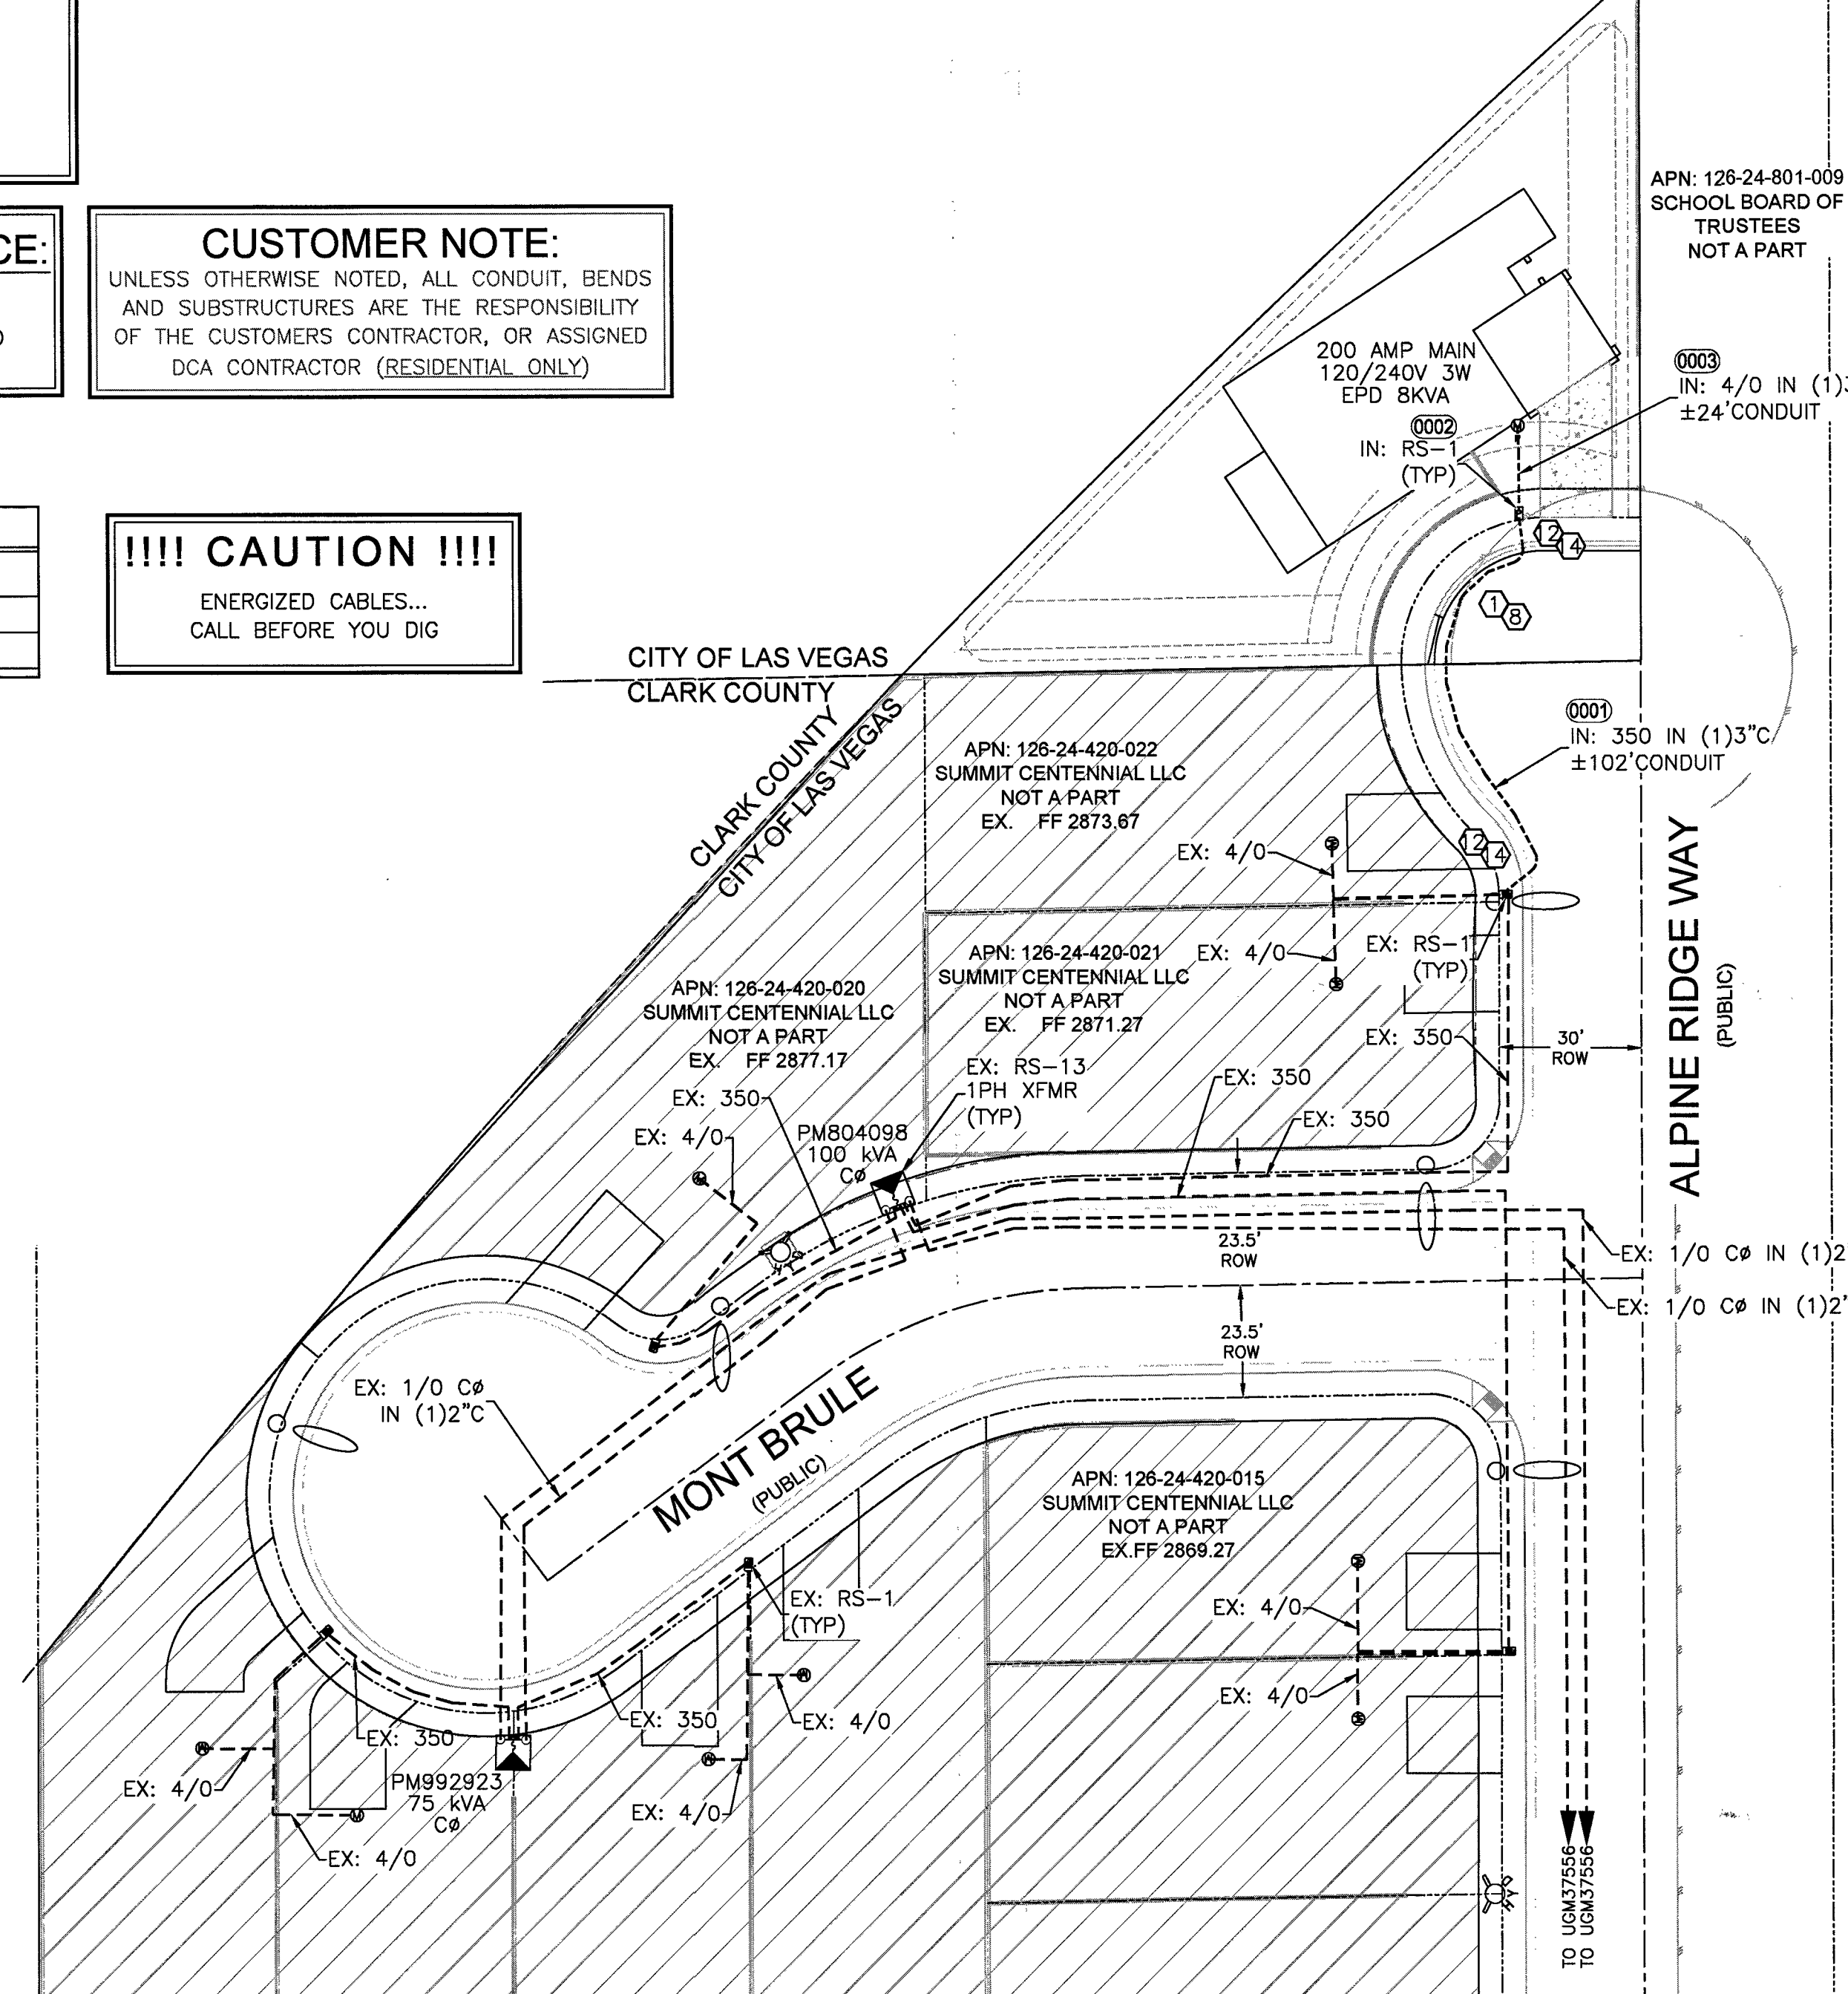

GENERAL NOTES:
ANY NOTES LOCATED IN DRAWING AREA TAKE PRECEDENCE OVER STANDARD NOTES.
REFER TO A CURRENT NVEnergy ELECTRIC SERVICE REQUIREMENTS HANDBOOK FOR FURTHER CLARIFICATION OF NVEnergy STANDARDS.
THE APPLICANT SHALL INFORM THE INSPECTOR AT LEAST 48 HOURS BEFORE COMMENCING ANY ITEM OF CONSTRUCTION OR INSTALLATION OF MATERIAL TO ENABLE PROPER INSPECTION OF MATERIALS AND WORKMANSHIP. MAIN TRENCH WIRE PULLS TO BE SCHEDULED 72 HOURS IN ADVANCE OF INSTALLATION. APPLICANT'S PROJECT WILL NOT BE SCHEDULED UNTIL FINAL APPROVAL FROM NVEnergy UNDERGROUND & ELECTRICAL INSPECTORS.
ALL WORK SHALL BE ACCOMPLISHED IN STRICT ACCORDANCE WITH THE SPECIFICATIONS SET FORTH IN THE ELECTRIC SERVICE REQUIREMENTS HANDBOOK, AS CURRENTLY ADOPTED BY NVEnergy. THE CONTRACTOR SHALL SECURE COPIES OF THE AFOREMENTIONED CONSTRUCTION SPECIFICATIONS ON HIS OR HER OWN BEHALF.
SYMBOLS ARE NOT TO SCALE AND DO NOT NECESSARILY REPRESENT ACTUAL LOCATIONS OF FACILITIES.
THIS DRAWING ILLUSTRATES DATA COLLECTED FROM VARIOUS SOURCES AND MAY NOT REPRESENT A SURVEY OF THE PREMISES.
APPLICANT SHALL FIELD DETERMINE POSITION AND DEPTH OF EXISTING UTILITY EQUIPMENT PRIOR TO COMMENCING CONSTRUCTION.
USE CAUTION PRIOR TO EXCAVATION. CHECK TO ENSURE ADDITIONAL DEPTH IS NOT REQUIRED TO ACCOMMODATE GAS AND/OR WATER FACILITIES AND DRAINAGE CHANNELS.
CALL NVEnergy UNDERGROUND INSPECTORS 48 HOURS PRIOR TO START OF CONSTRUCTION FOR TRENCH INSPECTION BEFORE COVERING TRENCH.
ALL NVEnergy CABLE TO BE INSTALLED BEHIND CURB, UNLESS OTHERWISE STATED.
APPLICANT IS RESPONSIBLE FOR STAKING OF PROPERTY CORNERS & ELEVATIONS.
ALL HANDHOLES AND PULLBOXES SHALL BE INSTALLED TO FINISHED GRADE OR 6" ABOVE IF GRADE IS NOT ESTABLISHED.
ANY SUBSTRUCTURE VAULT INSTALLED IN GRAVEL, GRASS, OR BARE GROUND WILL REQUIRE A CONCRETE 8" WIDE AND 6" DEEP COLLAR AROUND BOX IN ACCORDANCE TO RS-G6.
2" PLASTIC CONDUIT BENDS (90°, 45°) WITH 36" MIN. RADIUS. (USE FIBERGLASS IF CONDUIT LENGTH IS OVER 500')
3" & 4" PLASTIC CONDUIT BENDS (90°, 45°) WITH 36" MIN. RADIUS. (USE RGS IF CONDUIT LENGTH IS OVER 100')
6" PLASTIC CONDUIT BENDS (90°, 45°) WITH 48" MIN. RADIUS. (USE RGS IF CONDUIT LENGTH IS OVER 100')
WHEN INSTALLING CONDUIT IN FIELD, USE APPROPRIATE BENDS TO COMPLETE THE INSTALLATION.
DEFLECTION OF CONDUIT BENDS AND CONDUIT NOT TO EXCEED NVEnergy STANDARDS.
EXISTING STUB-OUT/CONDUIT INSTALLED BY PREVIOUS CONTRACTOR / DEVELOPER. NVEnergy DOES NOT GUARANTEE LOCATION, LENGTH, OR ACCESSIBILITY OF EXISTING STUB-OUT/CONDUIT. IF UTILIZING ANY PORTION OF EXISTING CONDUIT, IT MUST BE MANDRELED PRIOR TO FINAL RELEASE.
PREVIOUSLY MANDRELED CONDUIT WHICH HAS BEEN IN THE GROUND FOR OVER 6 MONTHS MUST BE RE-MANDRILLED PRIOR TO FINAL RELEASE.
WHEN NVEnergy FACILITIES ARE TO BE REMOVED, NVEnergy WILL REMOVE ALL WIRES AND EQUIPMENT. NVEnergy IS NOT RESPONSIBLE FOR THE REMOVAL OF CONDUIT RUNS OR SUBSTRUCTURES FROM THE PROPERTY.
NO COVERED PARKING IN FRONT OF EQUIPMENT.
ALL CONSTRUCTION AND MATERIALS SHALL BE IN ACCORDANCE WITH THE "UNIFORM STANDARD SPECIFICATIONS FOR PUBLIC WORKS CONSTRUCTION OFF-SITE IMPROVEMENTS, CLARK COUNTY AREA NEVADA", LATEST ISSUE; THE "UNIFORM STANDARD DRAWINGS FOR PUBLIC WORKS CONSTRUCTION, CLARK COUNTY AREA NEVADA", LATEST ISSUE; AND OTHER APPLICABLE APPROVED STANDARDS ISSUED BY THE CONTROLLING AGENCY; ALL LOCAL CITY CODES AND ORDINANCES APPLICABLE.

NVEnergy REQUIRES 24 HOUR ACCESS TO EQUIPMENT
NVE WILL NOT VERIFY THE EXISTING CONDUIT. CUSTOMER TO ENSURE ITS INTEGRITY AND REPAIR IF NECESSARY.

!!!! CAUTION !!!!
ENERGIZED CABLES...
CALL BEFORE YOU DIG

STANDARD

PROJECT PURPOSE:
TO PROVIDE 120/240V 1Ø SERVICE FOR
(1) 200 AMP PANEL FOR
(1) RESIDENTIAL CUSTOM HOME

EXHIBIT 'A'

NVEnergy INFORMATION:
COORDINATOR: GREEN, DAMARIO
PHONE: (702)545-8132 D.F. LOWELL, KEN
DESIGNER: MONROE, DAVID
DCA: N/A
INSPECTOR: 702-402-3008 OR UG@NVENERGY.COM
STAND BY: (702) 402-4450, 4150, 4114, 4117, 4118
DISTRICT: LAS VEGAS NORTH DISTRICT

JPA INFORMATION:
JPA ADMIN PHONE: N/A JPA#: N/A
CUSTOMER INFORMATION:
APPLICANT: ADAVEN HOMES, LLC
ENGINEER: N/A
CONTACT: CRAWFORD, PATTY ** 702-601-7497
APPROVAL DATE: 06/21/2019

GOVERNMENT INFORMATION:
AGENCY: CLV I
APPROVAL DATE: _____
FOR EACH SERVICE POINT (POINT OF DELIVERY), ENERGY FOR EACH TENANT SPACE WILL BE MEASURED THROUGH ONE WATT/OUR METER. ENERGY FOR ALL NON-TENANT SPACE WILL BE MEASURED THROUGH ONE WATT/OUR METER. CONTACT NVE METER OPERATIONS FOR MULTIPLE RATE CLASS INSTALLATIONS.

ADAVEN HOMES - ADD ON

CENTENNAIL AND ALPINE RIDGE
PROJ #3003739436 SCALE: 1"=30'
SHEET # 1 OF 1 DATE: 5/23/2019