

Avoid overhead power line contact. It's costly. Call before you Overhead 1-702-227-2929	Call before you Dig Avoid cutting underground utility lines. It's costly. CALL OR 1-800-227-2600
--	--


	EXISTING	PROPOSED
PROJECT BOUNDARY	---	---
RIGHT-OF-WAY	---	---
CENTERLINE	---	---
PROPERTY LINE	---	---
EDGE OF PAVEMENT	---	---
SIDEWALK	[---]	[---]
CURB AND GUTTER	---	---
FENCE	---	---
CONTOUR (1' INTERVAL)	---	---
CONTOUR (5' INTERVAL)	---	---
DIRECTION OF FLOW	---	---
CUT LINE-ASPHALT	---	---
SCARP (SLOPE VARIES)	---	---
DESIGN ELEVATION	(10.00)	10.00
FUTURE ELEVATION		[10.00]
NUMBER OF RETAINING COURSES		10
RETAINING WALL	---	---
CMU WALL	---	---
SOLID GROUTED WALL - NO RETAINING	---	---
CUT-OFF WALL	---	---
POWER POLE	---	---
SIDEWALK RAMP	---	---
CURB DROP INLET	---	---
STORM DRAIN WIMANHOLE	---	---
CUT-FILL LINE	---	---
SIGHT VISIBILITY ZONE		---
CAP & 2" BLOW OFF VALVE	---	---
WATERLINE FITTINGS	---	---
GATE VALVE	---	---
FIRE HYDRANT	---	---
SEWER LINE WIMANHOLE	---	---
SEWER LATERAL	---	---
WATER LINE	---	---
WATER LATERAL WIMETER	---	---
PRESSURE REDUCING VALVE		PRV
BACKWATER VALVE		BWV
200A SERVICE PEDESTAL		
STREET LIGHT CONDUIT	---	---
F.A.S.T. CONDUIT	---	---
TRAFFIC SIGN	---	---
STOP SIGN WESTREET NAME SIGN	---	---
100W HPS LUMINAIRE W/11 GA. POLE	---	---
250W HPS LUMINAIRE W/11 GA. POLE	---	---
400W HPS LUMINAIRE W/11 GA. POLE	---	---

[illegible]

ADAVEN HOMES
3425 CLIFF SHADOWS PKWY
LAS VEGAS, NV 89129
(702) 365-8598 FAX: (702) 365-5233



ALPINE RIDGE & 215
A RESIDENTIAL SUBDIVISION
COVER SHEET

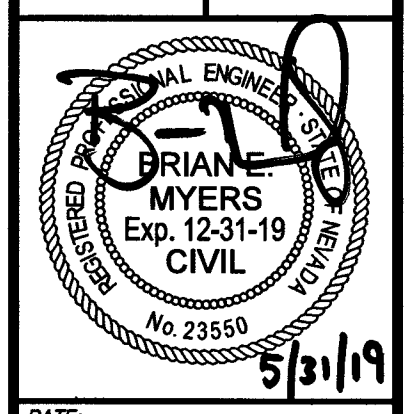

DATE:		5/31/2019	
SCALE:		NTS	
JOB NO:		ADV-108-108	
DESIGNED BY:	BP	CHECKED BY:	BM
SHEET NAME:		C1	
SHEET NUMBER:		01 OF 07	
L19-00760		—	
CITY		107Y5105	

SHEET INDEX		
Sheet Number	Sheet Title	Sheet Description
01	C1	COVER SHEET
02	C2	NOTES AND QUANTITIES
03	G1	GRADING PLAN
04	GD1	GRADING DETAILS
05	PP1	PLAN AND PROFILE
06	UT1	UTILITY PLAN 1
07	HZ 1	HORIZONTAL CONTROL PLAN

07	HZ 1	HORIZONTAL CONTROL PLAN
08 NVE1 NVENERGY SHEET 09-13 SWG1- SOUTHWEST GAS SWG5 SHEETS 1 THRU 5		

APPROVAL SIGNATURES	
APPROVED FOR CONSTRUCTION	
<i>[Signature]</i>	6/11/19
CDOX COMMUNICATIONS LAS VEGAS, INC.	
<i>[Signature]</i>	DATE
Matthew Pedraza	03 Jun 2019
SOUTHWEST GAS CORPORATION	DATE
<i>[Signature]</i>	6/3/19
CENTURY TELEPHONE COMPANY d/b/a CENTURYLINK	
THE AFFIXED CENTURYLINK APPROVAL DOES NOT ASSUME OR GUARANTEE LIABILITY FOR KNOWN OR UNKNOWN CONFLICTS WITH EXISTING OR PROPOSED IMPROVEMENTS. RESOLUTION OF ANY CONFLICT WILL BE ACCOMPLISHED PURSUANT TO LOCAL ORDINANCES, NEVADA REVISED STATUTES AND/OR PUBLIC UTILITY COMMISSION'S RULES AND REGULATIONS.	
<i>[Signature]</i>	06/03/19
Armando Romo	DATE
NV ENERGY	
NV ENERGY ACKNOWLEDGES THAT WE HAVE RECEIVED YOUR PLANS WILL PROVIDE SERVICE TO ALL ELECTRICAL NEEDS ASSOCIATED WITH THIS PROJECT. NV ENERGY RESERVES THE RIGHT TO ADDRESS ANY EXISTING OR FUTURE CONFLICTS ONCE THE FINAL DESIGN IS COMPLETED. THE NEW SERVICE AND THE RESOLUTION OF ANY CONFLICTS WILL BE ACCOMPLISHED PURSUANT TO THE NEVADA PUBLIC UTILITY COMMISSION'S RULES AND REGULATIONS.	
<i>[Signature]</i>	6/11/19
LAS VEGAS FIRE AND RESCUE	DATE

LAS VEGAS VALLEY WATER DISTRICT ENGINEERING SERVICES
 PROJECT# 135681 FIRST APPROVED DATE: 6-29-17
 LVWMD APPROVED FIRE FLOW: 1500 GPM AT 20 PSI RESIDUAL
 MAXIMUM AVAILABLE FIRE SPRINKLER FLOW 26 GPM
 LVWMD APPROVAL IS VALID FOR ONE (1) YEAR FROM THE SIGNATURE DATE. IF CONSTRUCTION
 IS NOT STARTED, PLANS MUST BE RESUBMITTED FOR REVIEW AND APPROVAL.
 SHEETS: C1, C2, P1, UTT

 CITY ENGINEER - ALLEN PAVELKA, PE #5029 DATE 6-24-19
 APPROVAL OF THESE PLANS BY THE CITY ENGINEER IS LIMITED TO THOSE IMPROVEMENTS
 CONSTRUCTED IN THE DEDICATED RIGHT-OF-WAY, AND/OR DEDICATED EASEMENTS. THIS
 APPROVAL DOES NOT AUTHORIZE CONSTRUCTION OF ANY IMPROVEMENTS THAT DEVIATE
 FROM ADOPTED STANDARDS AND/OR SPECIFICATIONS EXCEPT THOSE SPECIFICALLY LISTED
 UNDER DEVIATIONS FROM STANDARDS. THE ENGINEER SHALL RESOLVE ANY DEVIATION
 OTHER THAN THOSE LISTED IN DEVIATIONS FROM STANDARD IN FAVOR OF THE UTM
 STANDARD DRAWINGS AND SPECIFICATIONS, CLARK COUNTY AREA, NEVADA.

 CITY OF LAS VEGAS, PLANNING DEPARTMENT DATE 062419
 THIS PLAN MEETS THE APPLICABLE STANDARDS OF THE PLANNING DEPARTMENT.

SUBDIVISION INFORMATION

ACRES:	1.25 AC
AREA DISTURBED:	0.30 AC
LOTS:	1
LOT SIZE:	10,254 SF
ZONING:	R-SL RESIDENTIAL SMALL LOT DISTRICT
FMP:	N/A
TMP:	N/A
SETBACKS:	
FRONT:	15 FT
REAR:	5 FT
SIDE:	5 FT
CORNER:	15 FT

UTILITY DISCLAIMER

EXISTING UTILITY LOCATIONS SHOWN HEREIN ARE APPROXIMATE ONLY. IT SHALL BE THE CONTRACTORS RESPONSIBILITY TO DETERMINE THE EXACT VERTICAL AND HORIZONTAL LOCATION OF ALL EXISTING UNDERGROUND UTILITIES PRIOR TO COMMENCING CONSTRUCTION. NO REPRESENTATION IS MADE THAT ALL EXISTING UTILITIES ARE SHOWN HEREON. THE ENGINEER ASSUMES NO RESPONSIBILITY FOR UTILITIES NOT SHOWN OR UTILITIES NOT SHOWN IN THEIR EXISTING LOCATIONS.

BASIS OF BEARING

SOUTH 89°00'28" WEST, BEING THE BEARING OF SOUTH LINE OF THE SOUTHEAST QUARTER (SE 1/4) OF THE SOUTHWEST QUARTER (SW 1/4) OF SECTION 24, TOWNSHIP 19 SOUTH, RANGE 59 EAST, M.D.M., CITY OF LAS VEGAS, CLARK COUNTY, NEVADA, AS SHOWN IN BOOK 149 PAGE 30 OF PLATS, CLARK COUNTY, NEVADA, OFFICIAL RECORDS.

BENCHMARK

RIVET AND PLATE TOP CURB SE CORNER ALPINE RIDGE WAY AND CENTENNIAL PARKWAY
ELEVATION: 2856.12


LEGAL DESCRIPTION

BEING A PART OF THE SOUTHEAST QUARTER (SE 1/4) OF THE SOUTHWEST QUARTER (SE 1/4) OF SECTION 24, TOWNSHIP 19 SOUTH, RANGE 59 EAST, M.D.B. & M.

ENGINEER
TANEY ENGINEERING
6030 SOUTH JONES BLVD
LAS VEGAS, NV 89118
(702) 362-8844 PHONE (702) 362-5233 FAX


DEVELOPER
ADAVEN HOMES
3425 CLIFF SHADOWS PKWY
LAS VEGAS, NV 89129
(702) 365-8588

OWNER
ALPINE RIDGE 3 LLC
557 IVY SPRING STREET
LAS VEGAS, NV 89138

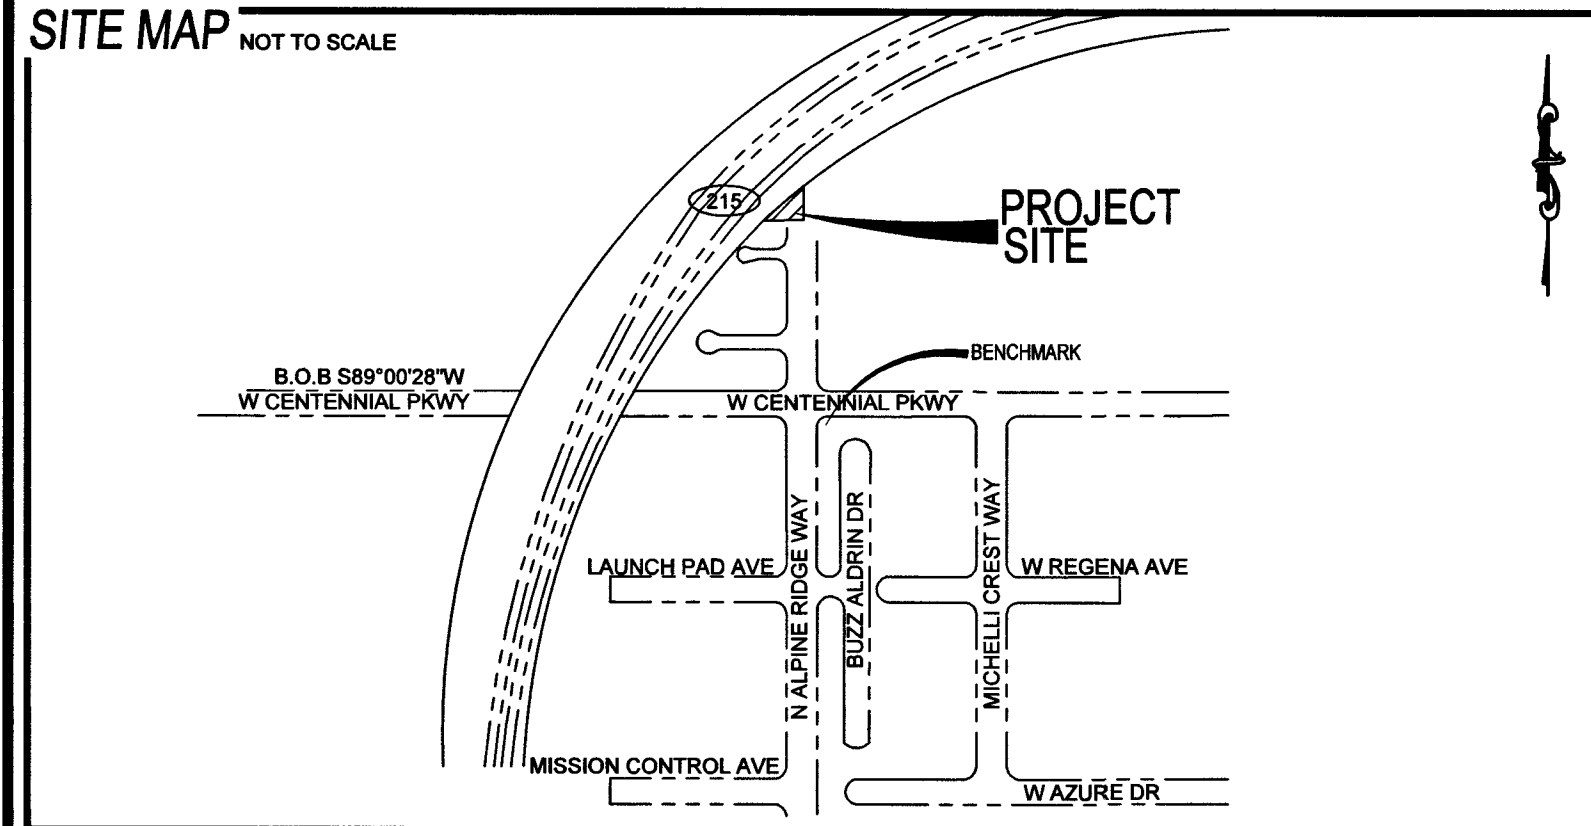

ABBREVIATIONS

AC	ASPHALTIC CONCRETE	EX	EXISTING	PT	POINT OF TANGENCY
ACP	ASBESTOS CEMENT PIPE	FF	FIRST FLOOR ELEVATION	PVC	POLYVINYL CHLORIDE
AVE	AVENUE	FG	FIRST GRADE	R	RADIUS
B	BACK OF CURB	FH	FIRE HYDRANT	RCB	REINFORCED CONCRETE BOX
BCR	BACK OF CURB RADIUS	FL	FLOW LINE	RCR	REINFORCED CONCRETE RCP
BFE	BASE FLOOR ELEVATION	FT	FEET	RW	RIGHT-OF-WAY
BFP	BACK FLOW PREVENTOR	G	GRADING	RT	RIGHT
BLM	BUREAU OF LAND MANAGEMENT	GB	GRADE BREAK	SD	STORM DRAIN
BM	BENCH MARK	GG	GARAGE FINISH FLOOR	SH	SHEET
BO	BOUNDARY	HP	HIGH POINT	SLT	STREETLIGHT
BRPM	BLUE RAISED PAVEMENT MARKER	HFF	HIGH PRESSURE GAS	SNVA	SOUTH NEVADA WATER AUTHORITY
BVC	BEGIN VERTICAL CURVE	INV	INVERT	SS	SANITARY SEWER
BW	BOTTOM OF WALL	LF	LINE FEET	ST	STREET
CC	CABLE TELEVISION	LANE	LANE	STA	STATION
CC	CLARK COUNTY	LS	LANDSCAPE	STD	STANDARD
CCFD	CLARK COUNTY FIRE DEPARTMENT	LT	LEFT	SVZ	SIGHT VISIBILITY ZONE
CCWR	CLARK COUNTY WATER RECLAMATION DISTRICT	LV	LAS VEGAS VALLEY WATER DISTRICT	SW	SIDEWALK
CL	CENTERLINE	MAX	MAXIMUM	SY	SQUARE YARD
CLSM	CONTROLLED LOW STRENGTH MATERIAL	MH	MANHOLE	T	TOP OF CURB
CLV	CITY OF LAS VEGAS	MIN	MINIMUM	TELE	TELEPHONE
CM	CORRUGATED METAL PIPE	NO	NUMBER	TF	TOP OF FOOTING
CNLY	CITY OF NORTH LAS VEGAS	NTS	NOT TO SCALE	T.O.P.	TOP OF PIPE
CO	CLEAN OUT, SEWER	OC	ON CENTER	TR	TOP OF RETAINING
CO	CITY OF HENDERSON	PB	PULL BOX	TW	TOP OF WALL
CY	CUBIC YARD	PC	POINT OF CURVE	TY	TYPICAL
DCSGWS	DESIGN AND CONSTRUCTION STANDARDS FOR WATER-CONCRETE DRAINAGE SYSTEMS	PCC	POINT OF COMPOUND CURVE	UDACS	UNIFORM DESIGN AND CONSTRUCTION STANDARDS
DG	DECOMPOSED GRANITE	PE	POLYETHYLENE	UT	UTILITY
DI	DRAIN INLET	PL	PROPERTY LINE	USD	UNIFORM STANDARD DRAWING
DIR	DUCTILE IRON PIPE	PLT	PLATE	VCB	VERTICAL CURVE
DR	DRAIN	POL	POINT OF CONNECTION	VCP	VITRIFIED CLAY PIPE
EG	END OF CURVE	PP	POWER POLE	VG	VALLEY GUTTER
EX	EXISTING GRADE	P&P	PLAN AND PROFILE	W	WATER
ELEC	ELECTRICAL	PRC	POINT OF REVERSE CURVE	ZC	ZERO LIP CURB
EP	EDGE OF PAVEMENT	PROJ	PROJECT		
EVC	END VERTICAL CURVE	PRV	PRESSURE REDUCING VALVE		

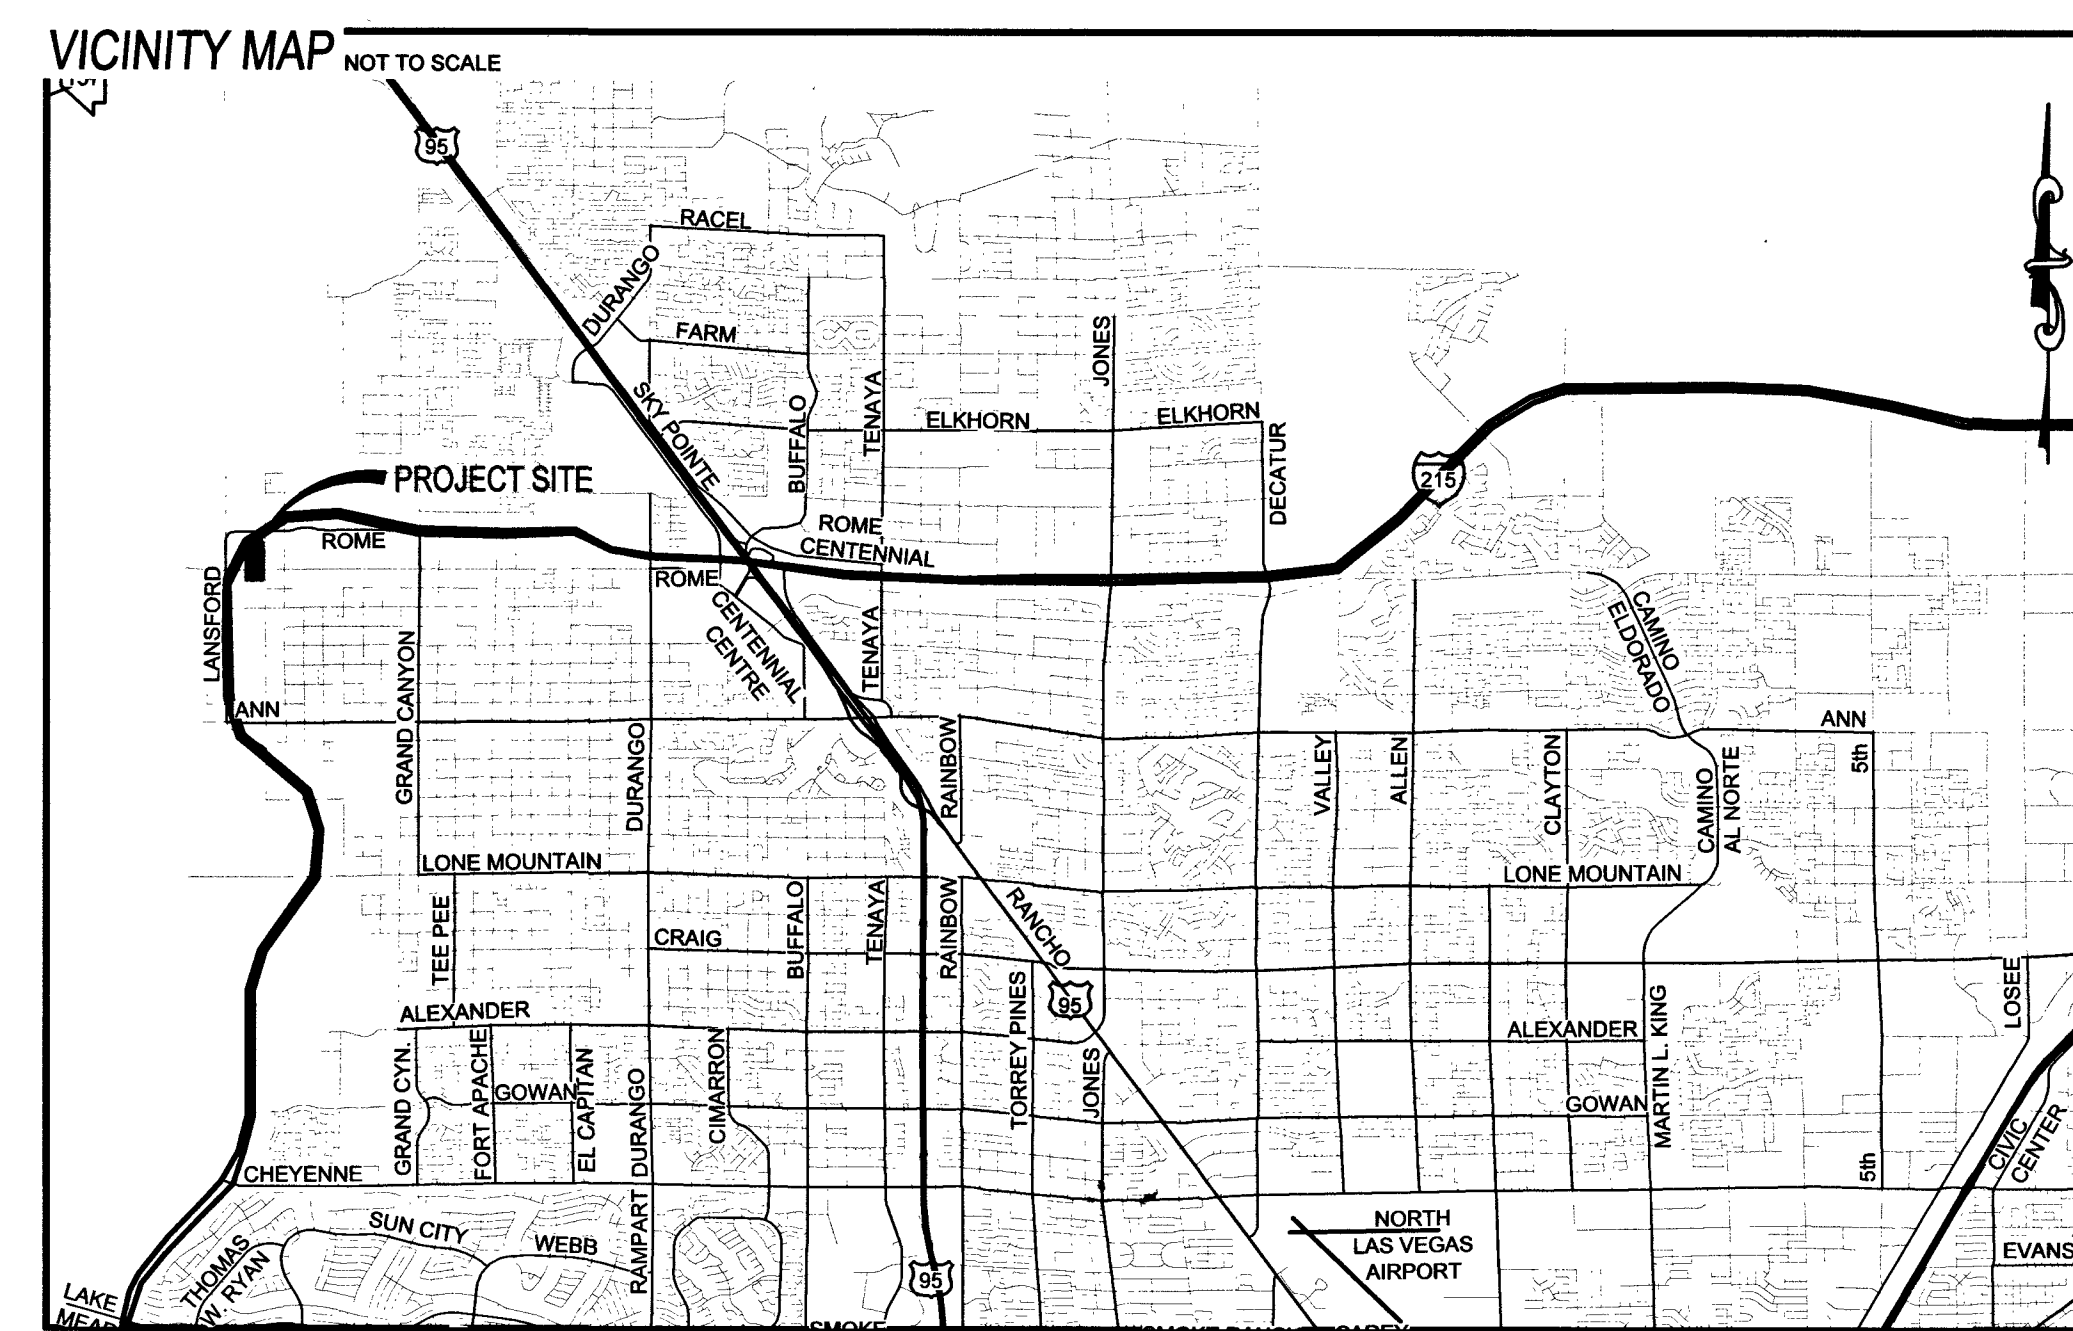

LAST PLOT: Mohit Khadka

CLV GENERAL NOTES

1. ALL CONSTRUCTION AND MATERIALS SHALL BE IN ACCORDANCE WITH THE "UNIFORM STANDARD SPECIFICATIONS FOR PUBLIC WORKS CONSTRUCTION OFF-SITE IMPROVEMENTS, CLARK COUNTY, NEVADA AREA", LATEST ISSUE, THE "UNIFORM STANDARD DRAWINGS FOR PUBLIC WORKS CONSTRUCTION, CLARK COUNTY AREA, NEVADA", LATEST REVISED EDITION, THE "SUMMERLIN IMPROVEMENT STANDARDS" FOR WORK IN THE SUMMERLIN AREA, AND OTHER APPLICABLE APPROVED STANDARDS ISSUED BY THE CONTROLLING AGENCY, THE "UNIFORM BUILDING CODE, AND ALL LOCAL CITY CODES AND ORDINANCES APPLICABLE, EXCEPT AS NOTED ON THIS SHEET AS "DEVIATIONS FROM STANDARDS".
2. THE EXISTENCE AND LOCATION OF ANY OVERHEAD OR UNDERGROUND UTILITY LINES, PIPES, OR STRUCTURES SHOWN ON THESE PLANS ARE OBTAINED BY A RESEARCH OF THE AVAILABLE RECORDS. EXISTING UTILITIES AS SHOWN FROM CLV PLANS LIBRARY ARE APPROXIMATE AND FOR RECORD PURPOSES. EXISTING UTILITIES ARE LOCATED ON PLANS ONLY FOR THE CONVENIENCE OF THE CONTRACTOR. EXISTING UTILITY SERVICE LATERALS MAY NOT BE SHOWN ON THE PLANS. THE CONTRACTOR SHALL, AT HIS OWN EXPENSE, LOCATE ALL UNDERGROUND AND OVERHEAD INTERFERENCES WHICH MAY AFFECT HIS OPERATION DURING CONSTRUCTION AND SHALL TAKE ALL NECESSARY PRECAUTIONS TO AVOID DAMAGE TO SAME. THE CONTRACTOR SHALL USE EXTREME CAUTION WHEN WORKING NEAR OVERHEAD UTILITIES SO AS TO SAFELY PROTECT ALL PERSONNEL AND EQUIPMENT, AND SHALL BE RESPONSIBLE FOR ALL COST AND LIABILITY IN CONNECTION THEREWITH.
3. THE CONTRACTOR SHALL TAKE ALL PRECAUTIONARY MEASURES NECESSARY TO PROTECT EXISTING UTILITY LINES, STRUCTURES, AND STREET IMPROVEMENTS WHICH ARE TO REMAIN IN PLACE, FROM DAMAGE, AND ALL SUCH IMPROVEMENTS OR STRUCTURES DAMAGED BY THE CONTRACTOR'S OPERATIONS SHALL BE REPAIRED OR REPLACED SATISFACTORY TO THE CITY ENGINEER AND OWNING UTILITY COMPANY AT THE EXPENSE OF THE CONTRACTOR.
4. ALL CONSTRUCTION SHALL BE AS SHOWN ON THESE PLANS. ANY REVISIONS SHALL HAVE THE PRIOR WRITTEN APPROVAL OF THE CITY ENGINEER.
5. TYPE V CEMENT SHALL BE USED IN ALL OFF-SITE WORK. CONCRETE TO BE 3000 P.S.I. MINIMUM @ 28 DAYS. MIX DESIGN TO BE APPROVED BY THE CITY. PRIOR TO USE ON THE PROJECT.
6. PERMITS ARE REQUIRED FOR ANY WORK IN THE PUBLIC RIGHT-OF-WAY. THE CONTRACTOR SHALL SECURE ALL PERMITS AND INSPECTIONS REQUIRED FOR THIS CONSTRUCTION.
7. EXPANSION JOINTS REQUIRED, MAXIMUM OF EVERY 300' IN EXTRUDED-TYPE CURB.
8. AC PAVEMENT TO BE ONE-HALF INCH (1/2") ABOVE LIP OF ALL GUTTERS AFTER COMPACTION, EXCEPT AT SIDEWALK RAMPS AND CROSS GUTTERS.
9. CURB AND GUTTER FOUND TO BE UNACCEPTABLE TO THE CITY OF LAS VEGAS SHALL BE REMOVED AND REPLACED PER STANDARD DRAWING 216.
10. SIDEWALK RAMPS SHALL BE CONSTRUCTED IN EACH QUADRANT OF AN INTERSECTION PER STANDARD DRAWING 235. EXACT LOCATION OF RAMPS MAY BE ADJUSTED IN THE FIELD BY A CITY INSPECTOR.
11. CONTRACTOR SHALL PROVIDE ALL NECESSARY HORIZONTAL AND VERTICAL TRANSITIONS BETWEEN NEW CONSTRUCTION AND EXISTING SURFACES TO PROVIDE FOR PROPER DRAINAGE AND FOR RECORD PURPOSES AND EGRESS TO NEW CONSTRUCTION. THE EXTENT OF TRANSITIONS TO BE AS SHOWN ON PLANS.
12. ALL GRADING WORK SHALL CONFORM TO THE SOILS REPORT AS PREPARED BY THE (COMPANY, REPORT#, DATE) APPROVED BY THE CITY ENGINEER, AND AS SHOWN ON THESE PLANS.
13. EXACT LOCATION OF ALL SAWCUT LINES MAY BE ADJUSTED OR DETERMINED IN THE FIELD BY A CITY OF LAS VEGAS ENGINEER IF LOCATION ON PLANS IS NOT CLEARLY SHOWN, OR EXISTING PAVEMENT CONDITION REQUIRES RELOCATIONS.
14. THE CONTRACTOR SHALL TAKE ALL PRECAUTIONS NECESSARY TO PROTECT EXISTING PERMANENT SURVEY MONUMENTS. ANY MONUMENTS DISTURBED SHALL BE REPLACED AND ADJUSTED PER AVAILABLE RECORDS IN ACCORDANCE WITH N.R.S. STATUTE NO. 625.380 & CITY OF LAS VEGAS TITLE 16, APPENDIX D.
15. UTILITY COMPANY METER BOXES, MANHOLE LIDS, VALVE COVERS, ETC. SHALL BE LOCATED OUT OF DRIVEWAYS, DRIVEWAY APRONS, FLOWLINES, AND CROSS GUTTERS UNLESS WRITTEN APPROVAL IS GRANTED BY THE UTILITY COMPANY AND THE CITY ENGINEER.

WALL NOTES:

16. ALL WALLS, NEW OR EXISTING, ARE ONLY SHOWN ON CIVIL PLANS FOR THE PURPOSE OF REVIEWING GRADING RELATIONSHIPS, FLOOD CONTROL, AND SIGHT DISTANCE AT INTERSECTIONS. NEW WALLS REQUIRE A SEPARATE PERMIT AND INSPECTION BY THE BUILDING DEPARTMENT.
17. ASPHALT MIX DESIGN MUST BE SUBMITTED AND APPROVED BY THE CITY ENGINEER PRIOR TO THE PLACEMENT OF ASPHALT WITHIN CITY RIGHT OF WAY.
18. CONTRACTOR SHALL ADJUST ALL NEW AND EXISTING INLETS, VALVE BOXES, MANHOLE RIMS, AND SEWER CLEANOUTS, ETC. TO FINISH GRADE AS APPLICABLE, WHETHER OR NOT THEY ARE SHOWN ON THE PLANS.
19. MATERIALS, HANDLING, AND PLACEMENT OF PORTLAND CEMENT CONCRETE SHALL BE IN ACCORDANCE WITH APPLICABLE SECTIONS OF MDTI OR THE CLARK COUNTY AREA SPECIFICATIONS (AS APPLICABLE) AND THE PLANS AND DETAILS SHOWN HEREON.
20. WHEN INSTALLING UNDERGROUND FACILITIES THAT REQUIRE UNDERGROUND LOCATING DEVICES SUCH AS MARKER BALLS, LOCATING RIBBON, ETC. THE CONTRACTOR SHALL PROVIDE WRITTEN DOCUMENTATION TO OFFSITE INSPECTION AND TESTING CERTIFYING THAT ALL DEVICES HAVE BEEN PLACED AND VERIFIED TO BE IN GOOD WORKING CONDITION PRIOR TO THE CONSTRUCTION OF ANY ROAD BASE.
21. AFTER HAUNCHING AND PRIOR TO BACKFILL OPERATIONS WHICH WOULD COVER SANITARY SEWER AND STORM DRAIN FACILITIES, CONTRACTOR IS REQUIRED TO SCHEDULE CLV OPEN-TRENCH UTILITY SURVEY INSPECTION FOR DETERMINATION OF FINAL LOCATION COORDINATES. FACILITIES TO BE LOCATED BY CLV SHALL INCLUDE AT A MINIMUM THE HORIZONTAL AND VERTICAL (INVERT) LOCATION OF PUBLIC SEWER MANHOLES, STORM DRAIN MANHOLES AND TRANSITION STRUCTURES, STORM DRAIN LATERALS AT THE CONNECTION TO THE STORM DRAIN MAIN AND AT THE CONNECTION TO A DROP INLET, THE CONNECTION OF SEWER SERVICE LATERALS TO THE MAIN AND THE SEWER SERVICE LATERALS EXIT TO THE SEWER MAINS, AND THE PUBLIC RIGHT-OF-WAY, SEWER AND STORM DRAIN MAIN ALIGNMENT, INCLUDING DEFLECTION POINTS.
22. CCTV VIDEO INSPECTION IS REQUIRED FOR ALL SEWER AND STORM DRAINS. THE CCTV VIDEO INSPECTIONS NEED TO BE PERFORMED PER THE DESIGN AND CONSTRUCTION STANDARDS FOR WASTEWATER COLLECTION SYSTEMS LATEST EDITION.
23. A SEPARATE BORING PERMIT IS REQUIRED FOR ALL BORING ACTIVITIES.

CLV STREETLIGHT NOTES

1. ALL STREET LIGHTING INSTALLATION SHALL BE IN ACCORDANCE WITH THE STREET LIGHTING PLANS, THE "UNIFORM STANDARD SPECIFICATIONS FOR PUBLIC WORKS CONSTRUCTION OFF-SITE IMPROVEMENTS, CLARK COUNTY, NEVADA AREA", LATEST REVISION, AND THE "UNIFORM STANDARD DRAWINGS FOR PUBLIC WORKS CONSTRUCTION OFF-SITE IMPROVEMENTS, CLARK COUNTY, NEVADA AREA", LATEST REVISION.
2. NO DEVIATION OF STREET LIGHT, PULL BOX, CONDUITS, ETC., LOCATIONS SHALL BE PERMITTED WITHOUT WRITTEN APPROVAL OF THE TRAFFIC/ELECTRICAL FIELD OPERATIONS DIVISION AND THE CONSTRUCTION PROJECT REPRESENTATIVE. ANY DEVIATION FROM THE PLAN LOCATION WILL REQUIRE COMPLIANCE WITH SECTION 623.10.03 (E) OF THE SPECIFICATIONS.
3. ALL EXISTING STREET LIGHTING SHALL REMAIN OPERATIONAL DURING CONSTRUCTION.
4. ALL EMPT CONDUIT SHALL HAVE PULL STRINGS INSTALLED PRIOR TO FINAL INSPECTION.
5. ANY STRUCTURE, SUCH AS BLOCK WALLS, CHAIN LINK FENCES, RETAINING WALLS, ETC., SHALL LEAVE A MINIMUM OF EIGHTEEN INCHES (18") TO THE FACE OF STREET LIGHTING POLE ON ALL SIDES WHEN STREET LIGHT IS INSTALLED BETWEEN SIDEWALK AND SHALL AT NO TIME COMPLETELY ENCLOSE THE STREET LIGHTING POLE.
6. AS-BUILT DRAWINGS SHALL BE SUPPLIED TO THE ELECTRICAL SERVICES SECTION PRIOR TO ANY PRE-FINAL INSPECTION. THE AS-BUILT DRAWINGS SHALL BE STAMPED AS-BUILT AND SIGNED BY THE PREPARER.
7. SERVICE POINTS SHALL BE COORDINATED WITH NEVADA POWER COMPANY, AND WHEREVER POSSIBLE, SHALL BE LOCATED NEAR THE CENTER OF THE CIRCUIT. SERVICE POINTS SHALL BE SHOWN ON THE PLANS.
8. IT SHALL BE ASSUMED THAT IN THE ABSENCE OF AN EXISTING, WORKABLE CIRCUIT TO ATTACH TO, ALL INSTALLATIONS SHALL REQUIRE A NEW SERVICE FOR OPERATION OF THE CIRCUIT.
9. WHEREVER THERE IS AN OVERHEAD UTILITY THAT MAY CONFLICT WITH THE INSTALLATION OF STREET LIGHTING CIRCUITS AND/OR POLES, THESE CONFLICTS MUST BE RESOLVED BETWEEN THE DEVELOPER AND THE UTILITIES INVOLVED BEFORE STREET LIGHT BASES ARE INSTALLED AT NO EXPENSE TO THE CITY OF LAS VEGAS.
10. THE CONTRACTOR SHALL FURNISH COMPLETE SERVICE TO TRANSFORMERS AND CONTROL SYSTEMS IF REQUIRED ON THE PLANS.

LEGAL DESCRIPTION

BEING A PART OF THE SOUTHEAST QUARTER (SE 1/4) OF THE SOUTHWEST QUARTER (SE 1/4) OF SECTION 24, TOWNSHIP 19 SOUTH, RANGE 59 EAST, M.D.B. & M.

EARTHWORK

TOTAL FOR OVERALL DEVELOPMENT: 72 CY CUT / 154 CY FILL / 82 CY NET (FILL)

NOTE: THIS OPINION OF THE CUT AND FILL QUANTITIES IS PROVIDED AS REQUIRED BY THE GOVERNING ENTITY. THIS INFORMATION SHOULD NOT BE USED FOR BIDDING PURPOSES. ALL CONTRACTORS ARE RESPONSIBLE FOR THEIR OWN QUANTITIES. THESE TOTALS ARE RAW AND DO NOT ACCOUNT FOR SHRINKAGE AND SUSSIDENCE.

CLV TRAFFIC NOTES

1. ALL CONSTRUCTION SIGNING, BARRICADE, AND TRAFFIC DELINEATION SHALL CONFORM TO THE "MANUAL OF UNIFORM TRAFFIC CONTROL DEVICES", LATEST EDITION.
2. THE STREET SIGN CONTRACTOR SHALL OBTAIN STREET NAMES AND BLOCK NUMBERING FROM THE PLANNING DEPARTMENT PRIOR TO CONSTRUCTION.
3. BEFORE ANY WORK IS STARTED IN THE RIGHT-OF-WAY, THE CONTRACTOR SHALL INSTALL ALL ADVANCE WARNING SIGNS FOR THE CONSTRUCTION ZONES. THE CONTRACTOR SHALL INSTALL TEMPORARY STOP SIGNS AT ALL NEW STREET ENCROACHMENT INTO EXISTING CITY STREETS WHERE WARRANTED IMMEDIATELY AFTER GRADING WORK IS ACCOMPLISHED, AND SHALL MAINTAIN SAID SIGNS UNTIL PERMANENT SIGNS ARE INSTALLED.
4. WHEN A DESIGNATED "SAFE ROUTE TO SCHOOL" IS ENCLOSED UPON BY A CONSTRUCTION WORK ZONE AND PUBLIC WORKS STAFF IDENTIFIED A NEED FOR STUDENTS TO BE ASSISTED IN THE SAFE CROSSING THROUGH THAT WORK ZONE, THE CONTRACTOR SHALL BE REQUIRED TO PROVIDE A QUALIFIED "CROSSING GUARD". THE GUARD SHALL BE PRESENT FOR THE FULL DURATION OF TIME THAT CHILDREN ARE LIKELY TO BE PRESENT.
5. IF THE IMPROVEMENTS NECESSITATE THE OBLITERATION, TEMPORARY OBSTRUCTION, TEMPORARY REMOVAL, OR RELOCATION OF ANY EXISTING TRAFFIC PAVEMENT MARKING, SUCH PAVEMENT MARKING SHALL BE RESTORED OR REPLACED WITH LIKE MATERIALS TO THE SATISFACTION OF THE CITY TRAFFIC ENGINEER.
6. THE CONTRACTOR SHALL BE RESPONSIBLE FOR PROVIDING AND INSTALLING ALL PERMANENT SIGNS SHOWN ON THESE PLANS. STREET NAME SIGNS SHALL BE INSTALLED IN THEIR ENTIRETY TO CURRENT CITY STANDARDS. ALL OTHER SIGNS SHALL BE STANDARD SIZE UNLESS OTHERWISE SPECIFIED ON THE PLANS. ALL SIGN POSTS SHALL BE INSTALLED IN ACCORDANCE WITH THE CURRENT CITY STANDARDS.
7. WHEN A PROPOSED STREET LIGHT STANDARD IS LOCATED WITHIN FIVE FEET (5') OF ANY PROPOSED SIGN SHOWN ON THE PLANS TO BE MOUNTED ON A SIGN POST, THE SIGN SHALL BE MOUNTED ON THE STREET LIGHT STANDARD AND THE SIGN POST SHALL BE ELIMINATED.
8. ALL PERMANENT TRAFFIC CONTROL DEVICES CALLED FOR HEREON SHALL BE IN PLACE AND IN FINAL POSITION PRIOR TO ALLOWING ANY PUBLIC TRAFFIC ONTO THE PORTIONS OF THE ROAD(S) BEING IMPROVED HEREUNDER, REGARDLESS OF THE STATUS OF COMPLETION OF PAVING OR OTHER OFF-SITE IMPROVEMENTS CALLED FOR BY THESE PLANS.
9. STREET SIGNS AND STOP SIGNS SHALL BE INSTALLED PER CITY STANDARD SPECIFICATIONS FOR PLACEMENT OF STREET NAME SIGNS.
10. THE CONTRACTOR SHALL PROVIDE ALL NECESSARY TRAFFIC CONTROL DEVICES AND FLAGGERS TO EQUIPMENT AND FLAG PERSONS NECESSARY TO ENSURE THE SAFETY OF THE PUBLIC IN AND AROUND THE WORK AREA. THE CONTRACTOR SHALL HAVE A CERTIFIED TRAFFIC CONTROL TECHNICIAN OR IMSA WORK ZONE SAFETY SPECIALIST SET UP, MAINTAIN AND/OR REMOVE ALL TRAFFIC CONTROL DEVICES IN THE CITY OF LAS VEGAS RIGHTS-OF-WAY.
11. WORK IN PUBLIC STREETS, ONCE BEGUN, SHALL BE EXPEDITED TO COMPLETION SO AS TO PROVIDE MINIMUM INCONVENIENCE TO ADJACENT PROPERTY OWNERS AND TO THE TRAVELING PUBLIC.
12. THE CONTRACTOR SHALL BE RESPONSIBLE FOR NOTIFYING CITIZEN AREA TRANSIT (C.A.T.) IF THE CONSTRUCTION INTERRUPTS OR RELOCATES A BUS STOP OR HAS AN ADVERSE EFFECT ON BUS SERVICE ON THAT STREET AND SHALL ARRANGE FOR TEMPORARY RELOCATION OF THE STOP.
13. GUARDS SHALL BE OBTAINED BY CONTACTING THE METROPOLITAN POLICE DEPARTMENT SPECIAL EVENTS UNIT (PHONE NO. 229-3442) WHO WILL PROVIDE OFFICERS PROPERLY TRAINED IN TRAFFIC CONTROL. FEES FOR THE USE OF THESE OFFICERS SHALL BE SET BY METRO AND WILL BE PAID BY THE CONTRACTOR. THE CONTRACTOR IS RESPONSIBLE FOR ALL ARRANGEMENTS WITH METRO.
14. ALL WORK WITHIN 300' OF A SIGNALIZED INTERSECTION WILL BE NIGHT WORK, UNLESS DIRECTED BY THE CITY OF LAS VEGAS TRAFFIC ENGINEER.
15. CONTRACTOR SHALL CONTACT THE TRAFFIC ENGINEERING DIVISION (TRANSPORTATION SECTION) THROUGH THE PROJECT'S OFFSITE INSPECTOR PRIOR TO INITIATING PAVING TO RECEIVE DIRECTION FOR ANY PERMANENT OR TEMPORARY MODIFICATIONS TO THE APPROVED DRAWINGS REGARDING FINAL PAVEMENT TRANSITIONS, MARKINGS AND SIGNING THAT ARE REQUIRED TO MATCH ADJACENT ROADWAY SEGMENTS. THE CONTRACTOR SHALL PROVIDE A DRAWING FOR APPROVAL BY THE TRAFFIC ENGINEERING DIVISION DEPICTING ANY ADJUSTMENTS TO THE FINAL PAVEMENT MARKINGS AND SIGNAGE, WHICH MAY INCLUDE THE REMOVAL OF THE EXISTING PAVEMENT MARKINGS AND TRAFFIC CONTROL SIGNS SUCH THAT ADEQUATE TRANSITIONS AND LANE TERMINATIONS BETWEEN ADJACENT ROADWAY SEGMENTS ARE CONSTRUCTED.

CLV GRADING NOTES

1. IN THE EVENT THAT ANY UNFORESEEN CONDITIONS NOT COVERED BY THESE NOTES ARE ENCOUNTERED DURING GRADING OPERATIONS, THE OWNER/ENGINEER SHALL BE IMMEDIATELY NOTIFIED FOR DIRECTION.
2. IT SHALL BE THE RESPONSIBILITY OF THE CONTRACTOR TO PERFORM ALL NECESSARY CUTS AND FILLS WITHIN THE LIMITS OF THIS PROJECT AND THE RELATED OFF-SITE WORK, SO AS TO GENERATE THE DESIRED SUBGRADE, FINISH GRADES AND SLOPES SHOWN.
3. CONTRACTOR SHALL TAKE FULL RESPONSIBILITY FOR ALL EXCAVATION, ADEQUATE SHORING SHALL BE DESIGNED AND PROVIDED BY THE CONTRACTOR TO PREVENT UNDERMINING OF ANY ADJACENT FEATURES OR FACILITIES AND/OR CAVING OF EXCAVATION.
4. THE CONTRACTOR IS WARNED THAT AN EARTHWORK BALANCE WAS NOT NECESSARILY THE INTENT OF THIS PROJECT. ANY ADDITIONAL MATERIALS REQUIRED OR EXCESSIVE MATERIAL FOLLOWING EARTHWORK OPERATIONS BECOMES THE RESPONSIBILITY OF THE CONTRACTOR.
5. THE GRADING CONTRACTOR IS RESPONSIBLE TO COORDINATE WITH THE OWNER TO PROVIDE FOR THE ELEMENTS OF THE PROJECT STORM WATER POLLUTION PREVENTION PLAN (SWPPP) AND ASSOCIATED PERMIT.
6. THE CONTRACTOR SHALL GRADE TO THE LINES AND ELEVATIONS SHOWN ON THE PLANS WITHIN THE FOLLOWING HORIZONTAL AND VERTICAL TOLERANCES AND DEGREES OF COMPACTION IN THE AREAS INDICATED:

	HORIZONTAL	VERTICAL	COMPACTION
A. PAVEMENT AREA SUBGRADE	±0.1"	±0.1"	SEE SOILS REPORT
B. ENGINEERED FILL	0.5"	±0.1" TO ±0.1"	SEE SOILS REPORT

 COMPACTION TESTING WILL BE PERFORMED BY THE OWNER OR HIS REPRESENTATIVE.
7. ALL CUT AND FILL SLOPES SHALL BE PROTECTED UNTIL EFFECTIVE EROSION CONTROL HAS BEEN ESTABLISHED.
8. THE USE OF POTABLE WATER WITHOUT A SPECIAL PERMIT FOR BUILDING OR CONSTRUCTION PURPOSES INCLUDING CONSOLIDATION OF BACKFILL OR DUST CONTROL IS PROHIBITED. THE CONTRACTOR SHALL OBTAIN ALL NECESSARY PERMITS FOR CONSTRUCTION WATER.
9. THE CONTRACTOR SHALL MAINTAIN THE STREETS, SIDEWALKS, AND ALL OTHER PUBLIC RIGHT-OF-WAY IN A CLEAN, SAFE, AND USABLE CONDITION. ALL SPILLS OF SOIL, ROCK, OR CONSTRUCTION DEBRIS SHALL BE PROMPTLY REMOVED FROM THE PUBLICLY OWNED PROPERTY DURING CONSTRUCTION AND UPON COMPLETION OF THE PROJECT. ALL ADJACENT PROPERTY, PRIVATE OR PUBLIC SHALL BE MAINTAINED IN A CLEAN, SAFE, AND USABLE CONDITION.
10. IN THE EVENT THAT ANY TEMPORARY CONSTRUCTION ITEM IS REQUIRED THAT IS NOT SHOWN ON THESE DRAWINGS, THE OWNER AGREES TO PROVIDE AND INSTALL SIGNS AT AND AT THE DISCRETION AND DIRECTION OF THE CITY ENGINEER. TEMPORARY CONSTRUCTION INCLUDES DITCHES, BERMS, ROAD SIGNS, BARRICADES, ETC.

STORMWATER RUNOFF MANAGEMENT NOTES

1. THE OWNER, SITE DEVELOPER, CONTRACTOR AND/OR THEIR AUTHORIZED AGENTS SHALL EACH DAY REMOVE ALL SEDIMENT, MUD, CONSTRUCTION DEBRIS, OR OTHER POTENTIAL POLLUTANTS THAT MAY HAVE BEEN DISCHARGED, OR ACCUMULATE IN, THE PUBLIC RIGHTS OF WAY OF CLARK COUNTY AS A RESULT OF CONSTRUCTION ACTIVITIES ASSOCIATED WITH THIS SITE DEVELOPMENT OR CONSTRUCTION PROJECT, SUCH MATERIALS SHALL BE PREVENTED FROM ENTERING THE STORM SEWER SYSTEM.
2. ADDITIONAL CONSTRUCTION SITE DISCHARGE BEST MANAGEMENT PRACTICES MAY BE REQUIRED OF THE OWNER AND HIS OR HER AGENTS DUE TO UNFORESEEN EROSION PROBLEMS OR IF THE SUBMITTED PLAN DOES NOT MEET THE PERFORMANCE STANDARDS SPECIFIED IN CLARK COUNTY TITLE 24.40 AND THE LAS VEGAS VALLEY CONSTRUCTION SITE BEST MANAGEMENT PRACTICES MANUAL.
3. TEMPORARY OR PERMANENT STABILIZATION PRACTICES WILL BE INSTALLED ON DISTURBED AREAS AS SOON AS PRACTICABLE AND NO LATER THAN 14 DAYS AFTER THE CONSTRUCTION ACTIVITY IN THAT PORTION OF THE SITE HAS TEMPORARILY CEASED OR PERMANENTLY CEASED. SUCH PRACTICES MAY APPLY, REFER TO CLARK COUNTY STORMWATER GENERAL PERMIT FOR CONSTRUCTION ACTIVITY NVR100000, SECTION III.A.5.
4. AT A MINIMUM, THE CONTRACTOR R HIS AGENT SHALL INSPECT ALL DISTURBED AREAS, AREAS USED FOR STORAGE OF MATERIALS AND EQUIPMENT THAT ARE EXPOSED TO PRECIPITATION, VEHICLE ENTRANCE AND EXIT LOCATIONS AND ALL BMPs WEEKLY, AND WITHIN 24 HOURS AFTER AND ACTUAL RAIN EVENT OF 0.5 INCHES OR MORE. THE CONTRACTOR OR HIS AGENT SHALL UPDATE HIS AGENT OF ANY STORMWATER POLLUTION PREVENTION PLAN AS NECESSARY. SOME EXCEPTIONS MAY APPLY, SUCH AS SUSPENSION OF LAND DISTURBANCE ACTIVITIES. REFER TO NEVADA STORMWATER GENERAL PERMIT FOR CONSTRUCTION ACTIVITY NVR100000, SECTION III.A.12.
5. ACCUMULATED SEDIMENT IN BMPs SHALL BE REMOVED WITHIN SEVEN DAYS AFTER A STORMWATER RUNOFF EVENT OR PRIOR TO THE NEXT ANTICIPATED STORM EVENT, WHICHEVER IS EARLIER. SEDIMENT MUST BE REMOVED WHEN BMP DESIGN CAPACITY HAS BEEN REDUCED BY 50 PERCENT OR MORE.

SOUTHERN NEVADA SOUTHWEST GAS CORP. GENERAL NOTES

1. IN THE EVENT OF NATURAL GAS EMERGENCIES CALL 911 AND 1-877-860-6020.
2. MINIMUM HORIZONTAL AND VERTICAL CLEARANCES BETWEEN NATURAL GAS FACILITIES AND ANY UNDERGROUND UTILITIES AND/OR STRUCTURES, INCLUDING BUT NOT LIMITED TO WATER, SEWER, STORM DRAIN, COMMUNICATIONS, AND ELECTRIC SHALL BE AT LEAST 12 INCHES OR GREATER AS DICTATED BY LOCAL CODES AND STANDARDS.
 A) ANY DEVIATION FROM SPECIFIED MINIMUM CLEARANCES MUST BE APPROVED BY ALL AFFECTED UTILITIES AND/OR MUNICIPALITIES.
3. FOR VALVE ADJUSTMENT CONTACT 702-668-6107 48 HOURS PRIOR TO CONSTRUCTION.
4. IN THE EVENT OF A NATURAL GAS CONFLICT WITH PROPOSED UTILITIES AND/OR STRUCTURES CONTACT 702-365-2089.
5. SWG STANDARD CONTACT NUMBER: (702) 400-1789

SOUTHWEST GAS CORPORATION DATE 6.3.19

CLV FIRE DEPARTMENT NOTES

1. ALL WORK SHALL BE DONE IN STRICT ACCORDANCE WITH THE LAS VEGAS FIRE AND RESCUE ADOPTED FIRE CODE ORDINANCE # 631 FOR HYDRANT SPECIFICATIONS AND HYDRANT INSTALLATION SPECIFICATIONS.
2. ONLY FIRE HYDRANTS THAT ARE ON THE LAS VEGAS VALLEY WATER DISTRICTS - APPROVED PRODUCTS LIST ARE ALLOWED TO BE INSTALLED.
3. A PERMIT IS REQUIRED FROM LAS VEGAS FIRE AND RESCUE FOR THE INSTALLATION OF ON-SITE WATER LINES AND FIRE HYDRANTS. THE PERMIT AND CONTRACTORS MATERIAL TEST CERTIFICATE FOR UNDERGROUND PIPING FORM SHALL BE OBTAINED FROM THE FIRE PROTECTION ENGINEER BEFORE COMMENCEMENT OF WORK. IFC § 105.6.15
4. ON ANY RESIDENTIAL OR COMMERCIAL INSTALLATIONS, FIRE HYDRANTS SHALL BE INSTALLED AND FIRE APPARATUS ACCESS ROADS SHALL BE MAINTAINED BEFORE COMMENCEMENT OF ANY COMBUSTIBLE CONSTRUCTION. ALL FIRE HYDRANTS SHALL BE IN GOOD WORKING ORDER AND SHALL BE CAPABLE OF DELIVERING THE REQUIRED FIRE FLOW. IFC § 3310, IFC § 3312
5. TO IDENTIFY THE FIRE HYDRANT LOCATIONS, THE CONTRACTOR SHALL PLACE A BLUE REFLECTIVE MARKER AT THE CENTER LINE OF THE STREET ADJACENT TO THE FIRE HYDRANTS. IFC § 507.5.7.3
6. ALL UNDERGROUND INSPECTIONS, PRESSURE AND FLUSH VERIFICATIONS OF ALL FIRE HYDRANTS AND FIRE LINES, SHALL BE CONDUCTED BEFORE COVERING THE LINES. CENTER LOADING IS ACCEPTABLE FOR THE HYDRO TESTS WITH PRIOR FIRE PREVENTION APPROVAL. IFC § 106.3
7. ALL ON-SITE UNDERGROUND WATER MAINS AND MATERIALS SHALL BE U.L. LISTED, A.W.W.A. APPROVED AND SHALL BE RATED FOR THE APPROPRIATE WORKING PRESSURE. IFC § 507.2.1, NFPA 24
8. PAINTING OF CURBS, FIRE HYDRANTS, PADS, PROTECTION OF FIRE HYDRANTS FROM PHYSICAL DAMAGE, AND ALL OTHER WORK NECESSARY PER PLANS SHALL BE COMPLETED BEFORE APPROVAL BY LAS VEGAS FIRE AND RESCUE, FIRE PREVENTION DIVISION. IFC § 507
9. PRIVATE HYDRANTS SHALL BE PAINTED RED. IFC § 507.5.7.1
10. PRIOR TO THE FINAL OCCUPANCY, A FIRE FLOW TEST SHALL BE WITNESSED BY LAS VEGAS FIRE AND RESCUE, FIRE PREVENTION DIVISION TO VERIFY AVAILABILITY OF THE REQUIRED FIRE FLOW. IFC § 507
11. FIRE HYDRANT SPACING SHALL BE AS FOLLOWS: IFC § C102
 □ H RESIDENTIAL - 500 FT UNSPRINKLERED; 400 FT SPRINKLERED.
 □ H COMMERCIAL - 300 FT UNSPRINKLERED; 400 FT SPRINKLERED.
12. WHERE THE WATER MAINS ARE EXTENDED ALONG NEW STREETS ARE INSTALLED WHERE FIRE HYDRANTS ARE NOT NEEDED FOR PROTECTION OF THE STRUCTURES, FIRE HYDRANTS SHALL BE INSTALLED AT A MAXIMUM OF 1000 FT SPACING, TO PROVIDE FOR TRANSPORTATION HAZARDS. WHERE STREETS ARE PROVIDED WITH MEDIAN DIVIDERS OR HAVE FOUR (4) OR MORE TRAFFIC LANES AND HAVE A TRAFFIC COUNT OF MORE THAN 30,000 PER DAY, HYDRANTS ARE REQUIRED ON EACH SIDE OF THE STREET SPACED AT 500 FT ON AN ALTERNATING BASIS. IFC § C102.8
13. NO FIRE HYDRANTS SHALL BE LOCATED WITHIN THE RADIUS OF A CUL-DE-SAC OR WITHIN 20 FT OF THE PERIMETER OF THE RADIUS OF THE CUL-DE-SAC.
14. NO FIRE HYDRANTS SHALL BE LOCATED WITHIN 8 FT OF ANY CURB RETURN, DRIVEWAY, POWER POLE, STREETLIGHT OR ANY OTHER OBSTRUCTION. IFC § C102.10
15. A MAXIMUM DISTANCE FROM A FIRE HYDRANT TO A ONE-TWO FAMILY DWELLING SHALL NOT EXCEED 300 FT, AS MEASURED BY AN APPROVED ROUTE. IFC § C102.4
16. THE MAXIMUM DISTANCE FROM A FIRE HYDRANT TO A FIRE DEPARTMENT CONNECTION (FDC) SHALL NOT EXCEED 100 FT, AS MEASURED BY AN APPROVED ROUTE. IFC § C102.7
17. THE MAXIMUM DISTANCE FROM A HYDRANT TO THE END OF A DEAD-END STREET SHALL NOT EXCEED 200 FT. IFC § C102.6
18. TWO (2) SOURCES OF SUPPLY ARE REQUIRED WHENEVER THERE IS 4 OR MORE FIRE HYDRANTS/SPRINKLER LEAD-INS ARE INSTALLED ON A SINGLE SYSTEM. FOR SYSTEMS REQUIRED TO HAVE TWO (2) SOURCES OF WATER SUPPLY, SECTIONAL CONTROL VALVES SHALL BE INSTALLED SO THAT NO MORE THAN TWO (2) FIRE HYDRANTS AND/OR FIRE SPRINKLER LEAD-INS CAN BE OUT OF SERVICE DUE TO A SERVICE INTERRUPTION. FOR SYSTEMS PERMITTED TO HAVE ONE SOURCE OF WATER SUPPLY, SECTIONAL CONTROL VALVES SHALL BE INSTALLED SO THAT NO MORE THAN 3 FIRE HYDRANTS AND/OR FIRE SPRINKLER LEAD-INS CAN BE OUT OF SERVICE DUE TO A SERVICE INTERRUPTION. IFC § C104
19. ALL FIRE APPARATUS ACCESS ROADS SHALL BE PAVED TO PROVIDE ALL-WEATHER DRIVING CAPABILITIES, AND SHALL BE DESIGNED AND MAINTAINED TO SUPPORT THE IMPOSED LOADS OF THE FIRE APPARATUS. IFC § 503.2.3
20. THE GRADIENT FOR THE FIRE APPARATUS ACCESS ROADS SHALL NOT EXCEED 12%, ANGLES OF APPROACH AND ANGLES OF DEPARTURE SHALL NOT EXCEED 6% FOR 25 FT PRIOR TO OR AFTER THE GRADE CHANGE. ADJACENT TO THE STRUCTURES GRADIENT SHALL NOT EXCEED 6%. IFC § 503.2.7, § 503.2.8
21. THE TURNING RADIUS OF THE FIRE APPARATUS ACCESS ROADS SHALL BE NO LESS THAN 52 FT OUTSIDE AND 28 FT INSIDE TURNING RADIUS. IFC § 503.2.4
22. VERTICAL CLEARANCE OF ALL FIRE APPARATUS ACCESS ROADS SHALL NOT BE LESS THAN 13FT 6 INS. IFC § 503.2.1
23. FIRE DEPARTMENT ACCESS ROADS SHALL HAVE A MINIMUM UNOBSTRUCTED WIDTH OF NOT LESS THAN 33 FT WITH PARKING ON BOTH SIDES MEASURED TO FACE OF CURB, NOT LESS THAN 28 FT WIDE WITH PARKING RESTRICTED TO ONE SIDE MEASURED TO FACE OF CURB, NOT LESS THAN 24 FT WIDE WITH NO PARKING ON EITHER SIDE MEASURED TO FACE OF CURB. FIRE LANES THROUGH PARKING LOTS SHALL BE NOT LESS THAN 24 FT. IFC § 503.2.1.1
24. A FIRE APPARATUS ACCESS ROAD SHALL BE REQUIRED WHEN ANY PORTION OF AN EXTERIOR WALL OF THE FIRST STORY IS LOCATED MORE THAN 150 FT FROM A FIRE DEPARTMENT VEHICLE ACCESS. IFC § 503.1.1
25. APPROVED SECONDARY FIRE APPARATUS ACCESS SHALL BE PROVIDED FOR 200 OR MORE DWELLING UNITS, ROAD(S) WITH DEAD-ENDS OR A SINGLE POINT OF ACCESS IN EXCESS OF 600 FT, CLV REGULATION AND MOU
26. ALL DEAD-END FIRE APPARATUS ROADS AND/OR FIRE LANES, PUBLIC OR PRIVATE, IN EXCESS OF 150 FT IN LENGTH SHALL BE PROVIDED WITH AN APPROVED TURN AROUND HAVING A MINIMUM DIAMETER OF 81 FT, CLV REGULATION
27. ALL FIRE APPARATUS ACCESS ROADS SHALL BE MARKED BY PLACING APPROVED SIGNS AT THE START OF THE DESIGNATED FIRE LANE, ONE SIGN AT THE END OF THE FIRE LANE AND WITH SIGNS AT INTERVALS OF 100 FT ALONG THE DESIGNATED FIRE LANES. SIGNS TO BE PLACED ON BOTH SIDES OF AN ACCESS ROADWAY IF NEEDED TO PREVENT PARKING ON EITHER SIDE, SIGNS TO BE INSTALLED NO HIGHER THAN 10 FT OR LESS THAN 6 FT FROM THE ROADWAY LEVEL. THE CURB ALONG OR ON THE PAVEMENT OR CEMENT (IF NO CURB IS PROVIDED) SHALL BE PAINTED WITH A RED WEATHER RESISTANT PAINT IN ADDITION TO THE SIGNS. IFC § 503.3
28. ELECTRICALLY CONTROLLED ACCESS GATES SHALL BE PROVIDED WITH AN APPROVED EMERGENCY VEHICLE DETECTOR/RECEIVER SYSTEM. IFC § 503.6
29. WHERE STREETS ARE PROVIDED WITH MEDIAN DIVIDERS, OR HAVING FOUR OR MORE TRAVEL LANES, AND A TRAFFIC COUNT OF MORE THAN 30,000 VEHICLES PER DAY, ALL HYDRANTS BEING UTILIZED TO DELIVER FIRE FLOW TO THE PROPOSED LOCATION SHALL BE LOCATED ON THE SAME SIDE OF THE STREET AS THE PROPOSED DEVELOPMENT. CLV REGULATION

SEWER MANHOLE SCHEDULE

N/A

STORM DRAIN MANHOLE SCHEDULE

N/A

CLV SEWER NOTES

1. ALL CONSTRUCTION AND MATERIALS SHALL BE IN ACCORDANCE WITH THE LATEST EDITION OF DESIGN & CONSTRUCTION STANDARDS FOR WASTEWATER COLLECTION SYSTEMS AND THE UNIFORM STANDARD SPECIFICATIONS FOR PUBLIC WORKS CONSTRUCTION OFF-SITE IMPROVEMENTS, CLARK COUNTY AREA, NEVADA, AS AMENDED. IT WILL BE THE RESPONSIBILITY OF THE CONTRACTORS TO BE AWARE OF THE CONTENTS OF THE ABOVE SPECIFICATIONS.
2. IT SHALL BE THE CONTRACTORS RESPONSIBILITY TO PERFORM CONSTRUCTION AS PER PLANS. ANY ADDITIONS, DELETIONS, OR CHANGES SHALL FIRST MEET WITH THE APPROVAL OF THE CITY ENGINEERS.
3. CHISEL "S" OR "G" IN CURBS WHERE SEWER OR GAS LATERALS PASS UNDER THE CURB.
4. POLYVINYL (PVC) SEWER PIPE SHALL MEET ASTM D-3034 SDR 35 SPECIFICATIONS, INSTALLED WITH SAND BEDDING AND BACKFILL OF TYPE II AGGREGATE BASE.
5. ALL MANHOLES IN PAVED STREETS EIGHTY FEET (80') RAW AND LARGER SHALL HAVE CONCRETE COLLARS. STREETS LESS THAN EIGHTY FEET (80') WILL REQUIRE RETROFITTING IF PAVING DOES NOT CONFORM TO CITY STANDARDS AT THE MANHOLE.
6. TEE SADDLES SHALL BE USED TO CONNECT SEWER LATERALS TO EXISTING MAIN LINES UP TO TWELVE INCHES (12") IN DIAMETER. CONNECTIONS TO FIFTEEN INCH (15") OR LARGER MAINS SHALL REQUIRE SPECIAL PROCEDURES. IN-LINE "Y" SHALL BE USED ON LINES TWELVE INCHES (12") IN DIAMETER AND ABOVE.
7. WATER MAINS SHALL BE PROTECTED IN ACCORDANCE WITH LVWVD STANDARDS WHENEVER A SEWER MAIN CROSSES OVER A MAIN LINE OR THE SEWER IS LESS THAN EIGHTEEN INCHES (18") UNDER A WATER MAIN.
8. ALL CONTRACTORS INSTALLING SEWER MAINS THAT WILL BE UNDER JURISDICTION OF THE CITY OF LAS VEGAS MUST BE STATE OF NEVADA CLASS "A" CONTRACTORS.
9. THE CITY OF LAS VEGAS WILL NOT ACCEPT ANY SEWER MAINS WHICH HAVE A VERTICAL DEFLECTION OF MORE THAN ONE TENTH OF A FOOT (0.1') FROM THE APPROVED CONSTRUCTION PLANS AT ANY LOCATION. SEWER MAINS FOUND TO EXCEED THIS TOLERANCE WILL HAVE TO BE REPAIRED OR REMOVED AND REPLACED TO THE SATISFACTION OF THE CITY ENGINEER PRIOR TO ACCEPTANCE BY THE CITY OF LAS VEGAS.
10. INSTALLATION OF CURVED SEWER REQUIRES THE USE OF PVC C800 WHICH ALLOWS FOR PIPE DEFLECTION AT THE JOINTS.

LAS VEGAS VALLEY WATER DISTRICT NOTES

1. NO WORK SHALL BEGIN UNTIL THE WATER PLANS HAVE BEEN APPROVED FOR CONSTRUCTION BY THE LVWVD. FOLLOWING WATER PLAN APPROVAL, NOTICE SHALL BE GIVEN TO THE LVWVD COMMUNICATION SUPPORT CENTER (258-7171) TWO (2) WORKING DAYS PRIOR TO THE START OF CONSTRUCTION. FOR FUTURE INSPECTIONS, NOTICE MUST BE GIVEN BY 2:00 P.M. THE BUSINESS DAY PRIOR TO THE REQUESTED LVWVD INSPECTION. WHEN REQUESTING INSPECTIONS, PLEASE REFER TO THE PROJECT NUMBER IDENTIFIED ABOVE.
2. ALL WORK SHALL CONFORM TO LVWVD STANDARD PLATES, DRAWINGS, AND SPECIFICATIONS AND TO THE 2010 EDITION OF THE UNIFORM DESIGN AND CONSTRUCTION STANDARDS FOR WASTEWATER COLLECTION SYSTEMS (UDACS). THE LATEST EDITION OF UDACS SHALL SUPERCEDE ANY CONFLICTS CONTAINED IN THE APPROVED DRAWINGS AND/OR SPECIFICATIONS.
3. ALL WORK, EXCEPT AS MODIFIED BY THESE PLANS OR BY NOTE 2 ABOVE, SHALL BE DONE IN ACCORDANCE WITH THE MOST RECENT DRAFT OR EDITION OF THE UNIFORM STANDARD SPECIFICATIONS FOR PUBLIC WORKS CONSTRUCTION OFFSITE IMPROVEMENT, CLARK COUNTY AREA.
4. A SINGLE PIPE MATERIAL SHALL BE USED THROUGHOUT THE PROJECT UNLESS OTHERWISE APPROVED BY THE LVWVD.
5. ALL SERVICE LATERALS TWO INCHES (2") IN DIAMETER AND SMALLER SHALL BE TYPE "K" COPPER TUBING WITH LVWVD APPROVED SERVICE SADDLES.
6. ALL WATER METER BOXES SHALL BE LOCATED OUTSIDE OF DRIVEWAY AREAS.
7. ALL VALVES SHALL BE LOCATED OUTSIDE OF DRIVEWAYS, VALLEY, AND CURB GUTTERS.
8. ALL WATER AND STORM DRAIN OR SANITARY SEWER CROSSINGS SHALL CONFORM TO SECTION 2.22 OF THE 2010 EDITION OF THE UDACS.
9. ALL WATER FACILITIES AND APPURTENANCES SHALL BE DISINFECTED, PRESSURE TESTED, AND HAVE AN ACCEPTABLE PASSING HEALTH WATER SAMPLE OBTAINED, PRIOR TO OPERATION AND USE.
10. THE CONTRACTOR MUST OBTAIN ALL METERS TWO INCHES (2") AND SMALLER FROM LVWVD CENTRAL STORES. TELEPHONE 255-3152 OR 255-3922 TWO (2) WORKING DAYS PRIOR TO METER PICKUP.
11. ANY INTERRUPTION OF SERVICE MUST BE PERFORMED IN ACCORDANCE WITH UDACS SECTION 3.1.01, AND APPROVED BY THE LVWVD INSPECTION DIVISION PRIOR TO SHUTDOWN. PROPER WRITTEN NOTIFICATION MUST BE GIVEN TO ALL AFFECTED CUSTOMERS.
12. ALL WATER FACILITY CONSTRUCTION MATERIALS USED MUST BE AS LISTED ON THE LVWVD APPROVED PRODUCTS LIST FOR NEW FACILITIES, LATEST REVISION, OR SPECIFICALLY APPROVED ON THESE PLANS BY SUBMITTING SHOP DRAWINGS.
13. TELEPHONE "CALL BEFORE YOU DIG" AT "811" OR 1-800-227-2600.
14. THE INSTALLATION OF LVWVD MUNICIPAL WATER FACILITIES WITHIN ALL STREETS IS ASSUMED TO BE IN COMPLIANCE WITH THE UNIFORM STANDARDS, INCLUDING PLACEMENT OF ASPHALT PAVING STREET SURFACES. ANY REPAIR WORK DONE BY THE LVWVD TO THE MUNICIPAL WATER MAINS WILL INCLUDE THE PLACEMENT OF AN APPROPRIATELY SIZED ASPHALT REPAIR PATCH ON THE STREET SURFACE.

ANY DECORATIVE PAVING SURFACE WITHIN THE STREET IS THE RESPONSIBILITY OF THE OWNER'S ASSOCIATION, OR THE INDIVIDUAL PROPERTY OWNERS IF NO OWNERS ASSOCIATION IS IN EXISTENCE, OR THE AGENCY HAVING JURISDICTION. DECORATIVE SURFACE MATERIALS PLACED WITHIN THE TEN FOOT EASEMENT ABUTTING A PUBLIC OR PRIVATE STREET, IF DISTURBED BY THE LVWVD DURING THE REPAIR OR OPERATION OF ITS FACILITIES, WILL BE REPLACED BY LVWVD WITH AN APPROPRIATELY SIZED PLAIN FINISH CONCRETE PATCH. THE LVWVD WILL NOT RESTORE, AND WILL NOT BE RESPONSIBLE FOR THE RESTORATION OF, ANY DECORATIVE PAVING SURFACE WITHIN THE STREET. THE LVWVD WILL NOT ATTEMPT TO MATCH COLOR OR FINISH OF ANY ADJACENT MATERIALS.


15. NO LEAD COMPLIANCE NOTE: TO COMPLY WITH THE FEDERAL SAFE DRINKING WATER ACT, ALL WATER WORKS BRASS PRODUCTS PROSED TO BE RELOCATED, OR INSTALLED AS NEW MUST BE INSTALLED WITH THE LEAD FREE APPROVED PRODUCT. THE OLD LEADED PRODUCT MAY NOT BE REUSED.

APPROVED FOR CONSTRUCTION
Jason
 LAS VEGAS VALLEY WATER DISTRICT ENGINEERING SERVICES
 PROJECT # 136461 FIRST APPROVED DATE 6/19/19
 LVWVD APPROVED FIRE FLOW: 1500 GPM AT 20' HEAD
 MAXIMUM AVAILABLE FIRE SPRINKLER FLOW 28 GPM
 LVWVD APPROVAL IS VALID FOR ONE (1) YEAR FROM THE SIGNATURE DATE. IF CONSTRUCTION IS NOT STARTED, PLANS MUST BE RESUBMITTED FOR REVIEW AND APPROVAL.

ABBREVIATIONS

AC	ASPHALTIC CONCRETE	EX	EXISTING	PT	POINT OF TANGENCY
ACP	ASEBESTOS CEMENT PIPE	FF	FINISH FLOOR ELEVATION	PVC	POLYVINYL CHLORIDE
AVE	AVENUE	FR	FINISH GRADE	R	RADIUS
BC	BACK OF CURB	FH	FIRE HYDRANT	RGB	REINFORCED CONCRETE BOX
BCR	BACK OF CURB RADIUS	FL	FLOW LINE	RCP	REINFORCED CONCRETE PIPE
BFE	BASE FLOOD ELEVATION	FT	FEET	ROW	RIGHT-OF-WAY
BFP	BACK FLOW PREVENTOR	G	GRADING	RT	RIGHT
BLM	BUREAU OF LAND MANAGEMENT	GB	GRADE BREAK	SD	STORM DRAIN
BM	BENCH MARK	GFF	GARAGE FINISH FLOOR	SHT	SHEET
BL	BOUNDARY	HP	HIGH POINT	STLT	STREETLIGHT
BRPM	BLUE RAISED PAVEMENT MARKER	HPG	HIGH PRESSURE GAS	SWA	SOUTHERN NEVADA WATER AUTHORITY
BVC	BEGIN VERTICAL CURVE	INV	INVERT	SS	SANITARY SEWER
BW	BOTTOM OF WALL	LF	LINEAR FEET	ST	STREET
CATV	CABLE TELEVISION	LN	LANE	STA	STATION
CC	CLARK COUNTY	LS	LANDSCAPE	STD	STANDARD
CCFD	CLARK COUNTY FIRE DEPARTMENT	LT	LEFT	SVZ	SIGHT VISIBILITY ZONE
COWD	CLARK COUNTY WATER RECLAMATION DISTRICT	LVWD	LAS VEGAS VALLEY WATER DISTRICT	SW	SIDEWALK
CL	CENTERLINE	MAX	MAXIMUM	SQ	SQUARE YARD
CLSM	CONTROLLED LOW STRENGTH MATERIAL	MH	MANHOLE	TC	TOP OF CURB
CLV	CITY OF LAS VEGAS	MIN	MINIMUM	TELE	TELEPHONE
CM	CORRUGATED METAL PIPE	NO	NUMBER	TOP	TOP OF FOOTING
CNLV	CITY OF NORTH LAS VEGAS	NTS	NOT TO SCALE	T.O.P.	TOP OF PIPE
CO	CLEAN OUT, SEWER	OC	ON CENTER	TR	TOP OF RETAINING
COH	CITY OF HENDERSON	PB	PULL BOX	TW	TOP OF WALL
CY	CUBIC YARD	PC	POINT OF CURVE	TYP	TYPICAL
COWD	DESIGN AND CONSTRUCTION STANDARDS FOR WASTE WATER COLLECTION SYSTEMS	POC	POINT OF COMPOUND CURVE	UDMS	UNIFORM DESIGN AND CONSTRUCTION STANDARDS
DG	DESIGN/DESIGNED GRANITE	PI	POINT OF INTERSECTION	UTD	UTILITY
DIP	DROP INLET	PL	PROPERTY LINE	UST	UNIFORM STANDARD DRAWING
DR	DRIVE	PLT	PLATE	VC	VERTICAL CURVE
DR	DRIVE	POC	POINT OF CONNECTION	VCP	VERTIFIED CLAY PIPE
END	END OF GRADE	PP	POWER POLE	VG	VALLEY GUTTER
EX	EXISTING GRADE	P&P	PLAN AND PROFILE	W	WATER
ELEC	ELECTRICAL	PRC	POINT OF REVERSE CURVE	ZC	ZERO LIP CURB
EP	EDGE OF PAVEMENT	PROJ	PROJECT		
EXP	EXISTENTIAL CURVE	PRV	PRESSURE REDUCING VALVE		

LAST PLOT: Mont Brule
FILE NAME: S:\CTY\ADVEN HOMES\ADV-18-108 - ALPINE RIDGE & 215 BELTWAY\DWG\SS\H108_SHT_G_1Z.DWG

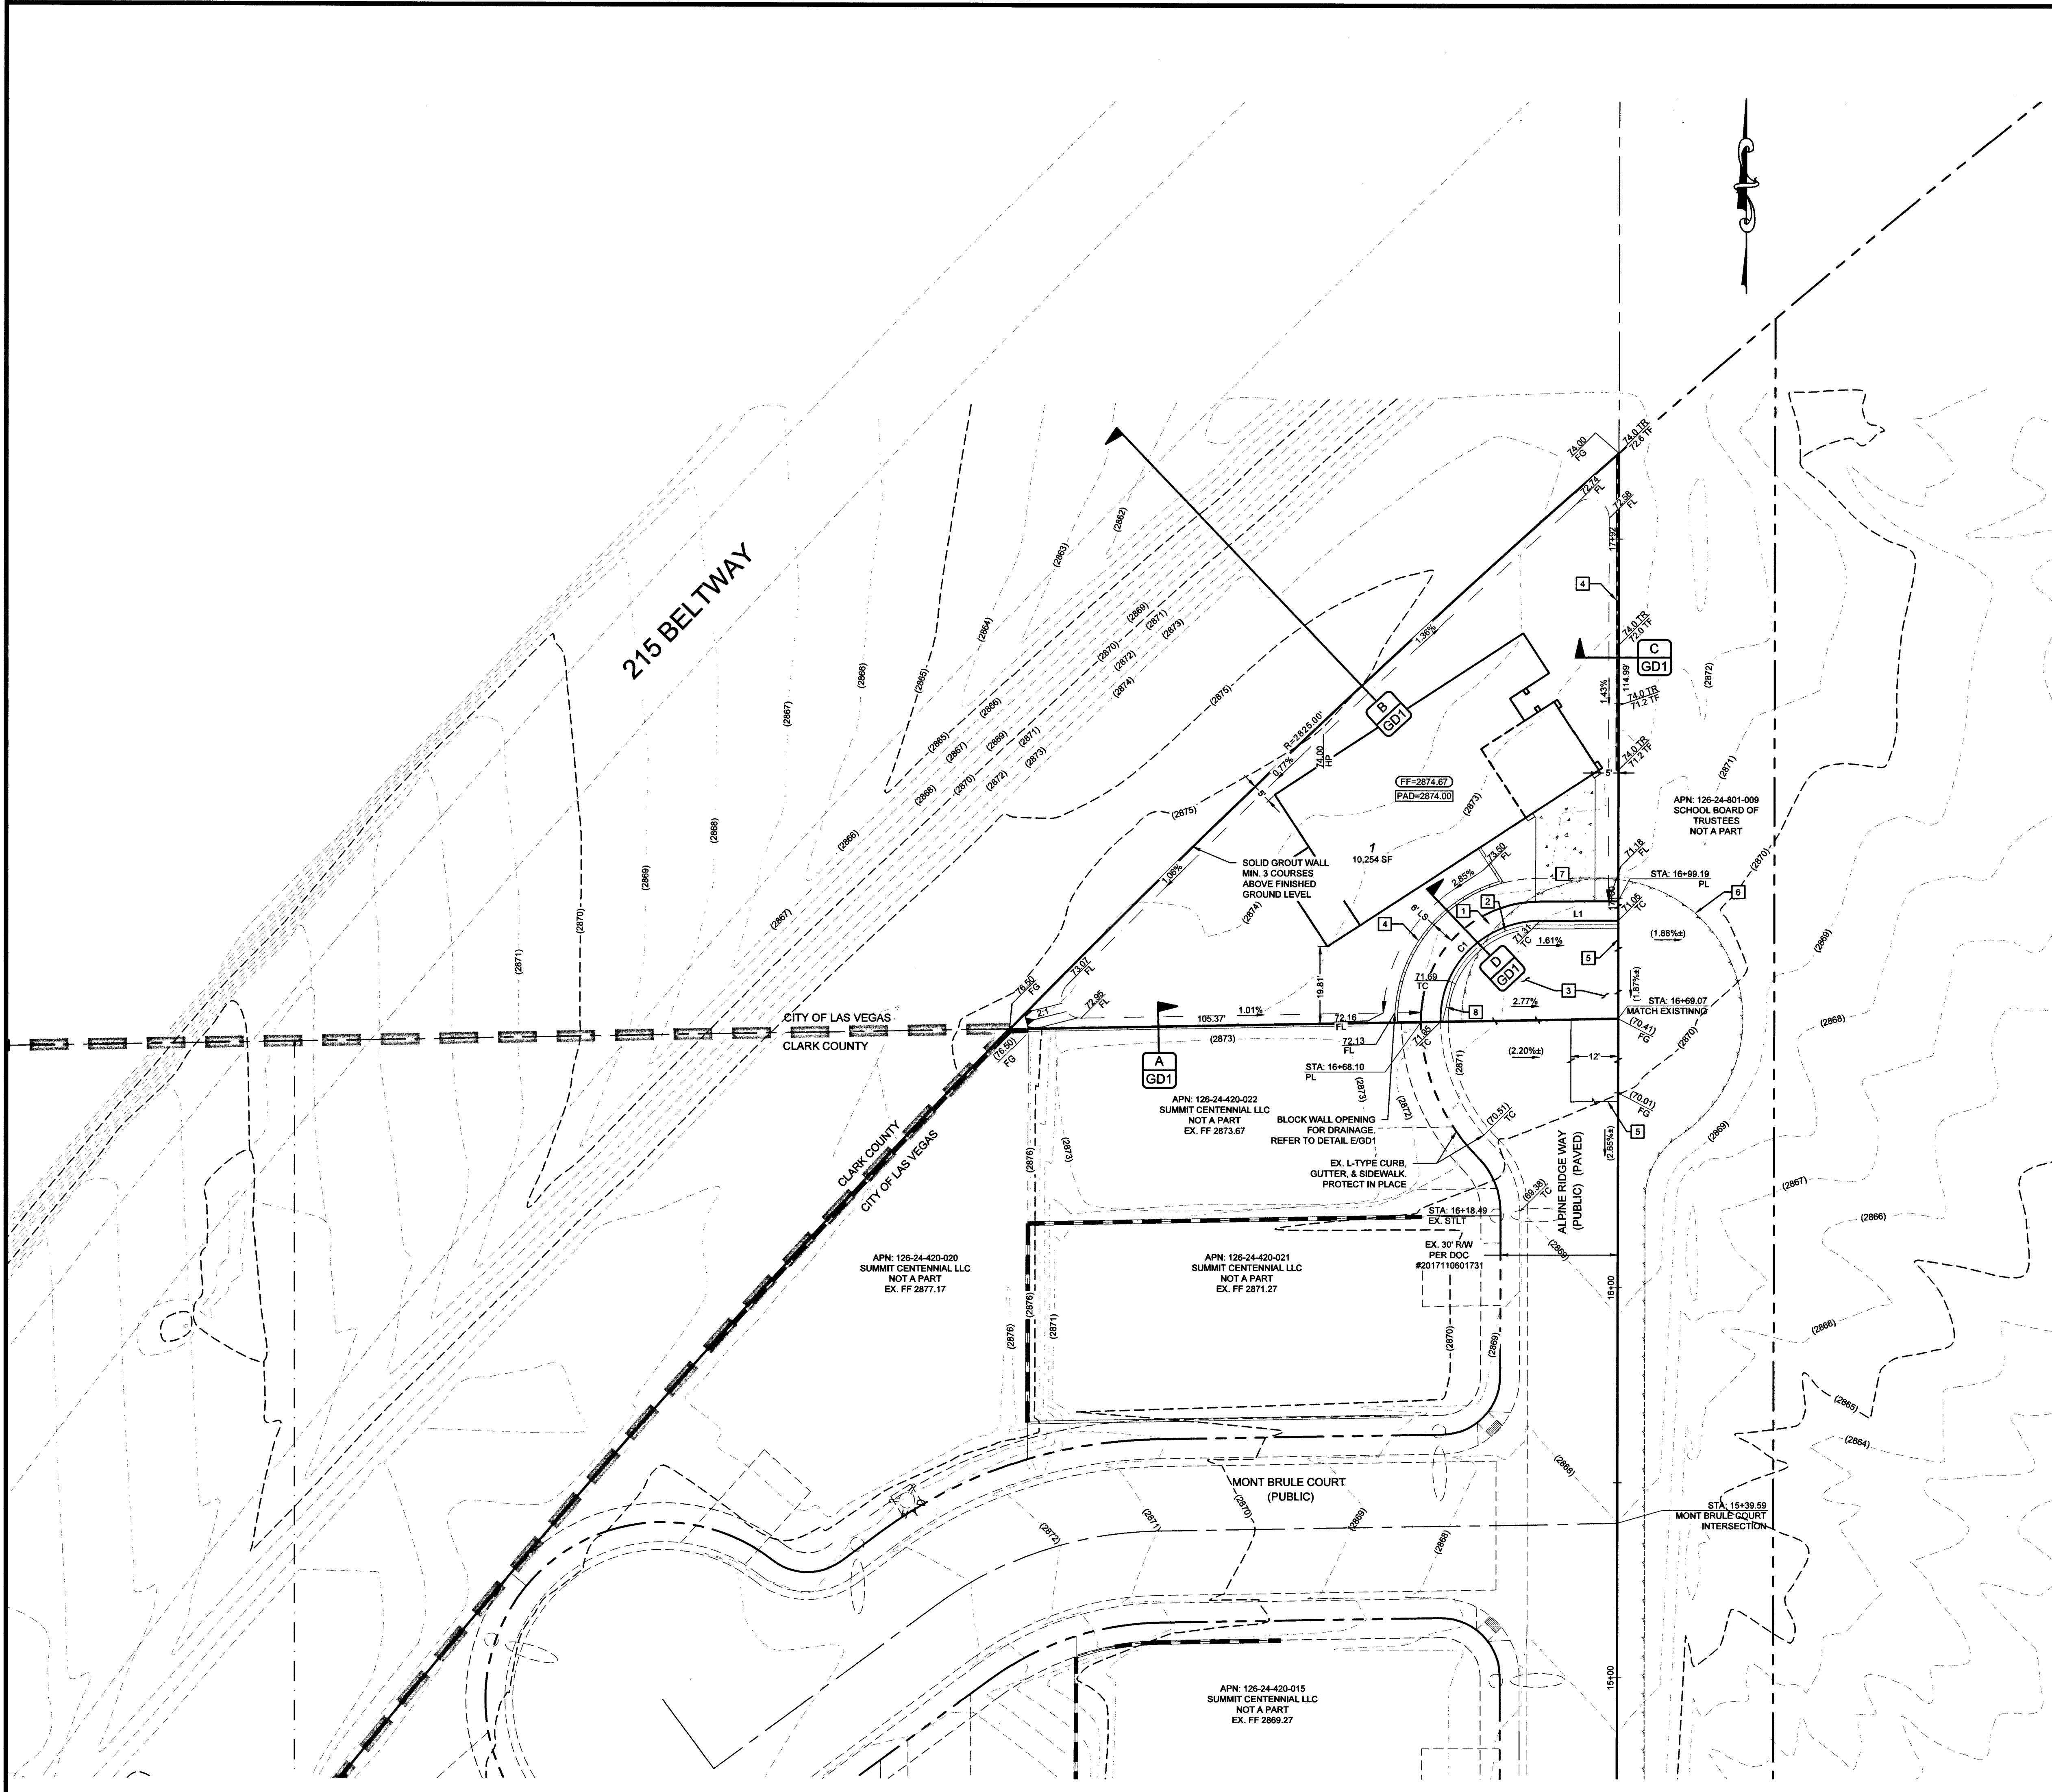

Avoid overhead power line contact. It's costly.

Call before you Overhead


1-702-227-2929

Call before you Dig

Avoid cutting underground utility lines. It's costly.

CALL 811

 OR 1-800-227-2600



- CONSTRUCTION NOTES**
1. INSTALL 5' WIDE SIDEWALK (PER CCAUSD #234)
 2. INSTALL 24" R-TYPE CURB & GUTTER (PER CCAUSD #217.3.S1)
 3. 2.0" AC PAVEMENT OVER 4" TYPE II PER SOILS REPORT #1991-GEO
 4. INSTALL 6.0' HIGH DECORATIVE SCREEN WALL
 5. SAWCUT AND MATCH EXISTING AC PAVEMENT (PER CCAUSD #500.5 & #503)
 6. PROTECT IN PLACE EXISTING AC PAVEMENT
 7. INSTALL RESIDENTIAL DRIVEWAY (PER CCAUSD #223)
 8. INSTALL 10' L-TYPE TO R-TYPE CURB TRANSITION (PER DETAIL F/GD1)

GEOTECHNICAL
AMERICAN SOILS ENGINEERING, LLC
LAS VEGAS, NV 89119
(702) 889-9617
REPORT NO.: 1991-GEO
DATE: 04/11/19

SEE H21 FOR LINE AND CURVE TABLE AND LOT DIMENSIONS.

EARTHWORK
TOTAL FOR OVERALL DEVELOPMENT: 72 CY CUT / 154 CY FILL / 82 CY NET (FILL)
NOTE: THIS OPINION OF THE CUT AND FILL QUANTITIES IS PROVIDED AS REQUIRED BY THE GOVERNING ENTITY. THIS INFORMATION SHOULD NOT BE USED FOR BIDDING PURPOSES. ALL CONTRACTORS ARE RESPONSIBLE FOR THEIR OWN QUANTITIES. THESE TOTALS ARE RAW AND DO NOT ACCOUNT FOR SHRINKAGE AND SUBSIDENCE.

FLOOD ZONE
THIS PROJECT IS LOCATED IN FLOOD ZONE "X", AN AREA DETERMINED TO BE OUTSIDE OF THE 0.2% ANNUAL CHANCE FLOOD PLAIN PER FIRM PANEL 32003C2150E, REVISED DATE.

UTILITY DISCLAIMER
EXISTING UTILITY LOCATIONS SHOWN HEREIN ARE APPROXIMATE ONLY. IT SHALL BE THE CONTRACTORS RESPONSIBILITY TO DETERMINE THE EXACT VERTICAL AND HORIZONTAL LOCATION OF ALL EXISTING UNDERGROUND UTILITIES PRIOR TO COMMENCING CONSTRUCTION. NO REPRESENTATION IS MADE THAT ALL EXISTING UTILITIES ARE SHOWN HEREON. THE ENGINEER ASSUMES NO RESPONSIBILITY FOR UTILITIES NOT SHOWN OR UTILITIES NOT SHOWN IN THEIR EXISTING LOCATIONS.

GRADING NOTES
COMPLETION OF SECTION II OF DRAINAGE COMPLIANCE REPORT REQUIRED.
ADD 2800 FEET TO ALL GRADE TAGS TO GET ACTUAL ELEVATION.
THE ELEVATION DIFFERENCE BETWEEN THE PAD AND FINISH FLOOR IS DETERMINED FROM THE MINIMUM THICKNESS REQUIRED PER THE GEOTECHNICAL REPORT. FINISH FLOORS MAY INCREASE DEPENDING ON THE TYPE OF SOIL AND FOUNDATION PLAN USED. NOTE THAT THE STRUCTURAL PLANS & GEOTECHNICAL REPORT SHALL SUPERSEDE THE CIVIL IMPROVEMENT PLANS.
ALL PRIVATE STREETS AND DRAINAGE EASEMENTS ARE TO BE PRIVATELY OWNED AND MAINTAINED BY THE HOMEOWNERS ASSOCIATION (H.O.A.).
ALL WORK TO BE PERFORMED OUTSIDE OF THE PROJECT BOUNDARY AND ON PRIVATE PROPERTY SHALL NOT BE PERFORMED UNTIL WRITTEN PERMISSION AND EASEMENTS HAVE BEEN OBTAINED FROM THE OFFSITE OWNER AND GIVEN TO THE GOVERNING ENTITY.
CONTRACTOR SHALL VERIFY HORIZONTAL AND VERTICAL LOCATION OF EXISTING UTILITIES AND NOTIFY THE DESIGN ENGINEER IMMEDIATELY OF ANY DISCREPANCIES PRIOR TO CONSTRUCTION.

BENCHMARK
RIVET AND PLATE TOP CURB SE CORNER ALPINE RIDGE WAY AND CENTENNIAL PARKWAY
ELEVATION: 2856.12

ACCEPTANCE OF PLANS FOR FILING

BY: _____ DATE: _____
DEVELOPMENT AND FLOOD CONTROL

ADAVEN HOMES
3425 CLIFF SHADOWS PKWY
LAS VEGAS, NV 89129
(702) 365-8886 FAX

ADAVEN HOMES
A RESIDENTIAL SUBDIVISION
ALPINE RIDGE & 215

REVISIONS

NO.	DESCRIPTION	BY	SHTS.	APPR.	DATE

ADVEN HOMES
A RESIDENTIAL SUBDIVISION
ALPINE RIDGE & 215

GRADING PLAN

DATE: 6/3/2019
SCALE: 1"=20'
JOB NO: ADV-18-108
DESIGNED BY: BP
CHECKED BY: BM
SHEET NAME: G1
SHEET NUMBER: 03 OF 07
CITY: 107Y5105

LAST PLOT: Mohit Khanna
FILE NAME: S:\ACTIVE\ADAVEN HOMES\ADV-18-108 - ALPINE RIDGE & 215\ENGINEERING\DWGS\ADV18108_SHT_DET.DWG

SECTION A
SOUTH BOUNDARY
NTS

SECTION B
NORTH BOUNDARY
NTS

SECTION C
EAST BOUNDARY
NTS

SECTION D
FRONT YARD
NTS

TYPICAL GRADING DETAIL
TYPE A
NTS

DETAIL E
DECORATIVE BLOCK WALL OPENING
NTS

DETAIL F
TRANSITION FROM L-TYPE
TO R-TYPE CURB
NTS

ADAVEN HOMES
5425 CLAYTON DRIVE
LAS VEGAS, NV 89120
(702) 365-6588 FAX

TANEY ENGINEERING
8030 S. JONES BOULEVARD
LAS VEGAS, NV 89118
(702) 362-8844 FAX (702) 362-5233

EST. 2000

ALPINE RIDGE & 215
A RESIDENTIAL SUBDIVISION

GRADING DETAILS

6/3/19

DATE: 6/3/2019
SCALE: NTS
JOB NO: ADV-18-108
DESIGNED BY: BP
CHECKED BY: BM
SHEET NAME: GD1
SHEET NUMBER: 04 OF 07
CITY: L19-00760 107Y5105

Avoid overhead power line contact, it's costly.

Call before you Dig

1-702-227-2929

Call before you Dig

Avoid cutting underground utility lines, it's costly.

811

OR 1-800-227-2600



CONSTRUCTION NOTES

1. INSTALL 5' WIDE SIDEWALK (PER CCAUSD #234)
2. INSTALL 24" R-TYPE CURB & GUTTER (PER CCAUSD #217.3.S1)
3. 2.0" AP VENT OVER OTHER 1" TYPE II PER SOILS REPORT #1804-GEO
4. INSTALL 6.0' HIGH DECORATIVE SCREEN WALL
5. SAWCUT AND MATCH EXISTING CAP PAVEMENT (PER CCAUSD #500.5 & #503)
6. PROTECT IN PLACE EXISTING CAP PAVEMENT
7. INSTALL RESIDENTIAL DRIVEWAY (PER CCAUSD #223)
8. INSTALL 10' 10" L-TO R-TYPE CURB TRANSITION (PER DETAIL F/GD1)
9. INSTALL 6" 90° BEND (PER UDACS PLT. NO. 31)
10. INSTALL 4" SEWER LATERAL AND CURB MARKING (DCSWCS SD-22 & SD-23)
11. INSTALL 1" WATER SERVICE W/ 3/4" METER (UDACS PLT. NO. 1)
12. INSTALL WYE CONNECTION (PER DCSWCS SD-22)
13. INSTALL 6" PUMP WATER
14. INSTALL CLEANOUT WITH TRAFFIC RATED LID (SEWER UNDER DRIVEWAY) (PER DCSWCS SD-26)
15. INSTALL CAP AND BLOW OFF ASSEMBLY (PER UDACS PLT. NO. 36)

GEOTECHNICAL

AMERICAN SOILS ENGINEERING, L.L.C.
LAS VEGAS, NV 89119
(702) 889-9617

REPORT NO: 1991-GEO
DATE: 04/11/19

UTILITY DISCLAIMER

EXISTING UTILITY LOCATIONS SHOWN HEREIN ARE APPROXIMATE ONLY. IT SHALL BE THE CONTRACTORS RESPONSIBILITY TO DETERMINE THE EXACT VERTICAL AND HORIZONTAL LOCATION OF ALL EXISTING UNDERGROUND UTILITIES PRIOR TO COMMENCING CONSTRUCTION. NO REPRESENTATION IS MADE THAT ALL EXISTING UTILITIES ARE SHOWN HEREON. THE ENGINEER ASSUMES NO RESPONSIBILITY FOR UTILITIES NOT SHOWN OR UTILITIES NOT SHOWN IN THEIR EXISTING LOCATIONS.

LINE AND CURVE DATA

FOR LINE AND CURVE DATA TABLES, SEE THE GRADING PLAN SHEETS FOR THIS PROJECT.

PROFILE NOTES

ADD 2800 FEET TO ALL GRADE TAGS TO GET ACTUAL ELEVATION.

ALL WORK TO BE PERFORMED OUTSIDE OF THE PROJECT BOUNDARY AND ON PRIVATE PROPERTY SHALL NOT BE PERFORMED UNTIL WRITTEN PERMISSION AND EASEMENTS HAVE BEEN OBTAINED FROM THE OFFSITE OWNER AND GIVEN TO GOVERNING ENTITY.

BENCHMARK

RIVET AND PLATE TOP CURB SE CORNER ALPINE RIDGE WAY AND CENTENNIAL PARKWAY
ELEVATION: 2856.12

ACCEPTANCE OF PLANS

Mary 6.3.19
SOUTHWEST GAS CORPORATION DATE

APPROVED FOR CONSTRUCTION

DAS VEGAS VALLEY WATER DISTRICT ENGINEERING SERVICES
 PROJECT # 136461 FIRST APPROVED DATE 8/2/19
 LVVWD APPROVED FIRE FLOW: 1500 GPM AT 20 PSI RESIDUAL
 MAXIMUM AVAILABLE FIRE SPRINKLER FLOW 26 GPM
 LVVWD APPROVAL IS VALID FOR ONE (1) YEAR FROM THE SIGNATURE DATE. IF CONSTRUCTION
 IS NOT STARTED, PLANS MUST BE RESUBMITTED FOR REVIEW AND APPROVAL.

~~ACCEPTANCE OF PLANS FOR FILING~~

BY: _____ DATE: _____
DEVELOPMENT AND FLOOD CONTROL

DEPTH OF COVER DURING CONSTRUCTION
MAINTAIN MINIMUM TWENTY-FOUR (24) INCH COVER PER UDACS SECTION
2.08.04. GRADING MUST BE COMPLETED PRIOR TO WATERLINE
INSTALLATION.

WATER MAIN JOINT DEFLECTION NOTE (PVC 4"-24")

PVC PIPE SHALL BE DEFLECTED AT THE JOINT ONLY. THE MAXIMUM ALLOWABLE DEFLECTION SHALL BE ONE (1) DEGREE PER JOINT WITH A MAXIMUM RADIUS OF CURVATURE OF 1,150 FEET, PER UDACS 2.07.01 AND 2.07.02.

FOR CHANGES IN DIRECTION EXCEEDING THE MAXIMUM ALLOWABLE JOINT DEFLECTION, FITTING SHALL BE USED.

Call before you Dig!
Avoid cutting underground utility lines. It's costly.

CALL
811
OR
1-800-227-2600


Avoid overhead power
line contact. it's costly.

Call
before you
Overhead
1-702-227-2929


[illegible]

ADAVEN HOMES
3425 CLIFF SHADOWS PKWY
LAS VEGAS, NV 89129
702) 365-8588 FAX:

TANEY & ENGINEERING
6030 S. JONES BOULEVARD
LAS VEGAS, NV 89118
(702) 362-9844 FAX: (702) 362-5233

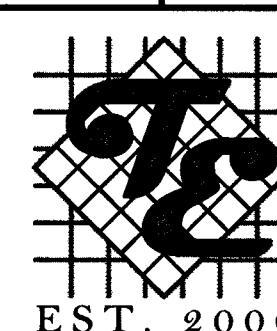ALPINE RIDGE & 215
A RESIDENTIAL SUBDIVISION

PLAN AND PROFILE


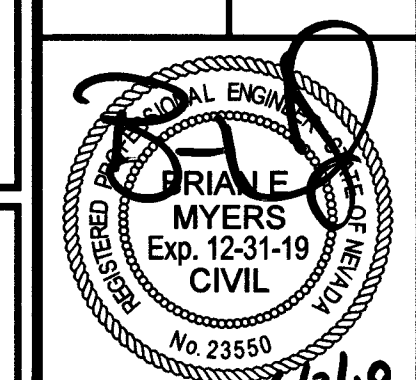


DATE:		6/3/2019	
SCALE:		1"=20'	
JOB NO:		ADV-18-108	
DESIGNED BY:	BP	CHECKED BY:	BM
SHEET NAME:		PP1	
SHEET NUMBER:		05 OF 07	
L19-00760		—	
CITY:		107N161E	

LAST PLOT: Mohit Khadka
FILE NAME: S:\ACTIVE\ADAVEN HOMES\ADV-18-108 - ALPINE RIDGE & 215\ENG\PSDWG\SSSHEET DWG\ADV18108_SHT_PP.DWG

LEGEND


EXISTING GAS MAIN	
EXISTING GAS SERVICE	
GAS LINE TO BE ABANDONED	
STEEL RISER	
ANODELESS RISER	
GASLIGHT	
GAS VALVE	
EXCESS FLOW VALVE	
RELIEF VALVE	
COUPLINGS	
BOND OVER	
TEST POINT	
INSULATOR	
REGULATOR STATION	
RECTIFIER	
ANODE	
SCADA	
METER SET ASSEMBLY	
PURGE POINT	
BRANCH,CVT,LINE STOPPER	
PROPOSED GAS MAIN	
PROPOSED GAS SERVICE	
EXISTING EASEMENT	
ROW LINE	
PROPERTY LINE	
STREET CENTERLINE	
EDGE OF PAVEMENT	
CABLE LINE - UNDERGROUND	
ELECTRIC - OVERHEAD	
ELECTRIC - UNDERGROUND	
FIBER OPTIC - UNDERGROUND	
PHONE - OVERHEAD	
PHONE - UNDERGROUND	
RECLAIMED WATER	
SEWER	
STORMWATER	
WATER	
UTILITY PEDESTALS	
FIRE HYDRANT	
MANHOLE	
WATER VALVE	
SURVEY MONUMENT	
POWER POLE	
GAS FLOW ARROW	

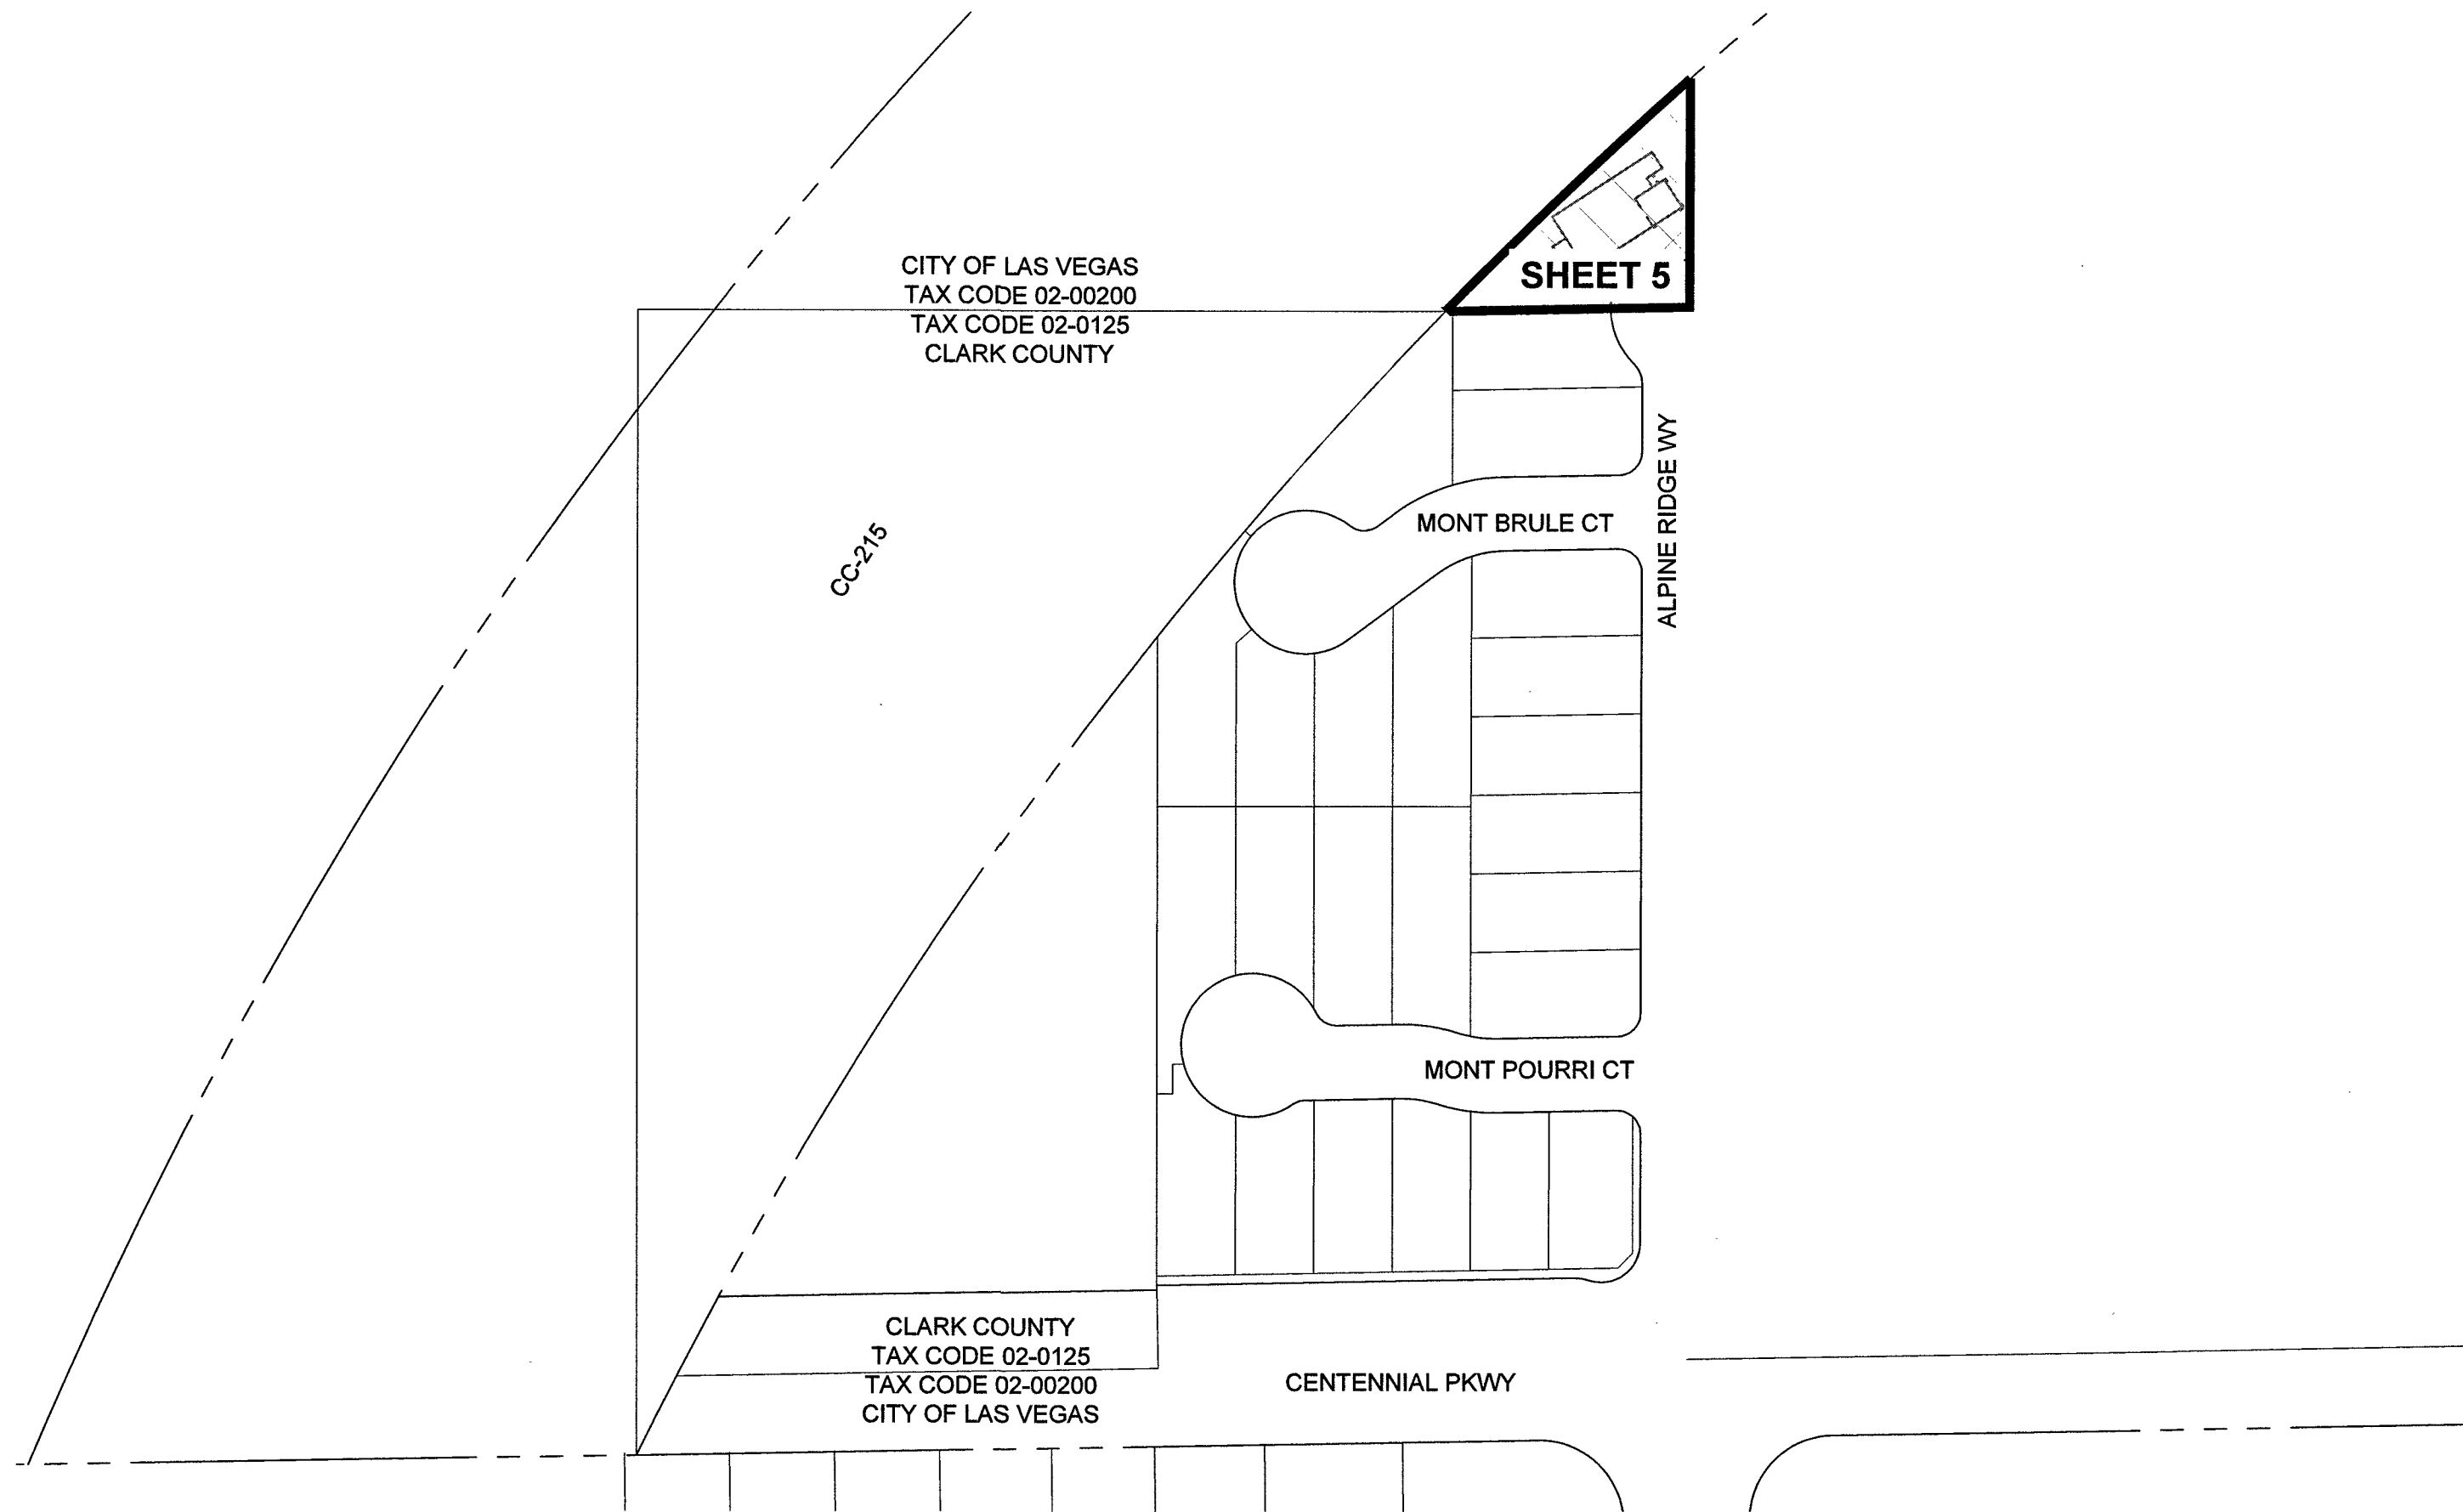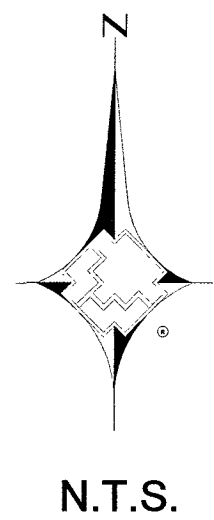

SHEET INDEX MAP


SHEET INDEX

- COVER SHEET
- SIGNATURE SHEET
- NOTES AND STANDARD DETAILS
- NOTES AND STANDARD DETAILS
- PLAN SHEET

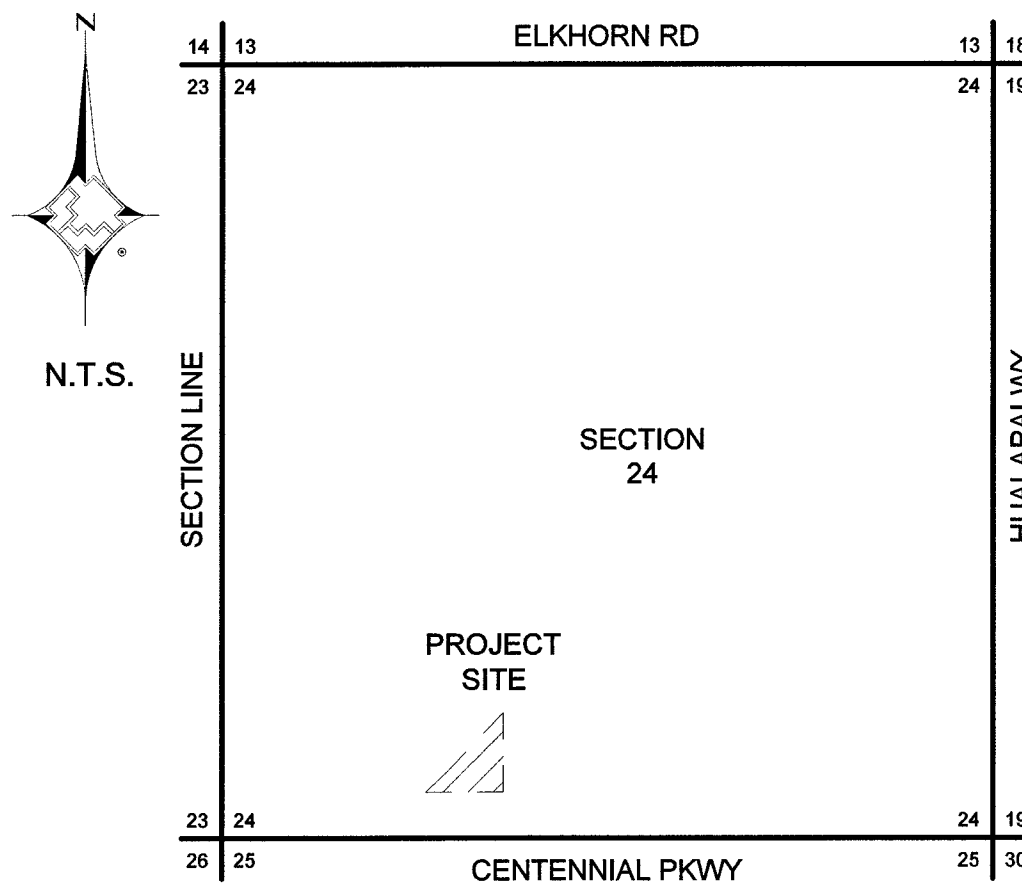

LOCATION MAP
T19S R59E S24

Total footage located in Public ROW

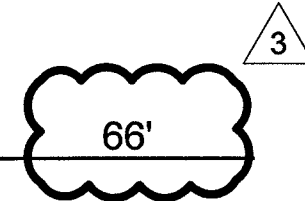

APPROVED FOR CONSTRUCTION

THIS APPROVAL IS FOR WORK IN CLV R/W
OR CLV EASEMENTS ONLY. OBTAINING PERMISSIONS
OR EASEMENTS FOR WORK SHOWN ON PRIVATE
PROPERTY IS THE RESPONSIBILITY OF THE
UTILITY.

APPROVAL


PRELIMINARY
NOT FOR
CONSTRUCTION

DATE: BY:

CUSTOMER 1



Know what's below.
Call before you dig.

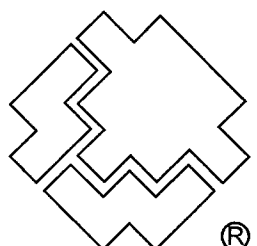

SOUTHWEST GAS CORPORATION

Southwest Gas Corporation Confidential and Proprietary Information

For Reference Only - Not Valid for Line Locating Purposes. No representation or warranty is made for the adequacy, accuracy or completeness of the information or depictions shown. This information is protected from further disclosure under the federal Freedom of Information Act and the Protected Critical Infrastructure Information Act of 2002, and Nevada Revised Statutes § 239C.

This document may not be copied, distributed, or shared to any other person or entity in any manner or form without prior written consent of Southwest Gas Corporation.

REVISIONS						D_VALLEY_WIDE		JOB TYPE	WR NO.	ENGINEER/TECHNICIAN	DAVID FRIEDLANDER	PHONE: (702) 365-2203			
						SYSTEM MAOP:	43	HP SERVICE ☐	3865970	ACCOUNT REP.	TONY VANCHIERI	PHONE: (702) 365-2308			
3	revised main & updated quantities							DISTRIBUTION ☒		PROJECT CONTACT	ANDREW ACUNA	PHONE: (702) 365-8588			
NO.	DESCRIPTION				BY	DATE	APPVD.			SHEET NO.	1 OF 5	SCALE N.T.S.	DATE 09/19/2019		
										DWN. BY	INFINITY	CHKD. BY CS	APPVD. BY BWJ		
PERMIT INFORMATION		ISOLATION AREA	LOCATION	ATLAS OR TILE		N/A		FEEDER ☐	RELATED WR NO.S	ALPINE RIDGE & 215					
CITY OF LAS VEGAS TAX CODE: 02-0200		ISO_21_DIST 024	T19S R59E S24 M.D.M.	X576Y556		SYSTEM MAOP:	N/A	TRANS. BY DEF ☐					N/A		
						SYSTEM MOP:	N/A	TRANS > 20% ☐							
Sheet 9 of 13															
L19-00760 107Y5105															

ALPINE RIDGE & 215

Sheet 9 of 13

L19-00760 107Y5105

PRESSURE TEST PERFORMED BY AND VERIFIED BY SIGNATURES

I HAVE **PERFORMED** THE PRESSURE TESTS AS SHOWN ON THE AS-BUILT AND IN ACCORDANCE WITH THE OPERATIONS MANUAL.
I HAVE **VERIFIED** THE PRESSURE TESTS AS SHOWN ON THE AS-BUILT AND IN ACCORDANCE WITH THE OPERATIONS MANUAL.

PRESSURE TEST # _____ PERFORMED BY _____ DATE _____

SWG VERIFIED BY _____ DATE _____

PURGE PLAN PERFORMED BY SIGNATURES

PURGE PLAN WAS COMPLETED IN ACCORDANCE WITH THE OPERATIONS MANUAL GUIDELINES:

PERFORMED BY _____ DATE _____ SHEET# _____

LOCATION _____

PIPE JOINER VISUAL INSPECTION CERTIFICATION

I HAVE VISUALLY INSPECTED ALL HEATED FUSIONS, SOLVENT, CEMENT, MECHANICAL JOINTS, AND WELDS THAT I HAVE PERFORMED

NAME _____ PJO# _____

2ND VISUAL INSPECTION CERTIFICATION

I HAVE VISUALLY INSPECTED ALL HEATED FUSIONS, SOLVENT, CEMENT AND MECHANICAL JOINTS THAT HAVE BEEN PERFORMED (INSPECTION OF FINAL JOINT ON PLASTIC PIPE ONLY)

NAME _____ PJO# _____

CONSTRUCTION

INSPECTOR _____ PJO# _____

FOREMAN _____ PJO# _____


REVIEWED BY _____ PJO# _____

PRELIMINARY
NOT FOR
CONSTRUCTION

DATE: _____ BY: _____


- GENERAL NOTES:
1. SUGGESTED GAS LOCATIONS ARE TO CLEAR SUBSTRUCTURES LOCATED IN THE FIELD.
 2. ALL PIPELINE CONSTRUCTION SHALL CONFORM TO APPLICABLE JURISDICTION SPECIFICATIONS.
 3. DO NOT SCALE THIS DRAWING.
 4. CHANGE IN PROPOSED MAIN LOCATION MUST BE AUTHORIZED BY SWG ENGINEER PRIOR TO INSTALLATION.
 5. GAS MAINS SHALL BE PURGED PER OPERATIONS MANUAL.
 6. ALL EXISTING UTILITY LOCATIONS TO BE VERIFIED PRIOR TO START OF CONSTRUCTION.
 7. CONTACT ENGINEERING FOR BYPASS INFORMATION.
 8. ALL MAIN TIE-INS REQUIRING TEES ARE TO BE FULL-FLOW TEES UNLESS OTHERWISE STATED.
 9. ALL SHORING REQUIREMENTS SHALL CONFORM TO APPLICABLE PORTIONS OF THE OPERATIONS MANUAL.
 10. REQUEST FOR SURVEYING AND/OR STAKING WILL BE SUBMITTED TO ENGINEERING 72 HOURS IN ADVANCE, MINIMUM.
 11. PROPOSED MAIN SHOULD END 3' PAST THE LAST SERVICE FOR MAIN NOT BEING STUBBED FOR FUTURE PHASE(S).
 12. MINIMUM TEST DURATION REQUIREMENTS AND GUIDELINES FOR MAIN INSTALLATION IN SYSTEMS <60 PSIG ARE:
 - A. MINIMUM TEST DURATION IS 8 HOURS FOR PIPES 1-1/4-INCHES OR GREATER, WITH FOOTAGES BETWEEN 3,001 FEET AND 10,000 FEET
 - B. ALL FOOTAGES GREATER THAN 3,000 FEET REQUIRE A CHART
 - C. CONSTRUCTION SHALL CONTACT ENGINEERING FOR MINIMUM TEST DURATIONS IF THE FOOTAGE TO BE TESTED EXCEEDS 10,000 FEET
 13. TRENCHING AND BACKFILL TO CONFORM WITH RTC STANDARD 503 AND UNIFORM STANDARD SPECIFICATION SECTION 208.
 14. MAINTAIN MINIMUM 12" VERTICAL SEPARATION AT ALL POINTS OF CROSSING.
 15. ANY EXCAVATION EXPOSING LVVWD FACILITIES 24" IN DIAMETER AND LARGER MUST REMAIN OPEN UNTIL INSPECTED BY LVVWD. NO BACKFILL MATERIAL IS TO BE PLACED IN THE EXCAVATION UNTIL APPROVED BY THE LVVWD INSPECTOR. ANY DAMAGE TO THE FACILITIES MUST BE REPORTED TO LVVWD IMMEDIATELY. CONTRACTOR TO CALL (702) 258-7171 TO SCHEDULE LVVWD INSPECTION.
 16. THIS PROJECT IS NOT INSTALLING, ABANDONING, OR TYING INTO ANY STEEL GAS FACILITIES.

THIS PROJECT IS NOT INSTALLING, ABANDONING, OR TYING INTO ANY STEEL GAS FACILITIES.

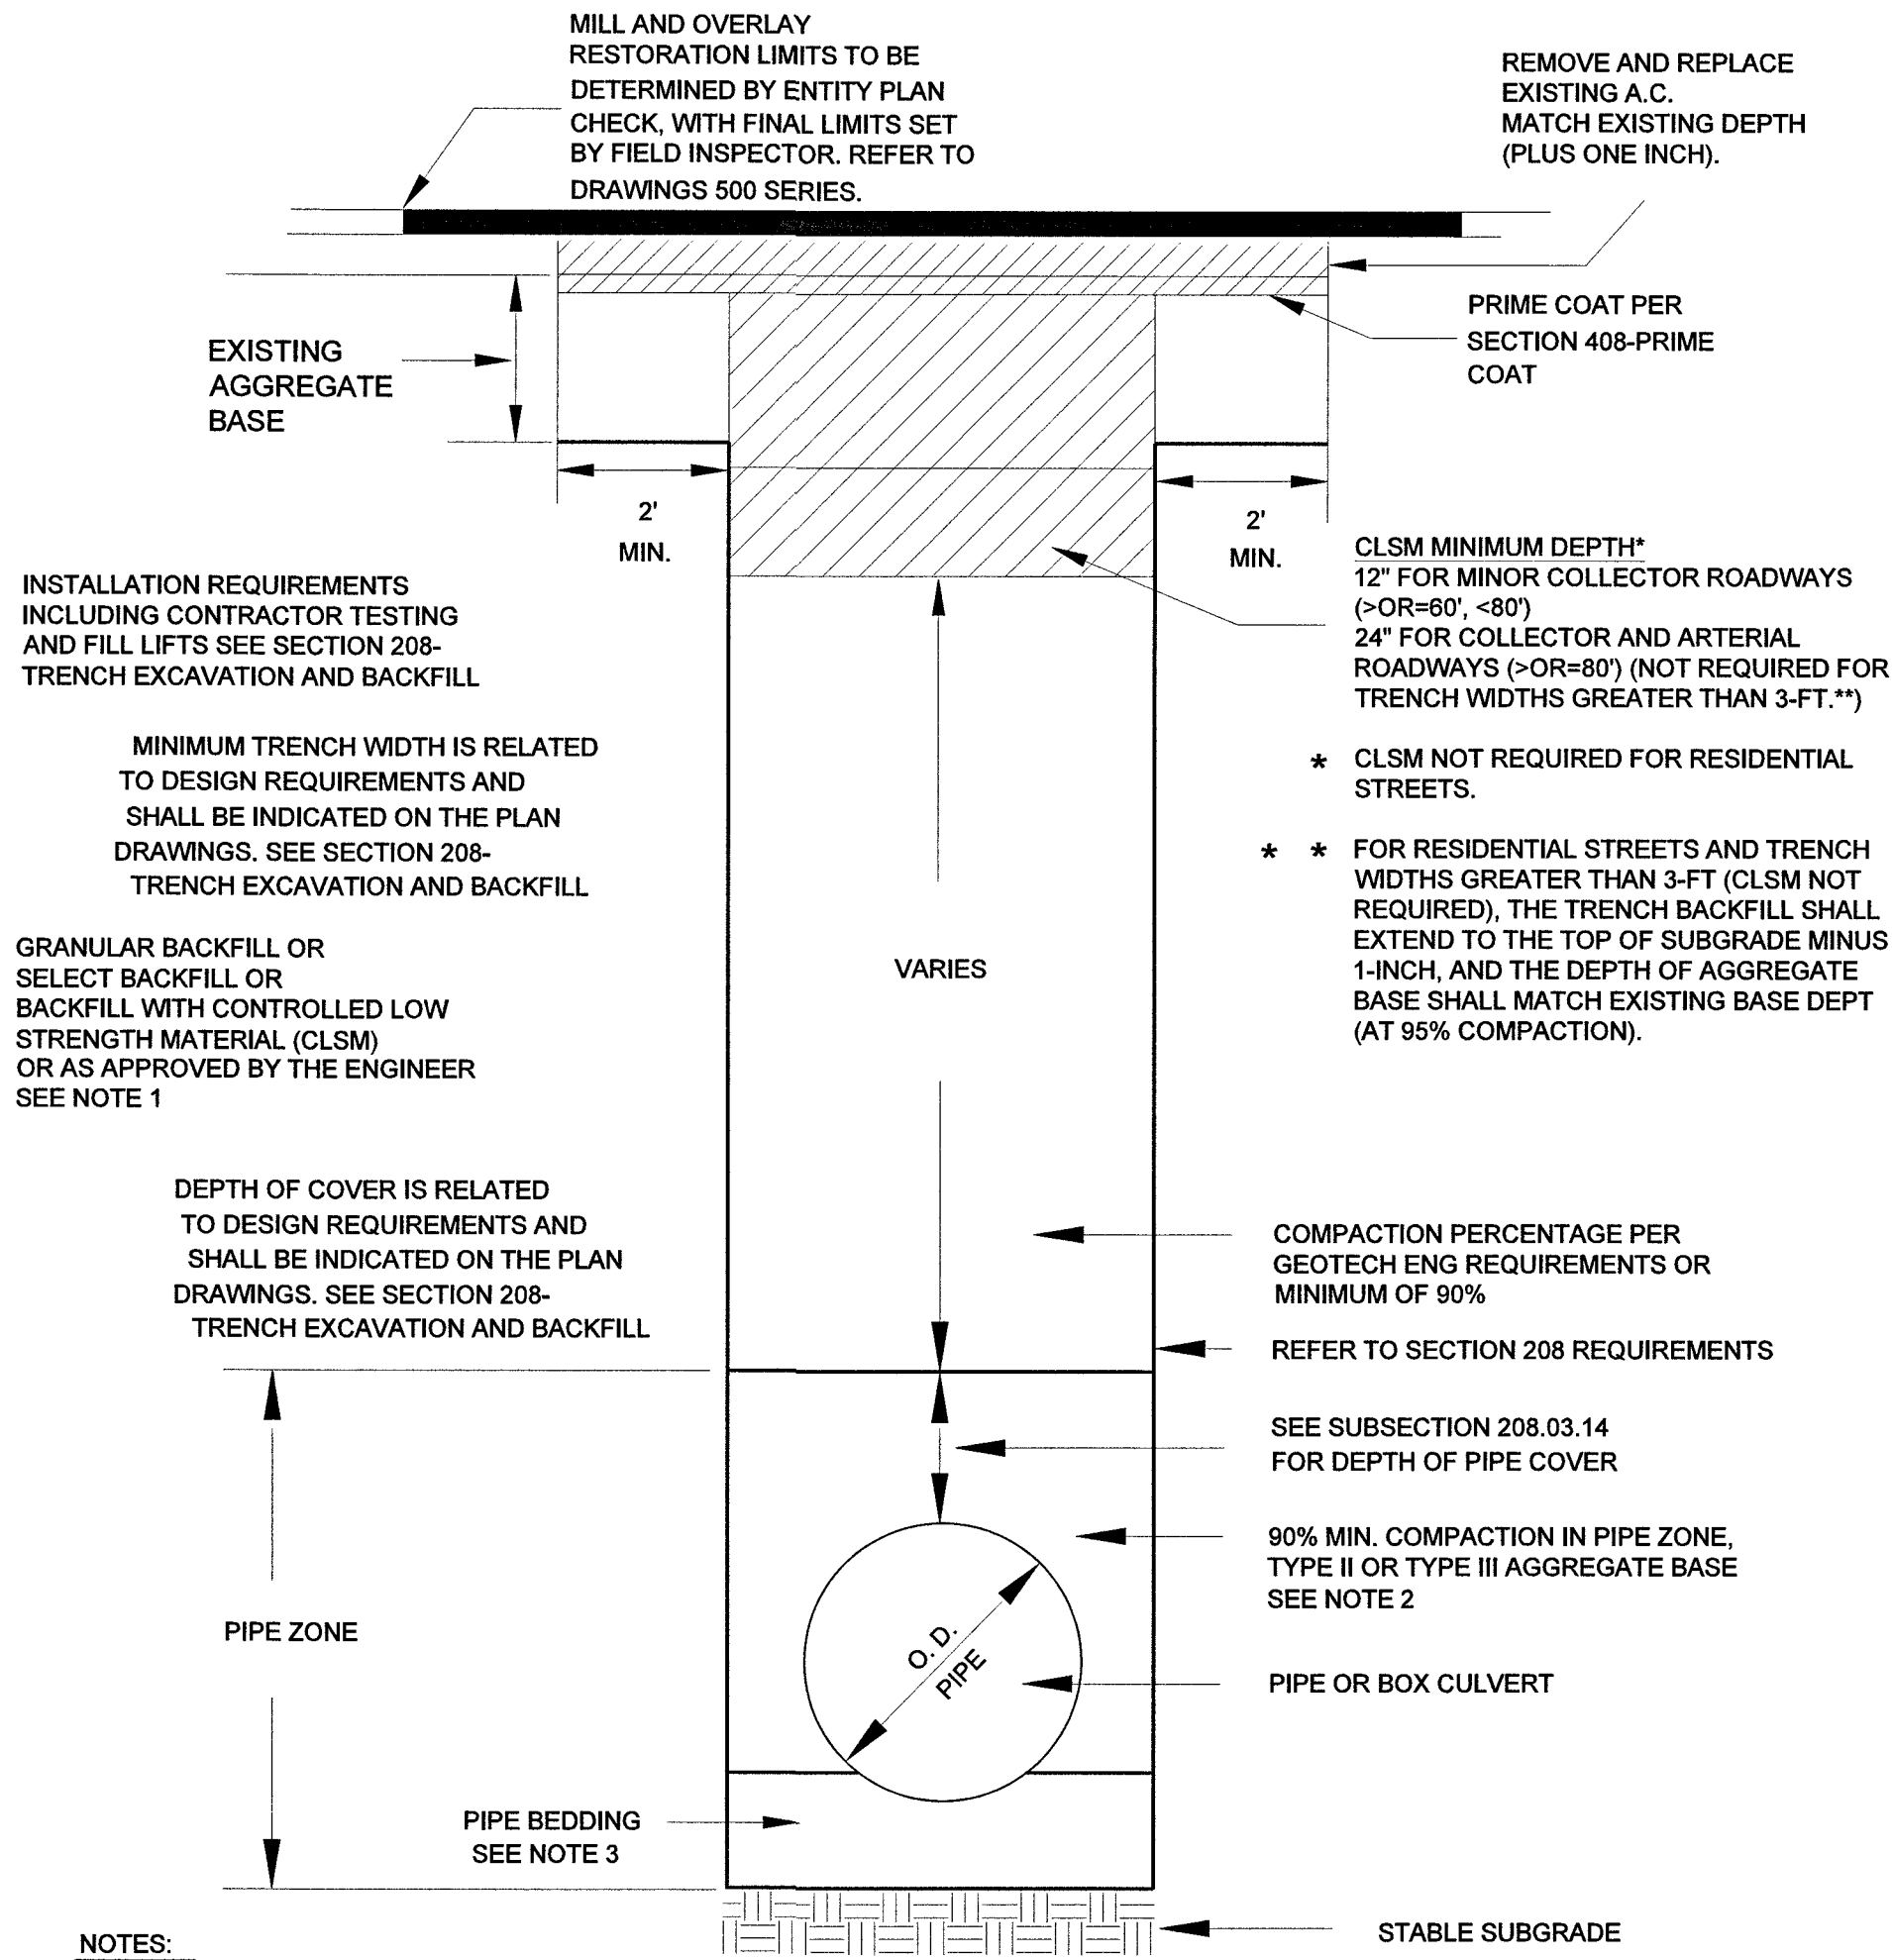

1. NO STONES OR LUMPS GREATER THAN 3" PERMITTED IN TRENCH 2' OR LESS IN WIDTH.
2. TRENCH WIDTH, BEDDING, SUBGRADE AND PIPE ZONE REQUIREMENTS FOR UTILITY INSTALLATIONS SHALL CONFORM TO THE RESPECTIVE ENTITY REQUIREMENTS.
3. CRUSHED ROCK MAY BE USED FOR PIPE BEDDING ONLY IF MATERIAL USE HAS BEEN SPECIFICALLY APPROVED BY THE GOVERNING AGENCY. SEE STANDARD DRAWING NO. 505 FOR PIPE BEDDING METHODS.
4. LAS VEGAS VALLEY WATER DISTRICT REQUIRES PIPE BEDDING AND BACKFILL WITHIN THE PIPE ZONE TO BE OF THE SAME MATERIAL.

RTC STD DWG 503

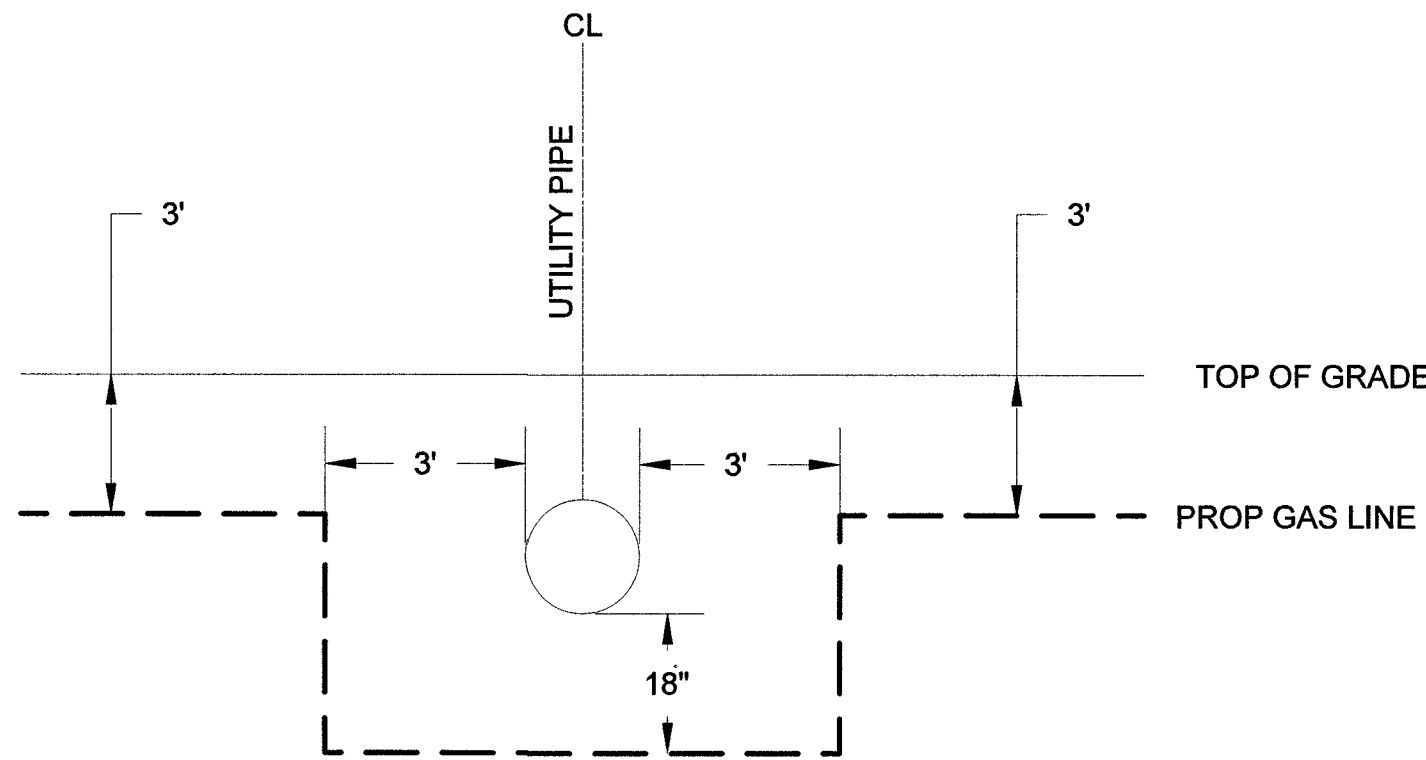

**TYPICAL UTILITY
CROSSING DETAIL
N.T.S.**

ABBREVIATIONS:

AA ALDYL-A PIPE
ABND ABANDONED
AC ASPHALTIC CONCRETE
AC# ACCELERATED CONSTRUCTION
ACP ASBESTOS CEMENT PIPE
APN ASSESSOR PARCEL NUMBER

BLVD BOULEVARD
BM BENCHMARK
BO BLOW OFF
BTU BRITISH THERMAL UNIT

CIP CAST IRON PIPE
CL CENTERLINE
CMP CORRUGATED METAL PIPE
CP CATHODIC PROTECTION

D INSIDE DIAMETER
DDCA DESIGN DATA COLLECTION APPLICATION
DET DETAIL
DIP DUCTILE IRON PIPE
DIA DIAMETER
DIMP DISTRIBUTION INTEGRITY MANAGEMENT PROGRAM
DP DESIGN PRESSURE
DWG DRAWING

EFV EXCESS FLOW VALVE
EG EXISTING GRADE
ELEC ELECTRICAL
ELEV ELEVATION
EMS ELECTRONIC MARKING SYSTEM
E.P END POINT
EPR ELECTRONIC PRESSURE RECORDERS
ESMT EASEMENT
EX EXISTING

FERC FEDERAL ENERGY REGULATORY COMMISSION
FH FIRE HYDRANT

GIR GAS INFRASTRUCTURE REPLACEMENT
GPR GAS PRESSURE REGULATOR

HCA HIGH CONSEQUENCE AREA
HDD HEATING DEGREE DAY
HDPE HIGH DENSITY POLYETHYLENE PIPE
HP HIGH PRESSURE
HOP HISTORIC OPERATING PRESSURE
HVTT HIGH VOLUME TAPPING TEE

IN INCH(ES)
IPS IRON PIPE SIZE

JT JOINT TRENCH

MAOP MAXIMUM ALLOWABLE OPERATING PRESSURE
M&C MEASUREMENTS & CONTROL
MCFH THOUSAND CUBIC FEET PER HOUR
MH MANHOLE
MOP MAXIMUM OPERATING PRESSURE
MP MANUFACTURER'S PRESSURE RATING
MSA METER SET ASSEMBLY
MVP MAPPING VERIFICATION PROCEDURE

NAP NOT A PART
NTSB NATIONAL TRANSPORTATION SAFETY BOARD

NTS NOT TO SCALE
OC ON CENTER
OD OUTSIDE DIAMETER
OH OVERHEAD
OHE OVERHEAD ELECTRIC

P POWER
PAOP POTENTIAL ALLOWABLE OPERATING PRESSURE
PCC PORTLAND CEMENT CONCRETE
PE POLYETHYLENE PIPE
PH POT HOLE
PHMSA PIPELINE & HAZARDOUS MATERIALS SAFETY

PL ADMINISTRATION
PL PROPERTY LINE
PIC POTENTIAL IMPACT CIRCLE
PLS PRESSURE LIMITING STATION
P.O.B POINT OF BEGINNING
PP POWER POLE
PROP PROPOSED
PQF PREQUALIFIED FITTING
PSIG POUNDS PER SQUARE INCH (GAUGE)
PVC POLYVINYL CHLORIDE
PUE PUBLIC UTILITY EASEMENT

RC REINFORCED CONCRETE
RCP REINFORCED CONCRETE PIPE
ROW RIGHT OF WAY

SCADA SUPERVISORY CONTROL AND DATA ACQUISITION
SD STORM DRAIN
SDMH STORM DRAIN MANHOLE
SDR STANDARD DIMENSION RATIO
SF SQUARE FOOT
SHT SHEET
SLSV SERVICE LINE SHUT-OFF VALVE
SMYS SPECIFIED MAXIMUM YIELD STRENGTH
SS SANITARY SEWER
SST STAINLESS STEEL
ST STREET
STA STATION
STL STEEL
SWG SOUTHWEST GAS

TDS TEST DATA SHEET
TEL TELEPHONE
TB THRUST BLOCK
TOP TOP OF PIPE
TP TEST POINT
TS TECHNICAL SERVICE NOTE
TRIMP TRANSMISSION INTEGRITY MANAGAMENT PROGRAM
TYP TYPICAL

U.E. UTILITY EASEMENT
UGE UNDERGROUND ELECTRIC
UOC UNUSUAL OPERATING CONDITION
USD UNIFORM STANDARD DRAWING
UGT UNDERGROUND TELEPHONE

VCP VITRIFIED CLAY PIPE
VERT VERTICAL
VG VALLEY GUTTER
VSP VINTAGE STEEL PIPE

W WATER
WMS WORK MANAGEMENT SYSTEM
WR WORK REQUEST
WT WALL THICKNESS
WV WATER VALVE


YD YARD(S)

**PRELIMINARY
NOT FOR
CONSTRUCTION**

DATE: _____ BY: _____



Know what's below.
Call before you dig.

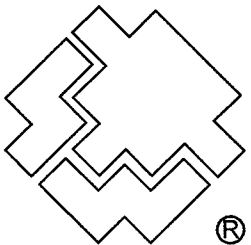

SOUTHWEST GAS CORPORATION

Southwest Gas Corporation Confidential and Proprietary Information

For Reference Only - Not Valid for Line Locating Purposes. No representation or warranty is made for the adequacy, accuracy or completeness of the information or depictions shown. This information is protected from further disclosure under the federal Freedom of Information Act and the Protected Critical Infrastructure Information Act of 2002, and Nevada Revised Statutes § 239C.

This document may not be copied, distributed, or shared to any other person or entity in any manner or form without prior written consent of Southwest Gas Corporation.

REVISIONS

NO.	DESCRIPTION	BY	DATE	APPVD.
3	revised main & updated quantities			

PERMIT INFORMATION	ISOLATION AREA	LOCATION	ATLAS OR TILE
CITY OF LAS VEGAS TAX CODE: 02-0200	ISO_21_DIST 024	T19S R59E S24 M.D.M.	X576Y556

D_VALLEY_WIDE

SYSTEM MAOP:	43
SYSTEM MOP:	43

SYSTEM MAOP:	N/A
SYSTEM MOP:	N/A

JOB TYPE

HP SERVICE	☐
DISTRIBUTION	☒
FEEDER	☐
TRANS. BY DEF	☐
TRANS > 20%	☐

WR NO.


3865970
RELATED WR NO.S
N/A

ENGINEER/TECHNICIAN	DAVID FRIEDLANDER	PHONE: (702) 365-2203
ACCOUNT REP.	TONY VANCHIERI	PHONE: (702) 365-2308
PROJECT CONTACT	ANDREW ACUNA	PHONE: (702) 365-8588
SHEET NO.	3 OF 5	SCALE N.T.S.
DWN. BY	INFINITY	CHKD. BY CS
APPVD. BY	BWJ	


ALPINE RIDGE & 215

Sheet 11 of 13 119-00760 107Y5105


TYPICAL SWPPP BMPs DETAILS

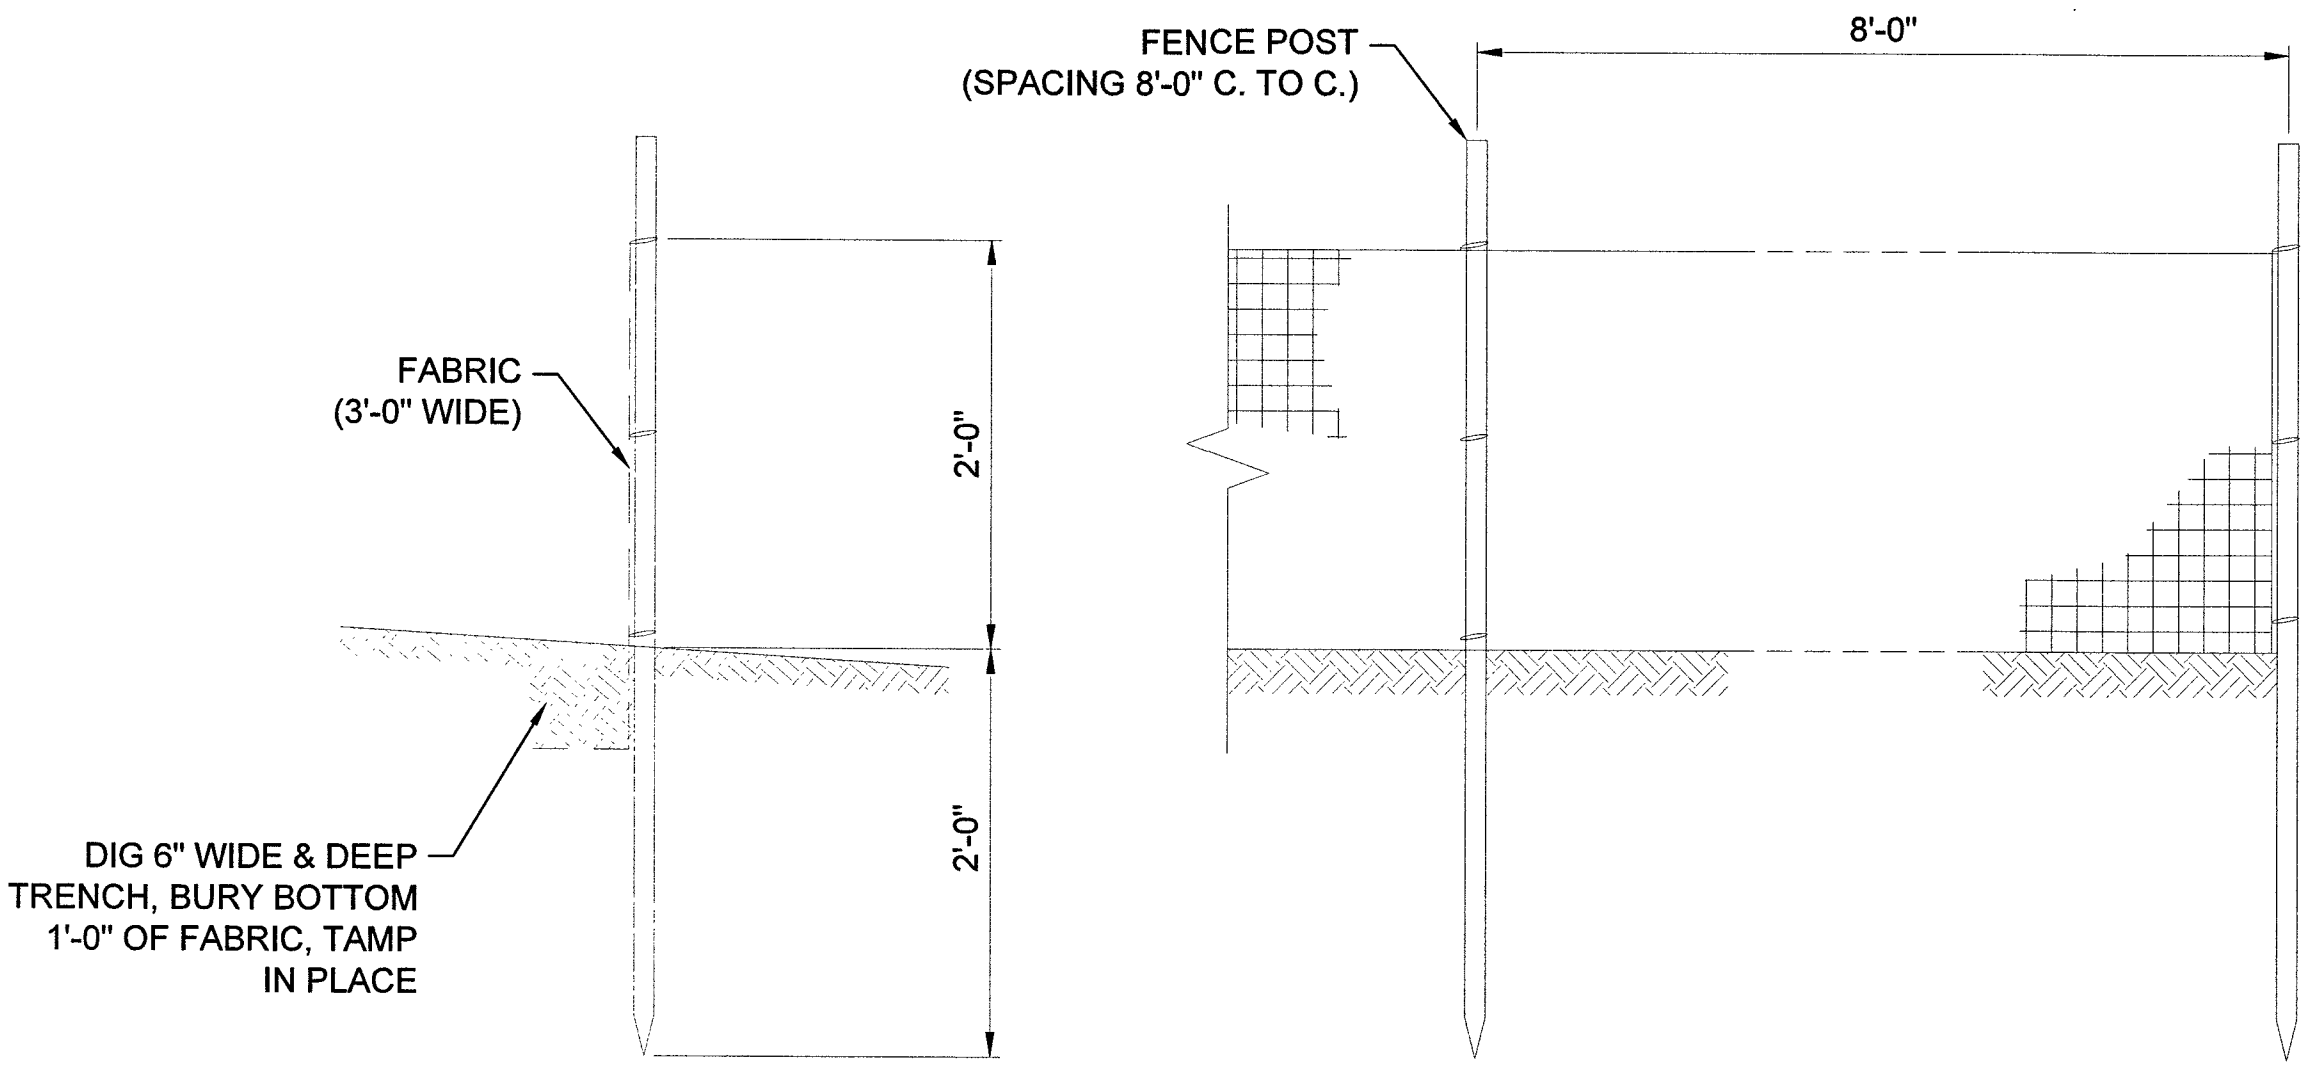


1 SILT FENCE
4 NOT TO SCALE

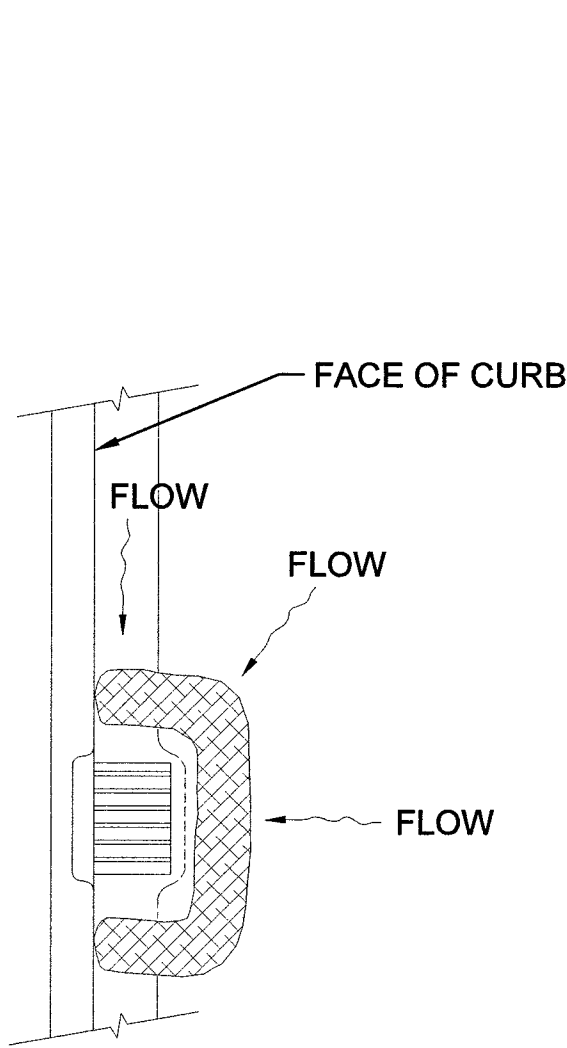


2 FIBER ROLL
4 NOT TO SCALE

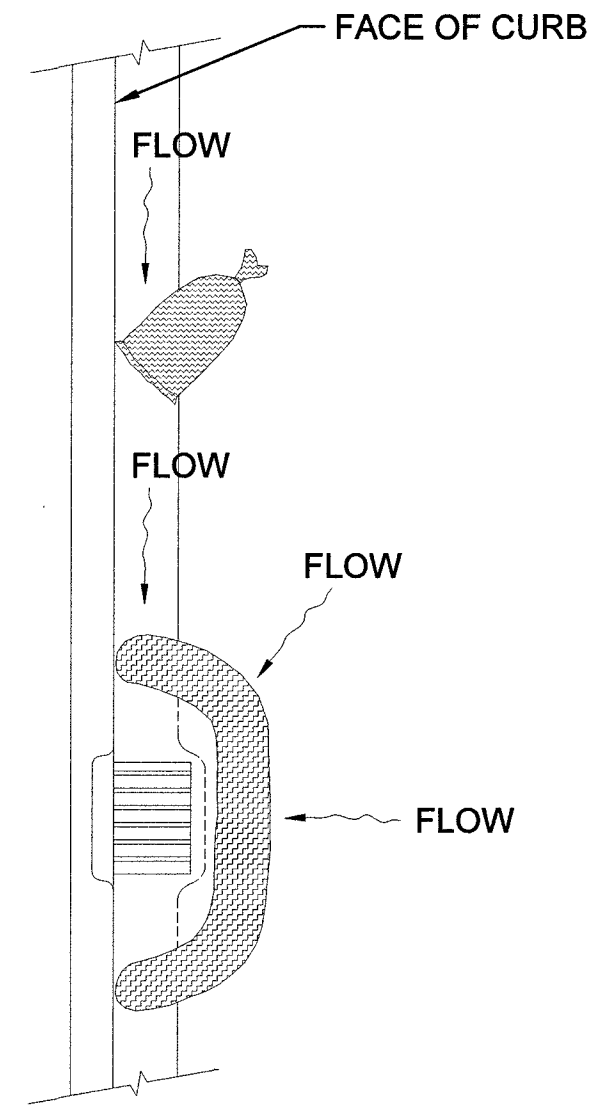



3 SAND BAG / ROLL
4 NOT TO SCALE

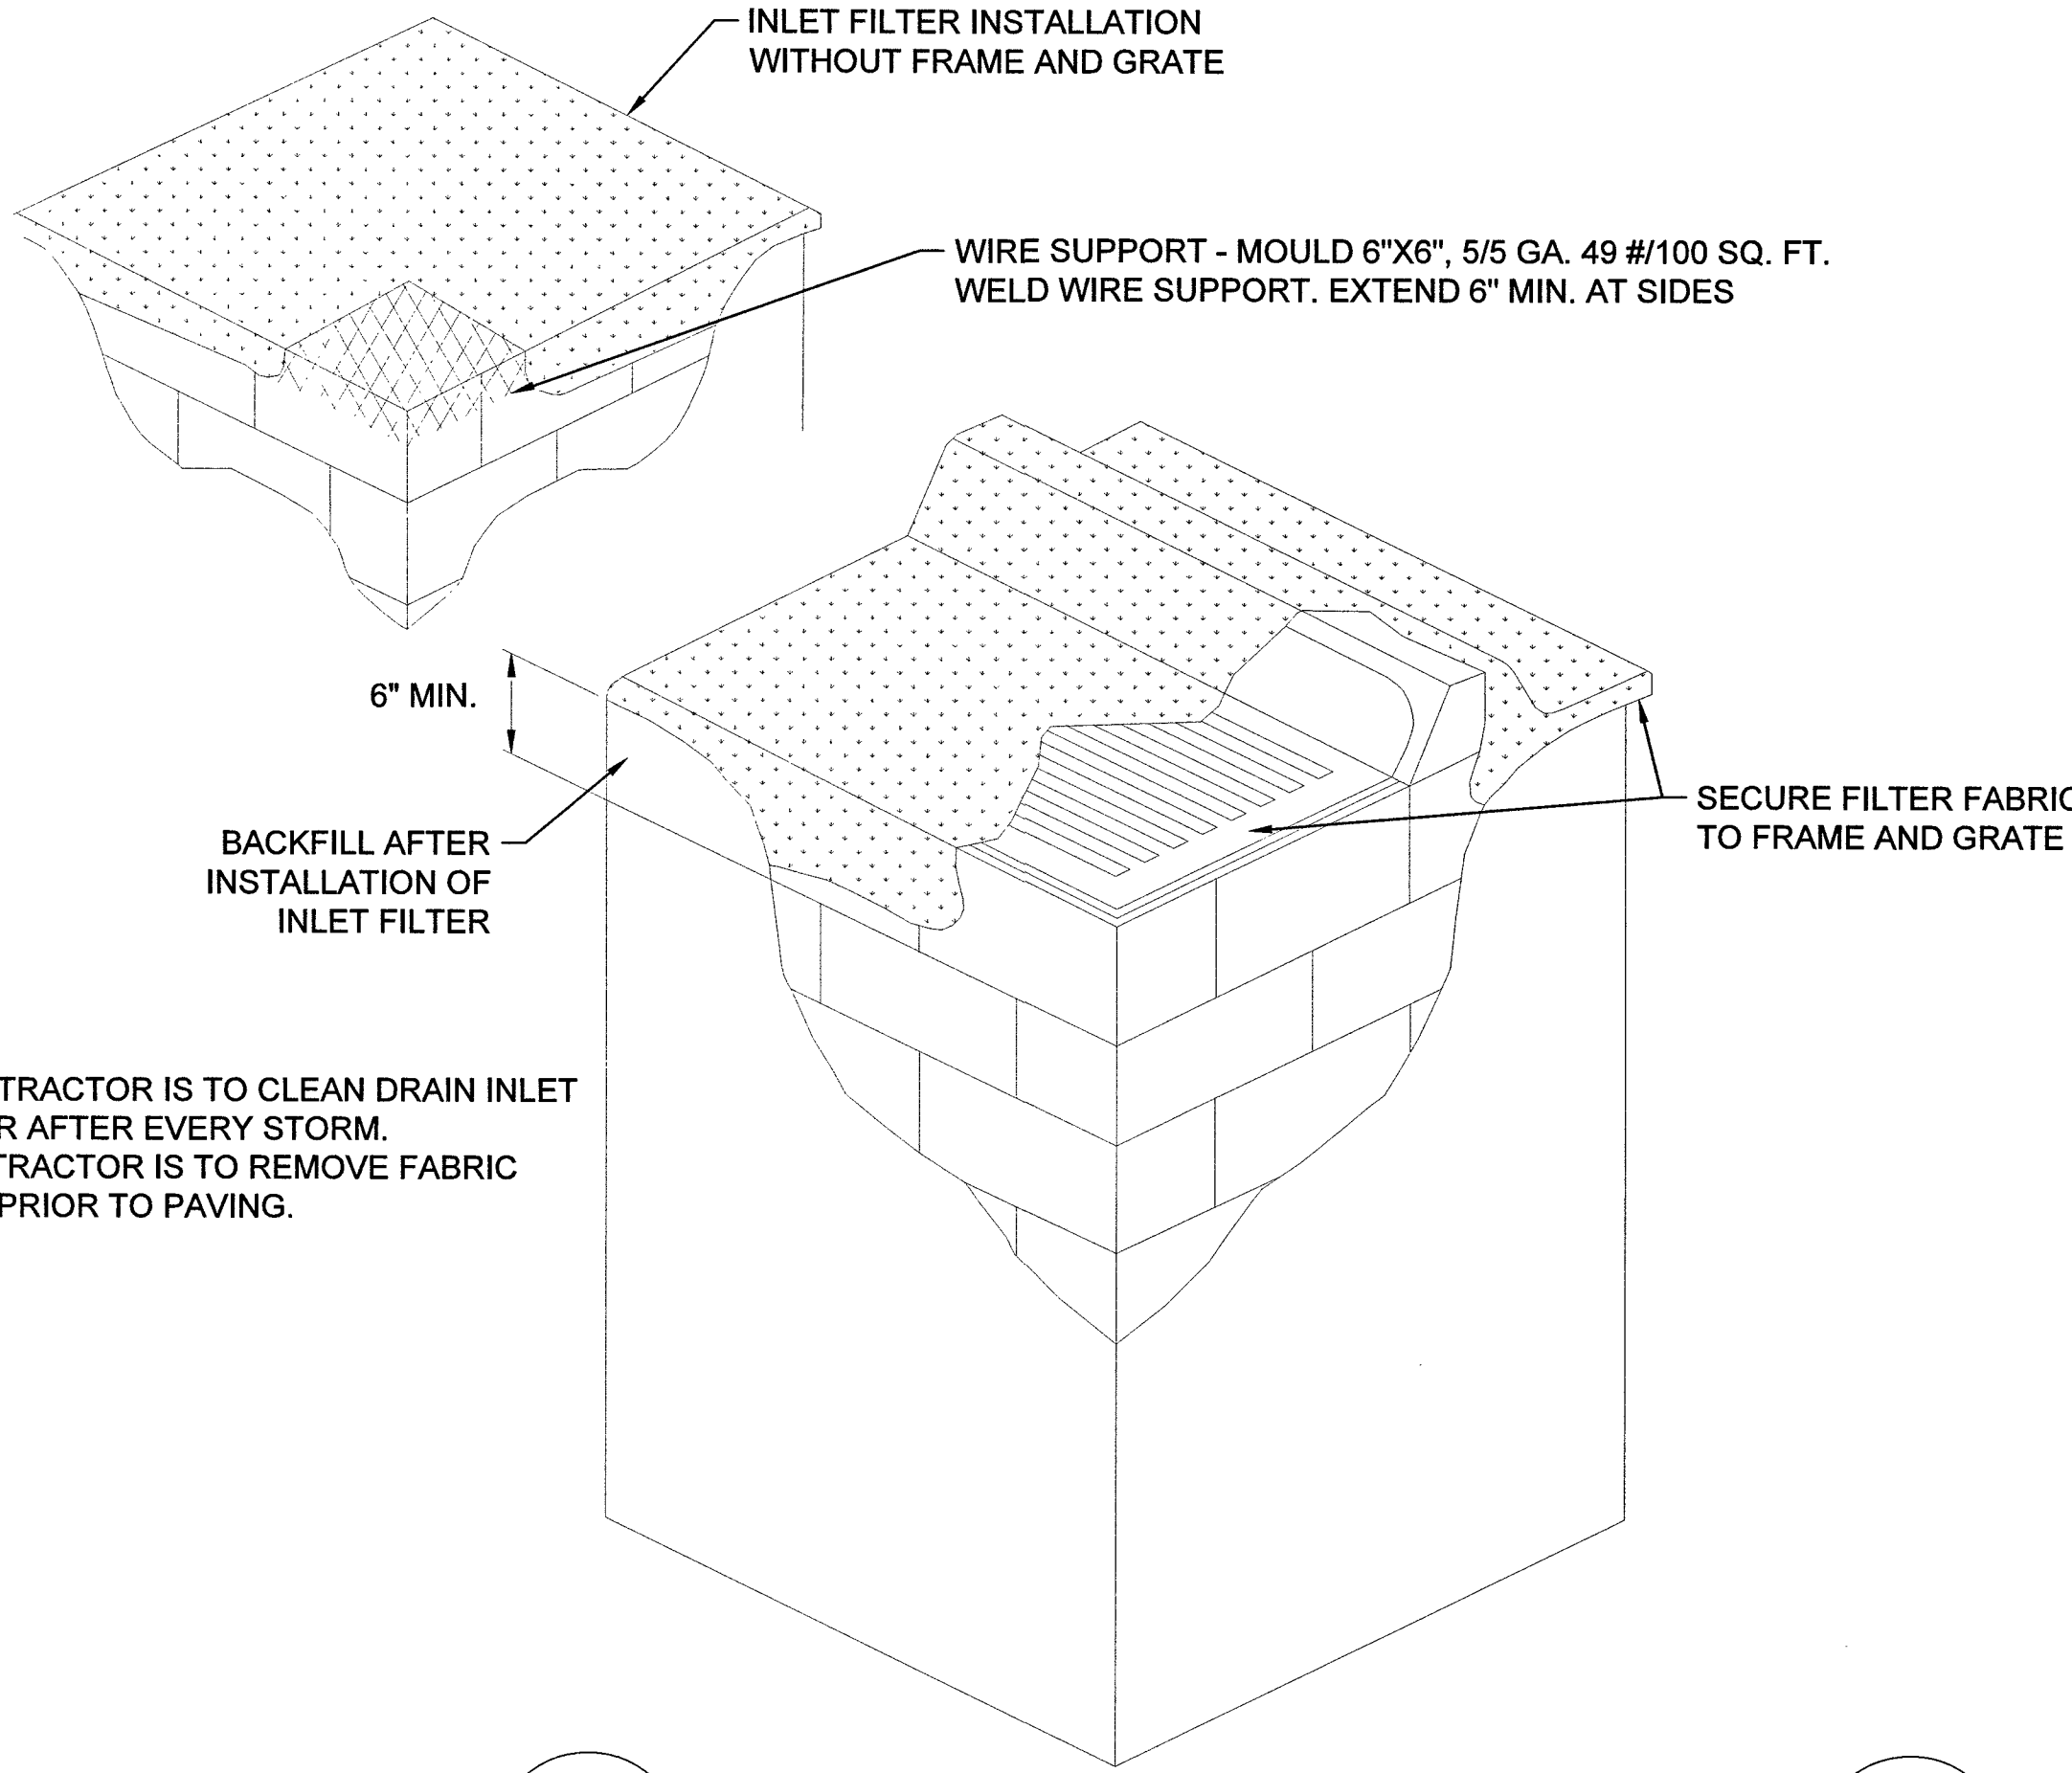

4 DRAIN INLET FILTER
4 NOT TO SCALE

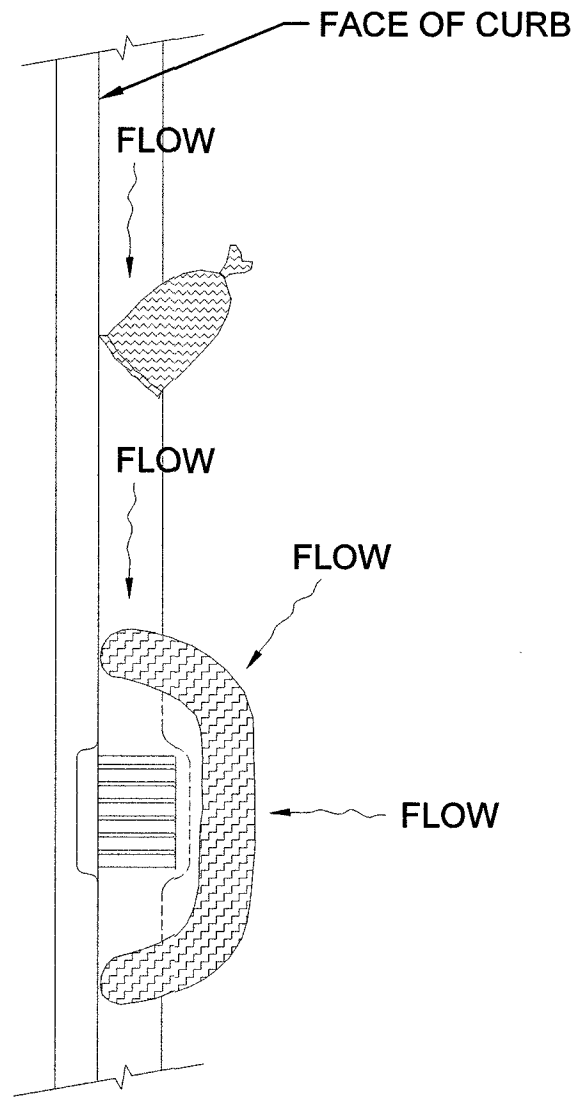

5 GRAVEL BAG / ROLL
4 NOT TO SCALE

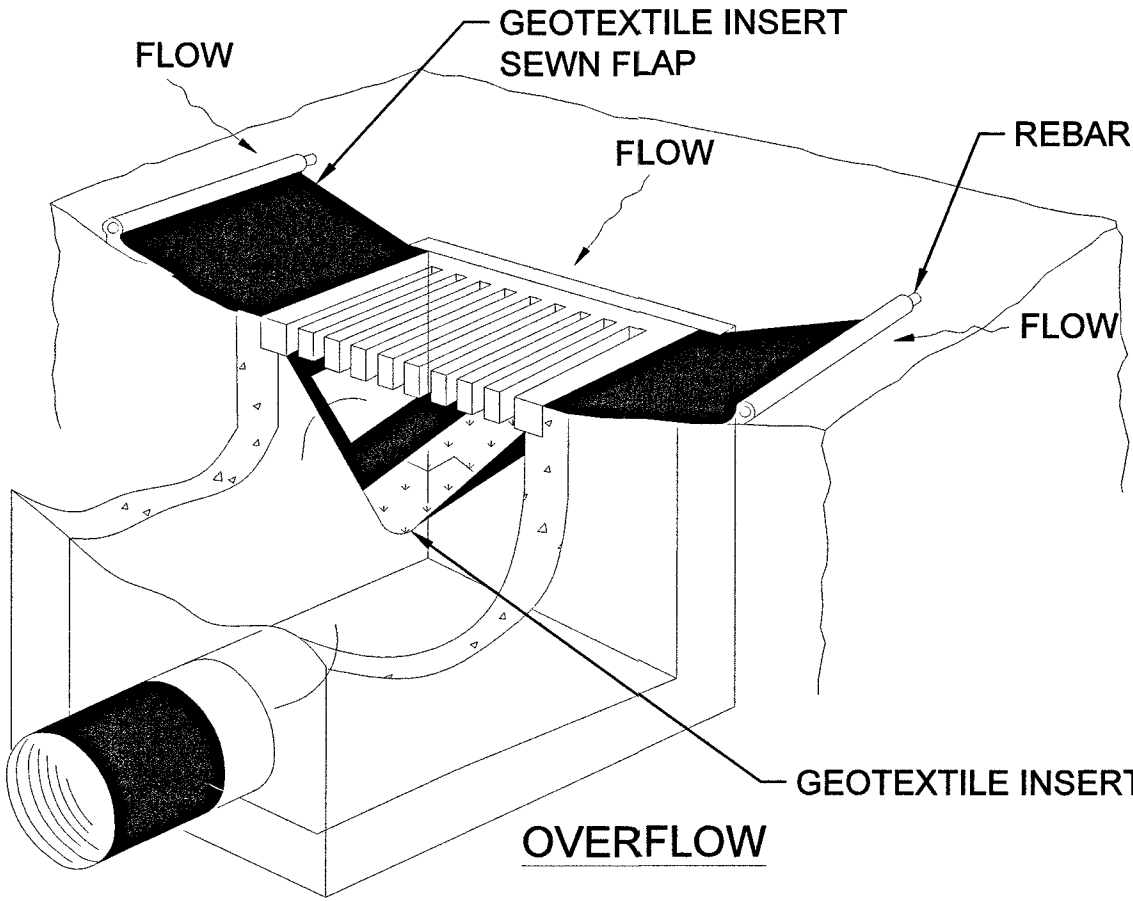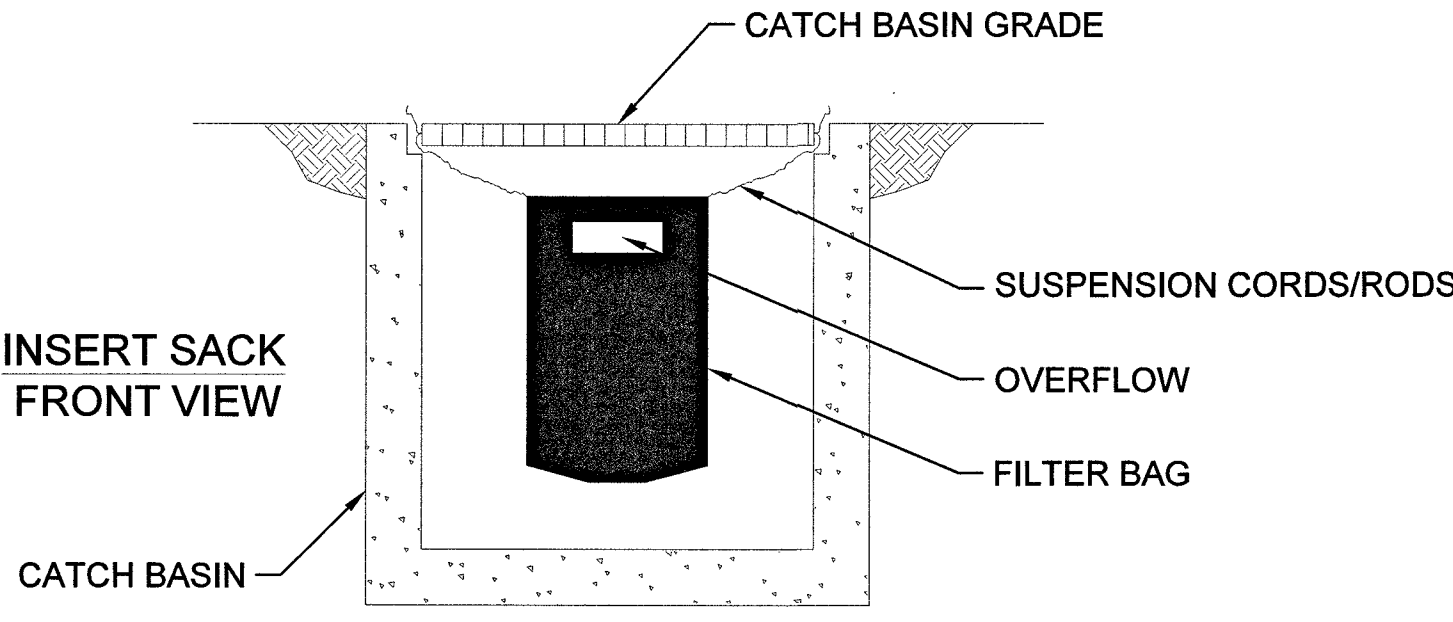

NOTE: RECESSED CURB INLET MUST BE BLOCKED WHEN USING FILTER FABRIC INLET SACKS. SIZE OF FILTER FABRIC INLET SACK TO BE DETERMINED BY MANUFACTURER.

6 SEDIMENT FILTER BAG
4 NOT TO SCALE

STORMWATER NOTES

1. SOUTHWEST GAS CORPORATION, ITS CONTRACTOR, AND/OR THEIR AUTHORIZED AGENTS SHALL INSTALL ONE OF THE APPROPRIATE BMPs FOR THE PROTECTION OF EXISTING STORM DRAIN INLETS, WITHIN OR SIGNIFICANTLY NEAR ANY IMPROVED RIGHT-OF-WAY, FROM DEBRIS AND SEDIMENT RESULTING FROM CONSTRUCTION OF NATURAL GAS FACILITIES.
2. SOUTHWEST GAS CORPORATION, ITS CONTRACTOR, AND/OR THEIR AUTHORIZED AGENTS SHALL EACH DAY REMOVE ALL SEDIMENT, MUD, CONSTRUCTION DEBRIS, OR OTHER POTENTIAL POLLUTANTS THAT MAY HAVE BEEN DISCHARGED TO, OR ACCUMULATED IN, THE PUBLIC RIGHTS OF WAY OF CLARK COUNTY AS A RESULT OF CONSTRUCTION ACTIVITIES ASSOCIATED WITH THIS SITE DEVELOPMENT OR CONSTRUCTION PROJECT. SUCH MATERIALS SHALL BE PREVENTED FROM ENTERING THE STORM SEWER SYSTEM, USING BEST MANAGEMENT PRACTICES DETAILED ON THIS SHEET.
3. ADDITIONAL CONSTRUCTION SITE DISCHARGE BEST MANAGEMENT PRACTICES MAY BE REQUIRED OF SOUTHWEST GAS CORPORATION, ITS CONTRACTOR, AND/OR THEIR AUTHORIZED AGENTS DUE TO UNFORESEEN EROSION PROBLEMS OR IF THE LISTED BMPs ON THIS SHEET DO NOT MEET THE PERFORMANCE STANDARDS SPECIFIED IN THE CLARK COUNTY CODE - CHAPTER 24.40/STORM SEWER SYSTEM DISCHARGE AND THE LAS VEGAS VALLEY CONSTRUCTION SITE BMP GUIDANCE MANUAL.
4. ACCUMULATED SEDIMENT IN BMPs SHALL BE REMOVED WITHIN SEVEN DAYS AFTER A STORMWATER RUNOFF EVENT OR PRIOR TO THE NEXT ANTICIPATED STORM EVENT, WHICHEVER IS EARLIER. SEDIMENT MUST BE REMOVED WHEN BMP DESIGN CAPACITY HAS BEEN REDUCED BY 50 PERCENT OR MORE.


NOTE:
1. CONTRACTOR IS TO CLEAN DRAIN INLET FILTER AFTER EVERY STORM.
2. CONTRACTOR IS TO REMOVE FABRIC JUST PRIOR TO PAVING.

PRELIMINARY
NOT FOR
CONSTRUCTION

DATE: _____ BY: _____



Know what's below.
Call before you dig.


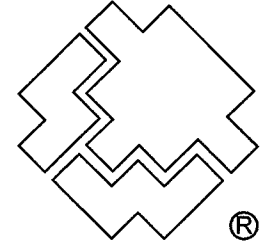


SOUTHWEST GAS CORPORATION

Southwest Gas Corporation Confidential and Proprietary Information
For Reference Only - Not Valid for Line Locating Purposes. No representation or warranty is made for the adequacy, accuracy or completeness of the information or depictions shown. This information is protected from further disclosure under the federal Freedom of Information Act and the Protected Critical Infrastructure Information Act of 2002, and Nevada Revised Statutes § 239C.

This document may not be copied, distributed, or shared to any other person or entity in any manner or form without prior written consent of Southwest Gas Corporation.

REVISIONS						D_VALLEY_WIDE		JOB TYPE		WR NO.		ENGINEER/TECHNICIAN	DAVID FRIEDLANDER	PHONE: (702) 365-2203	
										3865970	ACCOUNT REP.	TONY VANCHIERI	PHONE: (702) 365-2308		
											PROJECT CONTACT	ANDREW ACUNA	PHONE: (702) 365-8588		
3	revised main & updated quantities										SHEET NO. 4 OF 5	SCALE N.T.S.	DATE 09/19/2019		
NO.	DESCRIPTION					BY	DATE	APPVD.			DWN. BY INFINITY	CHKD. BY CS	APPVD. BY BWJ		
PERMIT INFORMATION		ISOLATION AREA		LOCATION		ATLAS OR TILE		N/A		FEEDER	RELATED WR NO.S	ALPINE RIDGE & 215			
CITY OF LAS VEGAS TAX CODE: 02-0200		ISO_21_DIST 024		T19S R59E S24 M.D.M.		X576Y556		SYSTEM MAOP: N/A	TRANS. BY DEF	N/A					
								SYSTEM MOP: N/A	TRANS > 20%						
Sheet 12 of 13															
119-00760 10745105															

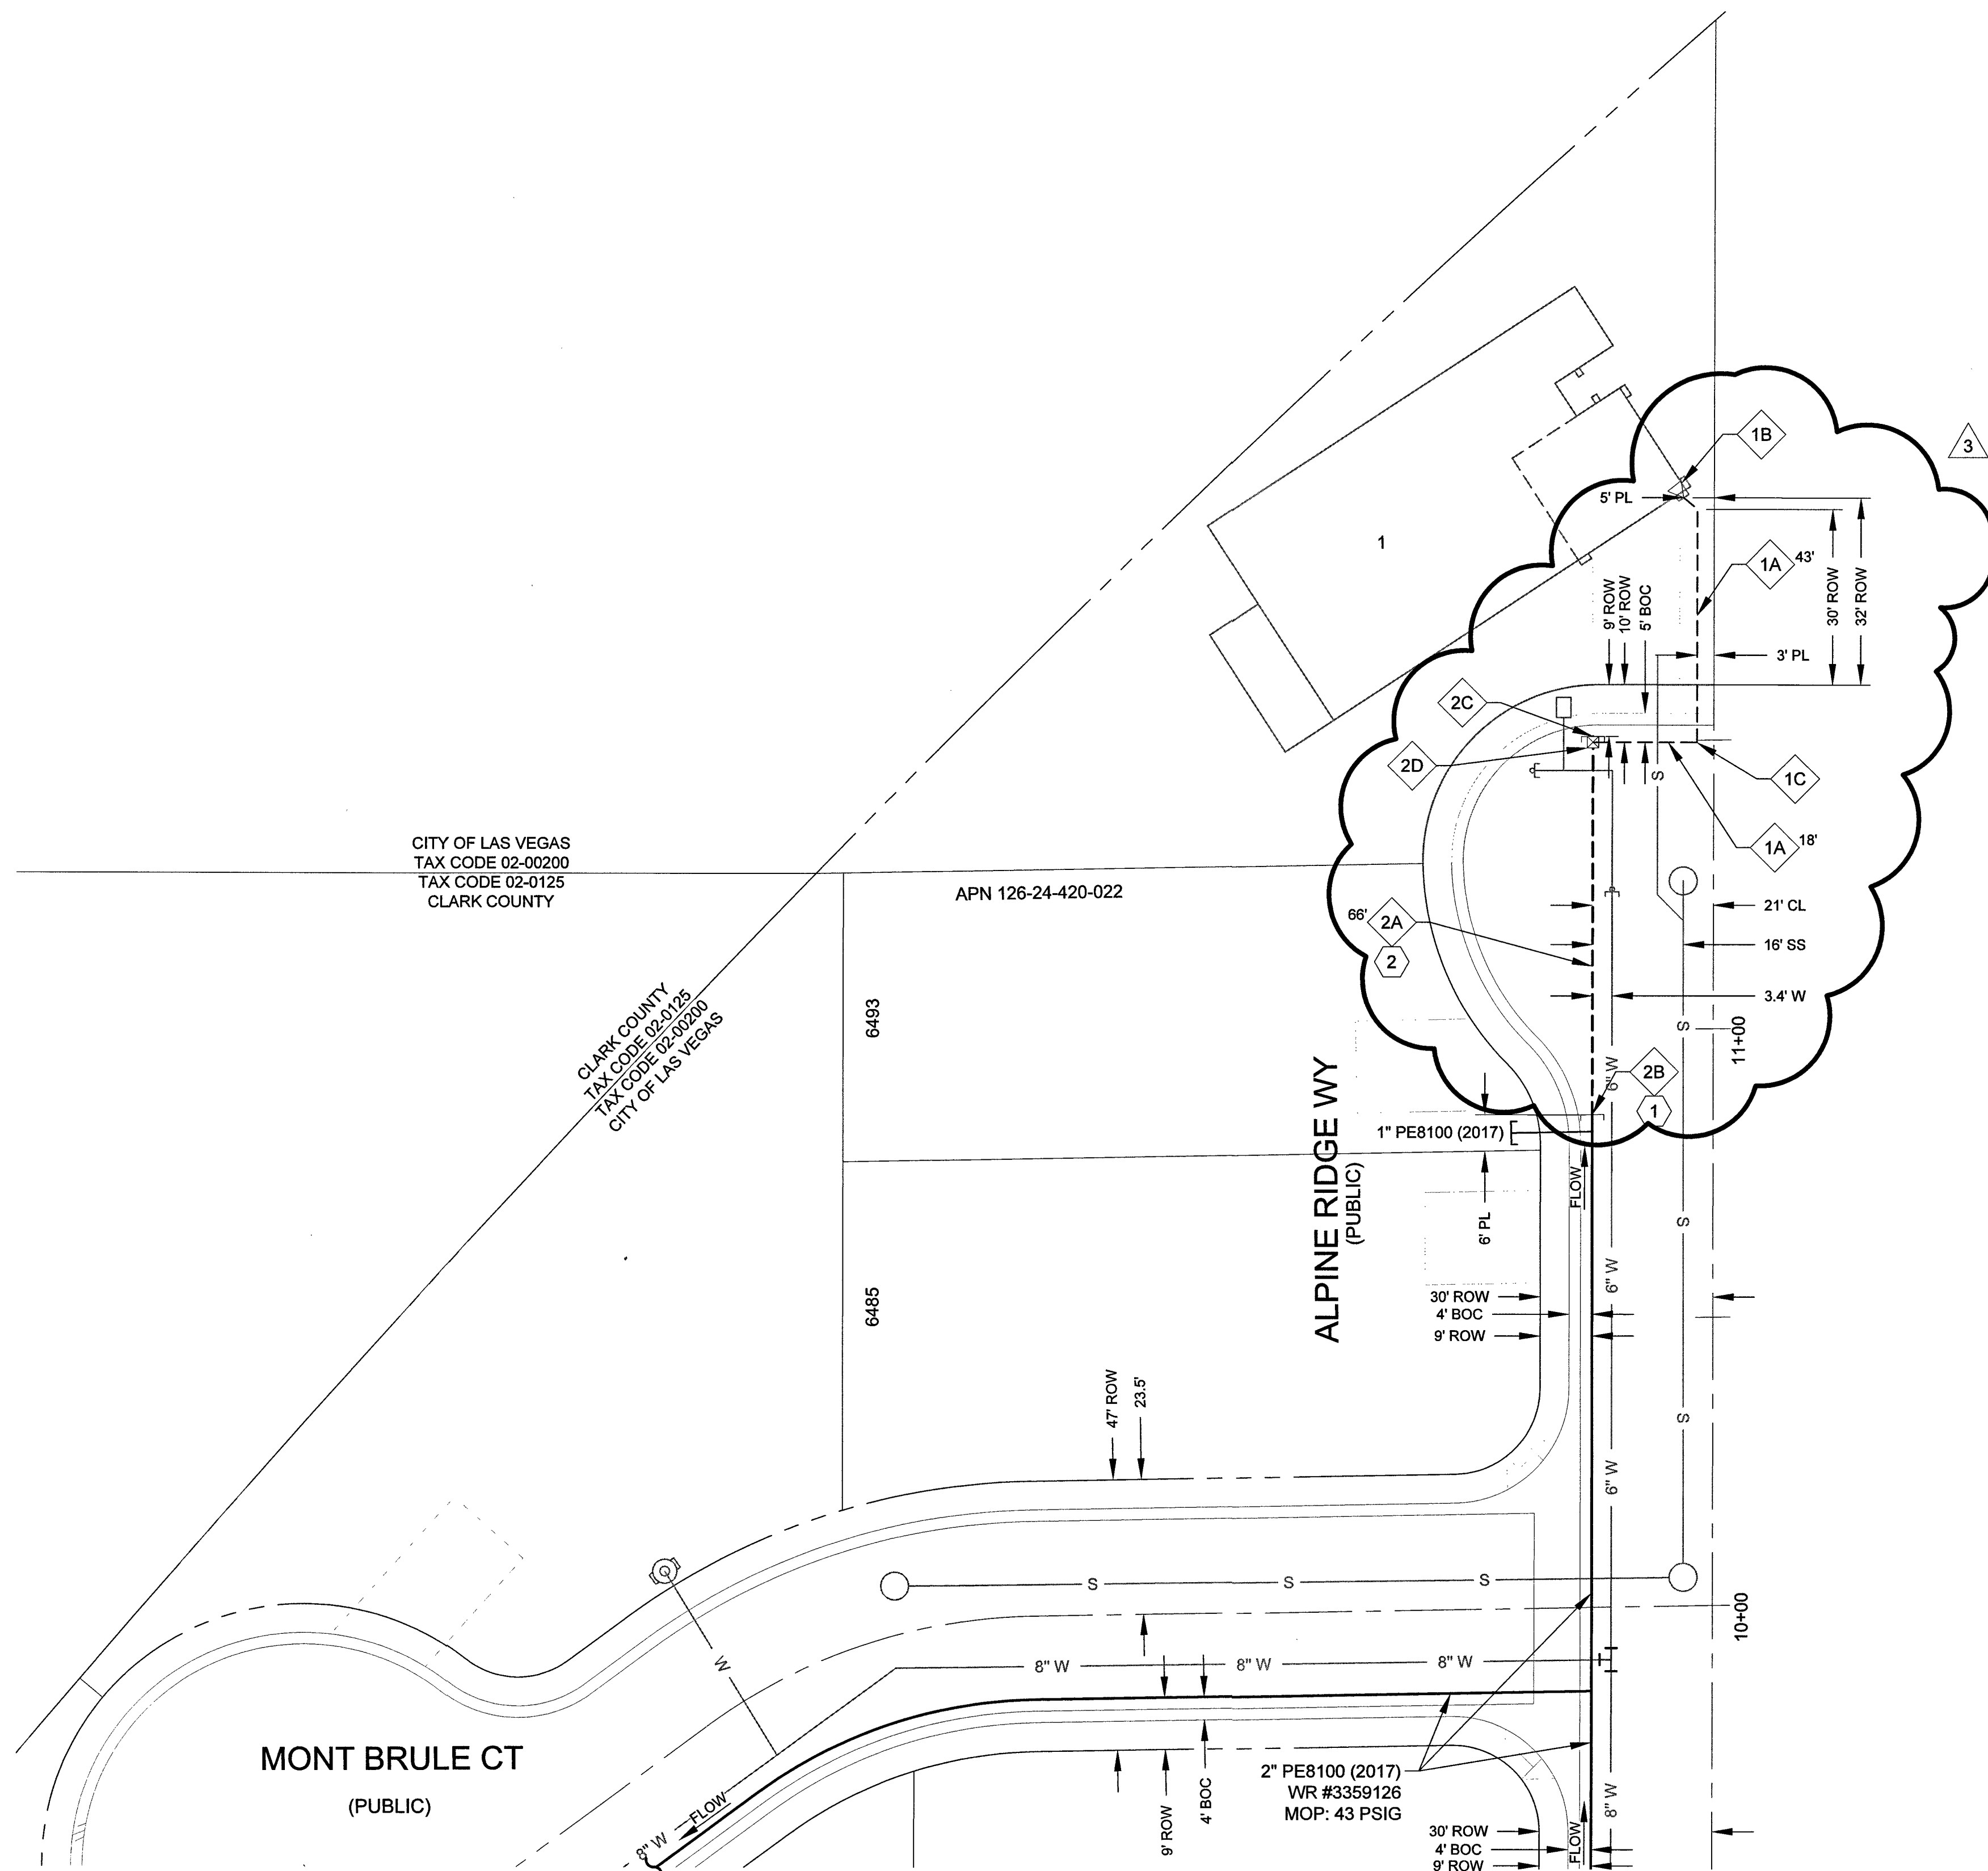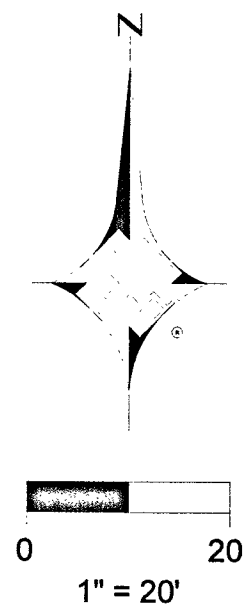

2" DISTRIBUTION MATERIALS LIST						
CODE	DESIGN QTY	AS-BUILT QTY	STOCK ID	DESCRIPTION	SEAM	COATING
2A	66	0	100-5101	PIPE 2" IPS PE 8100 500 FT COIL	N/A	N/A
2B	1	0	140-3532	COUPLING, 2" PE LYCO	N/A	N/A
2C	1	0	140-3060	CAP, 2" PE	N/A	N/A
2D	1	0	160-8577	TAPPING TEE, 2" X 1" PE, 1200 EFV	N/A	N/A

1 1/4" AND BELOW, DISTRIBUTION MATERIALS LIST						
CODE	DESIGN QTY	AS-BUILT QTY	STOCK ID	DESCRIPTION	SEAM	COATING
1A	61	0	101-8526	PIPE 1" IPS PE 8100 500 FT COIL	N/A	N/A
1B	1	0	161-7564	1" RISER, 740 CFH, 7" W.C. DEL PRESSURE, 2' MSA SPREAD	N/A	N/A
1C	1	0	850-9014	ELBOW, 1" PE, 90 DEGREE LYCO	N/A	N/A


CONSTRUCTION NOTES	
1	TIE NEW 2" PE8100 TO EXISTING 2" PE8100
2	RTC 503

PRELIMINARY
NOT FOR
CONSTRUCTION

DATE: _____ BY: _____



Know what's below.
Call before you dig.

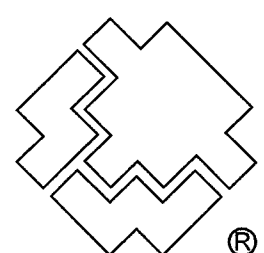

SOUTHWEST GAS CORPORATION

Southwest Gas Corporation Confidential and Proprietary Information

For Reference Only - Not Valid for Line Locating Purposes. No representation or warranty is made for the adequacy, accuracy or completeness of the information or depictions shown. This information is protected from further disclosure under the federal Freedom of Information Act and the Protected Critical Infrastructure Information Act of 2002, and Nevada Revised Statutes § 239C.

This document may not be copied, distributed, or shared to any other person or entity in any manner or form without prior written consent of Southwest Gas Corporation.

REVISIONS			
NO.	DESCRIPTION	BY	DATE APPVD.
3	revised main & updated quantities		
PERMIT INFORMATION		ISOLATION AREA	LOCATION
CITY OF LAS VEGAS TAX CODE: 02-0200		ISO_21_DIST 024	T19S R59E S24 M.D.M.

D_VALLEY_WIDE	
SYSTEM MAOP:	43
SYSTEM MOP:	43
N/A	
SYSTEM MAOP:	N/A
SYSTEM MOP:	N/A

JOB TYPE	
HP SERVICE	☐
DISTRIBUTION	☒
FEEDER	☐
TRANS. BY DEF	☐
TRANS > 20%	☐

WR NO.	
3865970	
RELATED WR NO.S	
N/A	

ENGINEER/TECHNICIAN	DAVID FRIEDLANDER	PHONE: (702) 365-2203
ACCOUNT REP.	TONY VANCHIERI	PHONE: (702) 365-2308
PROJECT CONTACT	ANDREW ACUNA	PHONE: (702) 365-8588
SHEET NO. 5 OF 5	SCALE 1" = 20'	DATE 09/19/2019
DWN. BY INFINITY	CHKD. BY CS	APPVD. BY BWJ
ALPINE RIDGE & 215		
Sheet 13 of 13		

L19-00760 10745105