


PROFILE
SCALE: HORIZ. 1" = 40'
VERT. 1" = 4'

NOTE:
ALL STATIONS ARE REFERENCED TO CENTERLINE OF PRIVATE STREET. NOT CENTERLINE OF AC.
ALL GRADES SHOWN IN PROFILE ARE REFERENCED TO CENTERLINE OF AC (CROWN LINE) AT THAT STATION.
SEE TYPICAL SECTION



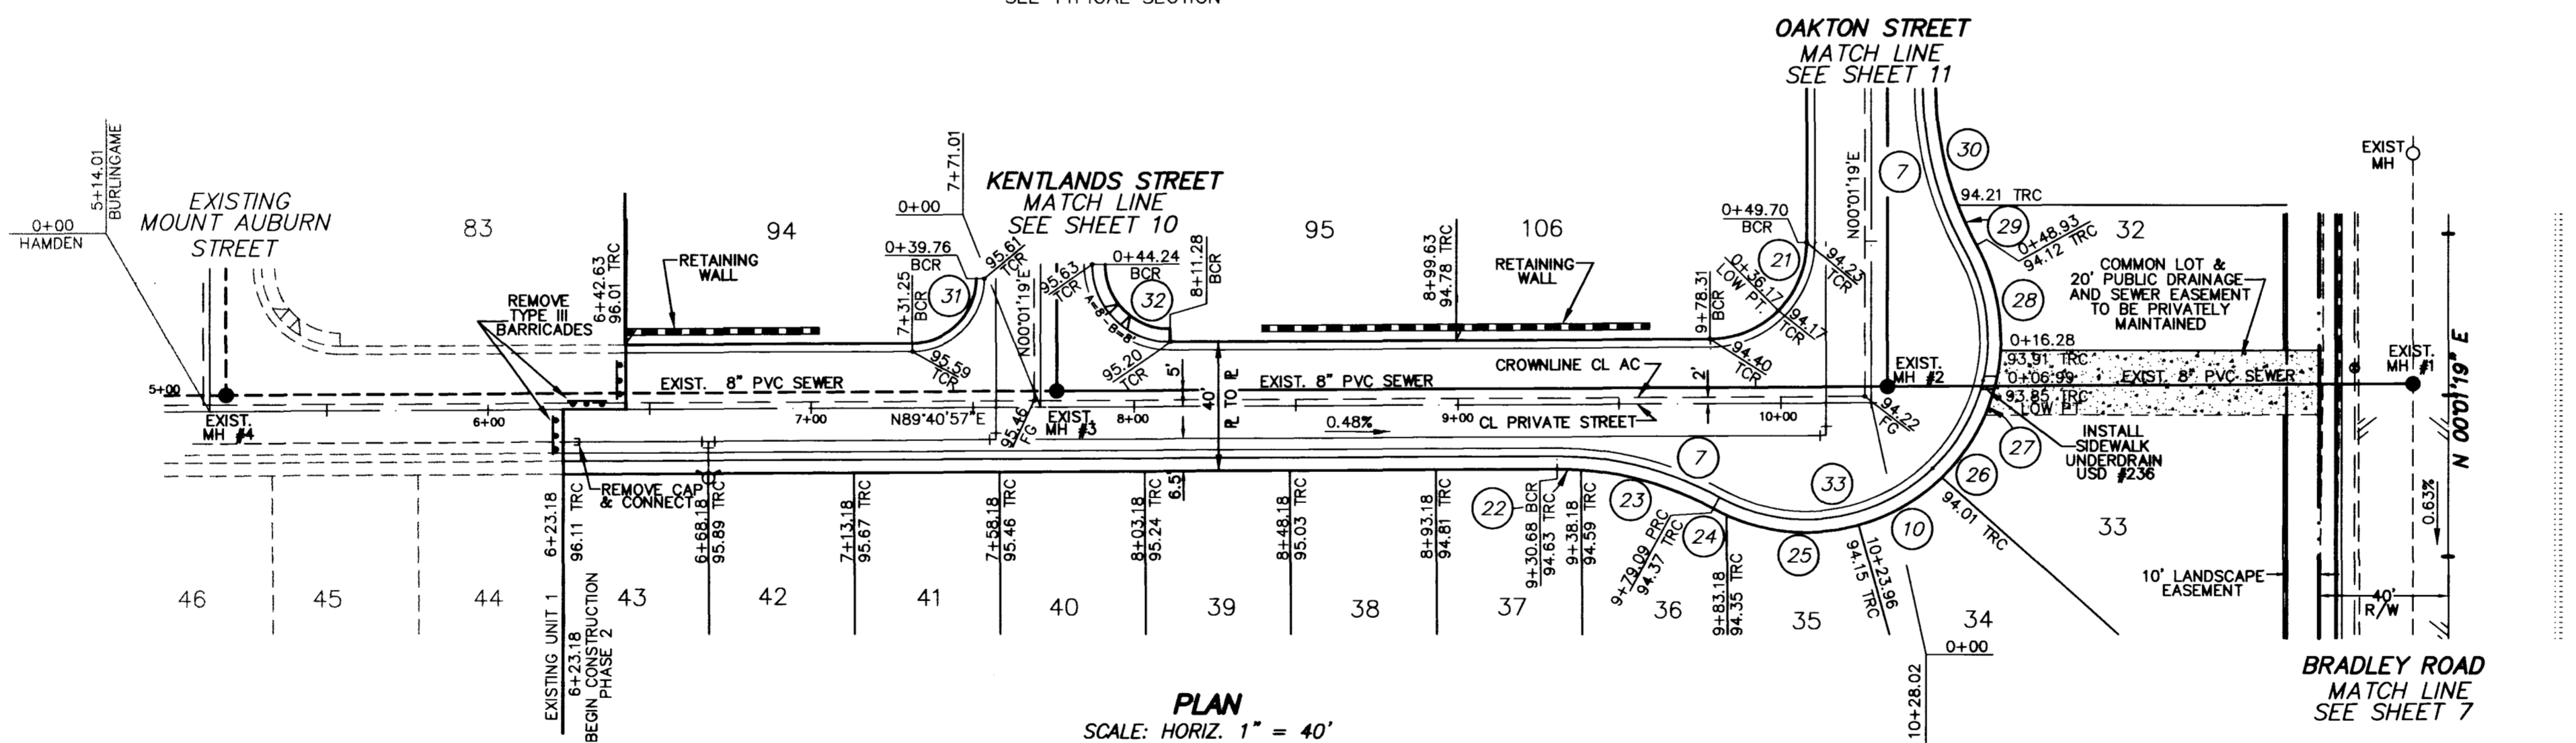


PLAN
SCALE: HORIZ. 1" = 40'

BRIDGEHAMPTON AVENUE
(PRIVATE DRIVE, P.U.E., C.L.V. SEWER EASEMENT & PUBLIC DRAINAGE EASEMENT)

CURVE TABLE

CURVE	DELTA	RADIUS	LENGTH	TANGENT
7	28°57'18"	100.00'	50.54'	25.82'
10	28°38'52"	60.00'	30.00'	15.32'
21	89°39'38"	30.00'	46.95'	29.82'
22	04°18'18"	100.00'	7.51'	3.76'
23	24°39'00"	100.00'	43.02'	21.85'
24	04°22'49"	60.00'	4.59'	2.29'
25	39°52'09"	60.00'	41.75'	21.76'
26	22°33'09"	60.00'	23.62'	11.96'
27	19°43'21"	60.00'	20.65'	10.43'
28	32°23'54"	60.00'	33.93'	17.43'
29	07°48'57"	100.00'	13.64'	6.83'
30	21°08'21"	100.00'	36.89'	18.66'
31	89°39'38"	20.00'	31.30'	19.88'
32	90°20'22"	20.00'	31.53'	20.12'
33	147°34'14"	60.00'	154.54'	206.32'

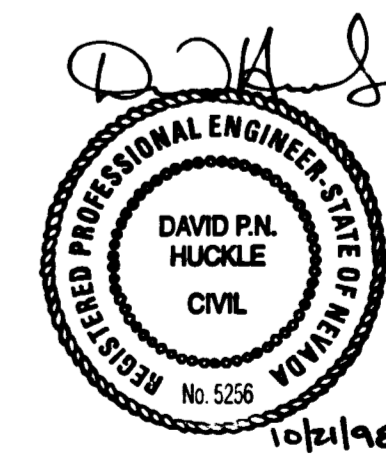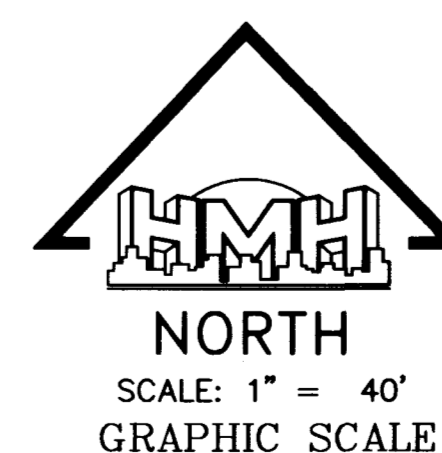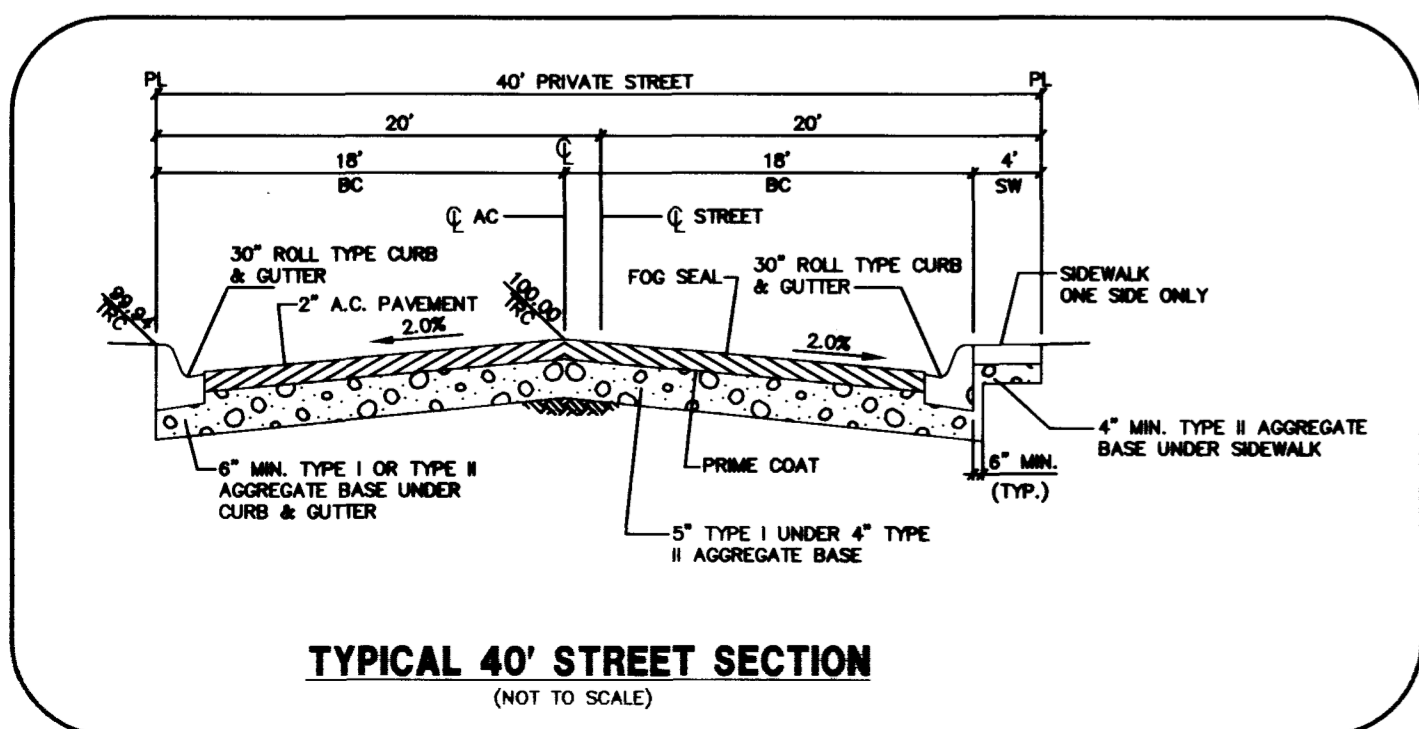

Avoid cutting underground utility lines. It's costly.
Call before you Dig.
1-800-227-2600
UNDERGROUND SERVICE (USA)

BASIS OF BEARING


NORTH 88°46'05" EAST BEING THE CENTERLINE OF AZURE DRIVE AS SHOWN BY A MAP ON FILE IN THE OFFICE OF THE COUNTY THE COUNTY RECORDER, CLARK COUNTY, NEVADA IN FILE 52 OF RECORDS OF SURVEYS, PAGE 70.

BENCHMARK

CITY OF LAS VEGAS VERTICAL CONTROL #38-1LV90-36N4 RIVET AND PLATE IN SOUTH TOP OF CURB, ANN ROAD AT CURB ANGLE POINT, 1530' EAST OF CALVERTS STREET. NAVD88 DATUM ELEVATION: 696.2262 METERS (2284.20 FEET)

REV	DATE	DESCRIPTION

BOBO WEST SAHARA AVENUE-SUITE D
LAS VEGAS, NEVADA 89117
PHONE: (702) 256-7850
FAX: (702) 256-1710

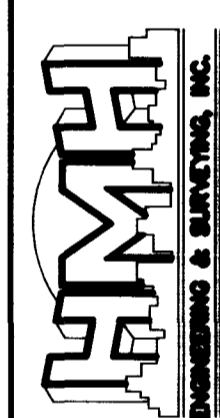

PULTE HOMES
EAGLE CREEK ESTATES SOUTH UNIT 2
PLAN AND PROFILE BRIDGEHAMPTON AVE.

SHEET
9


OF 12 SHEETS

107Y-4555-2

C:\DRAWINGS\EAGLE\NSOUTH\TMRPQV2\E2-sh1009a.dwg Mon Oct 12 16:36:19 1998 DRK


05201

11107

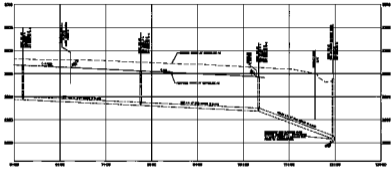

SEWER LINE
SCALE 1" = 40'

 NOTE: SEE SHEET 10-101 FOR
GENERAL NOTES AND SPECIFICATIONS.
ALL DIMENSIONS ARE IN FEET AND INCHES.
UNLESS OTHERWISE SPECIFIED.



BRIDGHAMPTON AVENUE
SCALE 1" = 40'



SEWER DATA

STATION	DEPTH	DIAMETER	MATERIAL	MANHOLE	INVERT
6+00	4.0	18"	CPVC	18"	3.8
6+50	4.0	18"	CPVC	18"	3.8
7+00	4.0	18"	CPVC	18"	3.8
7+50	4.0	18"	CPVC	18"	3.8
8+00	4.0	18"	CPVC	18"	3.8
8+50	4.0	18"	CPVC	18"	3.8
9+00	4.0	18"	CPVC	18"	3.8
9+50	4.0	18"	CPVC	18"	3.8
10+00	4.0	18"	CPVC	18"	3.8
10+50	4.0	18"	CPVC	18"	3.8
11+00	4.0	18"	CPVC	18"	3.8
11+50	4.0	18"	CPVC	18"	3.8
12+00	4.0	18"	CPVC	18"	3.8



Call before you Dig
888-888-8888

STATE OF FLORIDA
SEWER LINE INSTALLATION UNIT 3
PLAN AND PROFILE BRIDGHAMPTON AVE.

REVISIONS
NO. 1 - SEE SHEET 10-101 FOR GENERAL NOTES AND SPECIFICATIONS.
NO. 2 - SEE SHEET 10-102 FOR GENERAL NOTES AND SPECIFICATIONS.
NO. 3 - SEE SHEET 10-103 FOR GENERAL NOTES AND SPECIFICATIONS.