


SANITARY SEWER ALTERNATIVES


ALT "A" - 8" SEWER STA	1+03.75 TO STA	18+80.47
10" SEWER STA	18+80.47 TO STA	98+90.83
27" SEWER STA	98+90.83 TO STA	125+20.39
30" SEWER STA	125+20.39 TO STA	156+66.01
36" SEWER STA	156+66.01 TO STA	190+44.26
ALT "B" - 8" SEWER STA	1+03.75 TO STA	190+44.26
(FOR BIDDING PURPOSES ONLY)		

NOTE:
 ALL EXISTING UTILITY LOCATIONS SHOWN HEREON ARE APPROXIMATE ONLY. IT SHALL BE THE CONTRACTOR'S RESPONSIBILITY TO DETERMINE THE EXACT VERTICAL AND HORIZONTAL LOCATION OF ALL EXISTING UNDERGROUND UTILITIES PRIOR TO CONSTRUCTION AND RELOCATE THESE UTILITIES AS NECESSARY. NO REPRESENTATION IS MADE THAT ALL UTILITIES ARE SHOWN HEREON. THE ENGINEER ASSUMES NO LIABILITY FOR UTILITIES NOT SHOWN OR UTILITIES NOT SHOWN IN THEIR PROPER LOCATIONS.

SCALE: HORIZ. 1"=40'
 VERT. 1"=4'
 Call before you Dig
 1-800-227-2600

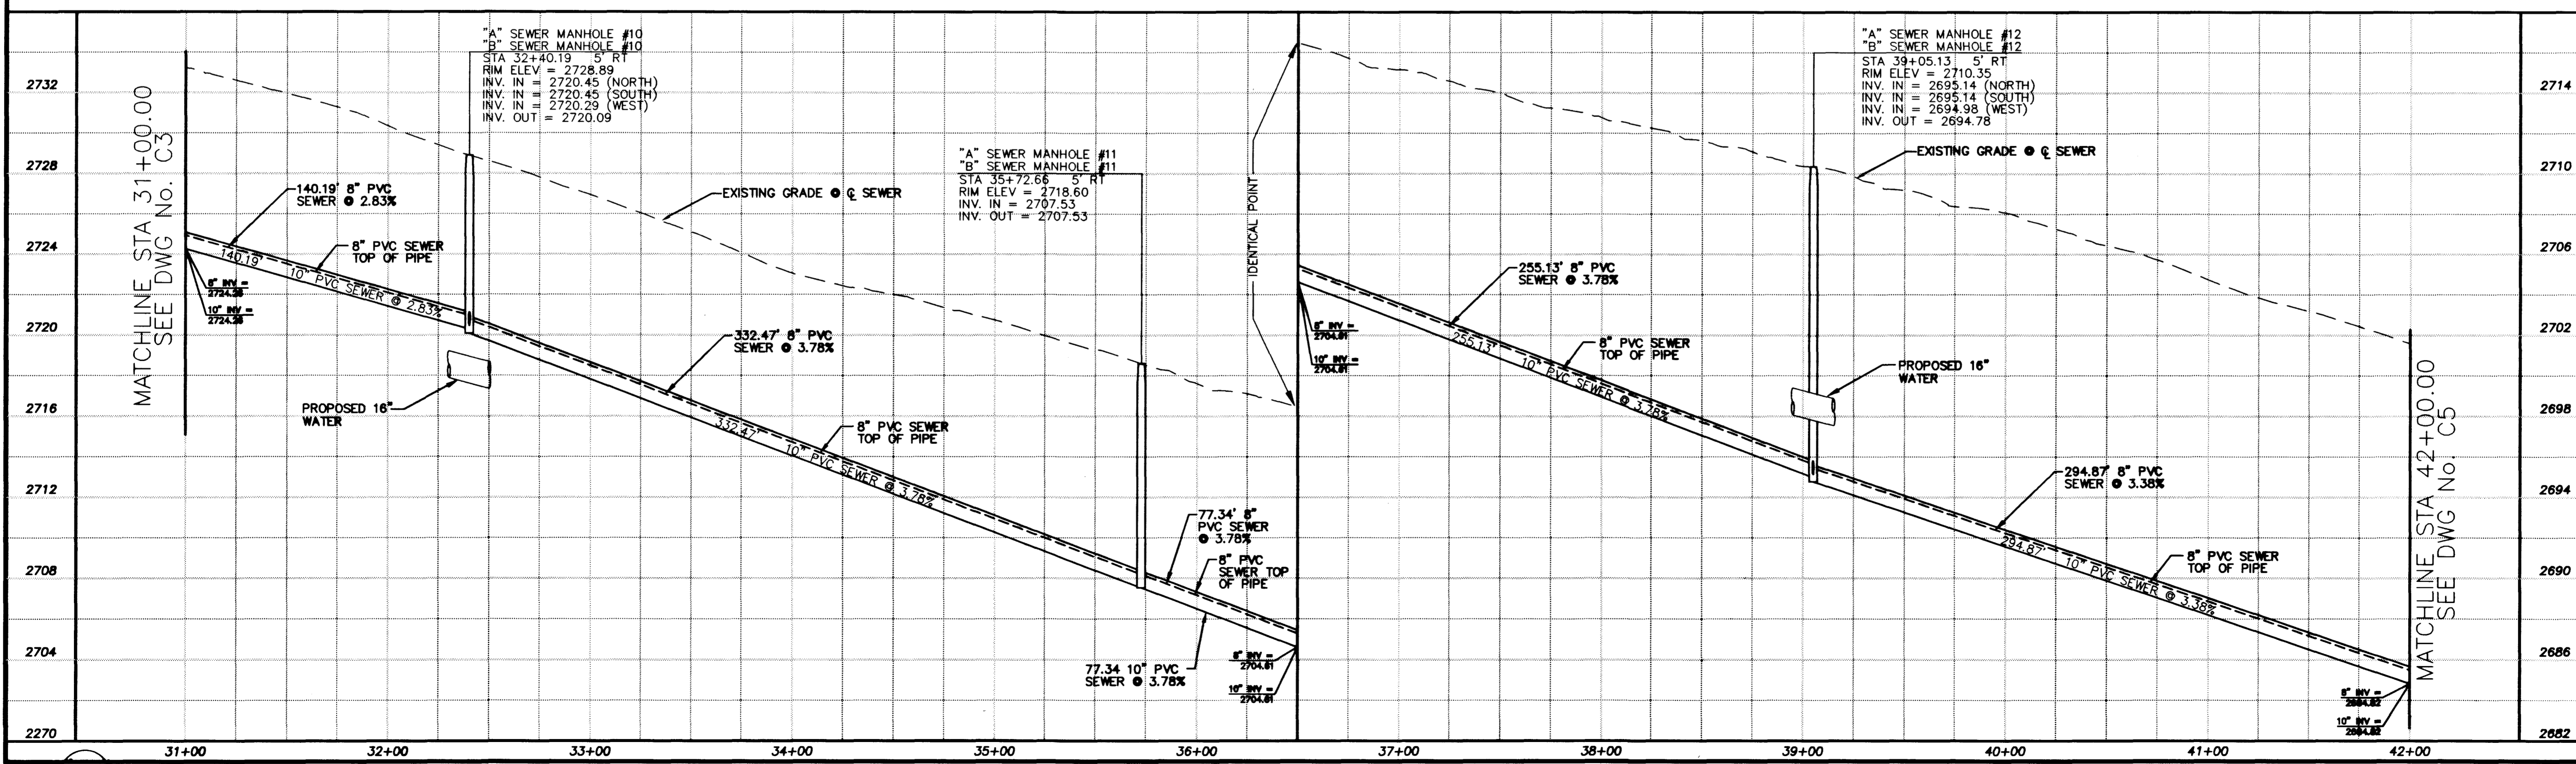

DURANGO INTERCEPTOR SEWER		REVISIONS	
DRAWN BY: J ARROYO	CHECKED BY: L ATWELL	10/1/98	Changed Pipe Size from 30" to 36"
DATE: 8-31-98	DATE: 8-31-98		
801 N. Green Valley Pkwy. Suite 100 Durango, CO 81301 Telephone: 762-728-9224 Fax: 762-762-7200			
Department of Public Works DURANGO INTERCEPTOR SEWER PLAN AND PROFILE STA 31+00.00 TO STA 42+00.00			
DRAWING No.	9	DATE	
C4		DESCRIPTION	
			APPROVED

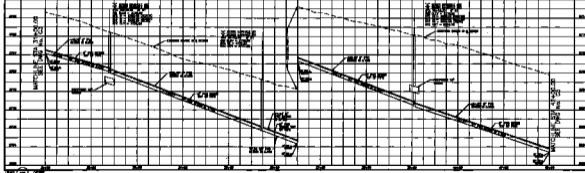

MATCHLINE STA 31+00.00
SEE PLAN NO. 48-400.00


MATCHLINE STA 48+00.00
SEE PLAN NO. 48-400.00

MATCHLINE STA 31+00.00
SEE PLAN NO. 48-400.00

MATCHLINE STA 48+00.00
SEE PLAN NO. 48-400.00

SYMBOL	DESCRIPTION
(Symbol)	SEWER
(Symbol)	MANHOLE
(Symbol)	SINK
(Symbol)	SUMP
(Symbol)	WATER MAIN
(Symbol)	STREET LIGHT
(Symbol)	RAILROAD
(Symbol)	POWER LINE
(Symbol)	TELEPHONE LINE
(Symbol)	ROAD
(Symbol)	RAILROAD
(Symbol)	POWER LINE
(Symbol)	TELEPHONE LINE
(Symbol)	ROAD

NOTES:
 1. ALL DIMENSIONS ARE IN FEET AND INCHES.
 2. ALL DIMENSIONS ARE TO CENTERLINE UNLESS OTHERWISE NOTED.
 3. ALL DIMENSIONS ARE TO CENTERLINE UNLESS OTHERWISE NOTED.
 4. ALL DIMENSIONS ARE TO CENTERLINE UNLESS OTHERWISE NOTED.
 5. ALL DIMENSIONS ARE TO CENTERLINE UNLESS OTHERWISE NOTED.

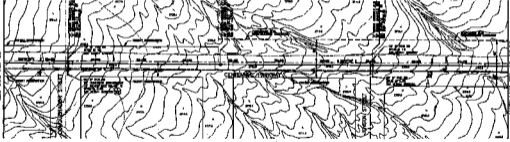

Department of Public Works
 DURANGO INTRACITIES SEWER
 PLAN AND PROFILE
 STA 31+00.00 TO STA 48+00.00



DATE	BY	REVISIONS

DATE	BY	REVISIONS