


MATCHLINE STA 86+00.00  
SEE DWG No. C8

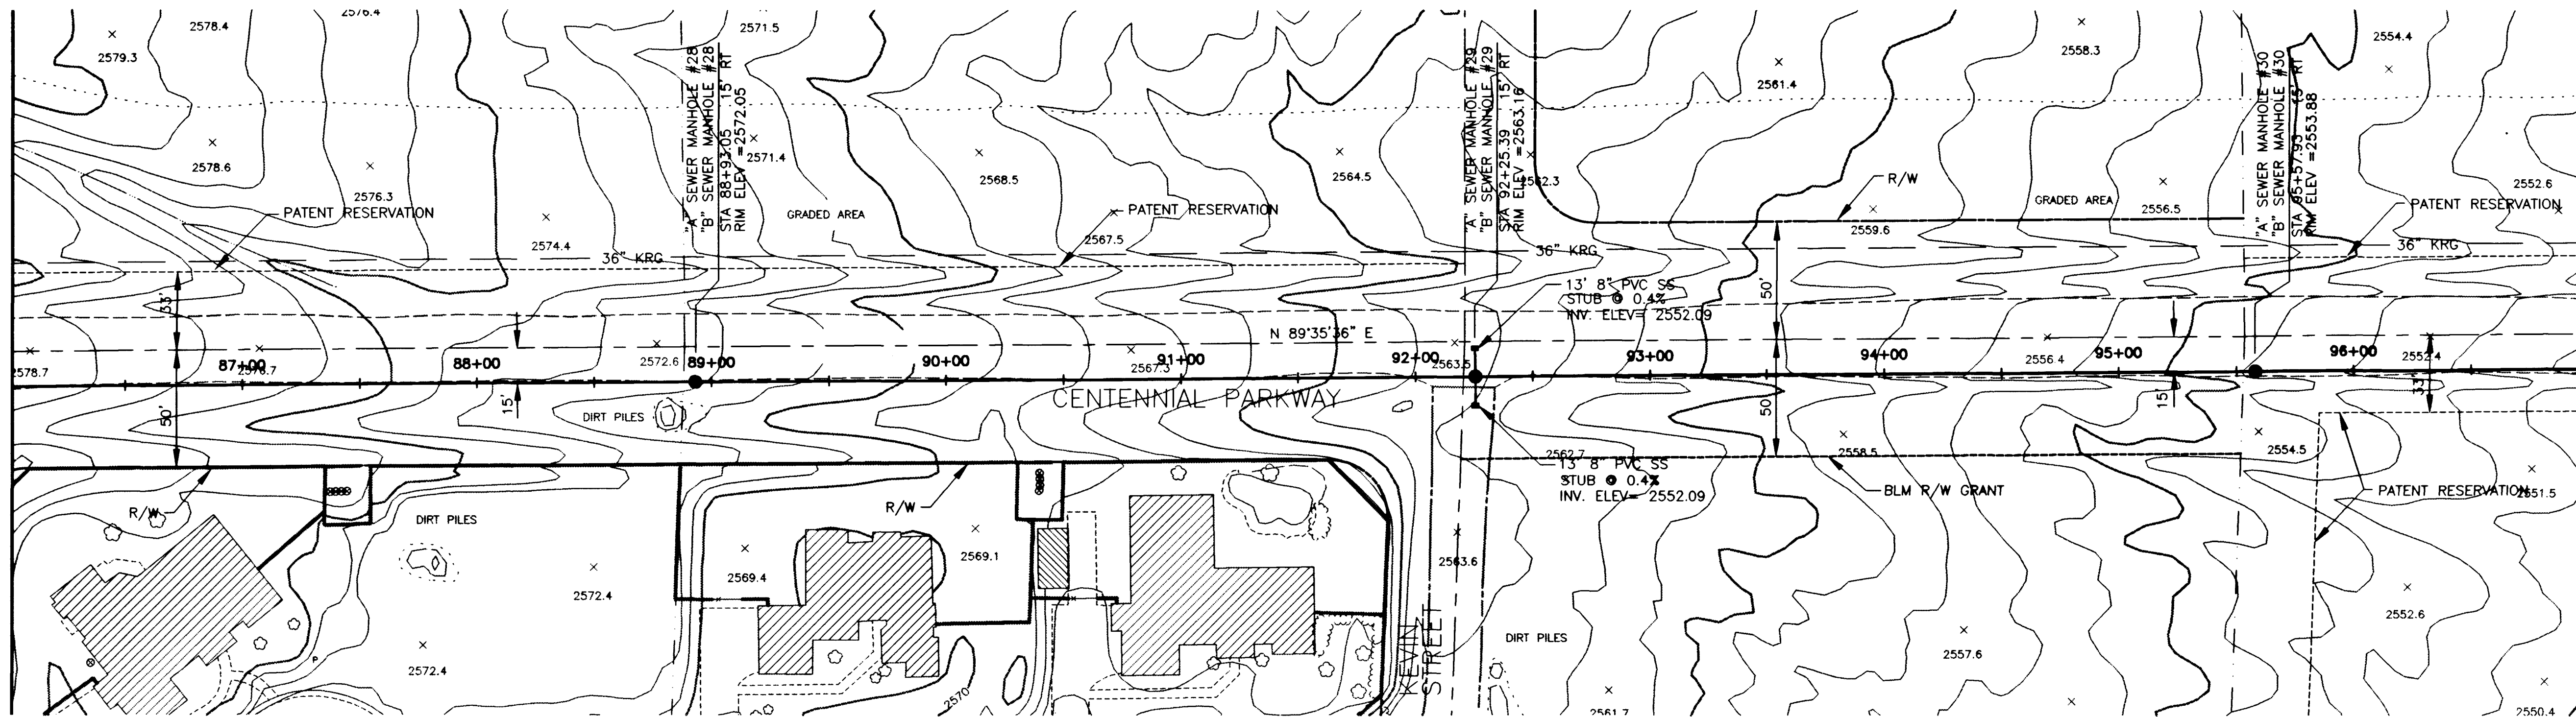


MATCHLINE STA 97+00.00  
SEE DWG No. C10




REVISIONS

NO.	DATE	DESCRIPTION
1	10/1/98	Changed Pipe Size from 36" to 30"

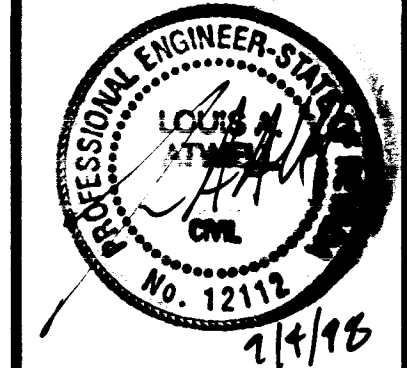

Department of Public Works  
DURANGO INTERCEPTOR SEWER  
PLAN AND PROFILE  
STA 86+00.00 TO STA 97+00.00

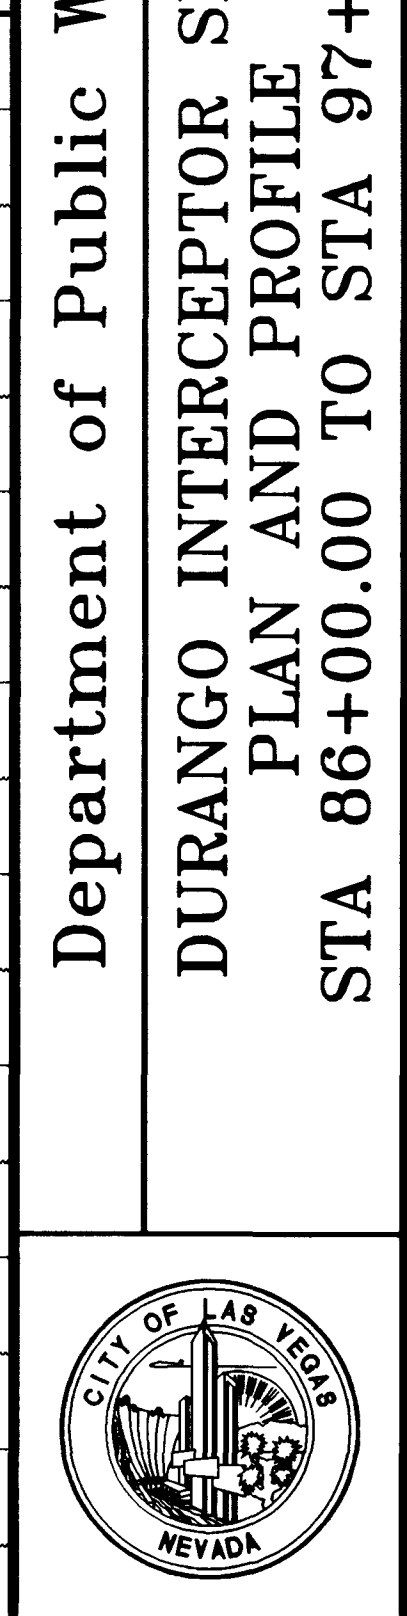

DRAWING No. 14  
C9


307-V770

**SANITARY SEWER ALTERNATIVES**

ALT "A" - 8" SEWER STA	1+03.75 TO STA	18+80.47
10" SEWER STA	18+80.47 TO STA	98+90.83
27" SEWER STA	98+90.83 TO STA	125+20.39
30" SEWER STA	125+20.39 TO STA	156+66.01
36" SEWER STA	156+66.01 TO STA	190+44.26
ALT "B" - 8" SEWER STA 1+03.75 TO STA 190+44.26 (FOR BIDDING PURPOSES ONLY)		

**NOTE:**  
ALL EXISTING UTILITY LOCATIONS SHOWN HEREON ARE APPROXIMATE ONLY. IT SHALL BE THE CONTRACTOR'S RESPONSIBILITY TO DETERMINE THE EXACT VERTICAL AND HORIZONTAL LOCATION OF ALL EXISTING UNDERGROUND UTILITIES PRIOR TO CONSTRUCTION AND RELOCATE THESE UTILITIES AS NECESSARY. NO REPRESENTATION IS MADE THAT ALL UTILITIES ARE SHOWN HEREON. THE ENGINEER ASSUMES NO LIABILITY FOR UTILITIES NOT SHOWN OR UTILITIES NOT SHOWN IN THEIR PROPER LOCATIONS.

SCALE: HORIZ. 1"=40'  
VERT. 1"=4'  
Call before you Dig  
1-800-227-2600

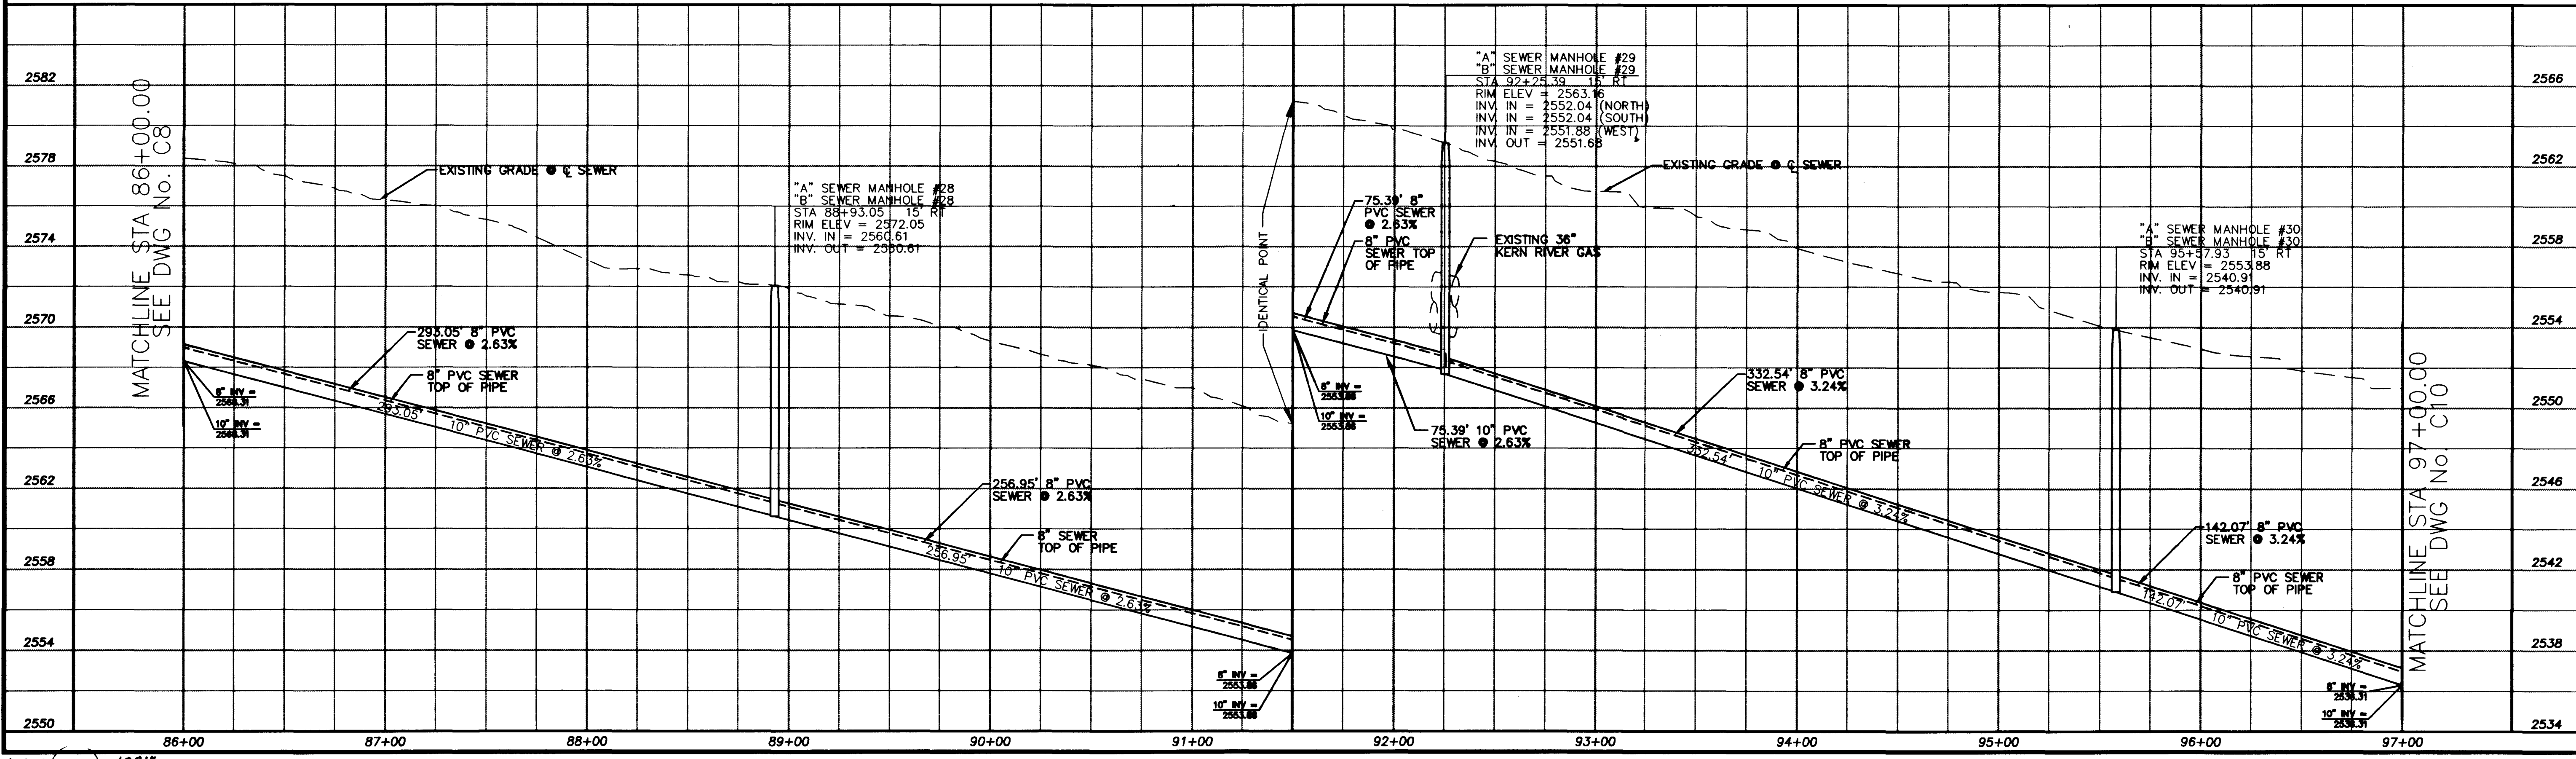

10427 10214

