


MATCHLINE STA 160+00.00
SEE DWG No. C15

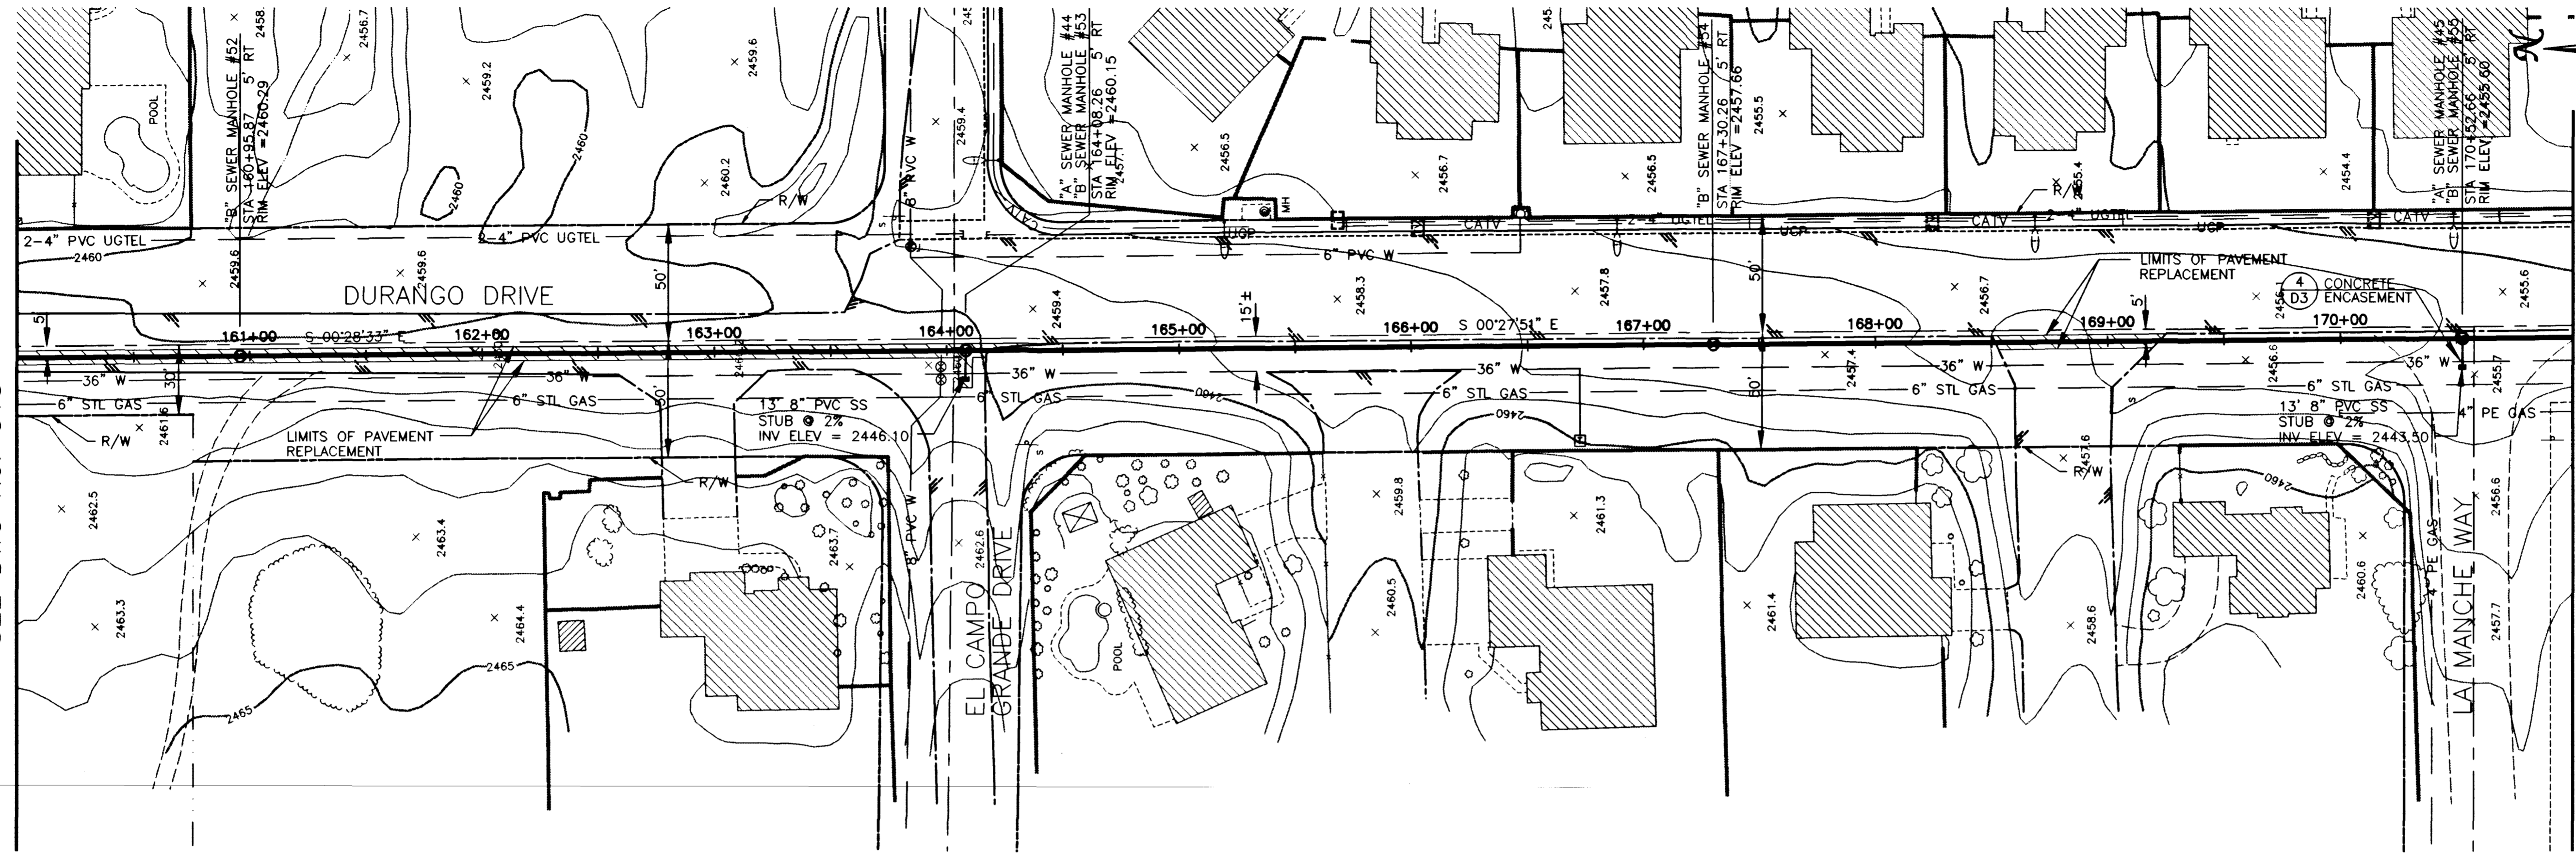

MATCHLINE STA 171+00.00
SEE DWG No. C17

SANITARY SEWER ALTERNATIVES

ALT "A" - 8" SEWER STA	1+03.75 TO STA 18+80.47
10" SEWER STA	18+80.47 TO STA 98+90.83
27" SEWER STA	98+90.83 TO STA 125+20.39
30" SEWER STA	125+20.39 TO STA 156+66.01
33" SEWER STA	156+66.01 TO STA 190+44.26
ALT "B" - 8" SEWER STA	1+03.75 TO STA 190+44.26


(FOR BIDDING PURPOSES ONLY)

NOTE:
ALL EXISTING UTILITY LOCATIONS SHOWN HEREON ARE APPROXIMATE ONLY. IT SHALL BE THE CONTRACTOR'S RESPONSIBILITY TO DETERMINE THE EXACT VERTICAL AND HORIZONTAL LOCATION OF ALL EXISTING UNDERGROUND UTILITIES PRIOR TO CONSTRUCTION AND RELOCATE THESE UTILITIES AS NECESSARY. NO REPRESENTATION IS MADE THAT ALL UTILITIES ARE SHOWN HEREON. THE ENGINEER ASSUMES NO LIABILITY FOR UTILITIES NOT SHOWN OR UTILITIES NOT SHOWN IN THEIR PROPER LOCATIONS.

SCALE: HORIZ. 1"=40'
VERT. 1"=4'

Call before you Dig
1-800-227-2600

MATCHLINE STA 160+00.00
SEE DWG No. C15

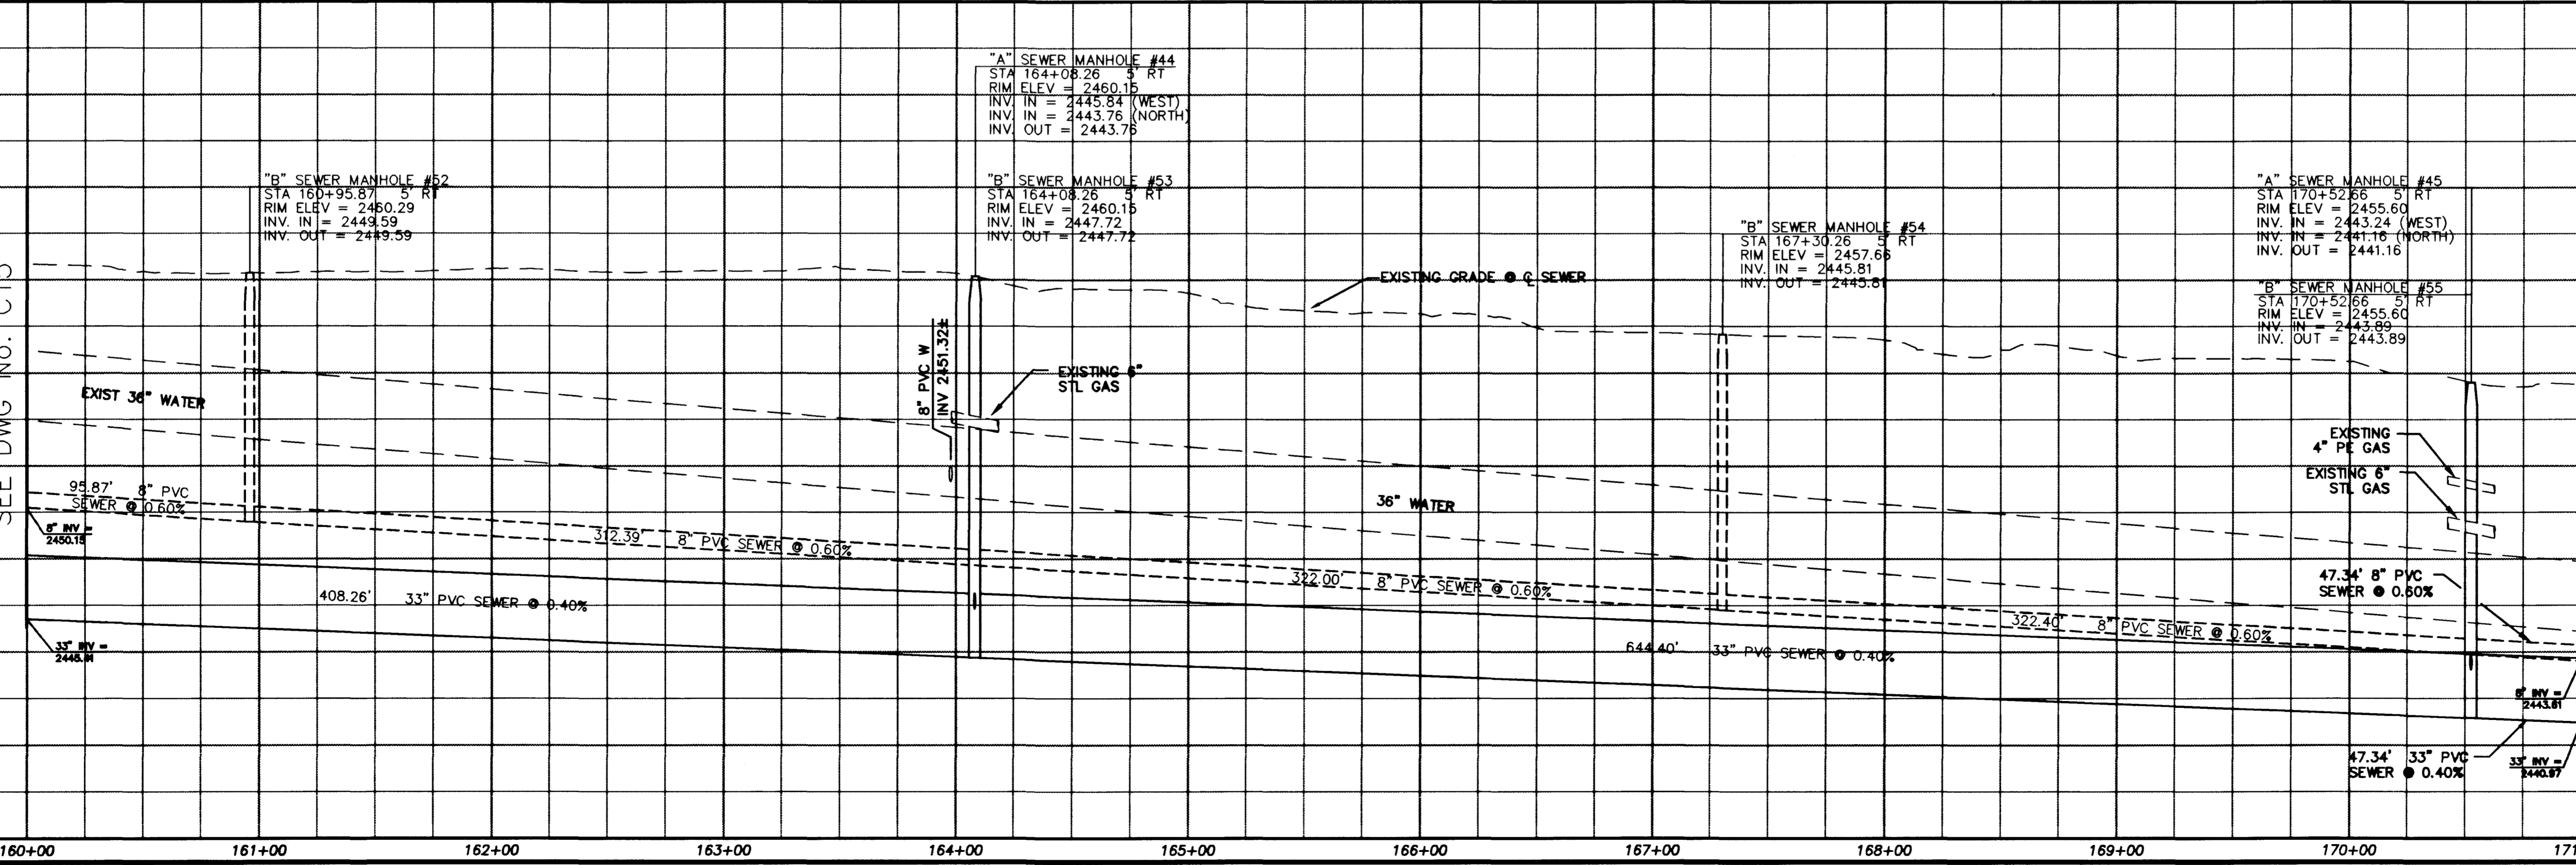

MATCHLINE STA 171+00.00
SEE DWG No. C17

REVISIONS

NO.	DATE	DESCRIPTION

DURANGO INTERCEPTOR SEWER
 DRAWN BY: J. ARROYO
 DESIGNED BY: J. LUSTIG
 CHECKED BY: L. ATWELL
 DATE: 8-31-98
 JOB NO.: 51449

PBSy
 ENGINEERING, PLANNING, SURVEYING, CONSTRUCTION SERVICES

901 N. Green Valley Hwy.
 Henderson, Nevada 89044
 Phone: 702/267-7775
 Fax: 702/267-7760


1/9/98

Department of Public Works
**DURANGO INTERCEPTOR SEWER
 PLAN AND PROFILE**
 STA 160+00.00 TO STA 171+00.00

**CITY OF LAS VEGAS
 NEVADA**

DRAWING No. 21
 C16

26

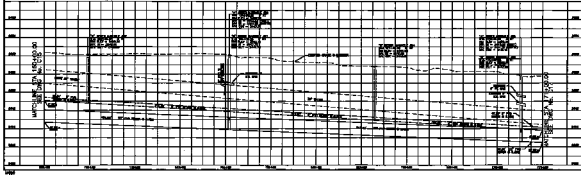


MANHOLE STA. 167+00.00
SEE SHEET NO. C-3

MANHOLE STA. 175+00.00
SEE SHEET NO. C-1

1" = 100'	1" = 50'	1" = 25'	1" = 12.5'	1" = 6.25'	1" = 3.125'	1" = 1.5625'
1" = 100'	1" = 50'	1" = 25'	1" = 12.5'	1" = 6.25'	1" = 3.125'	1" = 1.5625'
1" = 100'	1" = 50'	1" = 25'	1" = 12.5'	1" = 6.25'	1" = 3.125'	1" = 1.5625'

1" = 100'	1" = 50'	1" = 25'	1" = 12.5'	1" = 6.25'	1" = 3.125'	1" = 1.5625'
1" = 100'	1" = 50'	1" = 25'	1" = 12.5'	1" = 6.25'	1" = 3.125'	1" = 1.5625'
1" = 100'	1" = 50'	1" = 25'	1" = 12.5'	1" = 6.25'	1" = 3.125'	1" = 1.5625'

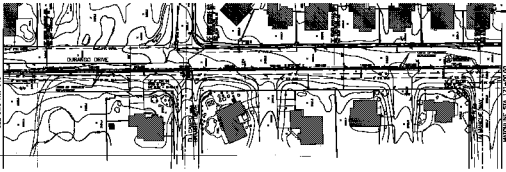

1" = 100'

1" = 50'

Department of Public Works
 BUBUNGO INTERCEPTOR SEWER
 PLAN AND PROFILE
 STA 160+00.00 TO STA 171+00.00

REVISIONS

