

SANITARY SEWER ALTERNATIVES

ALT "A" - 8" SEWER STA 1+03.75 TO STA 18+80.47
10" SEWER STA 18+80.47 TO STA 98+90.83
27" SEWER STA 98+90.83 TO STA 125+20.39
30" SEWER STA 125+20.39 TO STA 156+66.01
33" SEWER STA 156+66.01 TO STA 190+44.26
ALT "B" - 8" SEWER STA 1+03.75 TO STA 190+44.26
(FOR BIDDING PURPOSES ONLY)


NOTE:
 ALL EXISTING UTILITY LOCATIONS SHOWN HEREON ARE APPROXIMATE ONLY. IT SHALL BE THE CONTRACTOR'S RESPONSIBILITY TO DETERMINE THE EXACT VERTICAL AND HORIZONTAL LOCATION OF ALL EXISTING UNDERGROUND UTILITIES PRIOR TO CONSTRUCTION AND RELOCATE THESE UTILITIES AS NECESSARY. NO REPRESENTATION IS MADE THAT ALL UTILITIES ARE SHOWN HEREON. THE ENGINEER ASSUMES NO LIABILITY FOR UTILITIES NOT SHOWN OR UTILITIES NOT SHOWN IN THEIR PROPER LOCATIONS.

GENERAL NOTES

- SEWER LENGTHS ARE FROM CENTER OF MANHOLE TO CENTER OF MANHOLE, MEASURED HORIZONTALLY.
- 48" DIAMETER MANHOLES SHALL BE USED ON 8" THROUGH 12" SEWER AND 60" DIAMETER MANHOLES ON 30" SEWER.
- CONTRACTOR TO REPAIR OR REPLACE ANY DAMAGED PAVEMENT MARKINGS AND SIGNS.

SCALE: HORIZ. 1"=40'
 VERT. 1"=4'

Call before you Dig
 1-800-227-2600

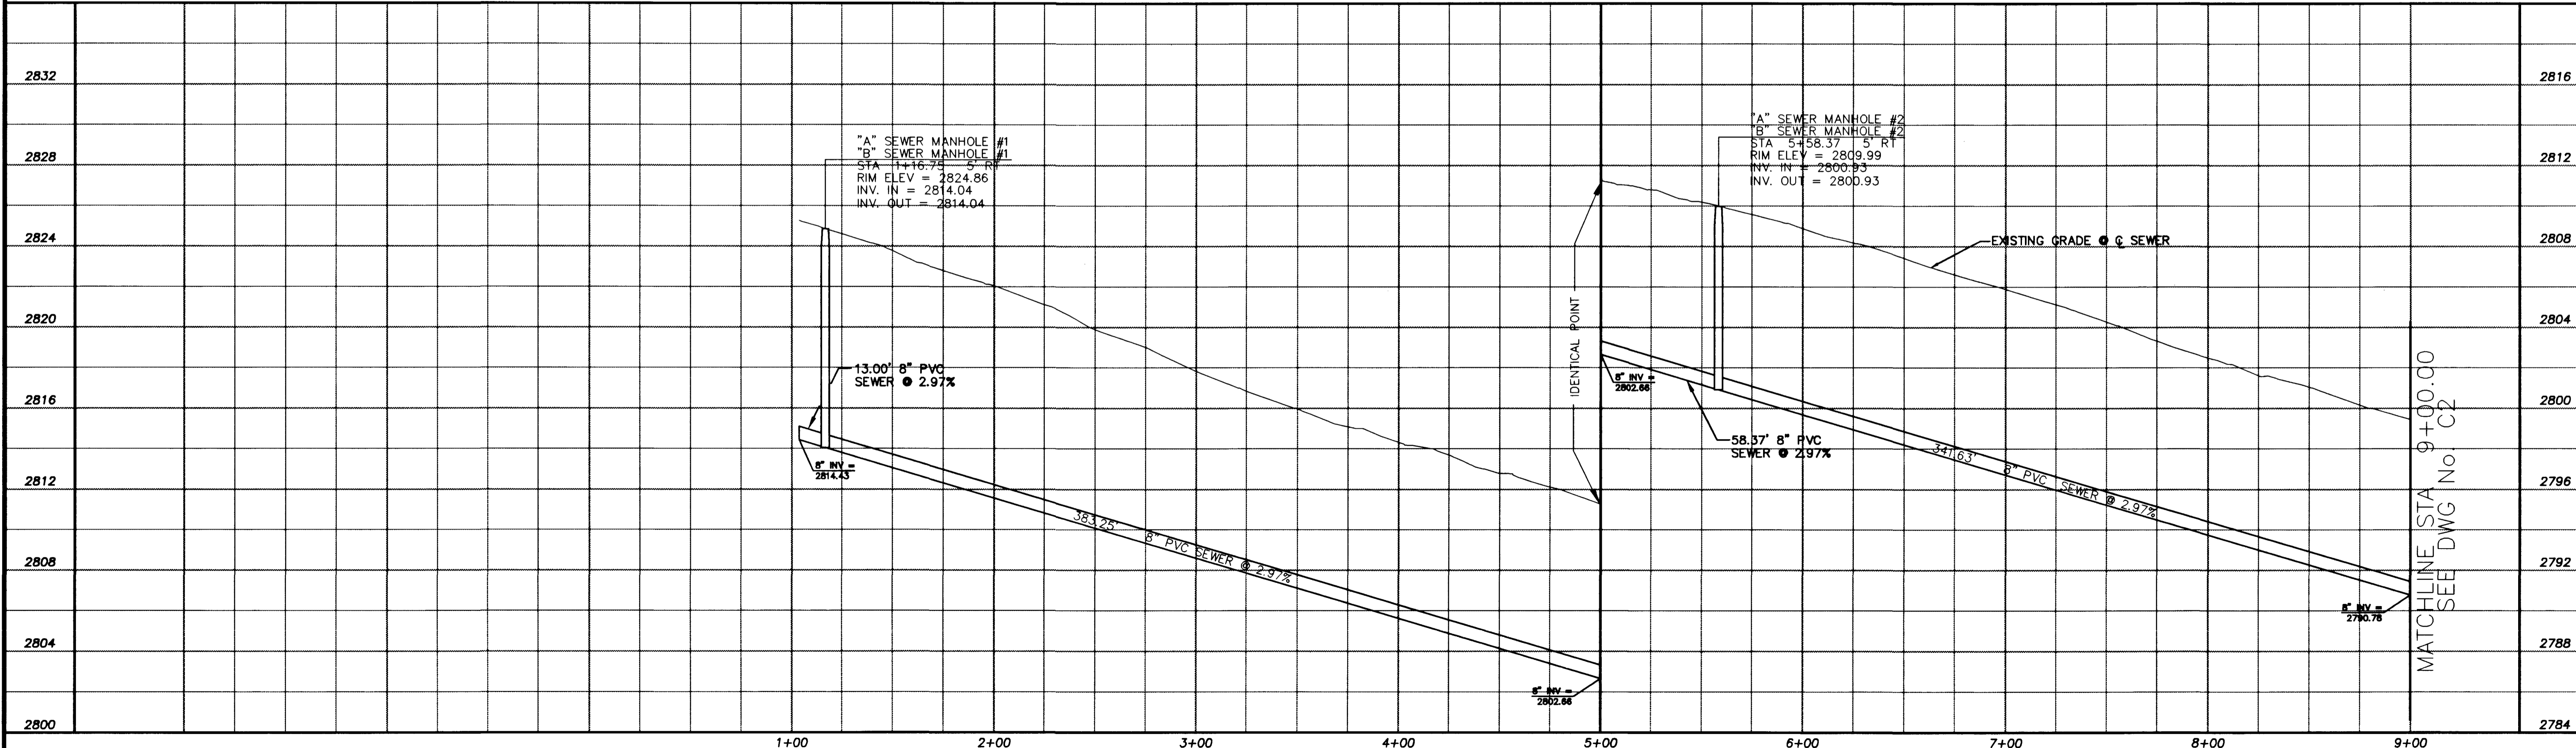


REVISIONS

NO.	DATE	DESCRIPTION

DURANGO INTERCEPTOR SEWER
 DRAWN BY: J. ARROYO
 DESIGNED BY: J. LUSTIG
 CHECKED BY: L. ATWELL
 DATE: 8-31-98
 APP NO: 51449

PBS&J
 ENGINEERING, PLANNING, SURVEYING, CONSTRUCTION SERVICES

951 N. Green Valley Pkwy.
 Suite 100
 Henderson, NV 89123
 Telephone: 702/763-2774
 Fax: 702/763-7200

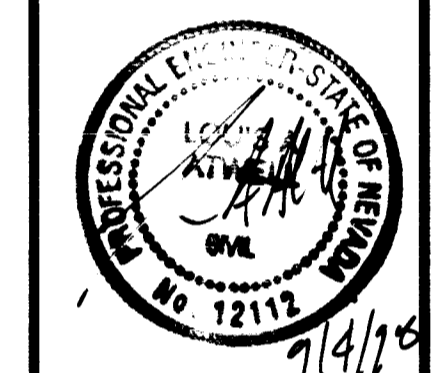

Department of Public Works
DURANGO INTERCEPTOR SEWER
PLAN AND PROFILE
STA 1+03.75 TO STA 9+00.00

CITY OF LAS VEGAS
 NEVADA

DRAWING No. 6
 C1

