


MATCHLINE STA 31+00.00
SEE DWG No. C3

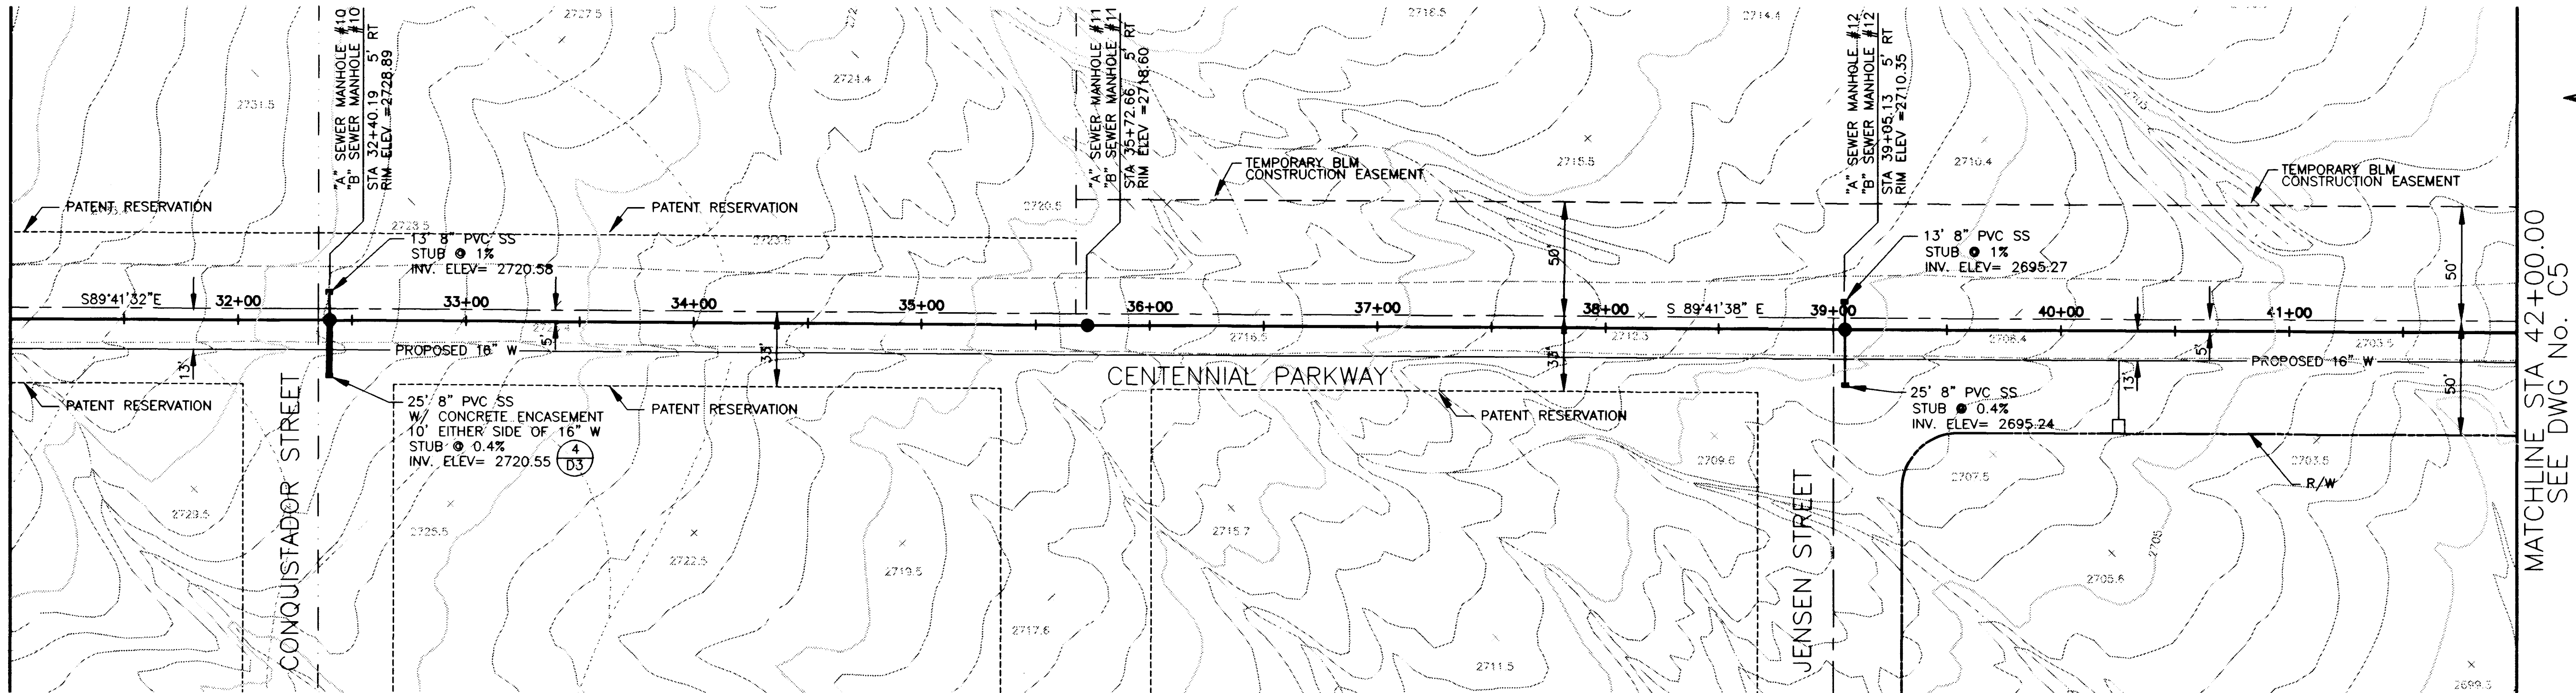


SANITARY SEWER ALTERNATIVES	
ALT "A" - 8" SEWER STA	1+03.75 TO STA 18+80.47
10" SEWER STA	18+80.47 TO STA 98+90.83
27" SEWER STA	98+90.83 TO STA 125+20.39
30" SEWER STA	125+20.39 TO STA 156+66.01
33" SEWER STA	156+66.01 TO STA 190+44.26
ALT "B" - 8" SEWER STA	1+03.75 TO STA 190+44.26
(FOR BIDDING PURPOSES ONLY)	

NOTE:
ALL EXISTING UTILITY LOCATIONS SHOWN HEREON ARE APPROXIMATE ONLY.
IT SHALL BE THE CONTRACTOR'S RESPONSIBILITY TO DETERMINE THE EXACT VERTICAL
AND HORIZONTAL LOCATION OF ALL EXISTING UNDERGROUND UTILITIES PRIOR TO
CONSTRUCTION AND RELOCATE THESE UTILITIES AS NECESSARY. NO REPRESENTATION
IS MADE THAT ALL UTILITIES ARE SHOWN HEREON. THE ENGINEER ASSUMES NO
LIABILITY FOR UTILITIES NOT SHOWN OR UTILITIES NOT SHOWN IN THEIR
PROPER LOCATIONS.

Call
before you
Dig
1-800-227-2600

SCALE: HORIZ. 1"=40'
VERT. 1"=4'

MATCHLINE STA 31+00.00
SEE DWG No. C3

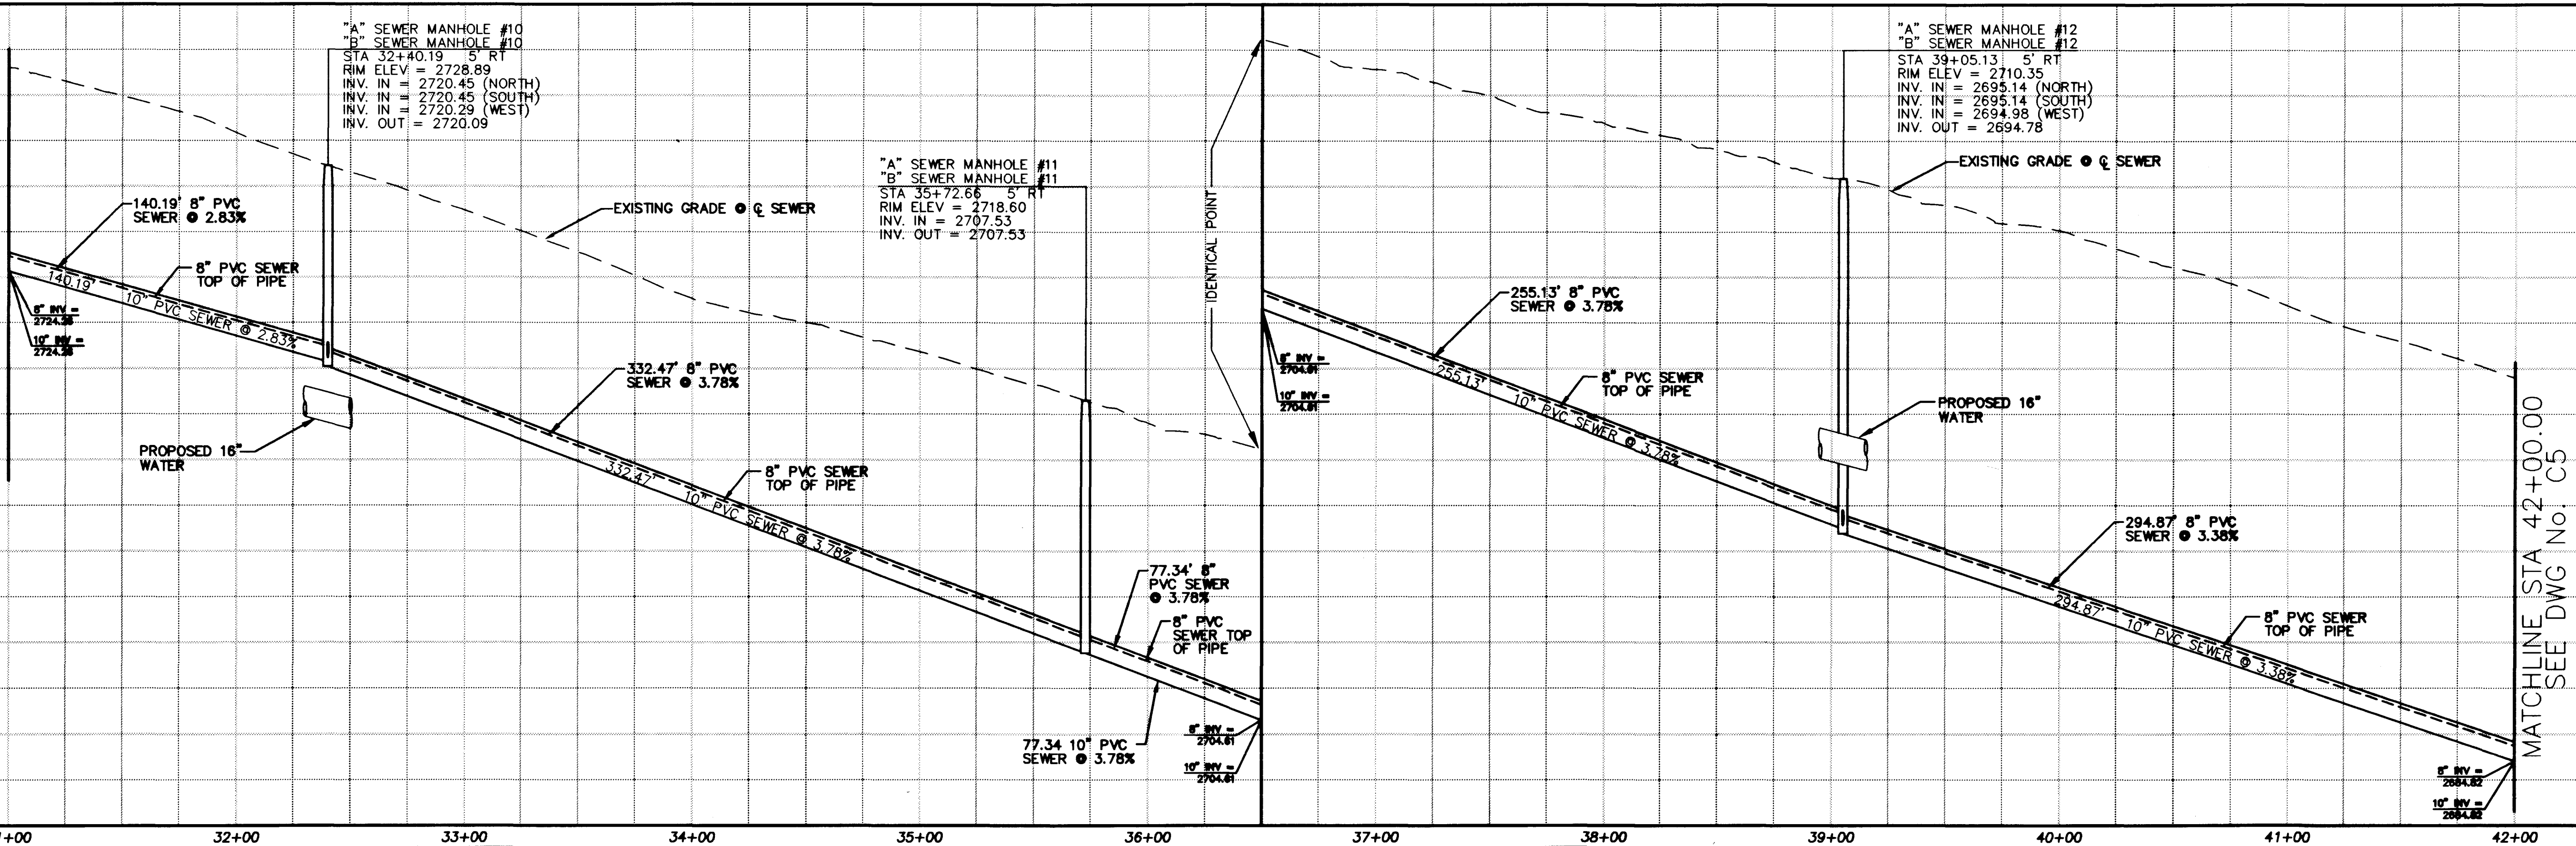


MATCHLINE STA 42+00.00
SEE DWG No. C5

Department of Public Works
DURANGO INTERCEPTOR SEWER
PLAN AND PROFILE
STA 31+00.00 TO STA 42+00.00



DRAWING No. 9
C4 26

REVISIONS		DATE	DESCRIPTION	APPROVED
1	DESIGNED BY: J. ARROYO	8-31-98	CONSTRUCTION SET	
2	CHECKED BY: L. ATWELL			
3	DATE: 8-31-98			
4	NO. 51449			
5	901 N. Green Valley Pkwy., Suite 100, North Las Vegas, NV 89004			
6	Phone: 702/263-7263 Fax: 702/263-7263			
7	ENGINEERING PLANNING SURVEYING CONSTRUCTION SERVICES			
8	PBS			
9	PROFESSIONAL ENGINEER - STATE OF NEVADA			
10	No. 12112			

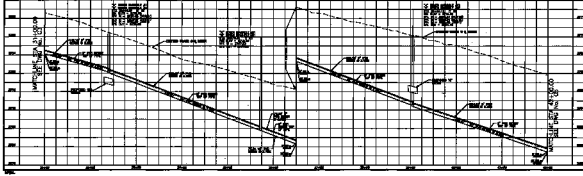

WATCHMAN'S DIA. 21'-00.00
SEE DWG NO. 12

WATCHMAN'S DIA. 21'-00.00
SEE DWG NO. 12


NO.	DESCRIPTION	DATE
1	REVISION	
2	REVISION	
3	REVISION	
100	REVISION	

NO.	DESCRIPTION	DATE
1	REVISION	
2	REVISION	
3	REVISION	
100	REVISION	

1 1 2
1 1 2
1 1 2

WATCHMAN'S DIA. 21'-00.00
SEE DWG NO. 12

WATCHMAN'S DIA. 21'-00.00
SEE DWG NO. 12

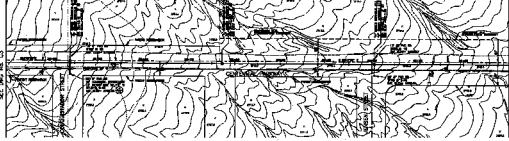

Department of Public Works
DURANGO INTERCEPTOR SEWER
PLAN AND PROFILE
STA 51+00.00 TO STA 51+50.00



REVISIONS

NO.	DESCRIPTION	DATE
1	REVISION	
2	REVISION	
3	REVISION	
100	REVISION	