



CAUTION:  
KERN RIVER GAS LINE, A KERN RIVER GAS TRANSMISSION CO. REPRESENTATIVE MUST BE PRESENT DURING CONSTRUCTION IN AND AROUND EQUIPMENT. CALL 399-1612 FOR AN APPOINTMENT 48 HOURS PRIOR.

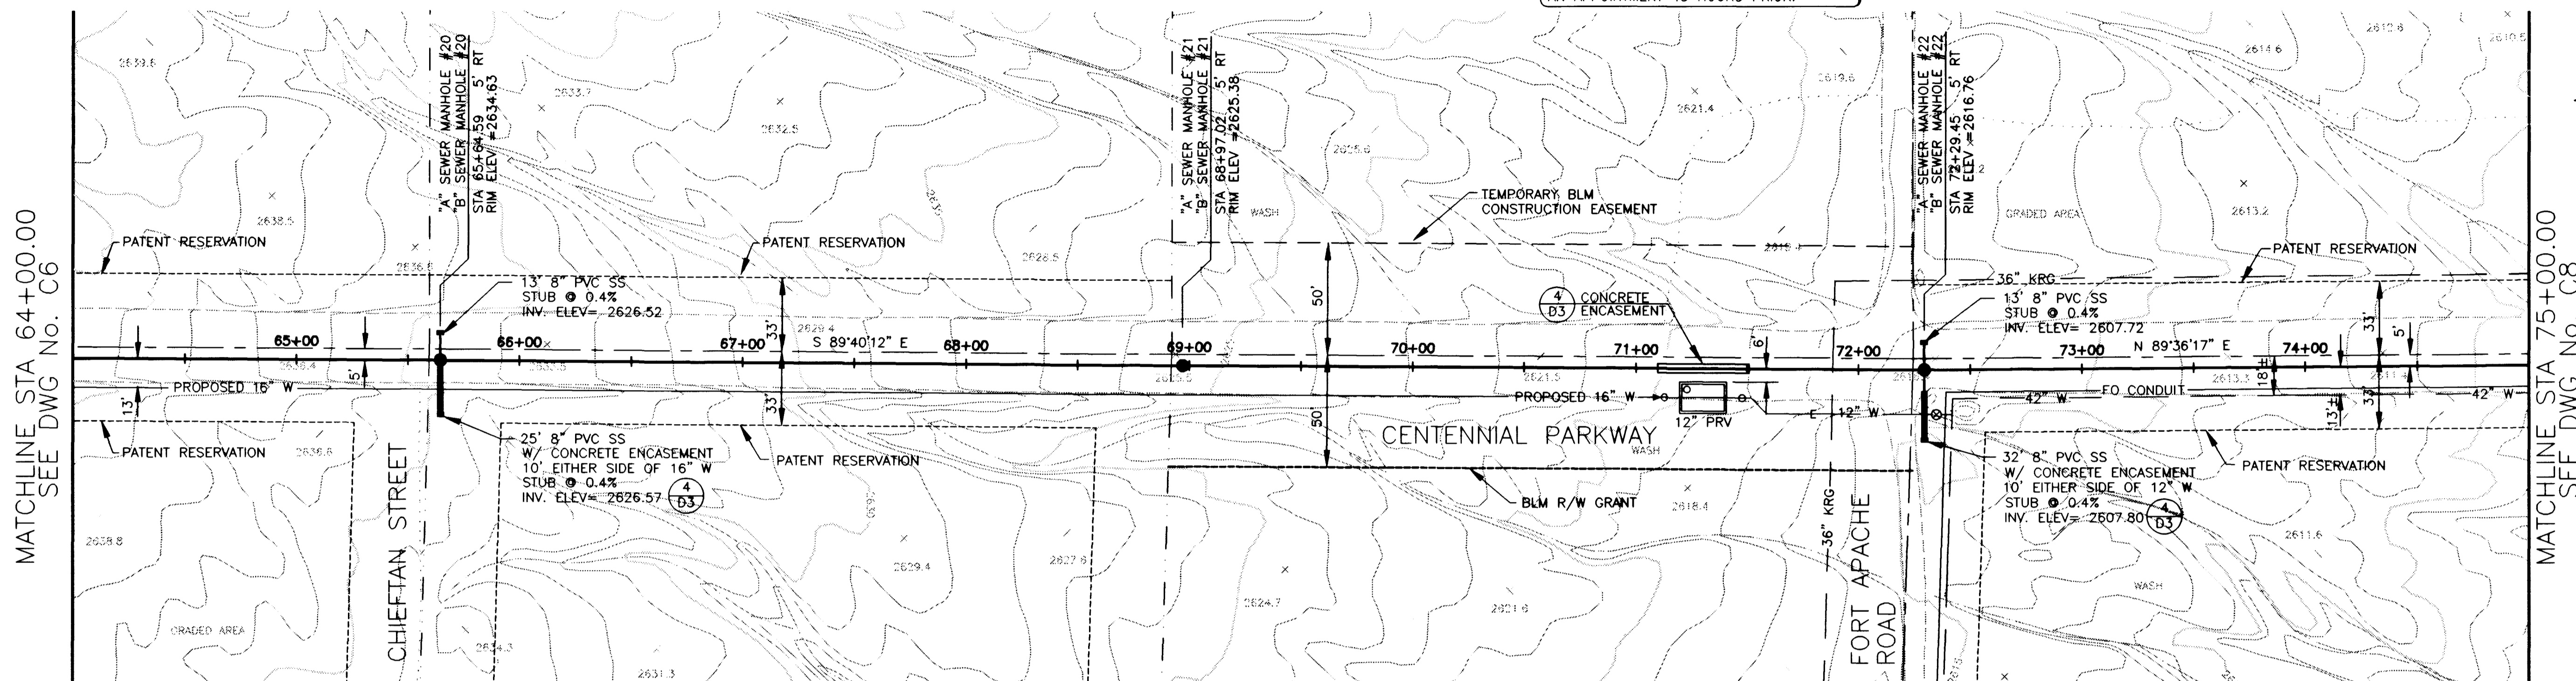

REVISIONS	DATE	DESCRIPTION	APPROVED

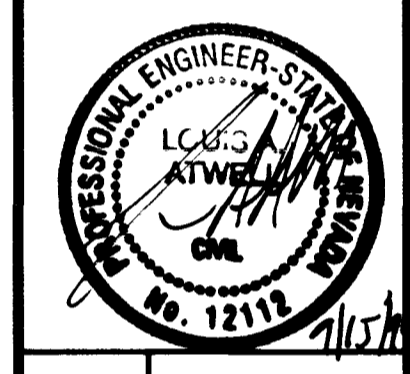

Department of Public Works  
**DURANGO INTERCEPTOR SEWER  
 PLAN AND PROFILE**  
 STA 64+00.00 TO STA 75+00.00

DRAWING No. 12  
 C7 26

**SANITARY SEWER ALTERNATIVES**

ALT "A" - 8" SEWER STA 1+03.75 TO STA 18+80.47
10" SEWER STA 18+80.47 TO STA 98+90.83
27" SEWER STA 98+90.83 TO STA 125+20.39
30" SEWER STA 125+20.39 TO STA 156+66.01
33" SEWER STA 156+66.01 TO STA 190+44.26
ALT "B" - 8" SEWER STA 1+03.75 TO STA 190+44.26
(FOR BIDDING PURPOSES ONLY)

**NOTE:**  
 ALL EXISTING UTILITY LOCATIONS SHOWN HEREON ARE APPROXIMATE ONLY. IT SHALL BE THE CONTRACTOR'S RESPONSIBILITY TO DETERMINE THE EXACT VERTICAL AND HORIZONTAL LOCATION OF ALL EXISTING UNDERGROUND UTILITIES PRIOR TO CONSTRUCTION AND RELOCATE THESE UTILITIES AS NECESSARY. NO REPRESENTATION IS MADE THAT ALL UTILITIES ARE SHOWN HEREON. THE ENGINEER ASSUMES NO LIABILITY FOR UTILITIES NOT SHOWN OR UTILITIES NOT SHOWN IN THEIR PROPER LOCATIONS.

SCALE: HORIZ. 1"=40'  
 VERT. 1"=4'

Call before you Dig  
 1-800-227-2600

