


MATCHLINE STA 149+00.00
SEE DWG No. C14

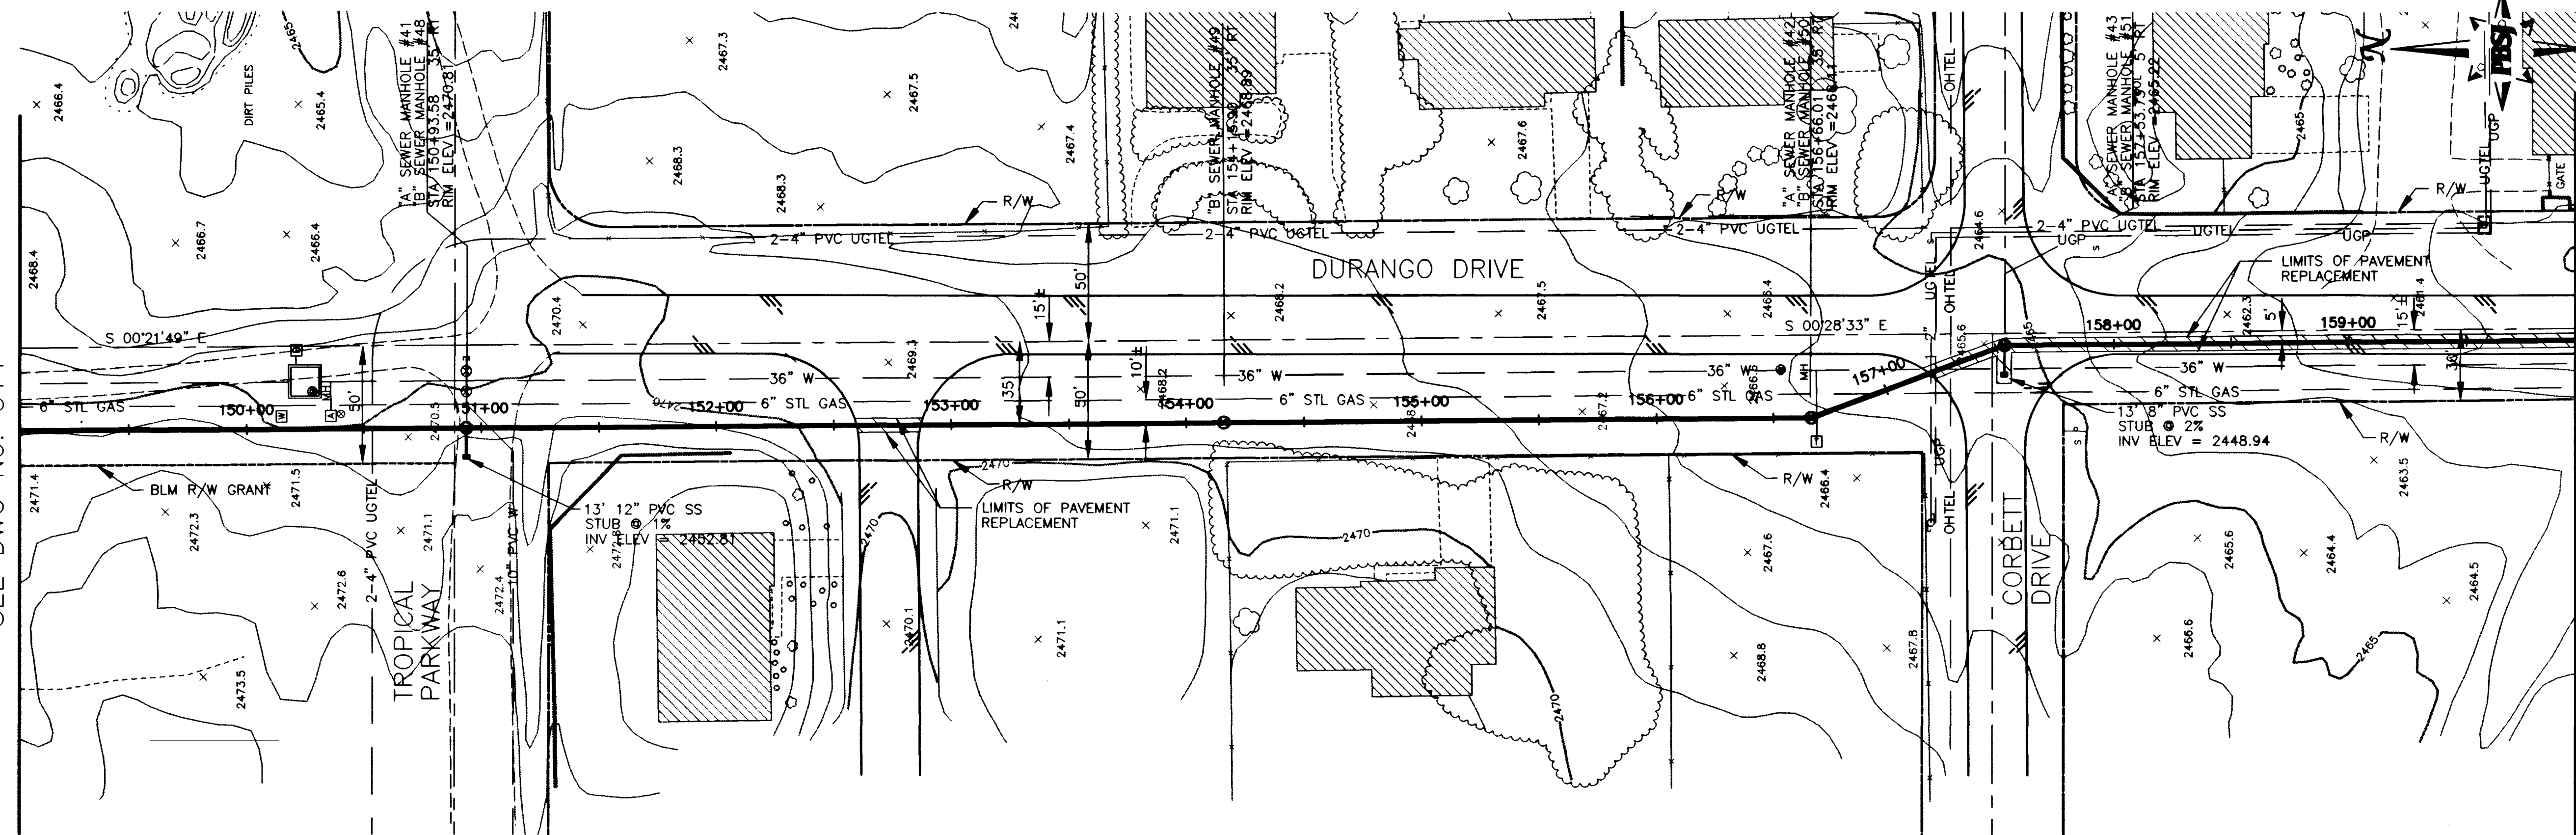

MATCHLINE STA 160+00.00
SEE DWG No. C16

SANITARY SEWER ALTERNATIVES

ALT "A" - 8" SEWER STA 1+03.75 TO STA 18+80.47
10" SEWER STA 18+80.47 TO STA 98+90.83
27" SEWER STA 98+90.83 TO STA 125+20.39
30" SEWER STA 125+20.39 TO STA 156+66.01
33" SEWER STA 156+66.01 TO STA 190+44.26

ALT "B" - 8" SEWER STA 1+03.75 TO STA 190+44.26
(FOR BIDDING PURPOSES ONLY)

NOTE:


ALL EXISTING UTILITY LOCATIONS SHOWN HEREON ARE APPROXIMATE ONLY.
IT SHALL BE THE CONTRACTOR'S RESPONSIBILITY TO DETERMINE THE EXACT VERTICAL
AND HORIZONTAL LOCATION OF ALL EXISTING UNDERGROUND UTILITIES PRIOR TO
CONSTRUCTION AND RELOCATE THESE UTILITIES AS NECESSARY. NO REPRESENTATION
IS MADE THAT ALL UTILITIES ARE SHOWN HEREON. THE ENGINEER ASSUMES NO
LIABILITY FOR UTILITIES NOT SHOWN OR UTILITIES NOT SHOWN IN THEIR
PROPER LOCATIONS.

SCALE: HORIZ. 1"=40'
VERT. 1"=4'

Call before you OVERHEAD
1-702-593-6111 1-800-227-2600


MATCHLINE STA 149+00.00
SEE DWG No. C14

MATCHLINE STA 160+00.00
SEE DWG No. C16

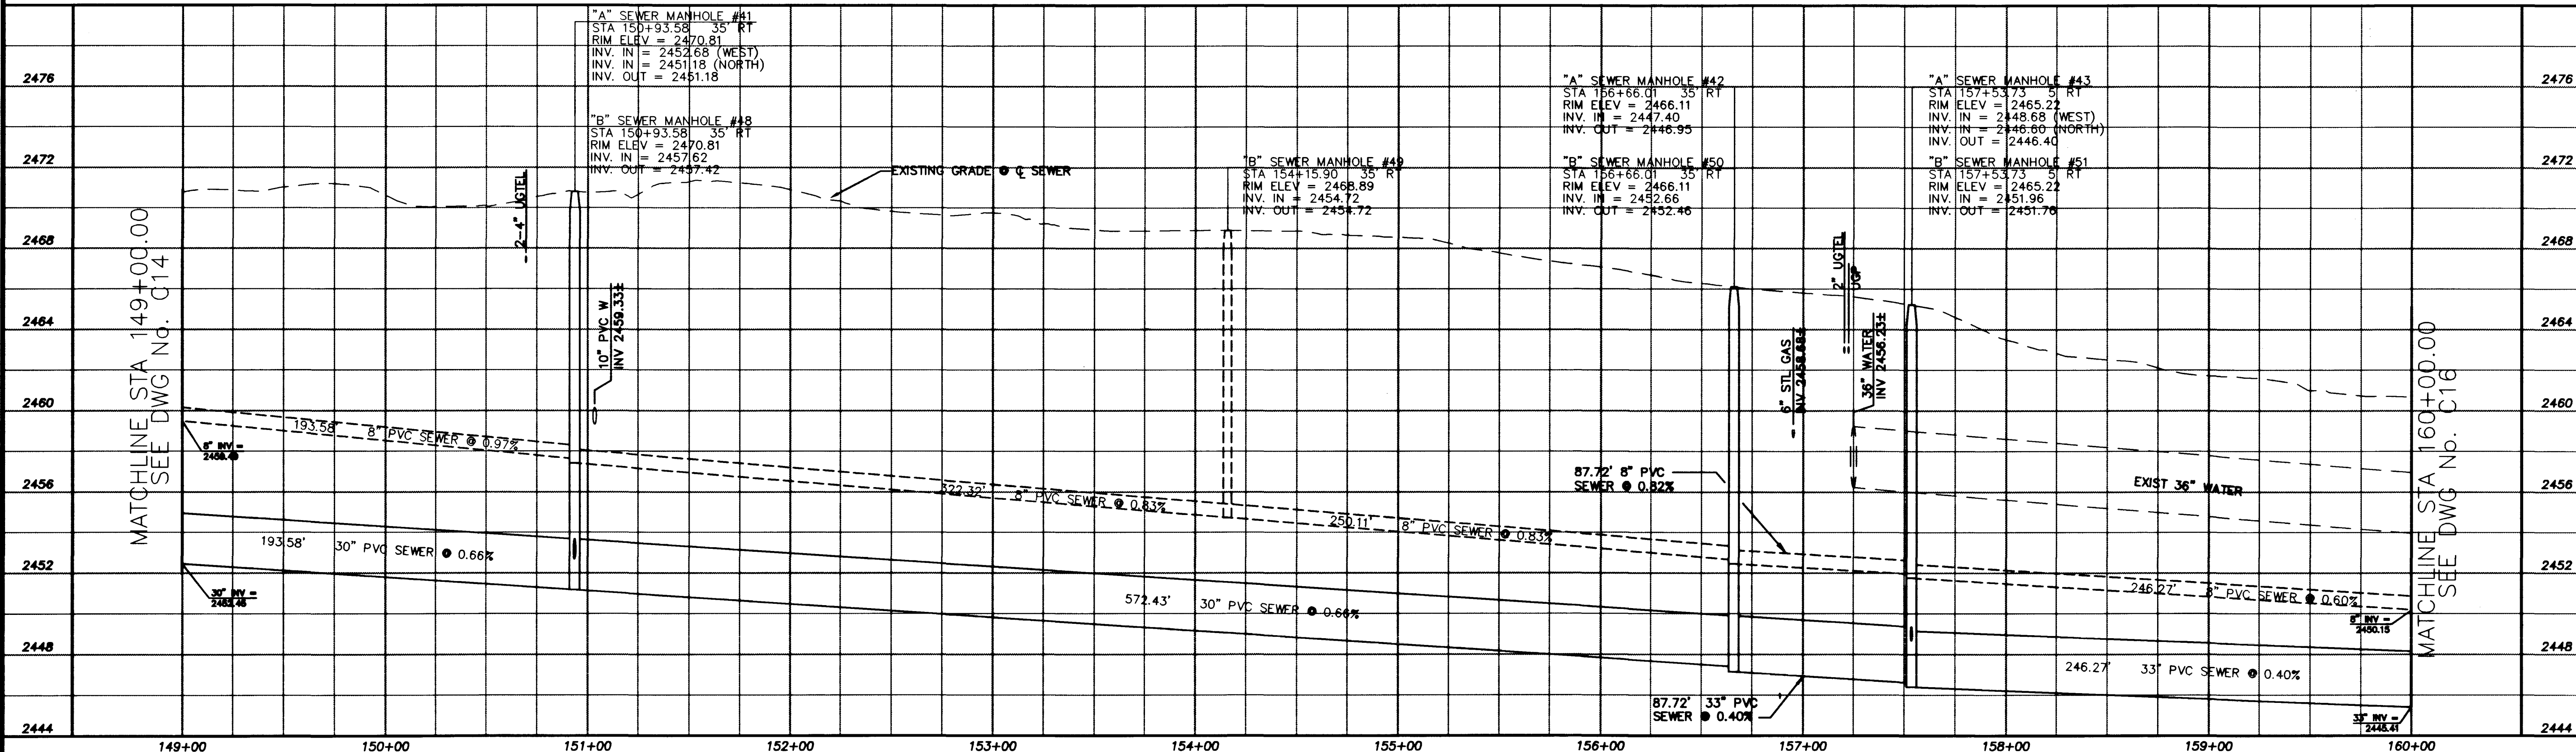

REVISIONS

DURANGO INTERCEPTOR SEWER
DRAWN BY: J. ARROYO
CHECKED BY: J. LUSTIG
DATE: 8-31-98

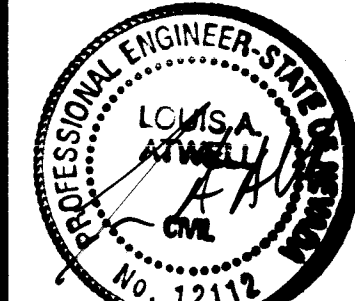

Department of Public Works

DURANGO INTERCEPTOR SEWER

PLAN AND PROFILE

STA 149+00.00 TO STA 160+00.00



DRAWING No. 20
C15

APPROVED

