
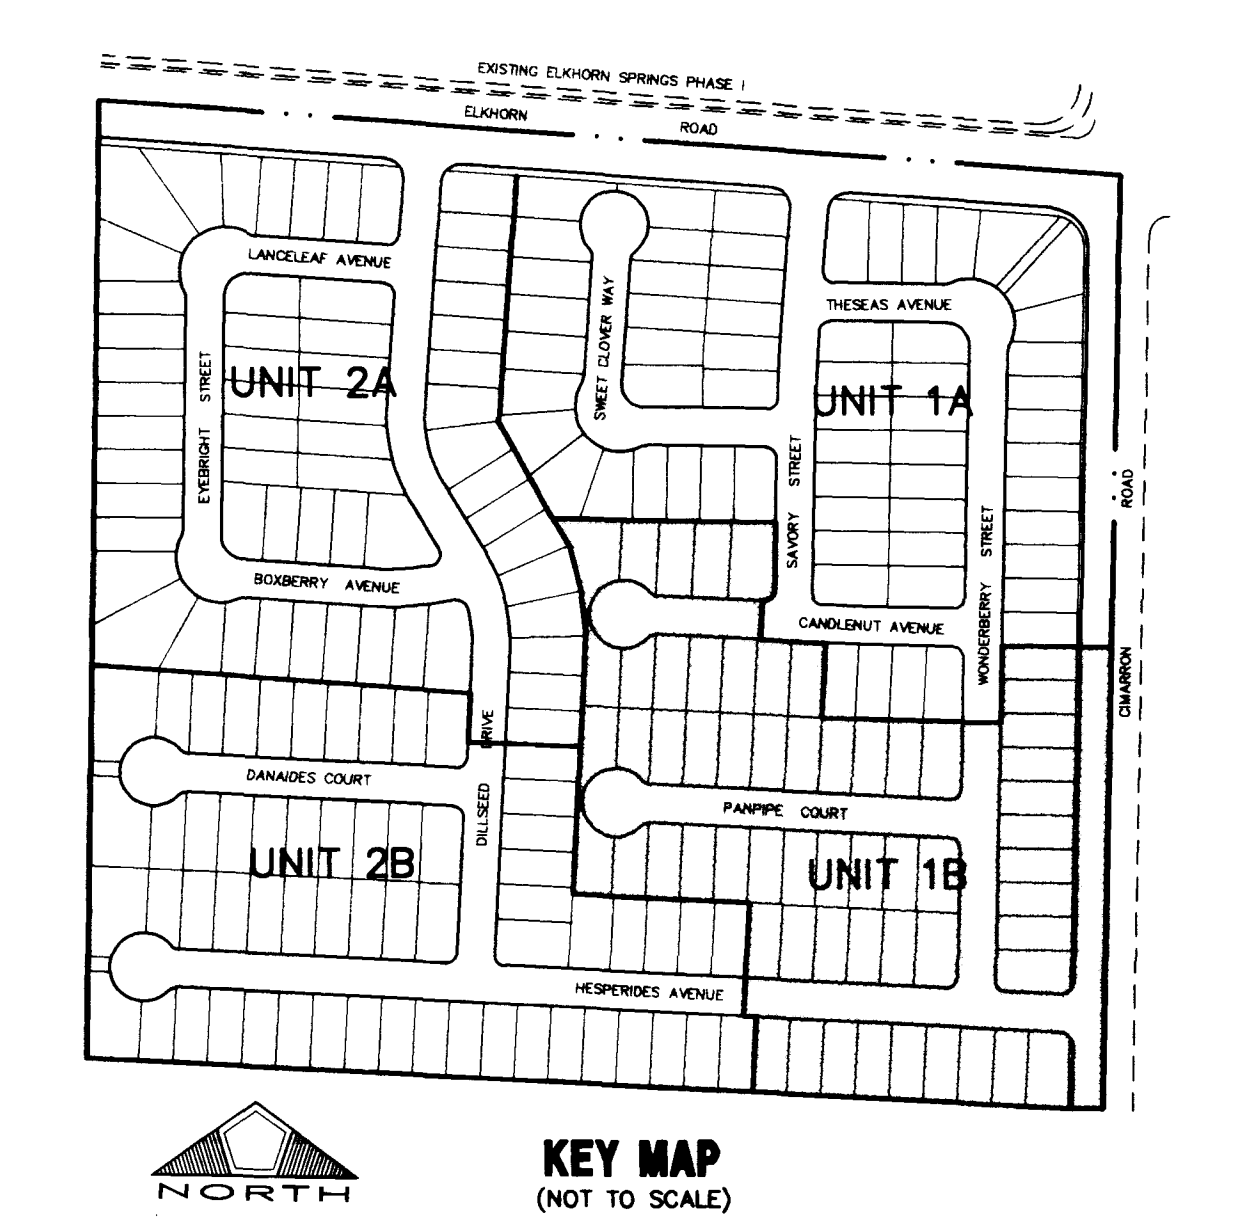
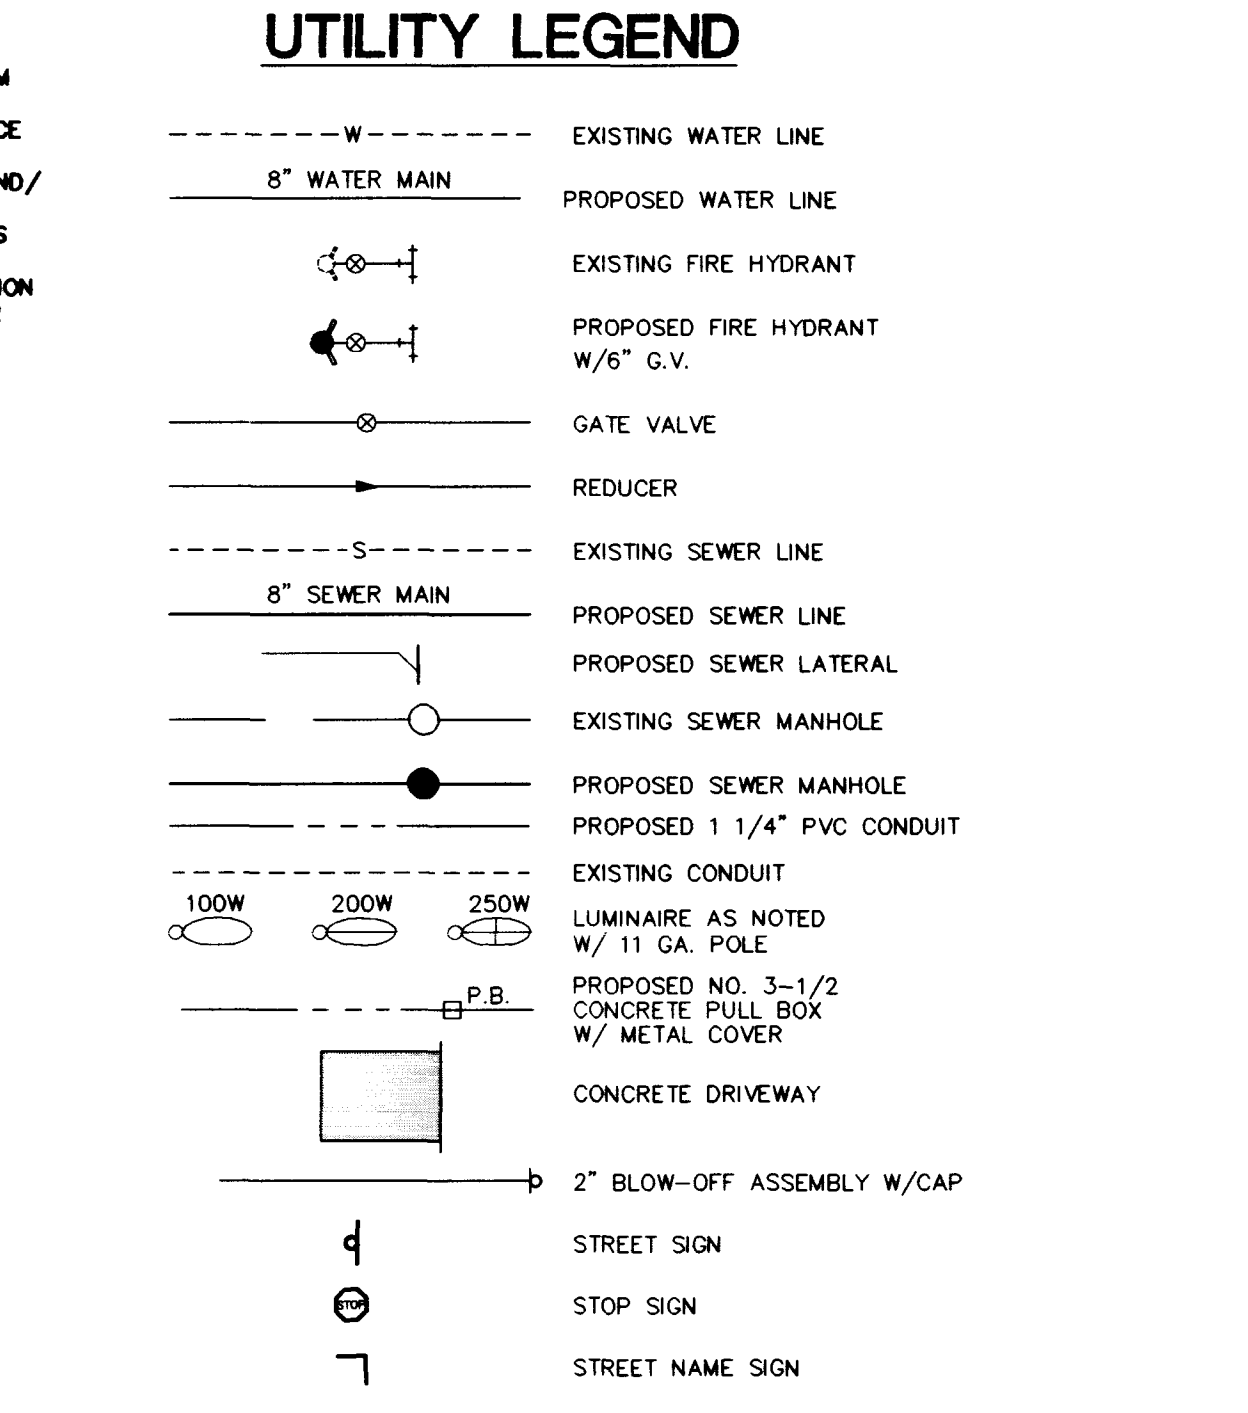
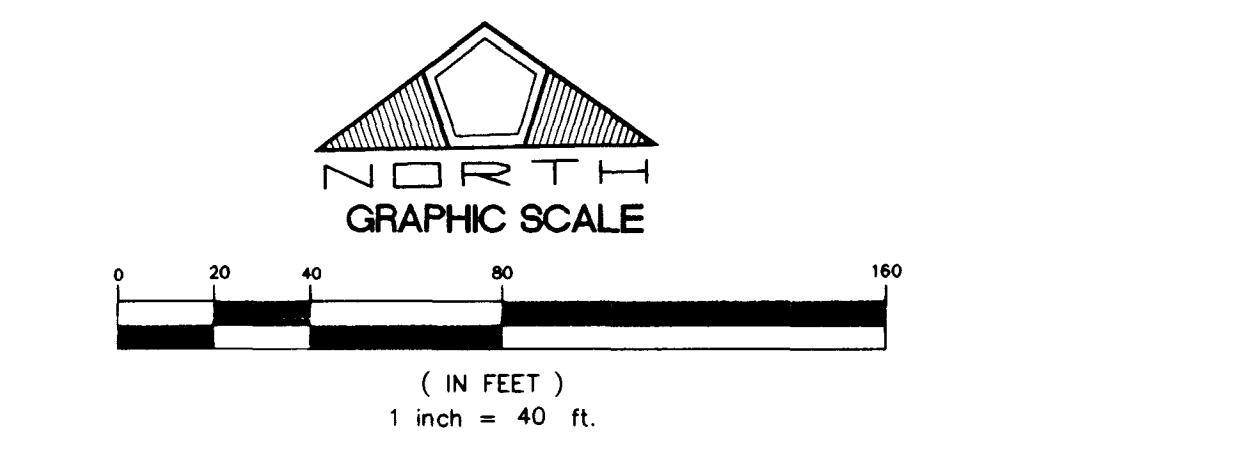
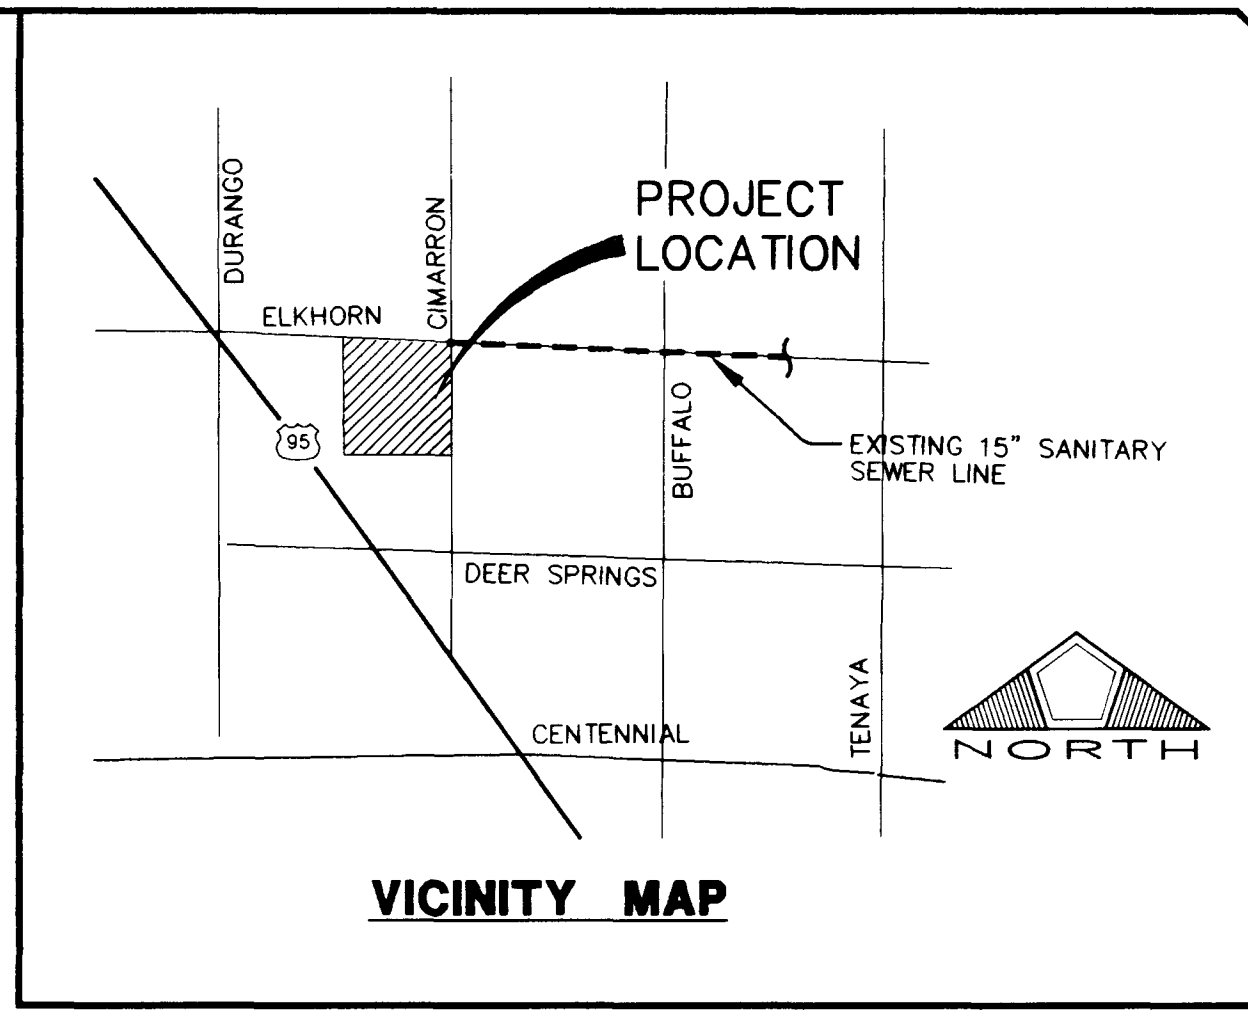
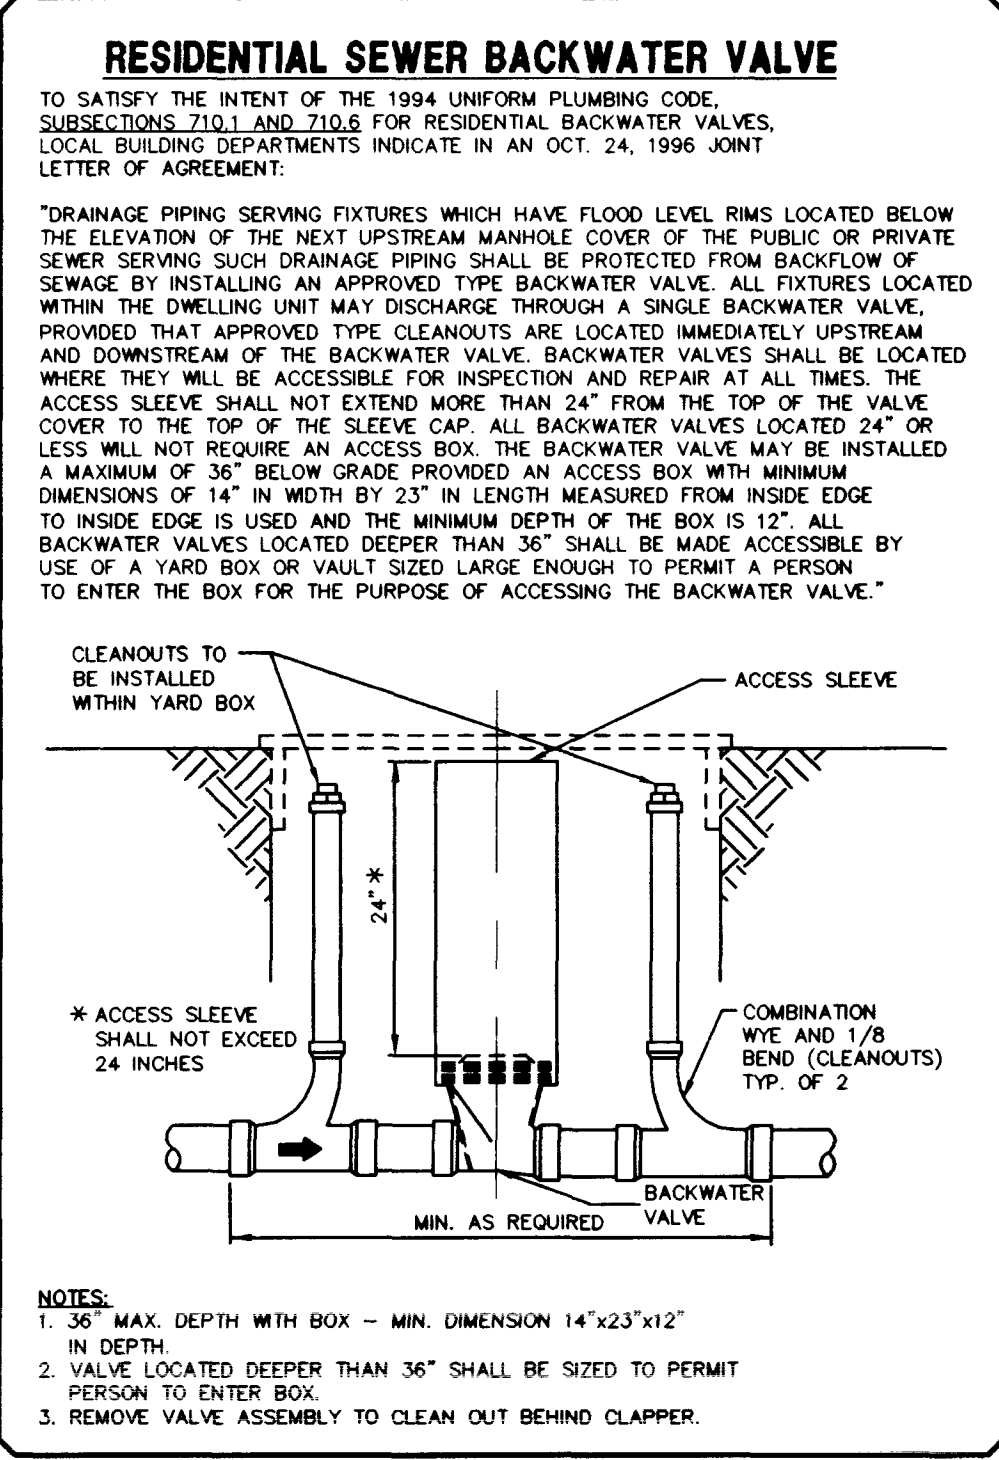


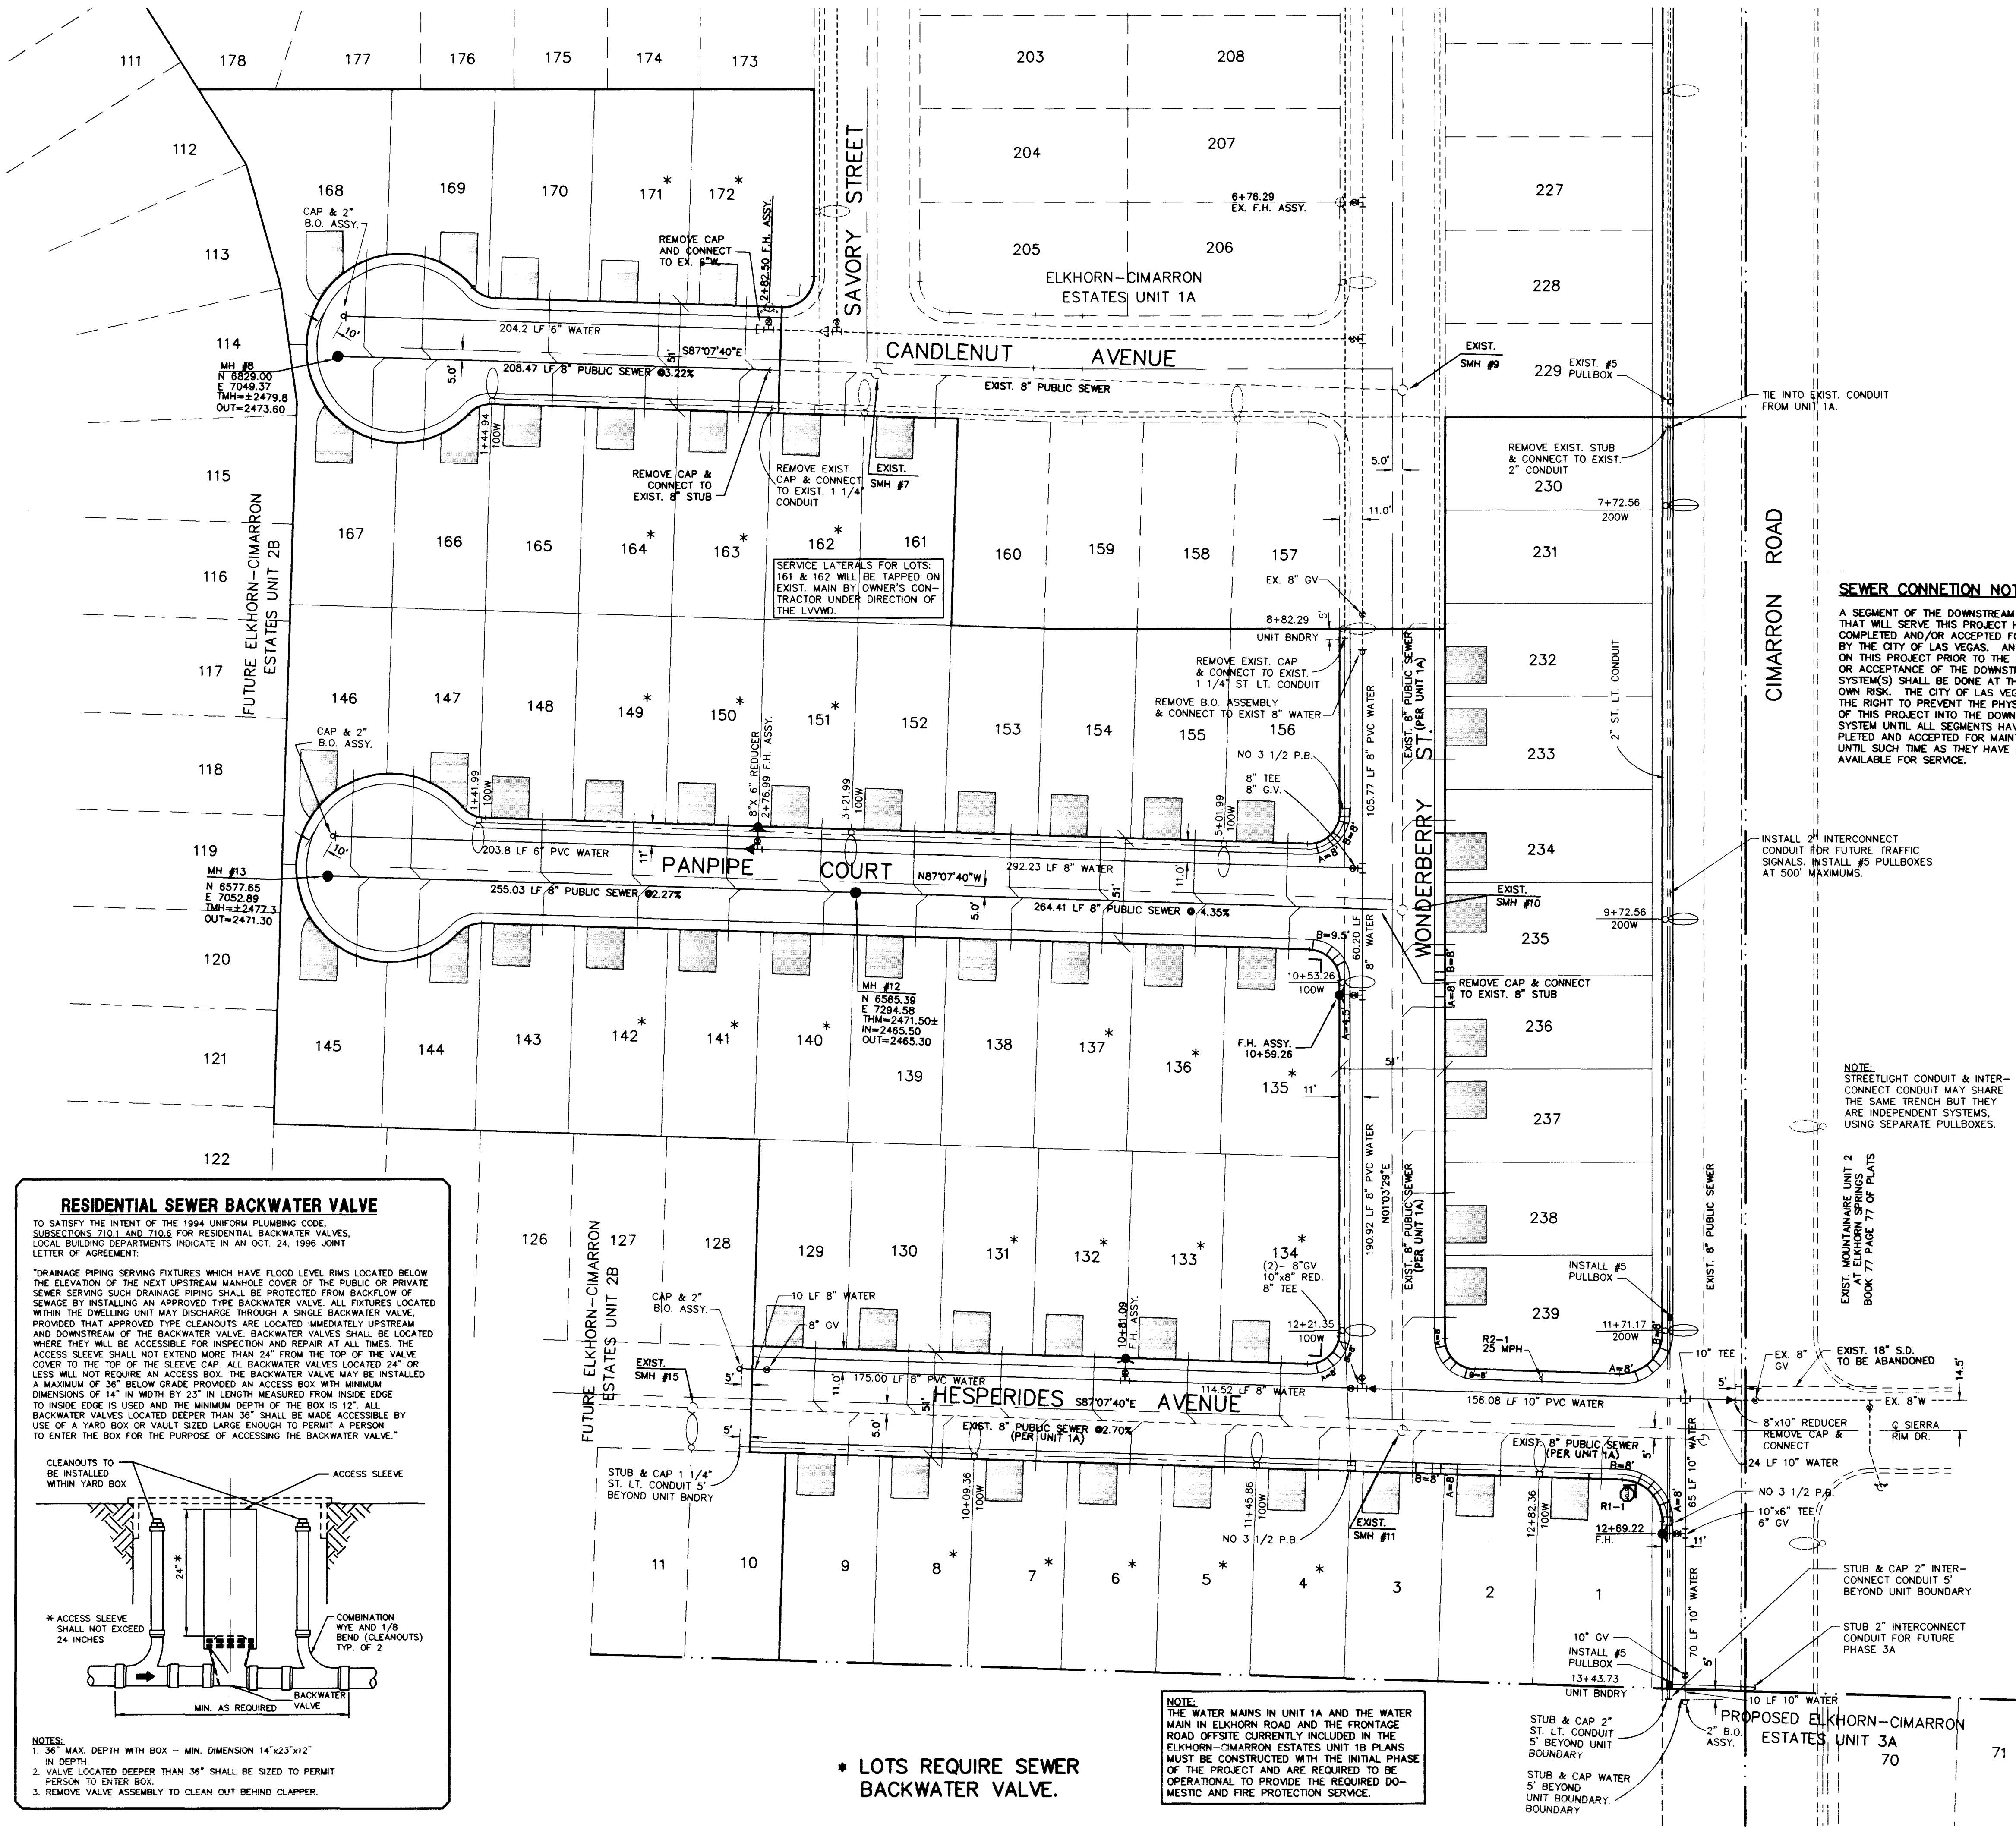

APPROVED FOR CONSTRUCTION
 LAS VEGAS VALLEY WATER DISTRICT
 DATE: 6/30/97

PENTACORE
 CIVIL ENGINEERING • LAND SURVEYING • PLANNING
 CONSTRUCTION MANAGEMENT • ADA CONSULTING
 6763 WEST CHARLESTON BOULEVARD
 LAS VEGAS, NEVADA 89102 (702)258-0115

EXECUTIVE DEVELOPMENT CORPORATION
 ELKHORN - CIMARRON ESTATES UNIT 1B
 UTILITY PLAN

DATE: 6/23/97
 DRAWN BY: J. HIRSHNER
 CHECKED BY: J. HIRSHNER
 JOB NO.: 041.0006
 SCALE: 1" = 40'

SHEET
4
 OF 10

307Y-4498-1B

DATE: 07/11/2010 BY: 60322/UCB/STC

